



95% Design Plans for Old River Site and Connection Slough Sites

TWO GATE FISH PROTECTION PLAN

BACON ISLAND, CALIFORNIA

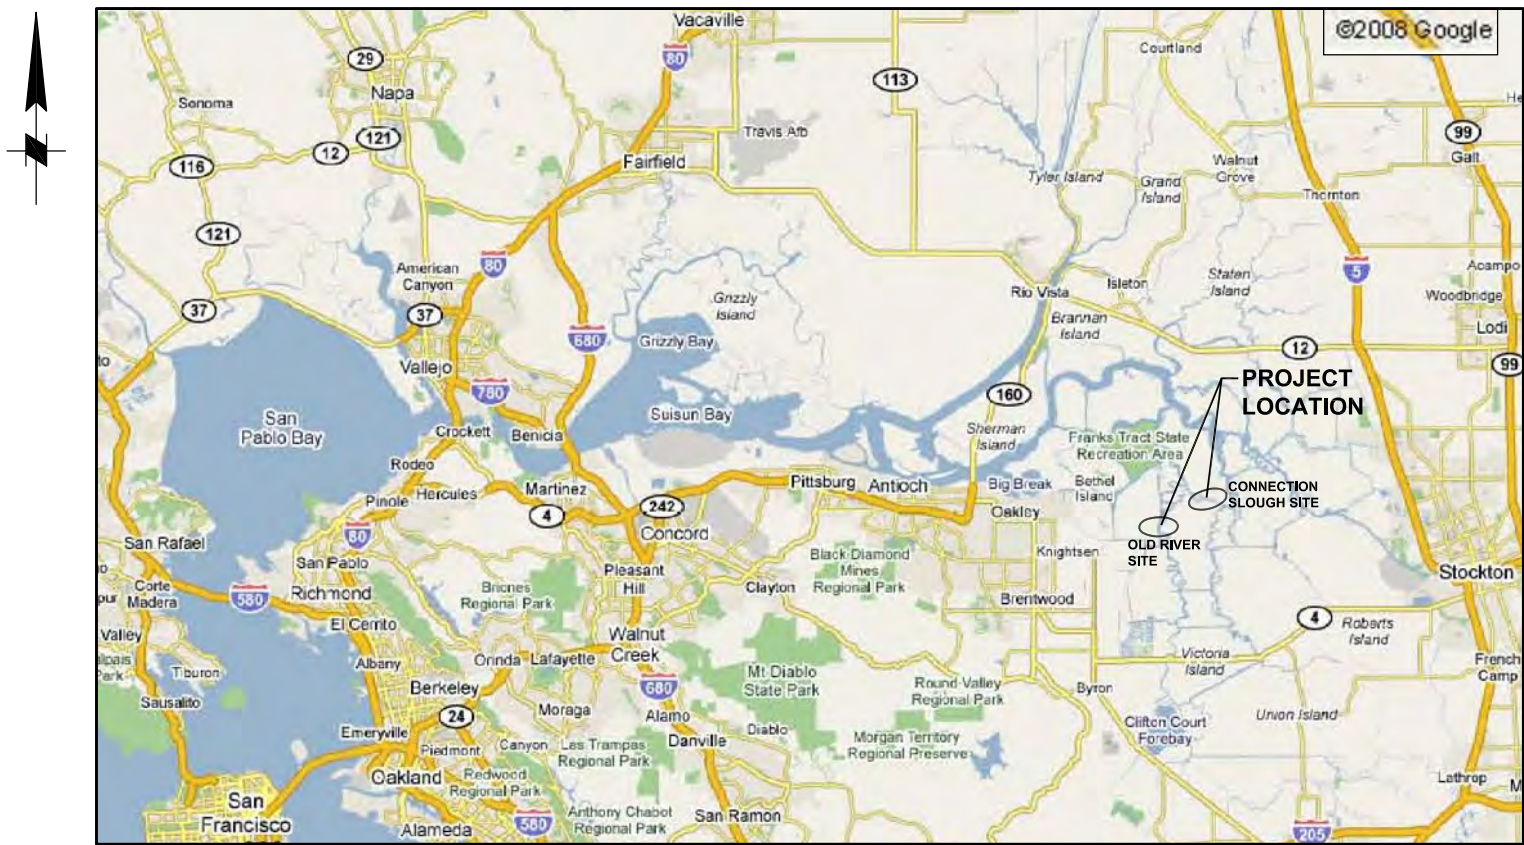

VICINITY MAP
NTS

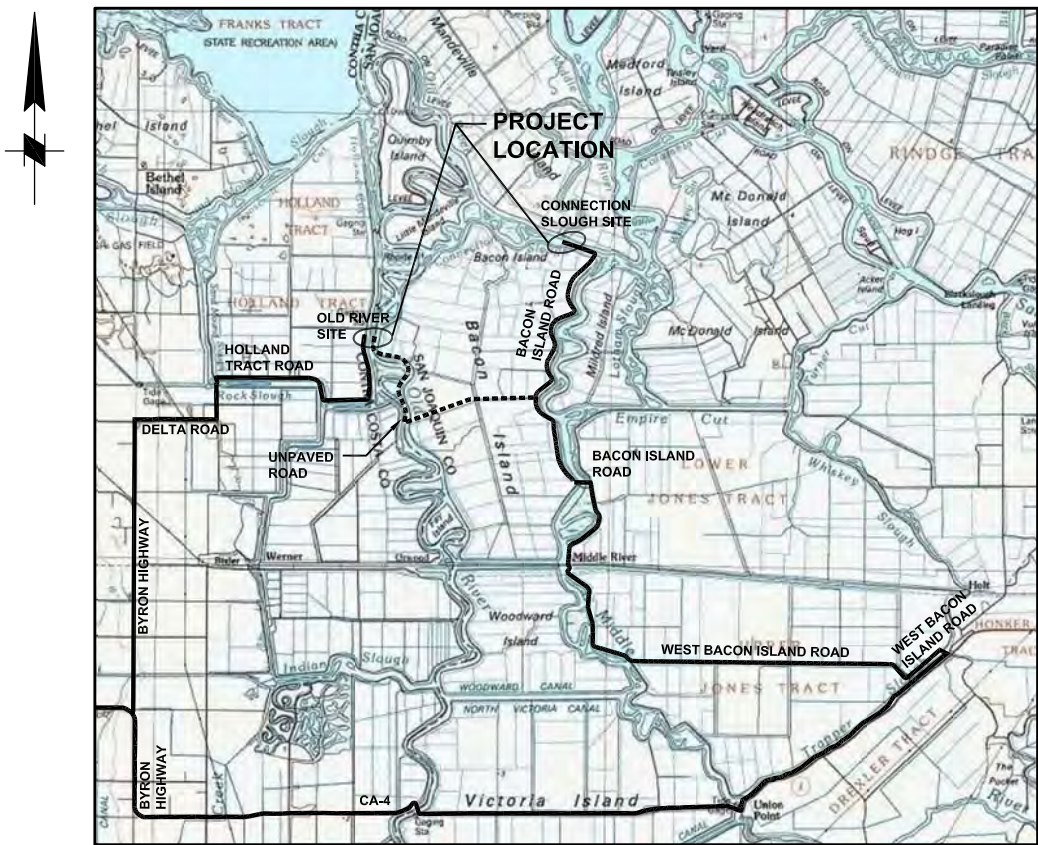

LOCATION MAP
NTS

TECHNICAL REVIEWERS			
CIVIL _____ (NAME)	STRUCTURAL _____ (NAME)	 1121 L Street, Suite 1050 Sacramento, California 95814-3944 (916) 447-7357 x203 APPROVED _____ DENNIS G. MAJORS	
ELECTRICAL _____ (NAME)	MECHANICAL _____ (NAME)		

95% SUBMITTAL IF SHEET IS LESS THAN 22" x 34"
IT IS A REDUCED PRINT -
SCALE REDUCED ACCORDINGLY.

REVISION	DESCRIPTION	BY	DATE			 2001 N. Main Street, Suite 360 Walnut Creek, California 94596 (925) 944-5411	TWO GATE FISH PROTECTION PLAN	DATE 08/07/09
								SHEET 1 OF 75
							TITLE SHEET	G1
						DSGN TDB DR AB CHK GTH JOB NO. 6097-03 SUBMITTED BY RMR TITLE		

P:\6097-03 SWC GATE DESIGN\CADD\DWG\609703-G2.DWG 7/30/2009 2:12 PM

INDEX OF DRAWINGS

SHEET NUMBER	DRAWING NUMBER	DESCRIPTION
		GENERAL
1	G1	TITLE SHEET
2	G2	INDEX OF DRAWINGS
3	G3	GENERAL NOTES, ABBREVIATIONS AND LEGEND
4	G4	PROJECT GENERAL PLAN
		OLD RIVER
5	C1	OLD RIVER, SITE PLAN
6	C2	OLD RIVER, DREDGING PLAN AND SECTION
7	C3	OLD RIVER, BARGE BEDDING PLAN AND SECTIONS
8	C4	OLD RIVER, BARGE – ROCK FILL PLAN AND SECTIONS
9	C5	OLD RIVER, SHEET PILE WALL ARRANGEMENT PLAN AND ELEVATION, SHEET 1
10	C6	OLD RIVER SHEET PILE WALL ARRANGEMENT PLAN AND ELEVATION, SHEET 2
11	C7	OLD RIVER, BOAT RAMP PLAN AND SECTION
12	C7.1	OLD RIVER, BOAT RAMP PILE PLAN
13	C7.2	OLD RIVER, BOAT RAMP FRAMING PLAN
14	C8	OLD RIVER, BOAT RAMP DETAILS AND SECTIONS, SHEET 1
15	C9	OLD RIVER, BOAT RAMP DETAILS AND SECTIONS, SHEET 2
16	C10	OLD RIVER, BOAT RAMP DETAILS AND SECTIONS, SHEET 3
17	C11	OLD RIVER, CATWALK PLAN AND ELEVATION, SHEET 1
18	C12	OLD RIVER, CATWALK PLAN AND ELEVATION, SHEET 2
19	C13	OLD RIVER, ELECTRICAL SITE PLAN
20	C14	OLD RIVER, BARGE GENERAL ARRANGEMENT PLAN
21	C15	OLD RIVER, BARGE GENERAL ARRANGEMENT ELEVATION
22	C16	OLD RIVER, GATE SCANTLINGS
23	C17	OLD RIVER, GATE FRAMING LAYOUT
24	C18	OLD RIVER, END WALL SCANTLINGS
25	C19	OLD RIVER, AIDS TO NAVIGATION PLAN
26	C20	NOT USED
27	C21	OLD RIVER, REMOVAL PLAN

SHEET NUMBER	DRAWING NUMBER	DESCRIPTION
		CONNECTION SLOUGH
28	C31	CONNECTION SLOUGH, SITE PLAN
29	C32	CONNECTION SLOUGH, DREDGING – PLAN AND SECTION
30	C33	CONNECTION SLOUGH, BARGE BEDDING PLAN
31	C34	CONNECTION SLOUGH, BARGE–ROCK FILL PLAN AND SECTIONS
32	C35	CONNECTION SLOUGH, SHEET PILE WALL ARRANGEMENT PLAN AND ELEVATION
33	C36	CONNECTION SLOUGH, BOAT RAMP PLAN AND SECTION
34	C36.1	CONNECTION SLOUGH, BOAT RAMP PILE PLAN
35	C36.2	CONNECTION SLOUGH, BOAT RAMP FRAMING PLAN
36	C37	CONNECTION SLOUGH, BOAT RAMP DETAILS AND SECTIONS, SHEET 1
37	C38	CONNECTION SLOUGH, BOAT RAMP DETAILS AND SECTIONS, SHEET 2
38	C39	CONNECTION SLOUGH, BOAT RAMP DETAILS AND SECTIONS, SHEET 3
39	C40	CONNECTION SLOUGH, CATWALK – PLAN AND ELEVATION
40	C41	CONNECTION SLOUGH, ELECTRICAL SITE PLAN
41	C42	CONNECTION SLOUGH, BARGE GENERAL ARRANGEMENT PLAN
42	C43	CONNECTION SLOUGH, BARGE GENERAL ARRANGEMENT ELEVATION
43	C44	CONNECTION SLOUGH, GATE SCANTLINGS
44	C45	CONNECTION SLOUGH, GATE FRAMING LAYOUT
45	C46	CONNECTION SLOUGH, END WALL SCANTLINGS
46	C47	CONNECTION SLOUGH, AIDS TO NAVIGATION PLAN
47	C48	NOT USED
48	C49	CONNECTION SLOUGH, REMOVAL PLAN

SHEET NUMBER	DRAWING NUMBER	DESCRIPTION
		COMMON DETAILS
49	C56	GATE STRUCTURAL DETAILS, SHEET 1
50	C57	GATE STRUCTURAL DETAILS, SHEET 2
51	C58	GATE STRUCTURAL DETAILS, SHEET 3
52	C59	GATE STRUCTURAL DETAILS, SHEET 4
53	C60	GATE STRUCTURAL DETAILS, SHEET 5
54	C61	GATE MECHANICAL DETAILS, SHEET 1
55	C62	GATE MECHANICAL DETAILS, SHEET 2
56	C63	SHEET PILE WALL DETAILS, SHEET 1
57	C64	SHEET PILE WALL DETAILS, SHEET 2
58	C65	BOAT RAMP PLAN AND SECTIONS
59	C66	BOAT RAMP DETAILS
60	C67	BOARDING FLOAT PLAN AND ELEVATION
61	C68	BOARDING FLOAT DETAILS
62	C69	CATWALK DETAILS, SHEET 1
63	C70	CATWALK DETAILS, SHEET 2
64	C71	CATWALK DETAILS, SHEET 3
65	C72	CATWALK DETAILS, SHEET 4
66	C73	CATWALK DETAILS, SHEET 5
67	C74	CATWALK DETAILS, SHEET 6
68	C75	AIDS TO NAVIGATION DETAILS, SHEET 1
69	C76	AIDS TO NAVIGATION DETAILS, SHEET 2
70	C77	UTILITY YARD DETAILS
71	C78	OPERATOR HOUSE EQUIPMENT AND DETAILS
72	C79	ELECTRICAL SYSTEM DIAGRAM
73	C80	HYDRAULICS SYSTEM DIAGRAM
74	C81	DREDGED MATERIAL DISPOSAL SITE
75	C82	MISCELLANEOUS DETAILS

95% SUBMITTAL

IF SHEET IS LESS THAN 22” x 34”
IT IS A REDUCED PRINT –
SCALE REDUCED ACCORDINGLY.

REVISION	DESCRIPTION	BY	DATE			Moffatt & Nichol 2001 N. Main Street, Suite 360 Walnut Creek, California 94596 (925) 944-5411	TWO GATE FISH PROTECTION PLAN		DATE 08/07/09
								SHEET 2 OF 75	
								INDEX OF DRAWINGS	G2
DSGN		DR		CHK					
TDB		AB		GTH					
JOB NO.		SUBMITTED BY		TITLE					
6097-03		RMR							

GENERAL NOTES

1. BATHYMETRY SURVEYED BY ENVIRONMENTAL DATA SOLUTIONS ON JUNE 23, 2008 AND REPRESENTS CONDITIONS ON THAT DATE.
2. KING PILE TYPE (36 INCH OD x 0.75 INCH WT) AND SPACING SHOWN ON THE PLANS WILL BE ADJUSTED ON THE BASIS OF IN-SITU SOIL BORING DATA AS SOON AS THIS INFORMATION BECOMES AVAILABLE.

VERTICAL DATUM

 
PROJECT ELEVATIONS ARE BASED ON NAVD’88.

HORIZONTAL DATUM

PROJECT COORDINATES ARE BASED ON THE CALIFORNIA STATE PLANE COORDINATE SYSTEM NAD 1983, ZONE 3.

DESIGN CONDITIONS

LIVE LOADS: CATWALK: 100 PSF
BOAT RAMP: 5,000 LBS
CONCENTRATED WHEEL LOAD (TOTAL 2 PER AXLE)



WATER ELEVATION: GATES AND SHEET PILES/ KING PILES/ ABUTMENT WALL:
DIFFERENTIAL WATER ELEVATION = 3.6 FT

EARTHQUAKE: QUASI – STATIC LATERAL SEISMIC
ACCELERATION, SA = 0.3g BASED ON 2006 IBC

CURRENT: CURRENT OF 2 KNOTS (3.4 FT/SEC) FREE STREAM VELOCITY


SHIP IMPACT: DOLPHINS/MONOPILES: ACCIDENTAL IMPACT 95 KIP LOAD
AT EL +7.0’

OPERATING LOAD: GATE/ FRAME: HYDRAULIC ACTUATORS (PISTON FORCES)
 $F_1 = +157.1 \text{ KIP}$ $F_2 = -125.3 \text{ KIP}$
 $F_1 = -125.3 \text{ KIP}$ $F_2 = +157.1 \text{ KIP}$
(COMPRESSION +, TENSION –)

ABBREVIATIONS


&	AND	NAD	NORTH AMERICAN DATUM
#	NUMBER	NAVD	NORTH AMERICAN VERTICAL DATUM
%	PERCENT	NTS	NOT TO SCALE
APPROX	APPROXIMATE	OC	ON CENTER
ASTM	ASTM INTERNATIONAL	OD	OUTSIDE DIAMETER
C/C	CENTER TO CENTER	OG	ORIGINAL GROUND
CJP	COMPLETE JOINT PENETRATION	OPP	OPPOSITE
℄	CENTER LINE	PC/PS	PRECAST/PRESTRESSED
CIP	CAST-IN-PLACE	℄	PLATE
CLR	CLEAR	PJP	PARTIAL JOINT PENETRATION
CONC	CONCRETE	PSF	POUNDS PER SQUARE FOOT
CONT	CONTINUOUS	REF	REFERENCE
DIA, ∅	DIAMETER	REINF	REINFORCEMENT
DIMS	DIMENSIONS	SA	SEISMIC ACCELERATION
DWG	DRAWING	SCH	SCHEDULE
DWT	DEAD WEIGHT	SIM	SIMILAR
(E)	EXISTING	SPA	SPACES
EL	ELEVATION	STD	STANDARD
EJ	EXPANSION JOINT	STIF	STIFFENER
EW	EACH WAY	SYMM	SYMMETRICAL
FG	FINISH GRADE	THRU	THROUGH
FT	FOOT OR FEET	TYP	TYPICAL
GALV	GALVANIZED	UHMW	ULTRA HIGH MOLECULAR WEIGHT
H	HORIZONTAL	UON	UNLESS OTHERWISE NOTED
HD	HEAD	V	VERTICAL
HDPE	HIGH DENSITY POLYETHYLENE	VC	VERTICAL CURVE
HW	HIGH WATER	WP	WORK POINT
IBC	INTERNATIONAL BUILDING CODE	WT	WALL THICKNESS
ID	INSIDE DIAMETER	W/	WITH
INFO	INFORMATION		
LB	POUND		
LW	LOW WATER		
MAX	MAXIMUM		
MFG	MANUFACTURING		
MIN	MINIMUM		

CROSS-REFERENCE LEGEND

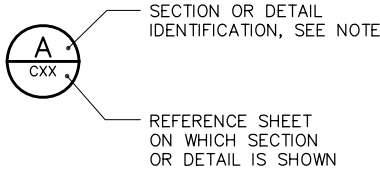

NOTE: LETTER INDICATES SECTION; NUMBER INDICATES DETAIL. WHERE THERE IS NO REFERENCE SHEET INDICATED, IT MEANS THE DETAIL OR SECTION IS TAKEN AND SHOWN ON THE SAME SHEET.

LEGEND

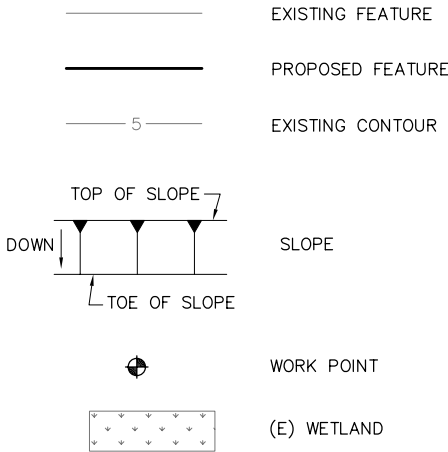

95% SUBMITTAL

IF SHEET IS LESS THAN 22” x 34”
IT IS A REDUCED PRINT –
SCALE REDUCED ACCORDINGLY.

REVISION	DESCRIPTION	BY	DATE


Moffatt & Nichol 2001 N. Main Street, Suite 360 Walnut Creek, California 94596 (925) 944-5411		
DSGN	TDB	CHK GTH
JOB NO.	SUBMITTED BY	TITLE
6097-03	RMR	

TWO GATE FISH PROTECTION PLAN	DATE 08/07/09
	SHEET 3 OF 75
ABBREVIATIONS, LEGEND AND GENERAL NOTES	G3

P:\6097-03 SWC GATE DESIGN\CADD\DWG\609703-G4.DWG 8/7/2009 11:01 AM



 PROJECT GENERAL PLAN
SCALE: 1"= 1000'



95% SUBMITTAL IF SHEET IS LESS THAN 22" x 34"
IT IS A REDUCED PRINT -
SCALE REDUCED ACCORDINGLY.


REVISION	DESCRIPTION	BY	DATE

 Moffatt & Nichol		2001 N. Main Street, Suite 360 Walnut Creek, California 94596 (925) 944-5411	
DSGN	TDB	DR	EP
JOB NO.	6097-03	SUBMITTED BY	RMR
CHK	GTH	TITLE	

TWO GATE FISH PROTECTION PLAN
PROJECT GENERAL PLAN

DATE 08/07/09
SHEET 4 OF 75
G4

P:\6097-03 SWC GATE DESIGN\CADD\DWG\609703-C1.DWG 8/5/2009 10:08 AM

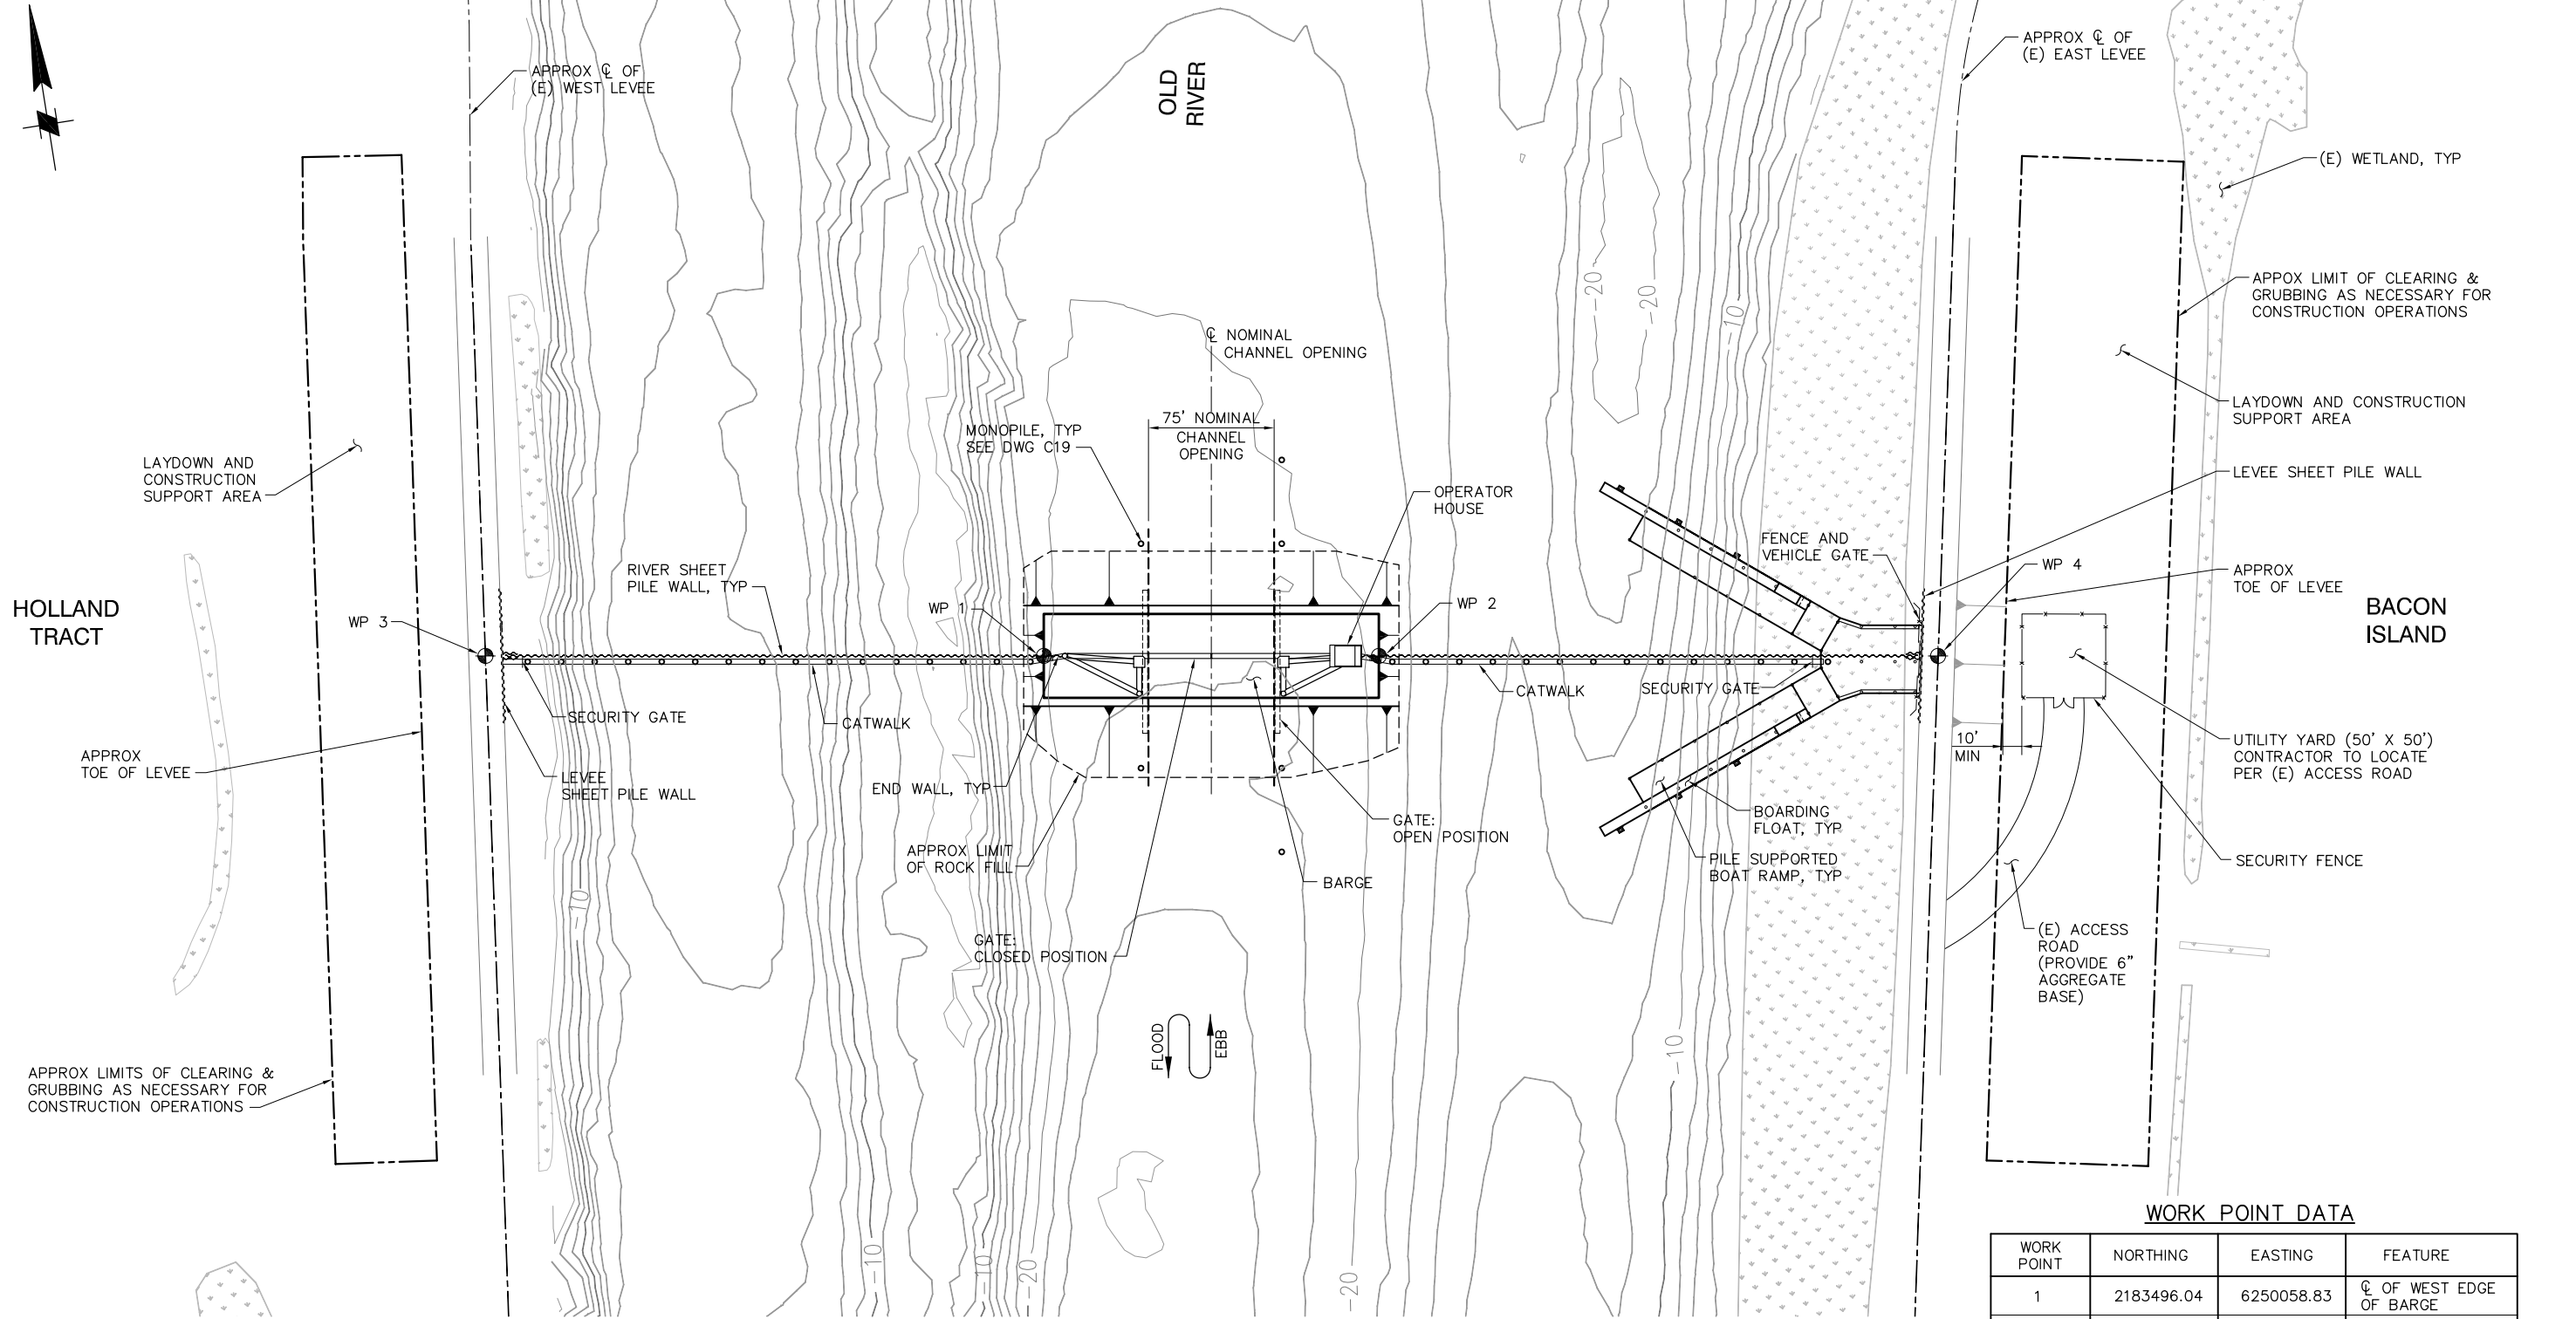

SITE PLAN
SCALE: 1"= 50'

WORK POINT DATA

WORK POINT	NORTHING	EASTING	FEATURE
1	2183496.04	6250058.83	CL OF WEST EDGE OF BARGE
2	2183465.50	6250256.48	CL OF EAST EDGE OF BARGE
3	2183546.94	6249729.50	CL OF WEST LEVEE AND GATE
4	2183414.53	6250586.33	CL OF EAST LEVEE AND GATE

95% SUBMITTAL

IF SHEET IS LESS THAN 22" x 34"
IT IS A REDUCED PRINT -
SCALE REDUCED ACCORDINGLY.

REVISION	DESCRIPTION	BY	DATE



2001 N. Main Street, Suite 360
Walnut Creek, California 94596
(925) 944-5411

DSGN	TDB	DR	EP	CHK	GTH
JOB NO.	6097-03	SUBMITTED BY	RMR	TITLE	

TWO GATE FISH PROTECTION PLAN


**OLD RIVER
SITE PLAN**

DATE 08/07/09


SHEET 5 OF 75

C1


P:\6097-03 SWC GATE DESIGN\CADD\DWG\609703-C2.DWG 7/28/2009 1:34 PM

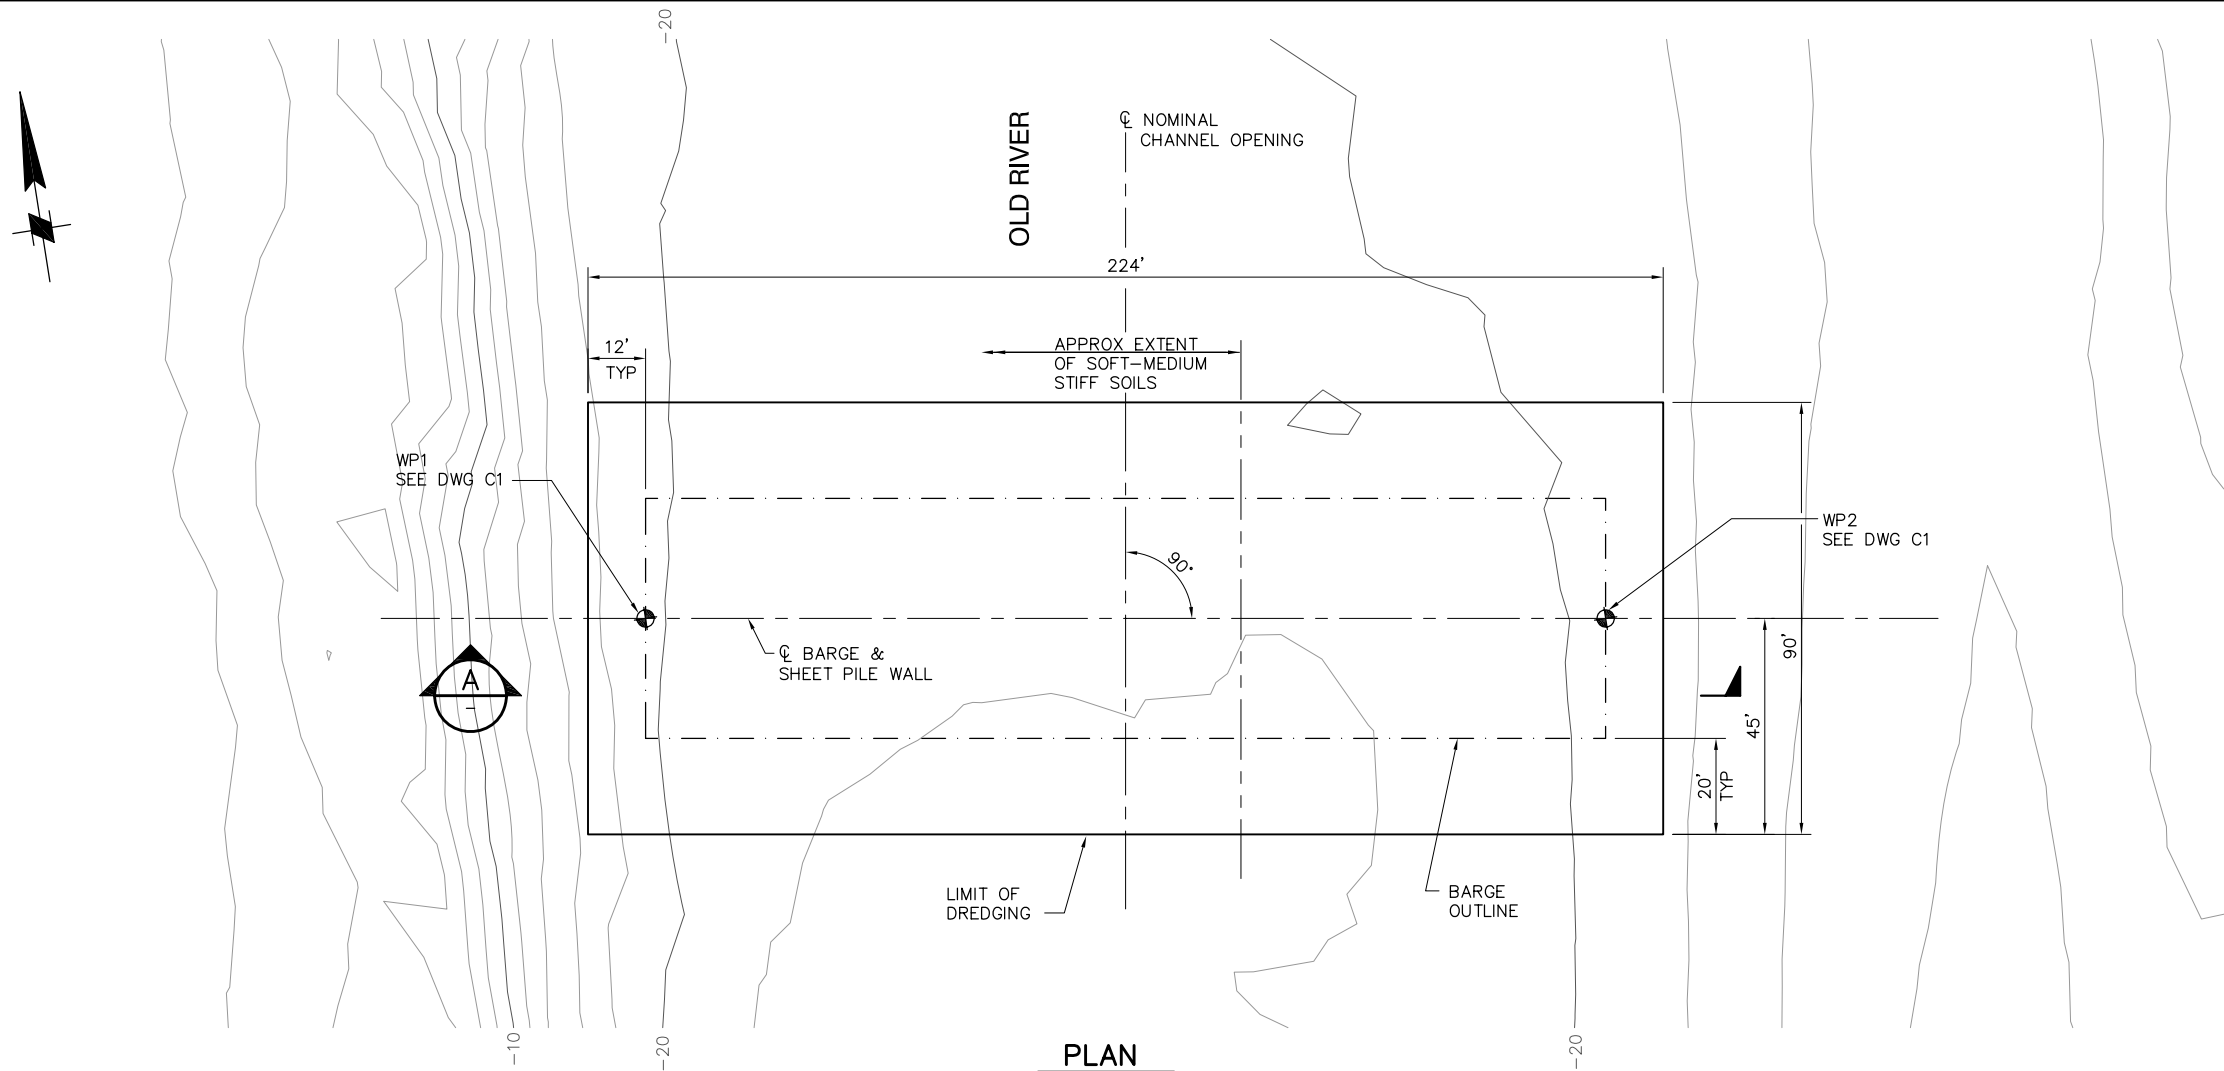

PLAN
SCALE: 1"= 20'

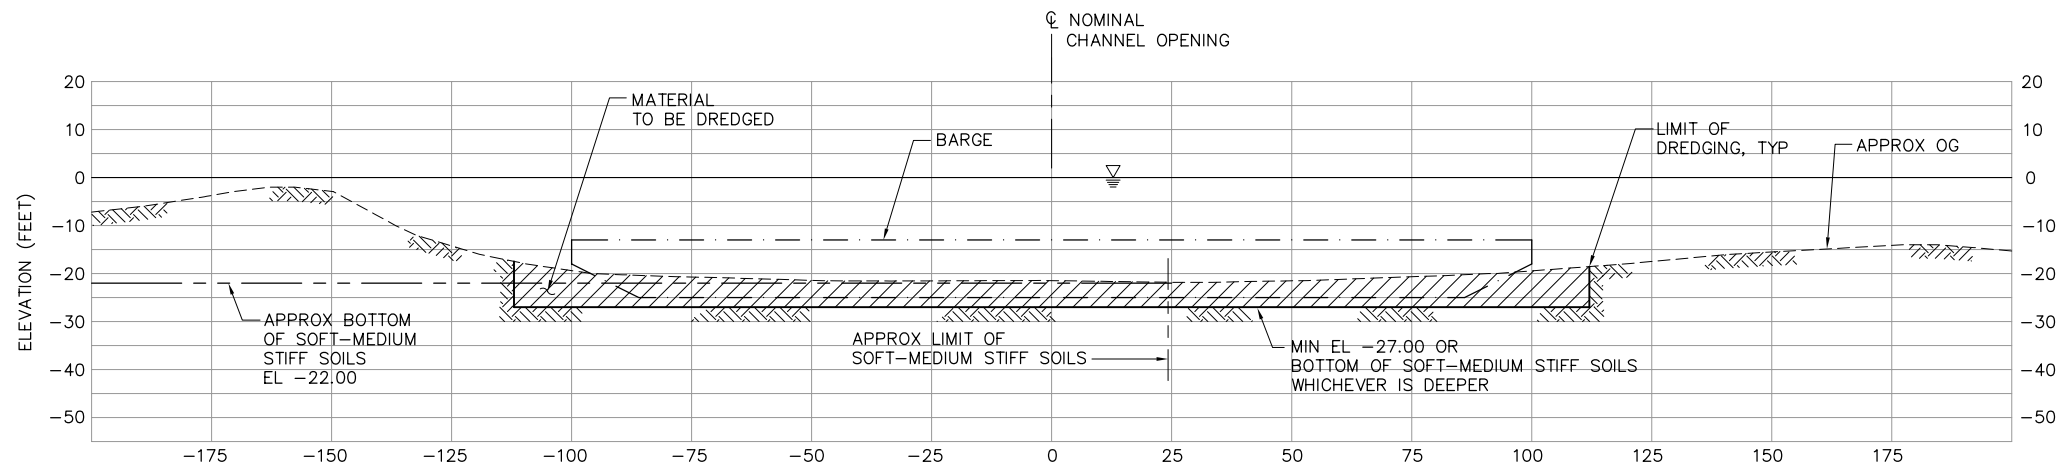

A SECTION
SCALE: 1"=20'

 

SCALE: 1"=20'

95% SUBMITTAL




IF SHEET IS LESS THAN 22" x 34"
IT IS A REDUCED PRINT -
SCALE REDUCED ACCORDINGLY.

NOTE:


GATE AND ALL OTHER FEATURES
NOT SHOWN FOR CLARITY.

REVISION	DESCRIPTION	BY	DATE						TWO GATE FISH PROTECTION PLAN		DATE 08/07/09
											SHEET 6 OF 75
									OLD RIVER DREDGING PLAN AND SECTION		C2
							 2001 N. Main Street, Suite 360 Walnut Creek, California 94596 (925) 944-5411				
							DSGN TDB	DR AB	CHK GTH		
							JOB NO. 6097-03	SUBMITTED BY RMR	TITLE		

P:\6097-03 SWC GATE DESIGN\CADD\DWG\609703-C3.DWG 7/28/2009 1:36 PM

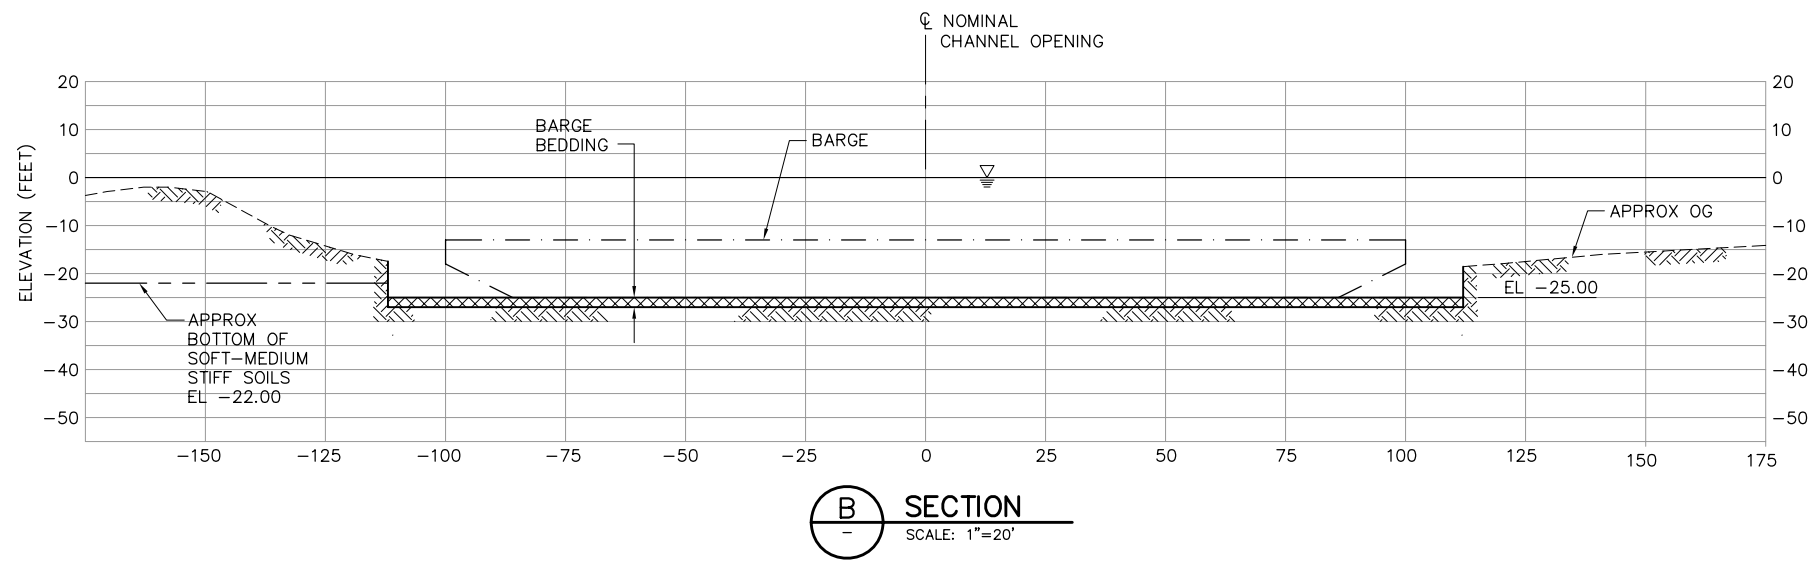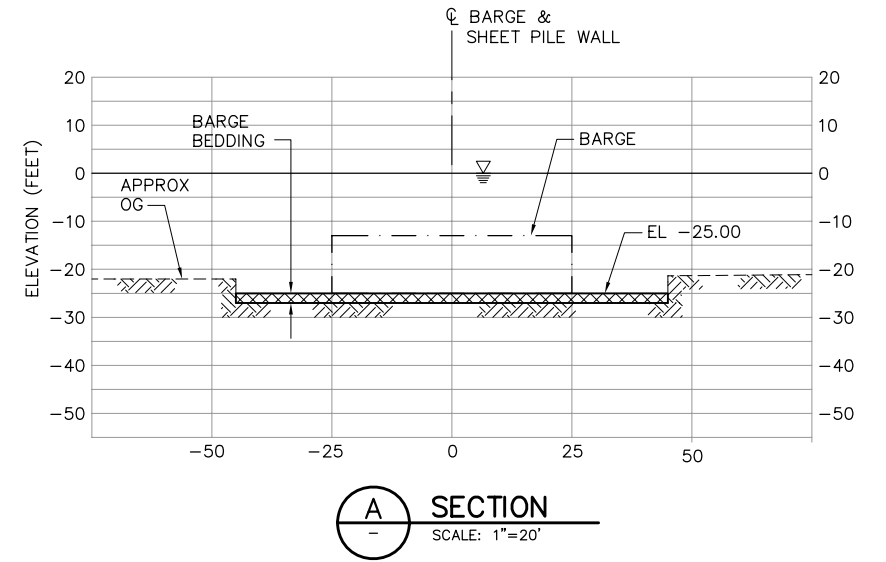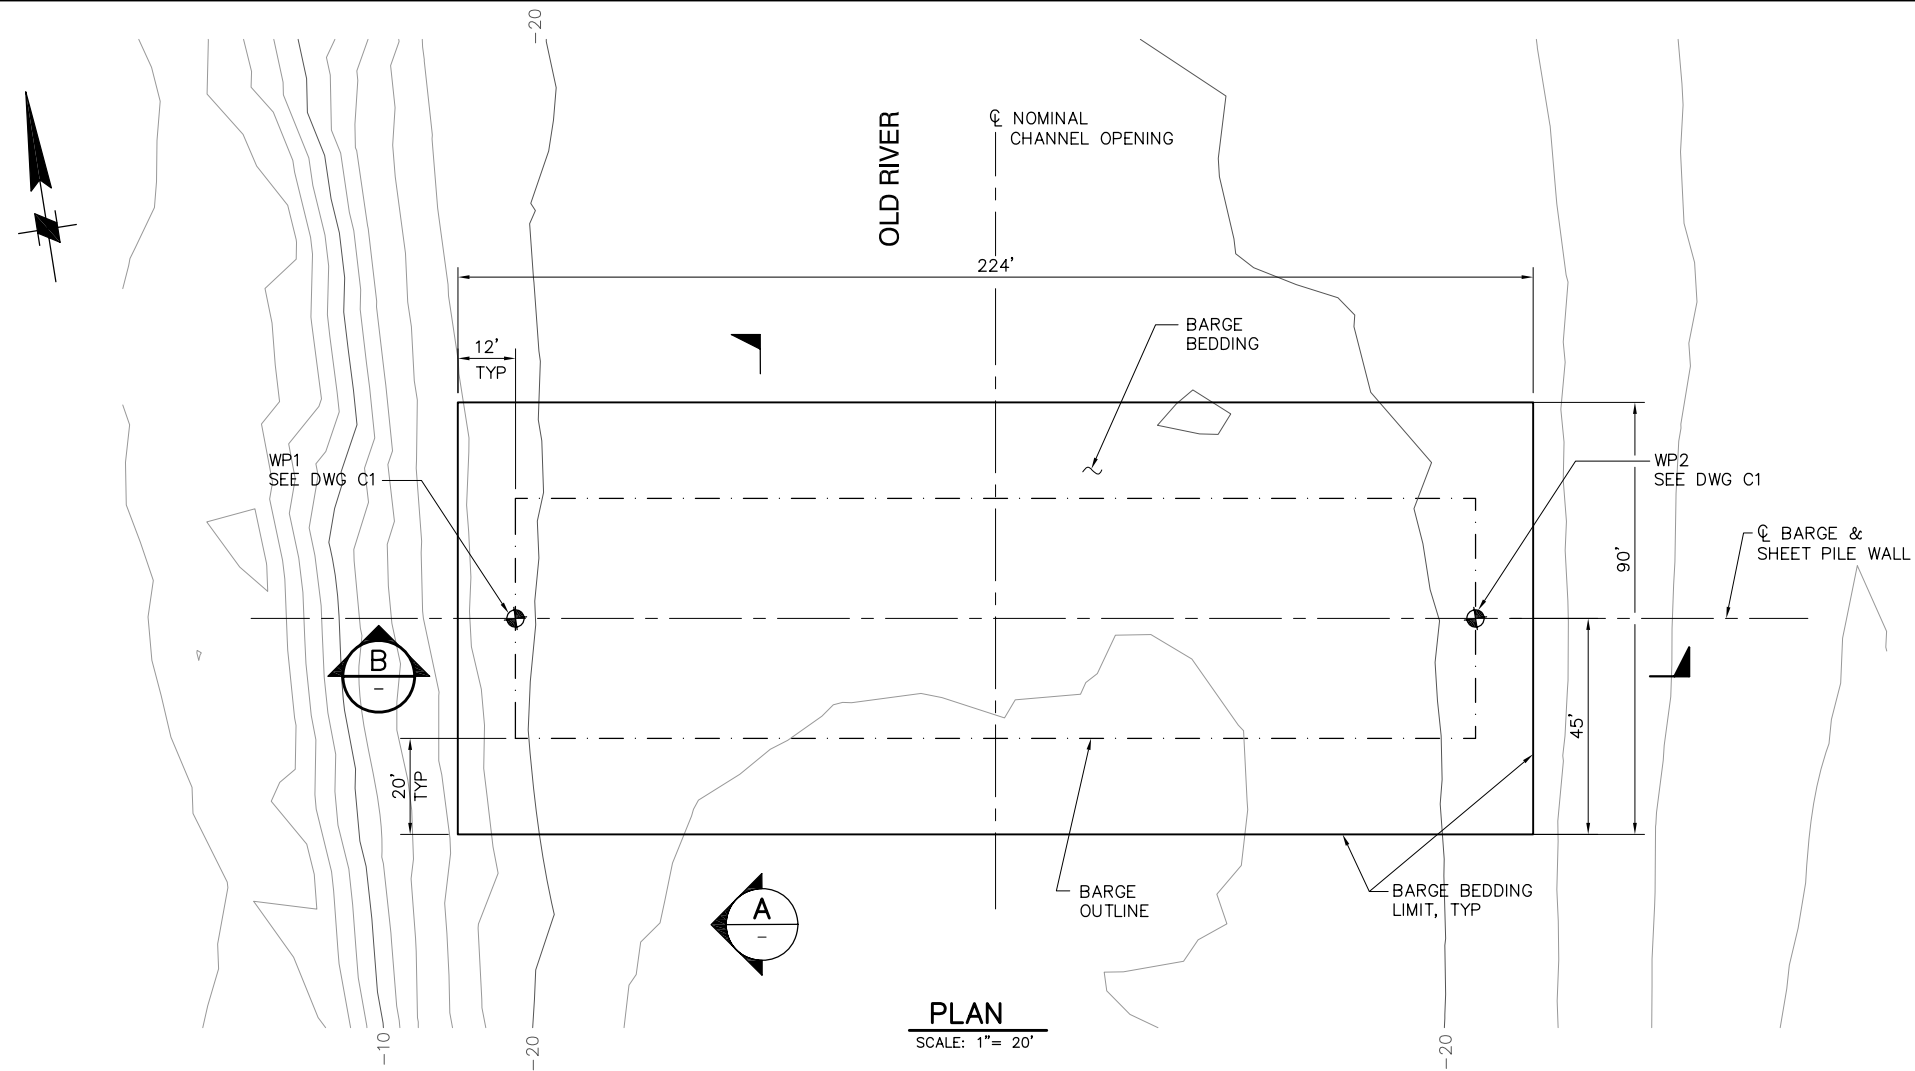


 NOTE:
GATE AND ALL OTHER FEATURES
NOT SHOWN FOR CLARITY.




95% SUBMITTAL IF SHEET IS LESS THAN 22" x 34"
IT IS A REDUCED PRINT -
SCALE REDUCED ACCORDINGLY.

REVISION	DESCRIPTION	BY	DATE				2001 N. Main Street, Suite 360 Walnut Creek, California 94596 (925) 944-5411		TWO GATE FISH PROTECTION PLAN		DATE 08/07/09
							Moffatt & Nichol		OLD RIVER BARGE BEDDING PLAN AND SECTIONS		SHEET 7 OF 75
							DSGN TDB	DR AB	CHK GTH	C3	
							JOB NO. 6097-03	SUBMITTED BY RMR	TITLE		

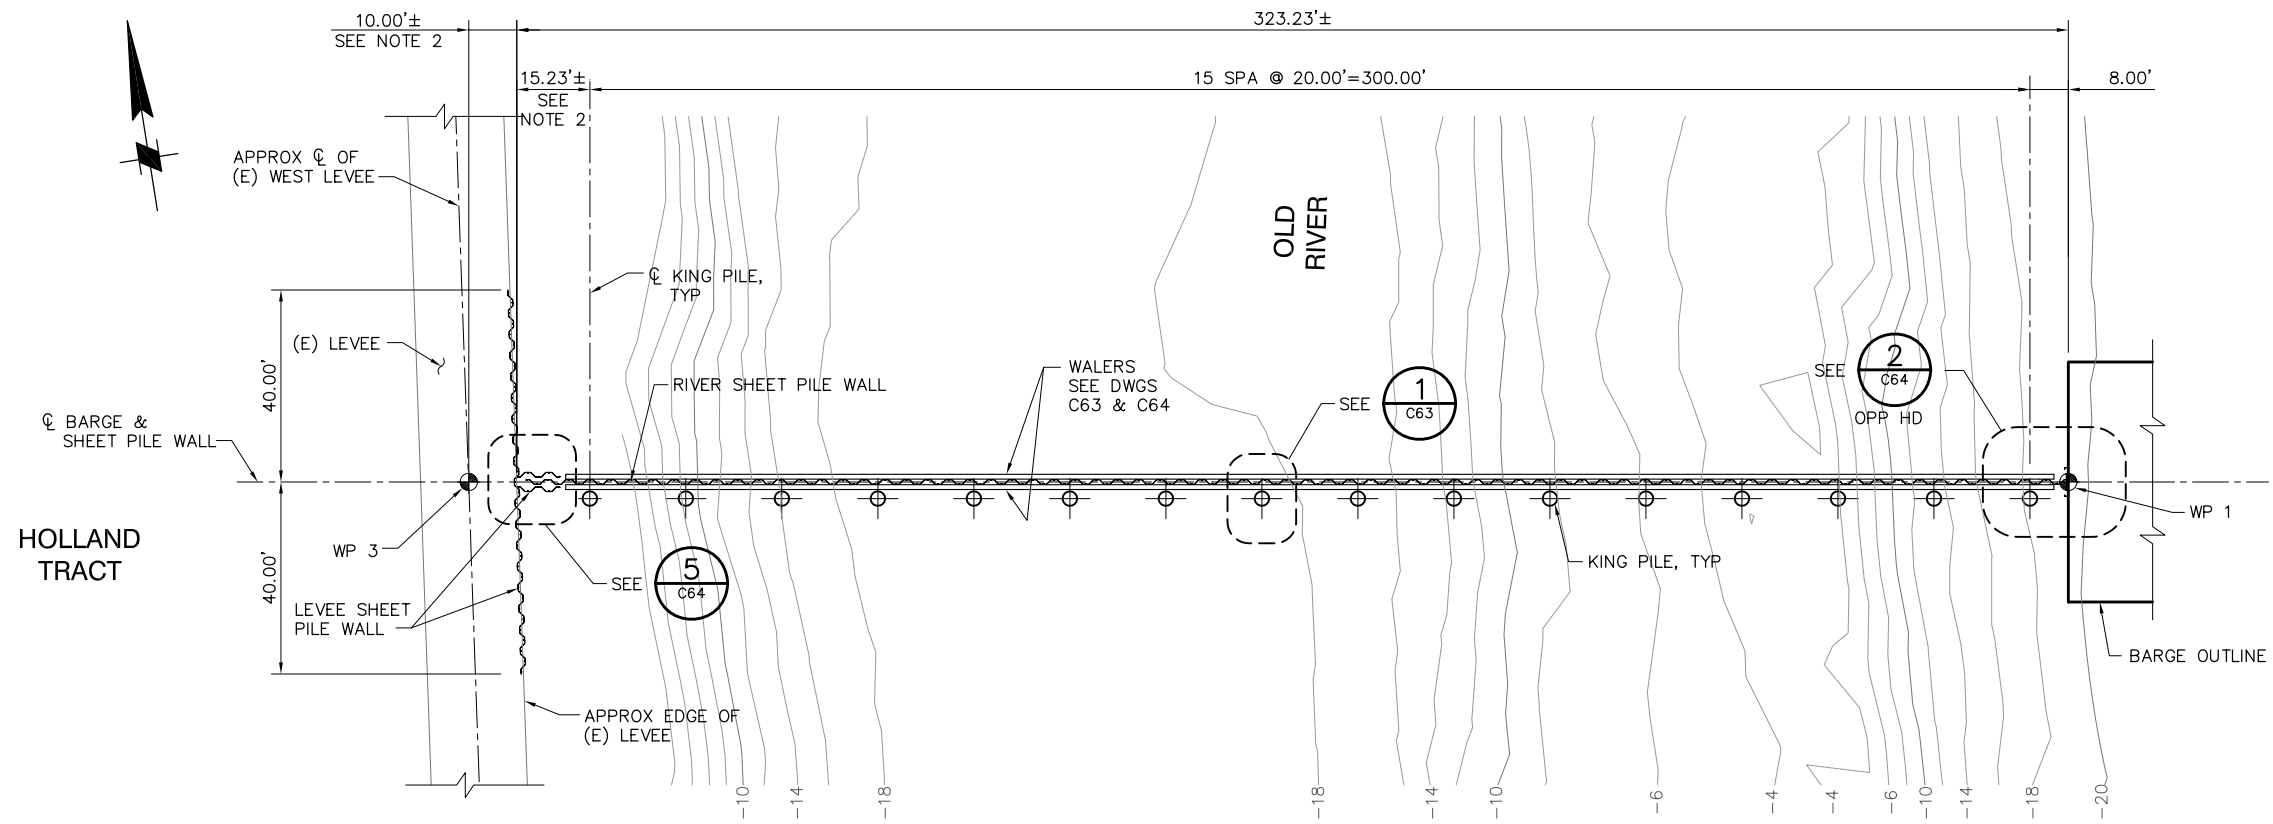


PLAN
SCALE: 1"= 20'

NOTE:
CATWALK NOT SHOWN
FOR CLARITY.

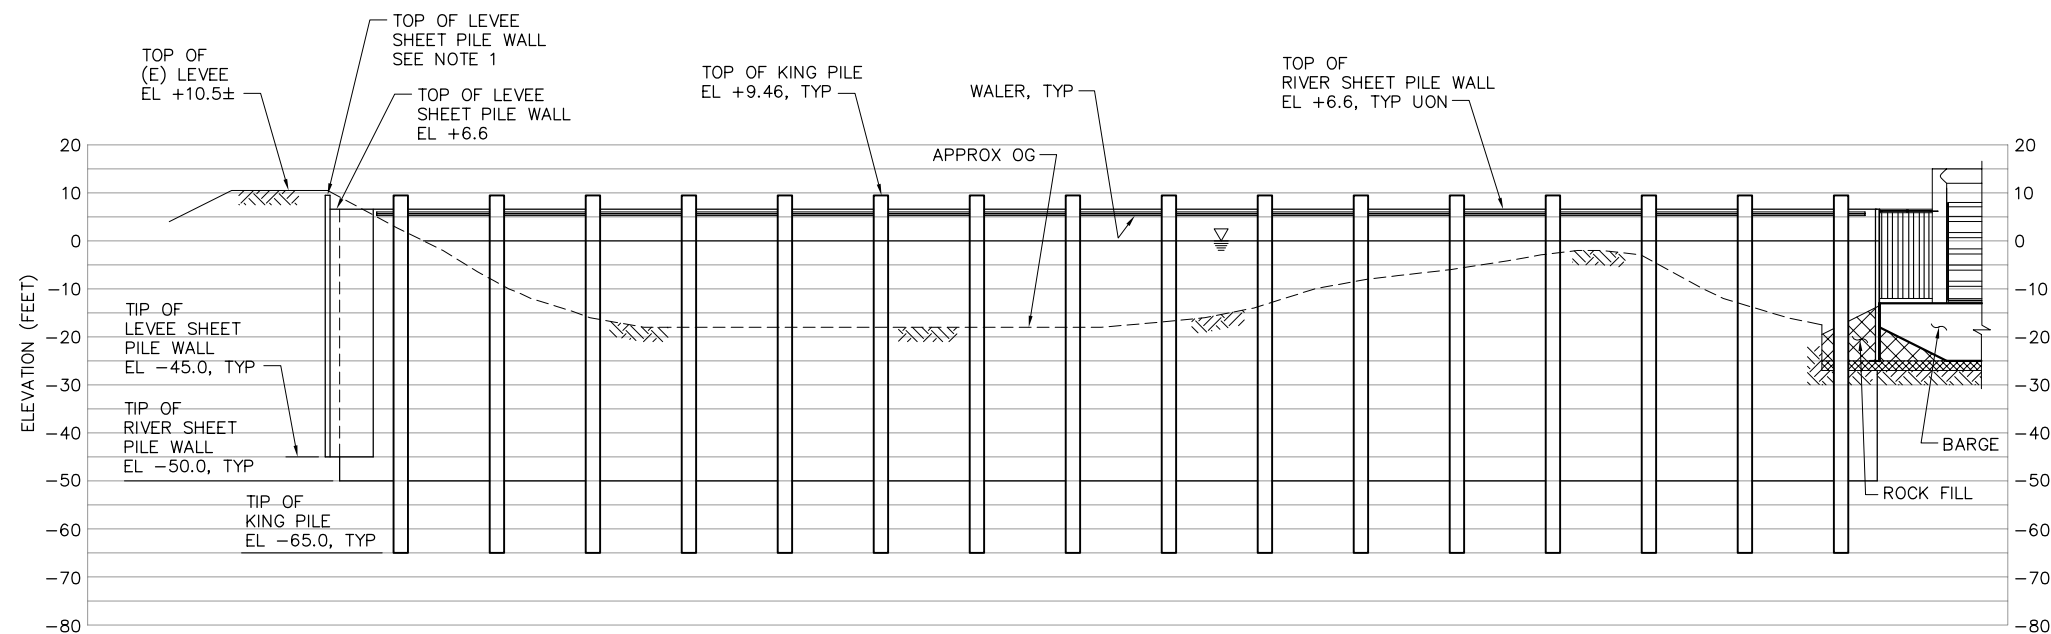

ELEVATION
SCALE: 1"= 20'

 NOTE:
CATWALK NOT SHOWN
FOR CLARITY.



95% SUBMITTAL

IF SHEET IS LESS THAN 22" x 34"
IT IS A REDUCED PRINT -
SCALE REDUCED ACCORDINGLY.

NOTES:

1. TOP OF LEVEE SHEET PILE WALL SHALL BE 6" BELOW TOP OF (E) LEVEE UON.
2. LEVEE SHEET PILE WALL TO BE LOCATED 1 FT MIN OFF THE EDGE OF (E) ROAD SURFACE.



P:\6097-03 SWC GATE DESIGN\CADD\DWG\609703-C5.DWG 7/28/2009 10:38 AM

REVISION	DESCRIPTION	BY	DATE

 Moffatt & Nichol		2001 N. Main Street, Suite 360 Walnut Creek, California 94596 (925) 944-5411	
DSGN	JMB	DR	EP
JOB NO.	6097-03	SUBMITTED BY	RMR
CHK	TDB	TITLE	


TWO GATE FISH PROTECTION PLAN	
OLD RIVER SHEET PILE WALL ARRANGEMENT PLAN AND ELEVATION, SHEET 1	

DATE	08/07/09
SHEET	9 OF 75
C5	

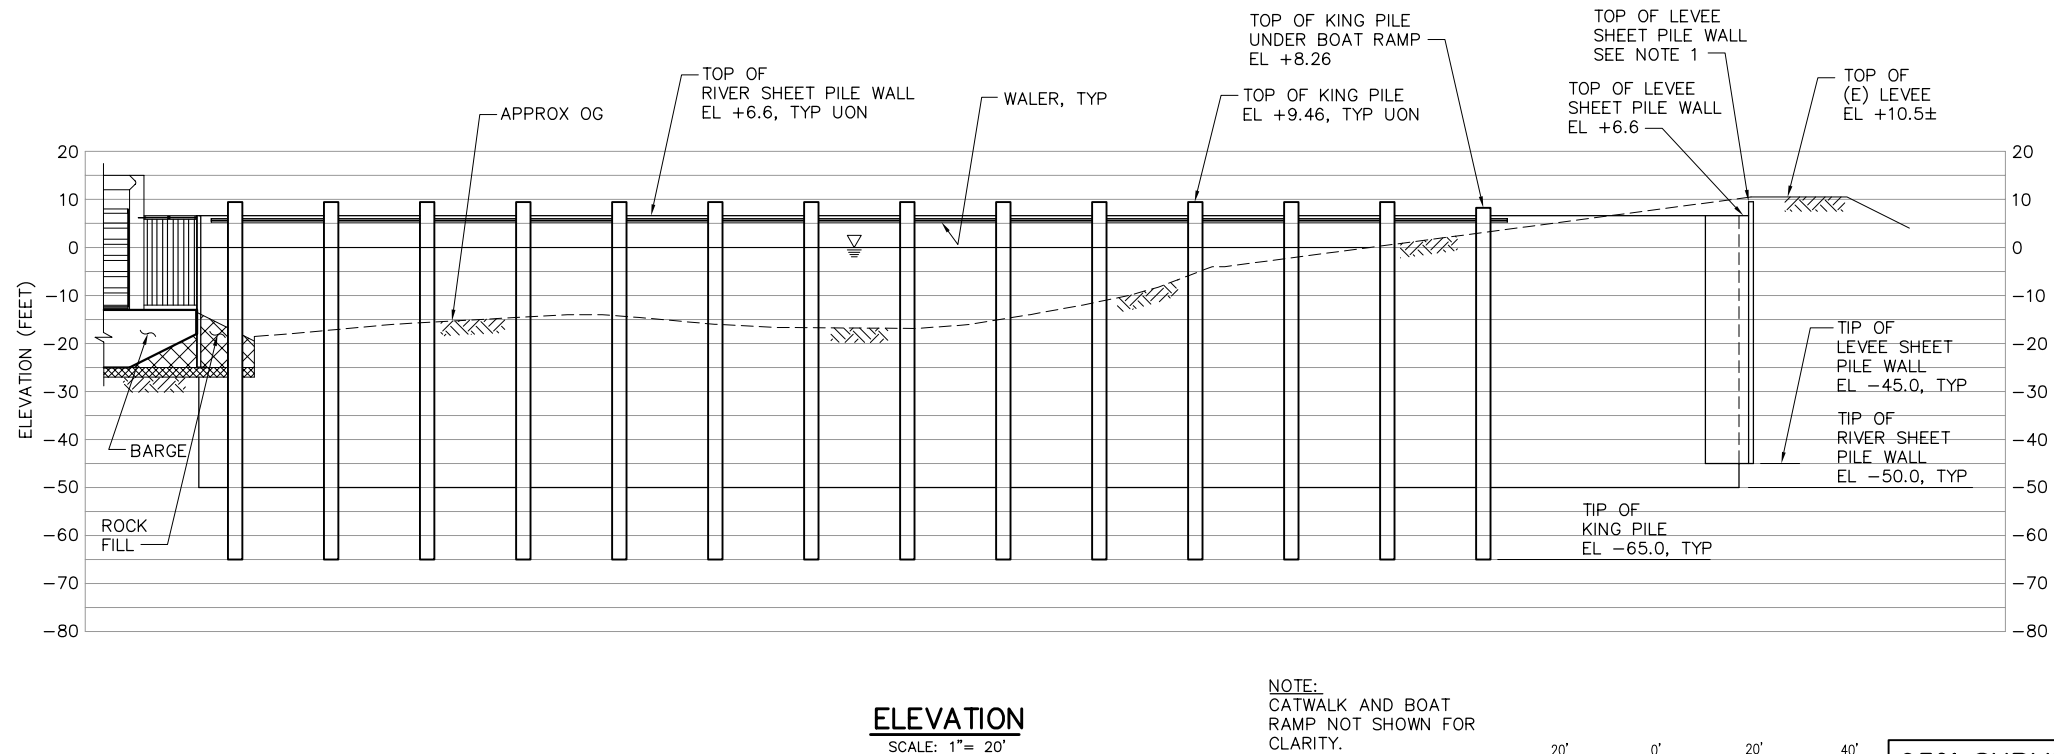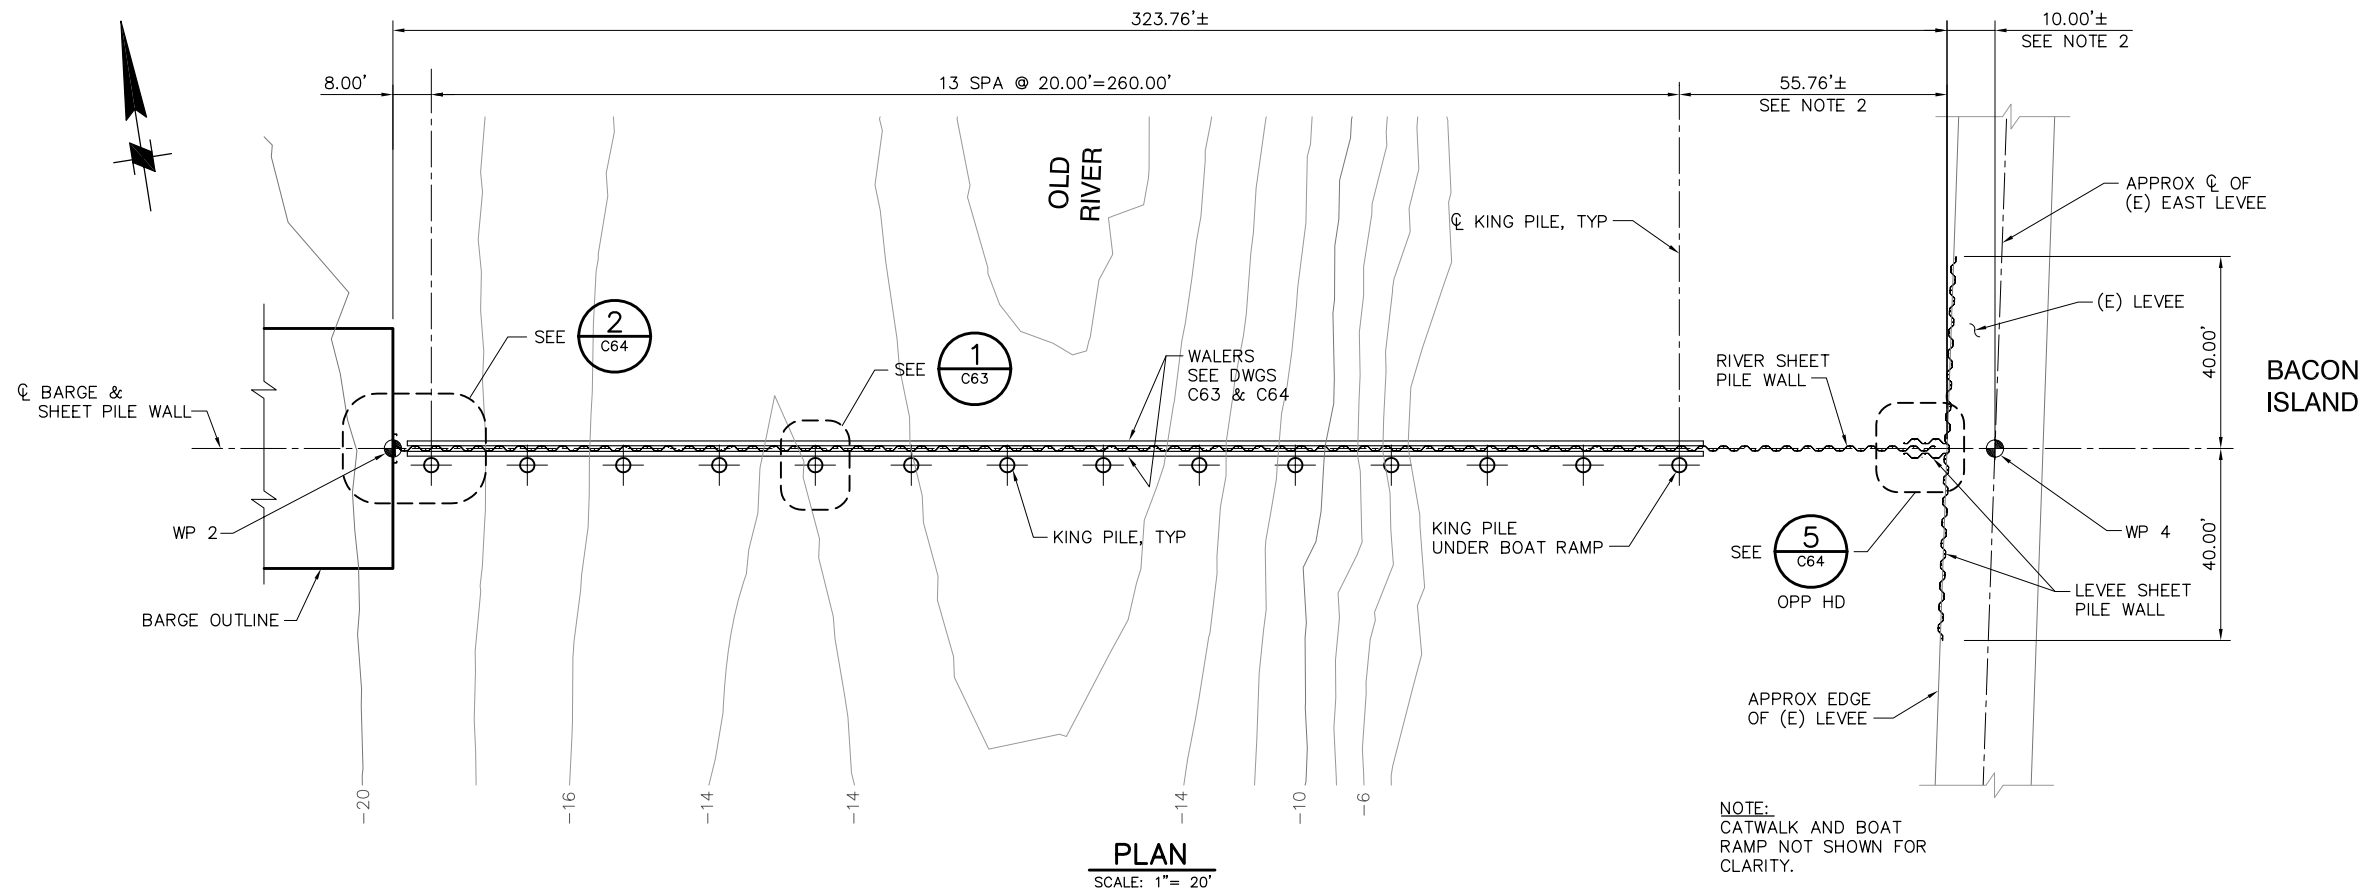

NOTES:

 1. TOP OF LEVEE SHEET PILE WALL SHALL BE 6" BELOW TOP OF (E) LEVEE UON.
2. LEVEE SHEET PILE WALL TO BE LOCATED 1 FT MIN OFF THE EDGE OF (E) ROAD SURFACE.



95% SUBMITTAL



IF SHEET IS LESS THAN 22" x 34"
IT IS A REDUCED PRINT -
SCALE REDUCED ACCORDINGLY.

REVISION	DESCRIPTION	BY	DATE

 Moffatt & Nichol		2001 N. Main Street, Suite 360 Walnut Creek, California 94596 (925) 944-5411	
DSGN	JMB	DR	EP
JOB NO.	6097-03	SUBMITTED BY	RMR
CHK	TDB	TITLE	

TWO GATE FISH PROTECTION PLAN		DATE 08/07/09
OLD RIVER SHEET PILE WALL ARRANGEMENT PLAN AND ELEVATION, SHEET 2		SHEET 10 OF 75
		C6

 P:\6097-03 SWC GATE DESIGN\CADD\DWG\609703-C7.1.DWG 8/6/2009 9:33 AM

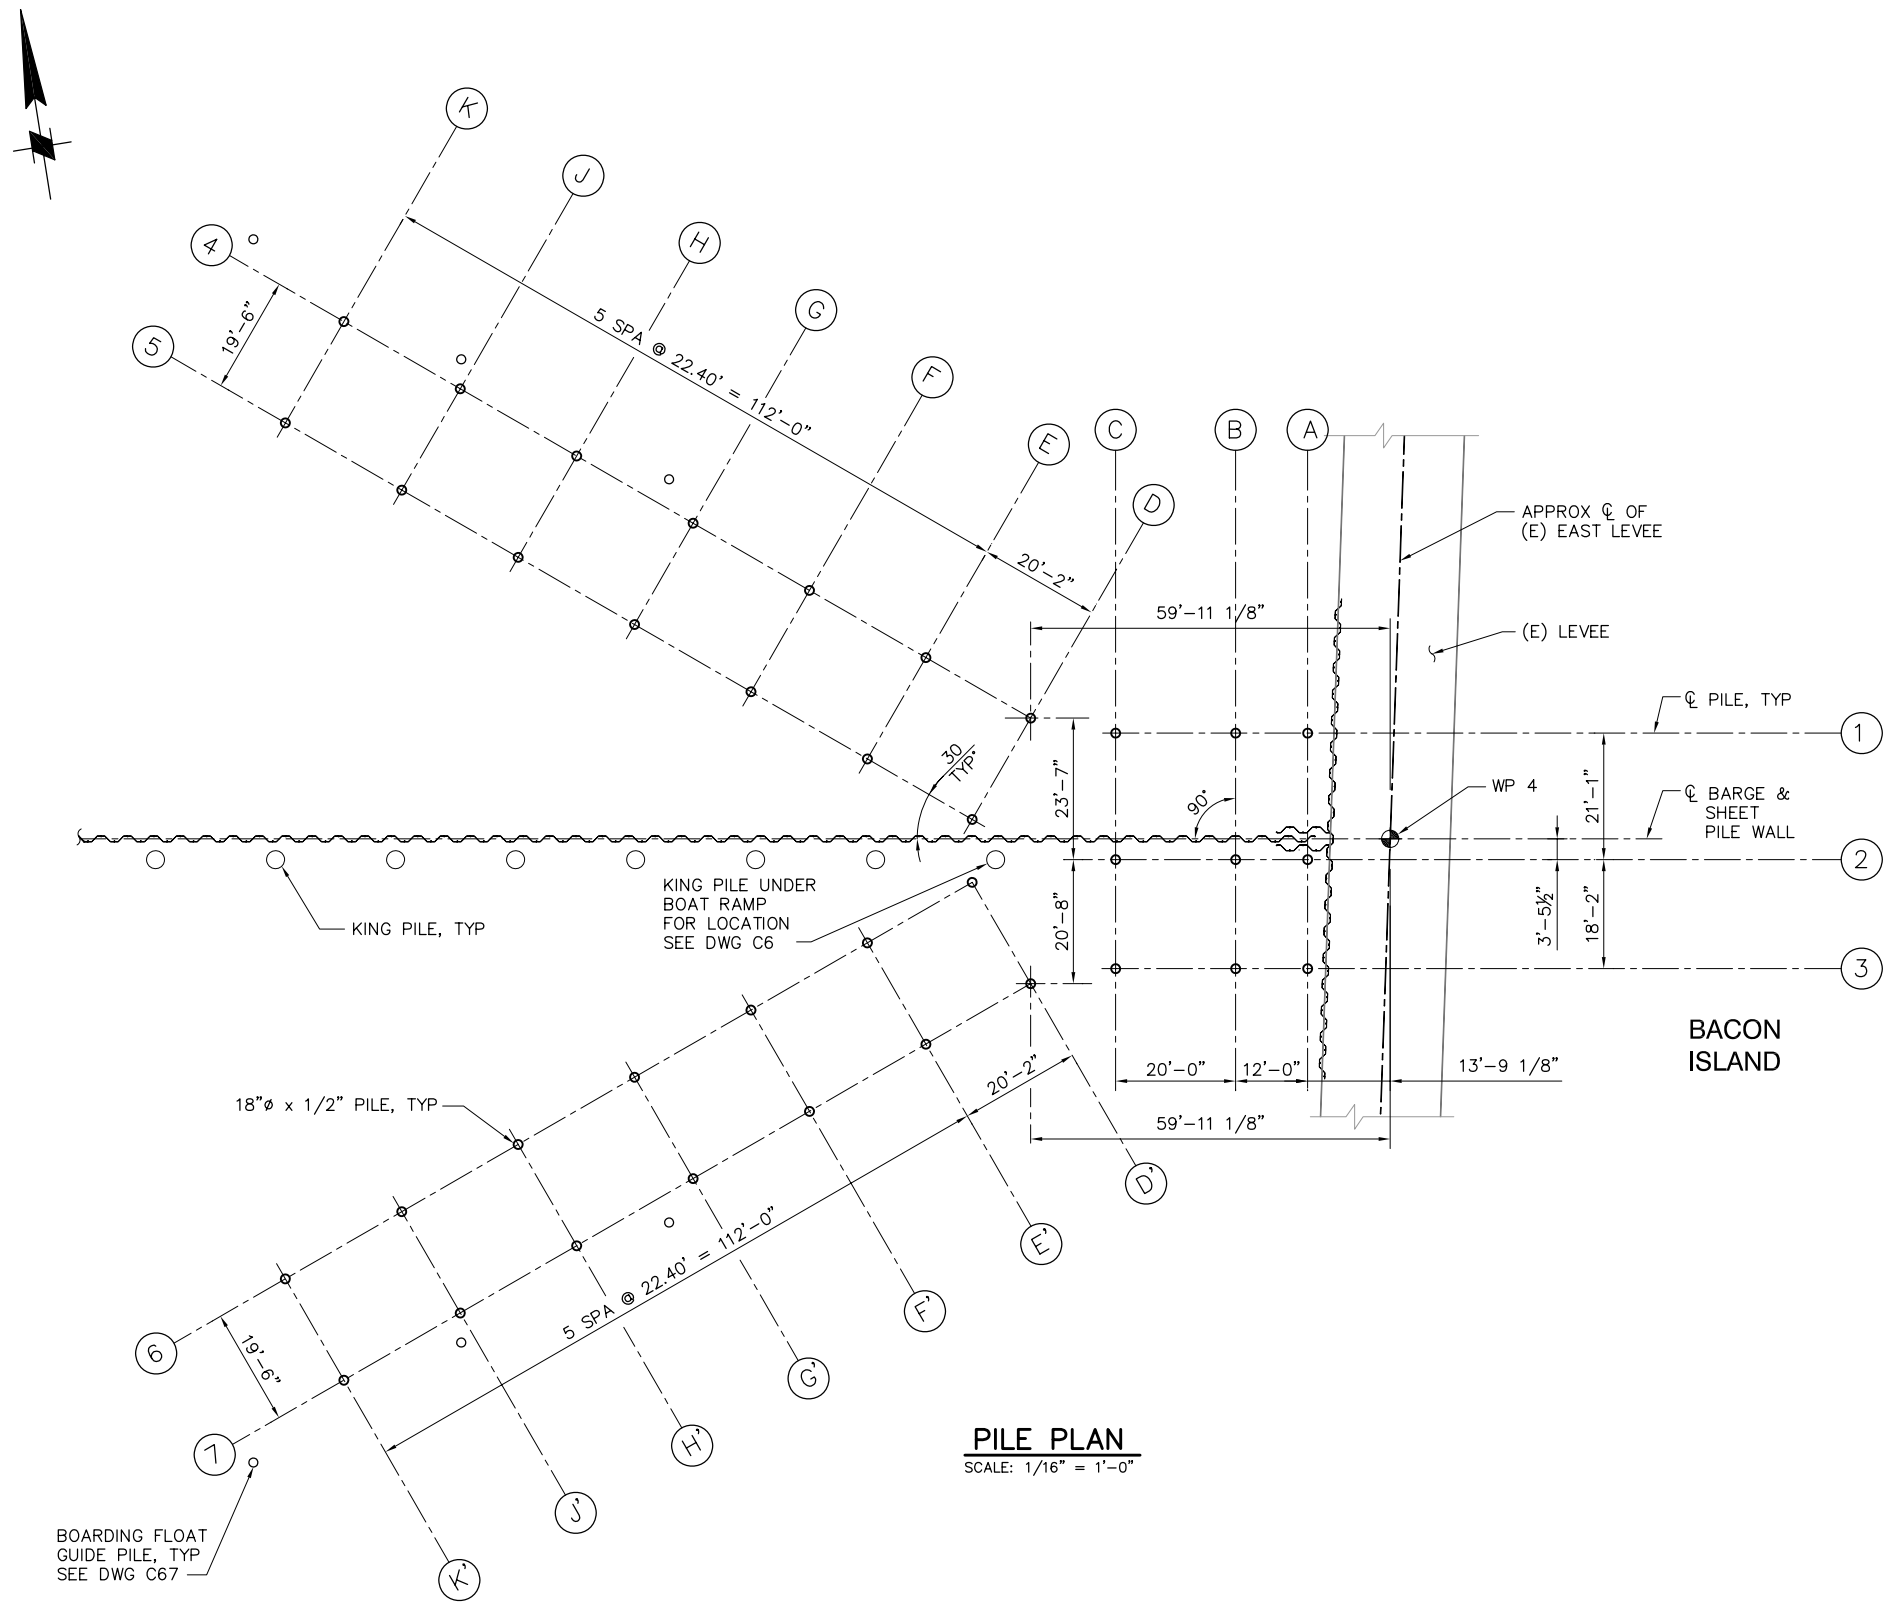

95% SUBMITTAL

IF SHEET IS LESS THAN 22" x 34"
IT IS A REDUCED PRINT -
SCALE REDUCED ACCORDINGLY.


REVISION	DESCRIPTION	BY	DATE

 Moffatt & Nichol		2001 N. Main Street, Suite 360 Walnut Creek, California 94596 (925) 944-5411	
DSGN	JMB	DR	EP
JOB NO.	6097-03	SUBMITTED BY	RMR
CHK	TDB	TITLE	

TWO GATE FISH PROTECTION PLAN	
OLD RIVER BOAT RAMP PILE PLAN	

DATE 08/07/09
SHEET 12 OF 75
C7.1

P:\6097-03 SWC GATE DESIGN\CADD\DWG\609703-C7.2.DWG 8/5/2009 10:22 AM

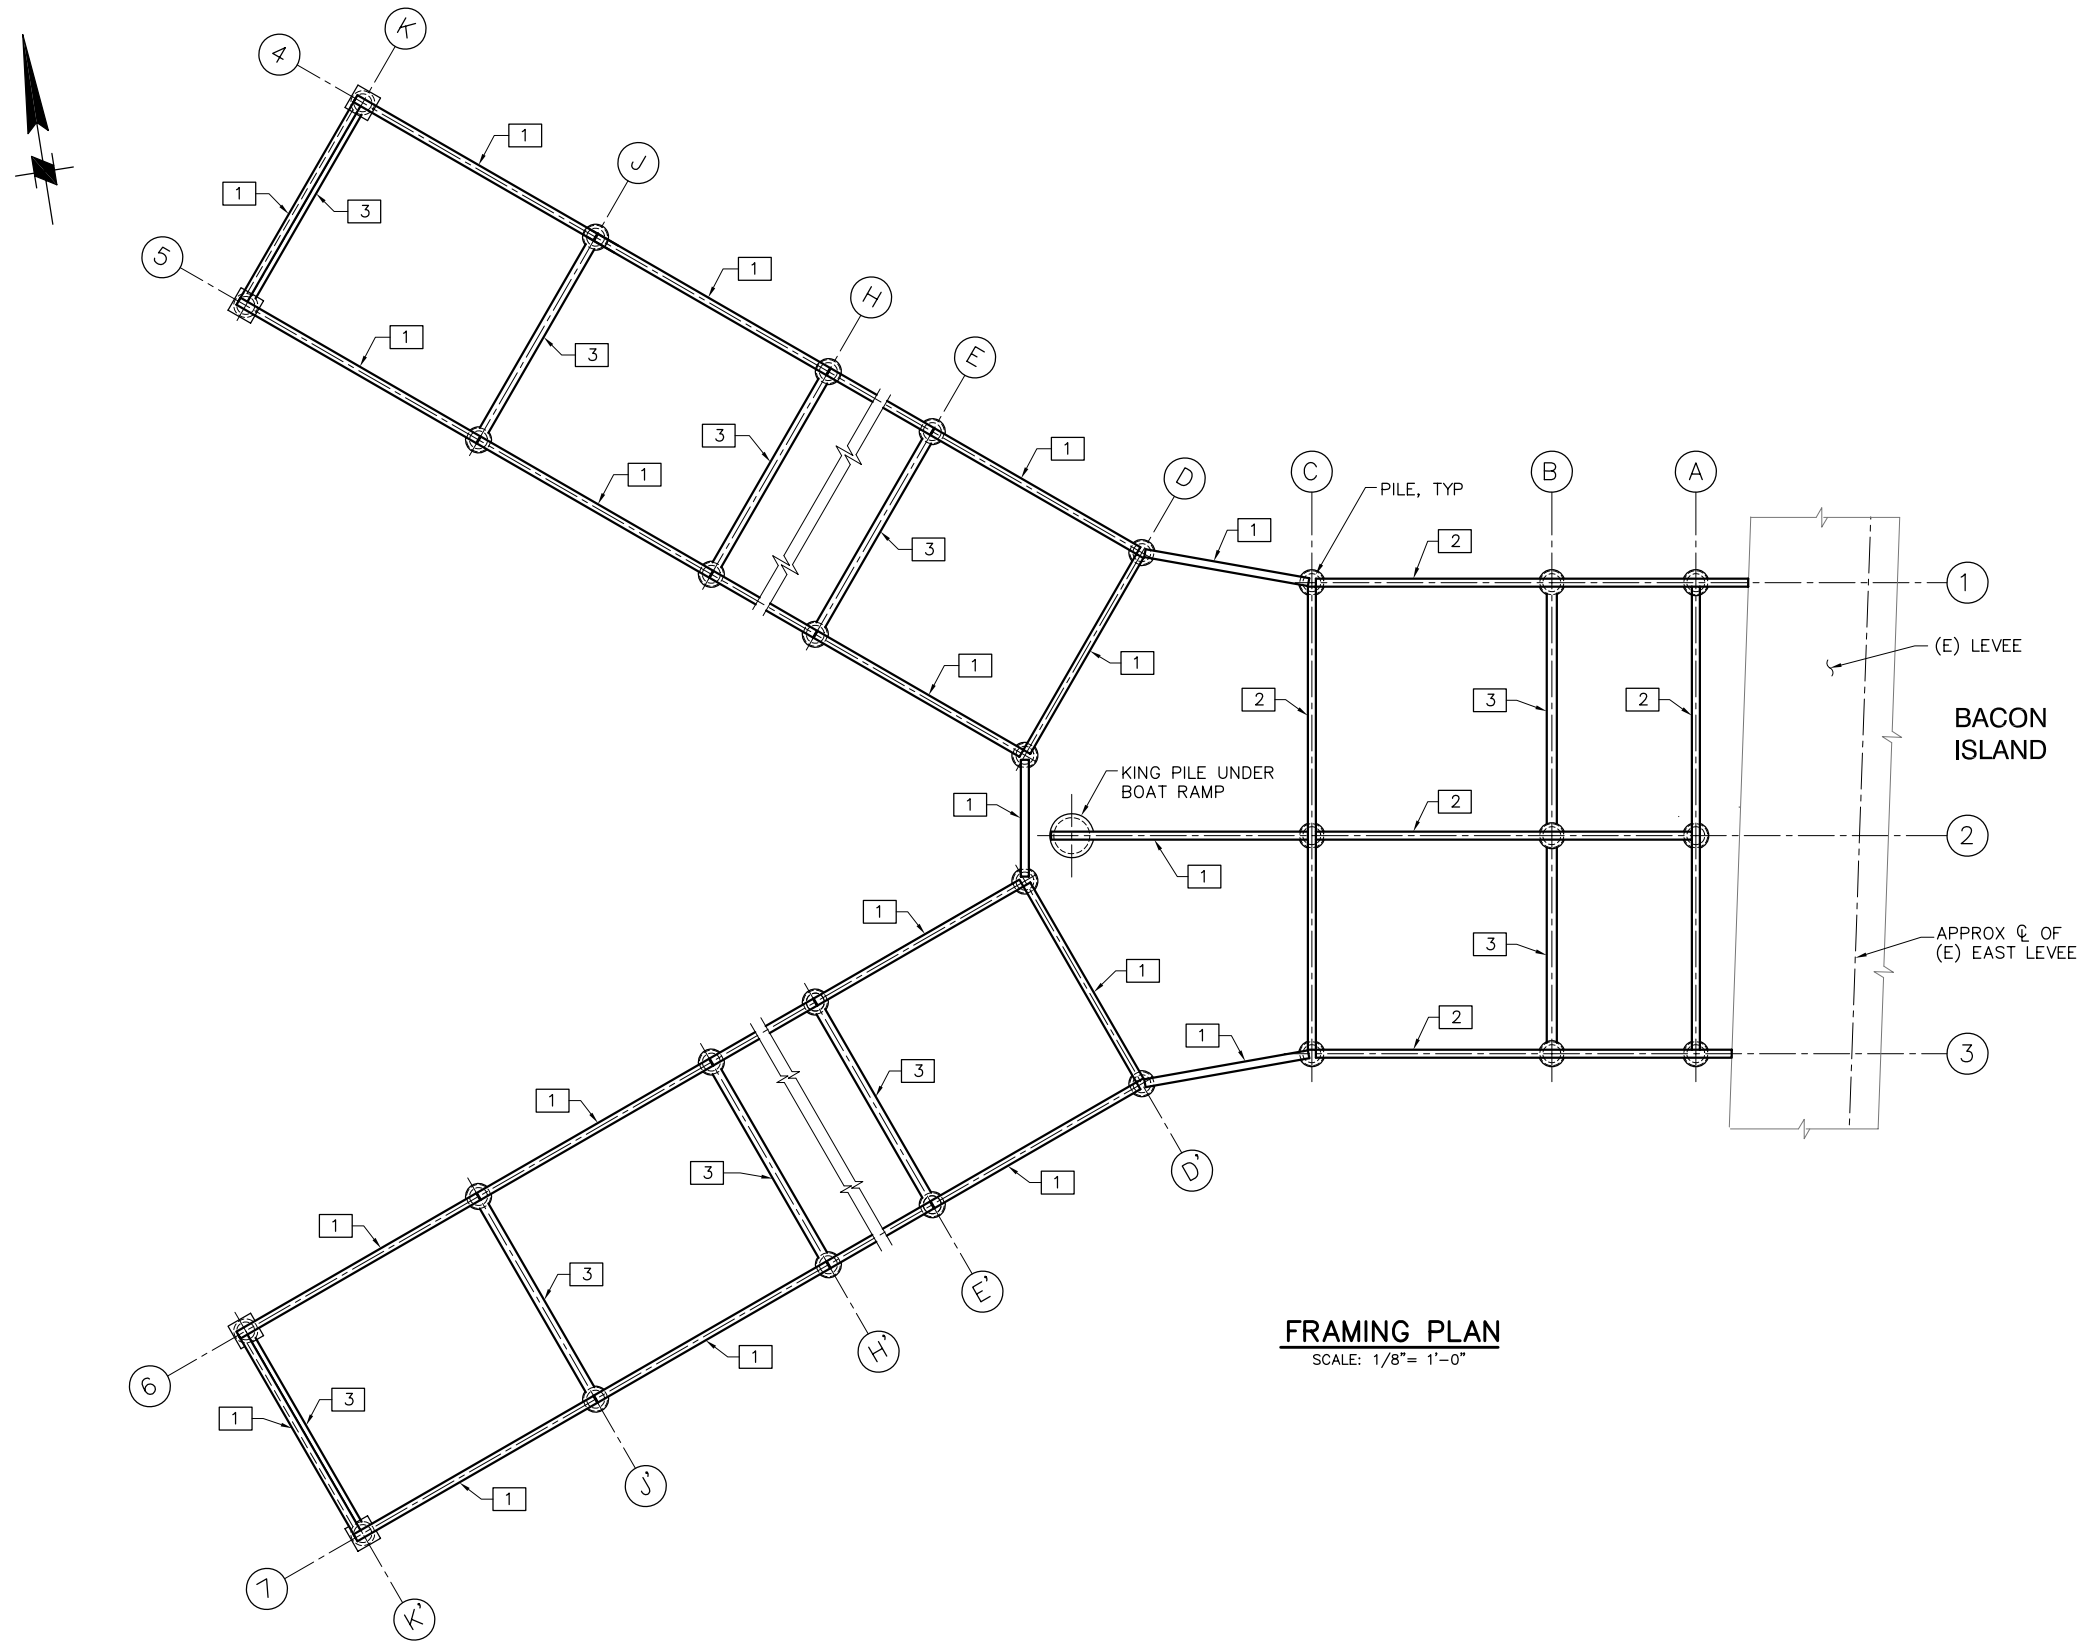


FRAMING PLAN
SCALE: 1/8"= 1'-0"

LEGEND:

- 1 HSS 16x8x1/2
- 2 HSS 16x8x1/2 CONTINUOUS THRU SUPPORT
- 3 10"Ø XSTRONG PIPE TRANSVERSE "CAP" BEAM

NOTE:

 LEVEE SHEET PILE WALL, RIVER SHEET PILE WALL AND KING PILES NOT SHOWN FOR CLARITY.



95% SUBMITTAL

IF SHEET IS LESS THAN 22" x 34"
IT IS A REDUCED PRINT -
SCALE REDUCED ACCORDINGLY.



REVISION	DESCRIPTION	BY	DATE

 Moffatt & Nichol		2001 N. Main Street, Suite 360 Walnut Creek, California 94596 (925) 944-5411	
DSGN	JMB	DR	EP
JOB NO.	6097-03	SUBMITTED BY	RMR
CHK	TDB	TITLE	

TWO GATE FISH PROTECTION PLAN
OLD RIVER BOAT RAMP FRAMING PLAN


DATE 08/07/09
SHEET 13 OF 75
C7.2

P:\6097-03 SWC GATE DESIGN\CADD\DWG\609703-C7.DWG 8/5/2009 10:14 AM

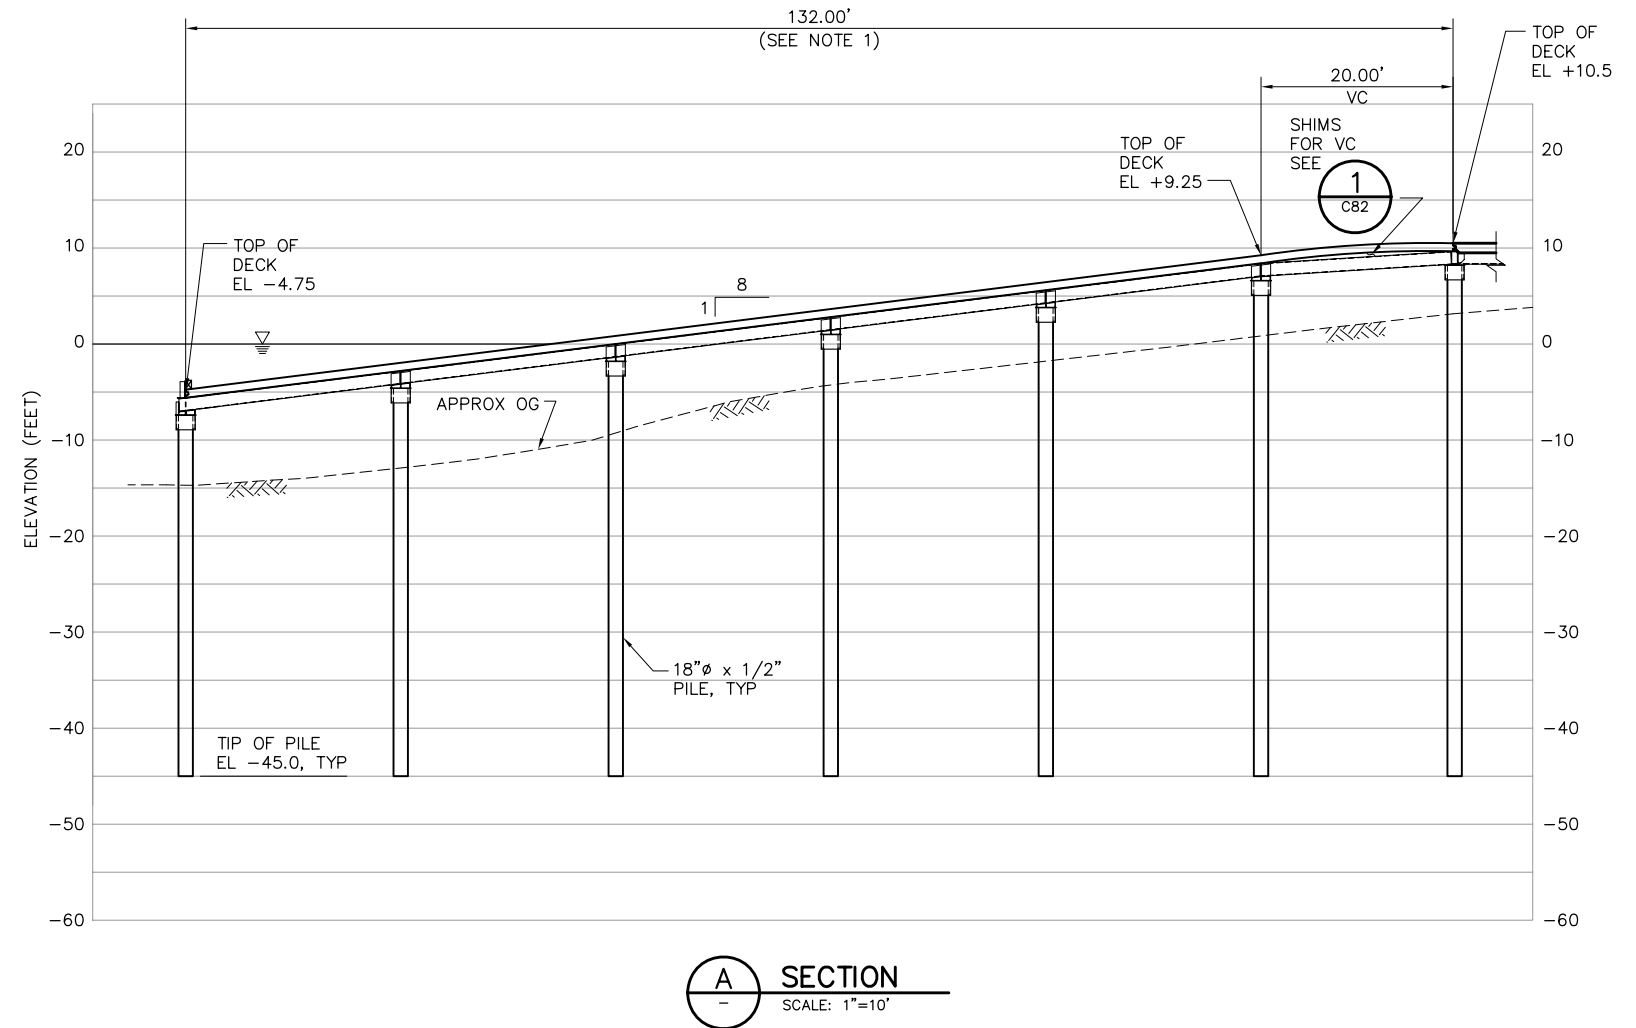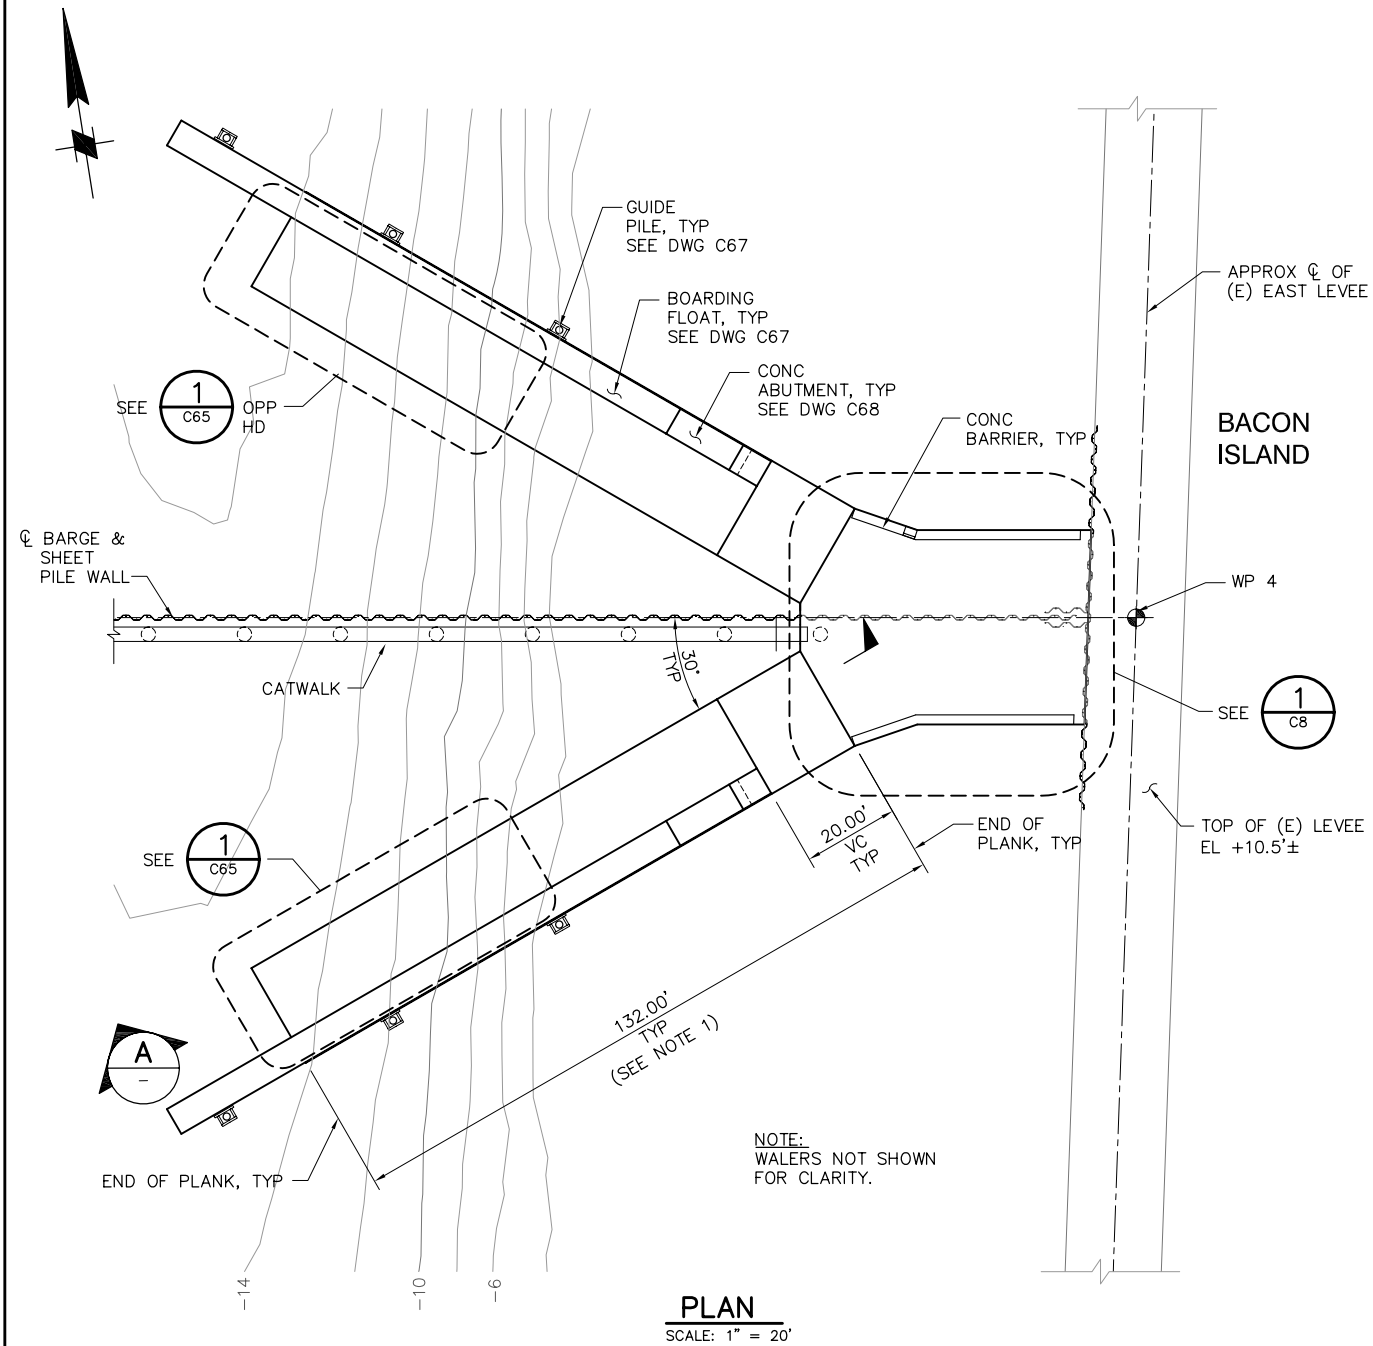

NOTES:

1. TRUE LENGTH OF RAMP ACCOUNTS FOR AN AVERAGE GAP OF 3/8" PER PLANK JOINT.

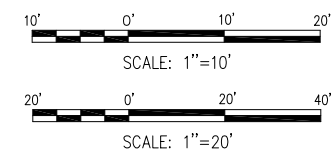

95% SUBMITTAL


IF SHEET IS LESS THAN 22" x 34"
IT IS A REDUCED PRINT -
SCALE REDUCED ACCORDINGLY.

REVISION	DESCRIPTION	BY	DATE

 2001 N. Main Street, Suite 360 Walnut Creek, California 94596 (925) 944-5411			
DSGN	JMB	DR	EP
JOB NO.	6097-03	SUBMITTED BY	RMR
CHK	TDB	TITLE	

TWO GATE FISH PROTECTION PLAN		DATE	08/07/09
OLD RIVER BOAT RAMP PLAN AND SECTION		SHEET	11 OF 75
			C7

P:\6097-03 SWC GATE DESIGN\CADD\DWG\609703-C8.DWG 8/5/2009 3:52 PM

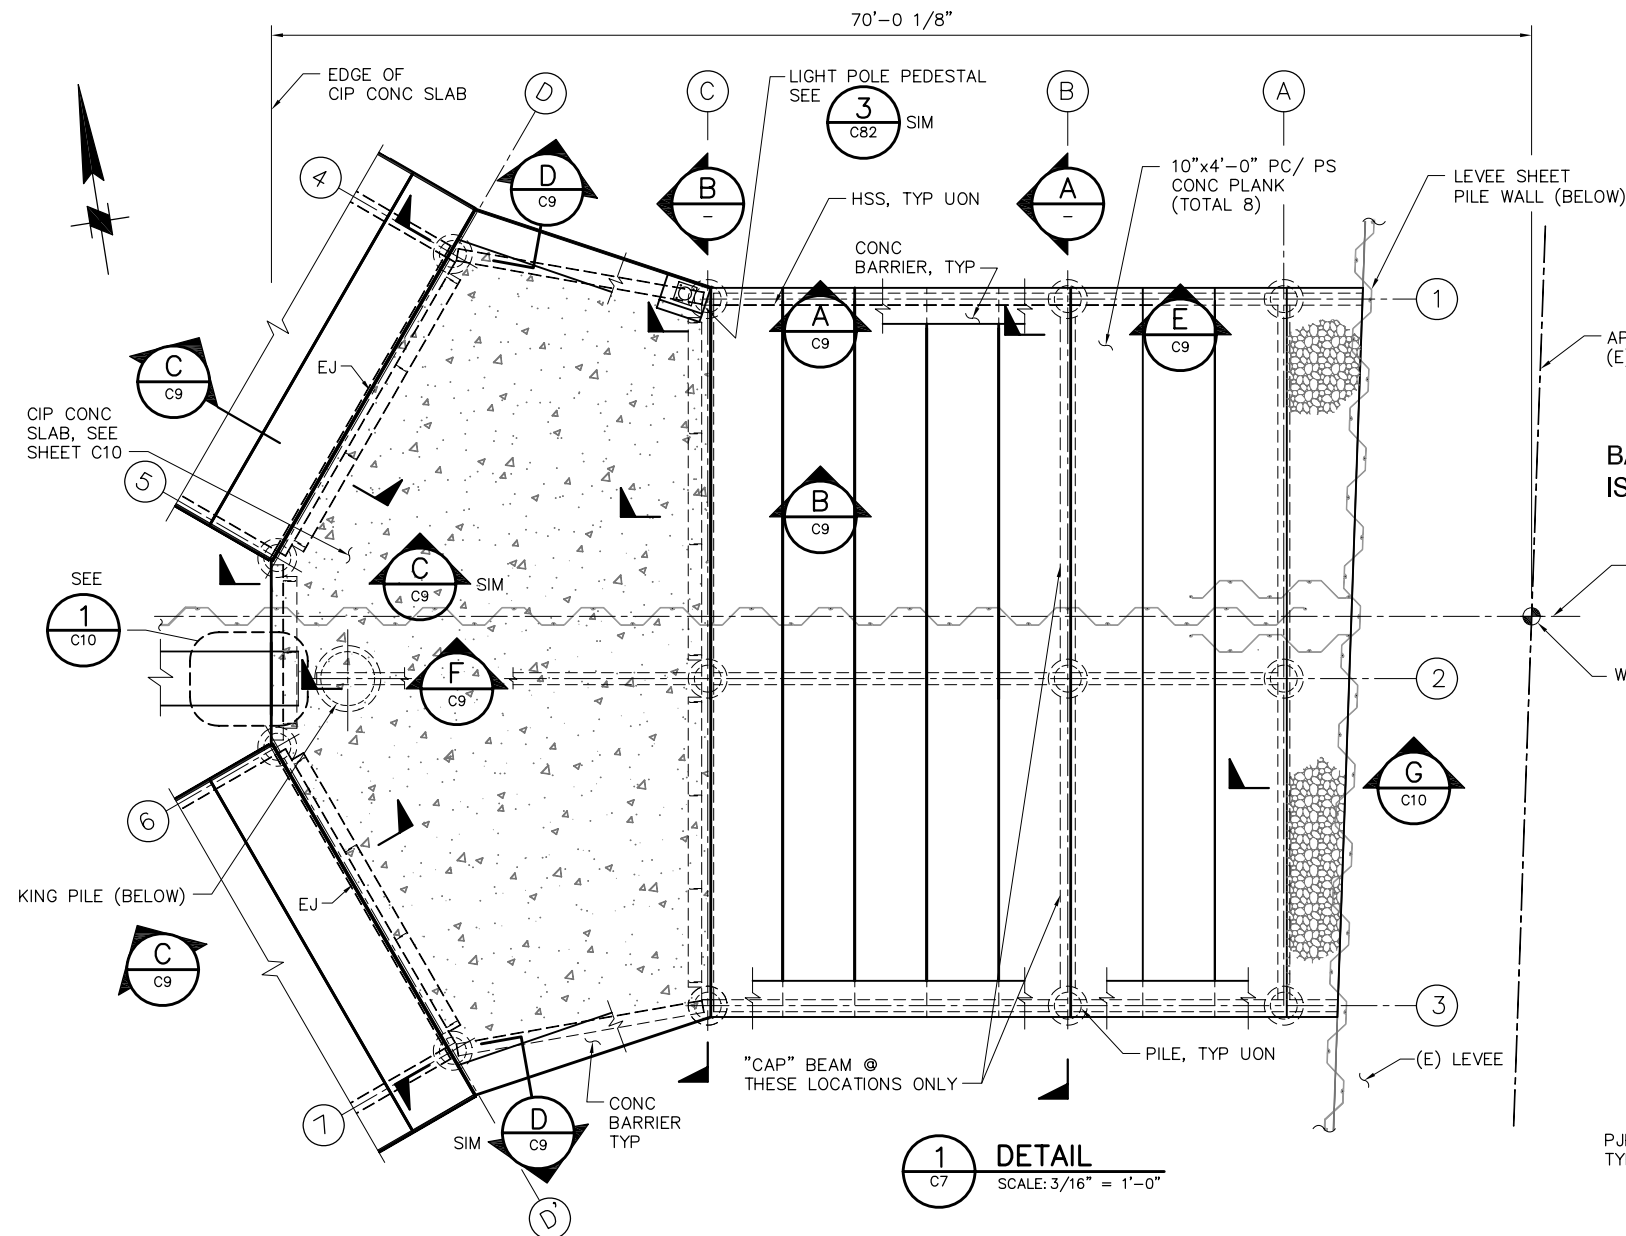

BACON
ISLAND


APPROX ϕ OF
(E) LEVEE

ϕ BARGE &
SHEET PILE
WALL

WP 4


NOTES:

1. ALL PC/PS PLANKS SHALL BEAR ON/AGAINST NEOPRENE "UNDERLAYMENT" BEARING STRIP WITH A MINIMUM 1/8" THICKNESS.

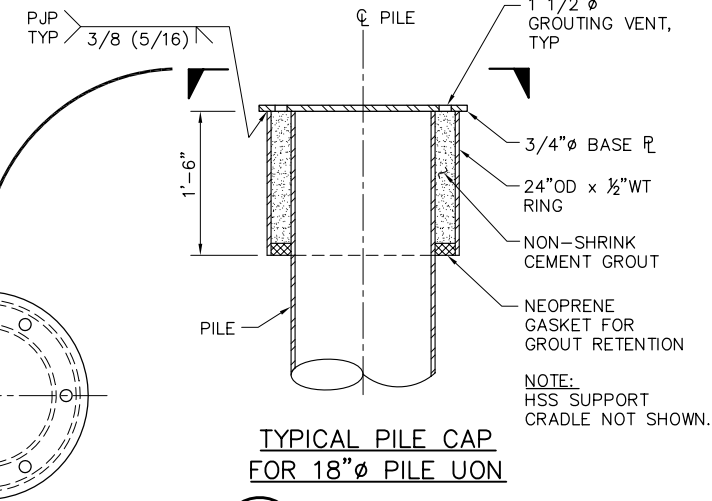

2 DETAIL
SCALE: 1" = 1'-0"


1'-0" 0'-0" 1'-0" 2'-0"
SCALE: 1" = 1'-0"

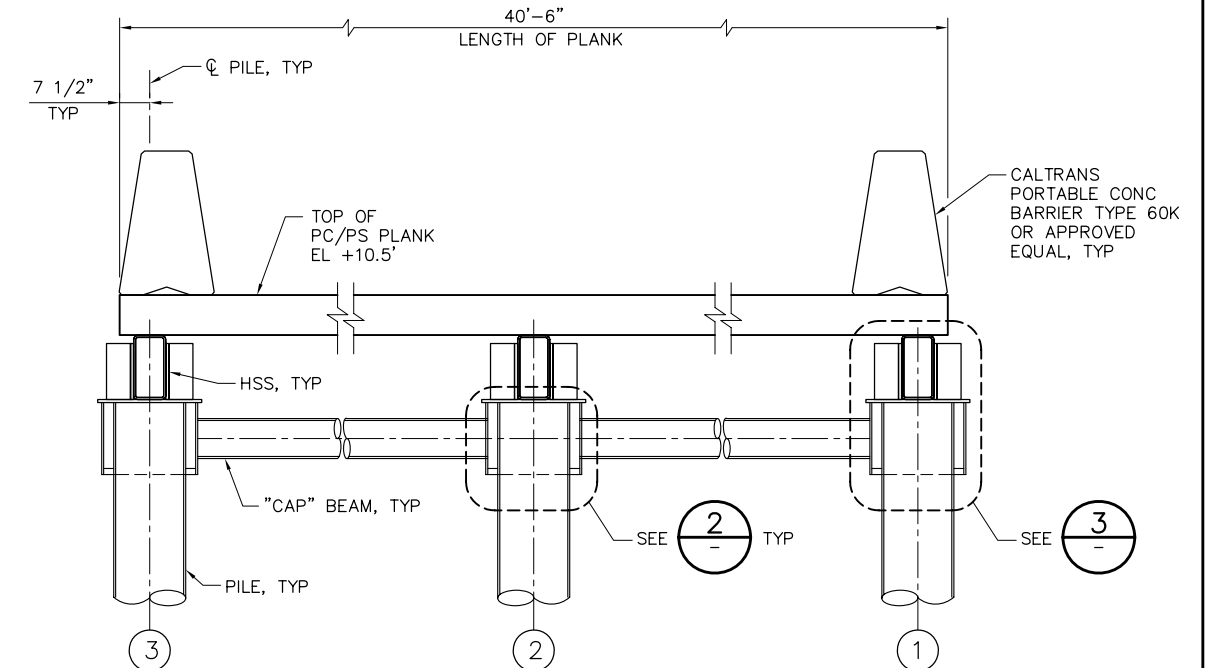

A SECTION
SCALE: 1/2" = 1'-0"

WELDING NOTE:

ALL STIFFENER PLATES SHALL HAVE DOUBLE SIDED 1/4" FILLET WELDS UON.

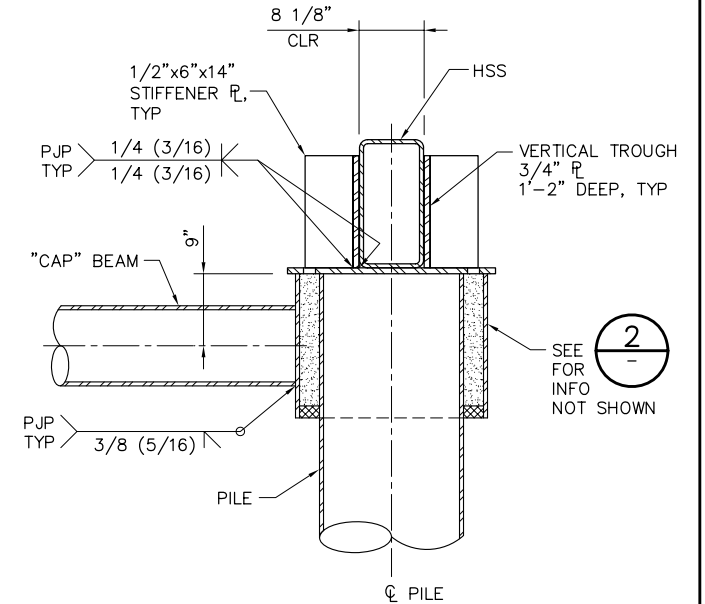

3 DETAIL
SCALE: 1" = 1'-0"

95% SUBMITTAL





IF SHEET IS LESS THAN 22" x 34"
IT IS A REDUCED PRINT -
SCALE REDUCED ACCORDINGLY.

REVISION	DESCRIPTION	BY	DATE

		2001 N. Main Street, Suite 360 Walnut Creek, California 94596 (925) 944-5411	
DSGN	JMB	DR	EP
JOB NO.	6097-03	SUBMITTED BY	RMR
CHK	TDB	TITLE	




TWO GATE FISH PROTECTION PLAN		DATE	08/07/09
OLD RIVER BOAT RAMP DETAILS AND SECTIONS SHEET 1		SHEET	14 OF 75
			C8

P:\6097-03 SWC GATE DESIGN\CADD\DWG\609703-C9.DWG 8/6/2009 8:27 AM

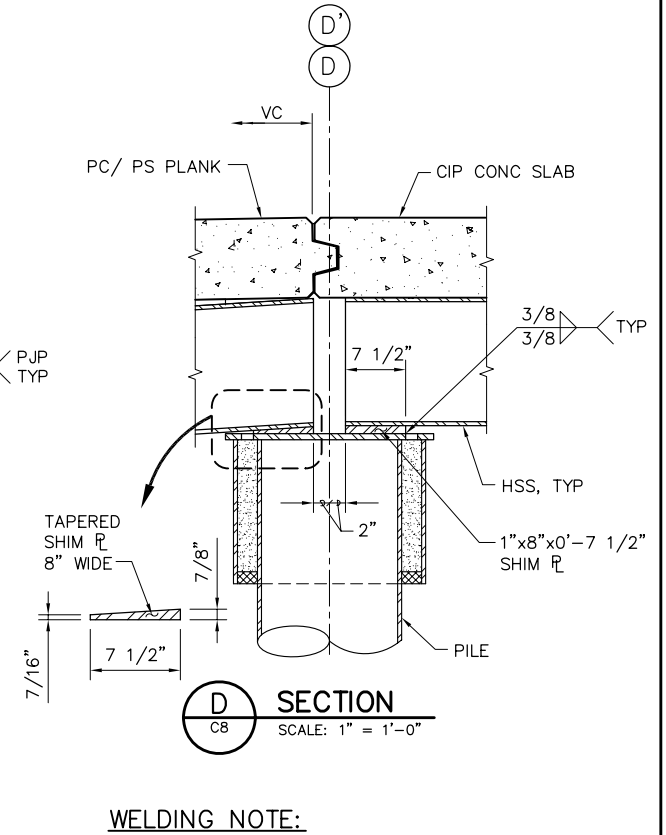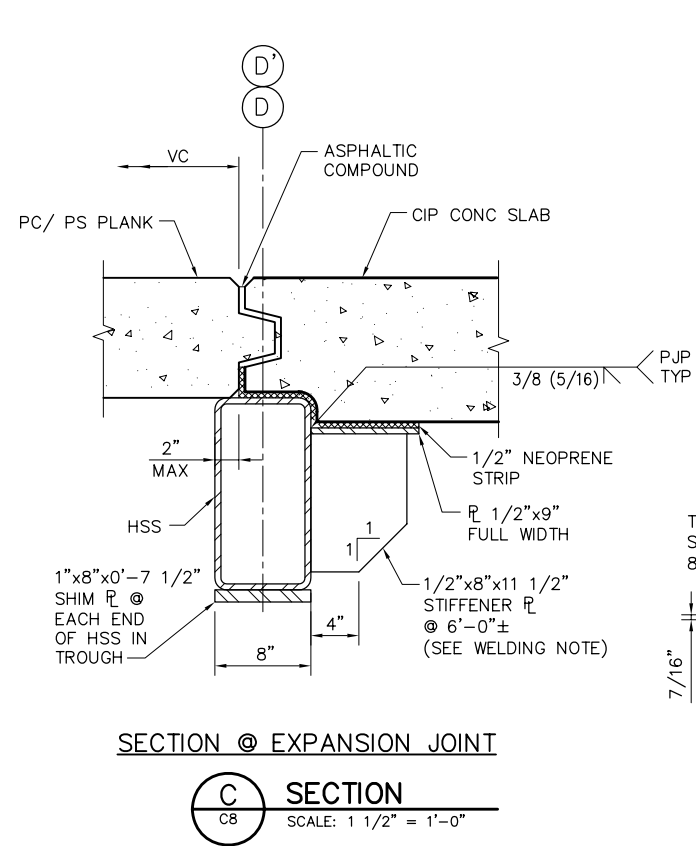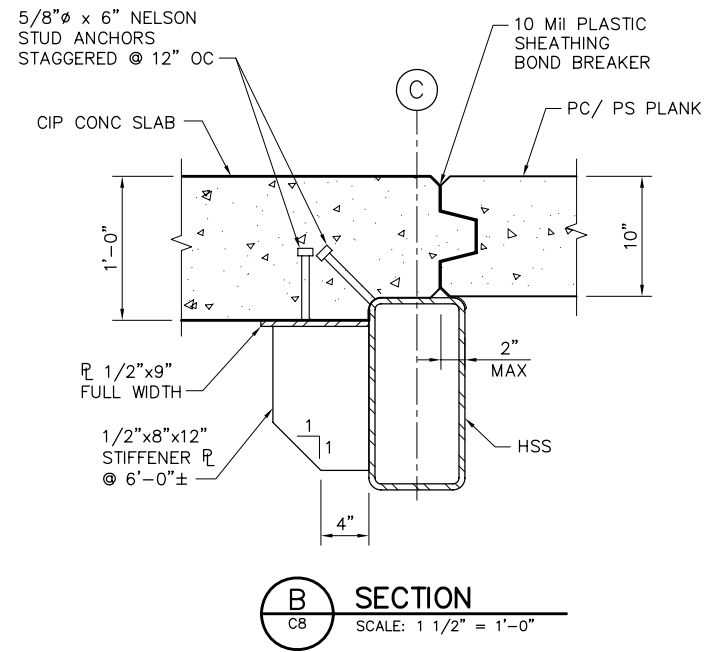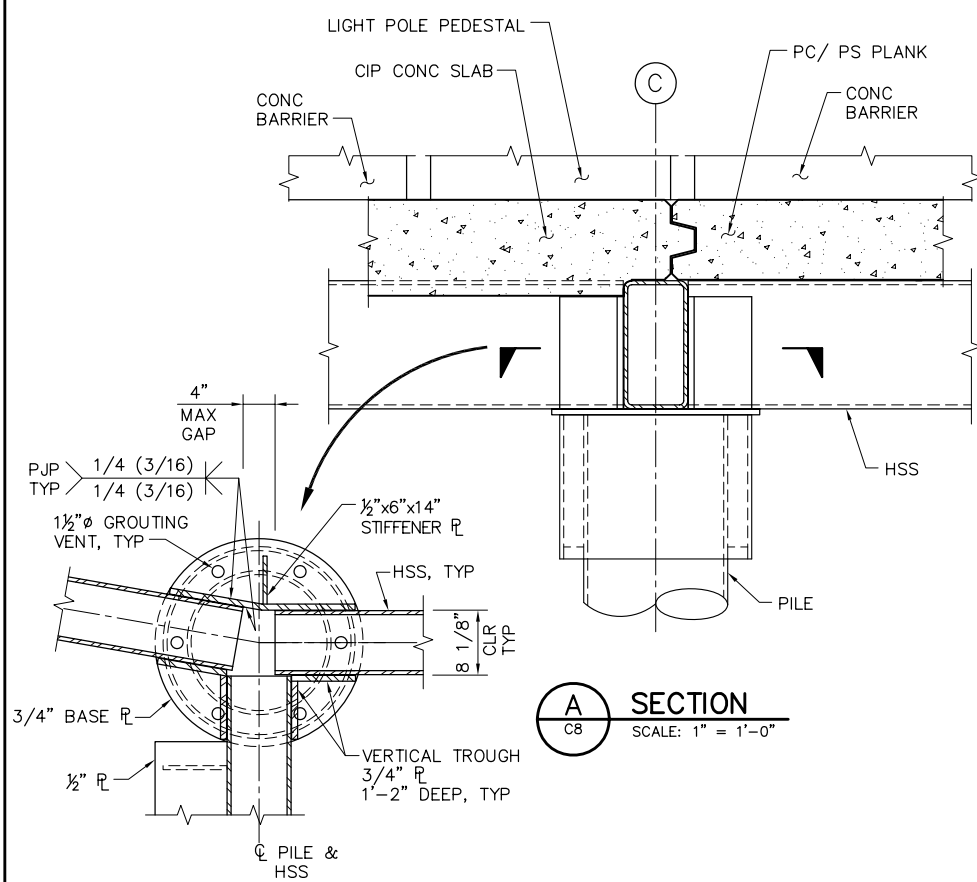

WELDING NOTE:

 ALL STIFFENER PLATES SHALL HAVE DOUBLE SIDED 1/4" FILLET WELDS UON.

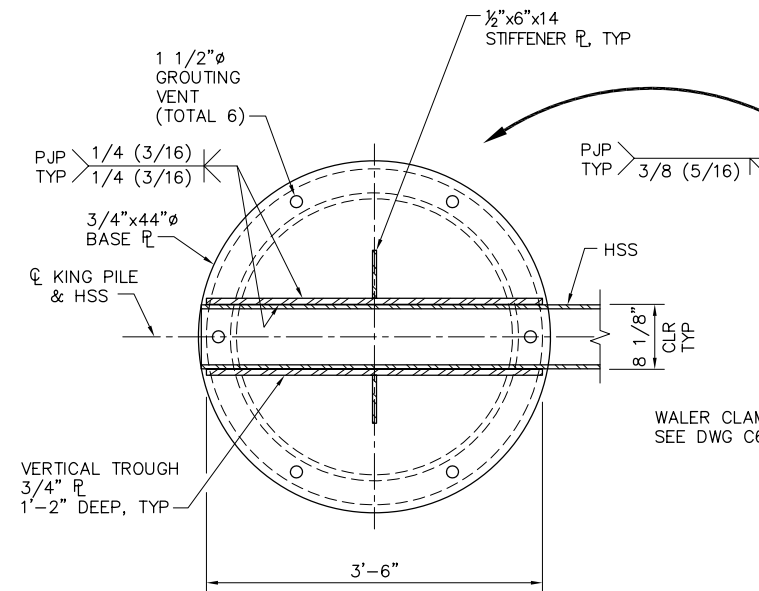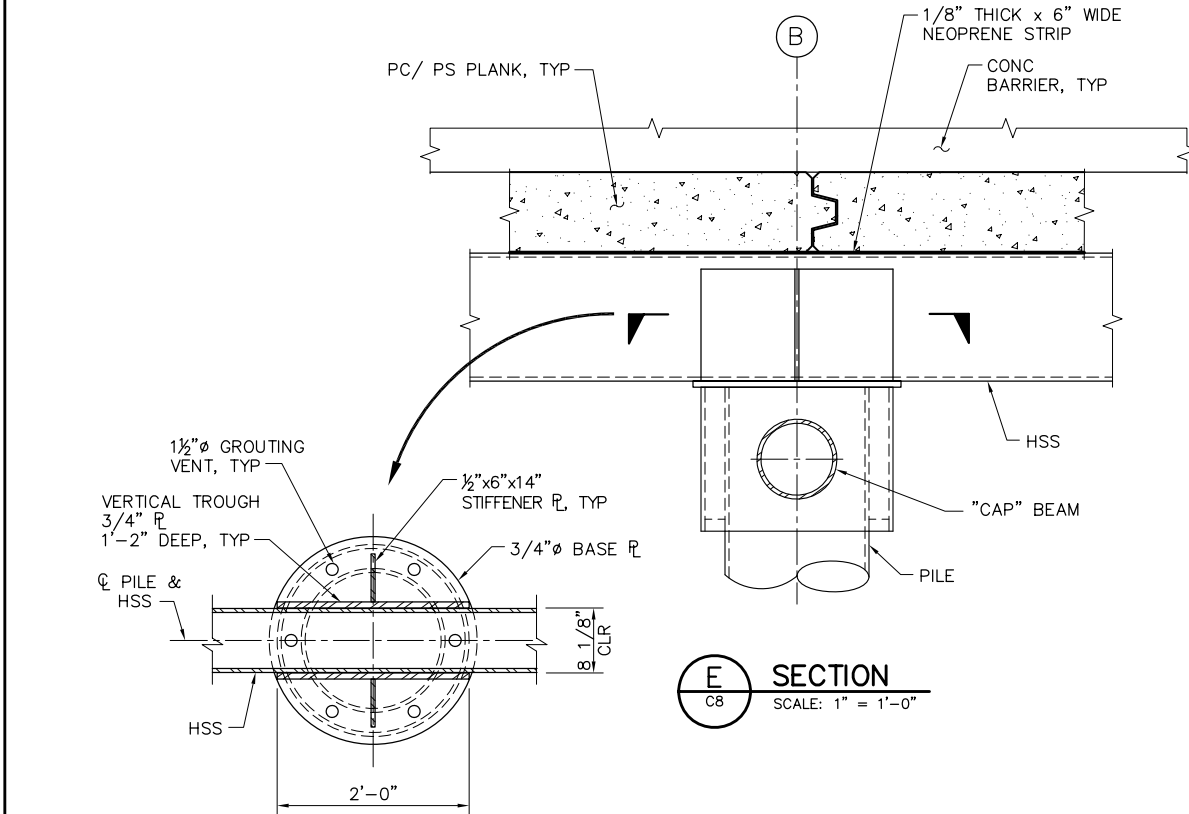

95% SUBMITTAL

IF SHEET IS LESS THAN 22" x 34"
IT IS A REDUCED PRINT -
SCALE REDUCED ACCORDINGLY.









REVISION	DESCRIPTION	BY	DATE

		2001 N. Main Street, Suite 360 Walnut Creek, California 94596 (925) 944-5411	
DSGN	JMB	DR	EP
JOB NO.	6097-03	SUBMITTED BY	RMR

TWO GATE FISH PROTECTION PLAN		DATE	08/07/09
OLD RIVER BOAT RAMP DETAILS AND SECTIONS SHEET 2		SHEET	15 OF 75

C9

 P:\6097-03 SWC GATE DESIGN\CADD\DWG\609703-C10.DWG 8/6/2009 8:30 AM

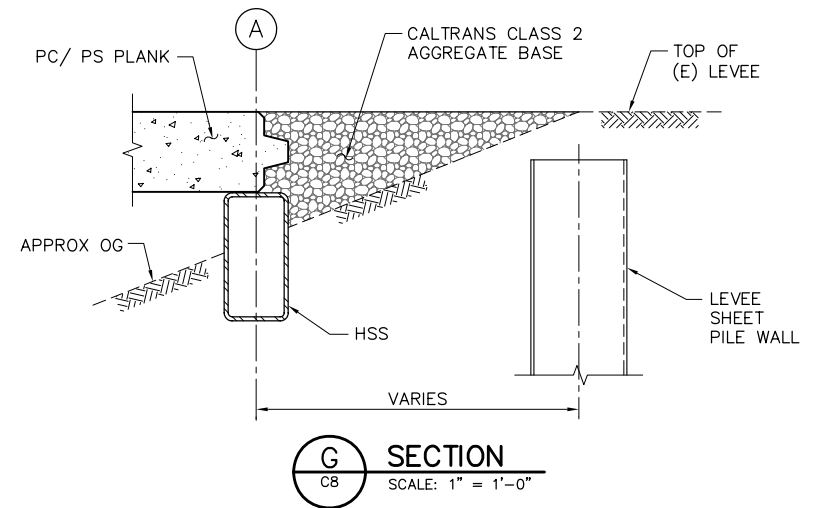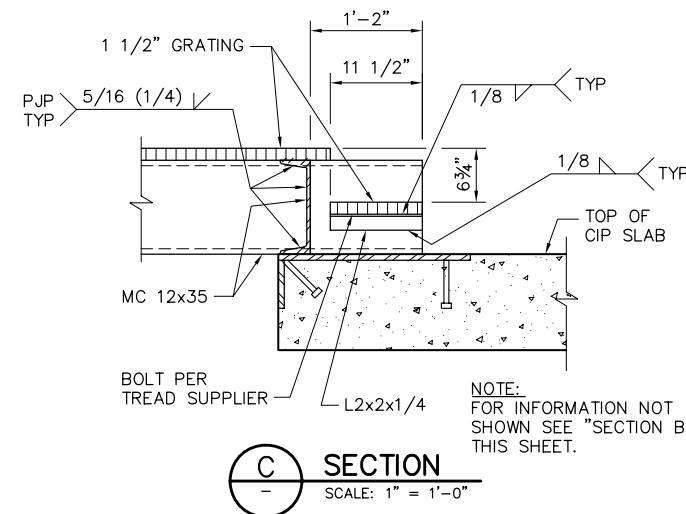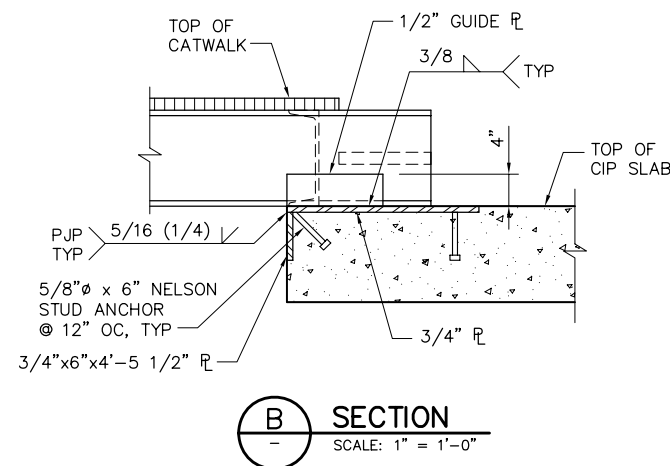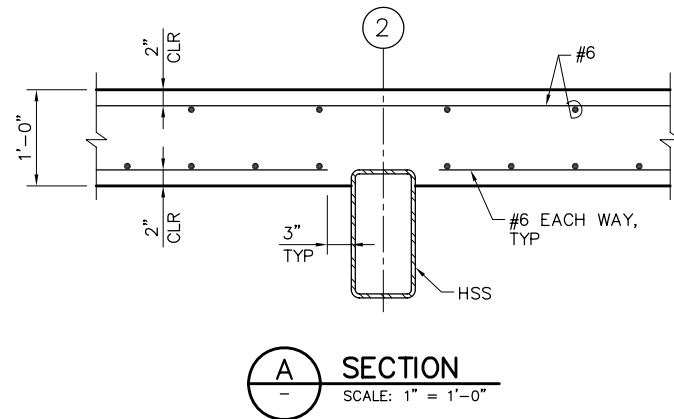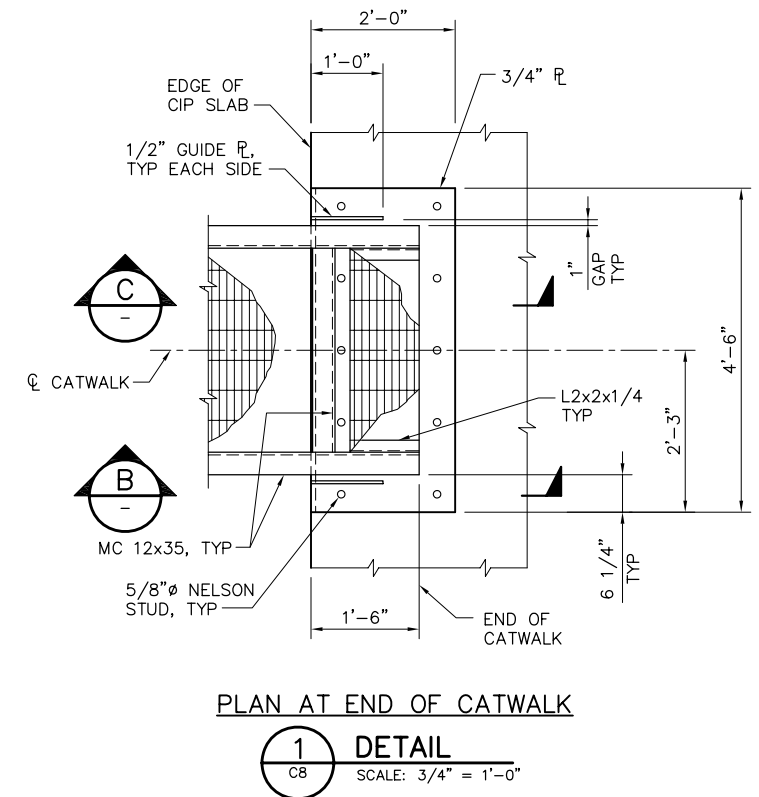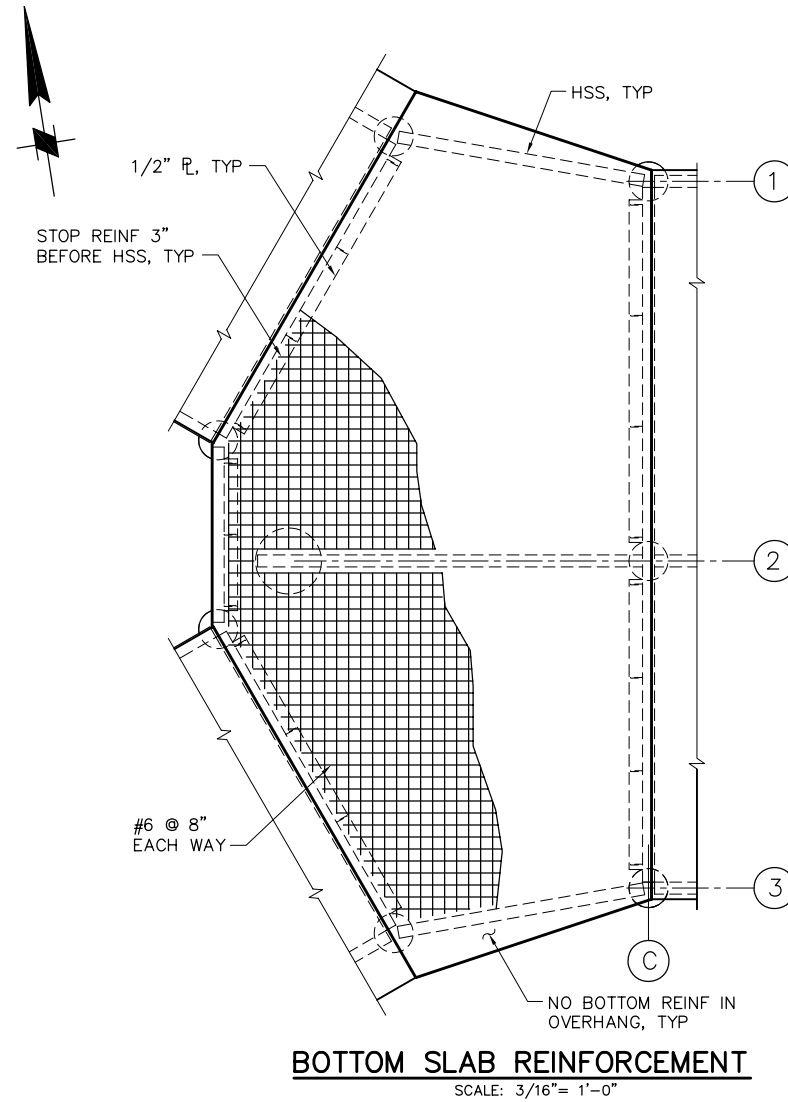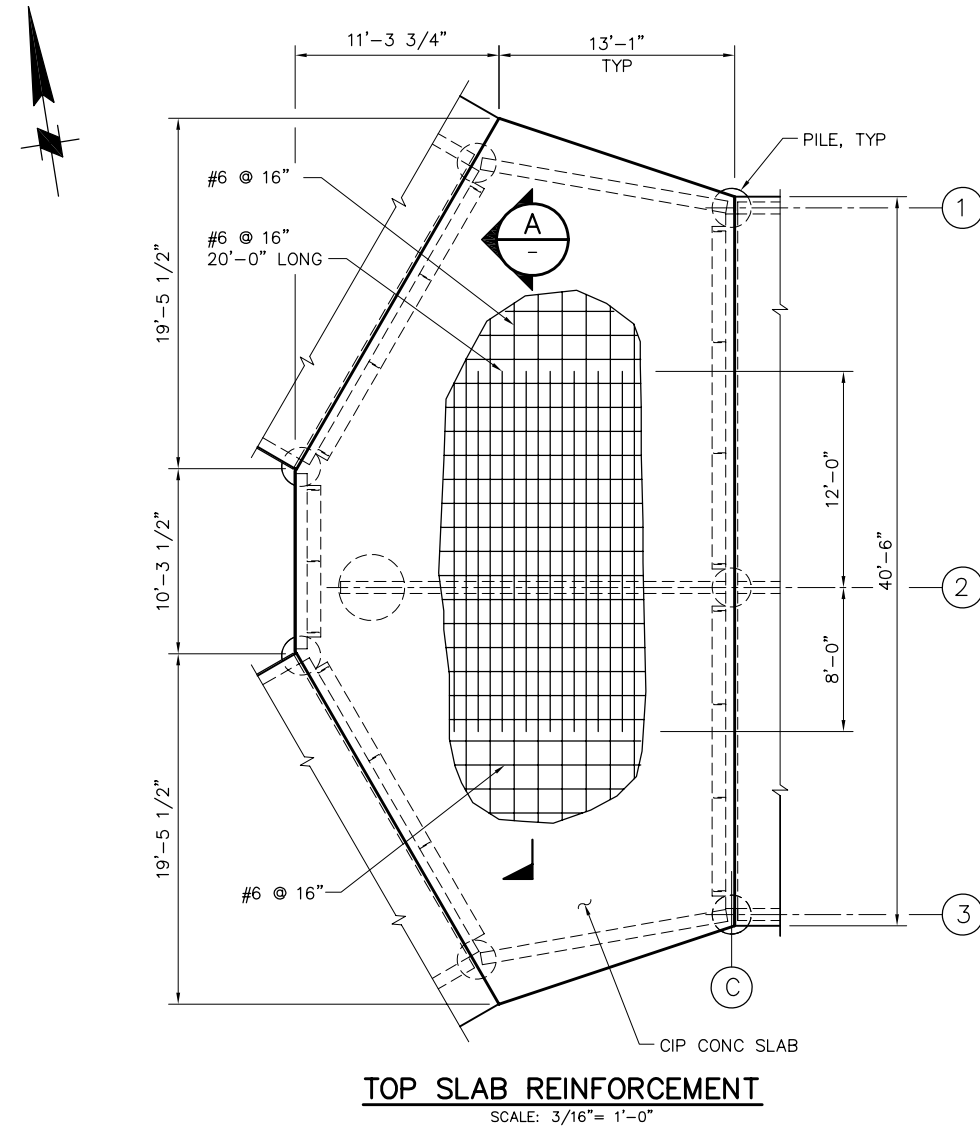


95% SUBMITTAL

IF SHEET IS LESS THAN 22" x 34" IT IS A REDUCED PRINT - SCALE REDUCED ACCORDINGLY.


REVISION	DESCRIPTION	BY	DATE

 Moffatt & Nichol		2001 N. Main Street, Suite 360 Walnut Creek, California 94596 (925) 944-5411	
DSGN	JMB	DR	EP
JOB NO.	6097-03	SUBMITTED BY	RMR
CHK	TDB	TITLE	


TWO GATE FISH PROTECTION PLAN		DATE	08/07/09
OLD RIVER BOAT RAMP DETAILS AND SECTIONS SHEET 3		SHEET	16 OF 75
C10			

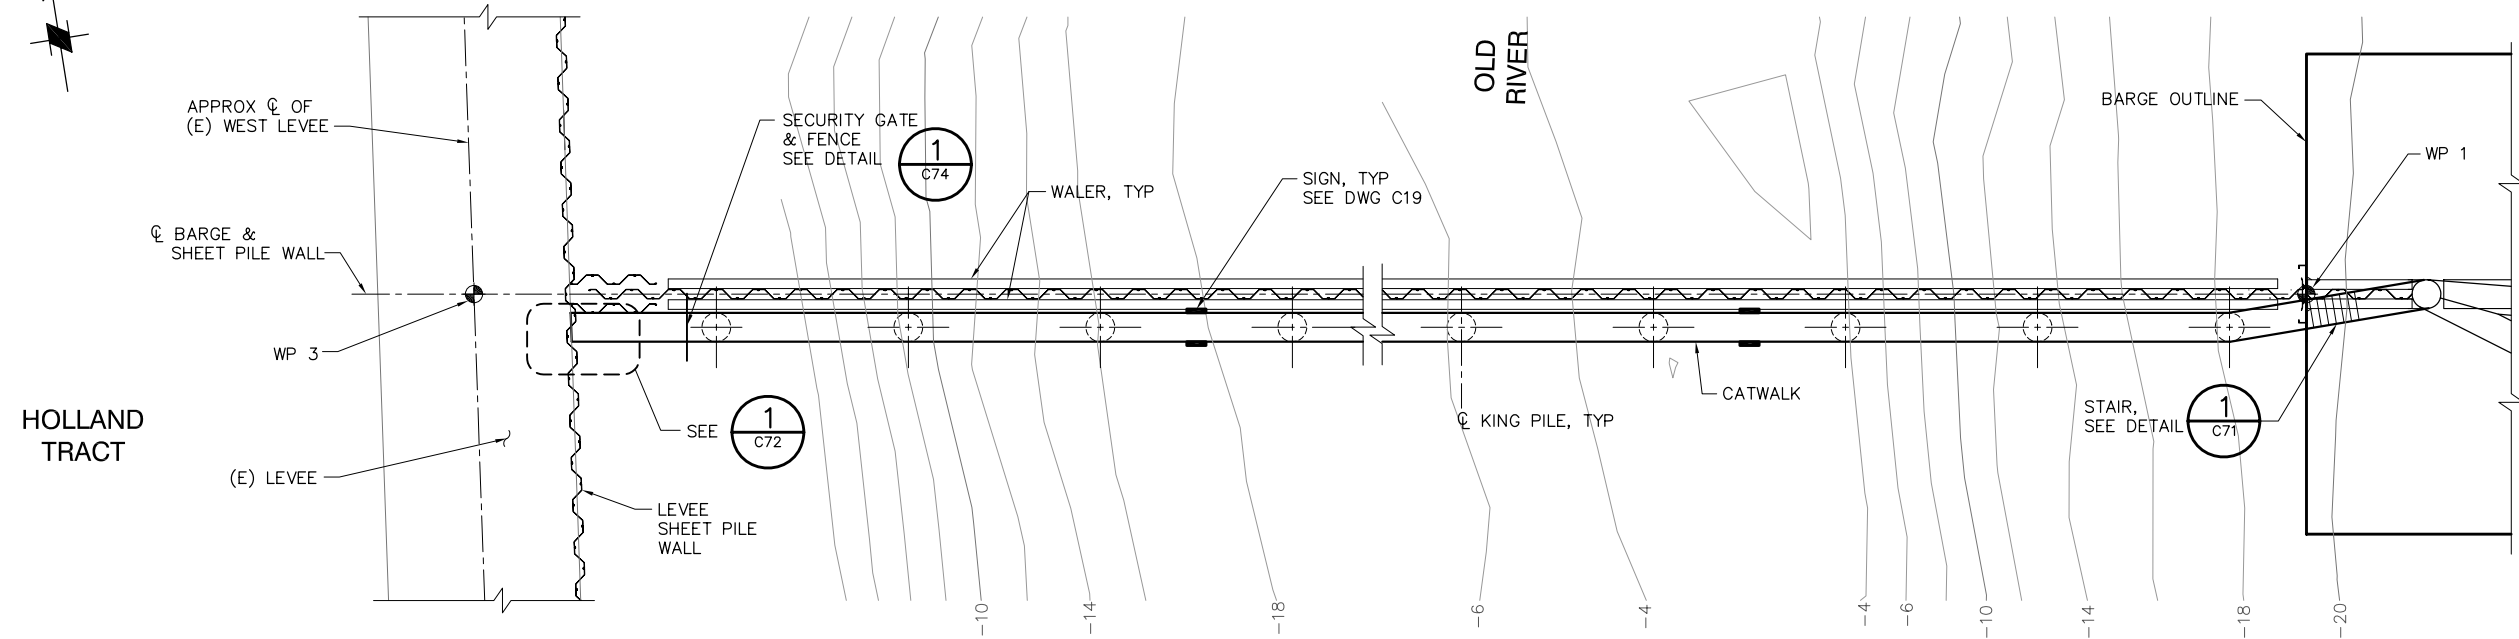

PLAN
SCALE: 1"= 10'

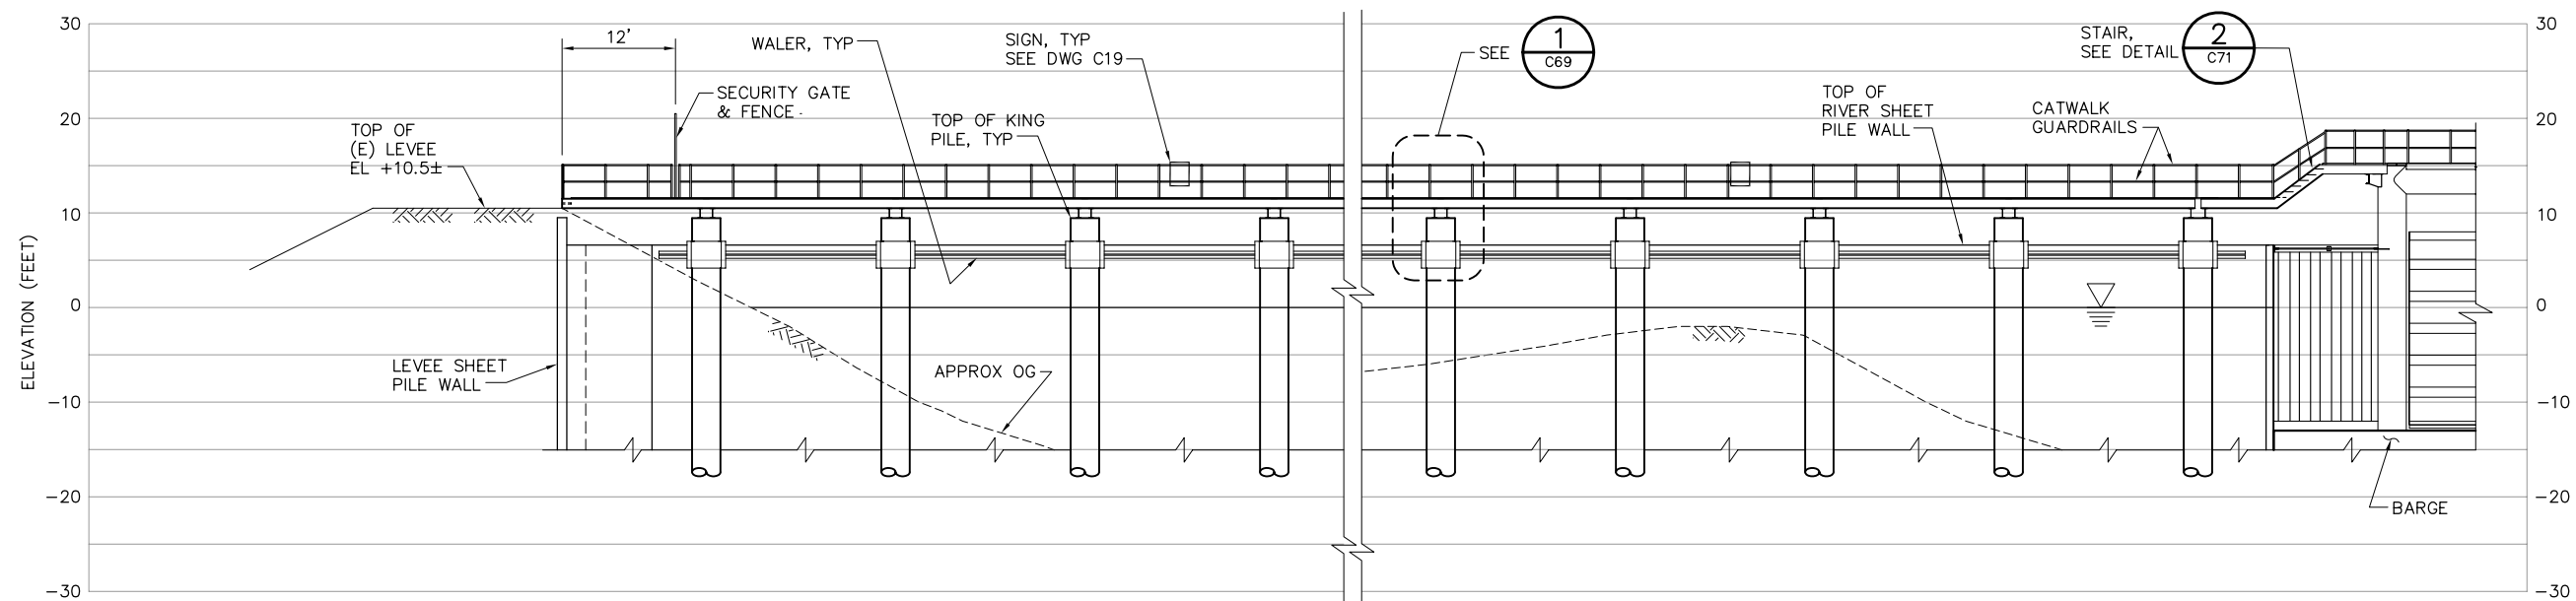

ELEVATION
SCALE: 1"= 10'

 

95% SUBMITTAL




IF SHEET IS LESS THAN 22" x 34"
IT IS A REDUCED PRINT -
SCALE REDUCED ACCORDINGLY.

REVISION	DESCRIPTION	BY	DATE

 Moffatt & Nichol	2001 N. Main Street, Suite 360 Walnut Creek, California 94596 (925) 944-5411	
	DSGN JMB	DR EP/AB
JOB NO. 6097-03	SUBMITTED BY RMR	CHK TDB

TWO GATE FISH PROTECTION PLAN		DATE 08/07/09
OLD RIVER CATWALK PLAN AND ELEVATION, SHEET 1		SHEET 17 OF 75
		C11

 P:\6097-03 SWC GATE DESIGN\CADD\DWG\609703-C12.DWG 8/6/2009 8:32 AM

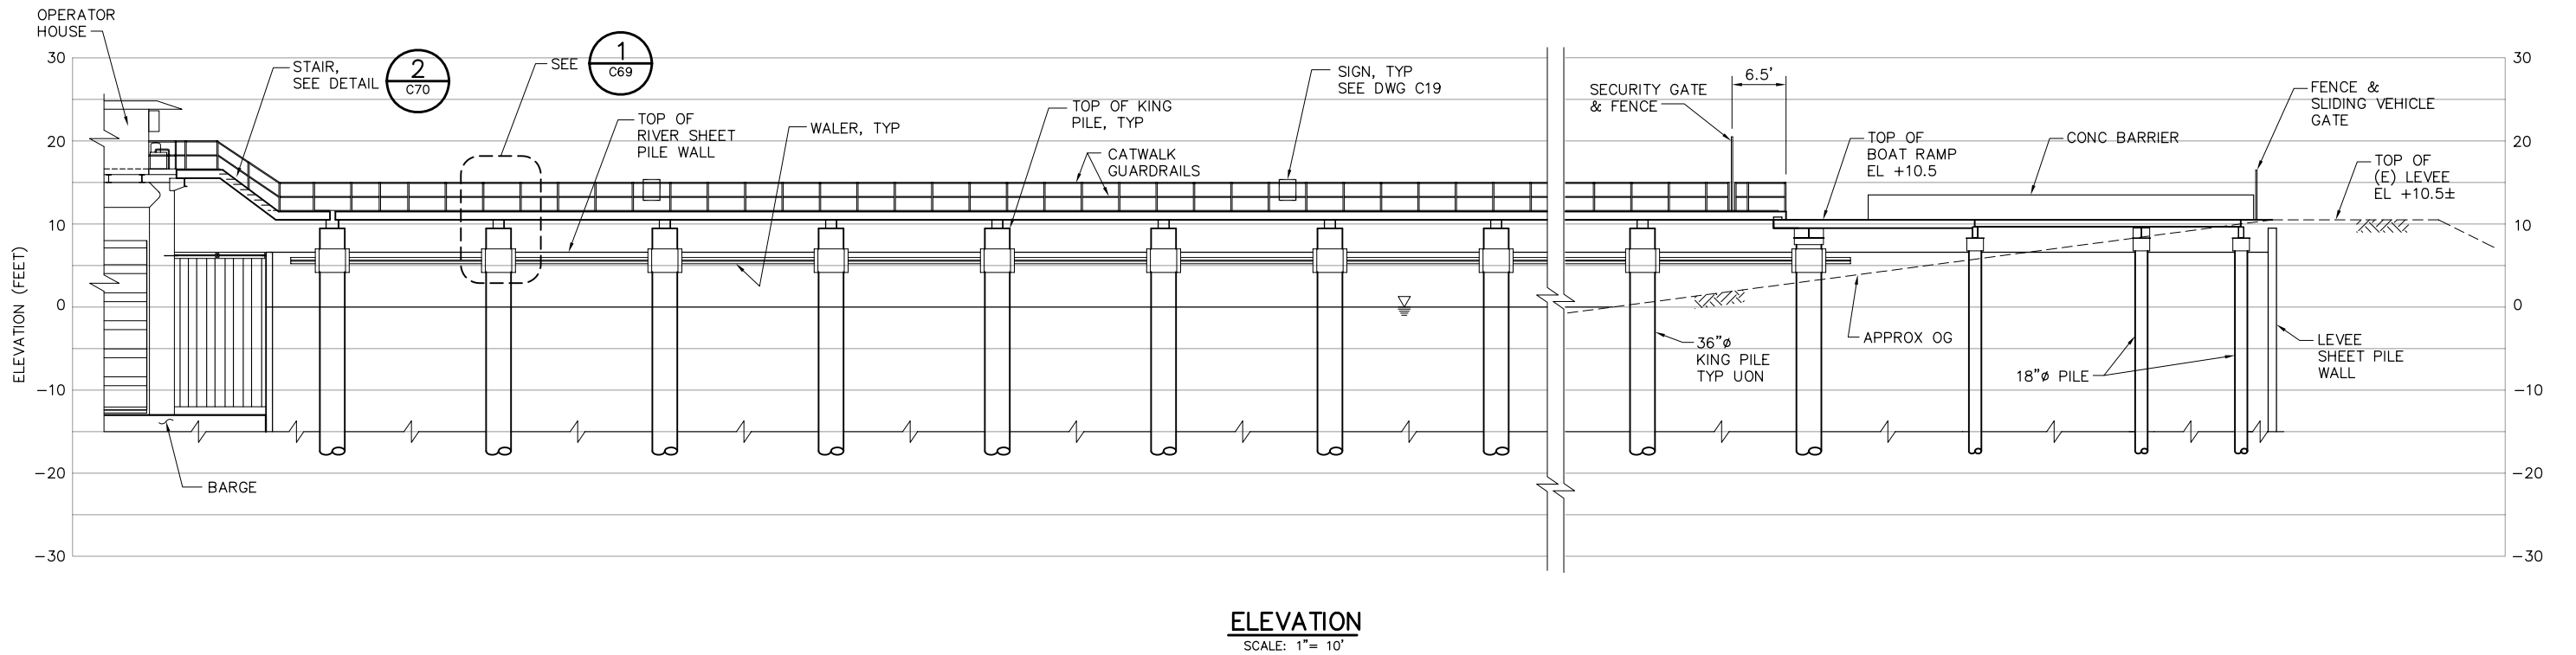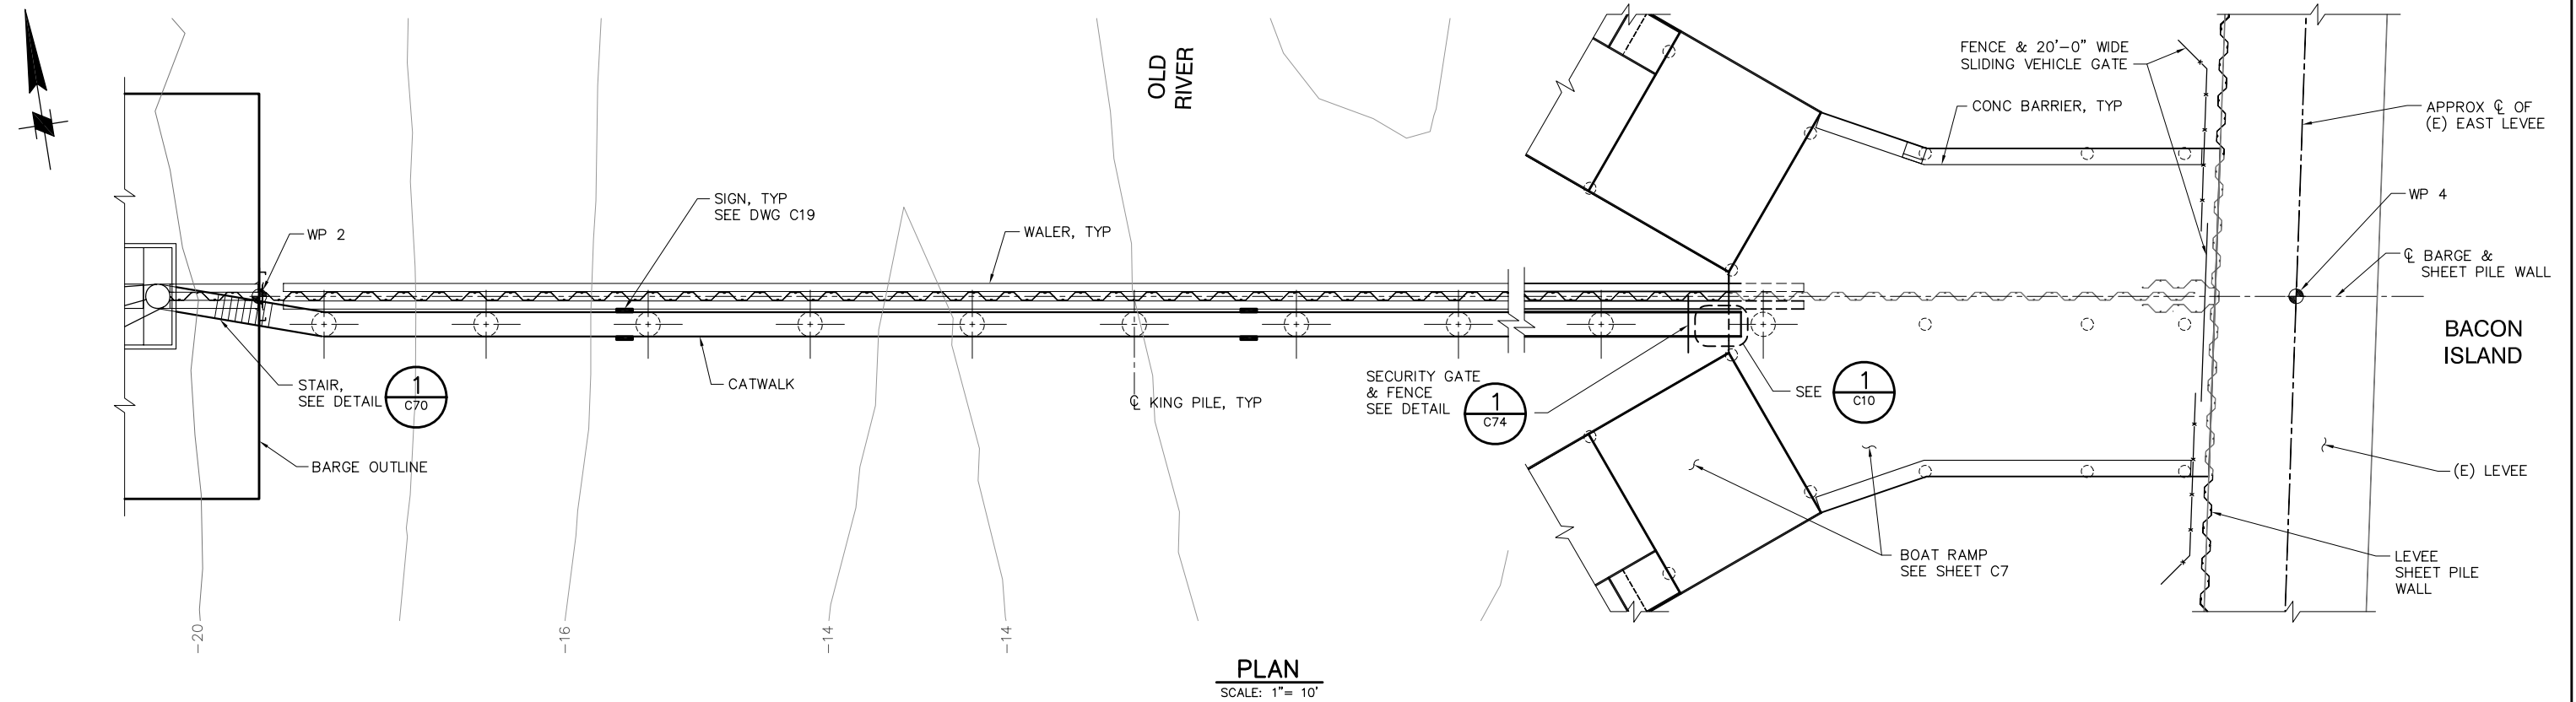

95% SUBMITTAL


IF SHEET IS LESS THAN 22" x 34"
IT IS A REDUCED PRINT -
SCALE REDUCED ACCORDINGLY.

REVISION	DESCRIPTION	BY	DATE

 Moffatt & Nichol		2001 N. Main Street, Suite 360 Walnut Creek, California 94596 (925) 944-5411	
DSGN	JMB	DR	EP/AB
JOB NO.	6097-03	SUBMITTED BY	RMR
CHK	TDB	TITLE	


TWO GATE FISH PROTECTION PLAN		DATE	08/07/09
OLD RIVER CATWALK PLAN AND ELEVATION, SHEET 2		SHEET	18 OF 75
			C12

P:\6097-03 SWC GATE DESIGN\CADD\DWG\609703-C13.DWG 7/23/2009 4:33 PM

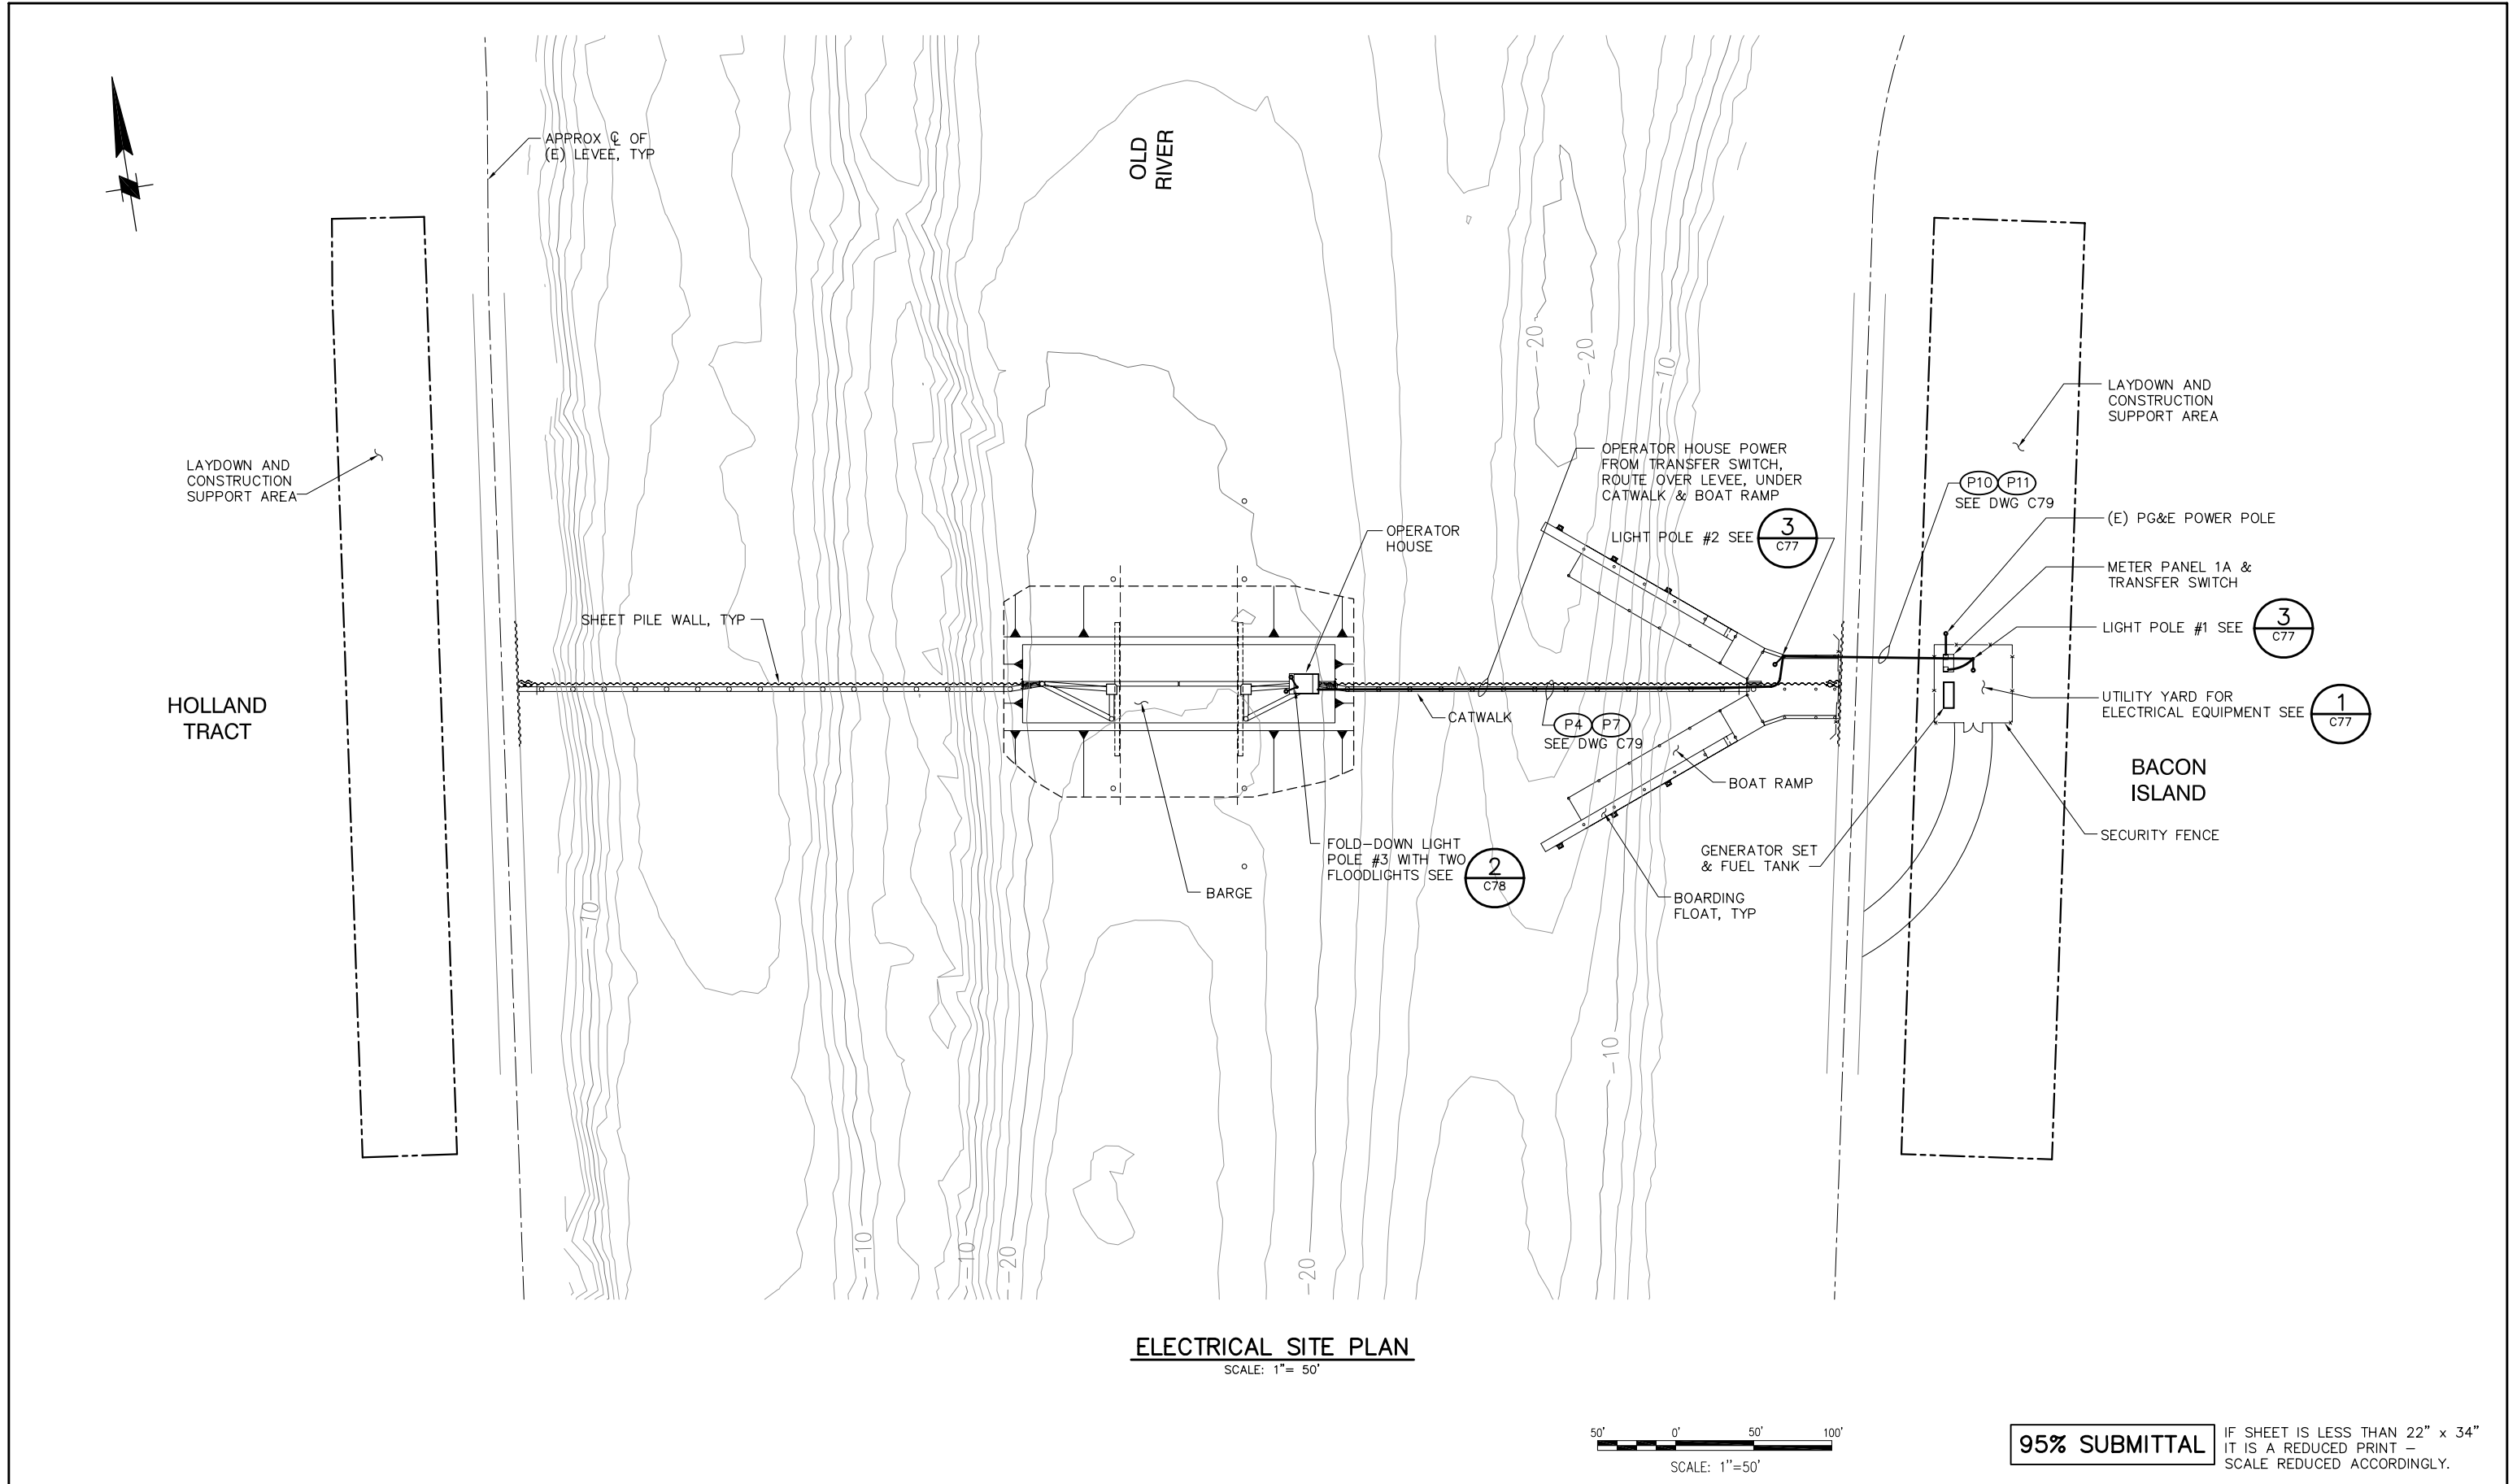


REVISION	DESCRIPTION	BY	DATE			Moffatt & Nichol 2001 N. Main Street, Suite 360 Walnut Creek, California 94596 (925) 944-5411	TWO GATE FISH PROTECTION PLAN		DATE 08/07/09
								SHEET 19 OF 75	
								OLD RIVER ELECTRICAL SITE PLAN C13	
DSGN		DM		DR	AB		CHK	CBS	
JOB NO.		6097-03		SUBMITTED BY		RMR		TITLE	

P:\6097-03 SWC GATE DESIGN\CADD\DWG\609703-C14.DWG 8/7/2009 9:21 AM

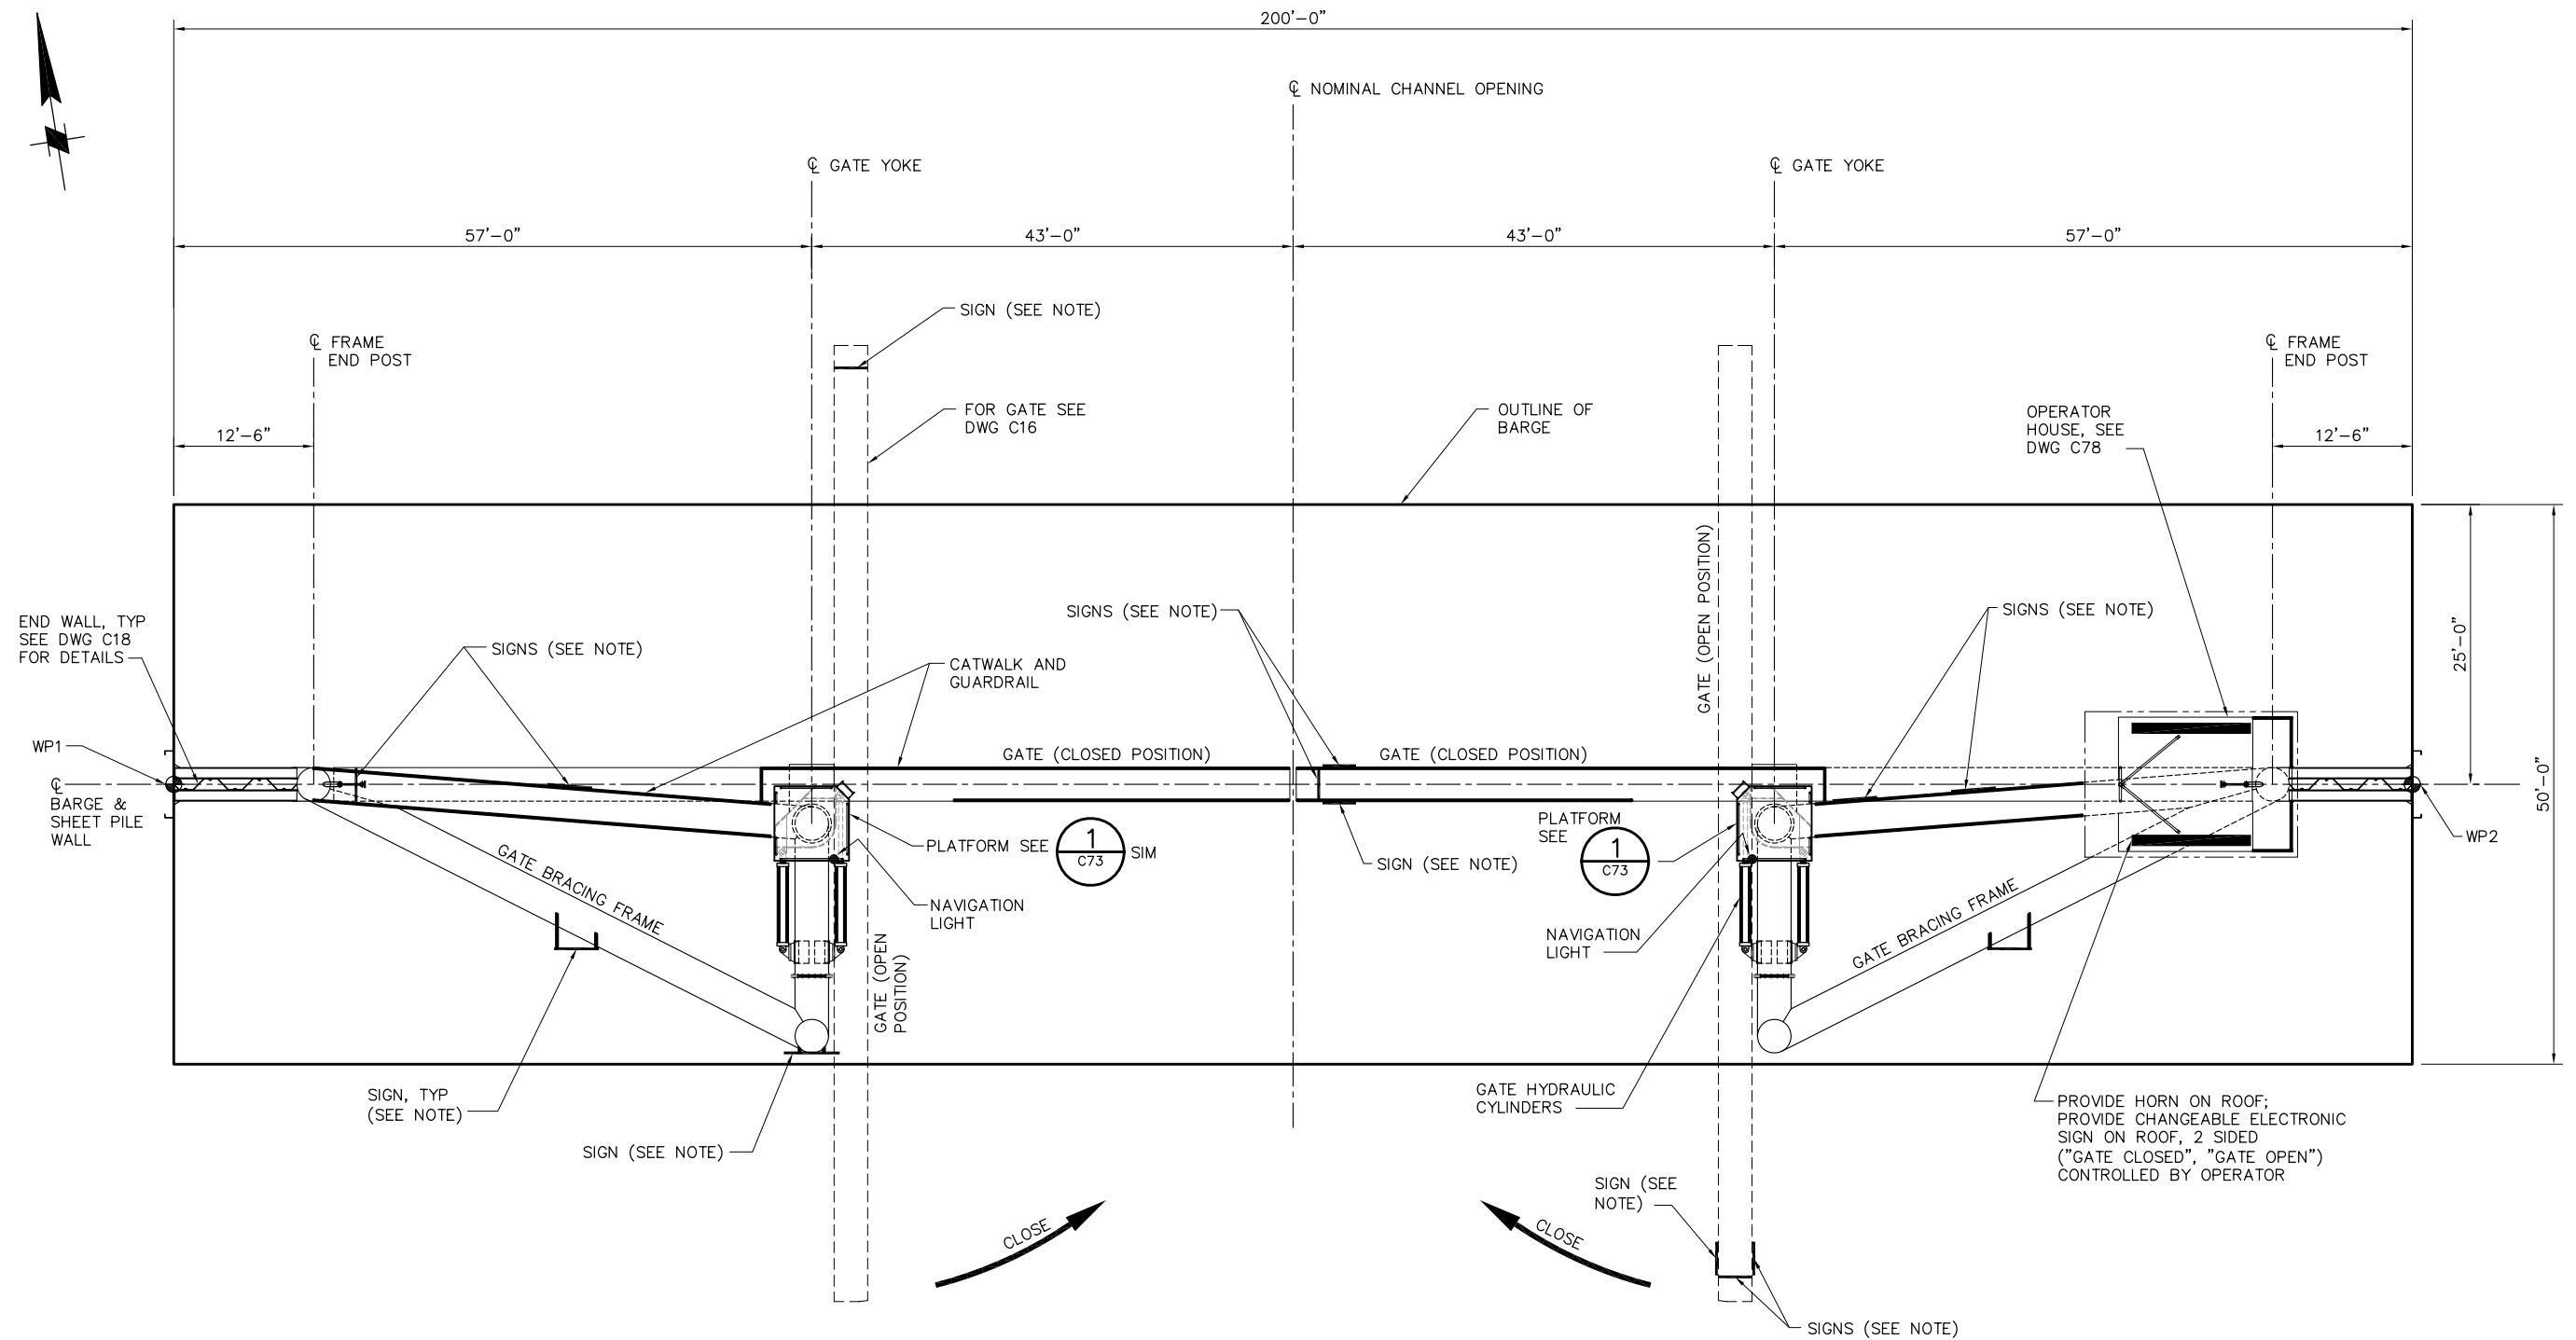

BARGE PLAN
SCALE: 1/8"= 1'-0"

 NOTE:
FOR SIGNAGE, SEE DRAWING C19.



95% SUBMITTAL


IF SHEET IS LESS THAN 22" x 34"
IT IS A REDUCED PRINT -
SCALE REDUCED ACCORDINGLY.

REVISION	DESCRIPTION	BY	DATE

 Moffatt & Nichol		2001 N. Main Street, Suite 360 Walnut Creek, California 94596 (925) 944-5411	
DSGN	CBS	DR	AB
JOB NO.	6097-03	SUBMITTED BY	RMR
CHK	TDB	TITLE	

TWO GATE FISH PROTECTION PLAN	DATE 08/07/09
	SHEET 20 OF 75
OLD RIVER BARGE GENERAL ARRANGEMENT PLAN	C14

P:\6097-03 SWC GATE DESIGN\CADD\DWG\609703-C15.DWG 8/7/2009 9:23 AM

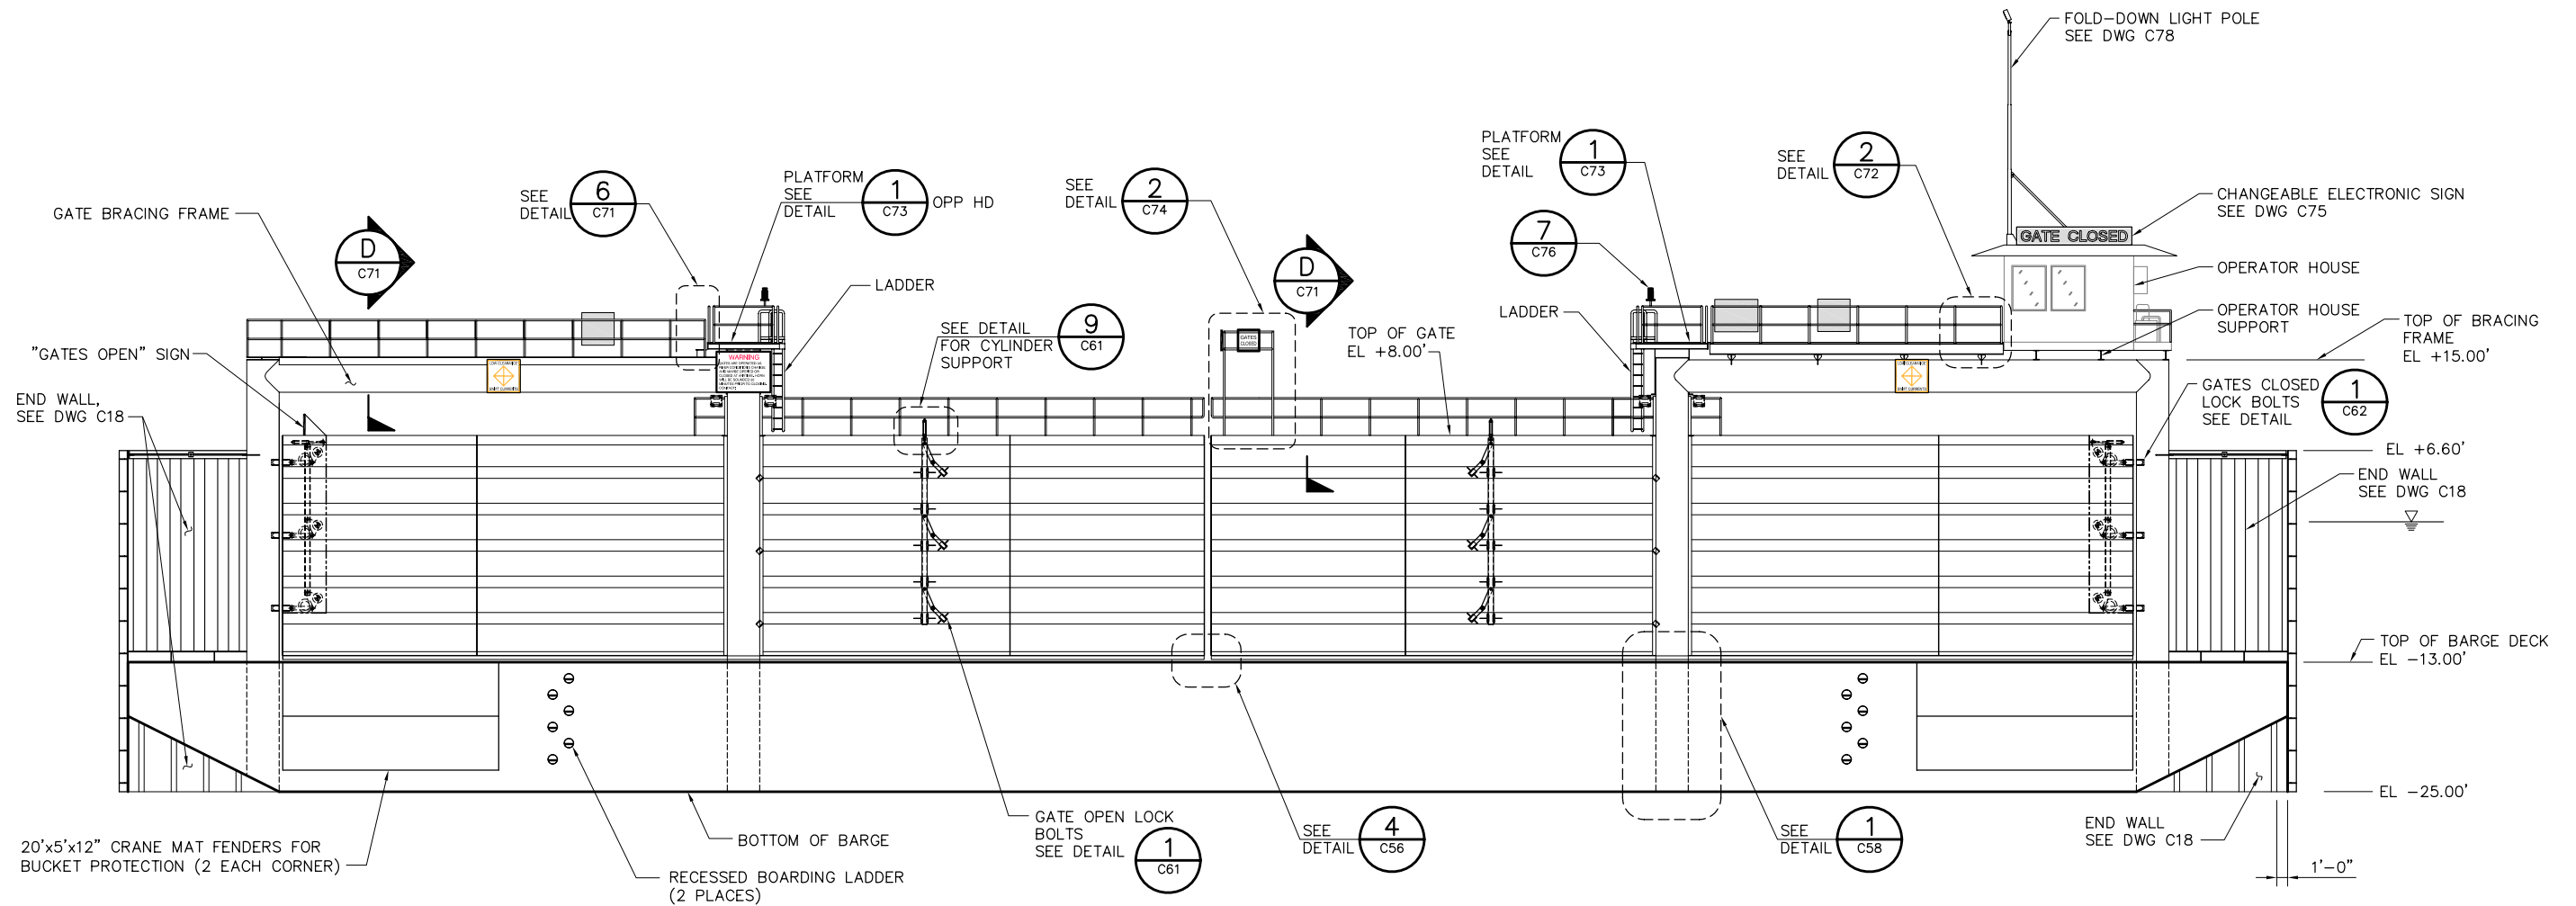

ELEVATION
SCALE: 1/8"= 1'-0"

NOTE: GATES SHOWN IN CLOSED POSITION

NOTES:

1. FOR SIGNAGE SEE DRAWING C19.
2. FOR CATWALK STAIRWAY SEE DRAWINGS C11 AND C12.


8'-0" 0'-0" 8'-0" 16'-0"
SCALE: 1/8"=1'-0"

95% SUBMITTAL


IF SHEET IS LESS THAN 22" x 34"
IT IS A REDUCED PRINT -
SCALE REDUCED ACCORDINGLY.

REVISION	DESCRIPTION	BY	DATE				 Moffatt & Nichol		2001 N. Main Street, Suite 360 Walnut Creek, California 94596 (925) 944-5411		TWO GATE FISH PROTECTION PLAN		DATE 08/07/09	
													SHEET 21 OF 75	
											OLD RIVER BARGE GENERAL ARRANGEMENT ELEVATION		C15	

P:\6097-03 SWC GATE DESIGN\CADD\DWG\609703-C17.DWG 8/6/2009 11:24 AM

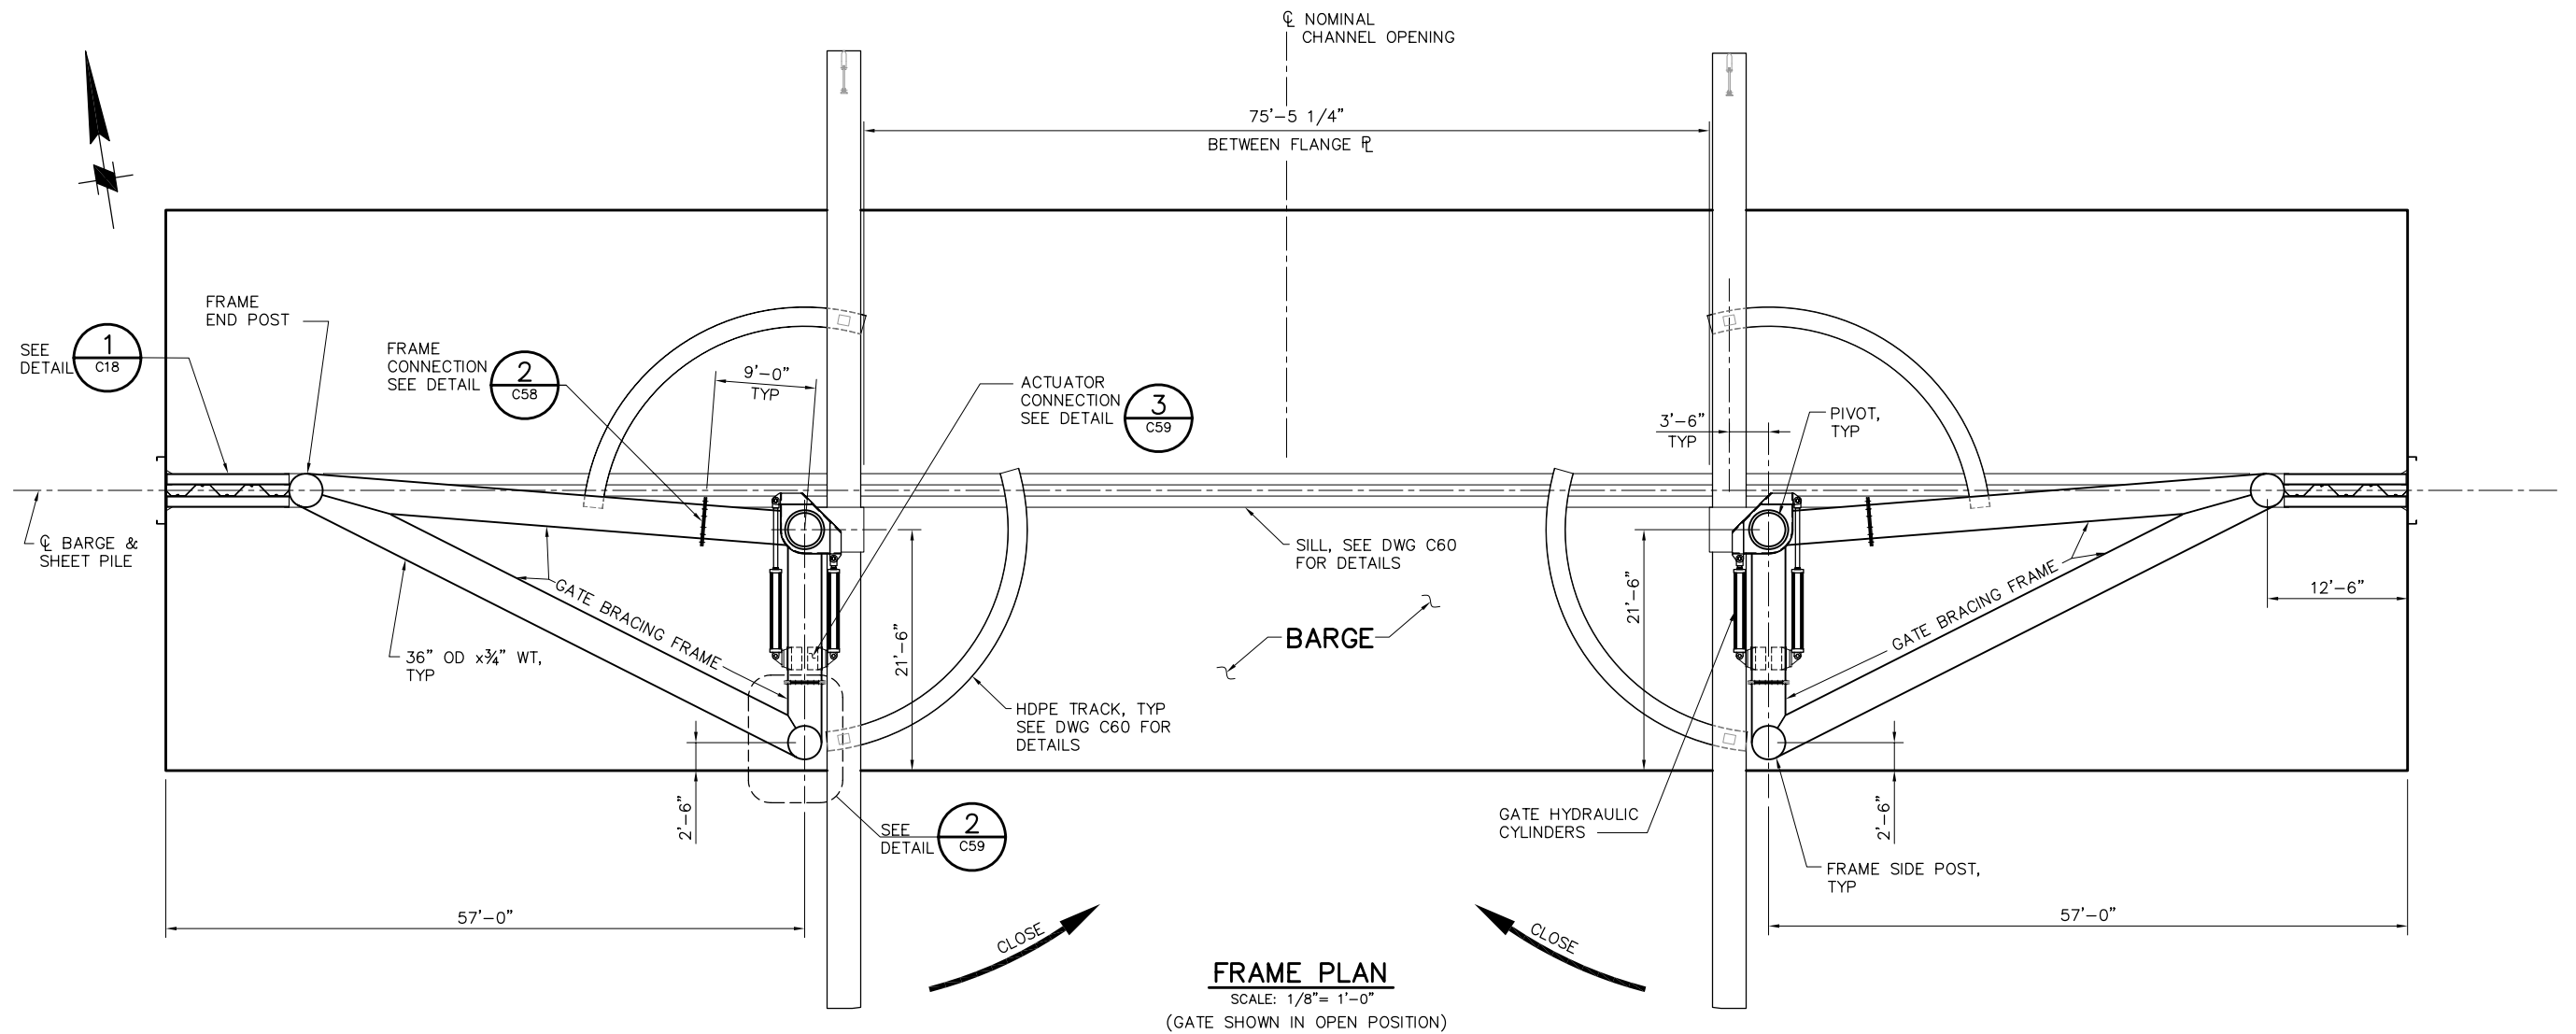

FRAME PLAN
SCALE: 1/8"= 1'-0"
(GATE SHOWN IN OPEN POSITION)

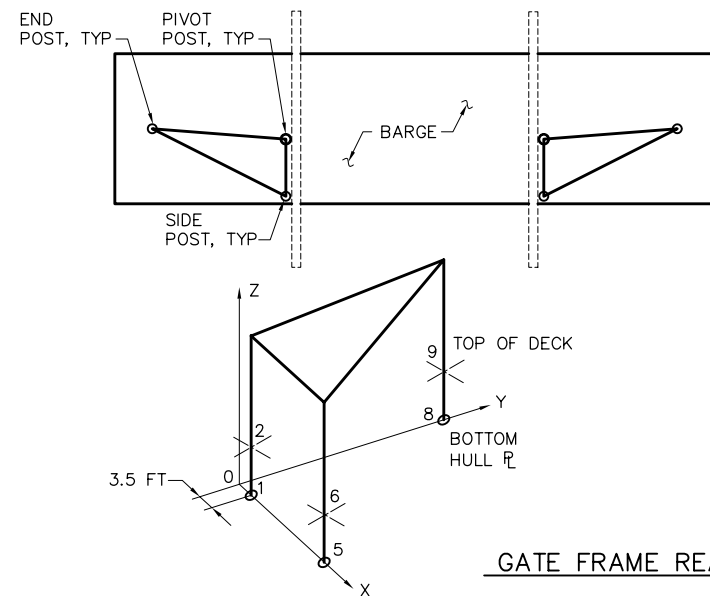

GATE FRAME REACTIONS

SERVICE LOAD REACTIONS (INCLUDES A 1.2 FACTOR)
(FOR LRFD USE A 1.6 FACTOR WITH THESE REACTIONS)

LOCATION ON BARGE	NODE	R _X (KIP)	R _Y (KIP)	R _Z (KIP)	DESCRIPTION
BOTTOM HULL $\bar{L}$	1	+130 -130	+30 -30	+200 -50	PIVOT
	5	+100 -100	-30 +30	-55 +170	SIDE POST
	8	+50 -50	+30 -30	+100	END POST
TOP OF DECK	2	+500 -500	-50 +50	0	PIVOT
	6	+200 -200	-50 +50	0	SIDE POST
	9	+100 -100	-50 +50	0	END POST

NOTE: CONTRACTOR SHALL PROVIDE A BARGE ADEQUATE TO SUPPORT THESE LOADS.

8'-0" 0'-0" 8'-0" 16'-0"
SCALE: 1/8"=1'-0"


95% SUBMITTAL IF SHEET IS LESS THAN 22" x 34"
IT IS A REDUCED PRINT -
SCALE REDUCED ACCORDINGLY.

REVISION	DESCRIPTION	BY	DATE

 Moffatt & Nichol		2001 N. Main Street, Suite 360 Walnut Creek, California 94596 (925) 944-5411	
DSGN	CBS	DR	AB
JOB NO.	6097-03	SUBMITTED BY	RMR
CHK	TDB	TITLE	


TWO GATE FISH PROTECTION PLAN		DATE	08/07/09
OLD RIVER GATE FRAMING LAYOUT		SHEET	23 OF 75
			C17

P:\6097-03 SMC GATE DESIGN\CADD\DWG\609703-C18.DWG 8/4/2009 4:46 PM

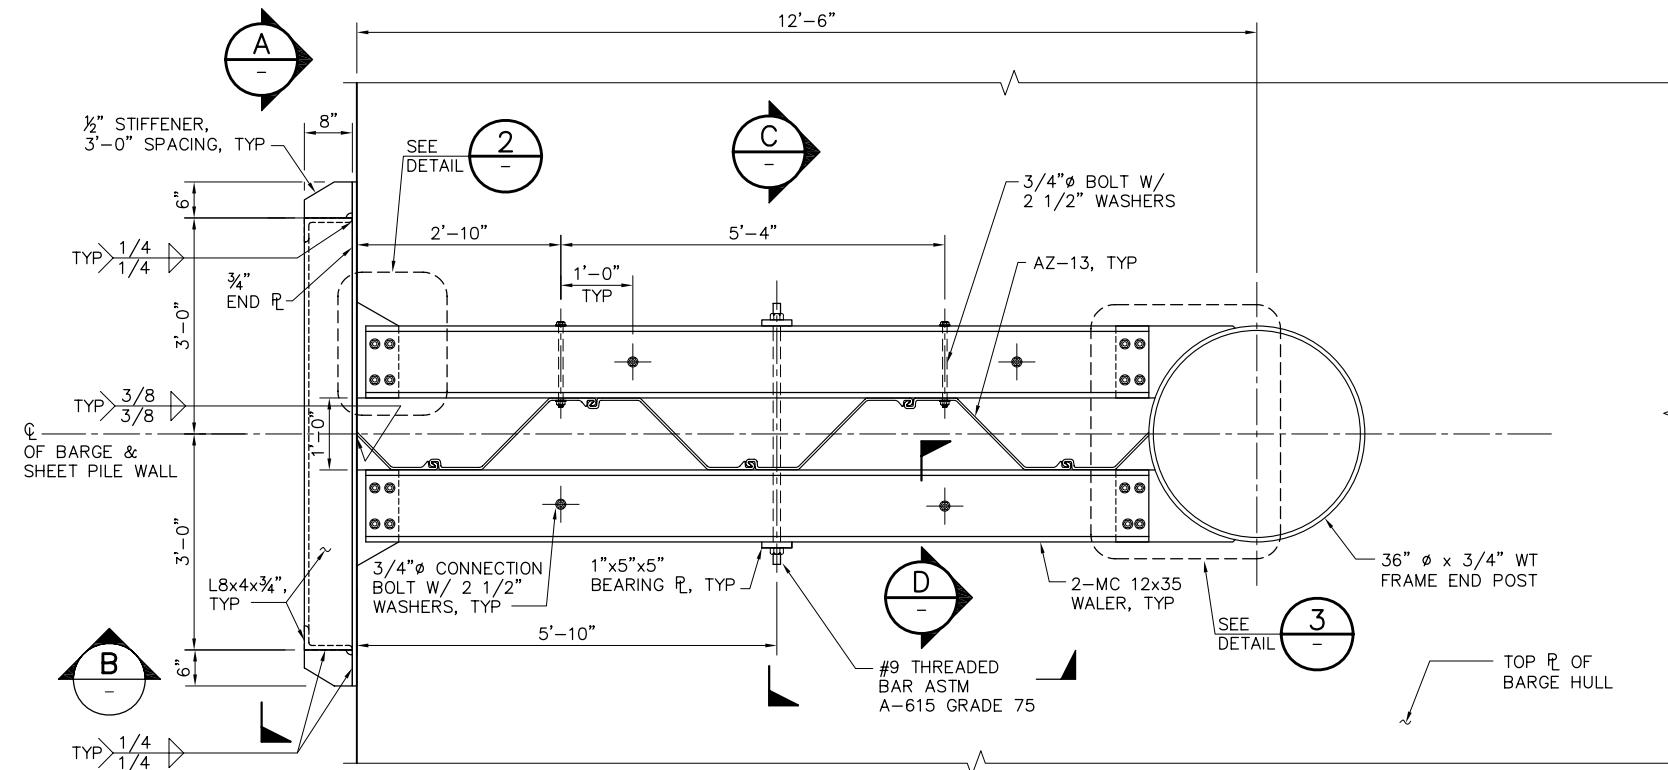


PLAN


1 DETAIL
SCALE: 3/4" = 1'-0"

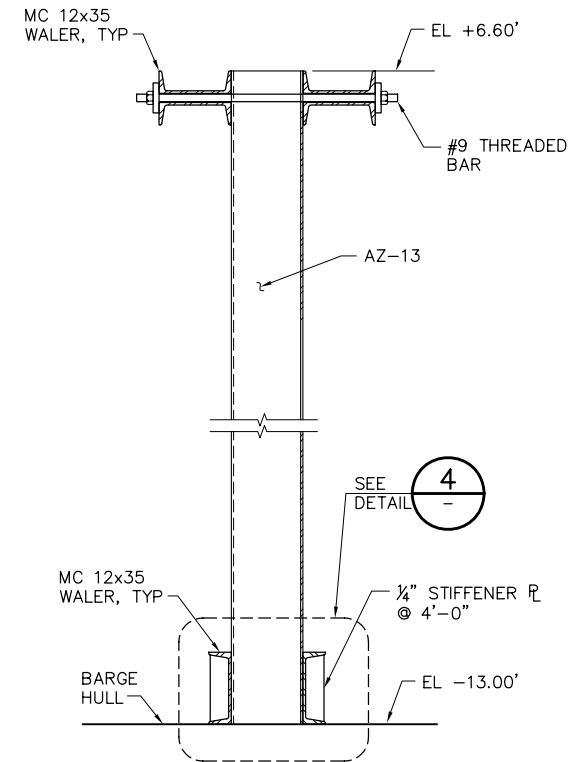


C SECTION
SCALE: 3/4" = 1'-0"

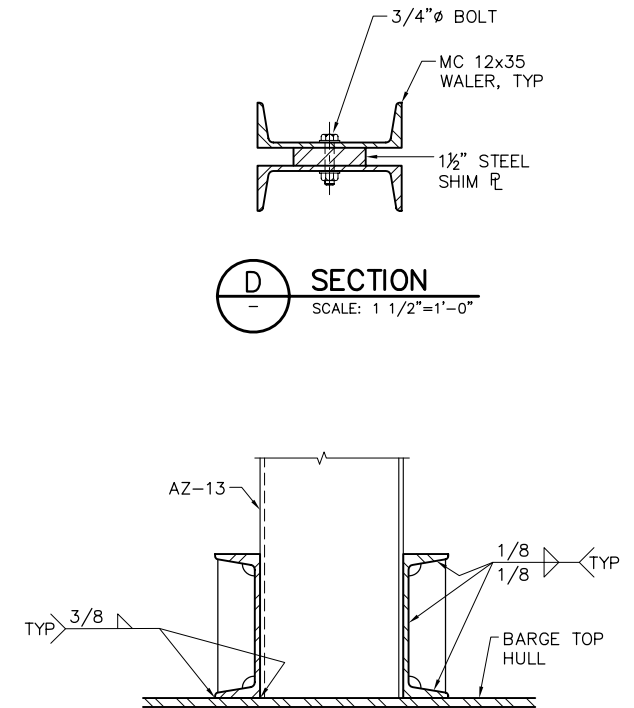


D SECTION
SCALE: 1 1/2" = 1'-0"

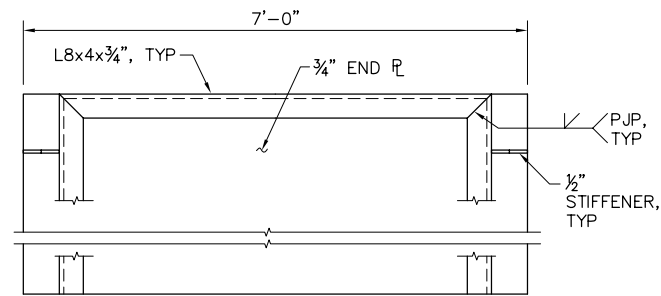


A SECTION
SCALE: 3/4" = 1'-0"

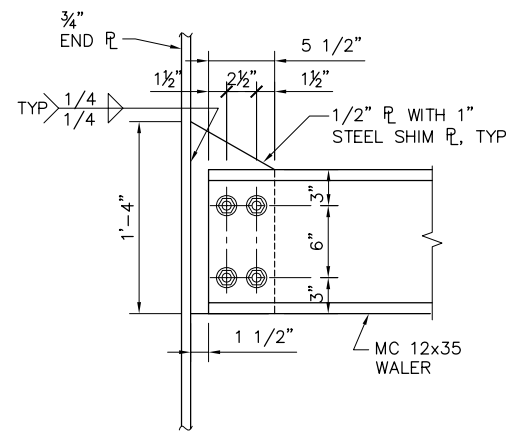


2 DETAIL
SCALE: 1 1/2" = 1'-0"

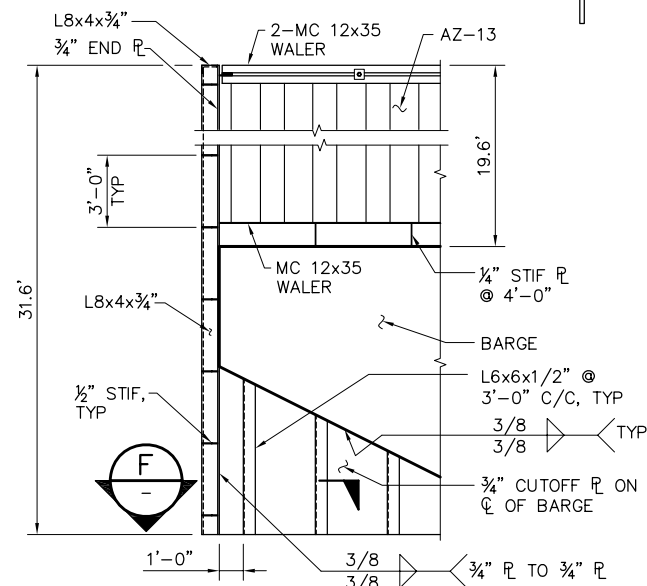



B SECTION
SCALE: 1/4" = 1'-0"

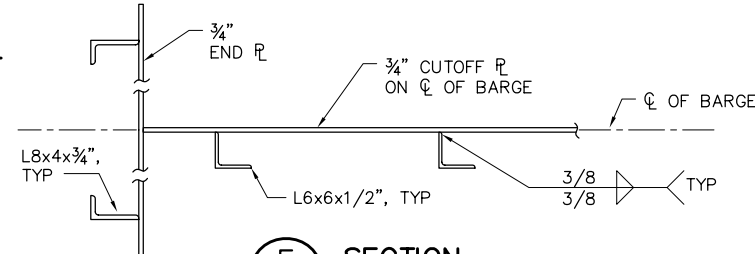

F SECTION
SCALE: 3/4" = 1'-0"

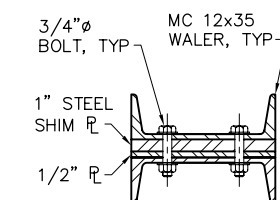


3 DETAIL
SCALE: 1 1/2" = 1'-0"

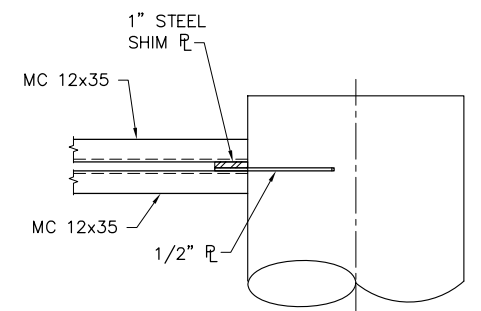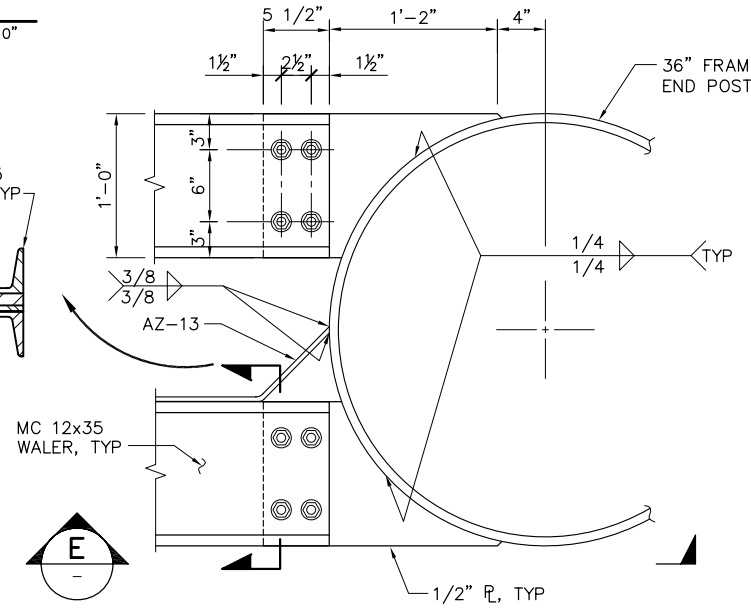

E SECTION
SCALE: 3/4" = 1'-0"

NOTE:
ALL BOLTS ARE ASTM A-307 U.O.N.

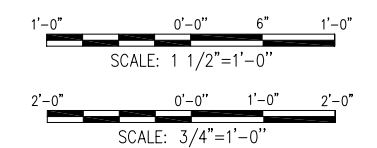

95% SUBMITTAL


IF SHEET IS LESS THAN 22" x 34"
IT IS A REDUCED PRINT -
SCALE REDUCED ACCORDINGLY.

REVISION	DESCRIPTION	BY	DATE


 Moffatt & Nichol		2001 N. Main Street, Suite 360 Walnut Creek, California 94596 (925) 944-5411	
DSGN	JMB	DR	AB
JOB NO.	6097-03	SUBMITTED BY	RMR
CHK	TDB	TITLE	

TWO GATE FISH PROTECTION PLAN		DATE	08/07/09
OLD RIVER END WALL SCANTLINGS		SHEET	24 OF 75
			C18

P:\6097-03 SWC GATE DESIGN\CADD\DWG\609703-C19.DWG 8/7/2009 9:26 AM

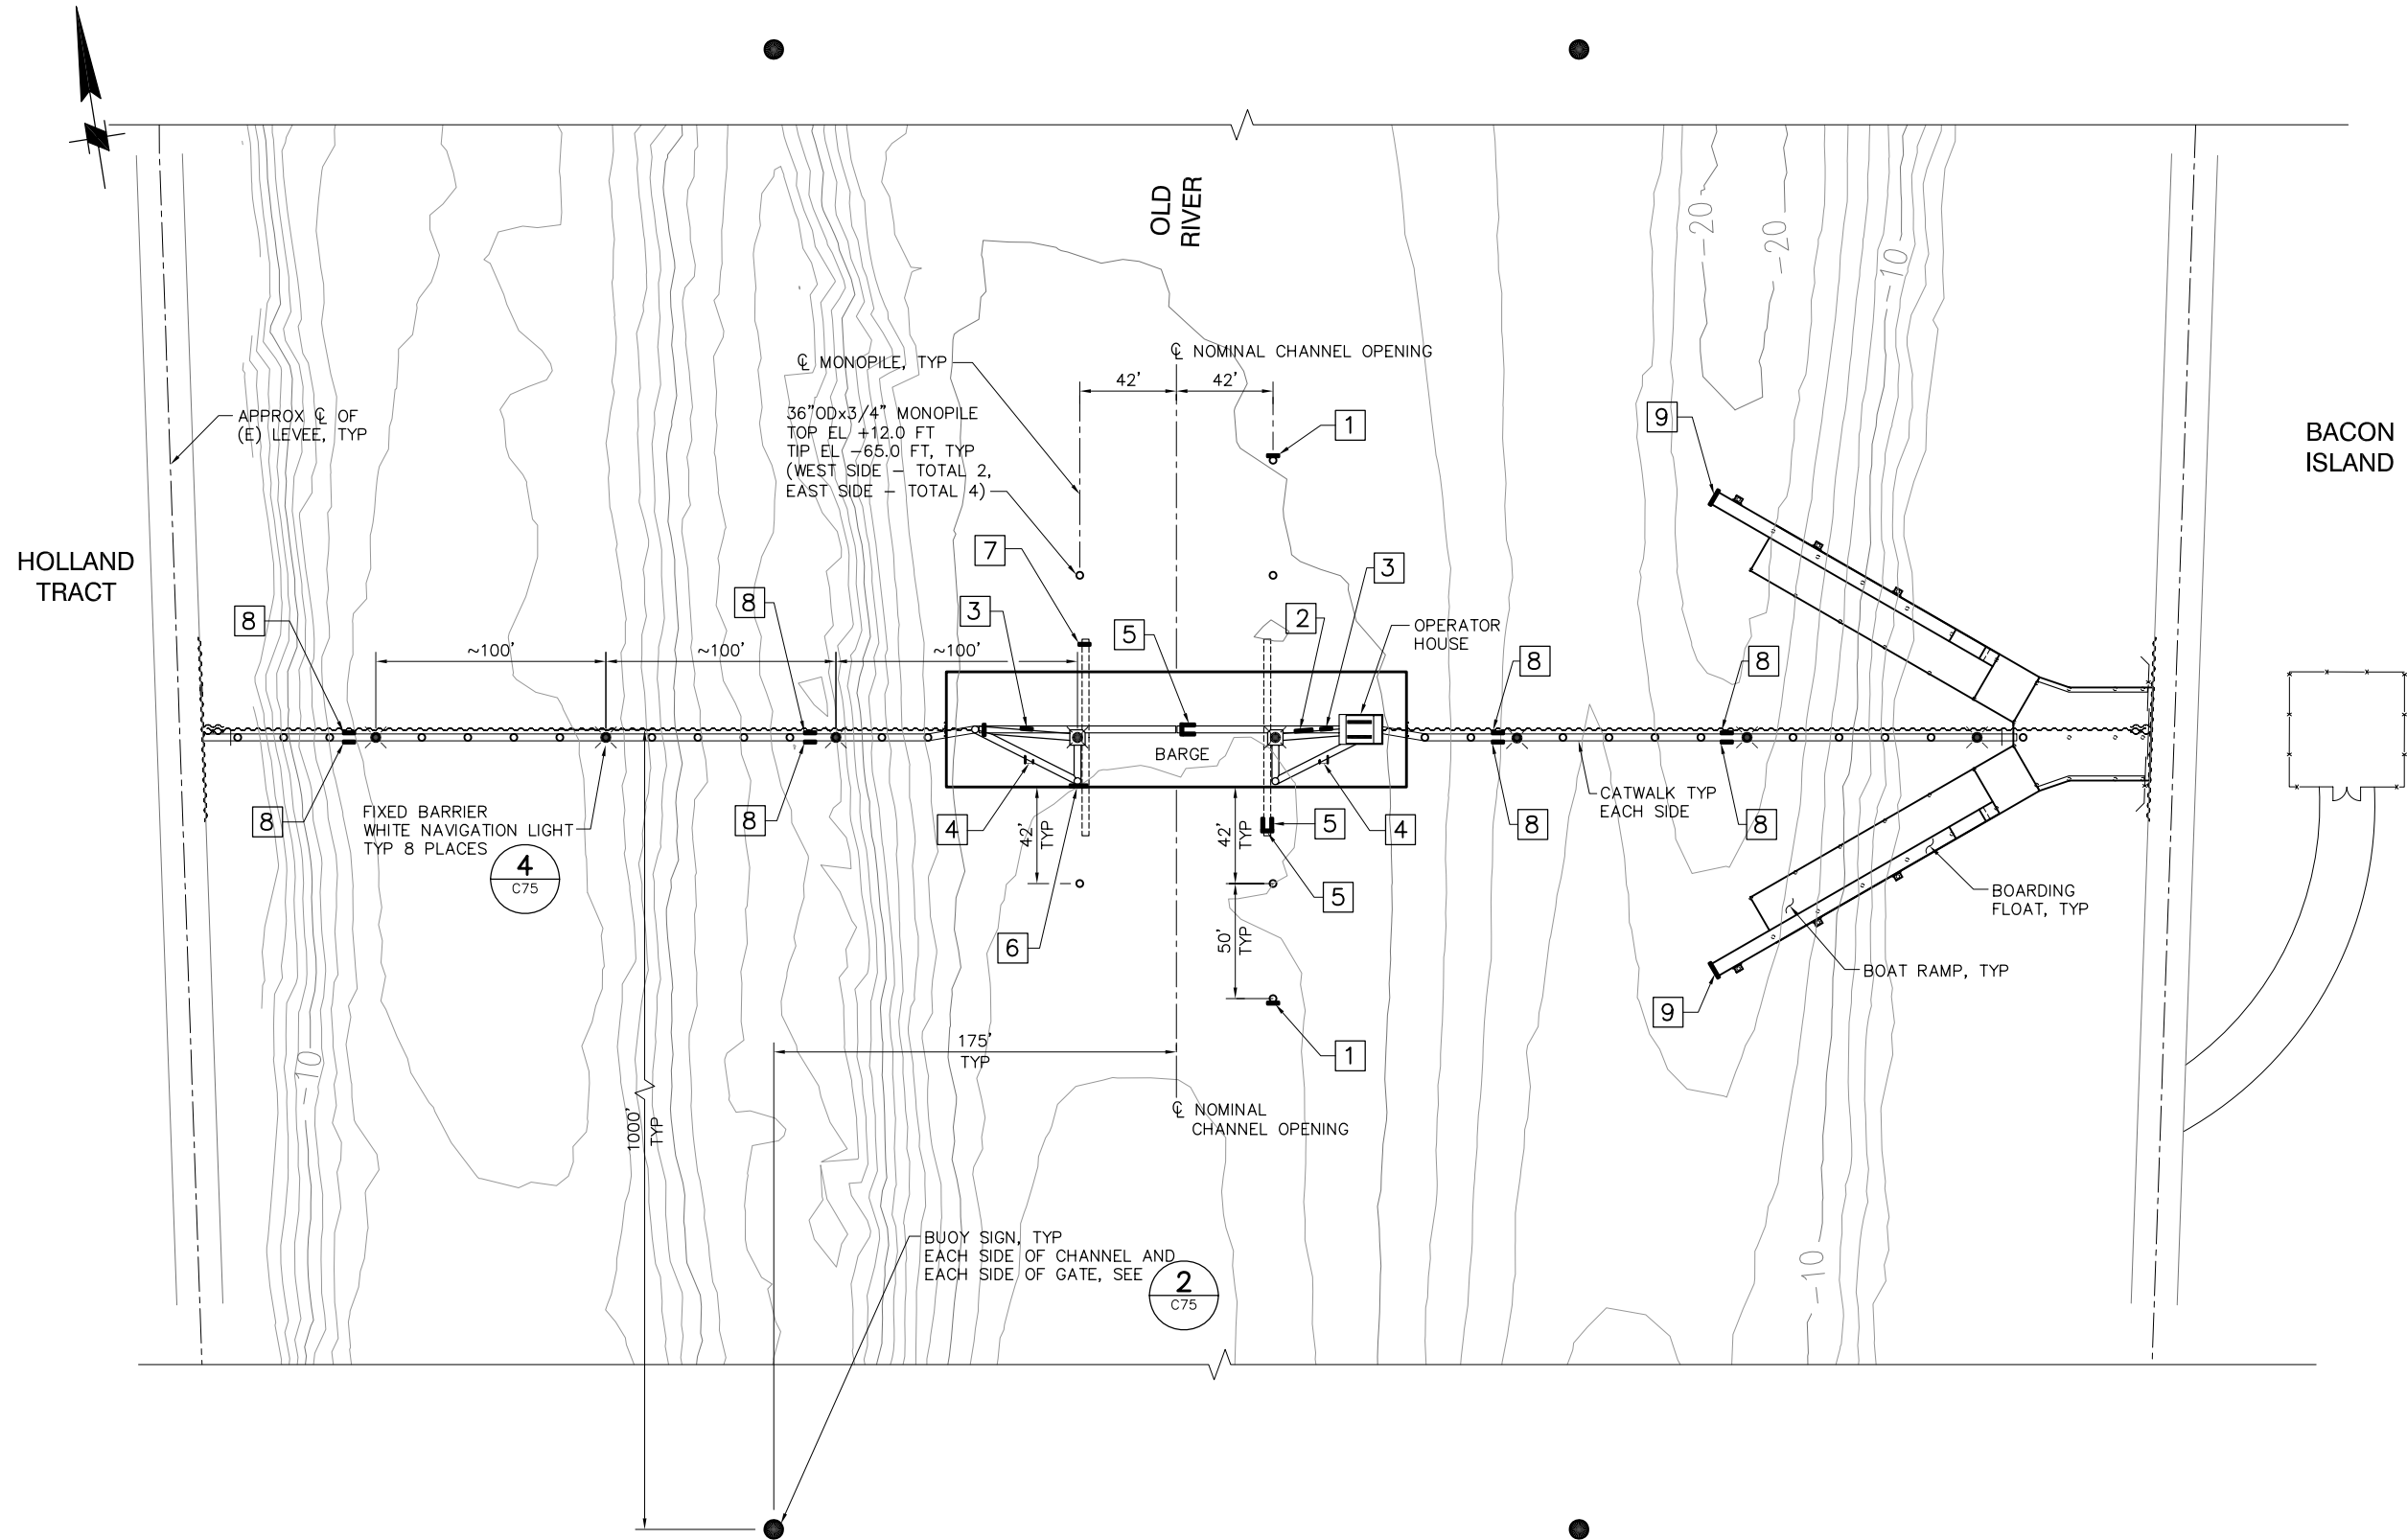

PLAN
SCALE: 1"= 40'

 

SIGN DATA

LOCATION	SIGN	SIGN DETAIL	SIGN MOUNTING DETAIL
1	GATE 5 MPH	1 C75	1 C76
2	GATE WARNING SIGN	5 C75	5 C76
3	DANGER SIGN	7 C75	5 C76
4	DANGER SIGN	7 C75	3 C76
5	GATE POSITION SIGNS "GATES OPEN" "GATES CLOSED"	6 C75	2 C74
6	GATE WARNING SIGN	5 C75	2 C76
7	GATE POSITION SIGN "GATES OPEN"	6 C75	4 C76
8	STAY BACK WARNING SIGN	9 C75	5 C76
9	BOAT RAMP DOCK SIGN	3 C75	6 C76

95% SUBMITTAL

IF SHEET IS LESS THAN 22" x 34"
IT IS A REDUCED PRINT -
SCALE REDUCED ACCORDINGLY.

REVISION	DESCRIPTION	BY	DATE


 Moffatt & Nichol		2001 N. Main Street, Suite 360 Walnut Creek, California 94596 (925) 944-5411	
DSGN	RBD	DR	AB
JOB NO.	6097-03	SUBMITTED BY	RMR
CHK	TDB	TITLE	

TWO GATE FISH PROTECTION PLAN		DATE 08/07/09
OLD RIVER AIDS TO NAVIGATION PLAN		SHEET 25 OF 75
		C19

P:\6097-03 SWC GATE DESIGN\CADD\DWG\609703-C21.DWG 8/6/2009 8:48 AM



HOLLAND
TRACT

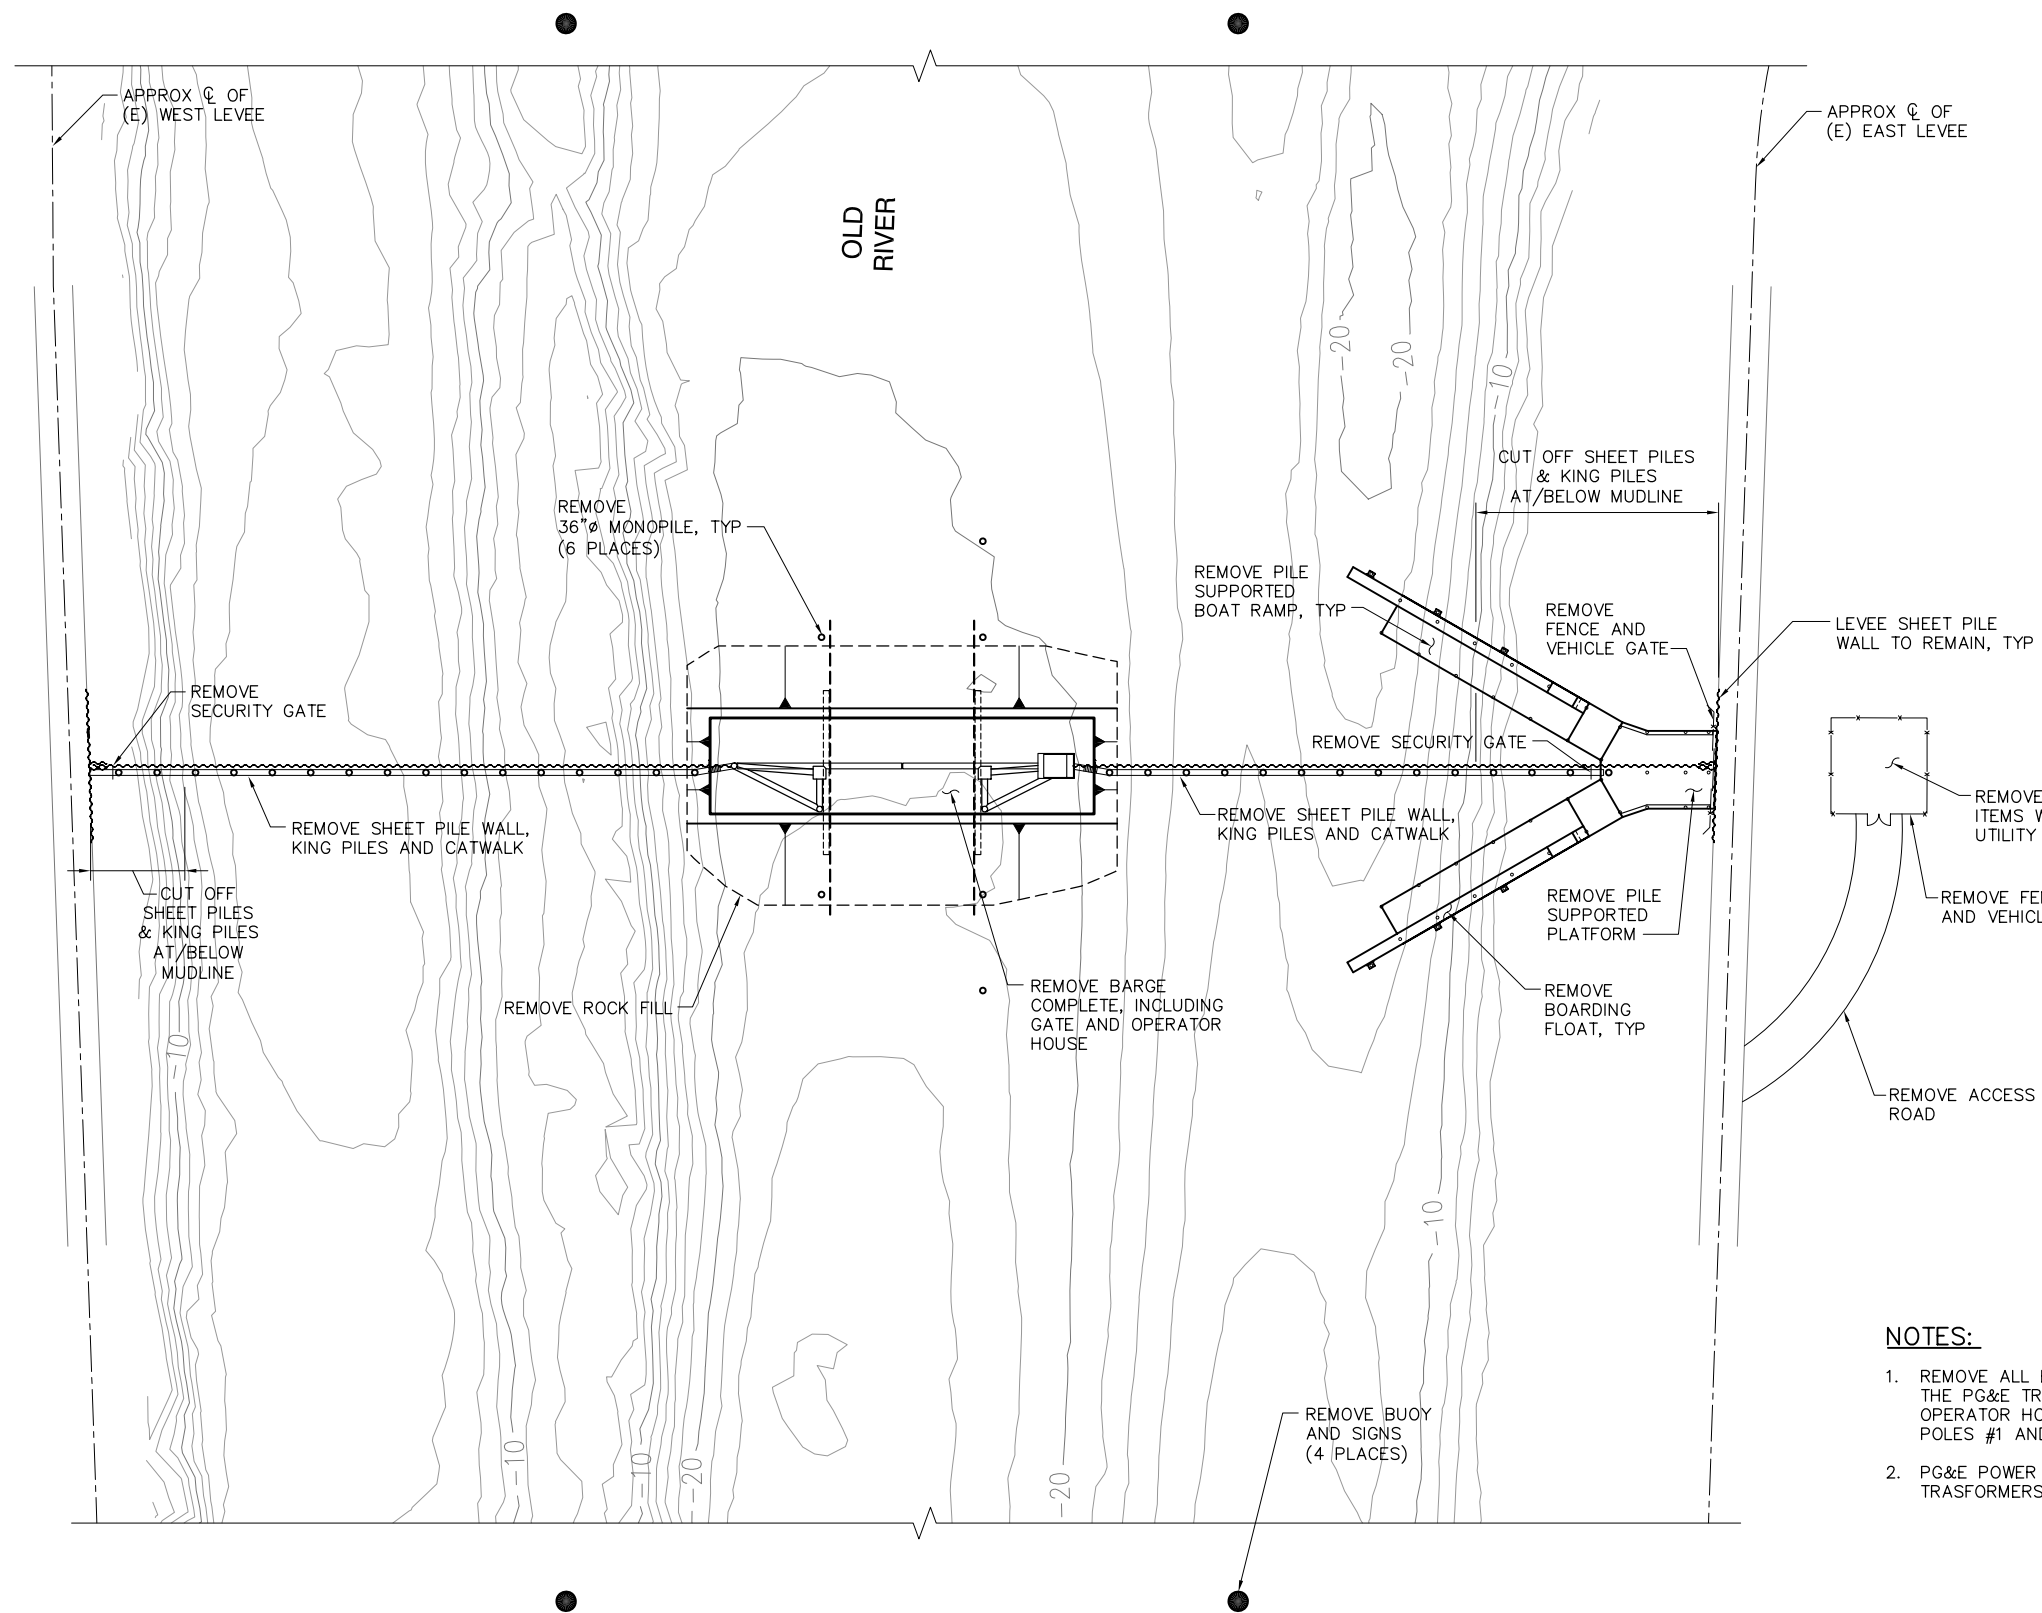


BACON
ISLAND

NOTES:

1. REMOVE ALL ELECTRICAL WIRING FROM THE PG&E TRANSFORMERS TO THE OPERATOR HOUSE. REMOVE LIGHT POLES #1 AND #2.
2. PG&E POWER POLE AND TRASFORMERS TO REMAIN.

 REMOVAL PLAN
SCALE: 1"= 50'



95% SUBMITTAL

IF SHEET IS LESS THAN 22" x 34"
IT IS A REDUCED PRINT -
SCALE REDUCED ACCORDINGLY.


REVISION	DESCRIPTION	BY	DATE

 Moffatt & Nichol		2001 N. Main Street, Suite 360 Walnut Creek, California 94596 (925) 944-5411	
DSGN	TDB	DR	EP
JOB NO.	6097-03	SUBMITTED BY	RMR
CHK	GTH	TITLE	

TWO GATE FISH PROTECTION PLAN
OLD RIVER REMOVAL PLAN

DATE 08/07/09
SHEET 27 OF 75
C21

P:\6097-03 SWC GATE DESIGN\CADD\DWG\609703-C31.DWG 8/6/2009 8:52 AM

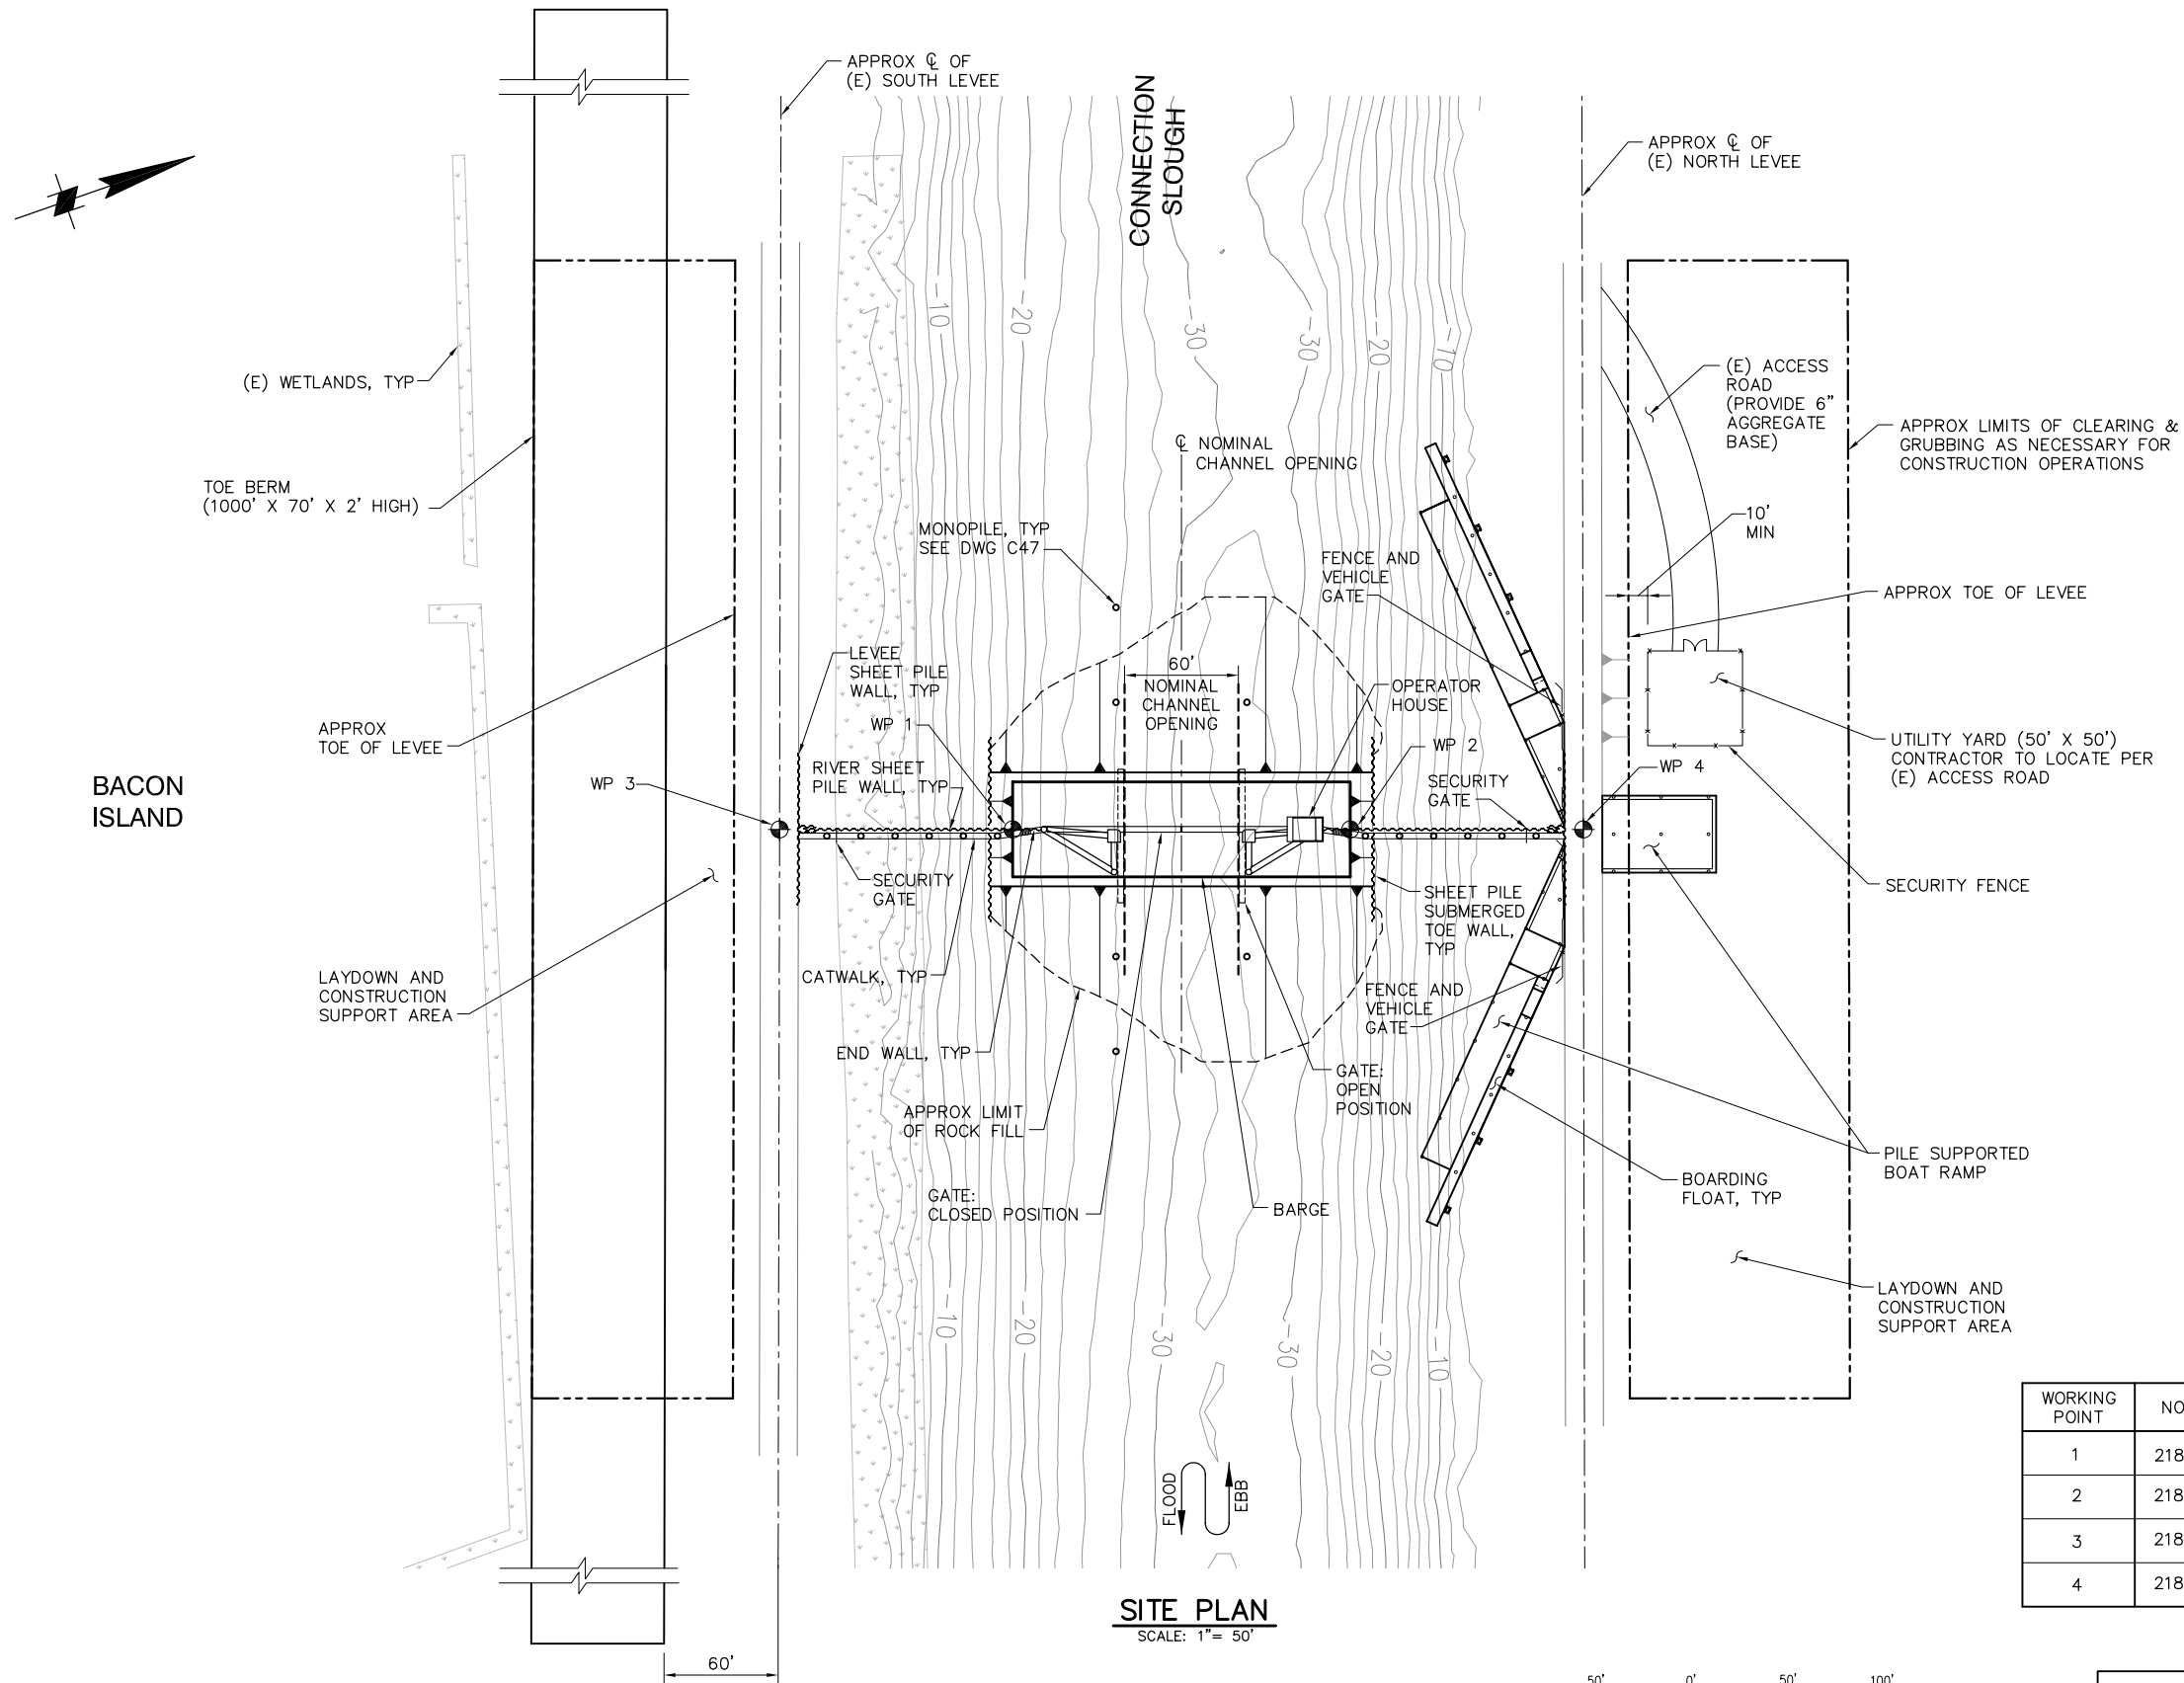

SITE PLAN
SCALE: 1"= 50'

WORK POINT DATA

WORKING POINT	NORTHING	EASTING	FEATURE
1	2189371.89	6265762.17	CL OF SOUTH SIDE OF BARGE
2	2189539.90	6265820.98	CL OF NORTH SIDE OF BARGE
3	2189255.91	6265721.56	CL OF SOUTH LEVEE AND GATE
4	2189655.88	6265861.59	CL OF NORTH LEVEE AND GATE

95% SUBMITTAL

IF SHEET IS LESS THAN 22" x 34"
IT IS A REDUCED PRINT -
SCALE REDUCED ACCORDINGLY.

REVISION	DESCRIPTION	BY	DATE



2001 N. Main Street, Suite 360
Walnut Creek, California 94596
(925) 944-5411

DSGN	TDB	DR	EP	CHK	GTH
JOB NO.	6097-03	SUBMITTED BY	RMR	TITLE	

TWO GATE FISH PROTECTION PLAN



DATE 08/07/09

SHEET 28 OF 75

**CONNECTION SLOUGH
SITE PLAN**

C31

P:\6097-03 SWC GATE DESIGN\CADD\DWG\609703-C32.DWG 7/28/2009 1:59 PM

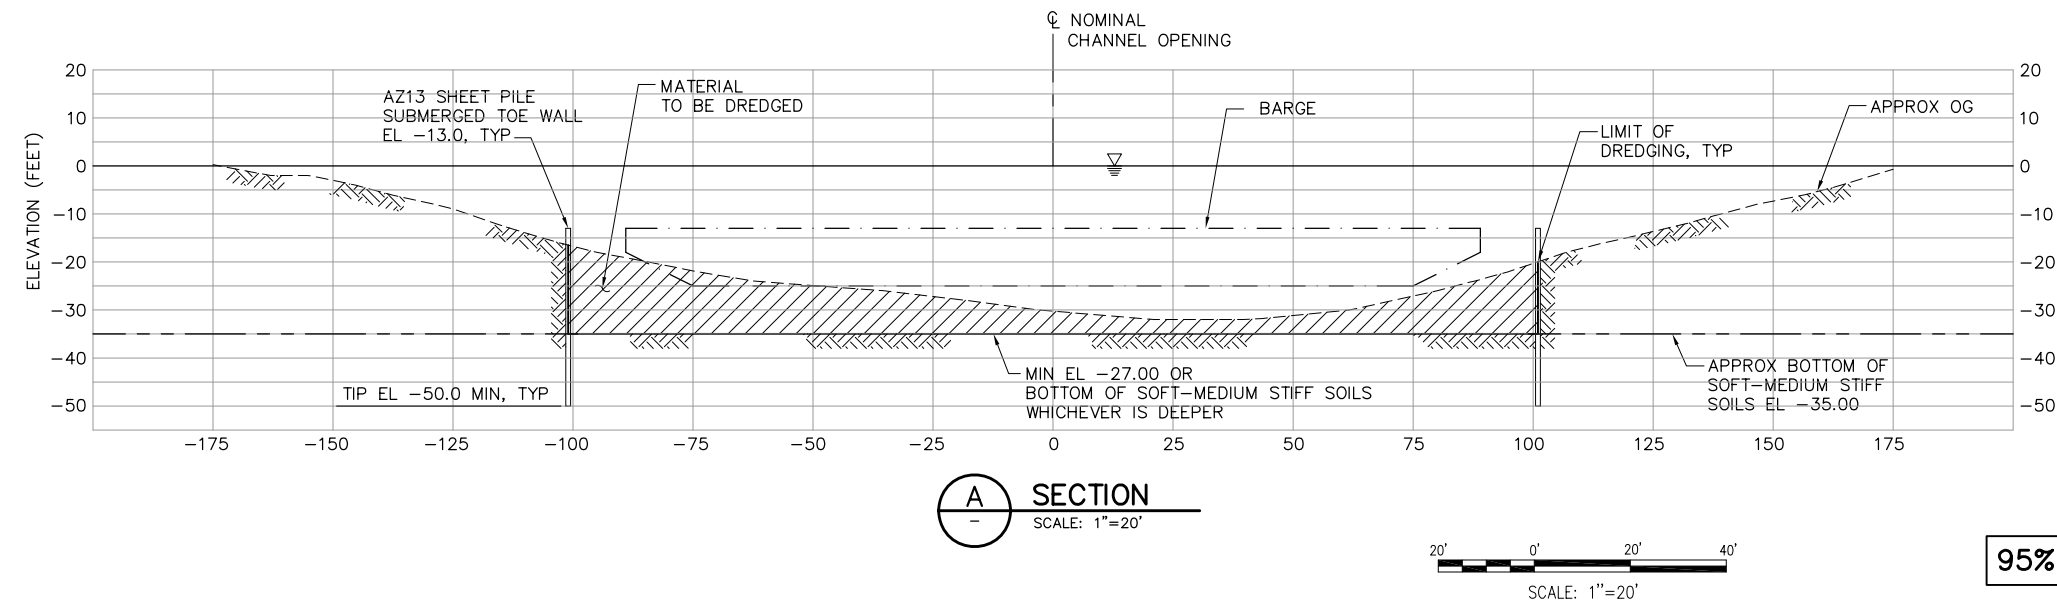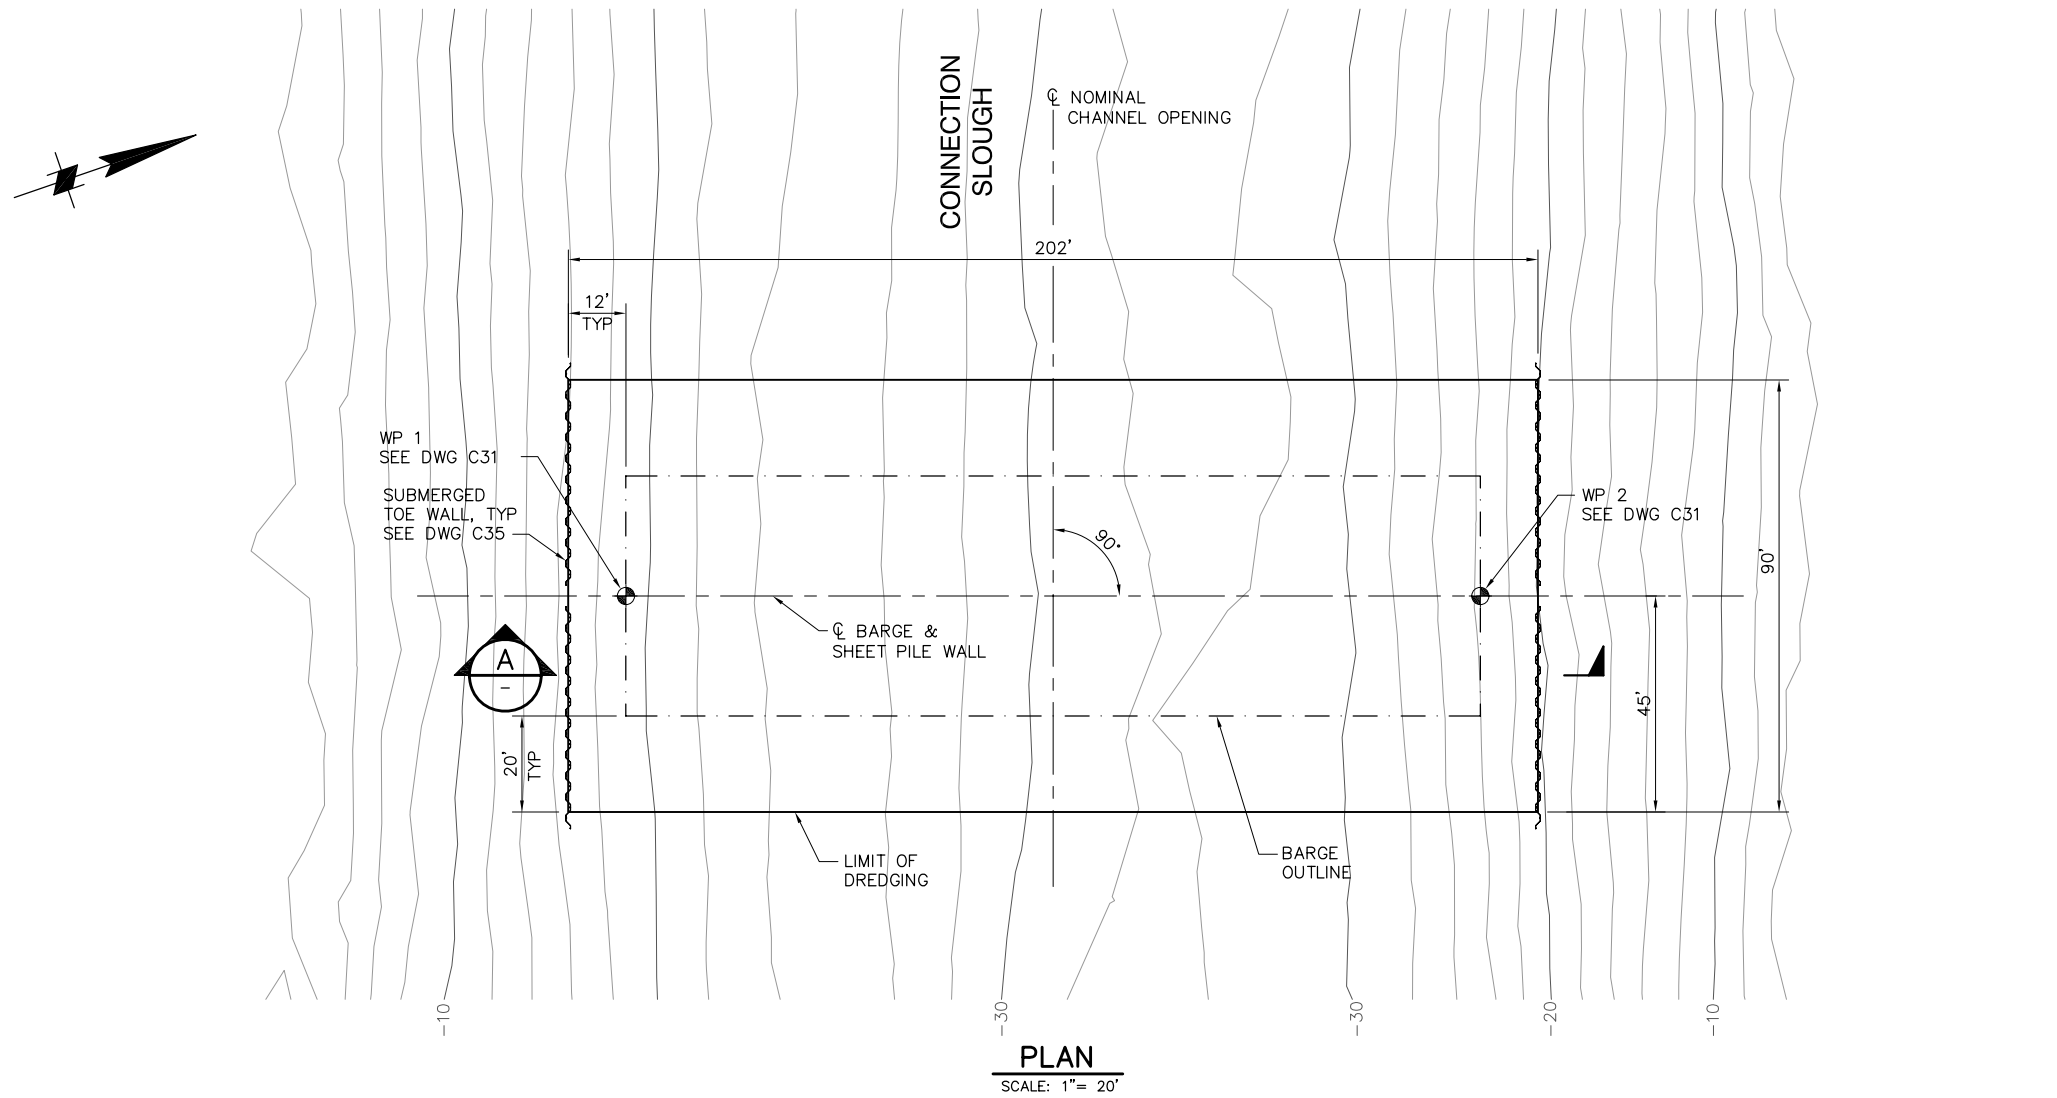

NOTE:
GATE AND ALL OTHER FEATURES
NOT SHOWN FOR CLARITY.

95% SUBMITTAL IF SHEET IS LESS THAN 22" x 34"
IT IS A REDUCED PRINT -
SCALE REDUCED ACCORDINGLY.





REVISION	DESCRIPTION	BY	DATE

 Moffatt & Nichol		2001 N. Main Street, Suite 360 Walnut Creek, California 94596 (925) 944-5411	
DSGN	TDB	DR	EP/AB
JOB NO.	6097-03	SUBMITTED BY	RMR
CHK	GTH	TITLE	


TWO GATE FISH PROTECTION PLAN	
CONNECTION SLOUGH DREDGING PLAN AND SECTION	

DATE	08/07/09
SHEET	29 OF 75
C32	

P:\6097-03 SWC GATE DESIGN\CADD\DWG\609703-C33.DWG 7/28/2009 1:59 PM

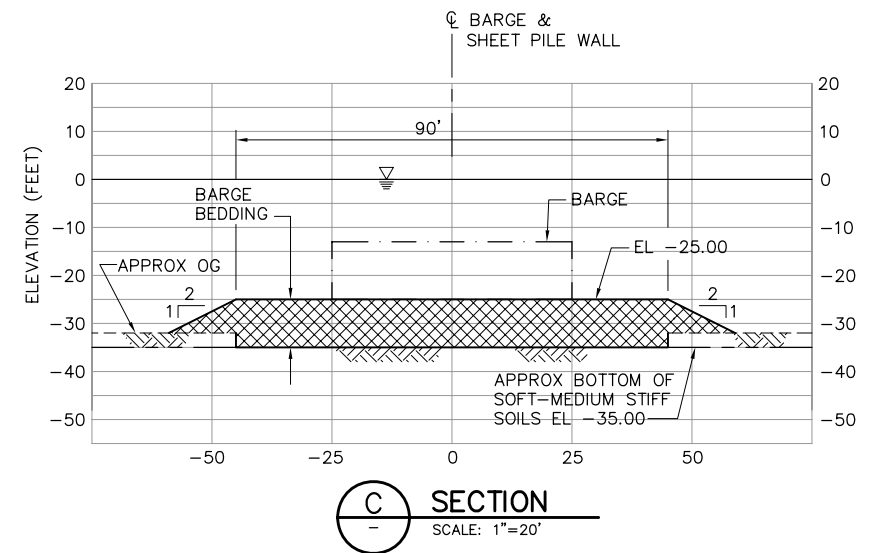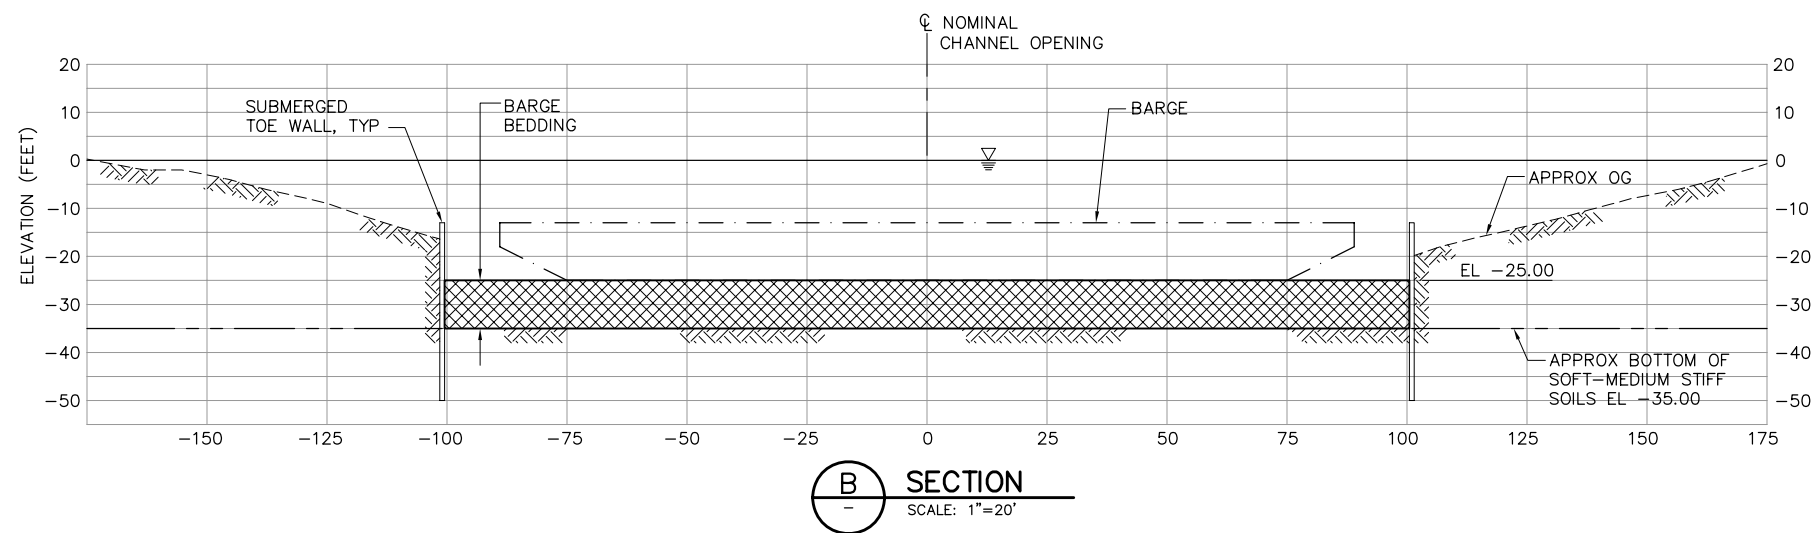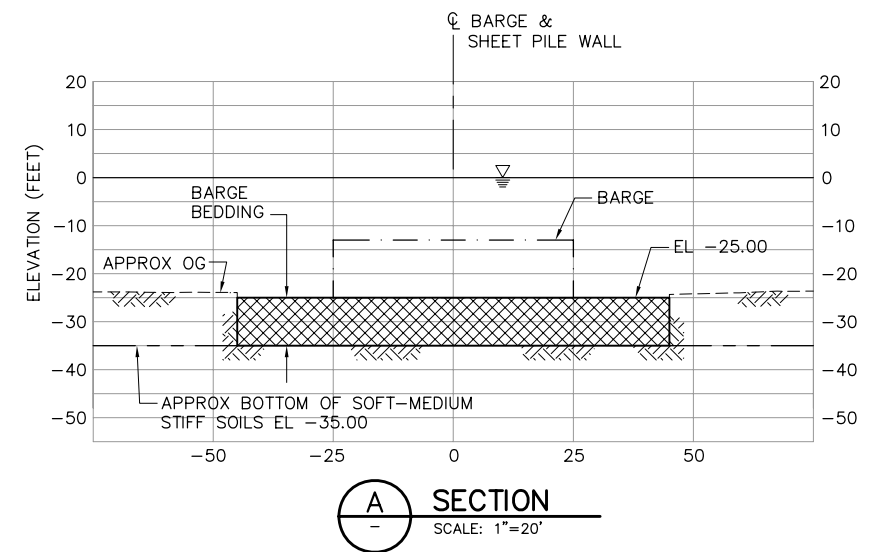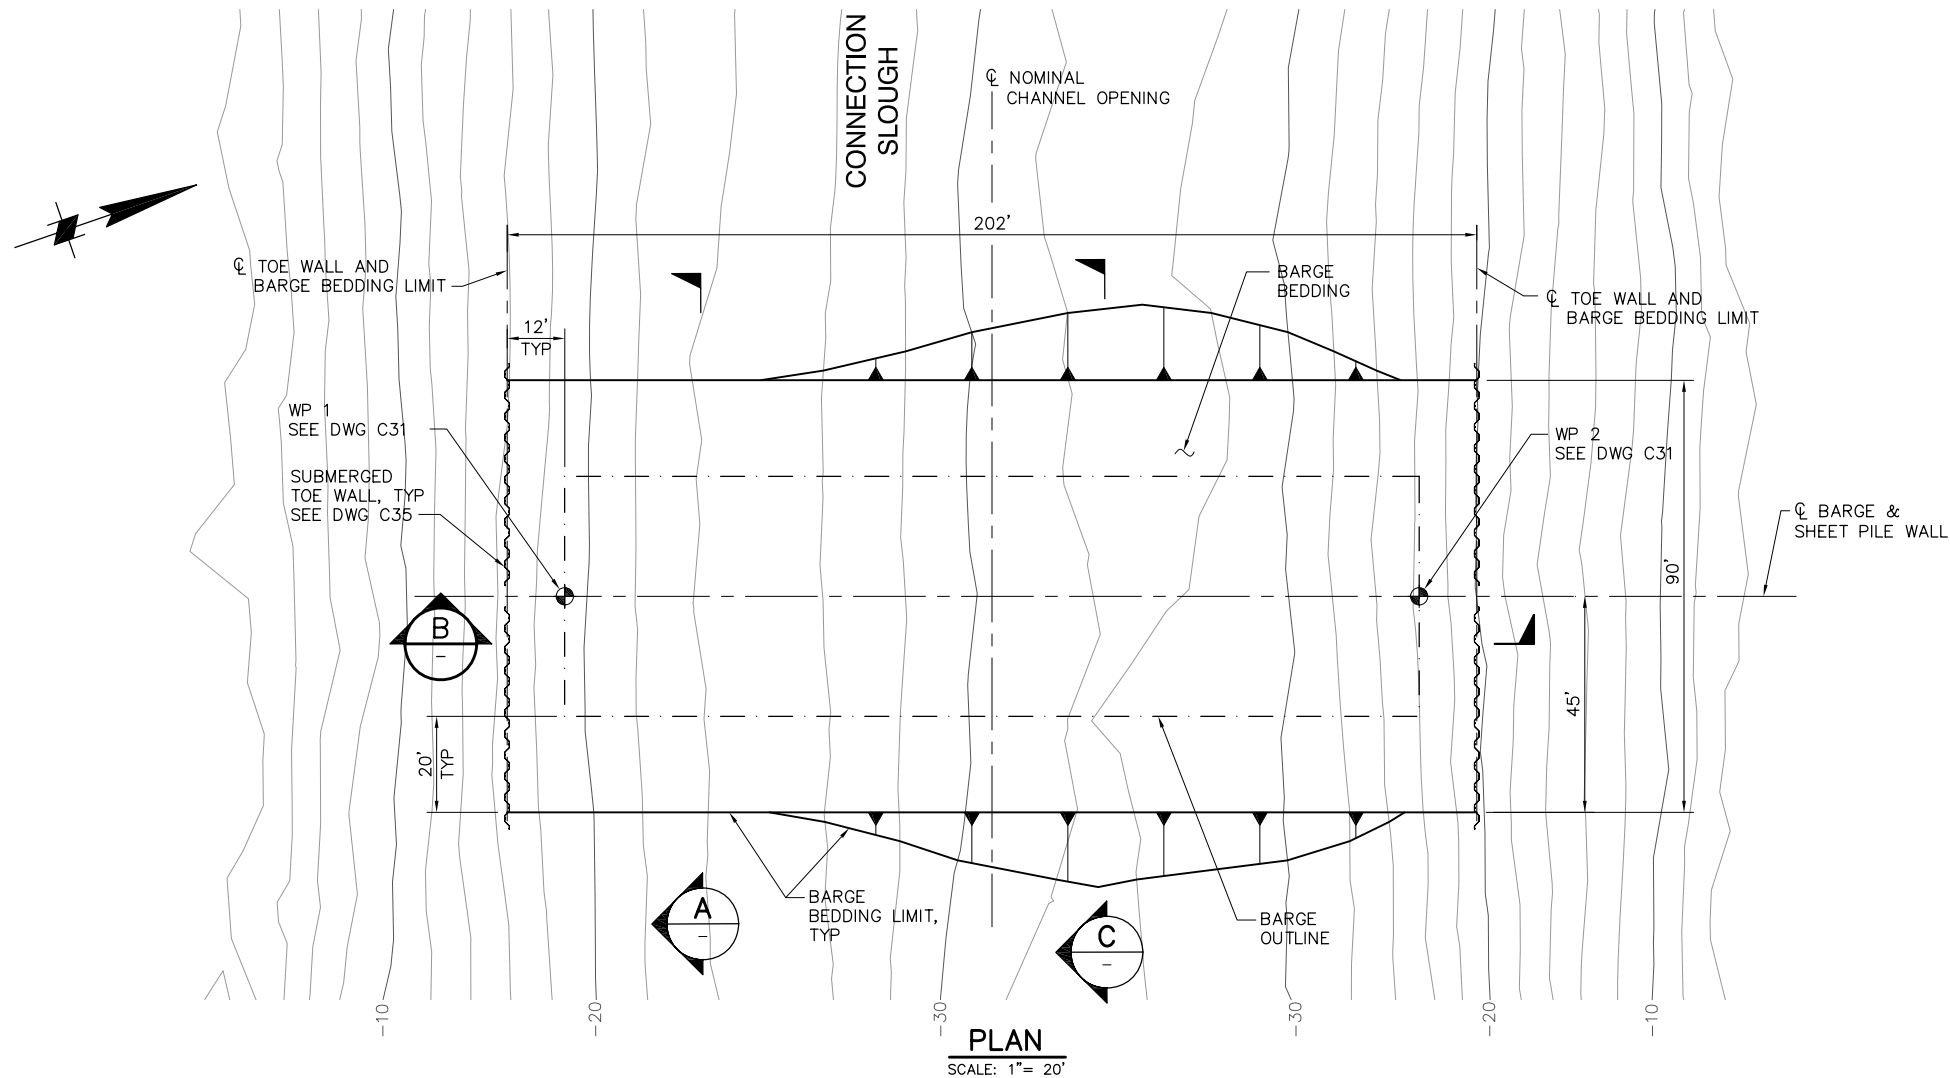

 NOTE:
GATE AND ALL OTHER FEATURES
NOT SHOWN FOR CLARITY.




95% SUBMITTAL IF SHEET IS LESS THAN 22" x 34"
IT IS A REDUCED PRINT -
SCALE REDUCED ACCORDINGLY.

REVISION	DESCRIPTION	BY	DATE			Moffatt & Nichol 2001 N. Main Street, Suite 360 Walnut Creek, California 94596 (925) 944-5411		TWO GATE FISH PROTECTION PLAN		DATE 08/07/09
										SHEET 30 OF 75
								CONNECTION SLOUGH, BARGE BEDDING PLAN		C33
						DSGN TDB	DR EP/AB	CHK GTH		
						JOB NO. 6097-03	SUBMITTED BY RMR		TITLE	


P:\6097-03 SWC GATE DESIGN\CADD\DWG\609703-C34.DWG 7/24/2009 8:36 AM

BACON
ISLAND

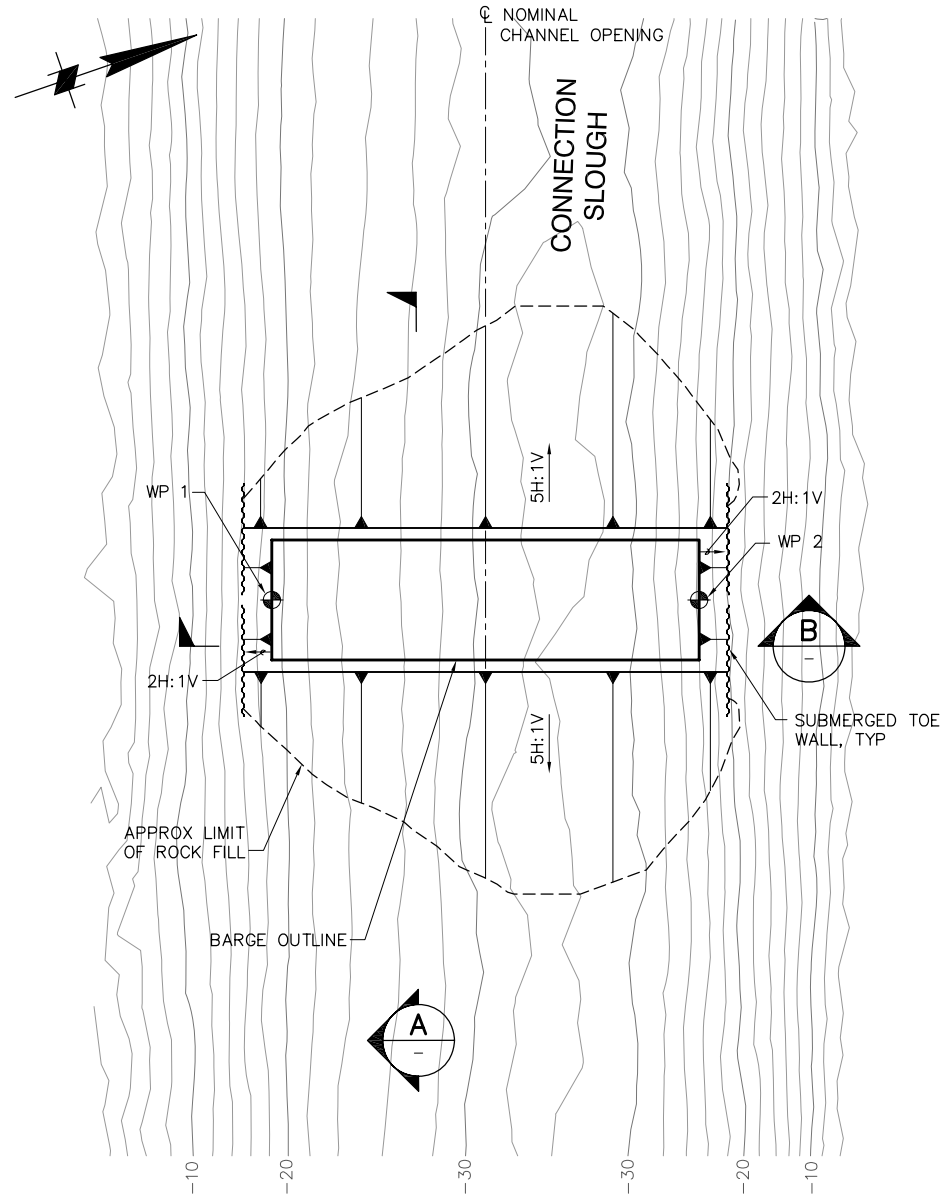


PLAN
SCALE: 1"= 40'

MANDEVILLE
ISLAND

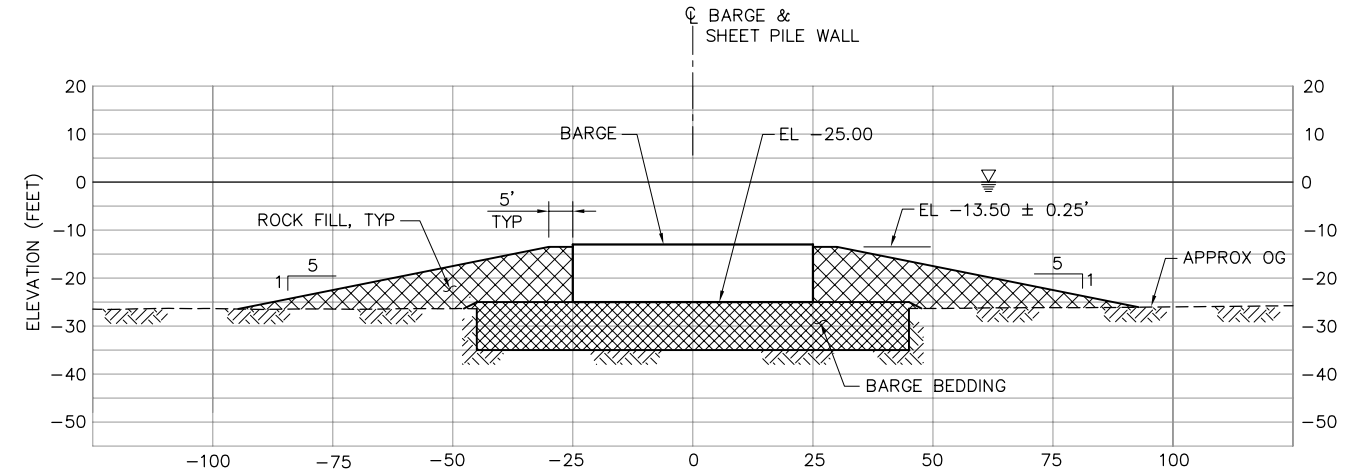


SECTION A
SCALE: 1"=20'

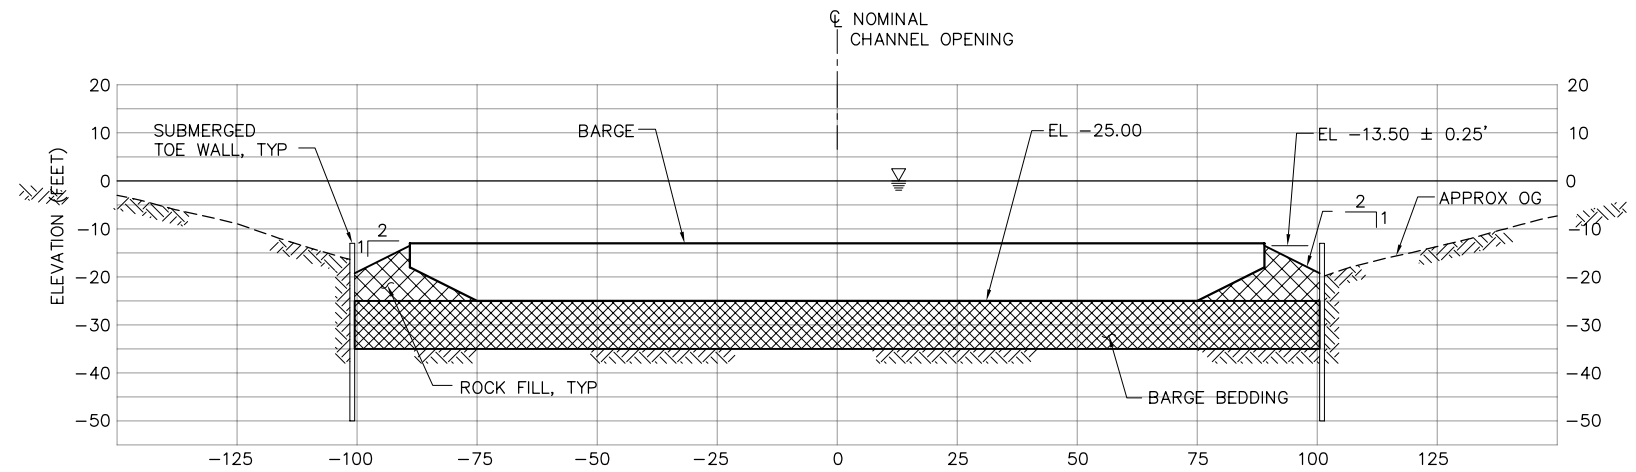

SECTION B
SCALE: 1"=20'

NOTES:

 1. KING PILES AND SHEET PILES NEAR BARGE SHALL BE PLACED BEFORE ROCK FILL.
2. GATE AND ALL OTHER FEATURES NOT SHOWN FOR CLARITY.



95% SUBMITTAL





IF SHEET IS LESS THAN 22" x 34"
IT IS A REDUCED PRINT -
SCALE REDUCED ACCORDINGLY.

REVISION	DESCRIPTION	BY	DATE

 Moffatt & Nichol		2001 N. Main Street, Suite 360 Walnut Creek, California 94596 (925) 944-5411	
DSGN	JMB	DR	EP/AB
JOB NO.	6097-03	SUBMITTED BY	RMR
CHK	TDB	TITLE	

TWO GATE FISH PROTECTION PLAN		DATE 08/07/09
CONNECTION SLOUGH BARGE - ROCK FILL PLAN AND SECTIONS		SHEET 31 OF 75
		C34


P:\6097-03 SWC GATE DESIGN\CADD\DWG\609703-C35.DWG 8/6/2009 9:15 AM

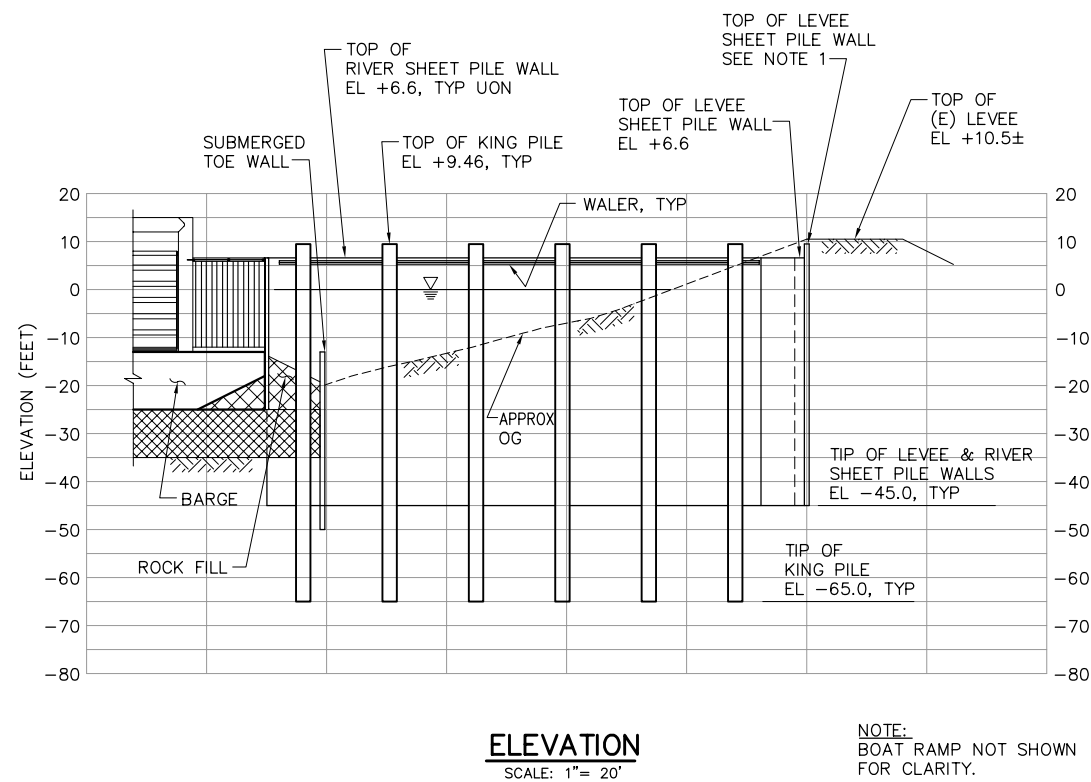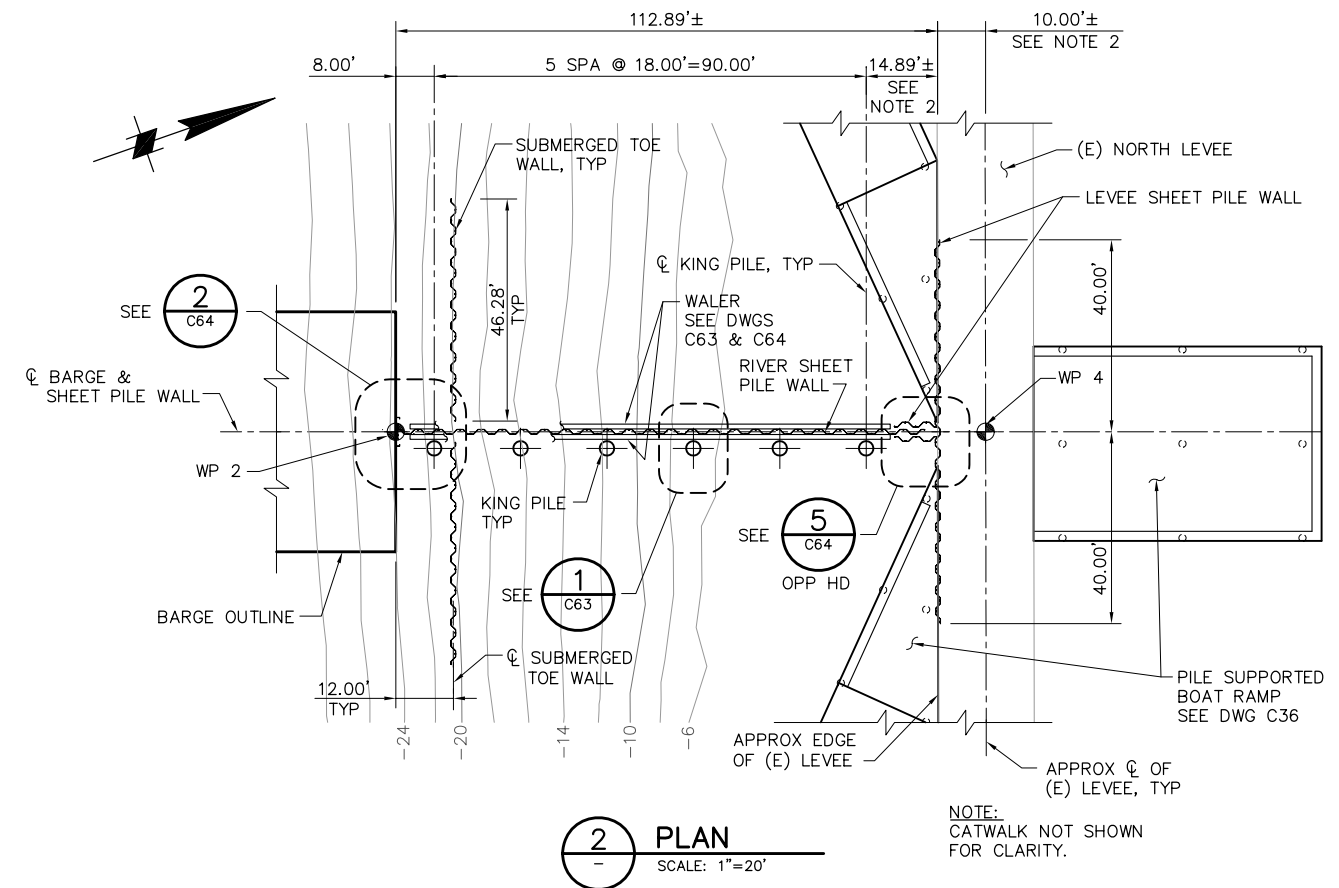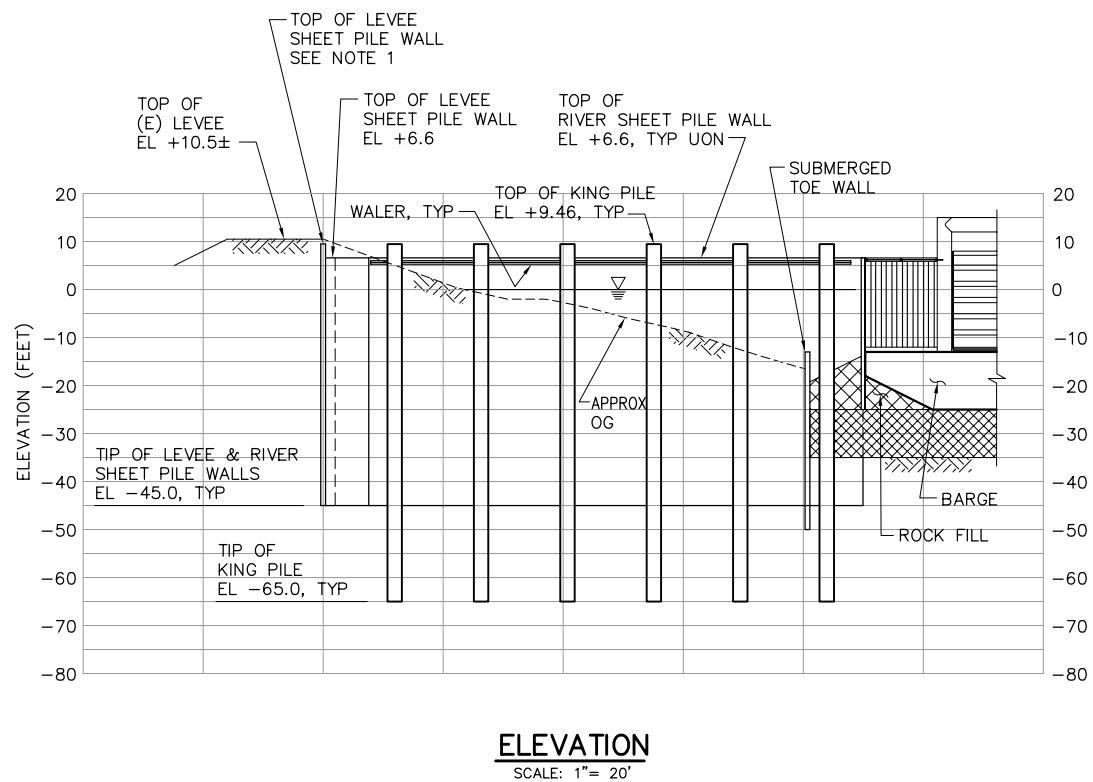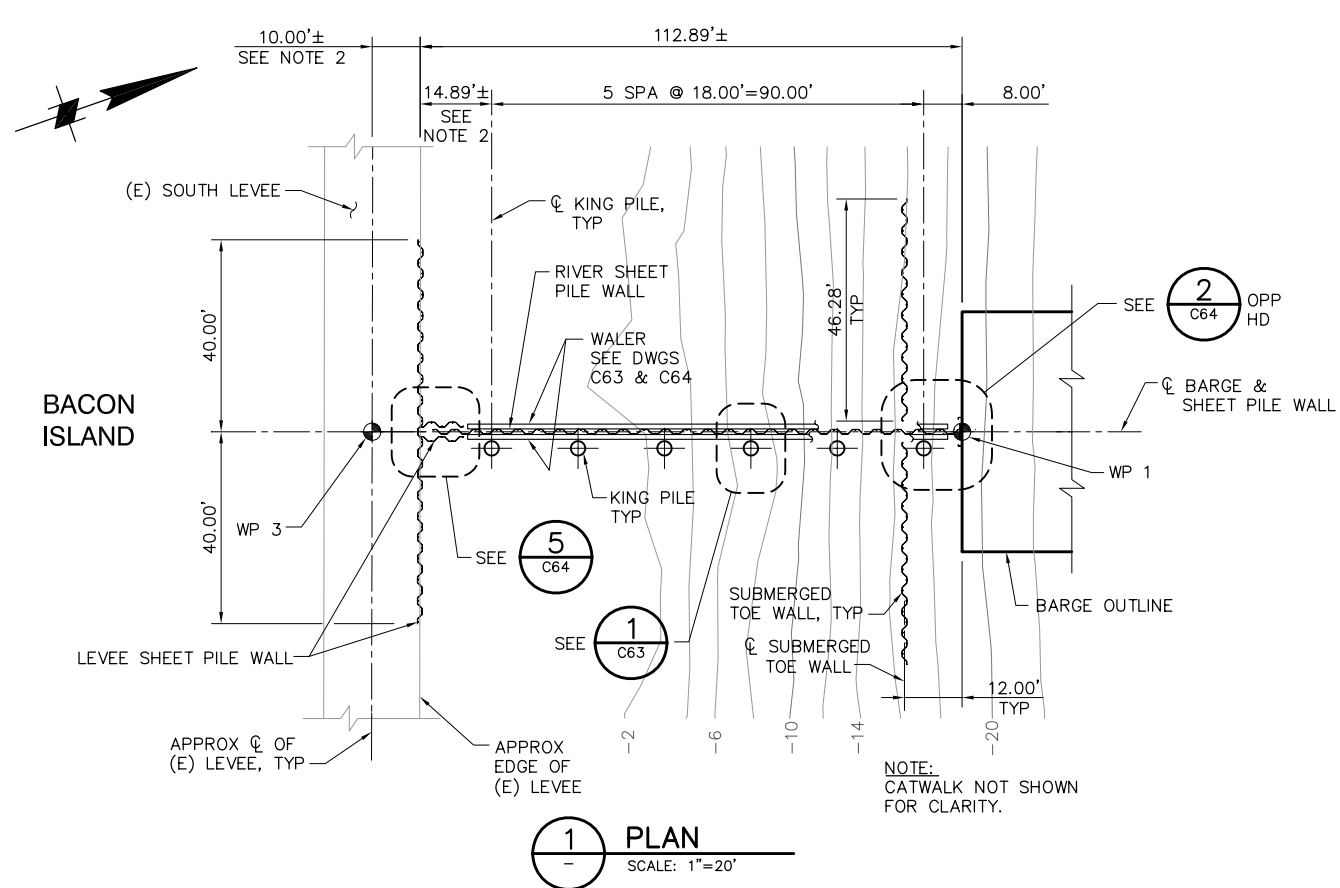

NOTES:

1. TOP OF LEVEE SHEET PILE WALL SHALL BE 6" BELOW TOP OF (E) LEVEE UON.
2. LEVEE SHEET PILE WALL TO BE LOCATED 1 FT MIN OFF THE EDGE OF (E) ROAD SURFACE.

 NOTE:
BOAT RAMP NOT SHOWN
FOR CLARITY.




95% SUBMITTAL

IF SHEET IS LESS THAN 22" x 34"
IT IS A REDUCED PRINT -
SCALE REDUCED ACCORDINGLY.

REVISION	DESCRIPTION	BY	DATE


 2001 N. Main Street, Suite 360 Walnut Creek, California 94596 (925) 944-5411			
DSGN	JMB	DR	EP/AB
JOB NO.	6097-03	SUBMITTED BY	RMR
CHK	TDB	TITLE	

TWO GATE FISH PROTECTION PLAN		DATE 08/07/09
CONNECTION SLOUGH SHEET PILE WALL ARRANGEMENT PLAN AND ELEVATION		SHEET 32 OF 75
C35		

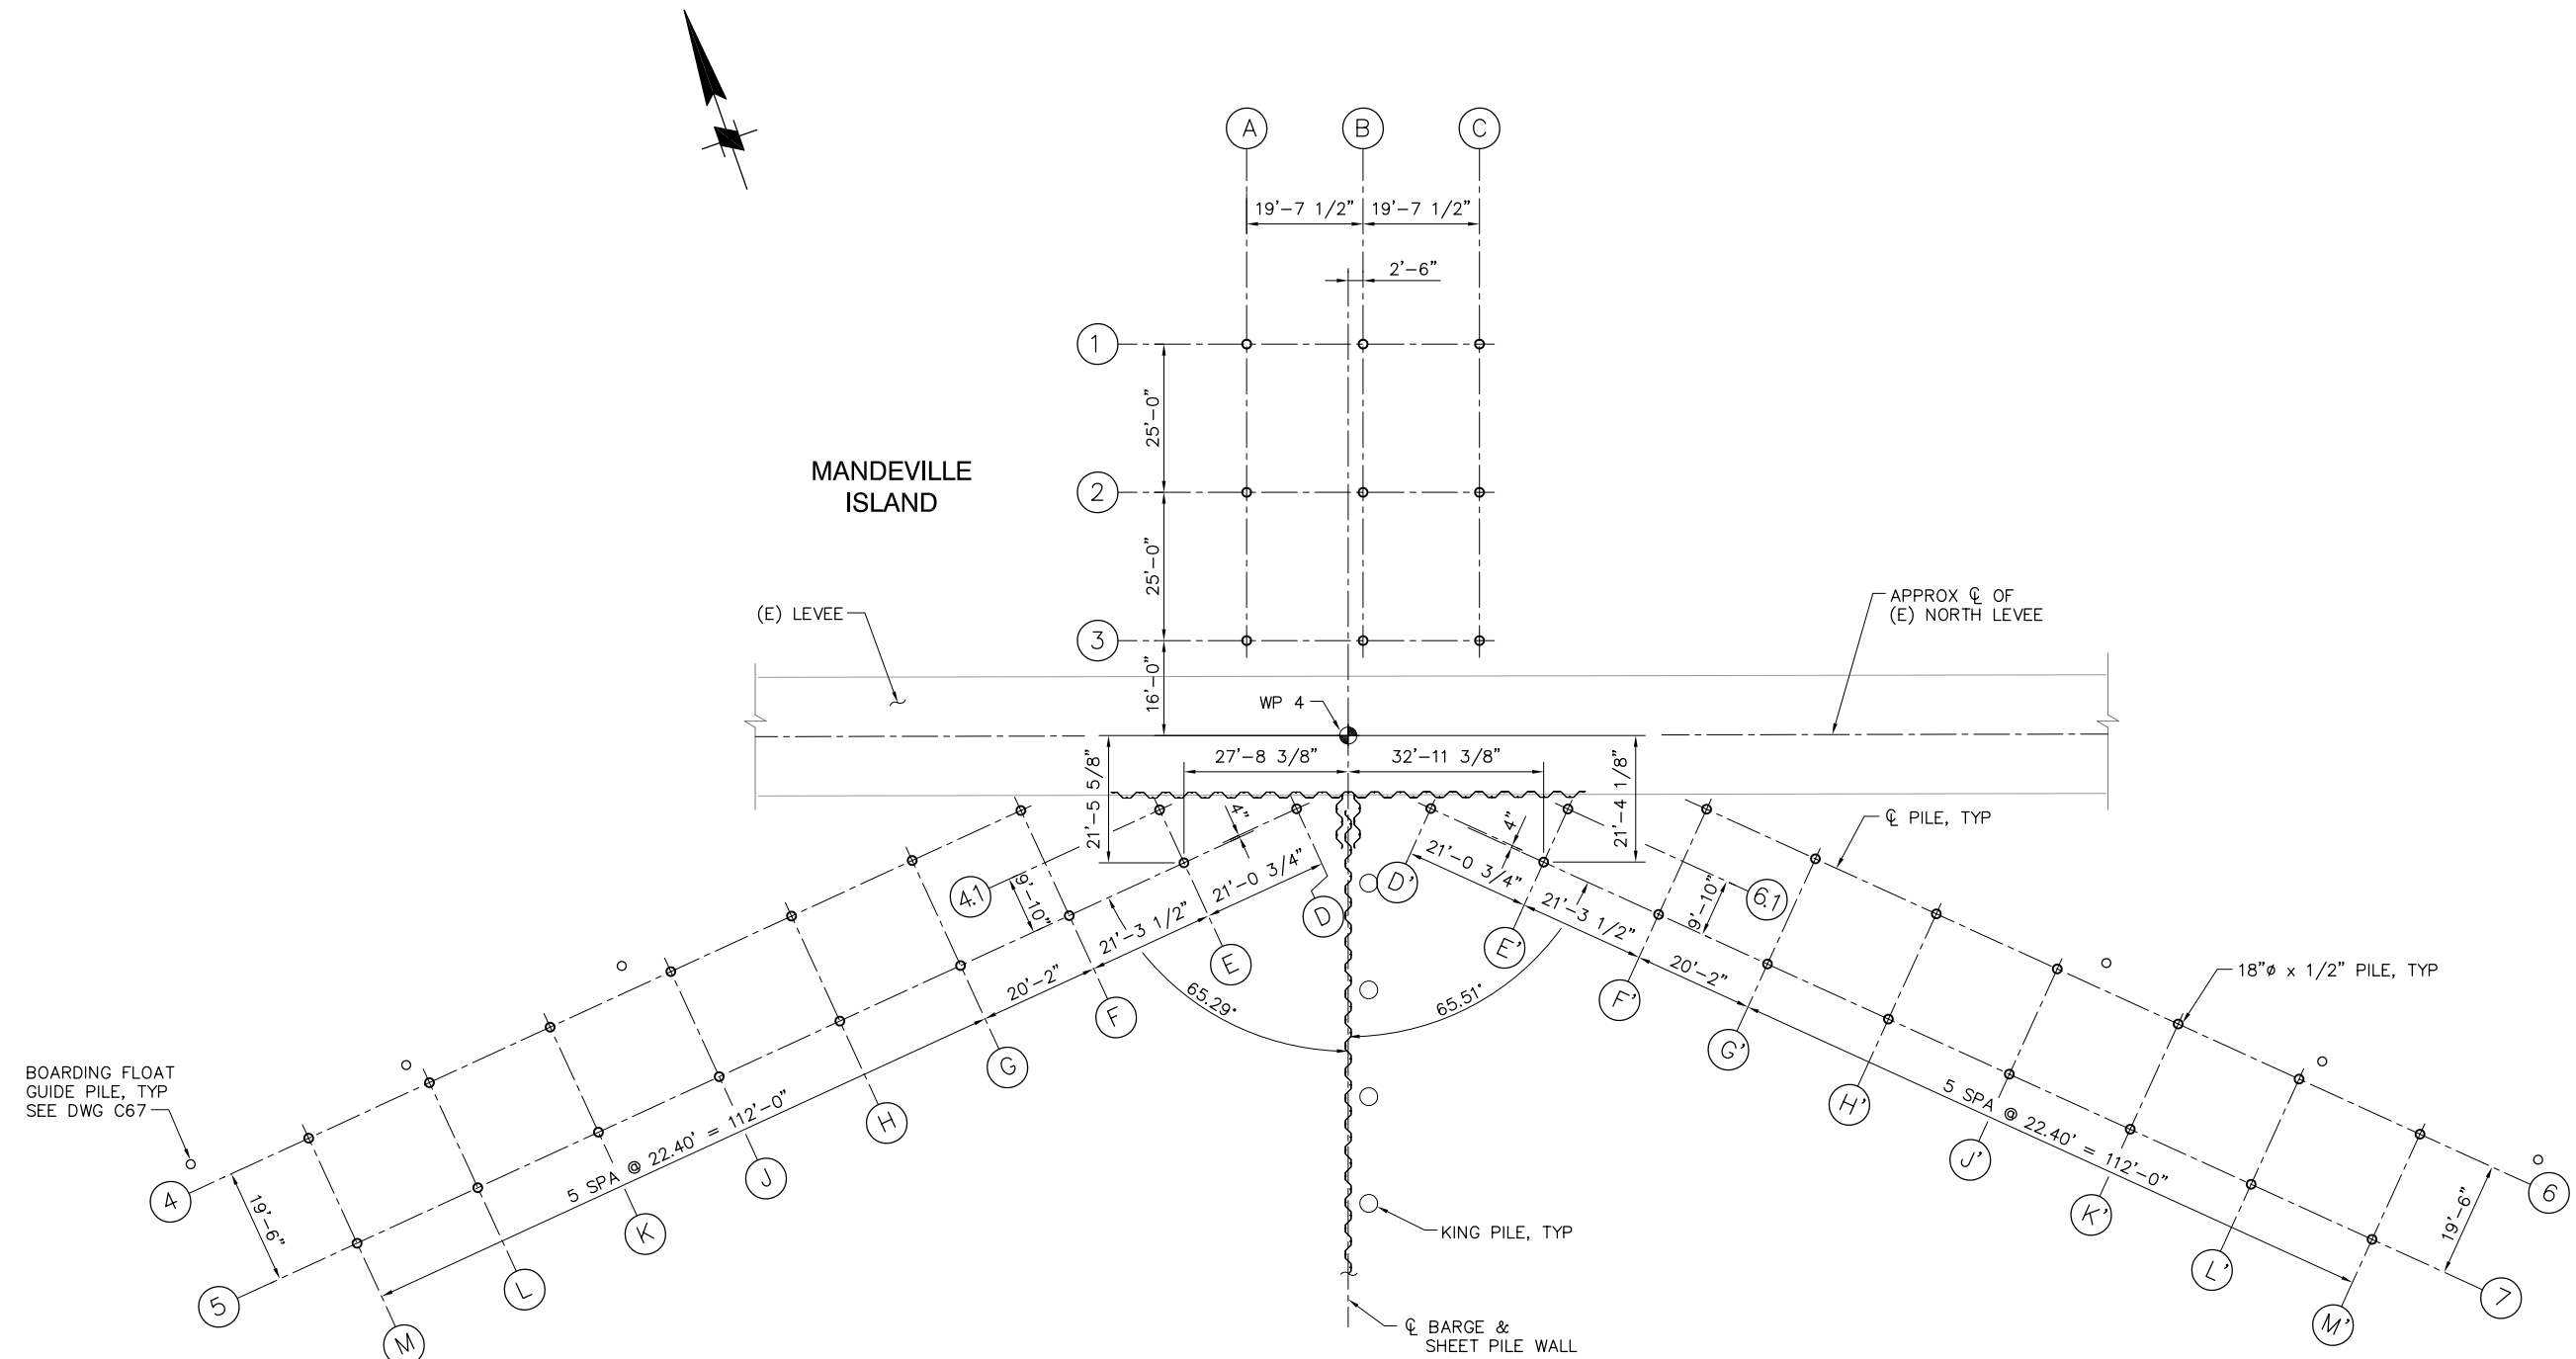

REVISION	DESCRIPTION	BY	DATE	Moffatt & Nichol 2001 N. Main Street, Suite 360 Walnut Creek, California 94596 (925) 944-5411	TWO GATE FISH PROTECTION PLAN		DATE 08/07/09	
							SHEET 34 OF 75	
				DSGN JMB	DR EP	CHK TDB	CONNECTION SLOUGH BOAT RAMP PILE PLAN	C36.1
				JOB NO. 6097-03	SUBMITTED BY RMR	TITLE		

P:\6097-03 SWC GATE DESIGN\CADD\DWG\609703-C36.2.DWG 8/5/2009 4:16 PM

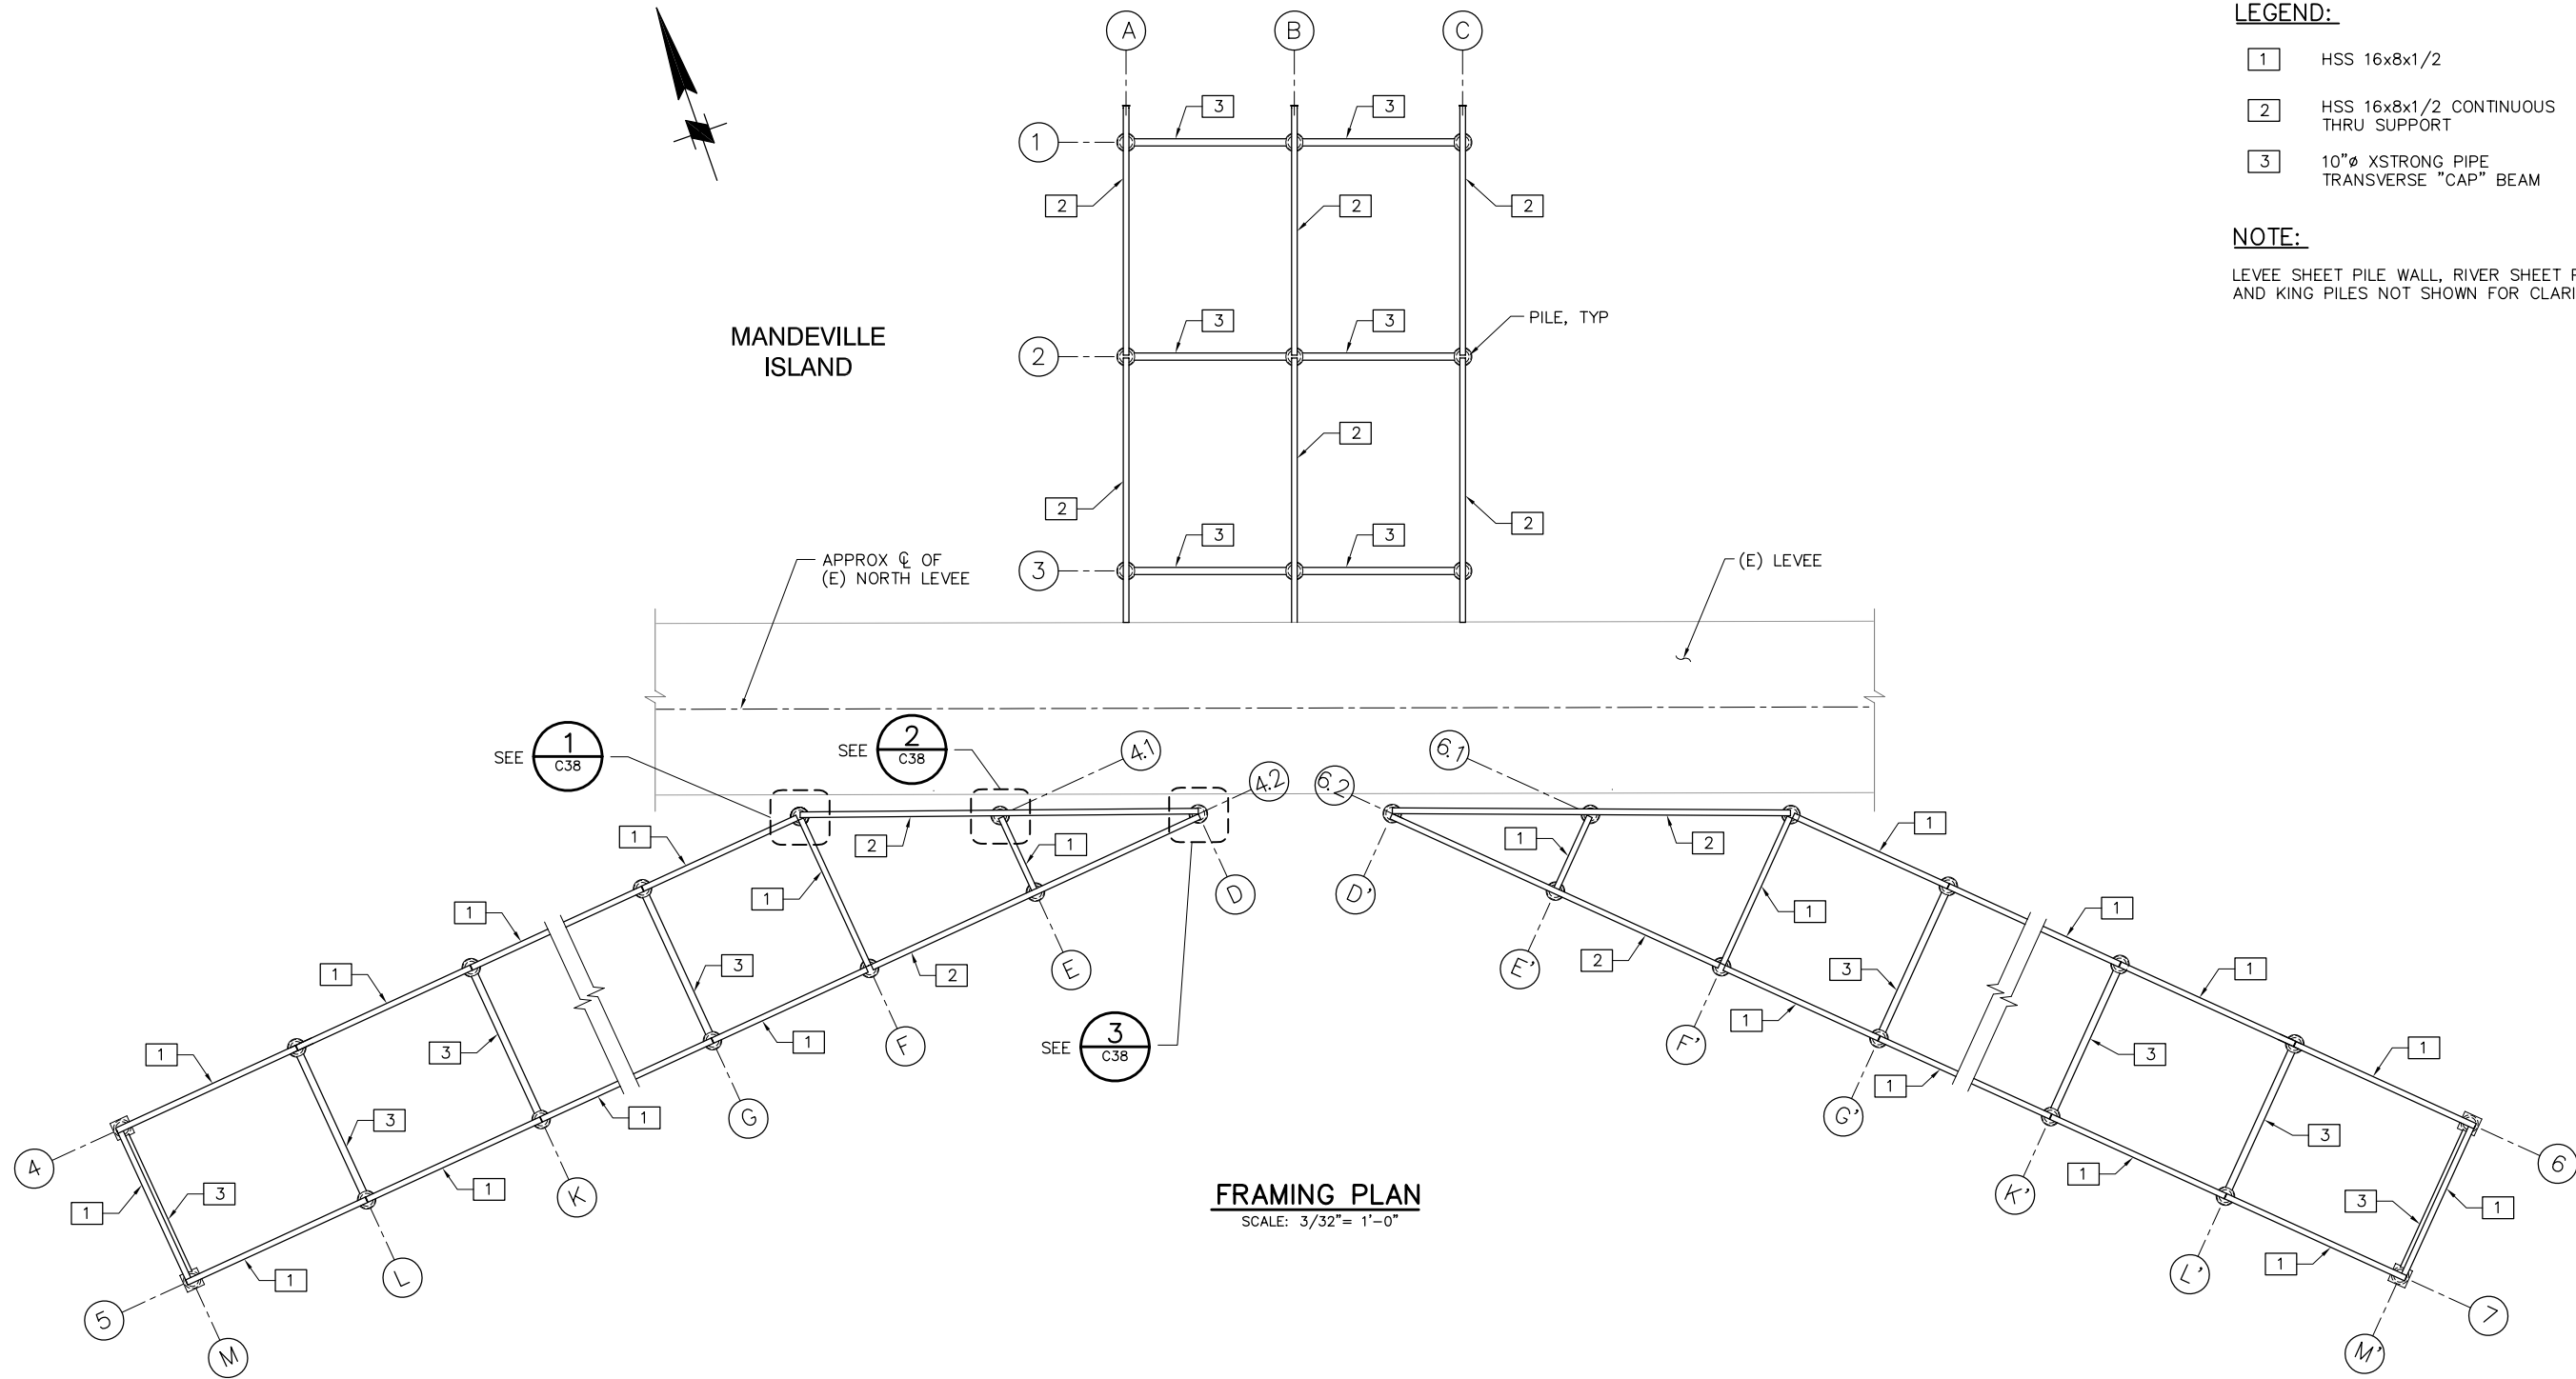


LEGEND:

- 1 HSS 16x8x1/2
- 2 HSS 16x8x1/2 CONTINUOUS THRU SUPPORT
- 3 10"Ø XSTRONG PIPE TRANSVERSE "CAP" BEAM

NOTE:

 LEVEE SHEET PILE WALL, RIVER SHEET PILE WALL AND KING PILES NOT SHOWN FOR CLARITY.



95% SUBMITTAL

IF SHEET IS LESS THAN 22" x 34"
IT IS A REDUCED PRINT -
SCALE REDUCED ACCORDINGLY.



REVISION	DESCRIPTION	BY	DATE

		2001 N. Main Street, Suite 360 Walnut Creek, California 94596 (925) 944-5411	
DSGN	JMB	DR	EP
JOB NO.	6097-03	SUBMITTED BY	RMR
CHK	TDB	TITLE	


TWO GATE FISH PROTECTION PLAN
CONNECTION SLOUGH BOAT RAMP FRAMING PLAN

DATE 08/07/09
SHEET 35 OF 75
C36.2

P:\6097-03 SWC GATE DESIGN\CADD\DWG\609703-C36.DWG 8/6/2009 9:26 AM

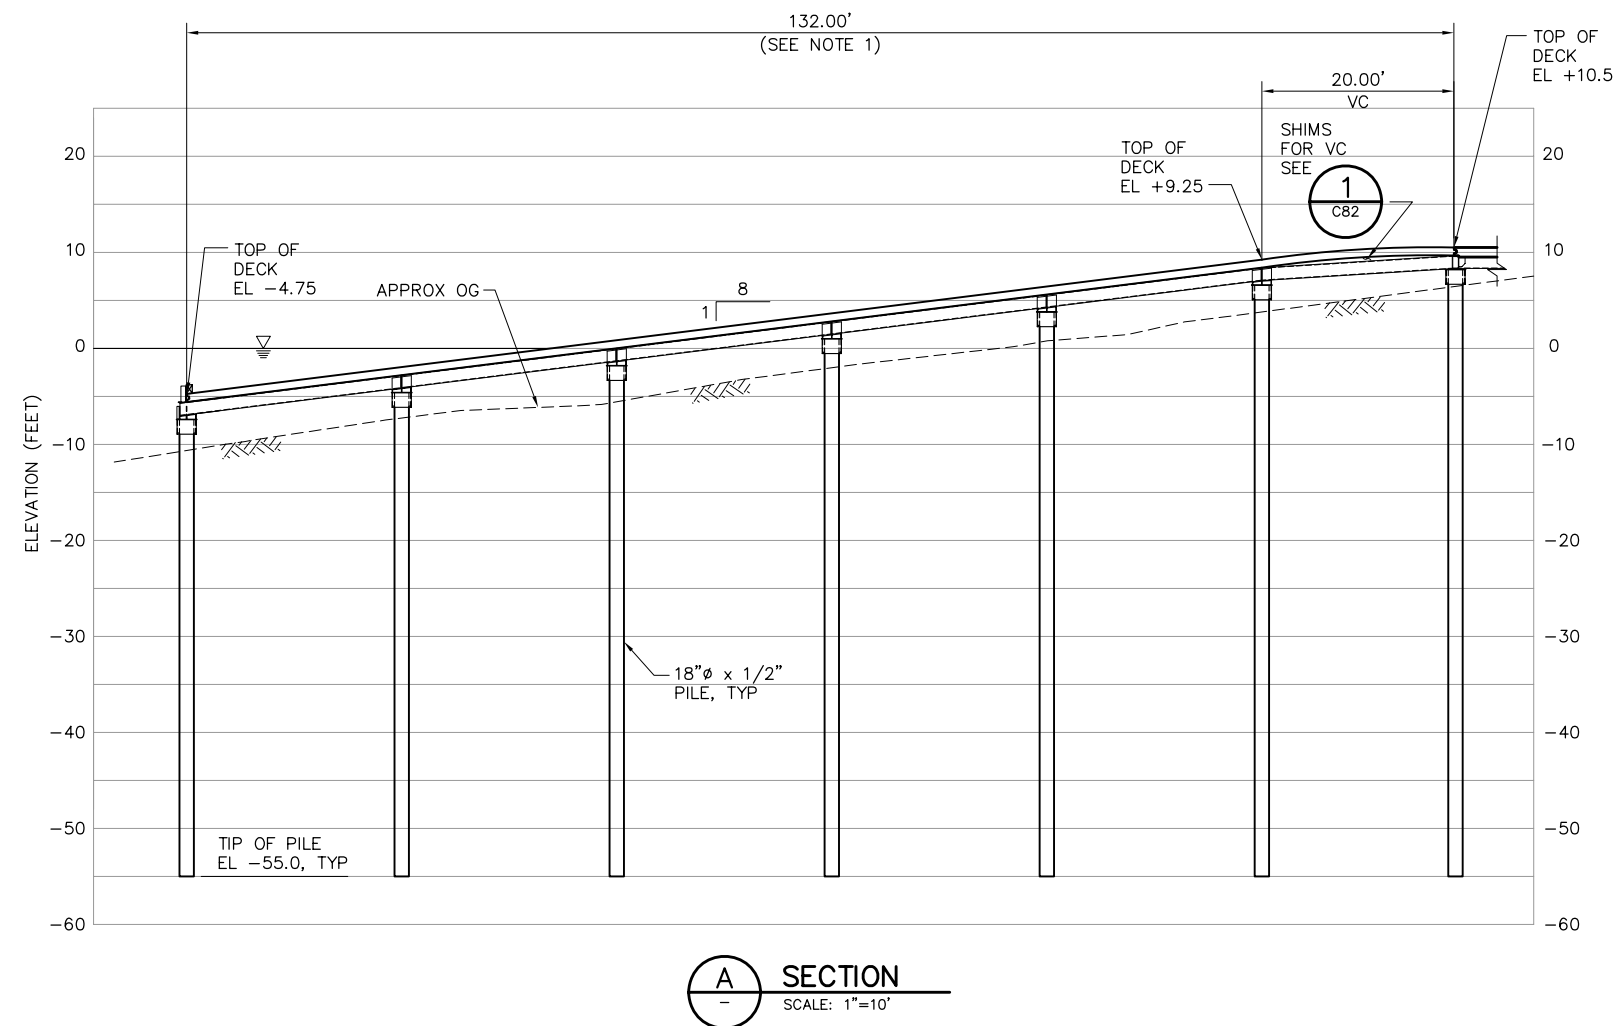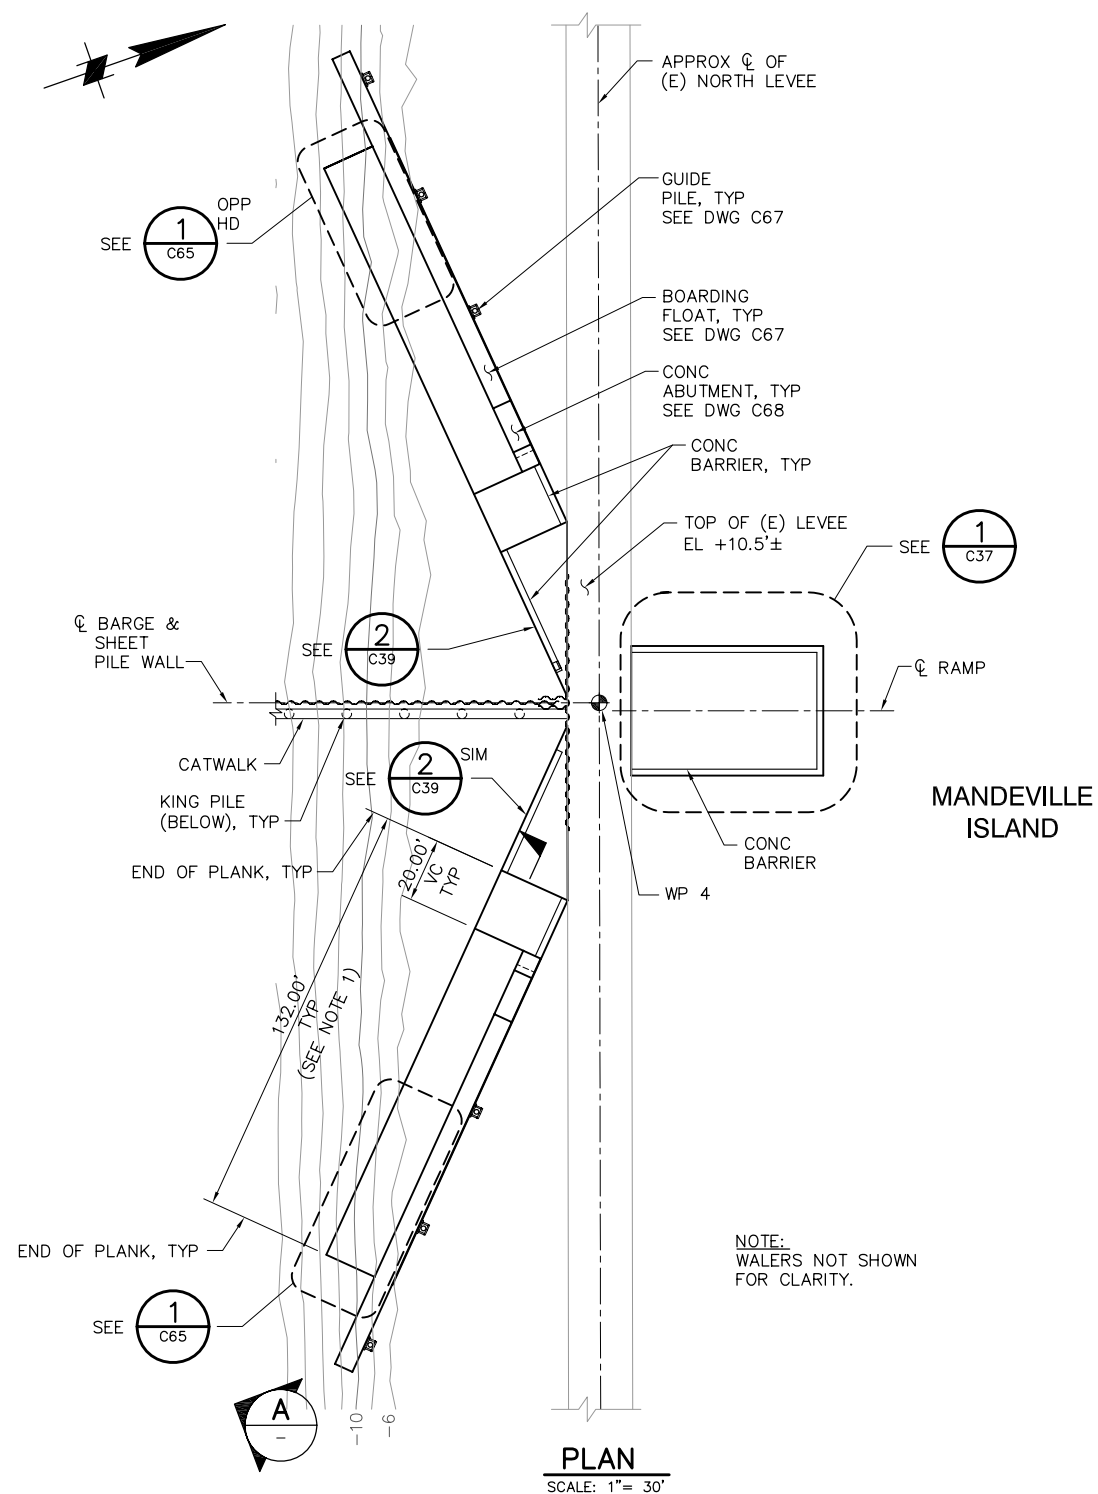


- NOTES:
1. TRUE LENGTH OF RAMP ACCOUNTS FOR AN AVERAGE GAP OF 3/8" PER PLANK JOINT.

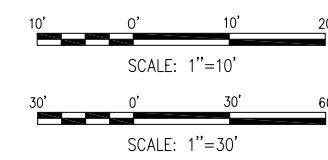

95% SUBMITTAL IF SHEET IS LESS THAN 22" x 34"
IT IS A REDUCED PRINT -
SCALE REDUCED ACCORDINGLY.

REVISION	DESCRIPTION	BY	DATE			 2001 N. Main Street, Suite 360 Walnut Creek, California 94596 (925) 944-5411	TWO GATE FISH PROTECTION PLAN		DATE 08/07/09
							CONNECTION SLOUGH BOAT RAMP PLAN AND SECTION	SHEET 33 OF 75	
								C36	

P:\6097-03 SWC GATE DESIGN\CADD\DWG\609703-C37.DWG 8/6/2009 10:40 AM

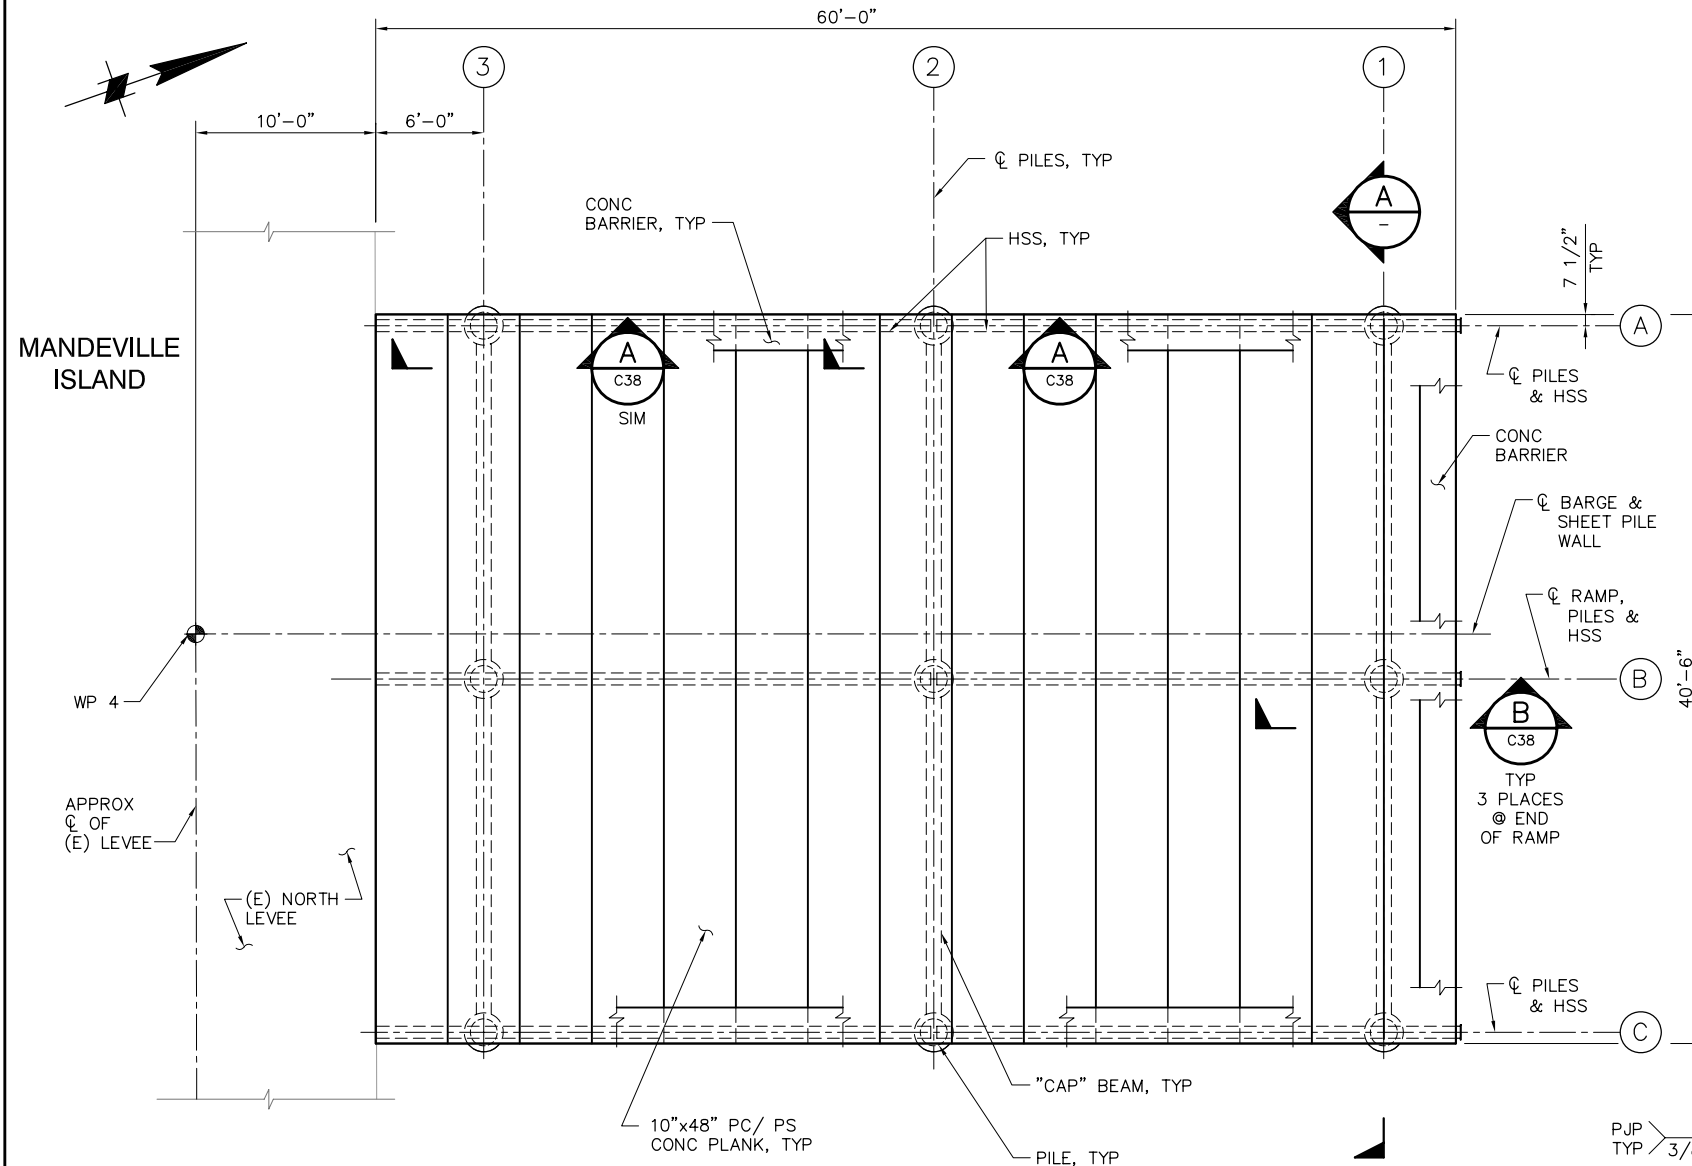


NOTES:

- ALL PC/PS PLANKS SHALL BEAR ON/AGAINST NEOPRENE "UNDERLAYMENT" BEARING STRIP WITH A MINIMUM 1/8" THICKNESS.

WELDING NOTE:

 ALL STIFFENER PLATES SHALL HAVE DOUBLE SIDED 1/4" FILLET WELDS UON.





95% SUBMITTAL

IF SHEET IS LESS THAN 22" x 34"
IT IS A REDUCED PRINT -
SCALE REDUCED ACCORDINGLY.





REVISION	DESCRIPTION	BY	DATE

 Moffatt & Nichol		2001 N. Main Street, Suite 360 Walnut Creek, California 94596 (925) 944-5411	
DSGN	JMB	DR	EP
JOB NO.	6097-03	SUBMITTED BY	RMR
CHK	TDB	TITLE	

TWO GATE FISH PROTECTION PLAN		DATE	08/07/09
CONNECTION SLOUGH BOAT RAMP DETAILS AND SECTIONS SHEET 1		SHEET	36 OF 75
C37			

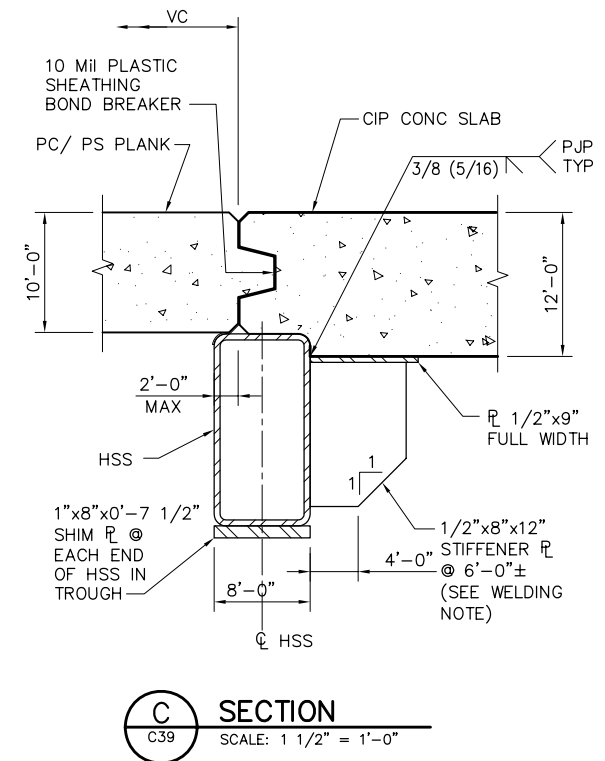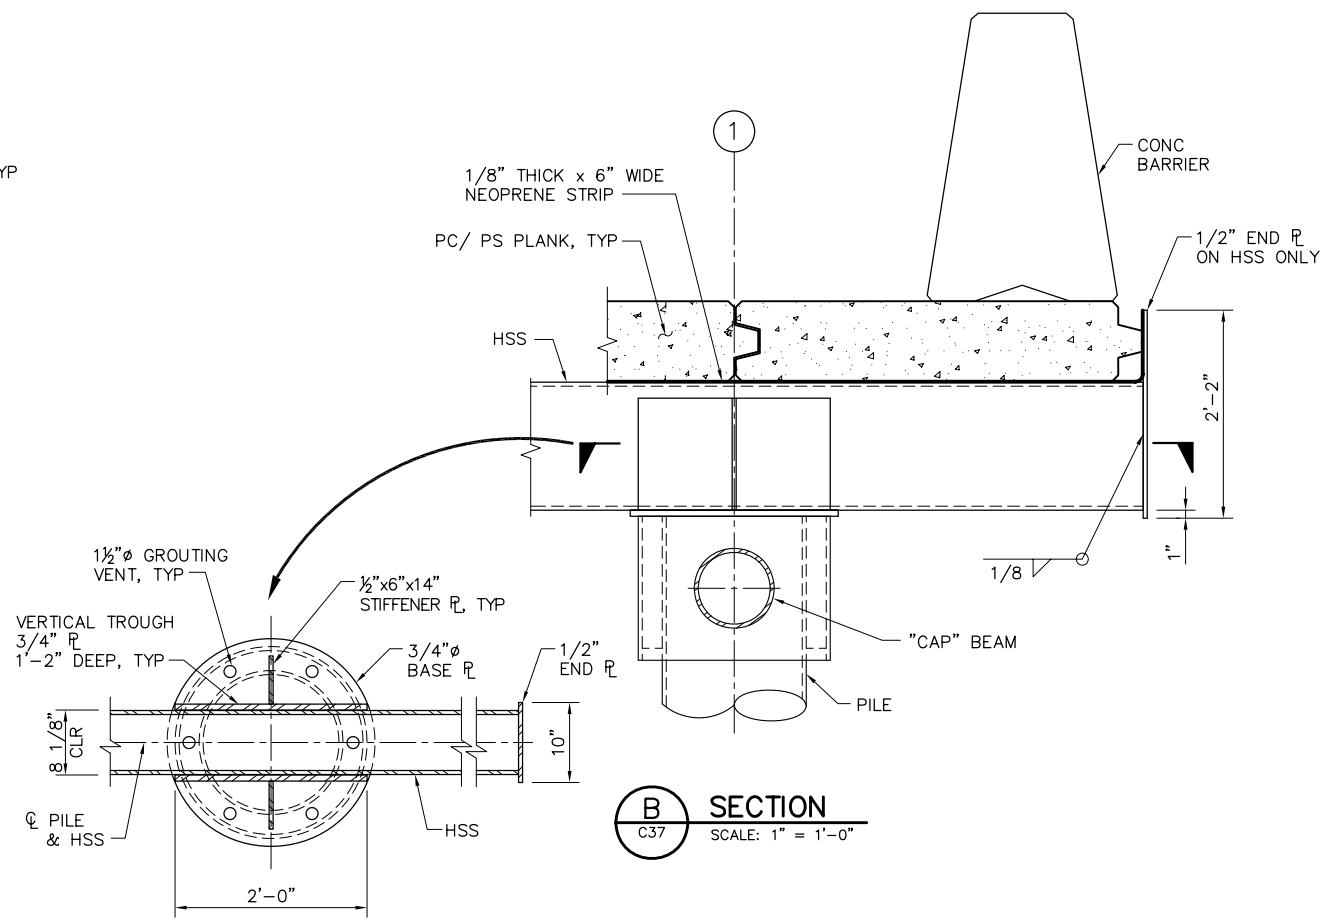

 ALL STIFFENER PLATES SHALL HAVE DOUBLE SIDED
1/4" FILLET WELDS UON.

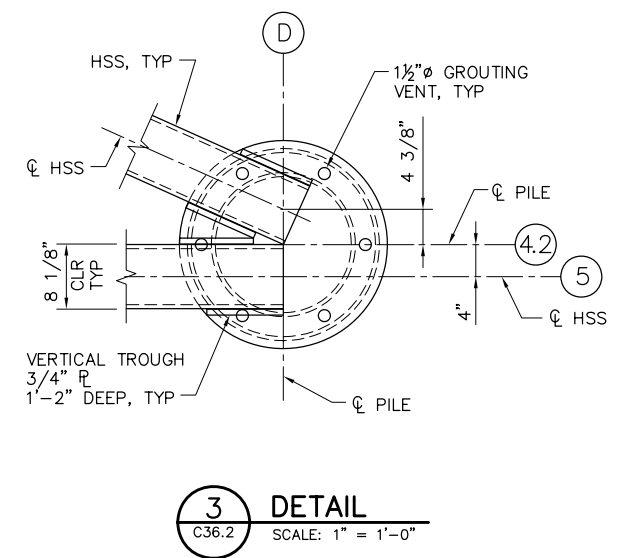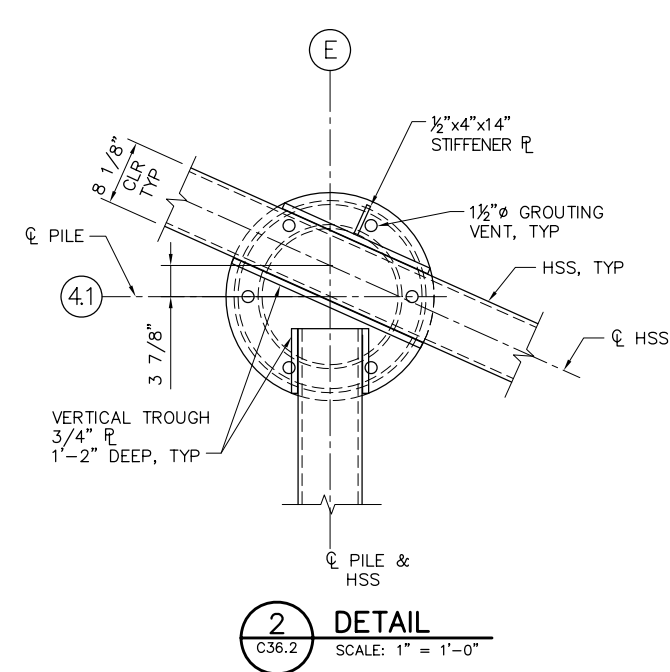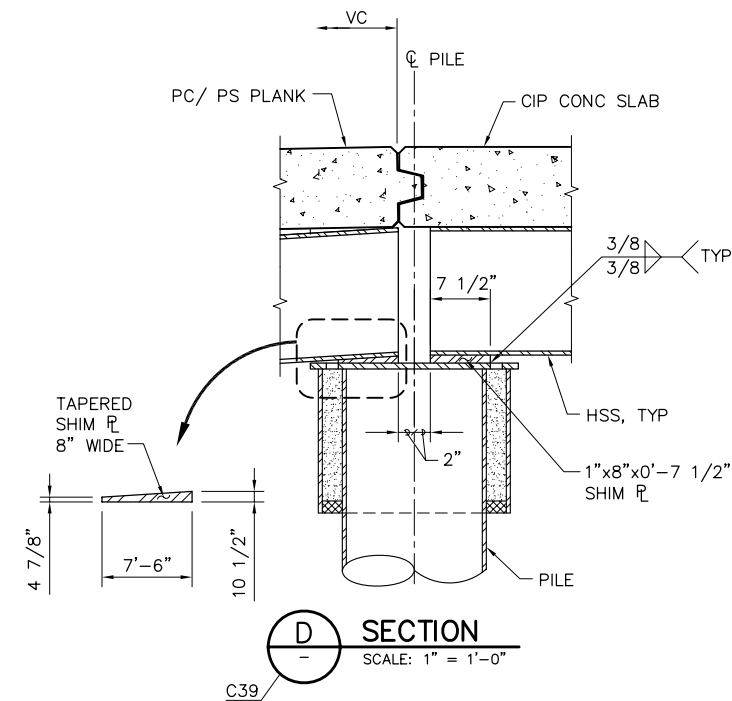

IF SHEET IS LESS THAN 22" x 34"
IT IS A REDUCED PRINT –
SCALE REDUCED ACCORDINGLY.

REVISION	DESCRIPTION	BY	DATE


 2001 N. Main Street, Suite 360 Walnut Creek, California 94596 (925) 944-5411		
DSGN JMB	DR EP	CHK TDB
JOB NO. 6097-03	SUBMITTED BY RMR	
TITLE		

CONNECTION SLOUGH
BOAT RAMP DETAILS AND SECTIONS
SHEET 2


SHEET 37 OF 75

C38


P:\6097-03 SWC GATE DESIGN\CADD\DWG\609703-C39.DWG 8/6/2009 10:42 AM

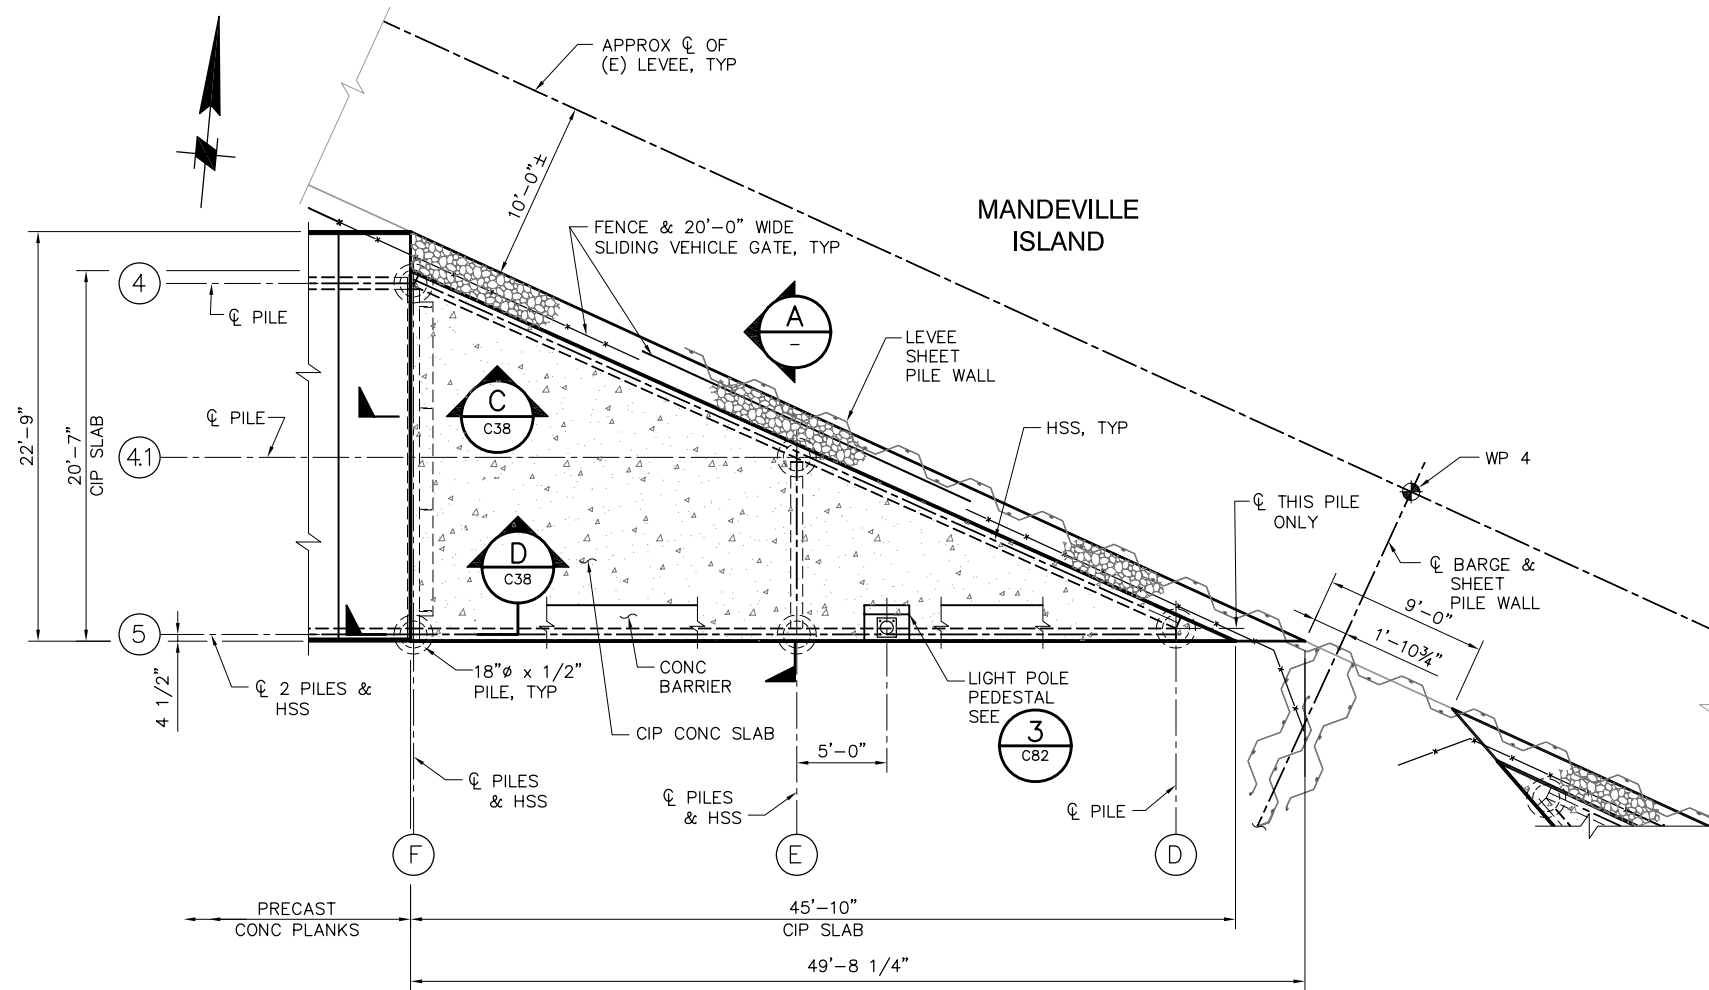


2 DETAIL
C36 SCALE: 3/16" = 1'-0"

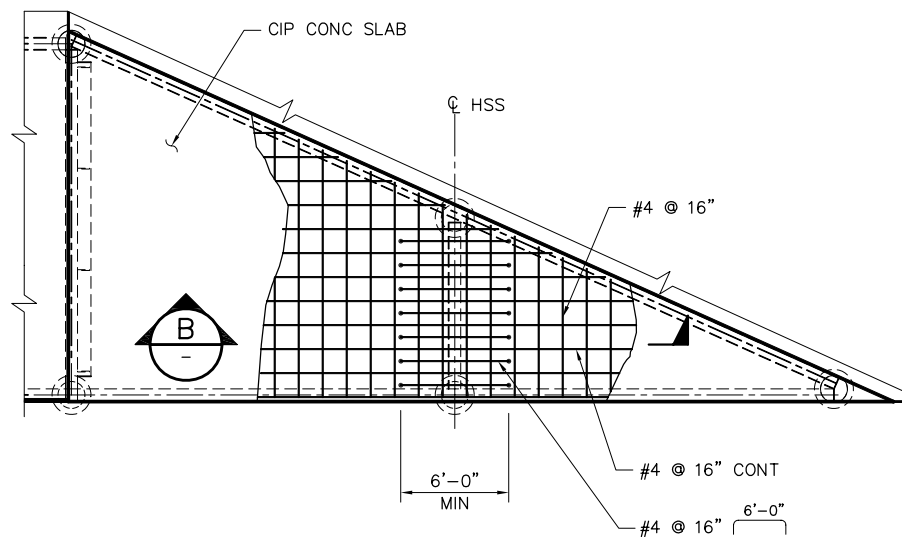


TOP SLAB REINFORCEMENT
SCALE: 3/16" = 1'-0"

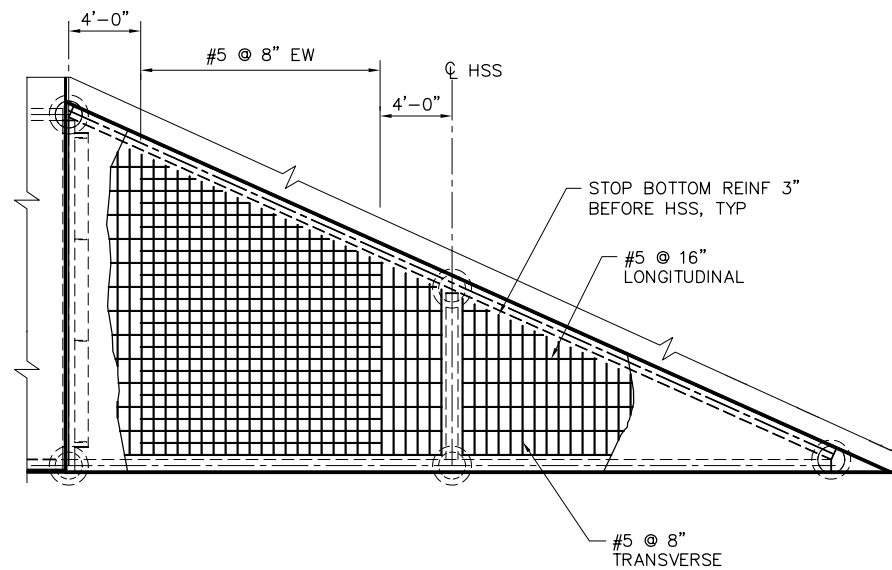

BOTTOM SLAB REINFORCEMENT
SCALE: 3/16" = 1'-0"

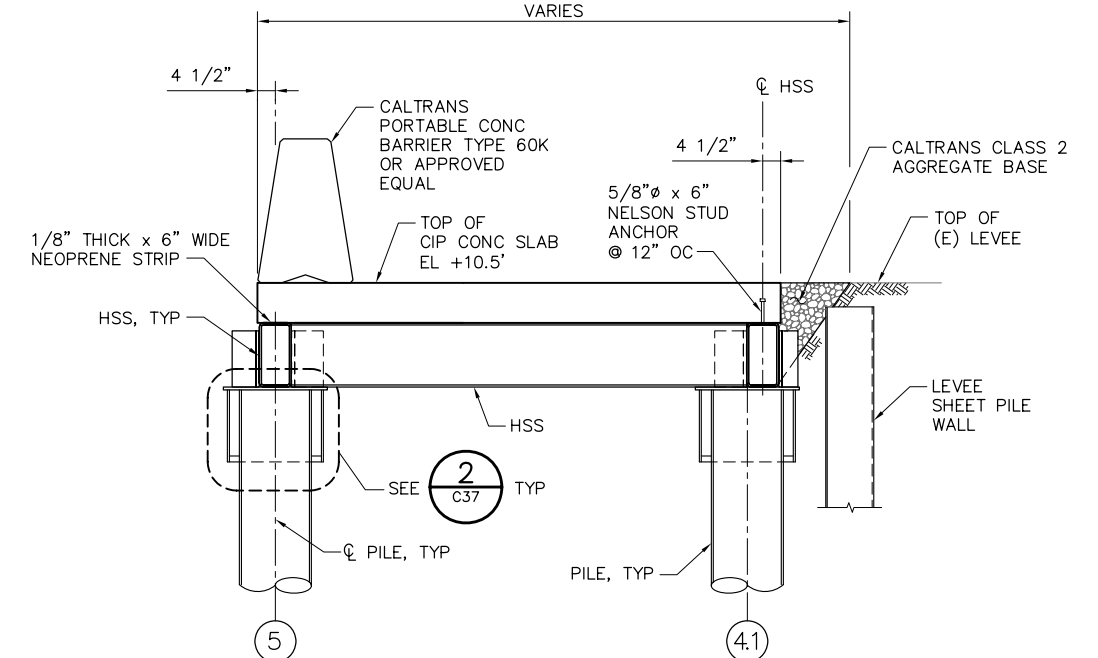

A SECTION
SCALE: 1/2" = 1'-0"

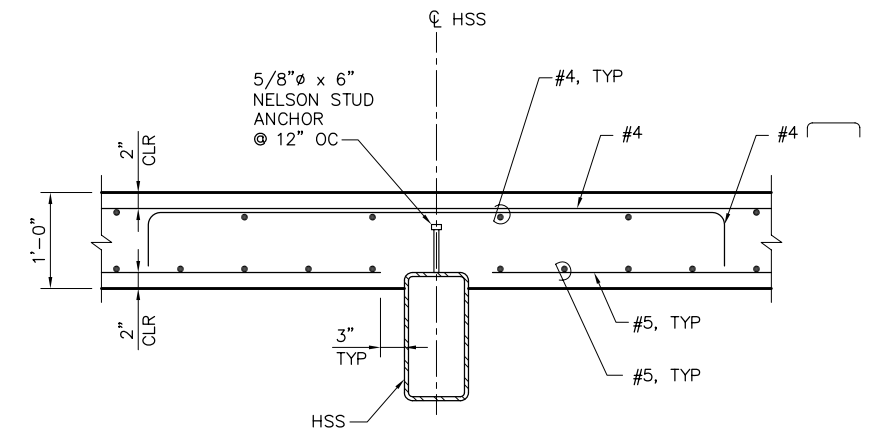

B SECTION
SCALE: 1" = 1'-0"

1'-0" 0'-0" 1'-0" 2'-0"
SCALE: 1" = 1'-0"

95% SUBMITTAL






IF SHEET IS LESS THAN 22" x 34"
IT IS A REDUCED PRINT -
SCALE REDUCED ACCORDINGLY.

REVISION	DESCRIPTION	BY	DATE

 Moffatt & Nichol		2001 N. Main Street, Suite 360 Walnut Creek, California 94596 (925) 944-5411	
DSGN	JMB	DR	EP
JOB NO.	6097-03	SUBMITTED BY	RMR
CHK	TDB	TITLE	

TWO GATE FISH PROTECTION PLAN		DATE	08/07/09
CONNECTION SLOUGH BOAT RAMP DETAILS AND SECTIONS SHEET 3		SHEET	38 OF 75
			C39

 P:\6097-03 SWC GATE DESIGN\CADD\DWG\609703-C40.DWG 8/5/2009 2:40 PM

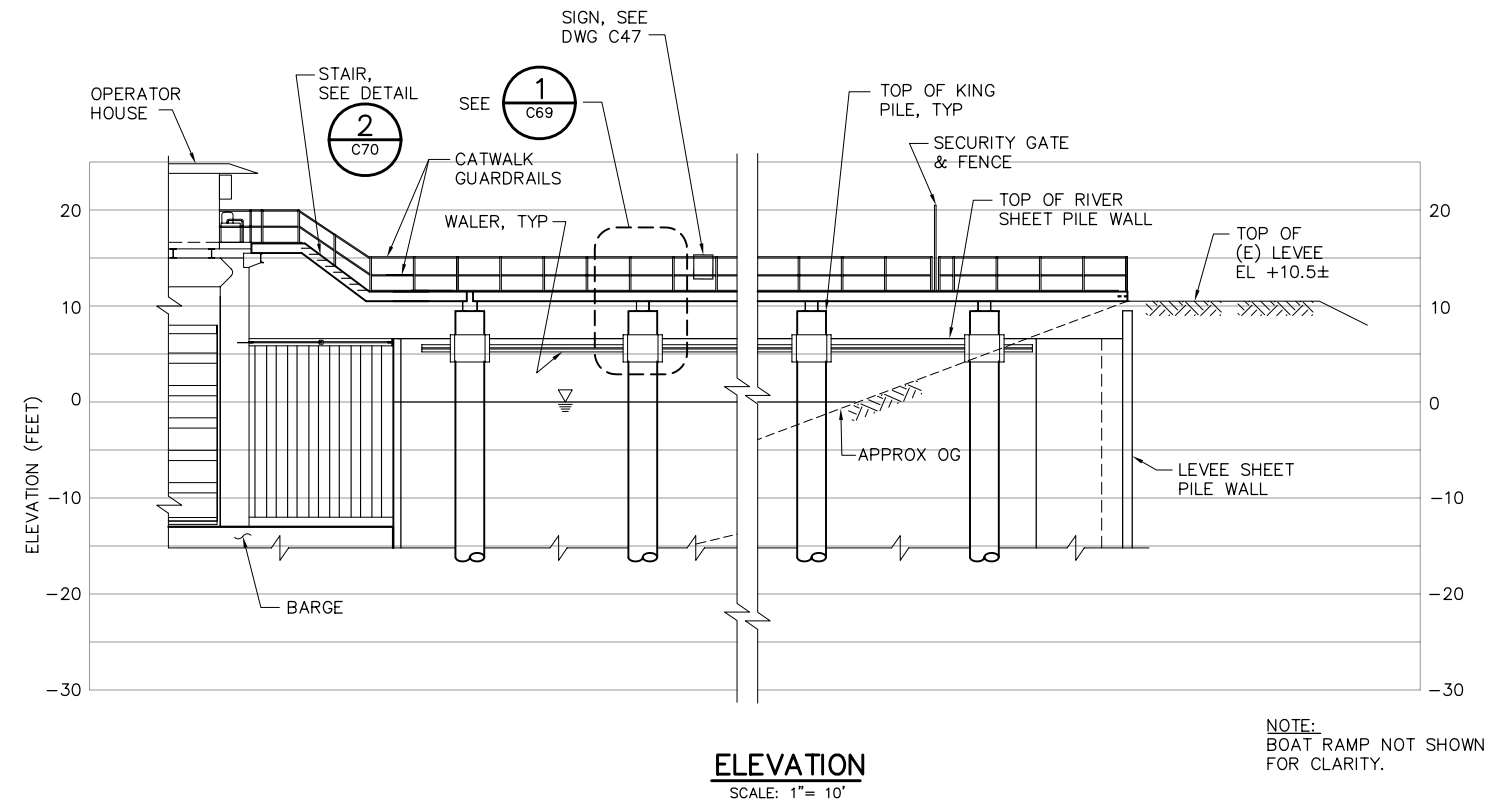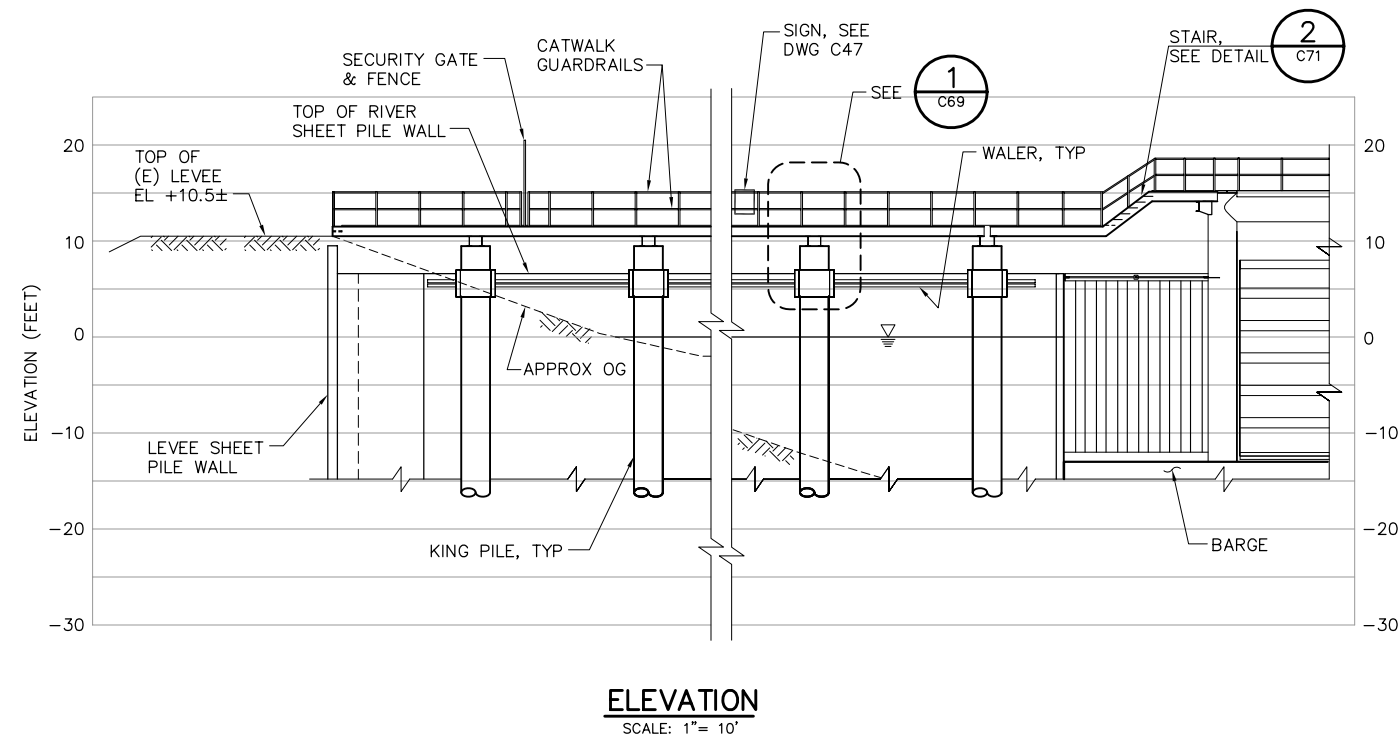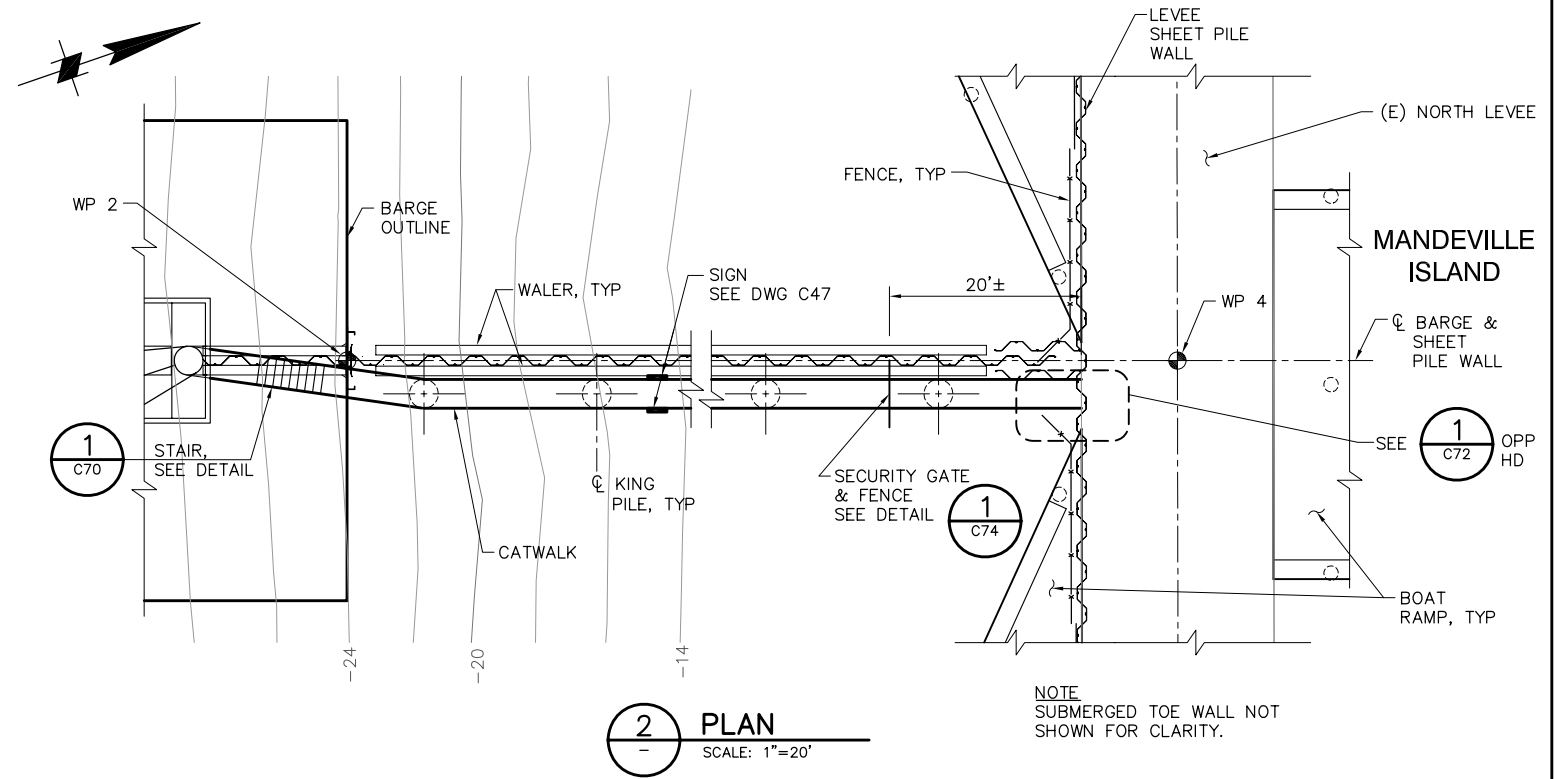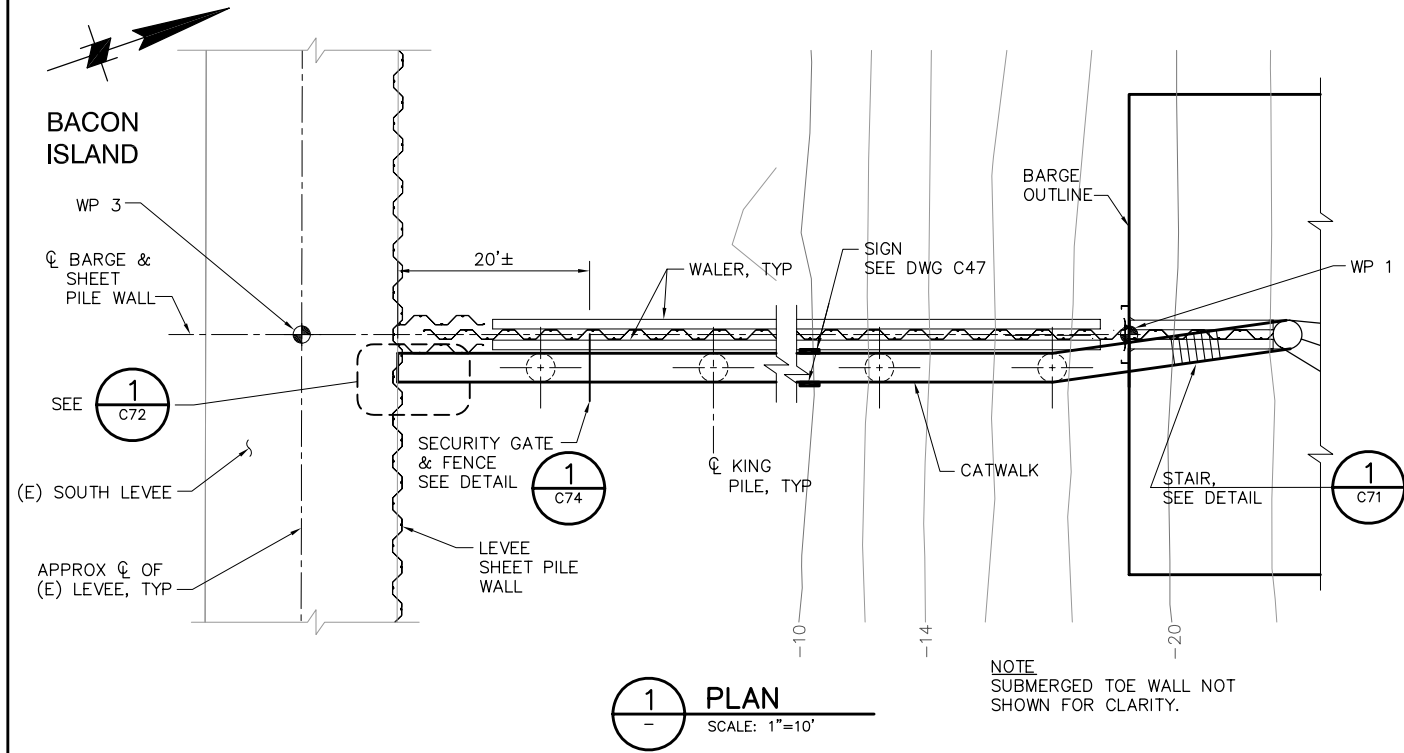


95% SUBMITTAL

IF SHEET IS LESS THAN 22" x 34"
IT IS A REDUCED PRINT -
SCALE REDUCED ACCORDINGLY.

REVISION	DESCRIPTION	BY	DATE


 Moffatt & Nichol 2001 N. Main Street, Suite 360 Walnut Creek, California 94596 (925) 944-5411			
DSGN	JMB	DR	EP/AB
JOB NO.	6097-03	SUBMITTED BY	RMR
CHK	TDB	TITLE	

TWO GATE FISH PROTECTION PLAN		DATE	08/07/09
CONNECTION SLOUGH CATWALK PLAN AND ELEVATION		SHEET	39 OF 75
			C40

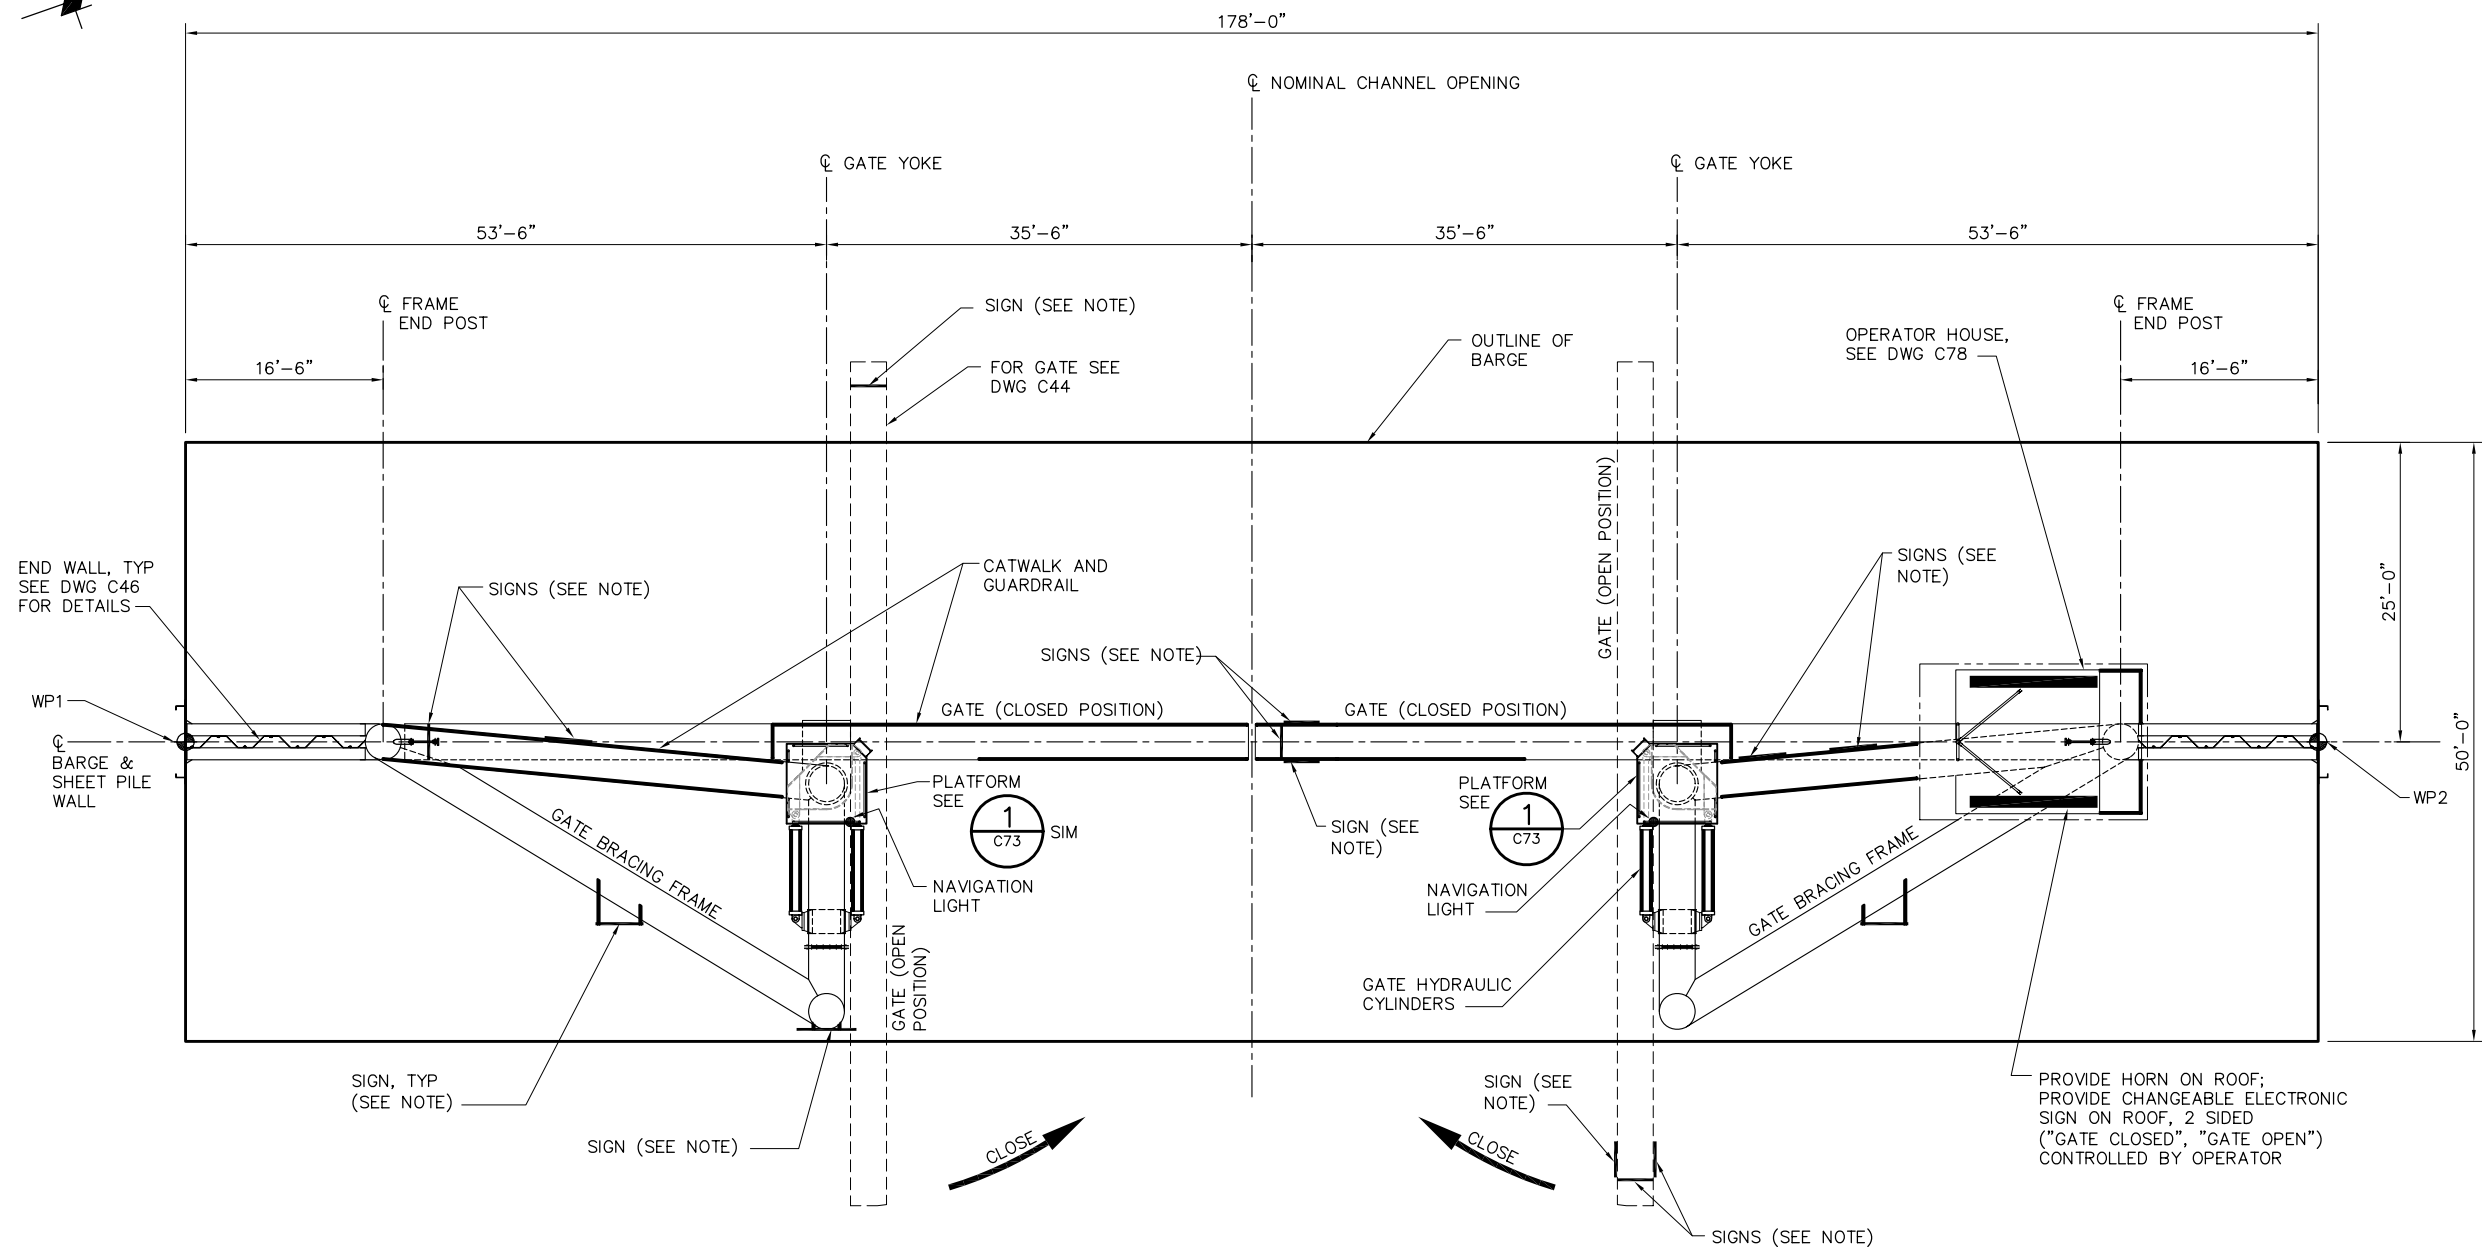

BARGE PLAN
SCALE: 1/8"= 1'-0"

 NOTE:
FOR SIGNAGE, SEE DRAWING C47.




95% SUBMITTAL

IF SHEET IS LESS THAN 22" x 34"
IT IS A REDUCED PRINT -
SCALE REDUCED ACCORDINGLY.



P:\6097-03 SWC GATE DESIGN\CADD\DWG\609703-C42.DWG 8/7/2009 10:15 AM

REVISION	DESCRIPTION	BY	DATE						TWO GATE FISH PROTECTION PLAN	DATE 08/07/09
										SHEET 41 OF 75
									CONNECTION SLOUGH BARGE GENERAL ARRANGEMENT PLAN	C42
							DSGN CBS	DR AB	CHK TDB	
							JOB NO. 6097-03	SUBMITTED BY RMR	TITLE	

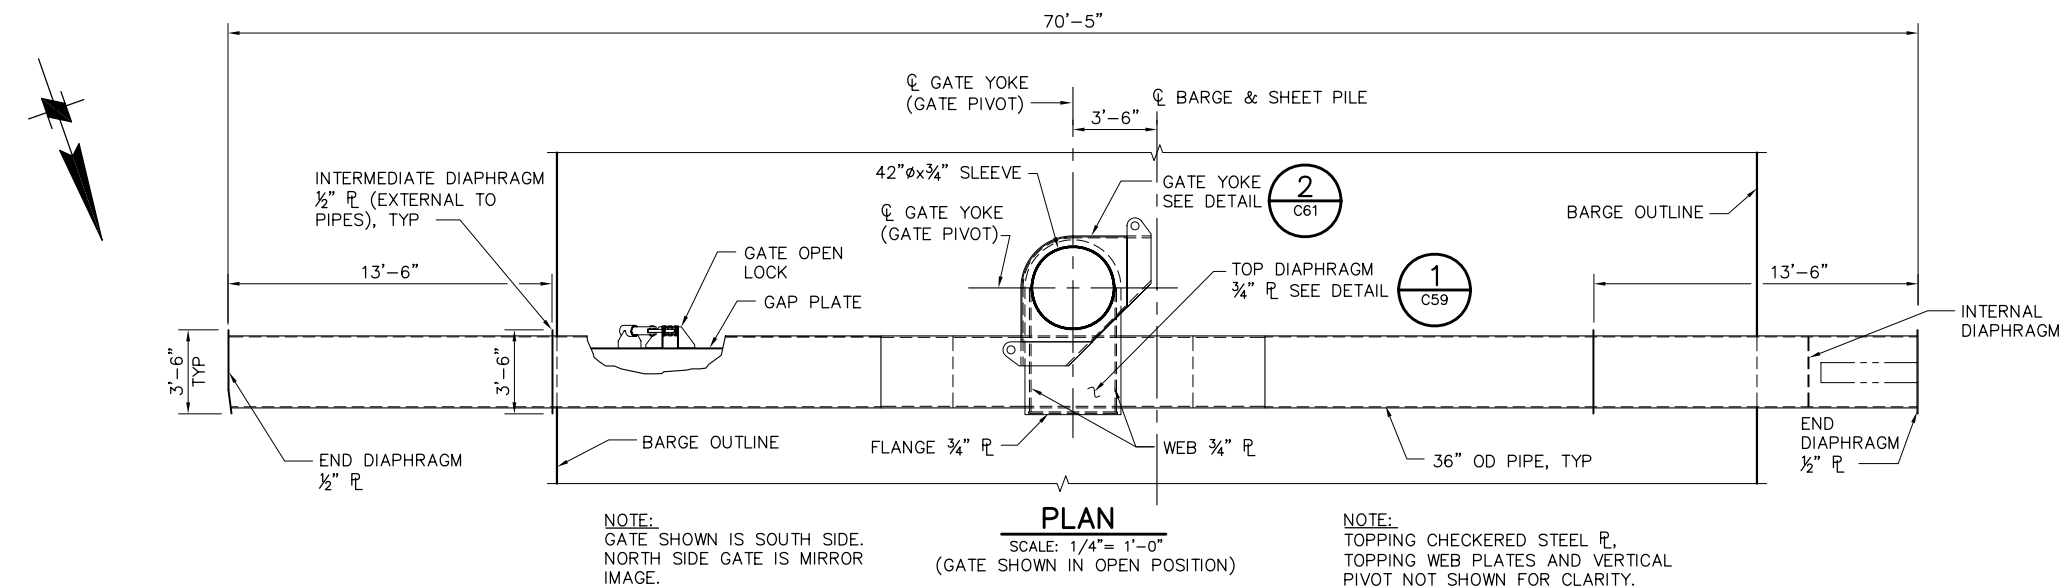

- WELDING NOTES:


1. ALL GATE AND PIPE FRAMING STRUCTURAL WELDS SHALL BE COMPETE JOINT PENETRATION (CJP) WELDS UON.
2. BACKING BARS SHALL NOT BE LEFT IN PLACE
3. ALL WELDS SHALL BE PREQUALIFIED.
4. ALL WELDING AND NON-DESTRUCTIVE TESTING (N.D.T.) INSPECTIONS SHALE BE IN ACCORDANCE WITH AWS-D1.1.

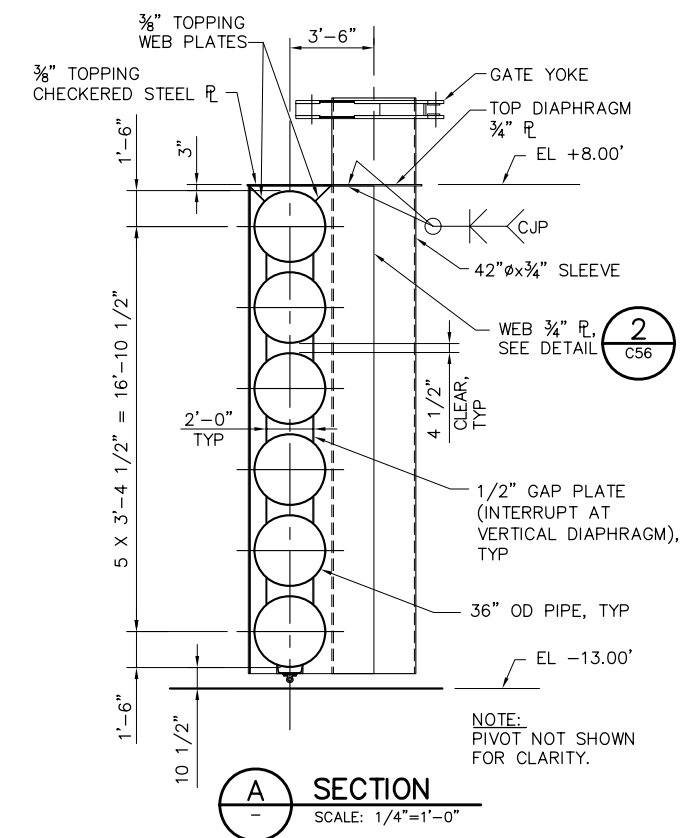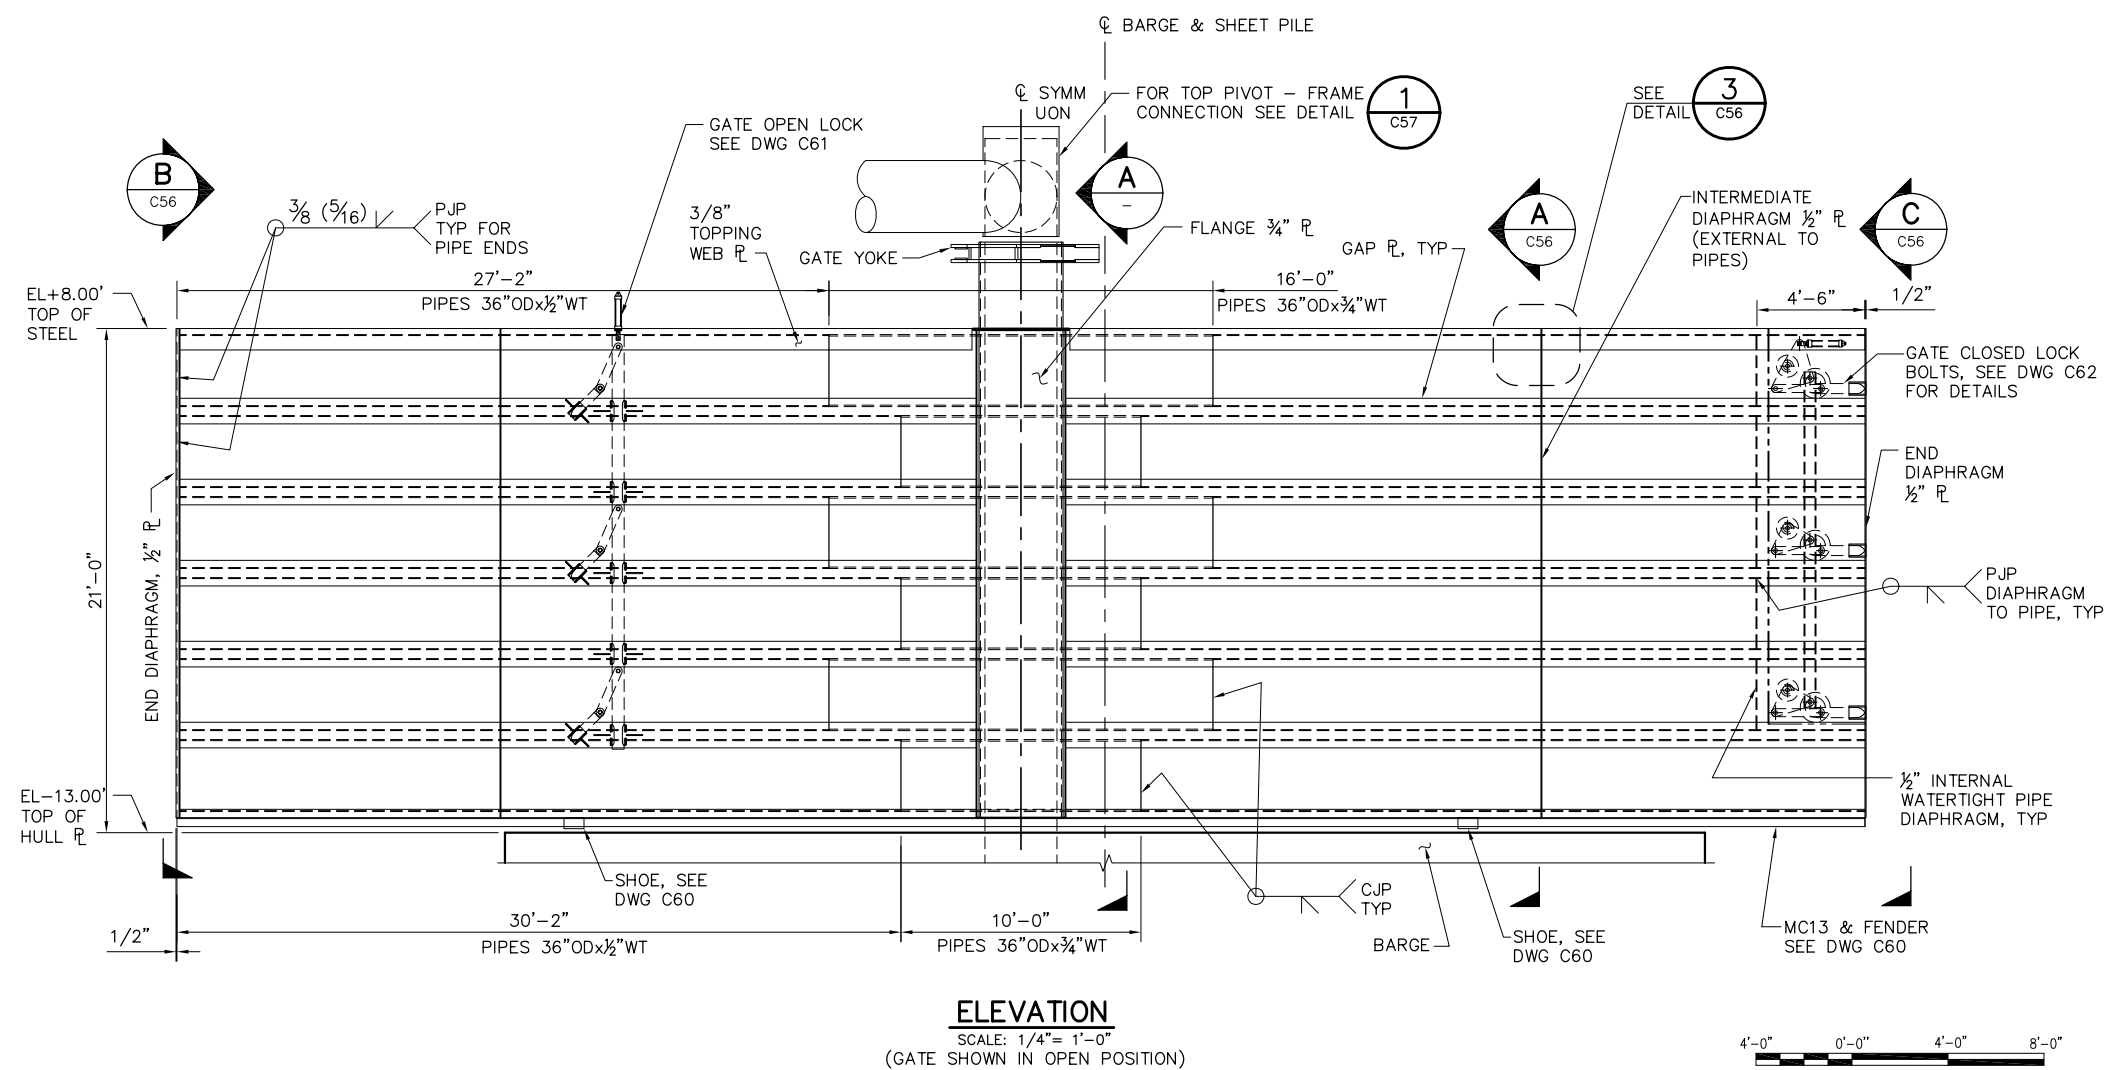

95% SUBMITTAL

IF SHEET IS LESS THAN 22" x 34"
IT IS A REDUCED PRINT –
SCALE REDUCED ACCORDINGLY.


REVISION	DESCRIPTION	BY	DATE	 2001 N. Main Street, Suite 360 Walnut Creek, California 94596 (925) 944-5411	TWO GATE FISH PROTECTION PLAN		DATE 08/07/09
							SHEET 43 OF 75
					CONNECTION SLOUGH GATE SCANTLINGS		C44
DSGN JMB		DR AB		CHK CBS			
JOB NO. 6097-03		SUBMITTED BY RMR		TITLE			

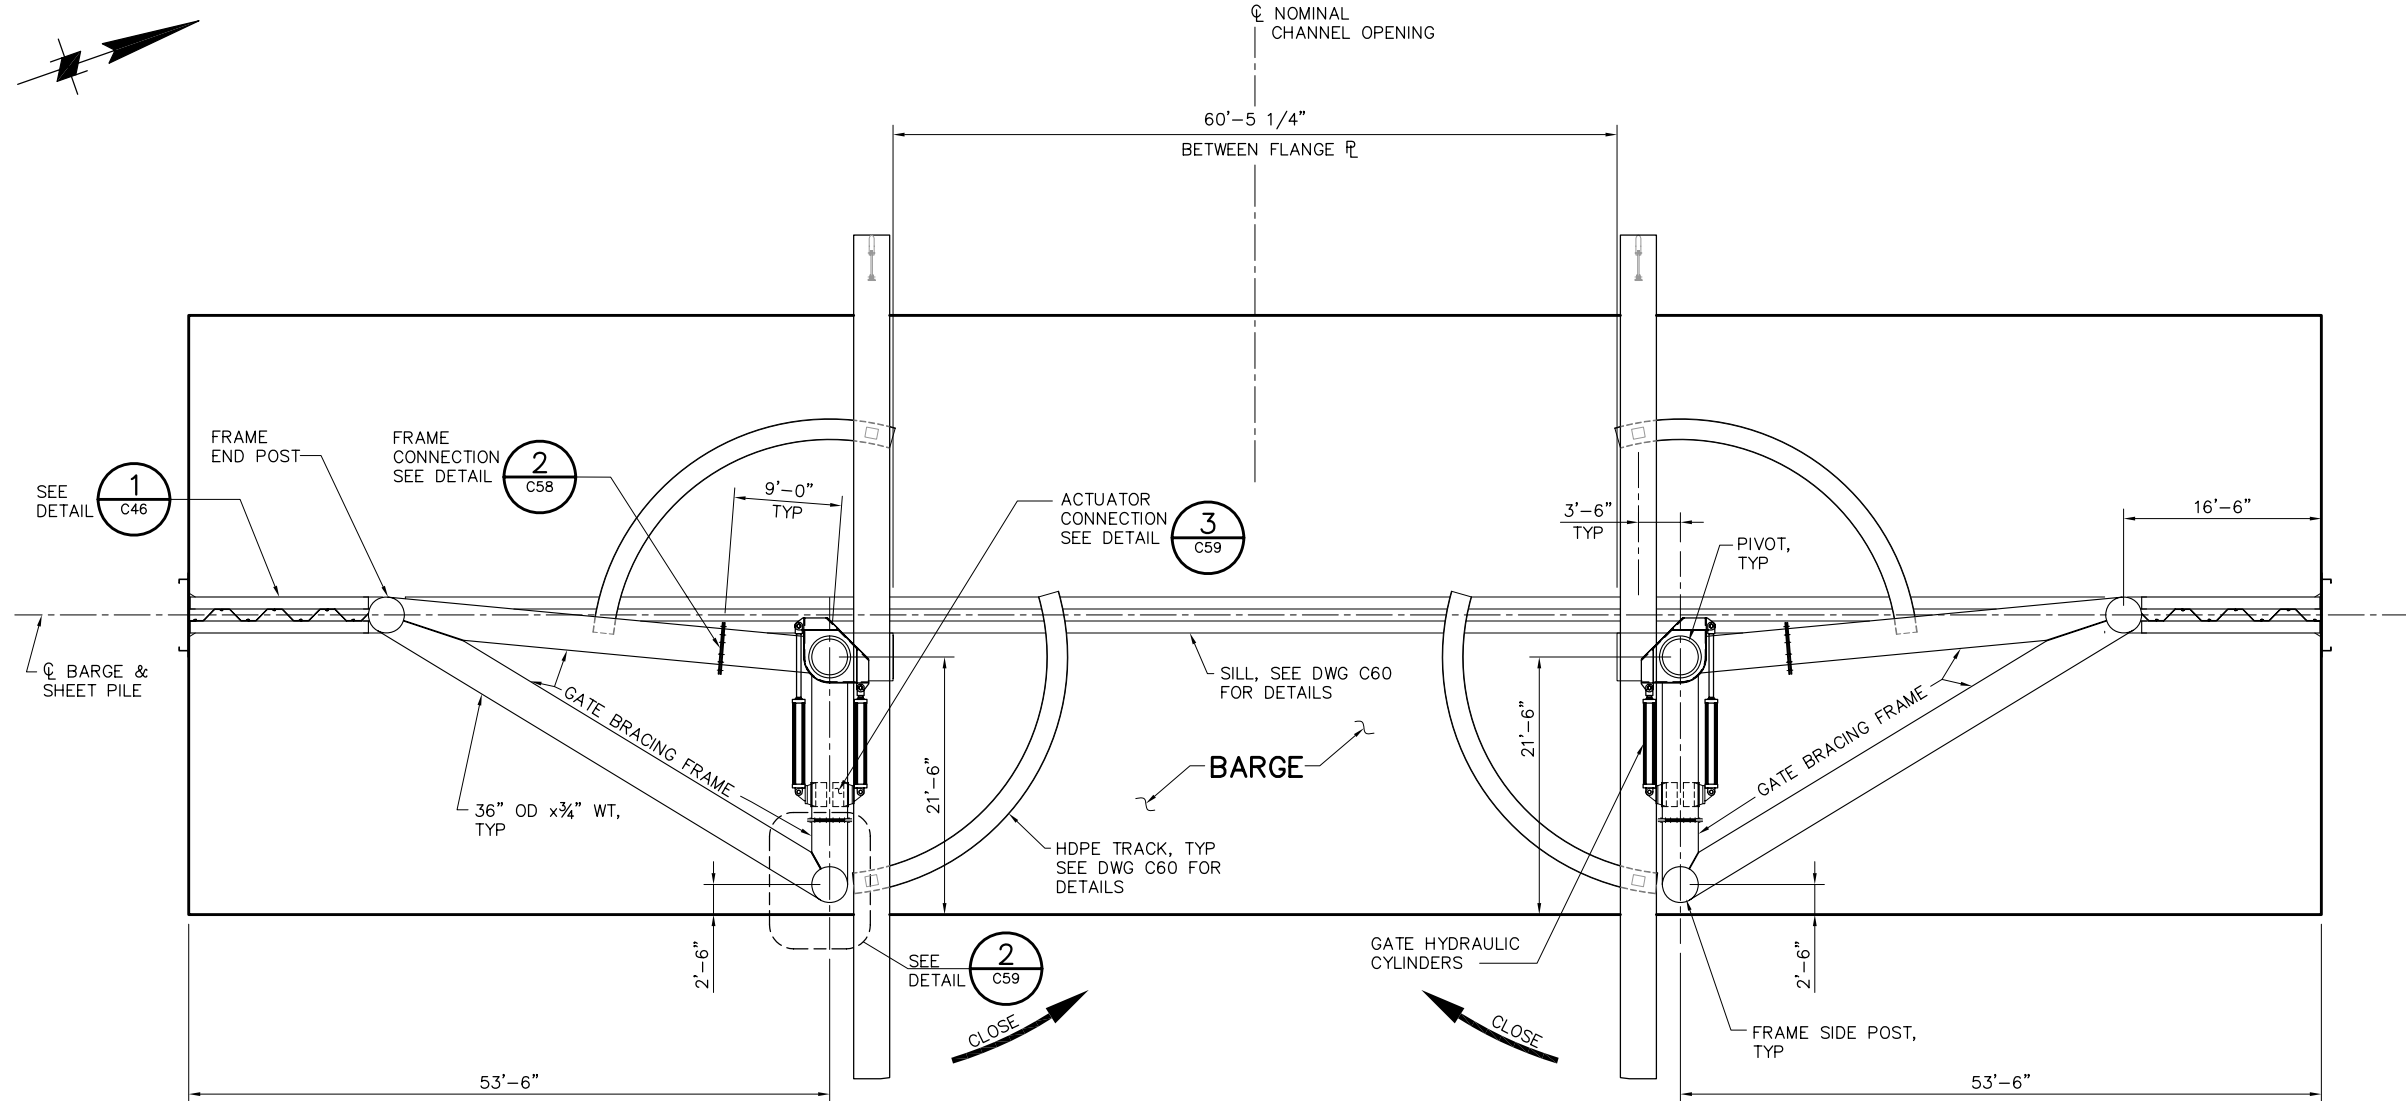

FRAME PLAN
 SCALE: 1/8"= 1'-0"
 (GATE SHOWN IN OPEN POSITION)

NOTE:

 FOR GATE FRAME REATIONS SEE DWG C17.



95% SUBMITTAL


IF SHEET IS LESS THAN 22" x 34"
 IT IS A REDUCED PRINT -
 SCALE REDUCED ACCORDINGLY.

P:\6097-03 SWC GATE DESIGN\CADD\DWG\609703-C45.DWG 8/7/2009 10:18 AM

REVISION	DESCRIPTION	BY	DATE				TWO GATE FISH PROTECTION PLAN		DATE 08/07/09
									SHEET 44 OF 75
							CONNECTION SLOUGH GATE FRAMING LAYOUT		C45


 2001 N. Main Street, Suite 360 Walnut Creek, California 94596 (925) 944-5411		DSGN CBS DR AB CHK TDB JOB NO. 6097-03 SUBMITTED BY RMR TITLE	
--	--	--	--

P:\6097-03 SMC GATE DESIGN\CADD\DWG\609703-C46.DWG 8/4/2009 4:41 PM

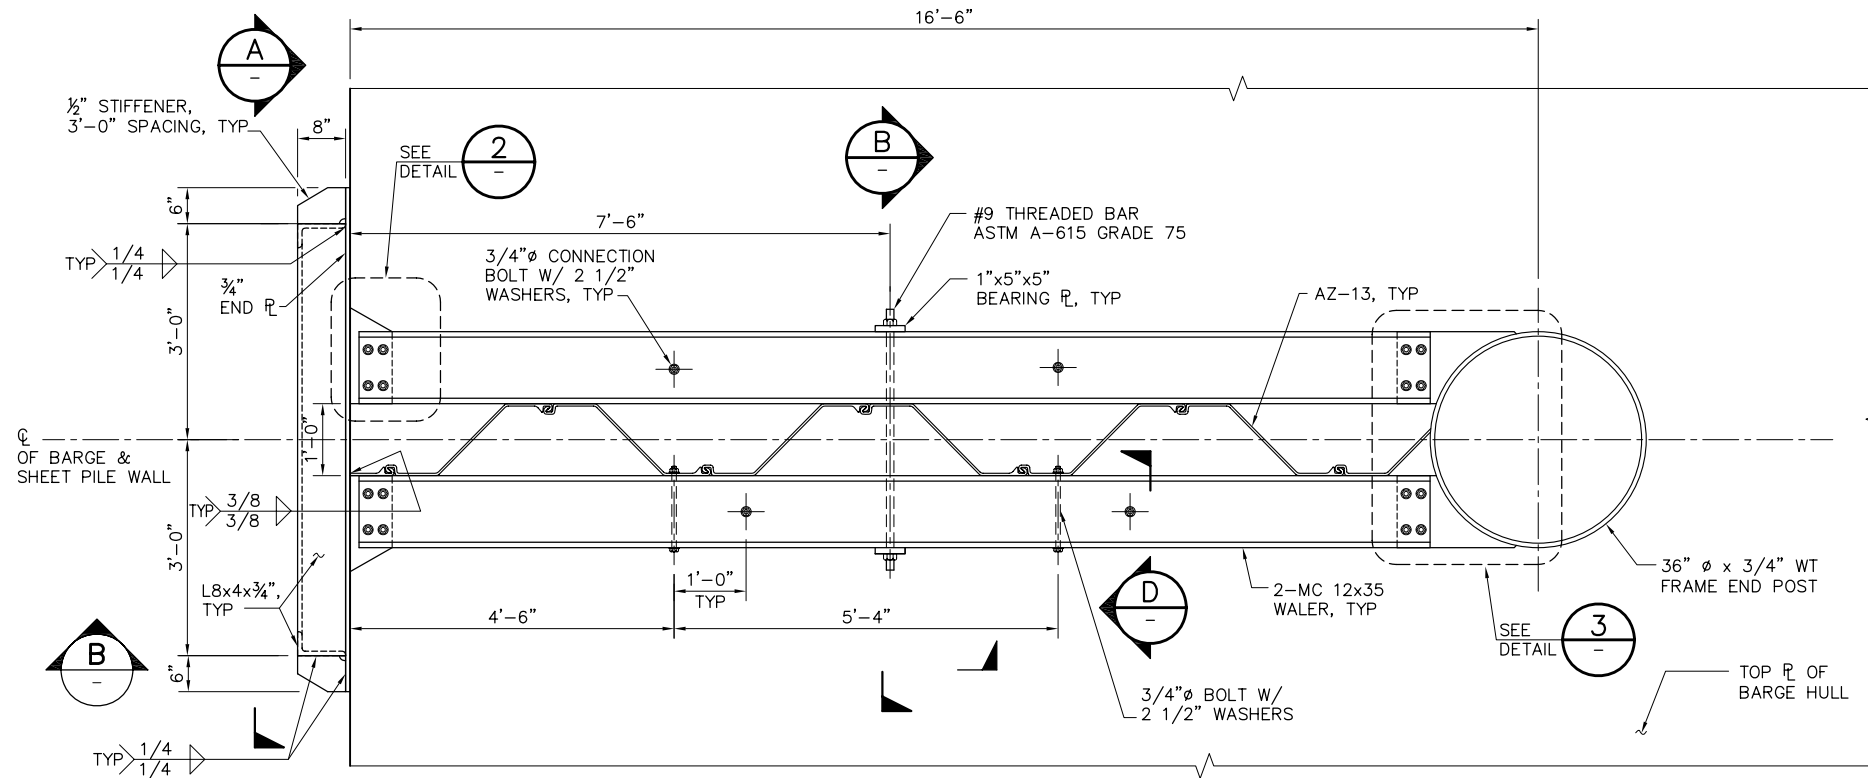


PLAN


1 DETAIL
SCALE: 3/4" = 1'-0"

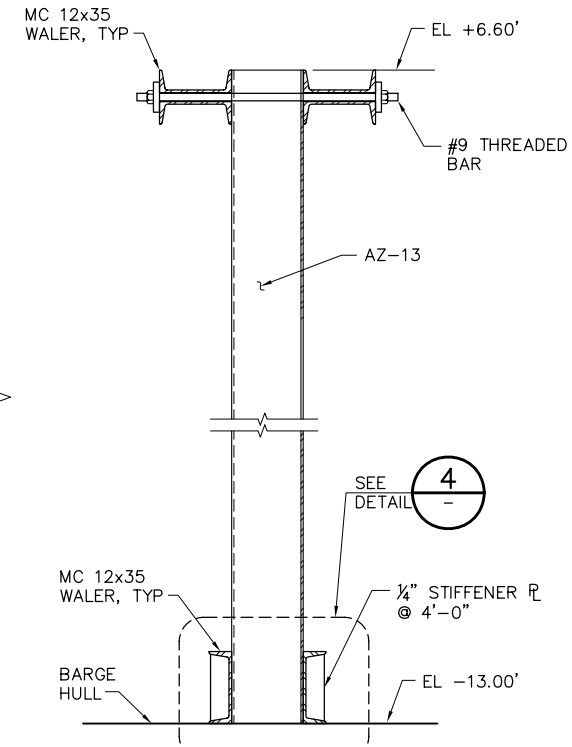


C SECTION
SCALE: 3/4" = 1'-0"

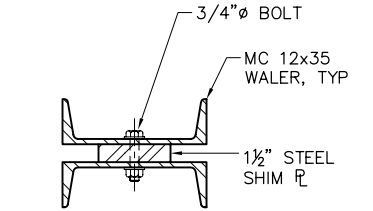


D SECTION
SCALE: 1 1/2" = 1'-0"

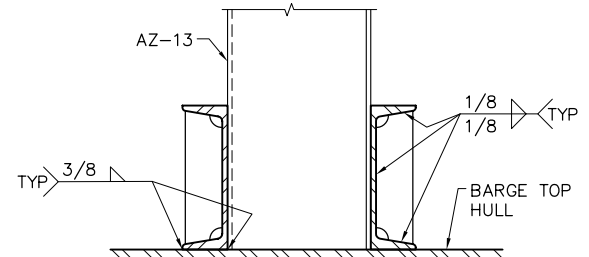


4 DETAIL
SCALE: 1 1/2" = 1'-0"

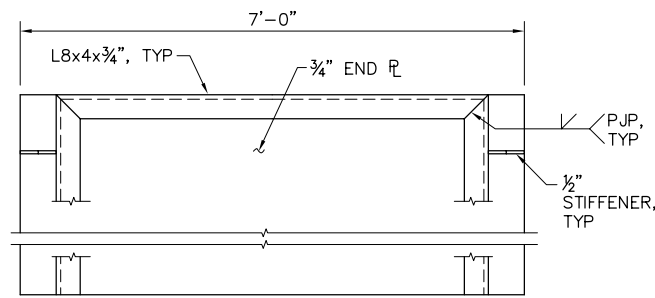


A SECTION
SCALE: 3/4" = 1'-0"

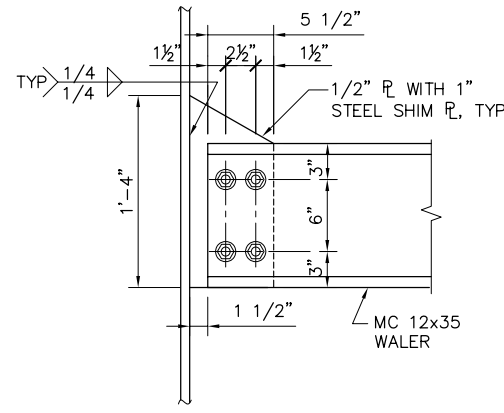

2 DETAIL
SCALE: 1 1/2" = 1'-0"

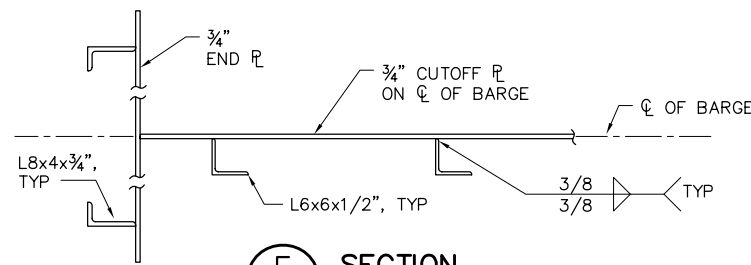


F SECTION
SCALE: 3/4" = 1'-0"

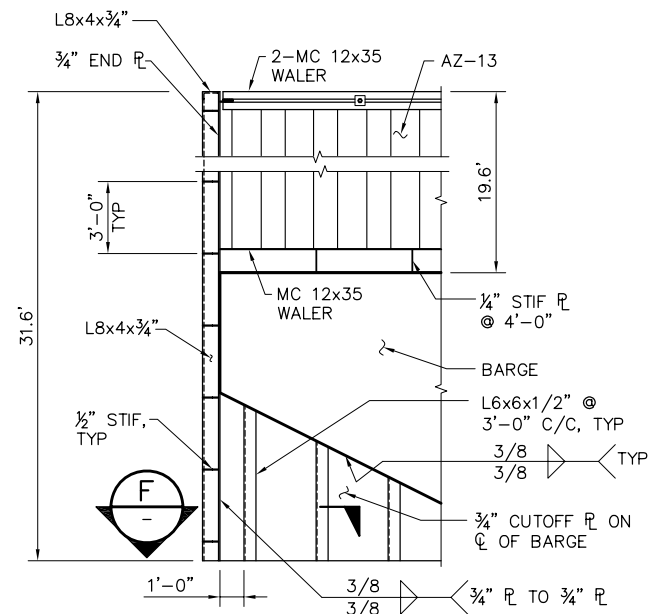


B SECTION
SCALE: 1/4" = 1'-0"


NOTE:
ALL BOLTS ARE ASTM A-307 U.O.N.

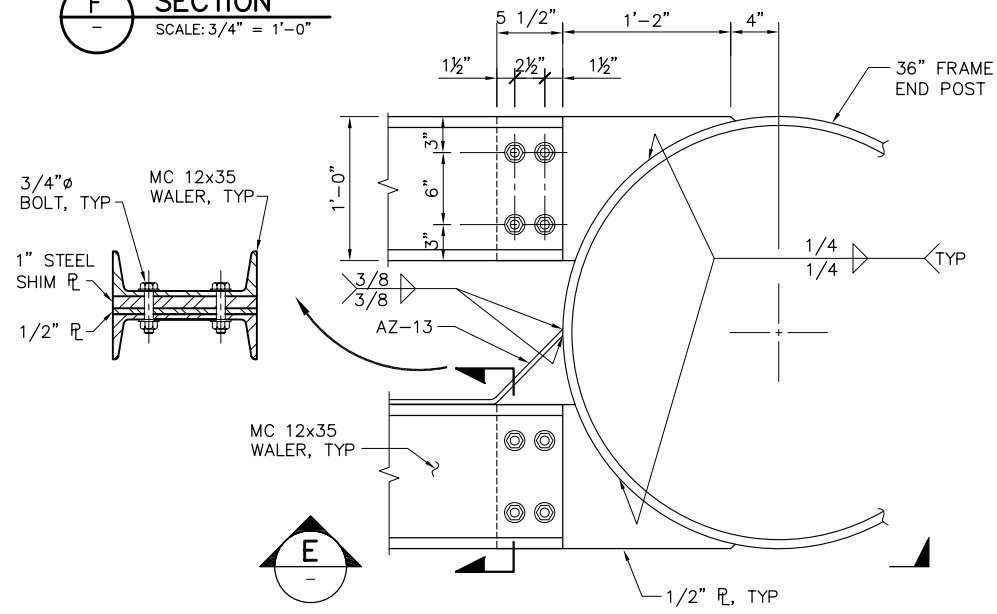

3 DETAIL
SCALE: 1 1/2" = 1'-0"

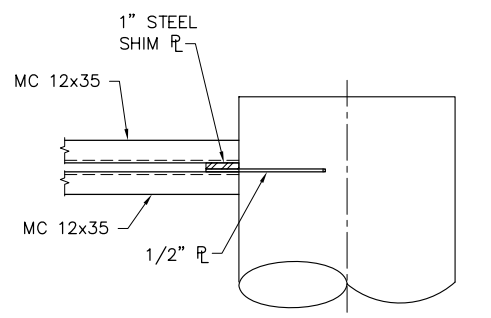

E SECTION
SCALE: 3/4" = 1'-0"

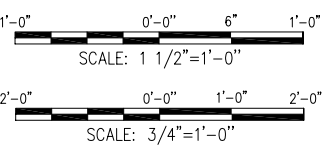

95% SUBMITTAL


IF SHEET IS LESS THAN 22" x 34"
IT IS A REDUCED PRINT -
SCALE REDUCED ACCORDINGLY.

REVISION	DESCRIPTION	BY	DATE

 Moffatt & Nichol		2001 N. Main Street, Suite 360 Walnut Creek, California 94596 (925) 944-5411	
DSGN	JMB	DR	AB
JOB NO.	6097-03	SUBMITTED BY	RMR
CHK	TDB	TITLE	

TWO GATE FISH PROTECTION PLAN		DATE 08/07/09
CONNECTION SLOUGH END WALL SCANTLINGS		SHEET 45 OF 75
C46		

P:\6097-03 SWC GATE DESIGN\CADD\DWG\609703-C47.DWG 8/7/2009 10:20 AM

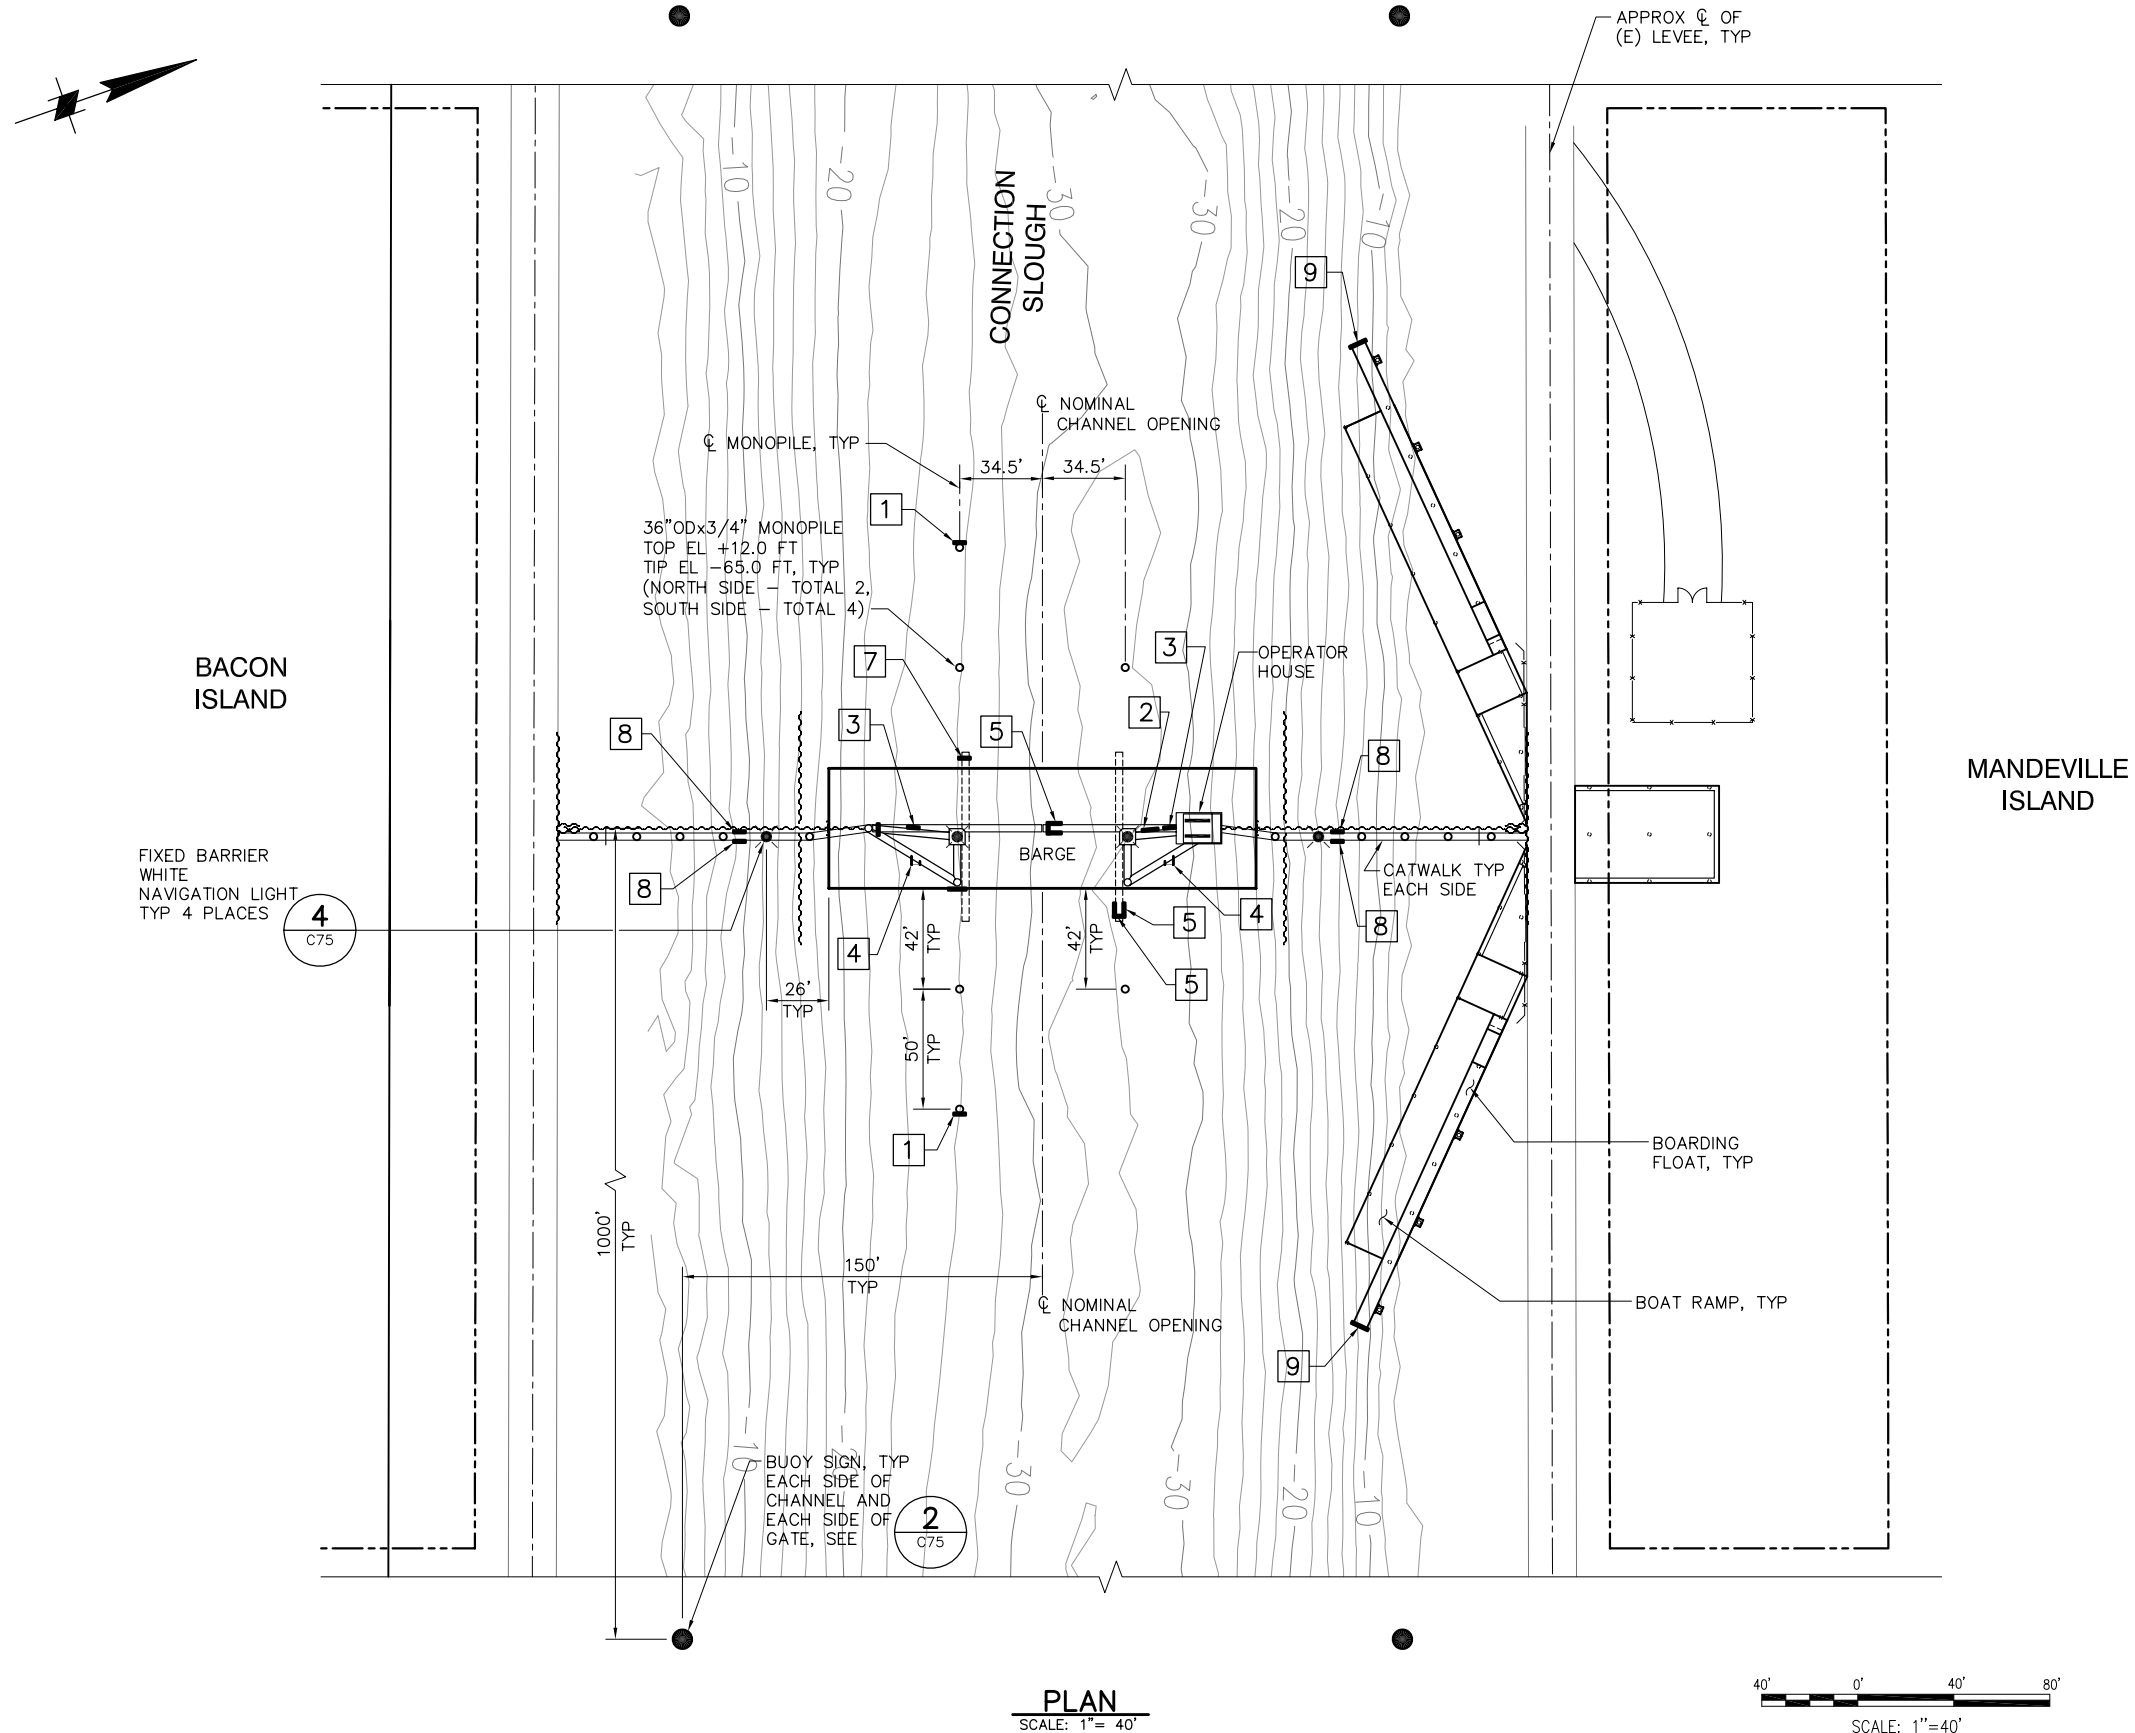

PLAN
SCALE: 1" = 40'

SIGN DATA

LOCATION	SIGN	SIGN DETAIL	SIGN MOUNTING DETAIL
1	GATE 5 MPH	1 C75	1 C76
2	GATE WARNING SIGN	5 C75	5 C76
3	DANGER SIGN	7 C75	5 C76
4	DANGER SIGN	7 C75	3 C76
5	GATE POSITION SIGNS "GATES OPEN" "GATES CLOSED"	6 C75	2 C74
6	GATE WARNING SIGN	5 C75	2 C76
7	GATE POSITION SIGN "GATES OPEN"	6 C75	4 C76
8	STAY BACK WARNING SIGN	9 C75	5 C76
9	BOAT RAMP DOCK SIGN	3 C75	6 C76

95% SUBMITTAL


IF SHEET IS LESS THAN 22" x 34"
IT IS A REDUCED PRINT -
SCALE REDUCED ACCORDINGLY.

REVISION	DESCRIPTION	BY	DATE


 Moffatt & Nichol		2001 N. Main Street, Suite 360 Walnut Creek, California 94596 (925) 944-5411	
DSGN	RBD	DR	AB
JOB NO.	6097-03	SUBMITTED BY	RMR
CHK	TDB	TITLE	

TWO GATE FISH PROTECTION PLAN		DATE 08/07/09
CONNECTION SLOUGH AIDS TO NAVIGATION PLAN		SHEET 46 OF 75
C47		

P:\6097-03 SWC GATE DESIGN\CADD\DWG\609703-C49.DWG 8/5/2009 2:37 PM

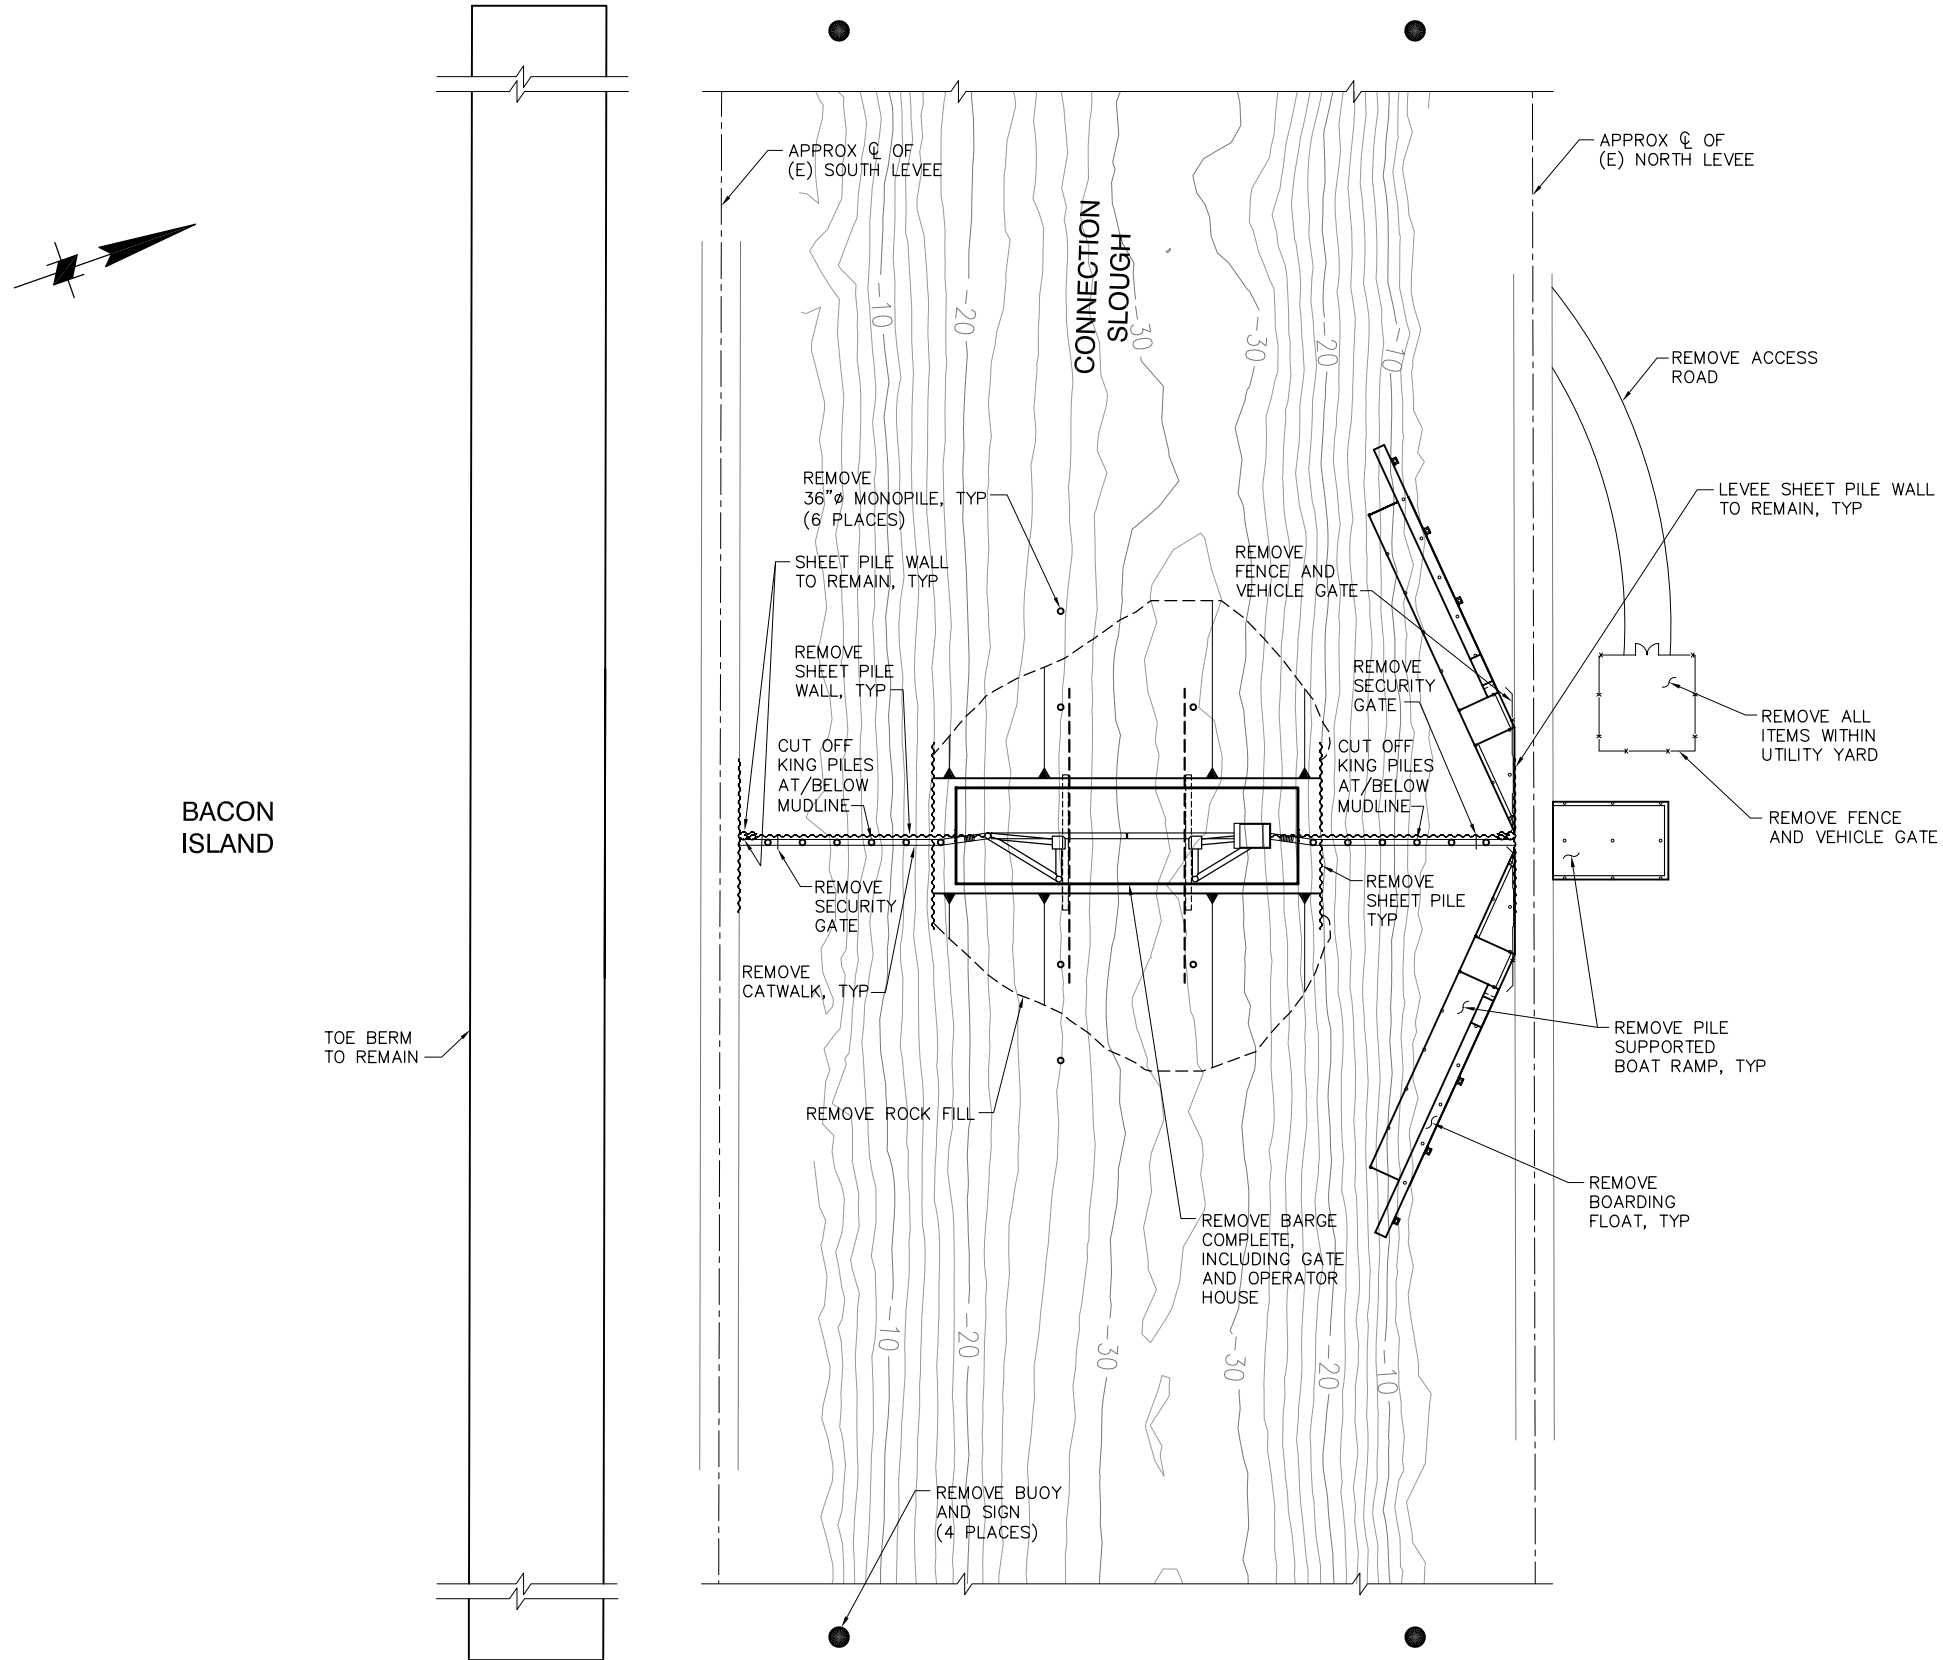

REMOVAL PLAN
SCALE: 1"= 50'

 

- NOTES:
1. REMOVE ALL ELECTRICAL WIRING FROM THE PG&E TRANSFORMERS TO THE OPERATOR HOUSE. REMOVE LIGHT POLES #1 AND #2.
 2. PG&E POWER POLE AND TRASFORMERS TO REMAIN.

95% SUBMITTAL

IF SHEET IS LESS THAN 22" x 34"
IT IS A REDUCED PRINT -
SCALE REDUCED ACCORDINGLY.


REVISION	DESCRIPTION	BY	DATE

 2001 N. Main Street, Suite 360 Walnut Creek, California 94596 (925) 944-5411	
DSGN	TDB
JOB NO.	6097-03
DR	EP
SUBMITTED BY	RMR
CHK	GTH
TITLE	


TWO GATE FISH PROTECTION PLAN
CONNECTION SLOUGH REMOVAL PLAN

DATE 08/07/09
SHEET 48 OF 75
C49


P:\6097-03 SWC GATE DESIGN\CADD\DWG\609703-C57.DWG 7/24/2009 10:01 AM

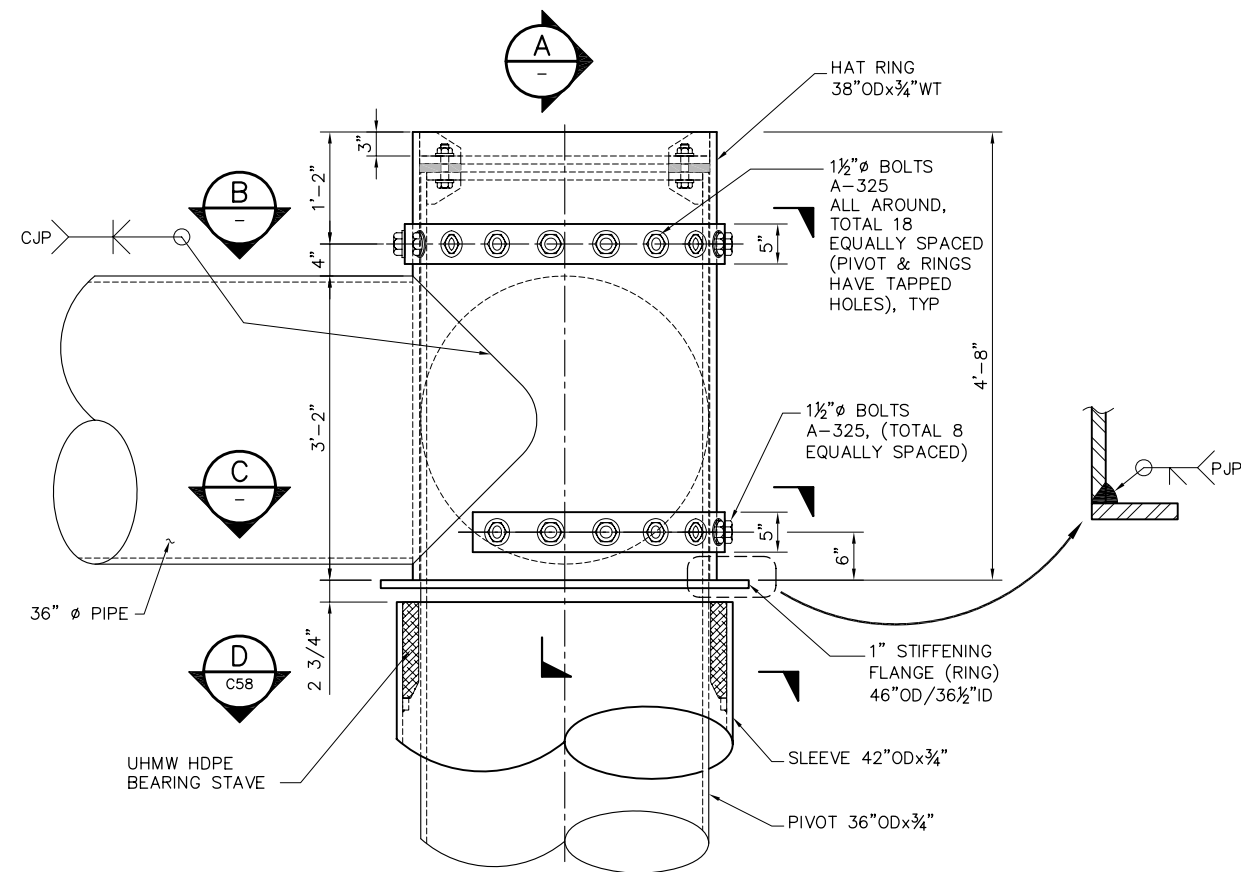


1 TOP PIVOT - FRAME CONNECTION
C16 SCALE: 1" = 1'-0"

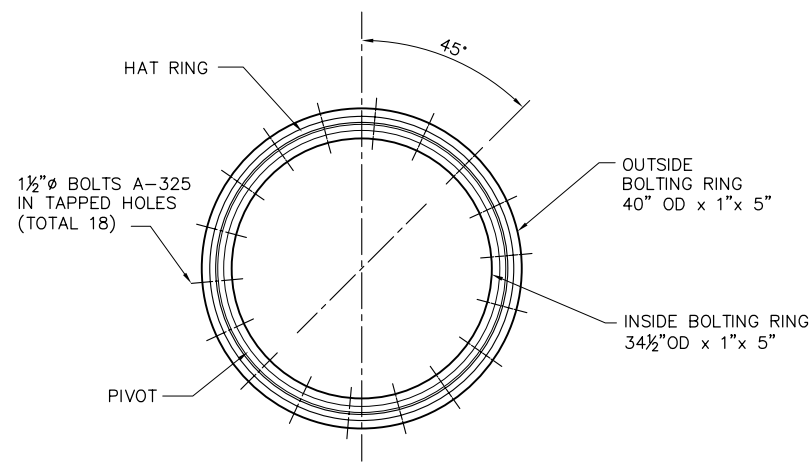


B SECTION
SCALE: 1" = 1'-0"

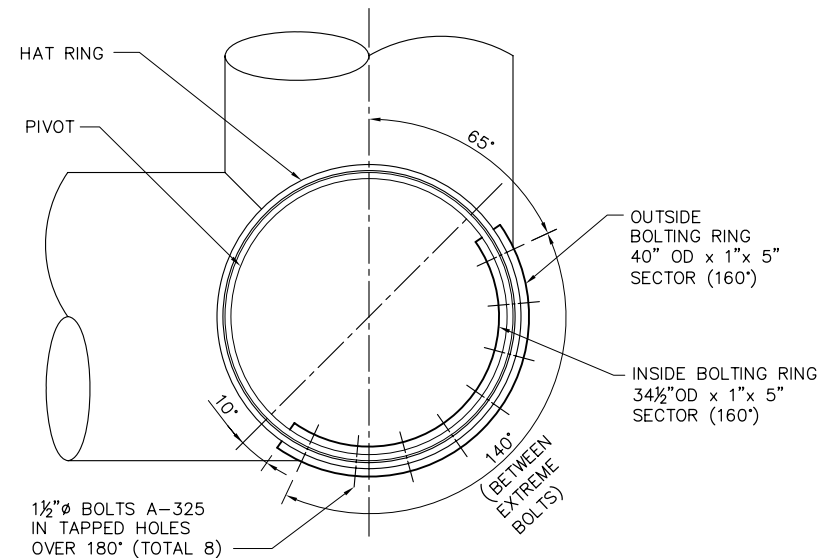


C SECTION
SCALE: 1" = 1'-0"

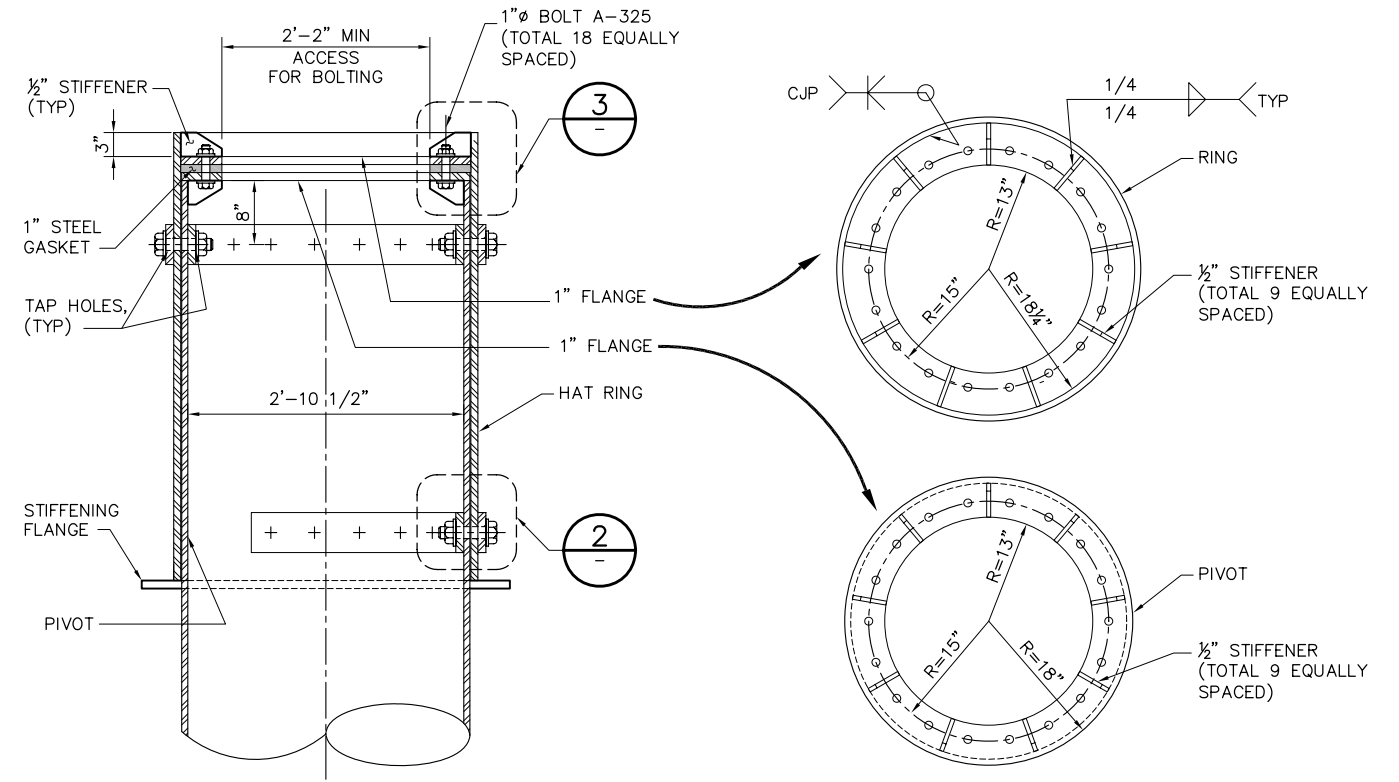

A SECTION
SCALE: 1" = 1'-0"

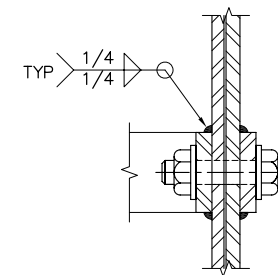

2 DETAIL
NTS

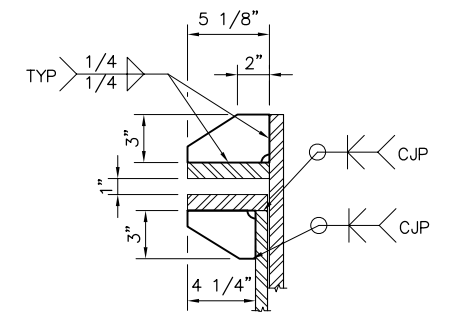

3 DETAIL
NTS

NOTES:

- ALL STIFFENER WELDS SHALL BE SYMMETRICAL 1/4" MIN. FILLET WELDS U.N.O.

1'-0" 0'-0" 1'-0" 2'-0"
SCALE: 1"=1'-0"

95% SUBMITTAL

IF SHEET IS LESS THAN 22" x 34"
IT IS A REDUCED PRINT -
SCALE REDUCED ACCORDINGLY.


REVISION	DESCRIPTION	BY	DATE

 Moffatt & Nichol		2001 N. Main Street, Suite 360 Walnut Creek, California 94596 (925) 944-5411	
DSGN	JMB/CBS	DR	AB
JOB NO.	6097-03	SUBMITTED BY	RMR
CHK	TDB	TITLE	


TWO GATE FISH PROTECTION PLAN		DATE	08/07/09
GATE STRUCTURAL DETAILS SHEET 2		SHEET	50 OF 75

C57


P:\6097-03 SWC GATE DESIGN\CADD\DWG\609703-C58.DWG 8/5/2009 12:27 PM

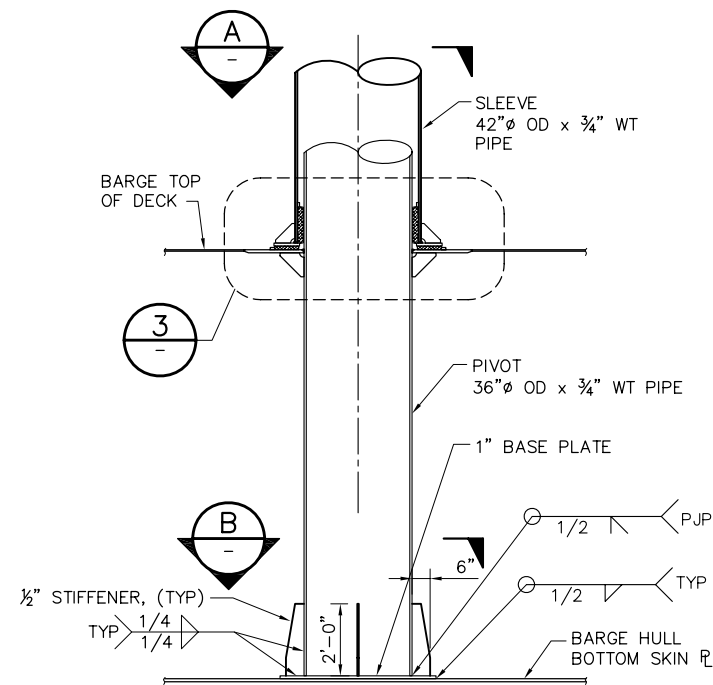


1 FRAMING PIVOT CONNECTION
C15 SCALE: 3/8" = 1'-0"
C43

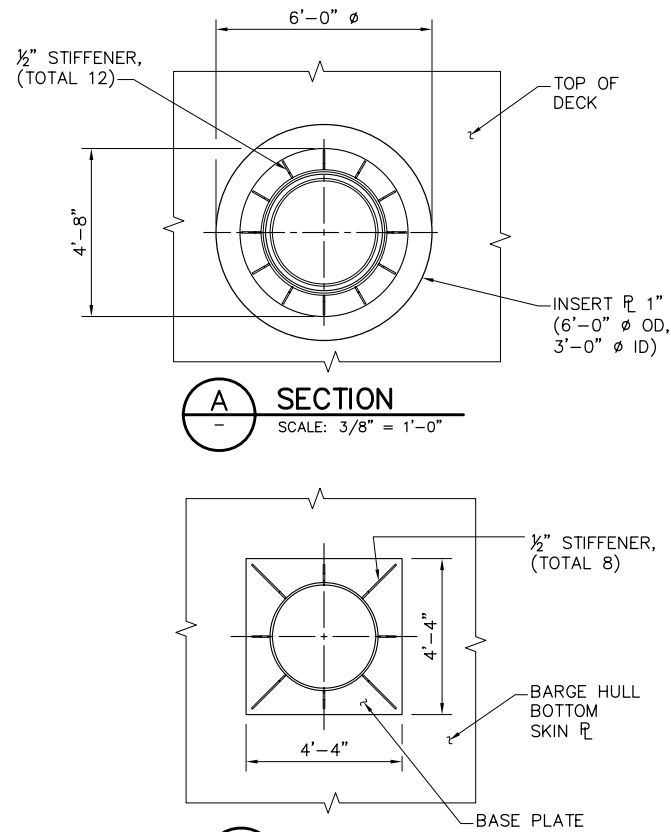


2 FRAME CONNECTION
C17 SCALE: 3/4" = 1'-0"
C59

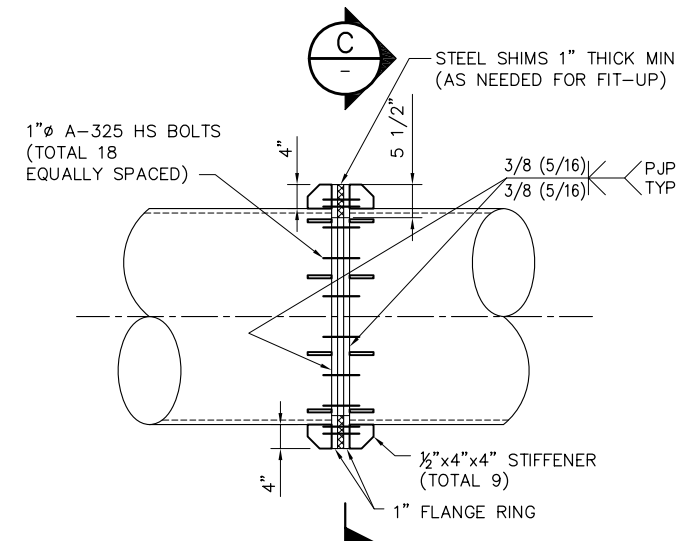


3 UHMW HDPE THRUST BEARING
C17 SCALE: 3/4" = 1'-0"
C45, C59

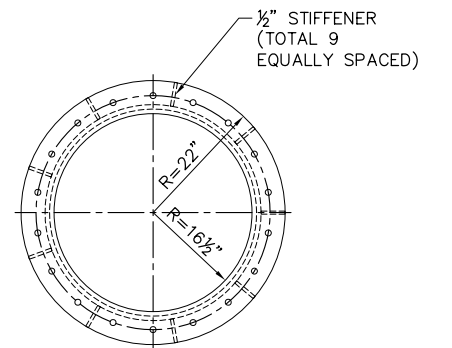


4 DETAIL
C17 SCALE: 3/4" = 1'-0"

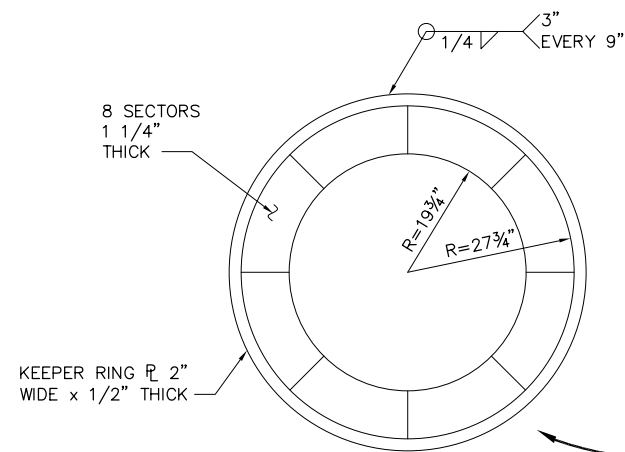

UHMW HDPE THRUST BEARING

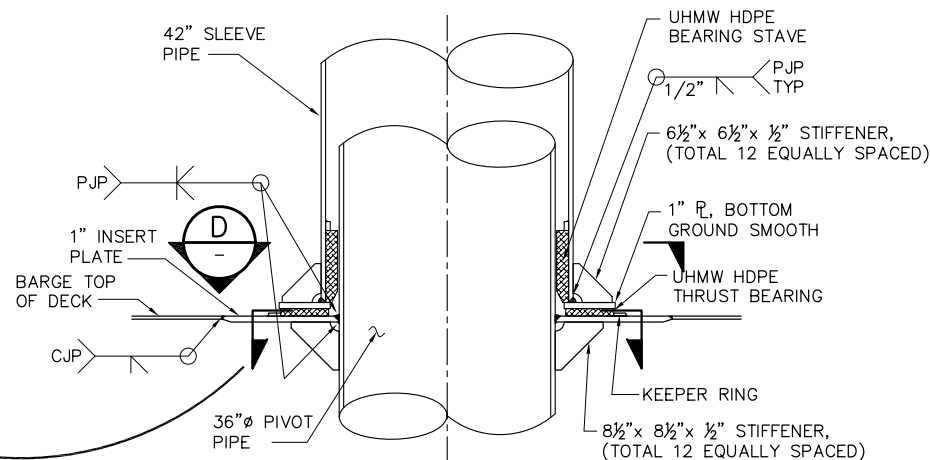


3 DETAIL
SCALE: 3/4" = 1'-0"

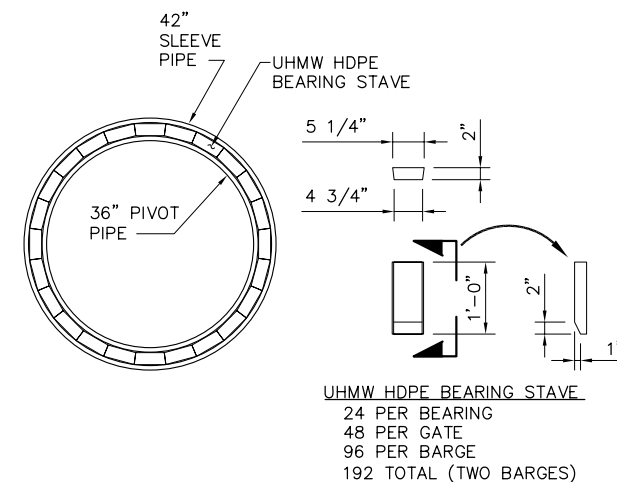

D SECTION
SCALE: 3/4" = 1'-0"

NOTES:

1. ALL STIFFENER WELDS SHALL BE SYMMETRICAL 1/4" MIN. FILLET WELDS U.N.O.

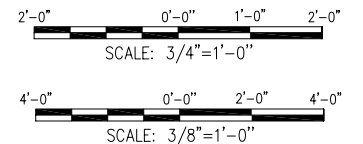









95% SUBMITTAL

IF SHEET IS LESS THAN 22" x 34"
IT IS A REDUCED PRINT -
SCALE REDUCED ACCORDINGLY.

REVISION	DESCRIPTION	BY	DATE


 Moffatt & Nichol		2001 N. Main Street, Suite 360 Walnut Creek, California 94596 (925) 944-5411	
DSGN	JMB/CBS	DR	AB
JOB NO.	6097-03	SUBMITTED BY	RMR
CHK	TDB	TITLE	

TWO GATE FISH PROTECTION PLAN		DATE	08/07/09
GATE STRUCTURAL DETAILS SHEET 3		SHEET	51 OF 75
			C58

 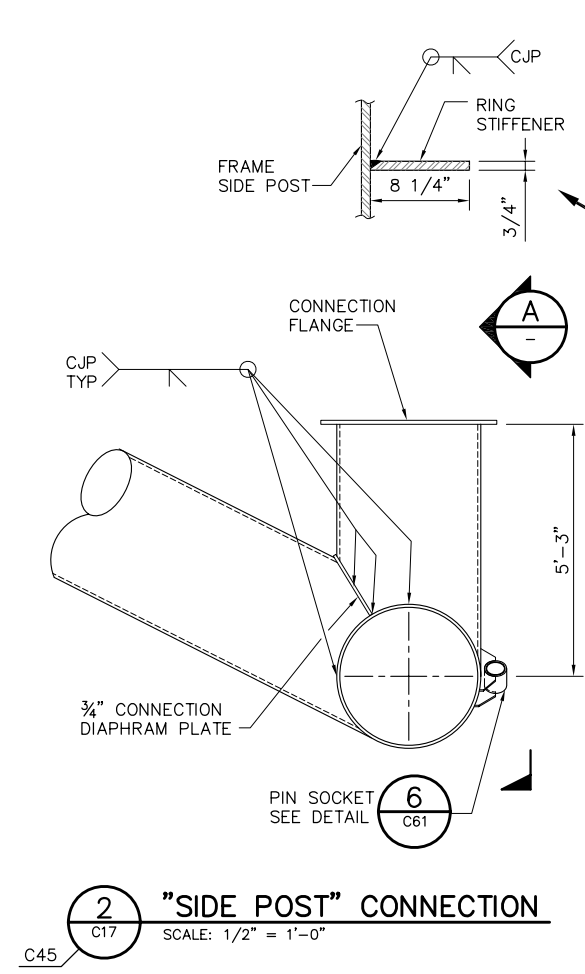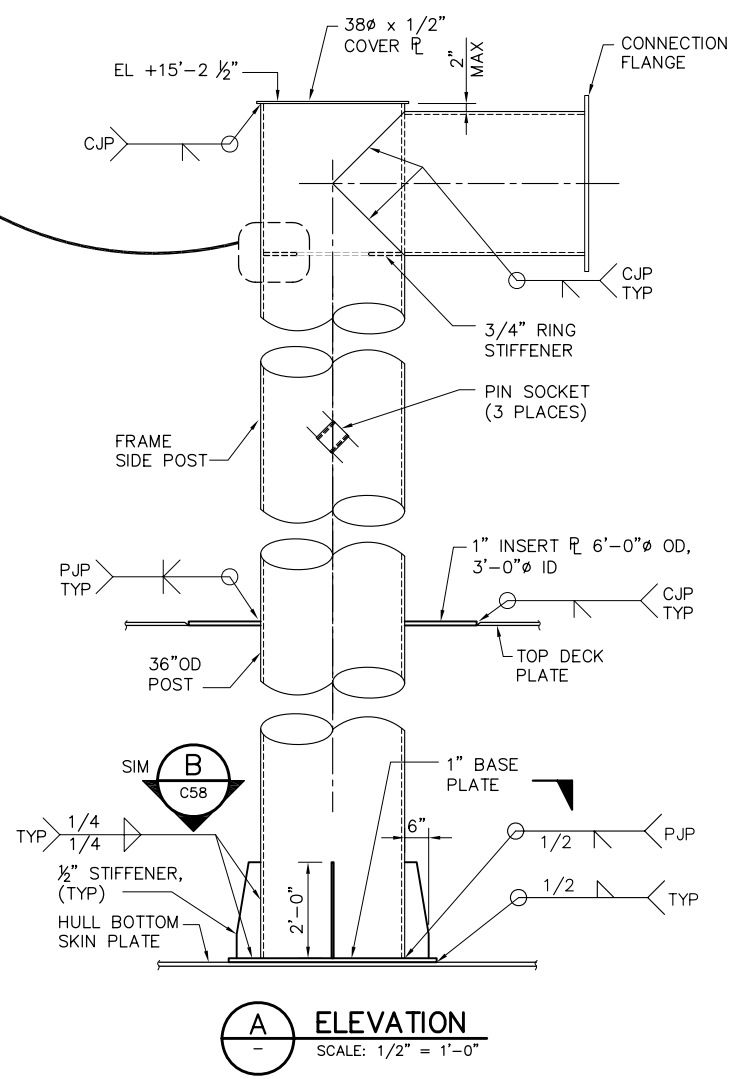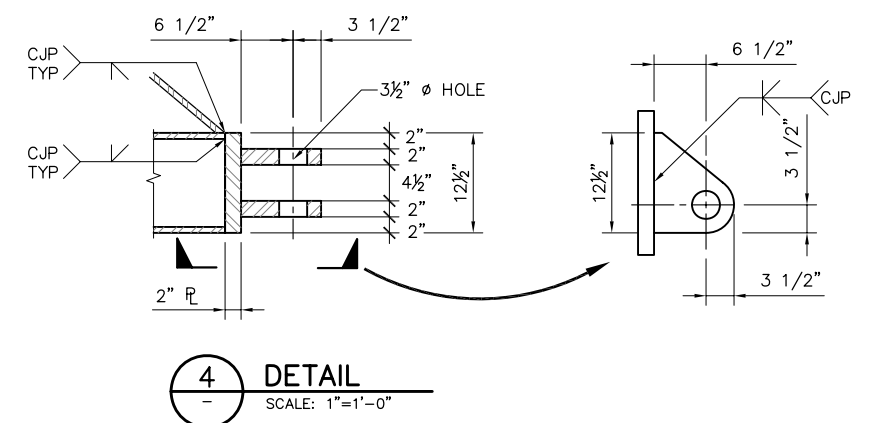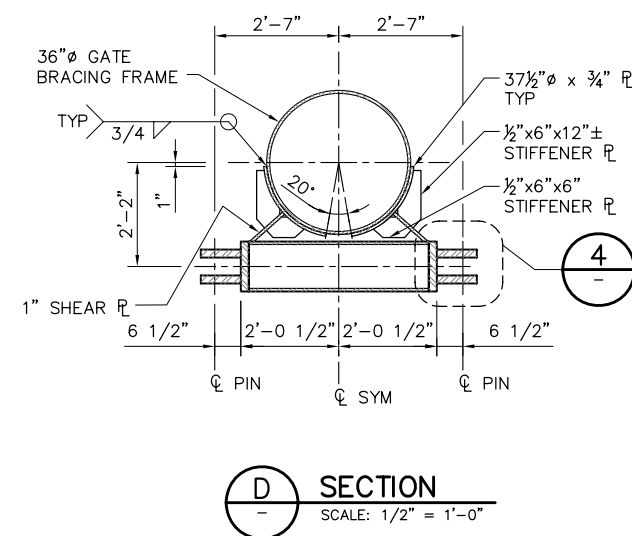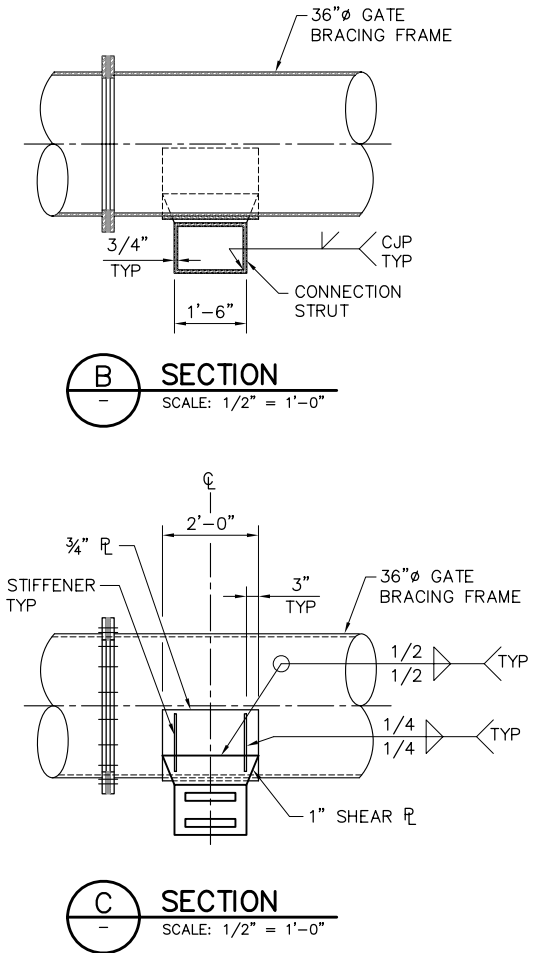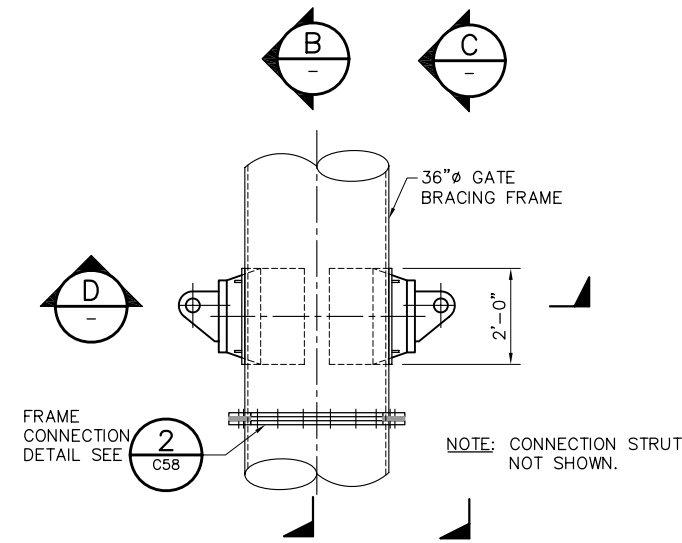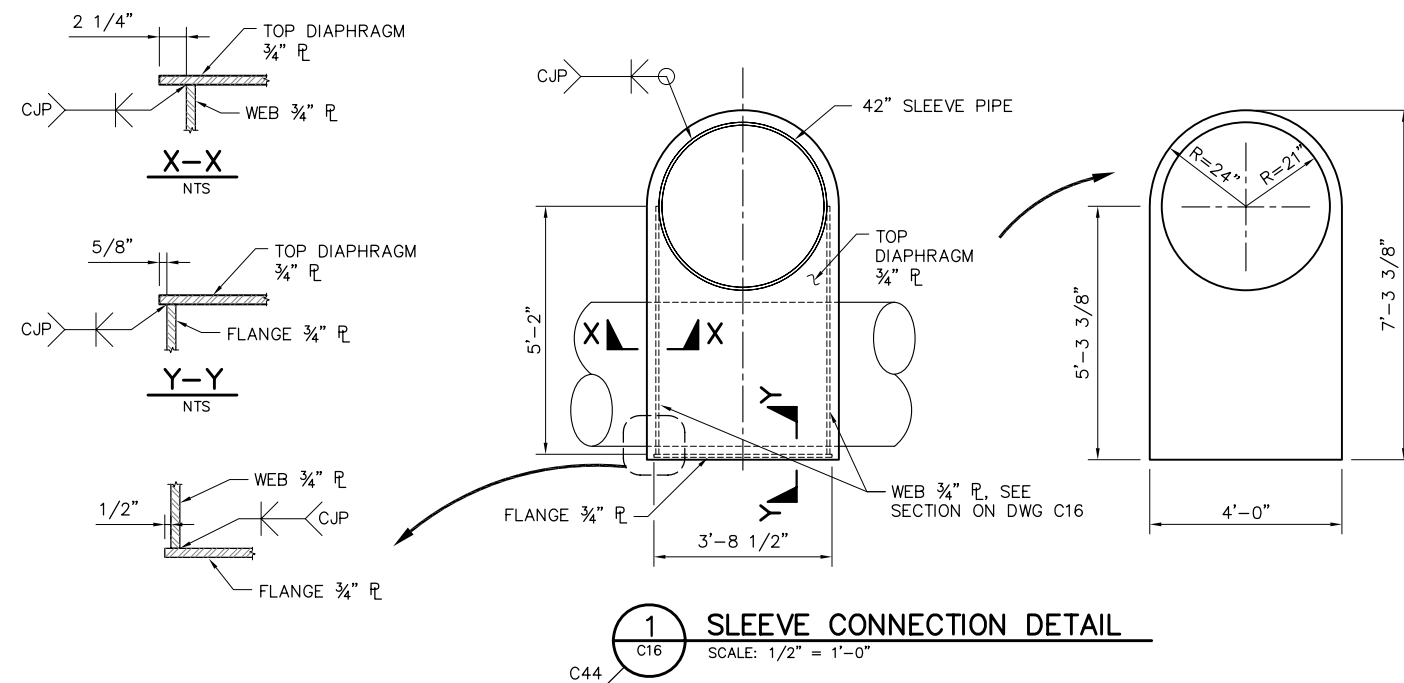


95% SUBMITTAL IF SHEET IS LESS THAN 22" x 34'
IT IS A REDUCED PRINT –
SCALE REDUCED ACCORDINGLY.


REVISION	DESCRIPTION	BY	DATE			Moffatt & Nichol 2001 N. Main Street, Suite 360 Walnut Creek, California 94596 (925) 944-5411	TWO GATE FISH PROTECTION PLAN		DATE 08/07/09		
											SHEET 52 OF 75
						DSGNJMB DRAB CHKCBS JOB NO.6097-03 SUBMITTED BYRMR TITLE	GATE STRUCTURAL DETAILS, SHEET 4		C59		

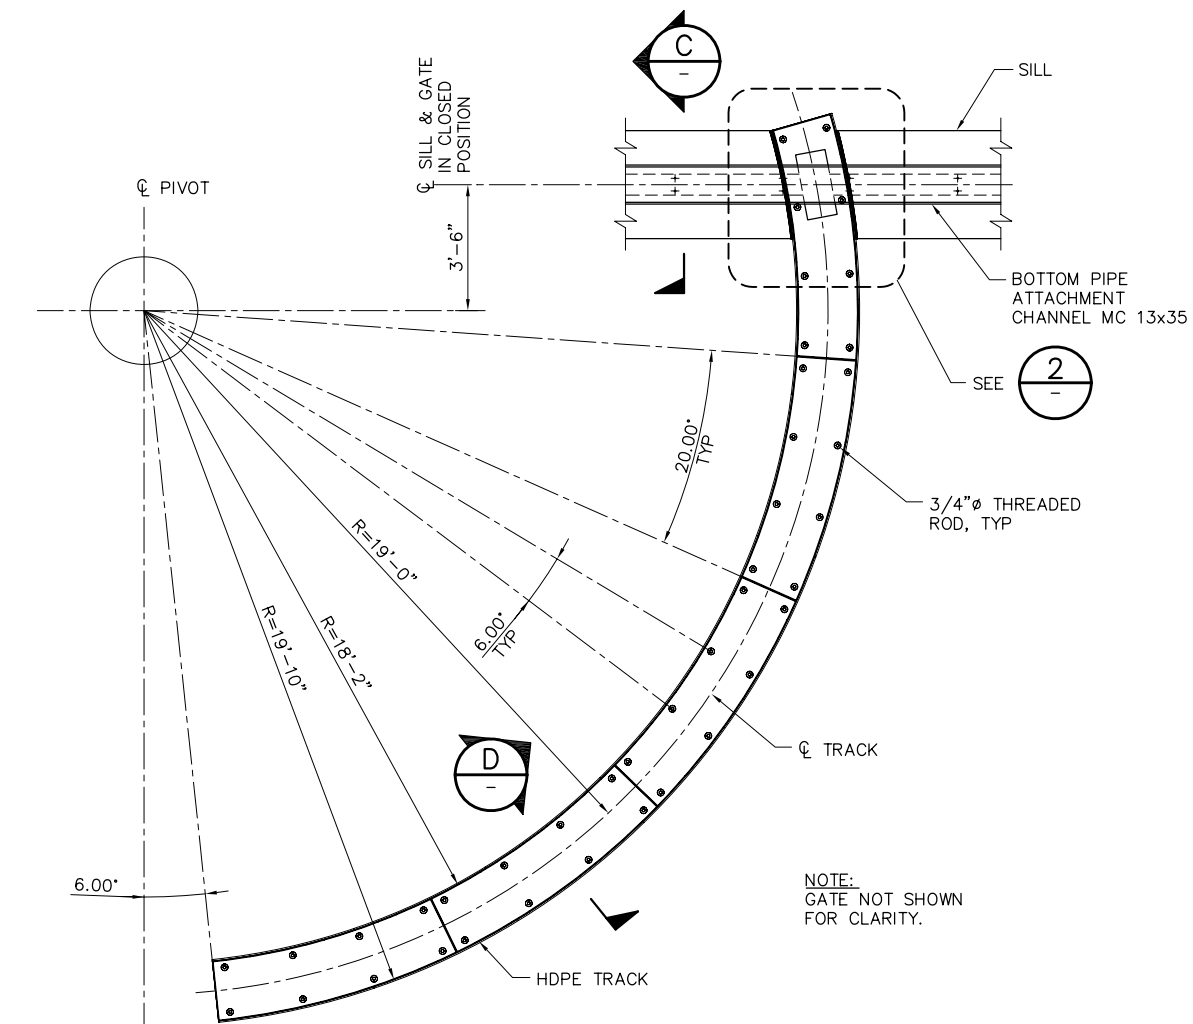


1 TRACK DETAIL
SCALE: 3/8" = 1'-0"

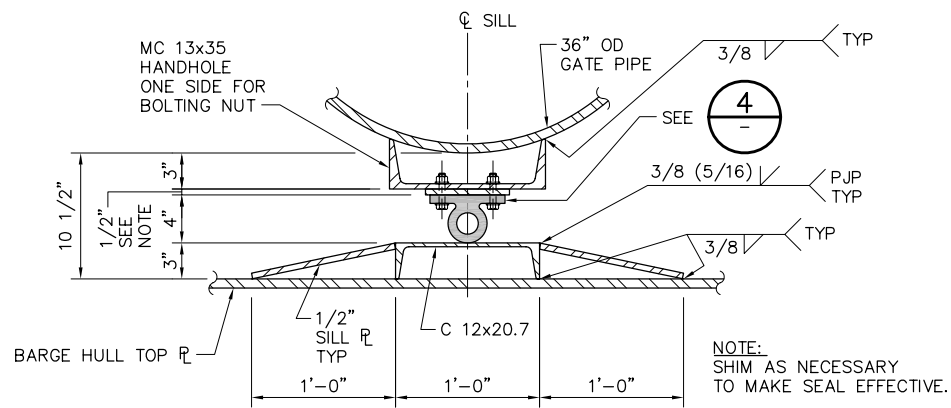


C SECTION
SCALE: 1 1/2" = 1'-0"

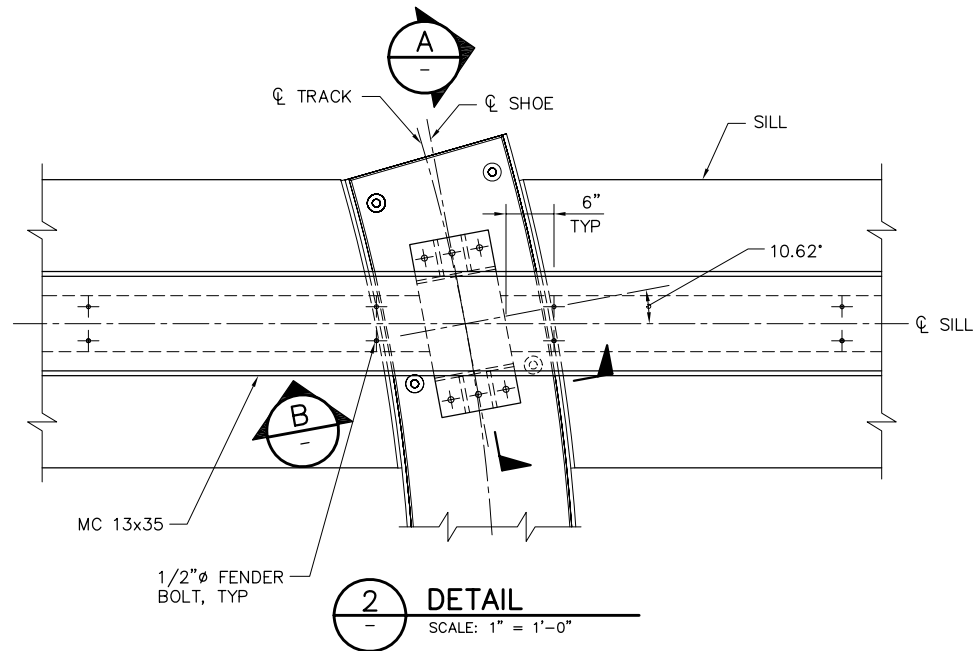


2 DETAIL
SCALE: 1" = 1'-0"

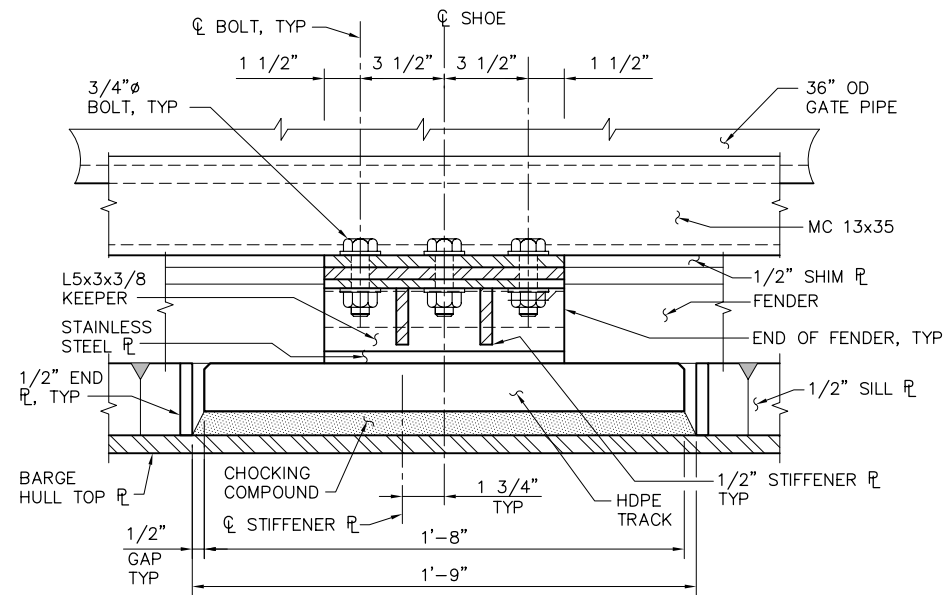


B SECTION
SCALE: 3" = 1'-0"

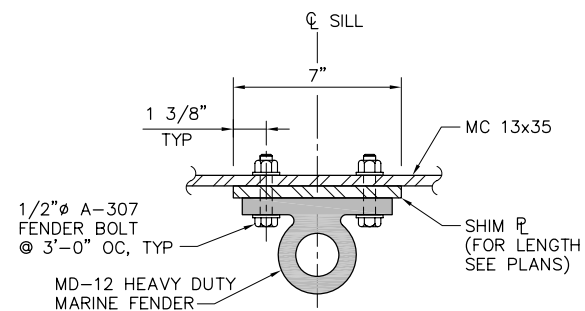


4 DETAIL
SCALE: 3" = 1'-0"

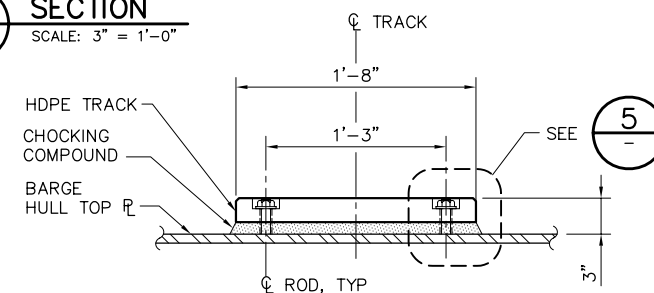


D SECTION
— SCALE: 1 1/2" = 1'-0"

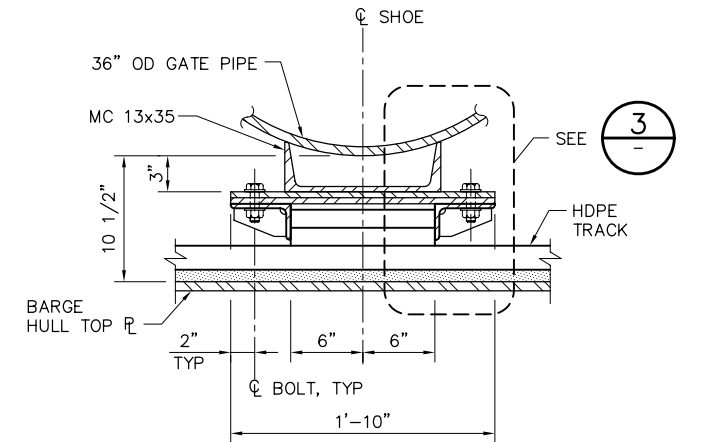

A SECTION
SCALE: 1 1/2" = 1'-0"

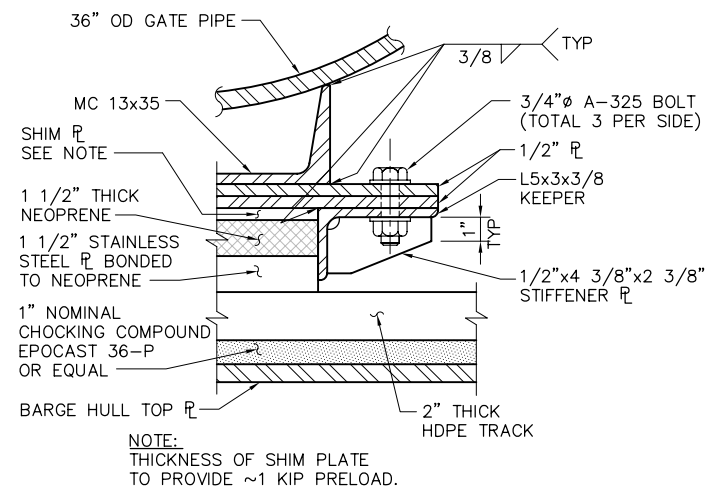

3
-
DETAIL
SCALE: 3" = 1'-0"

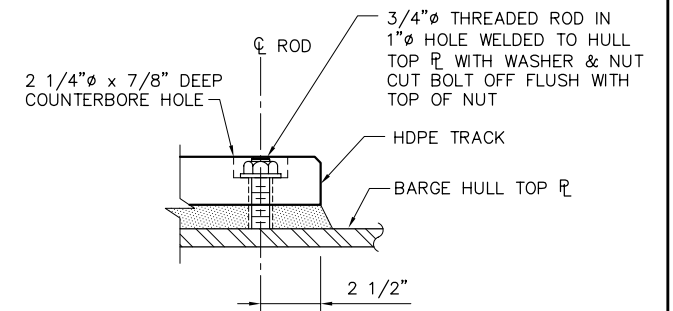

5 DETAIL
SCALE: 3" = 1'-0"

95% SUBMITTAL

IF SHEET IS LESS THAN 22" x 34"
IT IS A REDUCED PRINT –
SCALE REDUCED ACCORDINGLY.

REVISION	DESCRIPTION	BY	DATE



Moffatt & Nichol

2001 N. Main Street, Suite 360
Walnut Creek, California 94596
(925) 944-5411

TWO GATE FISH PROTECTION PLAN

DATE 08/07/09


SHEET 53 OF 75

DSGN JMB	DR EP/AB	CHK CBS
JOB NO. 6097-03	SUBMITTED BY RMR	TITLE


GATE STRUCTURAL DETAILS,
SHEET 5

C60


P:\6097-03 SWC GATE DESIGN\CADD\DWG\609703-C61.DWG 7/30/2009 12:03 PM

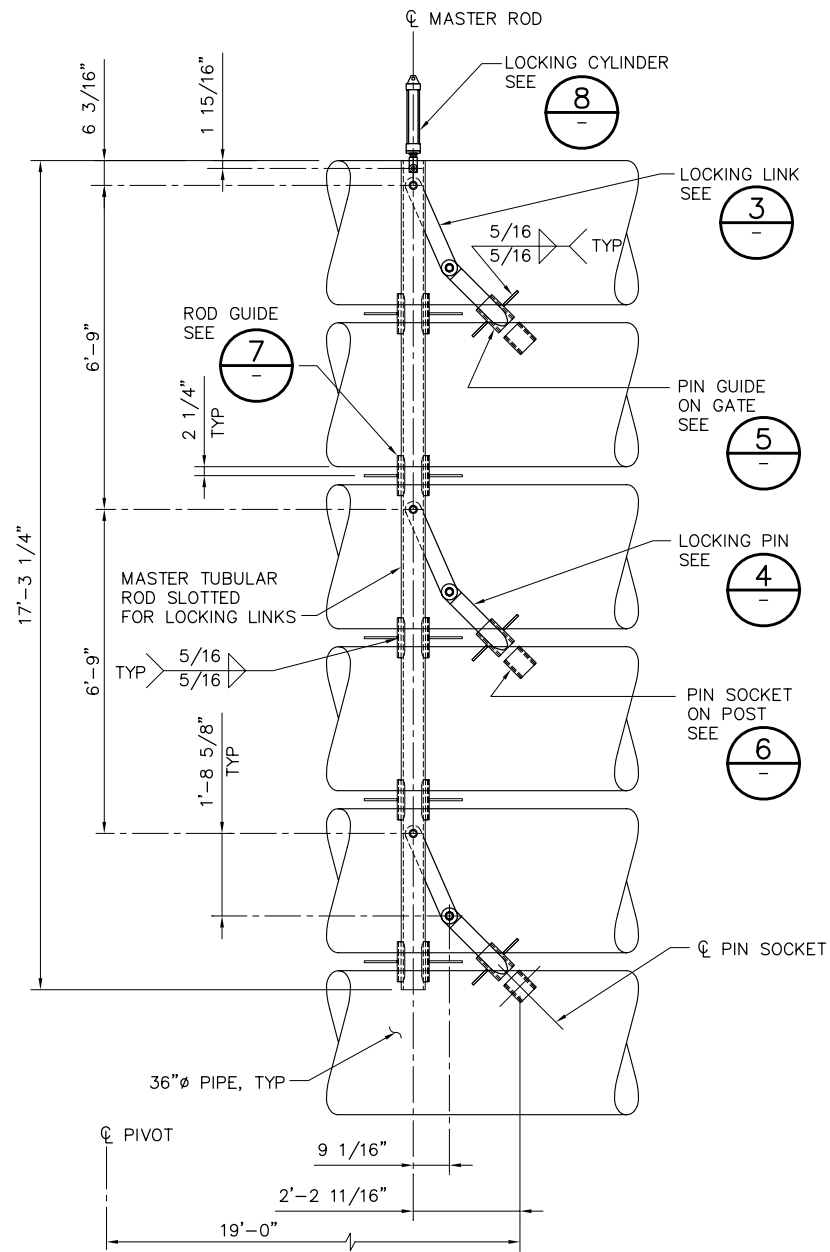


1 GATE OPEN LOCK (UNLOCKED) DETAIL
SCALE: 1/2" = 1'-0"

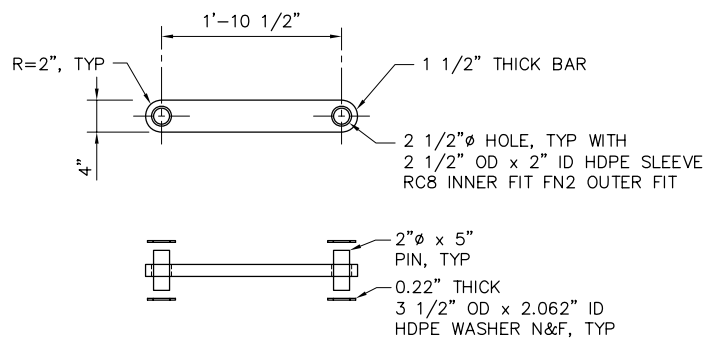


3 LOCKING LINK DETAIL
SCALE: 1" = 1'-0"

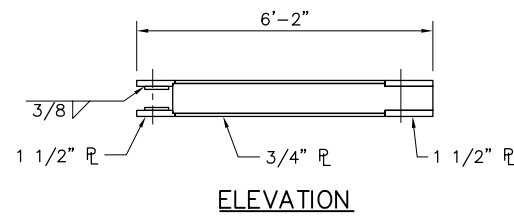



2 GATE YOKE DETAIL
SCALE: 1/2" = 1'-0"

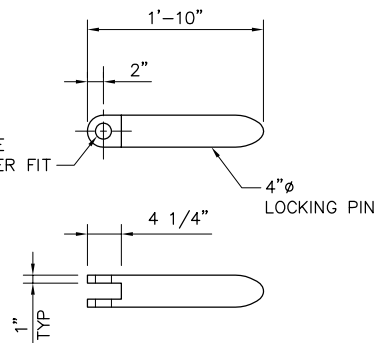


4 LOCKING PIN DETAIL
SCALE: 1" = 1'-0"

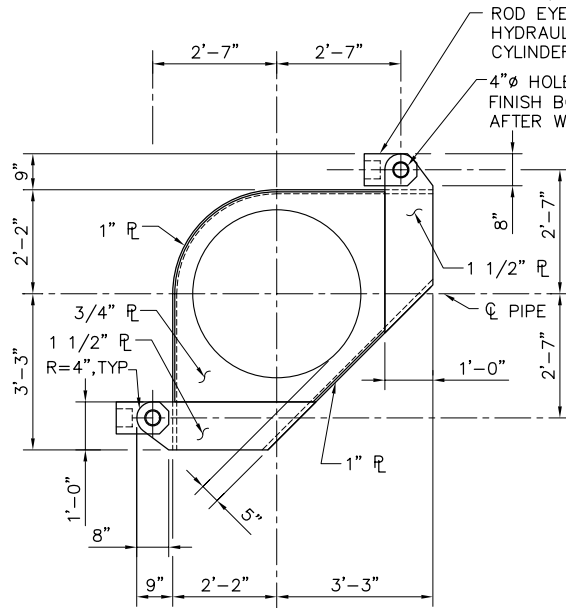


5 PIN GUIDE DETAIL
SCALE: 1" = 1'-0"

 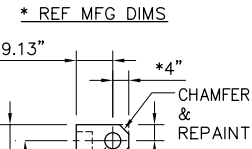


7 ROD GUIDE DETAIL
SCALE: 1" = 1'-0"

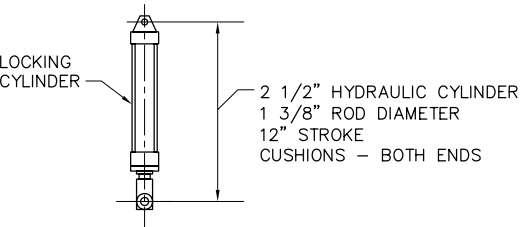

8 LOCKING CYLINDER DETAIL
SCALE: 1" = 1'-0"

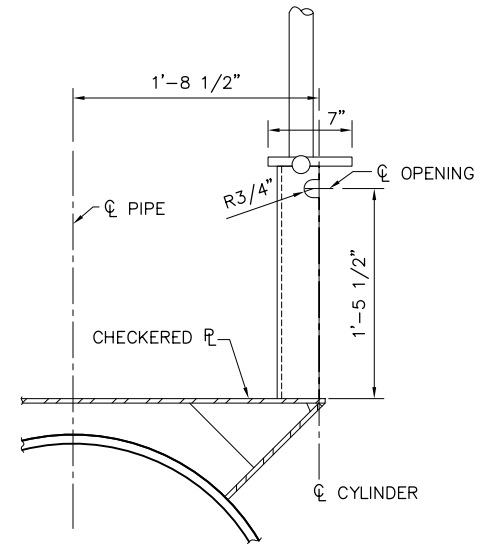

 9 CYLINDER SUPPORT DETAIL
SCALE: 1 1/2" = 1'-0"















95% SUBMITTAL IF SHEET IS LESS THAN 22" x 34" IT IS A REDUCED PRINT - SCALE REDUCED ACCORDINGLY.

REVISION	DESCRIPTION	BY	DATE

 Moffatt & Nichol		2001 N. Main Street, Suite 360 Walnut Creek, California 94596 (925) 944-5411	
DSGN	CBS	DR	CBS/EP
JOB NO.	6097-03	SUBMITTED BY	RMR
CHK	TDB	TITLE	

TWO GATE FISH PROTECTION PLAN		DATE	08/07/09
GATE MECHANICAL DETAILS SHEET 1		SHEET	54 OF 75

  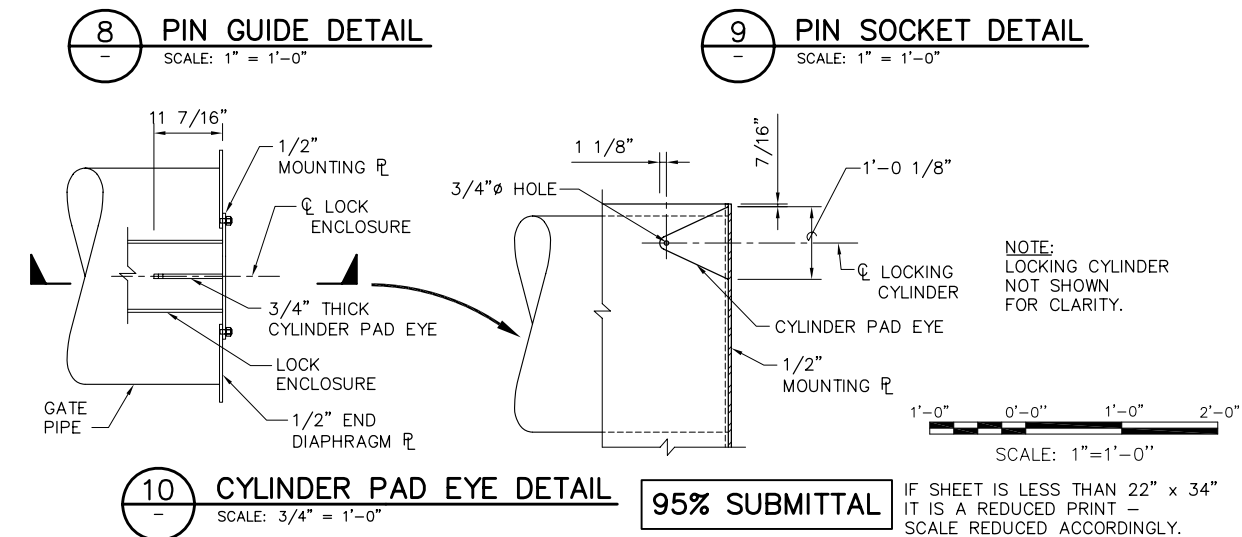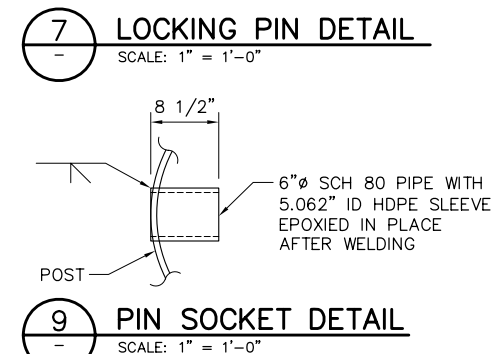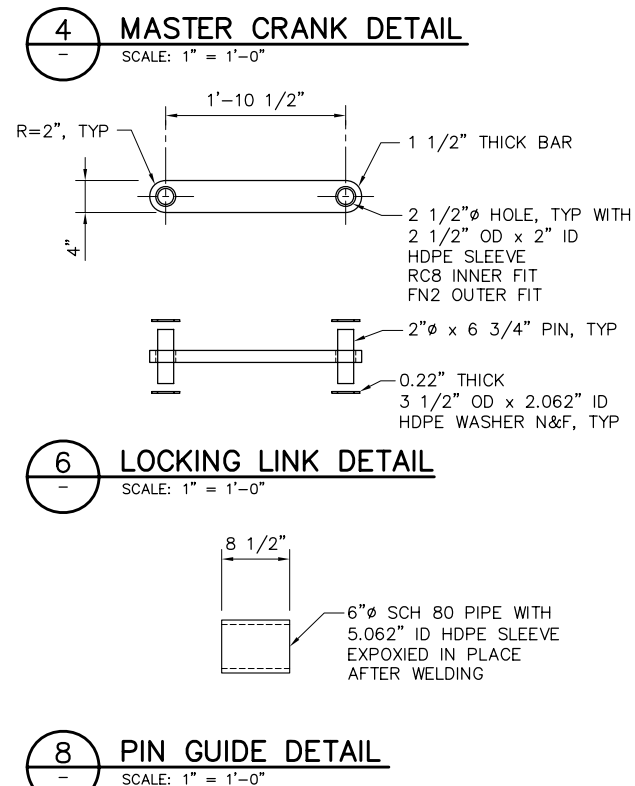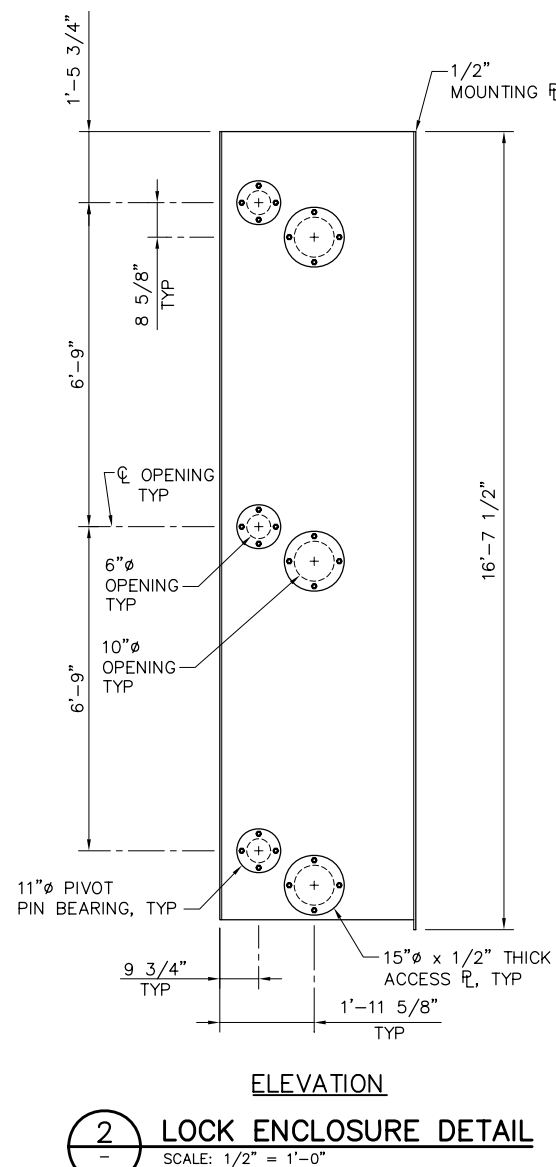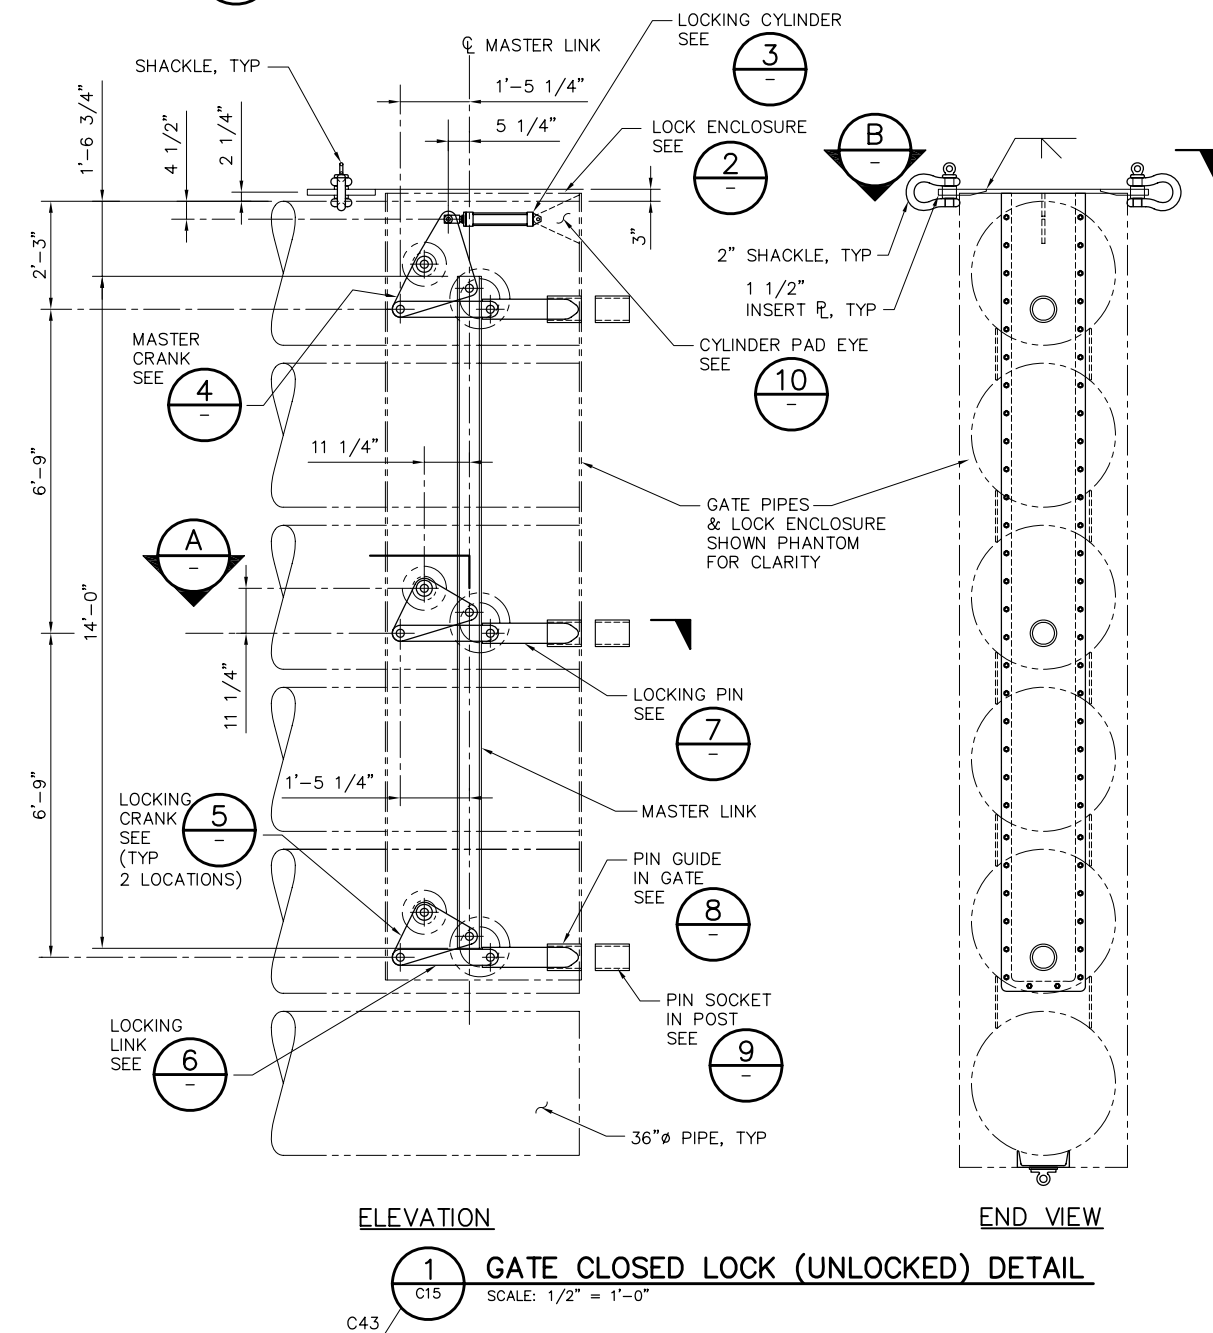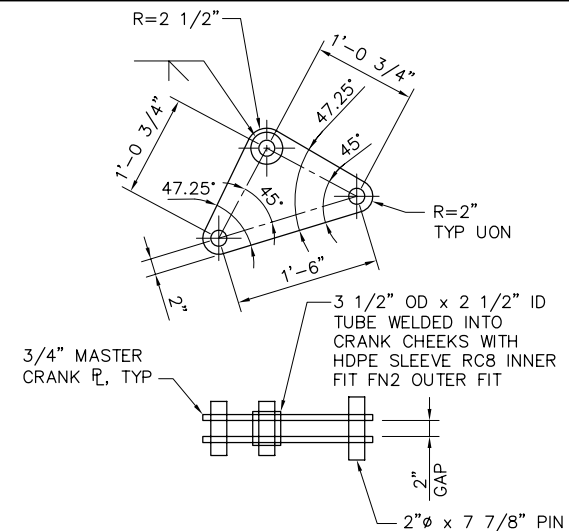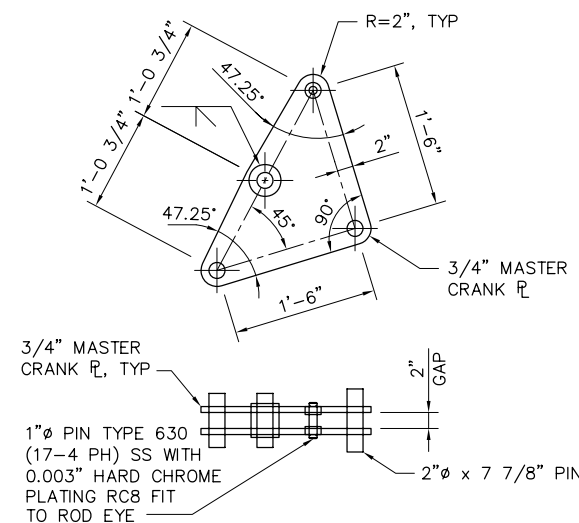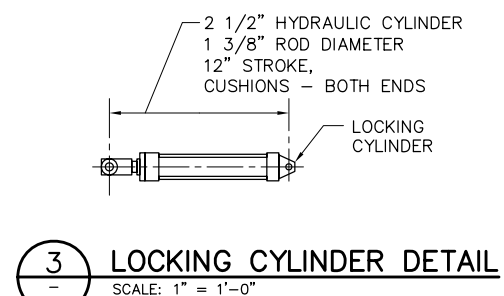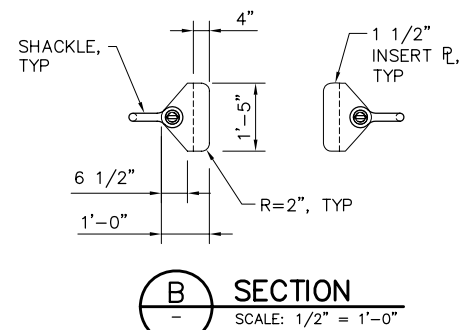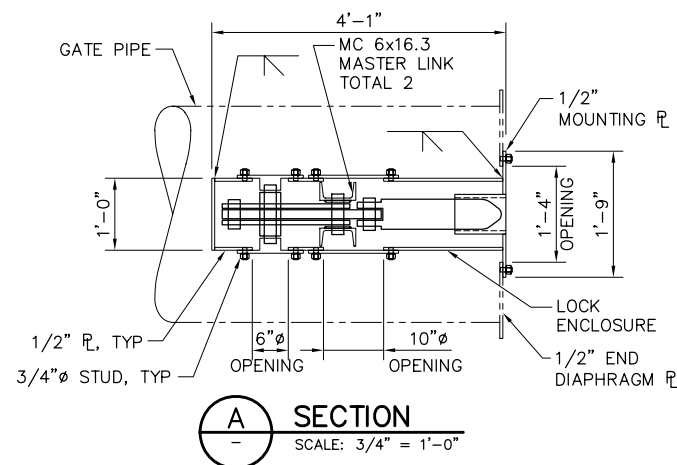

95% SUBMITTAL

IF SHEET IS LESS THAN 22" x 34"
IT IS A REDUCED PRINT –
SCALE REDUCED ACCORDINGLY.

REVISION	DESCRIPTION	BY	DATE



Moffatt & Nichol

2001 N. Main Street, Suite 360
Walnut Creek, California 94596
(925) 944-5411

DSGN	CBS	DR	EP/AB	CHK	TDB
JOB NO.	6097-03	SUBMITTED BY	RMR	TITLE	

 





TWO GATE FISH PROTECTION PLAN

DATE 08/07/09

SHEET 55 OF 75

GATE MECHANICAL DETAILS
SHEET 2

C62

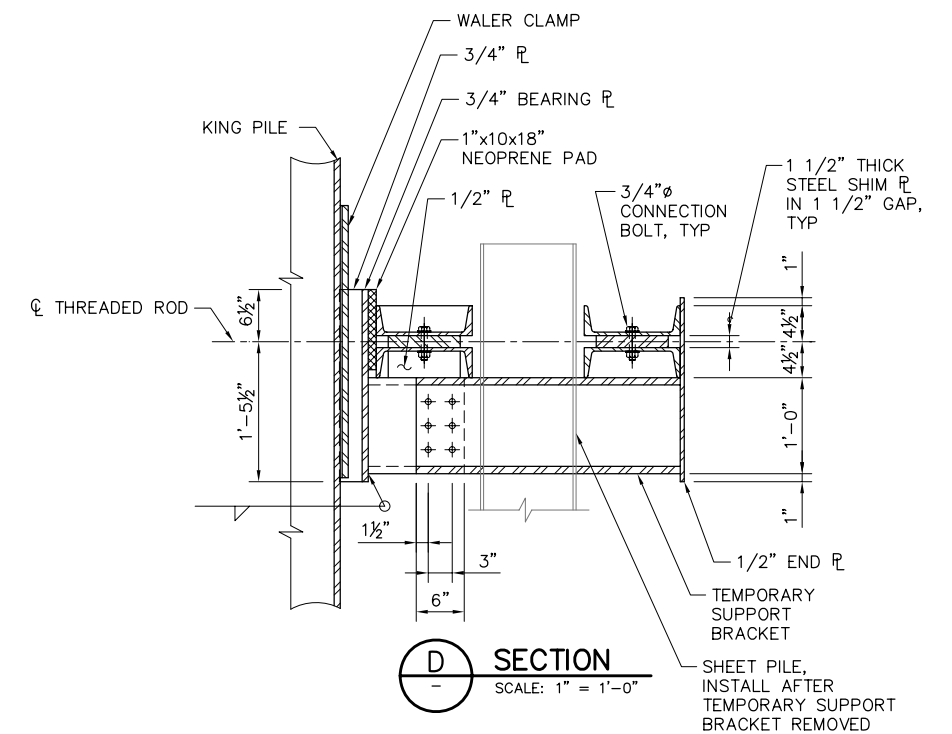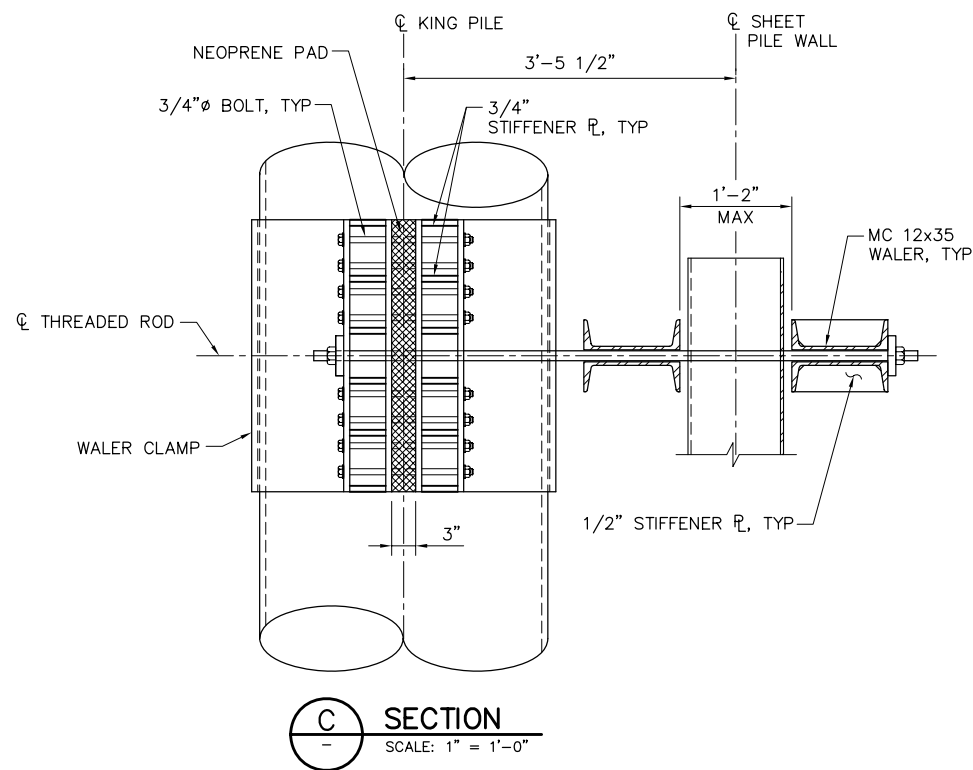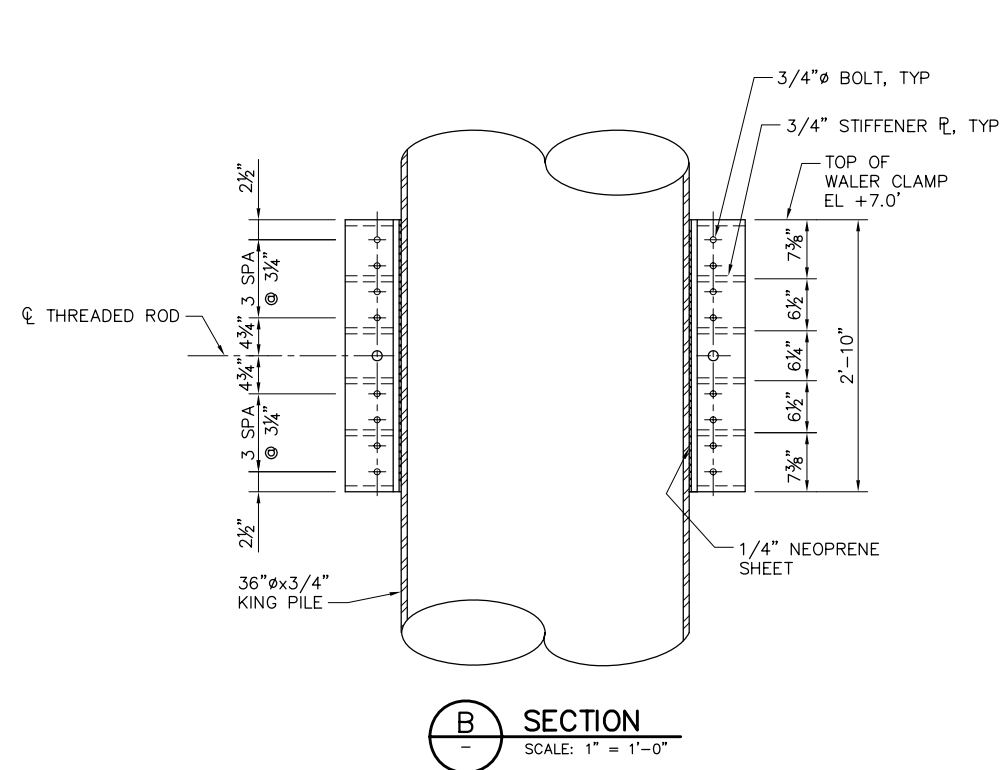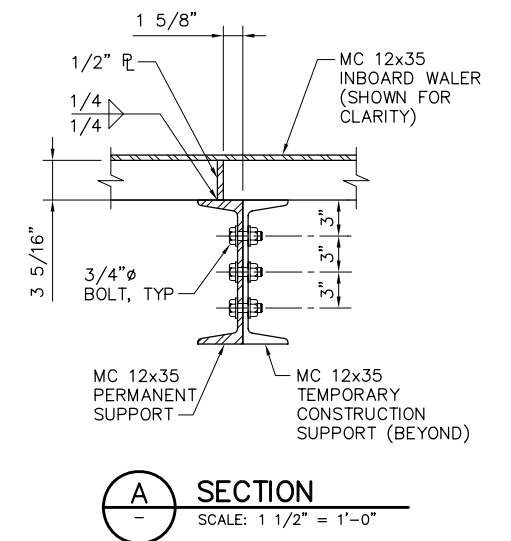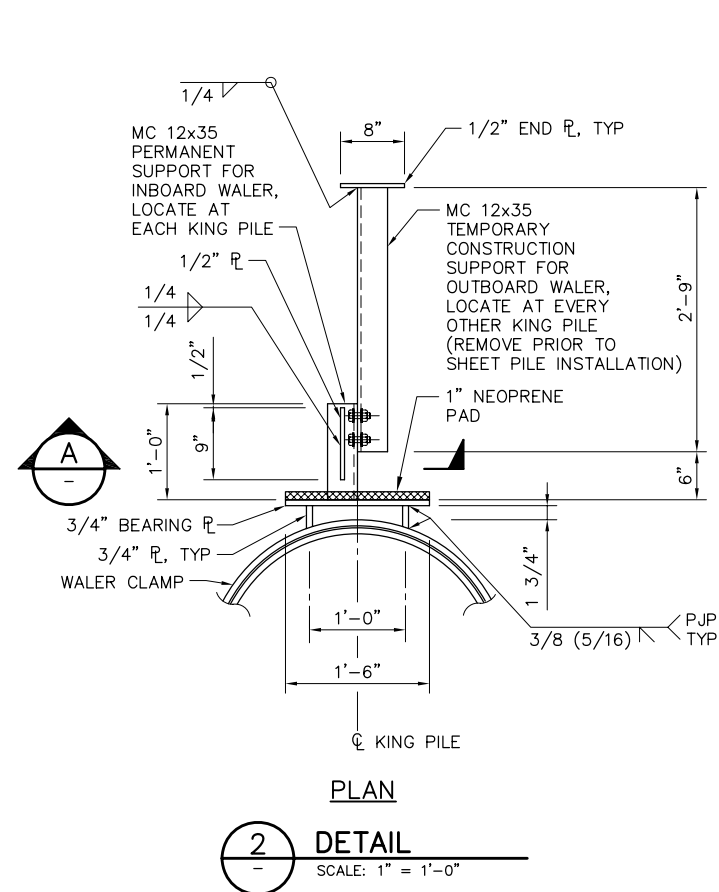

IF SHEET IS LESS THAN 22" x 34"
IT IS A REDUCED PRINT –
SCALE REDUCED ACCORDINGLY.

REVISION	DESCRIPTION	BY	DATE

	2001 N. Main Street, Suite 360 Walnut Creek, California 94596 (925) 944-5411	
	Moffatt & Nichol	

SHEET 56 OF 75

C63


Technical drawing of a bridge deck cross-section. The drawing shows a central section with a splice and walers. Key dimensions and labels include:

- Top Section:** A circular detail labeled 'B' with a horizontal line through the center, indicating a splice. The label 'SPLICE (SYM)' is next to it.
- Horizontal Dimensions:**
 - Top width: $1'-3 \frac{1}{2}"$
 - Inner width: $3 \frac{1}{2}"$
 - Left offset: $2"$
 - Right offset: $2 \frac{1}{4}"$
 - Right edge offset: $3 \frac{3}{4}"$
- Vertical Dimensions:**
 - Left side total height: $9"$
 - Left side top section height: $3"$
 - Left side bottom section height: $1 \frac{1}{2}"$ TYP
 - Bottom center gap: $1 \frac{1}{2}"$ GAP
- Labels:**
 - WALER:** Indicated by a dashed line and an arrow pointing to the right side.
 - MC 12x35 WALER, TYP:** Indicated by an arrow pointing to the bottom section.
- Bottom Section:** A circular detail labeled 'A' with a horizontal line through the center, indicating a splice.


PLAN

1
-
DETAIL


SCALE: 1 1/2" = 1'-0"

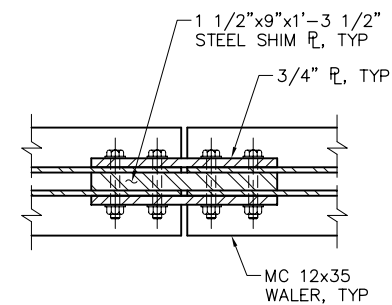


A SECTION
- SCALE: 1 1/2" = 1'-0"

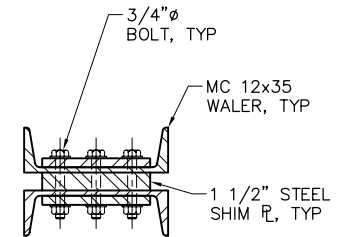


B SECTION
SCALE: 1 1/2" = 1'-0"

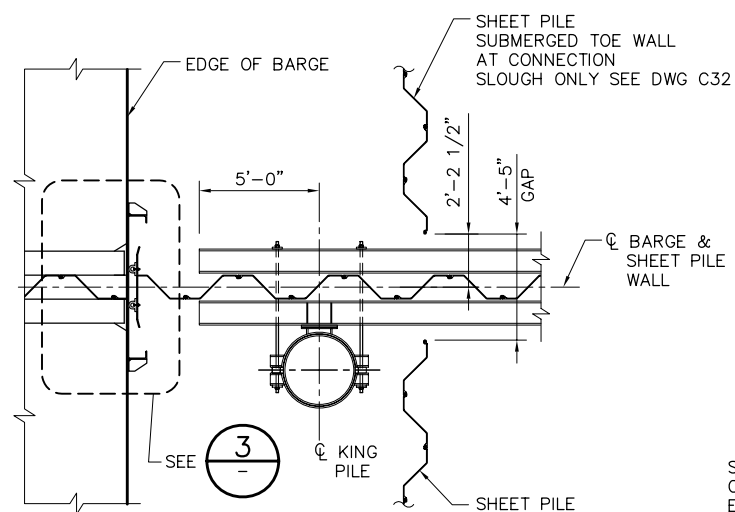


PLAN
DETAIL
SCALE: 1/4" = 1'-0"

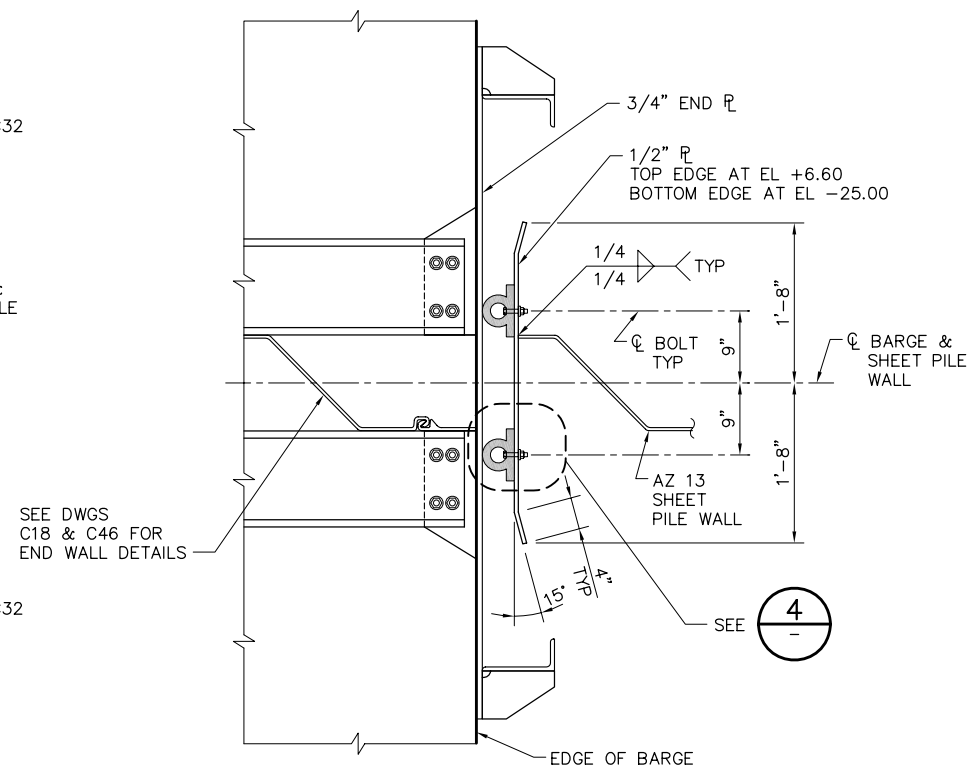

3 DETAIL
SCALE: 1" = 1'-0"

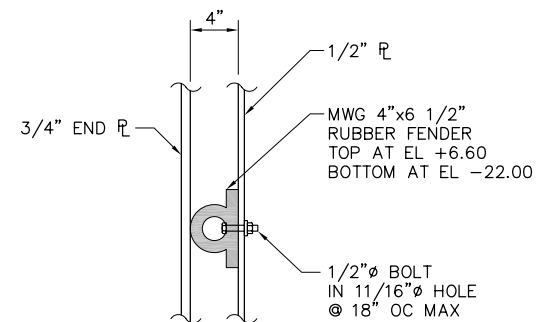

4 **DETAIL**
— SCALE: 1 1/2" = 1'-0"

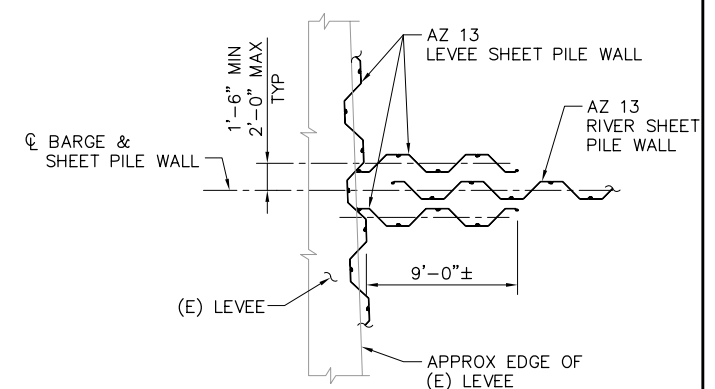


5
C35

DETAIL

SCALE: $\frac{3}{16}" = 1'-0"$

C5, C6

 1. LOCATE WALER SPLICES AS REQUIRED.




95% SUBMITTAL

IF SHEET IS LESS THAN 22" x 34"
IT IS A REDUCED PRINT –
SCALE REDUCED ACCORDINGLY.

REVISION	DESCRIPTION	BY	DATE			 2001 N. Main Street, Suite 360 Walnut Creek, California 94596 (925) 944-5411	TWO GATE FISH PROTECTION PLAN		DATE 08/07/09		
											SHEET 57 OF 75
				DSGN	JMB	DR	EP	CHK	TDB	SHEET PILE WALL DETAILS SHEET 2	C64
				JOB NO.	6097-03	SUBMITTED BY	RMR	TITLE			

P:\6097-03 SWC GATE DESIGN\CADD\DWG\609703-C65.DWG 8/6/2009 10:47 AM

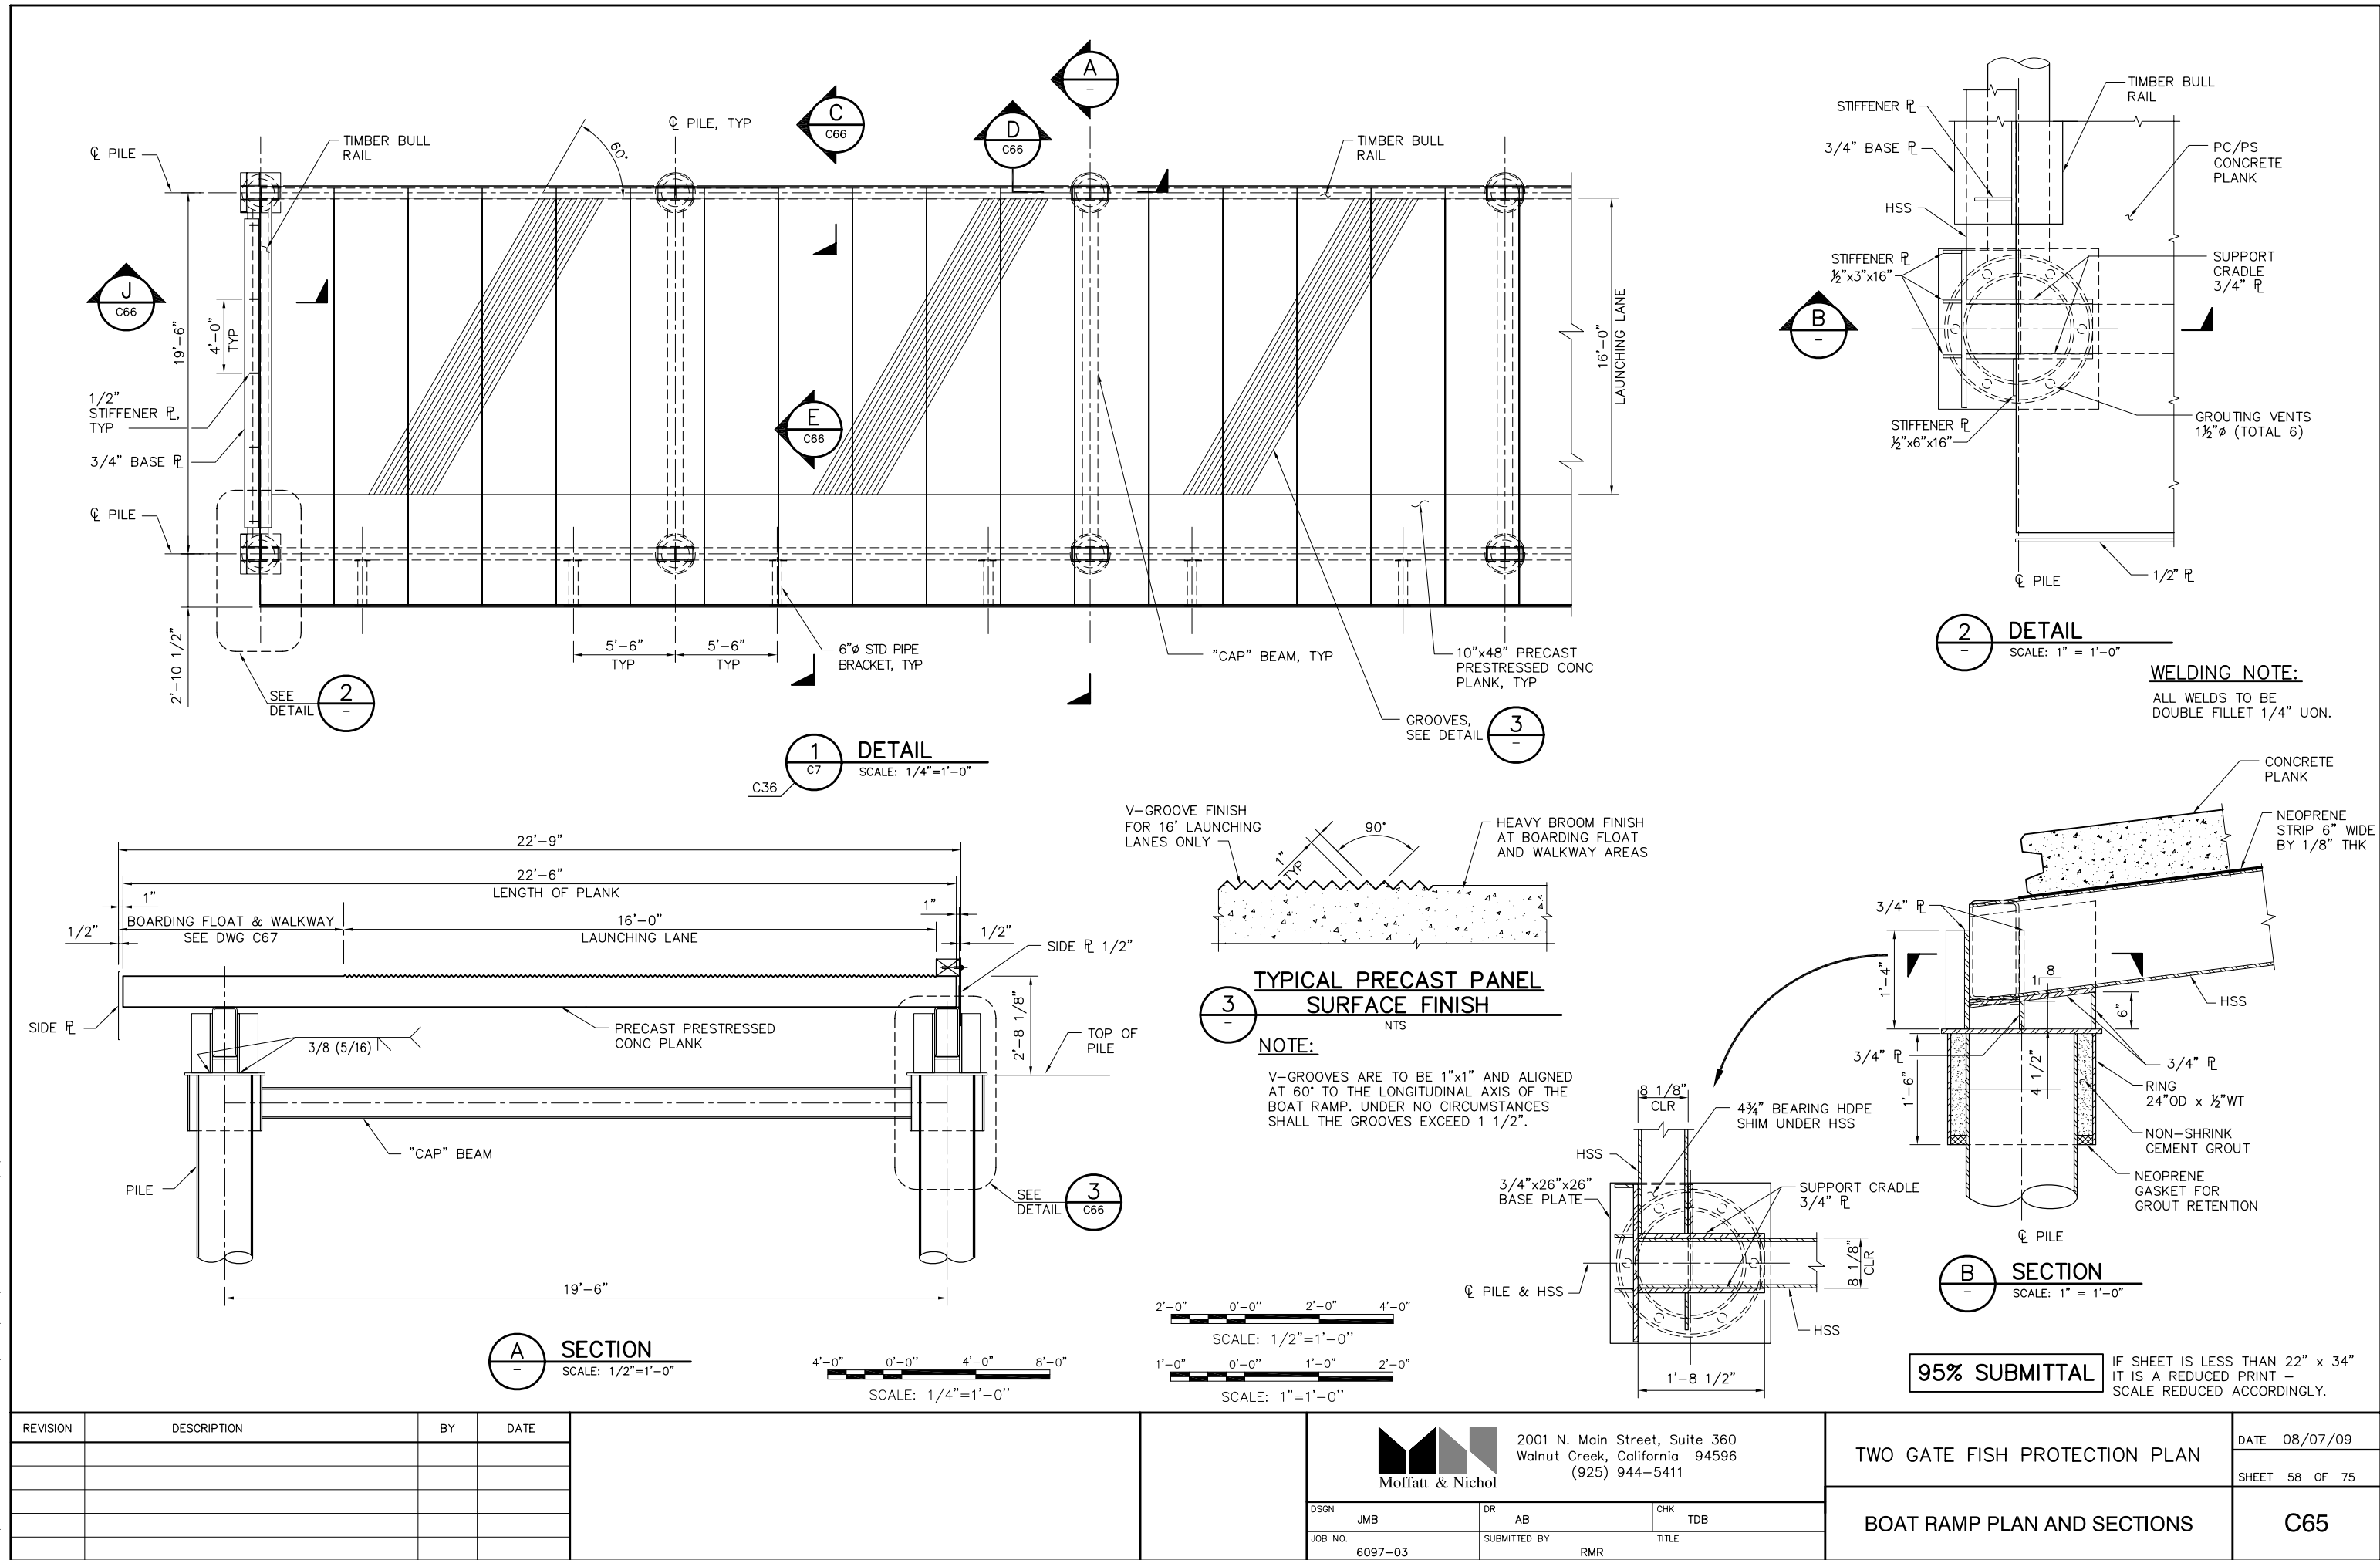

REVISION	DESCRIPTION	BY	DATE

Moffatt & Nichol
2001 N. Main Street, Suite 360
Walnut Creek, California 94596
(925) 944-5411

DSGN	JMB	DR	AB	CHK	TDB
JOB NO.	6097-03	SUBMITTED BY	RMR	TITLE	

TWO GATE FISH PROTECTION PLAN	DATE 08/07/09
BOAT RAMP PLAN AND SECTIONS	SHEET 58 OF 75
C65	

6x8 TREATED
TIMBER BULL RAIL

5/8" ϕ x 7"
LAG BOLT @
4'-0" OC, TYP

NEOPRENE STRIP
14" WIDE x 1/8"

10"

1"

GAP

1/2" SIDE FL

1'-10"

6"

3/8" TYP

PC/PS
PLANKS

HSS 16x8x1/2

3/8" TYP

GROUTING VENTS
1 1/2" ϕ (TOTAL 6)

SUPPORT CRADLE
3/4" ℓ

1/2" x 6" x 19 STIFFENER ℓ

8 1/8"

2'-0"

3/4" ℓ

PJP

SHIM AS NEEDED

TIMBER BULL RAIL

$\frac{1}{2}$ " SIDE PLATE

1'-10"

HSS 16 x 8 x $\frac{1}{2}$

LOWER SEGMENT

2"

2"

HSS

$\frac{3}{8}$ (5/16) V

PJP

VENTS L 6)

$\frac{1}{2}$ " x 6" x 19 STIFFENER

$\frac{3}{4}$ " R

4 1/2"

6" TYP. UON
5 1/4"
© BEGINNING OF VC

$\frac{3}{4}$ " R

1" GAP

2'-9"

CL

NEOPRENE STRIP
6" WIDE x 1/8"

10"

1'-10"

1/2" SIDE PL

5"

5"

6" STD PIPE

1/2"x10"x10"

2'-5 1/2"

2 1/2"

HSS

6" STD PIPE

1/2"x10"x13"

3/8" TYP

10"

16x8x1/8" HSS

SECTION C65

SCALE: 1 1/2" = 1'-0"

1 1/2" SIDE FL

1'-10"

6" Ø STD PIPE

3/4" Ø A-307 BOLTS (TOTAL 4)

FL 1/2"x10"x10"

3 1/2"

3"

2"

EACH SIDE

3/4" END PLATE
TYP 1/4
1/4

6"

5/8" ϕ x 7" LAG BOLT
@ 4'-0" OC, TYP

12x8 TREATED
TIMBER BULL RAIL

NEOPRENE END STRIP
1/4" THICK (16" WDE)

1/2" STIFFENER PLATE
TYP 3/8
3/8

3/4" BASE PLATE
TYP 3/8
3/8

2"

1'-0"

2"

3/4" BASE PLATE

PC/PS PLANKS

HSS

BEARING HDPE SHIM
@ END OF HSS

8 1/8"

10" ϕ "CAP" BEAM

 
1'-2 1/2"

4 3/4"

ϕ PILE

NOTE:
NEOPRENE STRIPS SHALL BE
PREGLUED TO CONCRETE PLANKS.

IF SHEET IS LESS THAN 22" x 34"
IT IS A REDUCED PRINT –
SCALE REDUCED ACCORDINGLY.




REVISION	DESCRIPTION	BY	DATE

		2001 N. Main Street, Suite 360 Walnut Creek, California 94596 (925) 944-5411	
DSGN	JMB	DR	CHK
		AB	TDB
JOB NO.	6097-03	SUBMITTED BY	TITLE
		RMR	


TWO GATE FISH PROTECTION PLAN	DATE 08/07/09
	SHEET 59 OF 75
BOAT RAMP DETAILS	C66

P:\6097-03 SWC GATE DESIGN\CADD\DWG\609703-C67.DWG 7/27/2009 8:41 AM

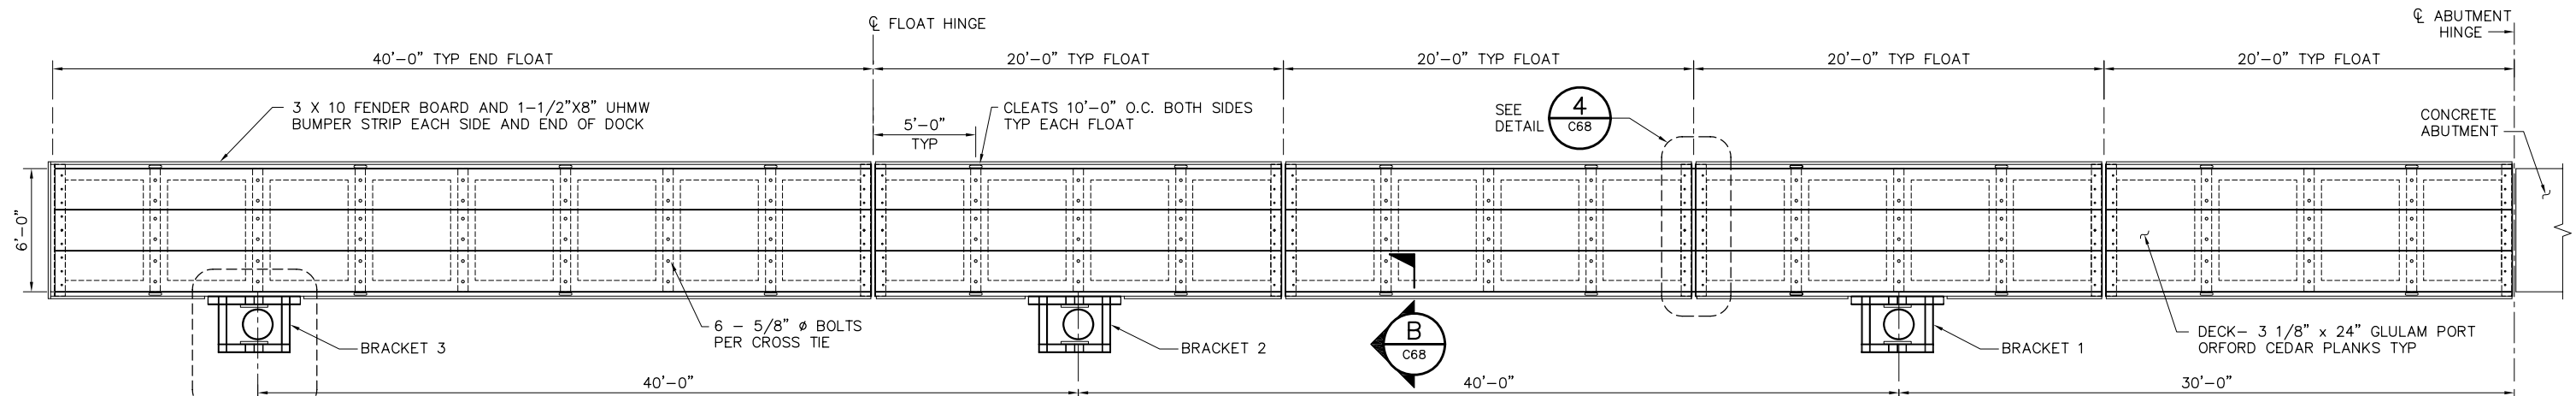

PLAN
SCALE: 1/4" = 1'-0"

NOTE:
ALL BOLTS THROUGH THE GLUED LAMINATED DECK SHALL BE ECONOMY BOLTS WITH STEEL FLAT WASHERS, HEX NUTS AND LOCK NUTS, ALL HOT DIPPED GALVANIZED.

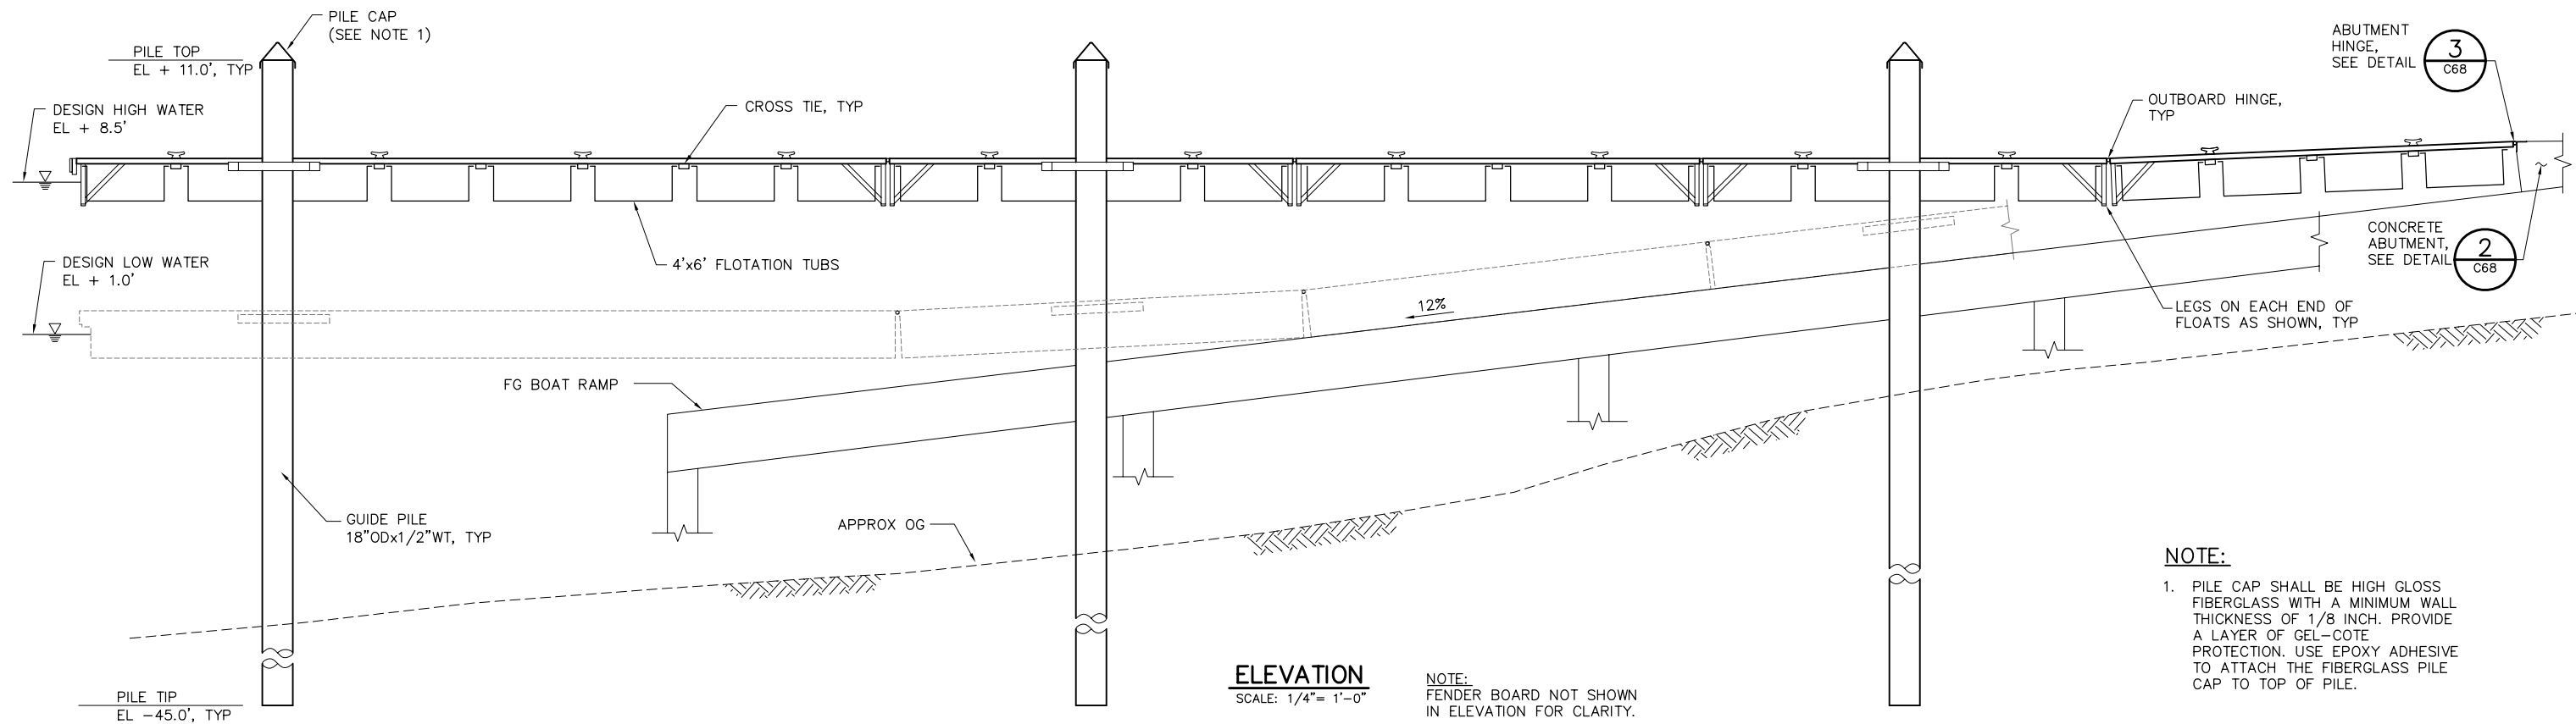


ELEVATION
SCALE: 1/4" = 1'-0"

NOTE:
FENDER BOARD NOT SHOWN
IN ELEVATION FOR CLARITY.

NOTE:

 1. PILE CAP SHALL BE HIGH GLOSS FIBERGLASS WITH A MINIMUM WALL THICKNESS OF 1/8 INCH. PROVIDE A LAYER OF GEL-COTE PROTECTION. USE EPOXY ADHESIVE TO ATTACH THE FIBERGLASS PILE CAP TO TOP OF PILE.



95% SUBMITTAL





IF SHEET IS LESS THAN 22" x 34"
IT IS A REDUCED PRINT -
SCALE REDUCED ACCORDINGLY.

REVISION	DESCRIPTION	BY	DATE

 Moffatt & Nichol			2001 N. Main Street, Suite 360 Walnut Creek, California 94596 (925) 944-5411		
DSGN	JMB	DR	AB	CHK	TDB
JOB NO.	6097-03	SUBMITTED BY	RMR	TITLE	

TWO GATE FISH PROTECTION PLAN		DATE 08/07/09
BOARDING FLOAT PLAN AND ELEVATION		SHEET 60 OF 75
		C67

P:\6097-03 SWC GATE DESIGN\CADD\DWG\609703-C68.DWG 7/27/2009 8:41 AM

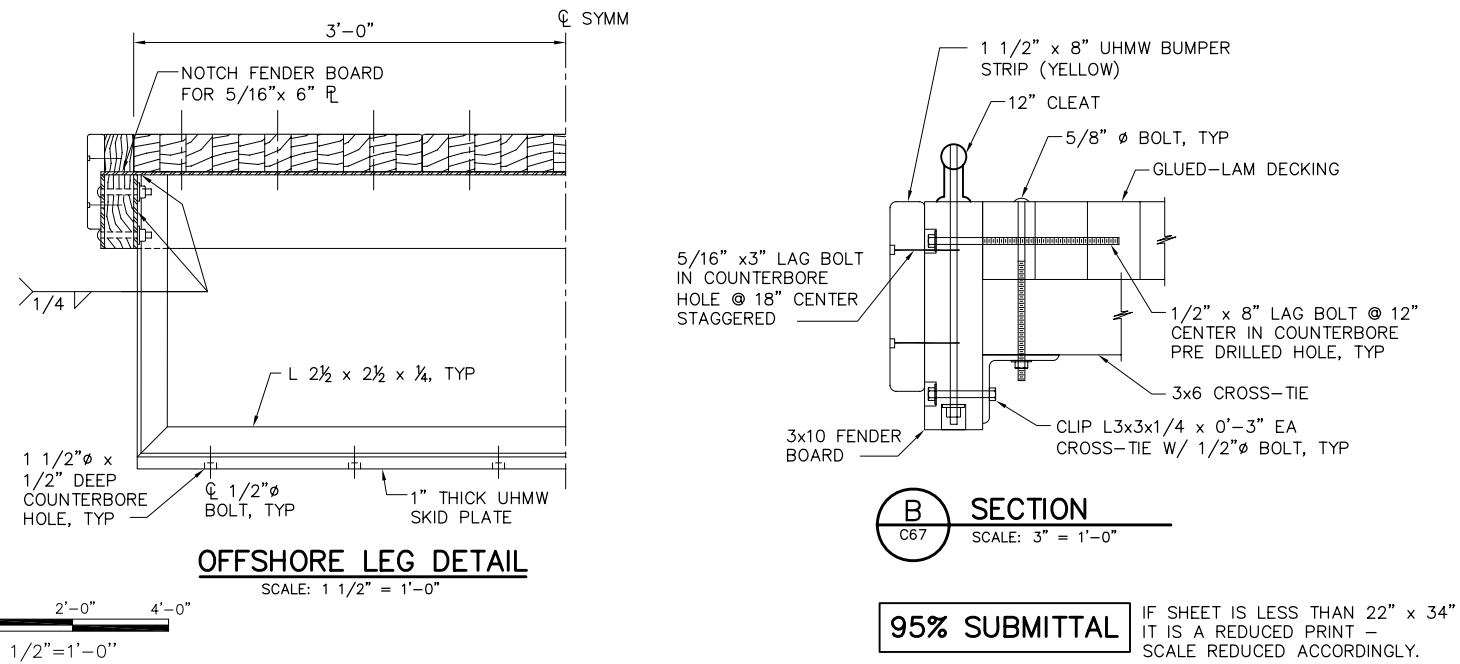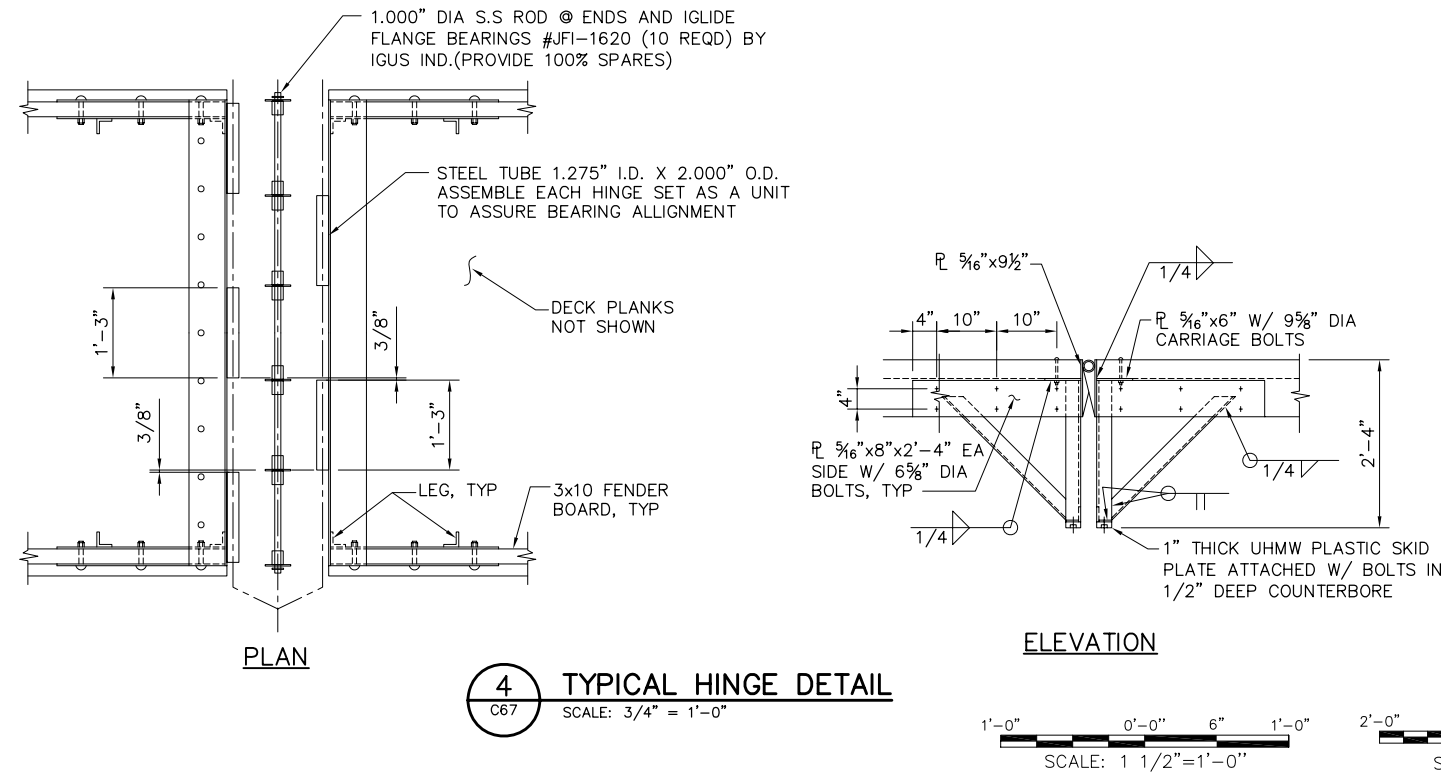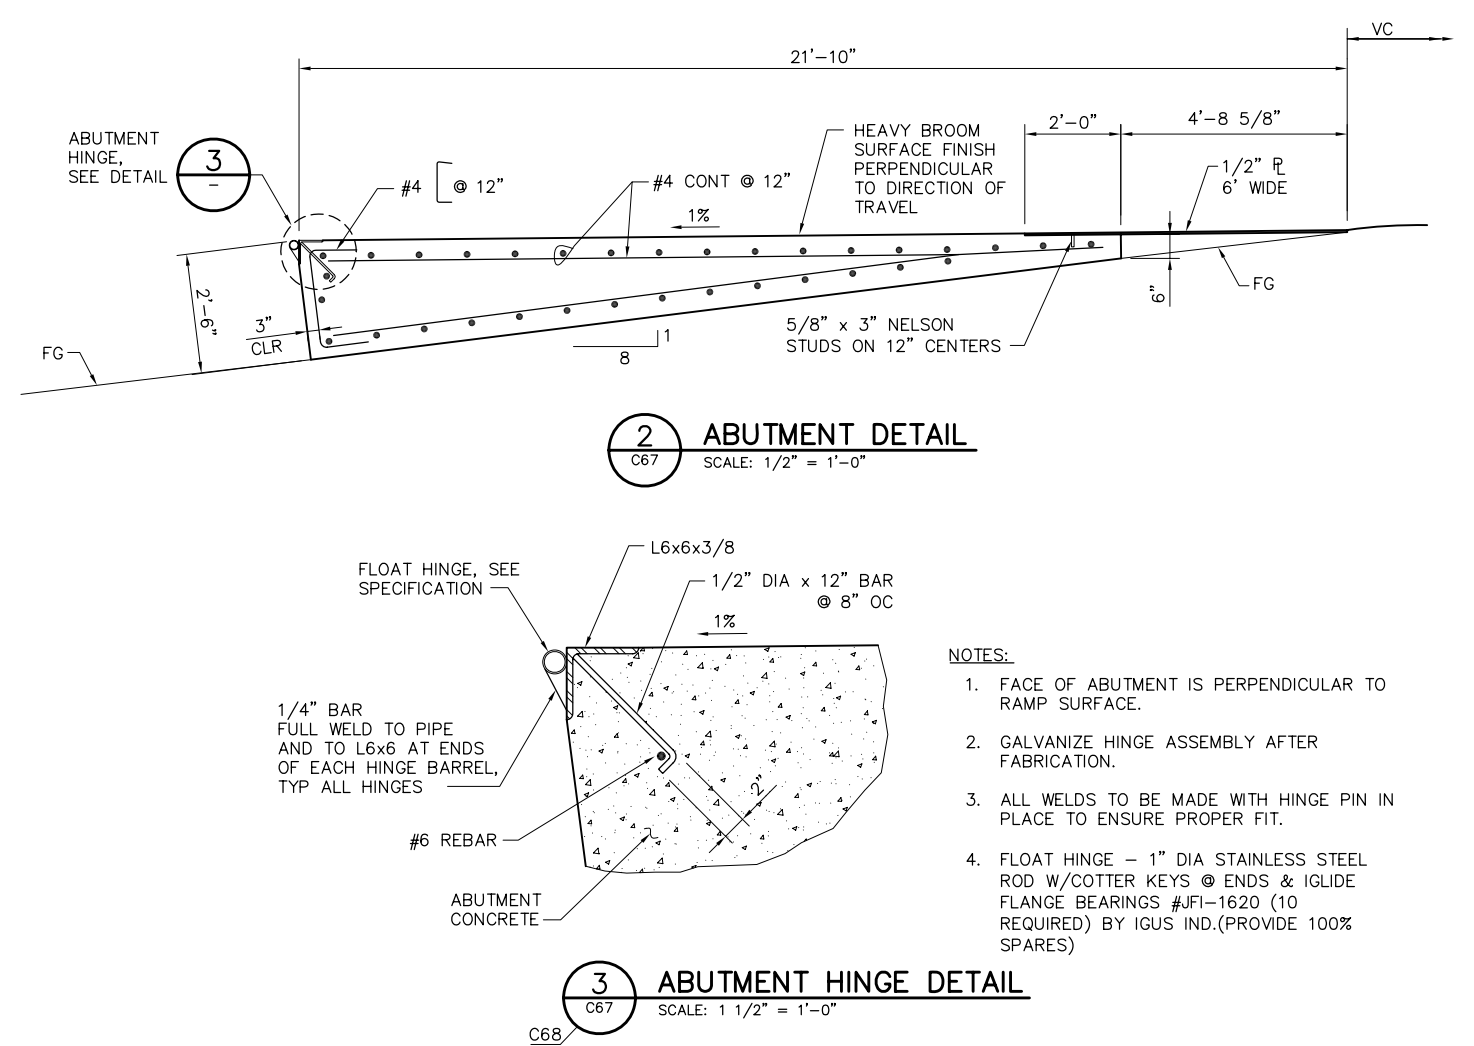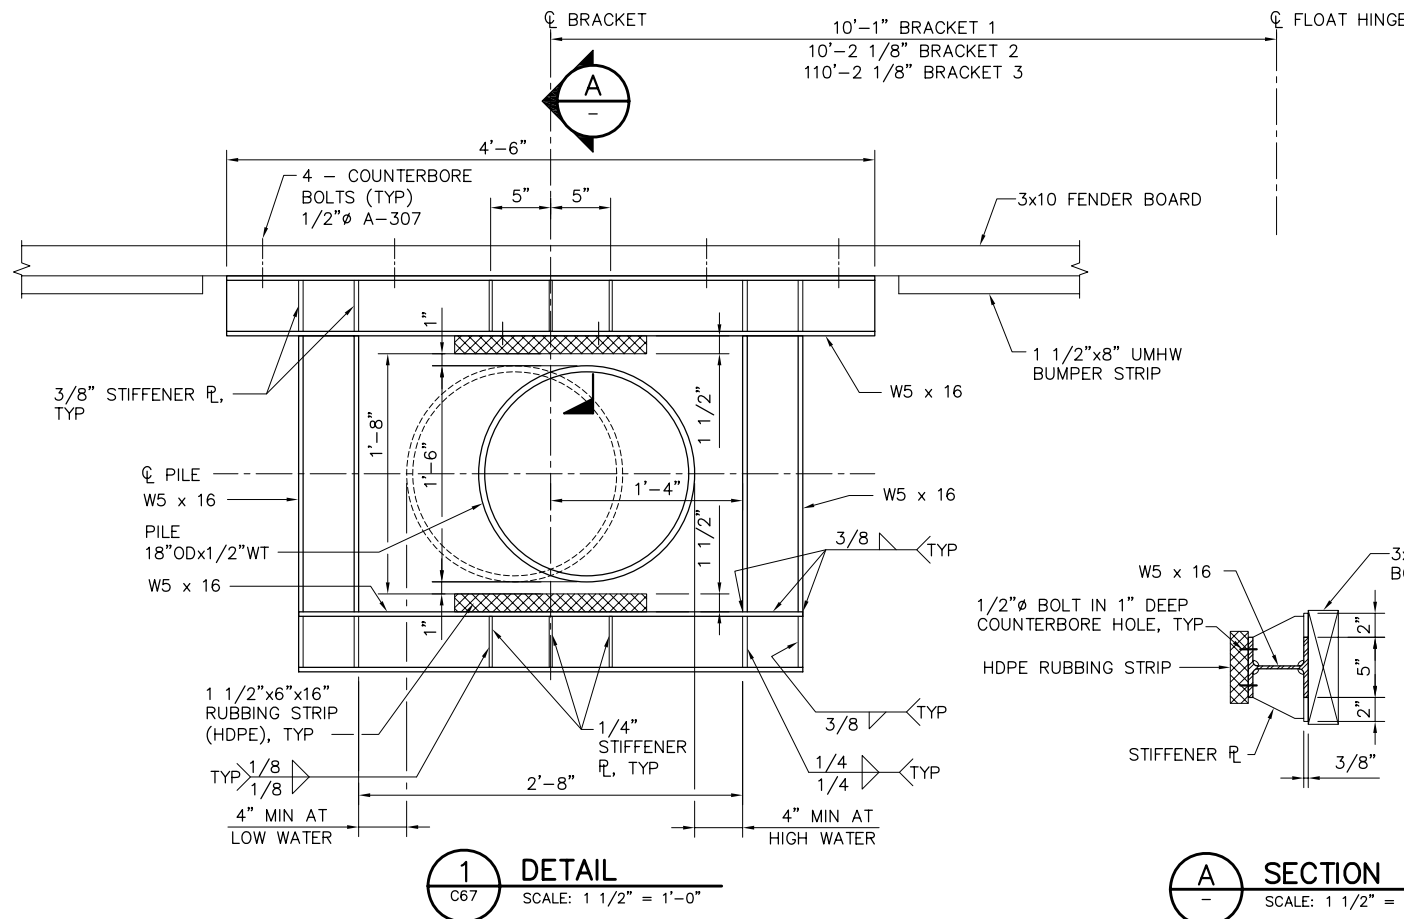


REVISION	DESCRIPTION	BY	DATE


 Moffatt & Nichol		2001 N. Main Street, Suite 360 Walnut Creek, California 94596 (925) 944-5411	
DSGN	JMB	DR	AB
JOB NO.	6097-03	SUBMITTED BY	RMR
CHK	TDB	TITLE	

TWO GATE FISH PROTECTION PLAN		DATE	08/07/09
BOARDING FLOAT DETAILS		SHEET	61 OF 75
			C68


P:\6097-03 SWC GATE DESIGN\CADD\DWG\609703-C69.DWG 7/24/2009 10:47 AM

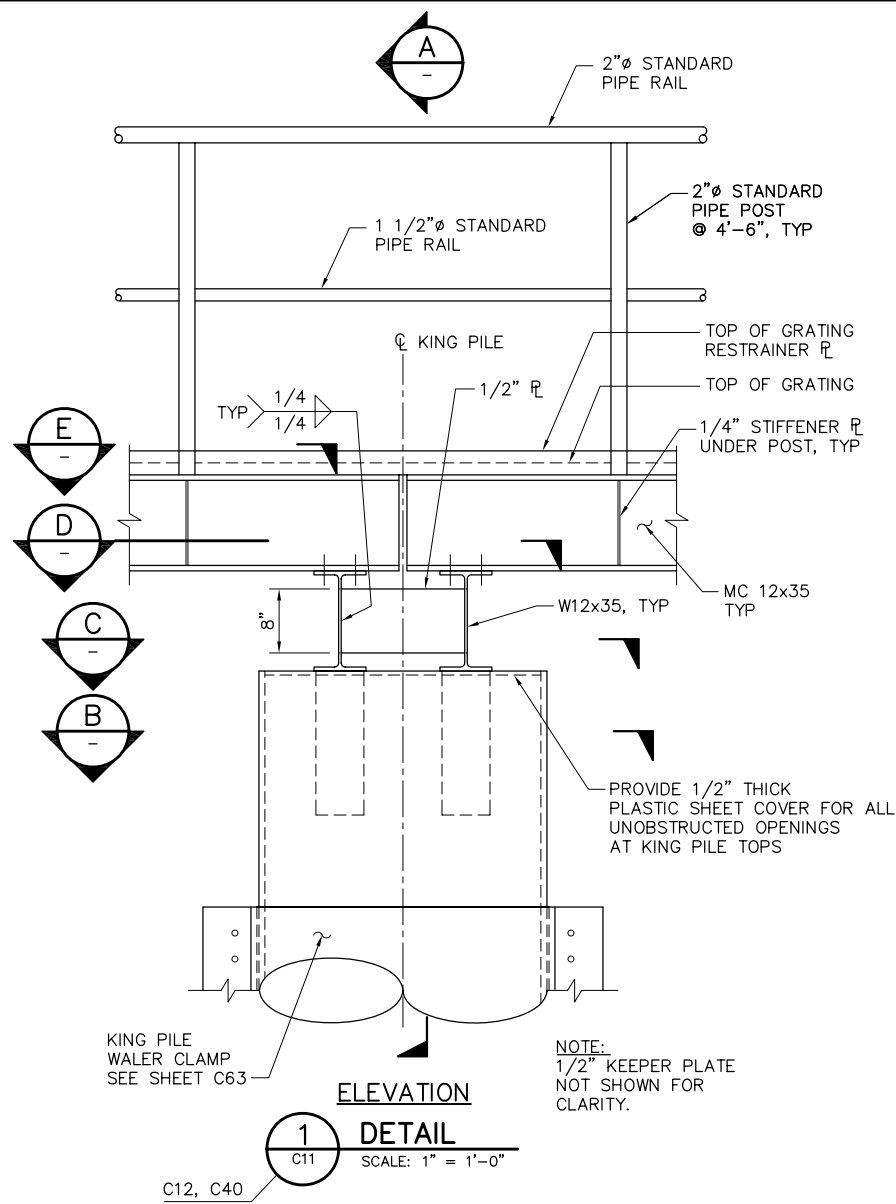


1 DETAIL
SCALE: 1" = 1'-0"

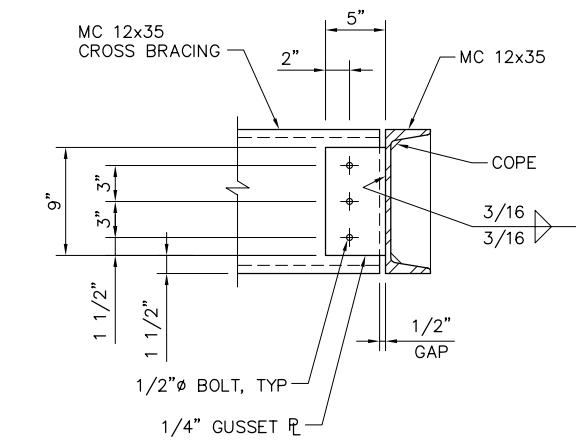


2
SCALE: 1 1/2" = 1'-0"

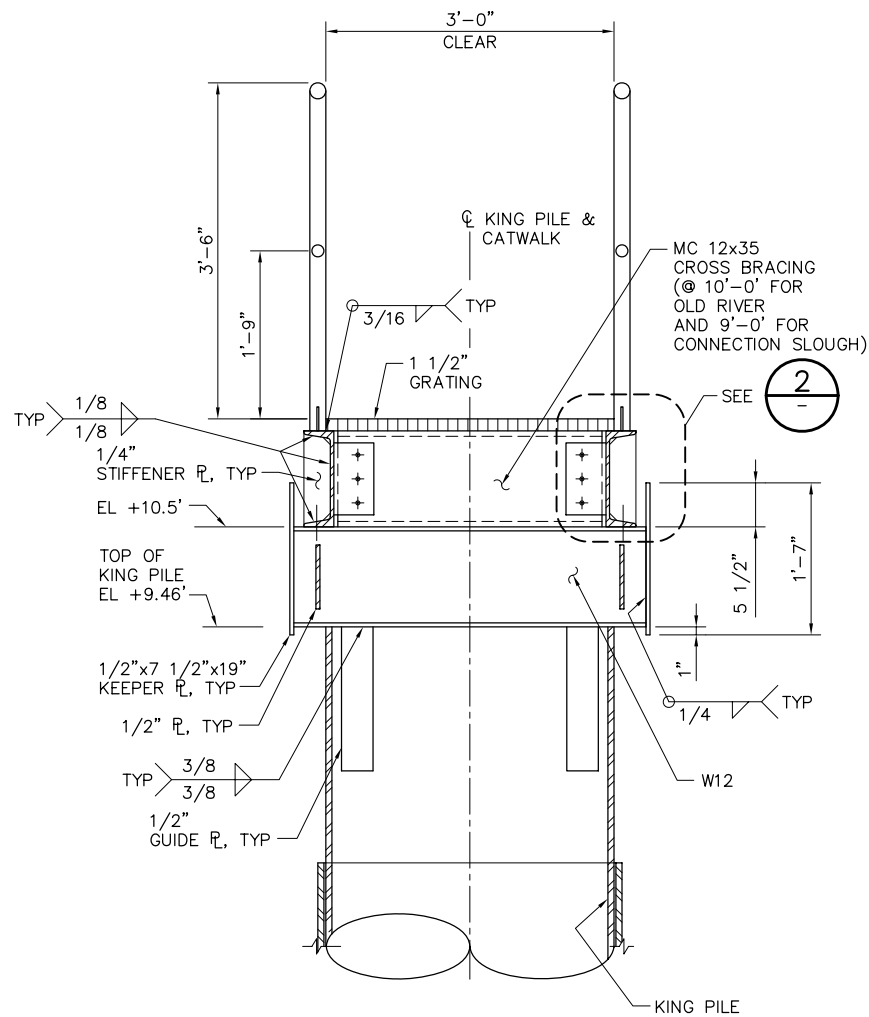


A
SCALE: 1" = 1'-0"

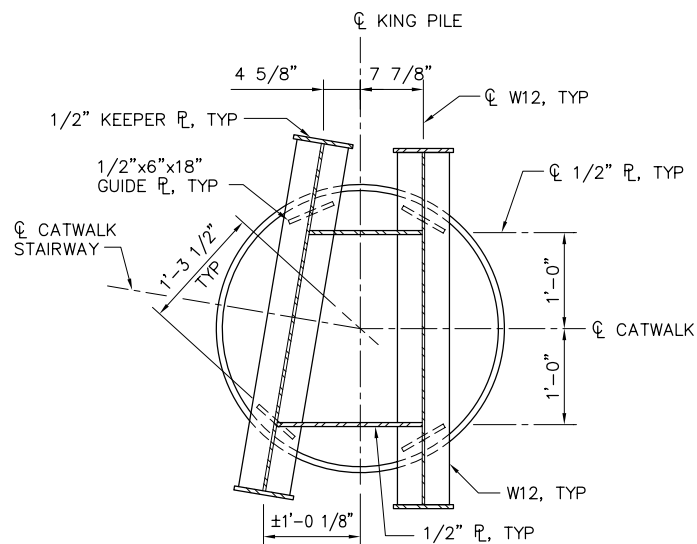


3 DETAIL
SCALE: 1" = 1'-0"

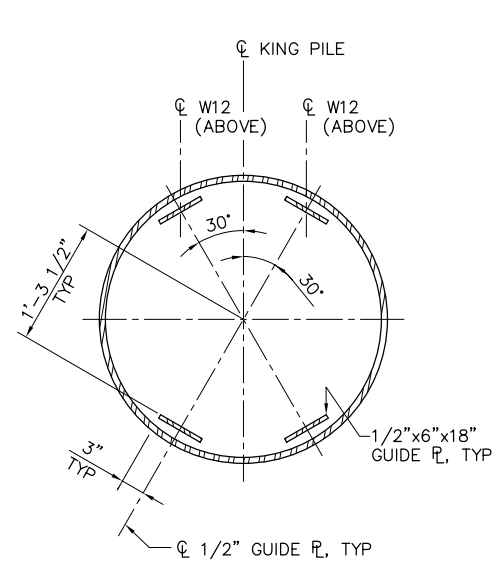


B
SCALE: 1" = 1'-0"

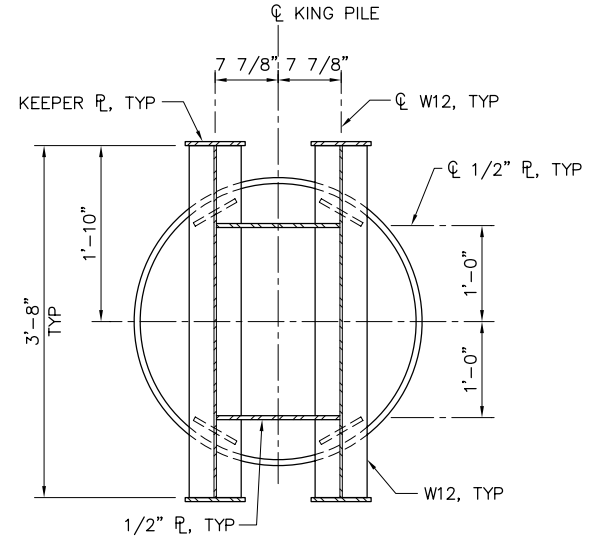

C
SCALE: 1" = 1'-0"

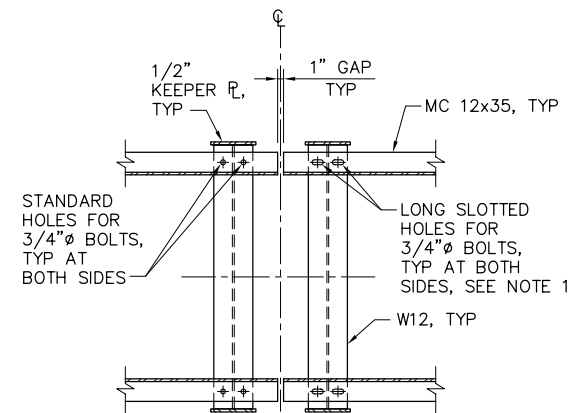

D
SCALE: 3/4" = 1'-0"

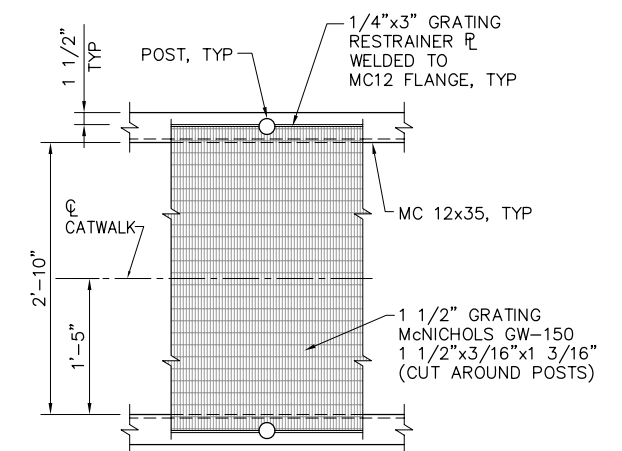

PLAN AT GRATING PLATE

E
SCALE: 1" = 1'-0"

NOTES:

1. PROVIDE 1/16" THICK SLIDE PAD (HDPE OR EQUIVALENT) AT EXPANSION SUPPORTS WHERE LONG SLOTTED HOLES PERMIT EXPANSION.
2. FOR ADDITIONAL WELD INFORMATION SEE DWGS C70 AND C71.

2'-0" 0'-0" 1'-0" 2'-0"
SCALE: 3/4"=1'-0"


95% SUBMITTAL IF SHEET IS LESS THAN 22" x 34" IT IS A REDUCED PRINT - SCALE REDUCED ACCORDINGLY.

REVISION	DESCRIPTION	BY	DATE


 Moffatt & Nichol		2001 N. Main Street, Suite 360 Walnut Creek, California 94596 (925) 944-5411	
DSGN	JMB	DR	EP/AB
JOB NO.	6097-03	SUBMITTED BY	RMR
CHK	TDB	TITLE	

TWO GATE FISH PROTECTION PLAN		DATE 08/07/09
CATWALK DETAILS SHEET 1		SHEET 62 OF 75
C69		


P:\6097-03 SWC GATE DESIGN\CADD\DWG\609703-C70.DWG 8/4/2009 4:32 PM

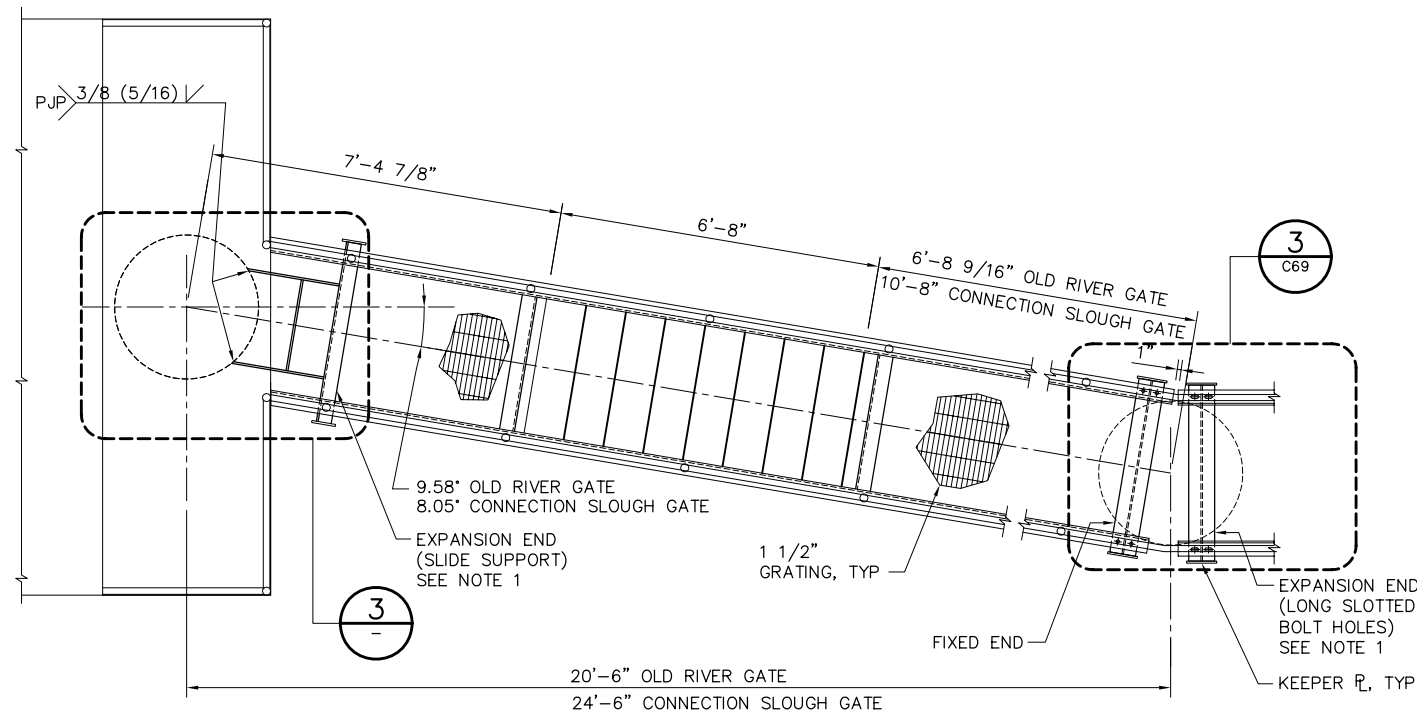


PLAN
1 DETAIL
C12 SCALE: 1/2" = 1'-0"
C40

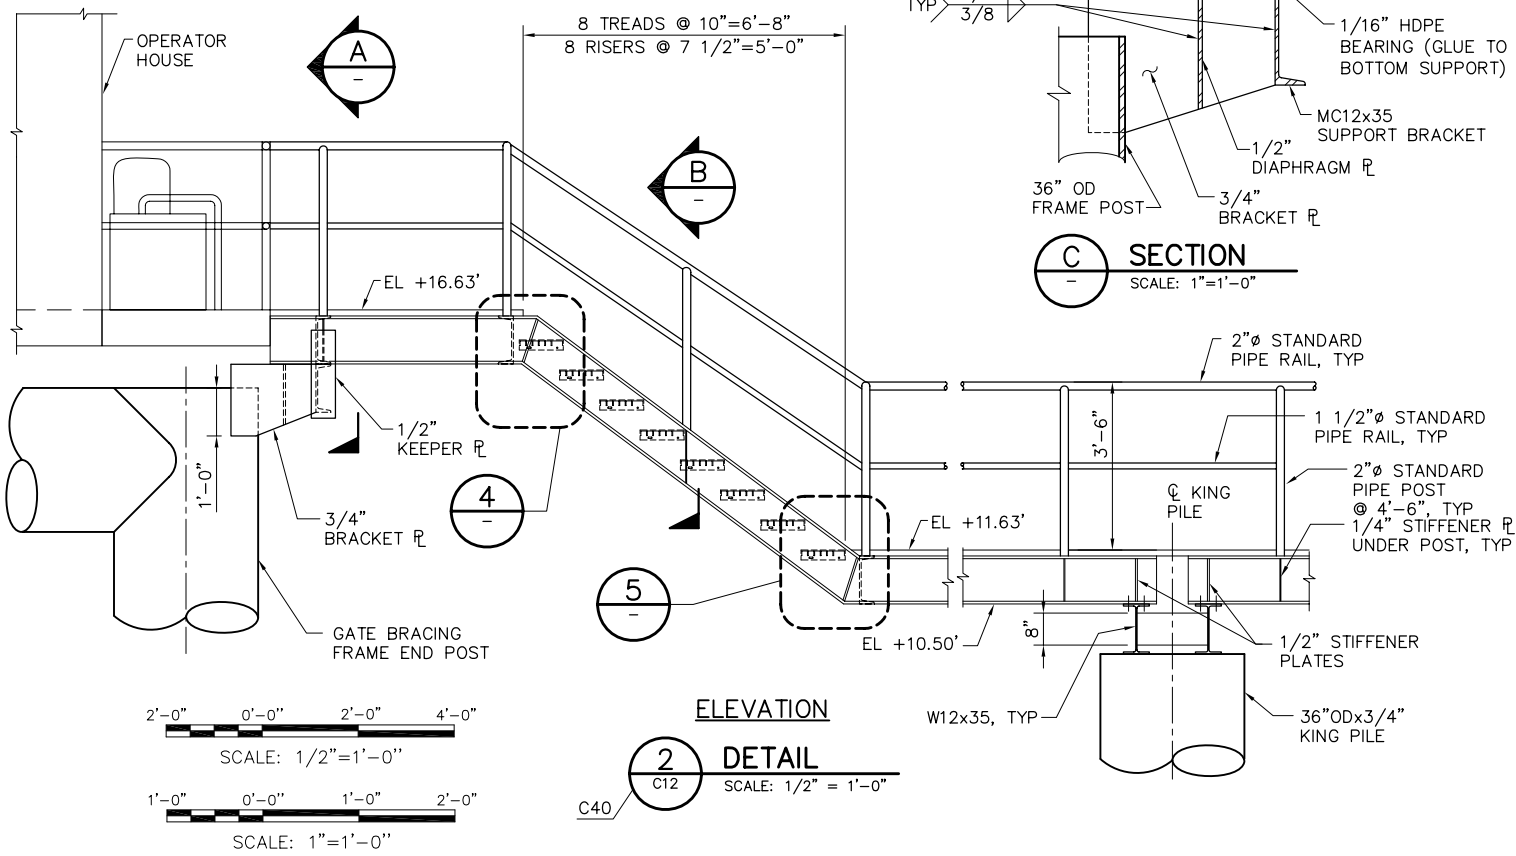


ELEVATION
2 DETAIL
C12 SCALE: 1/2" = 1'-0"
C40

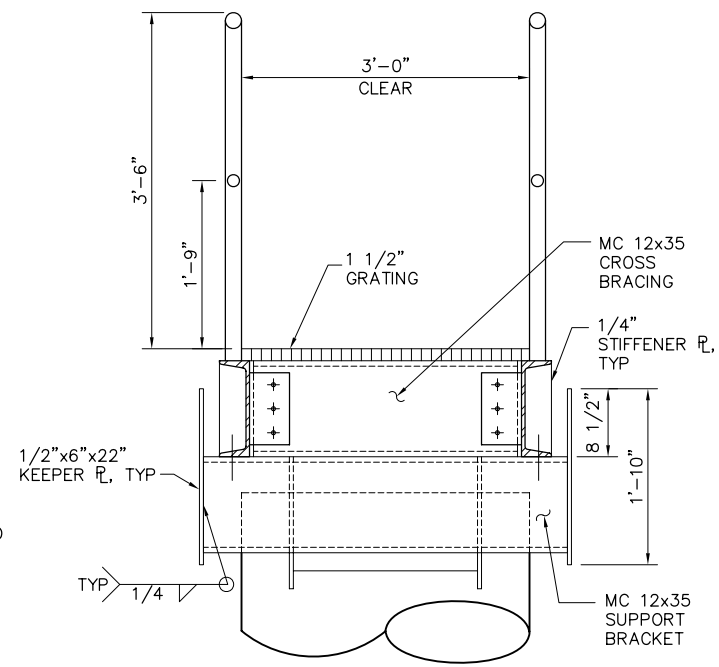


SECTION
A SCALE: 1"=1'-0"
C71

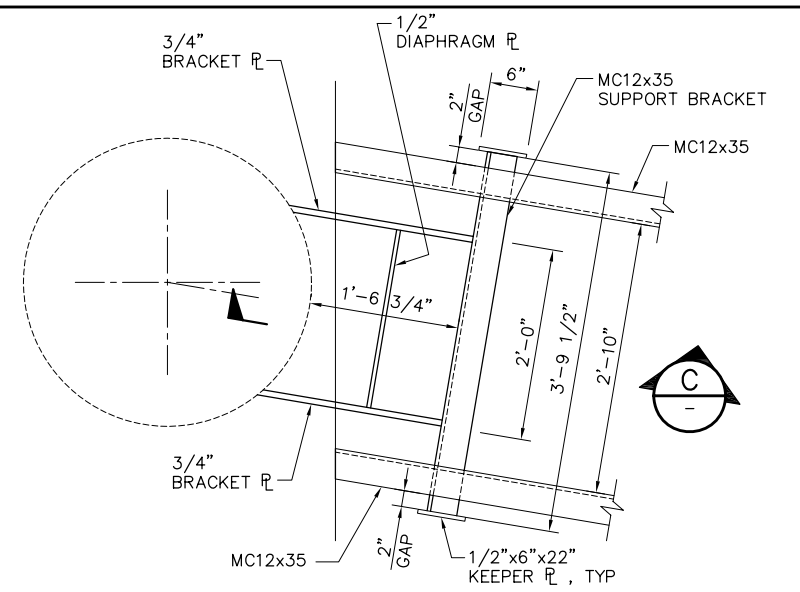


SECTION
C SCALE: 1"=1'-0"

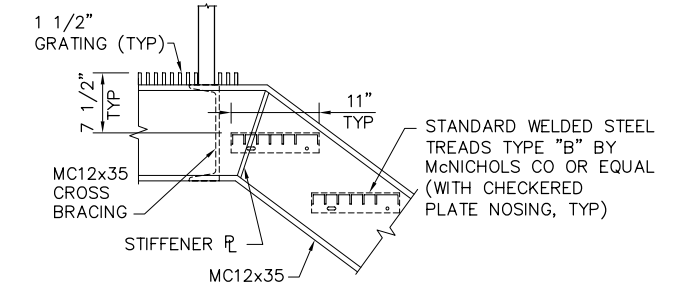

SECTION
4 SCALE: 1"=1'-0"

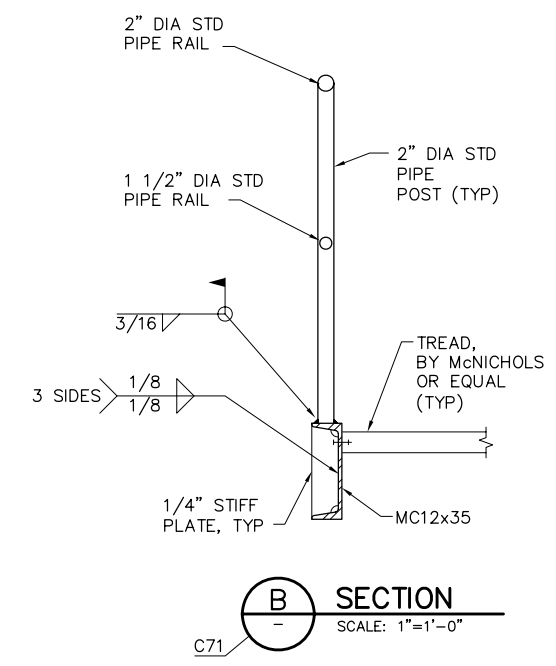

SECTION
B SCALE: 1"=1'-0"
C71

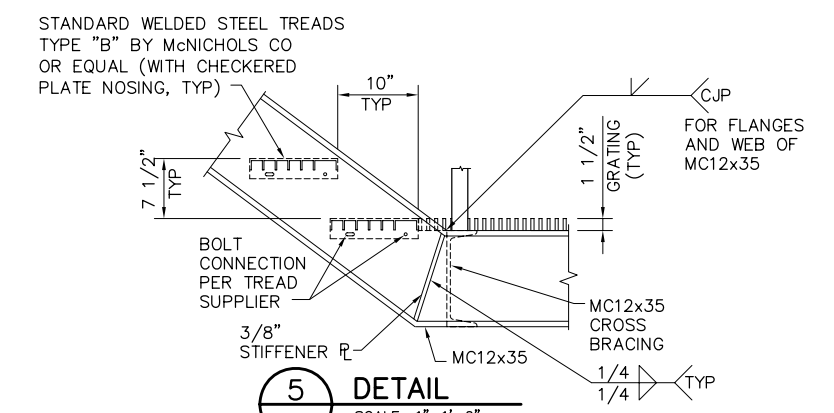

SECTION
5 SCALE: 1"=1'-0"

NOTES:

1. PROVIDE 1/16" THICK HDPE SLIDE/BEARING PLATE AT EXPANTION ENDS AT UNDERSIDE OF MC12x35.
2. FOR ADDITIONAL WELD INFORMATION SEE DWGS C69 AND C71.

95% SUBMITTAL


IF SHEET IS LESS THAN 22" x 34" IT IS A REDUCED PRINT - SCALE REDUCED ACCORDINGLY.

REVISION	DESCRIPTION	BY	DATE

 Moffatt & Nichol		2001 N. Main Street, Suite 360 Walnut Creek, California 94596 (925) 944-5411	
DSGN	JMB	DR	AB/EP
JOB NO.	6097-03	SUBMITTED BY	RMR
CHK	TDB	TITLE	


TWO GATE FISH PROTECTION PLAN		DATE	08/07/09
CATWALK DETAILS SHEET 2		SHEET	63 OF 75
			C70

P:\6097-03 SWC GATE DESIGN\CADD\DWG\609703-C72.DWG 7/24/2009 10:57 AM

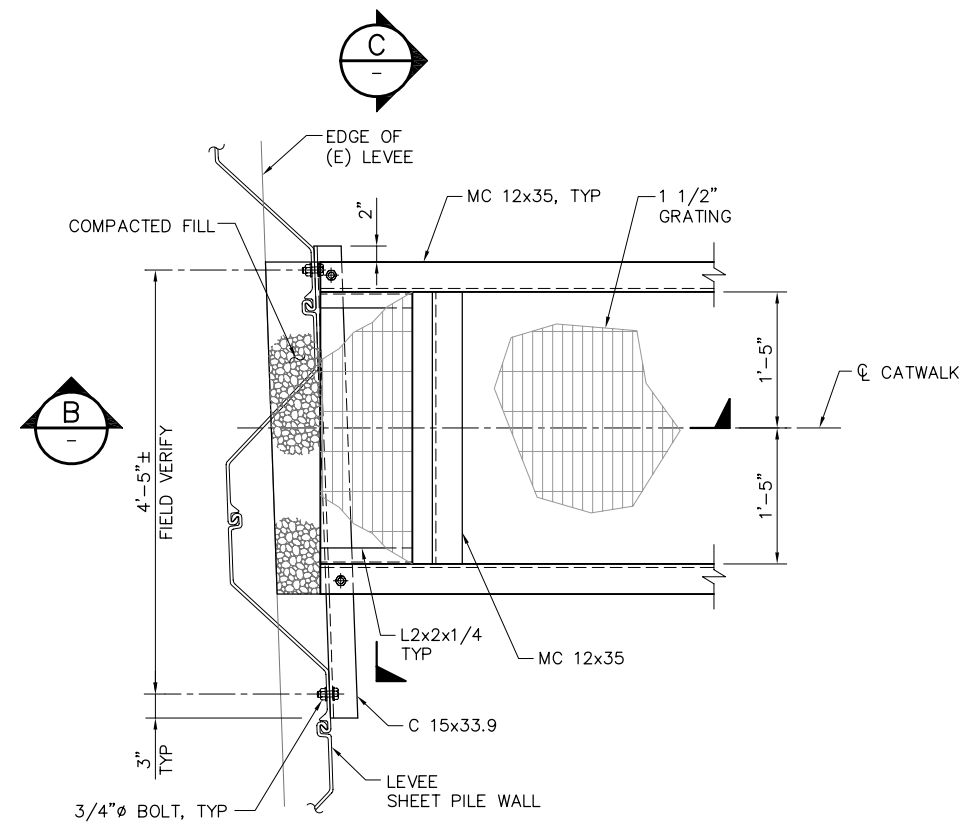


PLAN AT END OF CATWALK


1 **DETAIL**
C11 SCALE: 1" = 1'-0"
C40

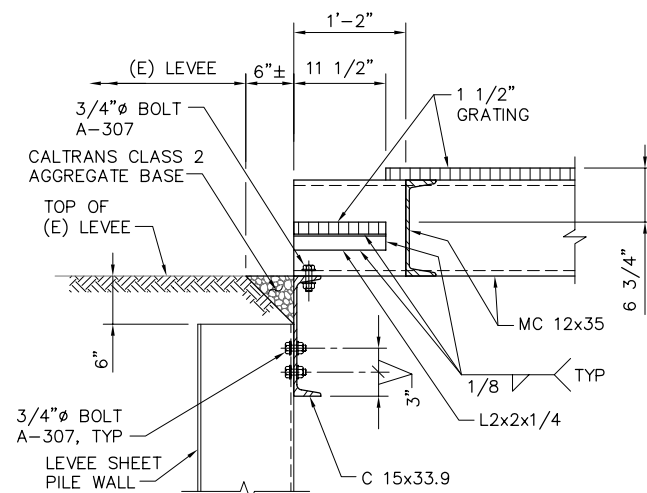

B **SECTION**
SCALE: 1" = 1'-0"

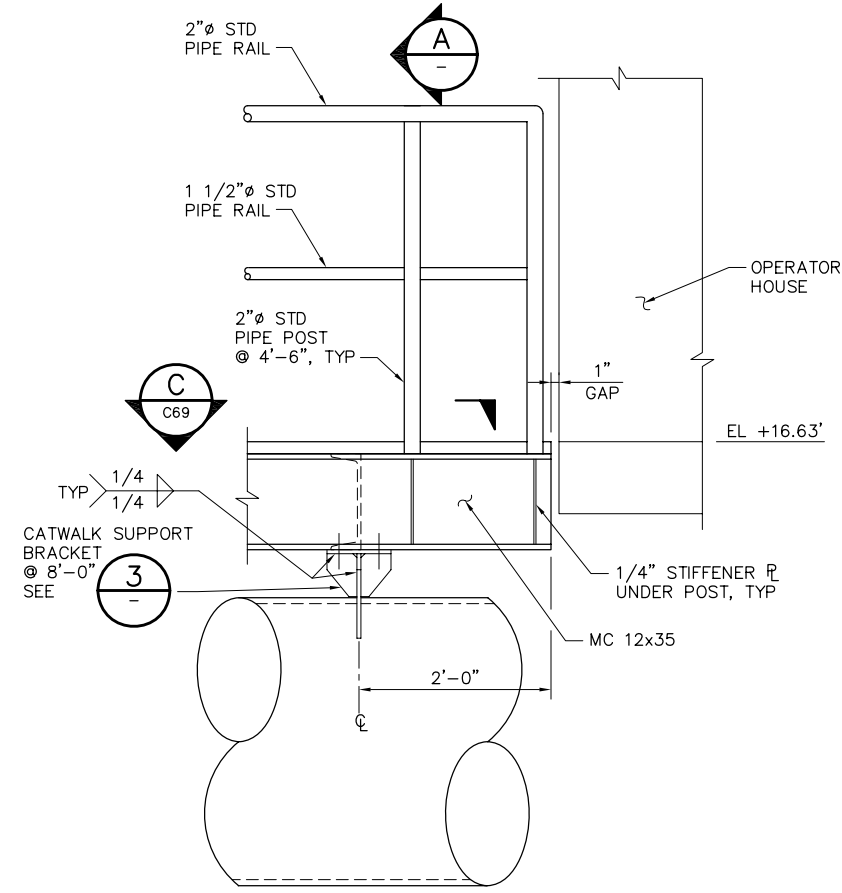


2 **DETAIL**
C15 SCALE: 1"=1'-0"
C43

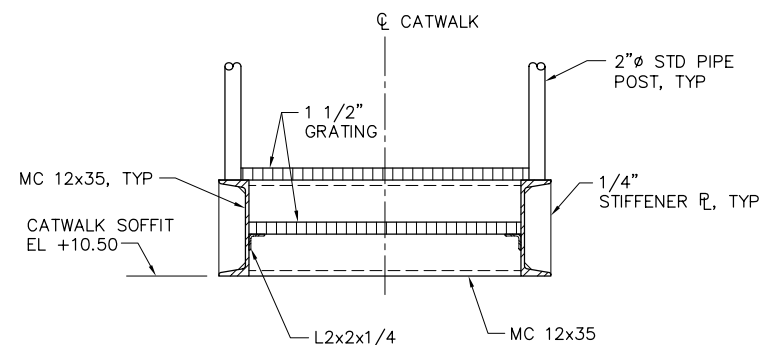


C **SECTION**
SCALE: 1" = 1'-0"

NOTE:

 
FOR ADDITIONAL WELD INFORMATION SEE DWGS C69, C70 AND C71.



SCALE: 1"=1'-0"

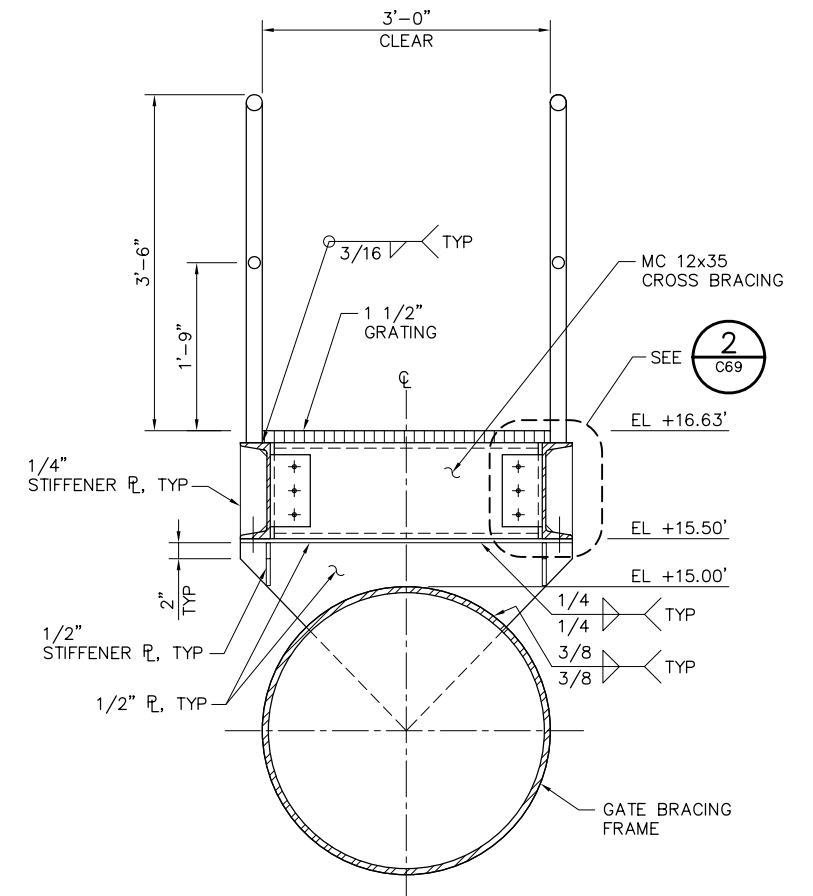

A **SECTION**
SCALE: 1"=1'-0"

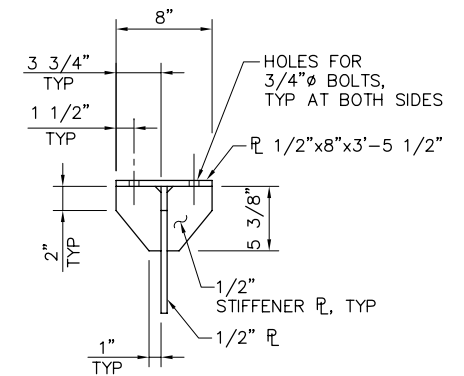

3 **DETAIL**
C73 SCALE: 1"=1'-0"

95% SUBMITTAL


IF SHEET IS LESS THAN 22" x 34"
IT IS A REDUCED PRINT -
SCALE REDUCED ACCORDINGLY.

REVISION	DESCRIPTION	BY	DATE

 Moffatt & Nichol		2001 N. Main Street, Suite 360 Walnut Creek, California 94596 (925) 944-5411	
DSGN	JMB	DR	EP
JOB NO.	6097-03	SUBMITTED BY	RMR
CHK	TDB	TITLE	


TWO GATE FISH PROTECTION PLAN		DATE 08/07/09
CATWALK DETAILS SHEET 4		SHEET 65 OF 75
		C72

P:\6097-03 SVC GATE DESIGN\CADD\DWG\609703-C73.DWG 7/24/2009 5:11 PM

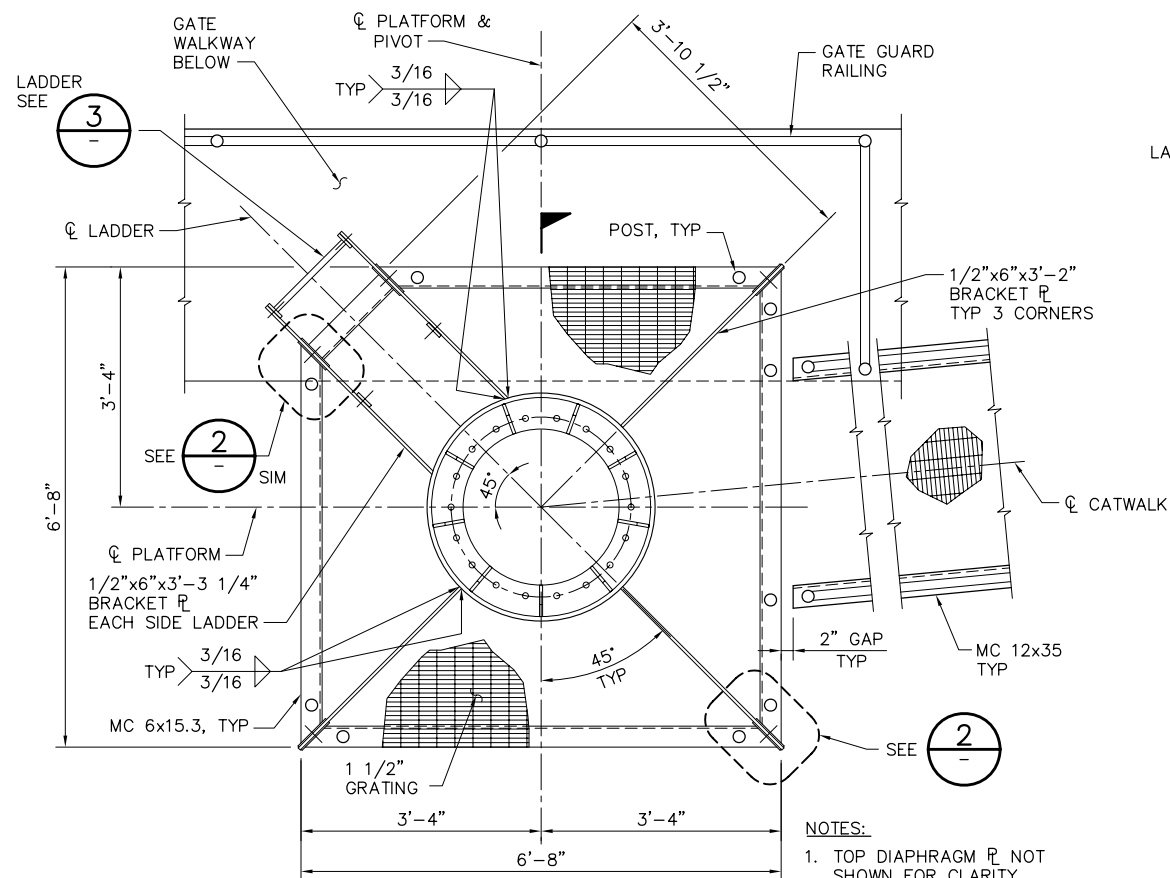


- NOTES:
1. TOP DIAPHRAGM $\bar{r}$ NOT SHOWN FOR CLARITY.
 2. NAVIGATION LIGHT NOT SHOWN FOR CLARITY.
 3. GRATING TO BE FASTENED TO MC 6x15.3 BY STD CLIPS.

1
C14
SCALE: 3/4" = 1'-0"

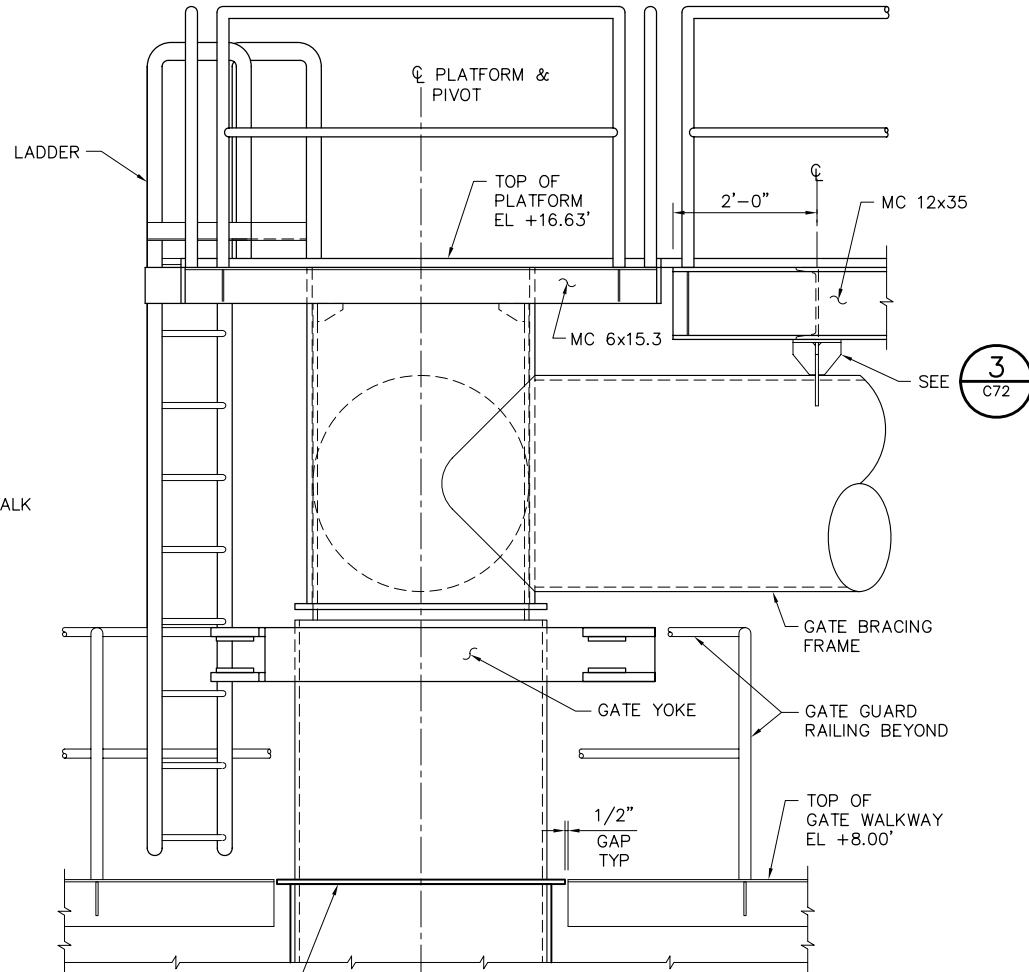


ELEVATION

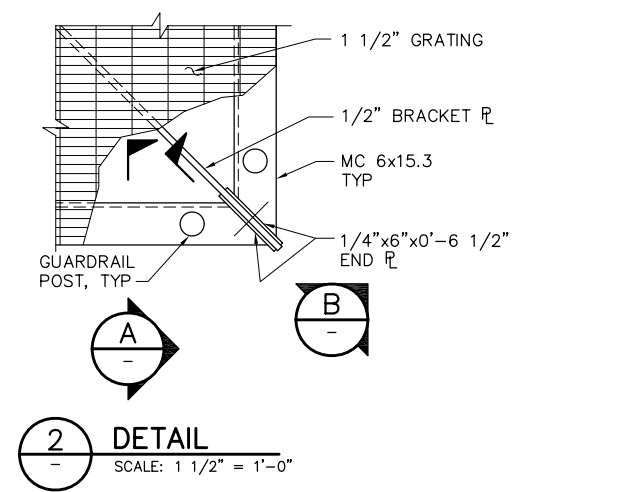


2
SCALE: 1 1/2" = 1'-0"

3
C72
SCALE: 1 1/2" = 1'-0"

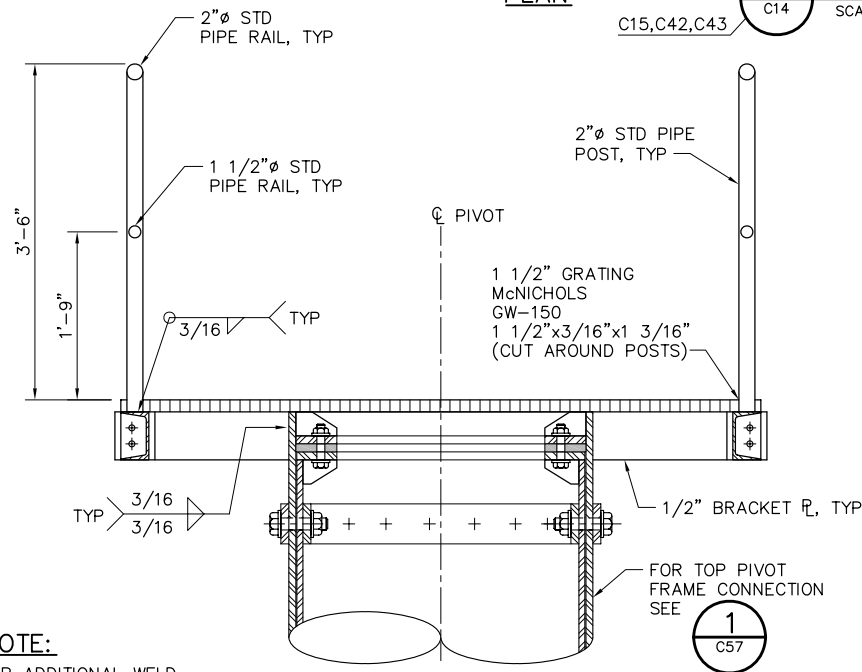


C
SCALE: 1" = 1'-0"

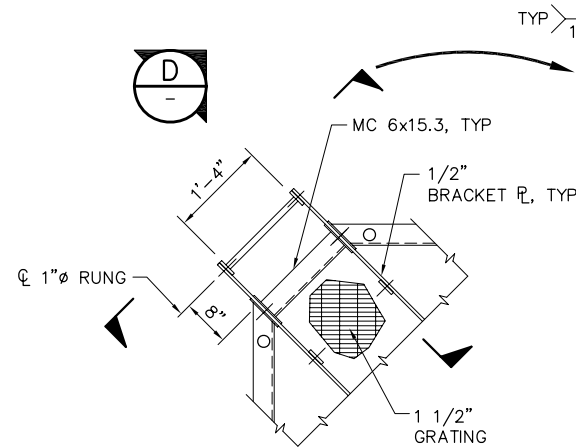


PLAN


3
SCALE: 3/4" = 1'-0"

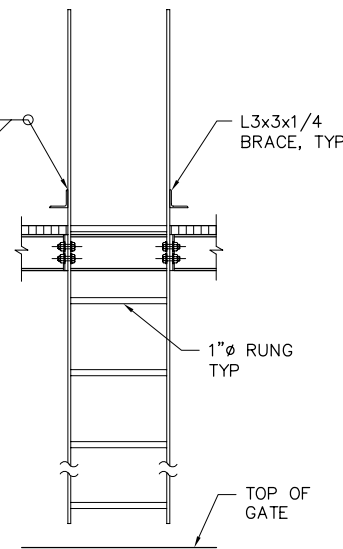

ELEVATION

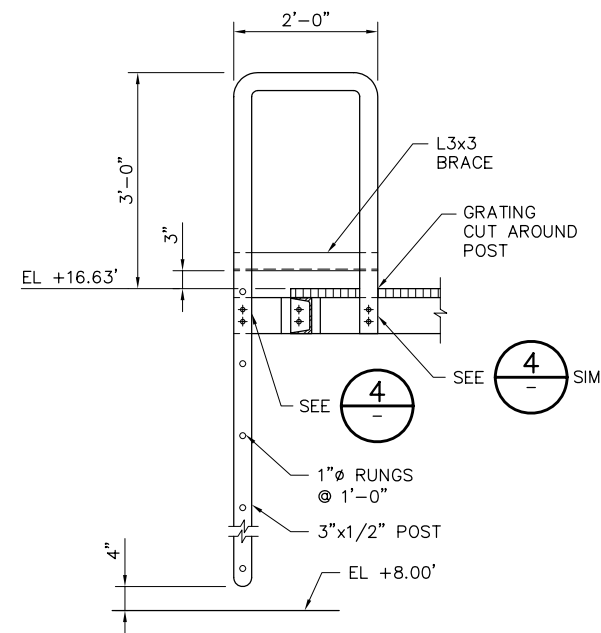

D
SCALE: 3/4" = 1'-0"

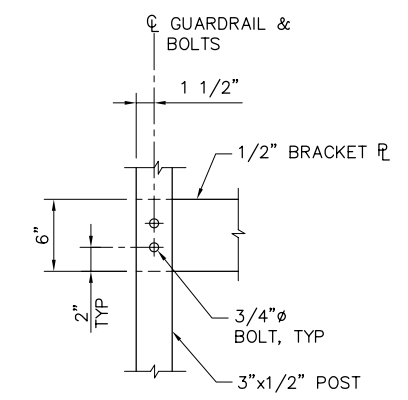

4
SCALE: 1 1/2" = 1'-0"

2'-0" 0'-0" 1'-0" 2'-0"
SCALE: 3/4" = 1'-0"

95% SUBMITTAL

IF SHEET IS LESS THAN 22" x 34"
IT IS A REDUCED PRINT -
SCALE REDUCED ACCORDINGLY.


REVISION	DESCRIPTION	BY	DATE

 Moffatt & Nichol		2001 N. Main Street, Suite 360 Walnut Creek, California 94596 (925) 944-5411	
DSGN	JMB	DR	EP/AB
JOB NO.	6097-03	SUBMITTED BY	RMR
CHK	TDB	TITLE	

TWO GATE FISH PROTECTION PLAN		DATE	08/07/09
CATWALK DETAILS SHEET 5		SHEET	66 OF 75

C73



P:\6097-03 SWC GATE DESIGN\CADD\DWG\609703-C74.DWG 7/24/2009 10:51 AM

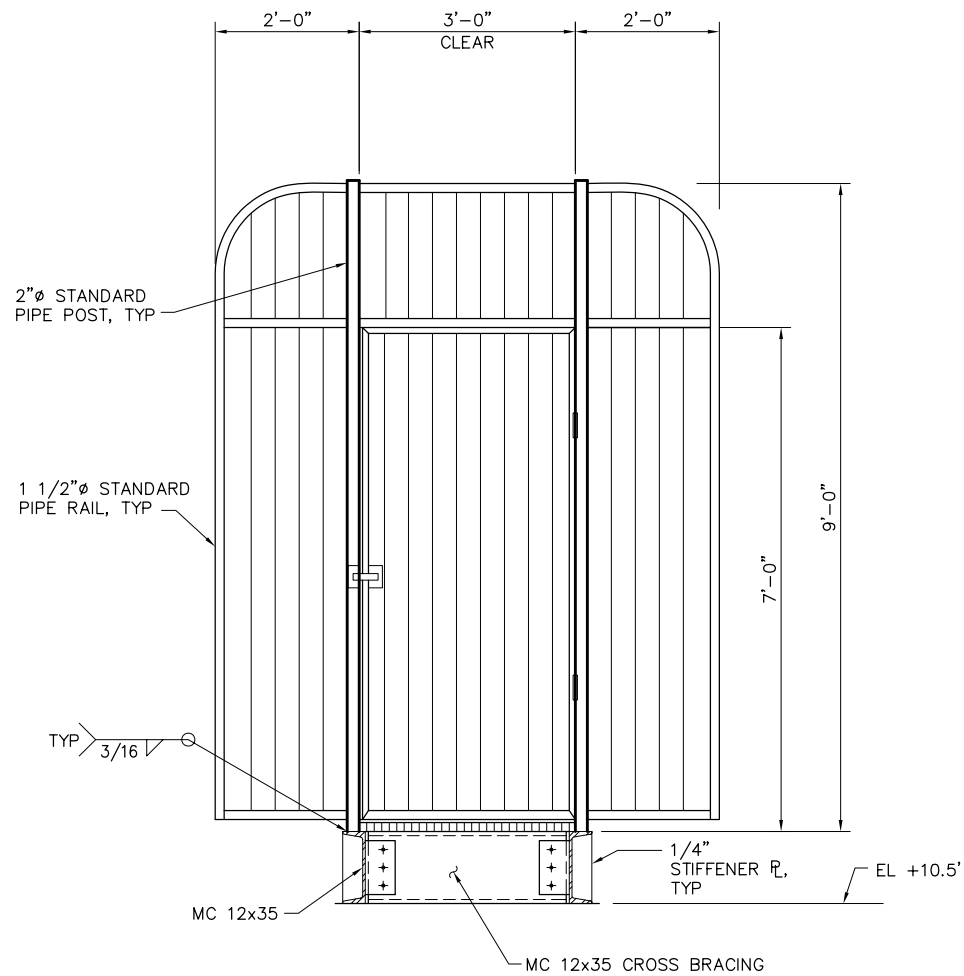

NOTE:
SECURITY GATE SHALL PROVIDE
A MINIMUM 36" CLEAR OPENING,
SHALL BE AUTOMATICALLY
CLOSING, AND SHALL INCLUDE
A LOCKABLE LATCH.

SECURITY GATE ELEVATION

1
C11
SCALE: 3/4" = 1'-0"

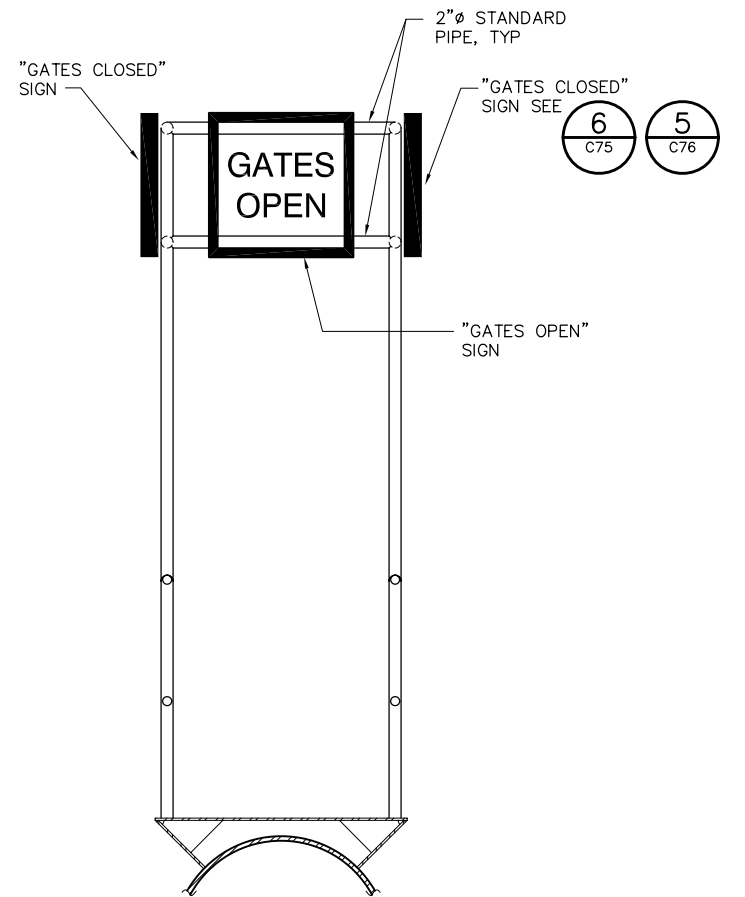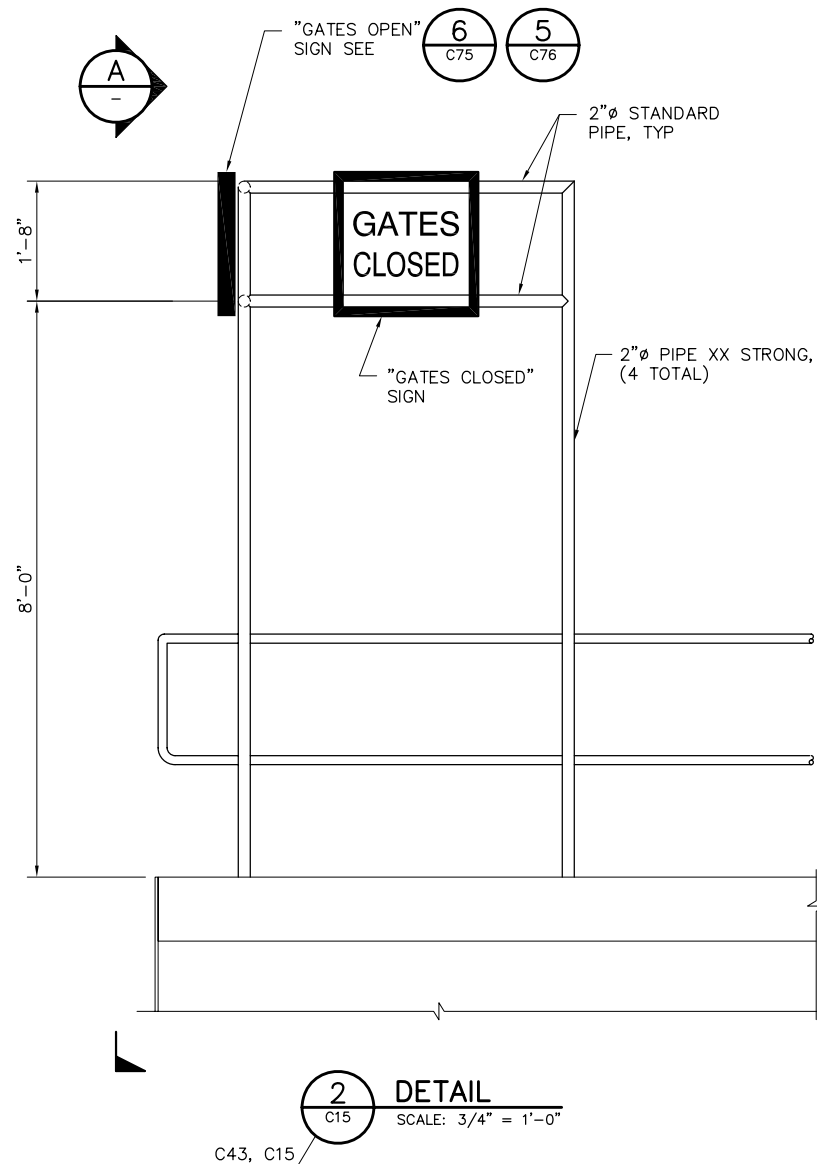

NOTE:
FOR ADDITIONAL WELD INFORMATION
SEE DWGS C68 THROUGH C73.


2'-0" 0'-0" 1'-0" 2'-0"
SCALE: 3/4"=1'-0"

95% SUBMITTAL

IF SHEET IS LESS THAN 22" x 34"
IT IS A REDUCED PRINT -
SCALE REDUCED ACCORDINGLY.


REVISION	DESCRIPTION	BY	DATE

		 Moffatt & Nichol	2001 N. Main Street, Suite 360 Walnut Creek, California 94596 (925) 944-5411	TWO GATE FISH PROTECTION PLAN		DATE 08/07/09
				CATWALK DETAILS SHEET 6		SHEET 67 OF 75
						C74

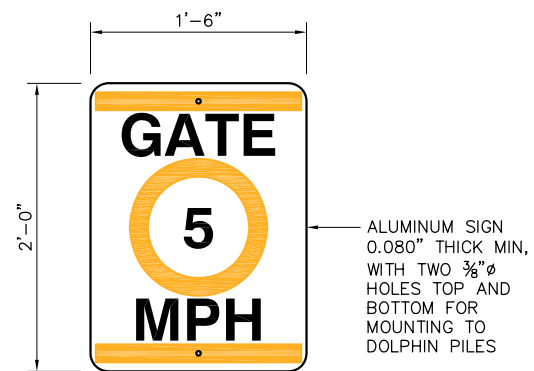

SIGNBOARD ON PILE, ORANGE
ON WHITE WITH BLACK LETTERS


1 GATE 5 MPH SIGN
C19 SCALE: 1/8" = 1'-0"
C47

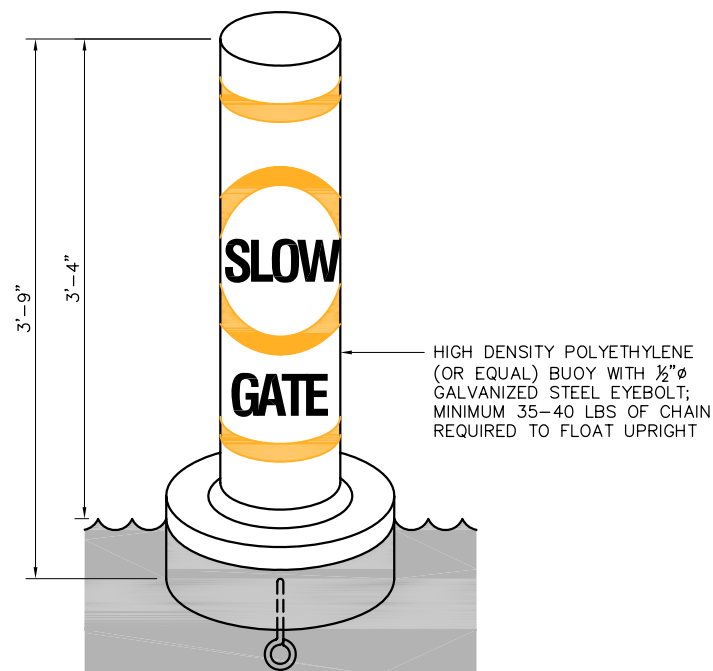

ORANGE ON WHITE WITH BLACK
LETTERS


NOTE:
45' OF 1/2" OPEN LINK CHAIN
WITH 25 LB DANFORTH
STANDARD ANCHOR.

2 SLOW GATE SIGN
C19 SCALE: 1/8" = 1'-0"
C47

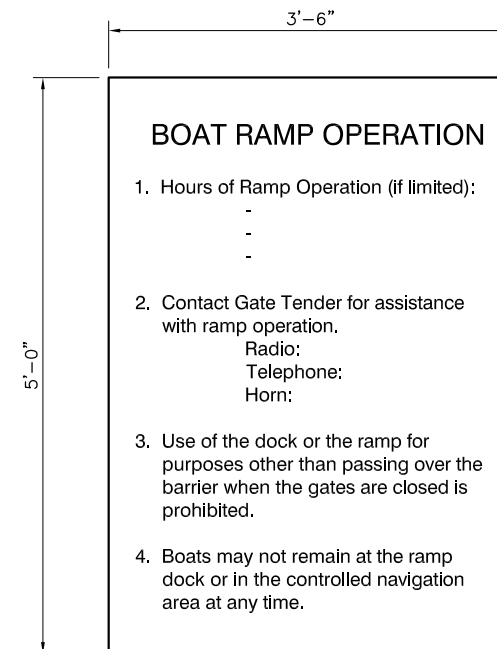


BLACK LETTERS ON WHITE
PAINTED ALUMINUM BOARD

3 BOAT RAMP DOCK SIGN
C19 SCALE: NONE
C47

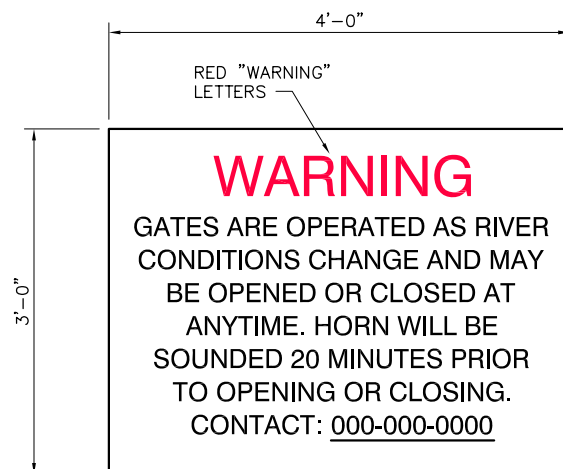


BLACK LETTERS ON WHITE PAINTED
ALUMINUM BOARD
CONTACT NUMBER TO BE PROVIDED BY OWNER

5 GATE WARNING SIGN
C19 SCALE: NONE
C47

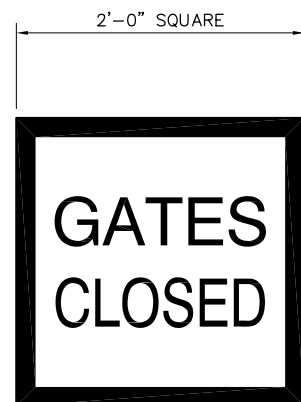


BLACK LETTERS AND BORDER ON
WHITE PAINTED ALUMINUM BOARD

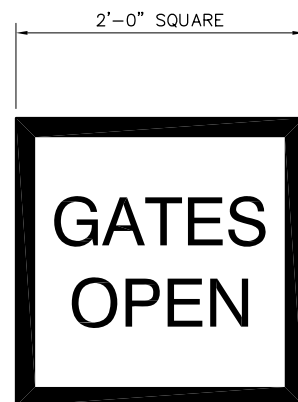


BLACK LETTERS AND BORDER ON
WHITE PAINTED ALUMINUM BOARD

6 GATE POSITION SIGNS
C19 SCALE: 1/8" = 1'-0"
C47, C74

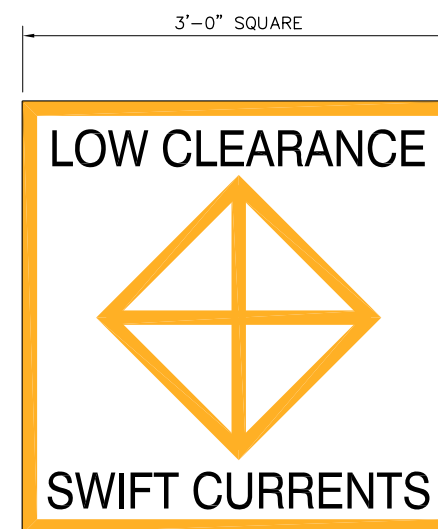


ORANGE SYMBOL AND BORDER,
BLACK LETTERS ON WHITE
PAINTED ALUMINUM BOARD

7 DANGER SIGN
C19 SCALE: 1/8" = 1'-0"
C47

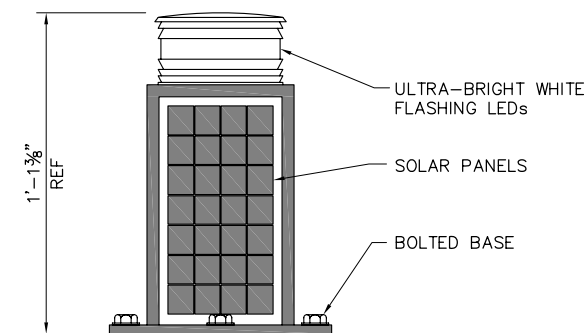


NAVIGATION LIGHT;
ATOP GATE PLATFORM AND ALONG SHEET PILE WHERE NOTED.
CARMANAH MODEL M702-5GPS OR EQUAL - SEE SPECIFICATIONS.

4 NAVIGATION LIGHT
C19 SCALE: NONE
C47, C76

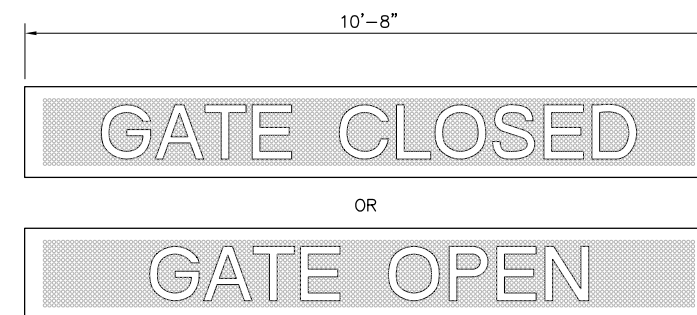

CHANGEABLE ELECTRIC MESSAGEBOARD 12 LETTER, 12" HIGH,
VISIBLE FROM 600', MOUNTED ON OPERATOR HOUSE ROOF
ONE EACH FACING UPSTREAM & DOWNSTREAM.
MODEL PDR0112-12 FROM GRANDWELL DISPLAYS OR EQUAL

8 ELECTRONIC MESSAGE SIGN
C19 SCALE: NONE
C47

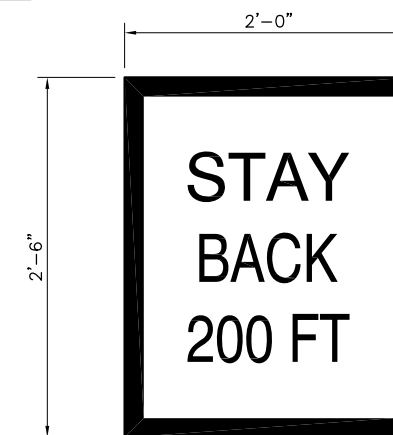

NOTE:
SEE DRAWING C76 FOR SIGN
MOUNTING DETAILS.


BLACK LETTERS AND BORDER ON WHITE PAINTED
ALUMINUM BOARD

9 STAY BACK WARNING SIGN
C19 SCALE: 1/8" = 1'-0"
C47


95% SUBMITTAL

IF SHEET IS LESS THAN 22" x 34"
IT IS A REDUCED PRINT -
SCALE REDUCED ACCORDINGLY.


REVISION	DESCRIPTION	BY	DATE			 2001 N. Main Street, Suite 360 Walnut Creek, California 94596 (925) 944-5411	TWO GATE FISH PROTECTION PLAN		DATE 08/07/09
									SHEET 68 OF 75
							AIDS TO NAVIGATION DETAILS, SHEET 1	C75	

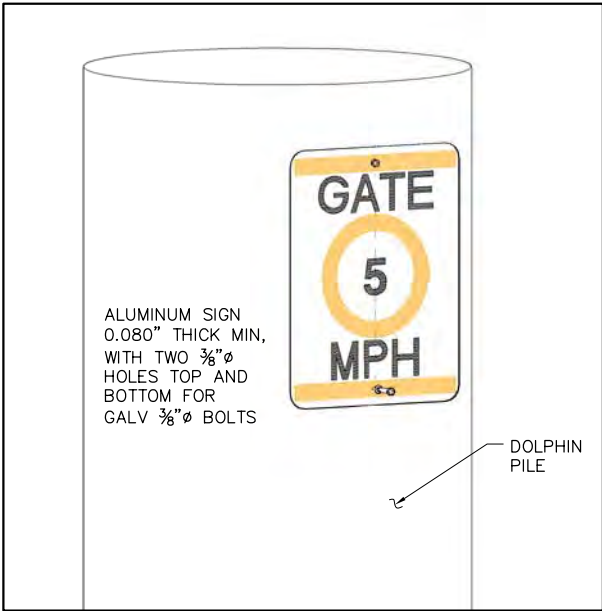


1 SIGN MOUNTING DETAIL
C19 SCALE: NONE
C47

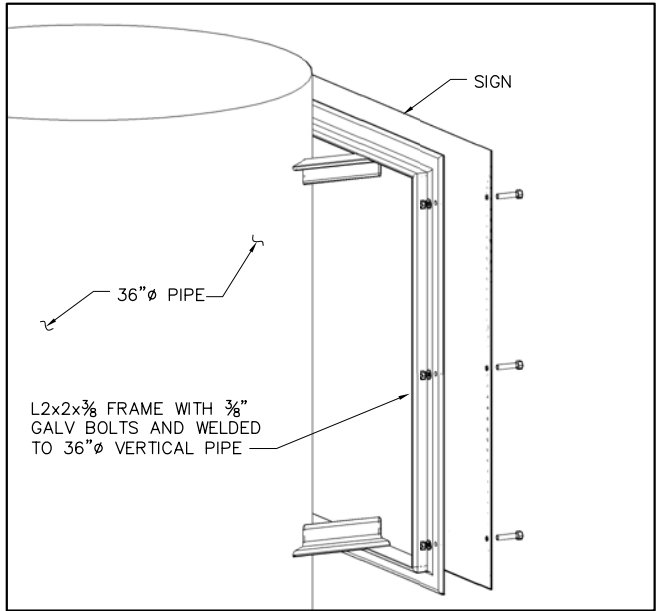


2 SIGN MOUNTING DETAIL
C19 SCALE: NONE
C47

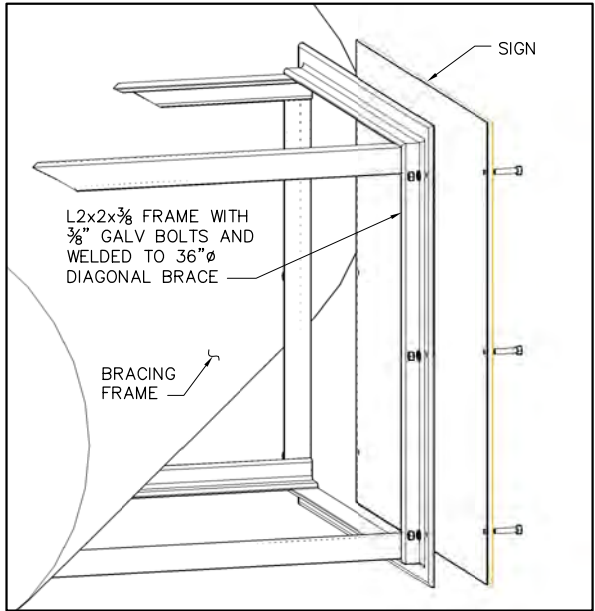


3 SIGN MOUNTING DETAIL
C19 SCALE: NONE
C47

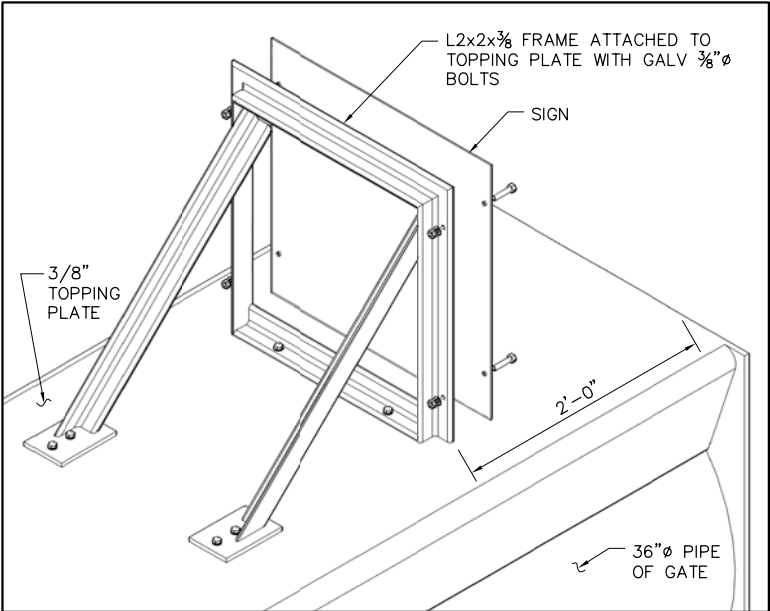


4 SIGN MOUNTING DETAIL
C19 SCALE: NONE
C47

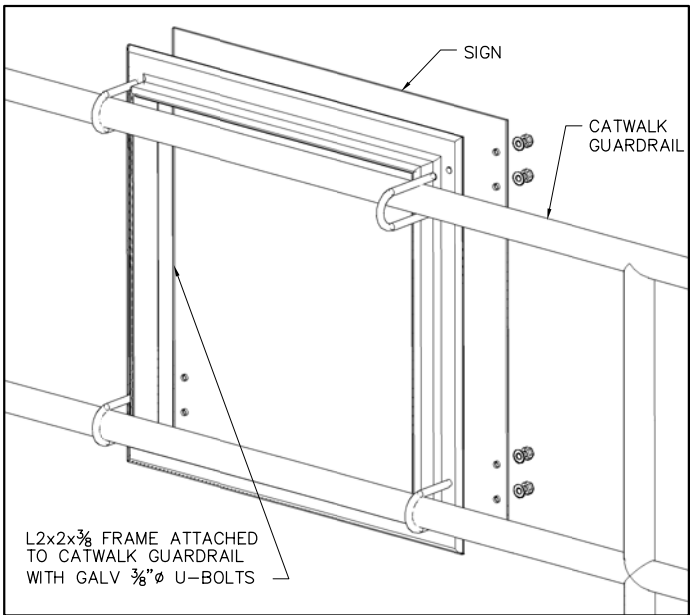

5 SIGNAGE MOUNTING DETAIL
C19 SCALE: NONE
C47

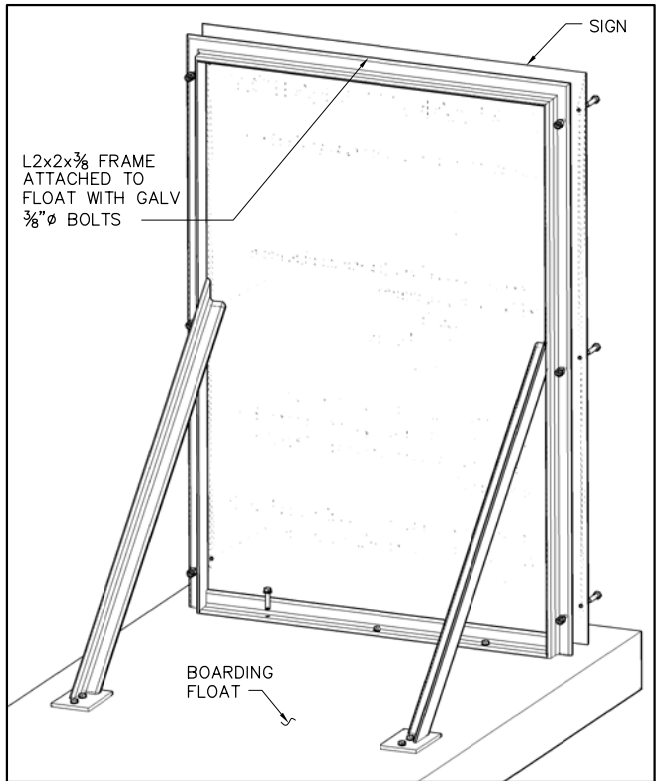

6 BOAT RAMP DOCK SIGN
C19 SCALE: NONE
C47

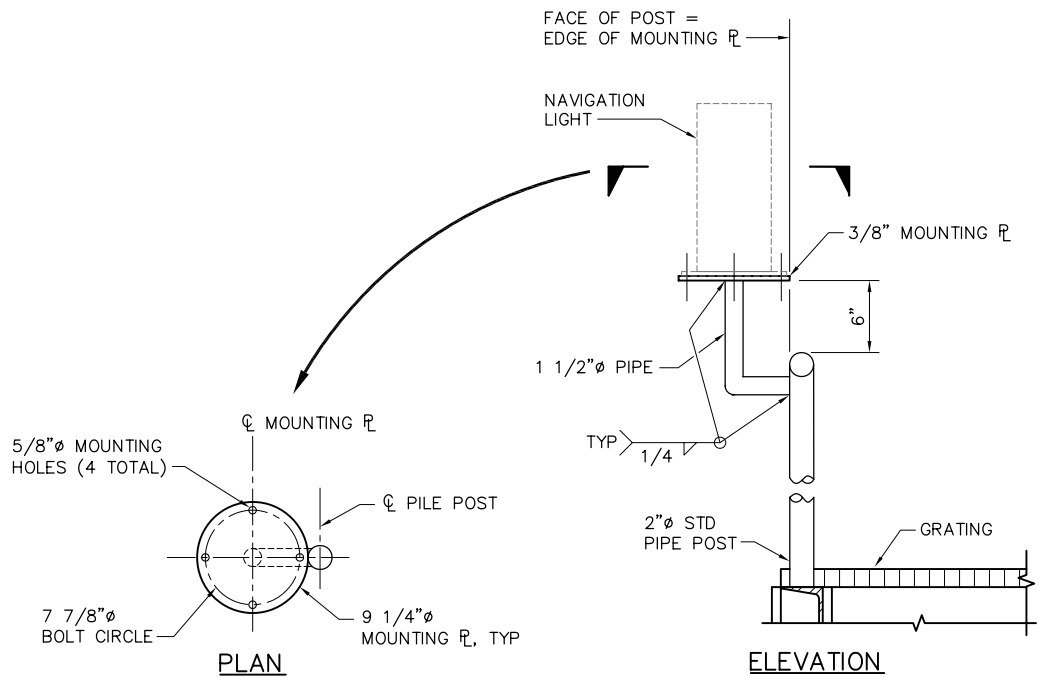

7 TYPICAL NAVIGATION LIGHT MOUNTING DETAIL
C15 SCALE: 1 1/2\"/>

95% SUBMITTAL

IF SHEET IS LESS THAN 22\"/>

REVISION	DESCRIPTION	BY	DATE



2001 N. Main Street, Suite 360
Walnut Creek, California 94596
(925) 944-5411

DSGN	TDB	DR	TAE/AB	CHK	RBD
JOB NO.	6097-03	SUBMITTED BY	RMR	TITLE	

 
TWO GATE FISH PROTECTION PLAN

DATE 08/07/09

SHEET 69 OF 75

AIDS TO NAVIGATION DETAILS
SHEET 2


C76



-  SERVICE PANEL AND
TRANSFER SWITCH ELEVATION
NTS



 - 3 AREA LIGHT POLE
C13 NTS
C82



GENERAL NOTES:

1. PROVIDE AND INSTALL MIN 20'-0"L, 1-#3/0 MIN. BARE COPPER UFER GROUND WIRE 2" ABOVE BOTTOM OF PAD. BOND TO ELECTRICAL EQUIPMENT.
2. ANCHOR EQUIPMENT TO CONCRETE PAD WITH ANCHORS PER EQUIPMENT MANUFACTURER'S INSTALLATION INSTRUCTIONS.
3. PROVIDE 6'-0" MIN. CLEAR WORKING SPACE AROUND EQUIPMENT.
4. STUB CONDUITS IN EQUIPMENT AT LOCATIONS PROVIDED BY EQUIPMENT MANUFACTURERS INSTALLATION INSTRUCTIONS. COORDINATE EXACT LOCATION WITH MANUFACTURERS INSTALLATION INSTRUCTIONS.
5. ALL UNDER GROUND CONDUIT SHALL BE SCH 40 PVC 36" BELOW FINISH GRADE.

REVISION	DESCRIPTION	BY	DATE

 2001 N. Main Street, Suite 360 Walnut Creek, California 94596 (925) 944-5411		
DSGN DM	DR AB/EP	CHK CBS
JOB NO. 6097-03	SUBMITTED BY RMR	TITLE


TWO GATE FISH PROTECTION PLAN

UTILITY YARD DETAILS

DATE 08/07/09

SHEET 70 OF 75


C77

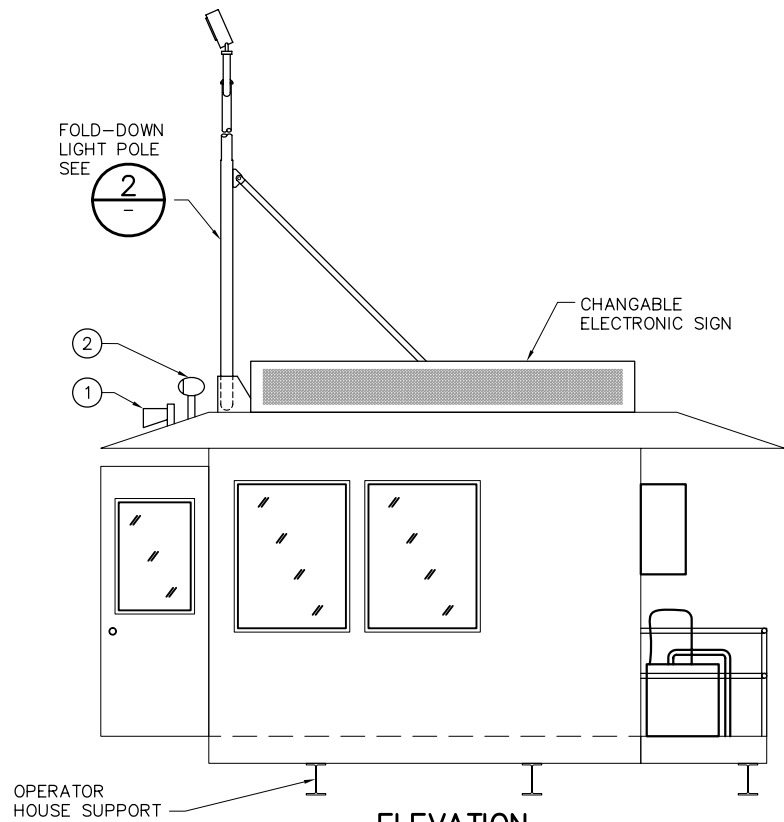


ELEVATION
SCALE: 3/8" = 1'-0"

NOTES:


- 1 SECO HAILER HORN
40 HMS, 15 WITH
STANDARD HORIZON
30W LOUD HAILER
MFG #VLH-3000
- 2 REMOTE CONTROLLED SEARCHLIGHT.
ACR ELECTRONICS
MFG #RCL-75 SPOTLIGHT
AND 17' L CABLE HARNESS

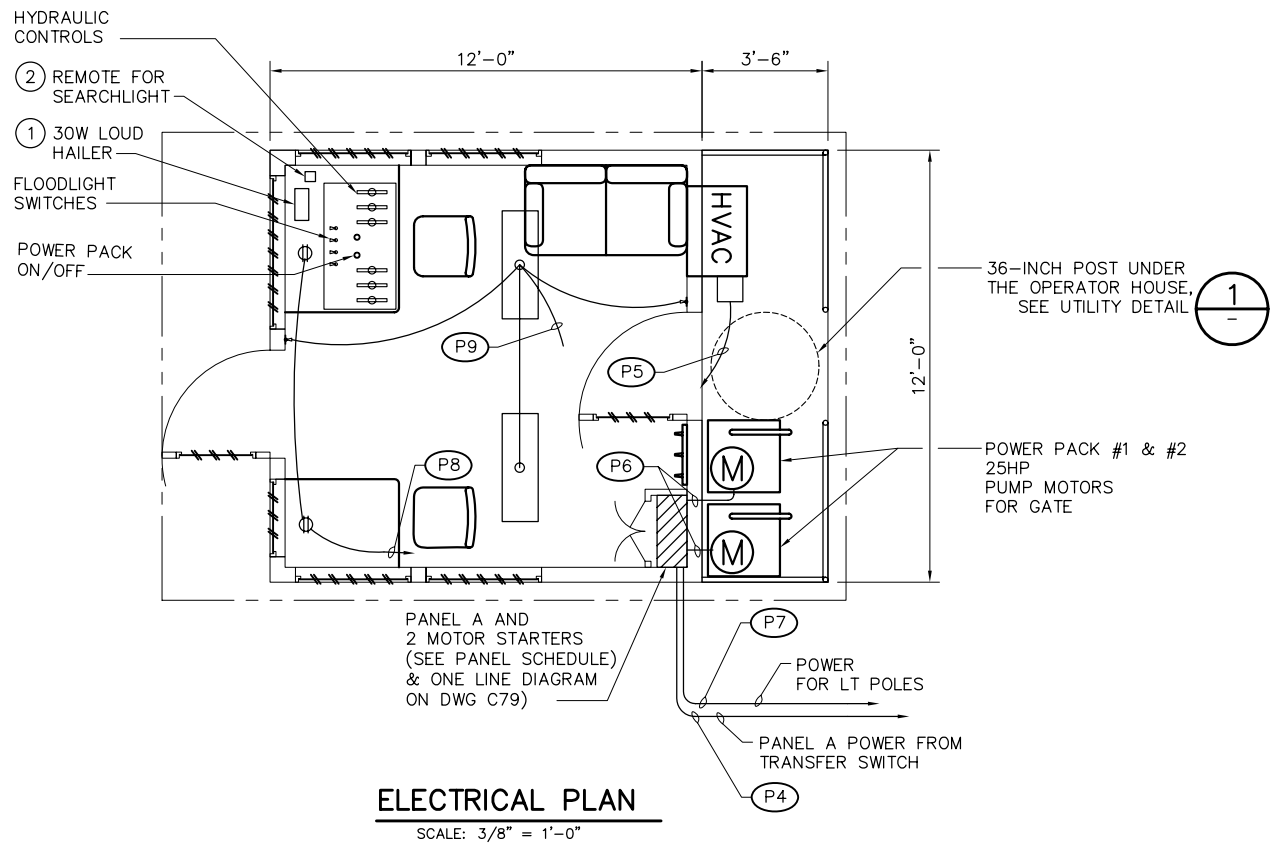


ELECTRICAL PLAN
SCALE: 3/8" = 1'-0"

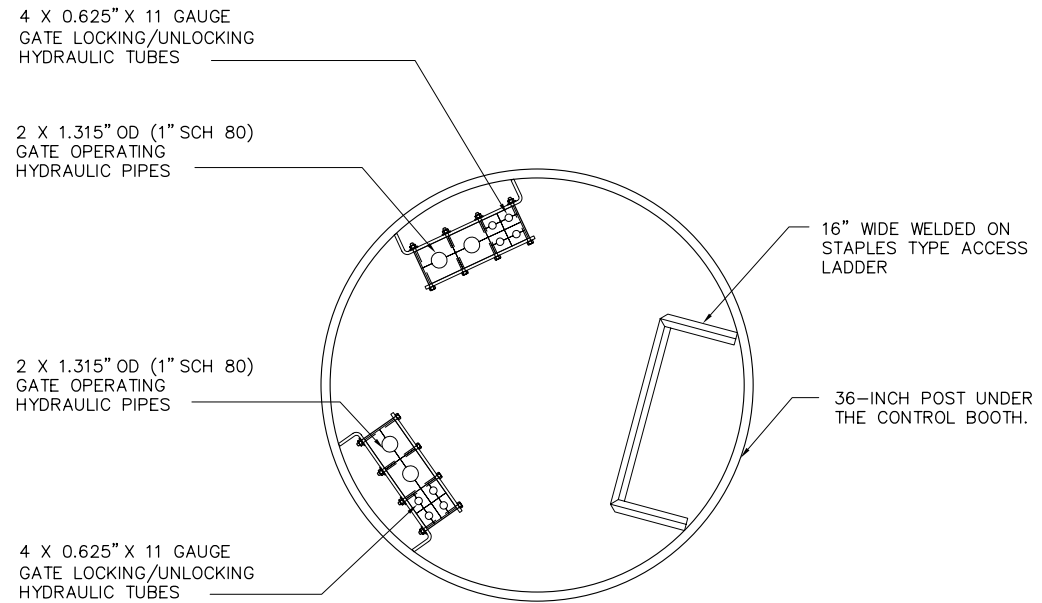

1 UTILITY DETAIL
SCALE: 1 1/2" = 1'-0"

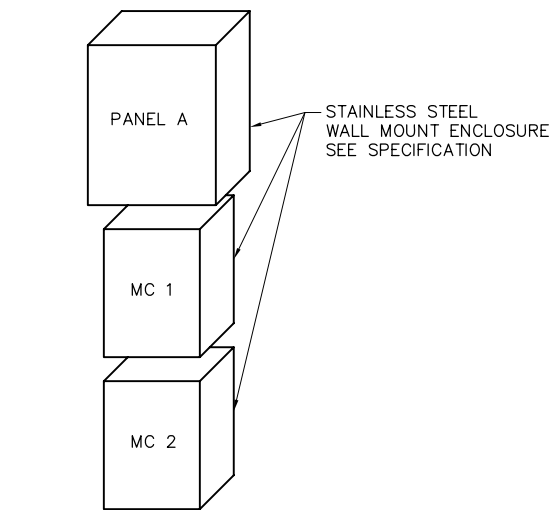

**ELECTRICAL CABINET
ARRANGEMENT**
NTS

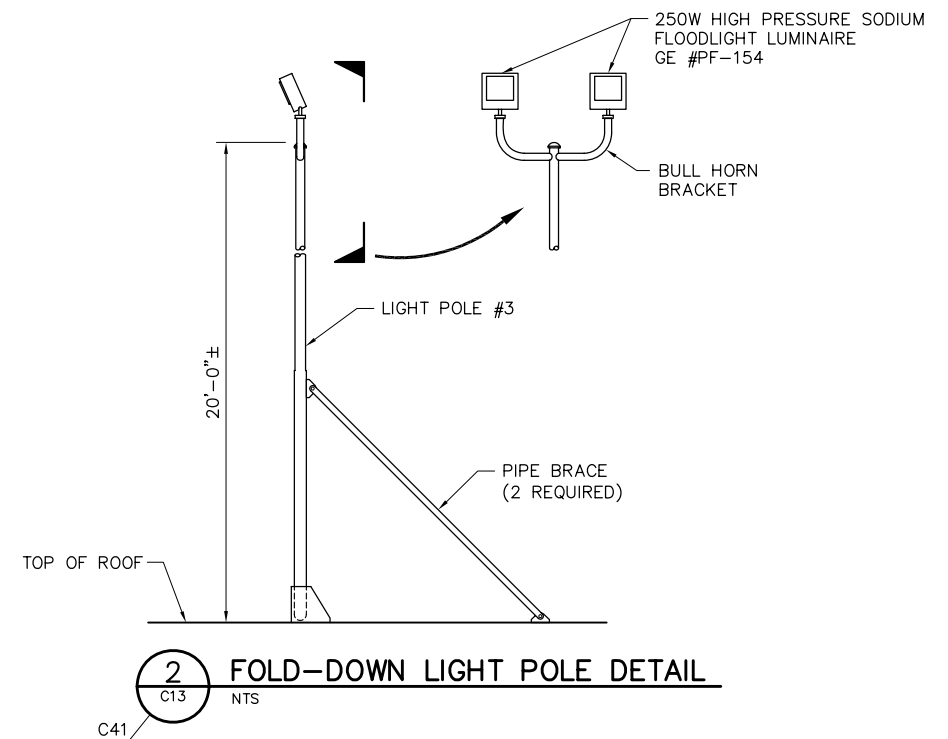


95% SUBMITTAL

IF SHEET IS LESS THAN 22" x 34"
IT IS A REDUCED PRINT -
SCALE REDUCED ACCORDINGLY.

REVISION	DESCRIPTION	BY	DATE

2001 N. Main Street, Suite 360 Walnut Creek, California 94596 (925) 944-5411		TWO GATE FISH PROTECTION PLAN		DATE 08/07/09
				SHEET 71 OF 75
DSGN CBS DR AB/EP CHK TDB JOB NO. 6097-03 SUBMITTED BY RMR TITLE		OPERATOR HOUSE EQUIPMENT AND DETAILS		C78

P:\6097-03 SWC GATE DESIGN\CADD\DWG\609703-C79.DWG 7/24/2009 10:53 AM

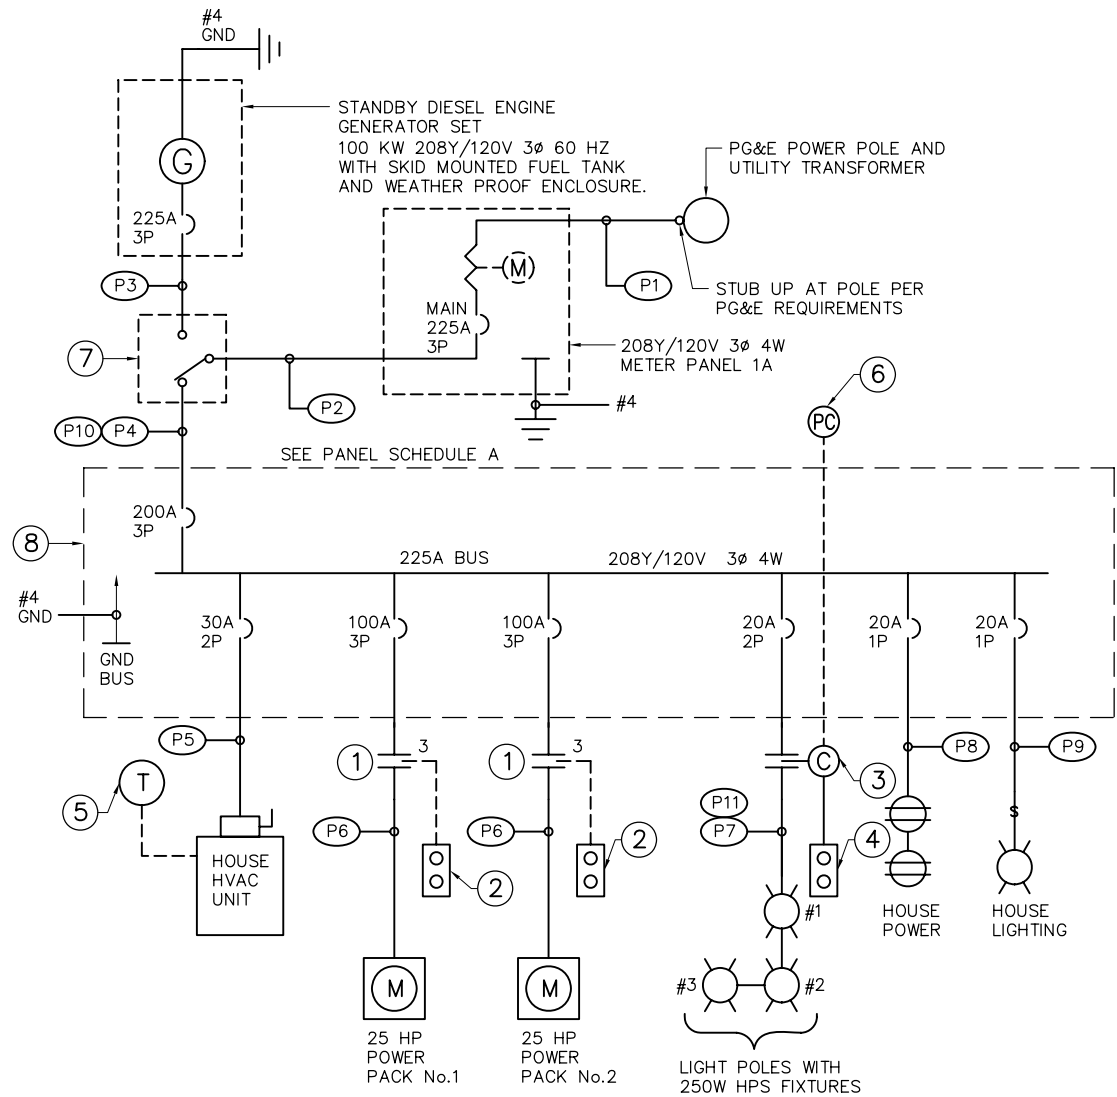

ONE LINE DIAGRAM
N.T.S.

NOTES:

- ① NEMA SIZE 3 COMBINATION MOTOR STARTER
- ② POWER PACK ON/OFF CONTROL IN OPERATOR HOUSE
- ③ 30A LIGHTING CONTACTOR
- ④ FLOOD LIGHT CONTROL. HAND OFF AUTO IN OPERATOR HOUSE
- ⑤ THERMOSTAT CONTROL IN OPERATOR HOUSE
- ⑥ PHOTO CELL LOCATED ON TOP OF OPERATOR HOUSE
- ⑦ 225A - 4W 208Y/120V 3PH. 4 POLE NONAUTOMATIC TRANSFER SWITCH IN A NEMA 3R ENCLOSURE
- ⑧ PANEL "A" LOCATED IN OPERATOR HOUSE

PANEL: A

LOCATION : CONTROL HOUSE					VOLTAGE/PHASE : 208Y/120V, 3Ø, 4W										FED FROM : PANEL 1A					
MOUNTING : SURFACE					BUS AMPS : 225A										MINIMUM BUS BRACING : 10 KA					
					MAIN BREAKER : 200A 3P															
LOADS	SEE NOTE	OUTLETS			VOLT-AMPS				BKR/ POLE	A B C	BKR/ POLE		VOLT-AMPS			OUTLETS			SEE NOTE	LOADS
		LTG	REC	MISC	A	B	C	CKT				CKT	A	B	C	MISC	REC	LTG		
POWER PACK #1	1			1	9360			1	100/3	*-----	20/2	2	500					4	2	OUT SIDE LIGHTS
25 HP MOTOR						9360		3	.	-----*	.	4		500						
							9360	5	.	-----*	20/1	6			720		2			HOUSE RECEPT
POWER PACK #2	1			1	9360			7	100/3	*-----	20/1	8	200					2		HOUSE LIGHTS
25 HP MOTOR						9360		9	.	-----*		10								SPACE
							9360	11	.	-----*		12								SPACE
HOUSE				1	2000			13	30/2	*-----		14								SPACE
HVAC UNIT						2000		15	.	-----*		16								SPACE
SPARE								17	20/1	-----*		18								SPACE
SPARE								19	20/1	*-----		20								SPACE
SPARE								21	20/1	-----*		22								SPACE
SPARE								23	20/1	-----*		24								SPACE
TOTAL ØA = 21420 VOLT-AMPS TOTAL ØB = 21220 VOLT-AMPS TOTAL ØC = 19440 VOLT-AMPS LCL = 300 VOLT-AMPS TOTAL = 62380 VA @ 208V, 3Ø 173.3 AMPS NOTES: 1. CONTROLLED BY SIZE 3 MOTOR STARTER 2. CONTROLLED BY PHOTOCELL AND HAND-OFF-AUTO SWITCH																				

CONDUIT AND FEEDER SCHEDULE

	CONDUIT	CONDUCTOR	REMARKS
P1	3" PVC	PULL ROPE	CONDUCTORS BY PG&E
P2	3" PVC	4 #4/0 & 1 #4 GND	TO TRANSFER SWITCH
P3	3" PVC	4 #4/0 & 1 #4 GND	TO TRANSFER SWITCH
P4	3" PVC	4 #4/0 & 1 #4 GND	SURVING PANEL A
P5	1" PVC	2 #10 & 1 #4 GND	HVAC
P6	1 1/4" PVC	3 #2 & 1 #2 GND	POWER PACK #1 & #2
P7	1" PVC	2 #8 & 1 #8 GND	AREA LIGHTING
P8	1/2" PVC	2 #12 & 1 #12 GND	HOUSE POWER
P9	1/2" PVC	2 #12 & 1 #12 GND	HOUSE LIGHTING
* P10	-	3 #4/0 & 1 #4/0 NET	OVERHEAD CABLE
* P11	-	2 #1/0 & 1 #1/0 NET	OVERHEAD CABLE

* PAC 600V PARALLEL AERIAL CABLE ALUMINUM HD POLY 75° C.

95% SUBMITTAL

IF SHEET IS LESS THAN 22" x 34"
IT IS A REDUCED PRINT -
SCALE REDUCED ACCORDINGLY.

REVISION	DESCRIPTION	BY	DATE



2001 N. Main Street, Suite 360
Walnut Creek, California 94596
(925) 944-5411

DSGN DM	DR AB/EP	CHK CBS
JOB NO. 6097-03	SUBMITTED BY RMR	TITLE

TWO GATE FISH PROTECTION PLAN


DATE 08/07/09

SHEET 72 OF 75

ELECTRICAL SYSTEM DIAGRAM


C79

P:\6097-03 SWC GATE DESIGN\CADD\DWG\609703-C80.DWG 7/24/2009 10:53 AM

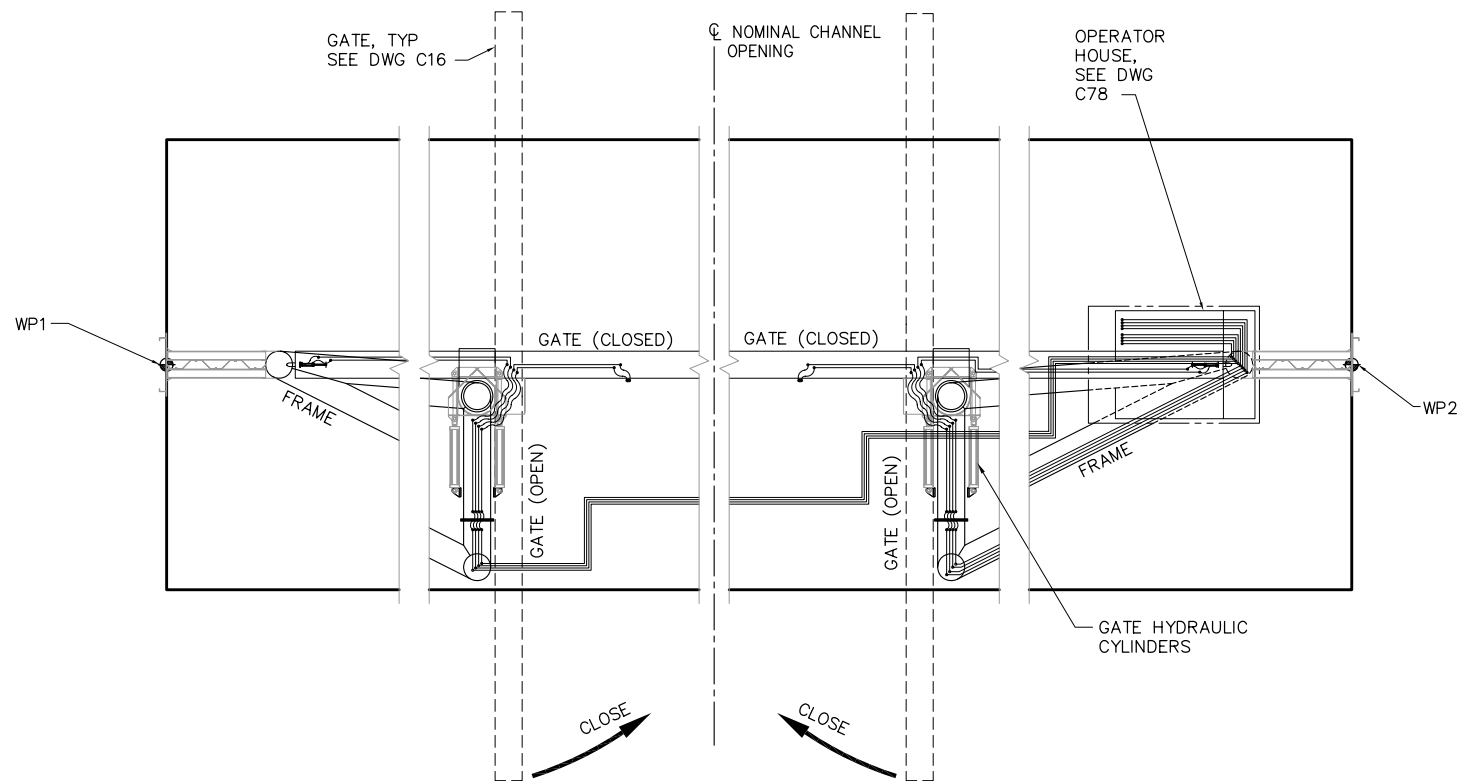


GATE LOCKING HYDRAULIC DIAGRAM

SCALE: 3/32" = 1'-0"

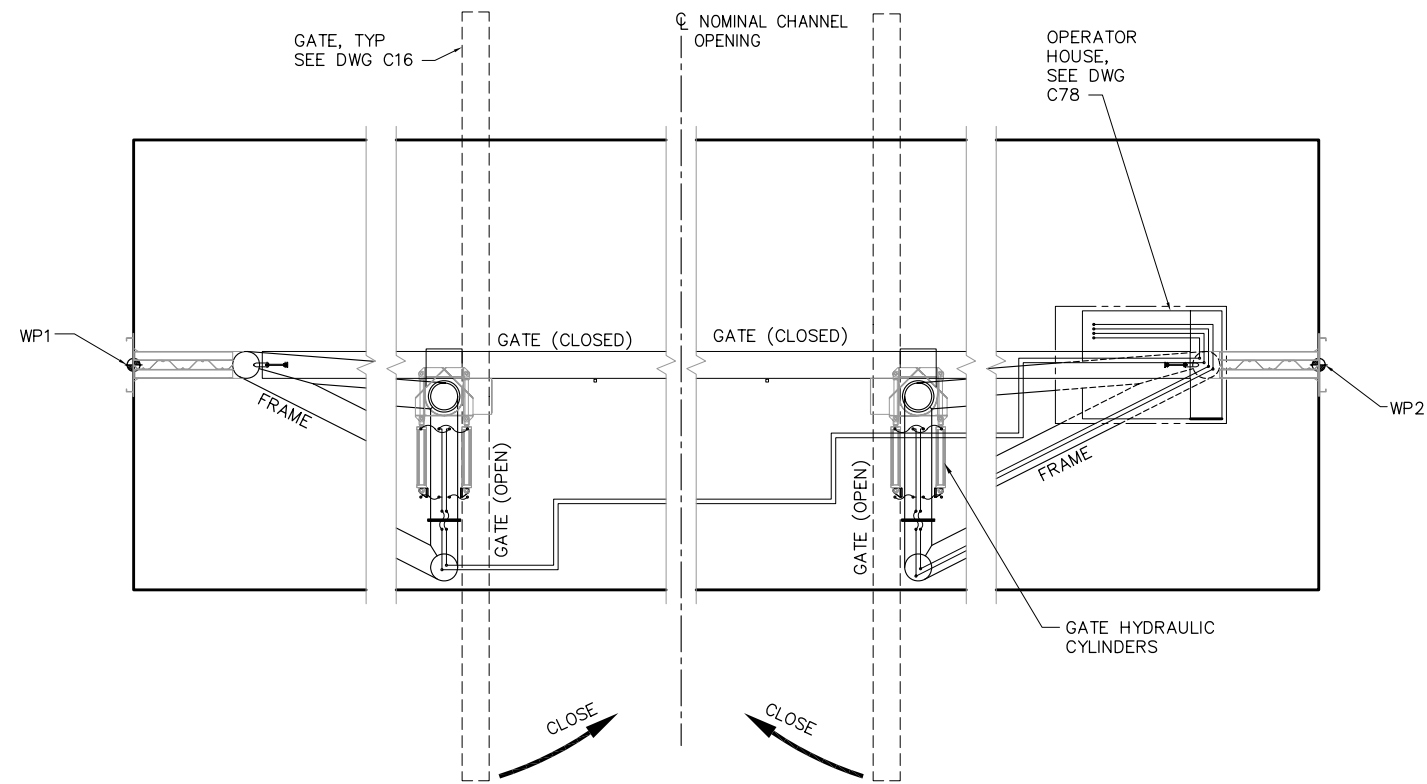


GATE OPERATOR HYDRAULIC DIAGRAM

SCALE: 3/32" = 1'-0"

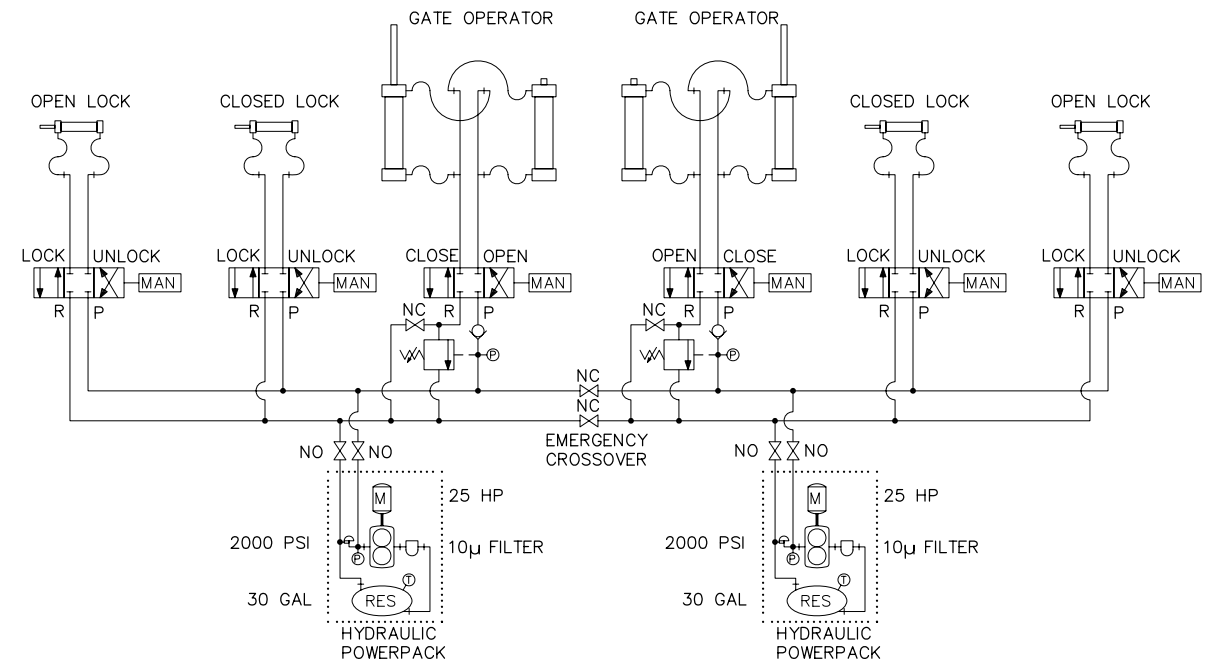

HYDRAULIC SYSTEM SCHEMATIC

NTS

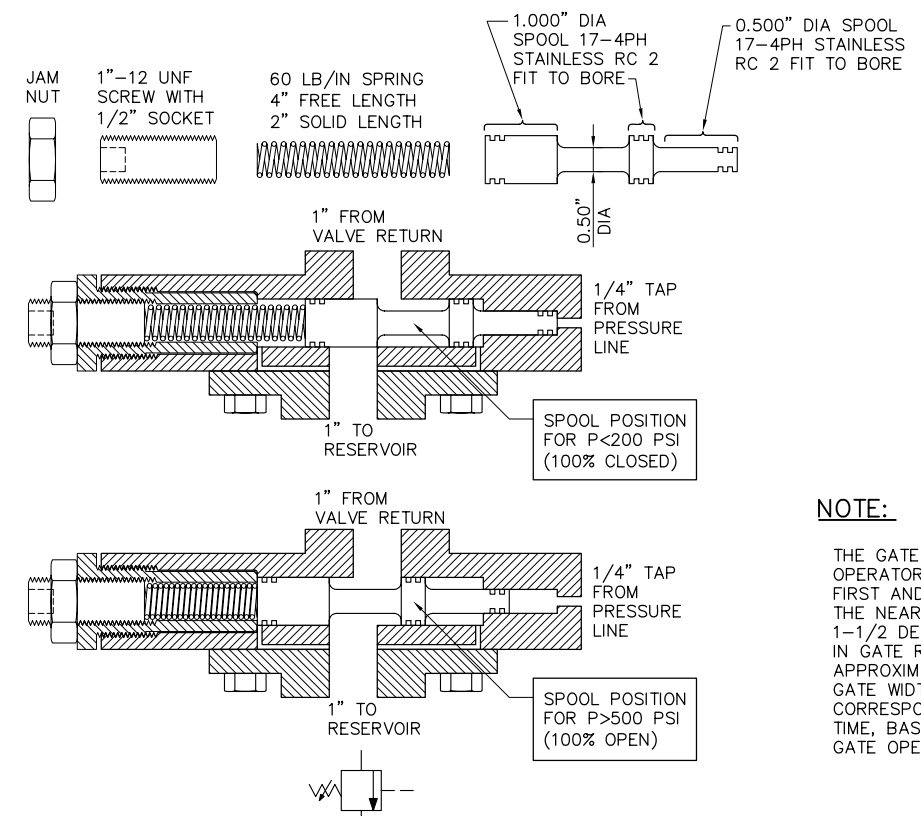

TYPICAL BRAKE VALVE

(EXTERNALLY PILOTED COUNTERBALANCE VALVE)

NTS

NOTE:

THE GATE FARTHEST FROM THE OPERATOR HOUSE MUST BEGIN OPENING FIRST AND CLOSE SLIGHTLY LATER THAN THE NEAR GATE WITH APPROXIMATELY 1-1/2 DEGREES MAXIMUM DIFFERENCE IN GATE ROTATION. (1-1/2 DEGREES IS APPROXIMATELY ONE-HALF OF THE GATE WIDTH LEAD OR LAG, AND CORRESPONDS TO A 4 SECOND DELAY TIME, BASED ON A 4 MINUTE TOTAL GATE OPENING TIME.)

95% SUBMITTAL

IF SHEET IS LESS THAN 22" x 34"
IT IS A REDUCED PRINT -
SCALE REDUCED ACCORDINGLY.

REVISION	DESCRIPTION	BY	DATE

 Moffatt & Nichol		2001 N. Main Street, Suite 360 Walnut Creek, California 94596 (925) 944-5411	
DSGN	CBS	DR	AB
JOB NO.	6097-03	SUBMITTED BY	RMR
CHK	TDB	TITLE	


TWO GATE FISH PROTECTION PLAN		DATE	08/07/09
HYDRAULICS SYSTEM DIAGRAM		SHEET	73 OF 75

C80


P:\6097-03 SWC GATE DESIGN\CADD\DWG\609703-C81.DWG 8/7/2009 10:54 AM



A DISPOSAL SITE PLAN
NTS
NOTE: SEE DWG G4 FOR LOCATION.

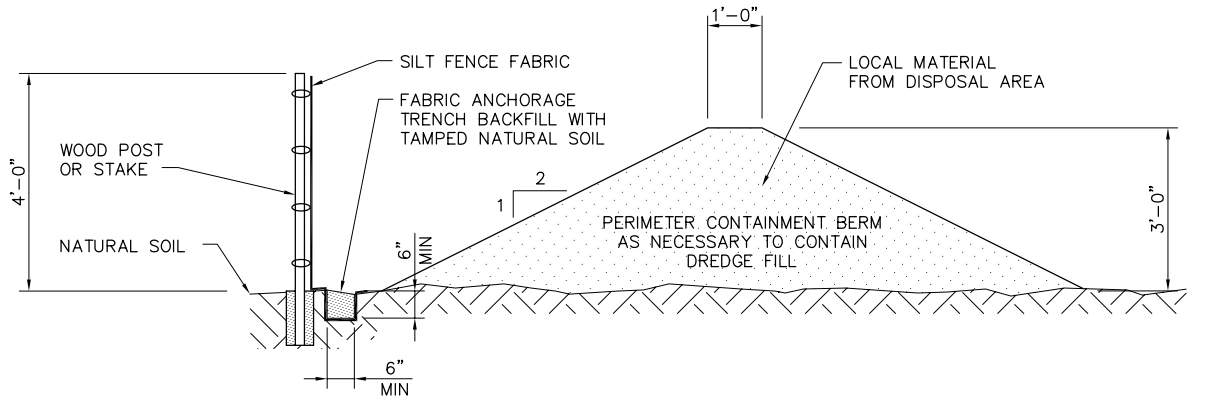

B SECTION
SCALE: NONE

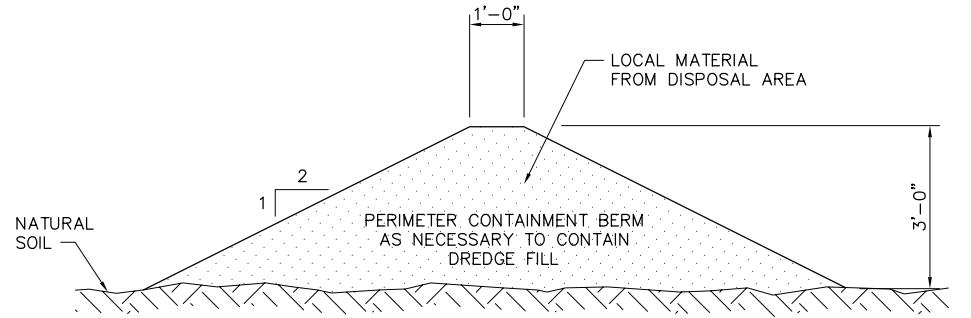

C SECTION
SCALE: NONE

NOTE:
NO DREDGE MATERIAL SHALL BE PLACED WITHIN 140'
OF THE LEVEE CENTERLINE AND 100' OF THE WETLANDS.

95% SUBMITTAL IF SHEET IS LESS THAN 22" x 34"
IT IS A REDUCED PRINT -
SCALE REDUCED ACCORDINGLY.

REVISION	DESCRIPTION	BY	DATE



2001 N. Main Street, Suite 360
Walnut Creek, California 94596
(925) 944-5411

DSGN	TDB	DR	TAE/AB	CHK	GTH
JOB NO.	6097-03	SUBMITTED BY	RMR	TITLE	

TWO GATE FISH PROTECTION PLAN


DREDGED MATERIAL DISPOSAL SITE

DATE 08/07/09


SHEET 74 OF 75

C81


P:\6097-03 SWC GATE DESIGN\CADD\DWG\609703-C82.DWG 8/5/2009 12:11 PM

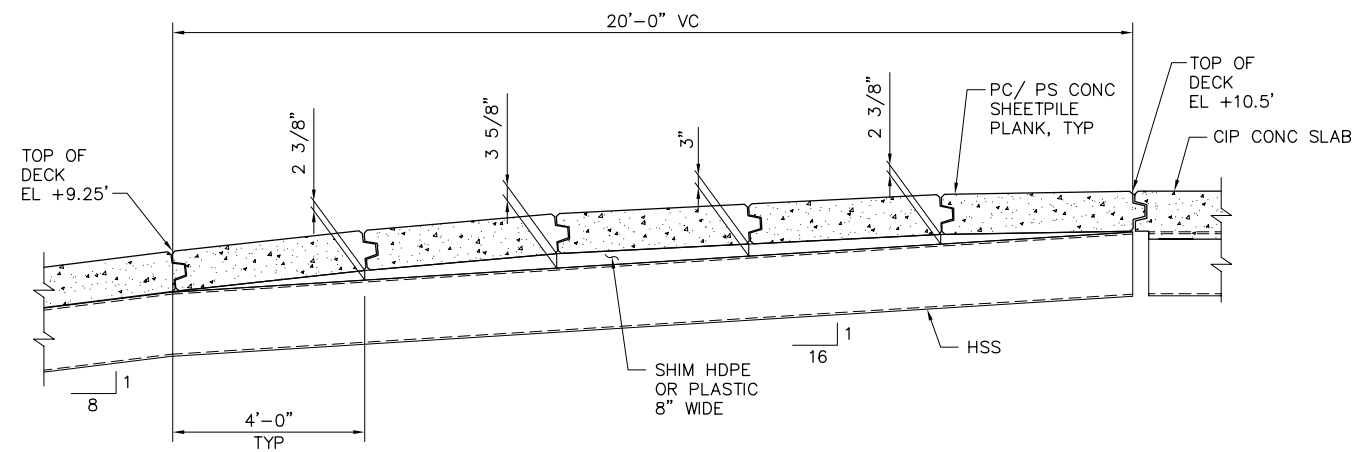


1
C7
DETAIL
SCALE: 1/2" = 1'-0"

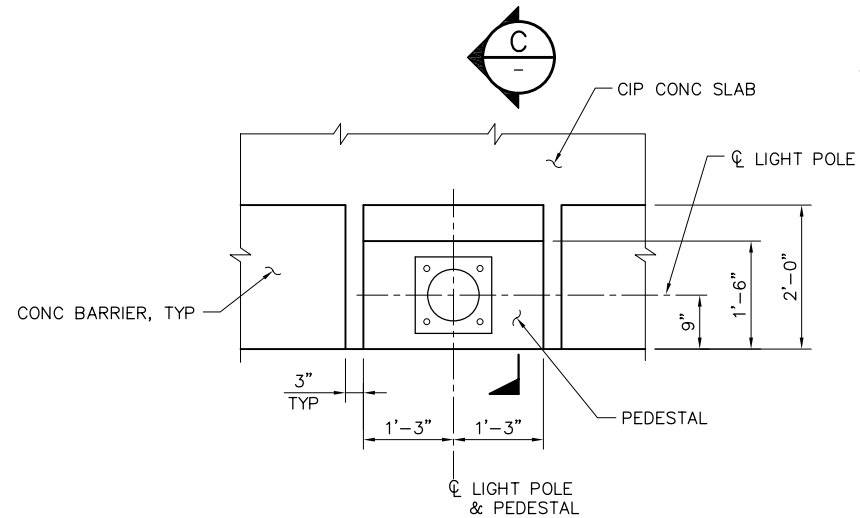


3
C39
DETAIL
SCALE: 3/4" = 1'-0"

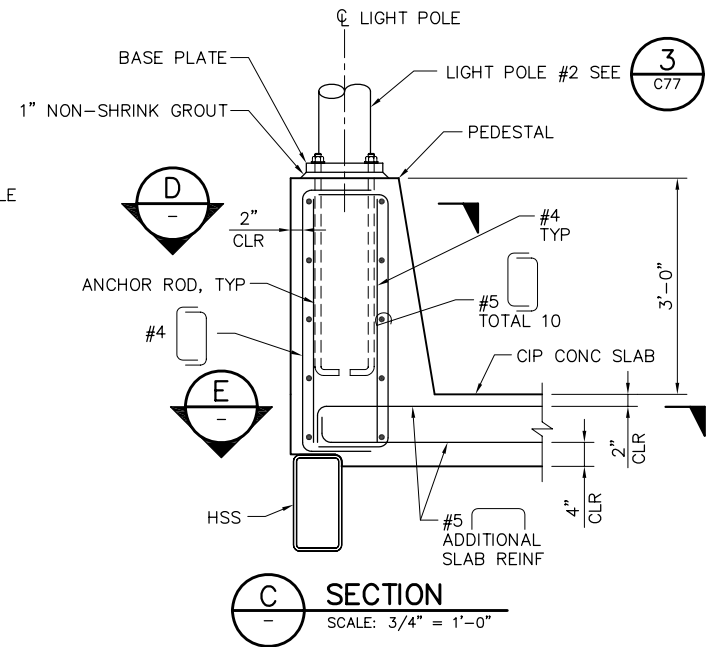


C
SECTION
SCALE: 3/4" = 1'-0"

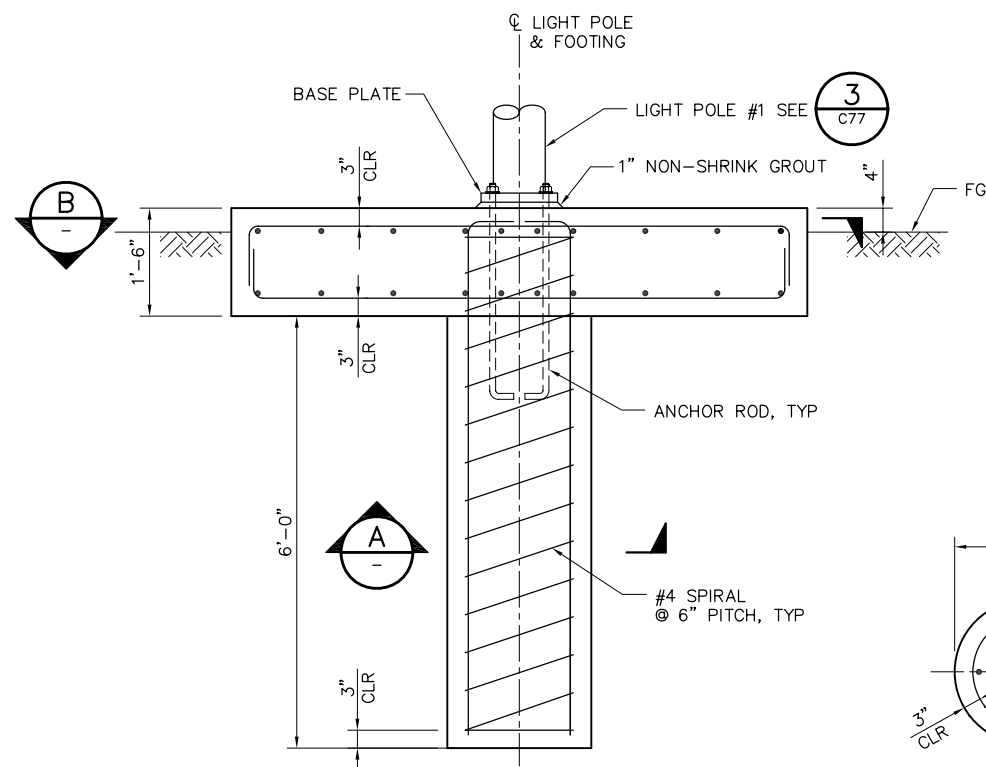


2
C77
DETAIL
SCALE: 3/4" = 1'-0"

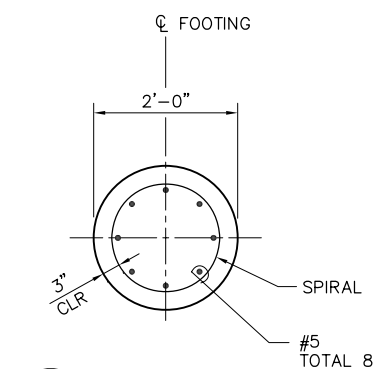


A
SECTION
SCALE: 3/4" = 1'-0"

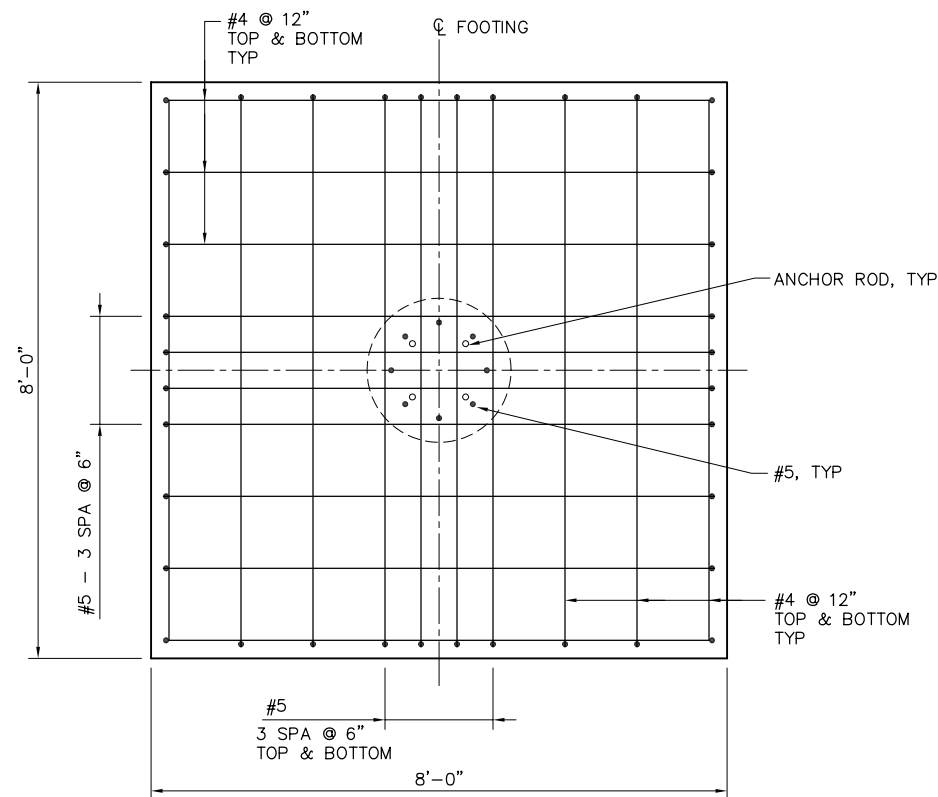

B
SECTION
SCALE: 3/4" = 1'-0"

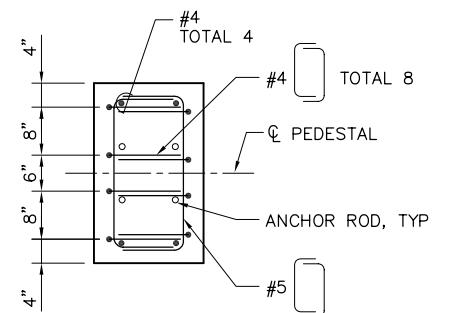

D
SECTION
SCALE: 3/4" = 1'-0"

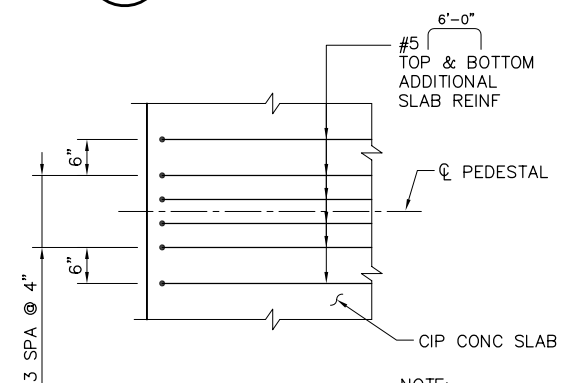

E
SECTION
SCALE: 3/4" = 1'-0"

NOTE:
PEDESTAL REINFORCEMENT
NOT SHOWN FOR CLARITY.

2'-0" 0'-0" 1'-0" 2'-0"
SCALE: 3/4" = 1'-0"

95% SUBMITTAL IF SHEET IS LESS THAN 22" x 34"
IT IS A REDUCED PRINT -
SCALE REDUCED ACCORDINGLY.

REVISION	DESCRIPTION	BY	DATE

 Moffatt & Nichol		2001 N. Main Street, Suite 360 Walnut Creek, California 94596 (925) 944-5411	
DSGN	JMB	DR	EP
JOB NO.	6097-03	SUBMITTED BY	RMR
CHK	TDB	TITLE	

TWO GATE FISH PROTECTION PLAN		DATE 08/07/09
MISCELLANEOUS DETAILS		SHEET 75 OF 75
		C82

