



BACON ISLAND, CALIFORNIA

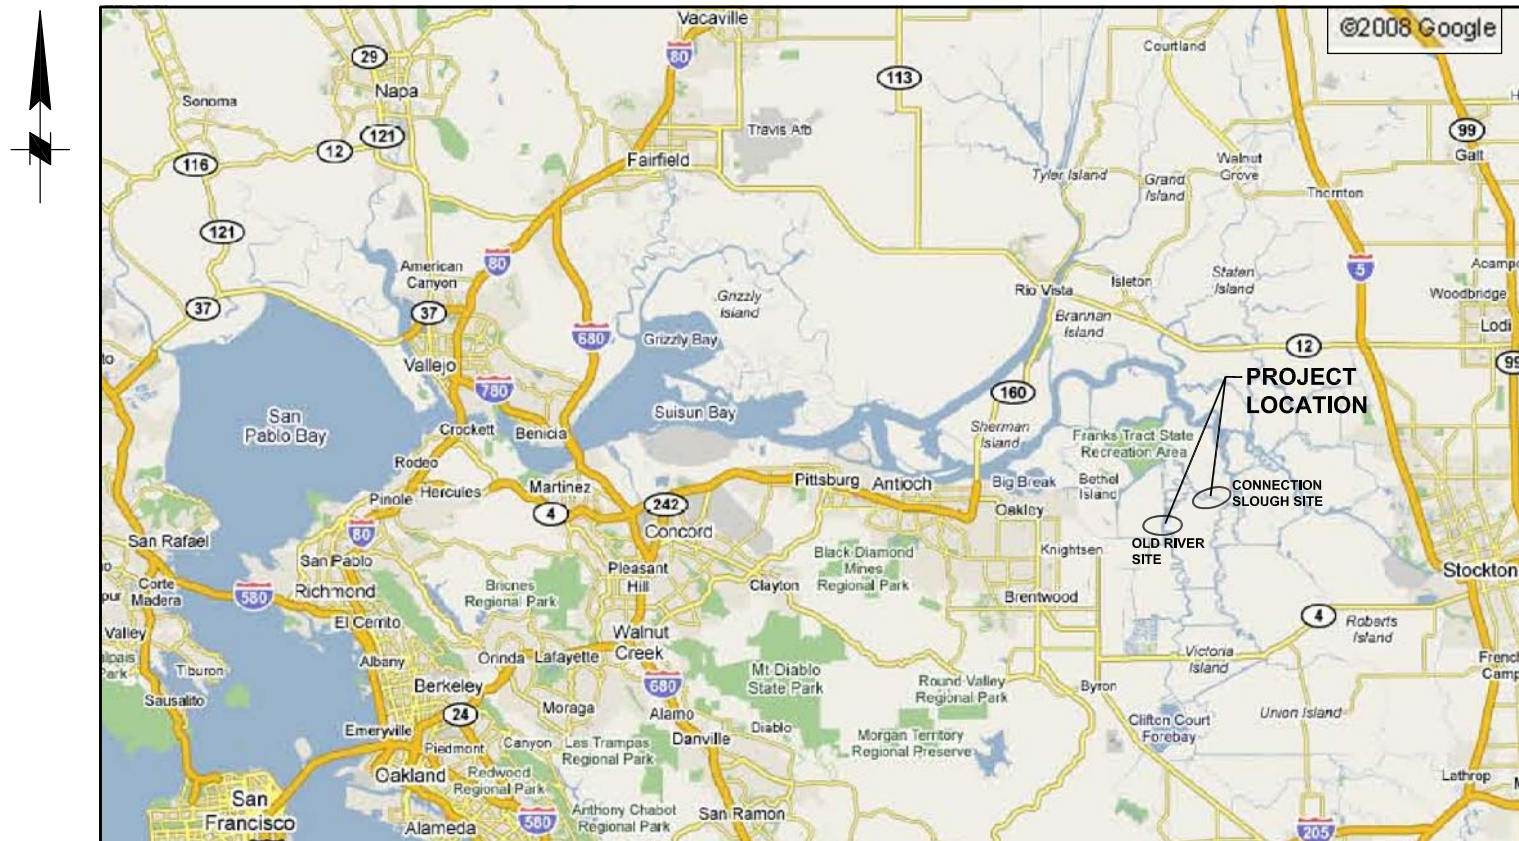

VICINITY MAP
NTS

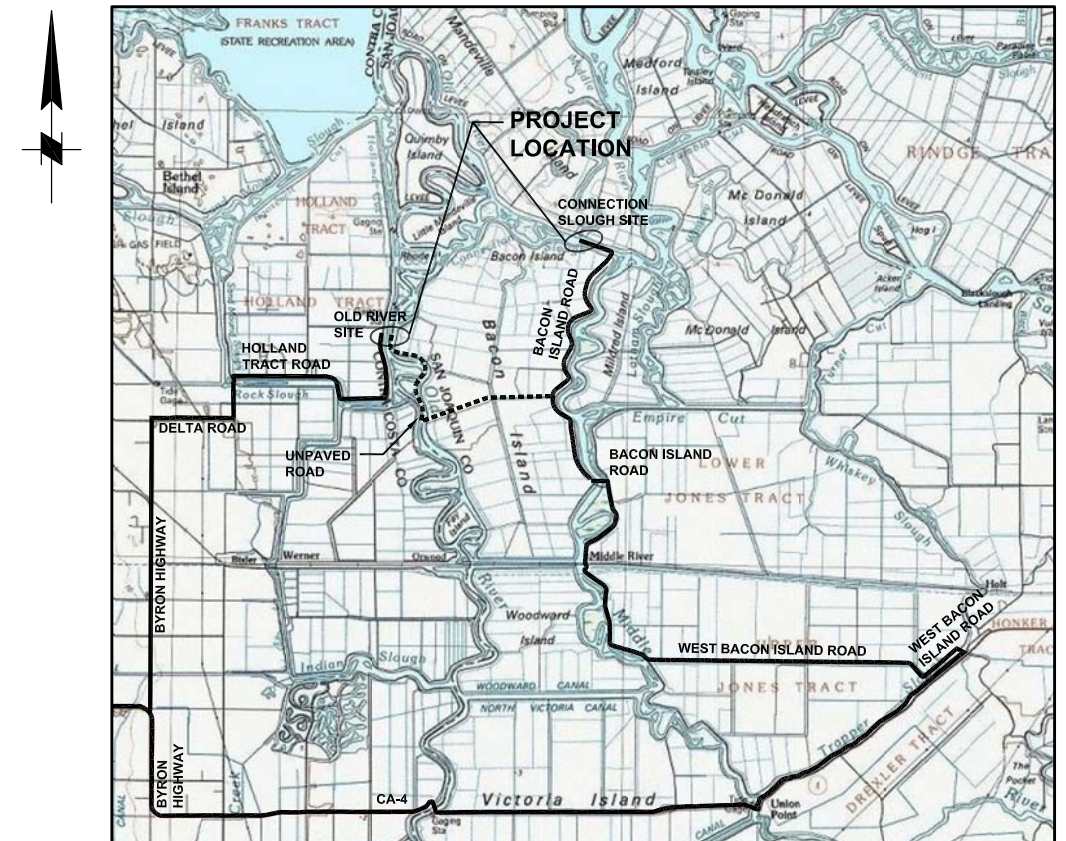

LOCATION MAP
NTS

REVISION	DESCRIPTION	BY	DATE



San Luis & Delta-Mendota Water Authority
842 6th Street, Suite 7
PO Box 2157
Los Banos, California 93635



2001 N. Main Street, Suite 360
Walnut Creek, California 94596
(925) 944-5411

DSGN	DR	CHK
TDB	AB	GTH
JOB NO.	SUBMITTED BY	
6097-03	RMR	

100% SUBMITTAL
REVISION 1

IF SHEET IS LESS THAN 22" x 34"
IT IS A REDUCED PRINT -
SCALE REDUCED ACCORDINGLY.

2-GATES FISH PROTECTION
DEMONSTRATION PROJECT

DATE 10/02/09

SHEET 1 OF 78

TITLE SHEET

G1

P:\6097-03 SWC GATE DESIGN\CADD\DWG\609703-G2.DWG 9/29/2009 3:59 PM

INDEX OF DRAWINGS

SHEET NUMBER	DRAWING NUMBER	DESCRIPTION
		<u>GENERAL</u>
1	G1	TITLE SHEET
2	G2	INDEX OF DRAWINGS
3	G3	GENERAL NOTES, ABBREVIATIONS AND LEGEND
4	G4	PROJECT GENERAL PLAN
		<u>OLD RIVER</u>
5	C1	OLD RIVER, SITE PLAN
6	C2	OLD RIVER, DREDGING PLAN AND SECTION
7	C3	OLD RIVER, BARGE BEDDING PLAN AND SECTIONS
8	C4	OLD RIVER, BARGE – ROCK FILL PLAN AND SECTIONS
9	C5	OLD RIVER, SHEET PILE WALL ARRANGEMENT PLAN AND ELEVATION, SHEET 1
10	C6	OLD RIVER SHEET PILE WALL ARRANGEMENT PLAN AND ELEVATION, SHEET 2
11	C7	OLD RIVER, BOAT RAMP PLAN AND SECTION
12	C7.1	OLD RIVER, BOAT RAMP PILE PLAN
13	C7.2	OLD RIVER, BOAT RAMP FRAMING PLAN
14	C8	OLD RIVER, BOAT RAMP DETAILS AND SECTIONS, SHEET 1
15	C9	OLD RIVER, BOAT RAMP DETAILS AND SECTIONS, SHEET 2
16	C10	OLD RIVER, BOAT RAMP DETAILS AND SECTIONS, SHEET 3
17	C11	OLD RIVER, CATWALK PLAN AND ELEVATION, SHEET 1
18	C12	OLD RIVER, CATWALK PLAN AND ELEVATION, SHEET 2
19	C13	OLD RIVER, ELECTRICAL SITE PLAN
20	C14	OLD RIVER, BARGE GENERAL ARRANGEMENT PLAN
21	C15	OLD RIVER, BARGE GENERAL ARRANGEMENT ELEVATION
22	C16	OLD RIVER, GATE SCANTLINGS
23	C17	OLD RIVER, GATE FRAMING LAYOUT
24	C18	OLD RIVER, GATE STRUCTURAL DETAILS, SHEET 1
25	C19	OLD RIVER, GATE STRUCTURAL DETAILS, SHEET 2
26	C20	OLD RIVER, GATE STRUCTURAL DETAILS, SHEET 3
27	C21	OLD RIVER, GATE STRUCTURAL DETAILS, SHEET 4
28	C22	OLD RIVER, GATE STRUCTURAL DETAILS, SHEET 5
29	C23	OLD RIVER, GATE MECHANICAL DETAILS, SHEET 1
30	C24	OLD RIVER, GATE MECHANICAL DETAILS, SHEET 2
31	C25	OLD RIVER, END WALL SCANTLINGS
32	C26	OLD RIVER, AIDS TO NAVIGATION PLAN

SHEET NUMBER	DRAWING NUMBER	DESCRIPTION
		<u>CONNECTION SLOUGH</u>
33	C31	CONNECTION SLOUGH, SITE PLAN
34	C32	CONNECTION SLOUGH, DREDGING – PLAN AND SECTION
35	C33	CONNECTION SLOUGH, BARGE BEDDING PLAN
36	C34	CONNECTION SLOUGH, BARGE–ROCK FILL PLAN AND SECTIONS
37	C35	CONNECTION SLOUGH, SHEET PILE WALL ARRANGEMENT PLAN AND ELEVATION
38	C36	CONNECTION SLOUGH, BOAT RAMP PLAN AND SECTION
39	C36.1	CONNECTION SLOUGH, BOAT RAMP PILE PLAN
40	C36.2	CONNECTION SLOUGH, BOAT RAMP FRAMING PLAN
41	C37	CONNECTION SLOUGH, BOAT RAMP DETAILS AND SECTIONS, SHEET 1
42	C38	CONNECTION SLOUGH, BOAT RAMP DETAILS AND SECTIONS, SHEET 2
43	C39	CONNECTION SLOUGH, BOAT RAMP DETAILS AND SECTIONS, SHEET 3
44	C40	CONNECTION SLOUGH, CATWALK – PLAN AND ELEVATION
45	C41	CONNECTION SLOUGH, ELECTRICAL SITE PLAN
46	C42	CONNECTION SLOUGH, BARGE GENERAL ARRANGEMENT PLAN
47	C43	CONNECTION SLOUGH, BARGE GENERAL ARRANGEMENT ELEVATION
48	C44	CONNECTION SLOUGH, GATE SCANTLINGS
49	C45	CONNECTION SLOUGH, GATE FRAMING LAYOUT
50	C46	CONNECTION SLOUGH, GATE STRUCTURAL DETAILS, SHEET 1
51	C47	CONNECTION SLOUGH, GATE STRUCTURAL DETAILS, SHEET 2
52	C48	CONNECTION SLOUGH, GATE STRUCTURAL DETAILS, SHEET 3
53	C49	CONNECTION SLOUGH, GATE STRUCTURAL DETAILS, SHEET 4
54	C50	CONNECTION SLOUGH, GATE STRUCTURAL DETAILS, SHEET 5
55	C51	CONNECTION SLOUGH, GATE MECHANICAL DETAILS, SHEET 1
56	C52	CONNECTION SLOUGH, GATE MECHANICAL DETAILS, SHEET 2
57	C53	CONNECTION SLOUGH, END WALL SCANTLINGS
58	C54	CONNECTION SLOUGH, AIDS TO NAVIGATION PLAN

SHEET NUMBER	DRAWING NUMBER	DESCRIPTION
		<u>COMMON DETAILS</u>
59	C63	SHEET PILE WALL DETAILS, SHEET 1
60	C64	SHEET PILE WALL DETAILS, SHEET 2
61	C65	BOAT RAMP PLAN AND SECTIONS
62	C66	BOAT RAMP DETAILS
63	C67	BOARDING FLOAT PLAN AND ELEVATION
64	C68	BOARDING FLOAT DETAILS
65	C69	CATWALK DETAILS, SHEET 1
66	C70	CATWALK DETAILS, SHEET 2
67	C71	CATWALK DETAILS, SHEET 3
68	C72	CATWALK DETAILS, SHEET 4
69	C73	CATWALK DETAILS, SHEET 5
70	C74	CATWALK DETAILS, SHEET 6
71	C75	AIDS TO NAVIGATION DETAILS, SHEET 1
72	C76	AIDS TO NAVIGATION DETAILS, SHEET 2
73	C77	UTILITY YARD DETAILS
74	C78	OPERATOR HOUSE EQUIPMENT AND DETAILS
75	C79	ELECTRICAL SYSTEM DIAGRAM
76	C80	HYDRAULICS SYSTEM DIAGRAM
77	C81	DREDGED MATERIAL DISPOSAL SITE
78	C82	MISCELLANEOUS DETAILS

REVISION	DESCRIPTION	BY	DATE



San Luis & Delta–Mendota Water Authority

842 6th Street, Suite 7

PO Box 2157

Los Banos, California 93635



2001 N. Main Street, Suite 360
Walnut Creek, California 94596
(925) 944–5411

DSGN

TDB

DR

AB

CHK

GTH

JOB NO.

6097–03

SUBMITTED BY

RMR

2–GATES FISH PROTECTION
DEMONSTRATION PROJECT

INDEX OF DRAWINGS

DATE 10/02/09

SHEET 2 OF 78

G2

100% SUBMITTAL
REVISION 1

IF SHEET IS LESS THAN 22” x 34”
IT IS A REDUCED PRINT –
SCALE REDUCED ACCORDINGLY.

GENERAL NOTES

1. BATHYMETRY SURVEYED BY ENVIRONMENTAL DATA SOLUTIONS ON JUNE 23, 2008 AND REPRESENTS CONDITIONS ON THAT DATE.
2. KING PILE TYPE (36 INCH OD x 0.75 INCH WT) AND SPACING SHOWN ON THE PLANS WILL BE ADJUSTED ON THE BASIS OF IN-SITU SOIL BORING DATA AS SOON AS THIS INFORMATION BECOMES AVAILABLE.

VERTICAL DATUM

 
PROJECT ELEVATIONS ARE BASED ON NAVD’88.

HORIZONTAL DATUM

PROJECT COORDINATES ARE BASED ON THE CALIFORNIA STATE PLANE COORDINATE SYSTEM NAD 1983, ZONE 3.

DESIGN CONDITIONS

LIVE LOADS: CATWALK: 100 PSF
BOAT RAMP: 5,000 LBS
CONCENTRATED WHEEL LOAD (TOTAL 2 PER AXLE)



WATER ELEVATION: GATES AND SHEET PILES/ KING PILES/ ABUTMENT WALL:
DIFFERENTIAL WATER ELEVATION = 3.6 FT

EARTHQUAKE: QUASI – STATIC LATERAL SEISMIC
ACCELERATION, SA = 0.3g BASED ON 2006 IBC

CURRENT: CURRENT OF 2 KNOTS (3.4 FT/SEC) FREE STREAM VELOCITY

SHIP IMPACT: DOLPHINS/MONOPILES: ACCIDENTAL IMPACT 95 KIP LOAD
AT EL +7.0’

OPERATING LOAD: GATE/ FRAME: HYDRAULIC ACTUATORS (PISTON FORCES)


OLD RIVER SITE $F_1 = +226.2 \text{ KIP}$ $F_2 = -149.2 \text{ KIP}$
 -149.2 KIP $+226.2 \text{ KIP}$
 (COMPRESSION +, TENSION –)

CONNECTION $F_1 = +157.1 \text{ KIP}$ $F_2 = -109.6 \text{ KIP}$
SLOUGH SITE -109.6 KIP $+157.1 \text{ KIP}$
 (COMPRESSION +, TENSION –)

ABBREVIATIONS


&	AND	NAD	NORTH AMERICAN DATUM
#	NUMBER	NAVD	NORTH AMERICAN VERTICAL DATUM
%	PERCENT	NIC	NOT IN CONTRACT
APPROX	APPROXIMATE	NTS	NOT TO SCALE
ASTM	ASTM INTERNATIONAL	OC	ON CENTER
C/C	CENTER TO CENTER	OD	OUTSIDE DIAMETER
CJP	COMPLETE JOINT PENETRATION	OG	ORIGINAL GROUND
CL	CENTER LINE	OPP	OPPOSITE
CIP	CAST-IN-PLACE	PC/PS	PRECAST/PRESTRESSED
CLR	CLEAR	PL	PLATE
CONC	CONCRETE	PJP	PARTIAL JOINT PENETRATION
CONT	CONTINUOUS	PSF	POUNDS PER SQUARE FOOT
DIA, Ø	DIAMETER	REF	REFERENCE
DIMS	DIMENSIONS	REINF	REINFORCEMENT
DWG	DRAWING	SA	SEISMIC ACCELERATION
DWT	DEAD WEIGHT	SCH	SCHEDULE
(E)	EXISTING	SIM	SIMILAR
EL	ELEVATION	SPA	SPACES
EJ	EXPANSION JOINT	STD	STANDARD
EW	EACH WAY	STIF	STIFFENER
FG	FINISH GRADE	SYMM	SYMMETRICAL
FT	FOOT OR FEET	THRU	THROUGH
GALV	GALVANIZED	TYP	TYPICAL
H	HORIZONTAL	UHMW	ULTRA HIGH MOLECULAR WEIGHT
HD	HEAD	UON	UNLESS OTHERWISE NOTED
HDPE	HIGH DENSITY POLYETHYLENE	V	VERTICAL
HW	HIGH WATER	VC	VERTICAL CURVE
IBC	INTERNATIONAL BUILDING CODE	WP	WORK POINT
ID	INSIDE DIAMETER	WT	WALL THICKNESS
INFO	INFORMATION	W/	WITH
LB	POUND		
LW	LOW WATER		
MAX	MAXIMUM		
MFG	MANUFACTURING		
MIN	MINIMUM		

CROSS-REFERENCE LEGEND

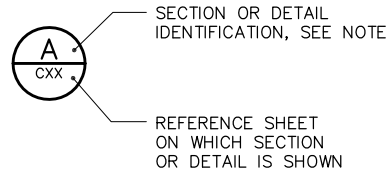

NOTE: LETTER INDICATES SECTION; NUMBER INDICATES DETAIL. WHERE THERE IS NO REFERENCE SHEET INDICATED, IT MEANS THE DETAIL OR SECTION IS TAKEN AND SHOWN ON THE SAME SHEET.

LEGEND

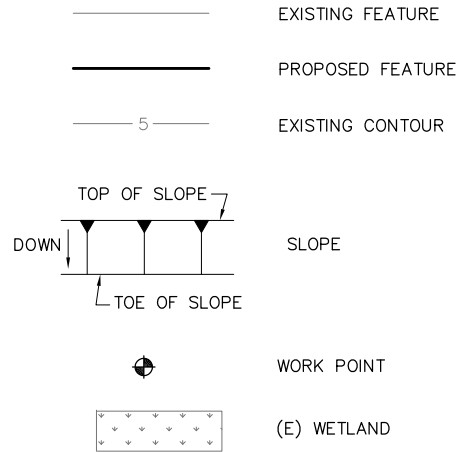

100% SUBMITTAL
REVISION 1

IF SHEET IS LESS THAN 22” x 34”
IT IS A REDUCED PRINT –
SCALE REDUCED ACCORDINGLY.

P:\6097-03 SWC GATE DESIGN\CADD\DWG\609703-C3.DWG 10/1/2009 10:14 AM

REVISION	DESCRIPTION	BY	DATE



San Luis & Delta–Mendota Water Authority
842 6th Street, Suite 7
PO Box 2157
Los Banos, California 93635



2001 N. Main Street, Suite 360
Walnut Creek, California 94596
(925) 944–5411

DSGN	TDB	DR	AB	CHK	GTH
JOB NO.	6097–03	SUBMITTED BY	RMR		

2–GATES FISH PROTECTION
DEMONSTRATION PROJECT

DATE 10/02/09

SHEET 3 OF 78

 
ABBREVIATIONS, LEGEND AND
GENERAL NOTES

G3

P:\6097-03 SWC GATE DESIGN\CADD\DWG\609703-G4.DWG 9/28/2009 11:00 AM



PROJECT GENERAL PLAN
SCALE: 1"= 1000'



100% SUBMITTAL
REVISION 1

IF SHEET IS LESS THAN 22" x 34"
IT IS A REDUCED PRINT -
SCALE REDUCED ACCORDINGLY.

REVISION	DESCRIPTION	BY	DATE



San Luis & Delta-Mendota Water Authority
842 6th Street, Suite 7
PO Box 2157
Los Banos, California 93635



2001 N. Main Street, Suite 360
Walnut Creek, California 94596
(925) 944-5411

DSGN	TDB	DR	EP	CHK	GTH
JOB NO.	6097-03	SUBMITTED BY RMR			

2-GATES FISH PROTECTION
DEMONSTRATION PROJECT

DATE 10/02/09

SHEET 4 OF 78

PROJECT GENERAL PLAN

G4

P:\6097-03 SWC GATE DESIGN\CADD\DWG\609703-C1.DWG 10/1/2009 9:15 AM

HOLLAND TRACT

M.H. CLEMENTS CORPORATION PROPERTY

NO ACCESS PERMITTED

WP 3

RIVER SHEET PILE WALL, TYP

SECURITY GATE

LEVEE SHEET PILE WALL
SEE NOTE

CATWALK

END WALL, TYP

APPROX LIMIT
OF ROCK FILL

MONOPILE, TYP
SEE DWG C26

SUBMERGED
SHEET PILE
ENCLOSURE

WP 1

FLOOD
EBB

OLD RIVER

NOMINAL
CHANNEL OPENING

75' NOMINAL
CHANNEL
OPENING

OPERATOR
HOUSE

WP 2

CATWALK

GATE: OPEN POSITION

BARGE

GATE:
CLOSED POSITION

SECURITY GATE

FENCE AND
VEHICLE GATE

BOARDING
FLOAT, TYP

PILE SUPPORTED
BOAT RAMP, TYP

WP 4

APPOX LIMIT OF CLEARING &
GRUBBING AS NECESSARY FOR
CONSTRUCTION OPERATIONS

LAYDOWN AND CONSTRUCTION
SUPPORT AREA (600' X 96.5')

LEVEE SHEET PILE WALL

APPROX
TOE OF LEVEE

BACON ISLAND

UTILITY YARD (50' X 50')
CONTRACTOR TO LOCATE
PER (E) ACCESS ROAD

SECURITY FENCE

(E) ACCESS
ROAD
(PROVIDE 12"
AGGREGATE
BASE)

WORK POINT DATA

WORK POINT	NORTHING	EASTING	FEATURE
1	2183496.04	6250058.83	CL OF WEST EDGE OF BARGE
2	2183465.50	6250256.48	CL OF EAST EDGE OF BARGE
3	2183549.08	6249715.65	WEST LEVEE AND CL OF GATE
4	2183415.60	6250579.41	EAST LEVEE AND CL OF GATE

100% SUBMITTAL
REVISION 1

IF SHEET IS LESS THAN 22" x 34"
IT IS A REDUCED PRINT -
SCALE REDUCED ACCORDINGLY.

NOTE:

LEVEE SHEET PILE WALL ON HOLLAND TRACK
SHALL BE DRIVEN FROM THE WATER ONLY.
NO LANDSIDE ACCESS SHALL BE PROVIDED.

SITE PLAN

SCALE: 1"= 50'



SCALE: 1"=50'

REVISION	DESCRIPTION	BY	DATE



San Luis & Delta-Mendota Water Authority
842 6th Street, Suite 7
PO Box 2157
Los Banos, California 93635



2001 N. Main Street, Suite 360
Walnut Creek, California 94596
(925) 944-5411

DSGN	TDB	DR	EP/AB	CHK	GTH
JOB NO.	6097-03	SUBMITTED BY	RMR		

2-GATES FISH PROTECTION
DEMONSTRATION PROJECT



DATE 10/02/09

SHEET 5 OF 78


OLD RIVER
SITE PLAN

C1

P:\6097-03 SWC GATE DESIGN\CADD\DWG\609703-C2.DWG 10/1/2009 2:37 PM

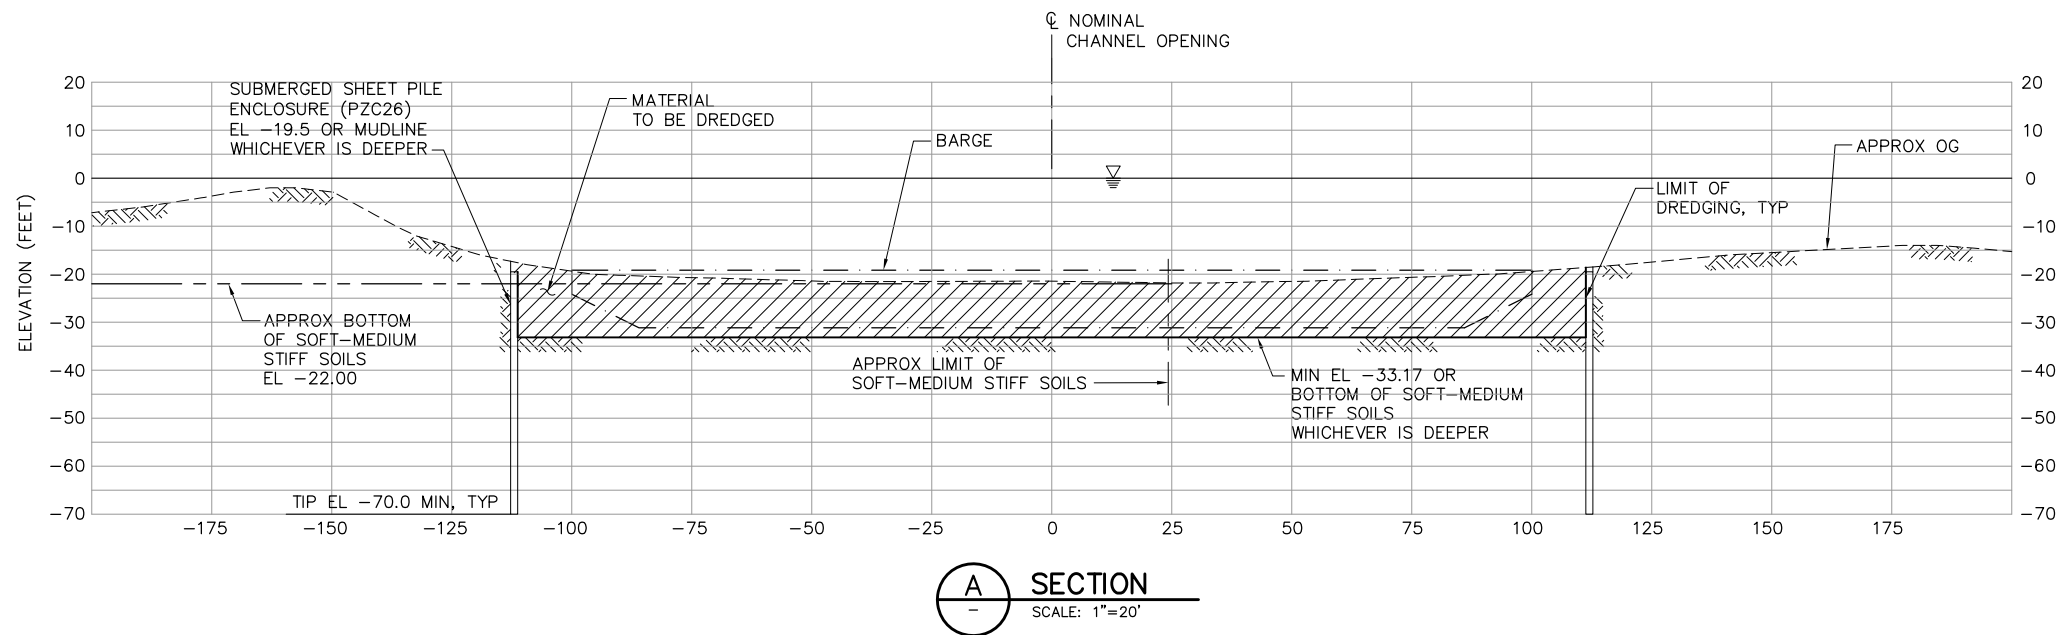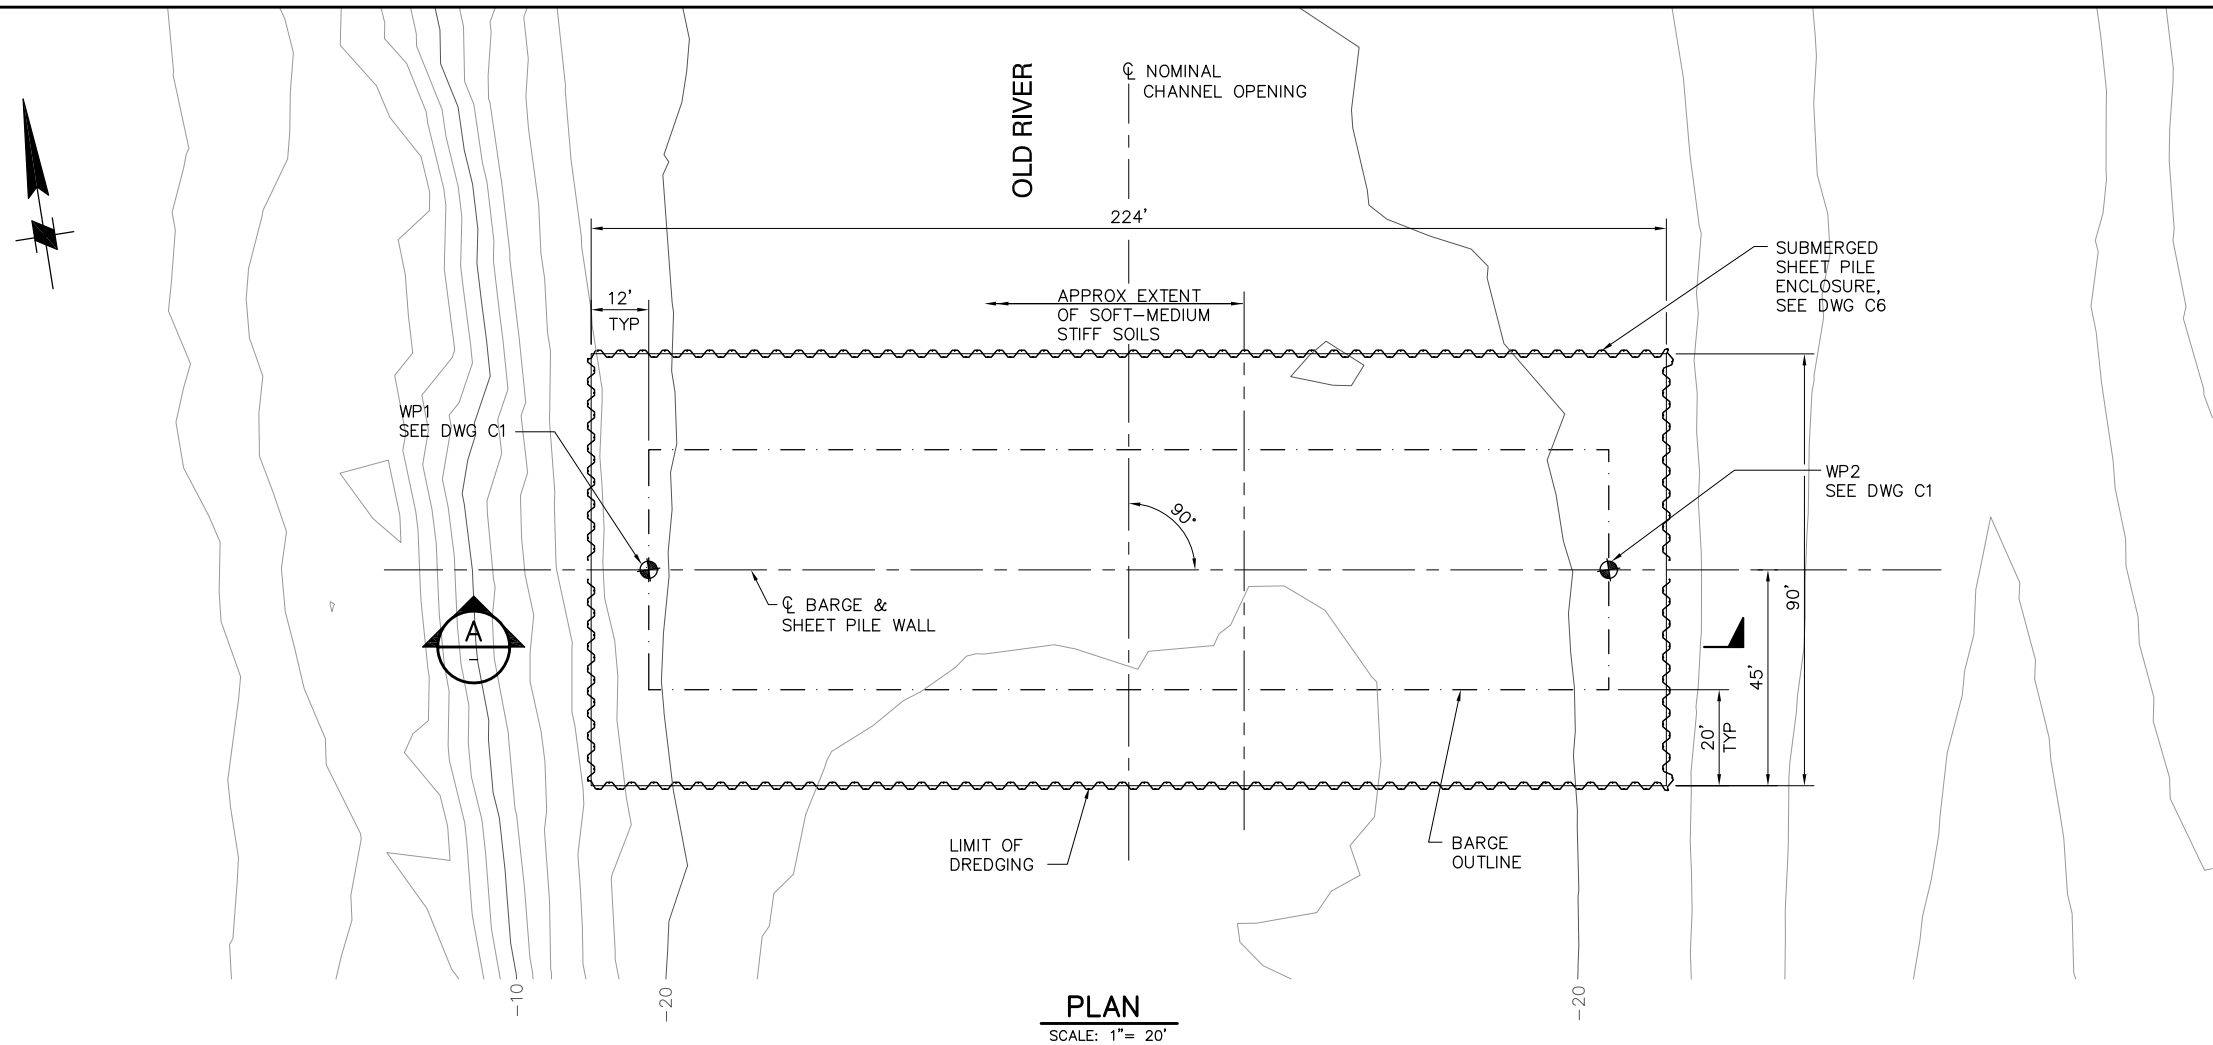

 NOTE:
GATE AND ALL OTHER FEATURES
NOT SHOWN FOR CLARITY.



**100% SUBMITTAL
REVISION 1**

IF SHEET IS LESS THAN 22" x 34"
IT IS A REDUCED PRINT -
SCALE REDUCED ACCORDINGLY.

REVISION	DESCRIPTION	BY	DATE



San Luis & Delta-Mendota Water Authority
842 6th Street, Suite 7
PO Box 2157
Los Banos, California 93635







2001 N. Main Street, Suite 360
Walnut Creek, California 94596
(925) 944-5411

DSGN	TDB	DR	AB	CHK	GTH
JOB NO. 6097-03		SUBMITTED BY RMR			

2-GATES FISH PROTECTION DEMONSTRATION PROJECT	DATE 10/02/09
	SHEET 6 OF 78
OLD RIVER DREDGING PLAN AND SECTION	C2

 P:\6097-03 SWC GATE DESIGN\CADD\DWG\609703-C3.DWG 10/1/2009 10:15 AM

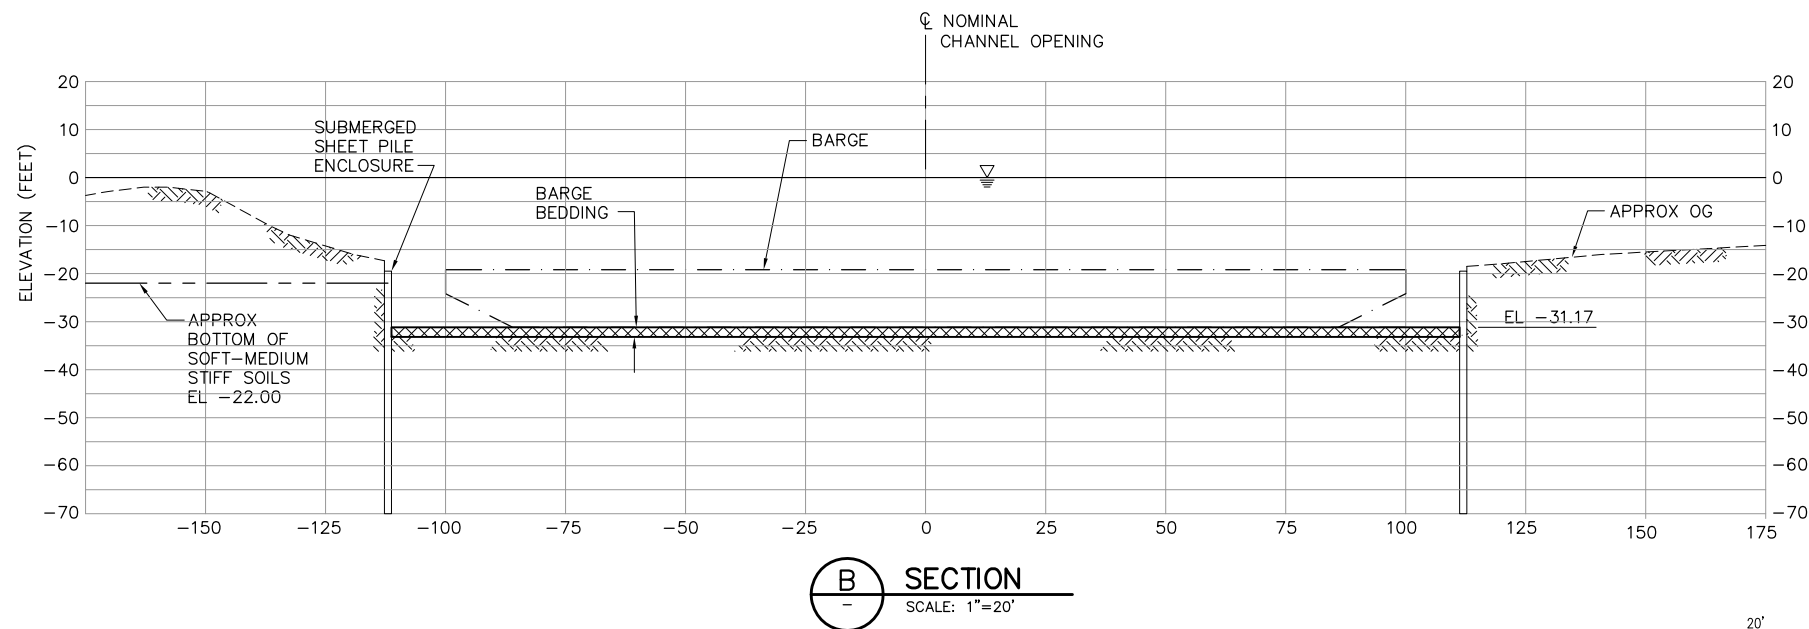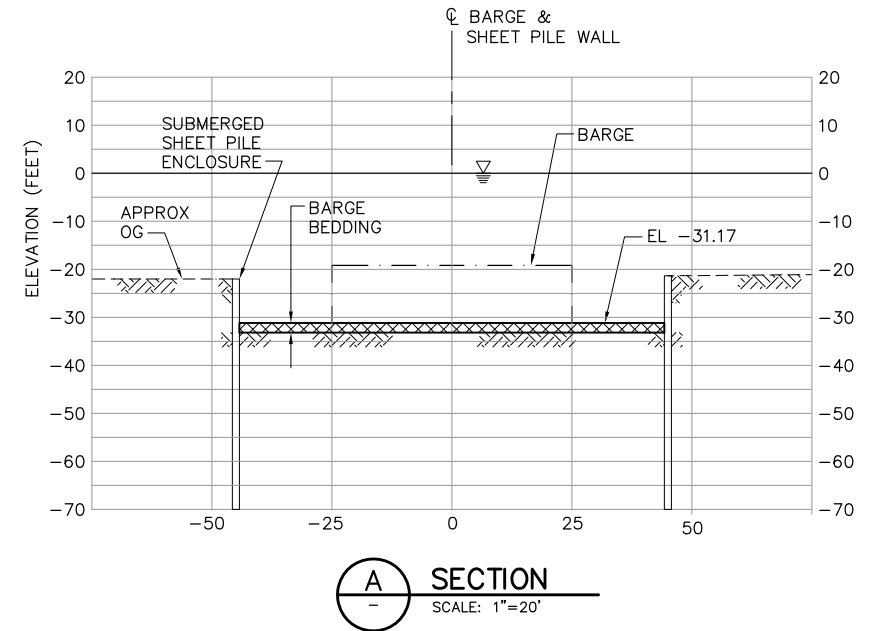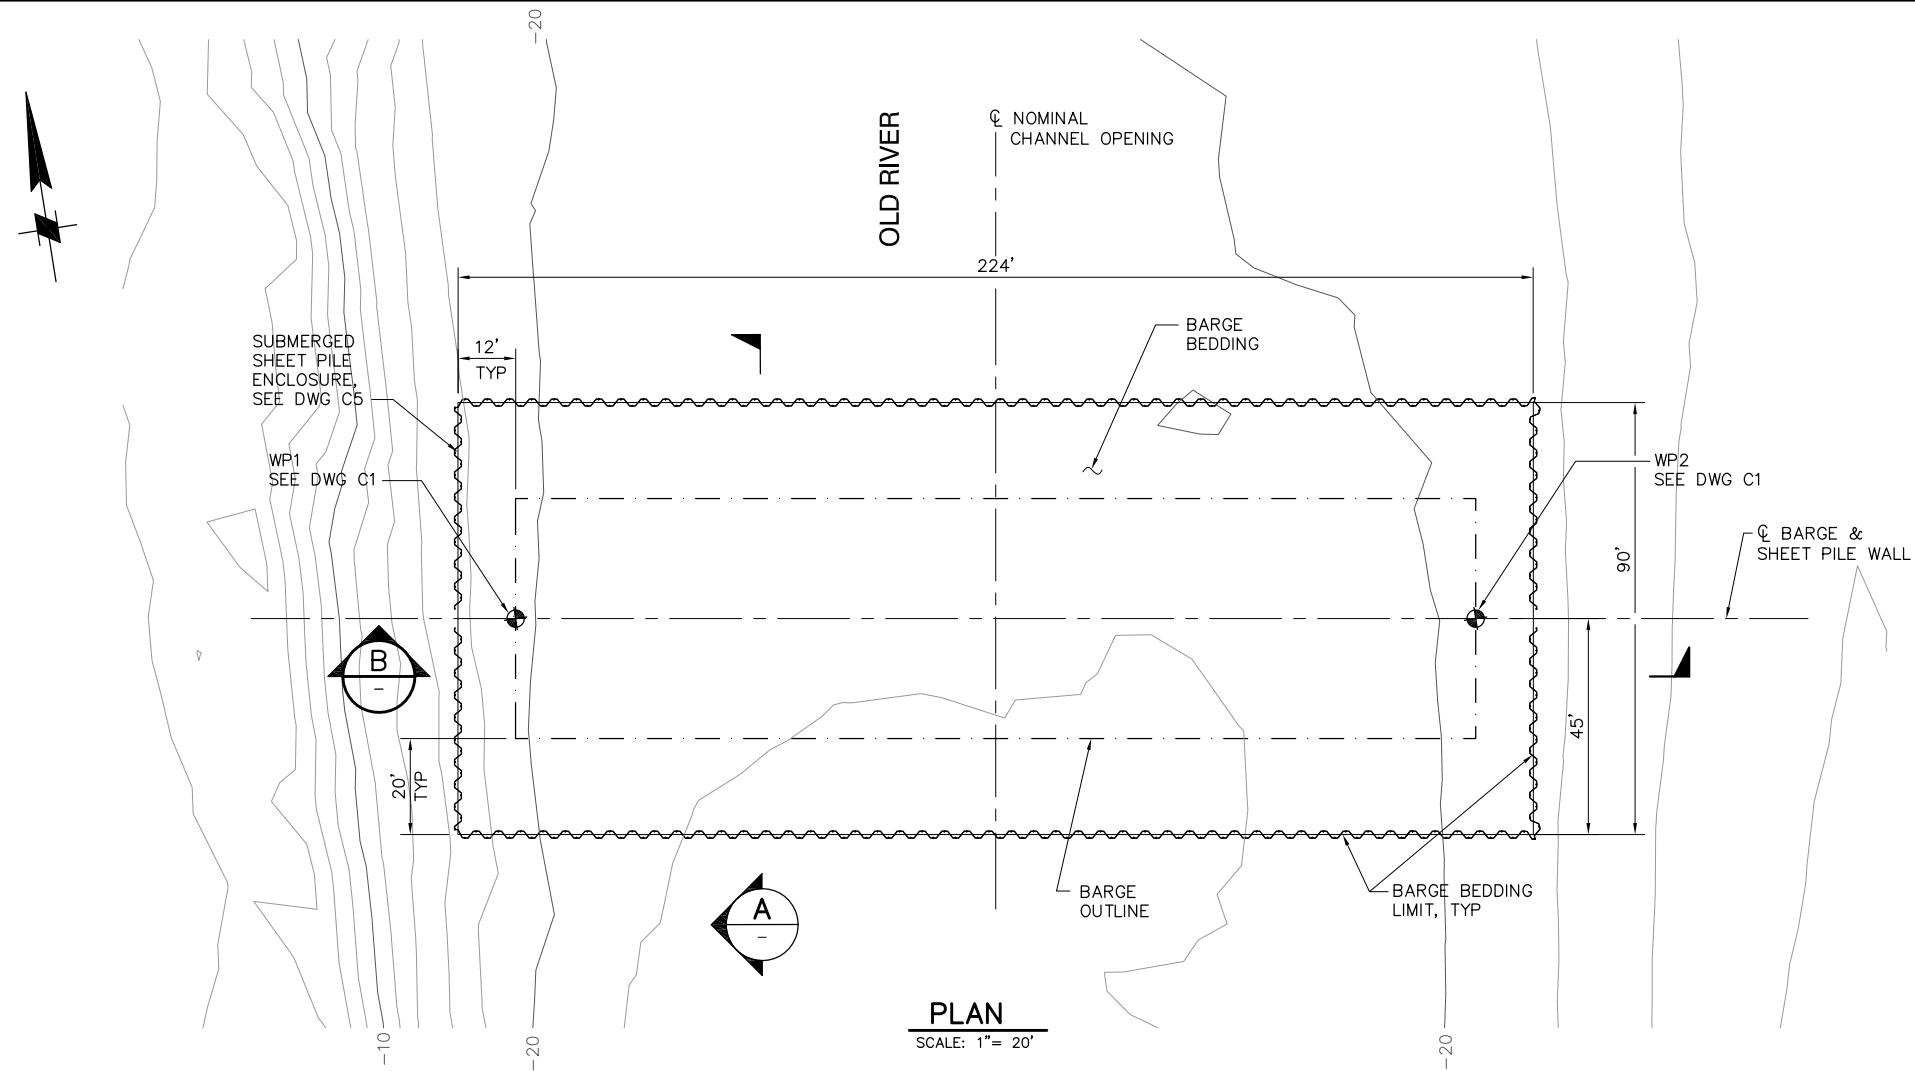


NOTE:
GATE AND ALL OTHER FEATURES
NOT SHOWN FOR CLARITY.

100% SUBMITTAL
REVISION 1

IF SHEET IS LESS THAN 22" x 34"
IT IS A REDUCED PRINT -
SCALE REDUCED ACCORDINGLY.

REVISION	DESCRIPTION	BY	DATE

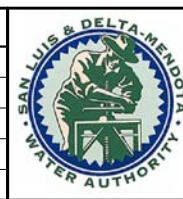

San Luis & Delta-Mendota Water Authority
842 6th Street, Suite 7
PO Box 2157
Los Banos, California 93635





2001 N. Main Street, Suite 360
Walnut Creek, California 94596
(925) 944-5411

DSGN	TDB	DR	AB	CHK	GTH
JOB NO.	6097-03	SUBMITTED BY	RMR		


2-GATES FISH PROTECTION DEMONSTRATION PROJECT OLD RIVER BARGE BEDDING PLAN AND SECTIONS	DATE 10/02/09
	SHEET 7 OF 78
C3	

P:\6097-03 SWC GATE DESIGN\CADD\DWG\609703-C4.DWG 10/1/2009 10:19 AM

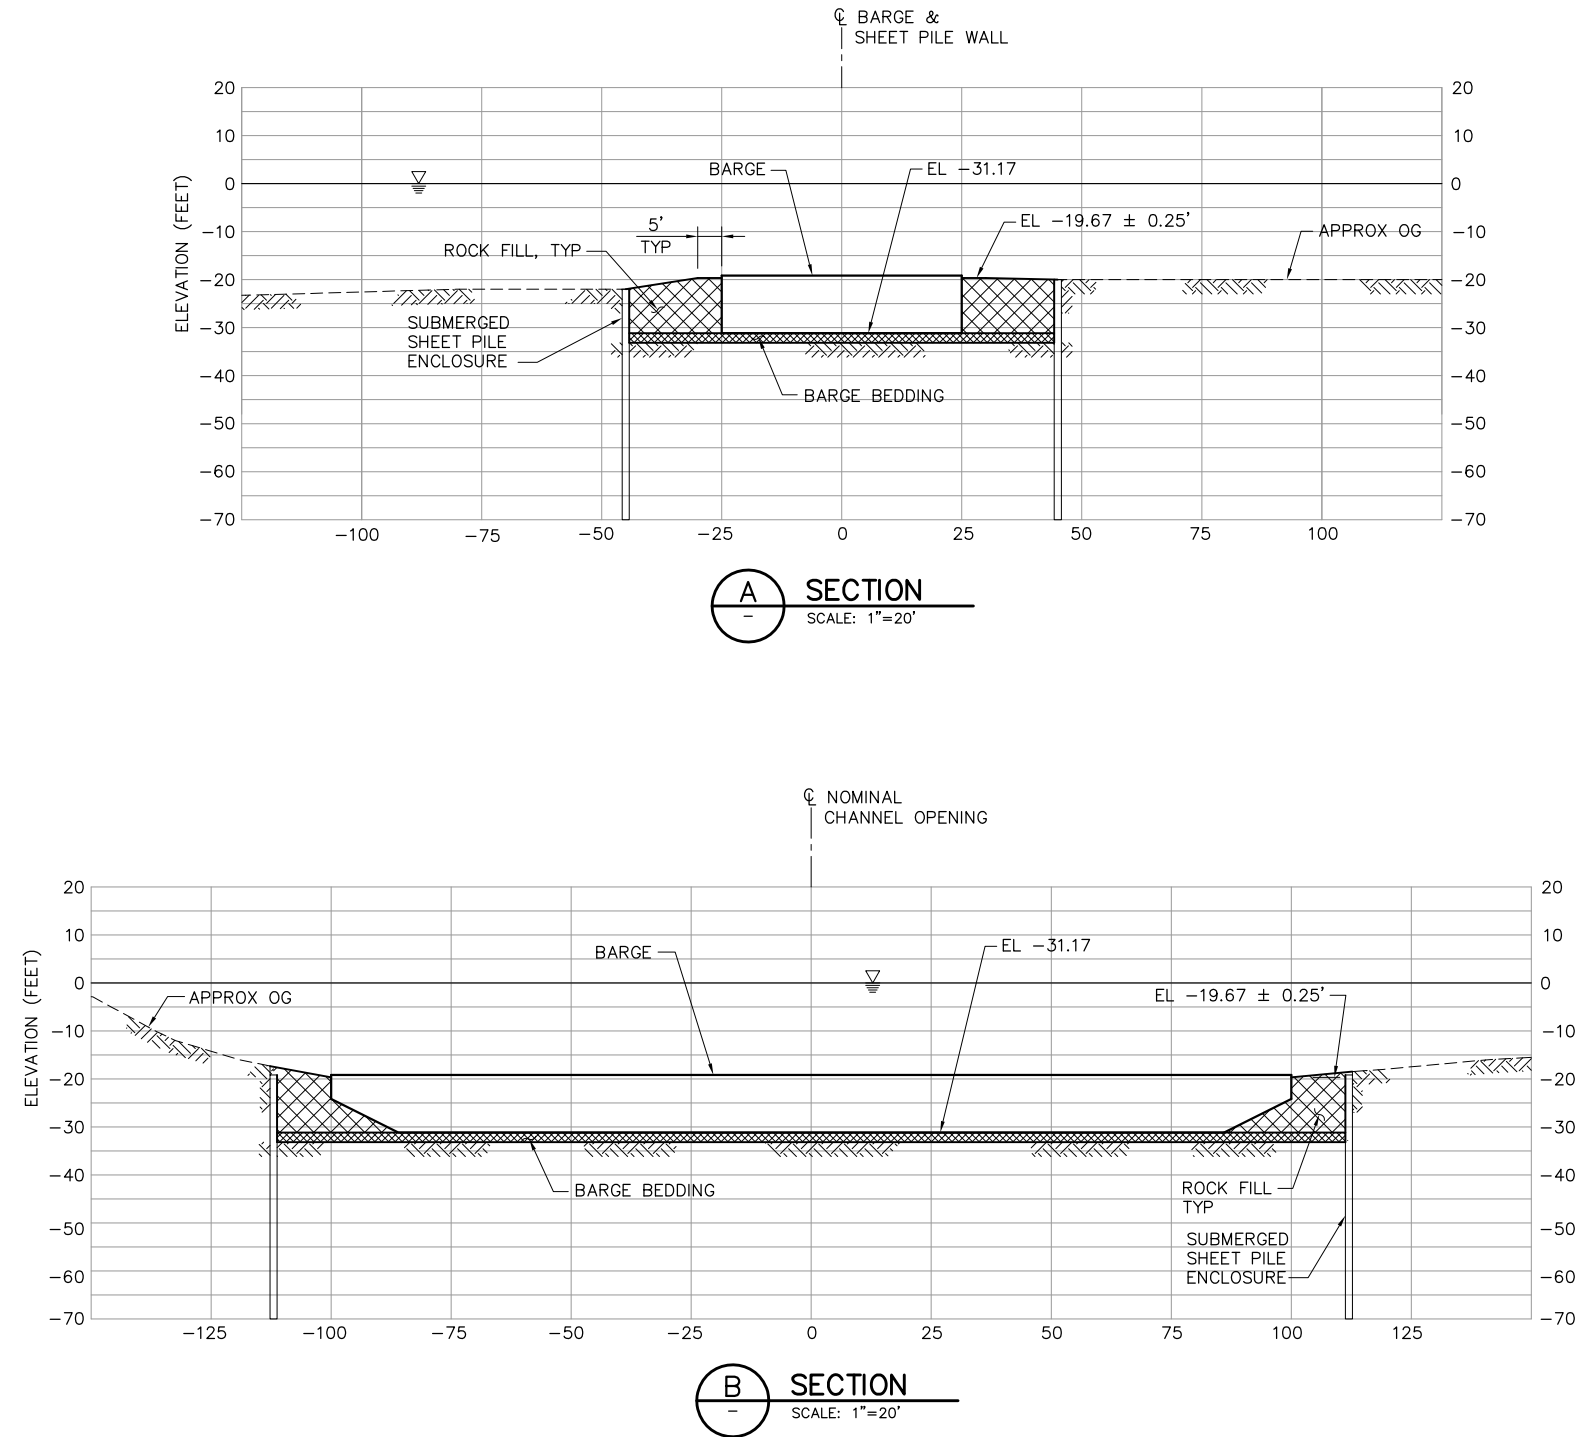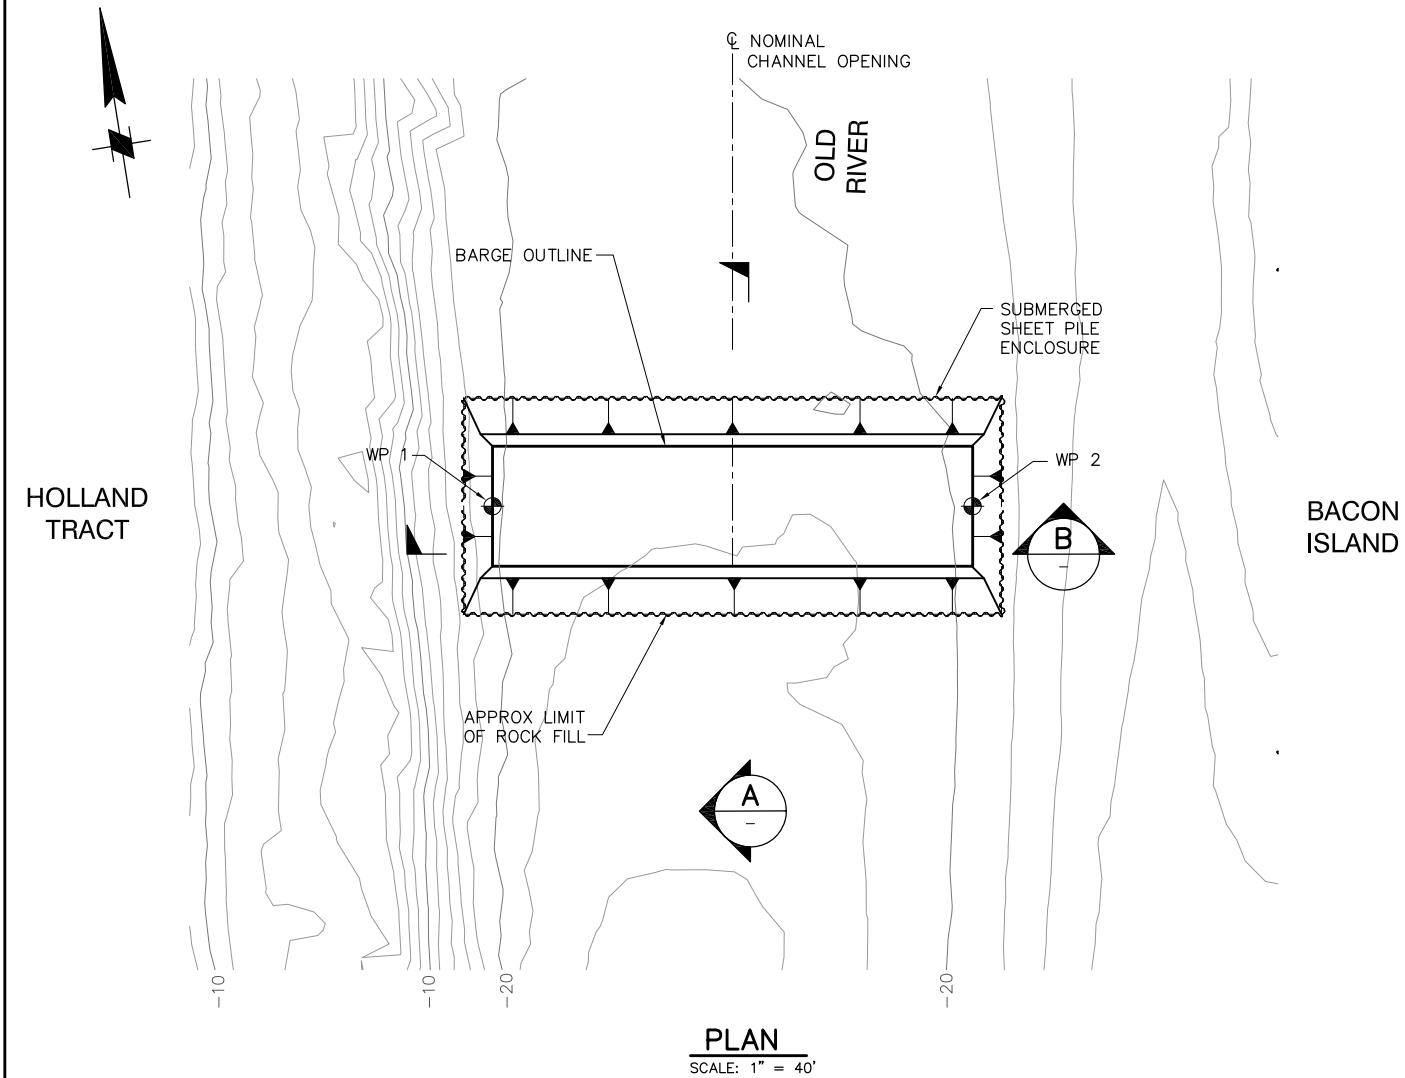

NOTES:

 
1. KING PILES AND SHEET PILES NEAR BARGE SHALL BE PLACED BEFORE ROCK LOCKING FILL.
2. GATE AND ALL OTHER FEATURES NOT SHOWN FOR CLARITY



100% SUBMITTAL
REVISION 1

IF SHEET IS LESS THAN 22" x 34"
IT IS A REDUCED PRINT -
SCALE REDUCED ACCORDINGLY.

REVISION	DESCRIPTION	BY	DATE

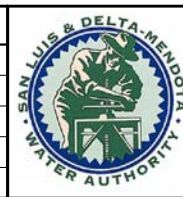

San Luis & Delta-Mendota Water Authority
842 6th Street, Suite 7
PO Box 2157
Los Banos, California 93635



2001 N. Main Street, Suite 360
Walnut Creek, California 94596
(925) 944-5411

DSGN	JMB	DR	EP/AB	CHK	TDB
JOB NO.	6097-03	SUBMITTED BY	RMR		

2-GATES FISH PROTECTION
DEMONSTRATION PROJECT


DATE 10/02/09

SHEET 8 OF 78

OLD RIVER
BARGE - ROCK FILL
PLAN AND SECTIONS


C4

P:\6097-03 SWC GATE DESIGN\CADD\DWG\609703-C5.DWG 10/1/2009 2:32 PM

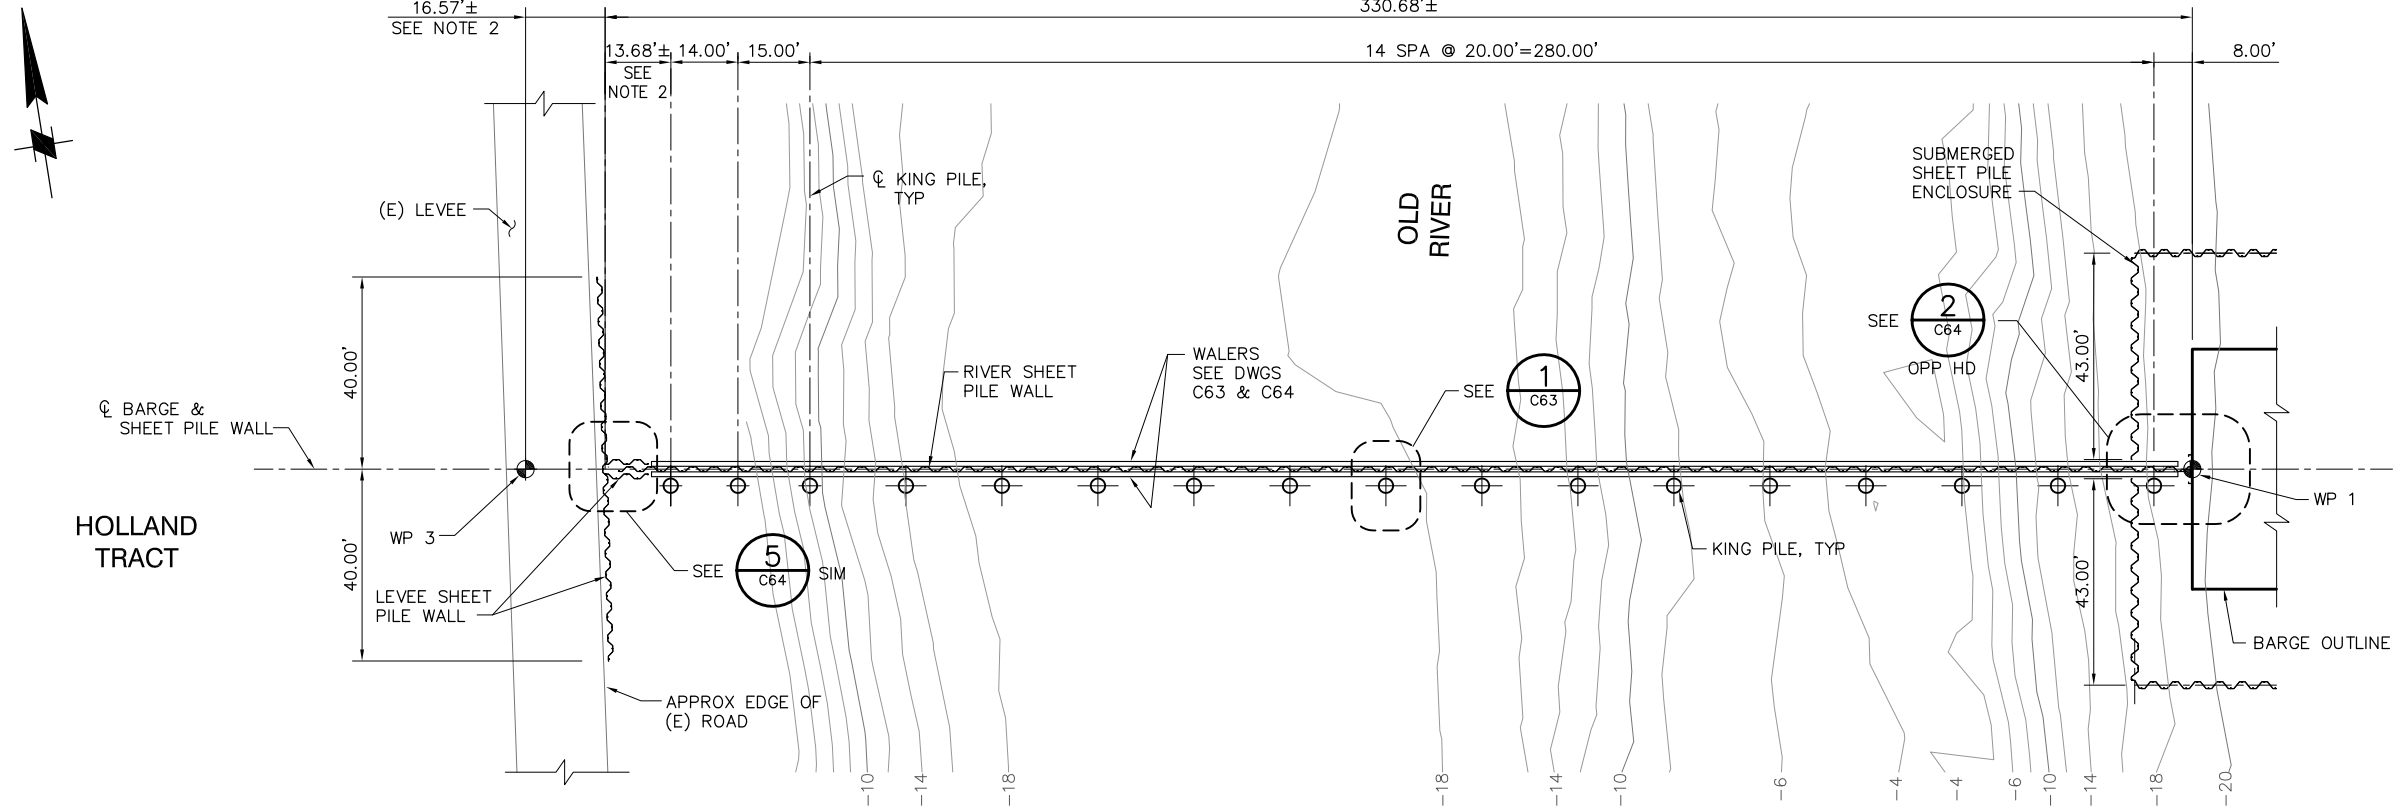


PLAN
SCALE: 1"= 20'

NOTE:
CATWALK NOT SHOWN
FOR CLARITY.

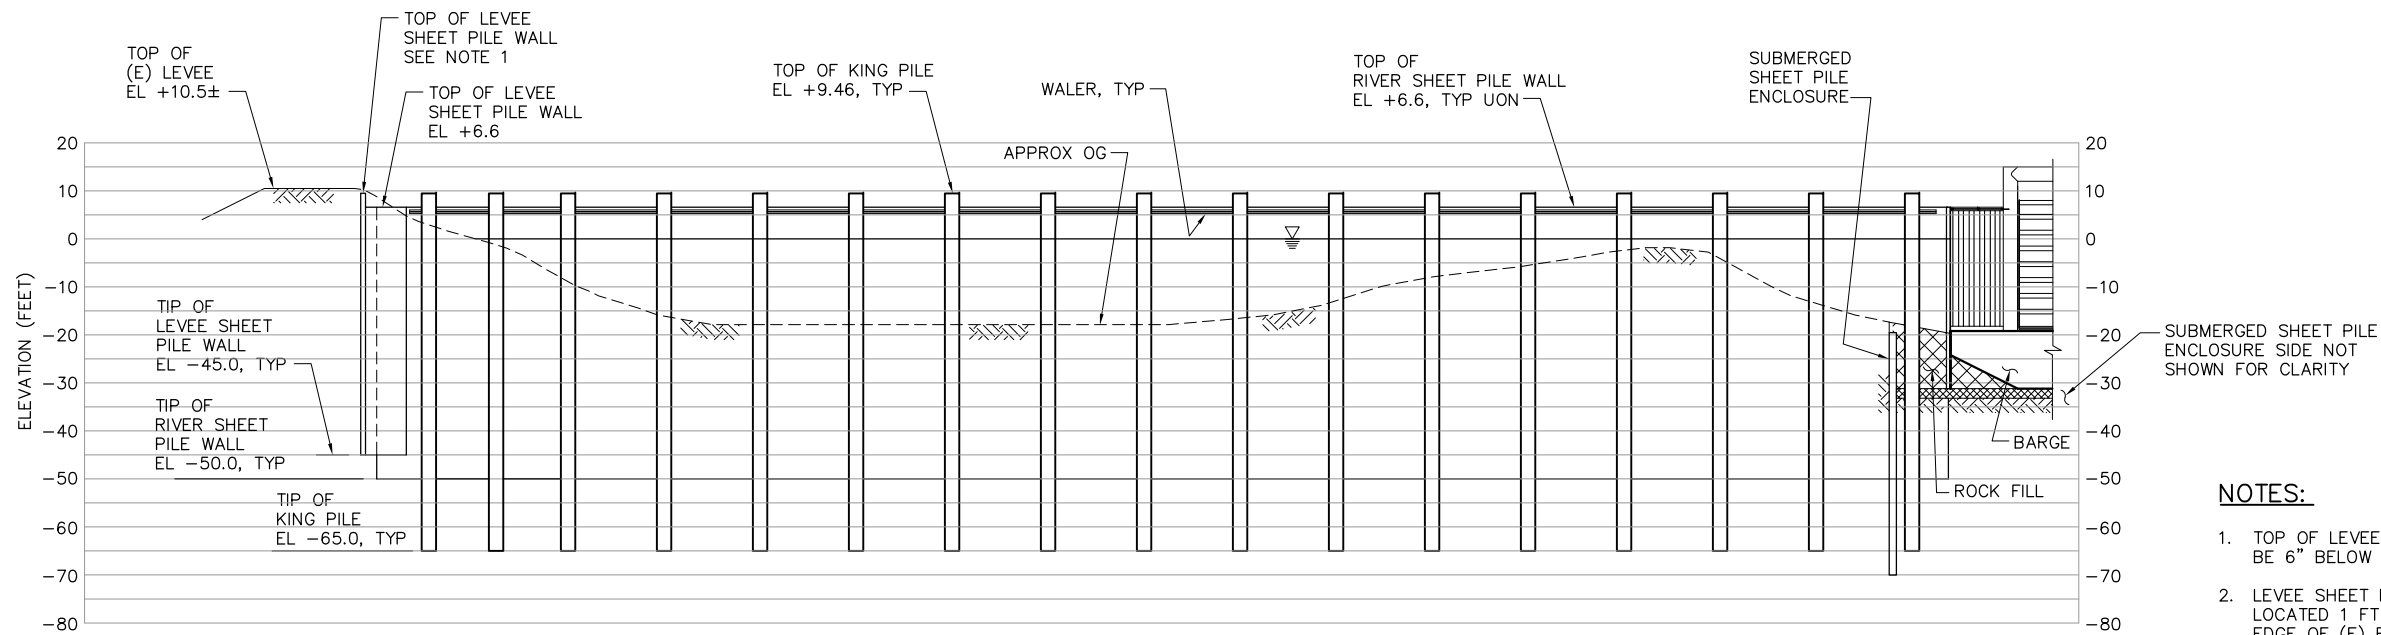

ELEVATION
SCALE: 1"= 20'

 NOTE:
CATWALK NOT SHOWN
FOR CLARITY.




100% SUBMITTAL
REVISION 1

IF SHEET IS LESS THAN 22" x 34"
IT IS A REDUCED PRINT -
SCALE REDUCED ACCORDINGLY.

NOTES:

1. TOP OF LEVEE SHEET PILE WALL SHALL BE 6" BELOW TOP OF (E) LEVEE UON.
2. LEVEE SHEET PILE WALL TO BE LOCATED 1 FT MIN CLEAR OFF THE EDGE OF (E) ROAD SURFACE AND THE CLEMENTS PROPERTY LINE.

REVISION	DESCRIPTION	BY	DATE

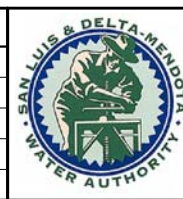

San Luis & Delta-Mendota Water Authority
842 6th Street, Suite 7
PO Box 2157
Los Banos, California 93635



2001 N. Main Street, Suite 360
Walnut Creek, California 94596
(925) 944-5411

DSGN	JMB	DR	EP/AB	CHK	TDB
JOB NO.	6097-03	SUBMITTED BY	RMR		



2-GATES FISH PROTECTION
DEMONSTRATION PROJECT

OLD RIVER
SHEET PILE WALL ARRANGEMENT
PLAN AND ELEVATION, SHEET 1


DATE 10/02/09

SHEET 9 OF 78

C5

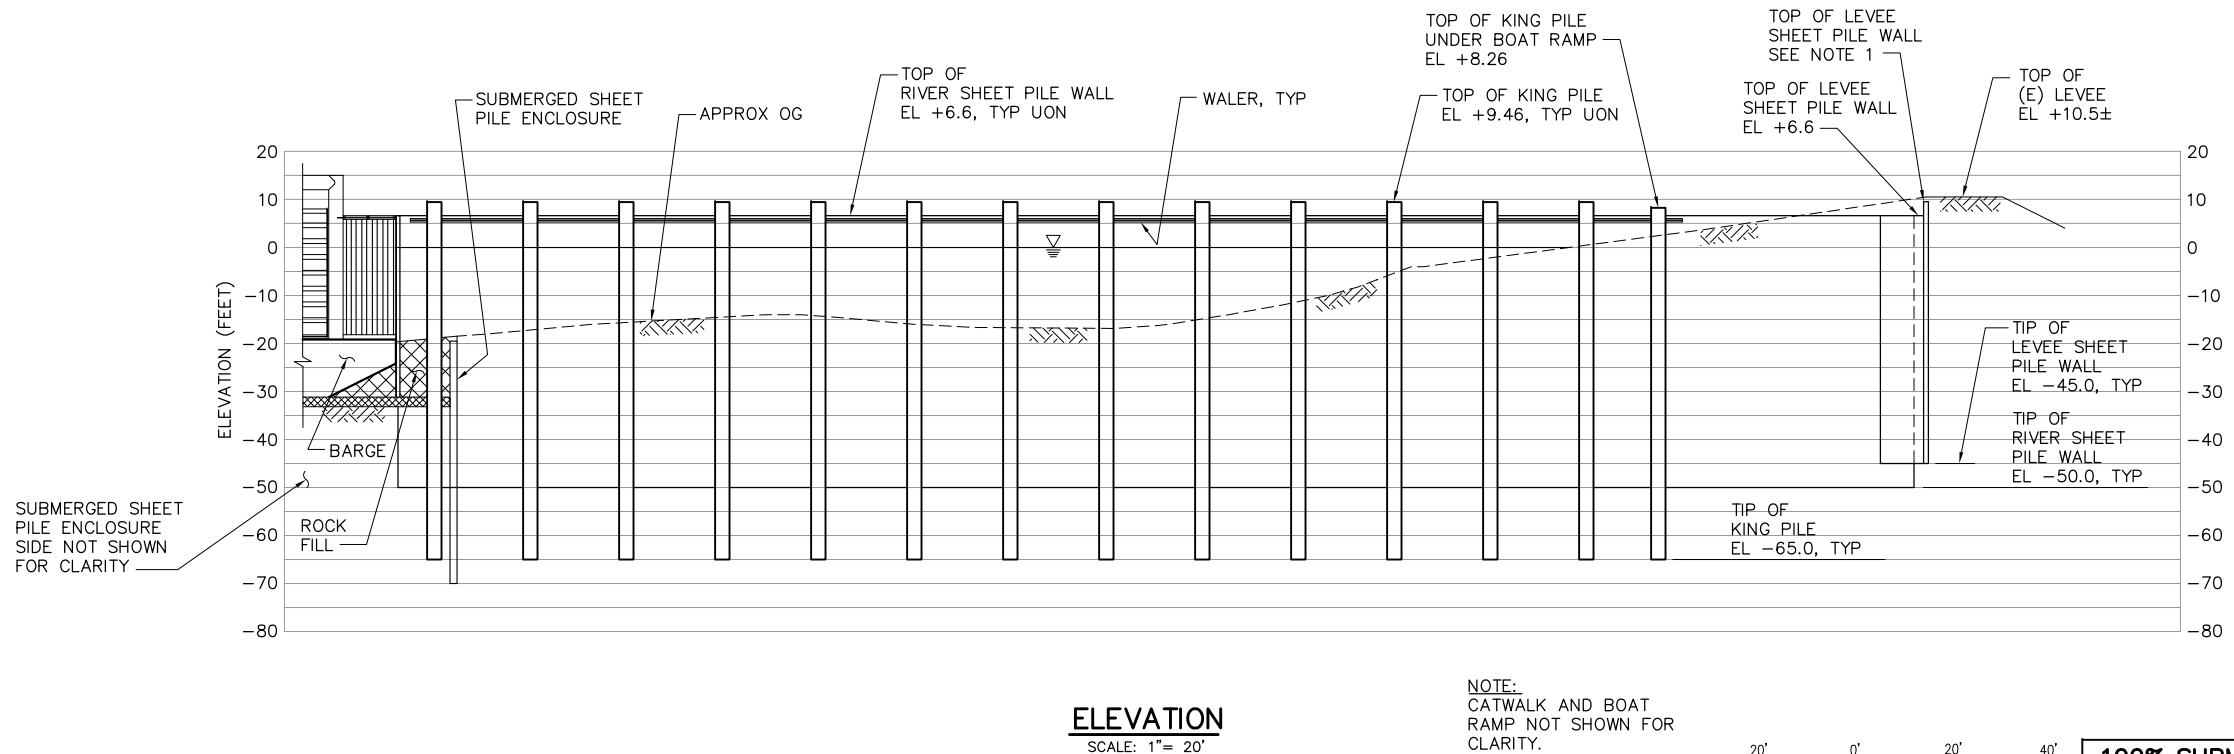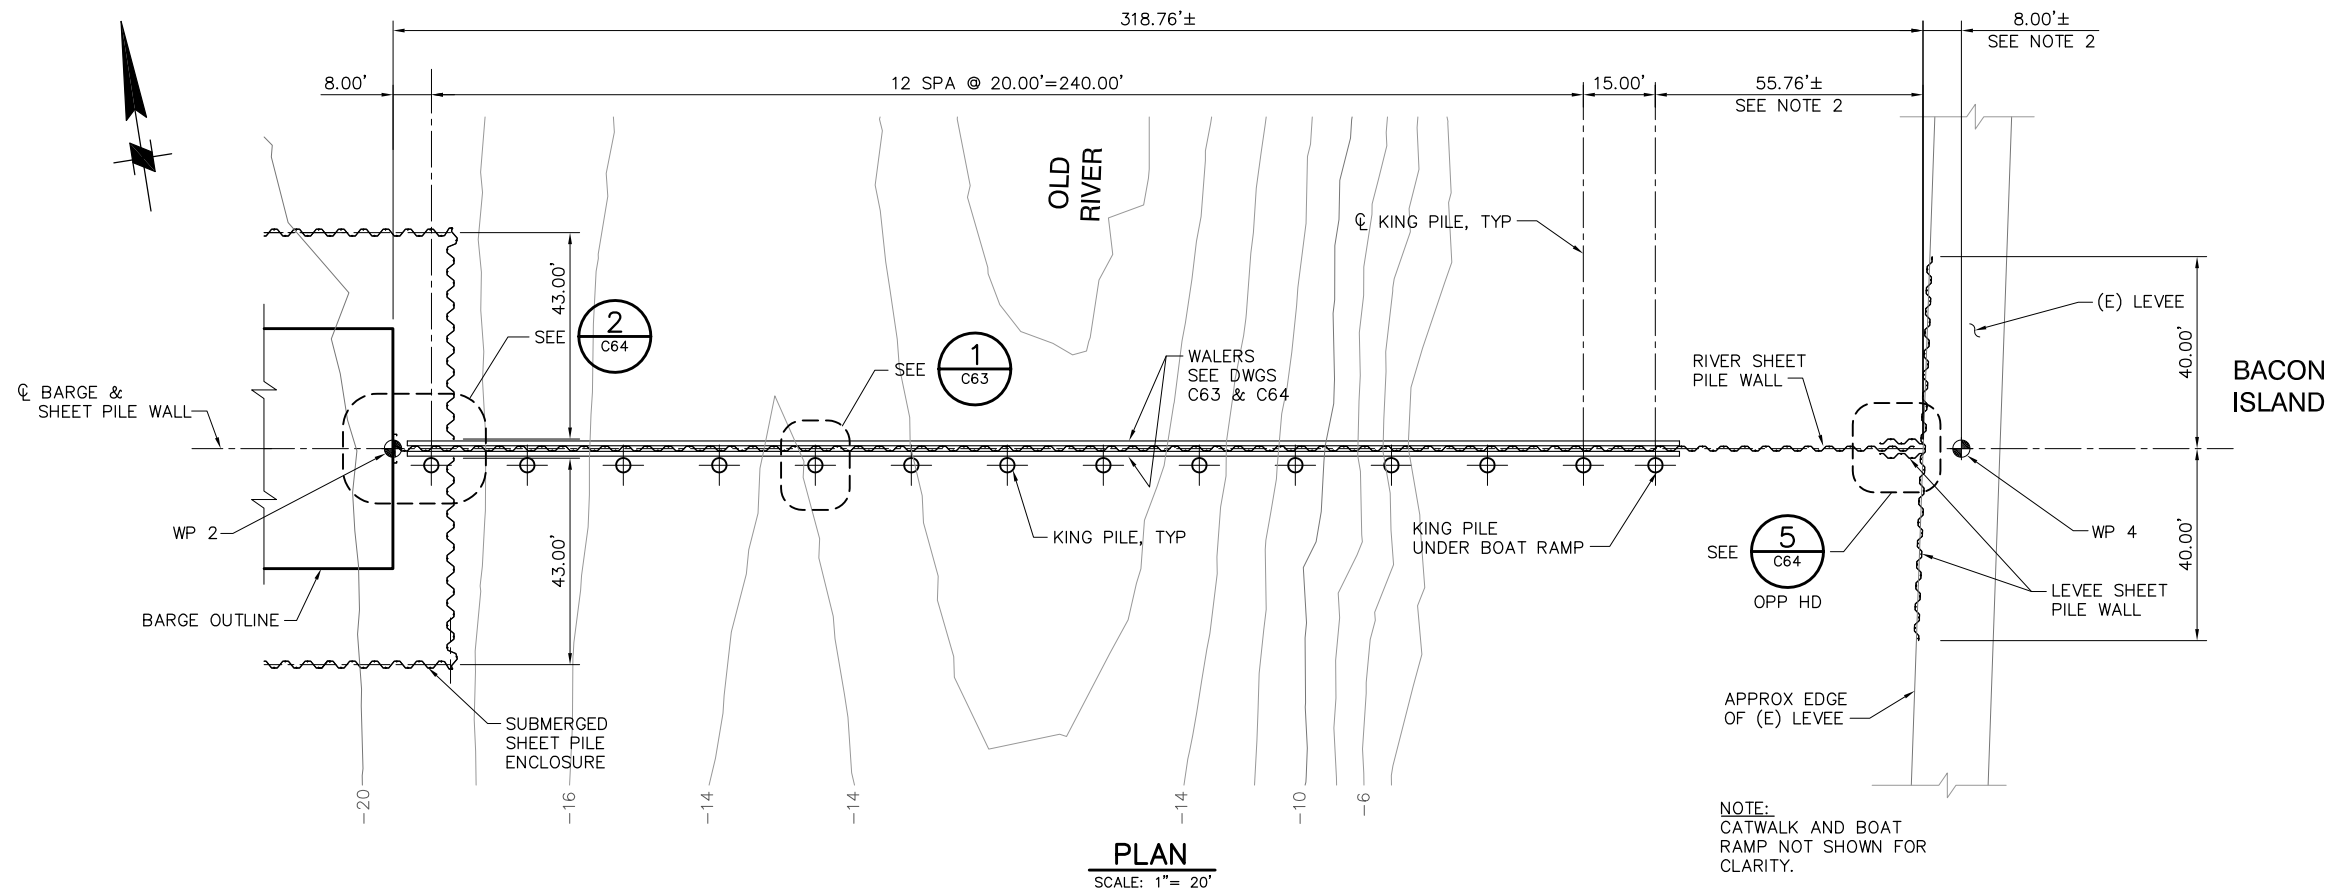

 NOTE:
CATWALK AND BOAT
RAMP NOT SHOWN FOR
CLARITY.



**100% SUBMITTAL
REVISION 1**


NOTES:

1. TOP OF LEVEE SHEET PILE WALL SHALL BE 6" BELOW TOP OF (E) LEVEE UON.
2. LEVEE SHEET PILE WALL TO BE LOCATED 1 FT MIN OFF THE EDGE OF (E) ROAD SURFACE.

IF SHEET IS LESS THAN 22" x 34"
IT IS A REDUCED PRINT -
SCALE REDUCED ACCORDINGLY.

P:\6097-03 SWC GATE DESIGN\CADD\DWG\609703-C6.DWG 9/30/2009 4:43 PM

REVISION	DESCRIPTION	BY	DATE

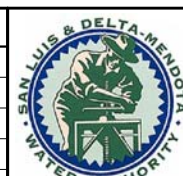

San Luis & Delta-Mendota Water Authority
842 6th Street, Suite 7
PO Box 2157
Los Banos, California 93635



2001 N. Main Street, Suite 360
Walnut Creek, California 94596
(925) 944-5411

DSGN	JMB	DR	EP/AB	CHK	TDB
JOB NO.	6097-03	SUBMITTED BY	RMR		

**2-GATES FISH PROTECTION
DEMONSTRATION PROJECT**



**OLD RIVER
SHEET PILE WALL ARRANGEMENT
PLAN AND ELEVATION, SHEET 2**

DATE 10/02/09

SHEET 10 OF 78


C6

P:\6097-03 SWC GATE DESIGN\CADD\DWG\609703-C7.DWG 9/30/2009 4:43 PM

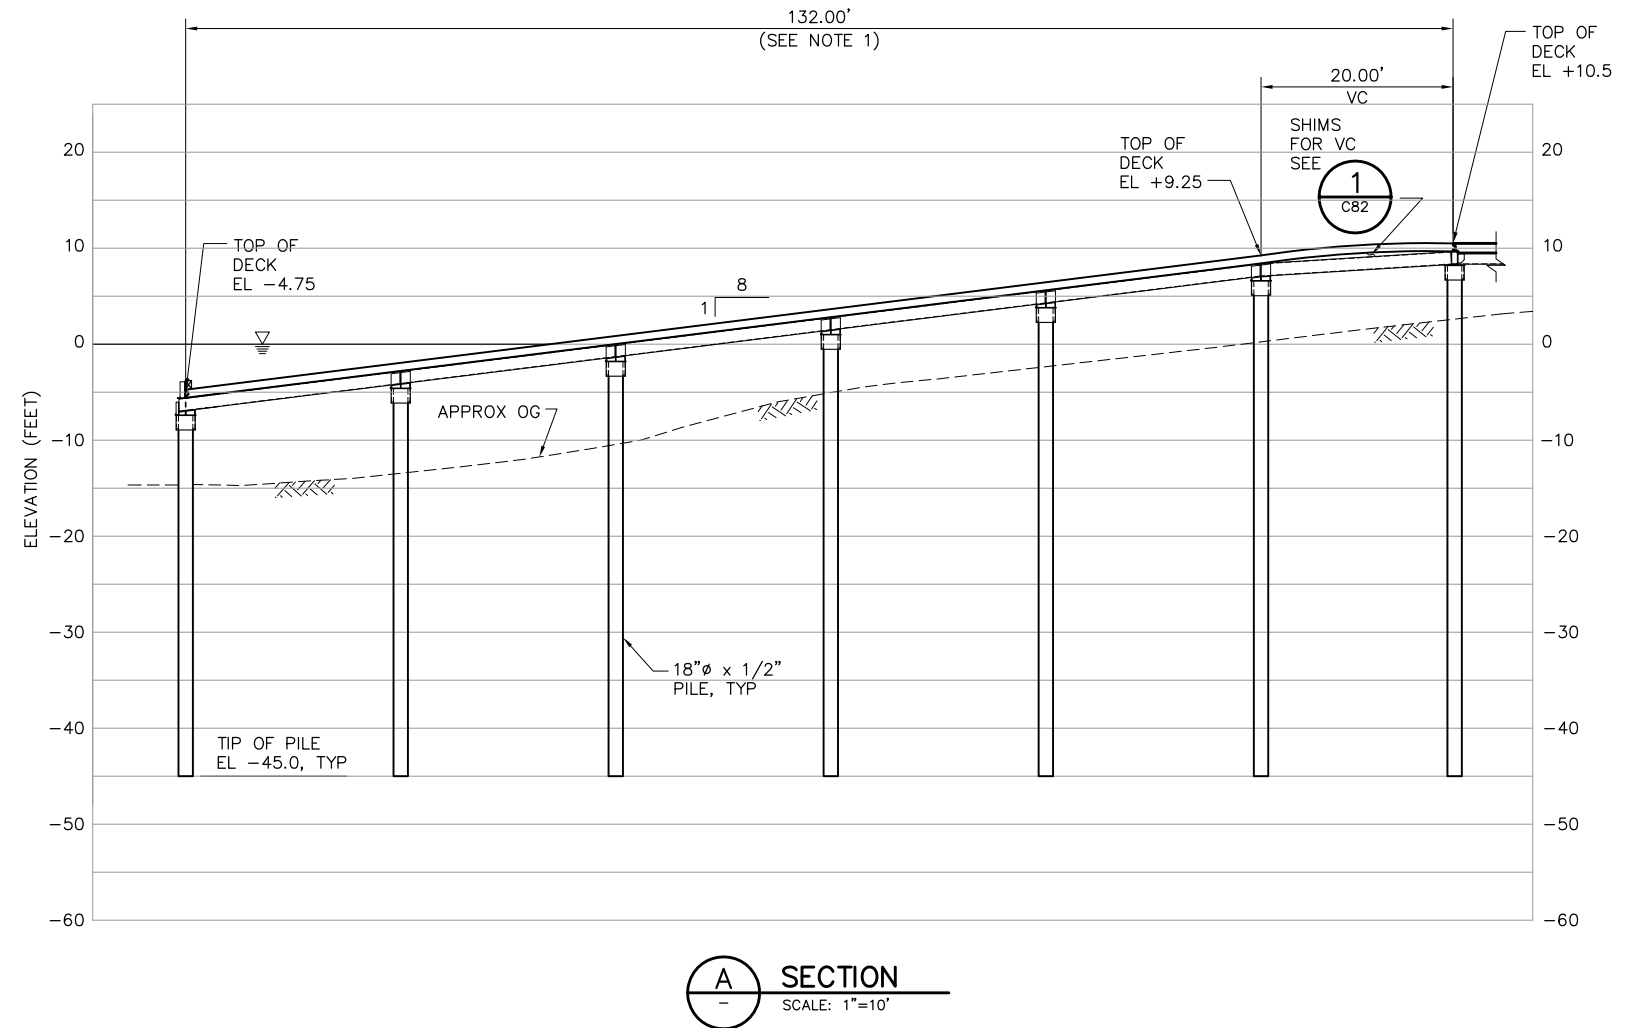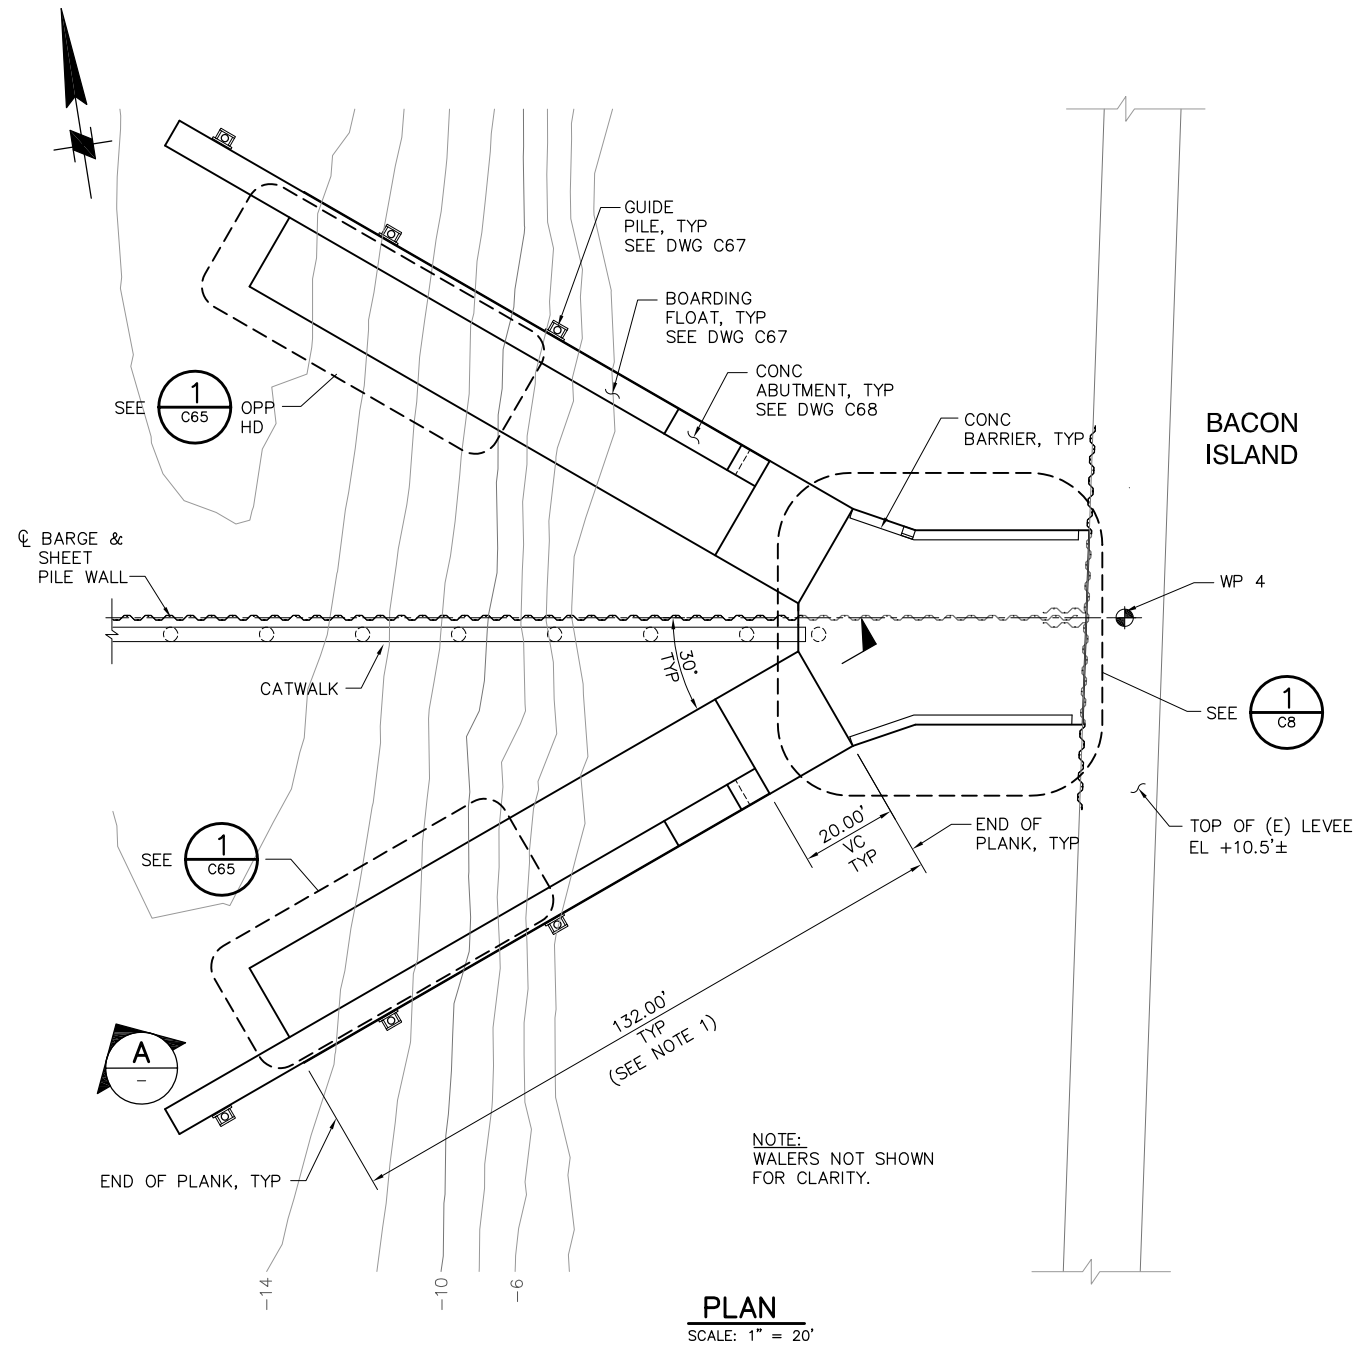

NOTES:

1. TRUE LENGTH OF RAMP ACCOUNTS FOR AN AVERAGE GAP OF 3/8" PER PLANK JOINT.

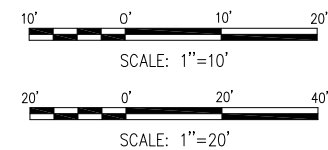

100% SUBMITTAL
REVISION 1

IF SHEET IS LESS THAN 22" x 34"
IT IS A REDUCED PRINT -
SCALE REDUCED ACCORDINGLY.

REVISION	DESCRIPTION	BY	DATE



San Luis & Delta-Mendota Water Authority
842 6th Street, Suite 7
PO Box 2157
Los Banos, California 93635



2001 N. Main Street, Suite 360
Walnut Creek, California 94596
(925) 944-5411

DSGN	JMB	DR	EP/AB	CHK	TDB
JOB NO.	6097-03	SUBMITTED BY	RMR		

2-GATES FISH PROTECTION
DEMONSTRATION PROJECT

 

OLD RIVER
BOAT RAMP PLAN AND SECTION

DATE 10/02/09

SHEET 11 OF 78

C7

P:\6097-03 SWC GATE DESIGN\CADD\DWG\609703-C7.1.DWG 9/30/2009 4:47 PM

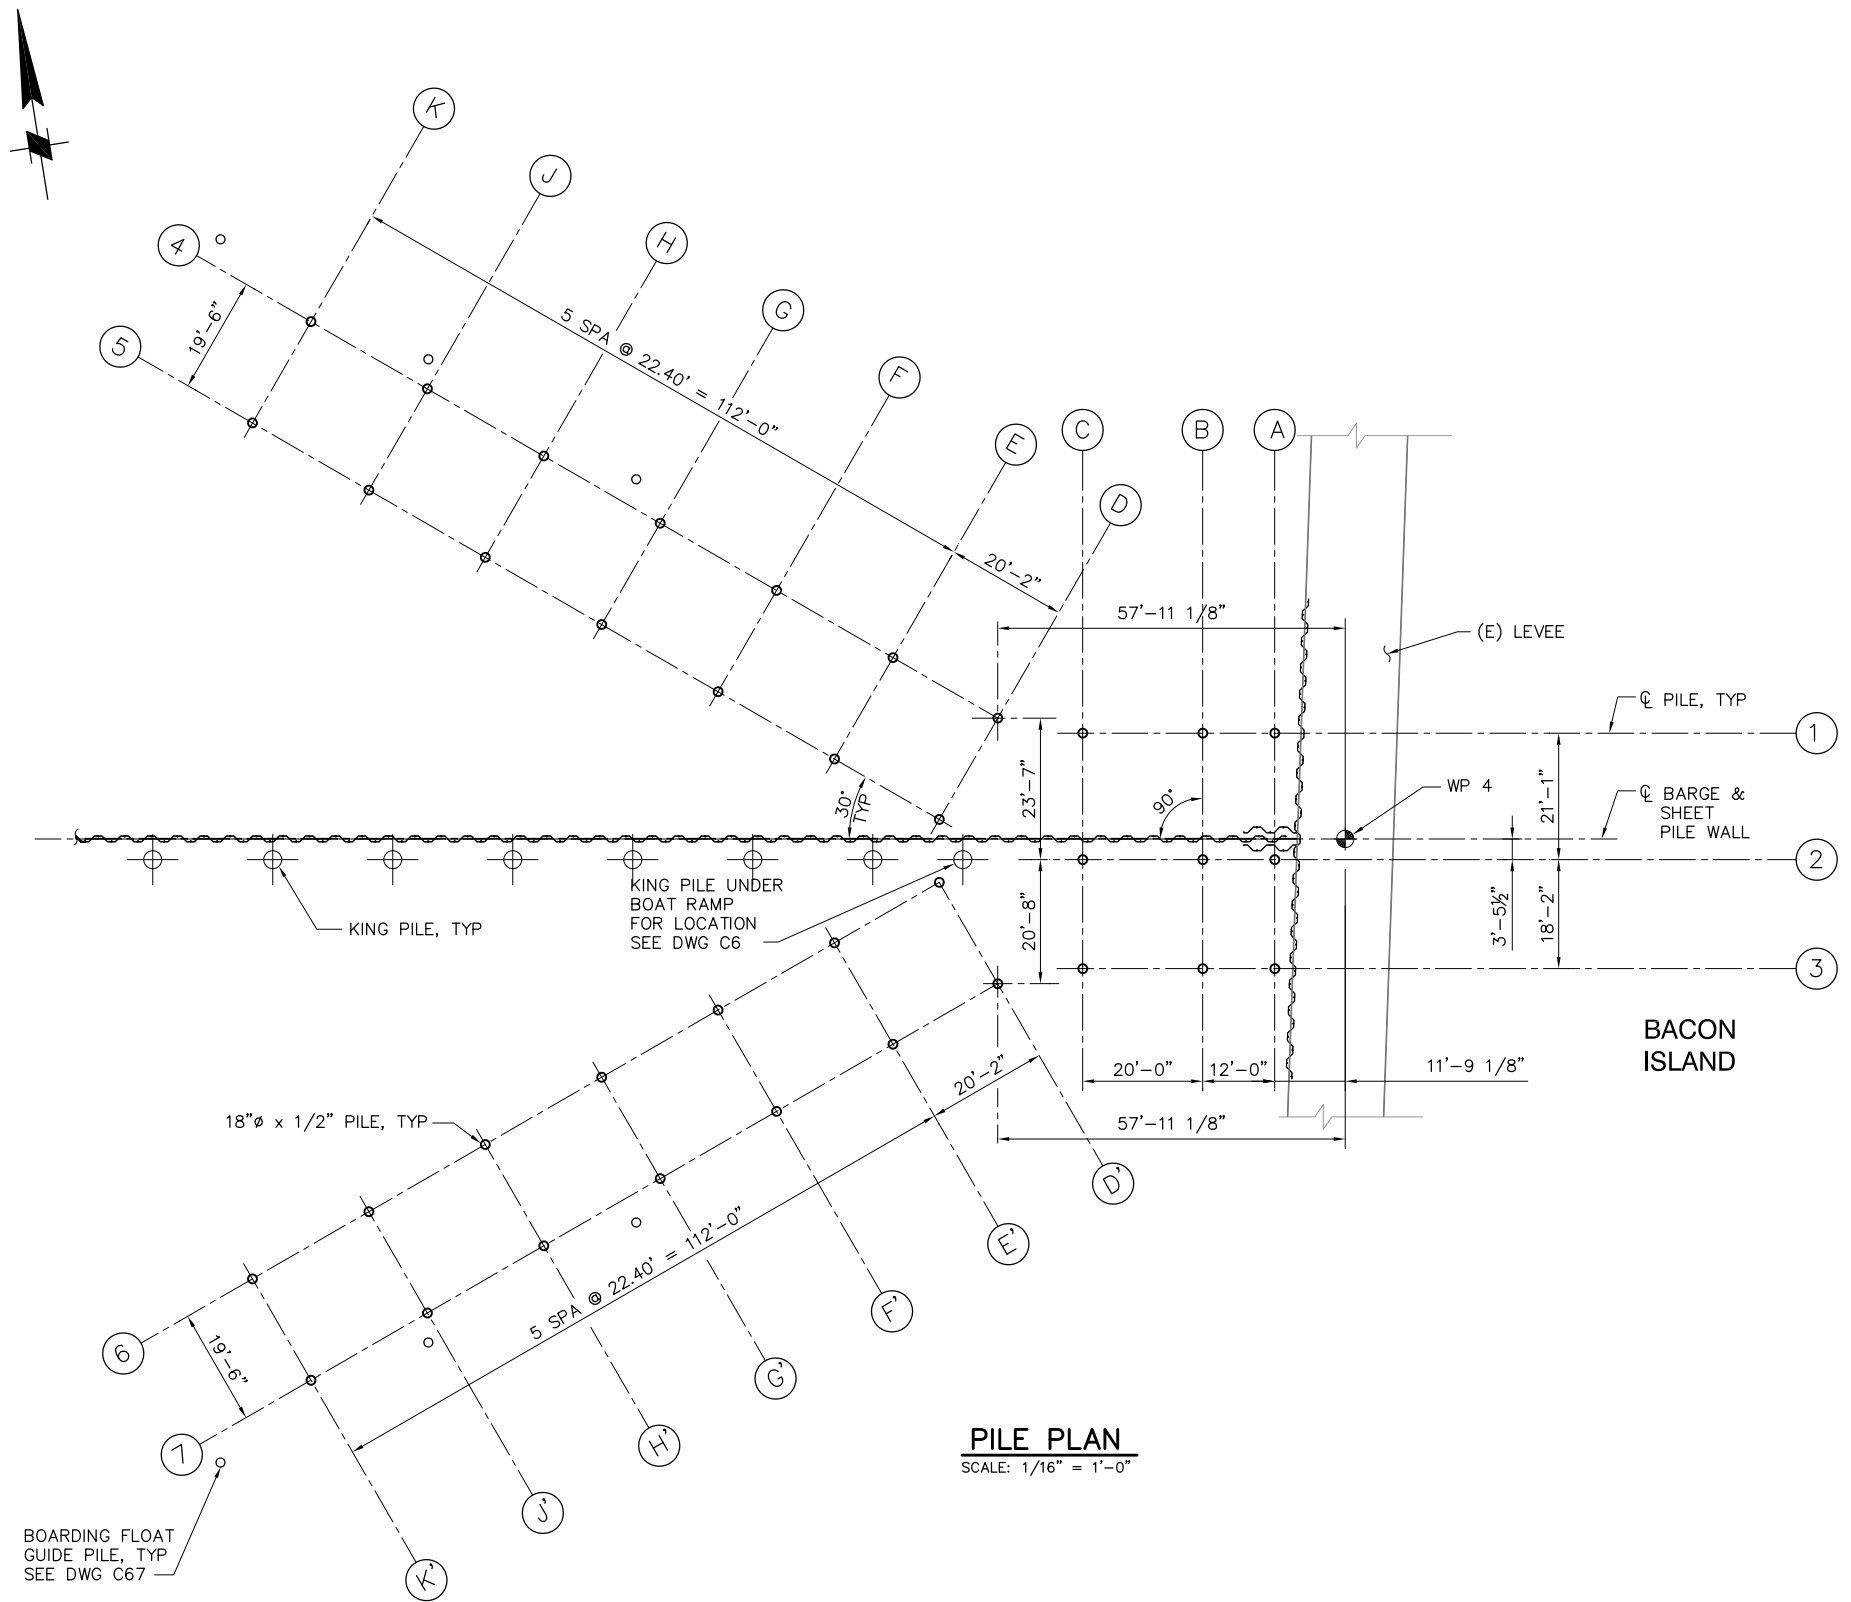


100% SUBMITTAL
REVISION 1

IF SHEET IS LESS THAN 22" x 34"
IT IS A REDUCED PRINT -
SCALE REDUCED ACCORDINGLY.

REVISION	DESCRIPTION	BY	DATE

 San Luis & Delta-Mendota Water Authority 842 6th Street, Suite 7 PO Box 2157 Los Banos, California 93635	 2001 N. Main Street, Suite 360 Walnut Creek, California 94596 (925) 944-5411	2-GATES FISH PROTECTION DEMONSTRATION PROJECT		DATE 10/02/09																
		OLD RIVER BOAT RAMP PILE PLAN		SHEET 12 OF 78																
		<table><tr><td>DSGN</td><td>JMB</td><td>DR</td><td>EP/AB</td><td>CHK</td><td>TDB</td></tr><tr><td>JOB NO.</td><td colspan="5">SUBMITTED BY</td></tr><tr><td>6097-03</td><td colspan="5">RMR</td></tr></table>		DSGN	JMB	DR	EP/AB	CHK	TDB	JOB NO.	SUBMITTED BY					6097-03	RMR			
DSGN	JMB	DR	EP/AB	CHK	TDB															
JOB NO.	SUBMITTED BY																			
6097-03	RMR																			

P:\6097-03 SWC GATE DESIGN\CADD\DWG\609703-C7.2.DWG 9/30/2009 4:47 PM

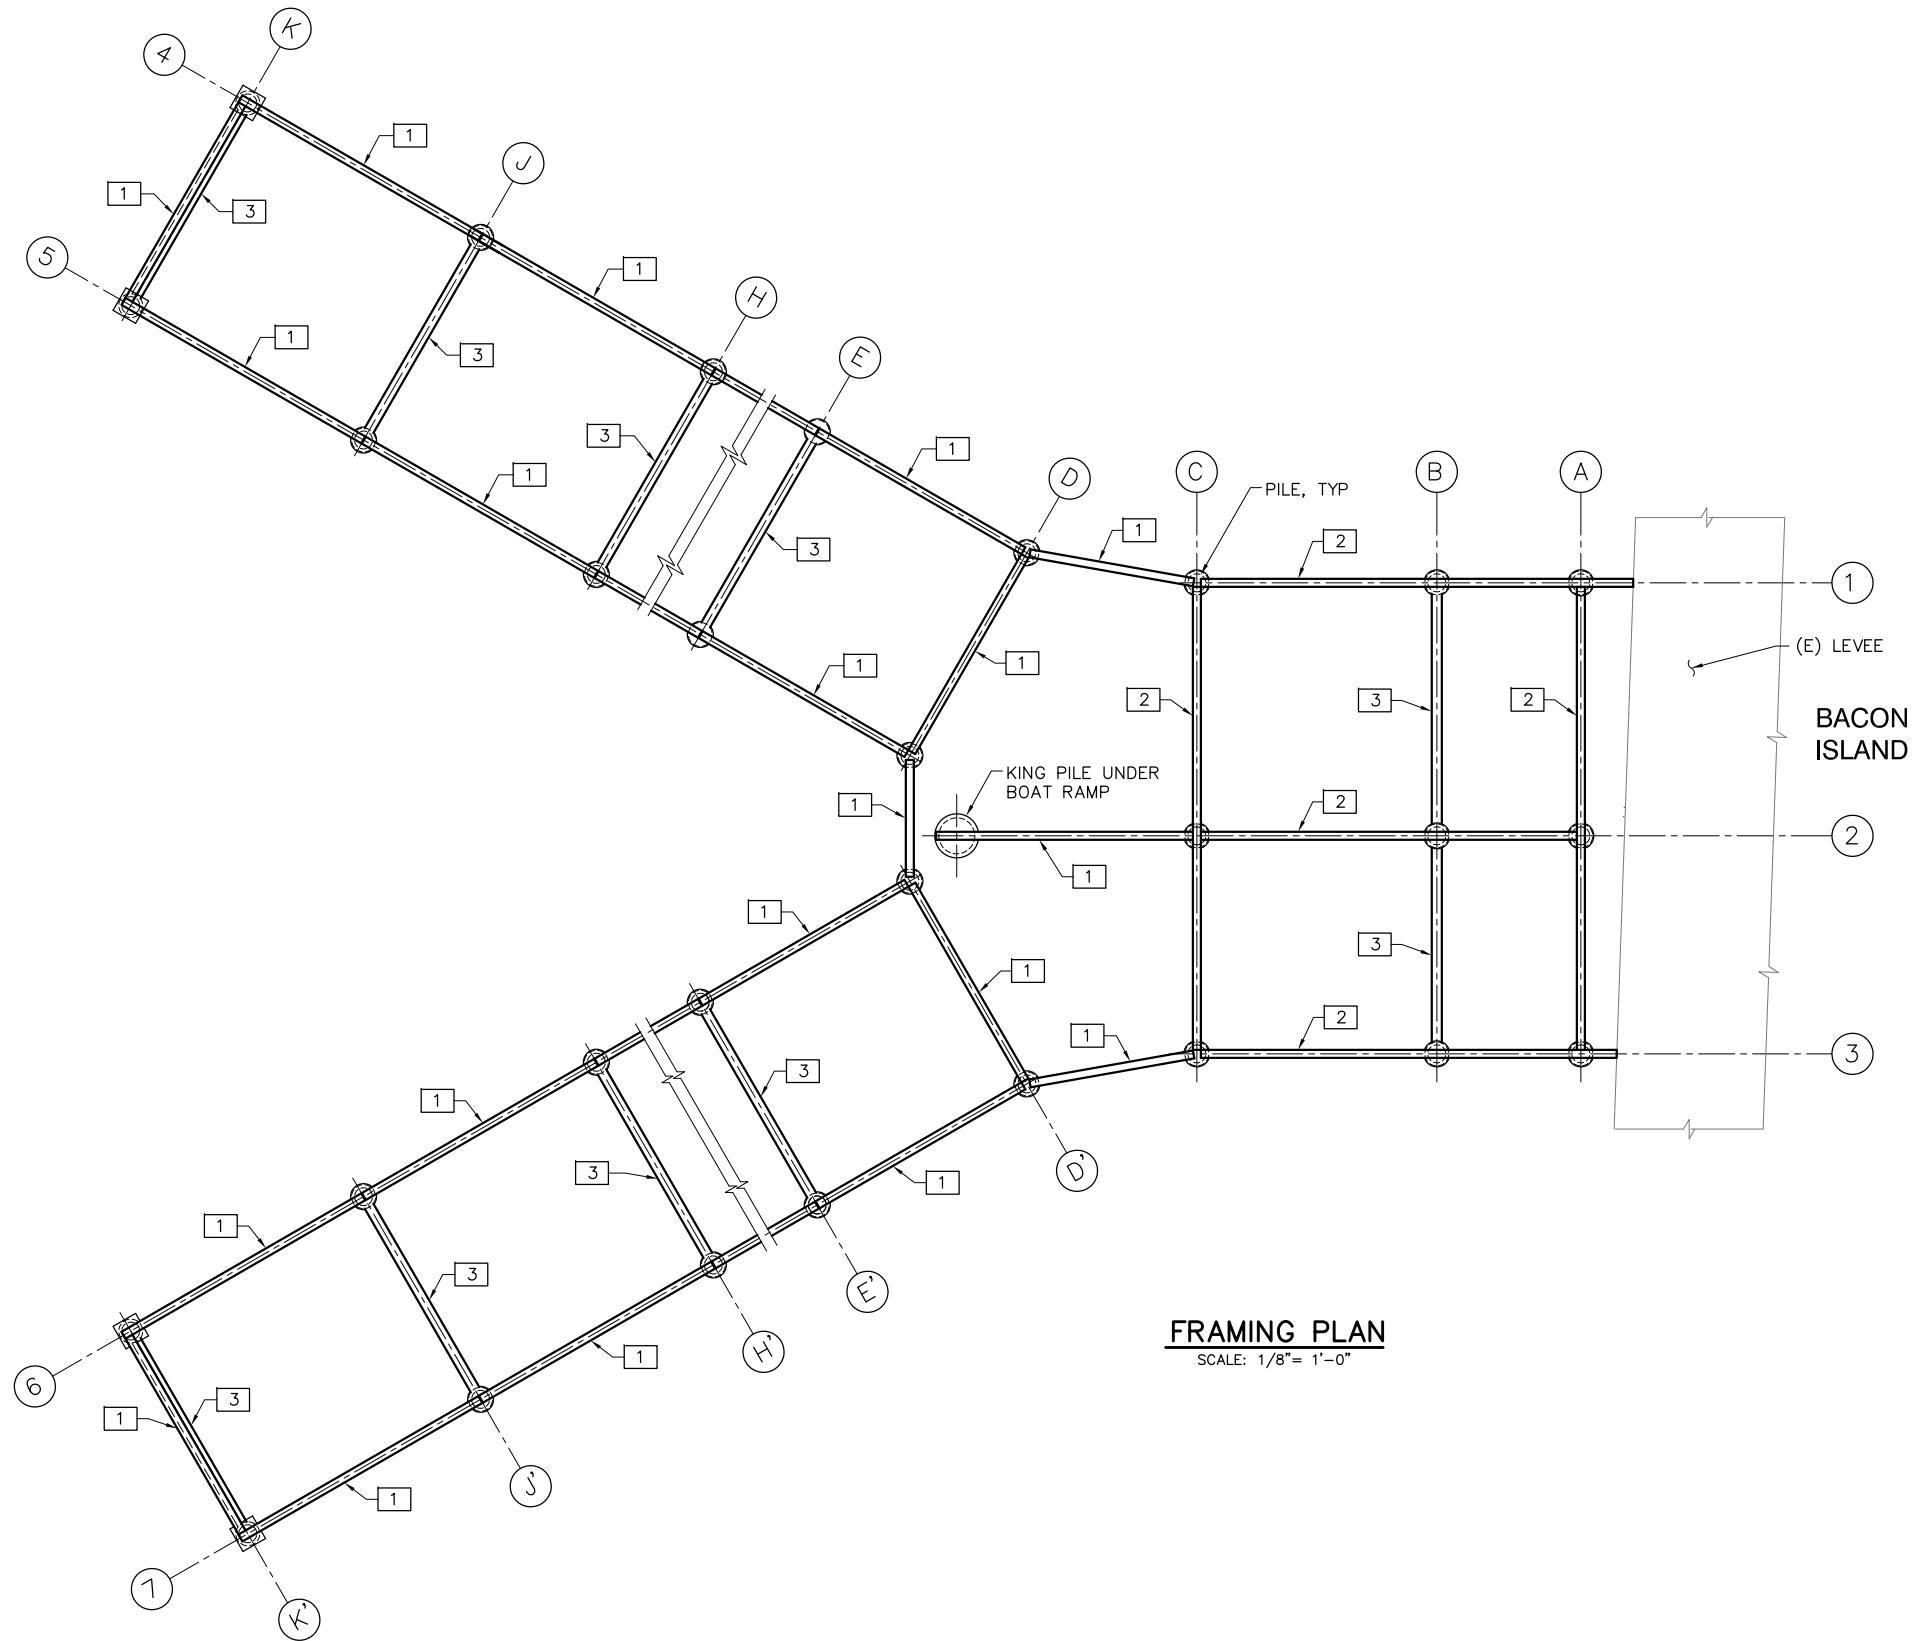


FRAMING PLAN
SCALE: 1/8"= 1'-0"

LEGEND:

- 1 HSS 16x8x1/2
- 2 HSS 16x8x1/2 CONTINUOUS THRU SUPPORT
- 3 10"Ø XSTRONG PIPE TRANSVERSE "CAP" BEAM

NOTE:

 LEVEE SHEET PILE WALL, RIVER SHEET PILE WALL AND KING PILES NOT SHOWN FOR CLARITY.



**100% SUBMITTAL
REVISION 1**

IF SHEET IS LESS THAN 22" x 34"
IT IS A REDUCED PRINT -
SCALE REDUCED ACCORDINGLY.

REVISION	DESCRIPTION	BY	DATE



San Luis & Delta-Mendota Water Authority
842 6th Street, Suite 7
PO Box 2157
Los Banos, California 93635




2001 N. Main Street, Suite 360
Walnut Creek, California 94596
(925) 944-5411


DSGN	JMB	DR	EP/AB	CHK	TDB
JOB NO.	SUBMITTED BY				
6097-03	RMR				

2-GATES FISH PROTECTION DEMONSTRATION PROJECT OLD RIVER BOAT RAMP FRAMING PLAN	DATE 10/02/09
	SHEET 13 OF 78
C7.2	


P:\6097-03 SWC GATE DESIGN\CADD\DWG\609703-C8.DWG 9/30/2009 4:48 PM

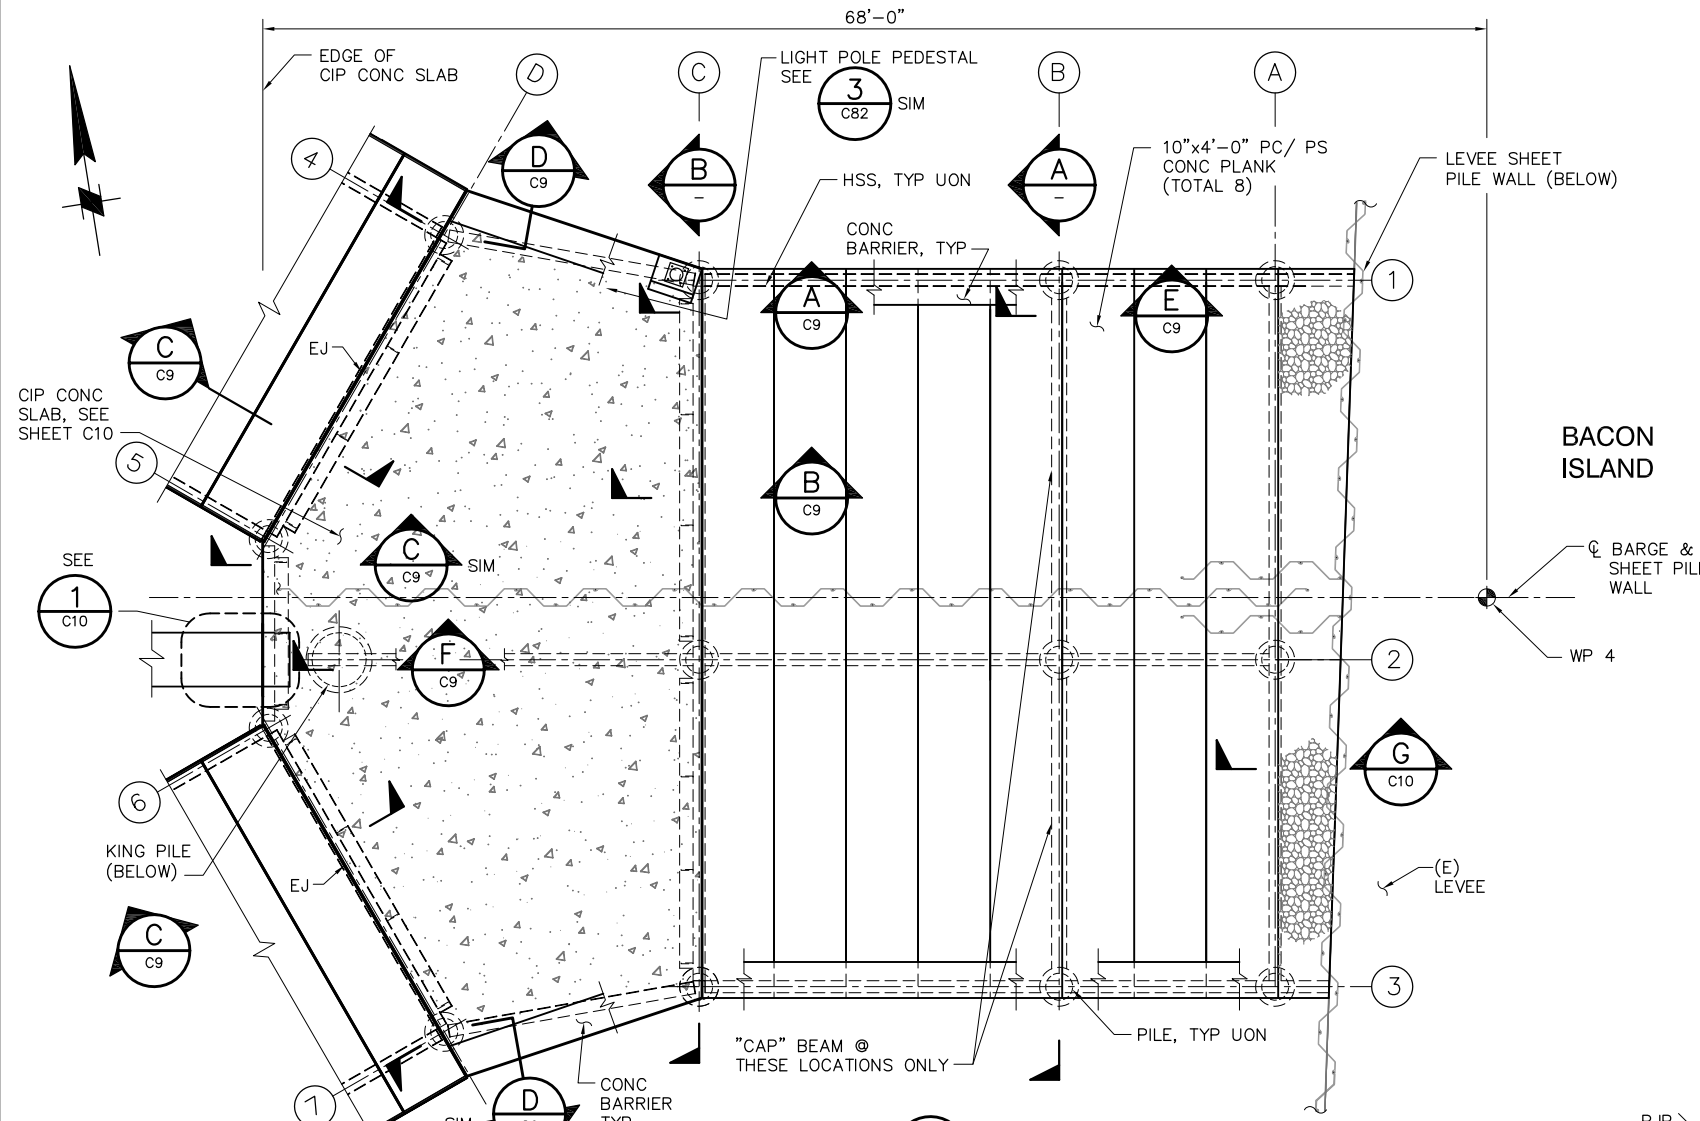

1 DETAIL
SCALE: 3/16" = 1'-0"

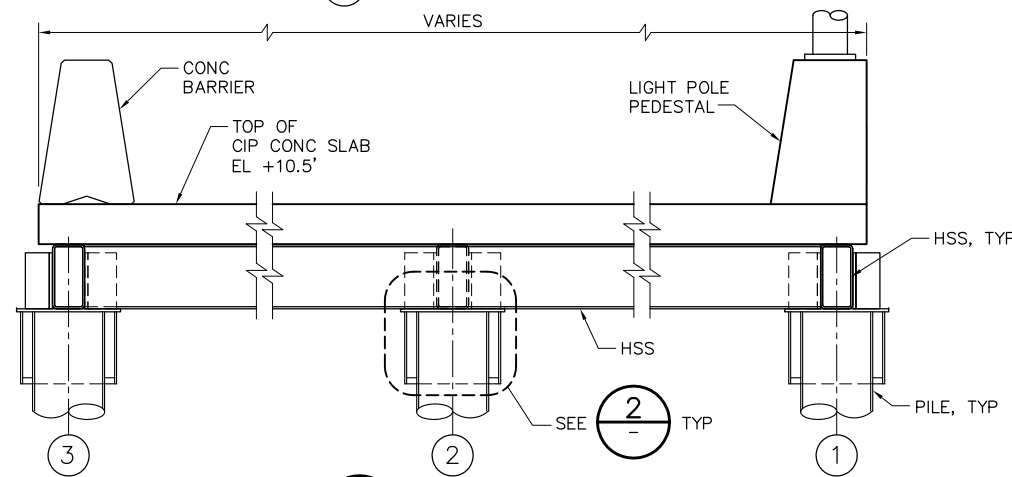


B SECTION
SCALE: 1/2"=1'-0"

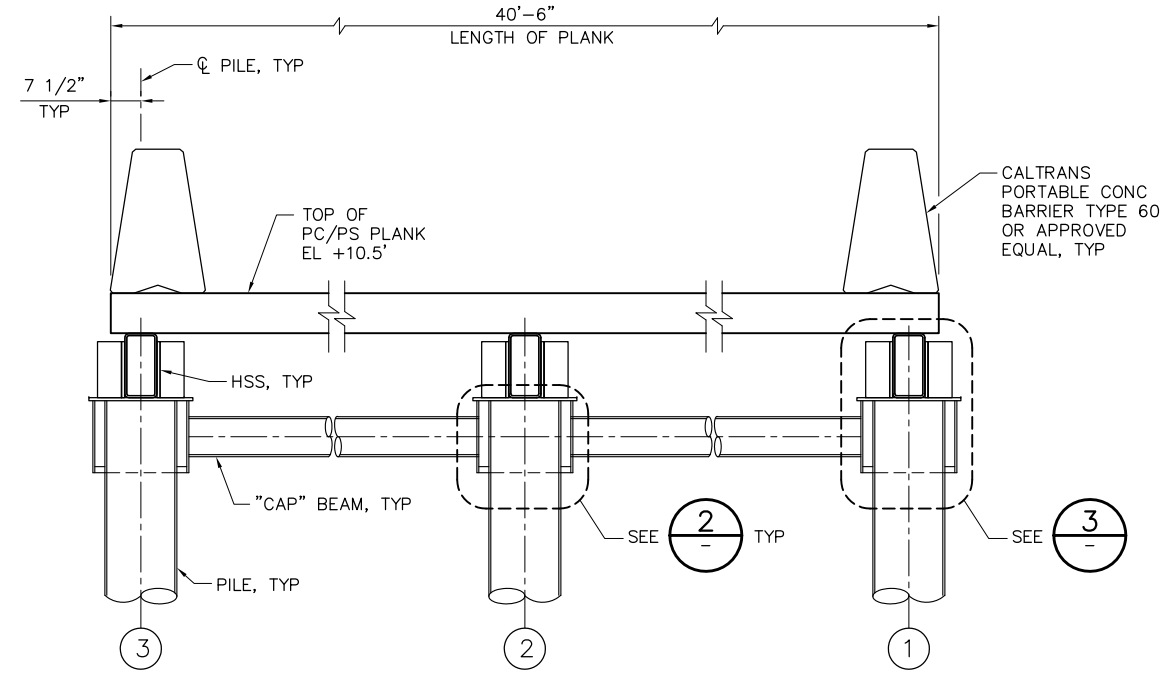


A SECTION
SCALE: 1/2"=1'-0"

WELDING NOTE:
ALL STIFFENER PLATES SHALL HAVE DOUBLE SIDED 1/4" FILLET WELDS UON.

NOTES:
1. ALL PC/PS PLANKS SHALL BEAR ON/AGAINST NEOPRENE "UNDERLAYMENT" BEARING STRIP WITH A MINIMUM 1/8" THICKNESS.

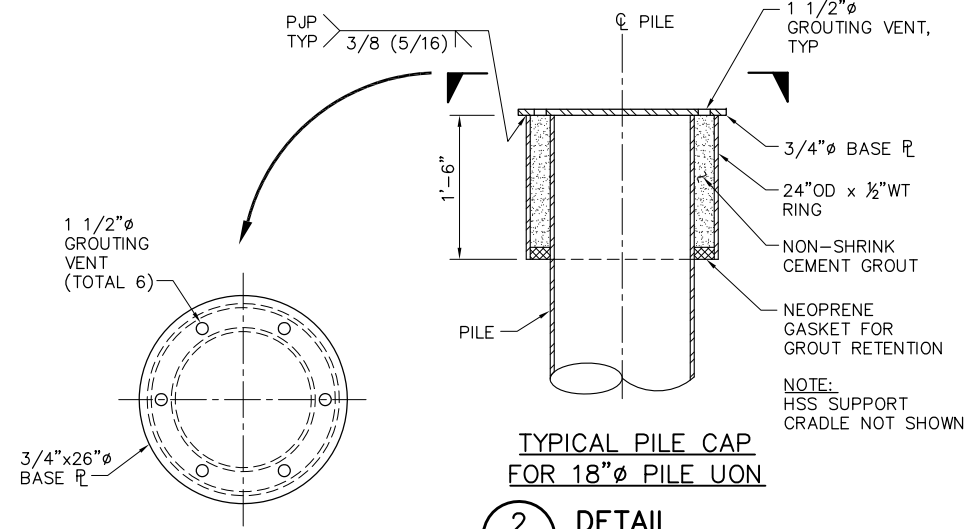

2 DETAIL
SCALE: 1" = 1'-0"

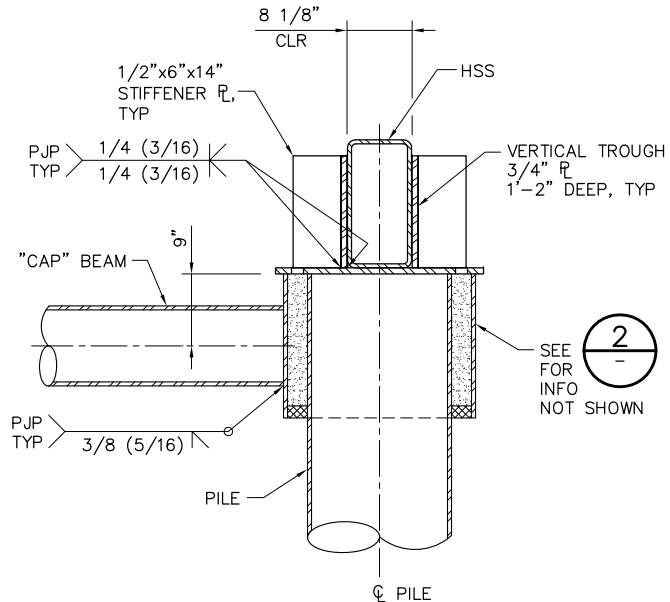


3 DETAIL
SCALE: 1" = 1'-0"


1'-0" 0'-0" 1'-0" 2'-0"
SCALE: 1"=1'-0"

100% SUBMITTAL REVISION 1
IF SHEET IS LESS THAN 22" x 34" IT IS A REDUCED PRINT - SCALE REDUCED ACCORDINGLY.

REVISION	DESCRIPTION	BY	DATE

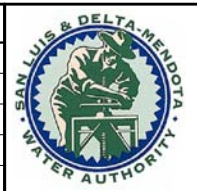

San Luis & Delta-Mendota Water Authority
842 6th Street, Suite 7
PO Box 2157
Los Banos, California 93635

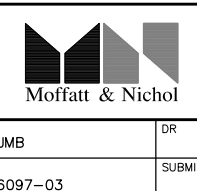





2001 N. Main Street, Suite 360
Walnut Creek, California 94596
(925) 944-5411

DSGN JMB DR EP CHK TDB
JOB NO. 6097-03 SUBMITTED BY RMR

2-GATES FISH PROTECTION DEMONSTRATION PROJECT
OLD RIVER BOAT RAMP DETAILS AND SECTIONS
SHEET 1




DATE 10/02/09
SHEET 14 OF 78
C8

P:\6097-03 SWC GATE DESIGN\CADD\DWG\609703-C9.DWG 9/1/2009 9:32 AM

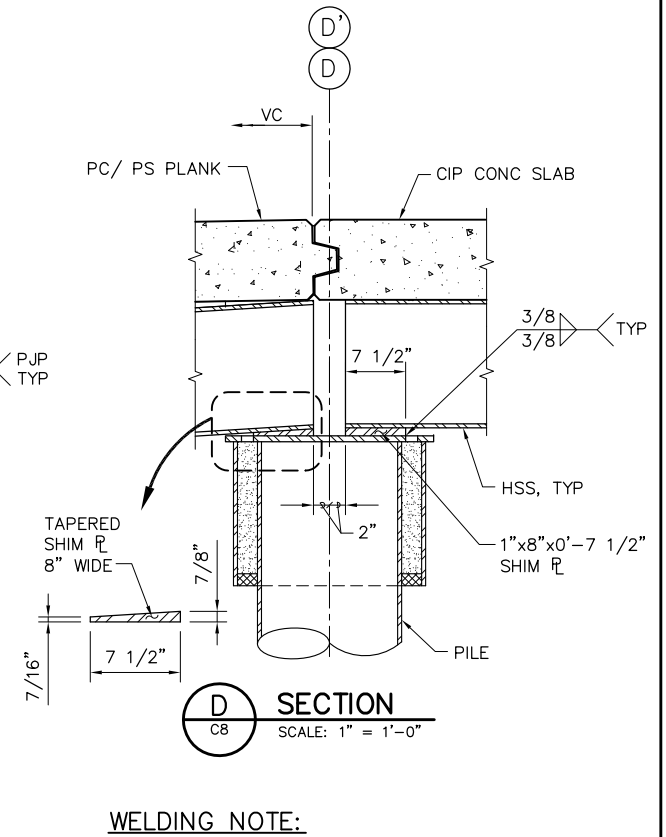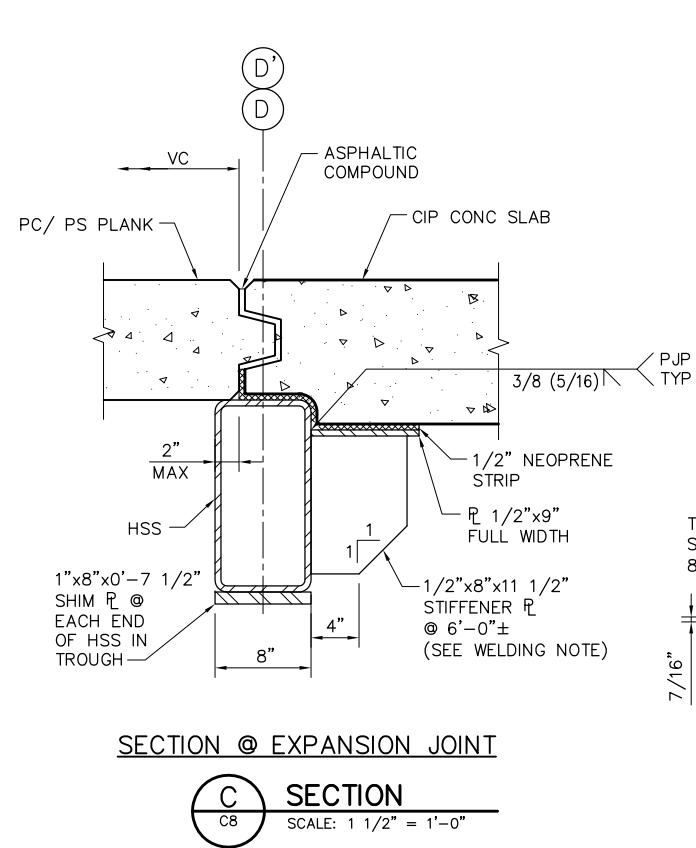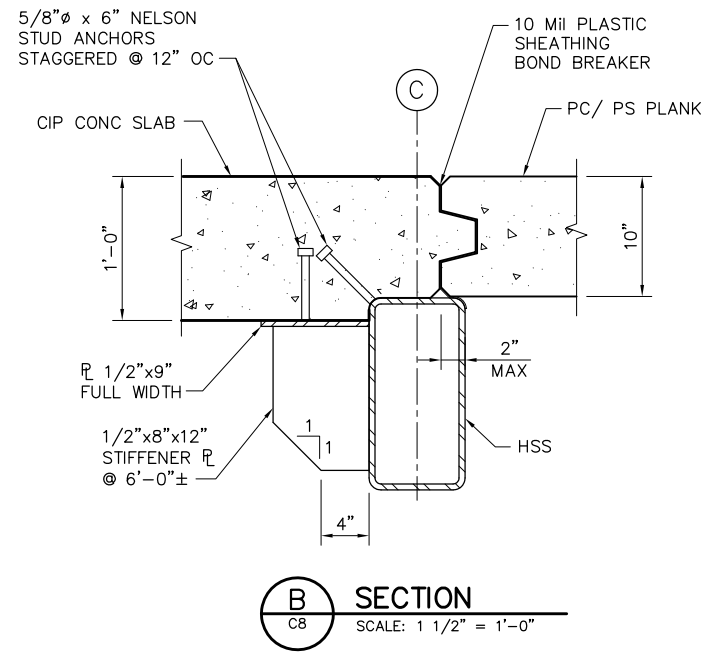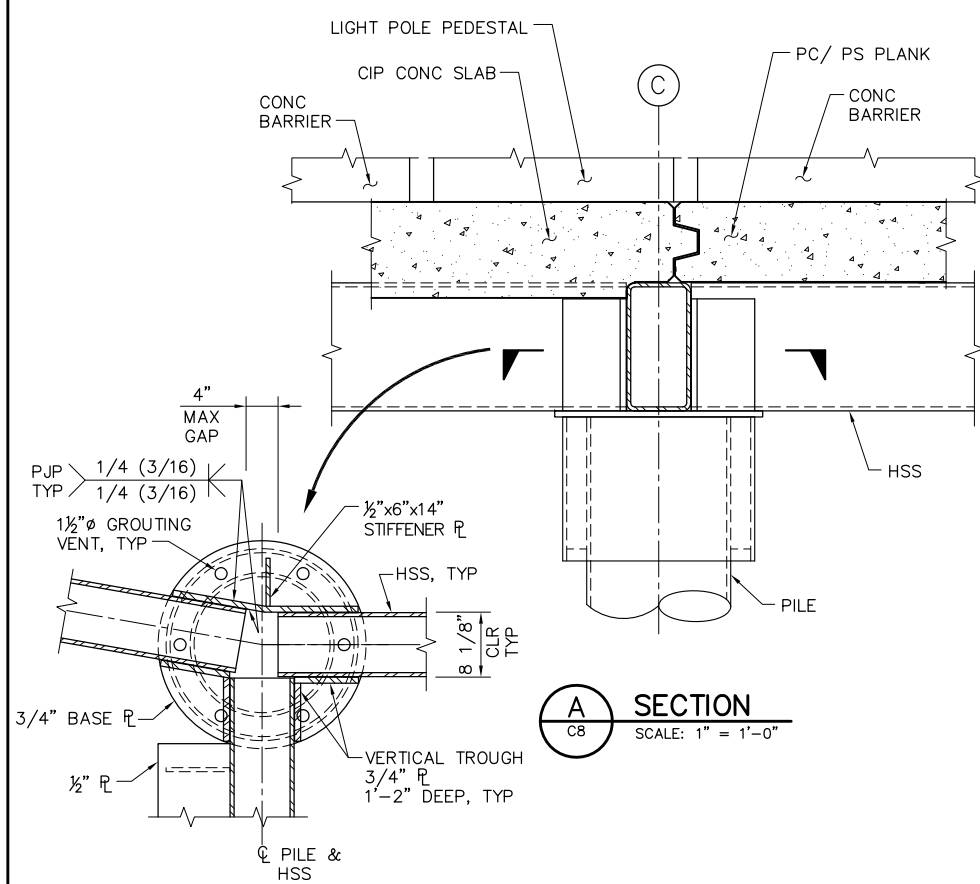

WELDING NOTE:

 ALL STIFFENER PLATES SHALL HAVE DOUBLE SIDED 1/4" FILLET WELDS UON.

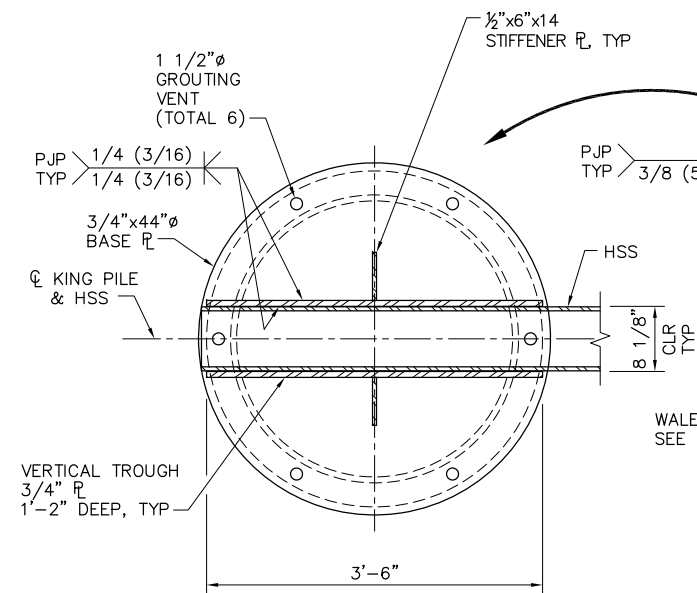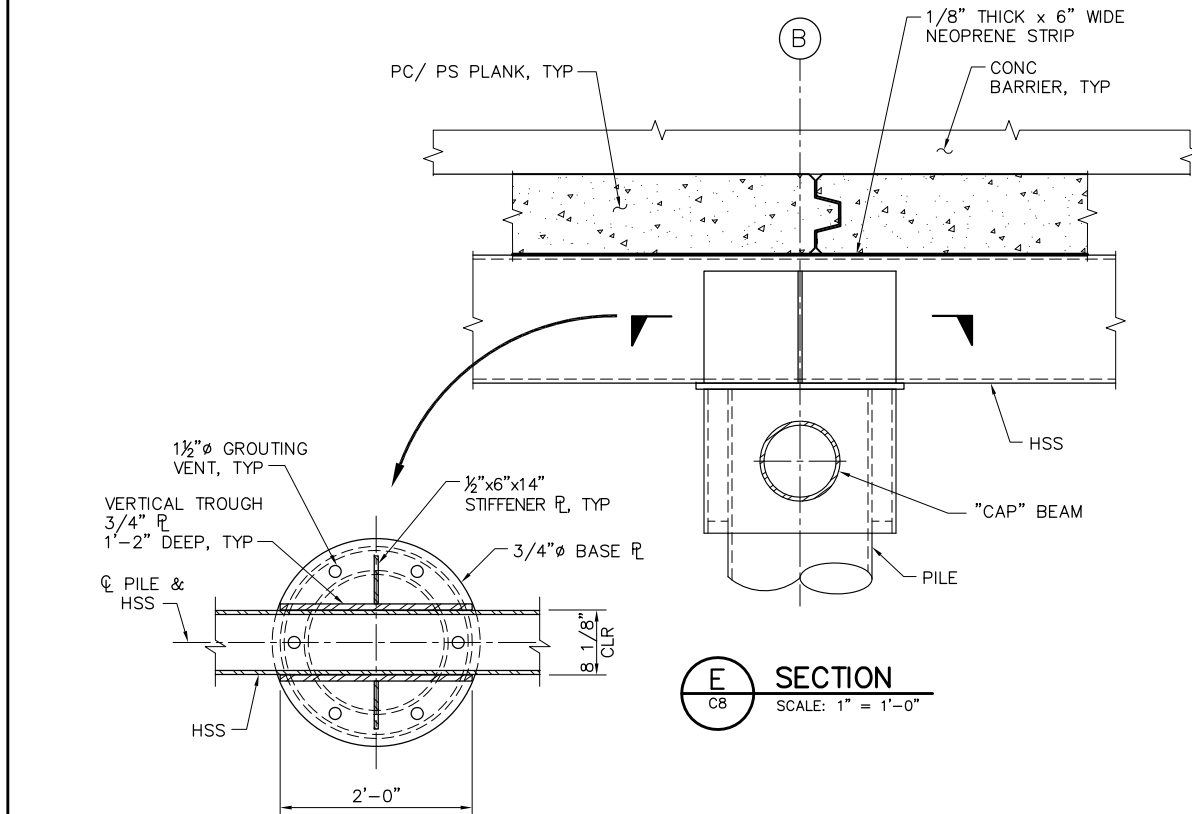

**100% SUBMITTAL
REVISION 1**

IF SHEET IS LESS THAN 22" x 34"
IT IS A REDUCED PRINT -
SCALE REDUCED ACCORDINGLY.

REVISION	DESCRIPTION	BY	DATE



San Luis & Delta-Mendota Water Authority
842 6th Street, Suite 7
PO Box 2157
Los Banos, California 93635



2001 N. Main Street, Suite 360
Walnut Creek, California 94596
(925) 944-5411

DSGN	JMB	DR	EP	CHK	TDB
JOB NO.	6097-03	SUBMITTED BY	RMR		

2-GATES FISH PROTECTION
DEMONSTRATION PROJECT


OLD RIVER
BOAT RAMP DETAILS AND SECTIONS
SHEET 2

DATE 10/02/09


SHEET 15 OF 78

C9


P:\6097-03 SMC GATE DESIGN\CADD\DWG\609703-C10.DWG 9/1/2009 9:33 AM

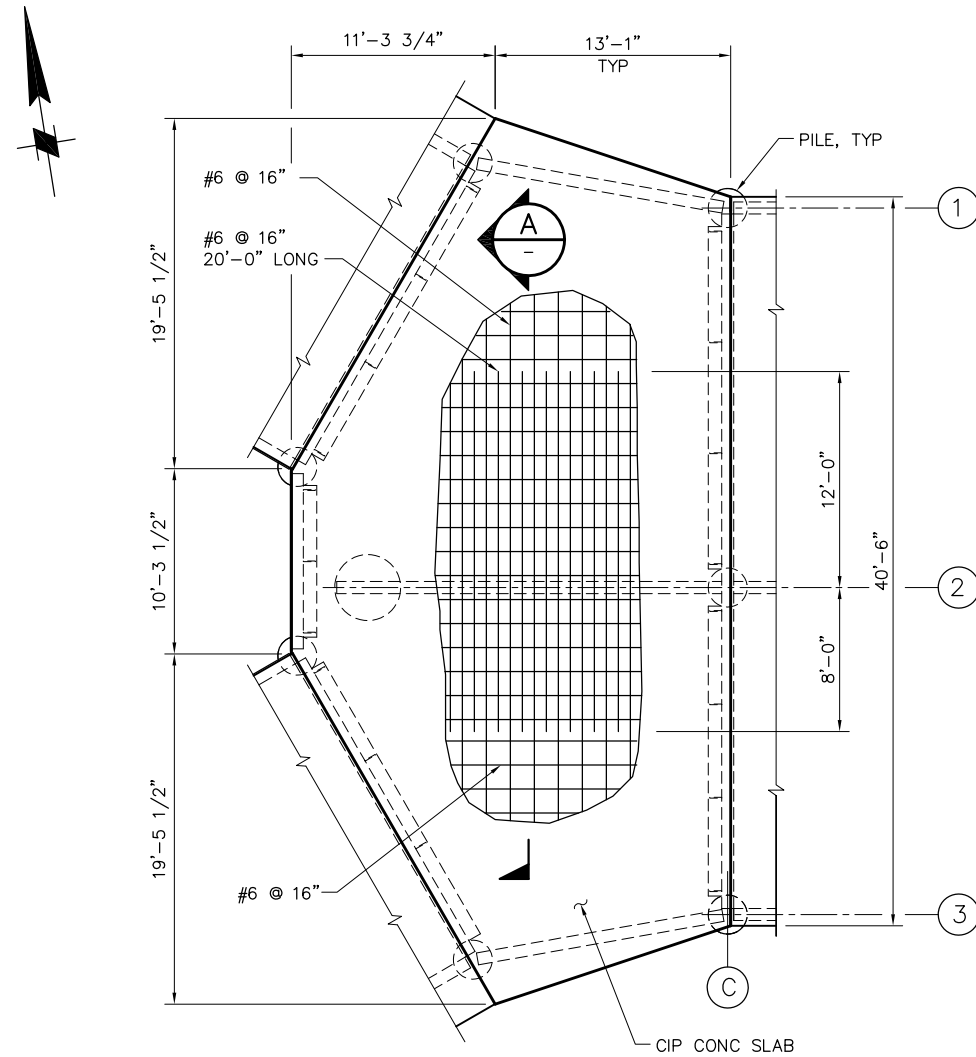


TOP SLAB REINFORCEMENT
SCALE: 3/16" = 1'-0"

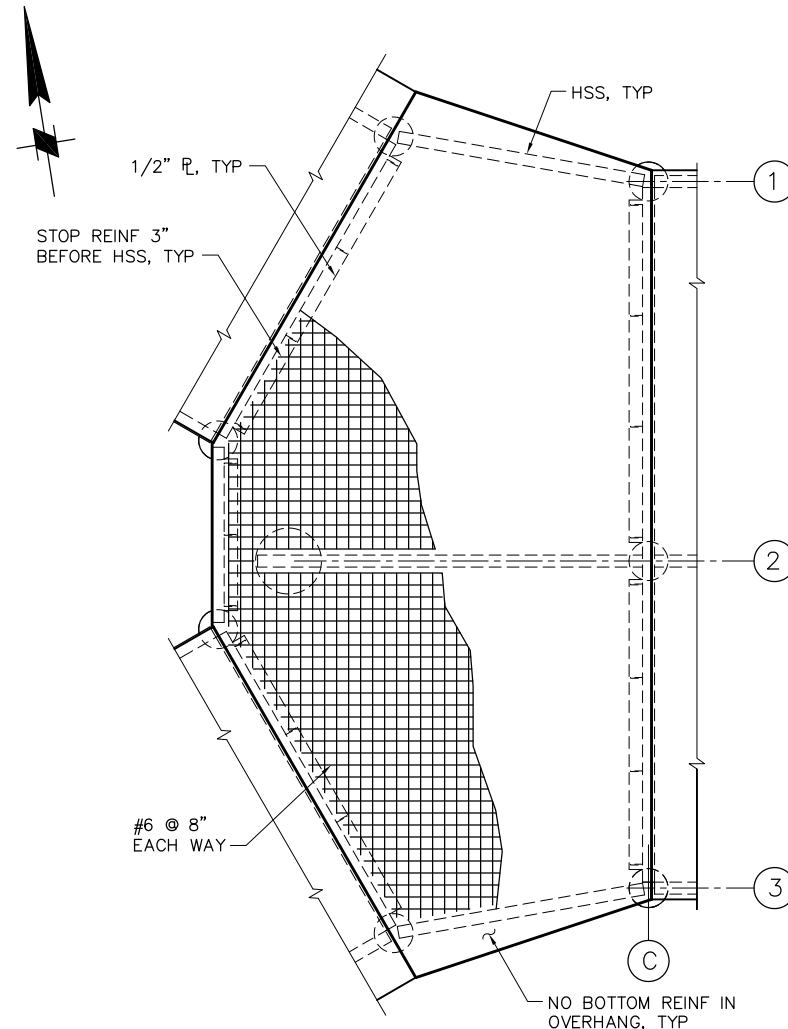


BOTTOM SLAB REINFORCEMENT
SCALE: 3/16" = 1'-0"

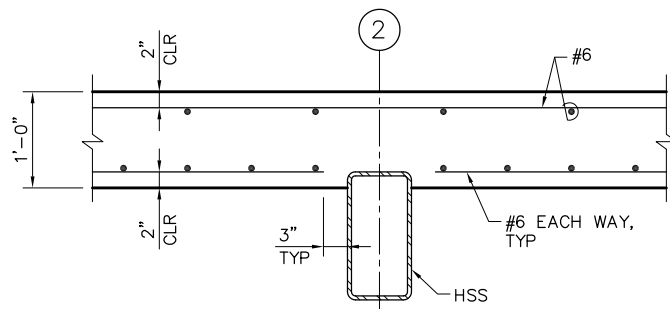


SECTION A
SCALE: 1" = 1'-0"

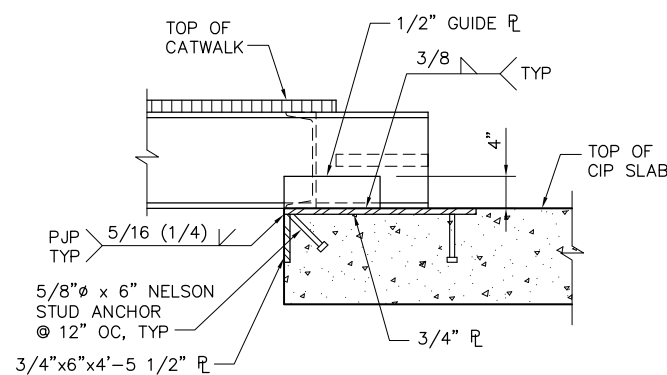

SECTION B
SCALE: 1" = 1'-0"

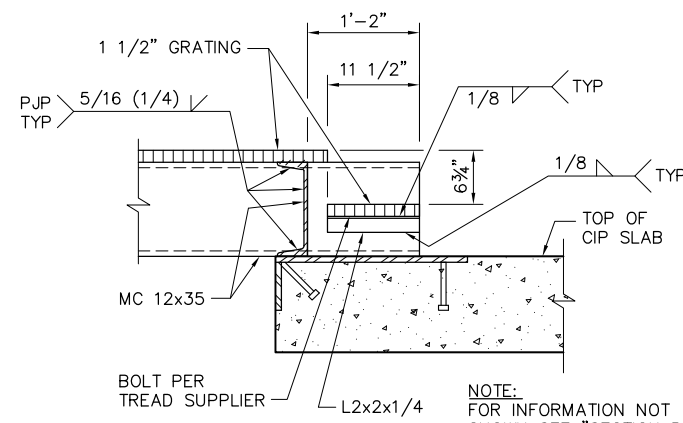


SECTION C
SCALE: 1" = 1'-0"

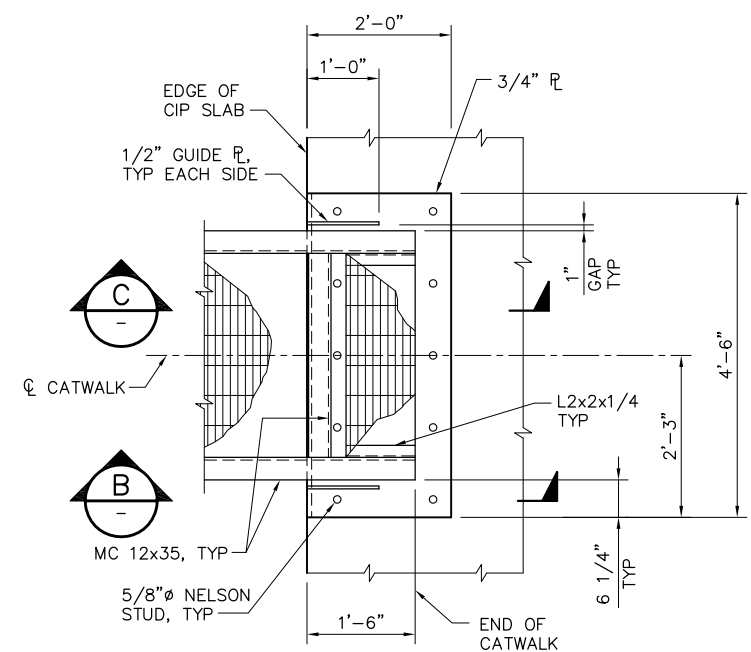


PLAN AT END OF CATWALK

1 DETAIL
C8 SCALE: 3/4" = 1'-0"

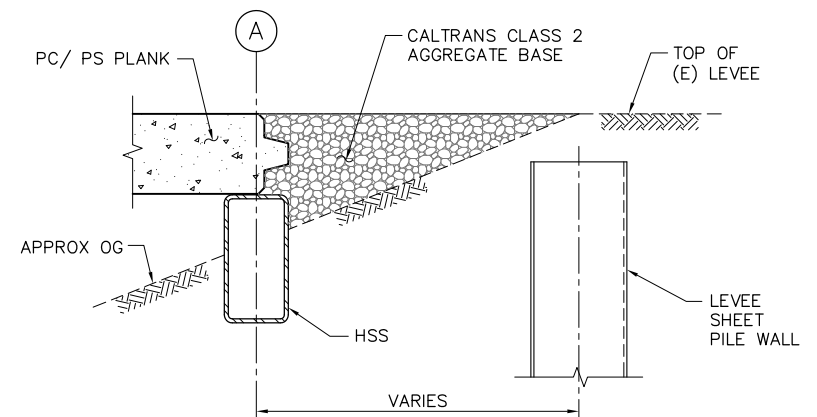

SECTION G
SCALE: 1" = 1'-0"

 

100% SUBMITTAL
REVISION 1

IF SHEET IS LESS THAN 22" x 34"
IT IS A REDUCED PRINT -
SCALE REDUCED ACCORDINGLY.

REVISION	DESCRIPTION	BY	DATE



San Luis & Delta-Mendota Water Authority
842 6th Street, Suite 7
PO Box 2157
Los Banos, California 93635



2001 N. Main Street, Suite 360
Walnut Creek, California 94596
(925) 944-5411

DSGN	JMB	DR	EP	CHK	TDB
JOB NO.	6097-03	SUBMITTED BY	RMR		

2-GATES FISH PROTECTION
DEMONSTRATION PROJECT


OLD RIVER
BOAT RAMP DETAILS AND SECTIONS
SHEET 3

DATE 10/02/09


SHEET 16 OF 78

C10

P:\6097-03 SWC GATE DESIGN\CADD\DWG\609703-C11.DWG 10/1/2009 9:47 AM

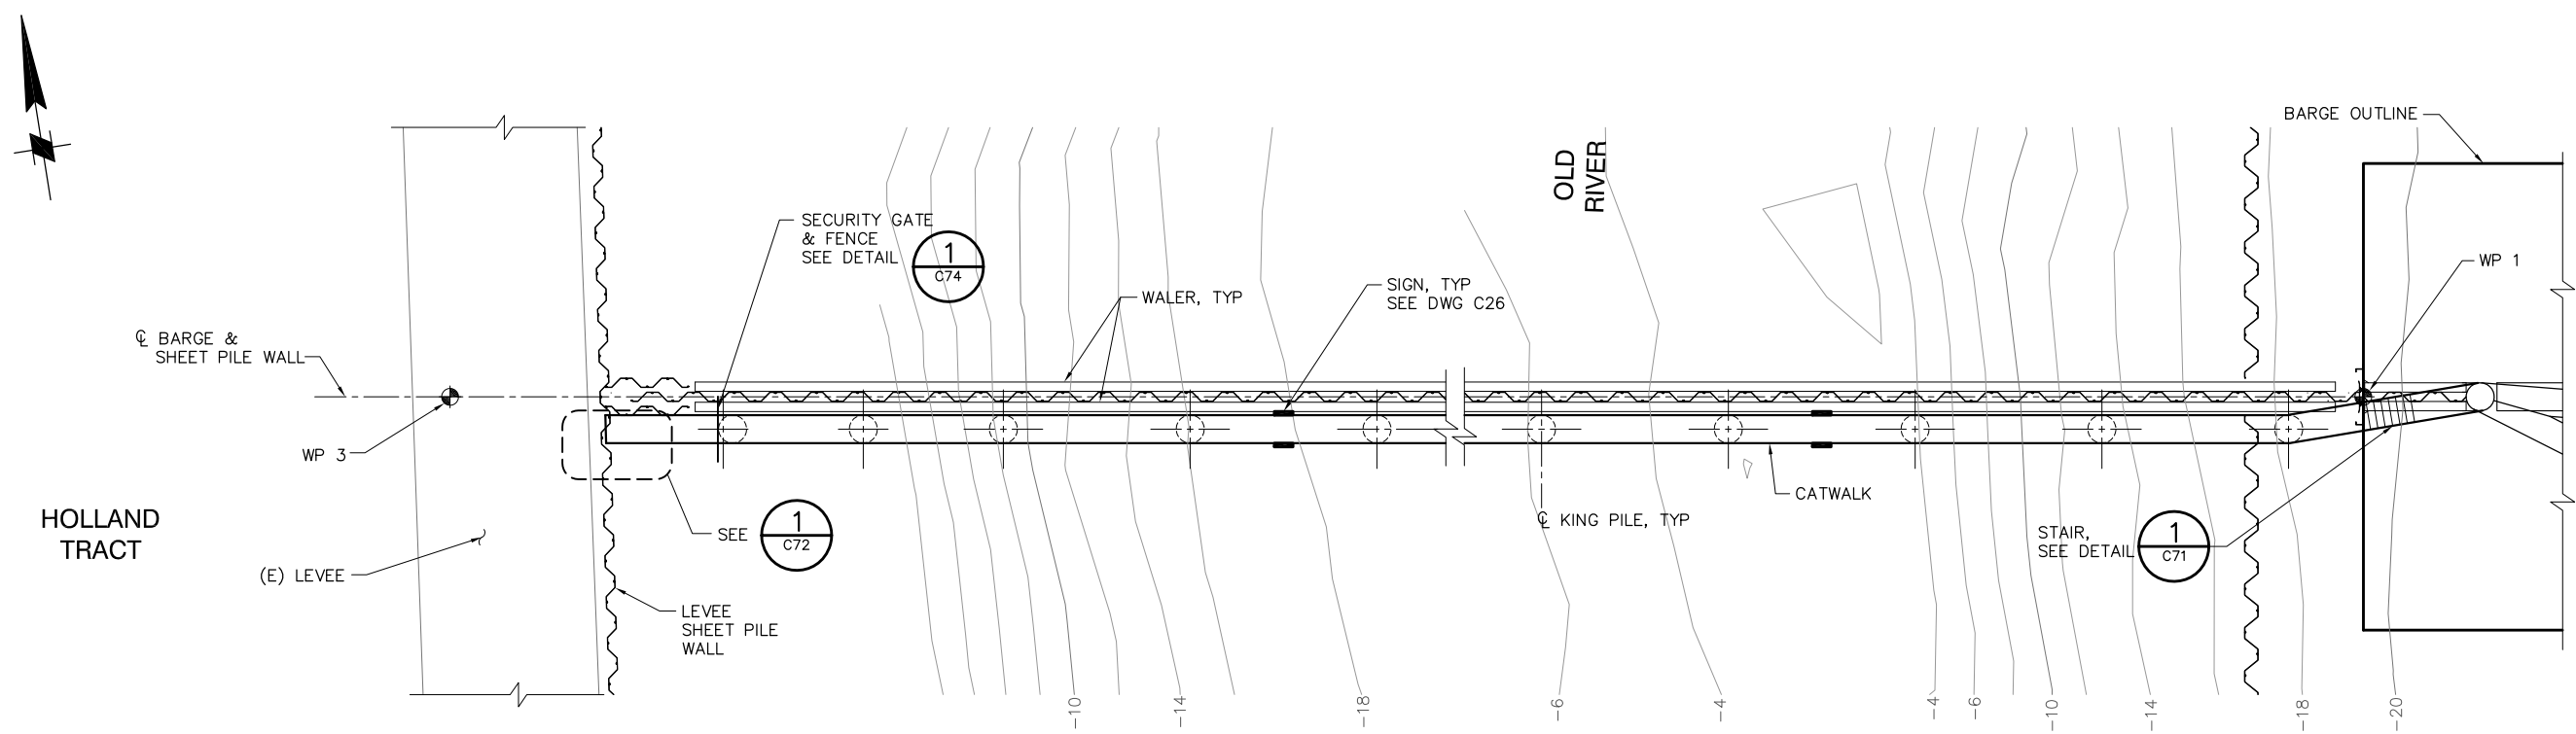


PLAN
SCALE: 1"= 10'

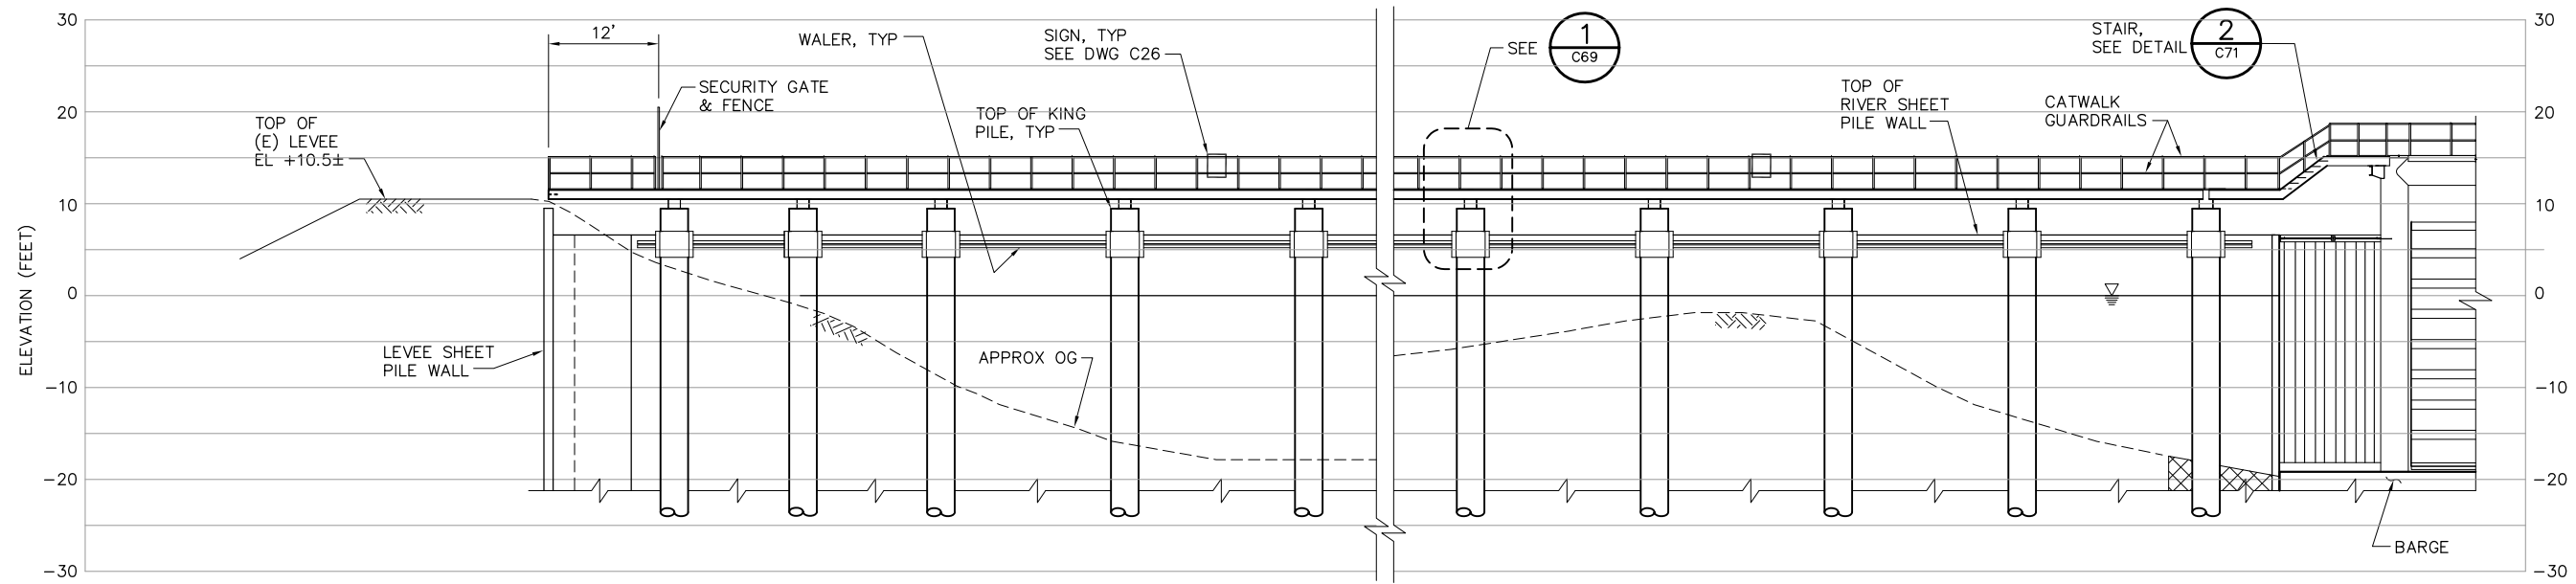

ELEVATION
SCALE: 1"= 10'

 NOTE: SUBMERGED SHEET PILE ENCLOSURE NOT SHOWN FOR CLARITY.



100% SUBMITTAL
REVISION 1

IF SHEET IS LESS THAN 22" x 34"
IT IS A REDUCED PRINT -
SCALE REDUCED ACCORDINGLY.

REVISION	DESCRIPTION	BY	DATE



San Luis & Delta-Mendota Water Authority
842 6th Street, Suite 7
PO Box 2157
Los Banos, California 93635



2001 N. Main Street, Suite 360
Walnut Creek, California 94596
(925) 944-5411

DSGN	JMB	DR	EP/AB	CHK	TDB
JOB NO.	6097-03	SUBMITTED BY	RMR		

2-GATES FISH PROTECTION
DEMONSTRATION PROJECT


OLD RIVER
CATWALK
PLAN AND ELEVATION, SHEET 1

DATE 10/02/09


SHEET 17 OF 78

C11

P:\6097-03 SWC GATE DESIGN\CADD\DWG\609703-C12.DWG 10/1/2009 10:24 AM

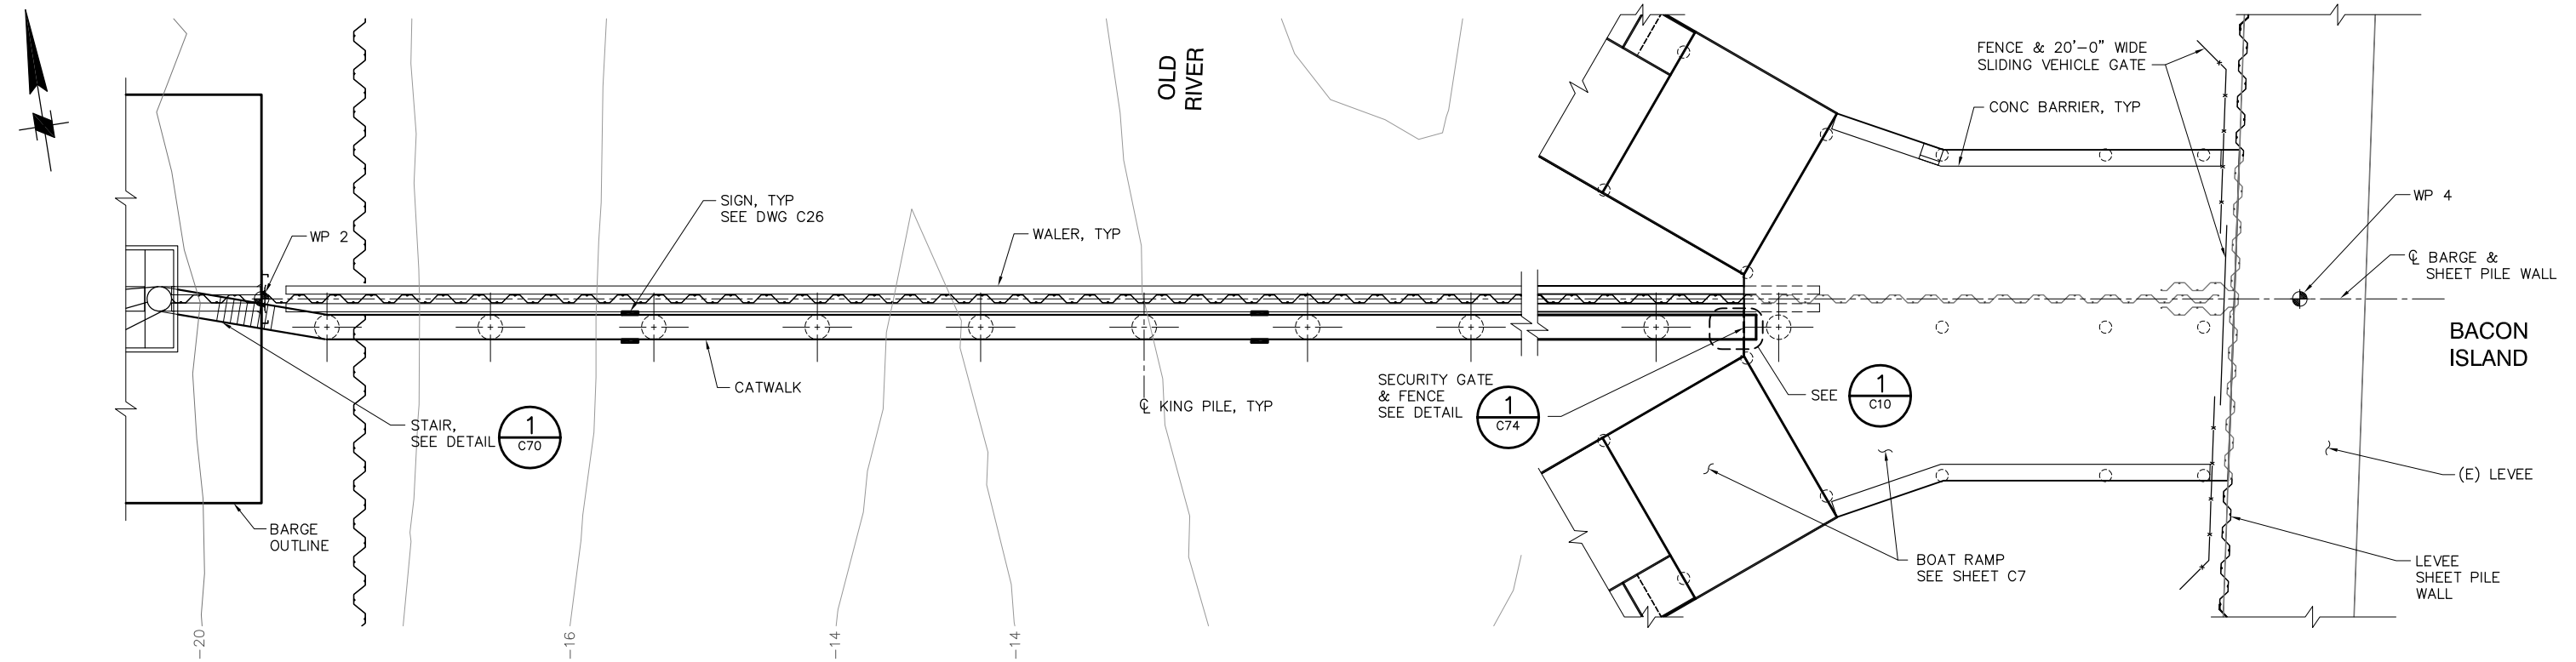


PLAN
SCALE: 1"= 10'

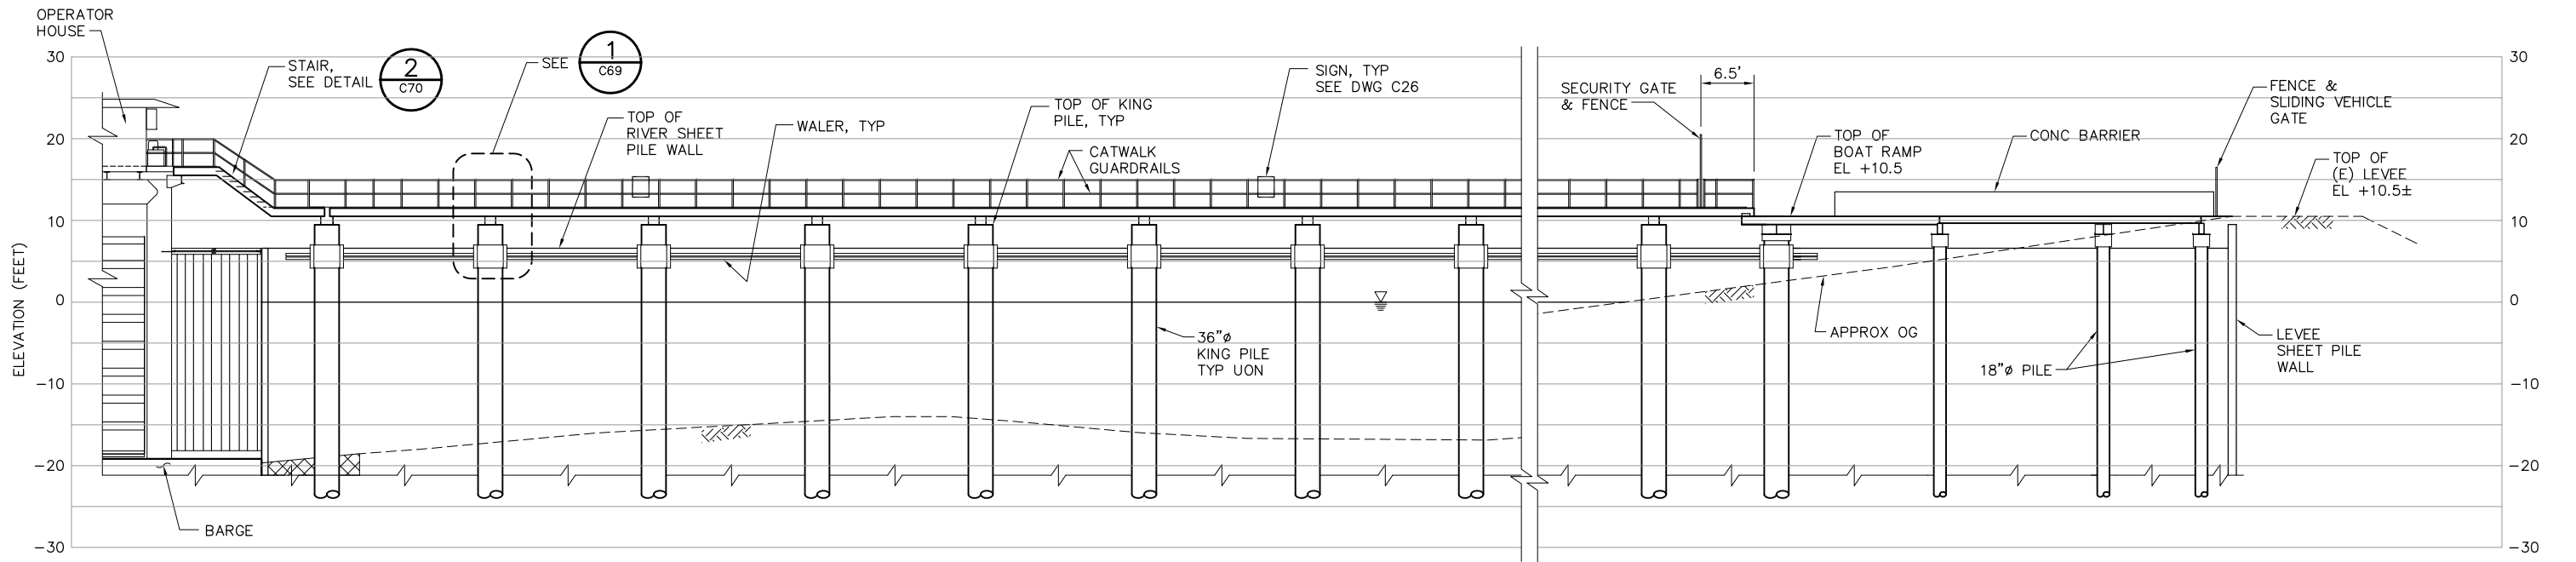

ELEVATION
SCALE: 1"= 10'

 NOTE: SUBMERGED SHEET PILE
ENCLOSURE NOT SHOWN
FOR CLARITY.



**100% SUBMITTAL
REVISION 1**

IF SHEET IS LESS THAN 22" x 34"
IT IS A REDUCED PRINT -
SCALE REDUCED ACCORDINGLY.

REVISION	DESCRIPTION	BY	DATE



San Luis & Delta-Mendota Water Authority
842 6th Street, Suite 7
PO Box 2157
Los Banos, California 93635



2001 N. Main Street, Suite 360
Walnut Creek, California 94596
(925) 944-5411

DSGN	JMB	DR	EP/AB	CHK	TDB
JOB NO.	6097-03	SUBMITTED BY	RMR		

2-GATES FISH PROTECTION
DEMONSTRATION PROJECT


**OLD RIVER
CATWALK
PLAN AND ELEVATION, SHEET 2**

DATE 10/02/09

SHEET 18 OF 78

C12

P:\6097-03 SWC GATE DESIGN\CADD\DWG\609703-C13.DWG 10/1/2009 10:43 AM

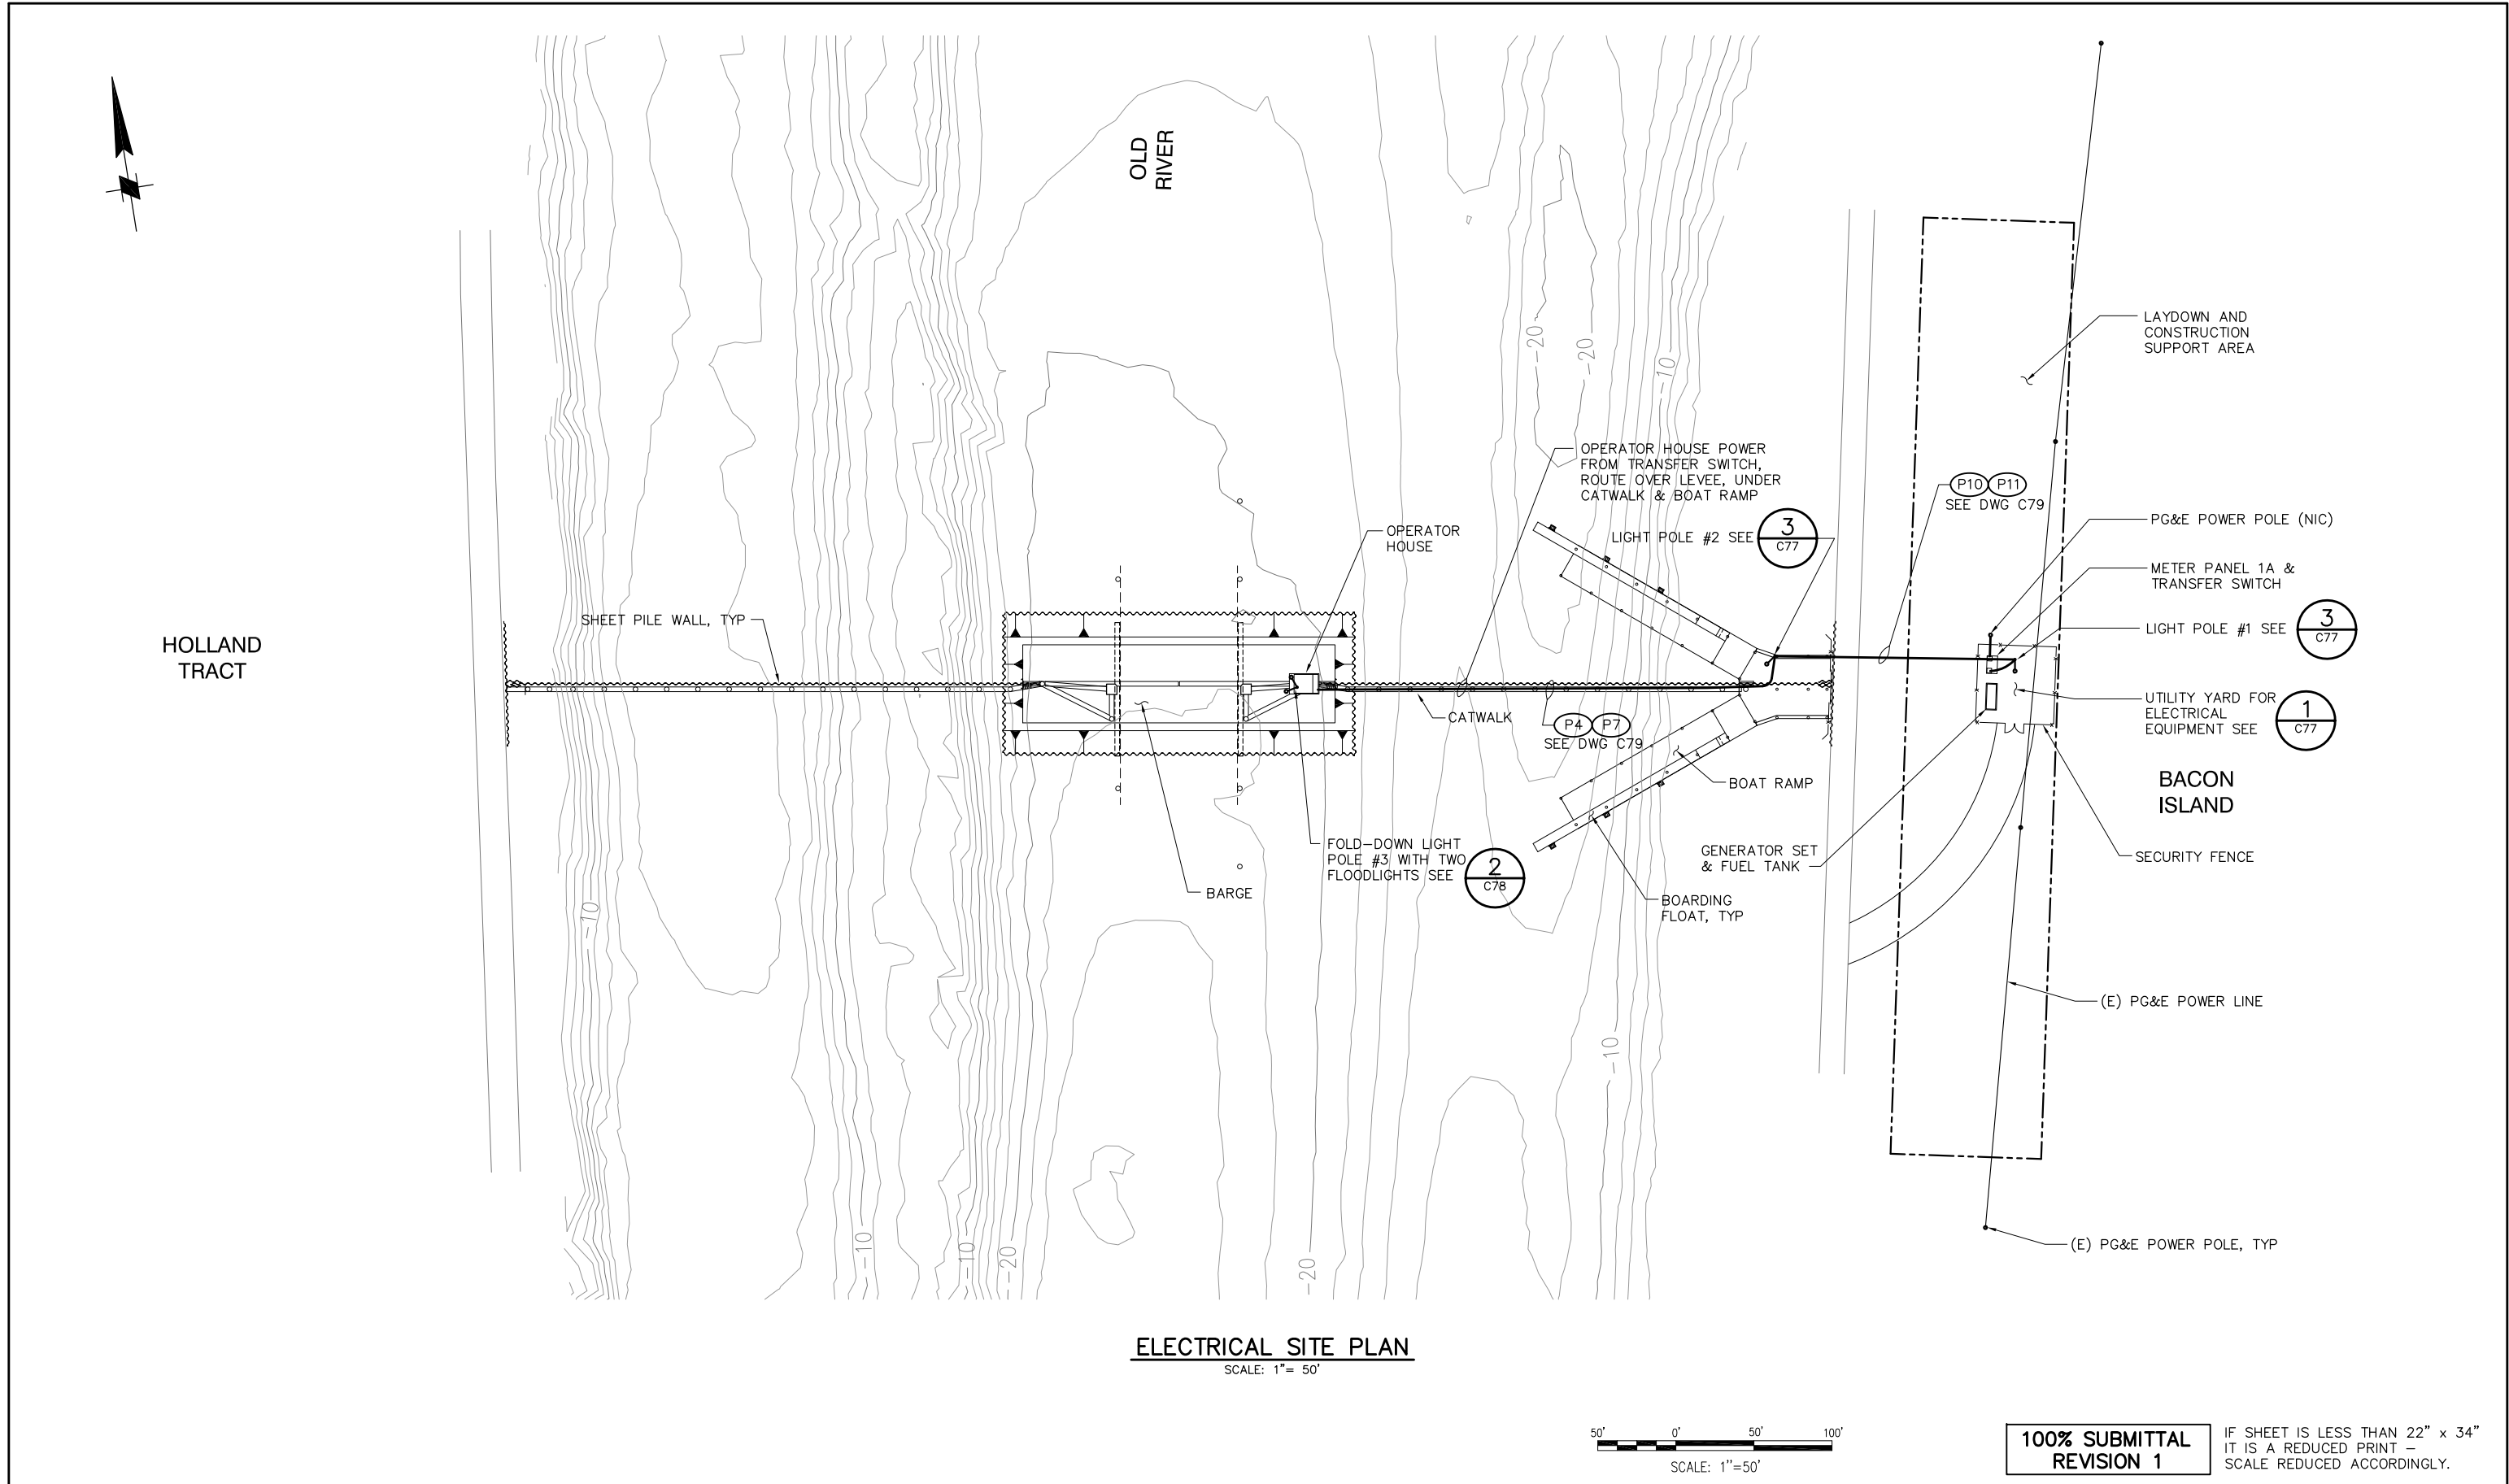


REVISION	DESCRIPTION	BY	DATE

	San Luis & Delta-Mendota Water Authority 842 6th Street, Suite 7 PO Box 2157 Los Banos, California 93635		2001 N. Main Street, Suite 360 Walnut Creek, California 94596 (925) 944-5411		2-GATES FISH PROTECTION DEMONSTRATION PROJECT	DATE 10/02/09
						SHEET 19 OF 78
						C13

DSGN DM	DR AB/EP	CHK CBS
JOB NO. 6097-03		SUBMITTED BY RMR


OLD RIVER ELECTRICAL SITE PLAN	
-----------------------------------	--

P:\6097-03 SWC GATE DESIGN\CADD\DWG\609703-C14.DWG 9/29/2009 3:20 PM

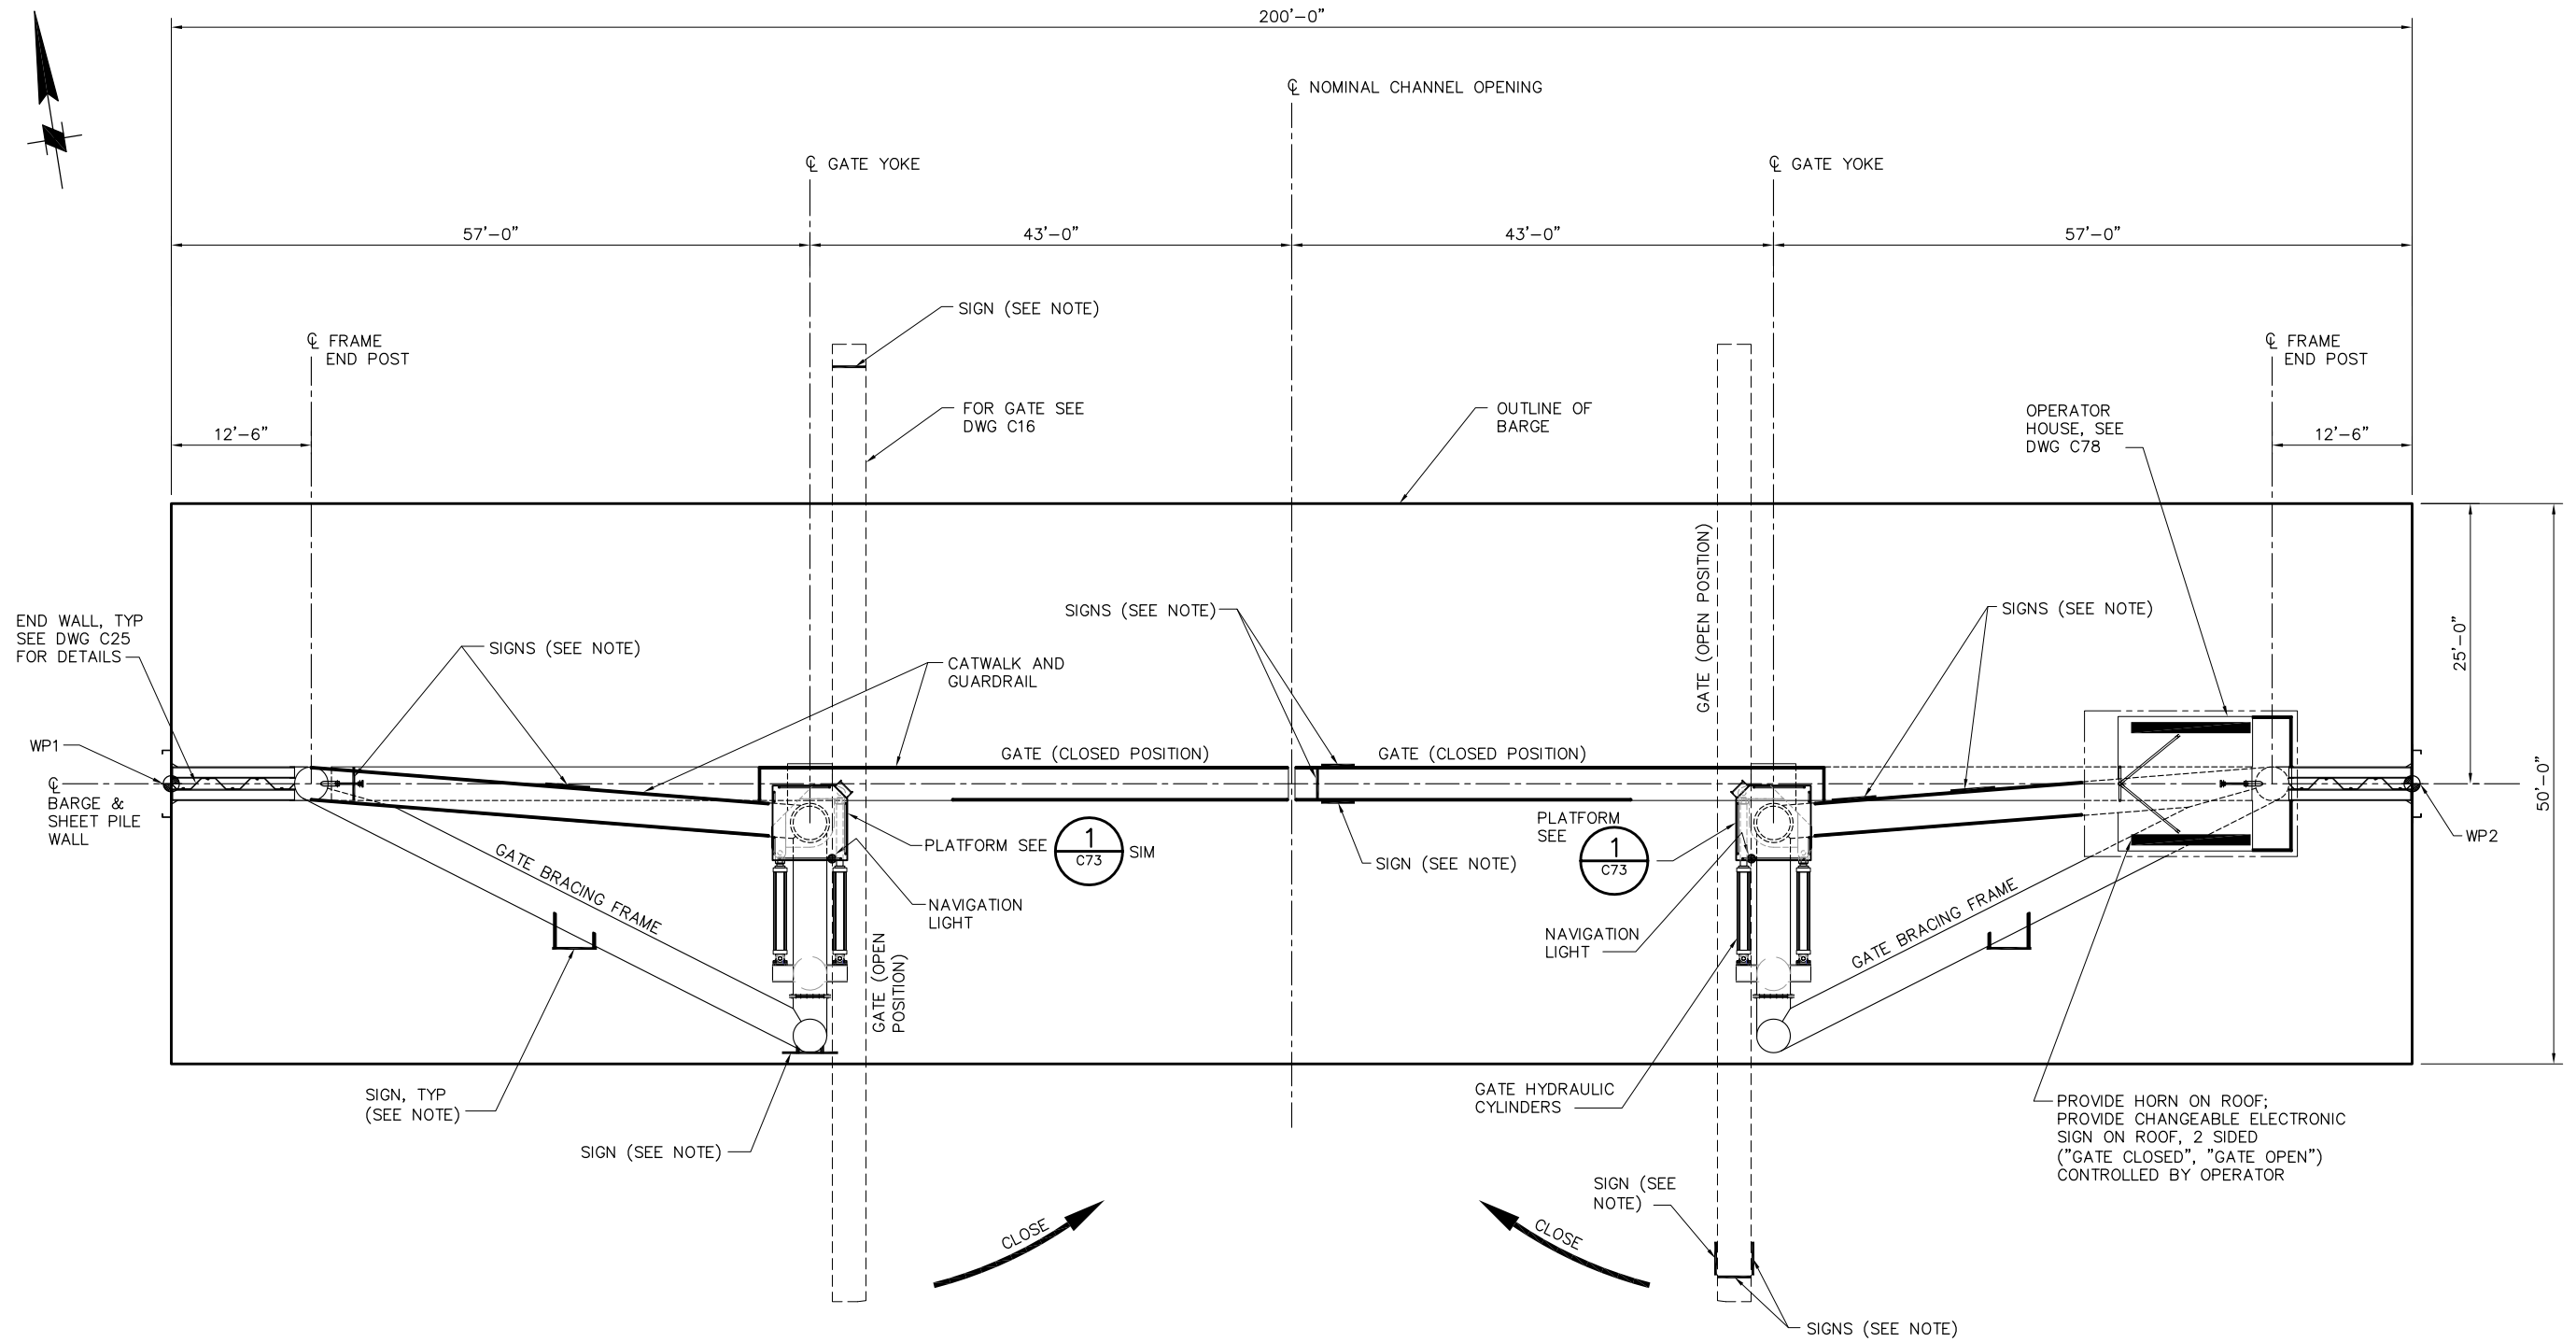

BARGE PLAN
SCALE: 1/8"= 1'-0"

 NOTE:
FOR SIGNAGE, SEE DRAWING C26.



**100% SUBMITTAL
REVISION 1**


IF SHEET IS LESS THAN 22" x 34"
IT IS A REDUCED PRINT -
SCALE REDUCED ACCORDINGLY.

REVISION	DESCRIPTION	BY	DATE

 San Luis & Delta-Mendota Water Authority 842 6th Street, Suite 7 PO Box 2157 Los Banos, California 93635	 2001 N. Main Street, Suite 360 Walnut Creek, California 94596 (925) 944-5411	2-GATES FISH PROTECTION DEMONSTRATION PROJECT		DATE 10/02/09
		OLD RIVER BARGE GENERAL ARRANGEMENT PLAN		SHEET 20 OF 78
		C14		

DSGN CBS	DR AB/EP	CHK TDB
JOB NO. 6097-03	SUBMITTED BY RMR	

P:\6097-03 SWC GATE DESIGN\CADD\DWG\609703-C15.DWG 9/29/2009 3:30 PM

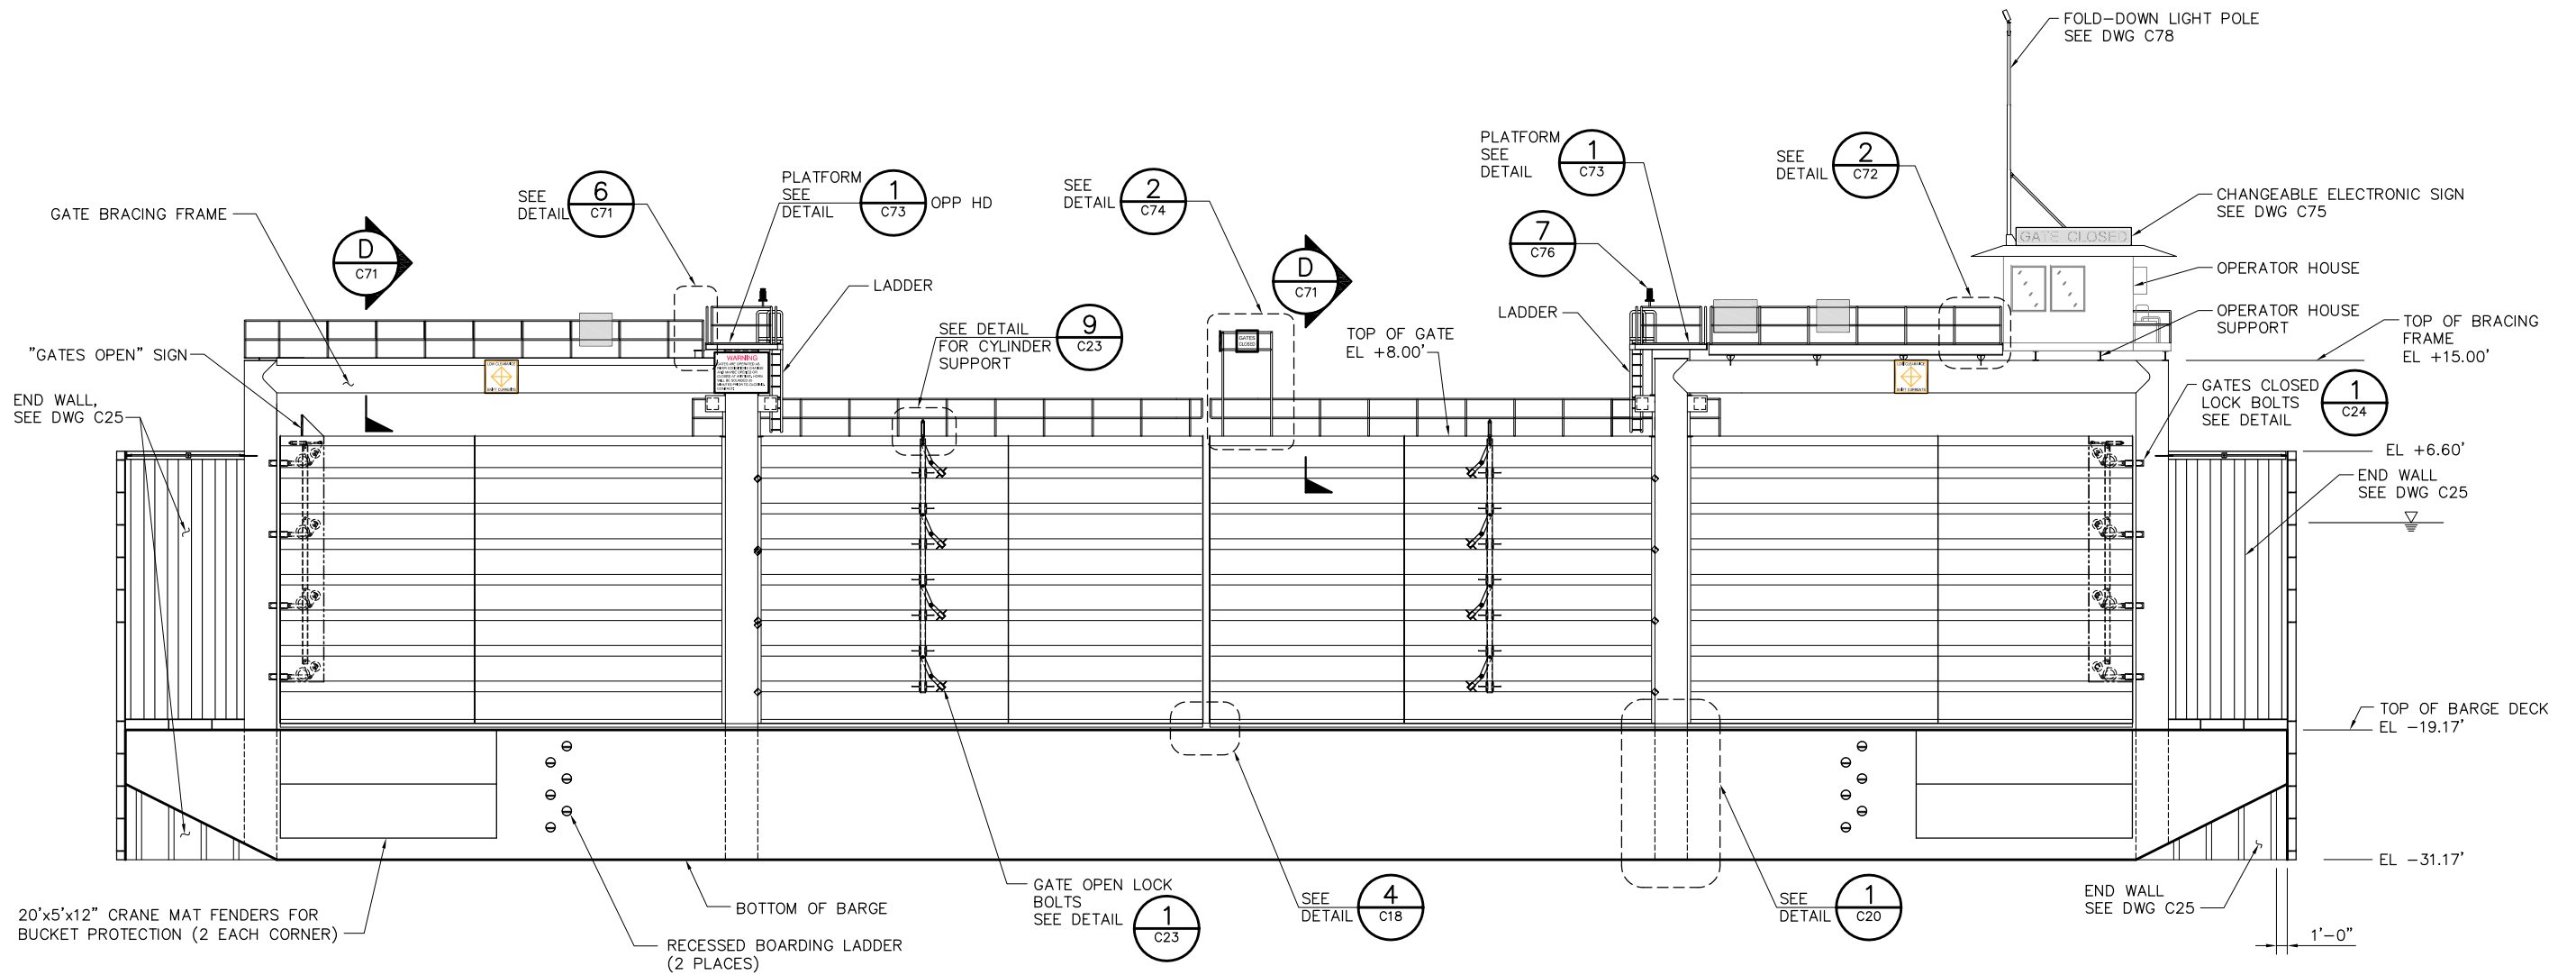

ELEVATION
SCALE: 1/8"= 1'-0"

NOTE: GATES SHOWN IN CLOSED POSITION

NOTES:

1. FOR SIGNAGE SEE DRAWING C26.
2. FOR CATWALK STAIRWAY SEE DRAWINGS C11 AND C12.

8'-0" 0'-0" 8'-0" 16'-0"
SCALE: 1/8"=1'-0"

**100% SUBMITTAL
REVISION 1**

IF SHEET IS LESS THAN 22" x 34"
IT IS A REDUCED PRINT -
SCALE REDUCED ACCORDINGLY.

REVISION	DESCRIPTION	BY	DATE



San Luis & Delta-Mendota Water Authority
842 6th Street, Suite 7
PO Box 2157
Los Banos, California 93635



2001 N. Main Street, Suite 360
Walnut Creek, California 94596
(925) 944-5411

DSGN	JMB	DR	AB/EP	CHK	TDB
JOB NO.	6097-03	SUBMITTED BY	RMR		


2-GATES FISH PROTECTION
DEMONSTRATION PROJECT

OLD RIVER
BARGE GENERAL ARRANGEMENT
ELEVATION

DATE 10/02/09



SHEET 21 OF 78

C15

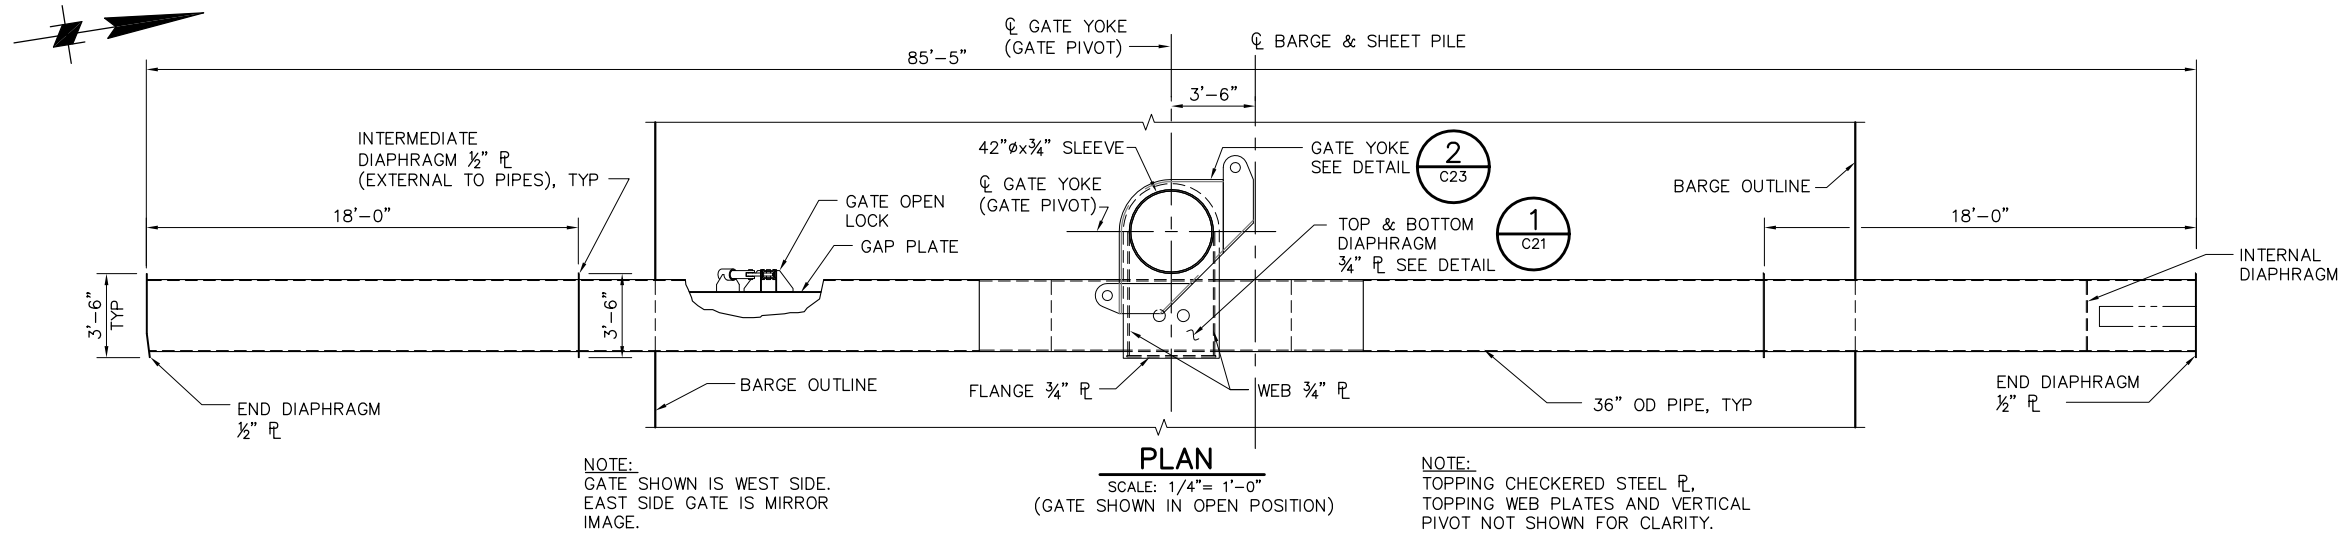

WELDING NOTES:

1. ALL GATE AND PIPE FRAMING STRUCTURAL WELDS SHALL BE COMPLETE JOINT PENETRATION (CJP) WELDS UON.
2. BACKING BARS SHALL NOT BE LEFT IN PLACE
3. ALL WELDS SHALL BE PREQUALIFIED.
4. ALL WELDING AND NON-DESTRUCTIVE TESTING (N.D.T.) INSPECTIONS SHALL BE IN ACCORDANCE WITH AWS-D1.1.

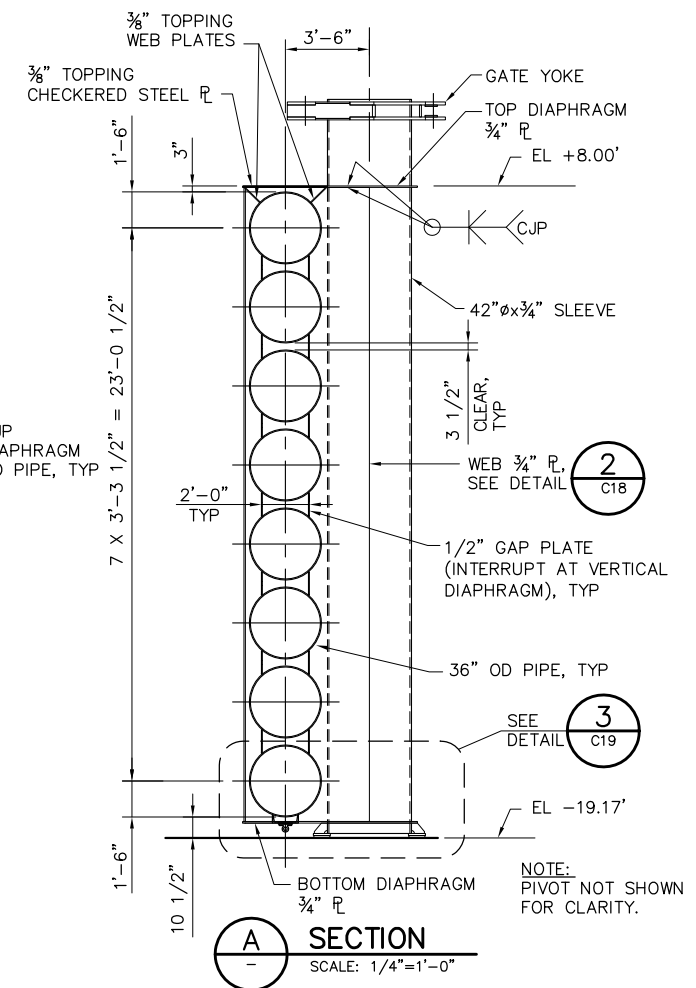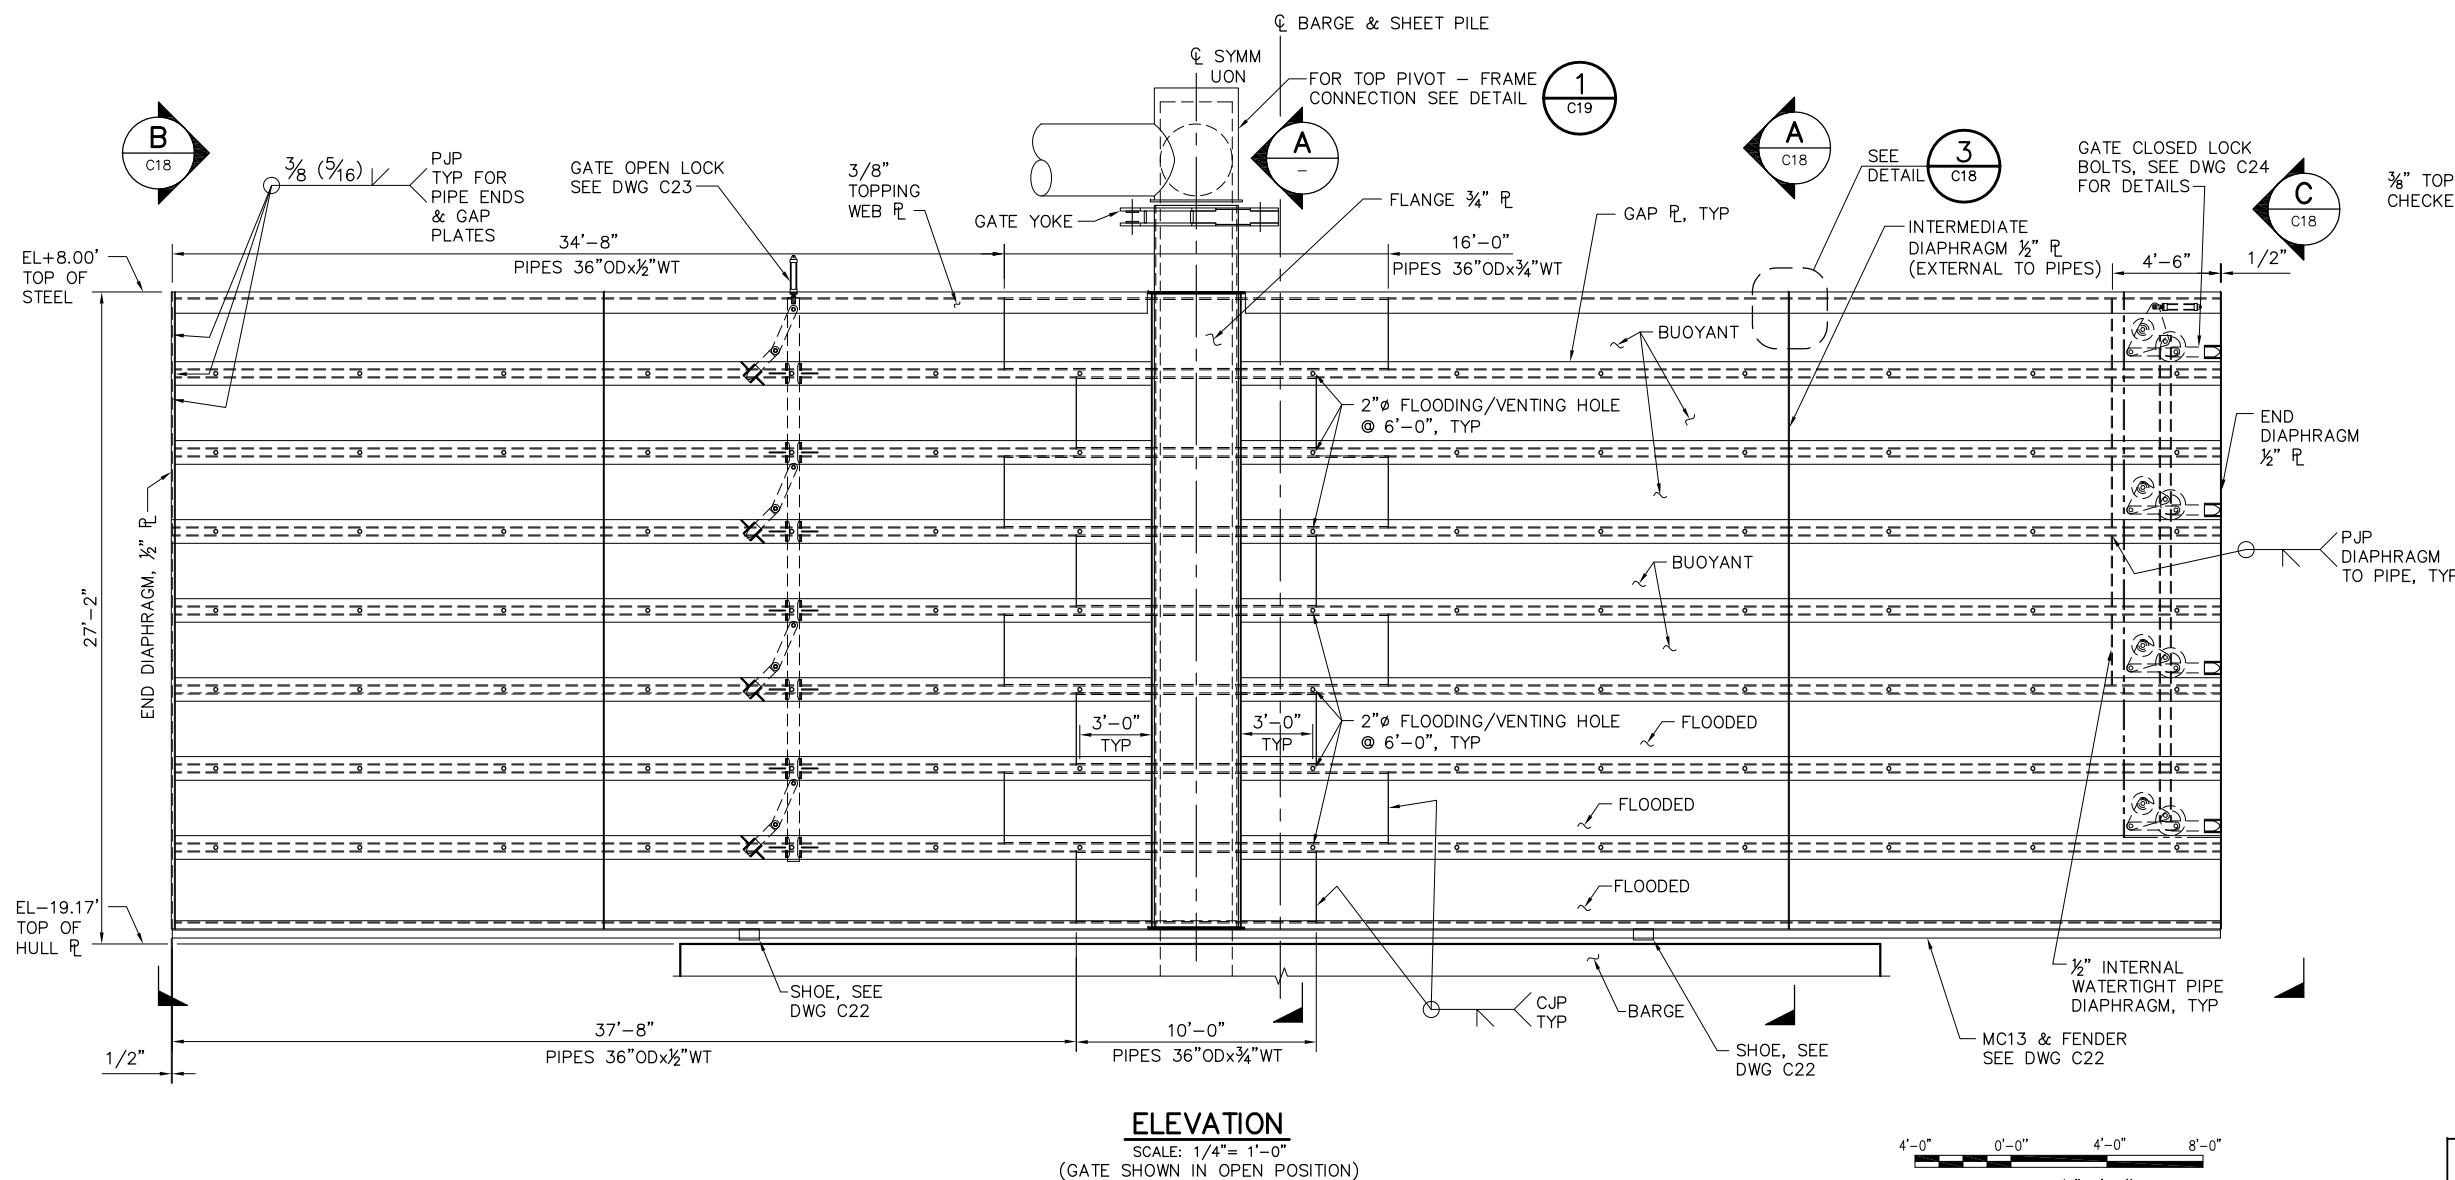

**100% SUBMITTAL
REVISION 1**

IF SHEET IS LESS THAN 22" x 34"
IT IS A REDUCED PRINT -
SCALE REDUCED ACCORDINGLY.

P:\6097-03 SWC GATE DESIGN\CADD\DWG\609703-C16.DWG 10/1/2009 8:46 AM

REVISION	DESCRIPTION	BY	DATE



San Luis & Delta-Mendota Water Authority
842 6th Street, Suite 7
PO Box 2157
Los Banos, California 93635



2001 N. Main Street, Suite 360
Walnut Creek, California 94596
(925) 944-5411

DSGN	JMB	DR	AB/EP	CHK	TDB
JOB NO.	6097-03	SUBMITTED BY	RMR		

2-GATES FISH PROTECTION
DEMONSTRATION PROJECT


DATE 10/02/09

SHEET 22 OF 78


OLD RIVER
GATE SCANTLINGS

C16


P:\6097-03 SWC GATE DESIGN\CADD\DWG\609703-C17.DWG 9/29/2009 11:54 AM

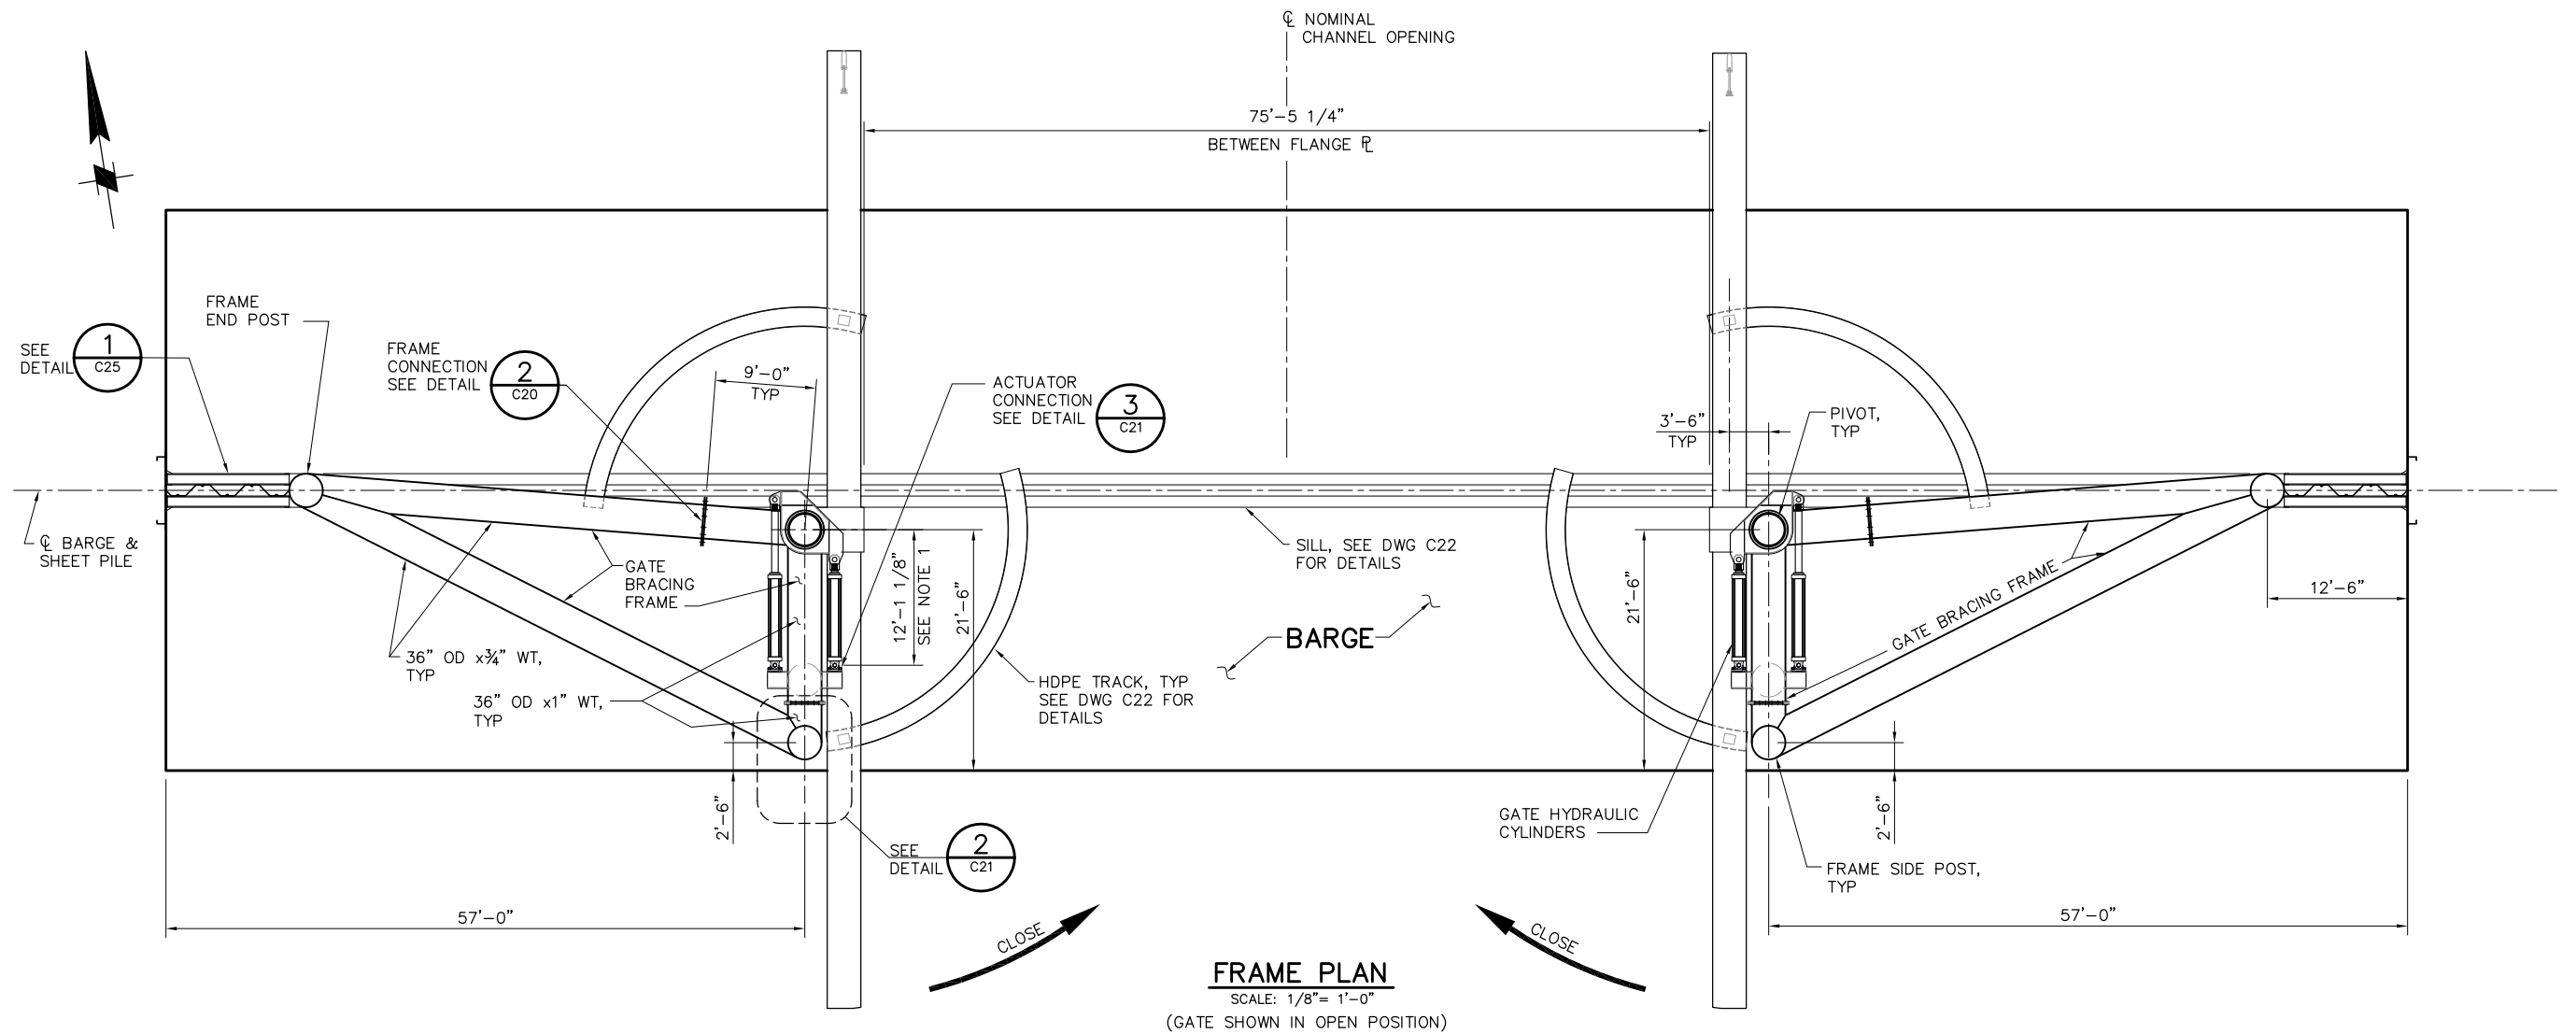

FRAME PLAN
SCALE: 1/8" = 1'-0"
(GATE SHOWN IN OPEN POSITION)

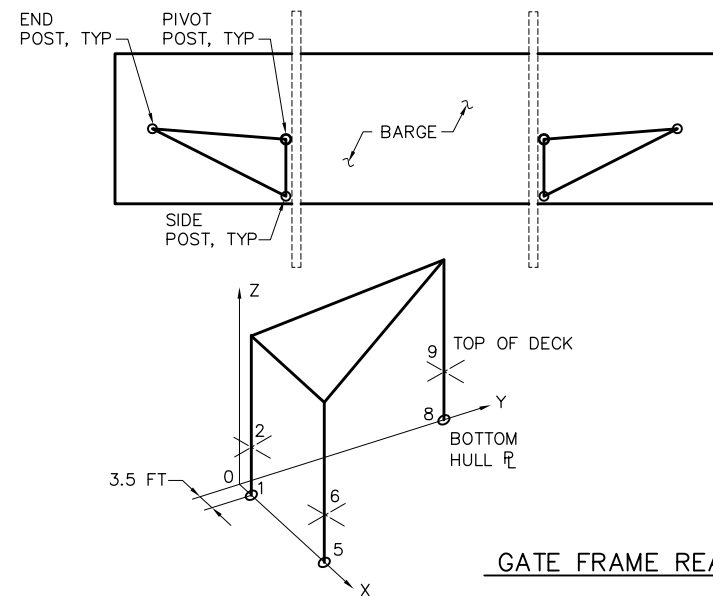

GATE FRAME REACTIONS

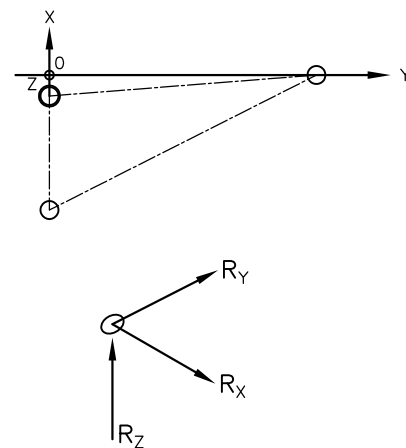

SERVICE LOAD REACTIONS (INCLUDES A 1.2 FACTOR)
(FOR LRFD USE A 1.6 FACTOR WITH THESE REACTIONS)

LOCATION ON BARGE	NODE	R _X (KIP)	R _Y (KIP)	R _Z (KIP)	DESCRIPTION
BOTTOM HULL FL	1	+240 -240	+30 -30	+300 -130	PIVOT
	5	+250 -250	-60 +60	-130 +230	SIDE POST
	8	+50 -50	+40 -40	+100	END POST
TOP OF DECK	2	+710 -710	-50 +50	0	PIVOT
	6	+410 -410	-90 +90	0	SIDE POST
	9	+100 -100	-70 +70	0	END POST

NOTE: CONTRACTOR SHALL PROVIDE A BARGE ADEQUATE TO SUPPORT THESE LOADS.

NOTES:

1. DIMENSION MAY VARY DEPENDING ON ACTUATOR VENDER.

8'-0" 0'-0" 8'-0" 16'-0"
SCALE: 1/8"=1'-0"

**100% SUBMITTAL
REVISION 1**

IF SHEET IS LESS THAN 22" x 34"
IT IS A REDUCED PRINT -
SCALE REDUCED ACCORDINGLY.

REVISION	DESCRIPTION	BY	DATE



San Luis & Delta-Mendota Water Authority
842 6th Street, Suite 7
PO Box 2157
Los Banos, California 93635



2001 N. Main Street, Suite 360
Walnut Creek, California 94596
(925) 944-5411

DSGN	CBS	DR	AB	CHK	TDB
JOB NO.	6097-03	SUBMITTED BY	RMR		






2-GATES FISH PROTECTION
DEMONSTRATION PROJECT

DATE 10/02/09


SHEET 23 OF 78

**OLD RIVER
GATE FRAMING LAYOUT**


C17

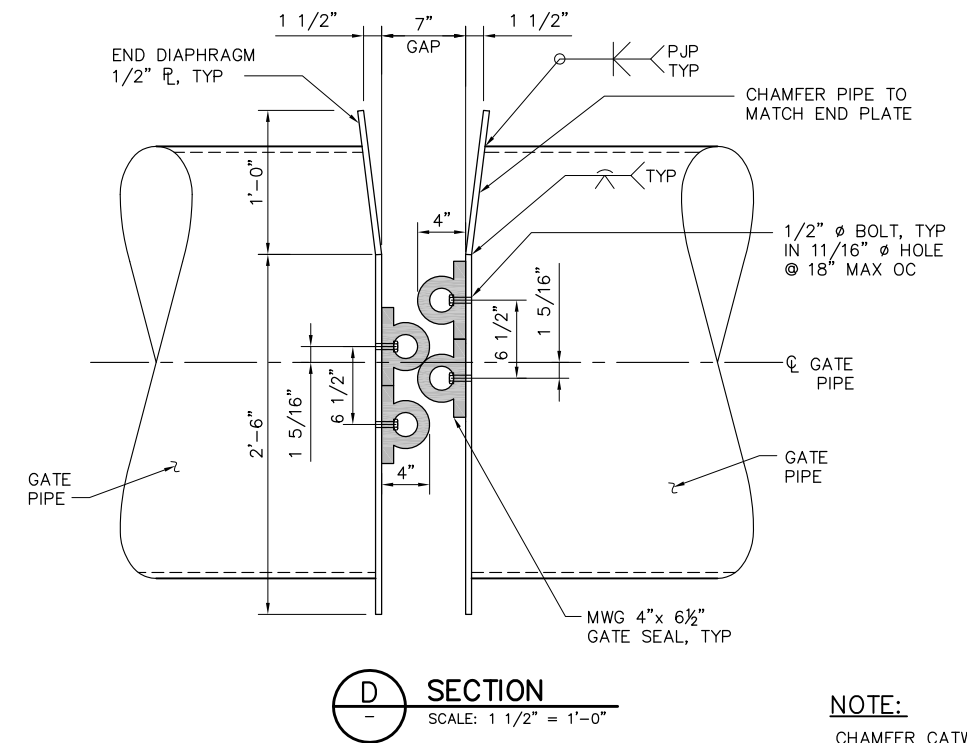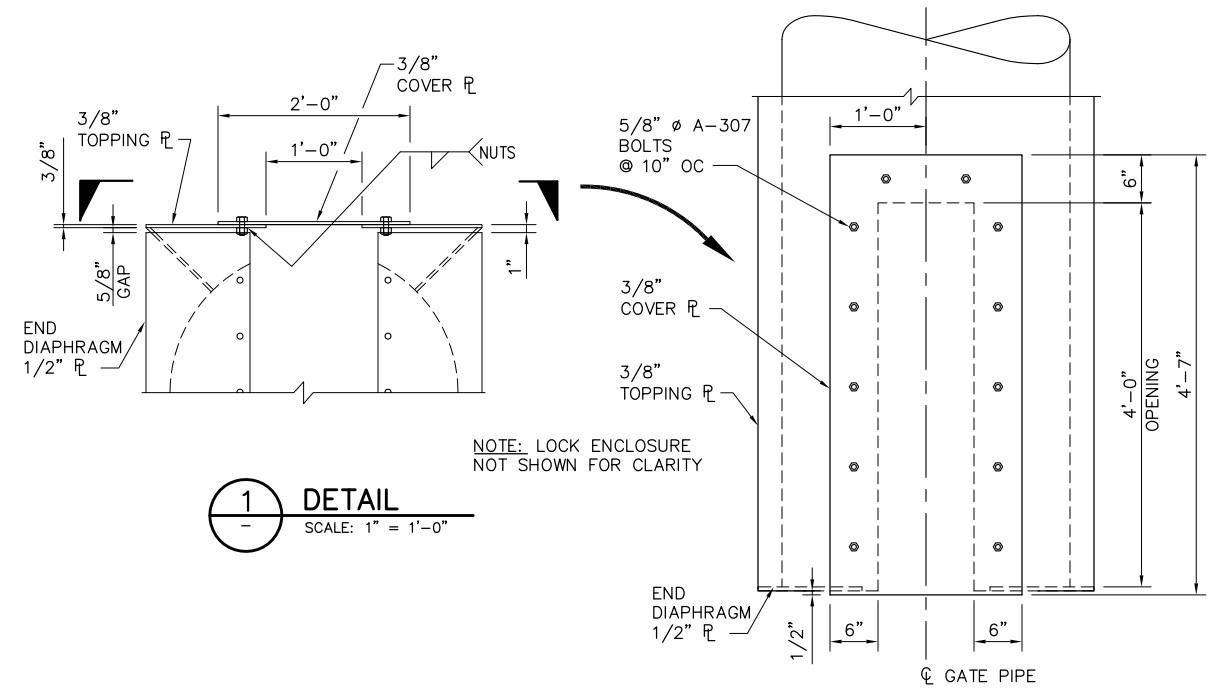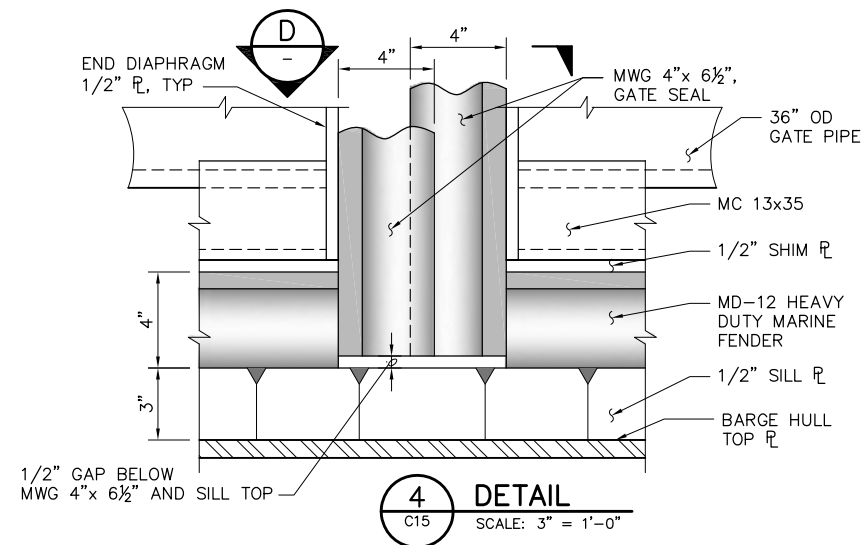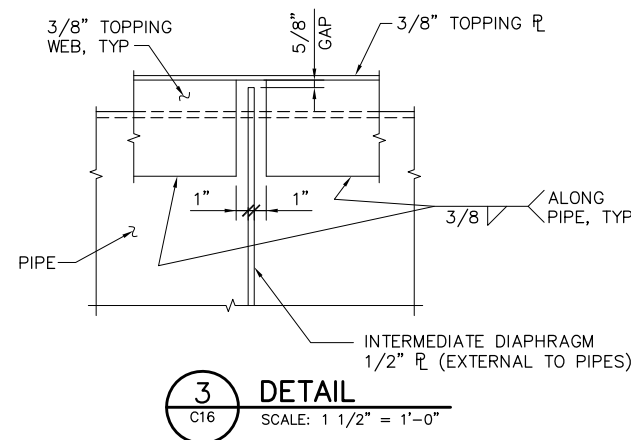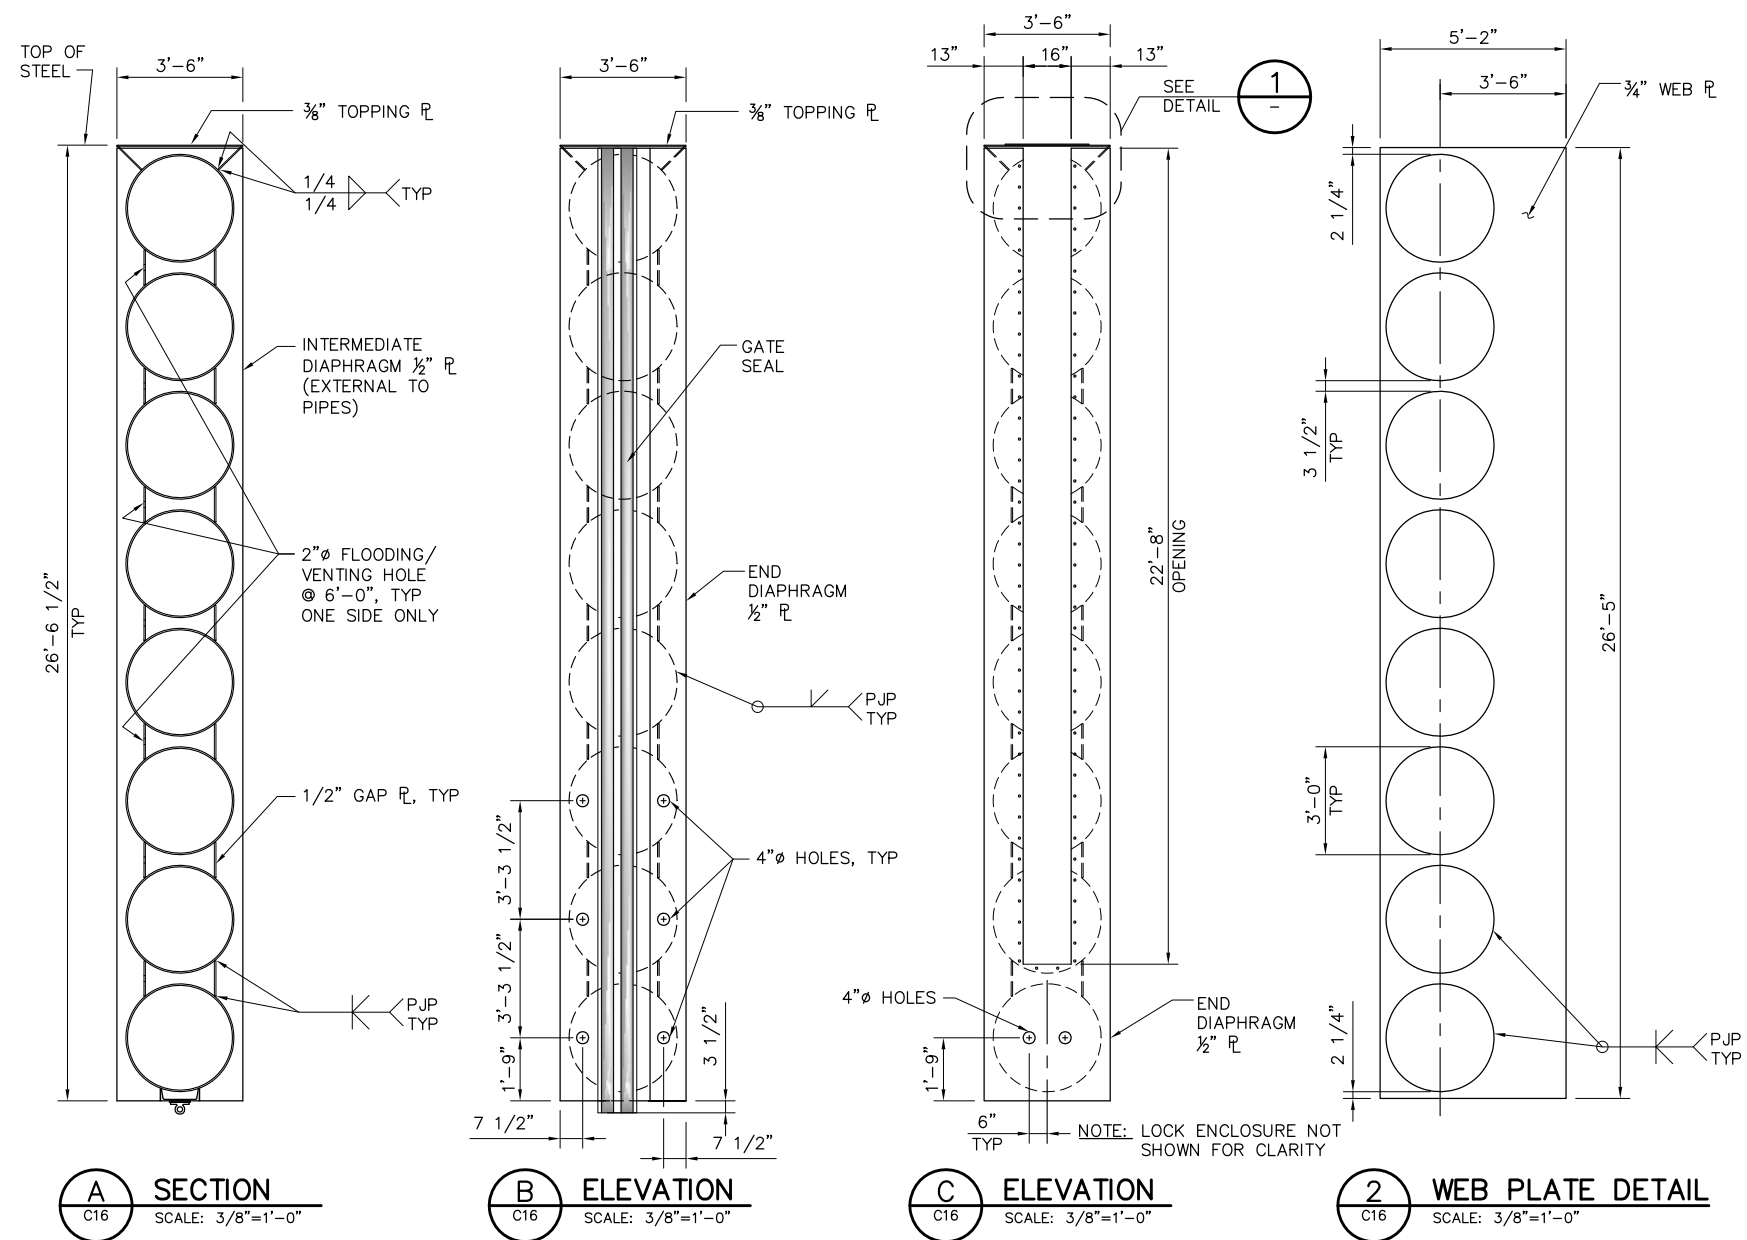

NOTE:
CHAMFER CATWALK TOPPING
CHECKER PLATE ABOVE GATE
MATING ENDS, TO PERMIT
RELATIVE OPENING MOVEMENTS.

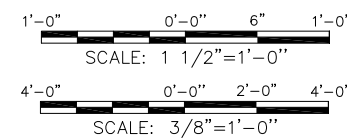

REVISION	DESCRIPTION	BY	DATE

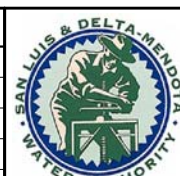

San Luis & Delta-Mendota Water Authority
842 6th Street, Suite 7
PO Box 2157
Los Banos, California 93635



2001 N. Main Street, Suite 360
Walnut Creek, California 94596
(925) 944-5411

DSGN JMB	DR AB/EP	CHK TDB
JOB NO. 6097-03	SUBMITTED BY RMR	

2-GATES FISH PROTECTION
DEMONSTRATION PROJECT


OLD RIVER
GATE STRUCTURAL DETAILS ,
SHEET 1

DATE 10/02/09


SHEET 24 OF 78

C18


P:\6097-03 SMC GATE DESIGN\CADD\DWG\609703-C19.DWG 9/29/2009 2:20 PM

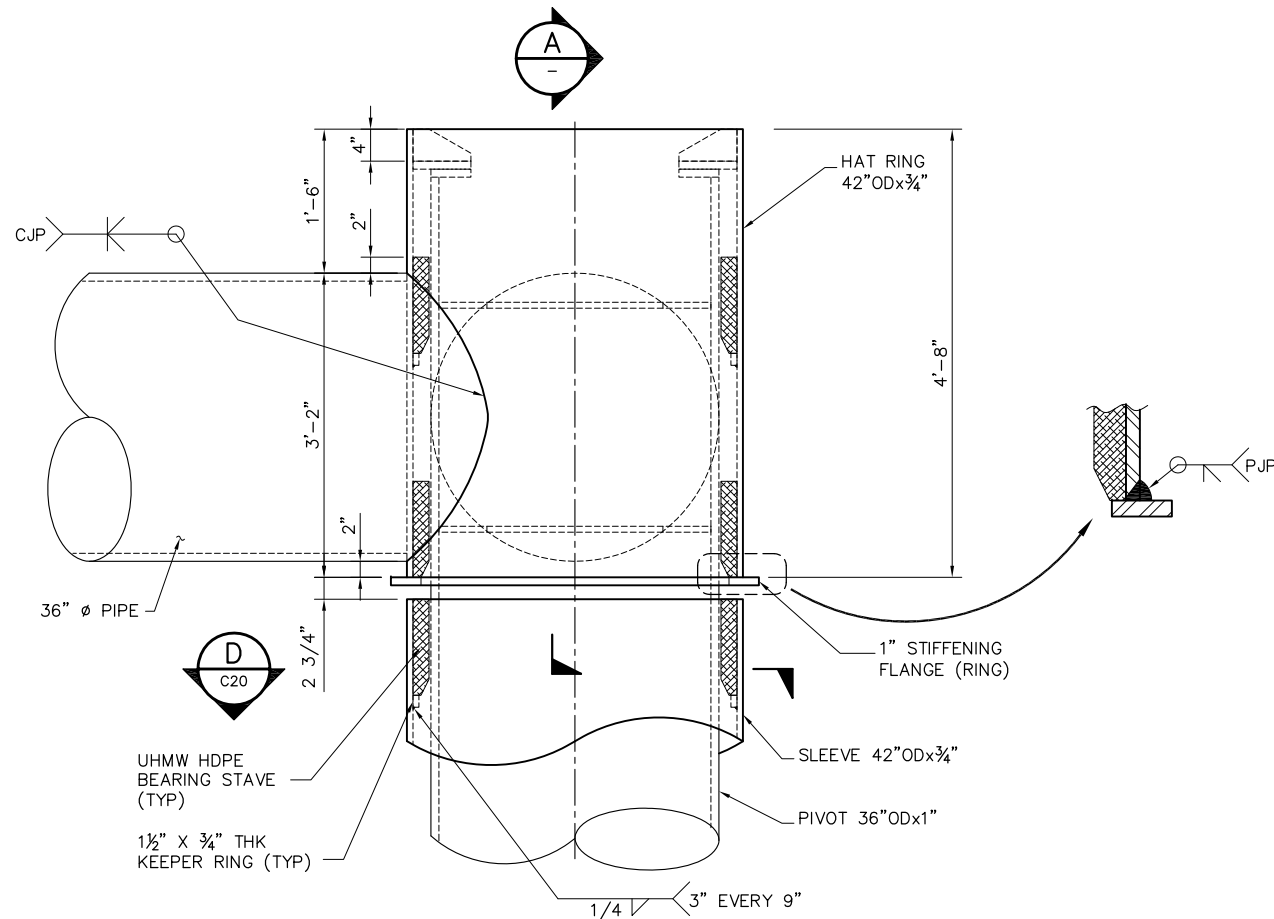


1 TOP PIVOT - FRAME CONNECTION
C16 SCALE: 1" = 1'-0"

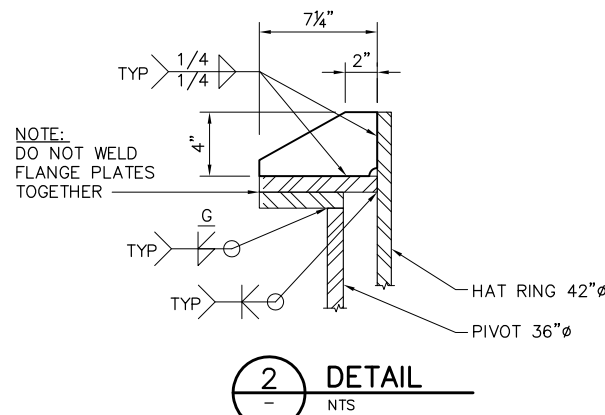

2 DETAIL
NTS

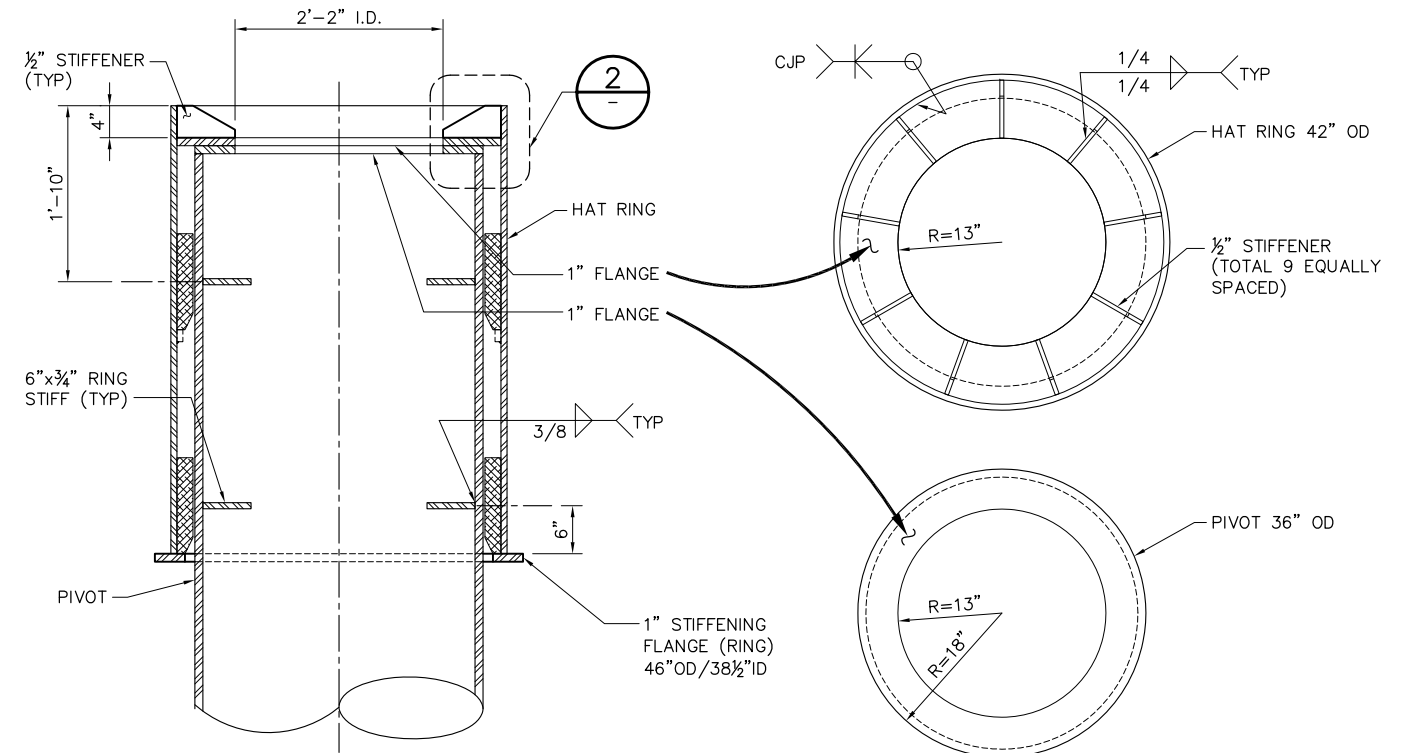

A SECTION
SCALE: 1" = 1'-0"

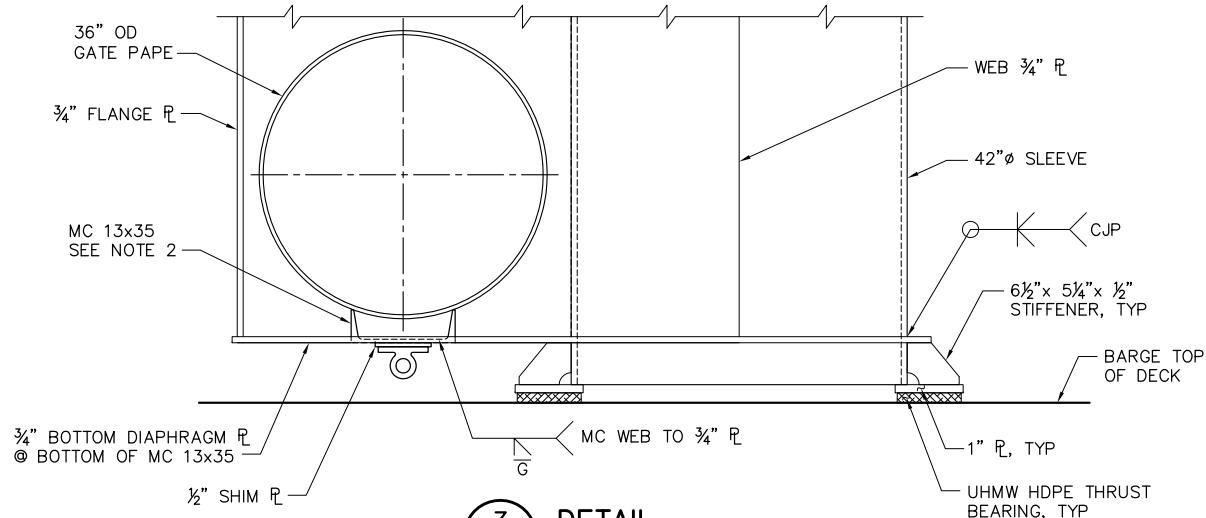

3 DETAIL
C16 SCALE: 1" = 1'-0"

NOTES:

- ALL STIFFENER WELDS SHALL BE SYMMETRICAL 1/4" MIN. FILLET WELDS U.N.O.
- NOTCH MC 13x35 WEB AROUND BOTTOM DIAPHRAGM PLATE AND WELD AS SHOWN.

1'-0" 0'-0" 1'-0" 2'-0"
SCALE: 1" = 1'-0"

**100% SUBMITTAL
REVISION 1**

IF SHEET IS LESS THAN 22" x 34"
IT IS A REDUCED PRINT -
SCALE REDUCED ACCORDINGLY.

REVISION	DESCRIPTION	BY	DATE



San Luis & Delta-Mendota Water Authority
842 6th Street, Suite 7
PO Box 2157
Los Banos, California 93635



2001 N. Main Street, Suite 360
Walnut Creek, California 94596
(925) 944-5411

DSGN	JMB/CBS	DR	AB/EP	CHK	TDB
JOB NO.	6097-03	SUBMITTED BY	RMR		

2-GATES FISH PROTECTION
DEMONSTRATION PROJECT








DATE 10/02/09

SHEET 25 OF 78

OLD RIVER
GATE STRUCTURAL DETAILS
SHEET 2


C19

P:\6097-03 SWC GATE DESIGN\CADD\DWG\609703-C20.DWG 9/29/2009 11:27 AM

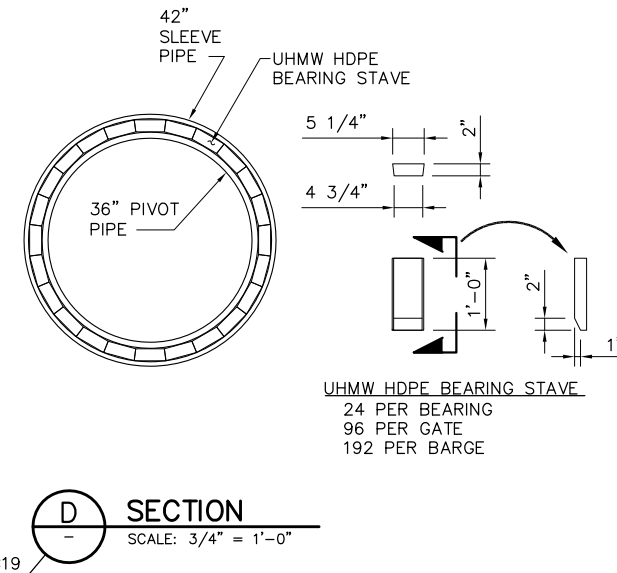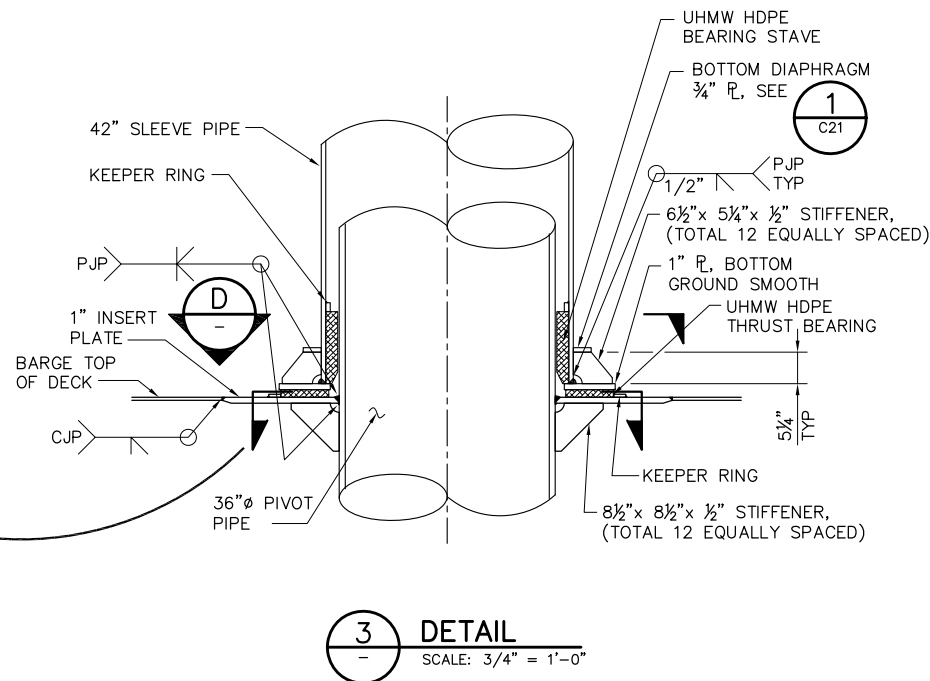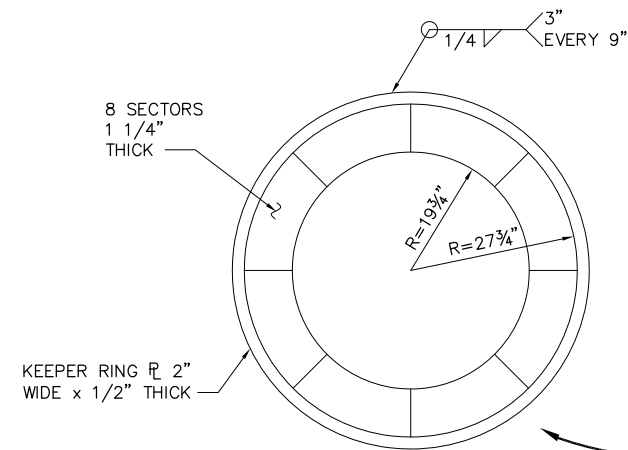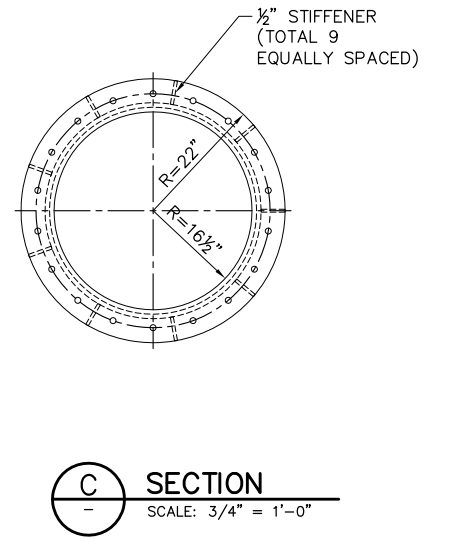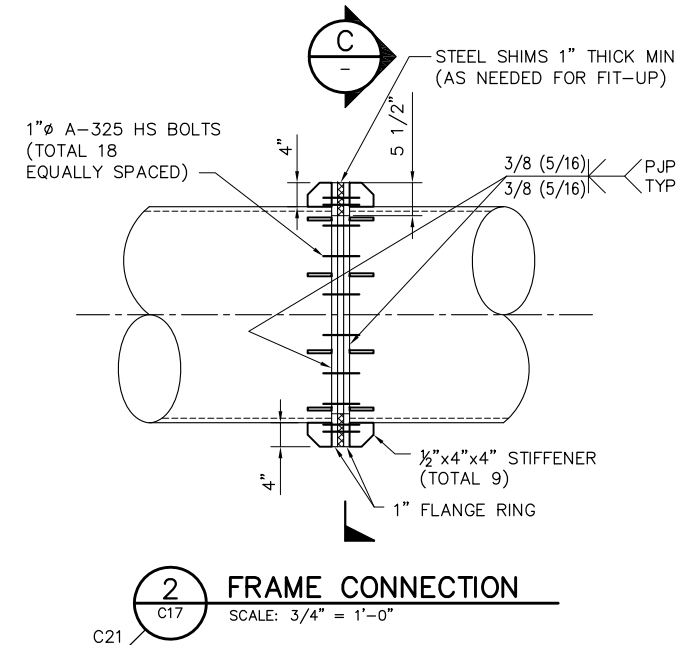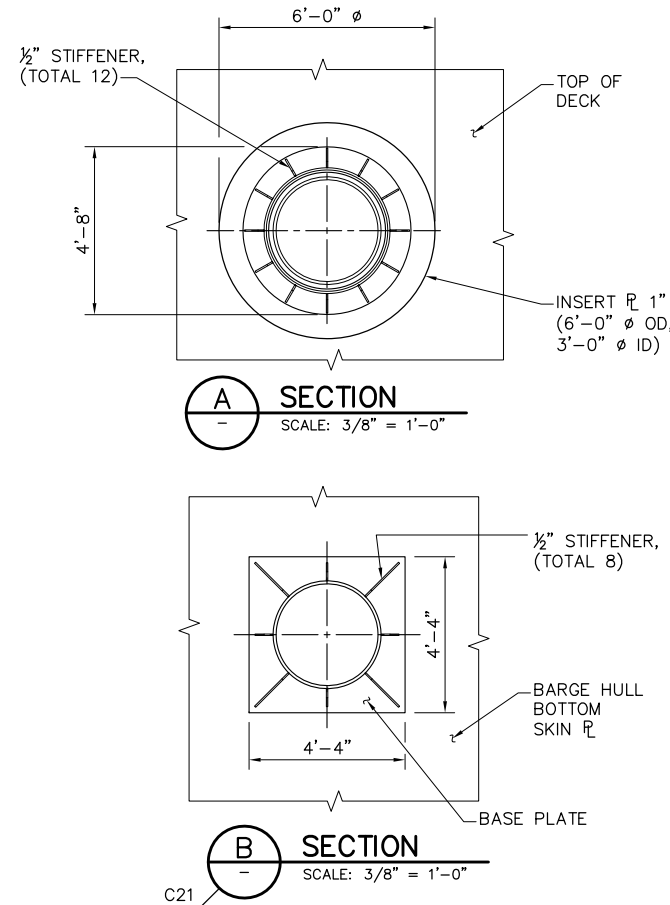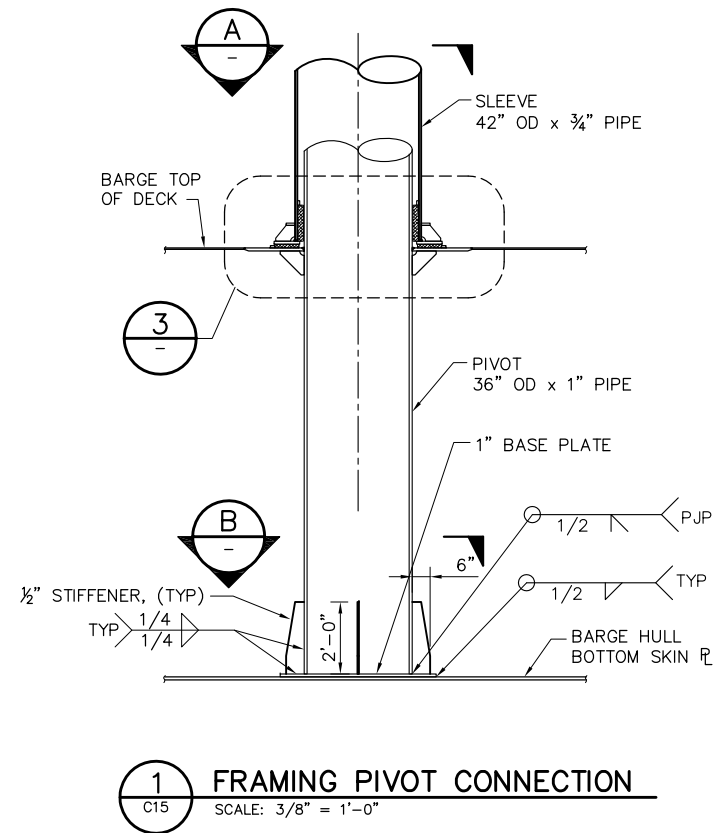

NOTES:

- ALL STIFFENER WELDS SHALL BE SYMMETRICAL 1/4" MIN. FILLET WELDS U.N.O.

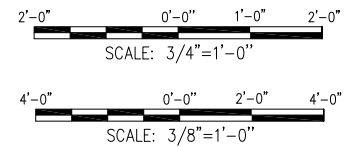

**100% SUBMITTAL
REVISION 1**

IF SHEET IS LESS THAN 22" x 34"
IT IS A REDUCED PRINT -
SCALE REDUCED ACCORDINGLY.

REVISION	DESCRIPTION	BY	DATE



San Luis & Delta-Mendota Water Authority
842 6th Street, Suite 7
PO Box 2157
Los Banos, California 93635



2001 N. Main Street, Suite 360
Walnut Creek, California 94596
(925) 944-5411

DSGN	JMB/CBS	DR	AB/EP	CHK	TDB
JOB NO.	6097-03	SUBMITTED BY	RMR		

2-GATES FISH PROTECTION
DEMONSTRATION PROJECT


OLD RIVER
GATE STRUCTURAL DETAILS
SHEET 3

DATE 10/02/09


SHEET 26 OF 78

C20


P:\6097-03 SWC GATE DESIGN\CADD\DWG\609703-C21.DWG 9/29/2009 3:48 PM

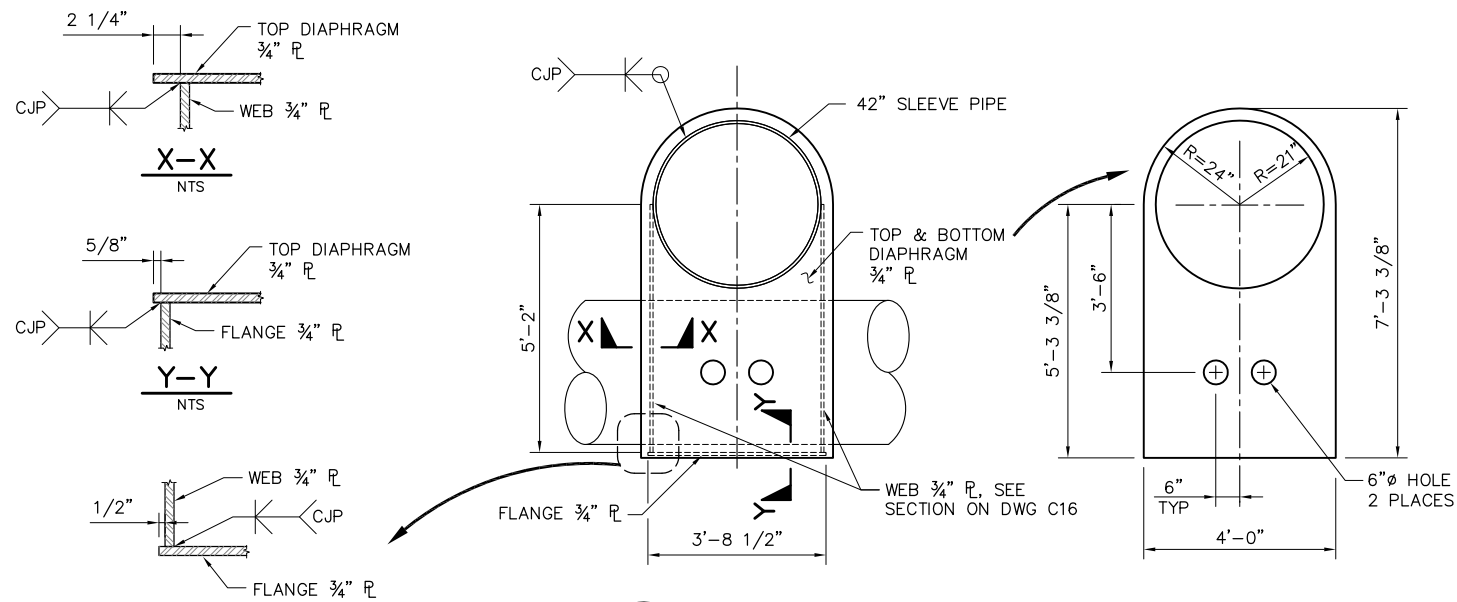


1 SLEEVE CONNECTION DETAIL
SCALE: 1/2" = 1'-0"

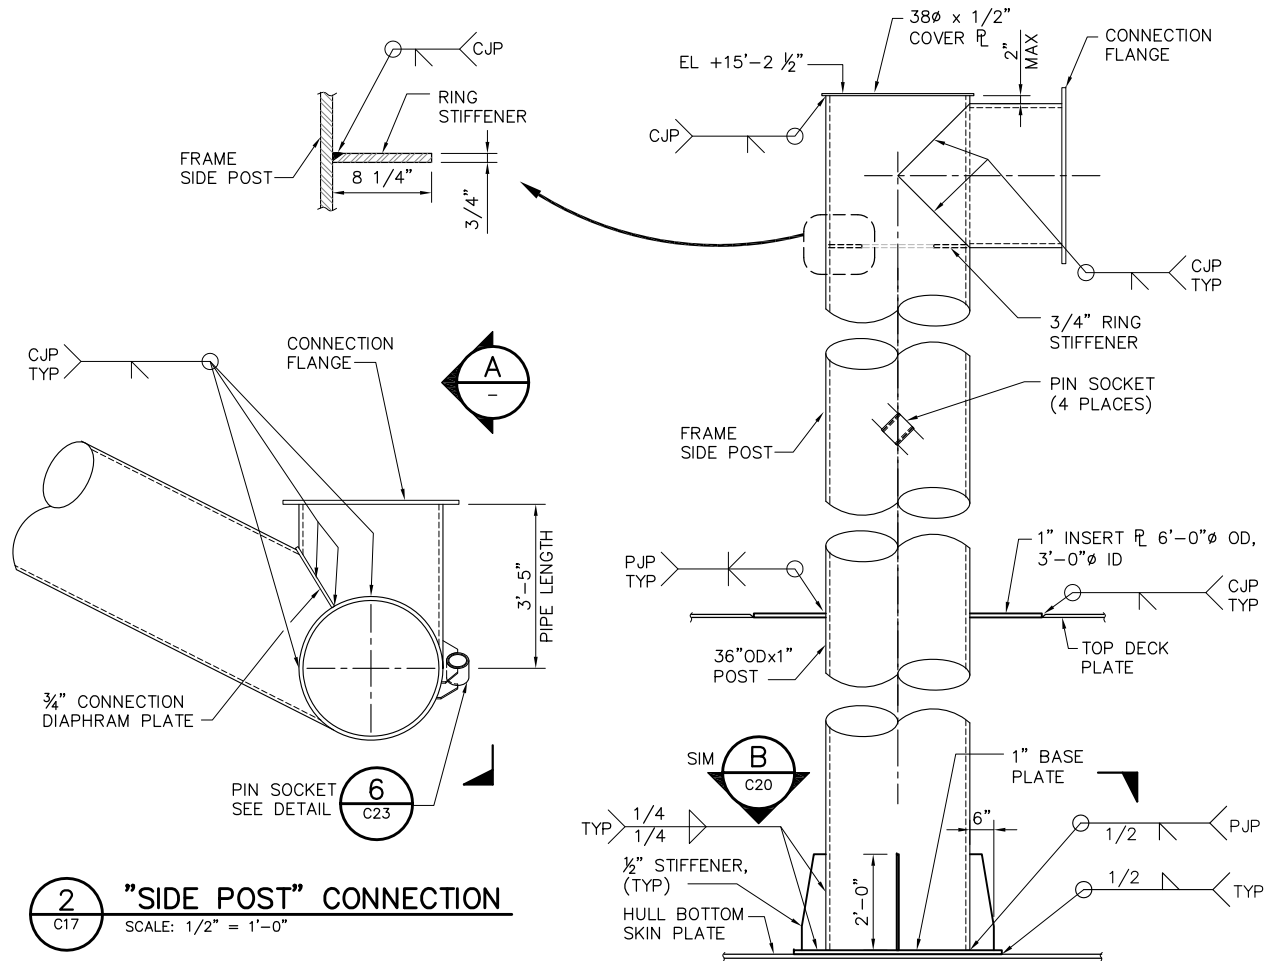


2 "SIDE POST" CONNECTION
SCALE: 1/2" = 1'-0"

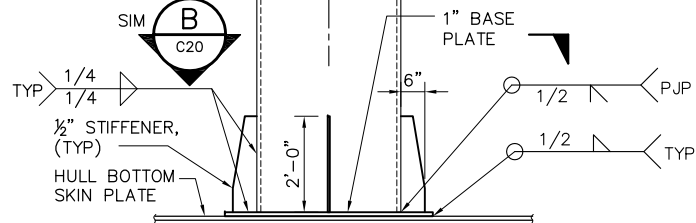


A ELEVATION
SCALE: 1/2" = 1'-0"

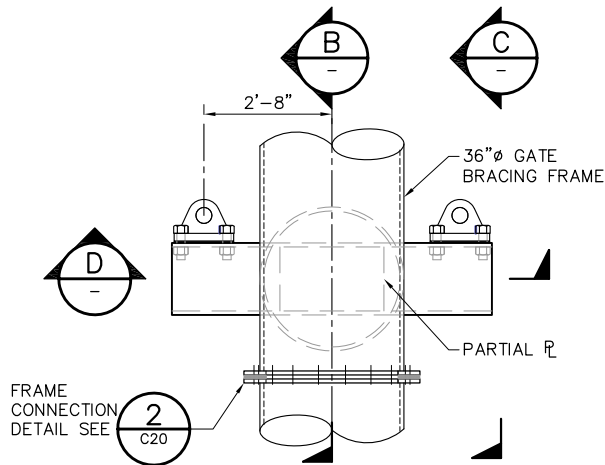


3 PLAN - ACTUATOR CONNECTION DETAIL
SCALE: 1/2" = 1'-0"

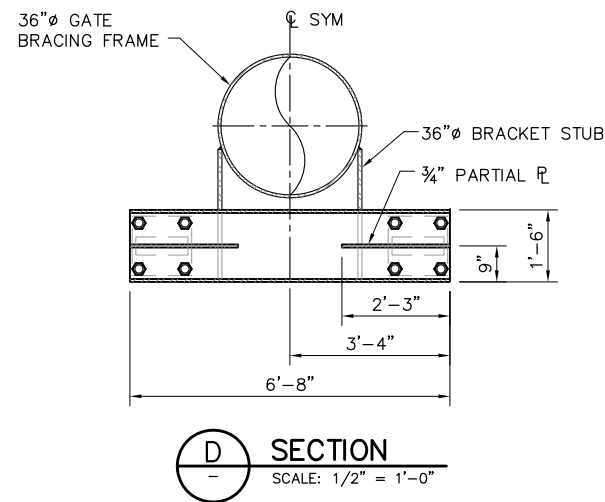


D SECTION
SCALE: 1/2" = 1'-0"

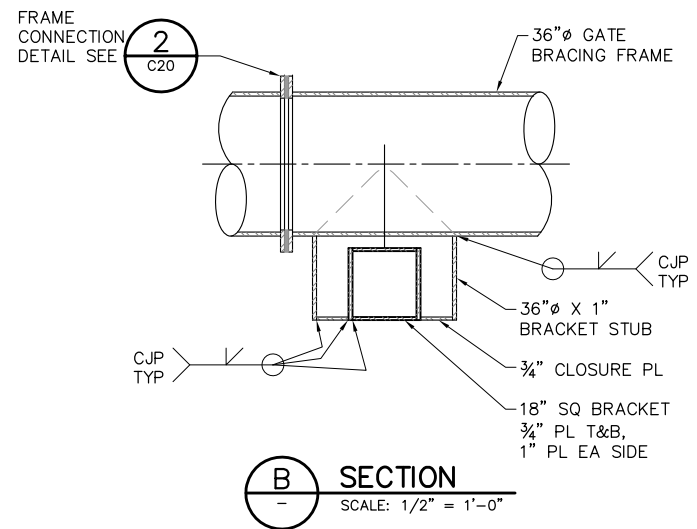

B SECTION
SCALE: 1/2" = 1'-0"

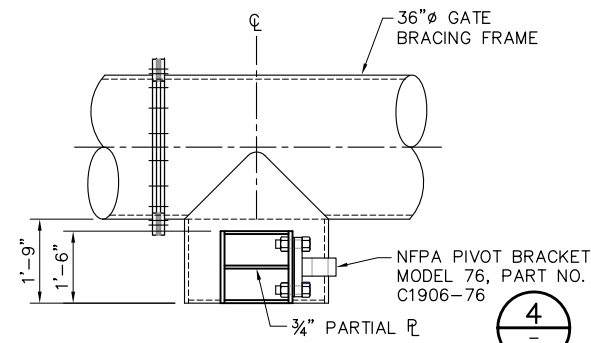

C SECTION
SCALE: 1/2" = 1'-0"

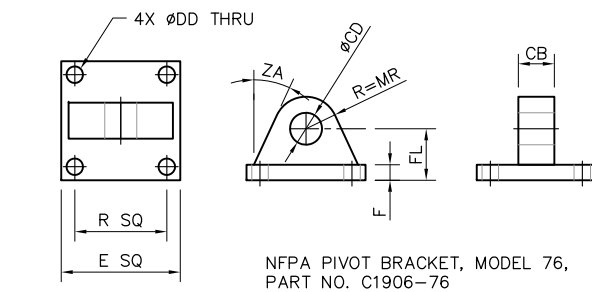

4 DETAIL
SCALE: 1" = 1'-0"


CB	CD	DD	E	F	FL	MR	R	ZA
4.500	4.000	2.062	14.875	1.938	6.438	4.000	11.500	25"

2'-0" 0'-0" 2'-0" 4'-0"
SCALE: 1/2" = 1'-0"

**100% SUBMITTAL
REVISION 1**

IF SHEET IS LESS THAN 22" x 34"
IT IS A REDUCED PRINT -
SCALE REDUCED ACCORDINGLY.

REVISION	DESCRIPTION	BY	DATE

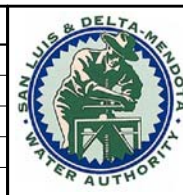

San Luis & Delta-Mendota Water Authority
842 6th Street, Suite 7
PO Box 2157
Los Banos, California 93635



2001 N. Main Street, Suite 360
Walnut Creek, California 94596
(925) 944-5411

DSGN	JMB	DR	AB/EP	CHK	CBS
JOB NO.	6097-03	SUBMITTED BY	RMR		

2-GATES FISH PROTECTION
DEMONSTRATION PROJECT


DATE 10/02/09

SHEET 27 OF 78


OLD RIVER
GATE STRUCTURAL DETAILS,
SHEET 4

C21


P:\6097-03 SWC GATE DESIGN\CADD\DWG\609703-C22.DWG 9/1/2009 9:37 AM

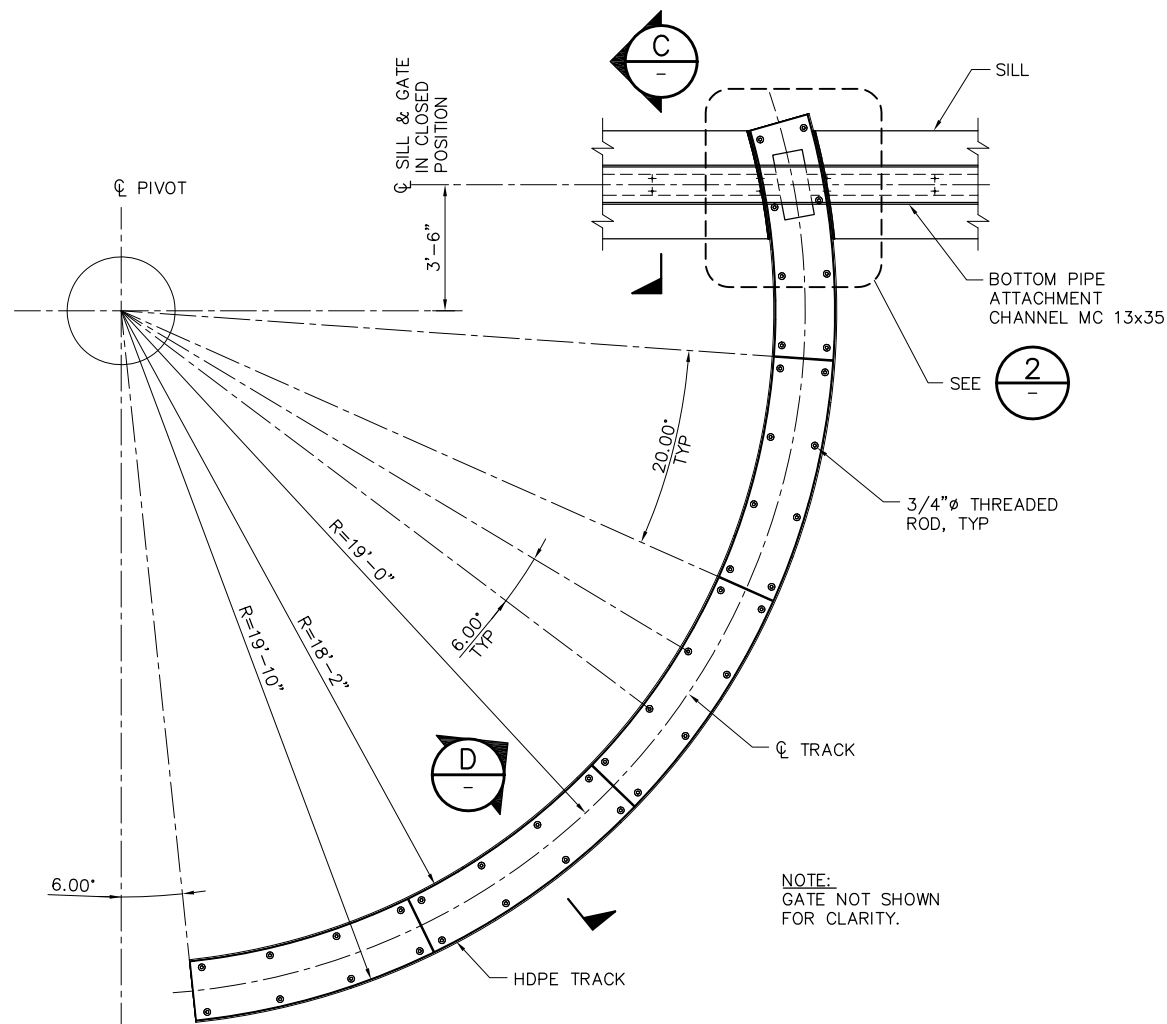


1 TRACK DETAIL
SCALE: 3/8" = 1'-0"

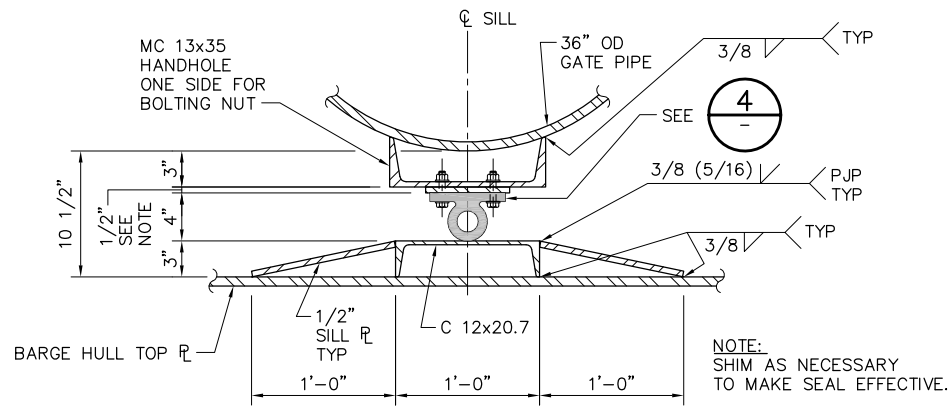


2 SECTION
SCALE: 1 1/2" = 1'-0"

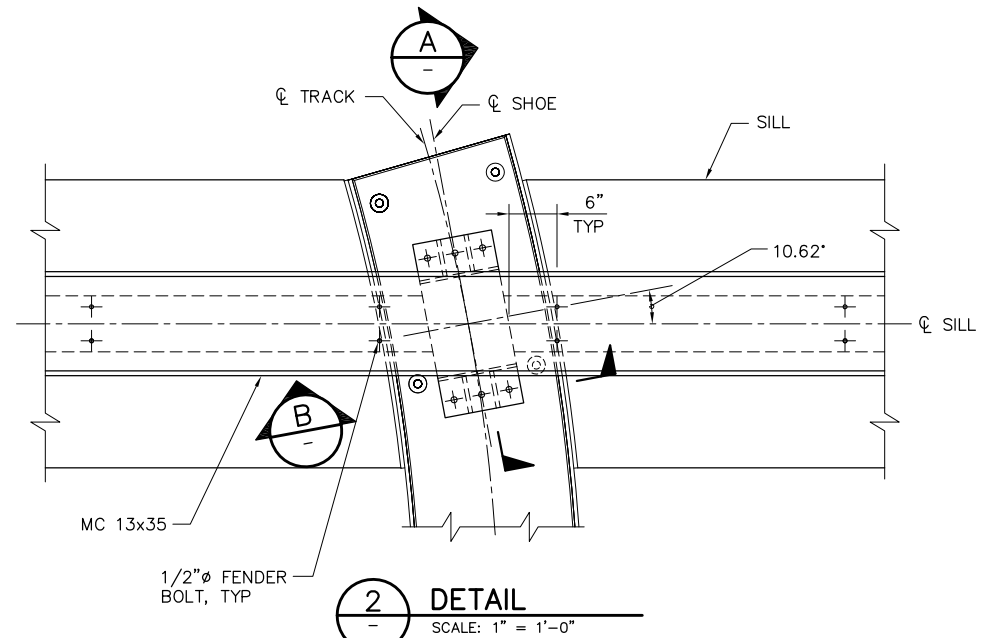


3 DETAIL
SCALE: 1" = 1'-0"

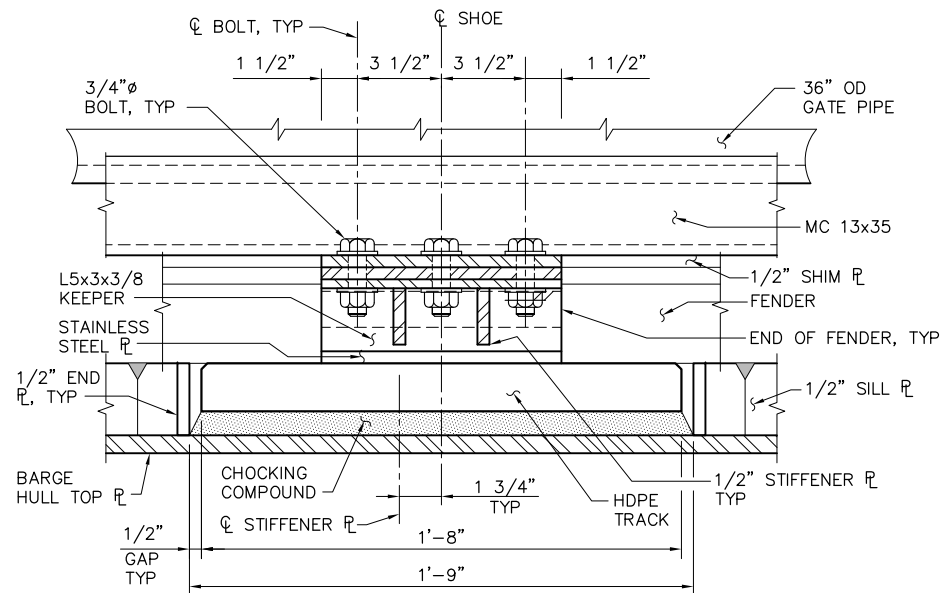


4 SECTION
SCALE: 3" = 1'-0"

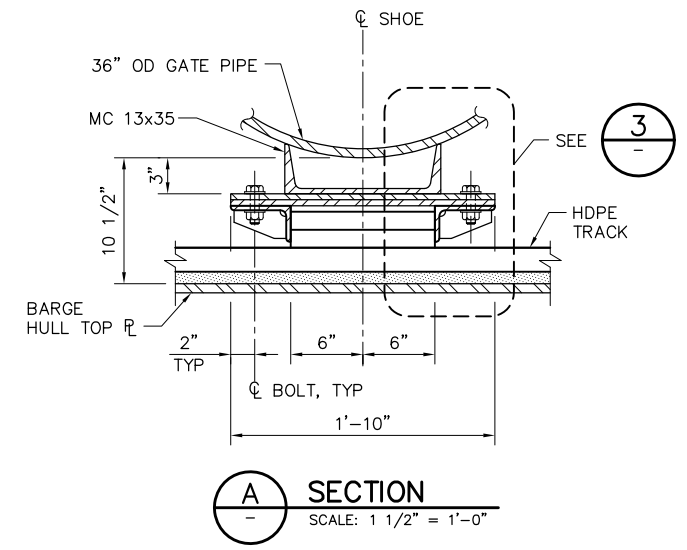


5 SECTION
SCALE: 1 1/2" = 1'-0"

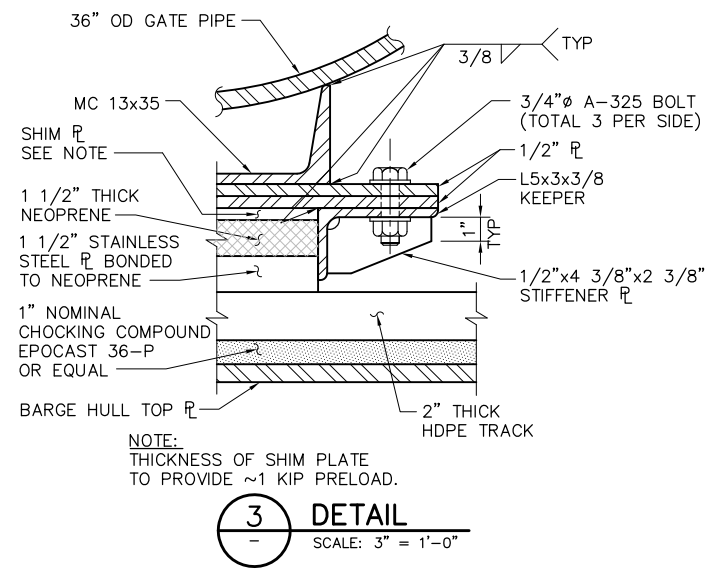


6 DETAIL
SCALE: 3" = 1'-0"

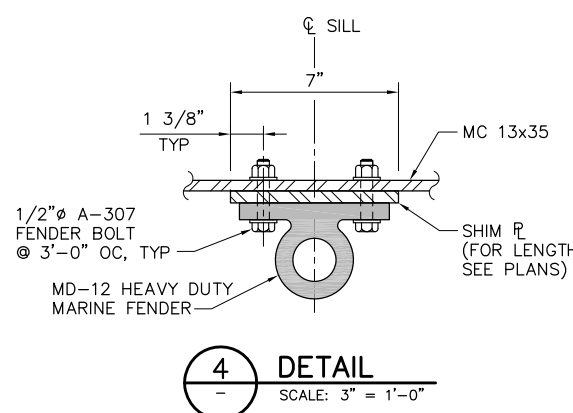

7 DETAIL
SCALE: 3" = 1'-0"

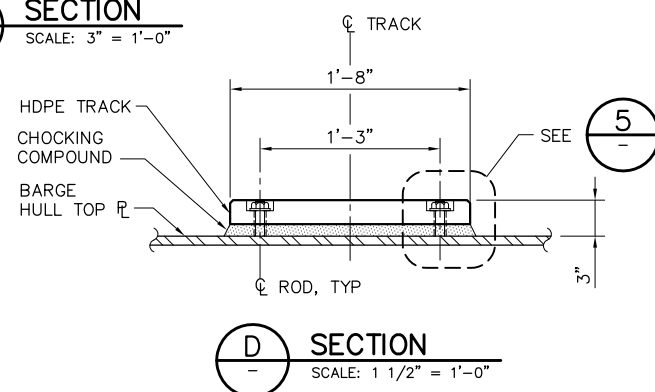

8 SECTION
SCALE: 1 1/2" = 1'-0"

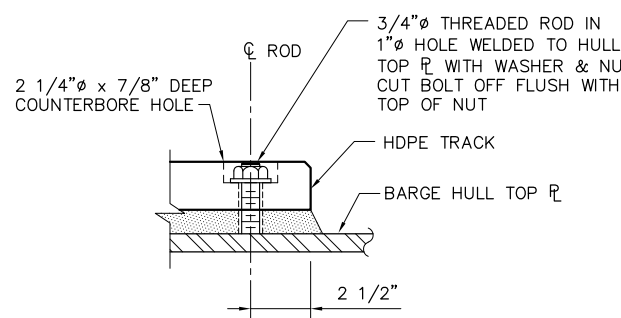

9 DETAIL
SCALE: 3" = 1'-0"

4'-0" 0'-0" 2'-0" 4'-0"
SCALE: 3/8"=1'-0"

100% SUBMITTAL
REVISION 1
IF SHEET IS LESS THAN 22" x 34"
IT IS A REDUCED PRINT -
SCALE REDUCED ACCORDINGLY.

REVISION	DESCRIPTION	BY	DATE



San Luis & Delta-Mendota Water Authority
842 6th Street, Suite 7
PO Box 2157
Los Banos, California 93635



2001 N. Main Street, Suite 360
Walnut Creek, California 94596
(925) 944-5411

DSGN	JMB	DR	AB	CHK	CBS
JOB NO.	6097-03	SUBMITTED BY	RMR		


2-GATES FISH PROTECTION
DEMONSTRATION PROJECT

OLD RIVER
GATE STRUCTURAL DETAILS,
SHEET 5


DATE 10/02/09
SHEET 28 OF 78

C22

P:\6097-03 SWC GATE DESIGN\CADD\DWG\609703-C23.DWG 9/1/2009 9:38 AM

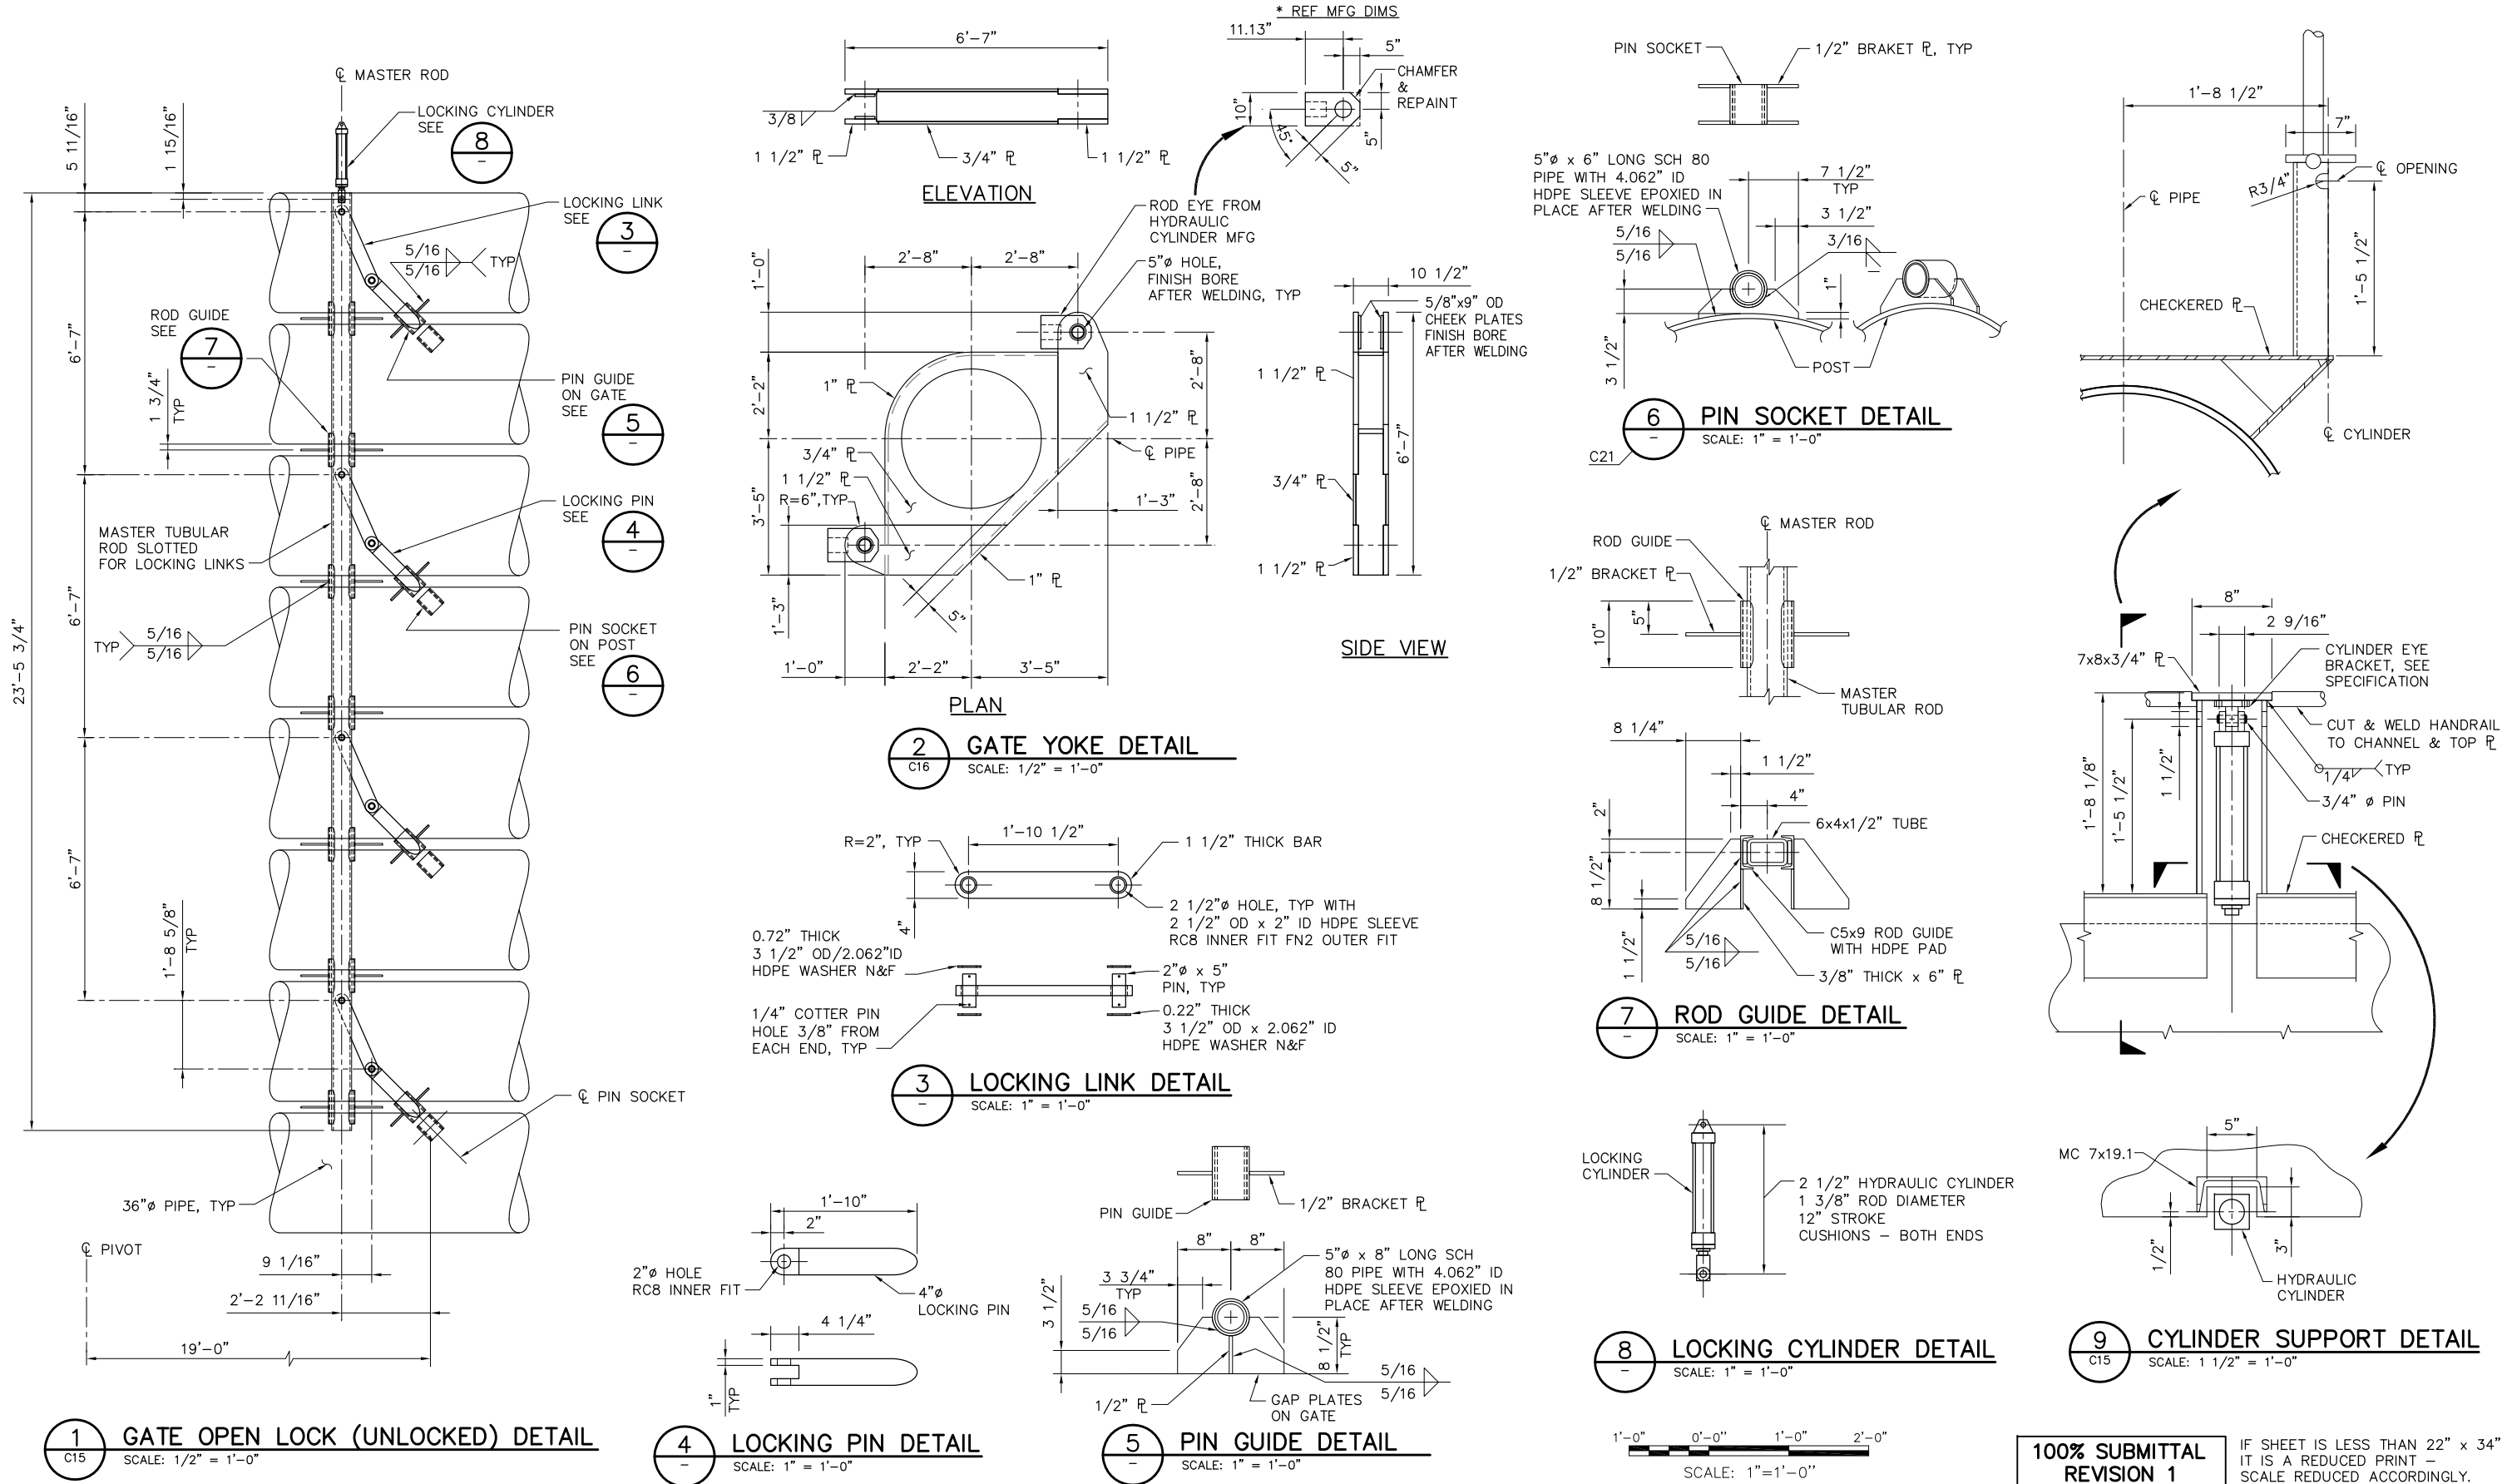

REVISION	DESCRIPTION	BY	DATE

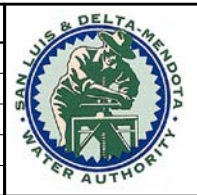

San Luis & Delta-Mendota Water Authority
842 6th Street, Suite 7
PO Box 2157
Los Banos, California 93635




2001 N. Main Street, Suite 360
Walnut Creek, California 94596
(925) 944-5411


DSGN	CBS	DR	AB/TAE	CHK	TDB
JOB NO.	6097-03	SUBMITTED BY	RMR		

2-GATES FISH PROTECTION DEMONSTRATION PROJECT	DATE 10/02/09
	SHEET 29 OF 78
OLD RIVER GATE MECHANICAL DETAILS SHEET 1	C23


P:\6097-03 SWC GATE DESIGN\CADD\DWG\609703-C24.DWG 10/1/2009 9:03 AM

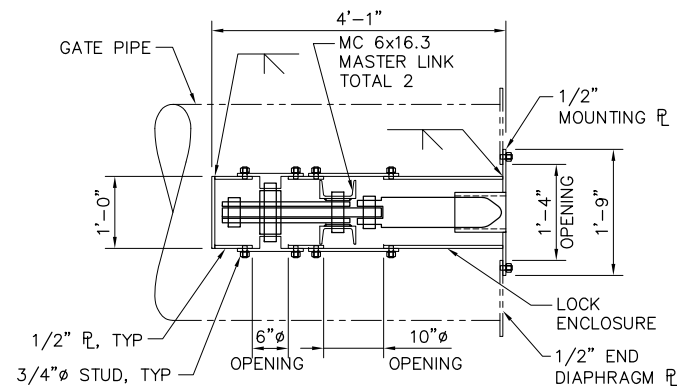


A SECTION
SCALE: 3/4" = 1'-0"

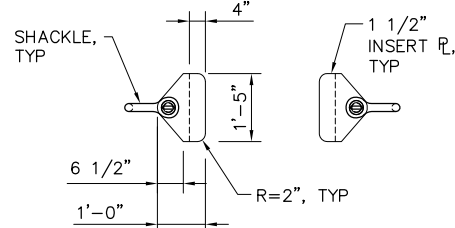


B SECTION
SCALE: 1/2" = 1'-0"

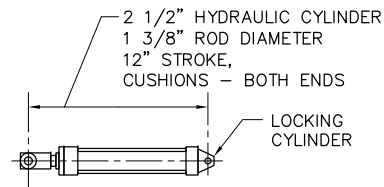


3 LOCKING CYLINDER DETAIL
SCALE: 1" = 1'-0"

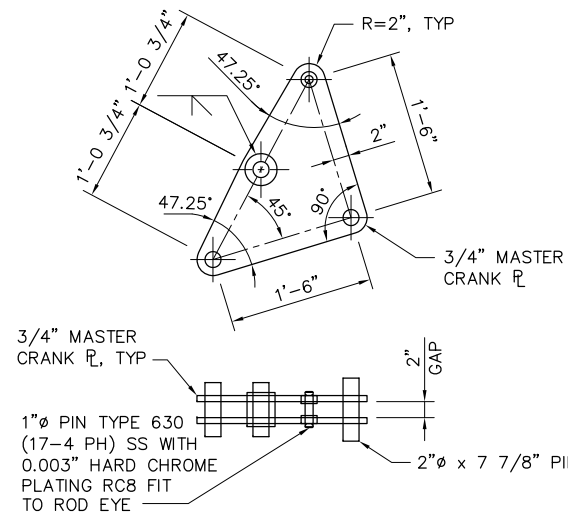


4 MASTER CRANK DETAIL
SCALE: 1" = 1'-0"

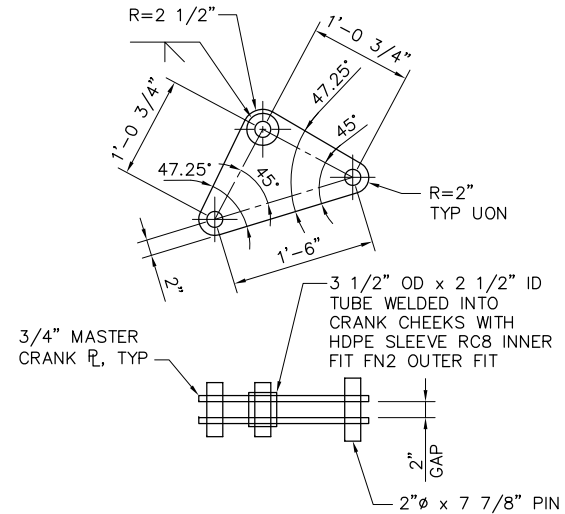


5 LOCKING CRANK DETAIL
SCALE: 1" = 1'-0"

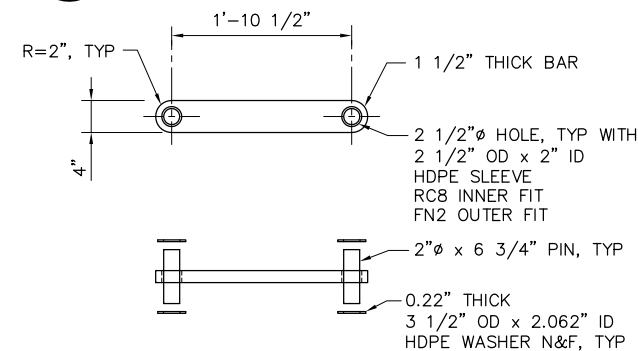


6 LOCKING LINK DETAIL
SCALE: 1" = 1'-0"

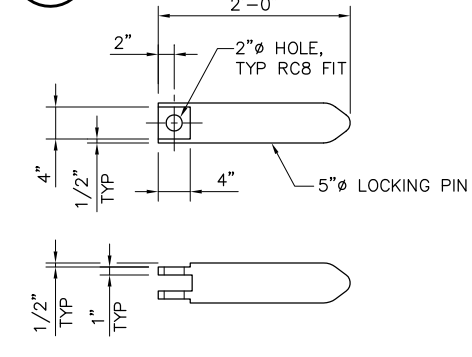


7 LOCKING PIN DETAIL
SCALE: 1" = 1'-0"

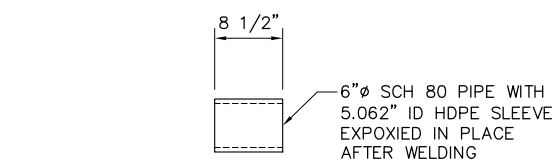


8 PIN GUIDE DETAIL
SCALE: 1" = 1'-0"

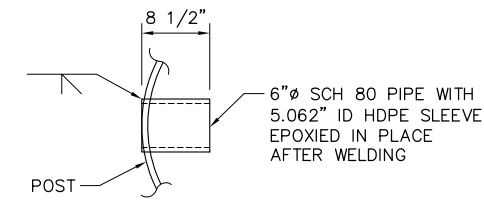


9 PIN SOCKET DETAIL
SCALE: 1" = 1'-0"

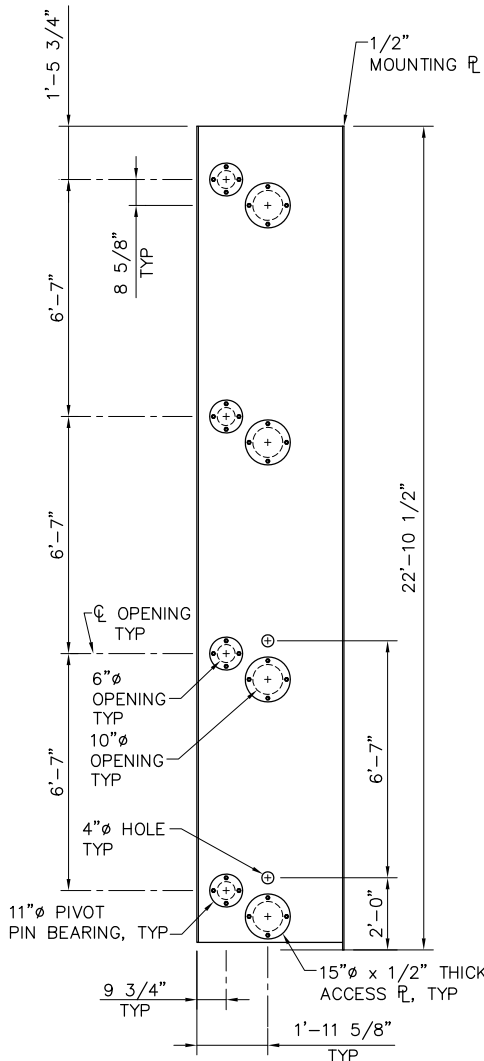

2 LOCK ENCLOSURE DETAIL
SCALE: 3/8" = 1'-0"

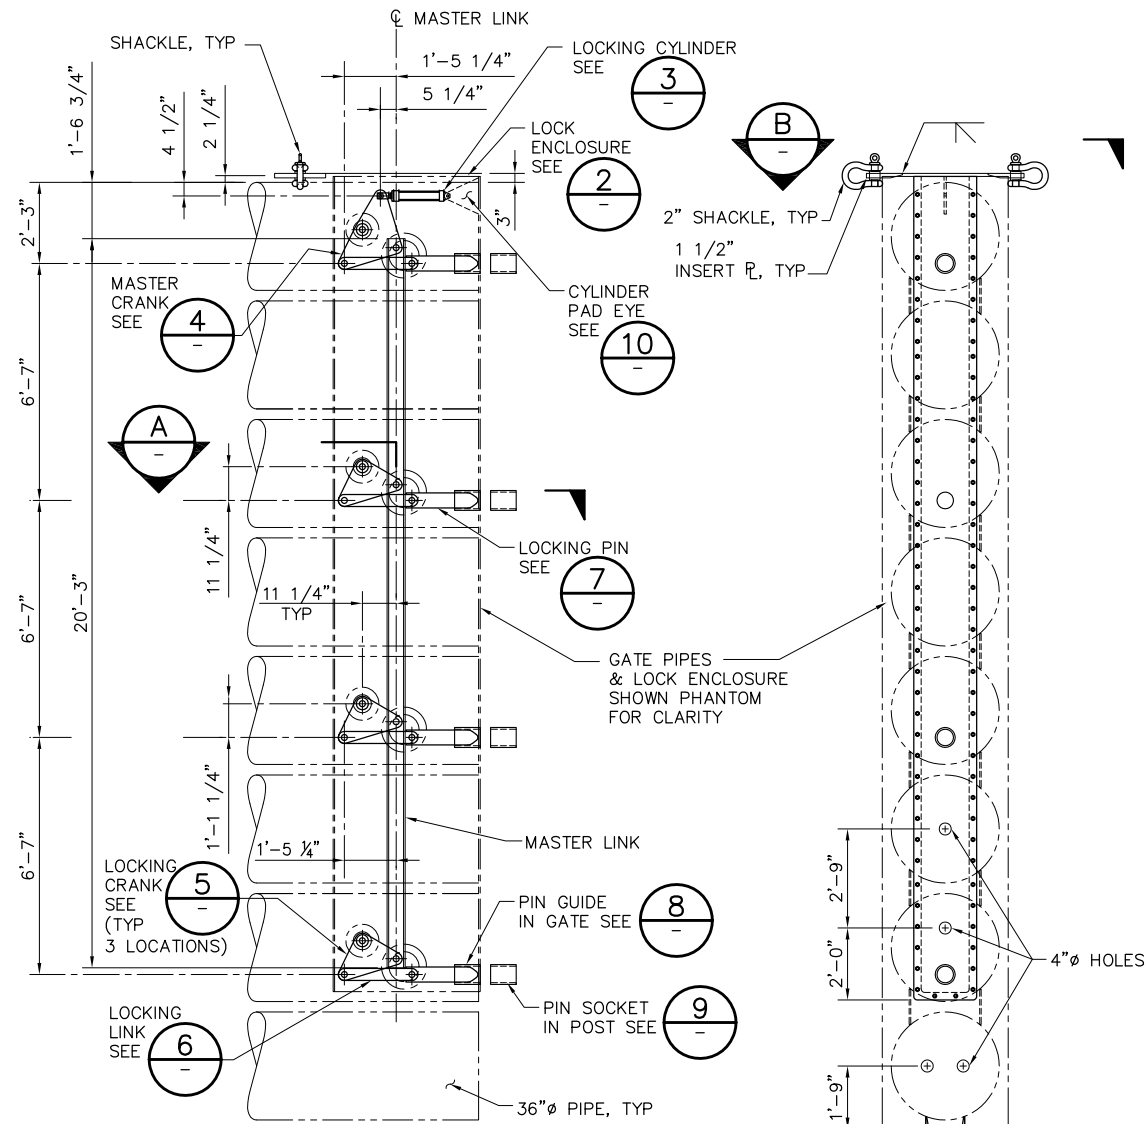

1 GATE CLOSED LOCK (UNLOCKED) DETAIL
SCALE: 3/8" = 1'-0"

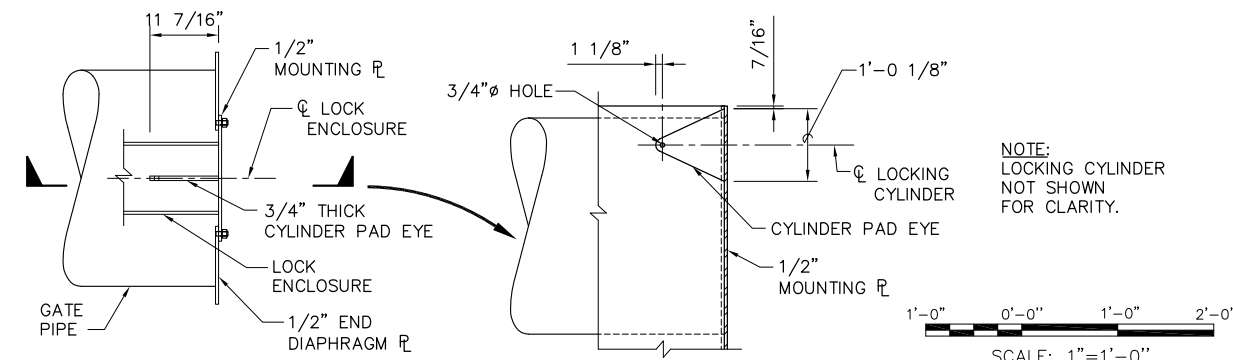

10 CYLINDER PAD EYE DETAIL
SCALE: 3/4" = 1'-0"

**100% SUBMITTAL
REVISION 1**

IF SHEET IS LESS THAN 22" x 34"
IT IS A REDUCED PRINT -
SCALE REDUCED ACCORDINGLY.

REVISION	DESCRIPTION	BY	DATE



San Luis & Delta-Mendota Water Authority
842 6th Street, Suite 7
PO Box 2157
Los Banos, California 93635



2001 N. Main Street, Suite 360
Walnut Creek, California 94596
(925) 944-5411

DSGN	CBS	DR	AB/EP	CHK	TDB
JOB NO.	6097-03	SUBMITTED BY	RMR		

2-GATES FISH PROTECTION
DEMONSTRATION PROJECT


OLD RIVER
GATE MECHANICAL DETAILS
SHEET 2

DATE 10/02/09

SHEET 30 OF 78


C24

P:\6097-03 SMC GATE DESIGN\CADD\DWG\609703-C25.DWG 9/1/2009 9:38 AM

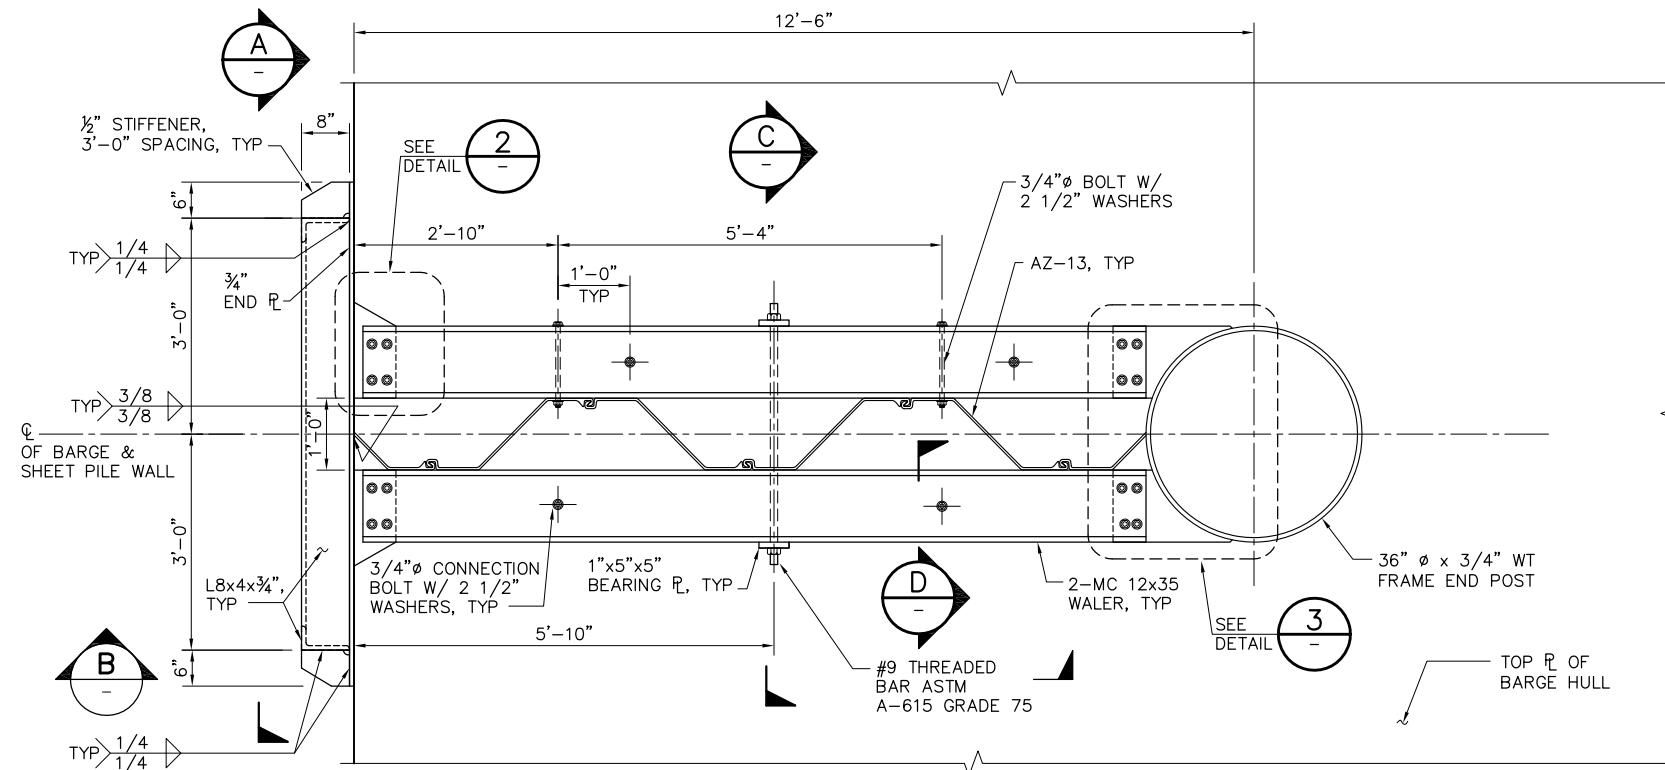


PLAN


1 DETAIL
C17
SCALE: 3/4" = 1'-0"

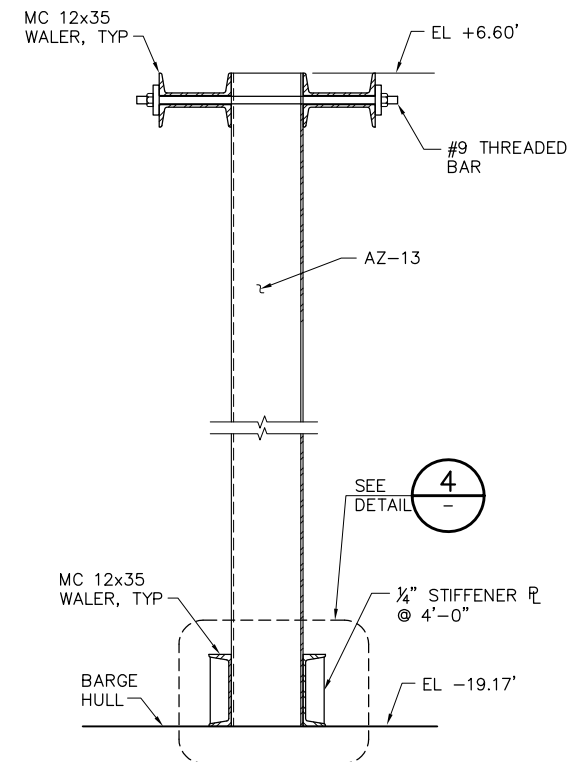


C SECTION
SCALE: 3/4" = 1'-0"

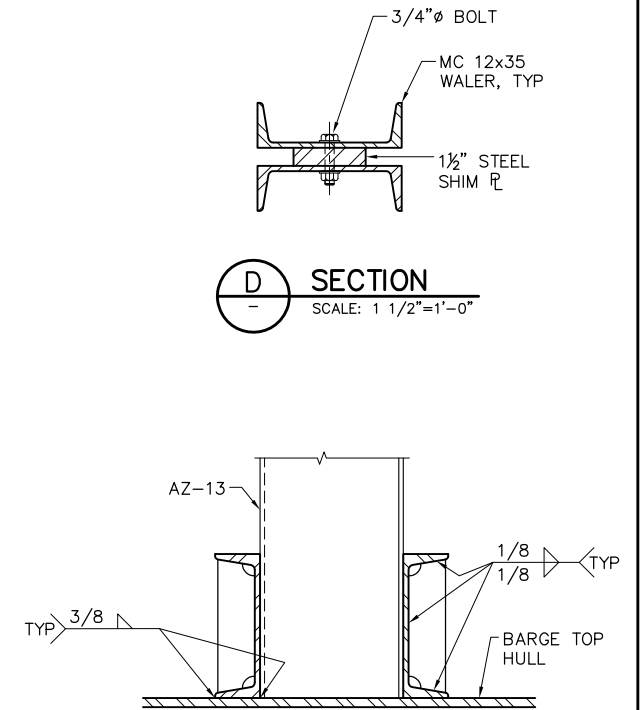


4 DETAIL
SCALE: 1 1/2" = 1'-0"

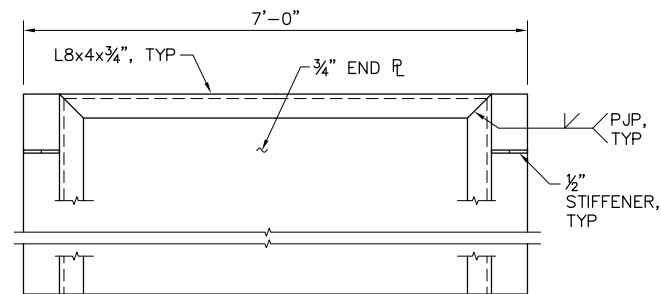


A SECTION
SCALE: 3/4" = 1'-0"

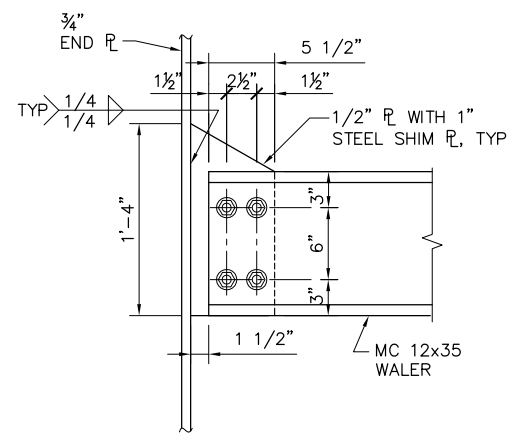


2 DETAIL
SCALE: 1 1/2" = 1'-0"

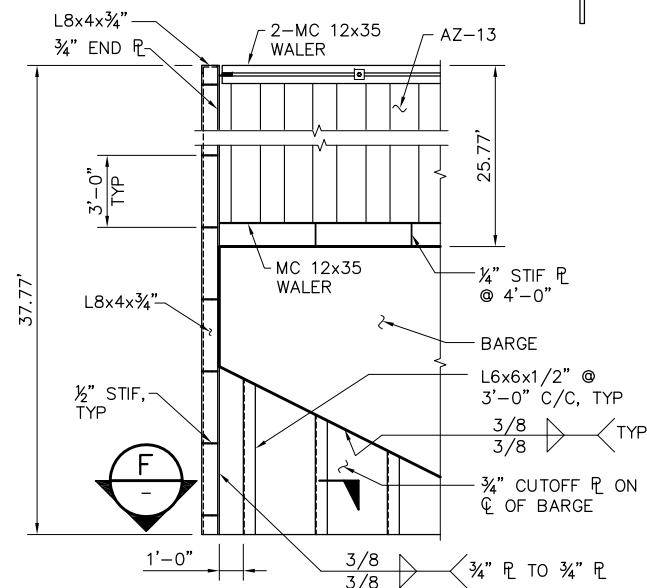


B SECTION
SCALE: 1/4" = 1'-0"

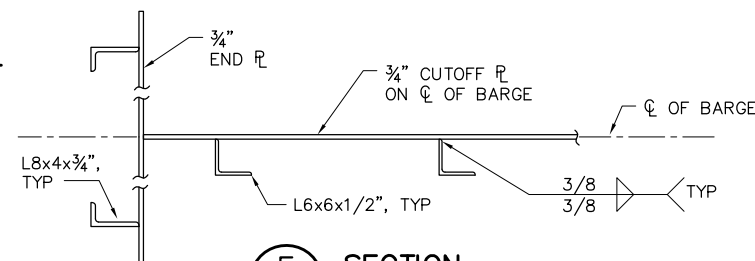


F SECTION
SCALE: 3/4" = 1'-0"

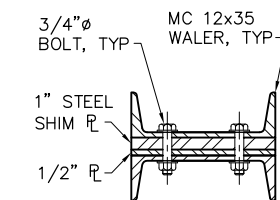

NOTE:
ALL BOLTS ARE ASTM A-307 U.O.N.

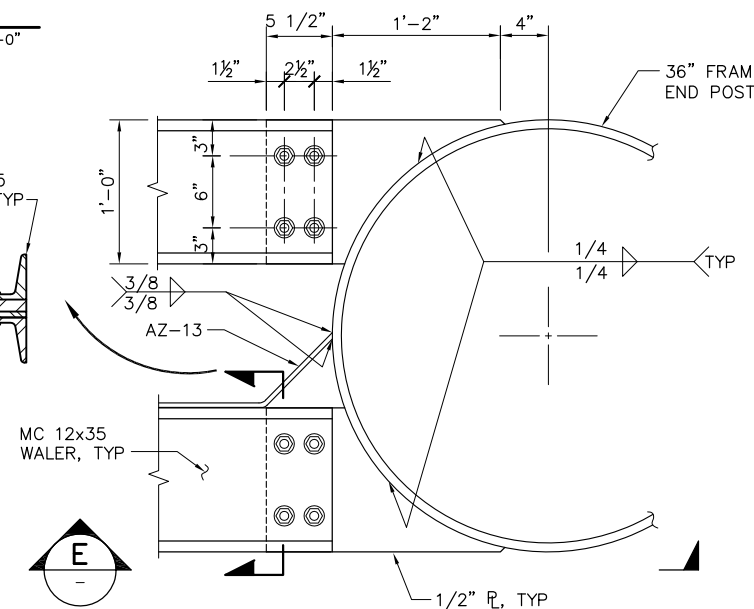

3 DETAIL
SCALE: 1 1/2" = 1'-0"

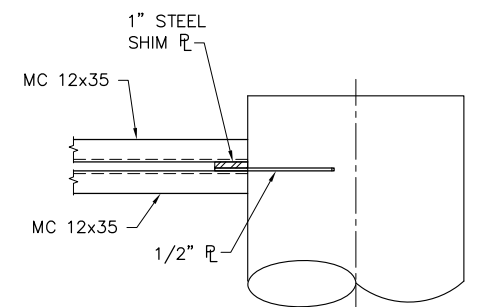


E SECTION
SCALE: 3/4" = 1'-0"

1'-0" 0'-0" 6" 1'-0"
SCALE: 1 1/2" = 1'-0"
2'-0" 0'-0" 1'-0" 2'-0"
SCALE: 3/4" = 1'-0"

100% SUBMITTAL
REVISION 1

IF SHEET IS LESS THAN 22" x 34"
IT IS A REDUCED PRINT -
SCALE REDUCED ACCORDINGLY.

REVISION	DESCRIPTION	BY	DATE

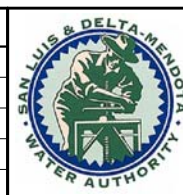

San Luis & Delta-Mendota Water Authority
842 6th Street, Suite 7
PO Box 2157
Los Banos, California 93635



2001 N. Main Street, Suite 360
Walnut Creek, California 94596
(925) 944-5411

DSGN	JMB	DR	AB	CHK	TDB
JOB NO.	6097-03	SUBMITTED BY	RMR		

2-GATES FISH PROTECTION
DEMONSTRATION PROJECT


DATE 10/02/09

SHEET 31 OF 78


OLD RIVER
END WALL SCANTLINGS

C25

P:\6097-03 SWC GATE DESIGN\CADD\DWG\609703-C26.DWG 9/30/2009 4:31 PM

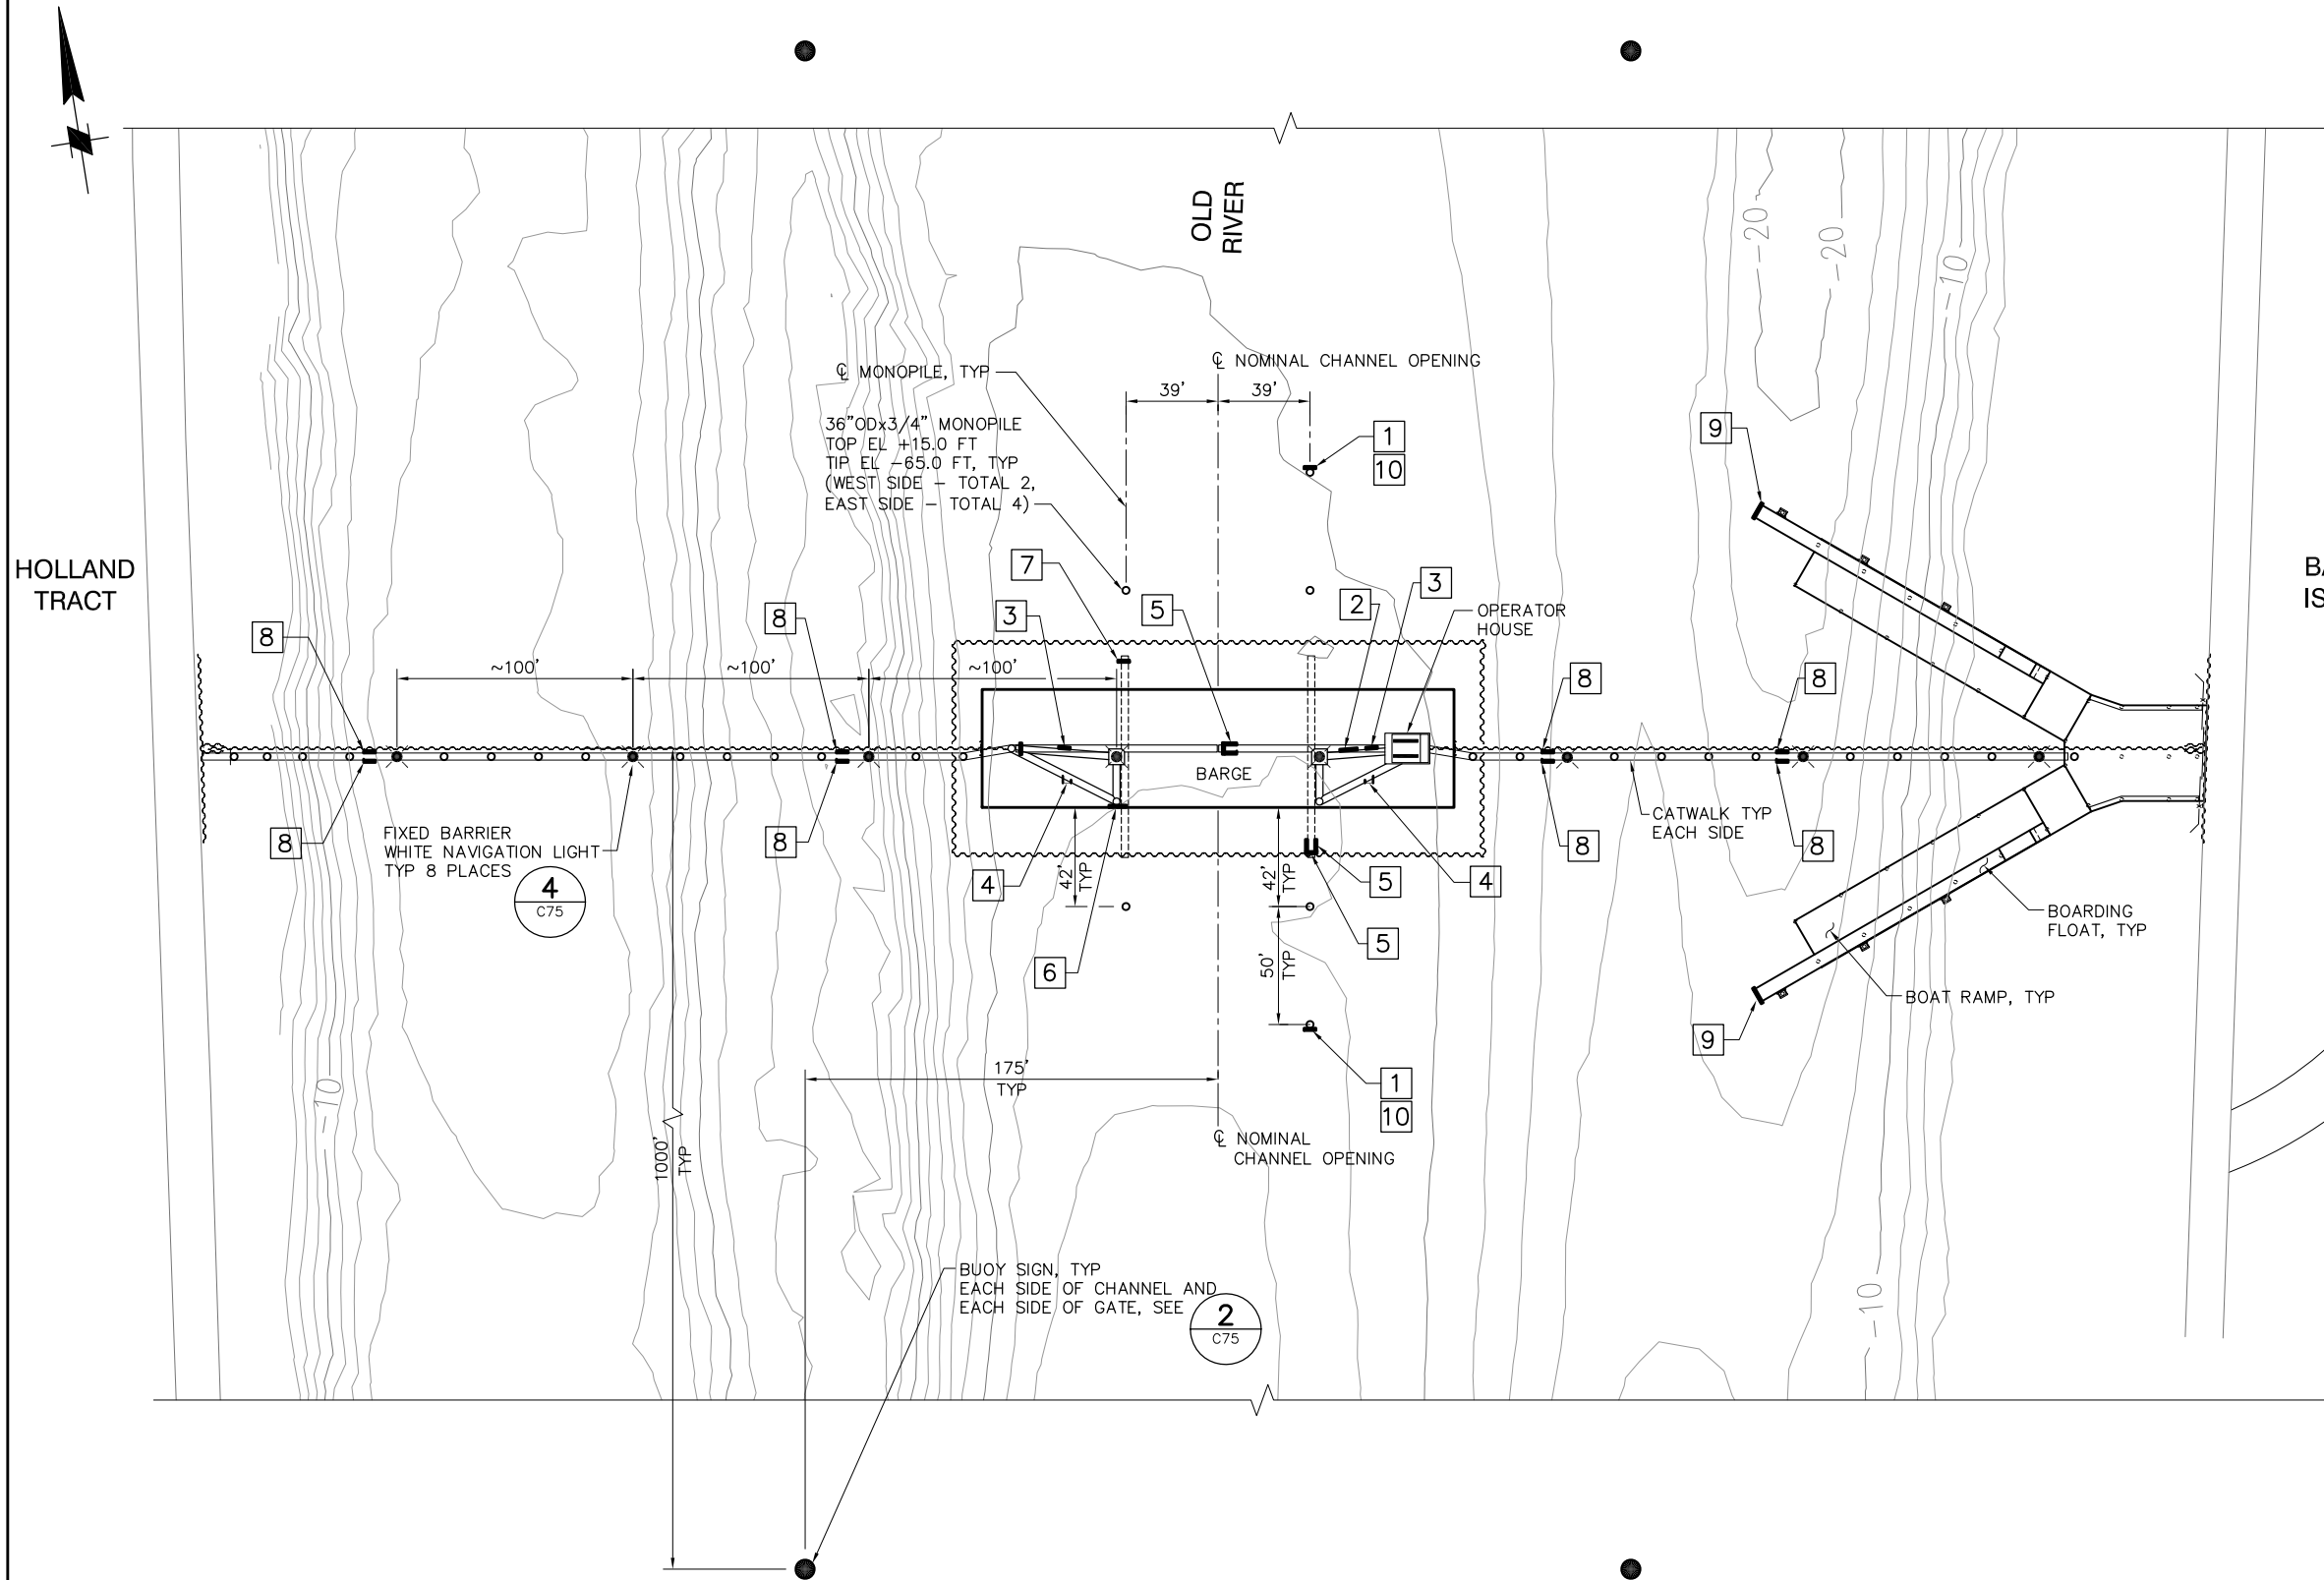

PLAN
SCALE: 1"= 40'

 

100% SUBMITTAL
REVISION 1

IF SHEET IS LESS THAN 22" x 34"
IT IS A REDUCED PRINT -
SCALE REDUCED ACCORDINGLY.

SIGN DATA			
LOCATION	SIGN	SIGN DETAIL	SIGN MOUNTING DETAIL
1	GATE 5 MPH	1 C75	1 C76
2	GATE WARNING SIGN	5 C75	5 C76
3	DANGER SIGN	7 C75	5 C76
4	DANGER SIGN	7 C75	3 C76
5	GATE POSITION SIGNS "GATES OPEN" "GATES CLOSED"	6 C75	2 C74
6	GATE WARNING SIGN	5 C75	2 C76
7	GATE POSITION SIGN "GATES OPEN"	6 C75	4 C76
8	STAY BACK WARNING SIGN	9 C75	5 C76
9	BOAT RAMP DOCK SIGN	3 C75	6 C76
10	GATE OPENING SIGN	10 C75	1 C76

REVISION	DESCRIPTION	BY	DATE



San Luis & Delta-Mendota Water Authority
842 6th Street, Suite 7
PO Box 2157
Los Banos, California 93635



2001 N. Main Street, Suite 360
Walnut Creek, California 94596
(925) 944-5411

DSGN	RBD	DR	AB	CHK	TDB
JOB NO.	6097-03	SUBMITTED BY	RMR		

2-GATES FISH PROTECTION
DEMONSTRATION PROJECT


DATE 10/02/09

SHEET 32 OF 78

OLD RIVER
AIDS TO NAVIGATION PLAN

C26

P:\6097-03 SWC GATE DESIGN\CADD\DWG\609703-C31.DWG 9/30/2009 1:32 PM

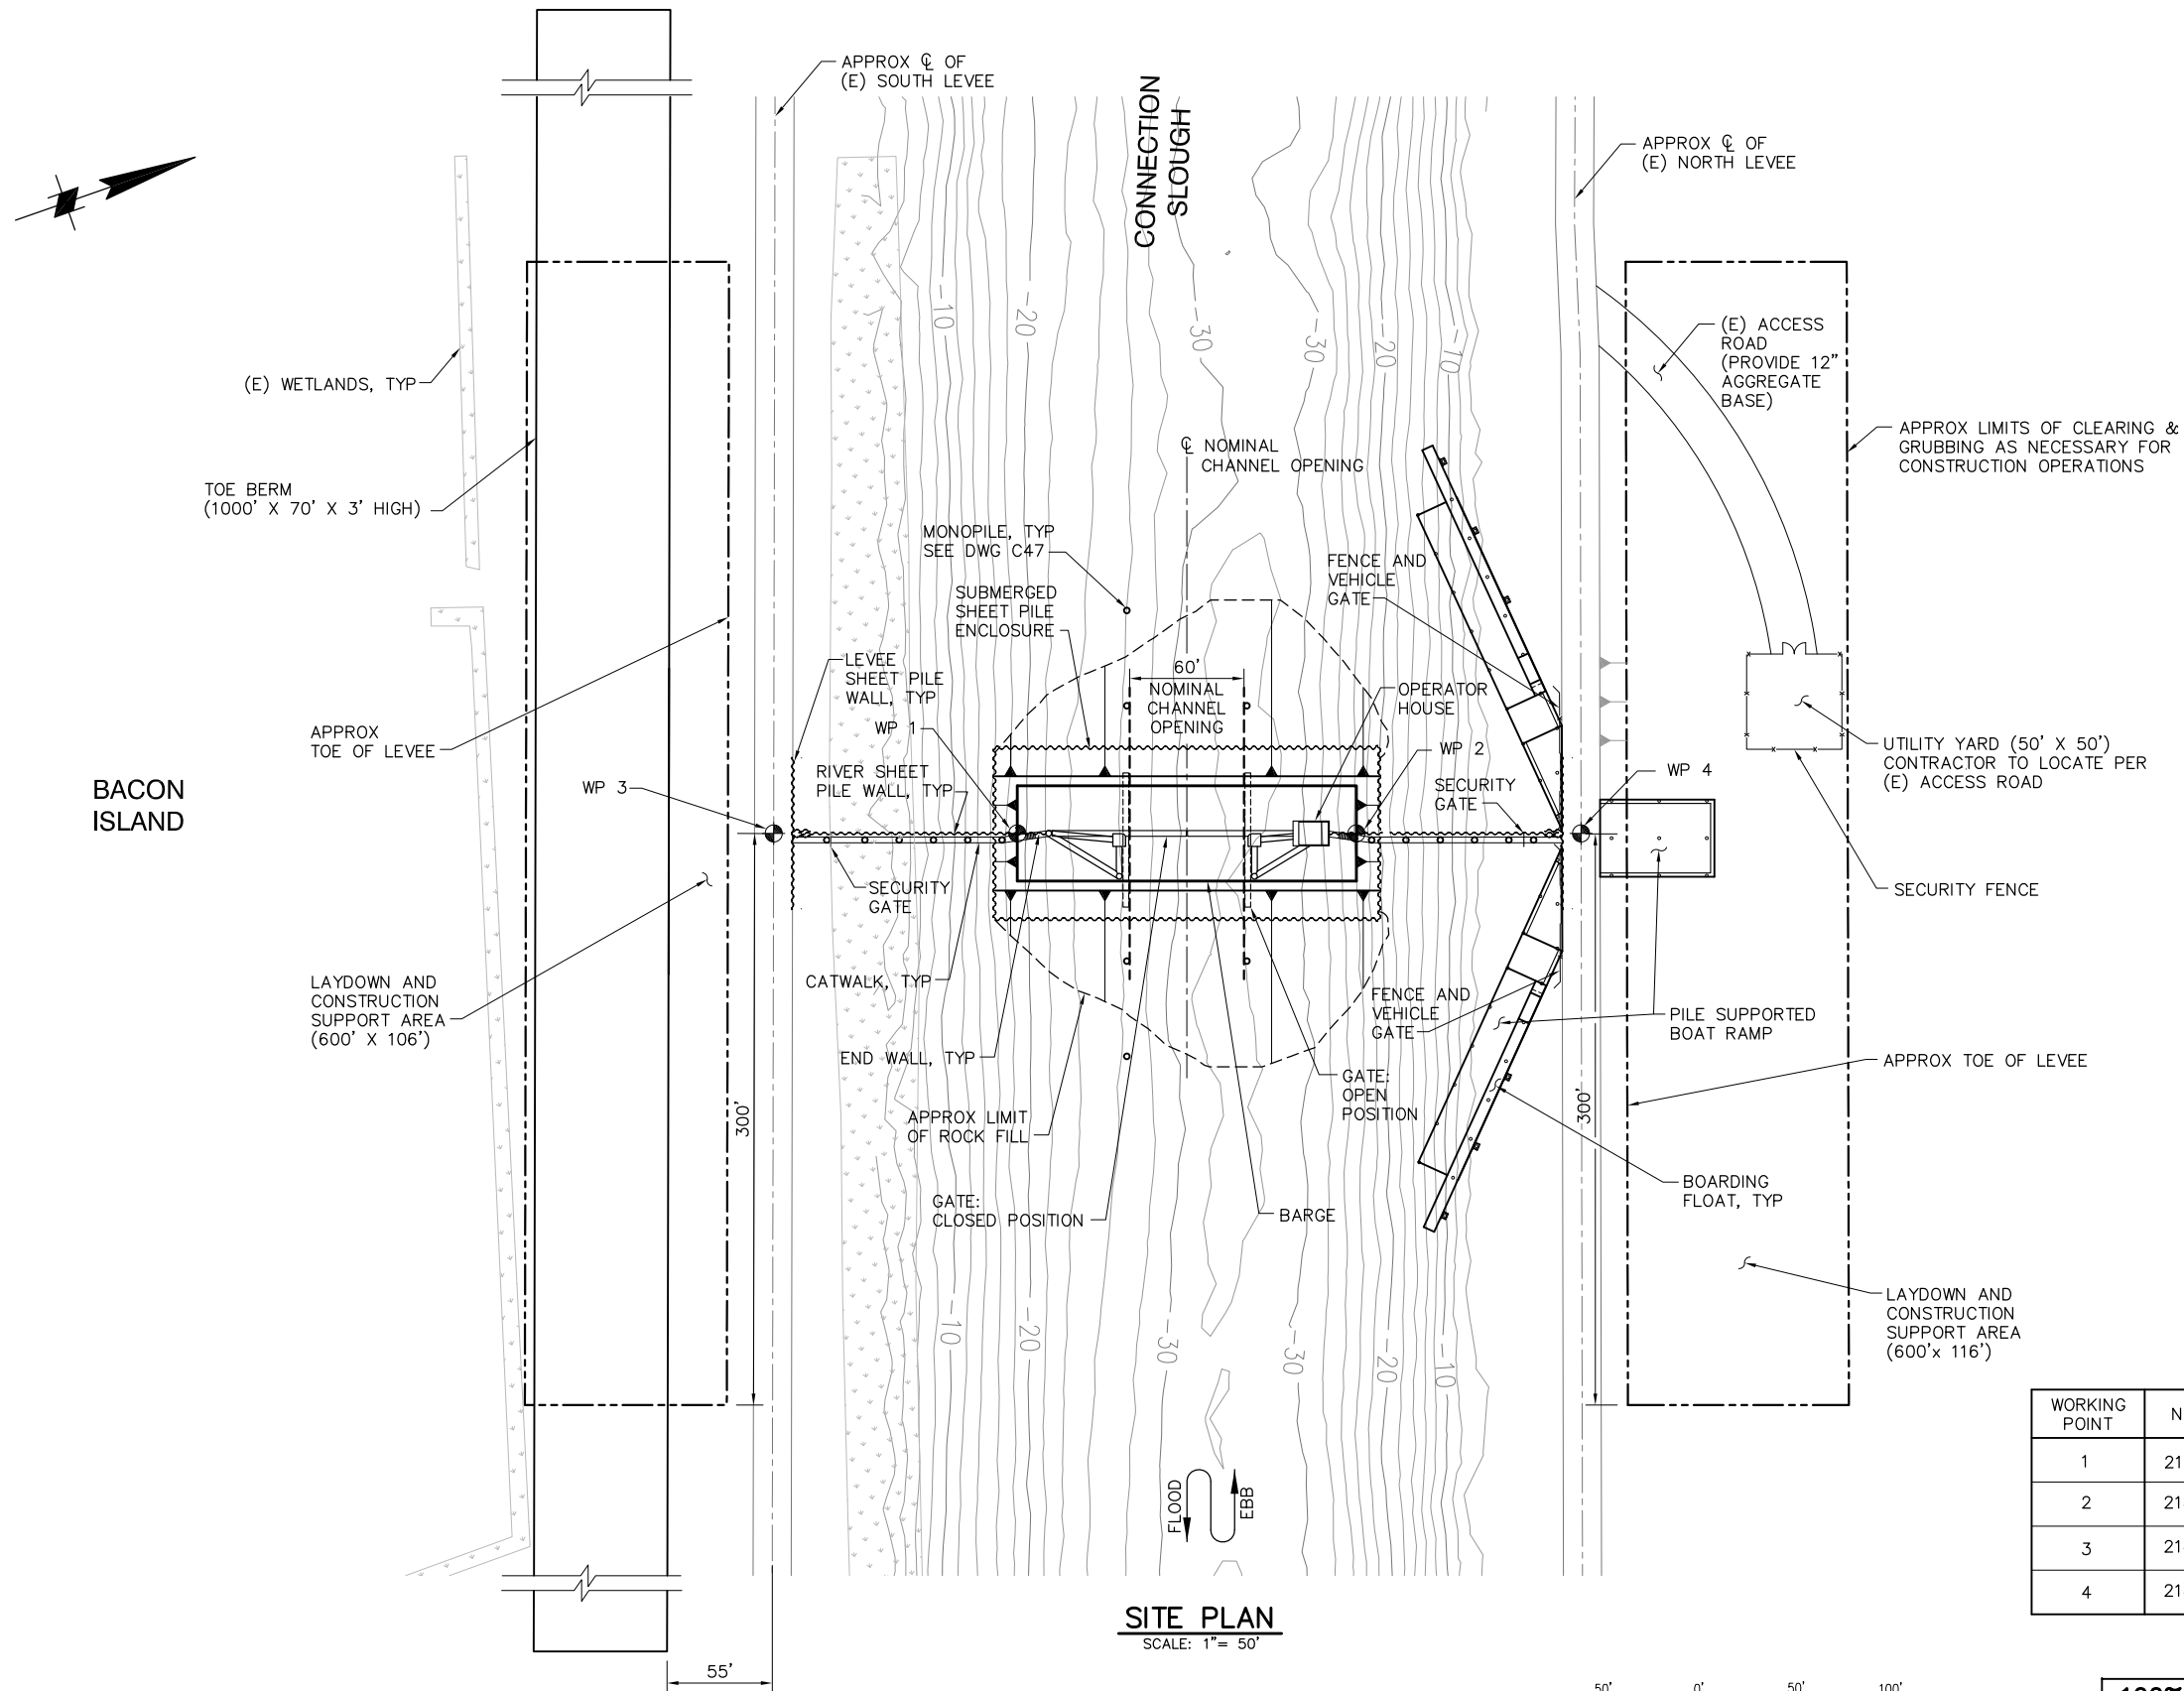

SITE PLAN
SCALE: 1"= 50'

WORK POINT DATA

WORKING POINT	NORTHING	EASTING	FEATURE
1	2189371.89	6265762.17	Q OF SOUTH SIDE OF BARGE
2	2189539.90	6265820.98	Q OF NORTH SIDE OF BARGE
3	2189251.19	6265719.91	Q OF SOUTH LEVEE AND GATE
4	2189651.16	6265859.94	Q OF NORTH LEVEE AND GATE

**100% SUBMITTAL
REVISION 1**

IF SHEET IS LESS THAN 22" x 34"
IT IS A REDUCED PRINT -
SCALE REDUCED ACCORDINGLY.

REVISION	DESCRIPTION	BY	DATE



San Luis & Delta-Mendota Water Authority
842 6th Street, Suite 7
PO Box 2157
Los Banos, California 93635



2001 N. Main Street, Suite 360
Walnut Creek, California 94596
(925) 944-5411

DSGN	TDB	DR	EP/AB	CHK	GTH
JOB NO.	6097-03	SUBMITTED BY	RMR		

**2-GATES FISH PROTECTION
DEMONSTRATION PROJECT**



DATE 10/02/09

SHEET 33 OF 78


**CONNECTION SLOUGH
SITE PLAN**

C31

P:\6097-03 SWC GATE DESIGN\CADD\DWG\609703-C32.DWG 10/1/2009 2:14 PM

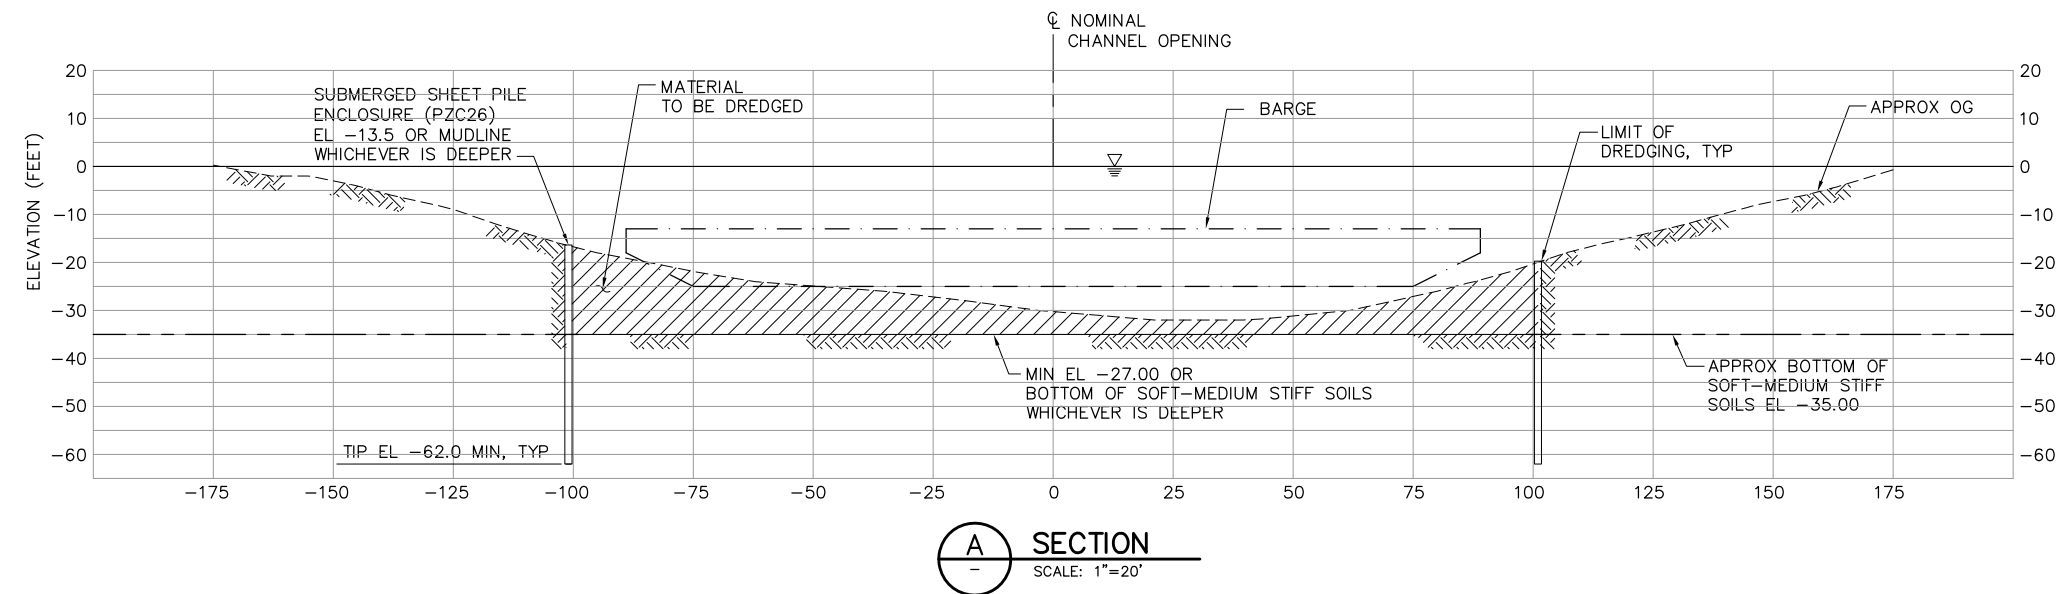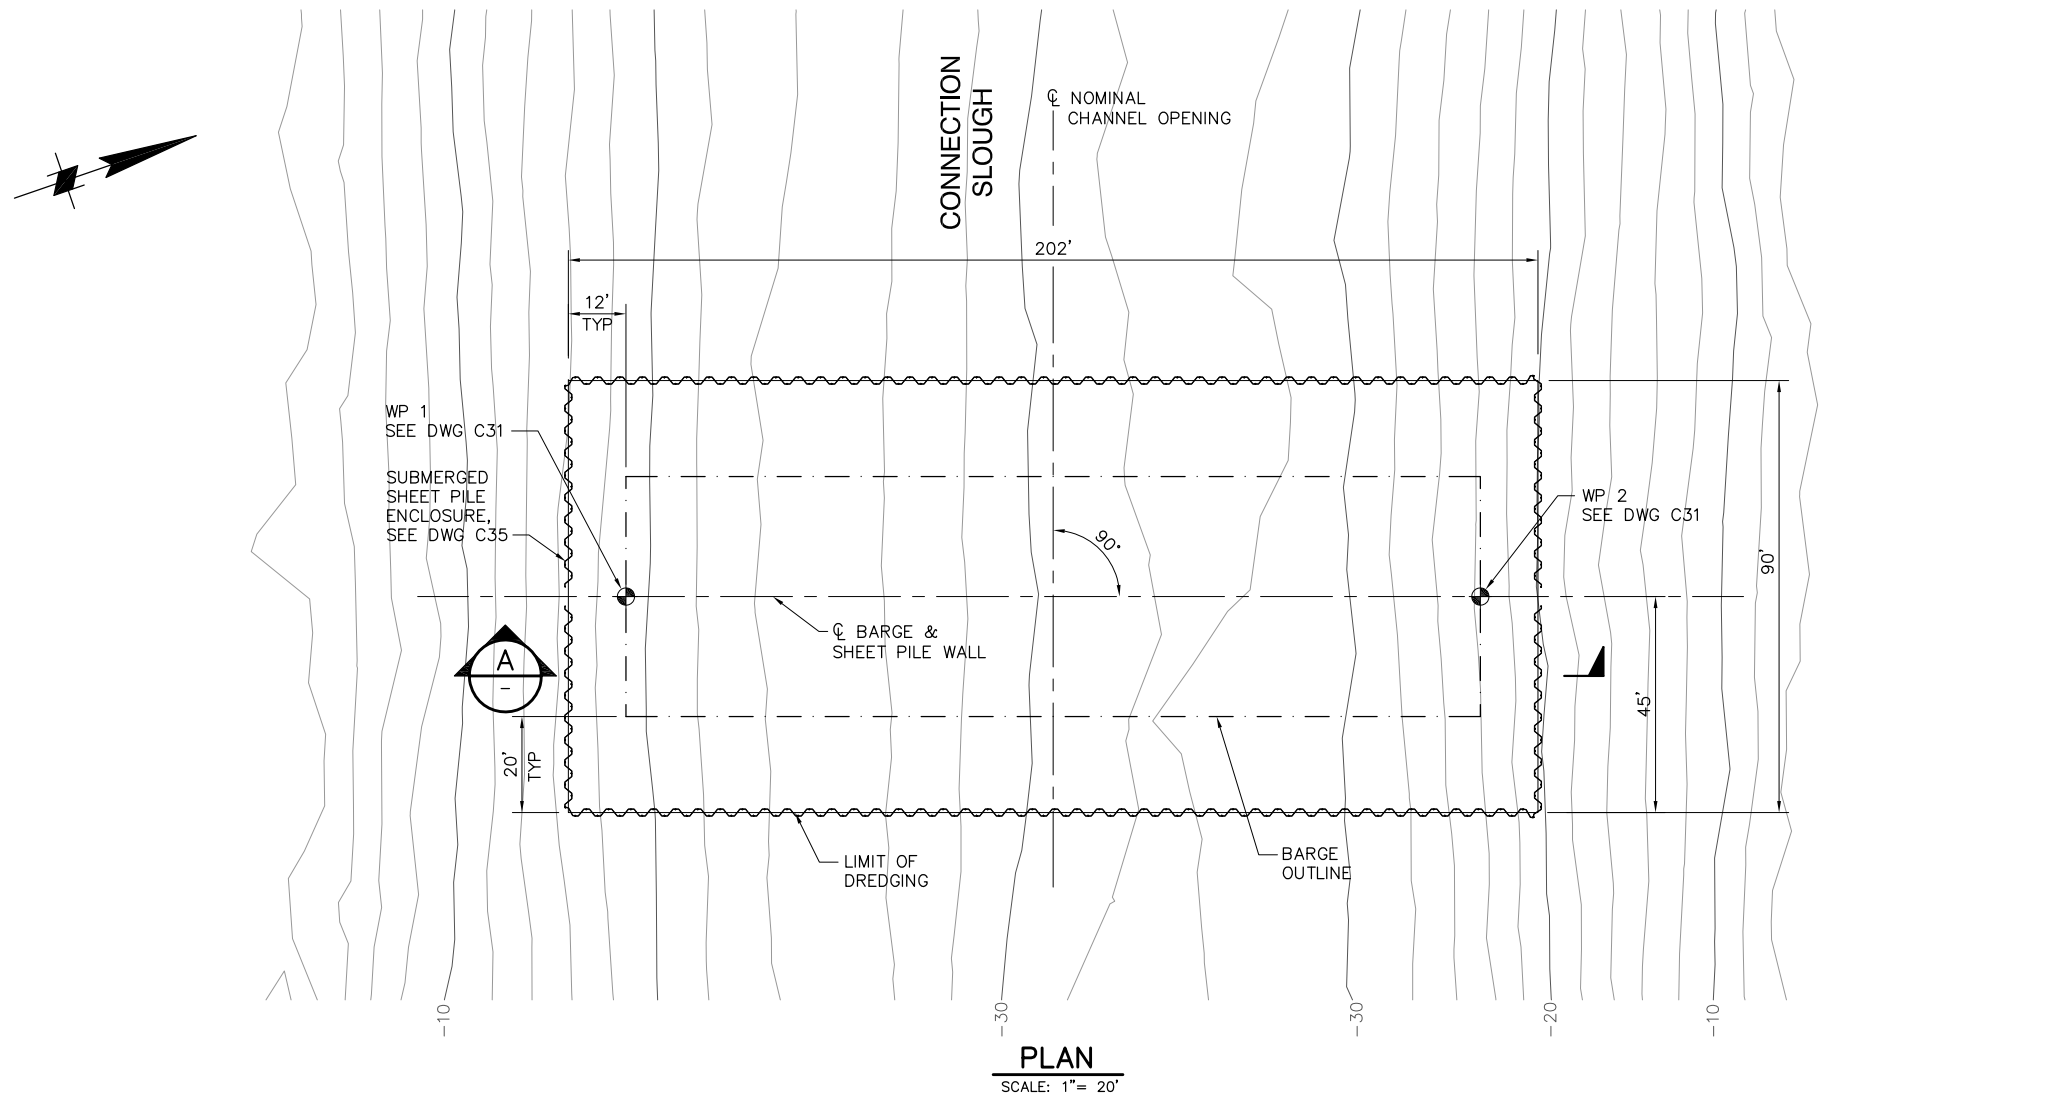

 NOTE:
GATE AND ALL OTHER FEATURES
NOT SHOWN FOR CLARITY.



**100% SUBMITTAL
REVISION 1** IF SHEET IS LESS THAN 22" x 34"
IT IS A REDUCED PRINT -
SCALE REDUCED ACCORDINGLY.

REVISION	DESCRIPTION	BY	DATE



San Luis & Delta-Mendota Water Authority
842 6th Street, Suite 7
PO Box 2157
Los Banos, California 93635






2001 N. Main Street, Suite 360
Walnut Creek, California 94596
(925) 944-5411


DSGN	TDB	DR	EP/AB	CHK	GTH
JOB NO. 6097-03		SUBMITTED BY RMR			

2-GATES FISH PROTECTION DEMONSTRATION PROJECT CONNECTION SLOUGH DREDGING PLAN AND SECTION	DATE 10/02/09
	SHEET 34 OF 78
C32	

P:\6097-03 SWC GATE DESIGN\CADD\DWG\609703-C33.DWG 10/1/2009 10:26 AM

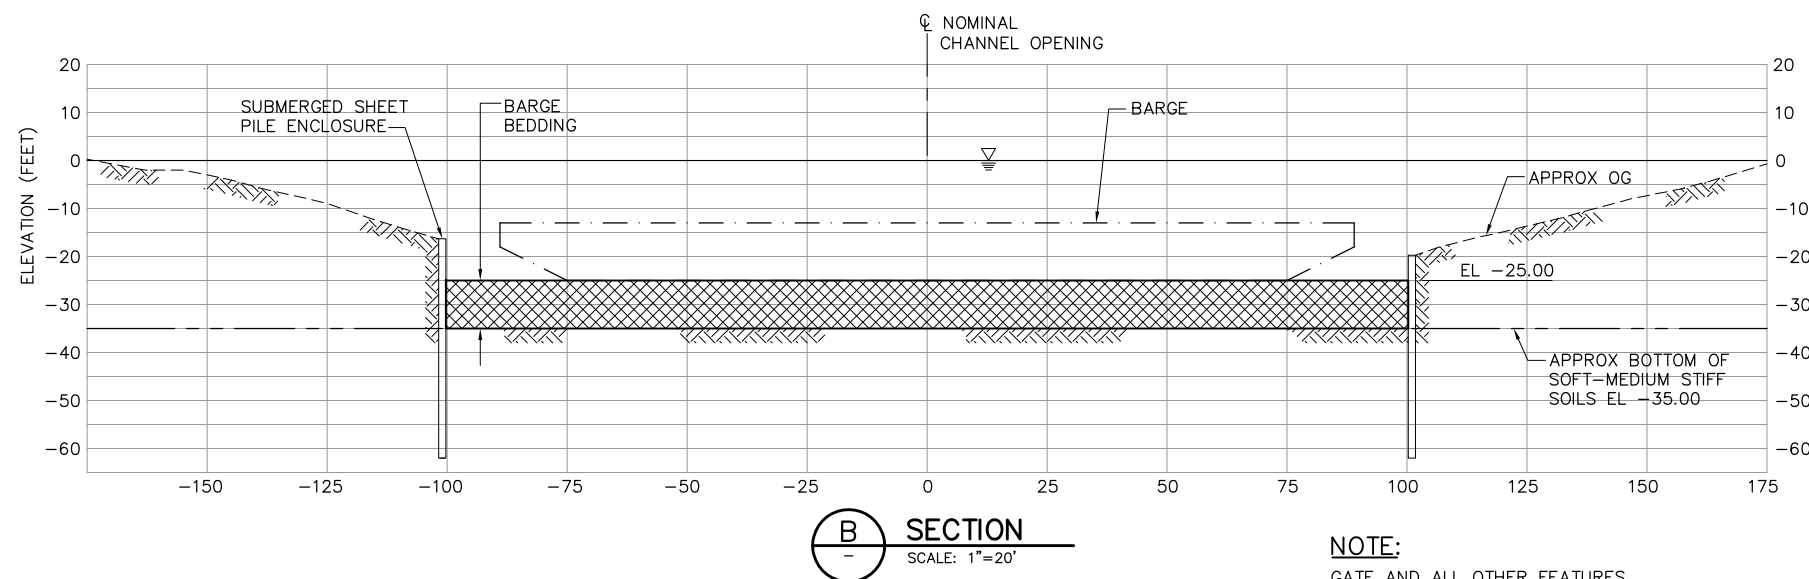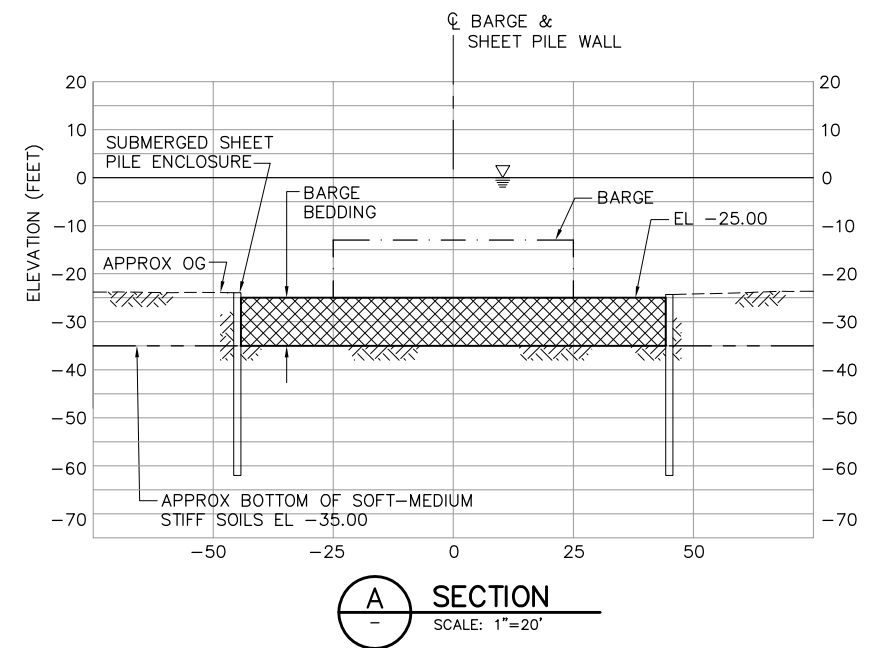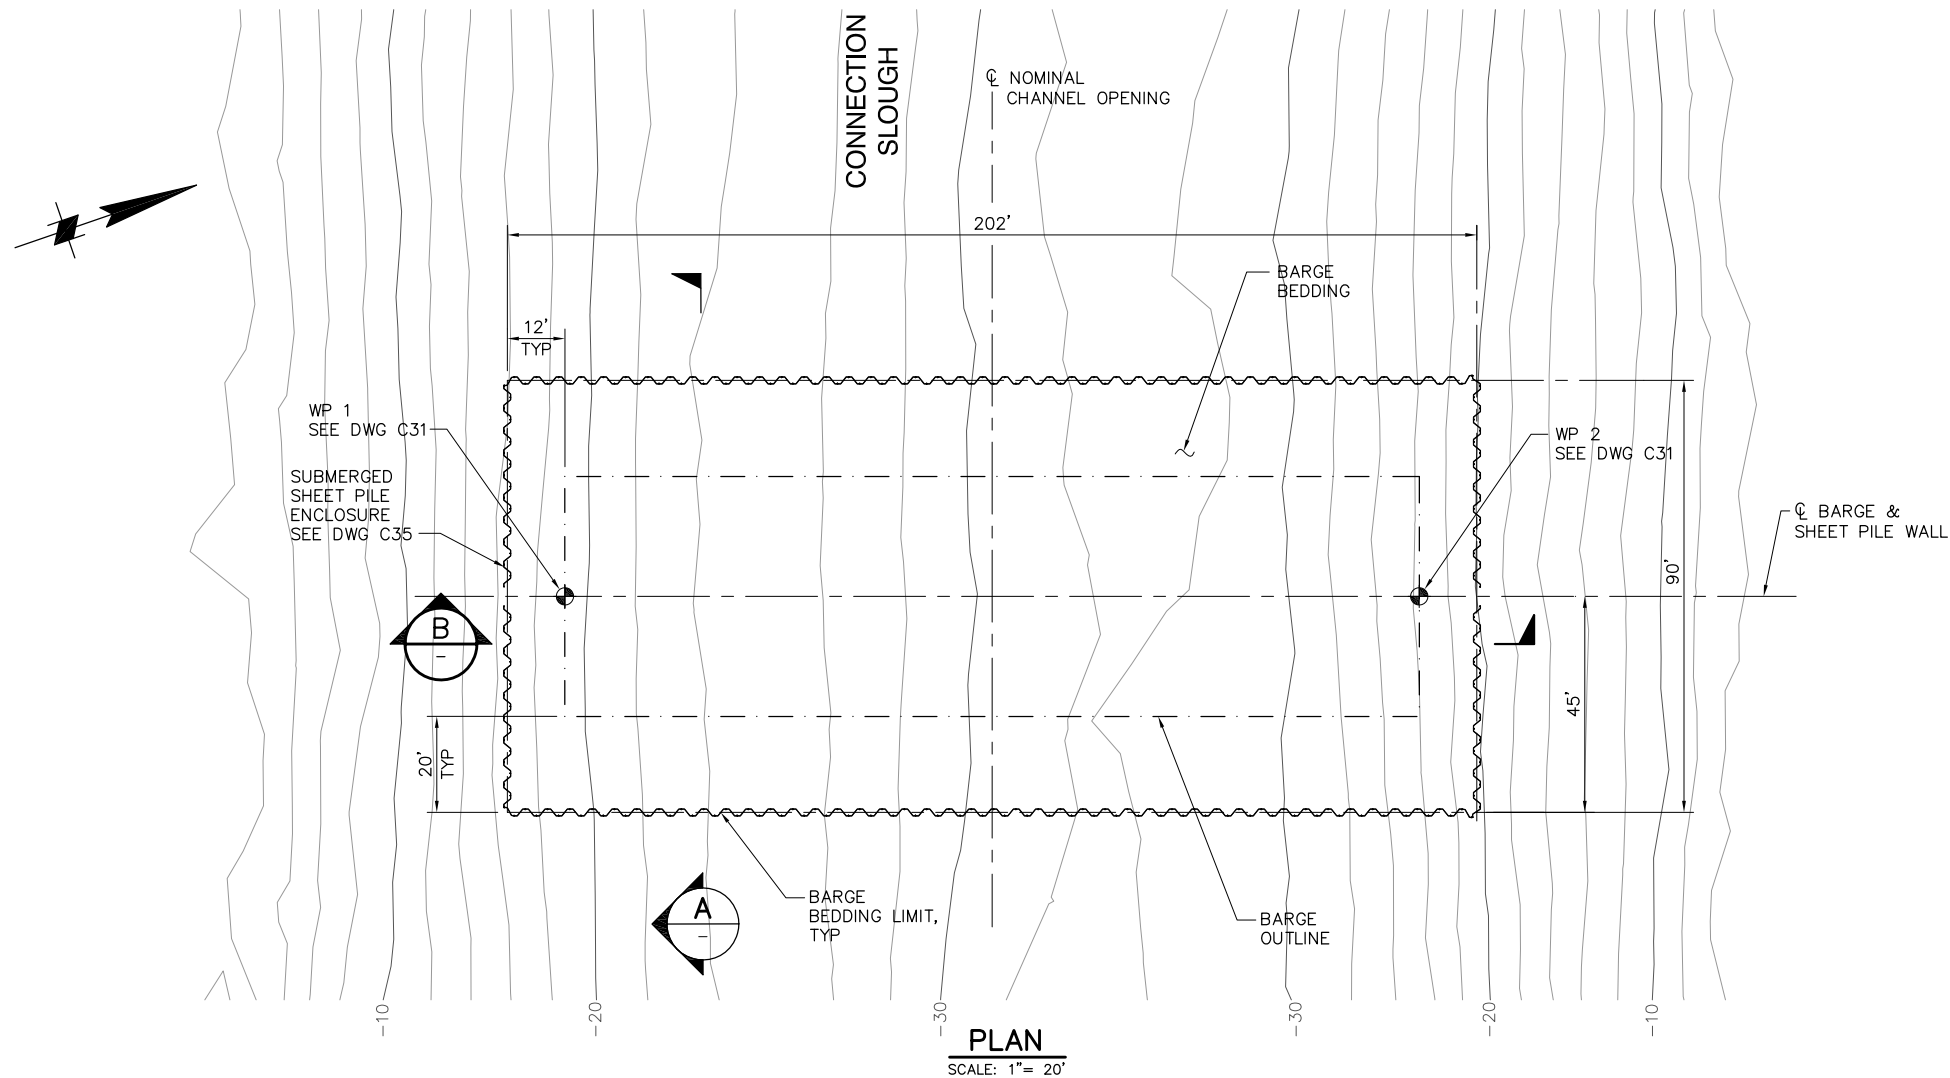

 NOTE:
GATE AND ALL OTHER FEATURES
NOT SHOWN FOR CLARITY.



100% SUBMITTAL
REVISION 1

IF SHEET IS LESS THAN 22" x 34"
IT IS A REDUCED PRINT -
SCALE REDUCED ACCORDINGLY.

REVISION	DESCRIPTION	BY	DATE



San Luis & Delta-Mendota Water Authority
842 6th Street, Suite 7
PO Box 2157
Los Banos, California 93635



2001 N. Main Street, Suite 360
Walnut Creek, California 94596
(925) 944-5411

DSGN	TDB	DR	EP/AB	CHK	GTH
JOB NO.	6097-03	SUBMITTED BY	RMR		

2-GATES FISH PROTECTION
DEMONSTRATION PROJECT

DATE 10/02/09


SHEET 35 OF 78

CONNECTION SLOUGH,
BARGE BEDDING PLAN



C33

P:\6097-03 SWC GATE DESIGN\CADD\DWG\609703-C34.DWG 9/30/2009 11:53 AM

BACON
ISLAND

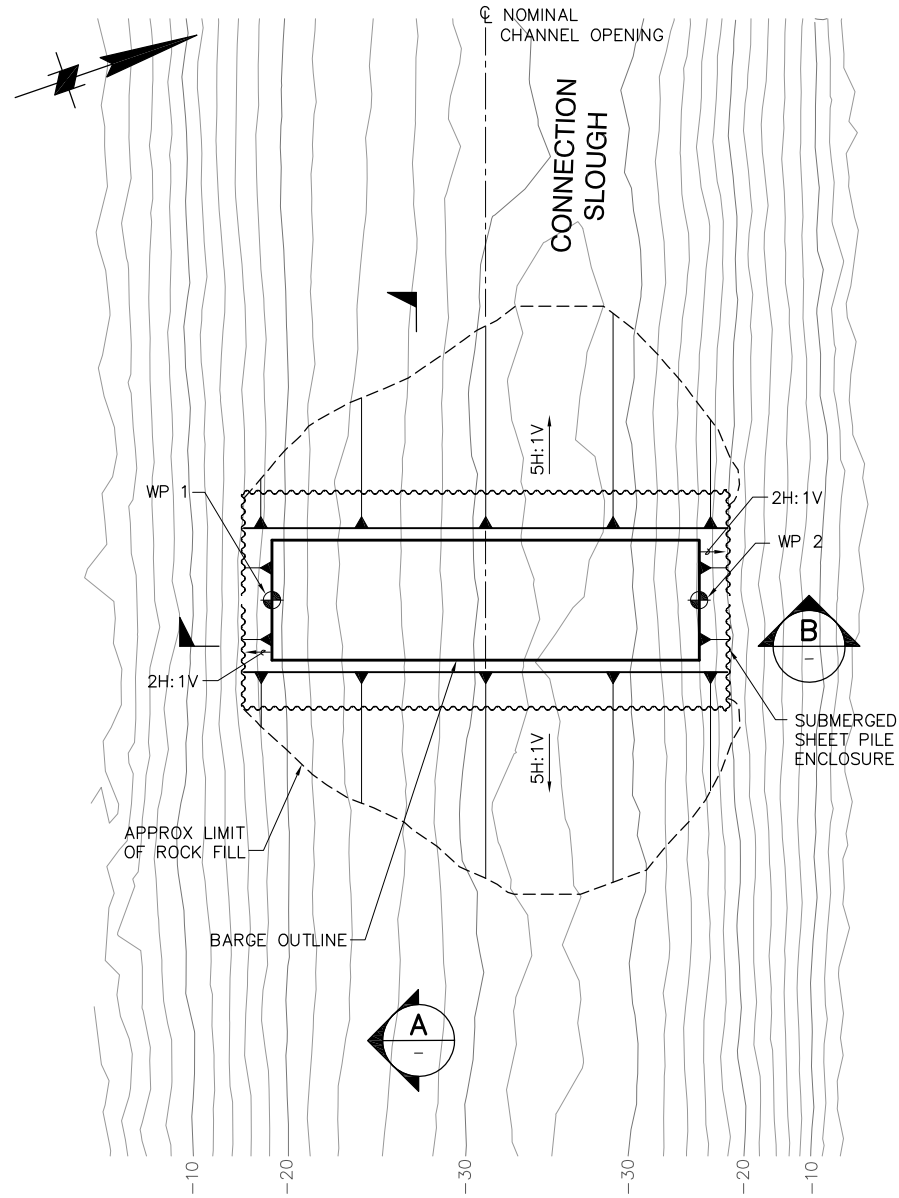


MANDEVILLE
ISLAND

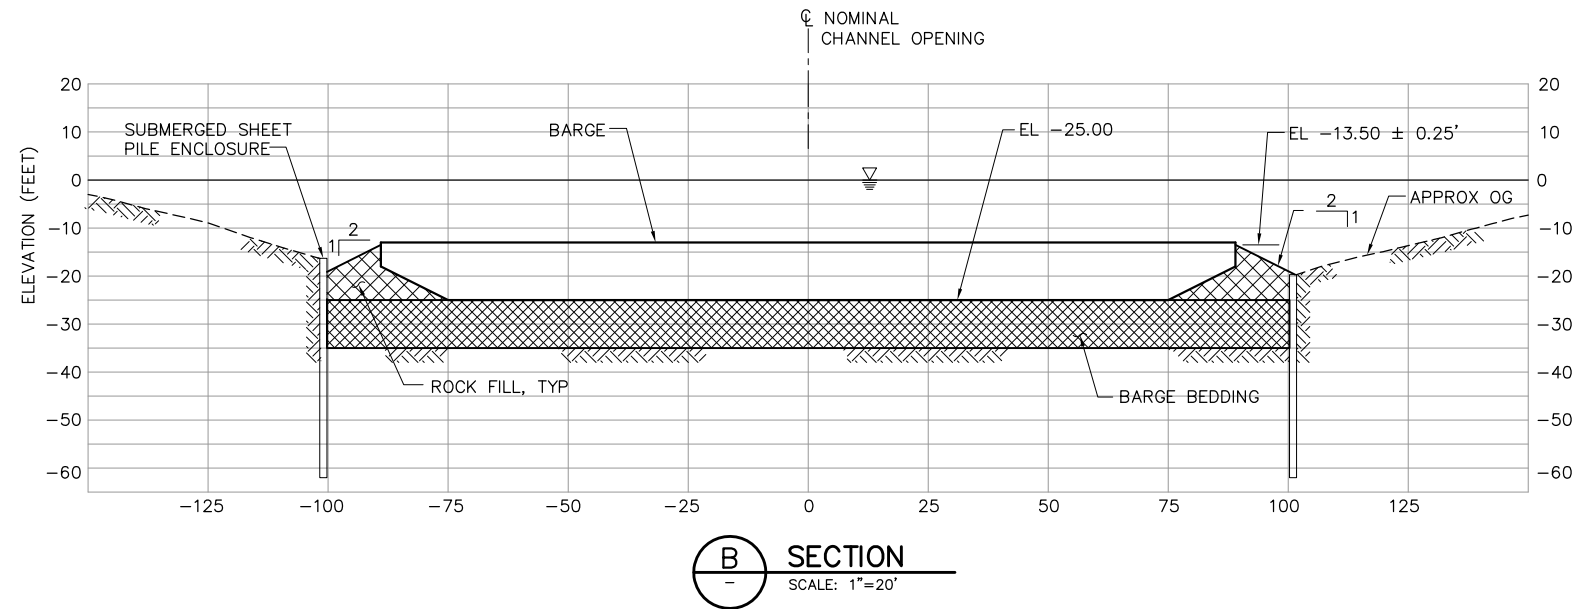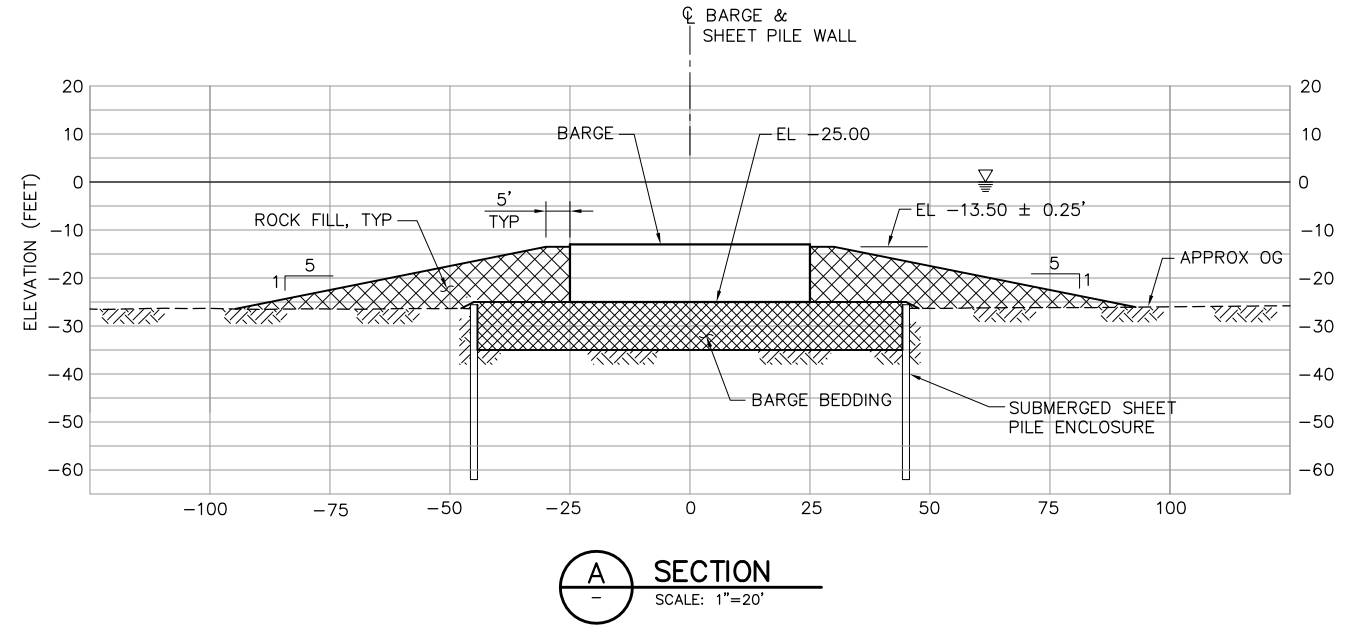

NOTES:

 
1. KING PILES AND SHEET PILES NEAR BARGE SHALL BE PLACED BEFORE ROCK FILL.
2. GATE AND ALL OTHER FEATURES NOT SHOWN FOR CLARITY.



100% SUBMITTAL
REVISION 1

IF SHEET IS LESS THAN 22" x 34"
IT IS A REDUCED PRINT -
SCALE REDUCED ACCORDINGLY.

REVISION	DESCRIPTION	BY	DATE

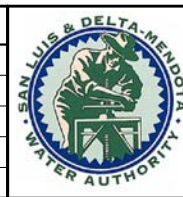

San Luis & Delta-Mendota Water Authority
842 6th Street, Suite 7
PO Box 2157
Los Banos, California 93635



2001 N. Main Street, Suite 360
Walnut Creek, California 94596
(925) 944-5411

DSGN	JMB	DR	EP/AB	CHK	TDB
JOB NO.	6097-03	SUBMITTED BY	RMR		

2-GATES FISH PROTECTION
DEMONSTRATION PROJECT





DATE 10/02/09

SHEET 36 OF 78


CONNECTION SLOUGH
BARGE - ROCK FILL
PLAN AND SECTIONS

C34

P:\6097-03 SWC GATE DESIGN\CADD\DWG\609703-C35.DWG 9/30/2009 4:14 PM

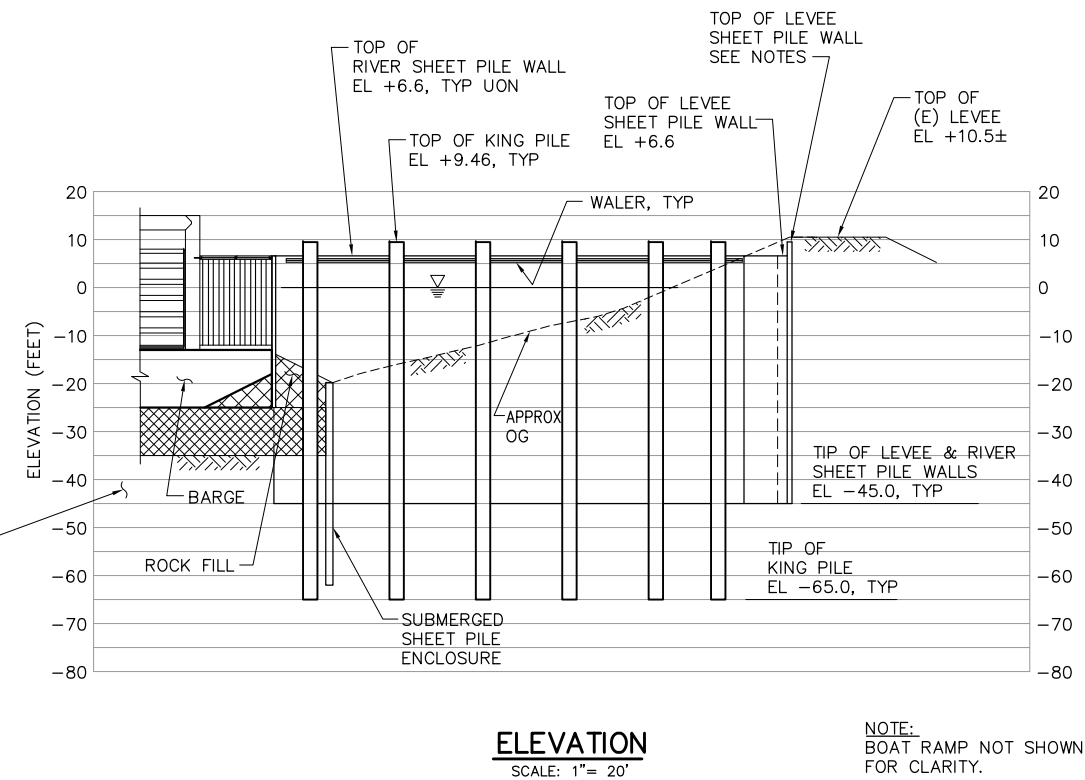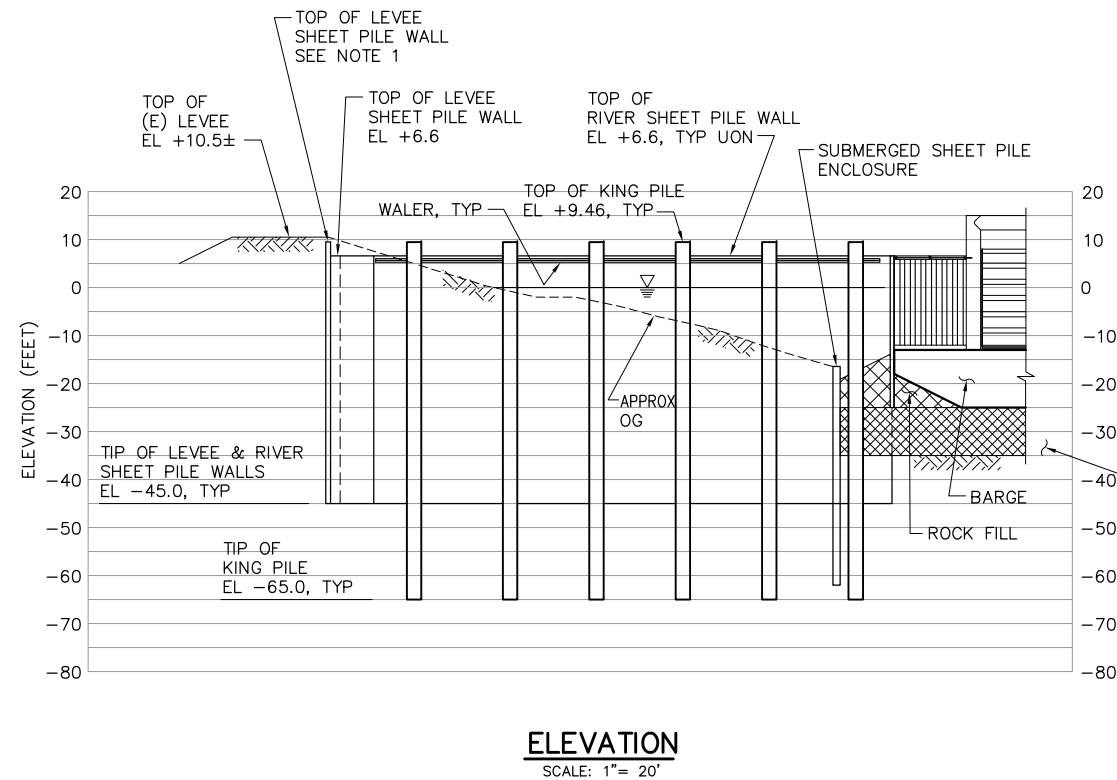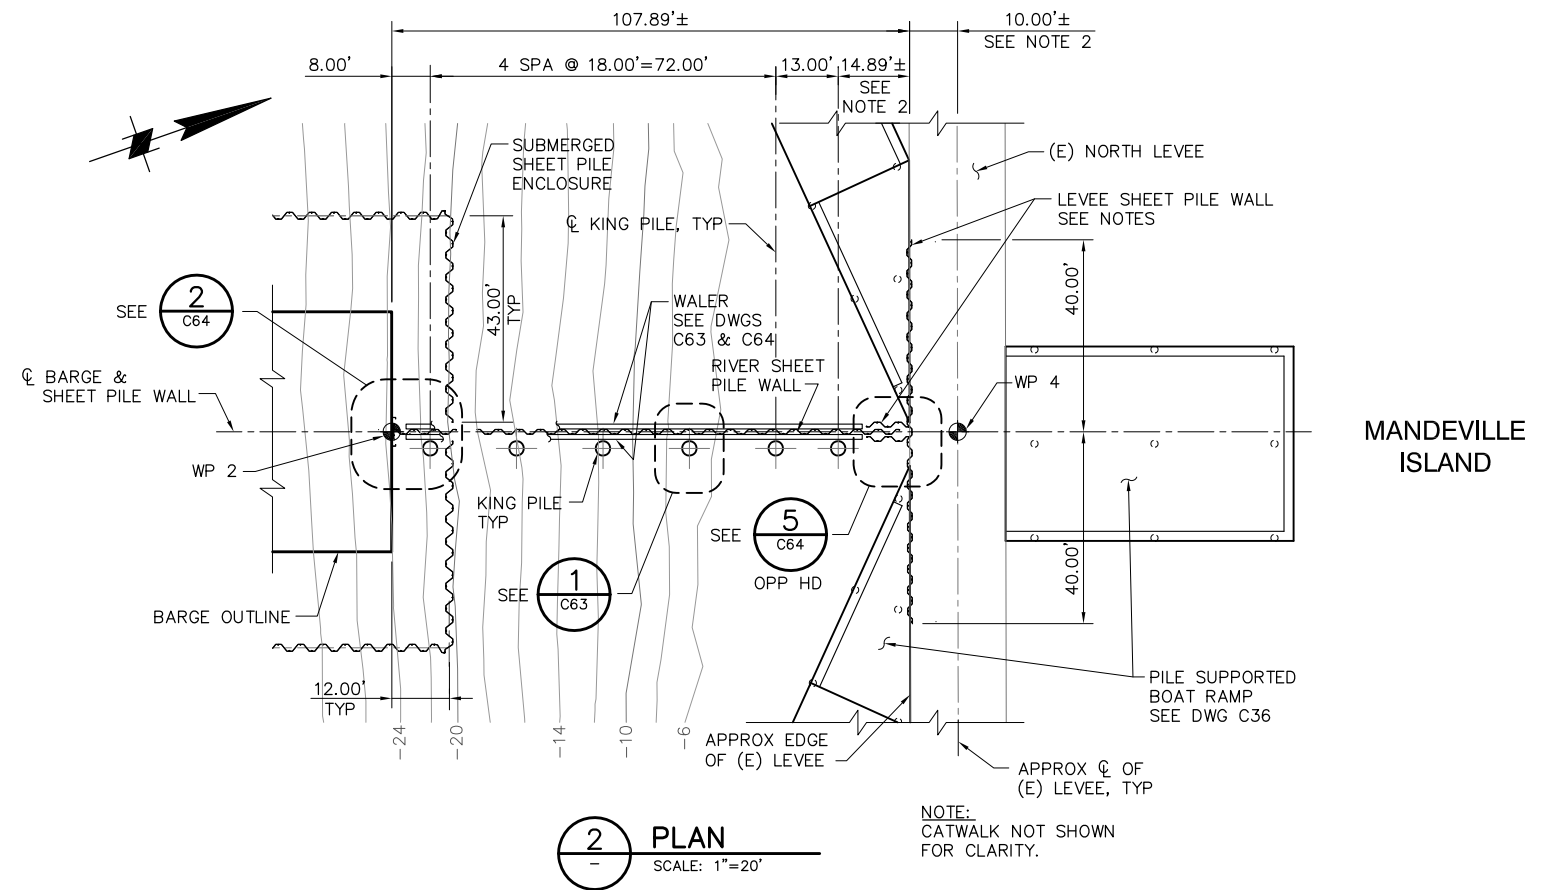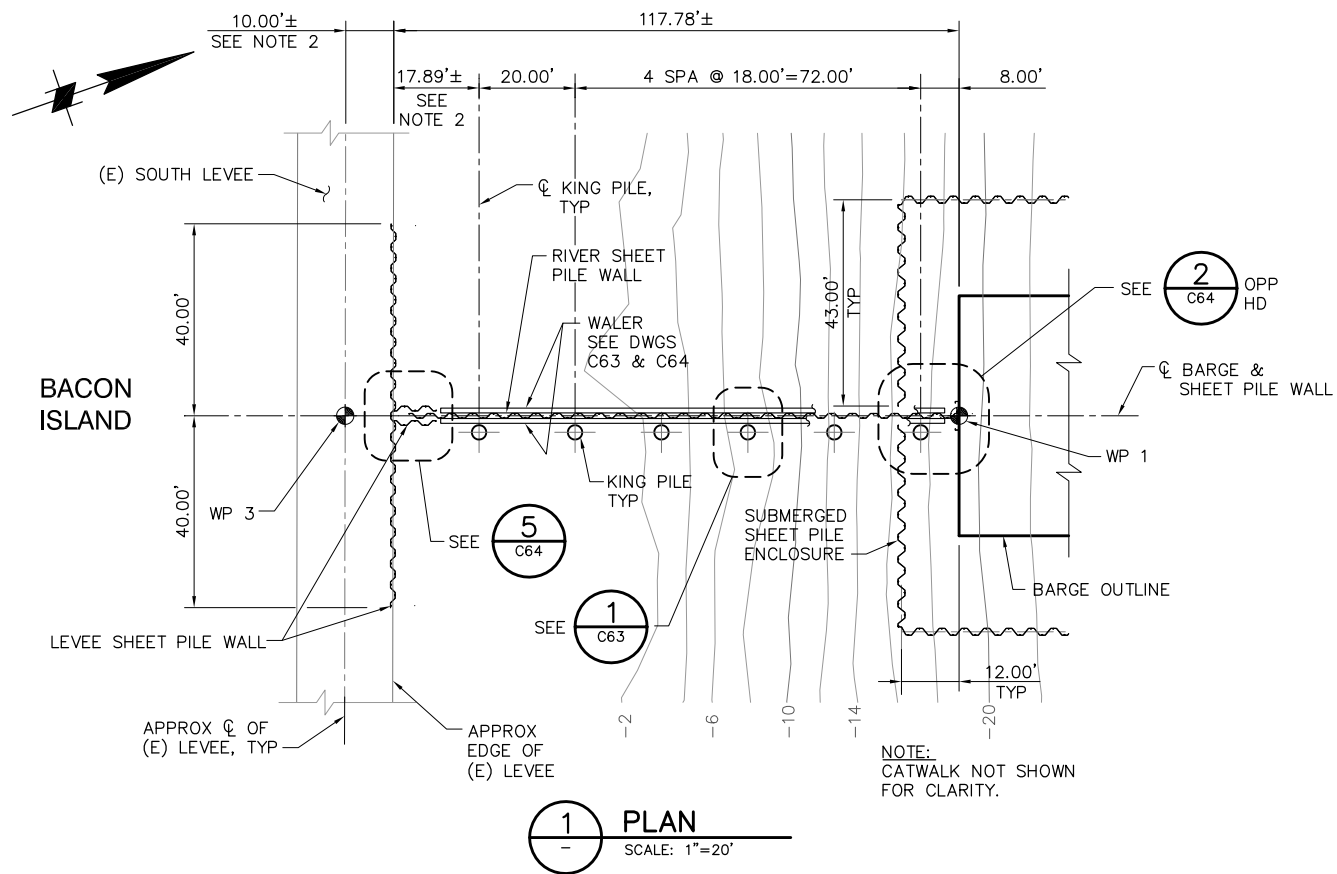

 
- NOTES:**
1. TOP OF LEVEE SHEET PILE WALL SHALL BE 6" BELOW TOP OF (E) LEVEE UON.
 2. LEVEE SHEET PILE WALL TO BE LOCATED 1 FT MIN OFF THE EDGE OF (E) ROAD SURFACE.



**100% SUBMITTAL
REVISION 1**

IF SHEET IS LESS THAN 22" x 34"
IT IS A REDUCED PRINT -
SCALE REDUCED ACCORDINGLY.

REVISION	DESCRIPTION	BY	DATE


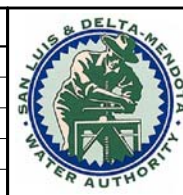


San Luis & Delta-Mendota Water Authority
842 6th Street, Suite 7
PO Box 2157
Los Banos, California 93635

		2001 N. Main Street, Suite 360 Walnut Creek, California 94596 (925) 944-5411	
DSGN	JMB	DR	EP/AB
JOB NO.	6097-03	SUBMITTED BY	RMR


2-GATES FISH PROTECTION DEMONSTRATION PROJECT		DATE 10/02/09
CONNECTION SLOUGH SHEET PILE WALL ARRANGEMENT PLAN AND ELEVATION		SHEET 37 OF 78
		C35

P:\6097-03 SWC GATE DESIGN\CADD\DWG\609703-C36.DWG 9/30/2009 10:31 AM

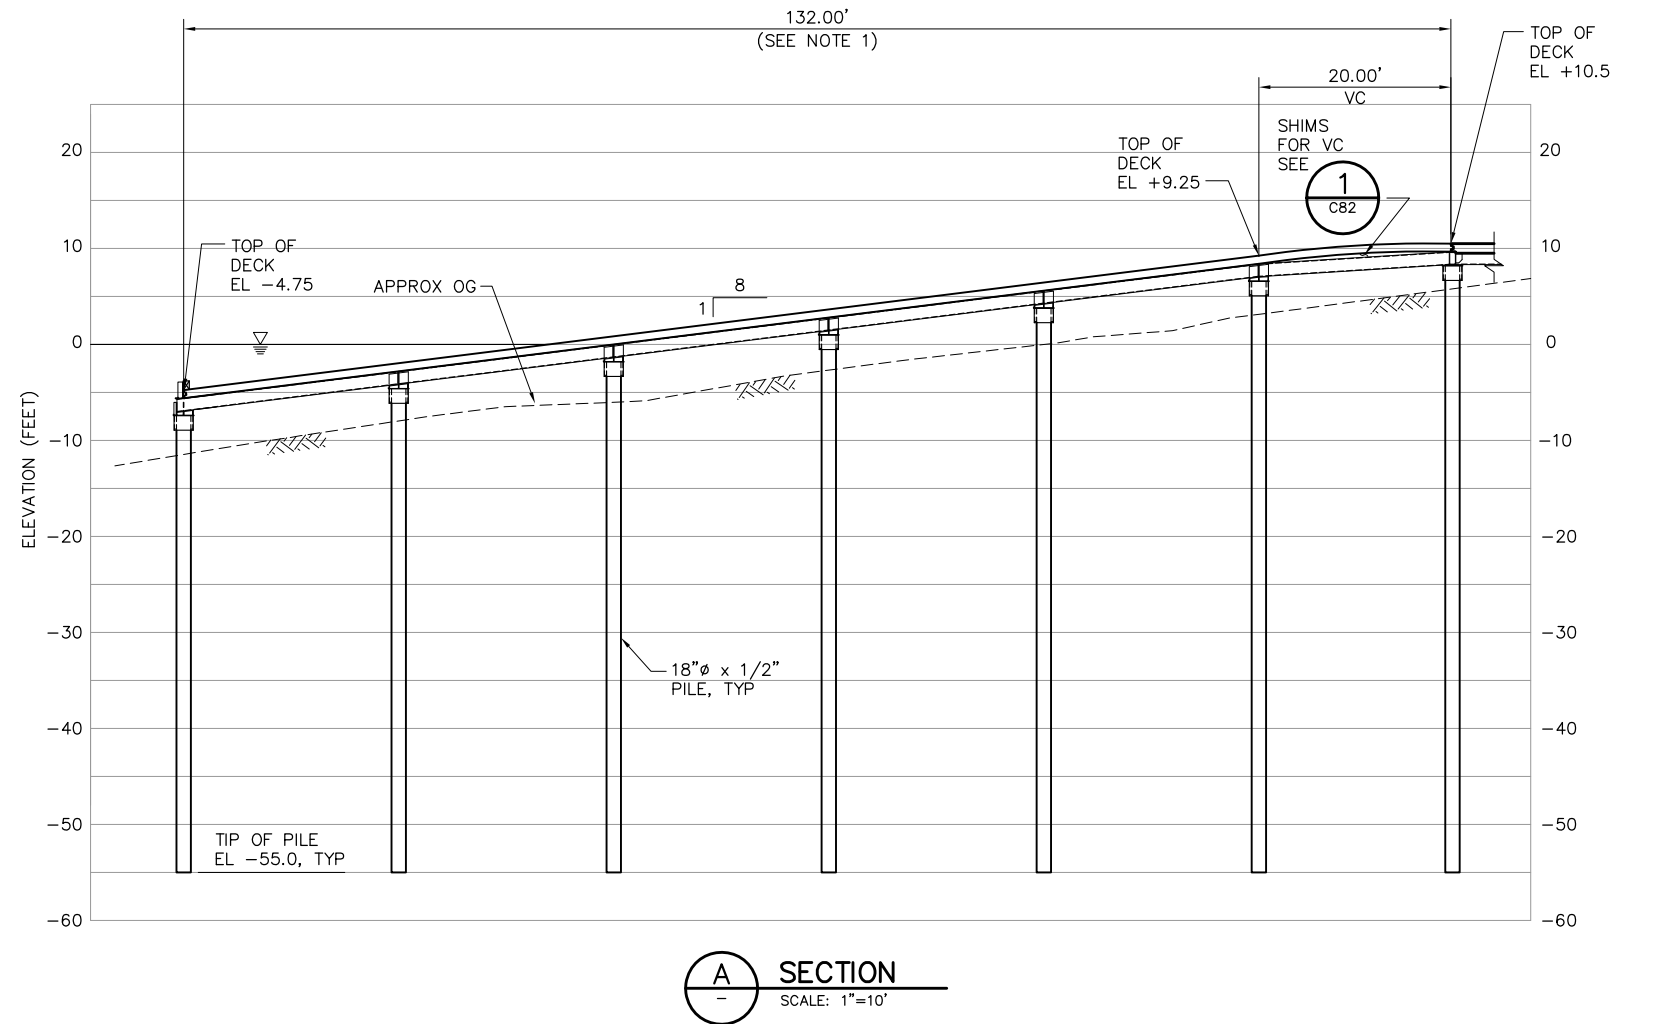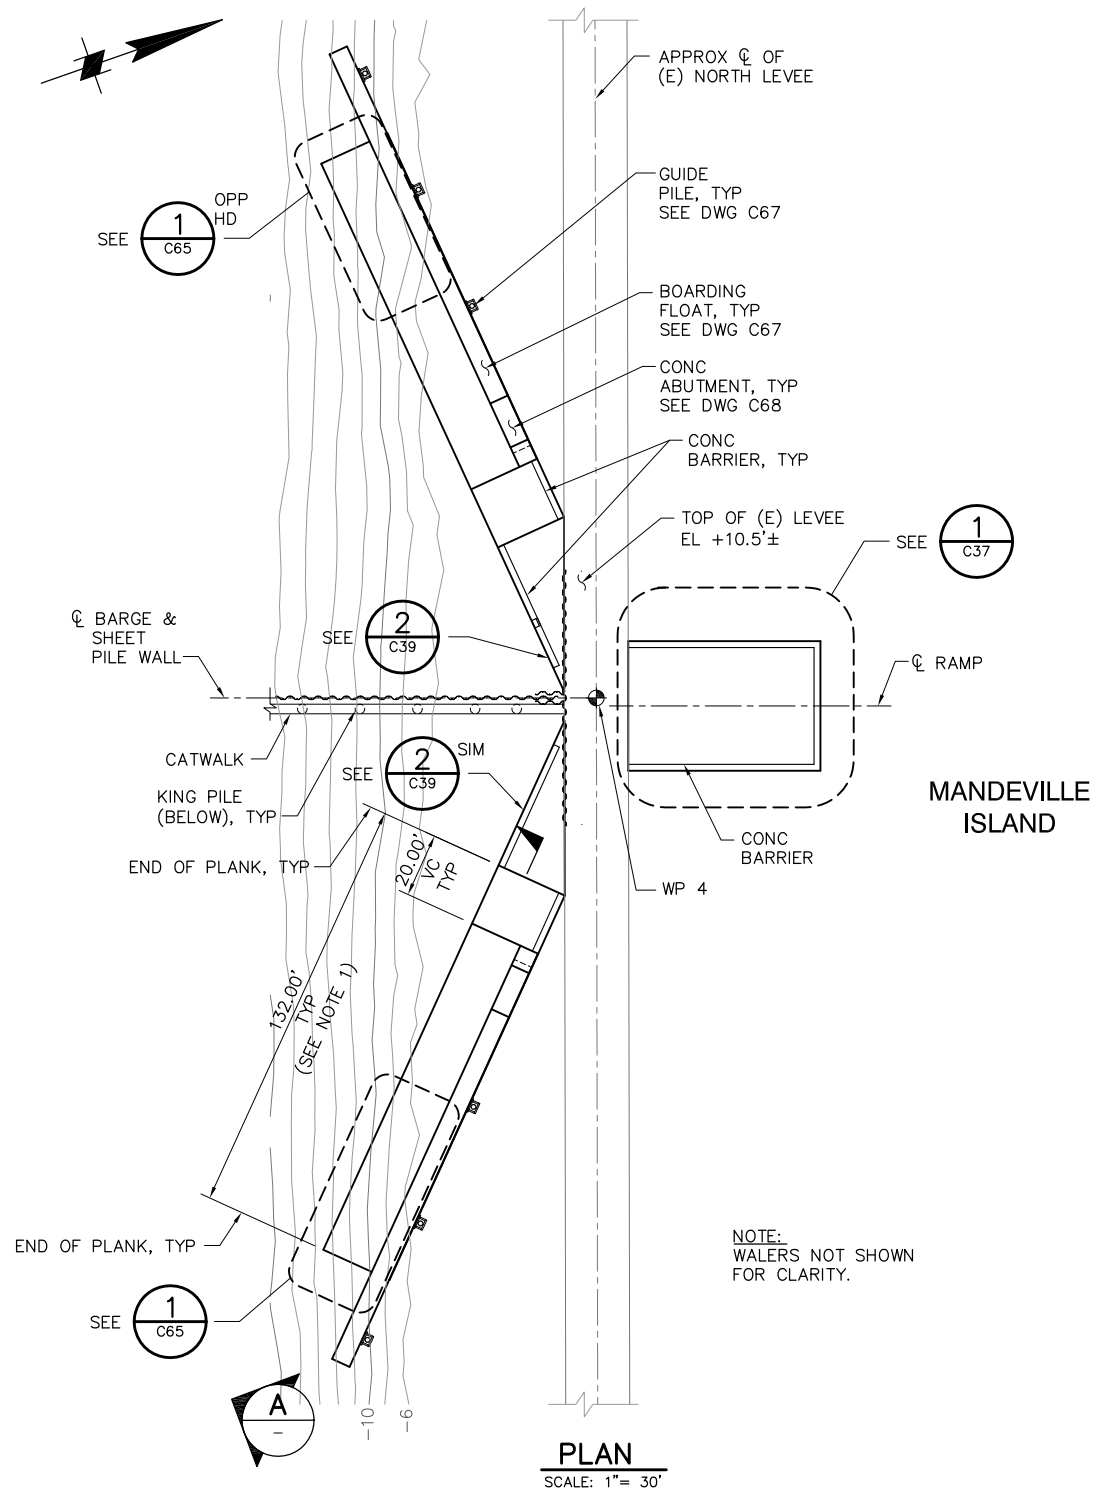

NOTES:


1. TRUE LENGTH OF RAMP ACCOUNTS FOR AN AVERAGE GAP OF 3/8" PER PLANK JOINT.

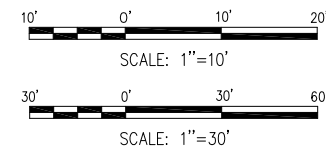

100% SUBMITTAL
REVISION 1

IF SHEET IS LESS THAN 22" x 34"
IT IS A REDUCED PRINT -
SCALE REDUCED ACCORDINGLY.

REVISION	DESCRIPTION	BY	DATE

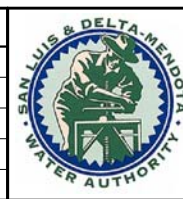

San Luis & Delta-Mendota Water Authority
842 6th Street, Suite 7
PO Box 2157
Los Banos, California 93635



2001 N. Main Street, Suite 360
Walnut Creek, California 94596
(925) 944-5411

DSGN	JMB	DR	EP/AB	CHK	TDB
JOB NO.	6097-03	SUBMITTED BY	RMR		

2-GATES FISH PROTECTION
DEMONSTRATION PROJECT


CONNECTION SLOUGH
BOAT RAMP PLAN AND SECTION

DATE 10/02/09

SHEET 38 OF 78

C36

P:\6097-03 SWC GATE DESIGN\CADD\DWG\609703-C36.2.DWG 10/1/2009 2:07 PM

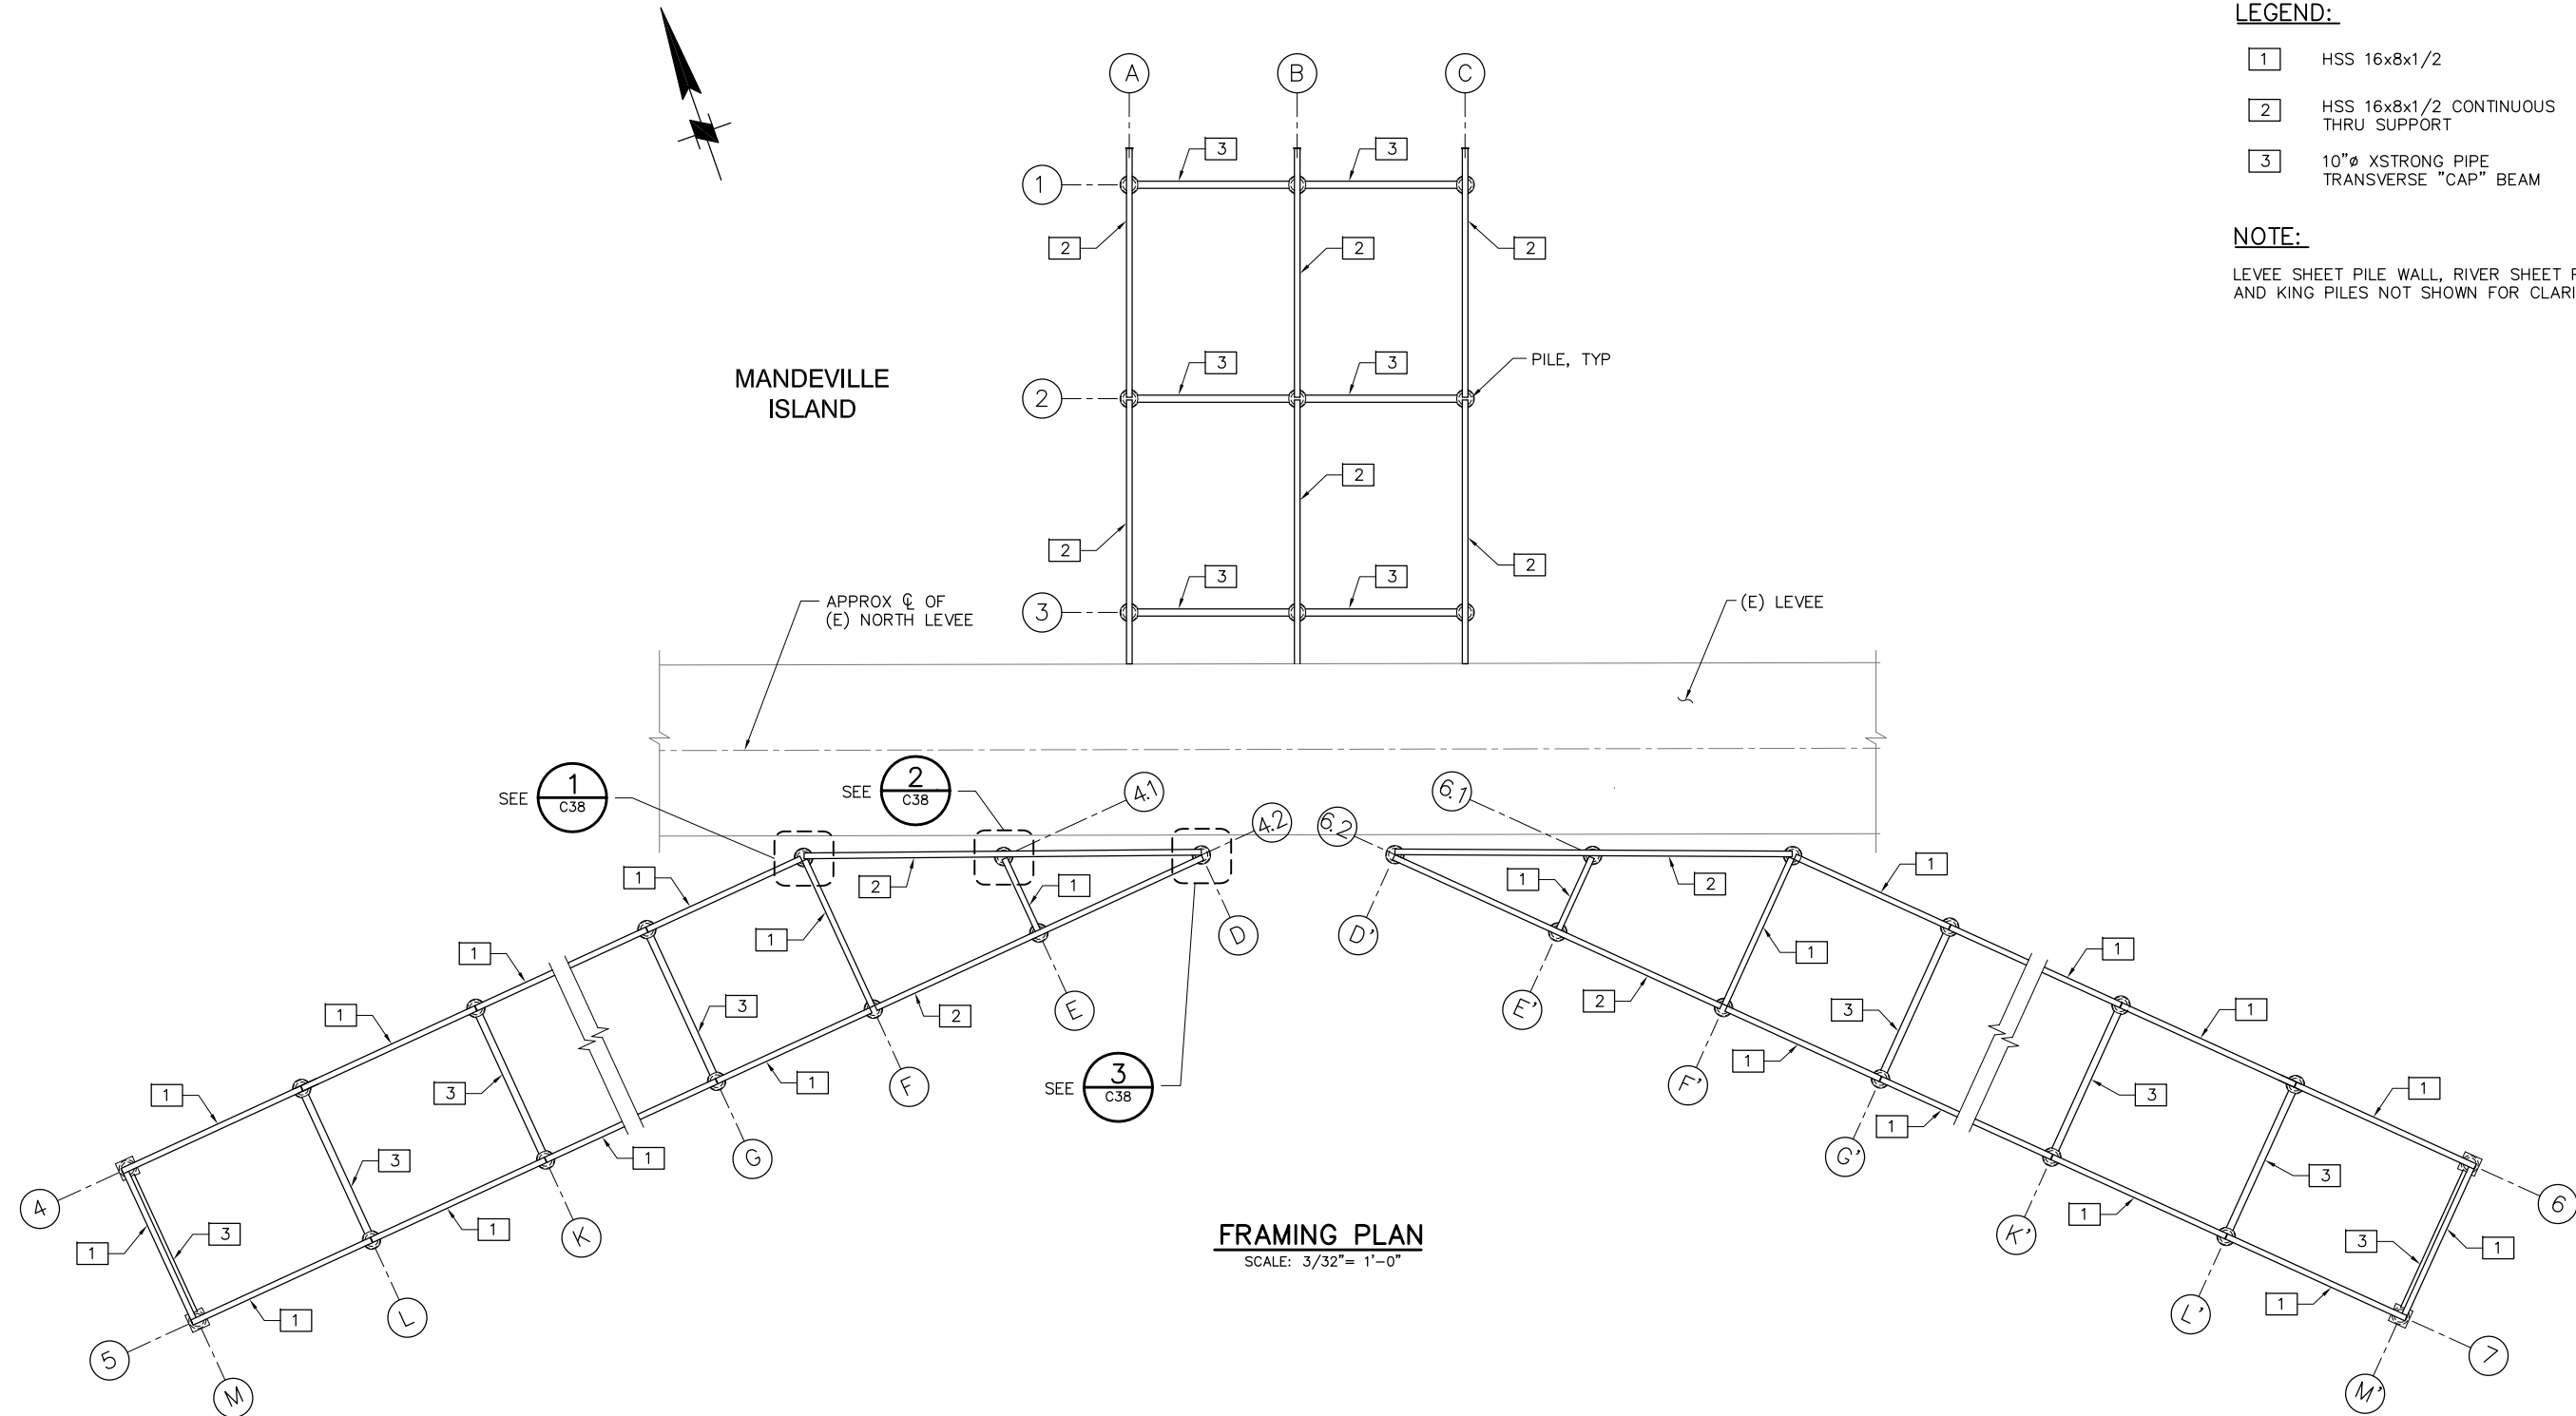


LEGEND:

- 1 HSS 16x8x1/2
- 2 HSS 16x8x1/2 CONTINUOUS THRU SUPPORT
- 3 10"Ø XSTRONG PIPE TRANSVERSE "CAP" BEAM

NOTE:

LEVEE SHEET PILE WALL, RIVER SHEET PILE WALL AND KING PILES NOT SHOWN FOR CLARITY.

 FRAMING PLAN
SCALE: 3/32"= 1'-0"




**100% SUBMITTAL
REVISION 1** IF SHEET IS LESS THAN 22" x 34"
IT IS A REDUCED PRINT -
SCALE REDUCED ACCORDINGLY.

REVISION	DESCRIPTION	BY	DATE

 San Luis & Delta-Mendota Water Authority 842 6th Street, Suite 7 PO Box 2157 Los Banos, California 93635	 2001 N. Main Street, Suite 360 Walnut Creek, California 94596 (925) 944-5411	2-GATES FISH PROTECTION DEMONSTRATION PROJECT		DATE 10/02/09
		CONNECTION SLOUGH BOAT RAMP FRAMING PLAN		SHEET 40 OF 78
				C36.2

DSGN JMB	DR EP/AB	CHK TDB
JOB NO. 6097-03	SUBMITTED BY RMR	

P:\6097-03 SWC GATE DESIGN\CADD\DWG\609703-C37.DWG 9/1/2009 9:53 AM

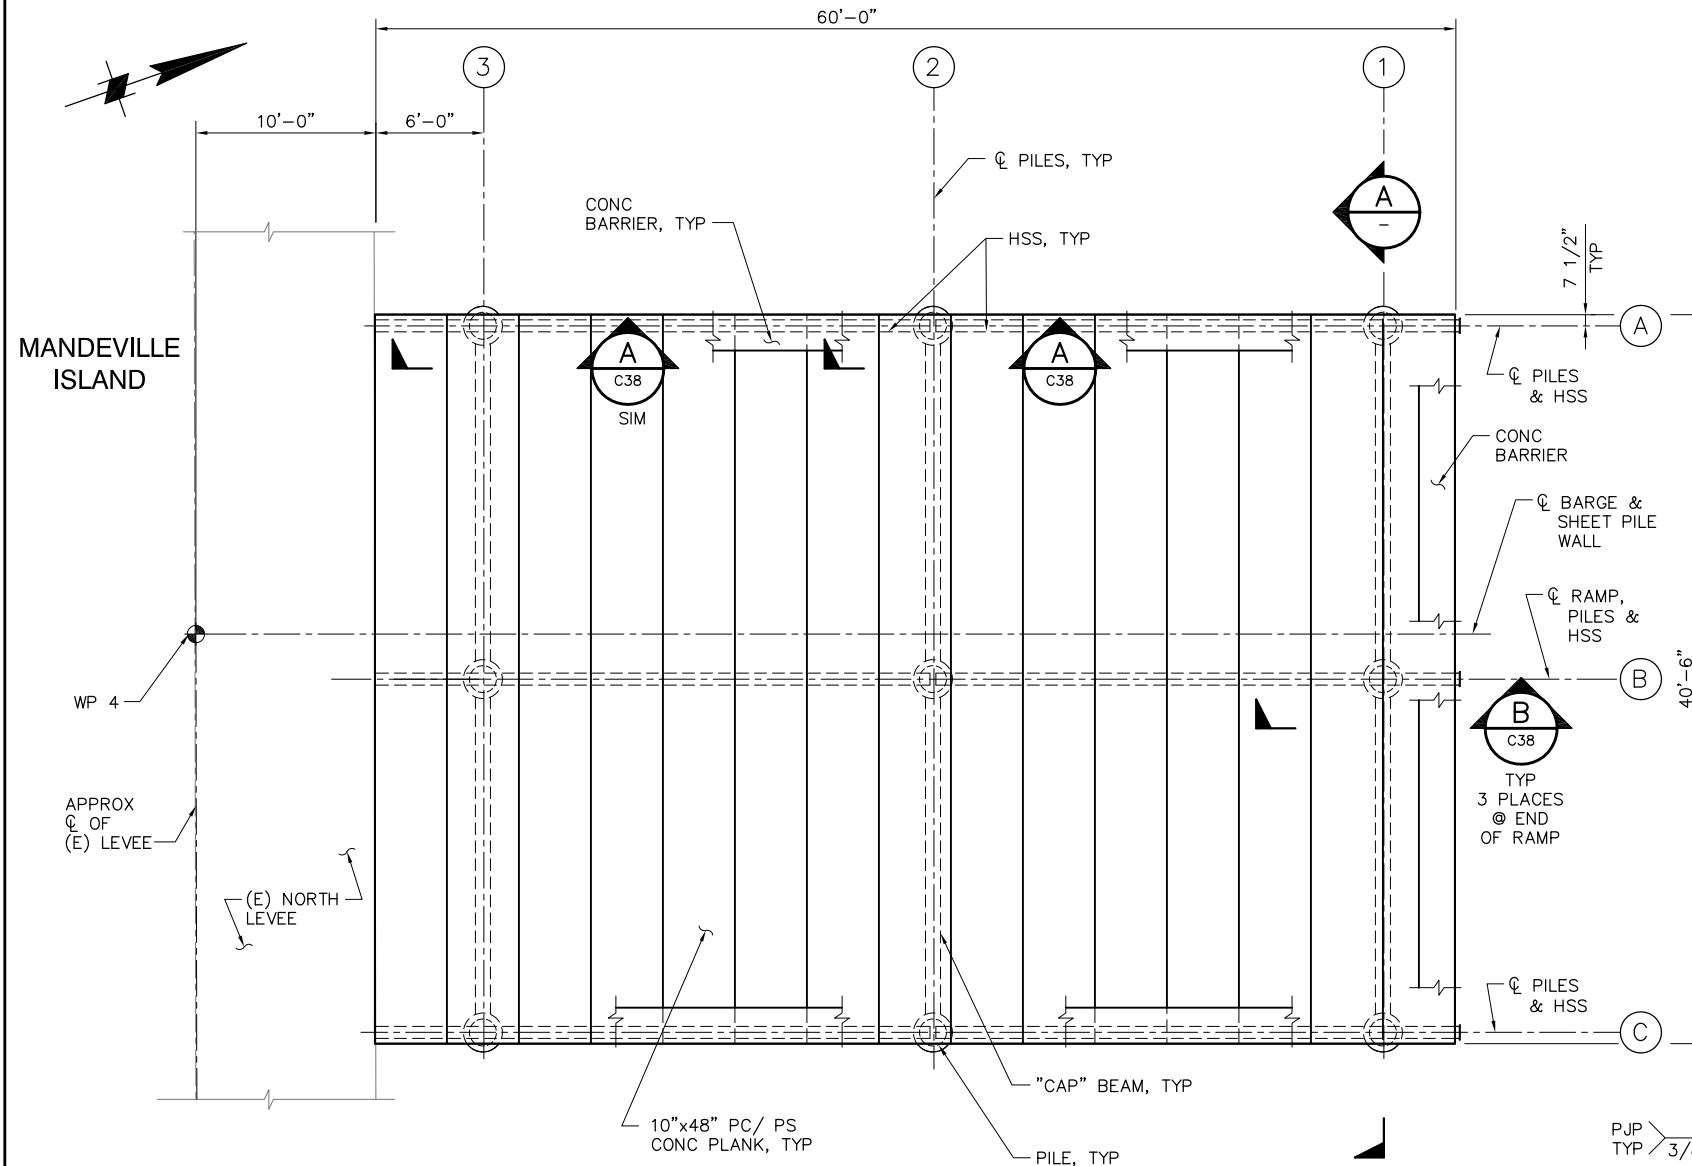


1 DETAIL
SCALE: 3/16" = 1'-0"

NOTES:


- ALL PC/PS PLANKS SHALL BEAR ON/AGAINST NEOPRENE "UNDERLAYMENT" BEARING STRIP WITH A MINIMUM 1/8" THICKNESS.

WELDING NOTE:

ALL STIFFENER PLATES SHALL HAVE DOUBLE SIDED 1/4" FILLET WELDS UON.

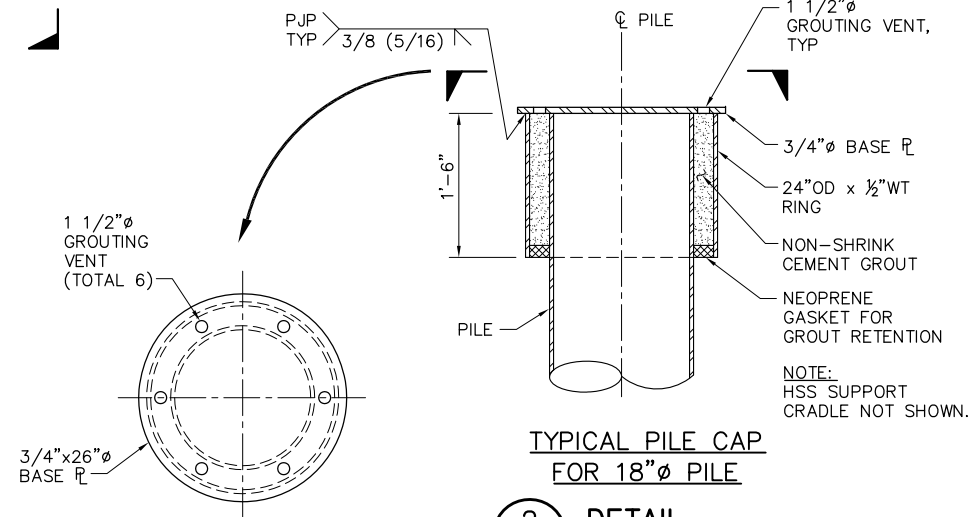

2 DETAIL
SCALE: 1" = 1'-0"

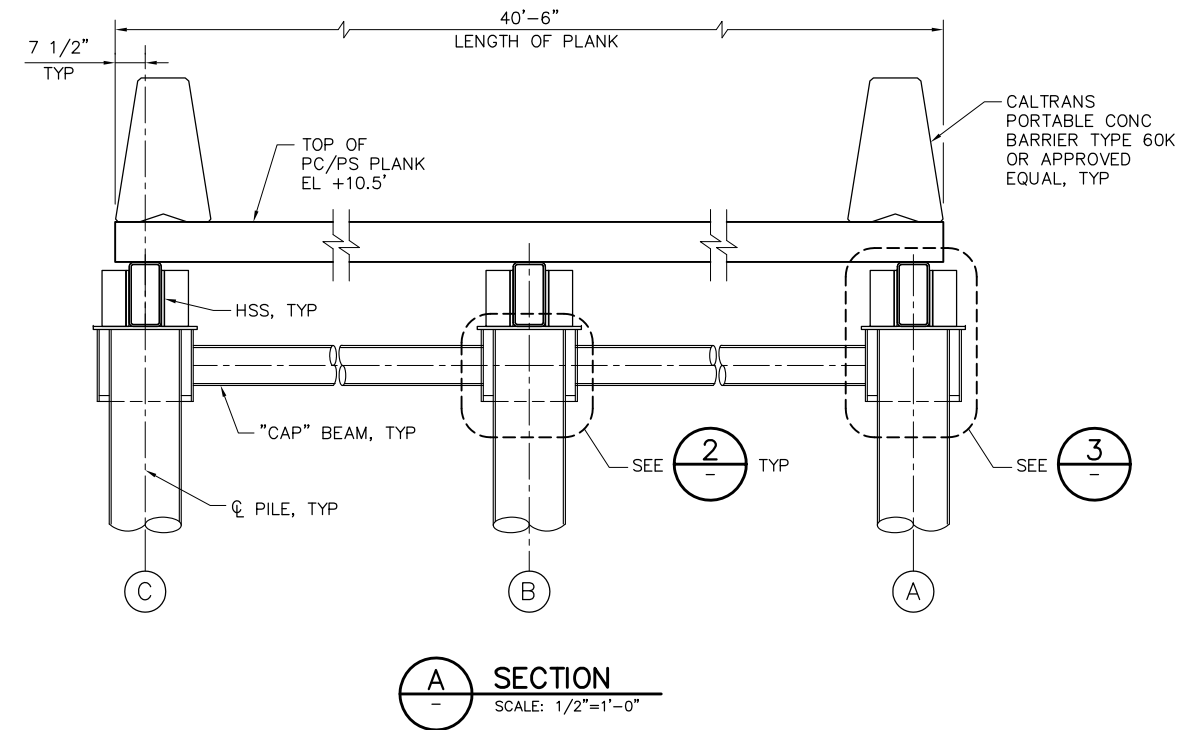

3 DETAIL
SCALE: 1" = 1'-0"

1'-0" 0'-0" 1'-0" 2'-0"
SCALE: 1" = 1'-0"

**100% SUBMITTAL
REVISION 1**

IF SHEET IS LESS THAN 22" x 34"
IT IS A REDUCED PRINT -
SCALE REDUCED ACCORDINGLY.

REVISION	DESCRIPTION	BY	DATE



San Luis & Delta-Mendota Water Authority
842 6th Street, Suite 7
PO Box 2157
Los Banos, California 93635



2001 N. Main Street, Suite 360
Walnut Creek, California 94596
(925) 944-5411

DSGN	JMB	DR	EP/AB	CHK	TDB
JOB NO.	6097-03	SUBMITTED BY	RMR		

2-GATES FISH PROTECTION
DEMONSTRATION PROJECT

CONNECTION SLOUGH
BOAT RAMP DETAILS AND SECTIONS
SHEET 1

 
DATE 10/02/09

SHEET 41 OF 78


C37




ALL STIFFENER PLATES SHALL HAVE DOUBLE SIDED
1/4" FILLET WELDS UON.

C38


P:\6097-03 SWC GATE DESIGN\CADD\DWG\609703-C39.DWG 9/2/2009 10:57 AM

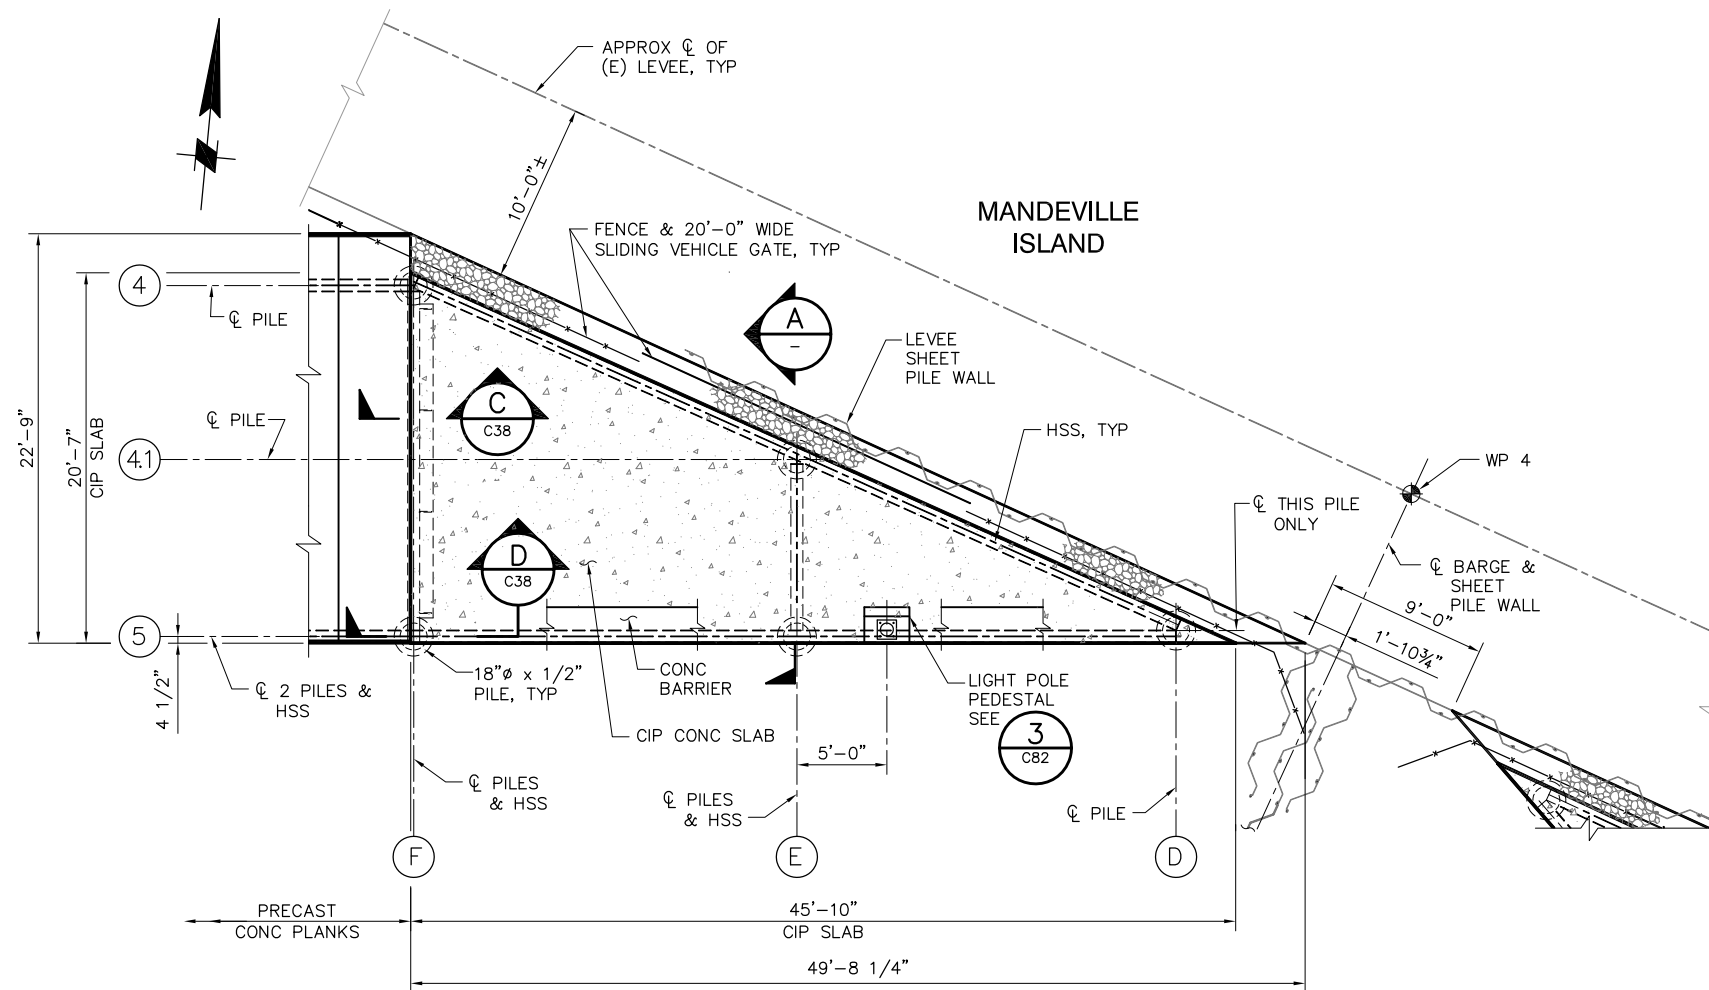


2 DETAIL
C36 SCALE: 3/16" = 1'-0"

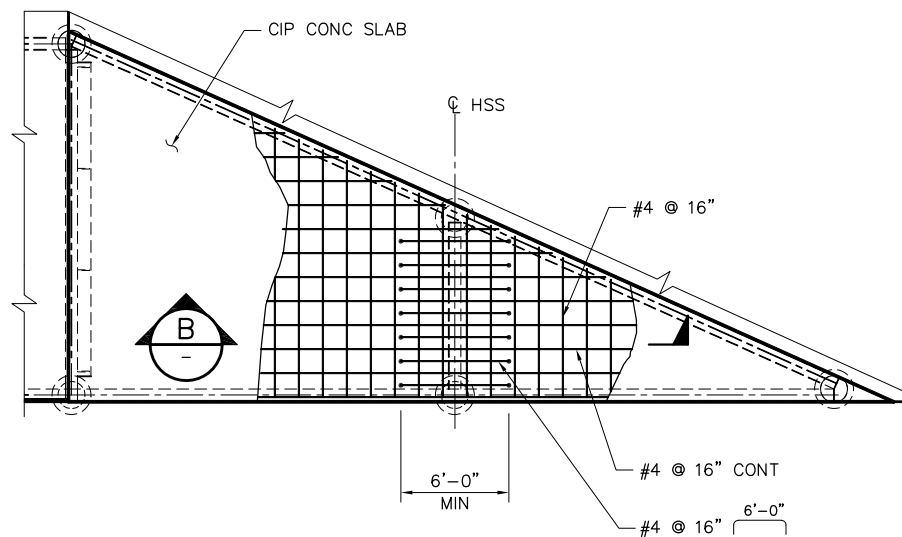


TOP SLAB REINFORCEMENT
SCALE: 3/16" = 1'-0"

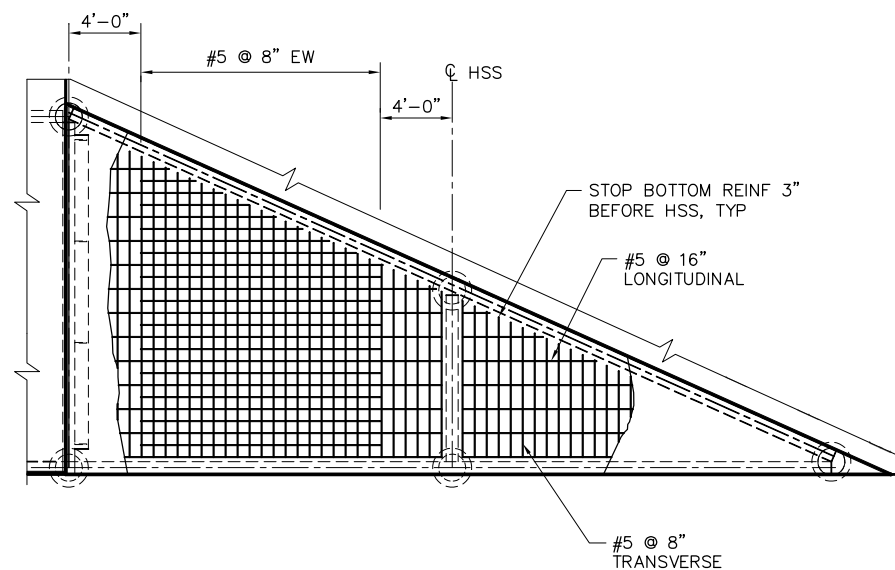


BOTTOM SLAB REINFORCEMENT
SCALE: 3/16" = 1'-0"

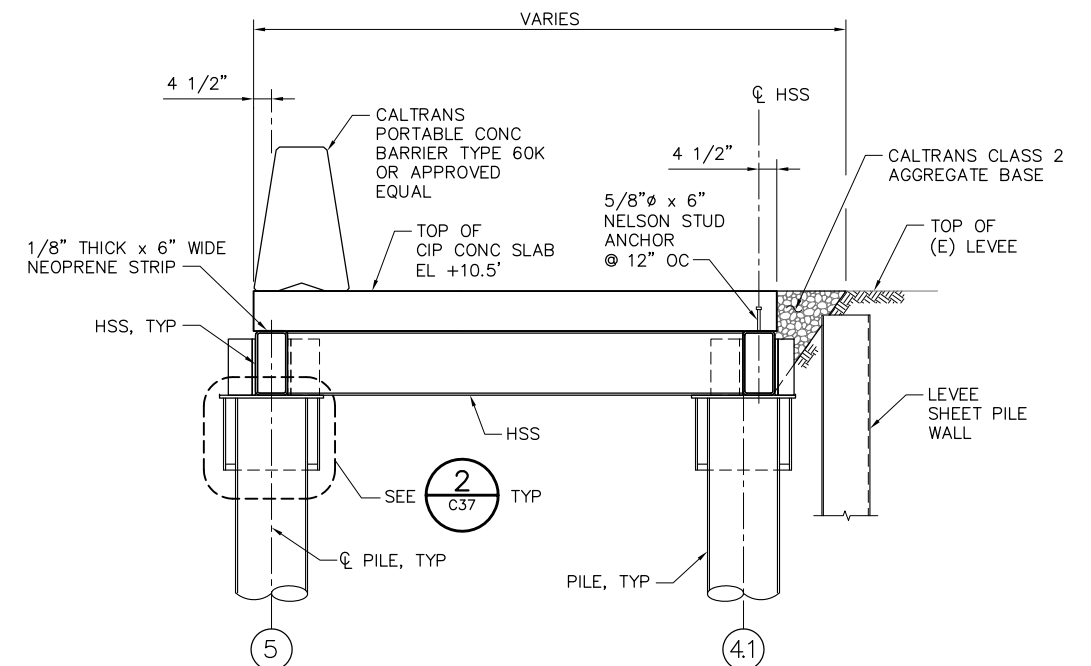

A SECTION
SCALE: 1/2" = 1'-0"

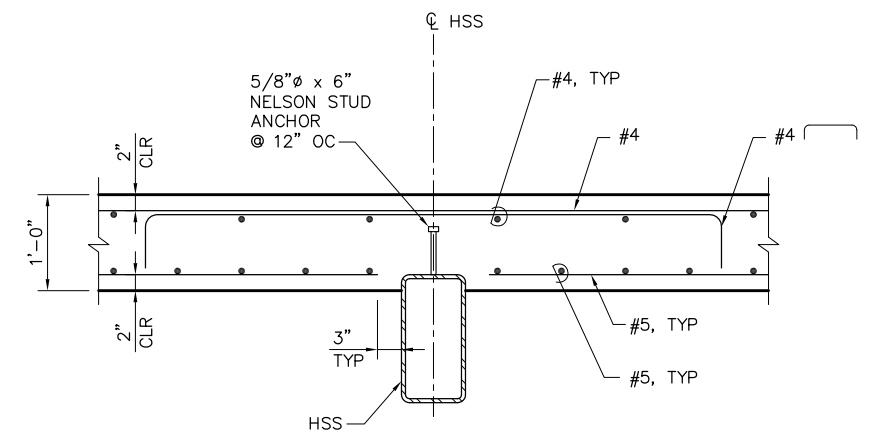


B SECTION
SCALE: 1" = 1'-0"

 

**100% SUBMITTAL
REVISION 1**

IF SHEET IS LESS THAN 22" x 34"
IT IS A REDUCED PRINT -
SCALE REDUCED ACCORDINGLY.

REVISION	DESCRIPTION	BY	DATE





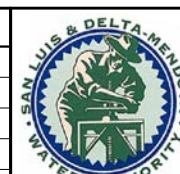


San Luis & Delta-Mendota Water Authority
842 6th Street, Suite 7
PO Box 2157
Los Banos, California 93635

		2001 N. Main Street, Suite 360 Walnut Creek, California 94596 (925) 944-5411	
DSGN	JMB	DR	EP/AB
JOB NO.	6097-03	SUBMITTED BY	RMR

2-GATES FISH PROTECTION DEMONSTRATION PROJECT		DATE 10/02/09
CONNECTION SLOUGH BOAT RAMP DETAILS AND SECTIONS SHEET 3		SHEET 43 OF 78
		C39

 
P:\6097-03 SWC GATE DESIGN\CADD\DWG\609703-C40.DWG 9/29/2009 11:48 AM

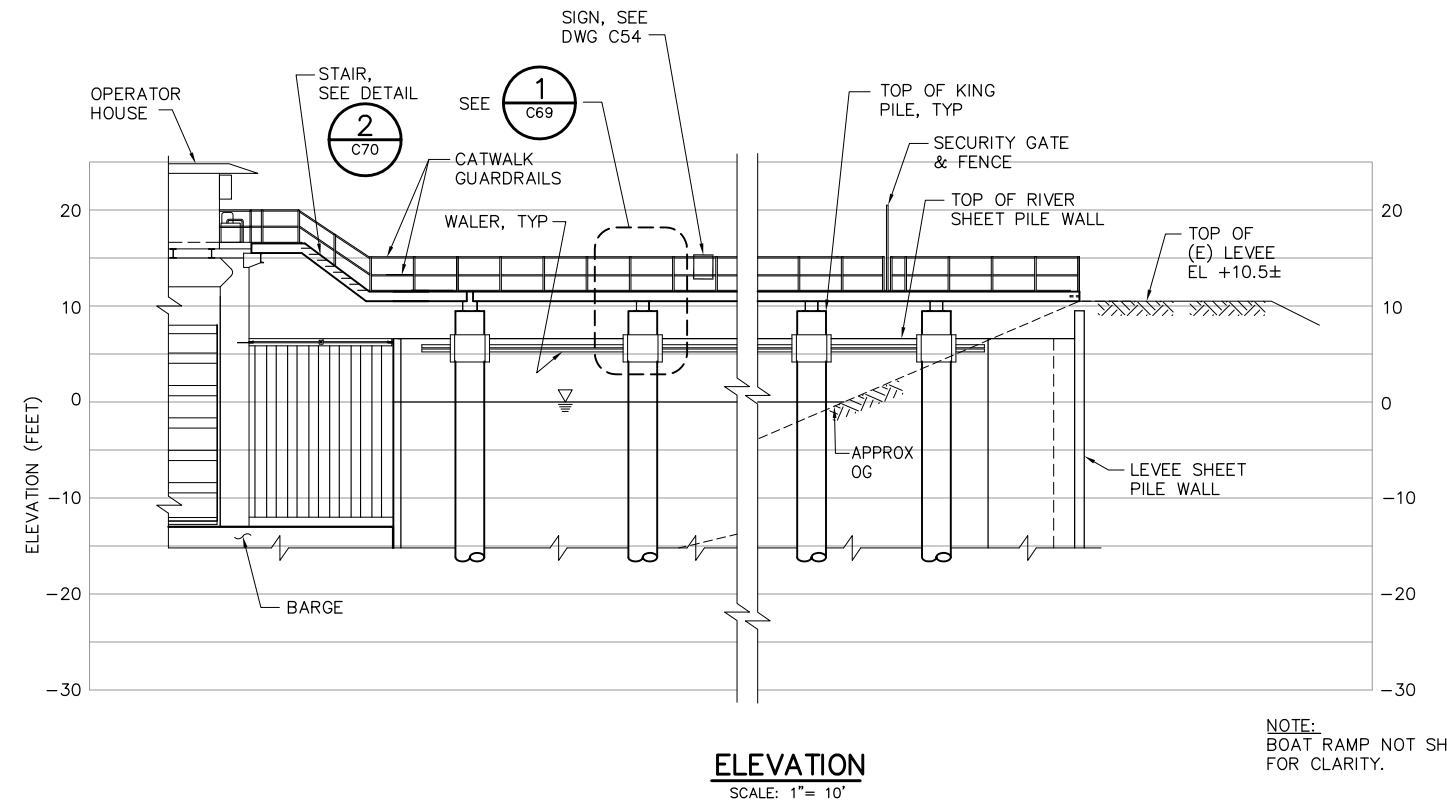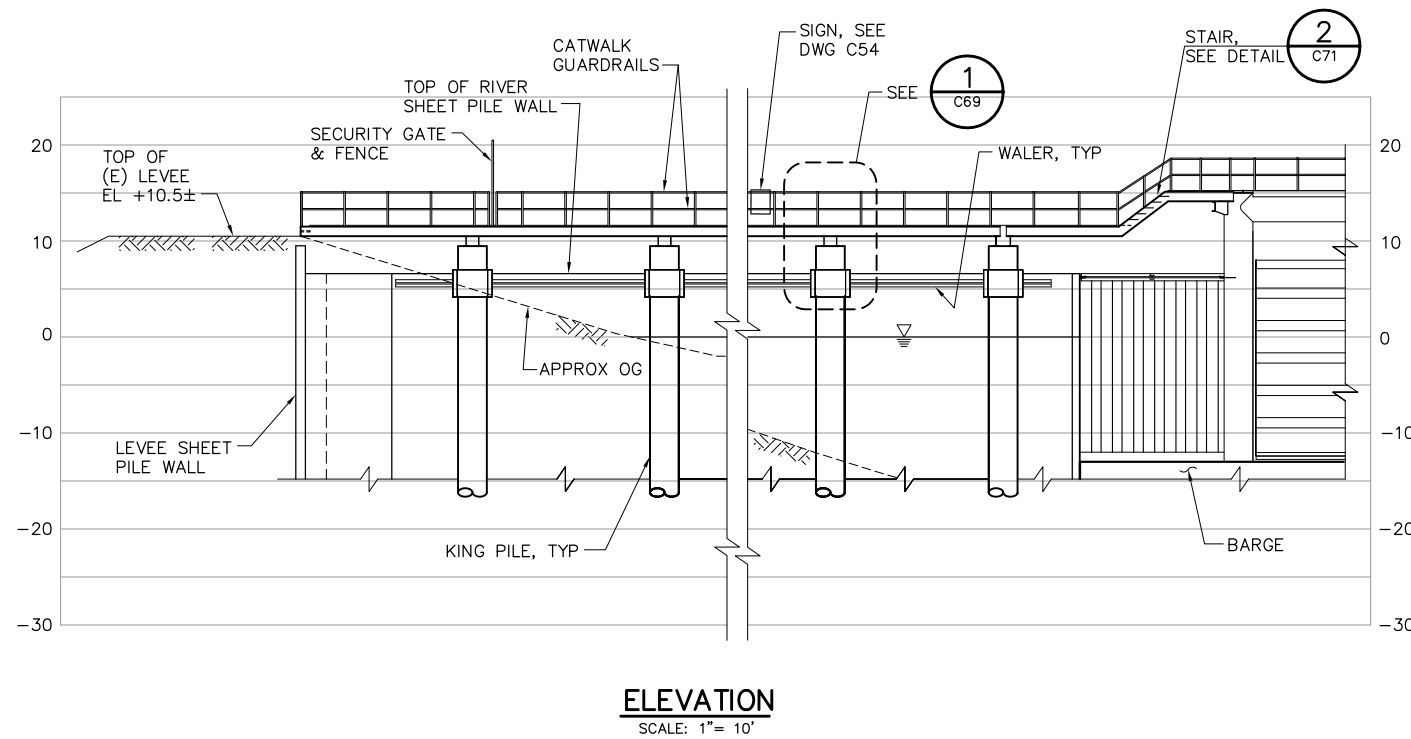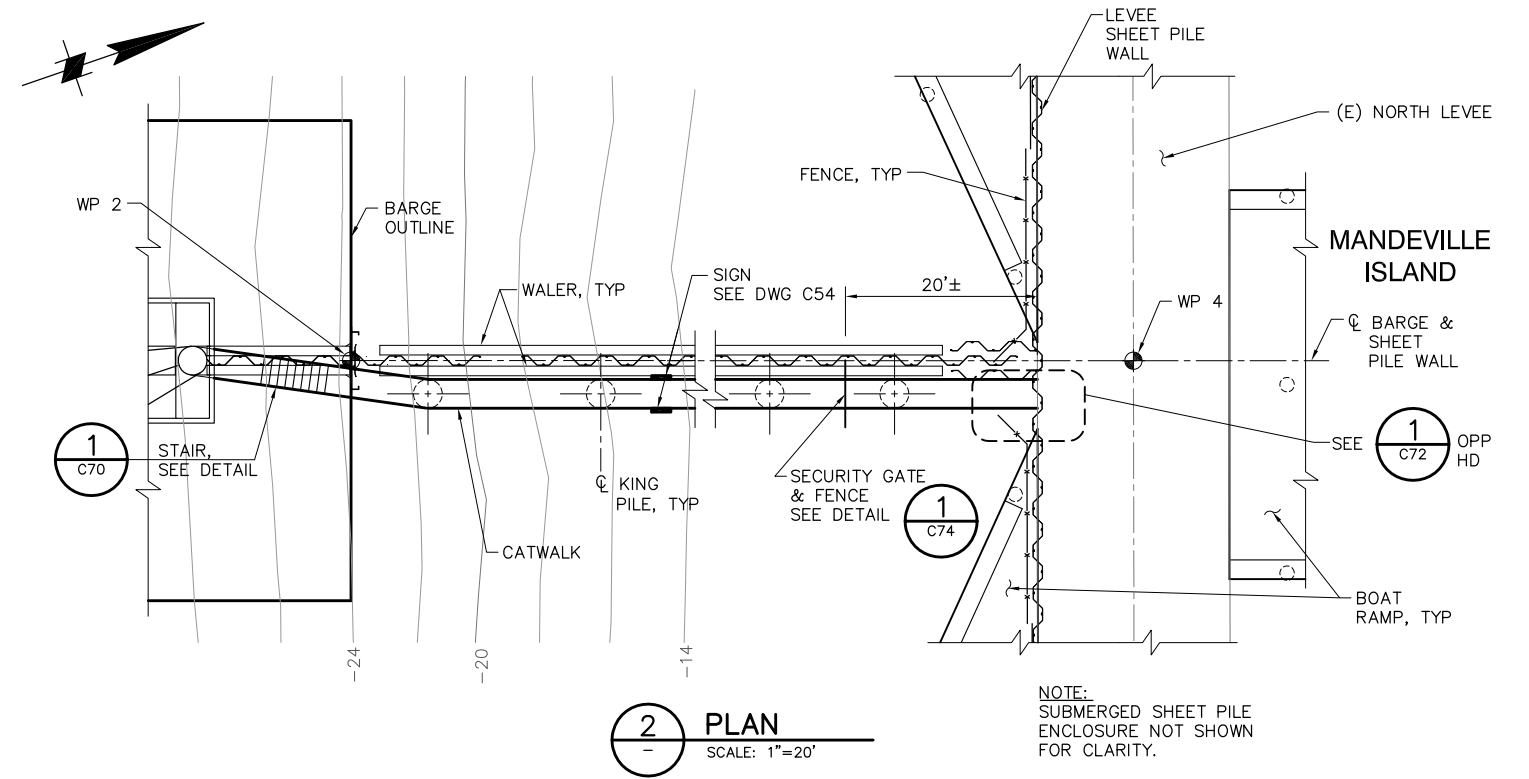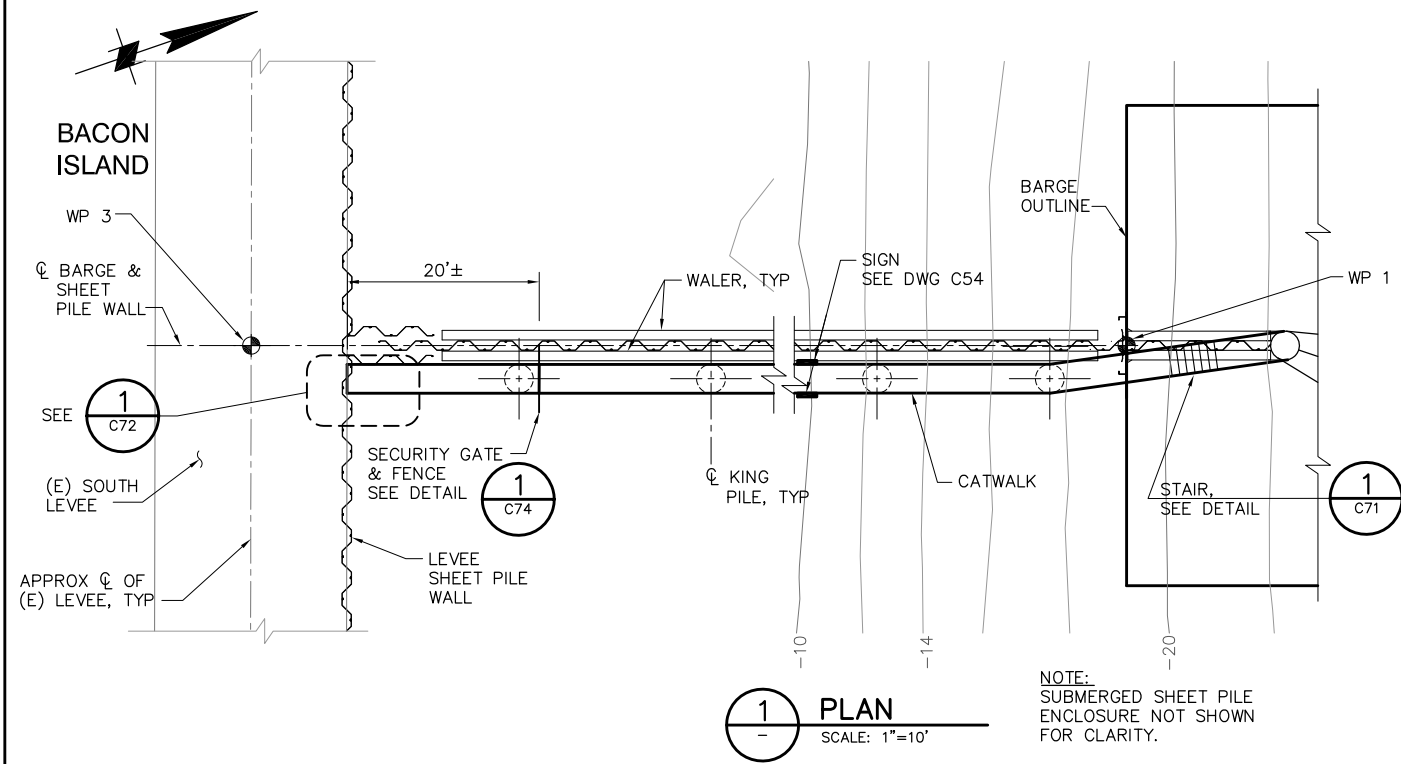

**100% SUBMITTAL
REVISION 1**

IF SHEET IS LESS THAN 22" x 34"
IT IS A REDUCED PRINT -
SCALE REDUCED ACCORDINGLY.

REVISION	DESCRIPTION	BY	DATE

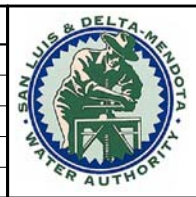

San Luis & Delta-Mendota Water Authority
842 6th Street, Suite 7
PO Box 2157
Los Banos, California 93635


 Moffatt & Nichol		2001 N. Main Street, Suite 360 Walnut Creek, California 94596 (925) 944-5411	
DSGN	JMB	DR	EP/AB
JOB NO.	6097-03	SUBMITTED BY	RMR
CHK	TDB		

2-GATES FISH PROTECTION
DEMONSTRATION PROJECT


CONNECTION SLOUGH
CATWALK
PLAN AND ELEVATION

DATE	10/02/09
SHEET	44 OF 78
C40	

P:\6097-03 SWC GATE DESIGN\CADD\DWG\609703-C41.DWG 10/1/2009 10:45 AM

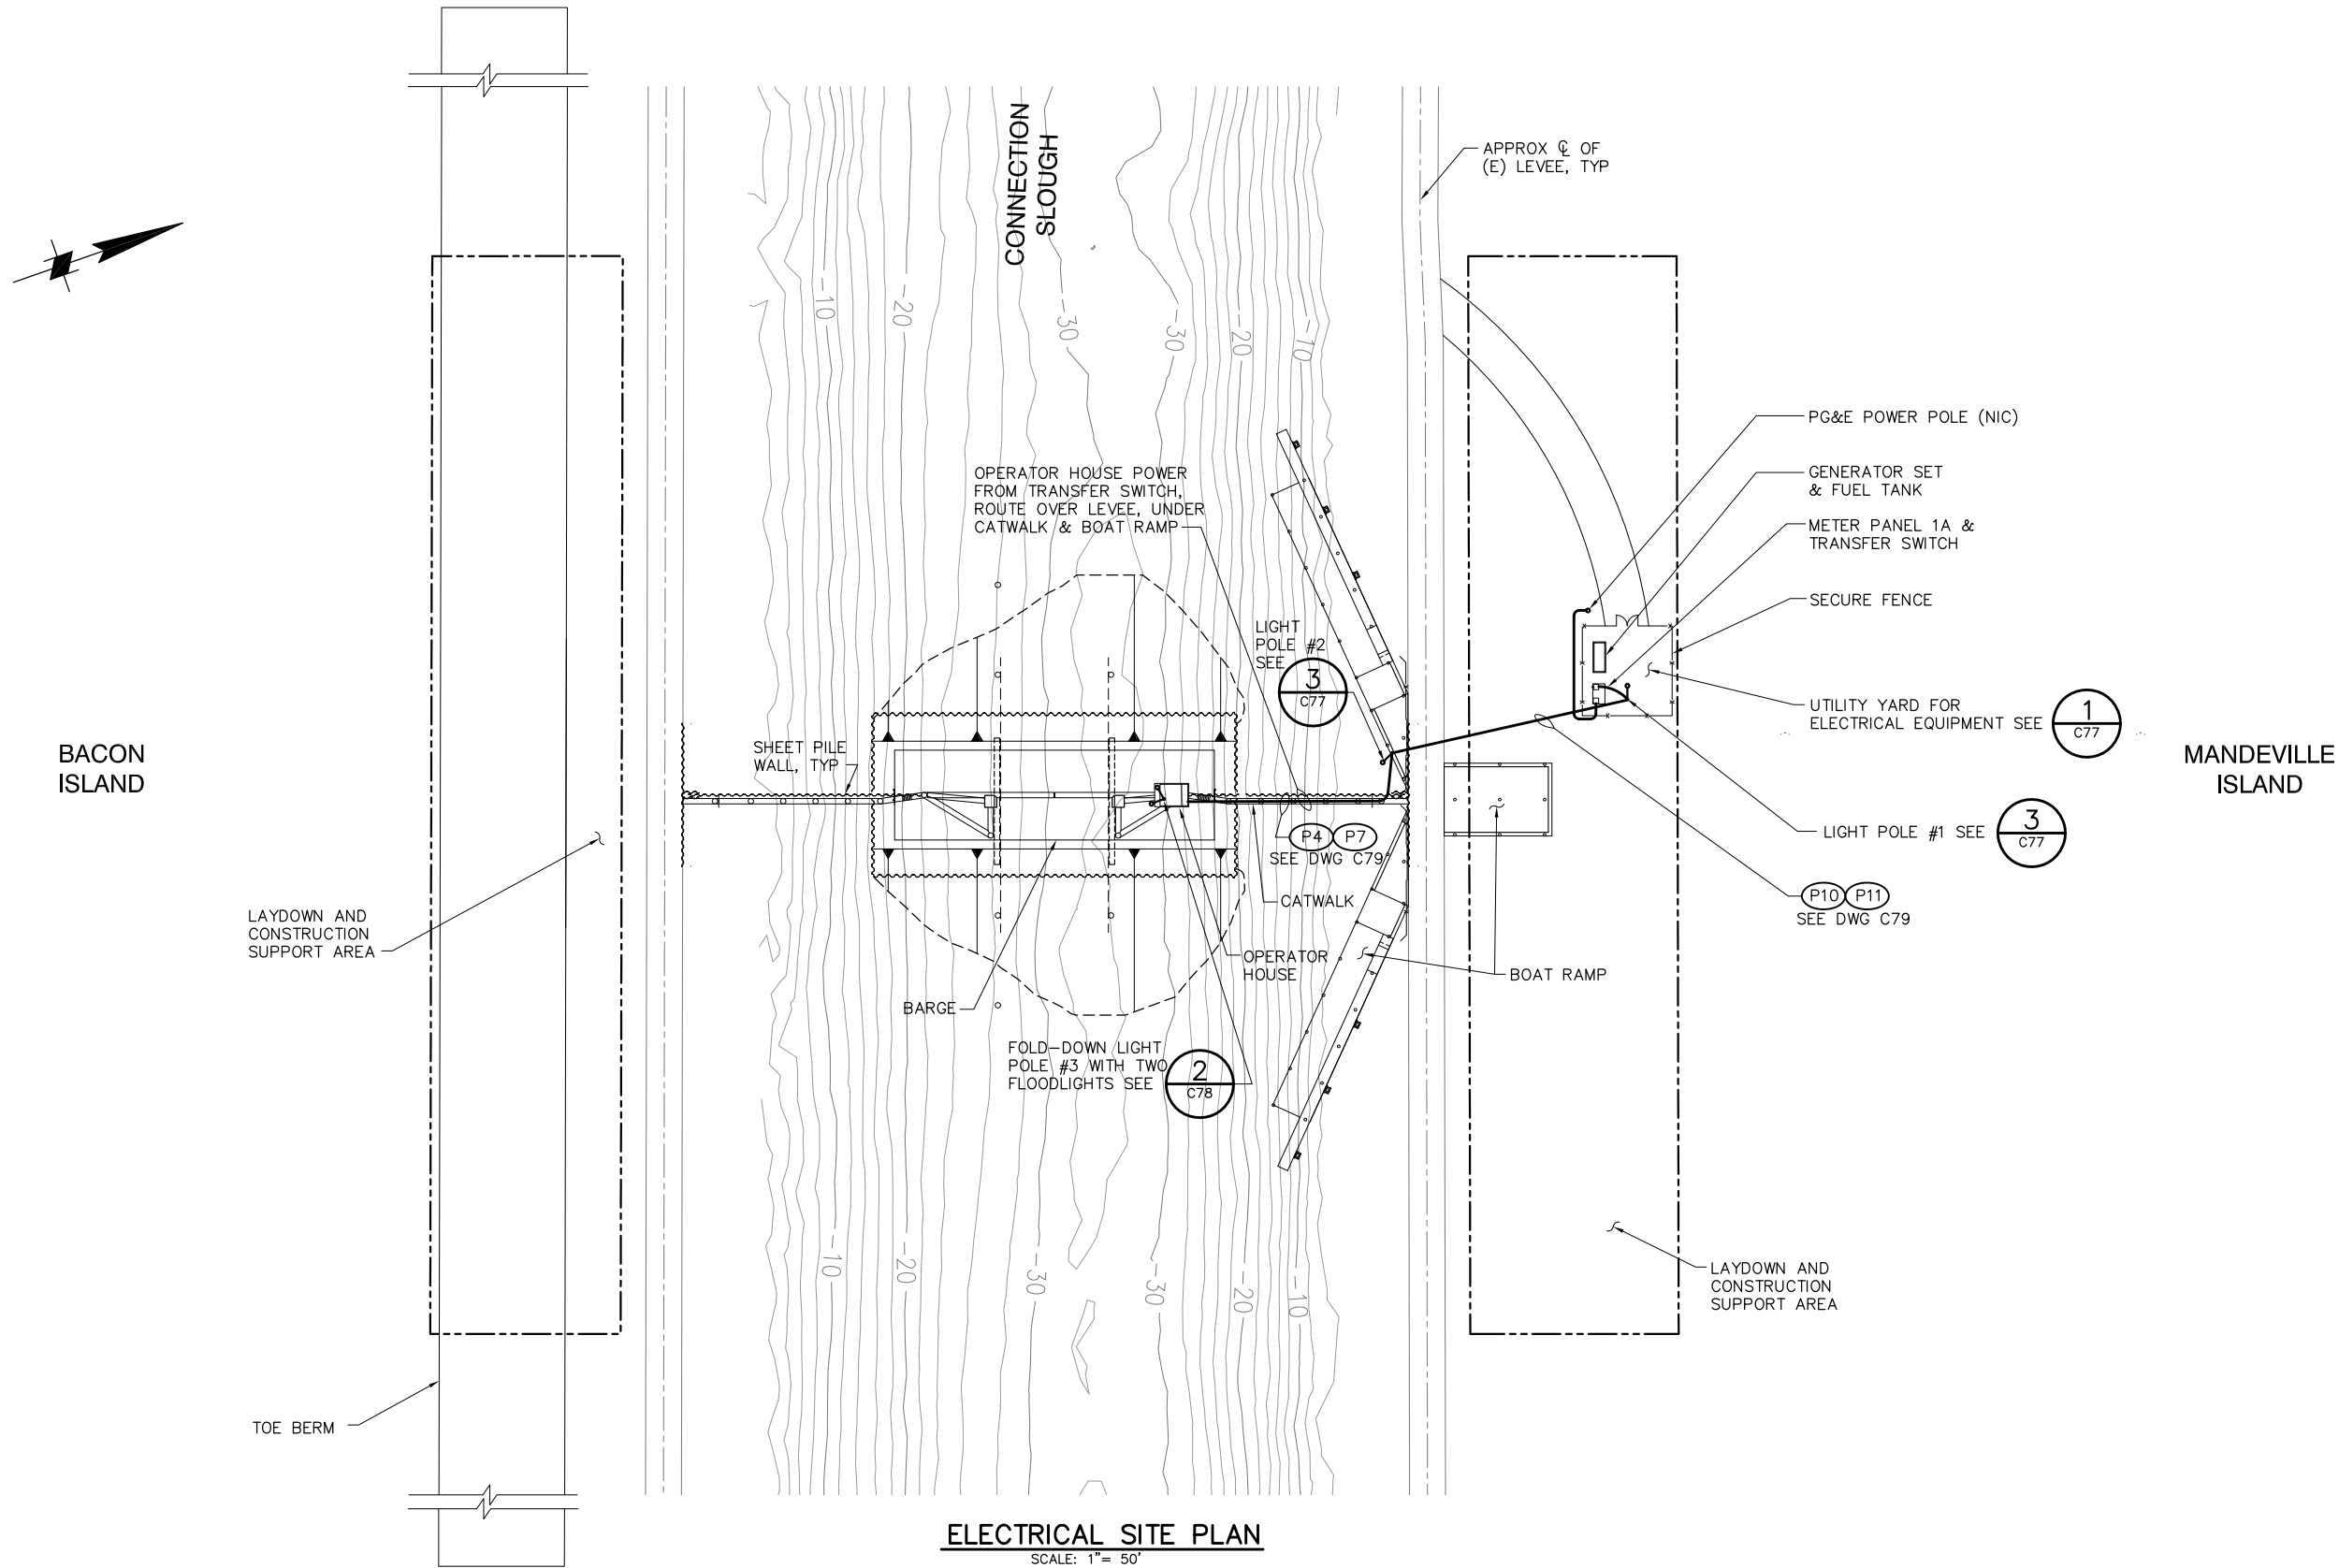

ELECTRICAL SITE PLAN
SCALE: 1"= 50'


 


**100% SUBMITTAL
REVISION 1**

IF SHEET IS LESS THAN 22" x 34"
IT IS A REDUCED PRINT -
SCALE REDUCED ACCORDINGLY.


REVISION	DESCRIPTION	BY	DATE

	San Luis & Delta-Mendota Water Authority 842 6th Street, Suite 7 PO Box 2157 Los Banos, California 93635	 Moffatt & Nichol	2001 N. Main Street, Suite 360 Walnut Creek, California 94596 (925) 944-5411		2-GATES FISH PROTECTION DEMONSTRATION PROJECT	DATE 10/02/09
						SHEET 45 OF 78
			DSGN DM DR AB CHK CBS JOB NO. 6097-03 SUBMITTED BY RMR			

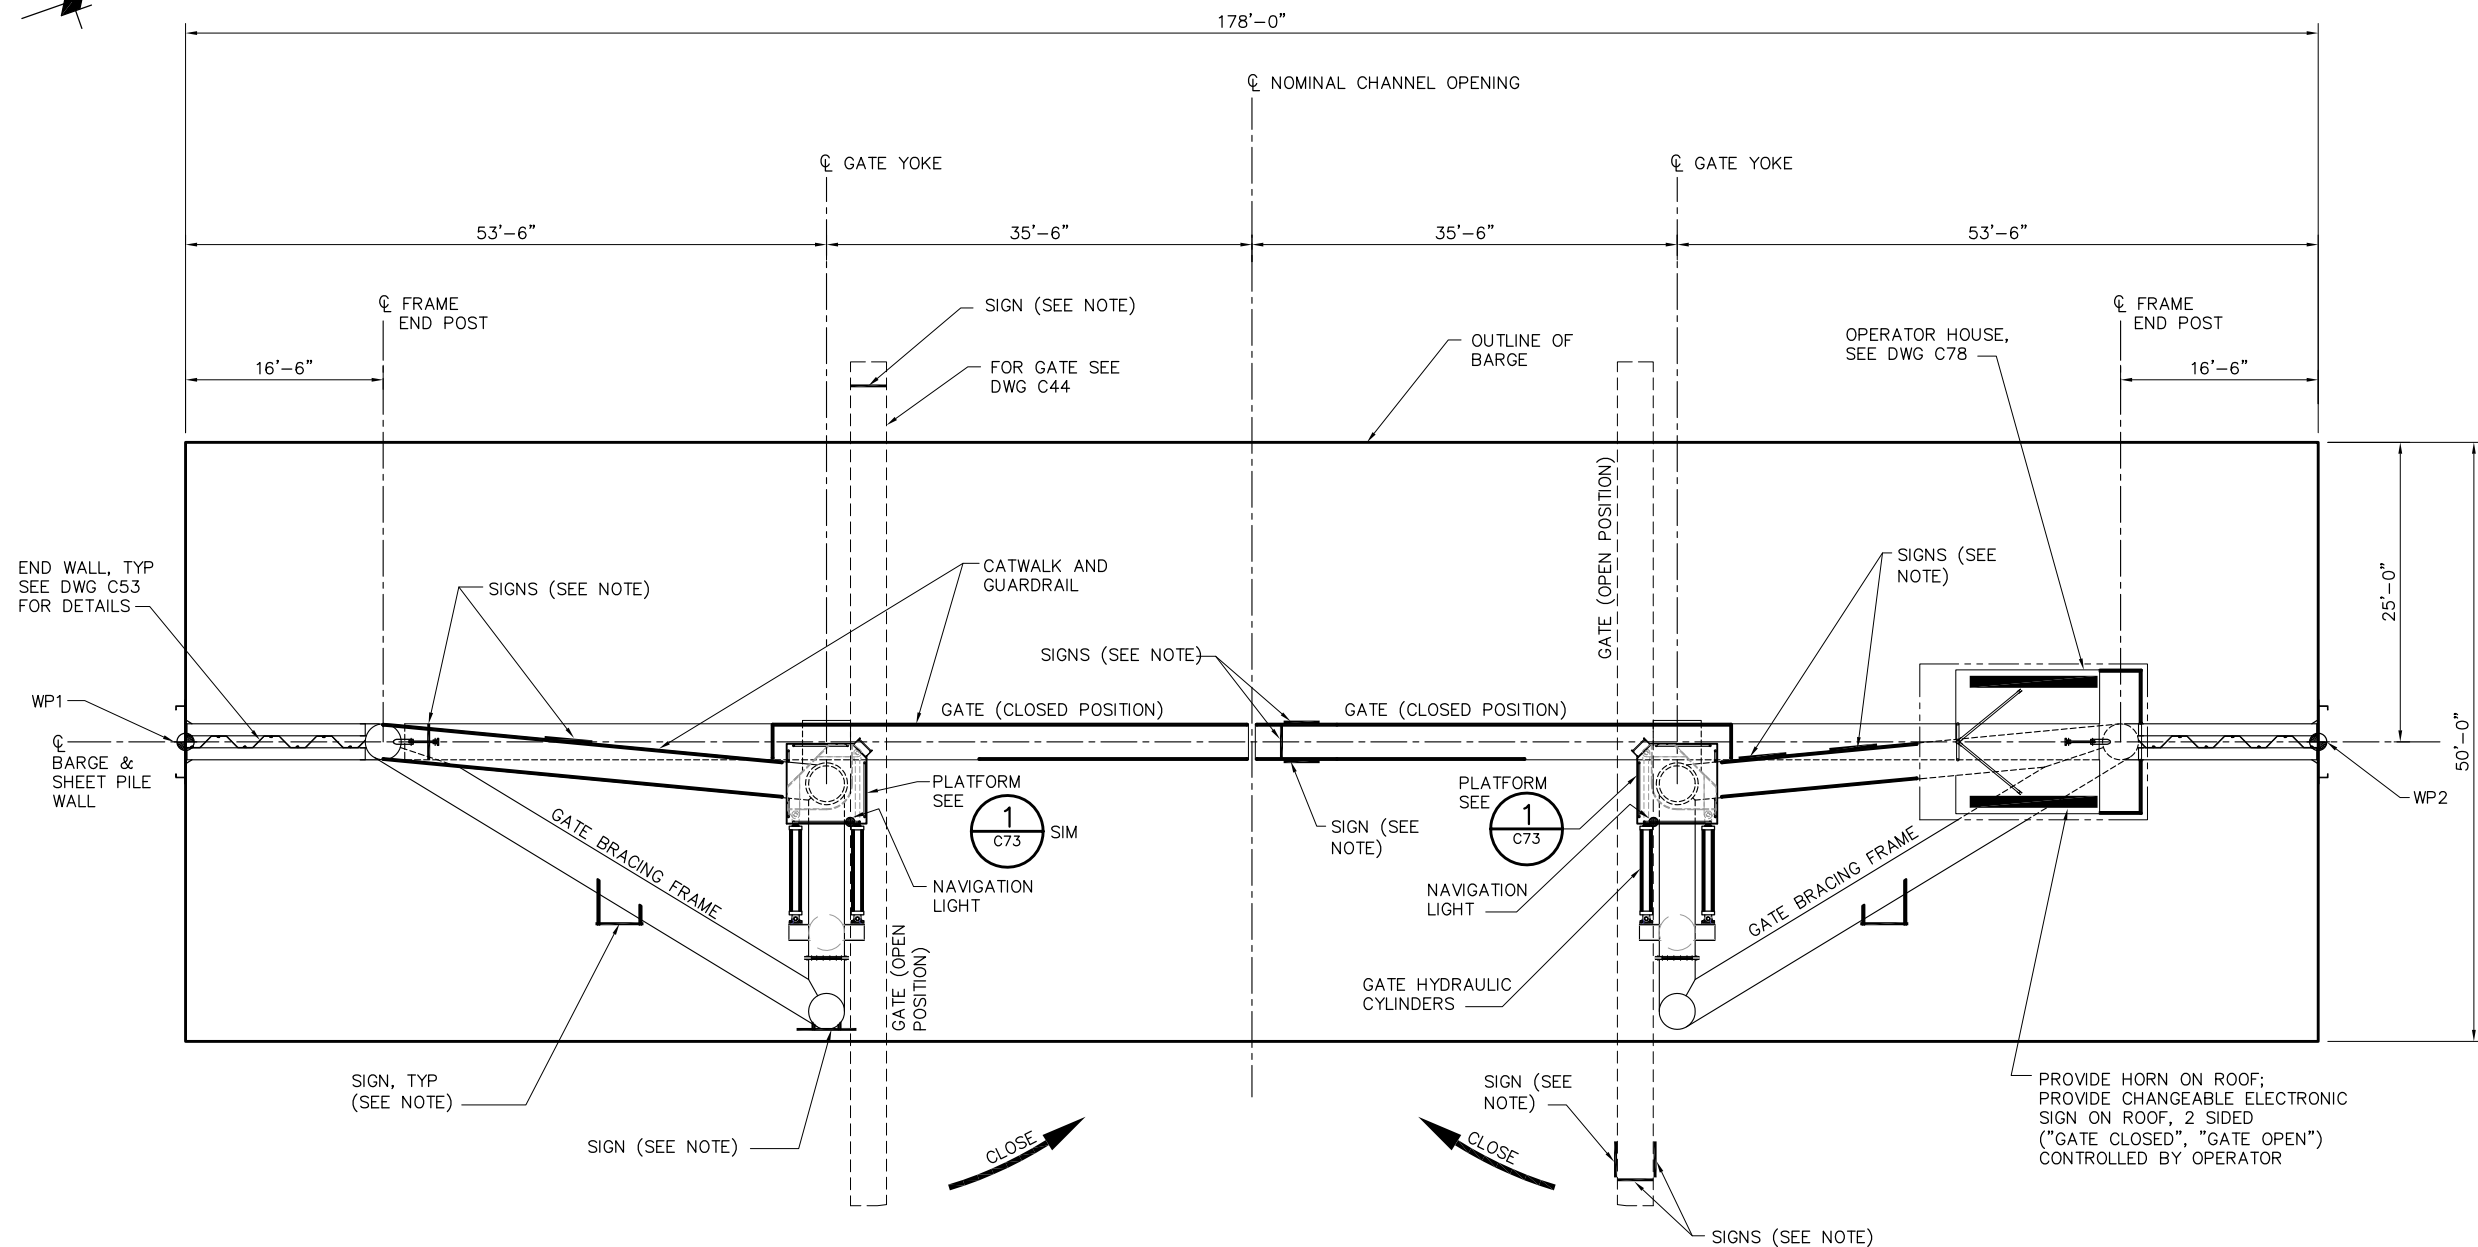 

BARGE PLAN
SCALE: 1/8"= 1'-0"

 NOTE:
FOR SIGNAGE, SEE DRAWING C54.



**100% SUBMITTAL
REVISION 1**

IF SHEET IS LESS THAN 22" x 34"
IT IS A REDUCED PRINT -
SCALE REDUCED ACCORDINGLY.

REVISION	DESCRIPTION	BY	DATE



San Luis & Delta-Mendota Water Authority
842 6th Street, Suite 7
PO Box 2157
Los Banos, California 93635




2001 N. Main Street, Suite 360
Walnut Creek, California 94596
(925) 944-5411

DSGN	CBS	DR	AB/EP	CHK	TDB
JOB NO.	6097-03	SUBMITTED BY	RMR		


2-GATES FISH PROTECTION DEMONSTRATION PROJECT	DATE 10/02/09
	SHEET 46 OF 78
CONNECTION SLOUGH BARGE GENERAL ARRANGEMENT PLAN	C42

P:\6097-03 SWC GATE DESIGN\CADD\DWG\609703-C43.DWG 9/29/2009 12:07 PM

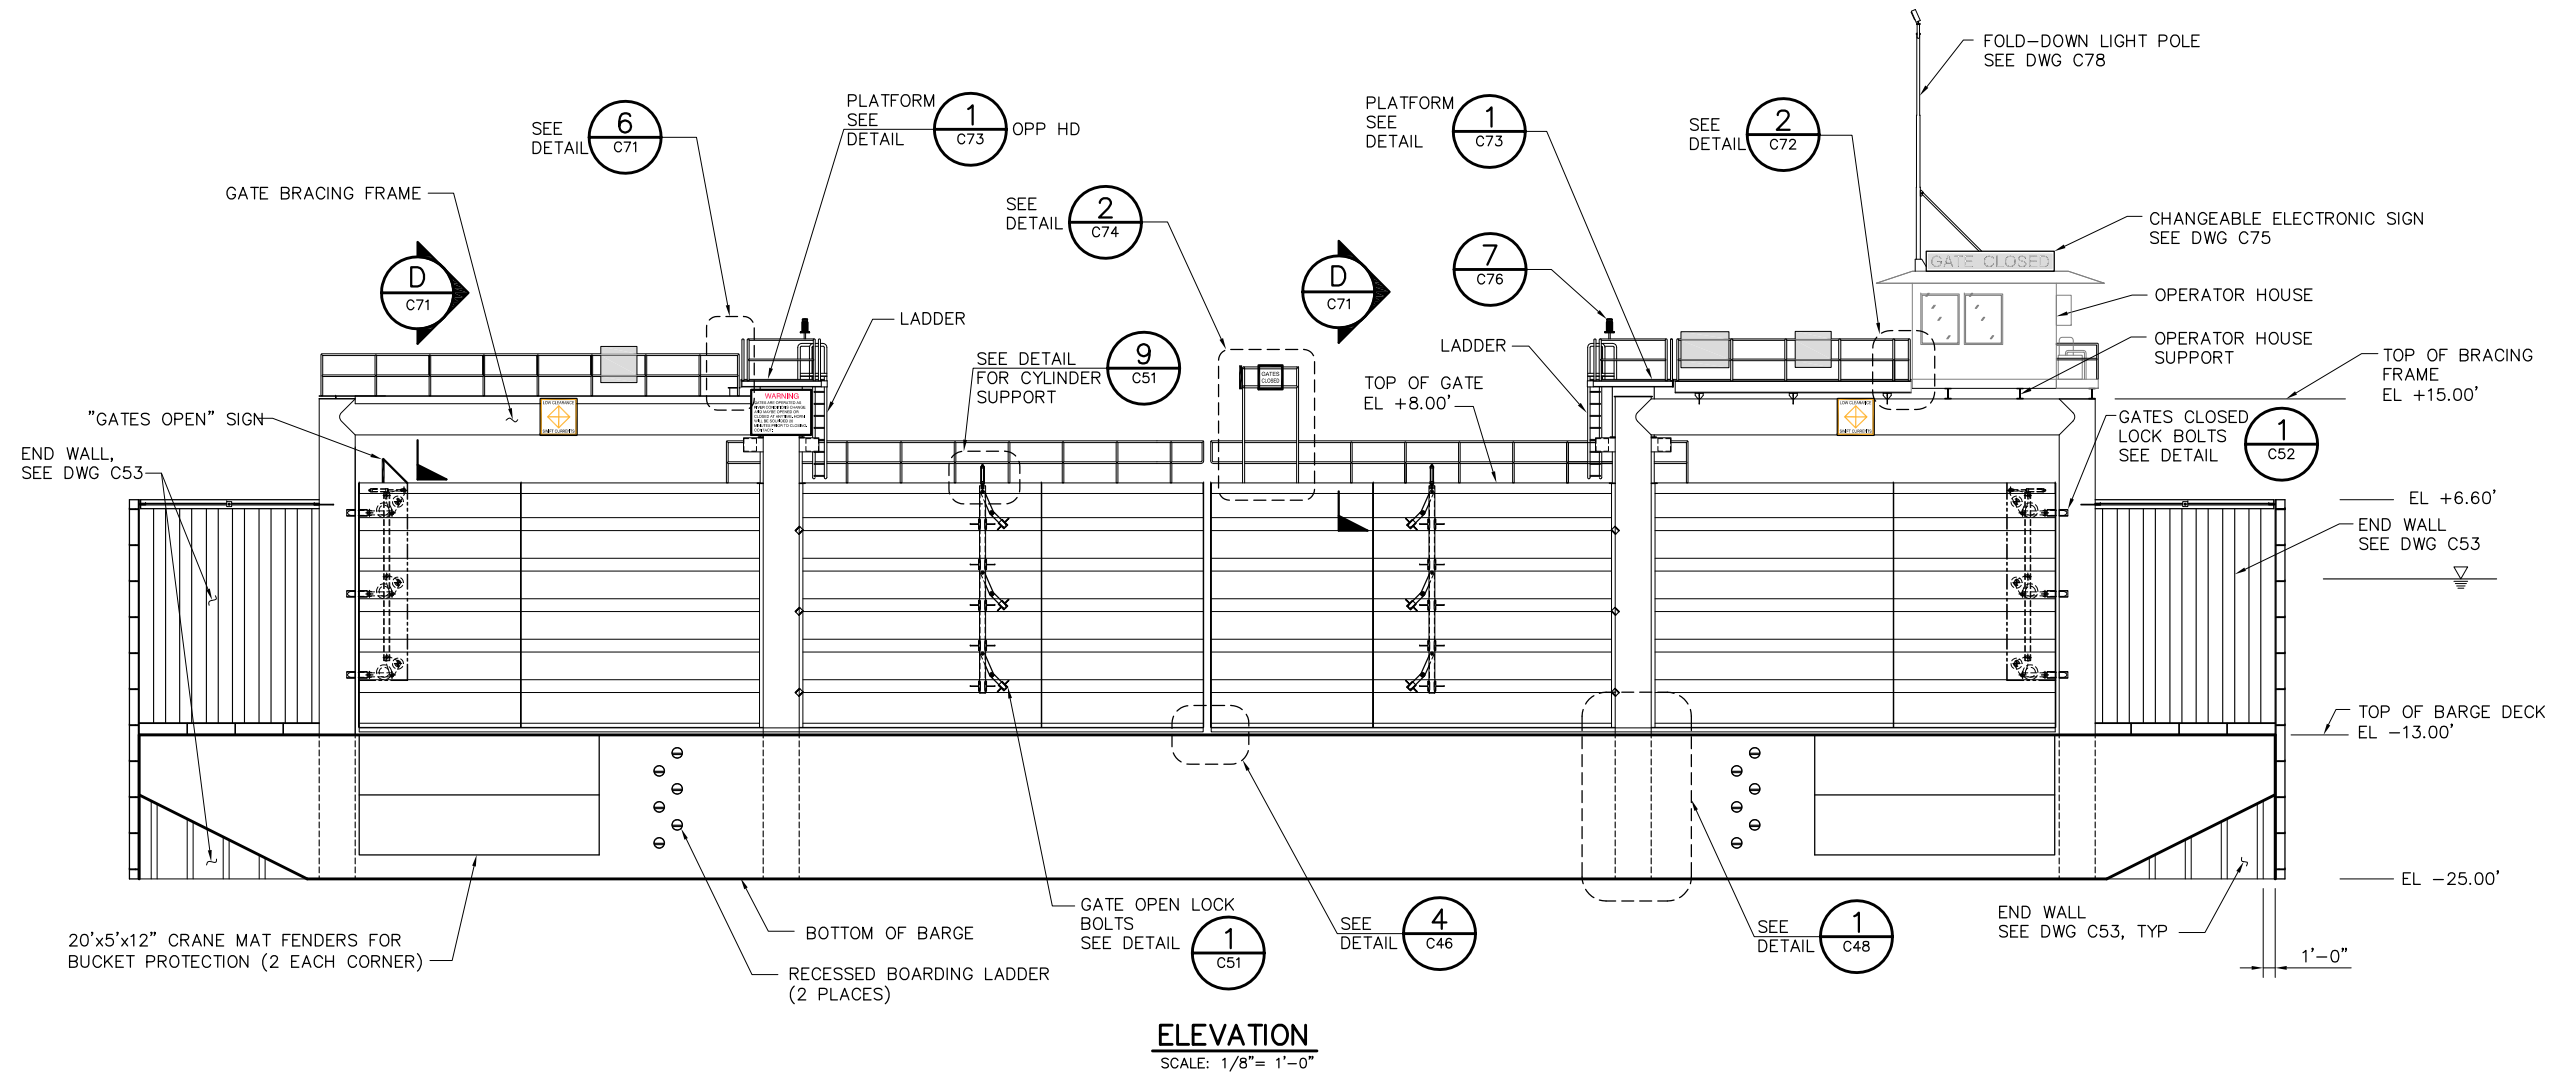

NOTES:

 1. FOR SIGNAGE SEE DRAWING C54.
2. FOR CATWALK STAIRWAY SEE DRAWING C40.



**100% SUBMITTAL
REVISION 1**

IF SHEET IS LESS THAN 22" x 34"
IT IS A REDUCED PRINT -
SCALE REDUCED ACCORDINGLY.

REVISION	DESCRIPTION	BY	DATE



San Luis & Delta-Mendota Water Authority
842 6th Street, Suite 7
PO Box 2157
Los Banos, California 93635



2001 N. Main Street, Suite 360
Walnut Creek, California 94596
(925) 944-5411

DSGN	JMB	DR	AB/EP	CHK	TDB
JOB NO.	6097-03	SUBMITTED BY	RMR		



2-GATES FISH PROTECTION
DEMONSTRATION PROJECT

CONNECTION SLOUGH
BARGE GENERAL ARRANGEMENT
ELEVATION

DATE 10/02/09

SHEET 47 OF 78

C43

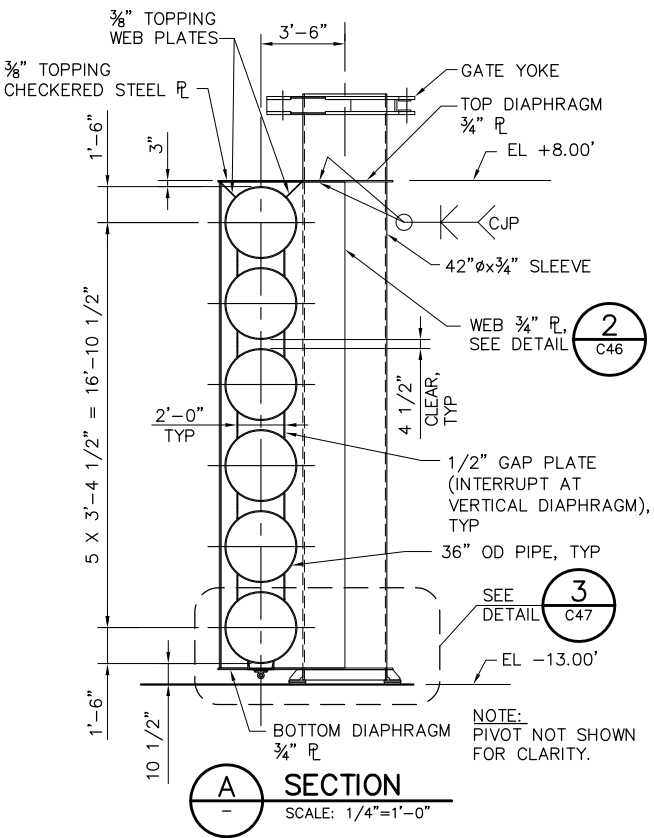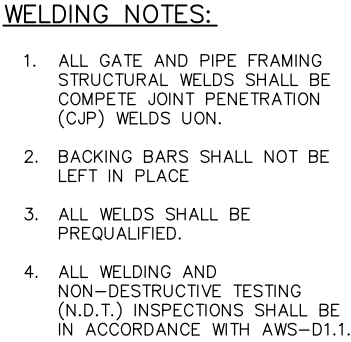

REVISION	DESCRIPTION	BY	DATE



San Luis & Delta-Mendota Water Authority
842 6th Street, Suite 7
PO Box 2157
Los Banos, California 93635



2001 N. Main Street, Suite 360
Walnut Creek, California 94596
(925) 944-5411

DSGN	JMB	DR	AB/EP	CHK	CBS
JOB NO.	6097-03	SUBMITTED BY RMR			

100% SUBMITTAL
REVISION 1

IF SHEET IS LESS THAN 22" x 34'
IT IS A REDUCED PRINT -
SCALE REDUCED ACCORDINGLY.



2-GATES FISH PROTECTION DEMONSTRATION PROJECT

DATE 10/02/09

SHEET 48 OF 78

CONNECTION SLOUGH GATE SCANTLINGS

C44

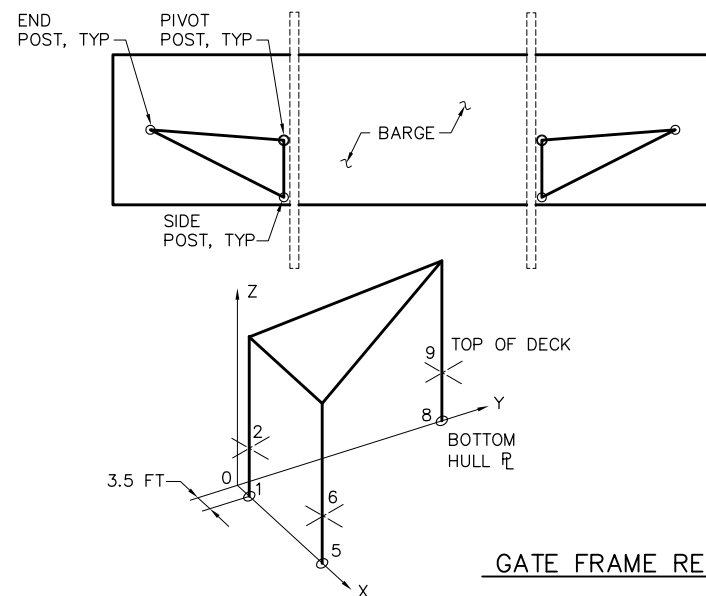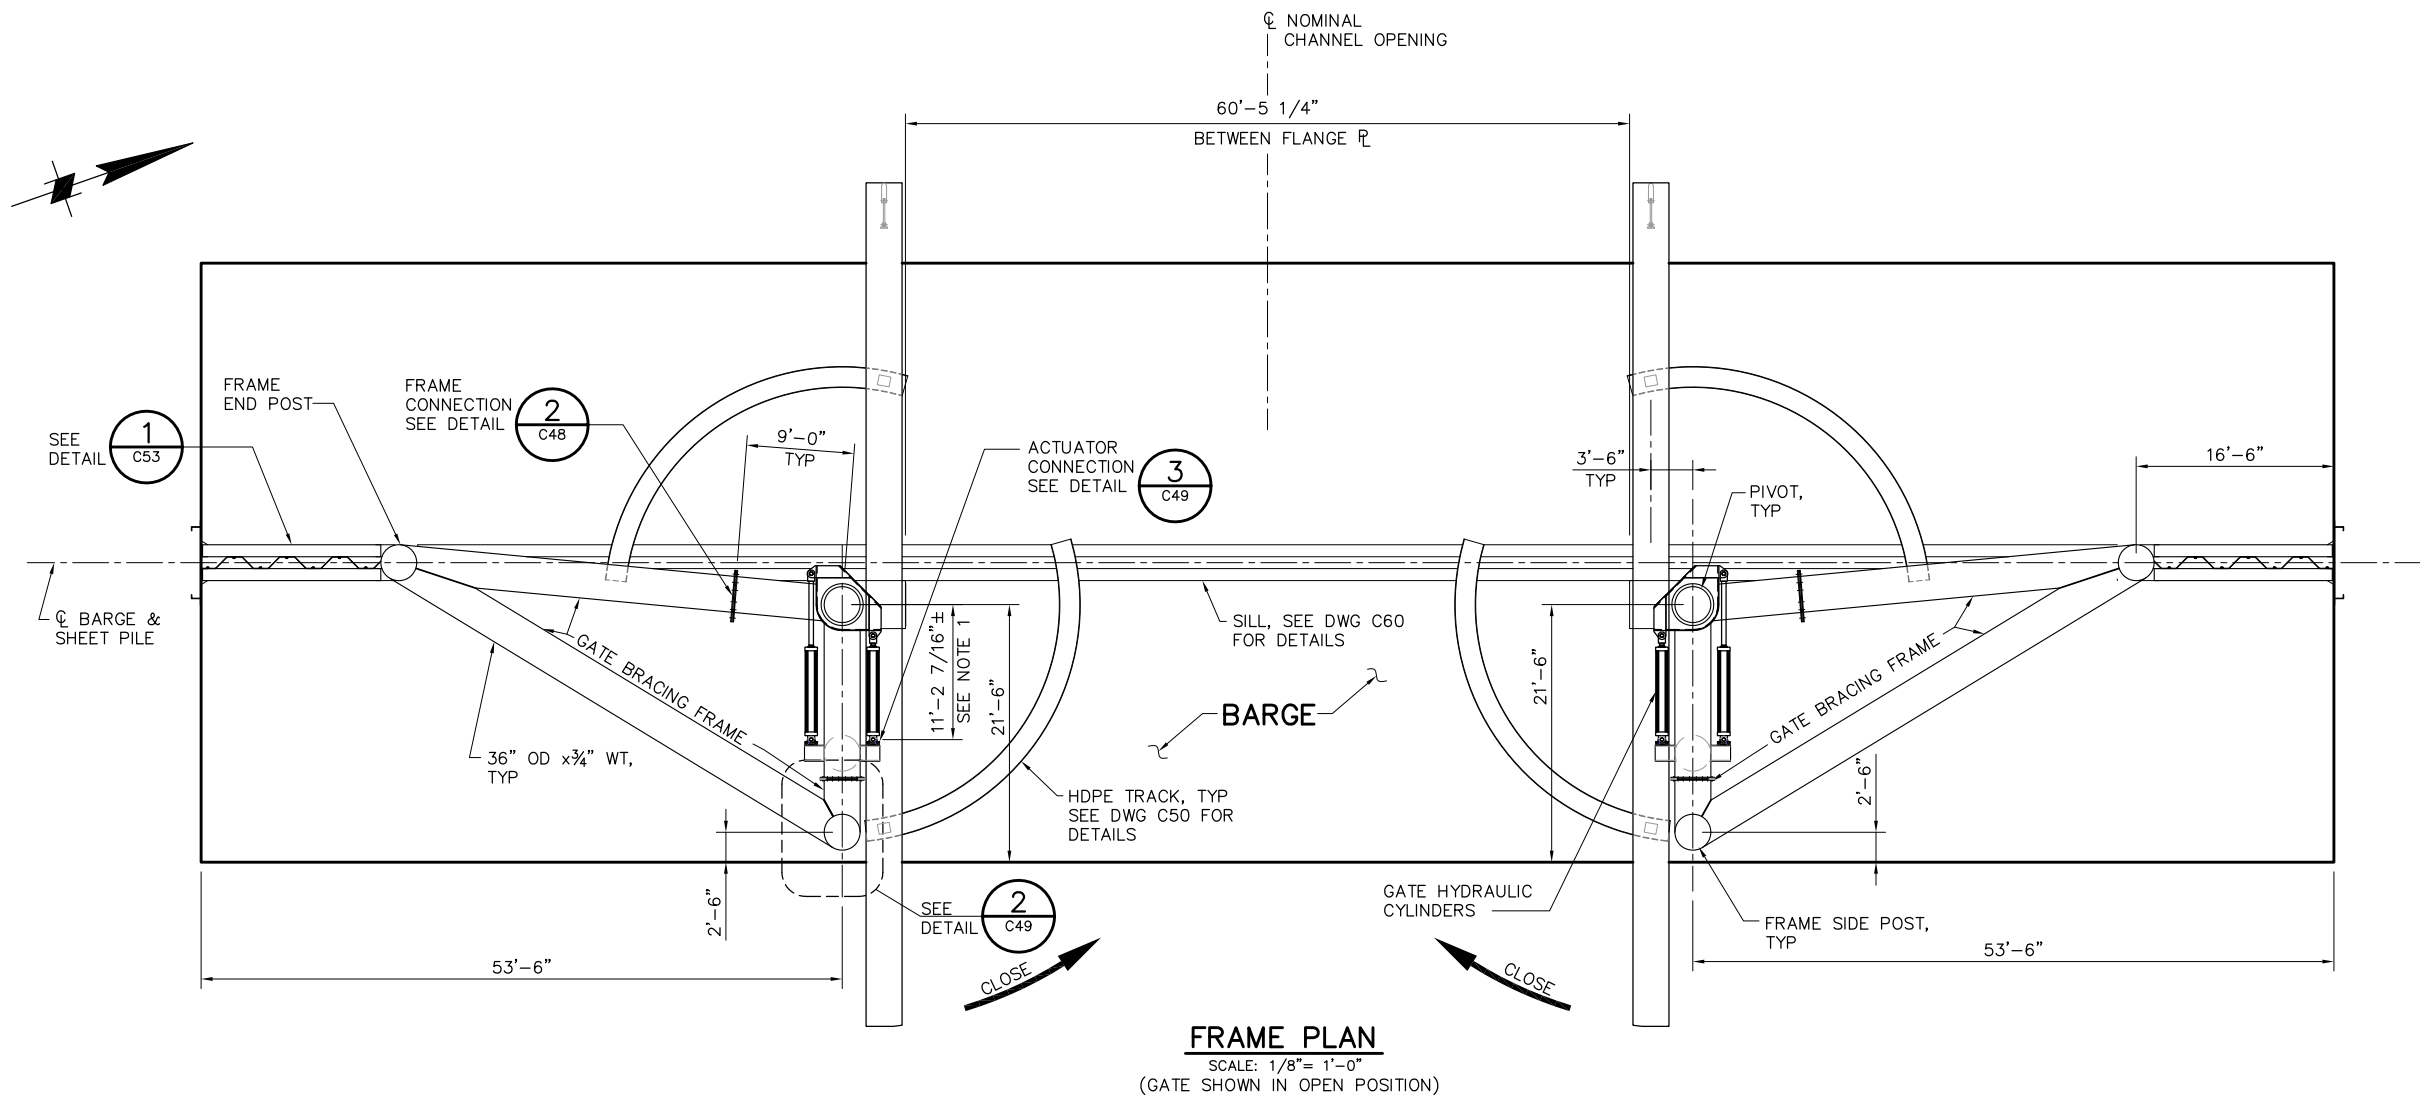

SERVICE LOAD REACTIONS (INCLUDES A 1.2 FACTOR)
(FOR LRFD USE A 1.6 FACTOR WITH THESE REACTIONS)

LOCATION ON BARGE	NODE	R _X (KIP)	R _Y (KIP)	R _Z (KIP)	DESCRIPTION
BOTTOM HULL CL	1	+140 -140	+30 -30	+200 -50	PIVOT
	5	+140 -140	-40 +40	-60 +170	SIDE POST
	8	+50 -50	+30 -30	+100	END POST
TOP OF DECK	2	+500 -500	-50 +50	0	PIVOT
	6	+260 -260	-60 +60	0	SIDE POST
	9	+100 -100	-50 +50	0	END POST

NOTE: CONTRACTOR SHALL PROVIDE A BARGE ADEQUATE TO SUPPORT THESE LOADS.

NOTES:


1. DIMENSION MAY VARY DEPENDING ON ACTUATOR VENDER.

8'-0" 0'-0" 8'-0" 16'-0"
SCALE: 1/8"=1'-0"

**100% SUBMITTAL
REVISION 1**

IF SHEET IS LESS THAN 22" x 34"
IT IS A REDUCED PRINT -
SCALE REDUCED ACCORDINGLY.

REVISION	DESCRIPTION	BY	DATE

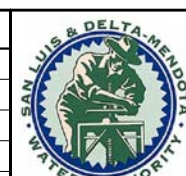

San Luis & Delta-Mendota Water Authority
842 6th Street, Suite 7
PO Box 2157
Los Banos, California 93635



2001 N. Main Street, Suite 360
Walnut Creek, California 94596
(925) 944-5411

DSGN	CBS	DR	AB	CHK	TDB
JOB NO.	6097-03	SUBMITTED BY RMR			

2-GATES FISH PROTECTION
DEMONSTRATION PROJECT





DATE 10/02/09

SHEET 49 OF 78


**CONNECTION SLOUGH
GATE FRAMING LAYOUT**

C45

P:\6097-03 SWC GATE DESIGN\CADD\DWG\609703-C46.DWG 9/29/2009 2:12 PM

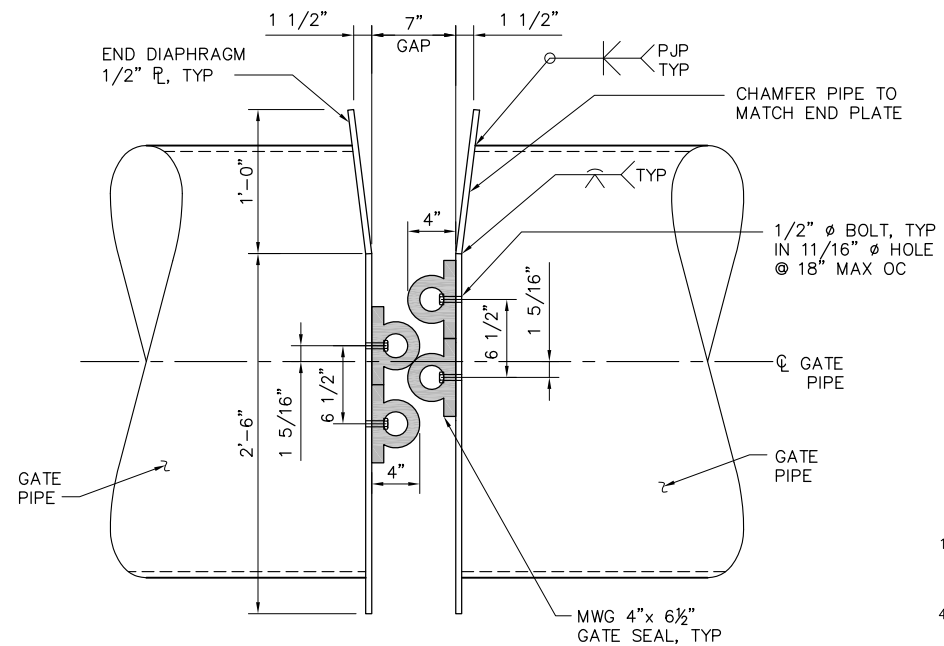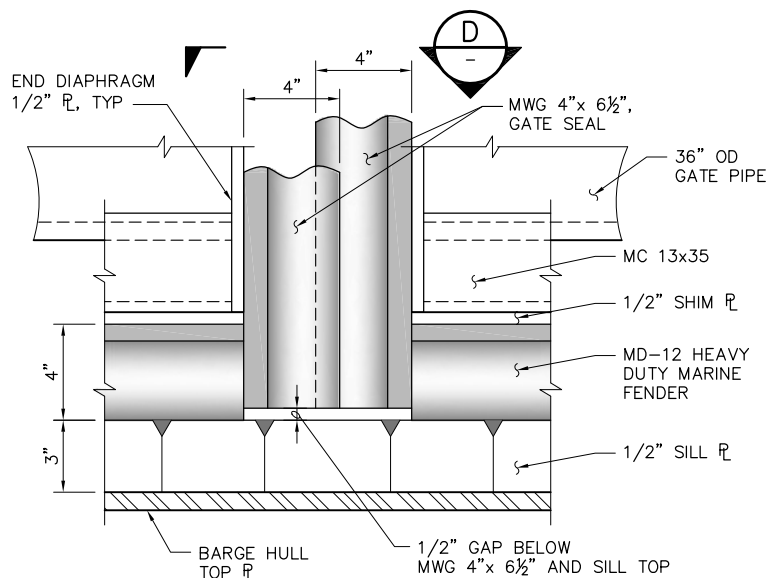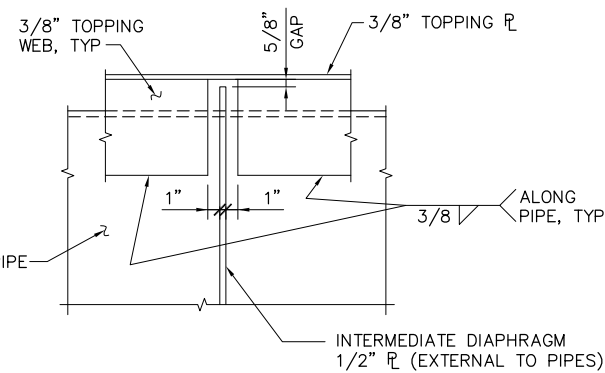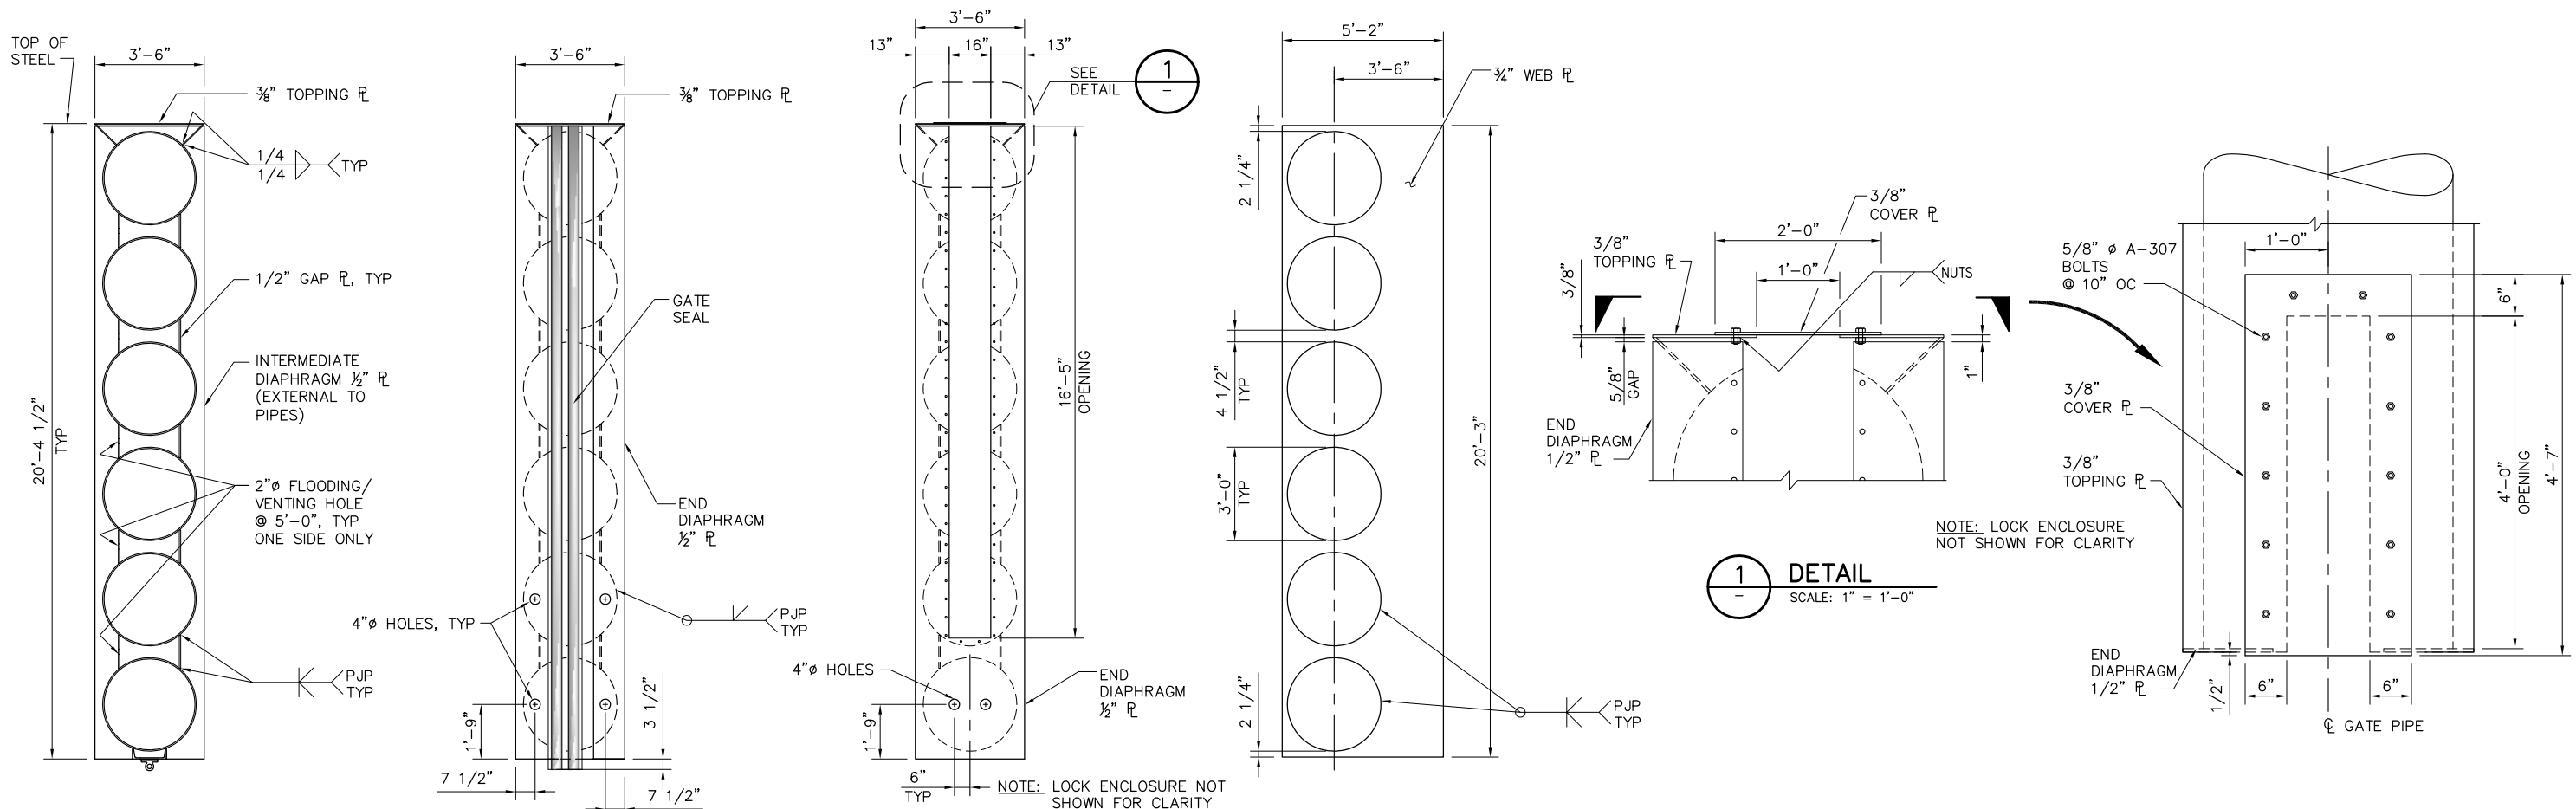


NOTE:
CHAMFER CATWALK TOPPING CHECKER PLATE ABOVE GATE MATING ENDS, TO PERMIT RELATIVE OPENING MOVEMENTS.

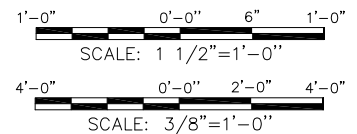

**100% SUBMITTAL
REVISION 1**

IF SHEET IS LESS THAN 22" x 34"
IT IS A REDUCED PRINT -
SCALE REDUCED ACCORDINGLY.

REVISION	DESCRIPTION	BY	DATE

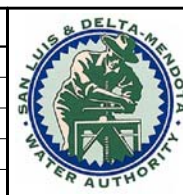

San Luis & Delta-Mendota Water Authority
842 6th Street, Suite 7
PO Box 2157
Los Banos, California 93635



2001 N. Main Street, Suite 360
Walnut Creek, California 94596
(925) 944-5411

DSGN	JMB	DR	AB/EP	CHK	TDB
JOB NO.	6097-03	SUBMITTED BY	RMR		

2-GATES FISH PROTECTION
DEMONSTRATION PROJECT


DATE 10/02/09

SHEET 50 OF 78


CONNECTION SLOUGH
GATE STRUCTURAL DETAILS,
SHEET 1

C46


P:\6097-03 SWC GATE DESIGN\CADD\DWG\609703-C47.DWG 9/29/2009 2:25 PM

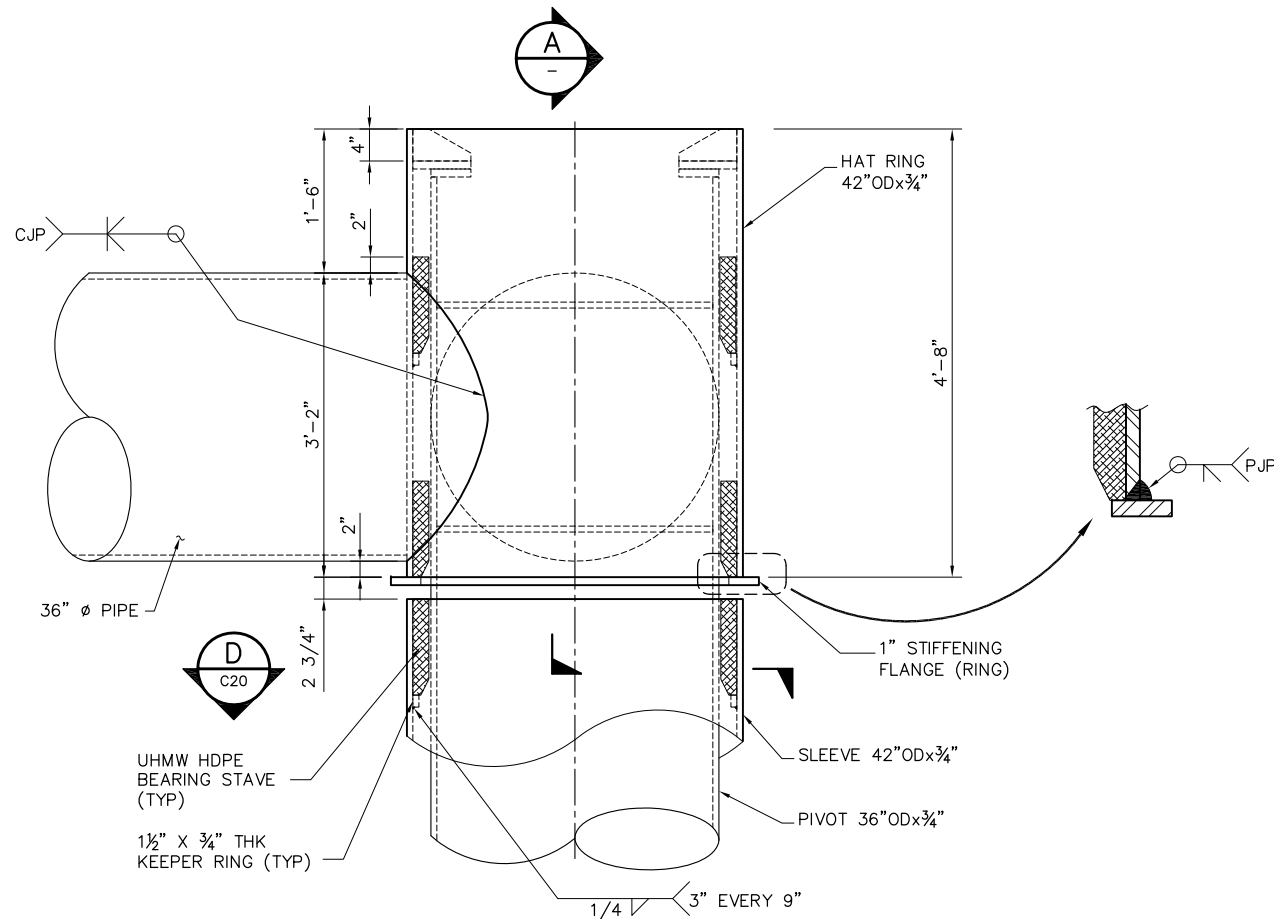


1 TOP PIVOT - FRAME CONNECTION
C44 SCALE: 1" = 1'-0"

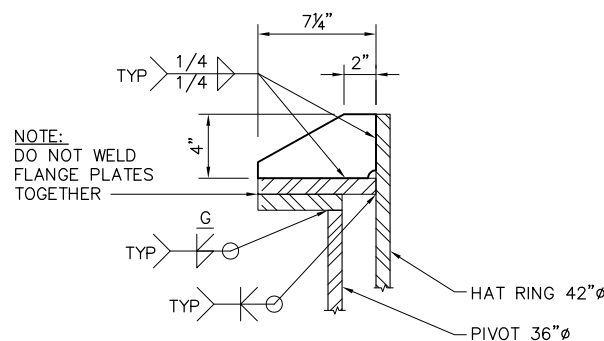

2 DETAIL
NTS

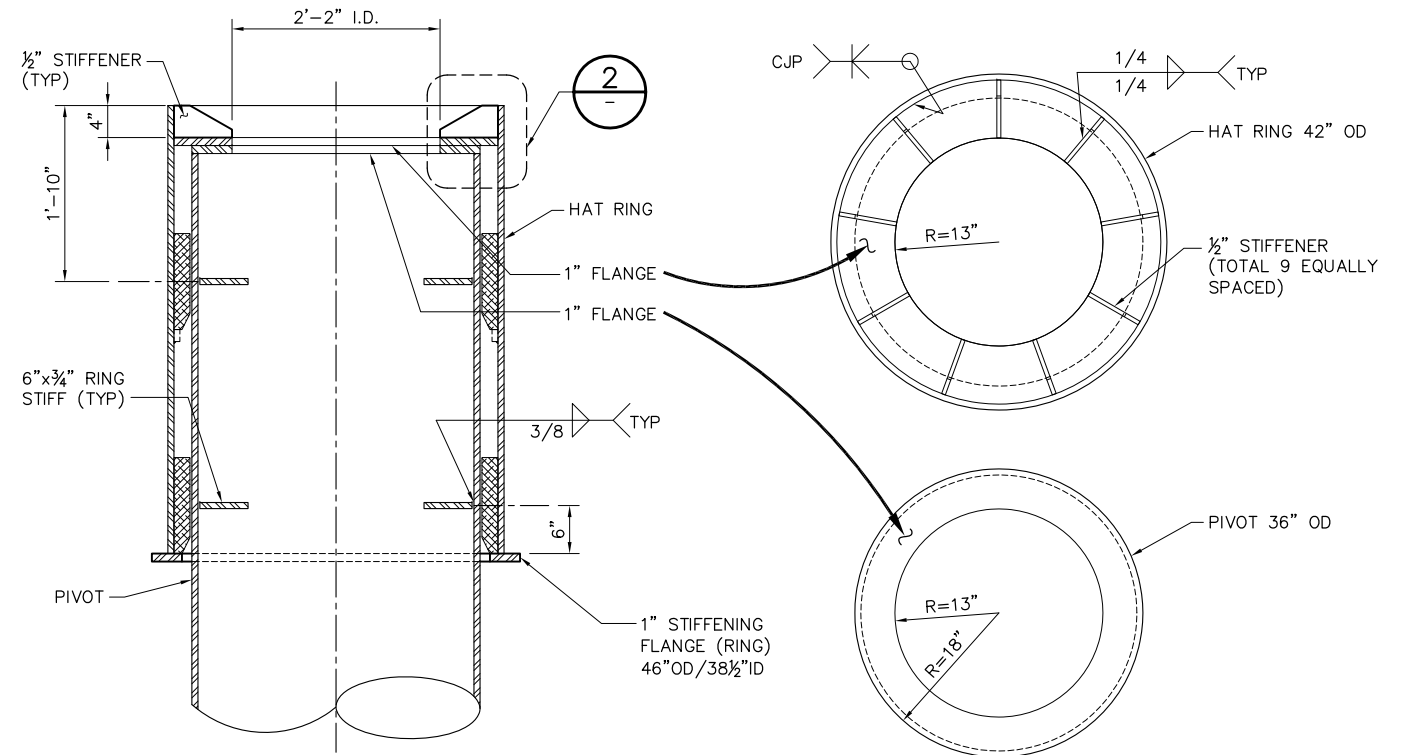

A SECTION
SCALE: 1" = 1'-0"

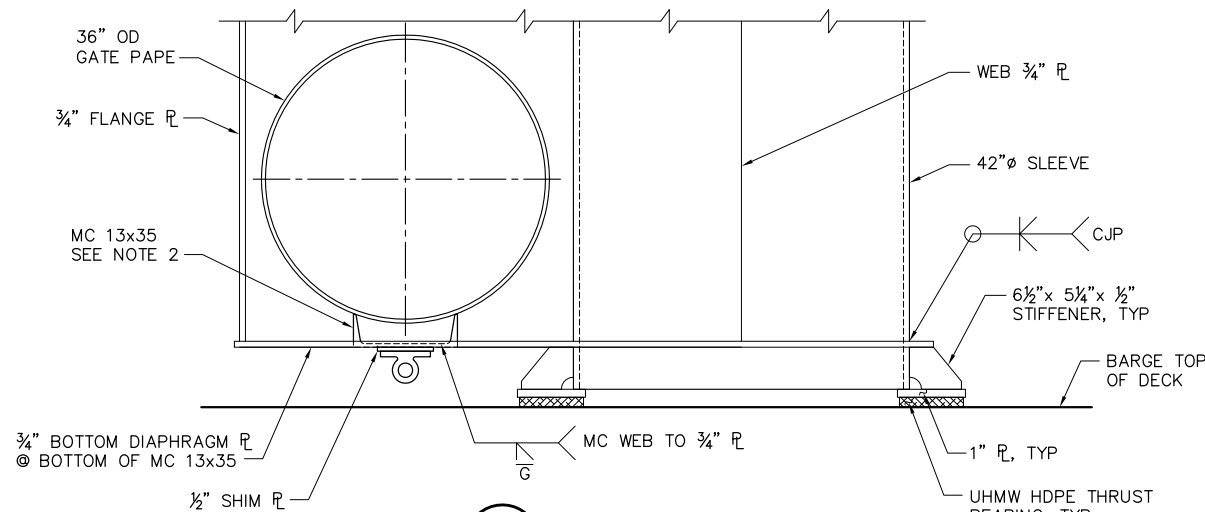

3 DETAIL
C44 SCALE: 1" = 1'-0"

NOTES:

1. ALL STIFFENER WELDS SHALL BE SYMMETRICAL 1/4" MIN. FILLET WELDS U.N.O.
2. NOTCH MC 13x35 WEB AROUND BOTTOM DIAPHRAGM PLATE AND WELD AS SHOWN.

1'-0" 0'-0" 1'-0" 2'-0"
SCALE: 1" = 1'-0"

**100% SUBMITTAL
REVISION 1**

IF SHEET IS LESS THAN 22" x 34"
IT IS A REDUCED PRINT -
SCALE REDUCED ACCORDINGLY.

REVISION	DESCRIPTION	BY	DATE



San Luis & Delta-Mendota Water Authority
842 6th Street, Suite 7
PO Box 2157
Los Banos, California 93635



2001 N. Main Street, Suite 360
Walnut Creek, California 94596
(925) 944-5411

DSGN	JMB/CBS	DR	AB/TAE/EP	CHK	TDB
JOB NO.	6097-03	SUBMITTED BY	RMR		

2-GATES FISH PROTECTION
DEMONSTRATION PROJECT







DATE 10/02/09

SHEET 51 OF 78

CONNECTION SLOUGH
GATE STRUCTURAL DETAILS
SHEET 2


C47

P:\6097-03 SWC GATE DESIGN\CADD\DWG\609703-C48.DWG 9/29/2009 2:48 PM

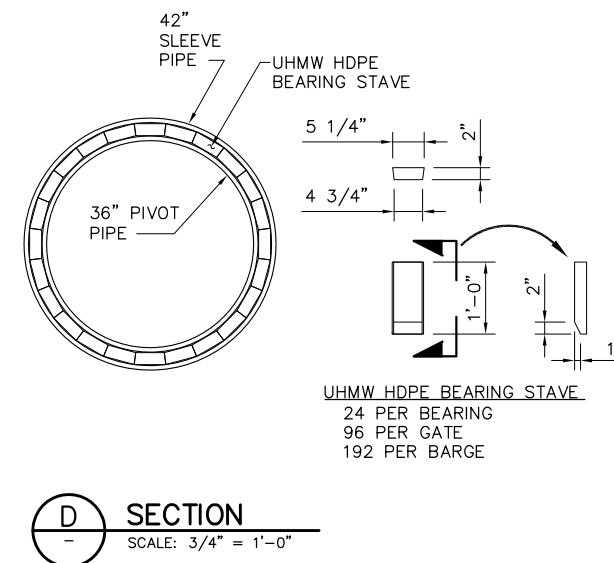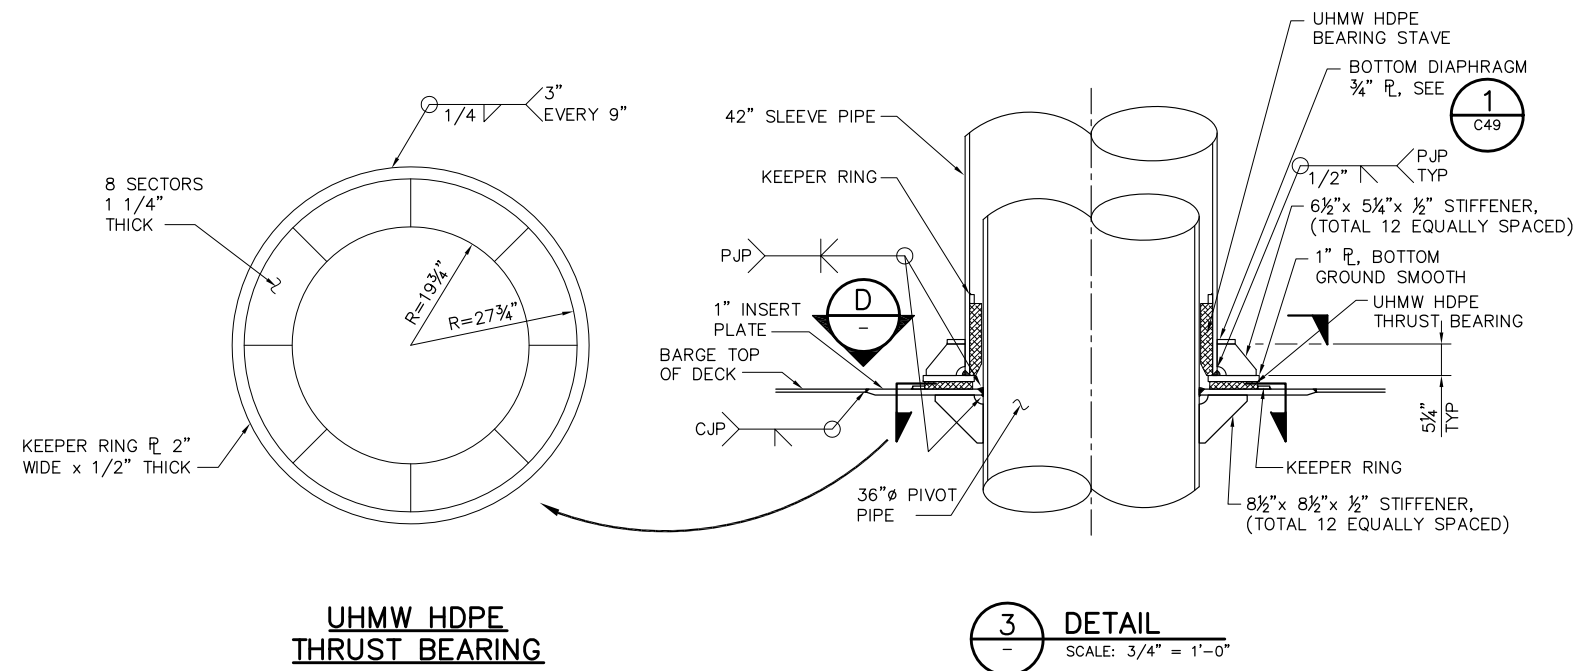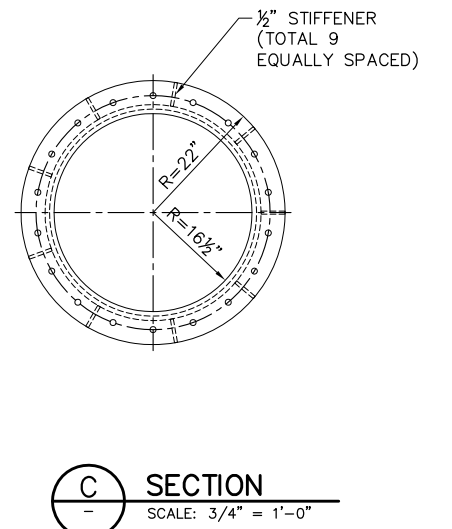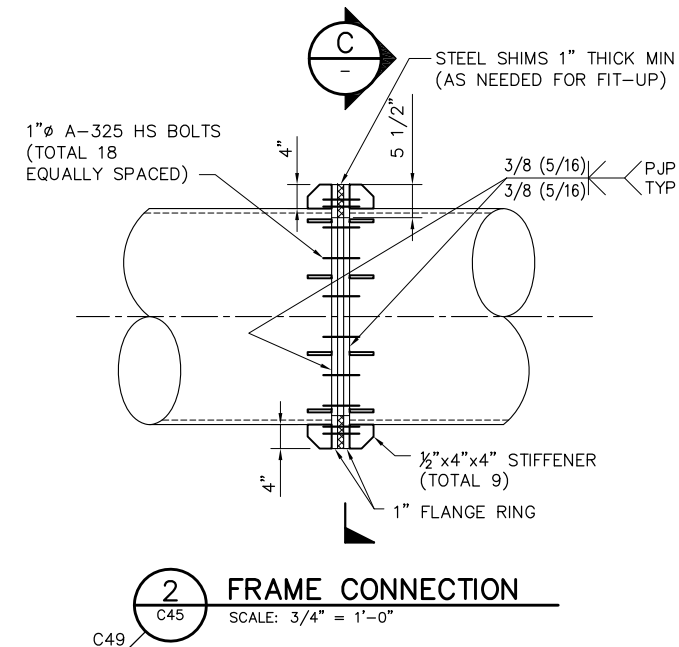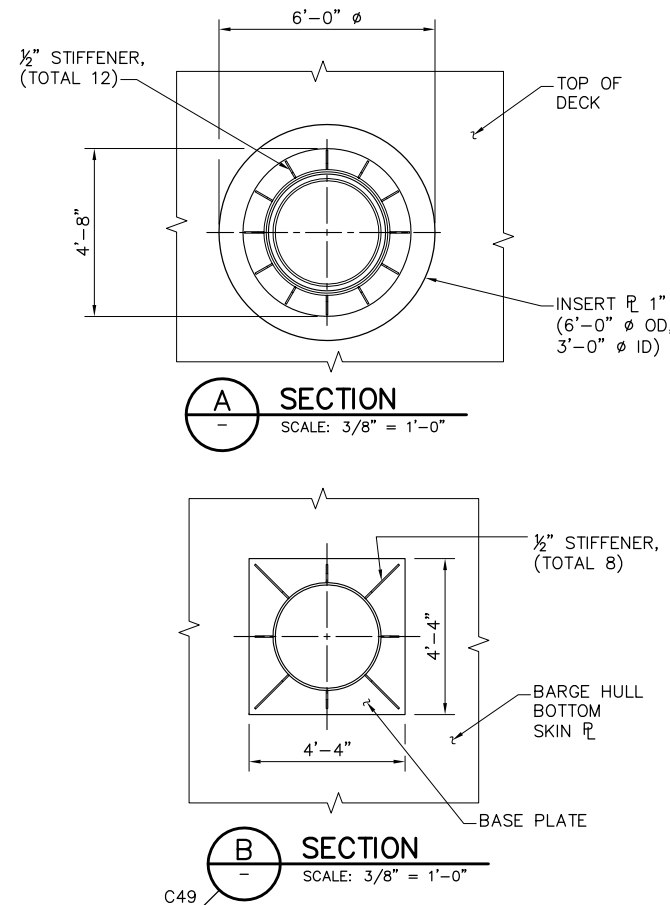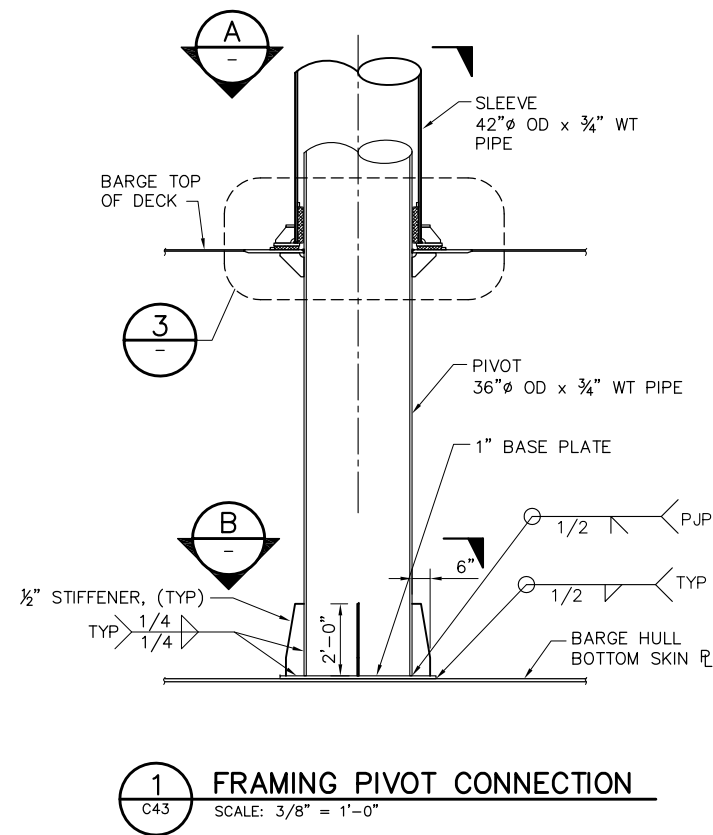

NOTES:

1. ALL STIFFENER WELDS SHALL BE SYMMETRICAL 1/4" MIN. FILLET WELDS U.N.O.

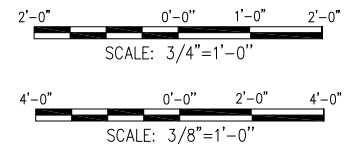

**100% SUBMITTAL
REVISION 1**

IF SHEET IS LESS THAN 22" x 34"
IT IS A REDUCED PRINT -
SCALE REDUCED ACCORDINGLY.

REVISION	DESCRIPTION	BY	DATE



San Luis & Delta-Mendota Water Authority
842 6th Street, Suite 7
PO Box 2157
Los Banos, California 93635



2001 N. Main Street, Suite 360
Walnut Creek, California 94596
(925) 944-5411

DSGN	JMB/CBS	DR	AB/EP	CHK	TDB
JOB NO.	6097-03	SUBMITTED BY	RMR		

2-GATES FISH PROTECTION
DEMONSTRATION PROJECT





DATE 10/02/09

SHEET 52 OF 78

CONNECTION SLOUGH
GATE STRUCTURAL DETAILS
SHEET 3

C48

P:\6097-03 SWC GATE DESIGN\CADD\DWG\609703-C49.DWG 9/29/2009 3:05 PM

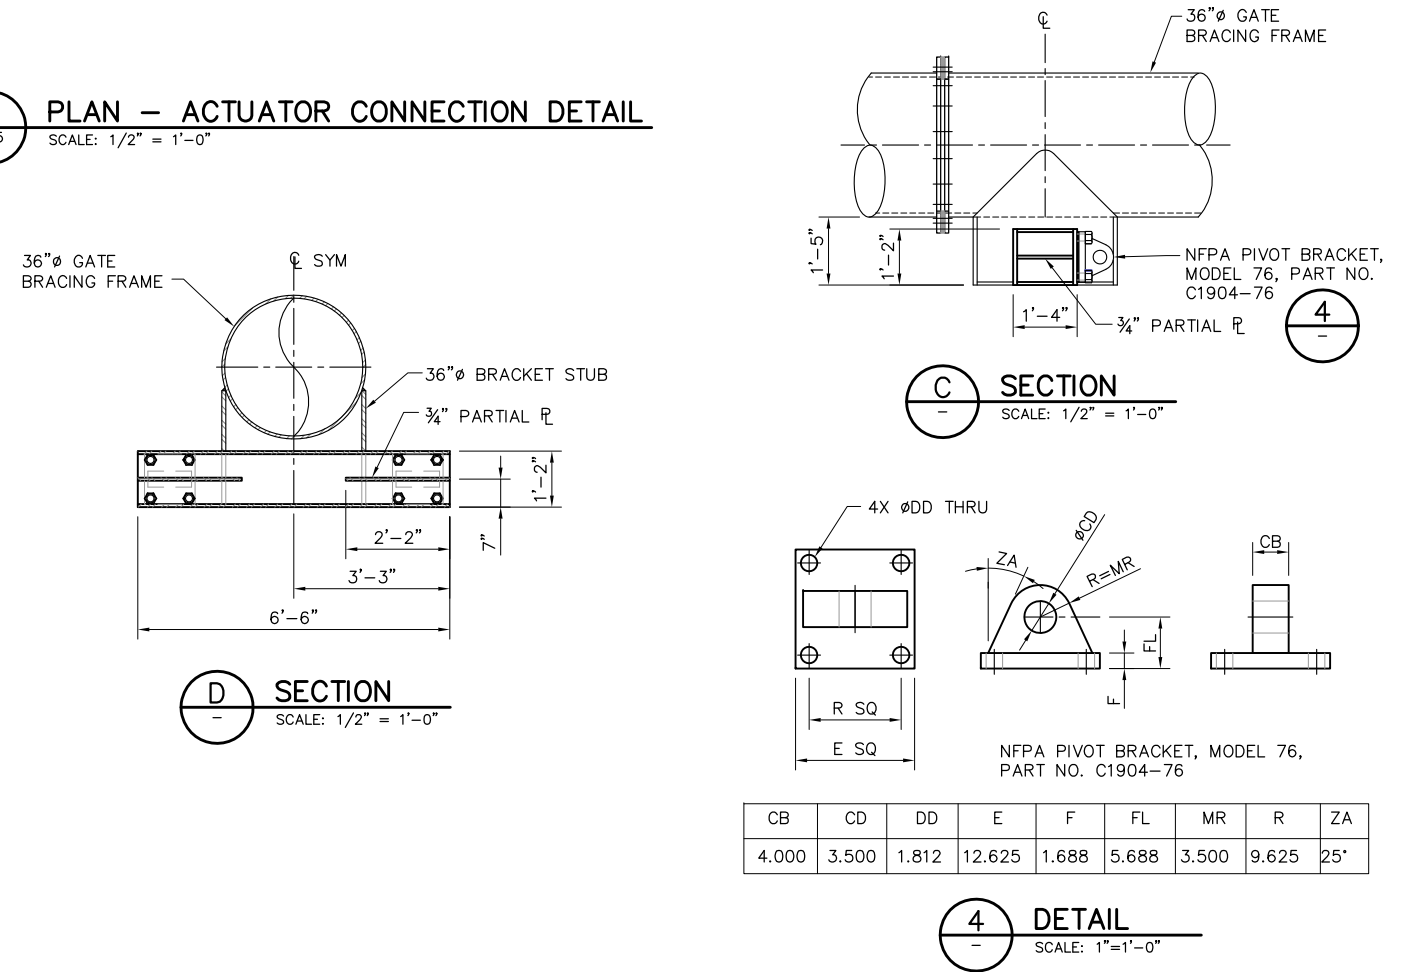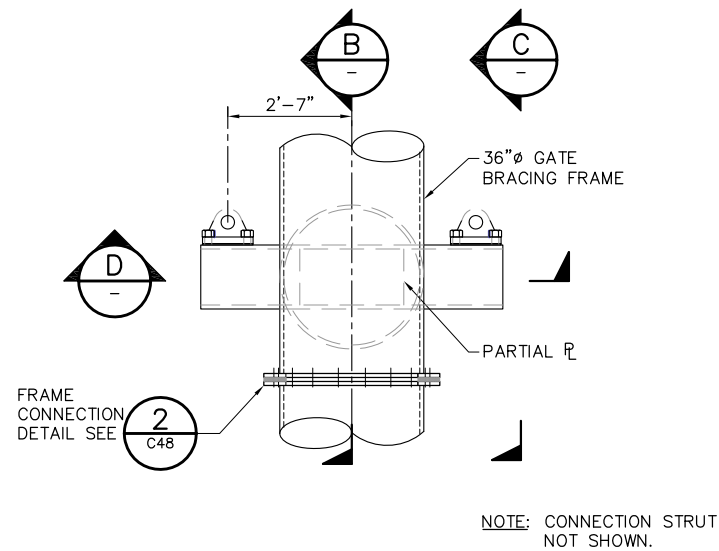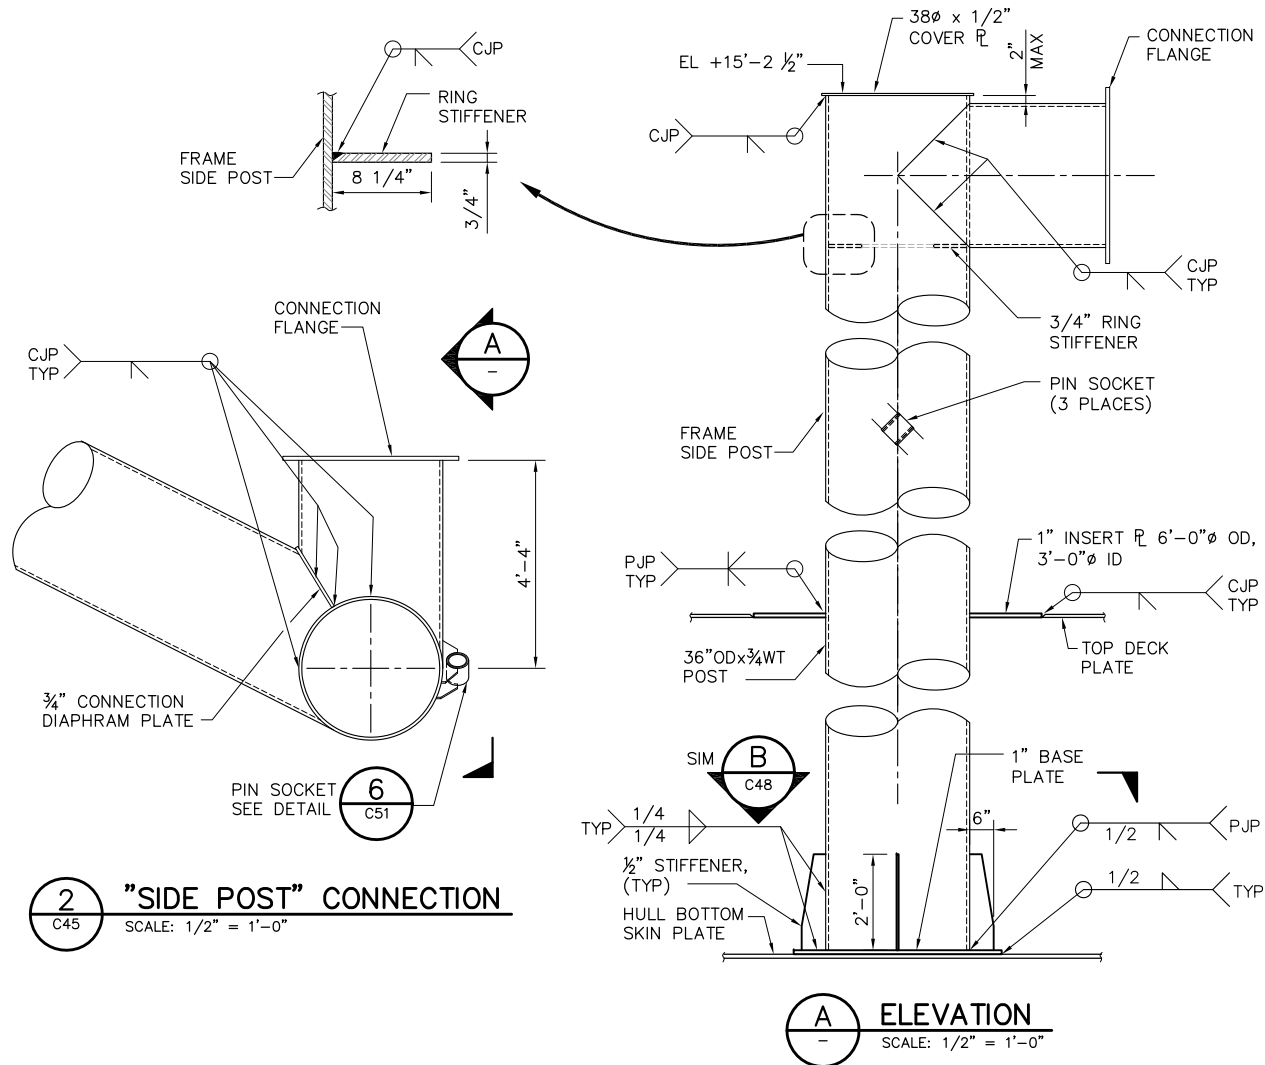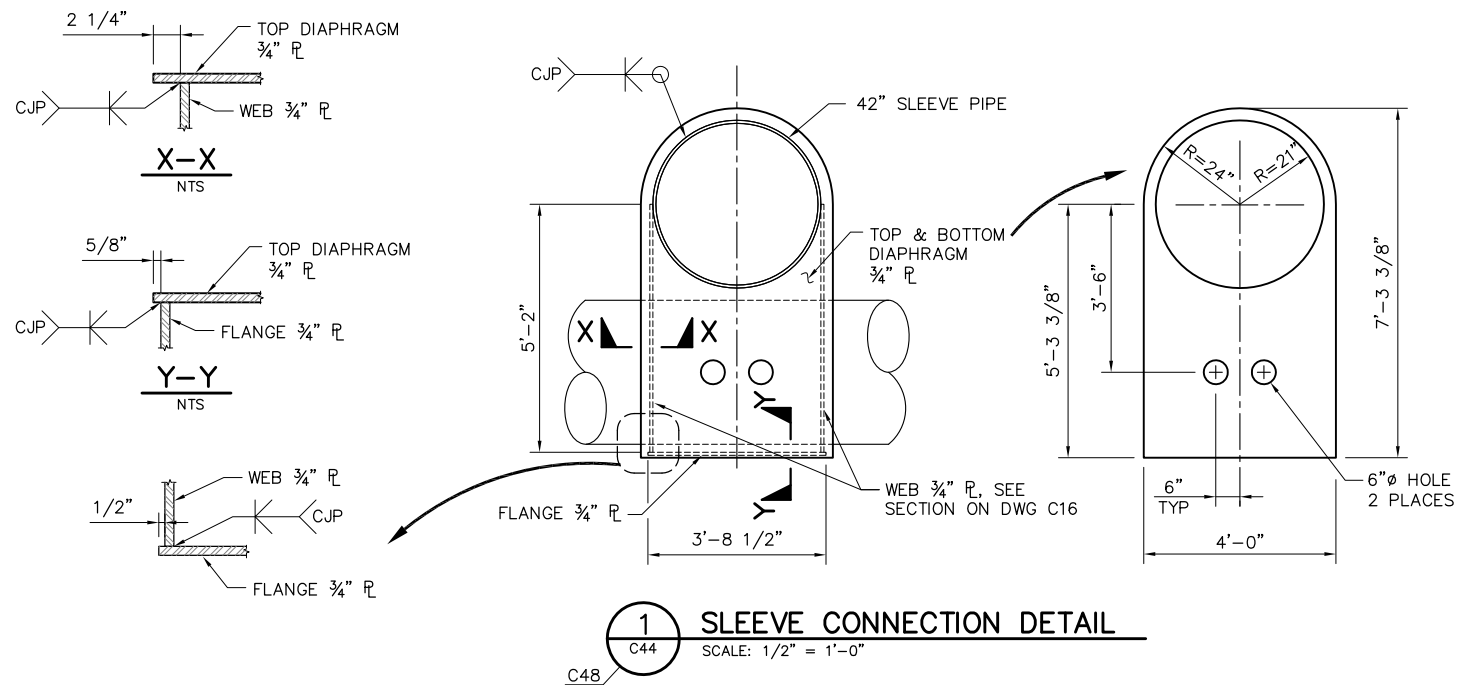

REVISION	DESCRIPTION	BY	DATE

SAN LUIS & DELTA-MENDOTA WATER AUTHORITY

San Luis & Delta-Mendota Water Authority
842 6th Street, Suite 7
PO Box 2157
Los Banos, California 93635

Moffatt & Nichol

2001 N. Main Street, Suite 360
Walnut Creek, California 94596
(925) 944-5411


DSGN JMB DR AB/EP CHK CBS
JOB NO. 6097-03 SUBMITTED BY RMR

2-GATES FISH PROTECTION DEMONSTRATION PROJECT


CONNECTION SLOUGH GATE STRUCTURAL DETAILS, SHEET 4

DATE 10/02/09
SHEET 53 OF 78
C49


P:\6097-03 SWC GATE DESIGN\CADD\DWG\609703-C50.DWG 9/1/2009 10:14 AM

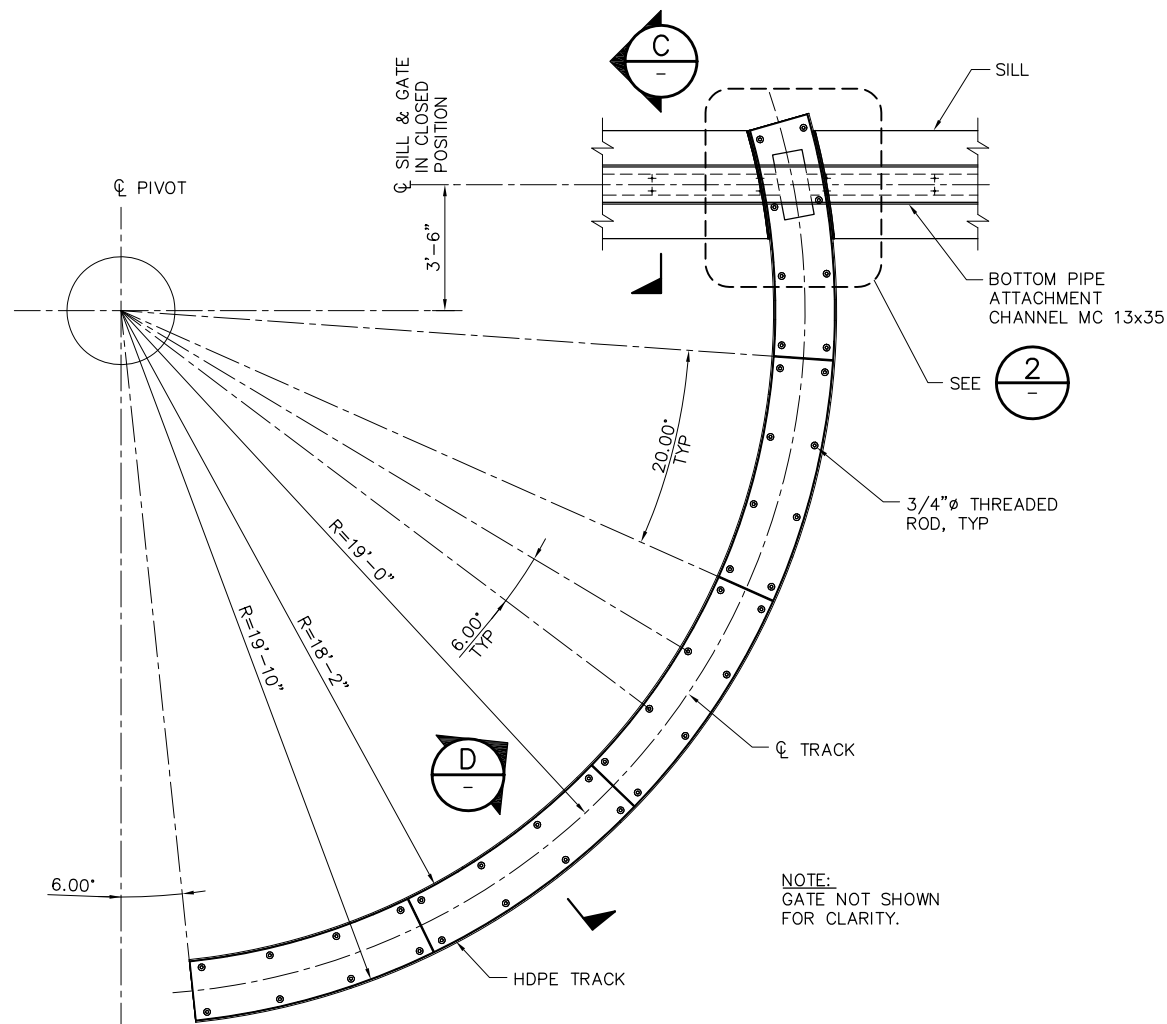


1 TRACK DETAIL
SCALE: 3/8" = 1'-0"

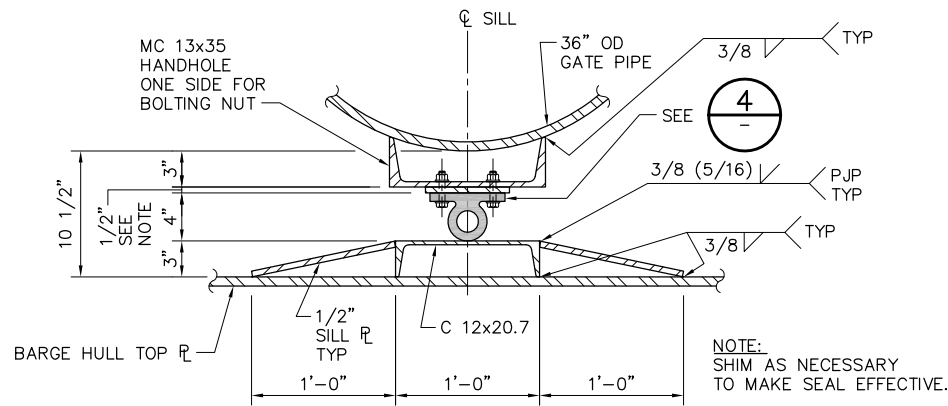


C SECTION
SCALE: 1 1/2" = 1'-0"

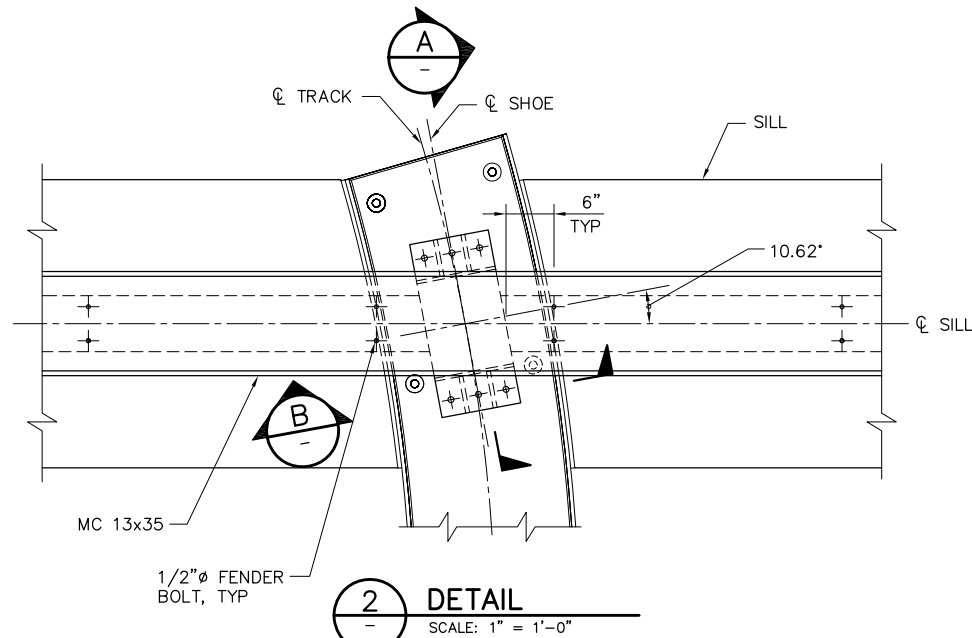


2 DETAIL
SCALE: 1" = 1'-0"

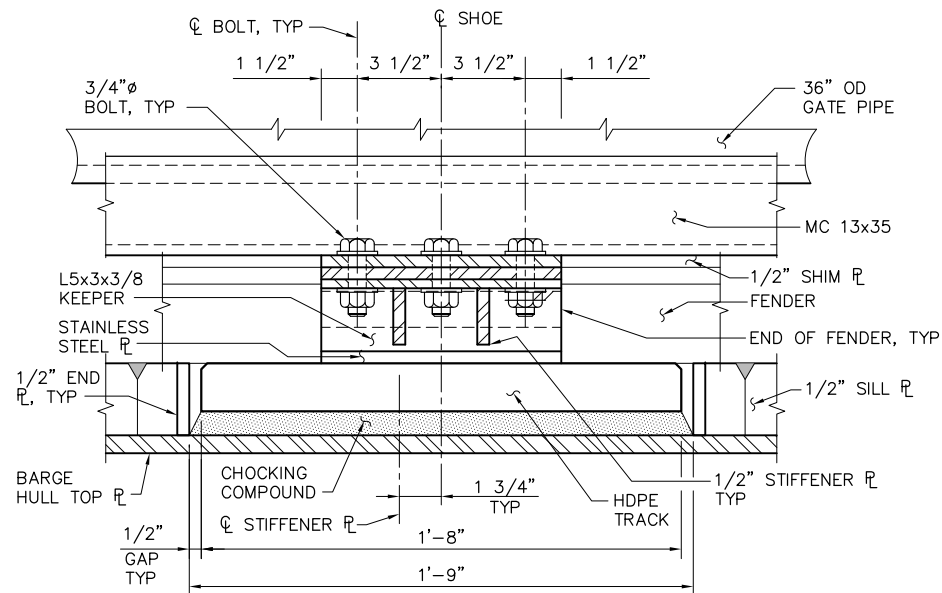


B SECTION
SCALE: 3" = 1'-0"

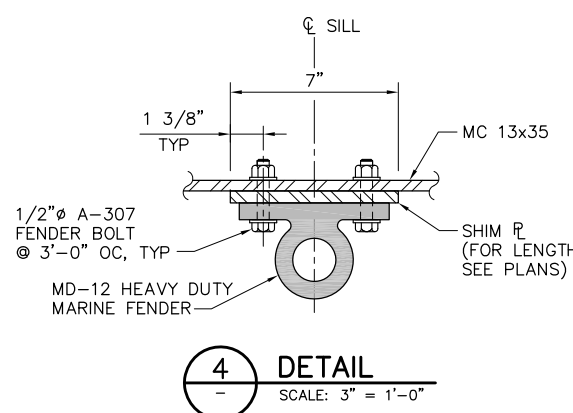


4 DETAIL
SCALE: 3" = 1'-0"

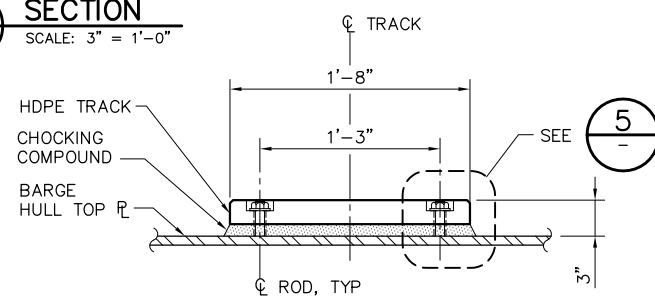


D SECTION
SCALE: 1 1/2" = 1'-0"

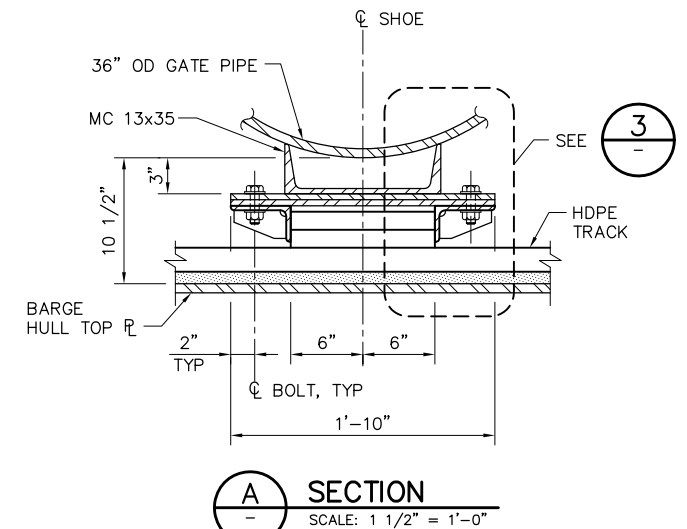


A SECTION
SCALE: 1 1/2" = 1'-0"

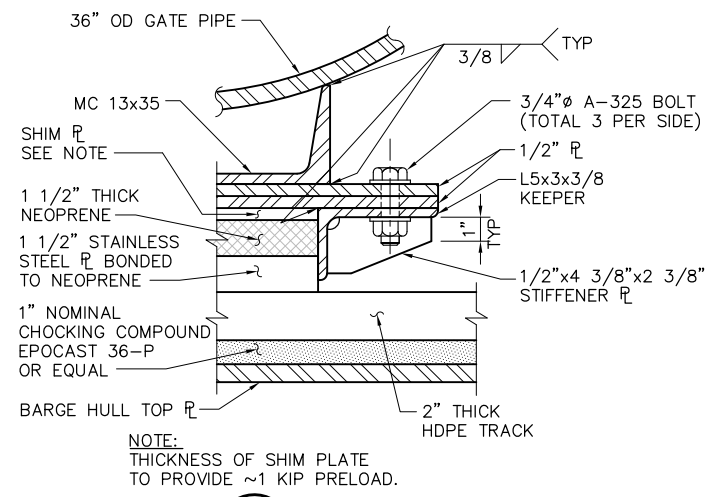

3 DETAIL
SCALE: 3" = 1'-0"

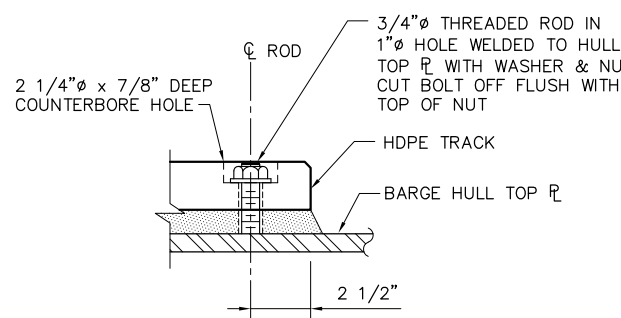

5 DETAIL
SCALE: 3" = 1'-0"

 

**100% SUBMITTAL
REVISION 1**

IF SHEET IS LESS THAN 22" x 34"
IT IS A REDUCED PRINT -
SCALE REDUCED ACCORDINGLY.

REVISION	DESCRIPTION	BY	DATE



San Luis & Delta-Mendota Water Authority
842 6th Street, Suite 7
PO Box 2157
Los Banos, California 93635



2001 N. Main Street, Suite 360
Walnut Creek, California 94596
(925) 944-5411

DSGN	JMB	DR	EP/AB	CHK	CBS
JOB NO.	6097-03	SUBMITTED BY	RMR		










2-GATES FISH PROTECTION
DEMONSTRATION PROJECT

CONNECTION SLOUGH
GATE STRUCTURAL DETAILS,
SHEET 5


DATE 10/02/09

SHEET 54 OF 78

C50

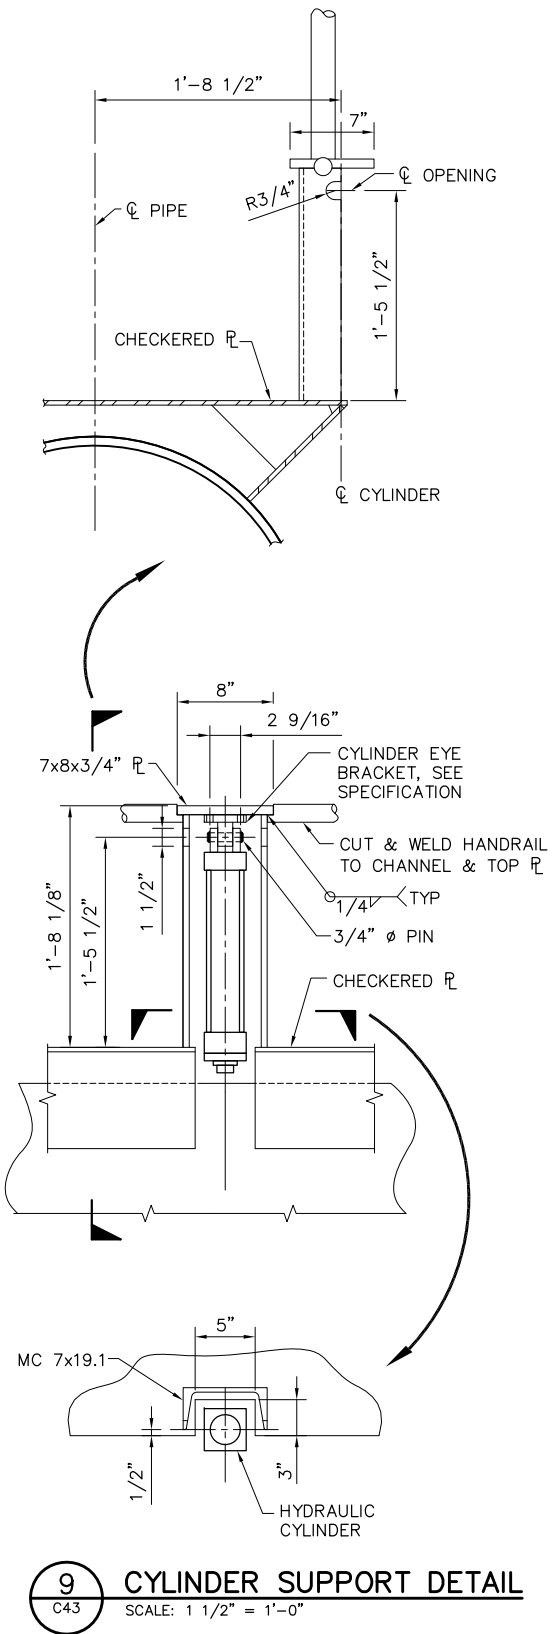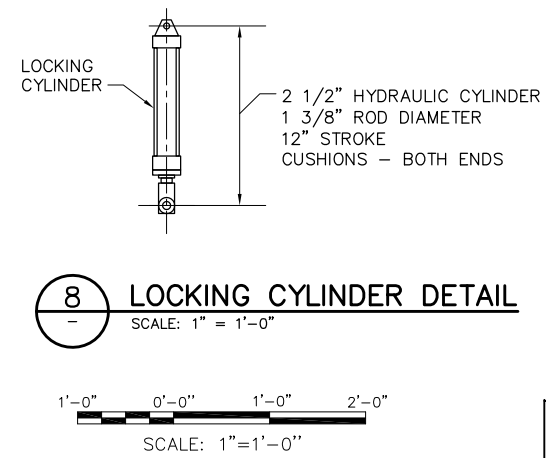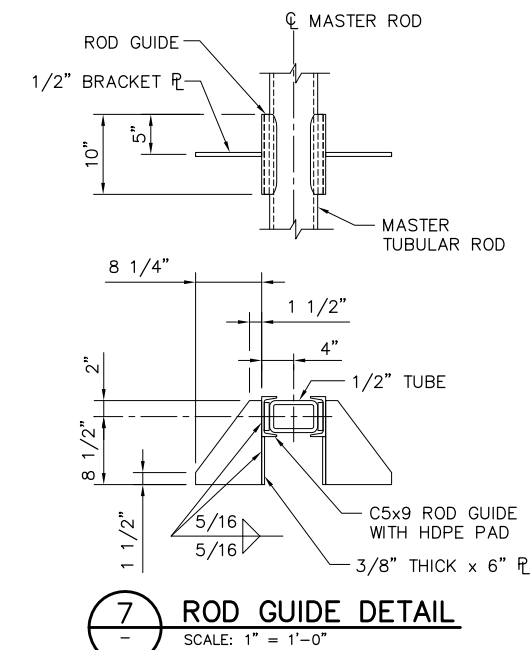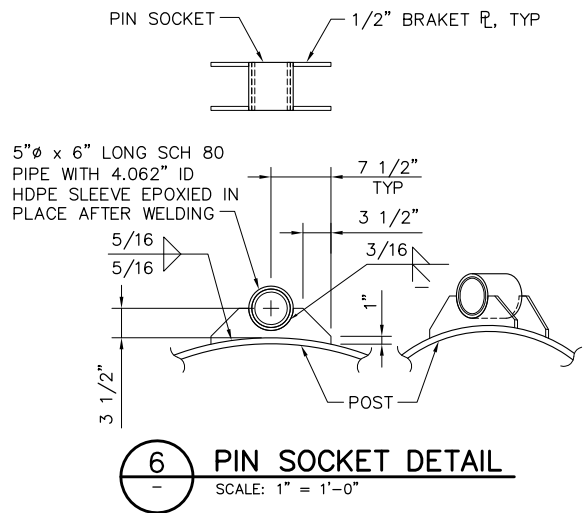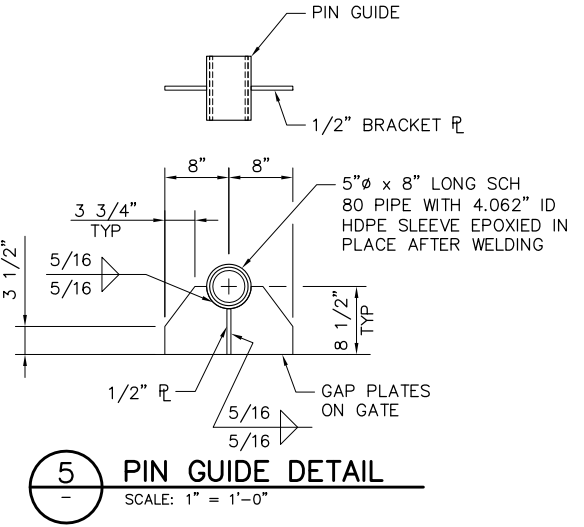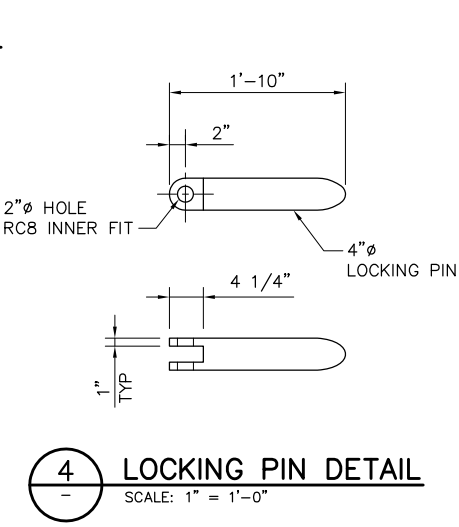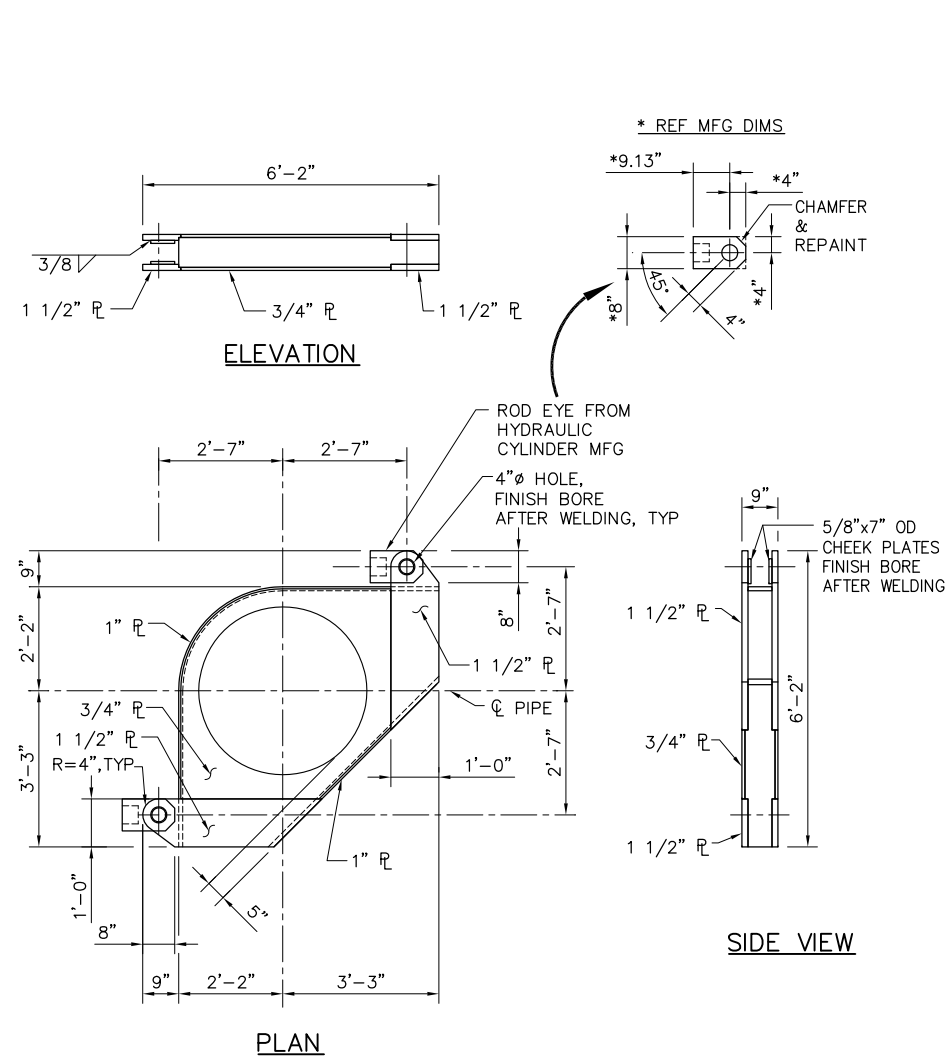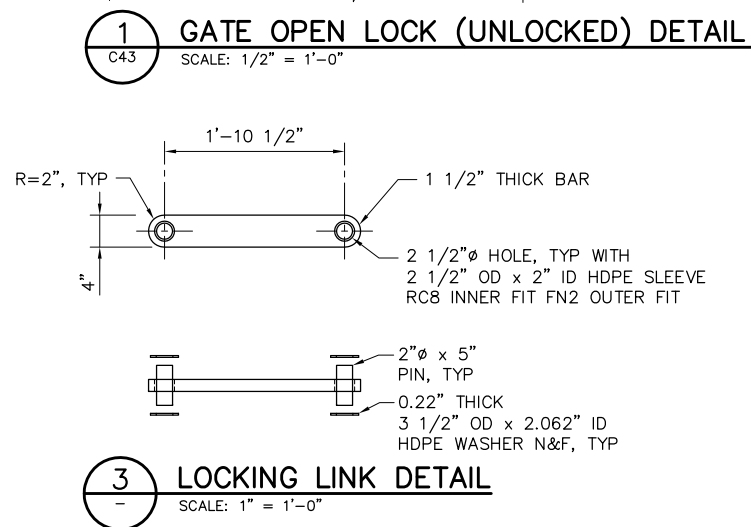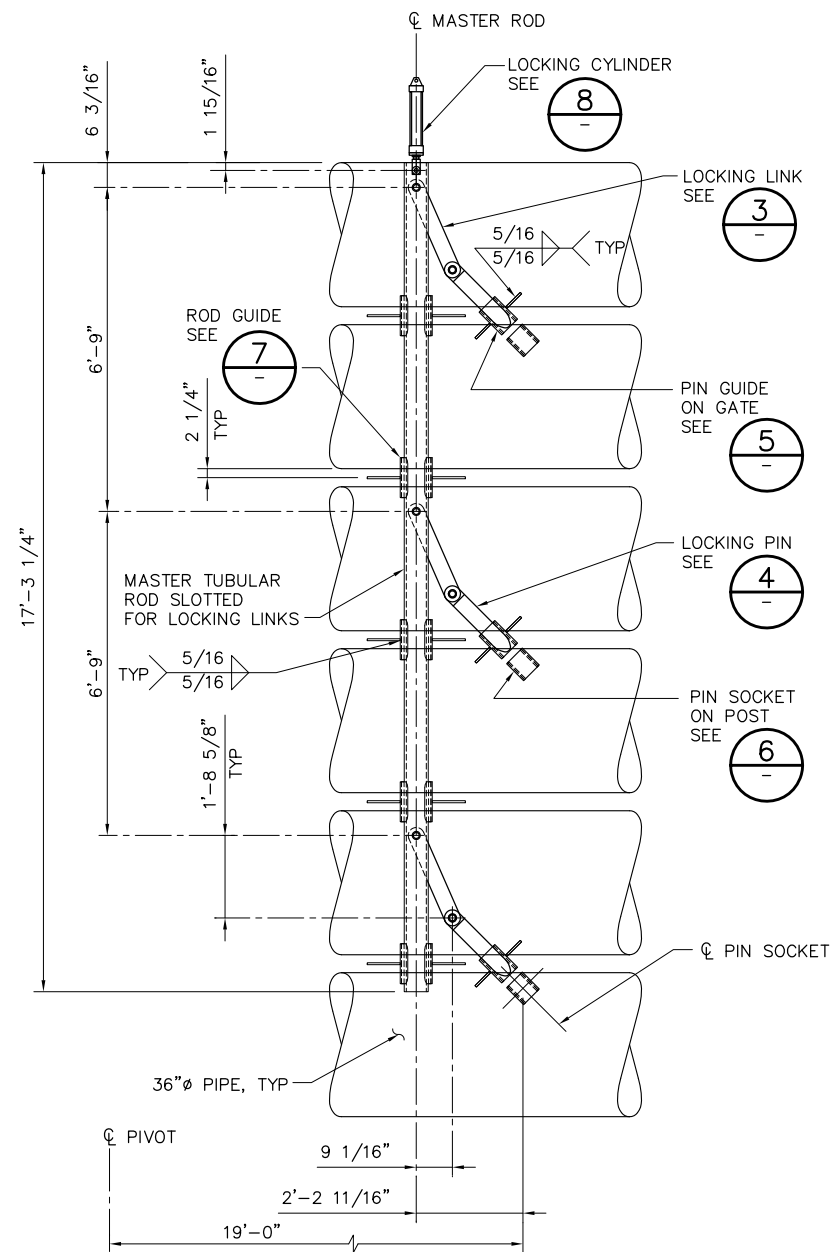

REVISION	DESCRIPTION	BY	DATE

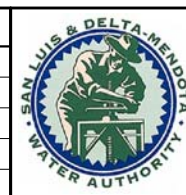

San Luis & Delta-Mendota Water Authority
842 6th Street, Suite 7
PO Box 2157
Los Banos, California 93635



2001 N. Main Street, Suite 360
Walnut Creek, California 94596
(925) 944-5411

DSGN CBS	DR CBS/EP	CHK TDB
JOB NO. 6097-03	SUBMITTED BY RMR	

2-GATES FISH PROTECTION
DEMONSTRATION PROJECT

CONNECTION SLOUGH
GATE MECHANICAL DETAILS
SHEET 1

DATE 10/02/09


SHEET 55 OF 78

C51


100% SUBMITTAL
REVISION 1

IF SHEET IS LESS THAN 22" x 34"
IT IS A REDUCED PRINT –
SCALE REDUCED ACCORDINGLY.


P:\6097-03 SWC GATE DESIGN\CADD\DWG\609703-C52.DWG 9/29/2009 3:29 PM

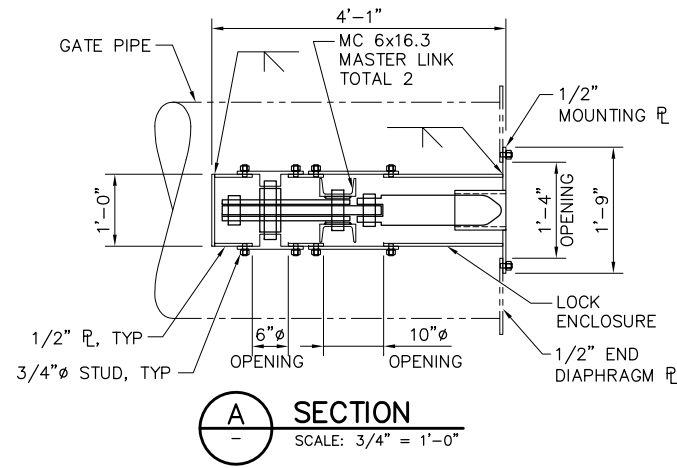


A SECTION
SCALE: 3/4" = 1'-0"

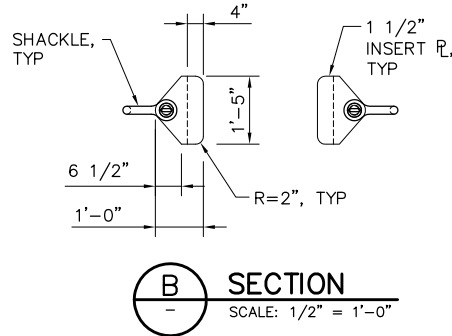


B SECTION
SCALE: 1/2" = 1'-0"

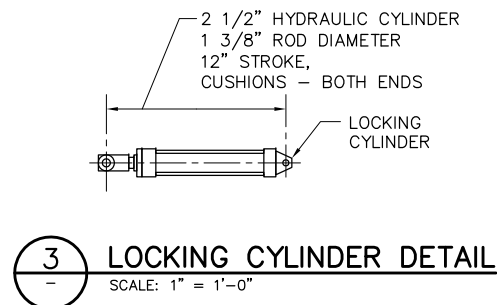


3 LOCKING CYLINDER DETAIL
SCALE: 1" = 1'-0"

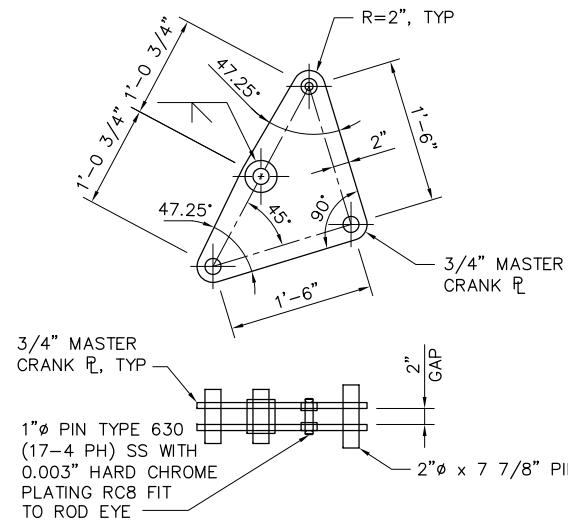


4 MASTER CRANK DETAIL
SCALE: 1" = 1'-0"

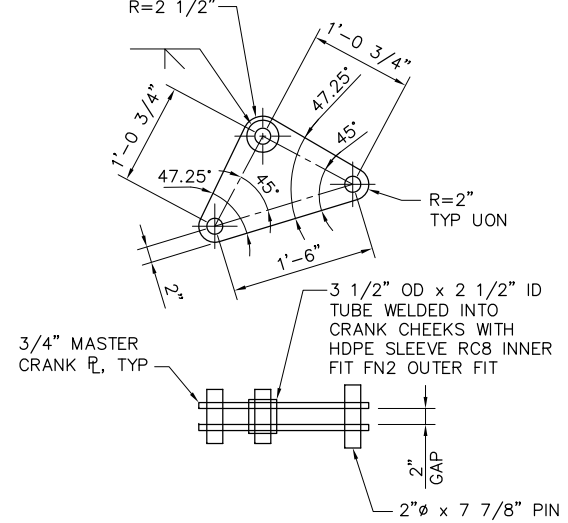


5 LOCKING CRANK DETAIL
SCALE: 1" = 1'-0"

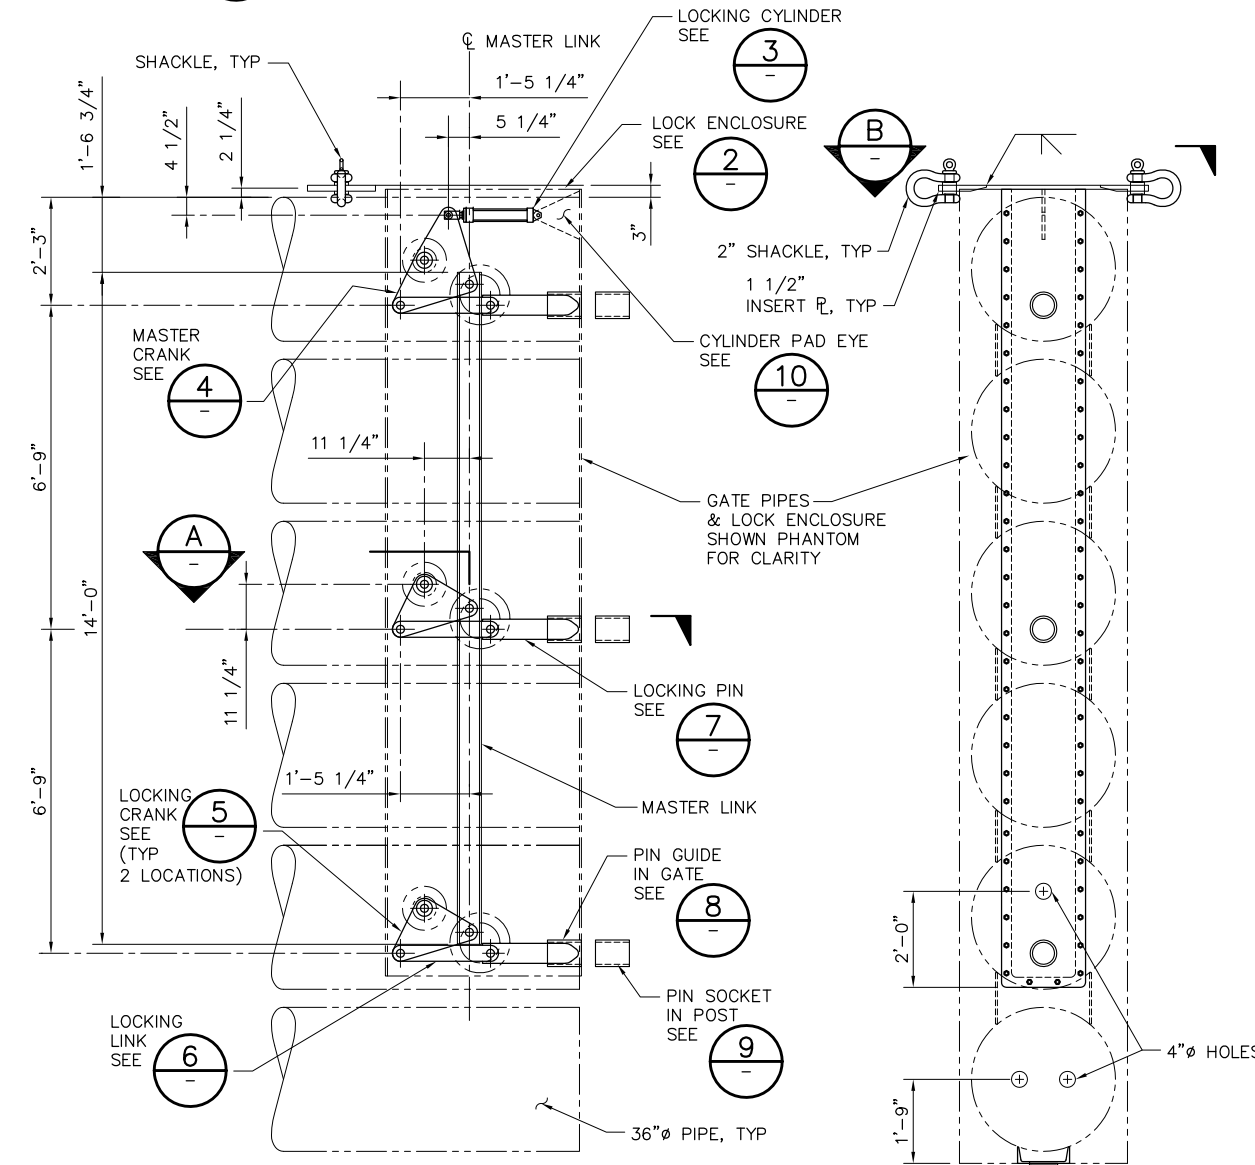


1 GATE CLOSED LOCK (UNLOCKED) DETAIL
SCALE: 1/2" = 1'-0"

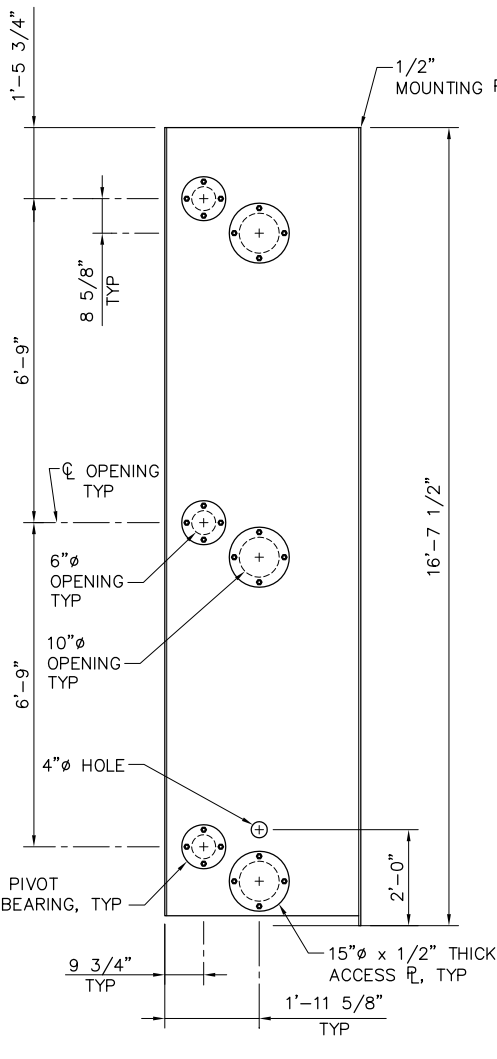


2 LOCK ENCLOSURE DETAIL
SCALE: 1/2" = 1'-0"

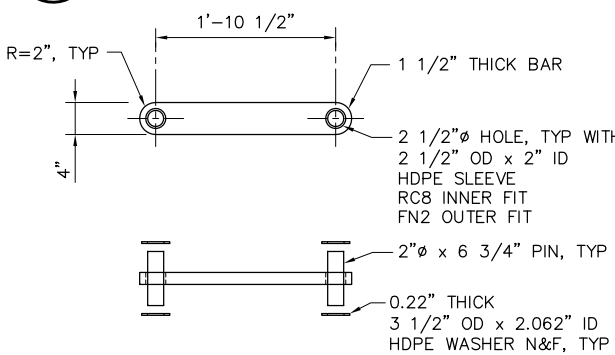


6 LOCKING LINK DETAIL
SCALE: 1" = 1'-0"

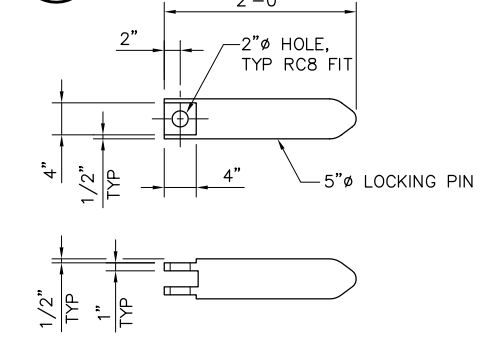


7 LOCKING PIN DETAIL
SCALE: 1" = 1'-0"

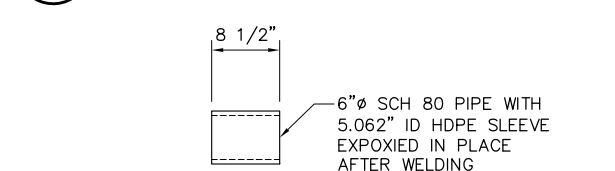

8 PIN GUIDE DETAIL
SCALE: 1" = 1'-0"

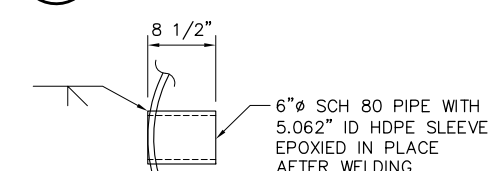


9 PIN SOCKET DETAIL
SCALE: 1" = 1'-0"

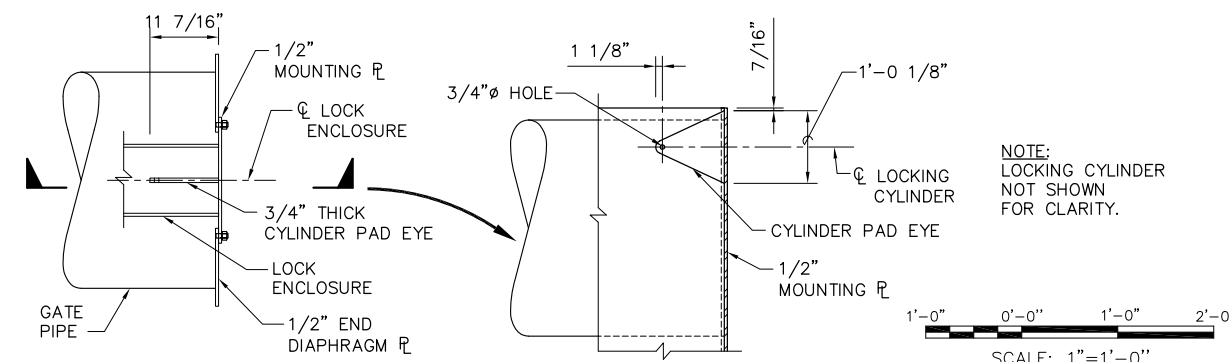

10 CYLINDER PAD EYE DETAIL
SCALE: 3/4" = 1'-0"

100% SUBMITTAL REVISION 1
IF SHEET IS LESS THAN 22" x 34" IT IS A REDUCED PRINT - SCALE REDUCED ACCORDINGLY.

REVISION	DESCRIPTION	BY	DATE

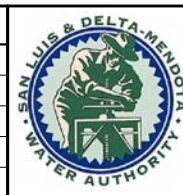

San Luis & Delta-Mendota Water Authority
842 6th Street, Suite 7
PO Box 2157
Los Banos, California 93635



2001 N. Main Street, Suite 360
Walnut Creek, California 94596
(925) 944-5411

DSGN	CBS	DR	EP/AB	CHK	TDB
JOB NO.	6097-03	SUBMITTED BY	RMR		

2-GATES FISH PROTECTION
DEMONSTRATION PROJECT


CONNECTION SLOUGH
GATE MECHANICAL DETAILS
SHEET 2

DATE 10/02/09

SHEET 56 OF 78


C52

P:\6097-03 SMC GATE DESIGN\CADD\DWG\609703-C53.DWG 9/1/2009 10:15 AM

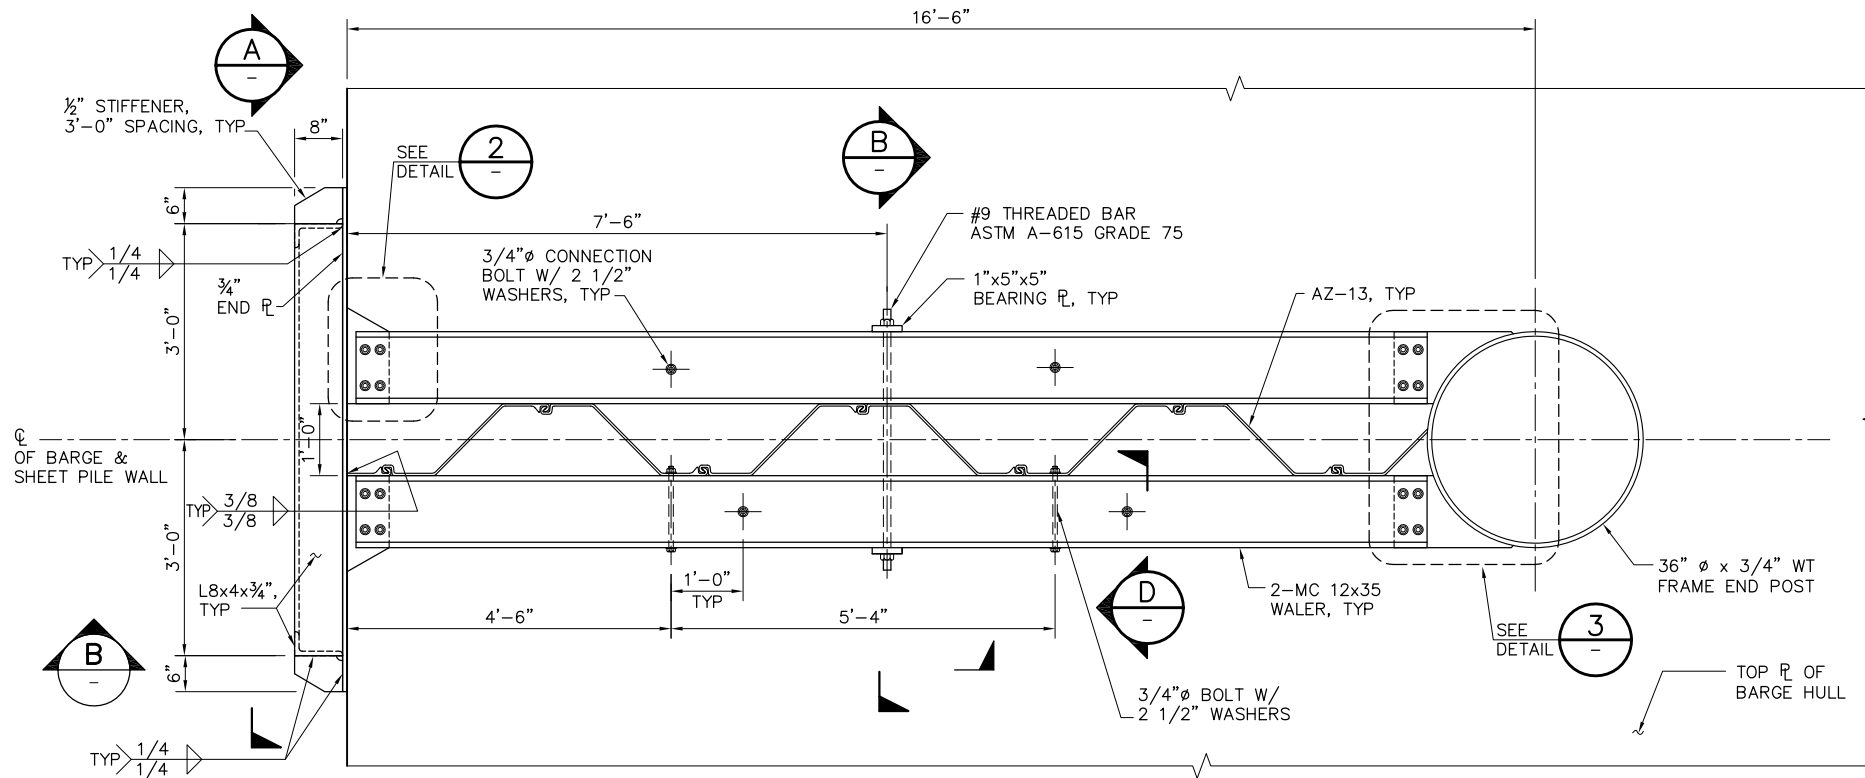


PLAN


1 DETAIL
SCALE: 3/4" = 1'-0"

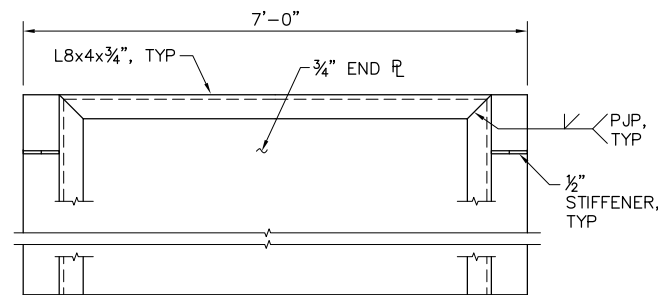


A SECTION
SCALE: 3/4" = 1'-0"

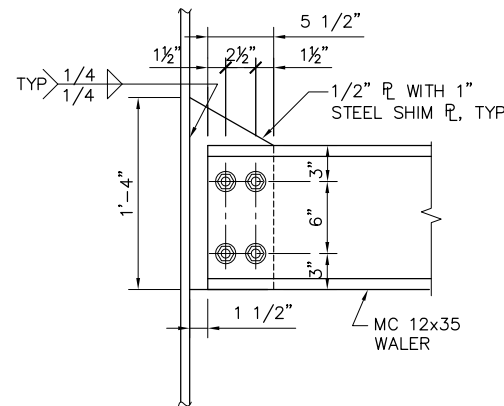

2 DETAIL
SCALE: 1 1/2" = 1'-0"


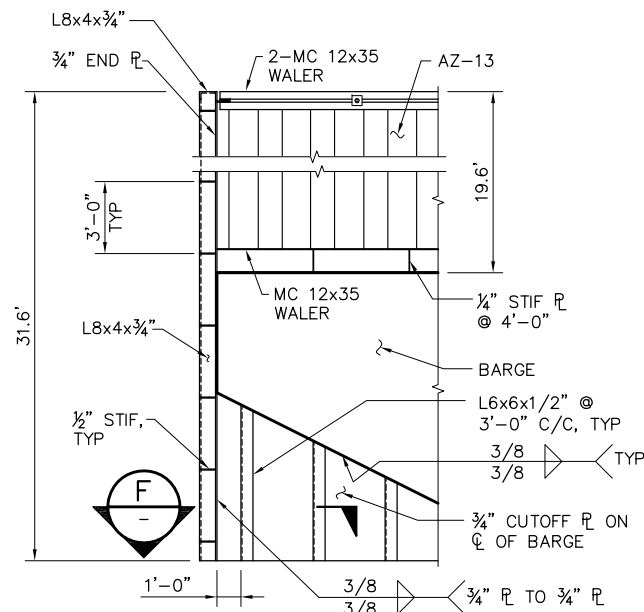


B SECTION
SCALE: 1/4" = 1'-0"

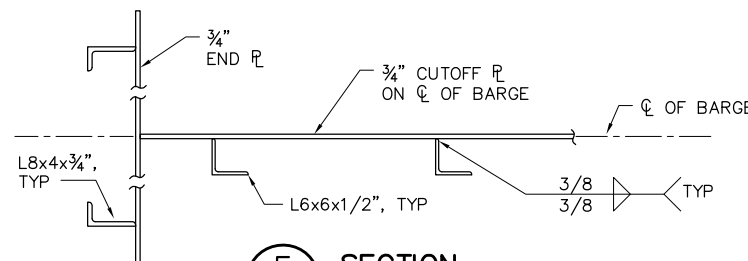


C SECTION
SCALE: 3/4" = 1'-0"


F SECTION
SCALE: 3/4" = 1'-0"

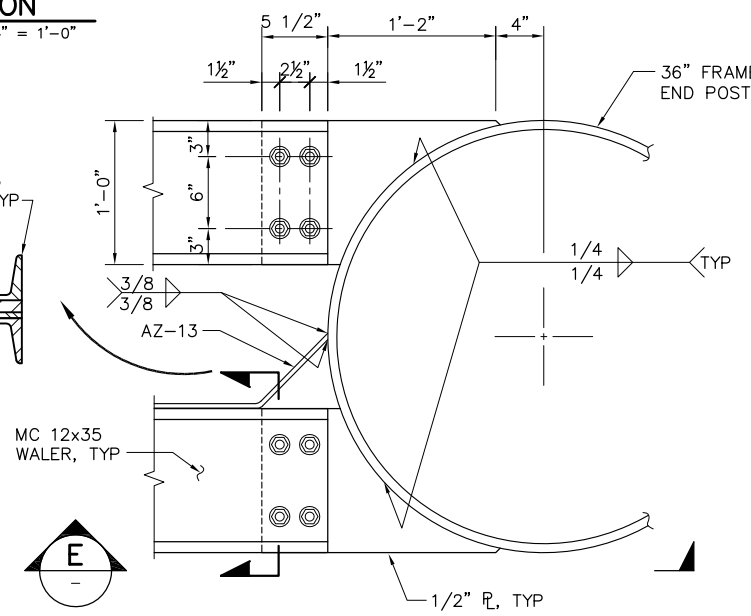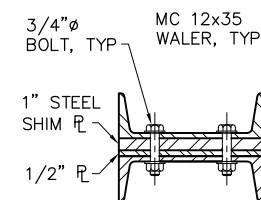


3 DETAIL
SCALE: 1 1/2" = 1'-0"

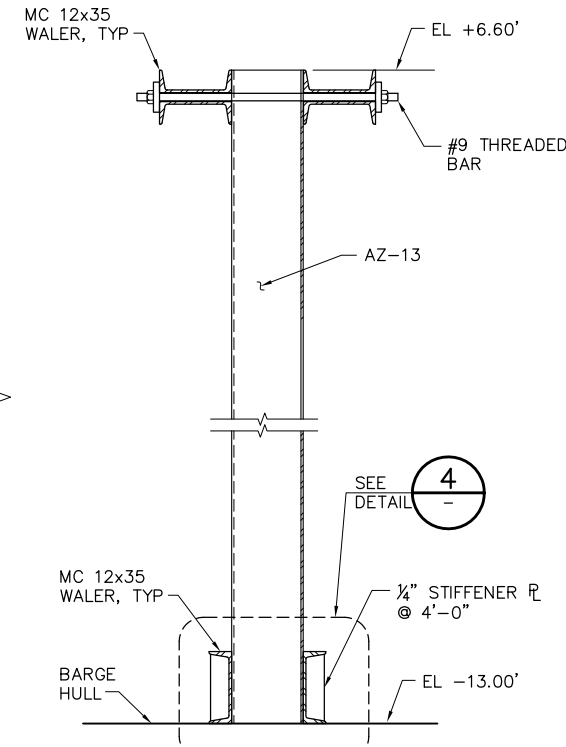


D SECTION
SCALE: 1 1/2" = 1'-0"

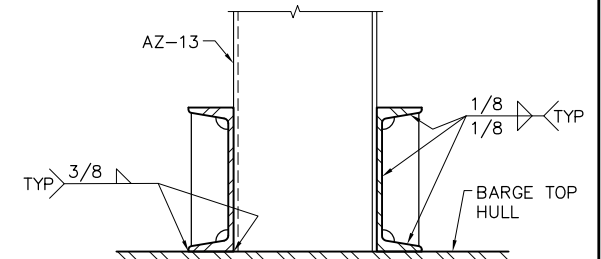

4 DETAIL
SCALE: 1 1/2" = 1'-0"

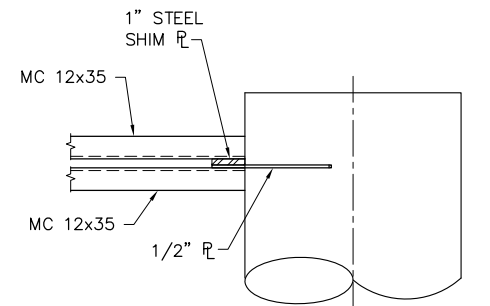

E SECTION
SCALE: 3/4" = 1'-0"

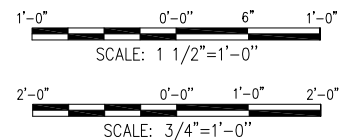

NOTE:
ALL BOLTS ARE ASTM A-307 U.O.N.

100% SUBMITTAL
REVISION 1

IF SHEET IS LESS THAN 22" x 34"
IT IS A REDUCED PRINT -
SCALE REDUCED ACCORDINGLY.

REVISION	DESCRIPTION	BY	DATE



San Luis & Delta-Mendota Water Authority
842 6th Street, Suite 7
PO Box 2157
Los Banos, California 93635



2001 N. Main Street, Suite 360
Walnut Creek, California 94596
(925) 944-5411

DSGN	JMB	DR	AB	CHK	TDB
JOB NO.	6097-03	SUBMITTED BY	RMR		

2-GATES FISH PROTECTION
DEMONSTRATION PROJECT


DATE 10/02/09

SHEET 57 OF 78


CONNECTION SLOUGH
END WALL SCANTLINGS

C53

P:\6097-03 SWC GATE DESIGN\CADD\DWG\609703-C54.DWG 9/29/2009 3:41 PM

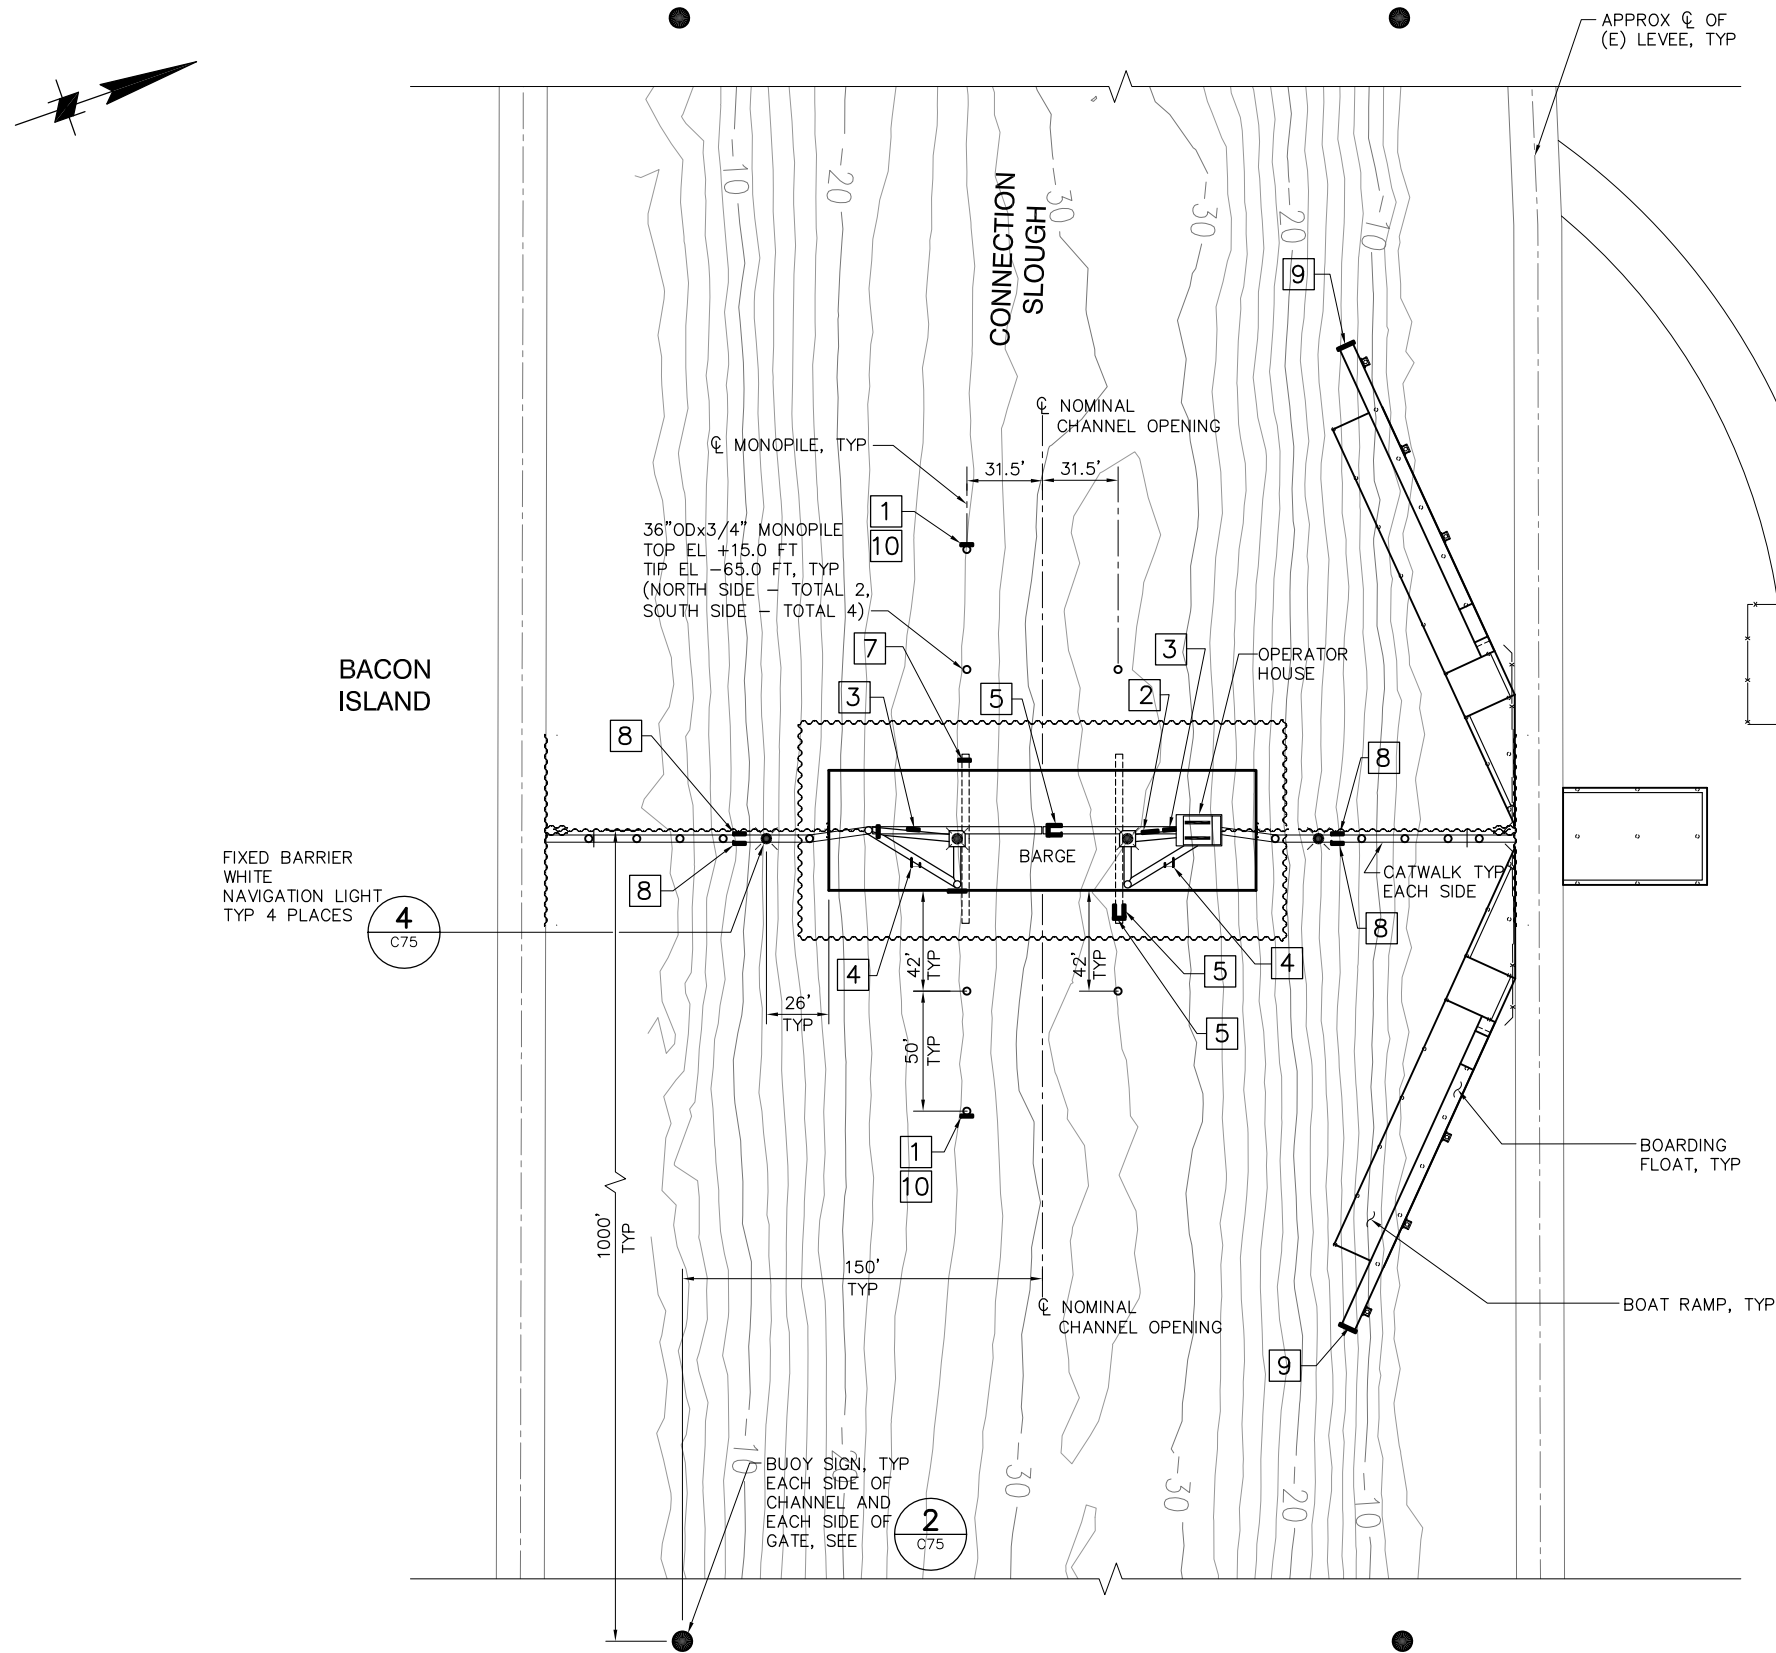

PLAN
SCALE: 1"= 40'

 

SIGN DATA

LOCATION	SIGN	SIGN DETAIL	SIGN MOUNTING DETAIL
1	GATE 5 MPH	1 C75	1 C76
2	GATE WARNING SIGN	5 C75	5 C76
3	DANGER SIGN	7 C75	5 C76
4	DANGER SIGN	7 C75	3 C76
5	GATE POSITION SIGNS "GATES OPEN" "GATES CLOSED"	6 C75	2 C74
6	GATE WARNING SIGN	5 C75	2 C76
7	GATE POSITION SIGN "GATES OPEN"	6 C75	4 C76
8	STAY BACK WARNING SIGN	9 C75	5 C76
9	BOAT RAMP DOCK SIGN	3 C75	6 C76
10	GATE OPENING SIGN	10 C75	1 C76

REVISION	DESCRIPTION	BY	DATE



San Luis & Delta-Mendota Water Authority
842 6th Street, Suite 7
PO Box 2157
Los Banos, California 93635



2001 N. Main Street, Suite 360
Walnut Creek, California 94596
(925) 944-5411

DSGN	RBD	DR	AB	CHK	TDB
JOB NO.	6097-03	SUBMITTED BY	RMR		

2-GATES FISH PROTECTION
DEMONSTRATION PROJECT

DATE 10/02/09

SHEET 58 OF 78





CONNECTION SLOUGH
AIDS TO NAVIGATION PLAN

C54

100% SUBMITTAL
REVISION 1

IF SHEET IS LESS THAN 22" x 34"
IT IS A REDUCED PRINT -
SCALE REDUCED ACCORDINGLY.

C63

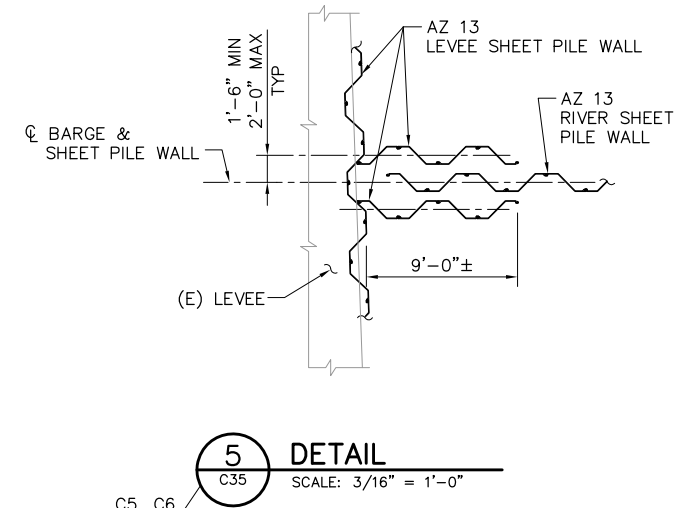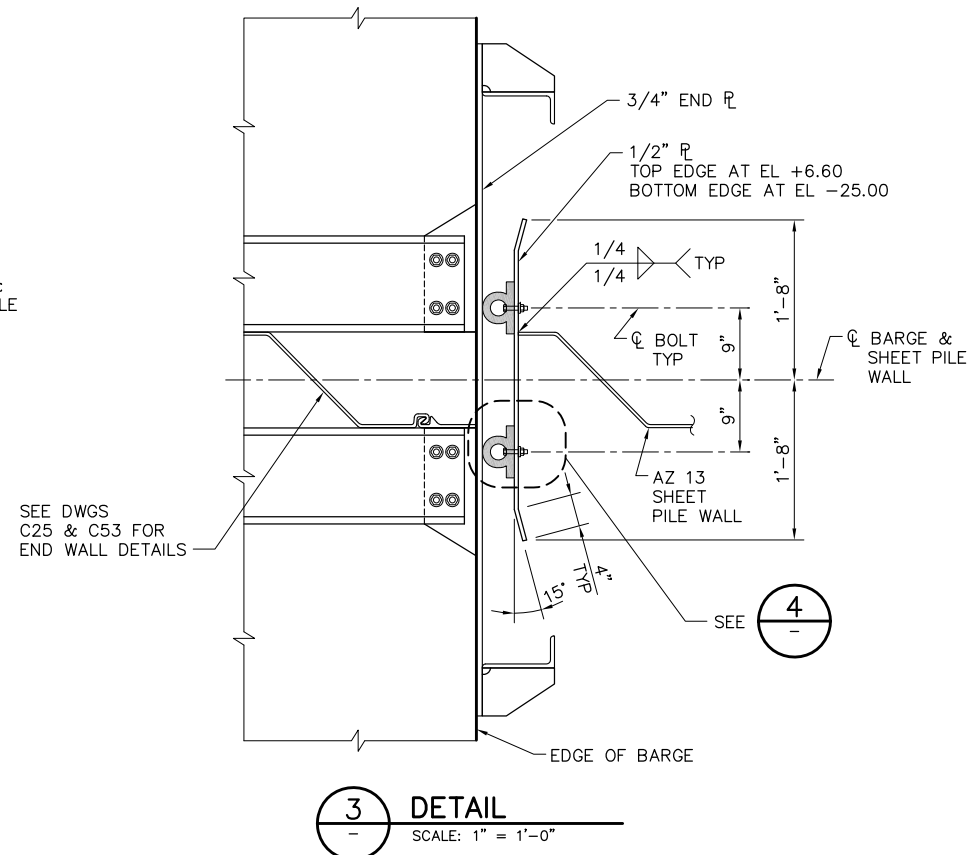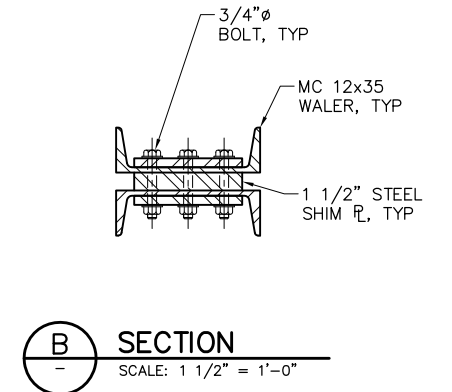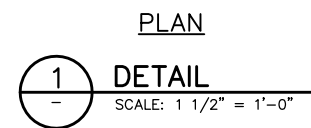

IF SHEET IS LESS THAN 22" x 34"
IT IS A REDUCED PRINT –
SCALE REDUCED ACCORDINGLY.

REVISION	DESCRIPTION	BY	DATE



San Luis & Delta-Mendota Water Authority
842 6th Street, Suite 7
PO Box 2157
Los Banos, California 93635



2001 N. Main Street, Suite 360
Walnut Creek, California 94596
(925) 944-5411

DSGN	DR	CHK
JMB	EP	TDB
JOB NO.	SUBMITTED BY	
6097-03	RMR	

2-GATES FISH PROTECTION
DEMONSTRATION PROJECT


DATE 10/02/09

SHEET 60 OF 78


SHEET PILE WALL DETAILS
SHEET 2

C64


P:\6097-03 SWC GATE DESIGN\CADD\DWG\609703-C65.DWG 9/1/2009 10:36 AM

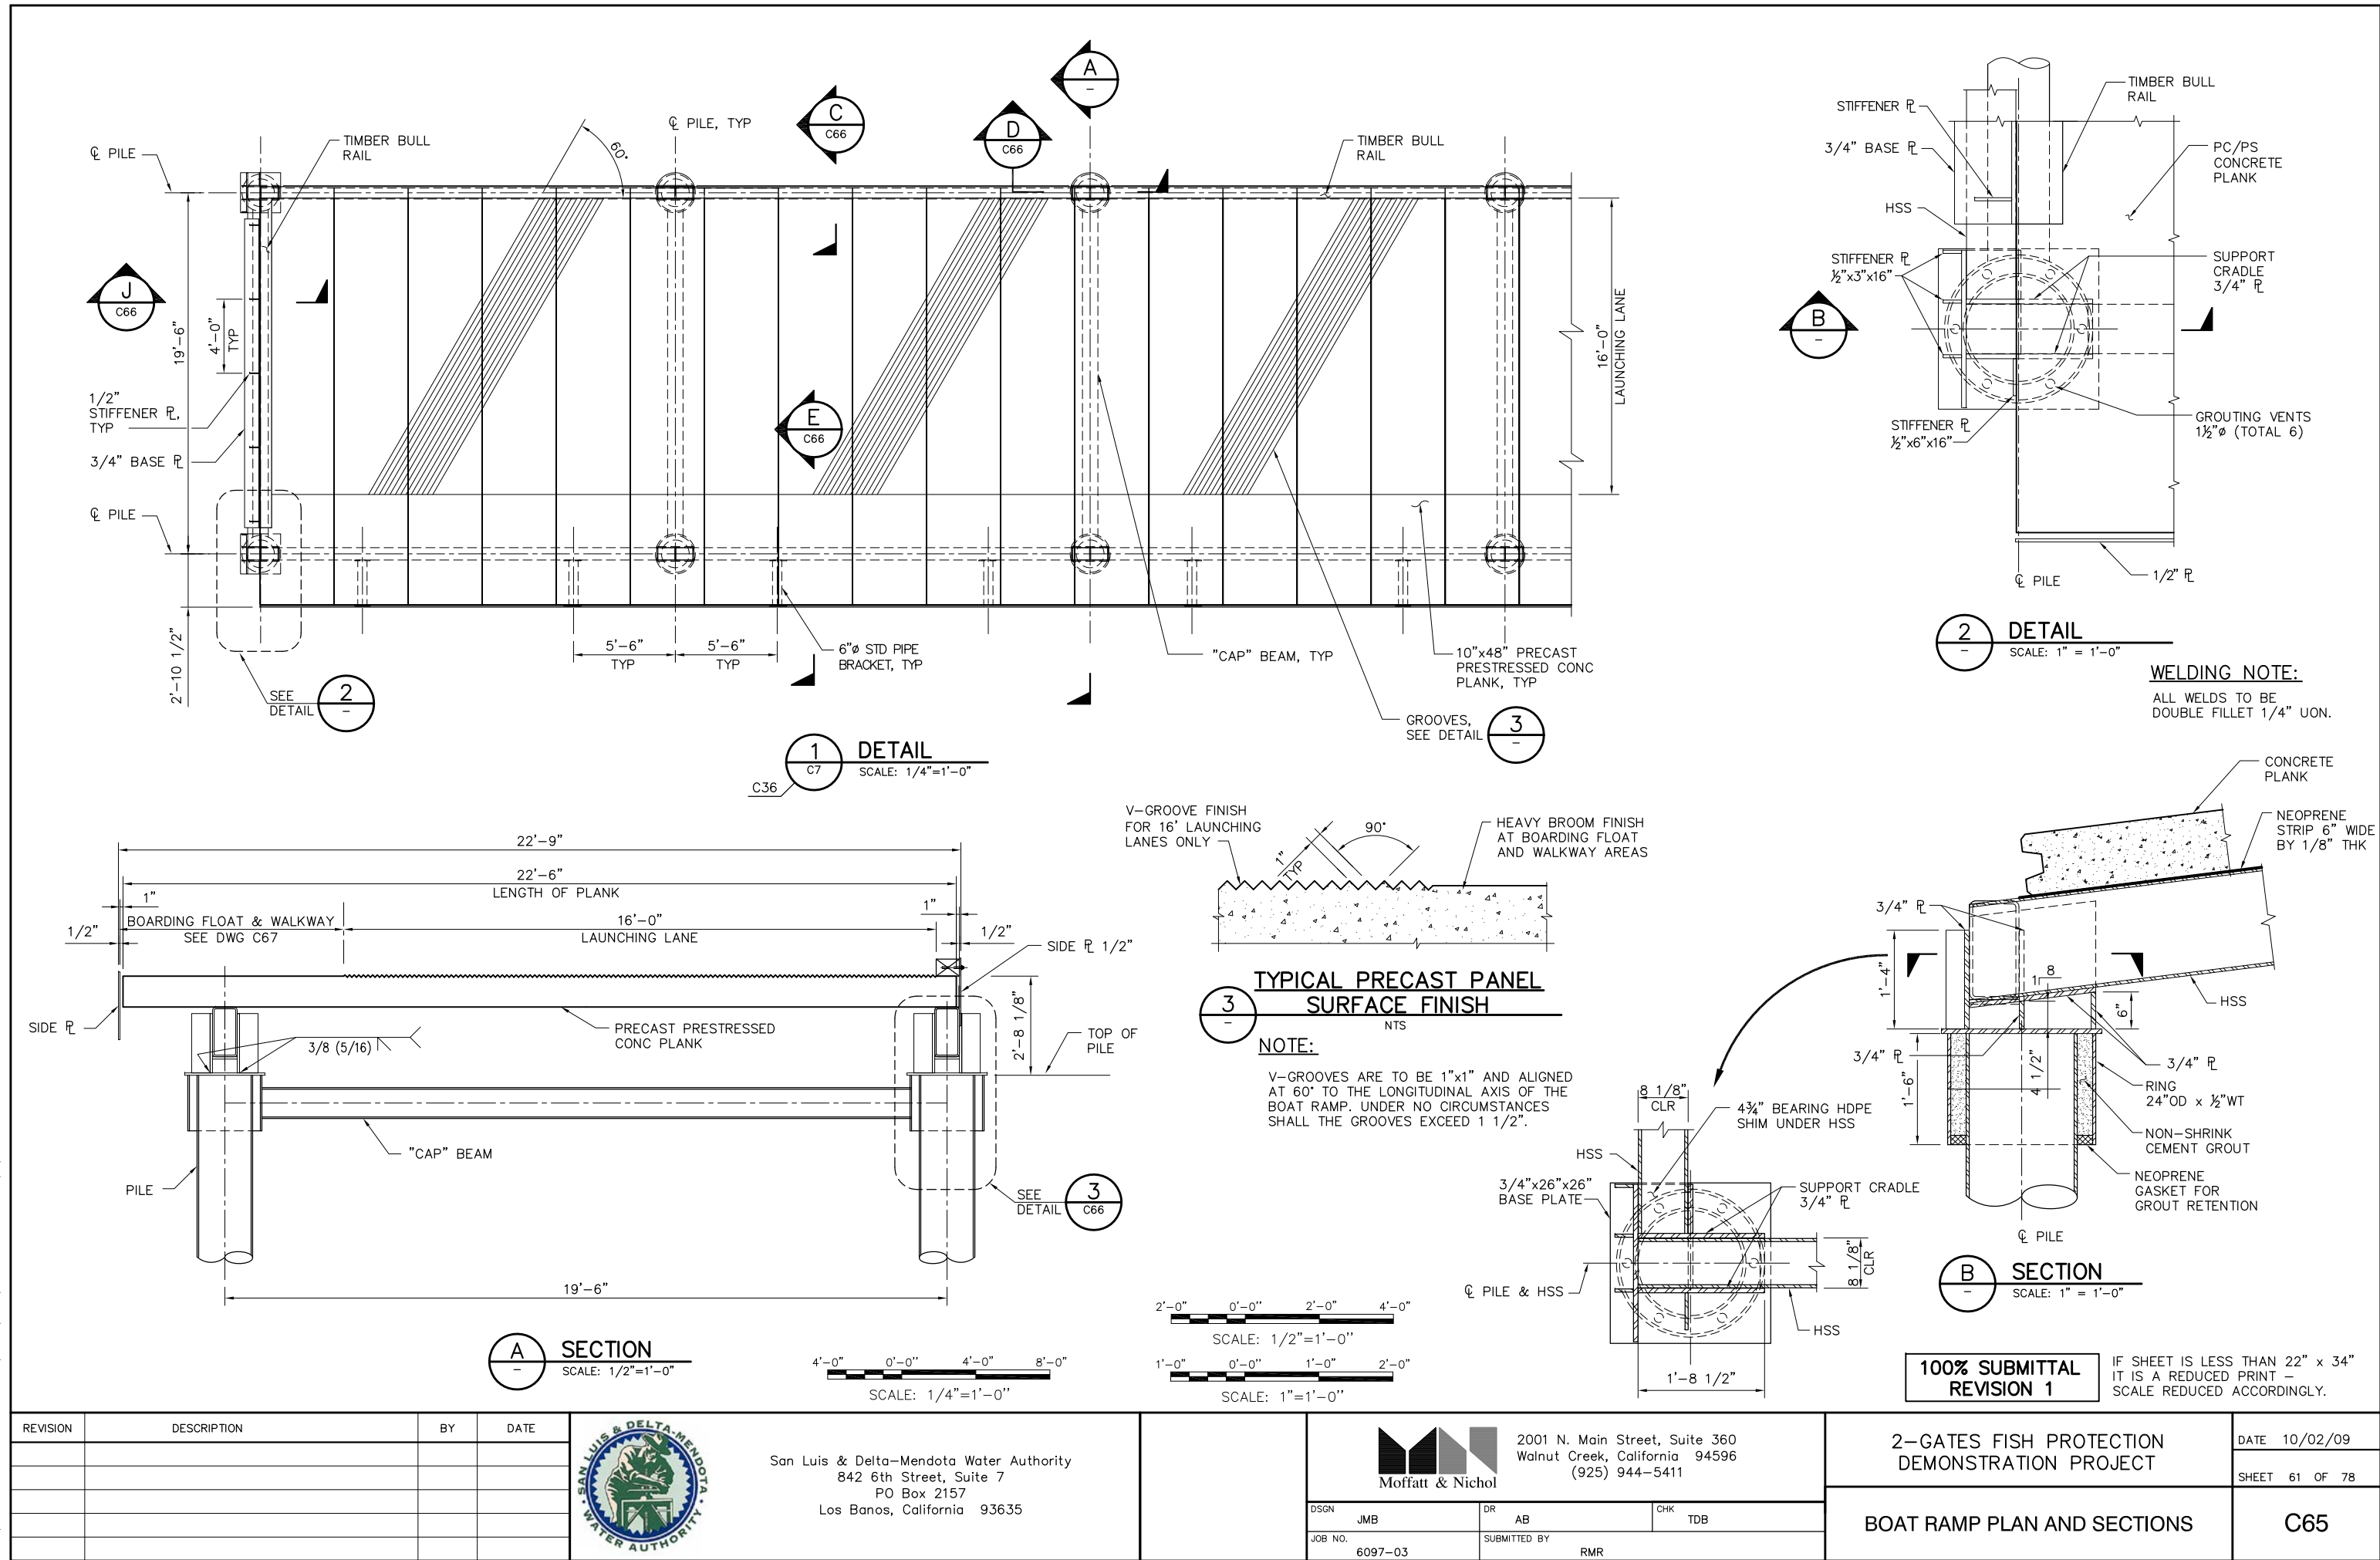


P:\6097-03 SWC GATE DESIGN\CADD\DWG\609703-C66.DWG 9/1/2009 10:38 AM

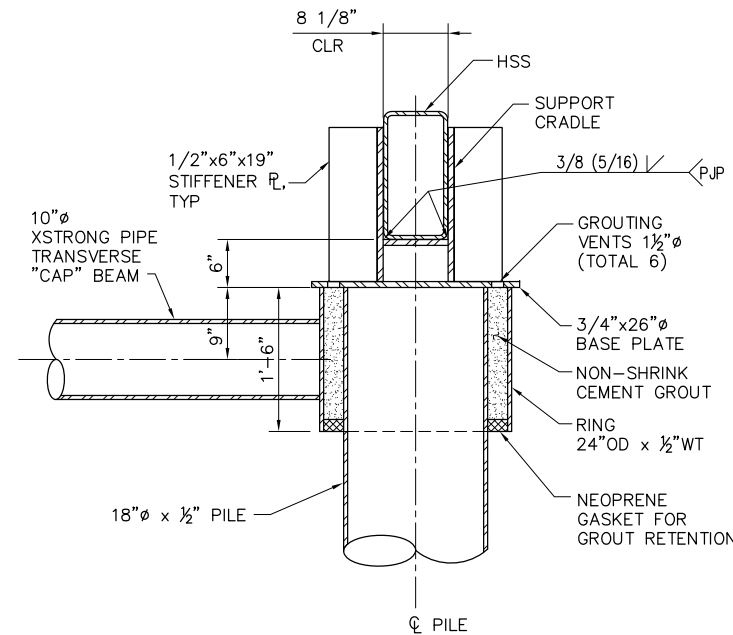


3 **DETAIL**
C65 SCALE: 1" = 1'-0"

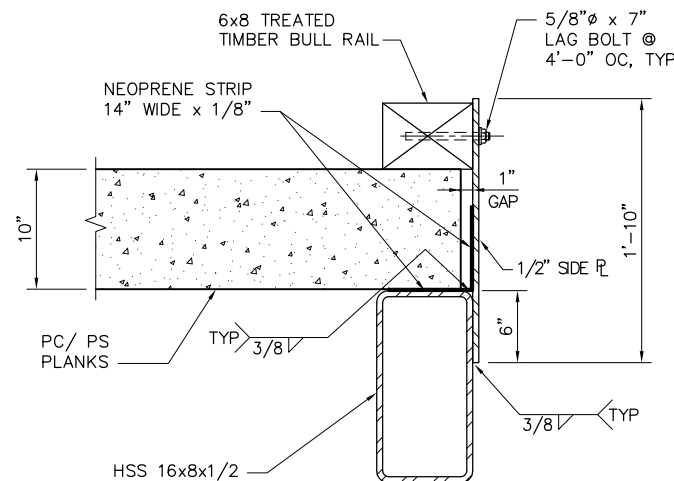


C **SECTION**
C65 SCALE: 1 1/2" = 1'-0"

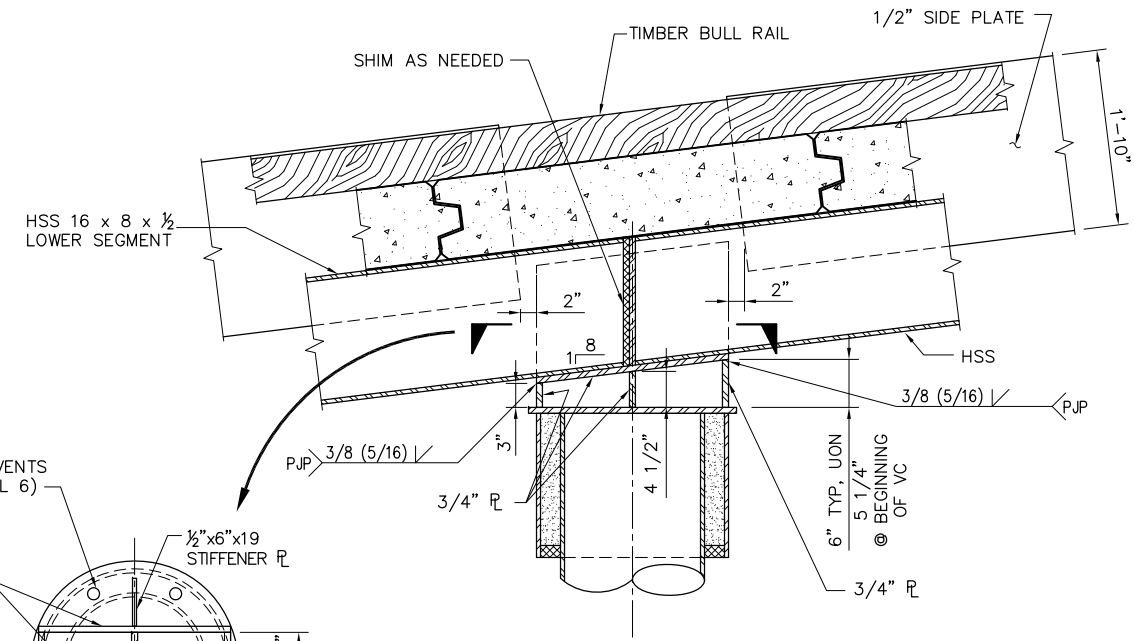


D **SECTION**
C65 SCALE: 1" = 1'-0"

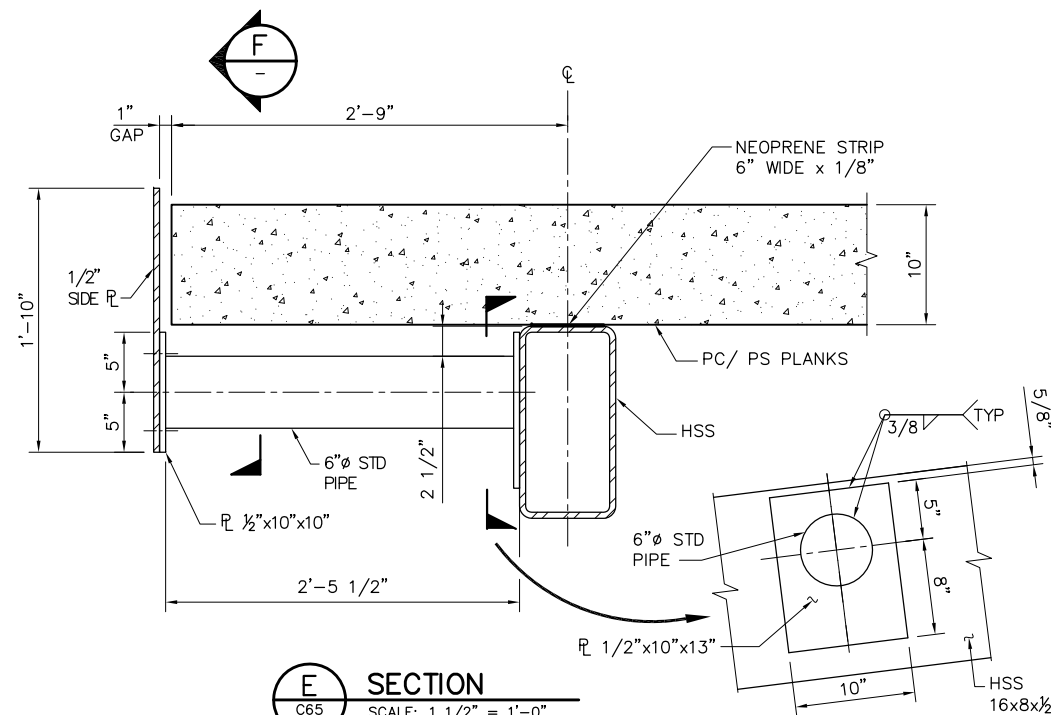

E **SECTION**
C65 SCALE: 1 1/2" = 1'-0"

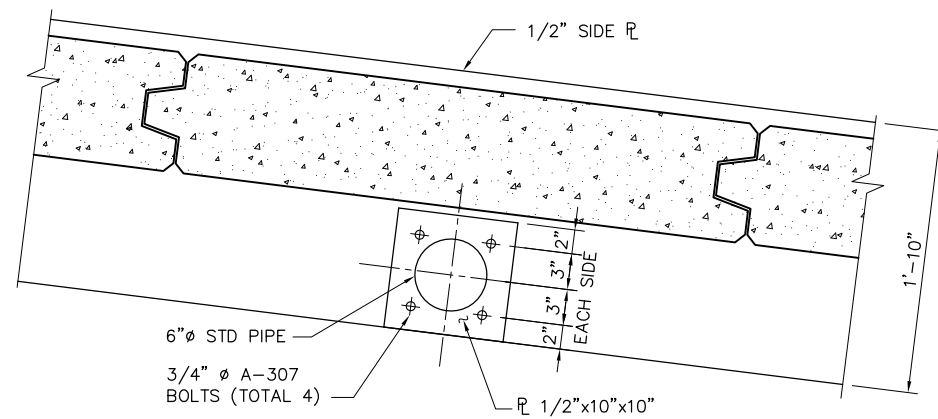

F **SECTION**
SCALE: 1 1/2" = 1'-0"

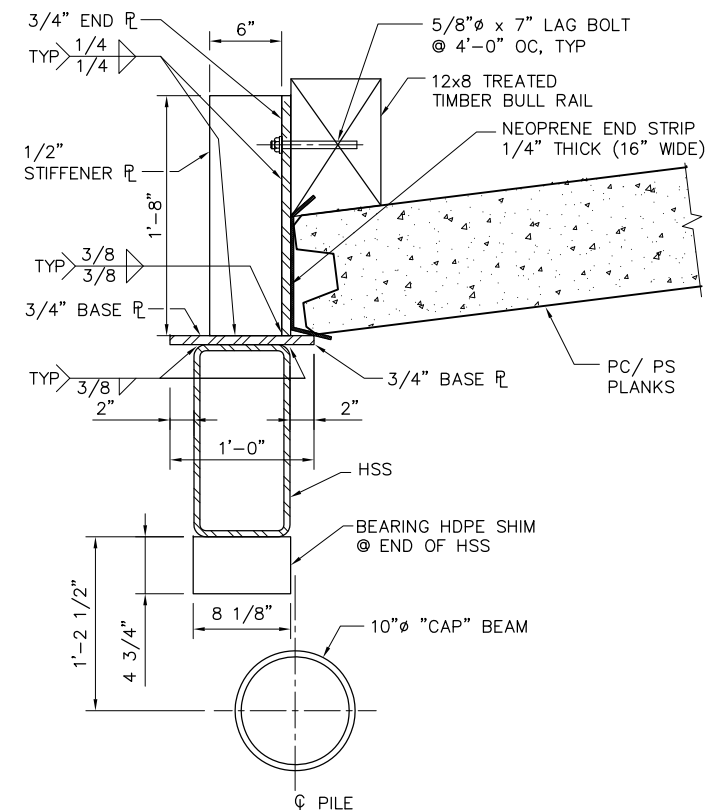

J **SECTION**
65 SCALE: 1 1/2" = 1'-0"


NOTE:
NEOPRENE STRIPS SHALL BE
PREGLUED TO CONCRETE PLANKS.

1'-0" 0'-0" 1'-0" 2'-0"
SCALE: 1"=1'-0"

1'-0" 0'-0" 6" 1'-0"
SCALE: 1 1/2"=1'-0"

**100% SUBMITTAL
REVISION 1** IF SHEET IS LESS THAN 22" x 34"
IT IS A REDUCED PRINT -
SCALE REDUCED ACCORDINGLY.

REVISION	DESCRIPTION	BY	DATE

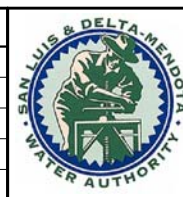

San Luis & Delta-Mendota Water Authority
842 6th Street, Suite 7
PO Box 2157
Los Banos, California 93635



2001 N. Main Street, Suite 360
Walnut Creek, California 94596
(925) 944-5411

DSGN	JMB	DR	AB	CHK	TDB
JOB NO.	6097-03	SUBMITTED BY	RMR		

2-GATES FISH PROTECTION
DEMONSTRATION PROJECT

 


DATE 10/02/09

SHEET 62 OF 78

BOAT RAMP DETAILS

C66

P:\6097-03 SWC GATE DESIGN\CADD\DWG\609703-C67.DWG 9/1/2009 10:38 AM

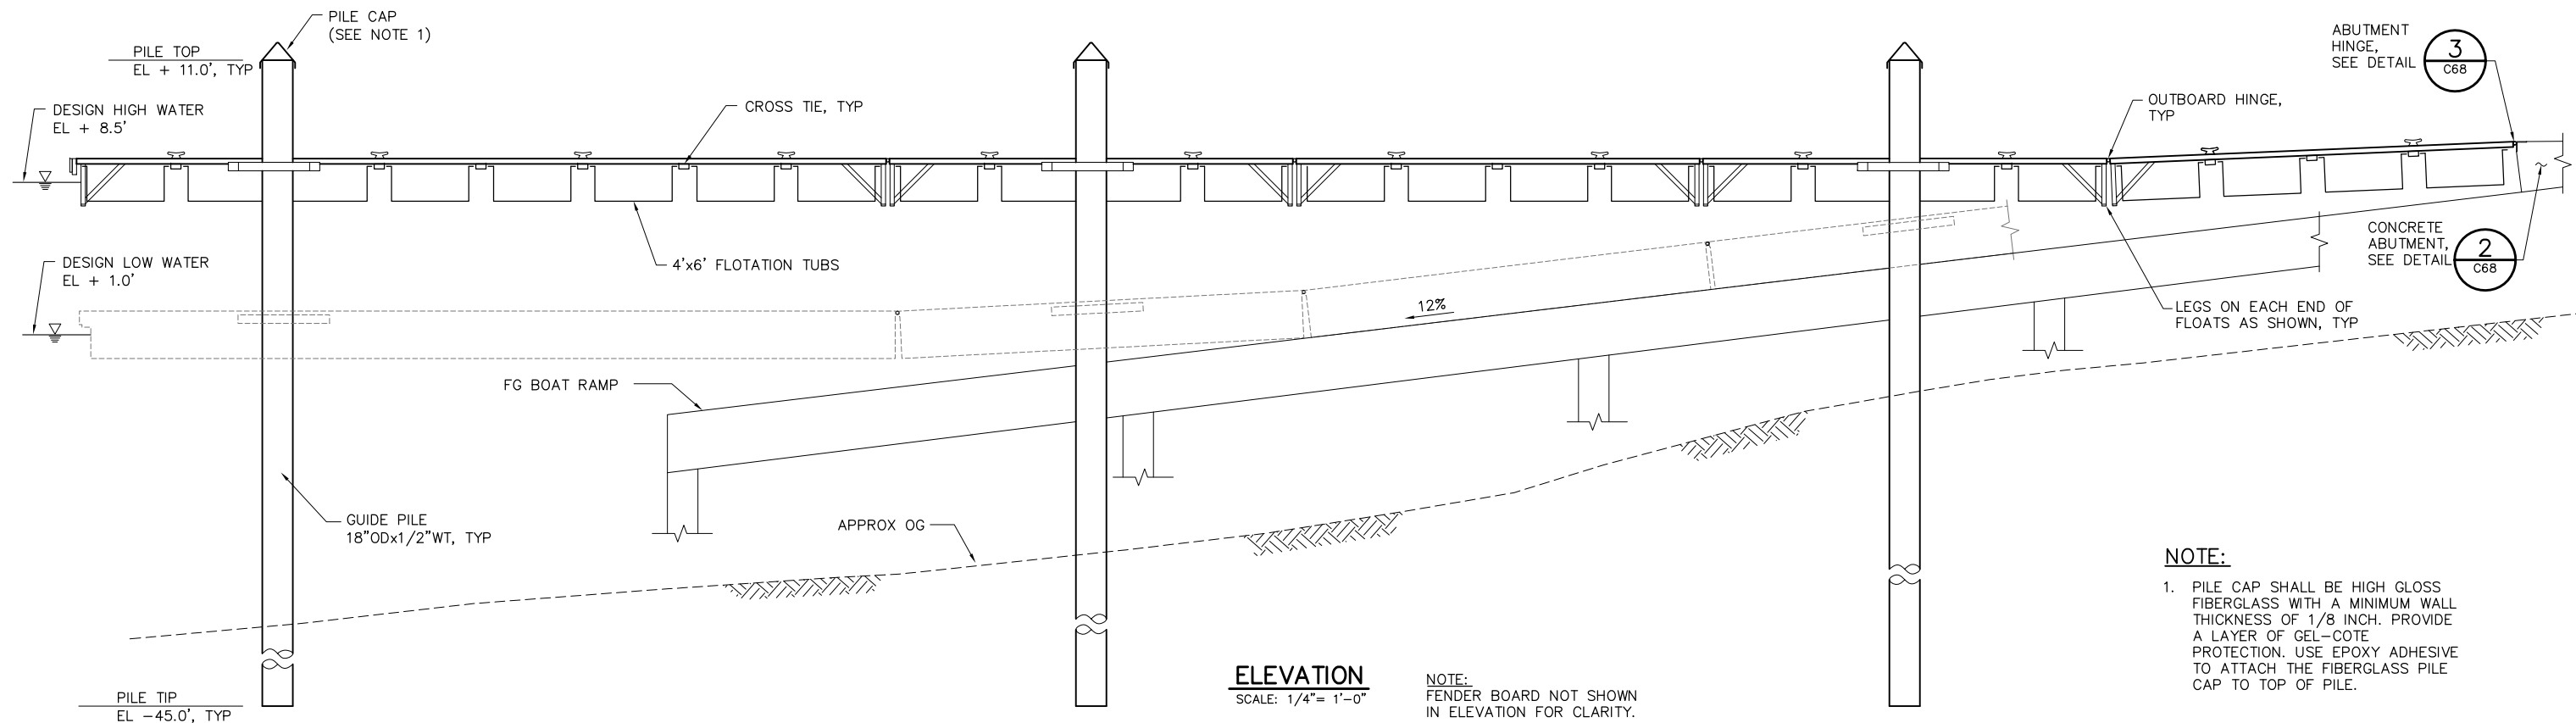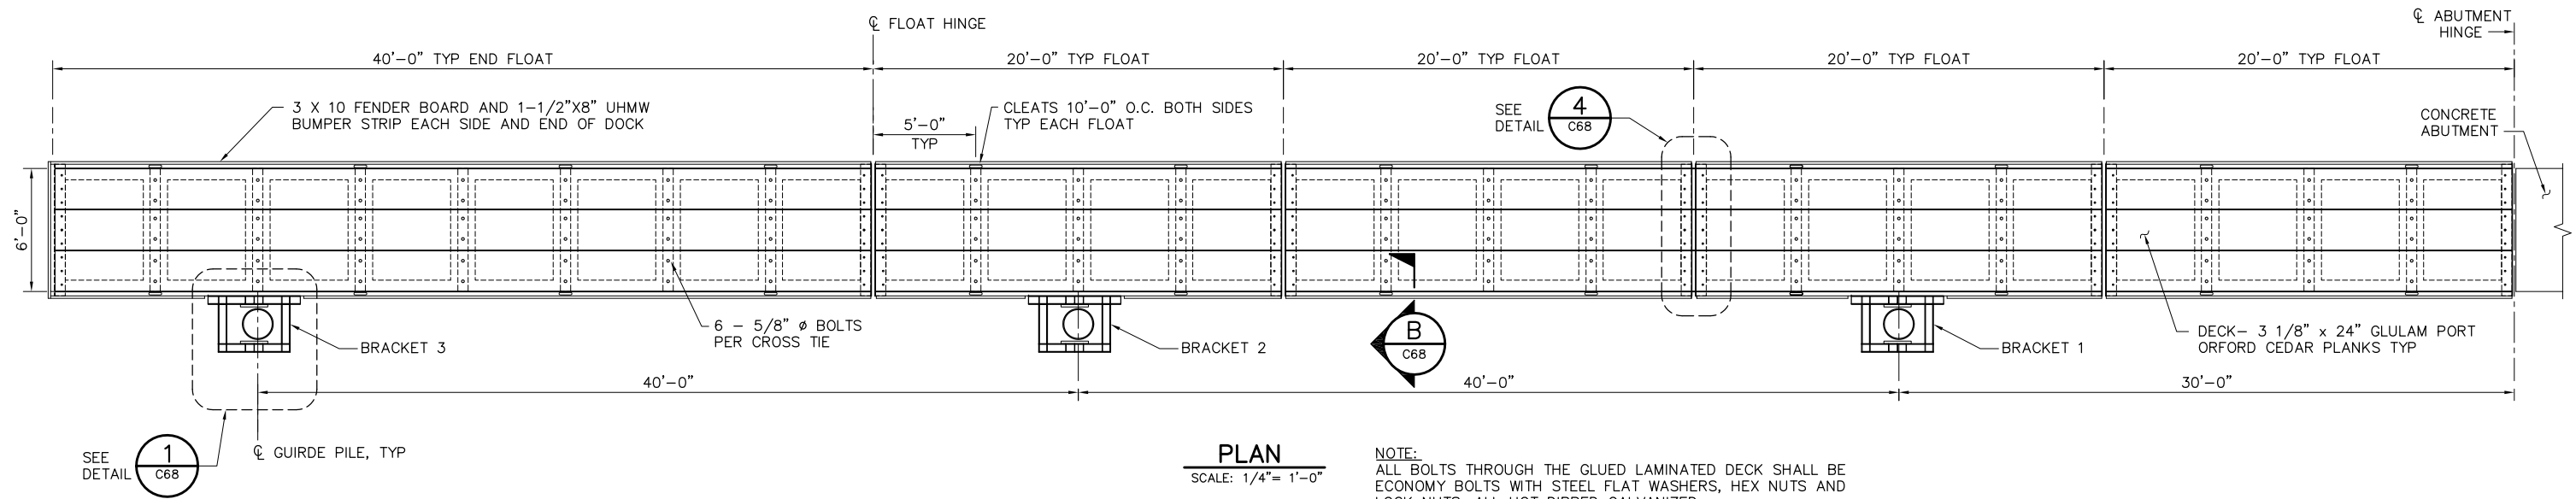

100% SUBMITTAL
REVISION 1

IF SHEET IS LESS THAN 22" x 34"
IT IS A REDUCED PRINT -
SCALE REDUCED ACCORDINGLY.

REVISION	DESCRIPTION	BY	DATE



San Luis & Delta-Mendota Water Authority
842 6th Street, Suite 7
PO Box 2157
Los Banos, California 93635



2001 N. Main Street, Suite 360
Walnut Creek, California 94596
(925) 944-5411

DSGN	JMB	DR	AB	CHK	TDB
JOB NO.	6097-03	SUBMITTED BY	RMR		




2-GATES FISH PROTECTION
DEMONSTRATION PROJECT

DATE 10/02/09

SHEET 63 OF 78





BOARDING FLOAT
PLAN AND ELEVATION

C67

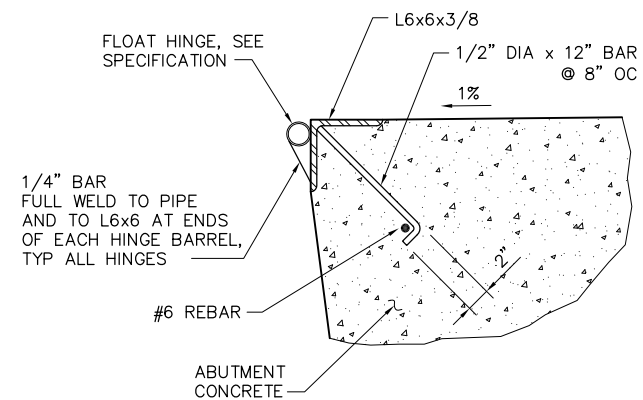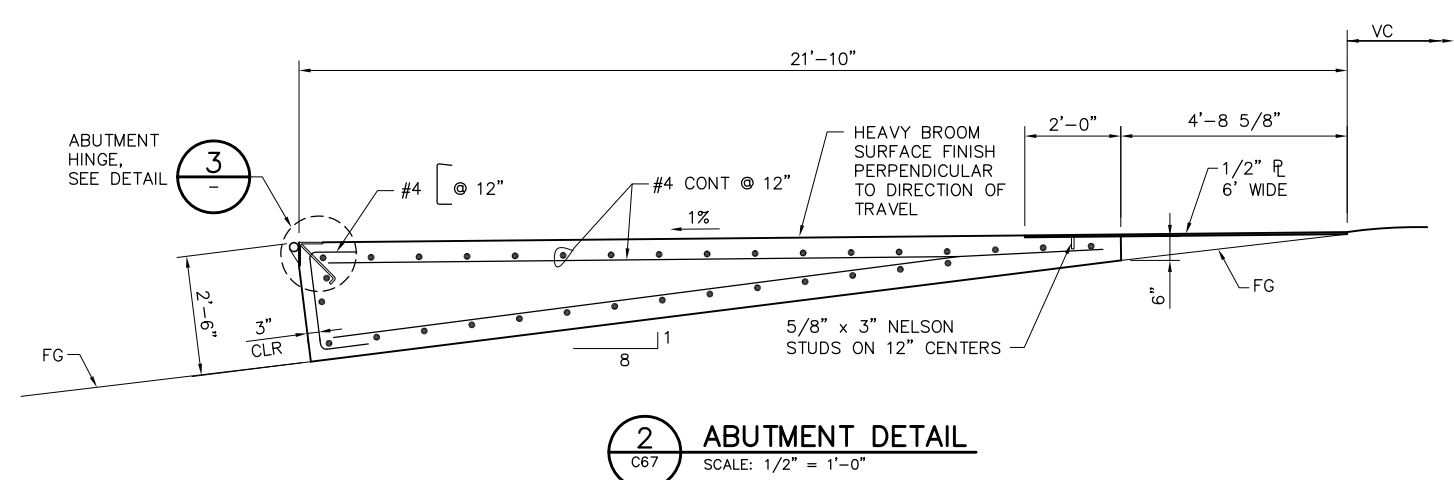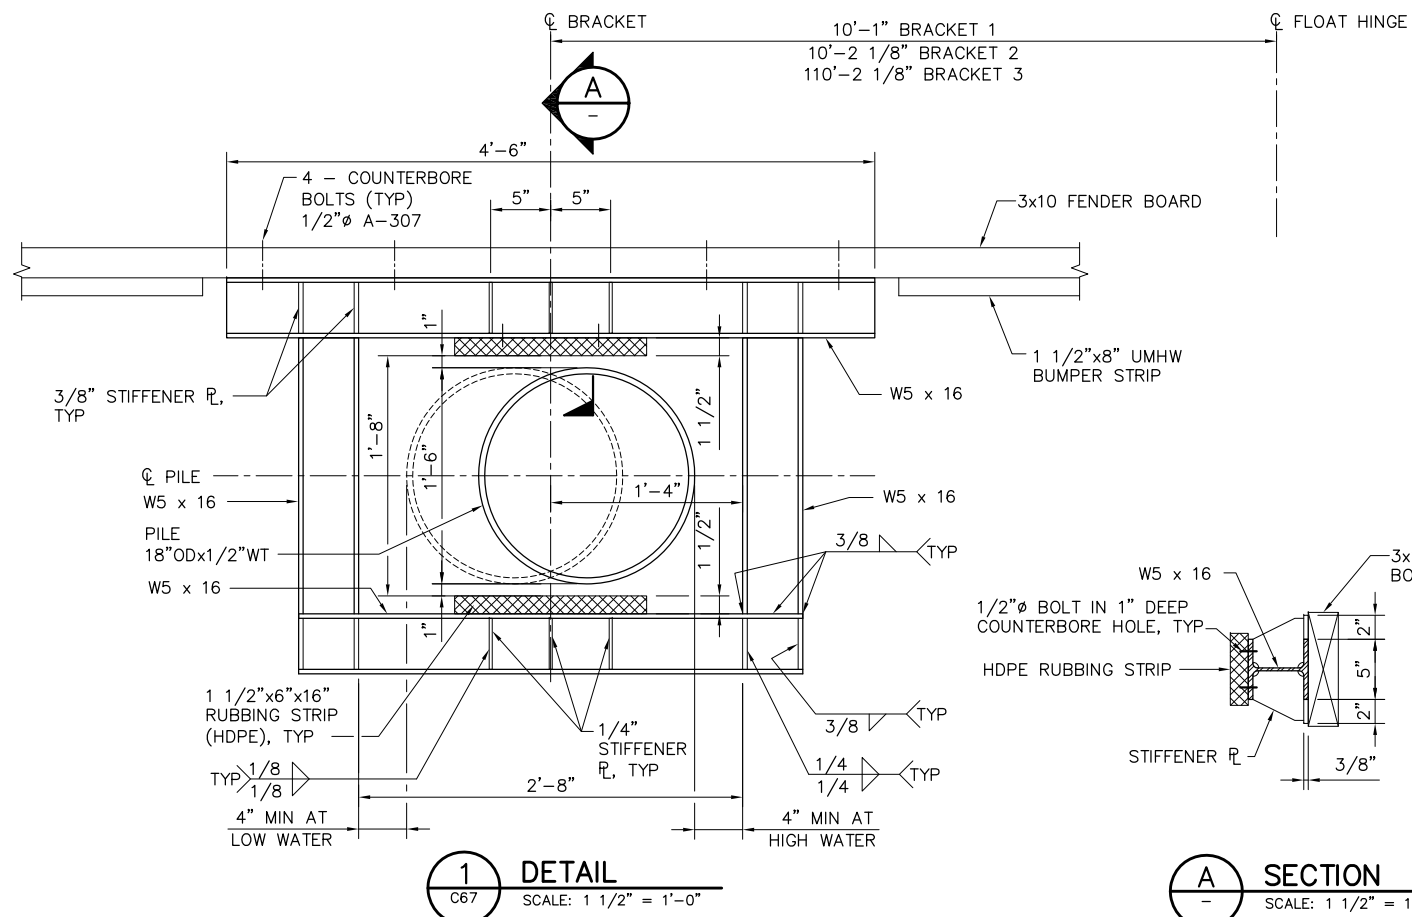

- NOTES:

1. FACE OF ABUTMENT IS PERPENDICULAR TO RAMP SURFACE.
2. GALVANIZE HINGE ASSEMBLY AFTER FABRICATION.
3. ALL WELDS TO BE MADE WITH HINGE PIN IN PLACE TO ENSURE PROPER FIT.
4. FLOAT HINGE - 1" DIA STAINLESS STEEL ROD W/COTTER KEYS @ ENDS & IGLIDE FLANGE BEARINGS #JFI-1620 (10 REQUIRED) BY IGUS IND.(PROVIDE 100% SPARES)

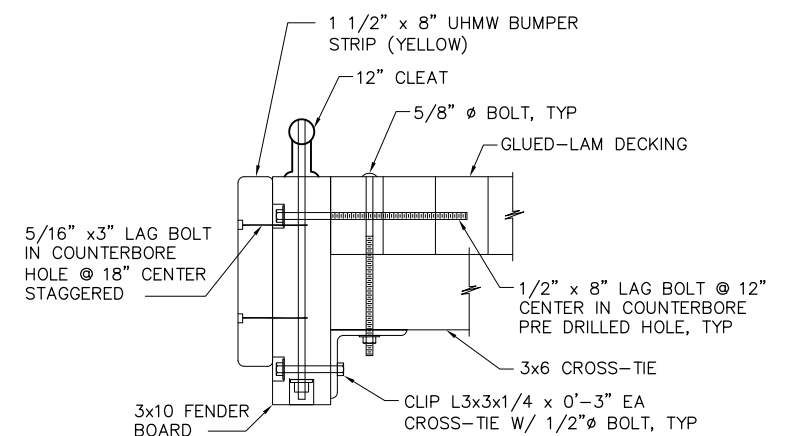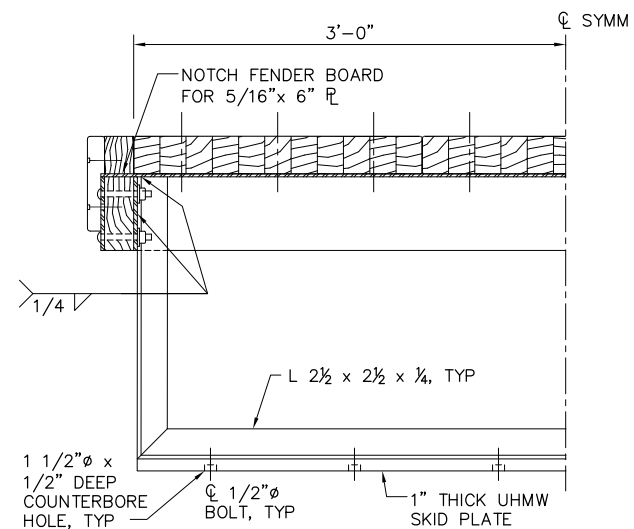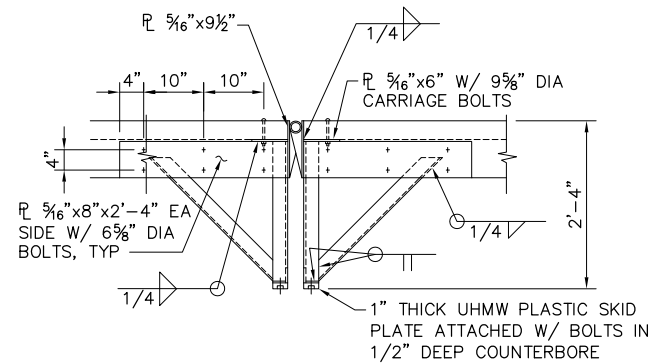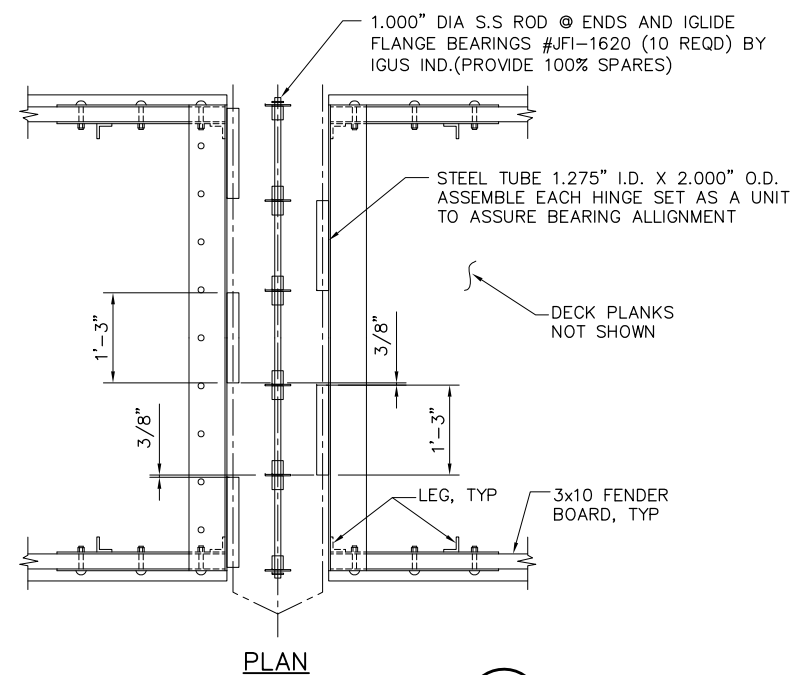

100% SUBMITTAL
REVISION 1

IF SHEET IS LESS THAN 22" x 34"
IT IS A REDUCED PRINT –
SCALE REDUCED ACCORDINGLY.

REVISION	DESCRIPTION	BY	DATE



San Luis & Delta-Mendota Water Authority
842 6th Street, Suite 7
PO Box 2157
Los Banos, California 93635



2001 N. Main Street, Suite 360
Walnut Creek, California 94596
(925) 944-5411

DSGN JMB	DR AB	CHK TDB
JOB NO. 6097-03	SUBMITTED BY RMR	

2-GATES FISH PROTECTION
DEMONSTRATION PROJECT








BOARDING FLOAT DETAILS

DATE 10/02/09

SHEET 64 OF 78

C68

P:\6097-03 SWC GATE DESIGN\CADD\DWG\609703-C69.DWG 9/1/2009 10:39 AM

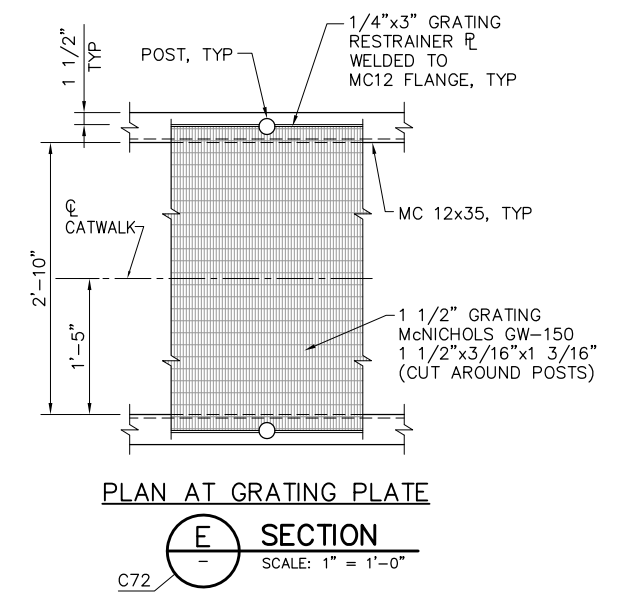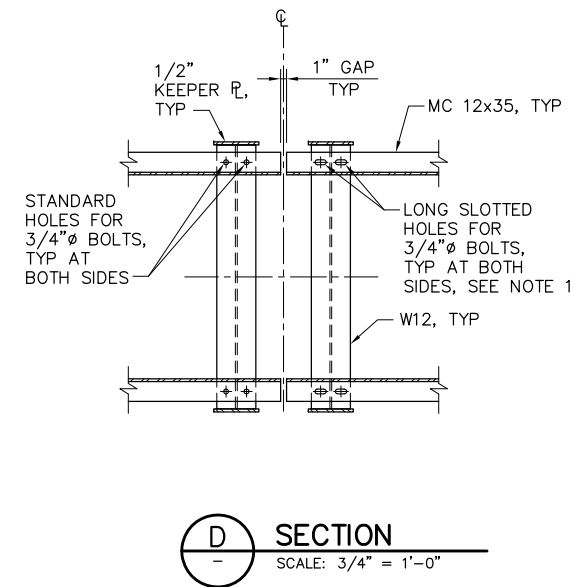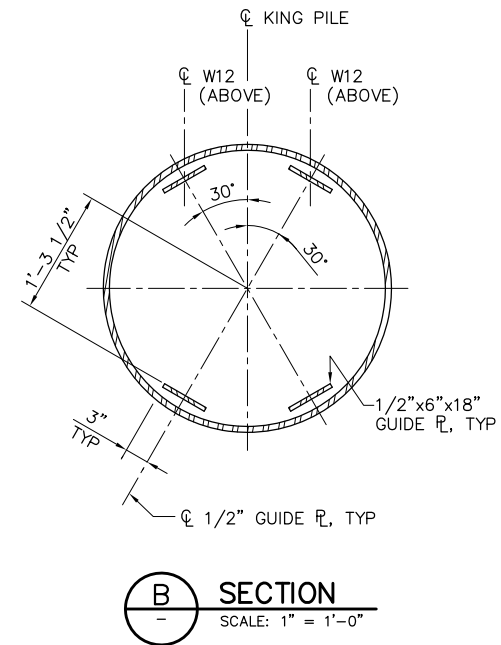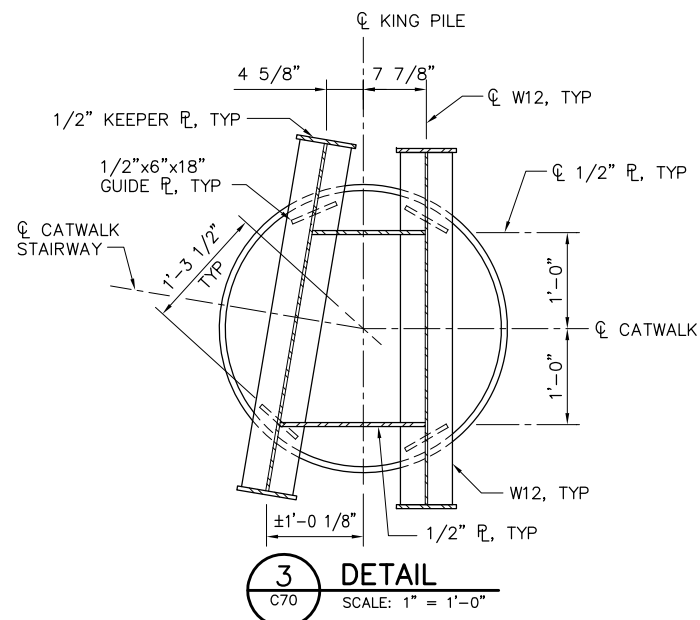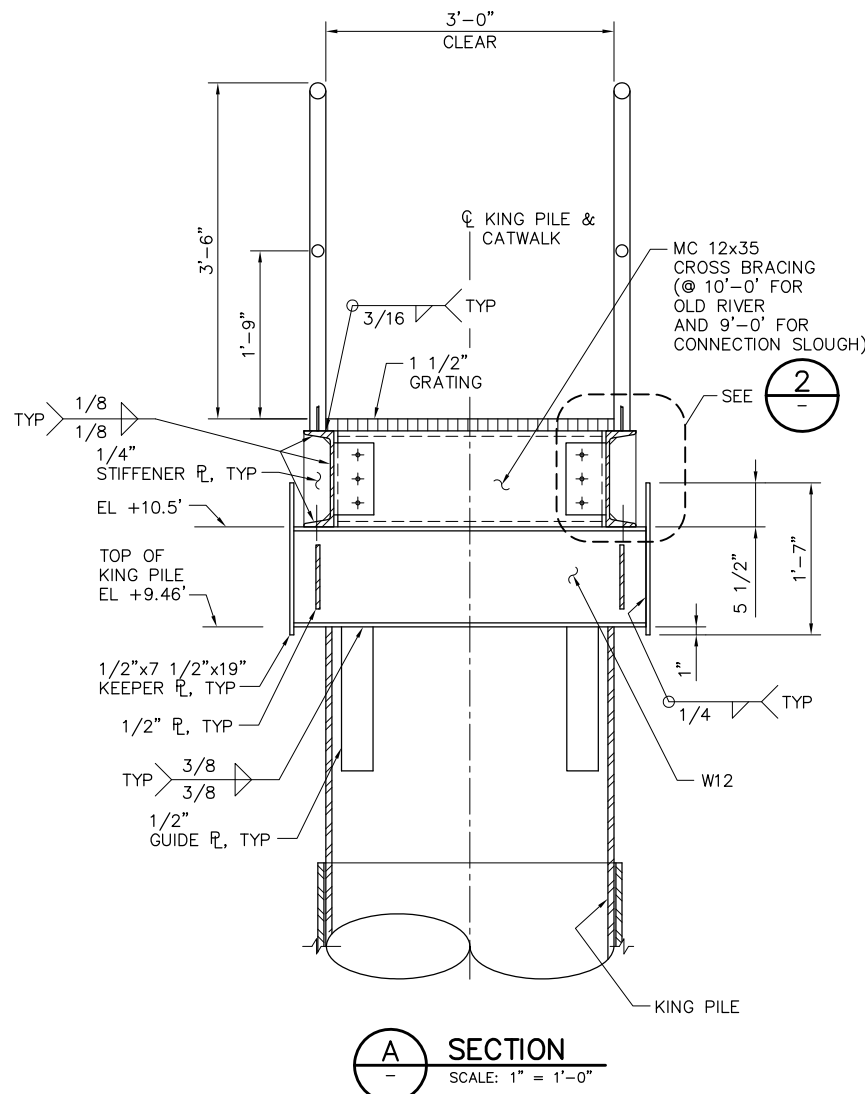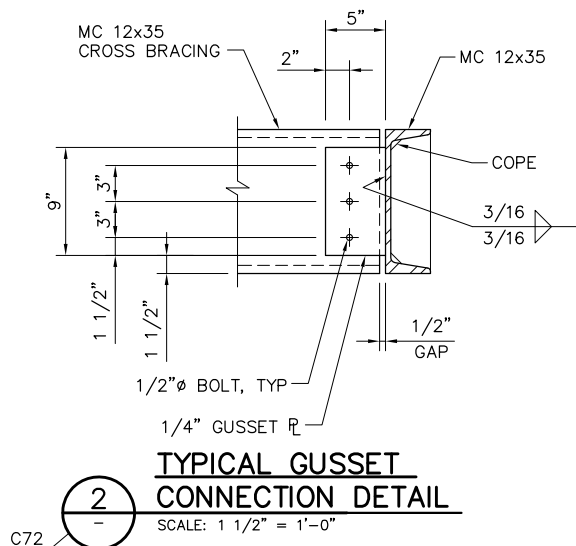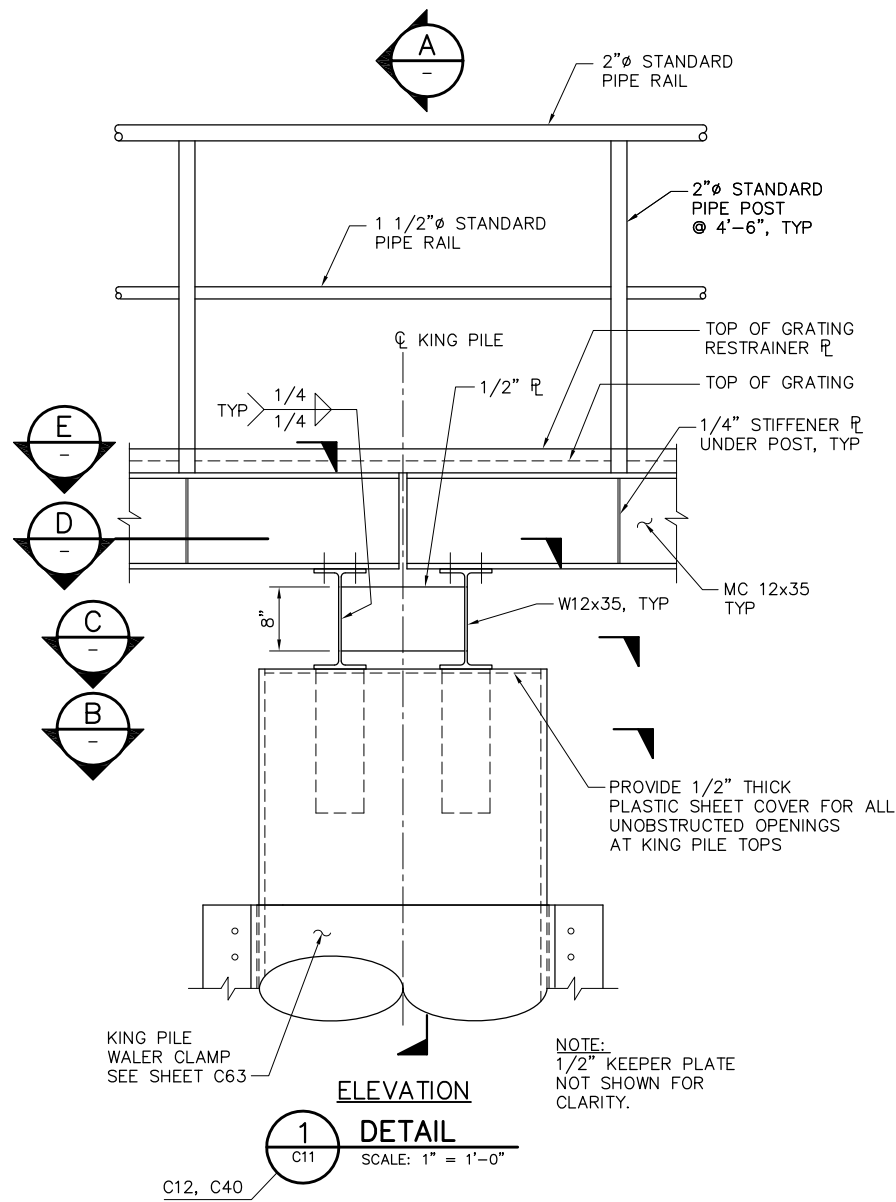


- NOTES:**
1. PROVIDE 1/16" THICK SLIDE PAD (HDPE OR EQUIVALENT) AT EXPANSION SUPPORTS WHERE LONG SLOTTED HOLES PERMIT EXPANSION.
 2. FOR ADDITIONAL WELD INFORMATION SEE DWGS C70 AND C71.

2'-0" 0'-0" 1'-0" 2'-0"
SCALE: 3/4"=1'-0"

100% SUBMITTAL REVISION 1

IF SHEET IS LESS THAN 22" x 34" IT IS A REDUCED PRINT - SCALE REDUCED ACCORDINGLY.

REVISION	DESCRIPTION	BY	DATE

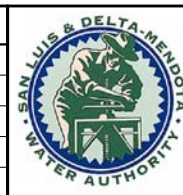

San Luis & Delta-Mendota Water Authority
842 6th Street, Suite 7
PO Box 2157
Los Banos, California 93635



2001 N. Main Street, Suite 360
Walnut Creek, California 94596
(925) 944-5411

DSGN	JMB	DR	EP/AB	CHK	TDB
JOB NO.	6097-03	SUBMITTED BY	RMR		

2-GATES FISH PROTECTION
DEMONSTRATION PROJECT


DATE 10/02/09

SHEET 65 OF 78


CATWALK DETAILS
SHEET 1

C69


P:\6097-03 SWC GATE DESIGN\CADD\DWG\609703-C70.DWG 9/1/2009 10:40 AM

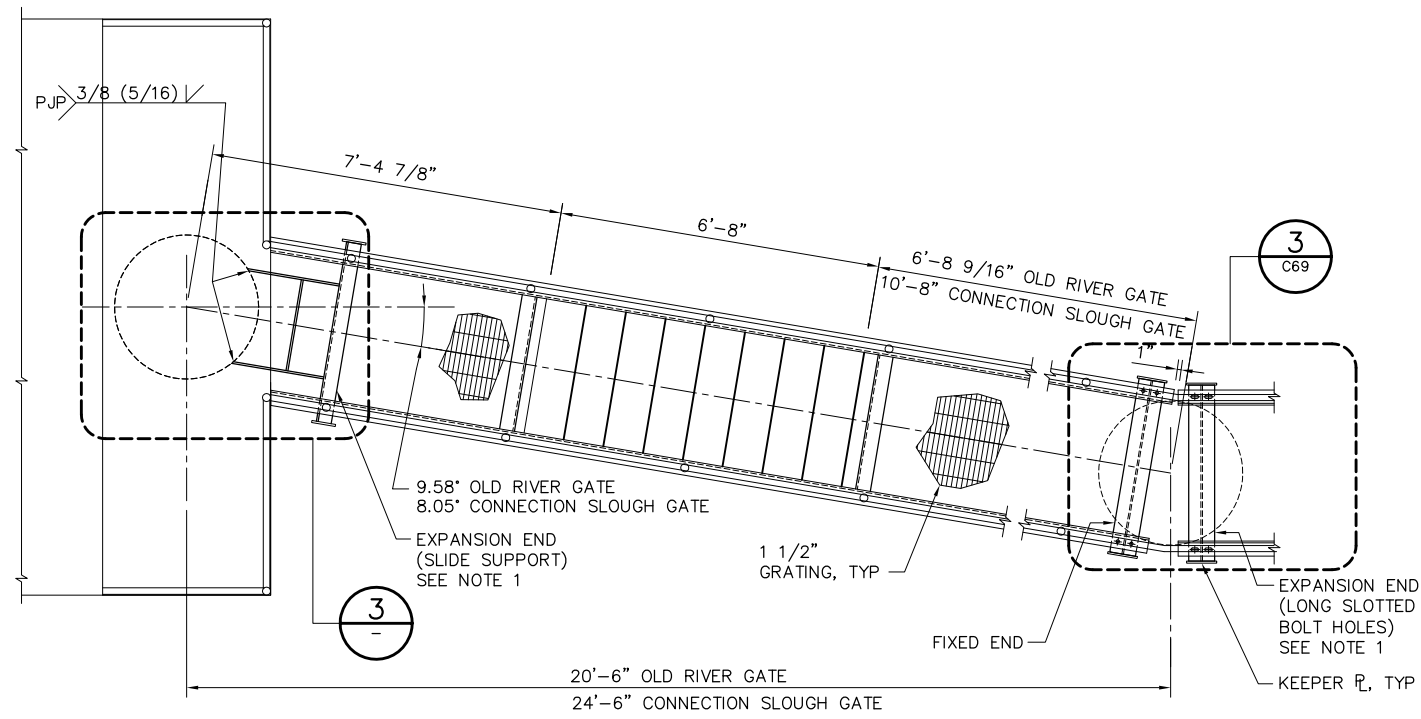


PLAN
1 DETAIL
C12 SCALE: 1/2" = 1'-0"

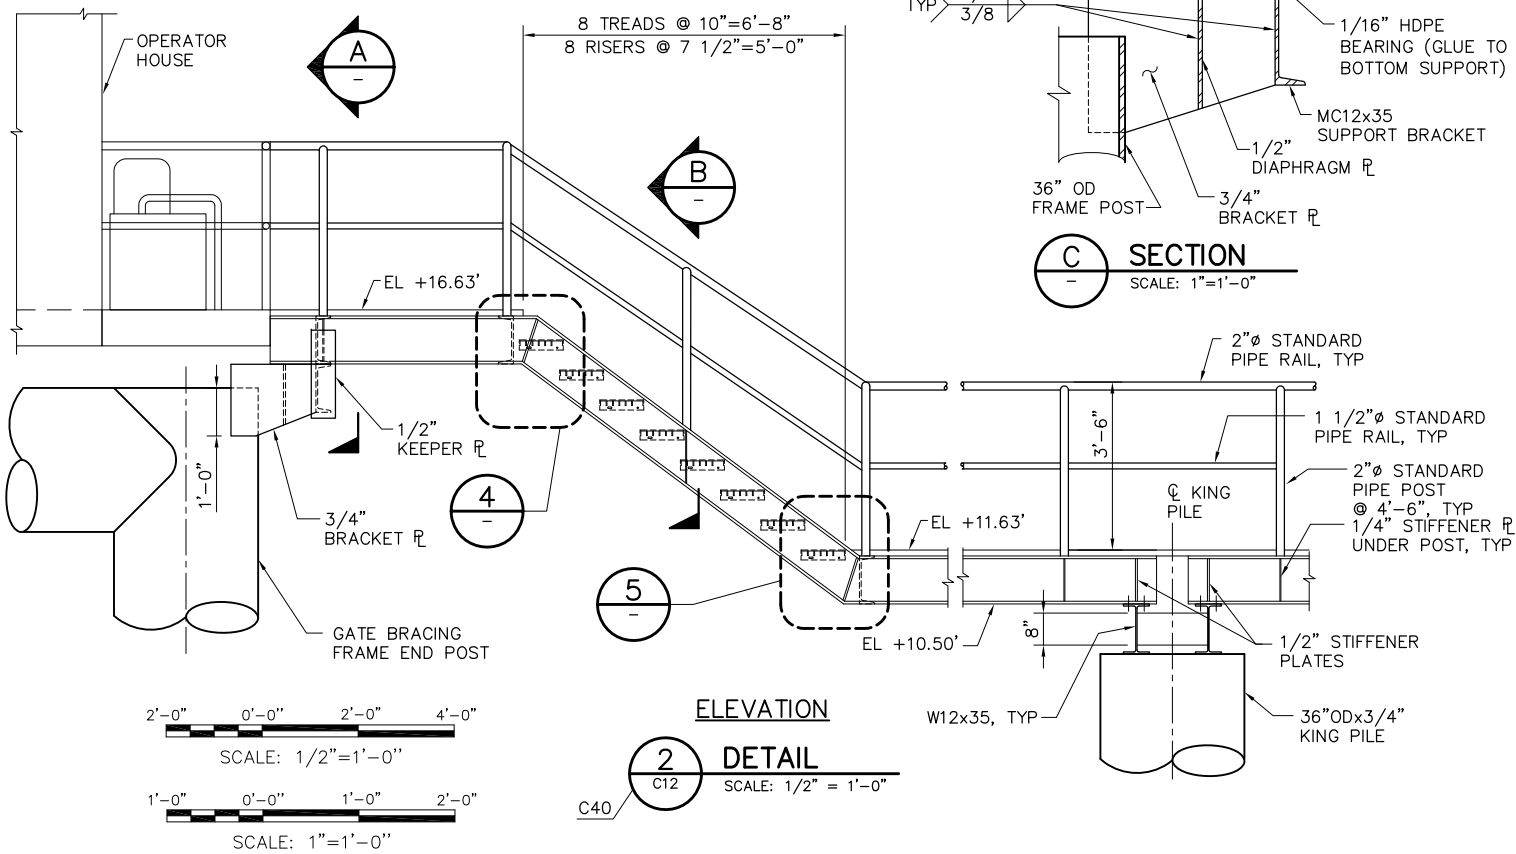


ELEVATION
2 DETAIL
C12 SCALE: 1/2" = 1'-0"

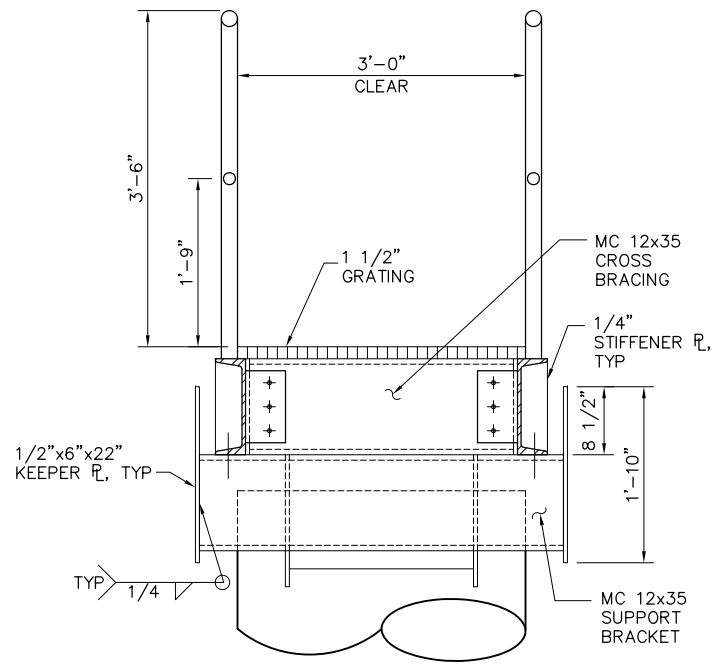


SECTION
A SCALE: 1" = 1'-0"

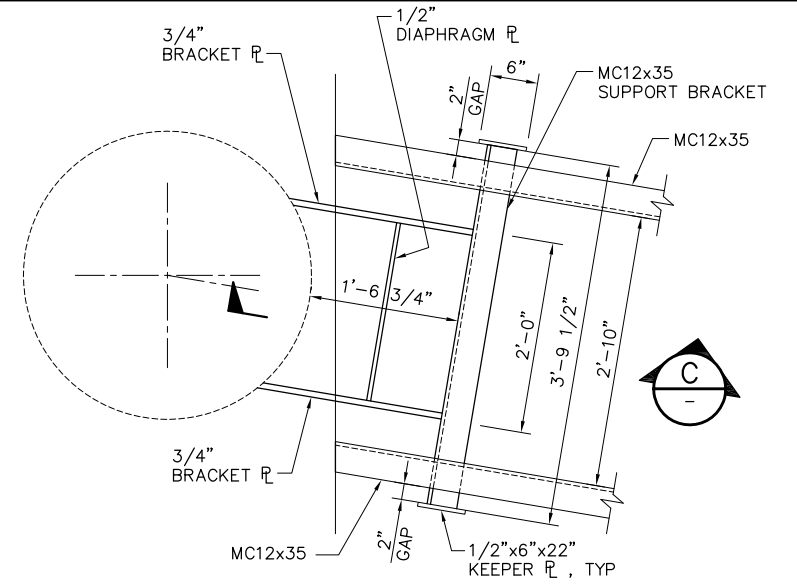

SECTION
C SCALE: 1" = 1'-0"

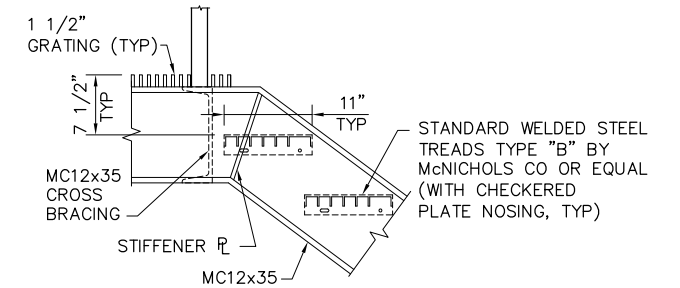

SECTION
B SCALE: 1" = 1'-0"

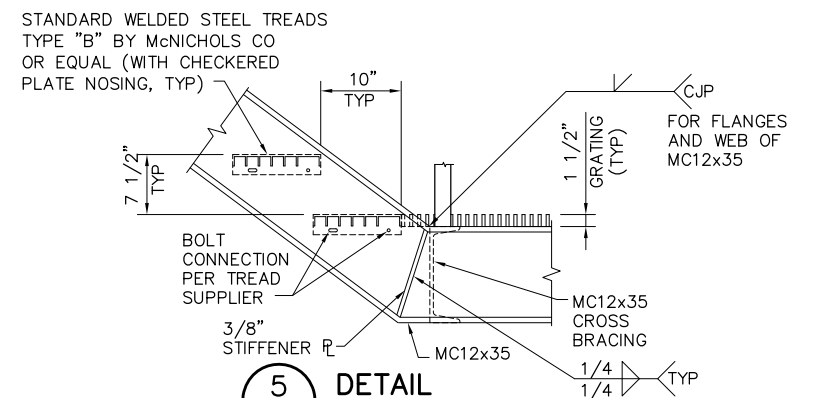

SECTION
D SCALE: 1" = 1'-0"

NOTES:

1. PROVIDE 1/16" THICK HDPE SLIDE/BEARING PLATE AT EXPANSION ENDS AT UNDERSIDE OF MC12x35.
2. FOR ADDITIONAL WELD INFORMATION SEE DWGS C69 AND C71.

100% SUBMITTAL
REVISION 1

IF SHEET IS LESS THAN 22" x 34"
IT IS A REDUCED PRINT -
SCALE REDUCED ACCORDINGLY.

REVISION	DESCRIPTION	BY	DATE



San Luis & Delta-Mendota Water Authority
842 6th Street, Suite 7
PO Box 2157
Los Banos, California 93635



2001 N. Main Street, Suite 360
Walnut Creek, California 94596
(925) 944-5411

DSGN	JMB	DR	AB/EP	CHK	TDB
JOB NO.	6097-03	SUBMITTED BY	RMR		

2-GATES FISH PROTECTION
DEMONSTRATION PROJECT


DATE 10/02/09

SHEET 66 OF 78

CATWALK DETAILS
SHEET 2


C70

P:\6097-03 SWC GATE DESIGN\CADD\DWG\609703-C72.DWG 9/30/2009 4:30 PM

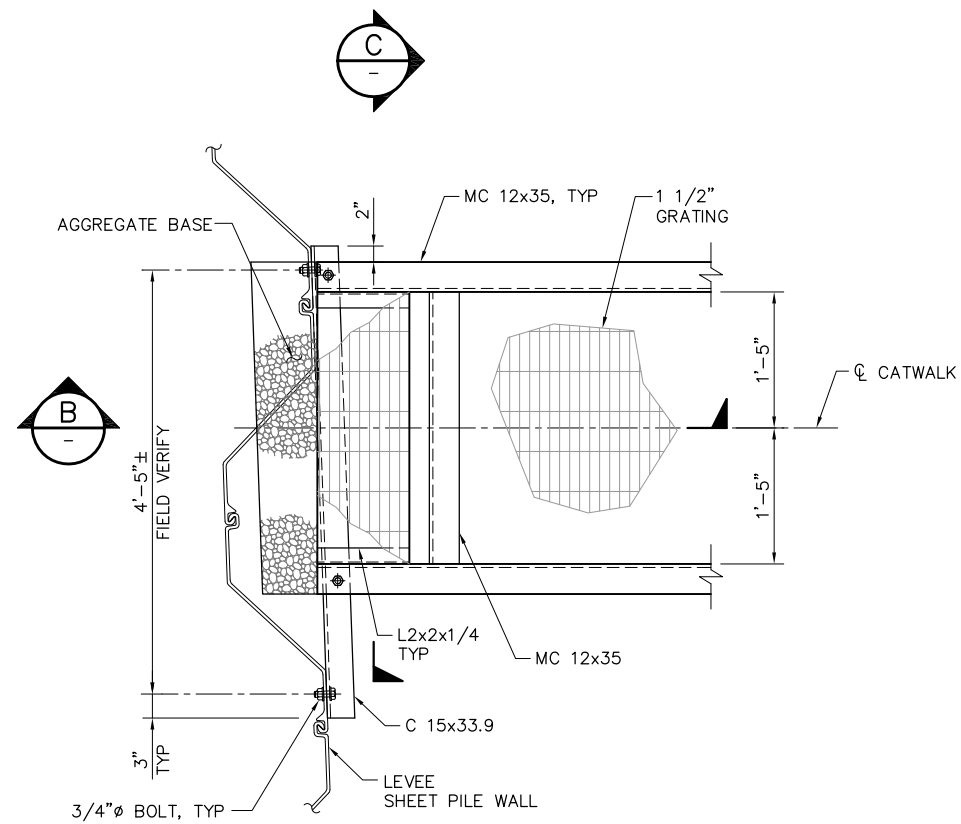


PLAN AT END OF CATWALK


1 **DETAIL**
C11 SCALE: 1" = 1'-0"
C40

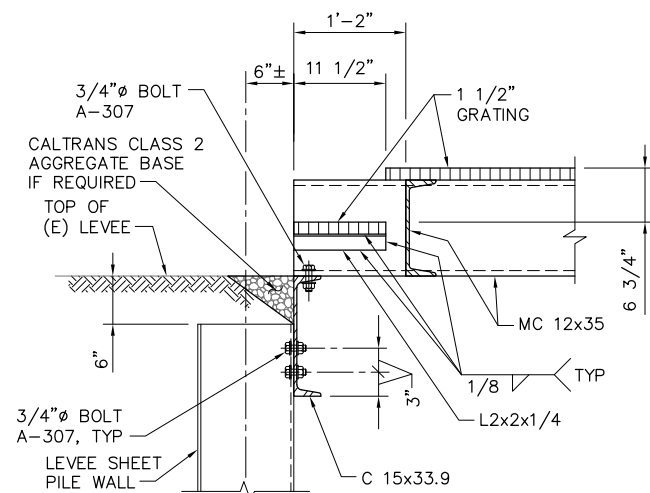

B **SECTION**
SCALE: 1" = 1'-0"

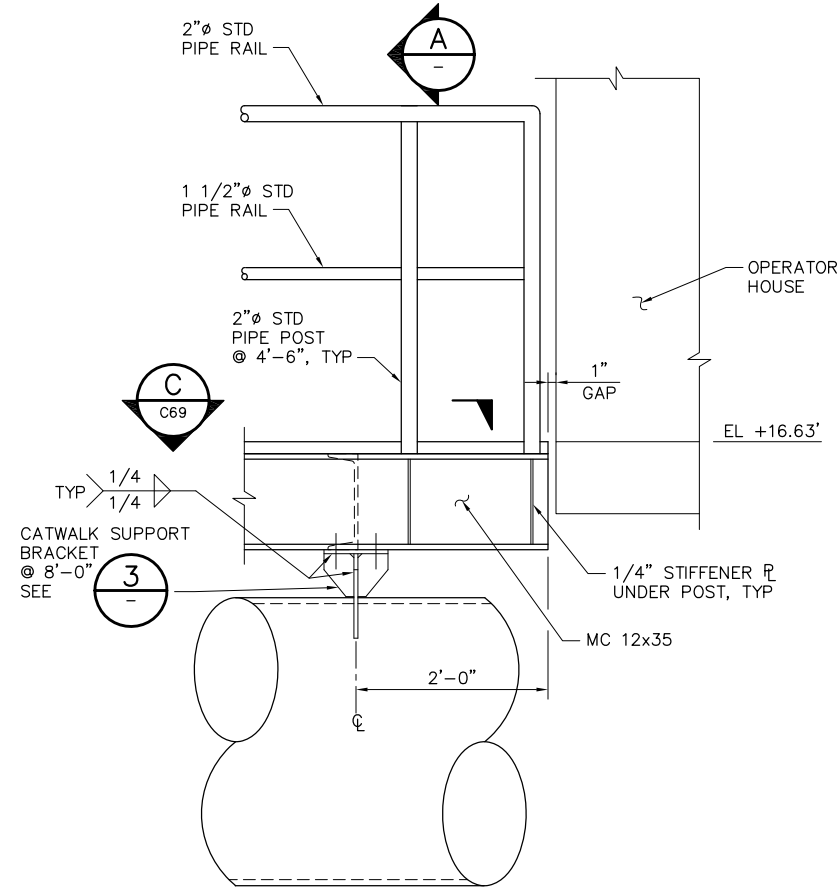

2 **DETAIL**
C15 SCALE: 1"=1'-0"
C43

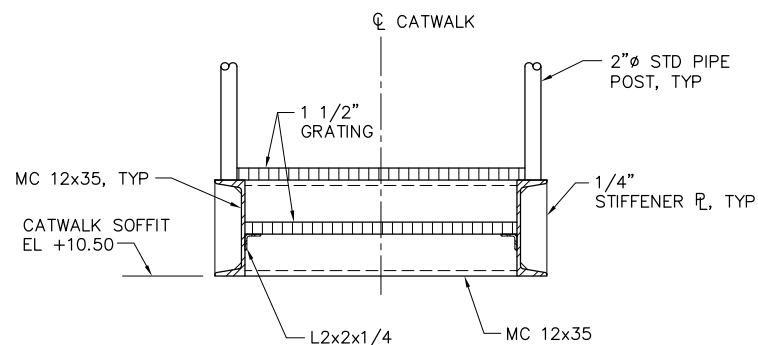


C **SECTION**
SCALE: 1" = 1'-0"


NOTE:

FOR ADDITIONAL WELD INFORMATION SEE DWGS C69, C70 AND C71.

1'-0" 0'-0" 1'-0" 2'-0"
SCALE: 1"=1'-0"

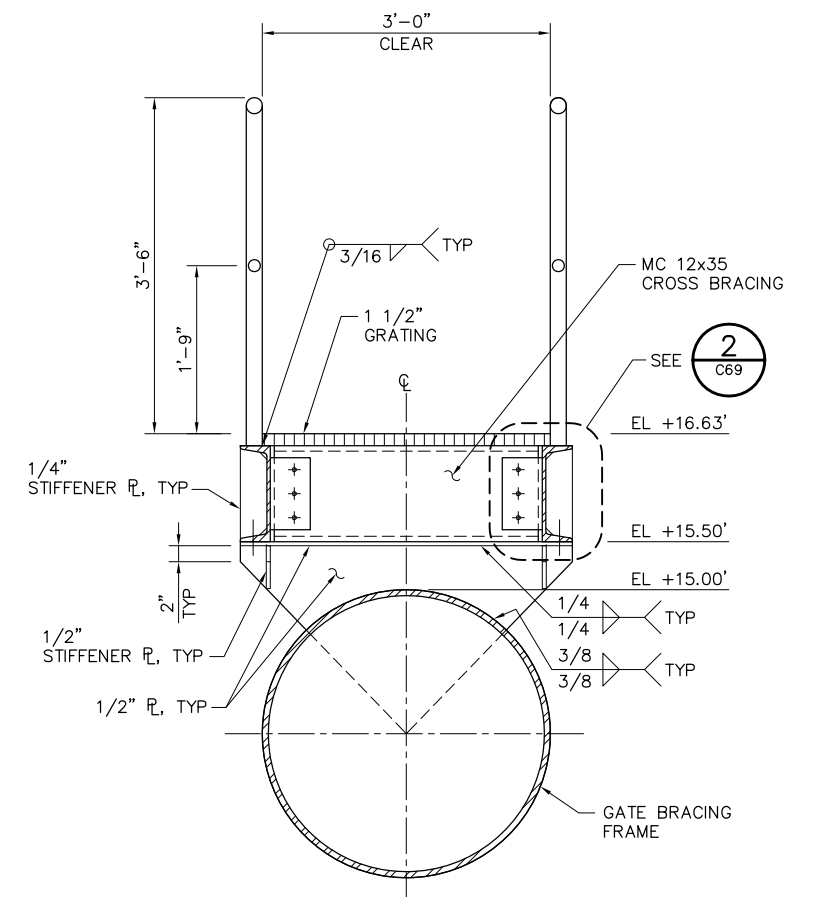

A **SECTION**
SCALE: 1"=1'-0"

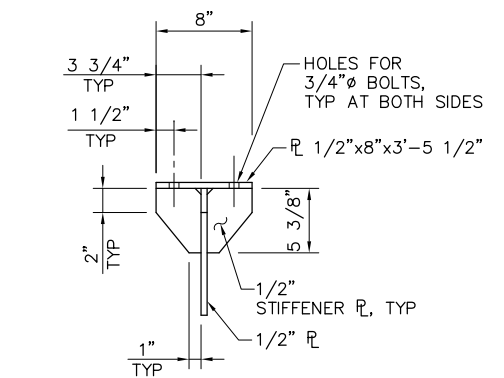


3 **DETAIL**
SCALE: 1"=1'-0"
C73

**100% SUBMITTAL
REVISION 1**

IF SHEET IS LESS THAN 22" x 34"
IT IS A REDUCED PRINT -
SCALE REDUCED ACCORDINGLY.

REVISION	DESCRIPTION	BY	DATE

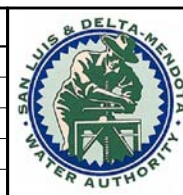


San Luis & Delta-Mendota Water Authority
842 6th Street, Suite 7
PO Box 2157
Los Banos, California 93635

		2001 N. Main Street, Suite 360 Walnut Creek, California 94596 (925) 944-5411	
DSGN	JMB	DR	EP
JOB NO.	6097-03	SUBMITTED BY	RMR

2-GATES FISH PROTECTION DEMONSTRATION PROJECT	DATE 10/02/09
	SHEET 68 OF 78
CATWALK DETAILS SHEET 4	
C72	



P:\6097-03 SWC GATE DESIGN\CADD\DWG\609703-C74.DWG 9/1/2009 10:41 AM

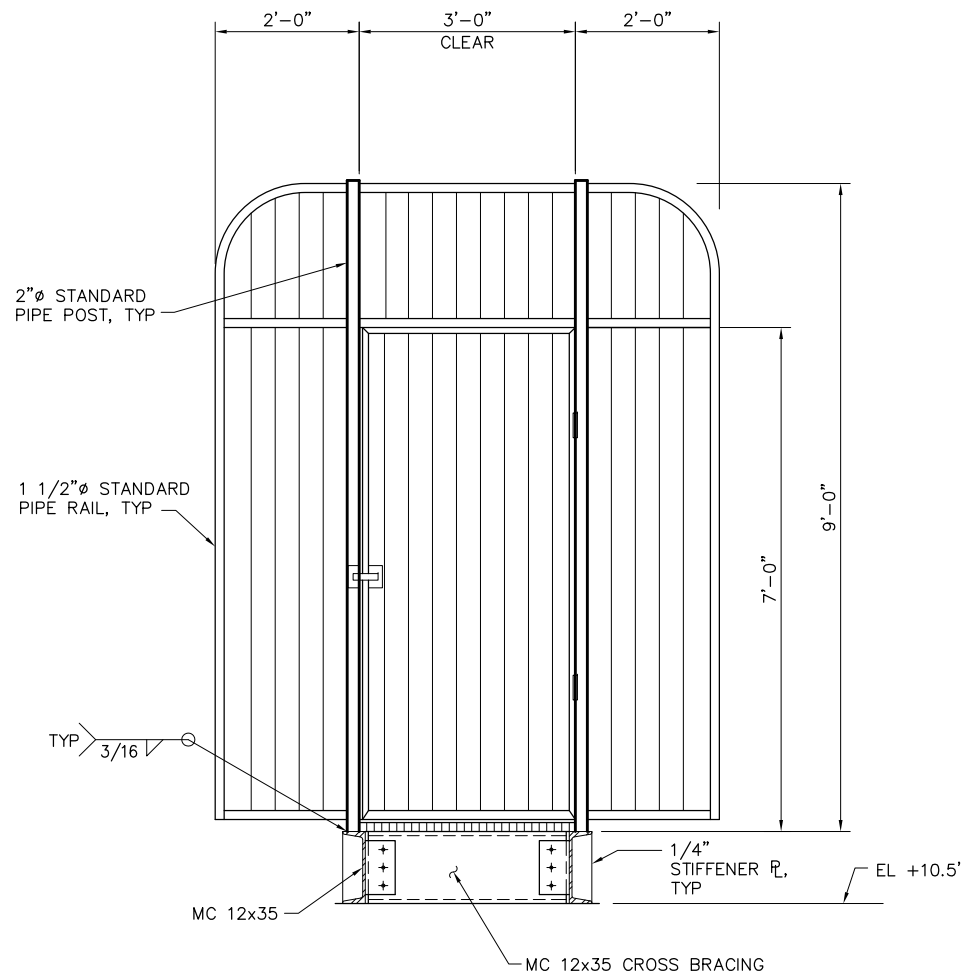


NOTE:
SECURITY GATE SHALL PROVIDE
A MINIMUM 36" CLEAR OPENING,
SHALL BE AUTOMATICALLY
CLOSING, AND SHALL INCLUDE
A LOCKABLE LATCH.

SECURITY GATE ELEVATION

1
C11
SCALE: 3/4" = 1'-0"

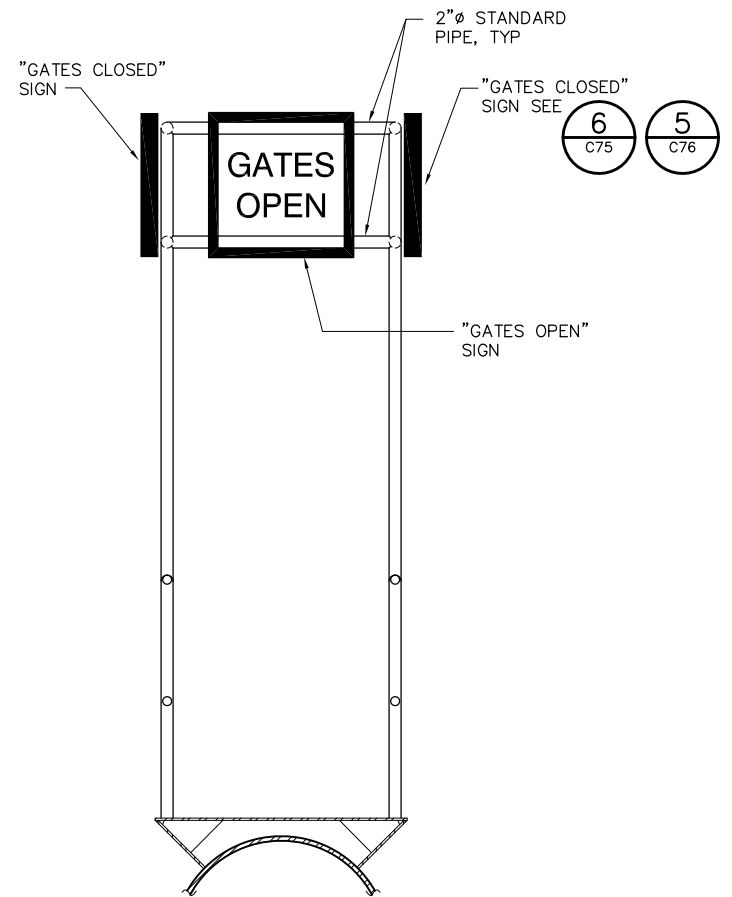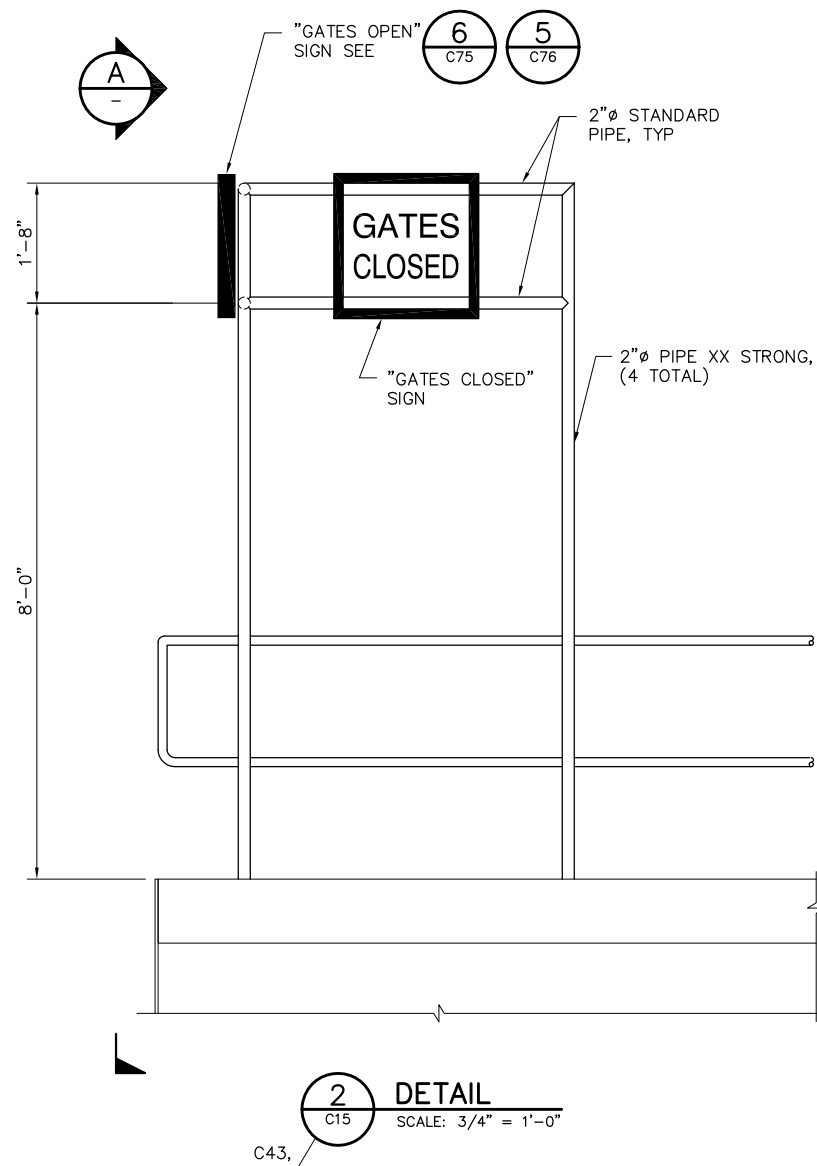

 NOTE:
FOR ADDITIONAL WELD INFORMATION
SEE DWGS C68 THROUGH C73.



100% SUBMITTAL
REVISION 1

IF SHEET IS LESS THAN 22" x 34"
IT IS A REDUCED PRINT -
SCALE REDUCED ACCORDINGLY.

REVISION	DESCRIPTION	BY	DATE



San Luis & Delta-Mendota Water Authority
842 6th Street, Suite 7
PO Box 2157
Los Banos, California 93635



2001 N. Main Street, Suite 360
Walnut Creek, California 94596
(925) 944-5411

DSGN	JMB	DR	AB	CHK	TDB
JOB NO.	6097-03	SUBMITTED BY	RMR		


2-GATES FISH PROTECTION
DEMONSTRATION PROJECT

DATE 10/02/09

SHEET 70 OF 78

CATWALK DETAILS
SHEET 6


C74

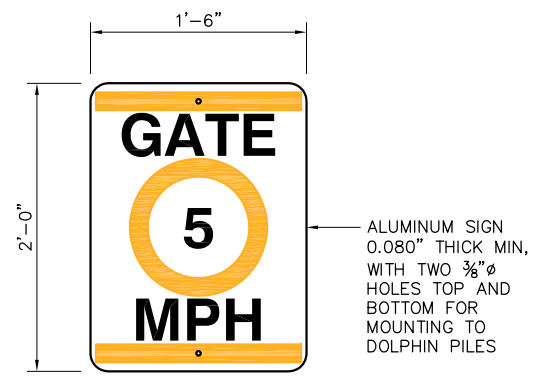

ALUMINUM SIGN
0.080" THICK MIN.
WITH TWO 3/8"Ø
HOLES TOP AND
BOTTOM FOR
MOUNTING TO
DOLPHIN PILES

SIGNBOARD ON PILE, ORANGE
ON WHITE WITH BLACK LETTERS


1 GATE 5 MPH SIGN
C26 SCALE: NONE
C54

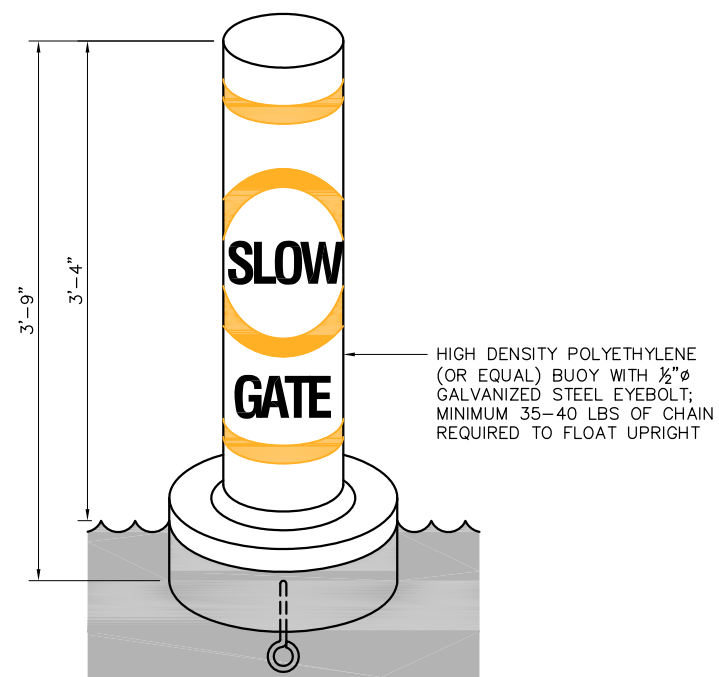

ORANGE ON WHITE WITH BLACK
LETTERS


NOTE:
45' OF 1/2" OPEN LINK CHAIN
WITH 25 LB DANFORTH
STANDARD ANCHOR.

2 SLOW GATE SIGN
C26 SCALE: NONE
C54

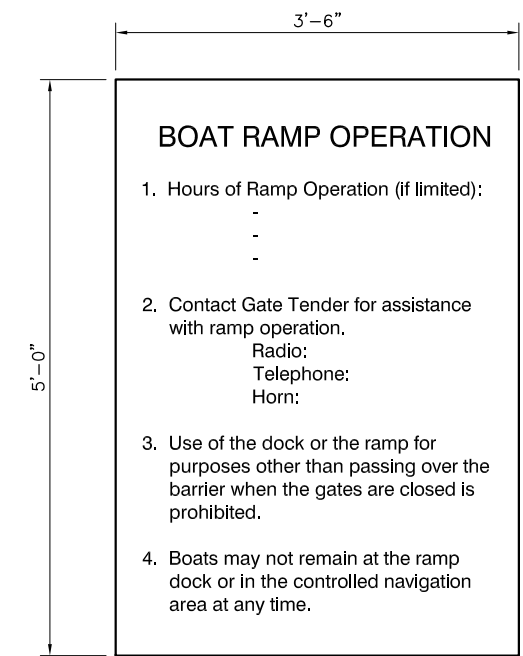


BLACK LETTERS ON WHITE
PAINTED ALUMINUM BOARD

3 BOAT RAMP DOCK SIGN
C26 SCALE: NONE
C54

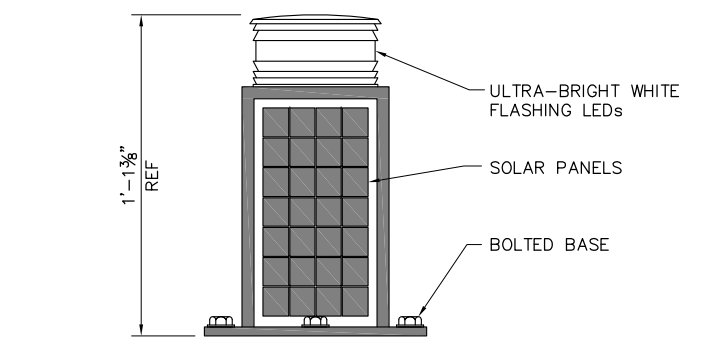


NAVIGATION LIGHT;
ATOP GATE PLATFORM AND ALONG SHEET PILE WHERE NOTED.
CARMANAH MODEL M702-5GPS OR EQUAL - SEE SPECIFICATIONS.

4 NAVIGATION LIGHT
C26 SCALE: NONE
C54

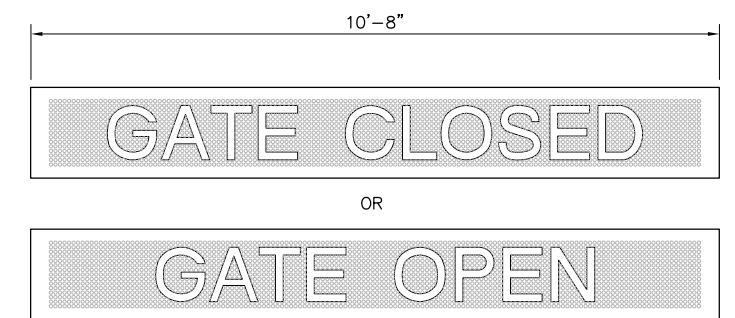

CHANGEABLE ELECTRIC MESSAGEBOARD 12 LETTER, 12" HIGH,
VISIBLE FROM 600', MOUNTED ON OPERATOR HOUSE ROOF
ONE EACH FACING UPSTREAM & DOWNSTREAM.
MODEL PDR0112-12 FROM GRANDWELL DISPLAYS OR EQUAL

8 ELECTRONIC MESSAGE SIGN
C26 SCALE: NONE
C54

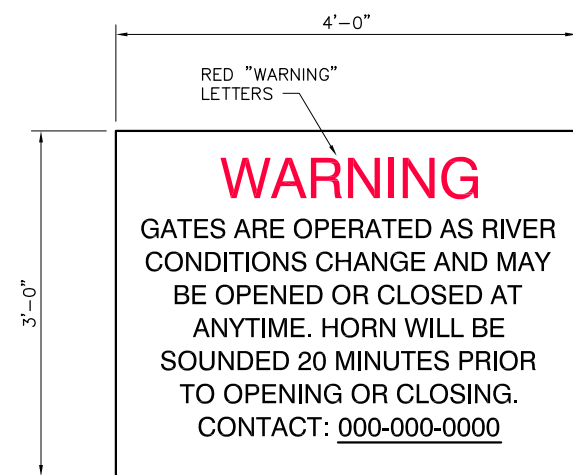


BLACK LETTERS ON WHITE PAINTED
ALUMINUM BOARD
CONTACT NUMBER TO BE PROVIDED BY OWNER

5 GATE WARNING SIGN
C26 SCALE: NONE
C54




BLACK LETTERS AND BORDER ON
WHITE PAINTED ALUMINUM BOARD

6 GATE POSITION SIGNS
C26 SCALE: NONE
C54, C74

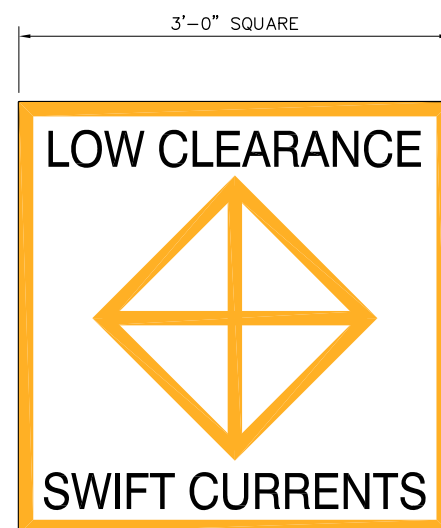


ORANGE SYMBOL AND BORDER,
BLACK LETTERS ON WHITE
PAINTED ALUMINUM BOARD

7 DANGER SIGN
C26 SCALE: NONE
C54

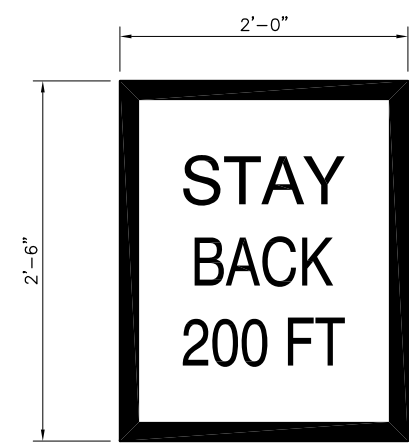

BLACK LETTERS AND BORDER ON WHITE PAINTED
ALUMINUM BOARD

9 STAY BACK WARNING SIGN
C26 SCALE: NONE
C54

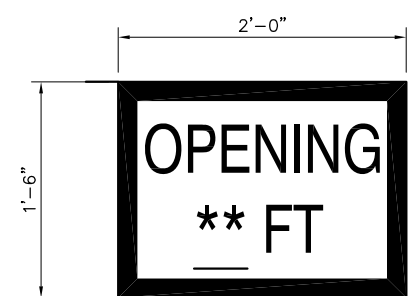


SIGN TO BE MOUNTED
ON DOLPHIN PILES
BENEATH GATE 5 MPH
SIGNS.
OLD RIVER ** 75 FT
CONNECTION SLOUGH
** 60 FT








10 GATE OPENING SIGN
C26 SCALE: NONE
C54

NOTE:
SEE DRAWING C76 FOR SIGN MOUNTING DETAILS.

**100% SUBMITTAL
REVISION 1** IF SHEET IS LESS THAN 22" x 34"
IT IS A REDUCED PRINT -
SCALE REDUCED ACCORDINGLY.

 P:\6097-03 SWC GATE DESIGN\CADD\DWG\609703-C75.DWG 9/28/2009 2:00 PM

REVISION	DESCRIPTION	BY	DATE	 San Luis & Delta–Mendota Water Authority 842 6th Street, Suite 7 PO Box 2157 Los Banos, California 93635	 2001 N. Main Street, Suite 360 Walnut Creek, California 94596 (925) 944–5411	2–GATES FISH PROTECTION DEMONSTRATION PROJECT		DATE 10/02/09
AIDS TO NAVIGATION DETAILS, SHEET 1		SHEET 71 OF 78						
		C75						

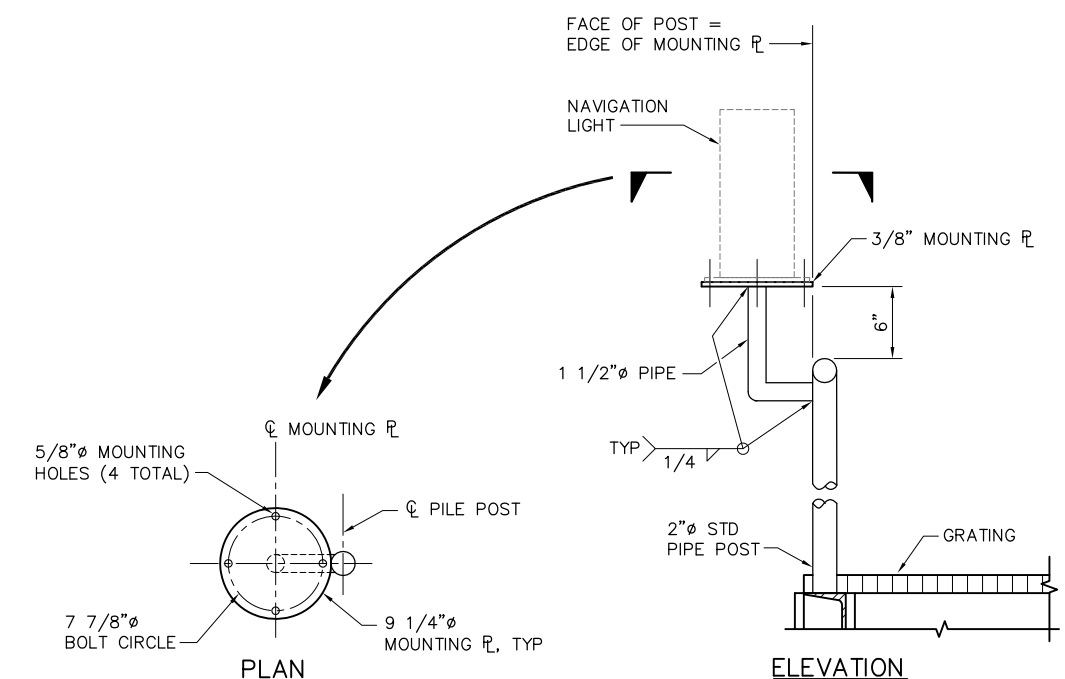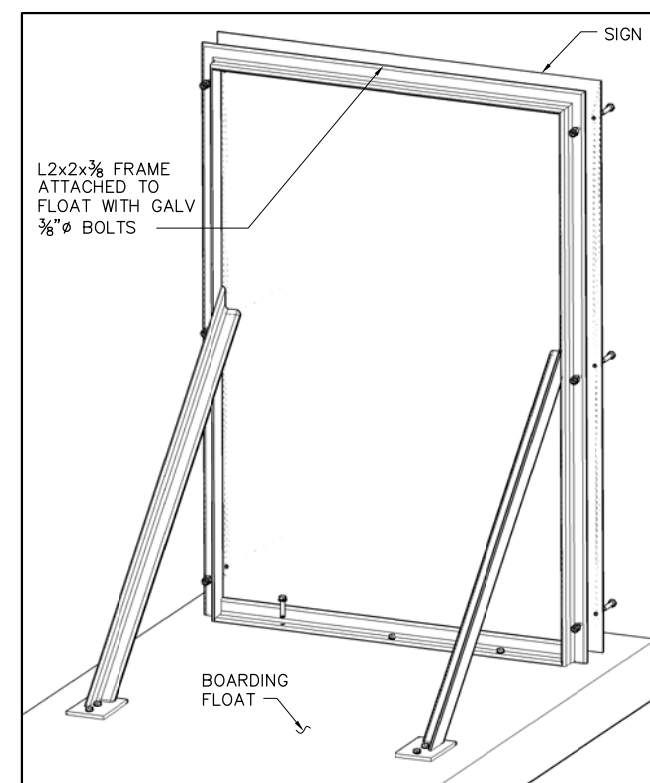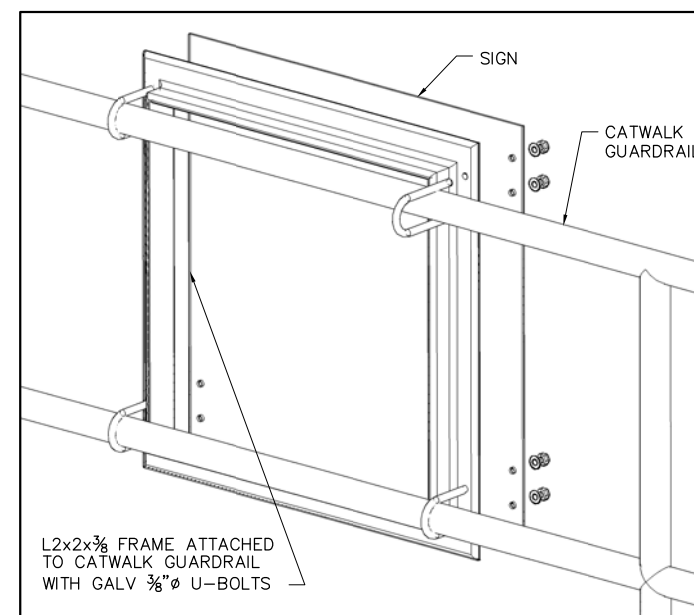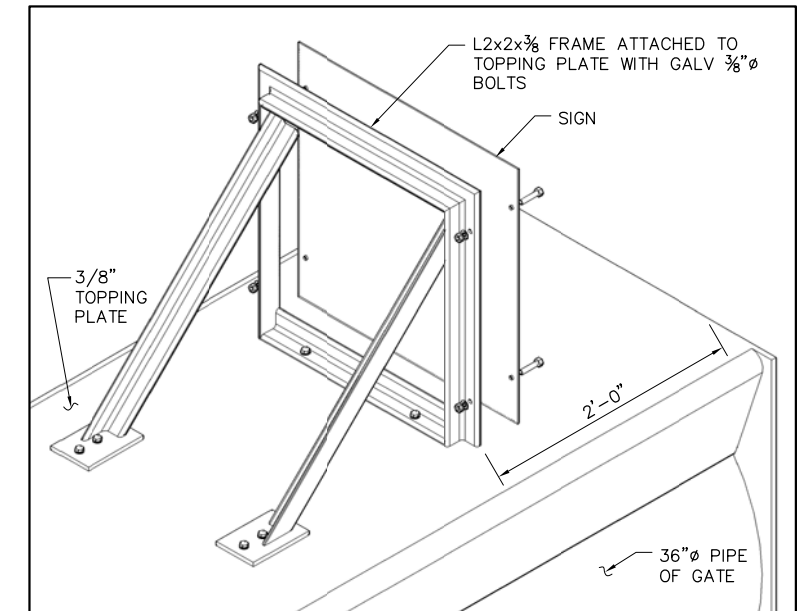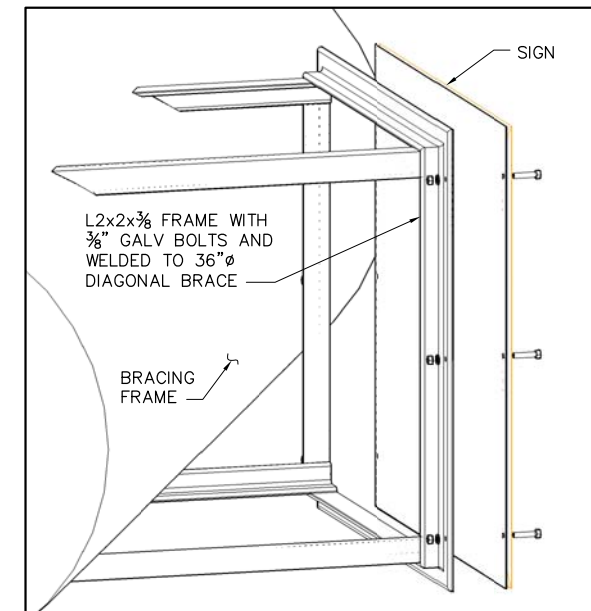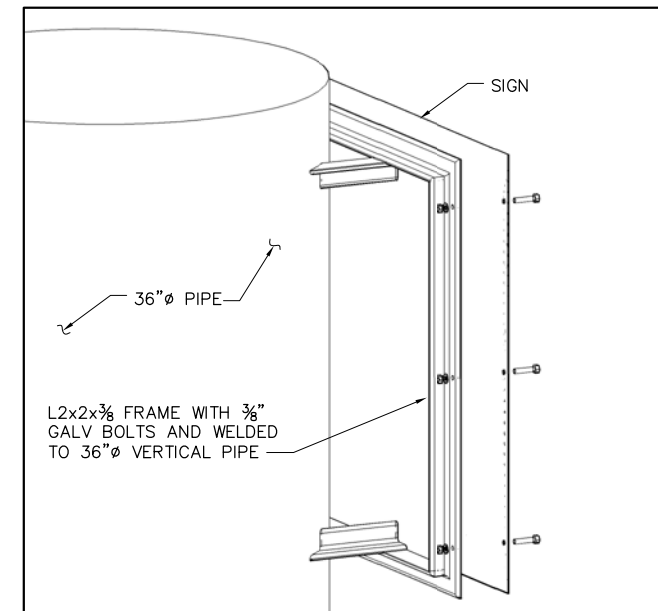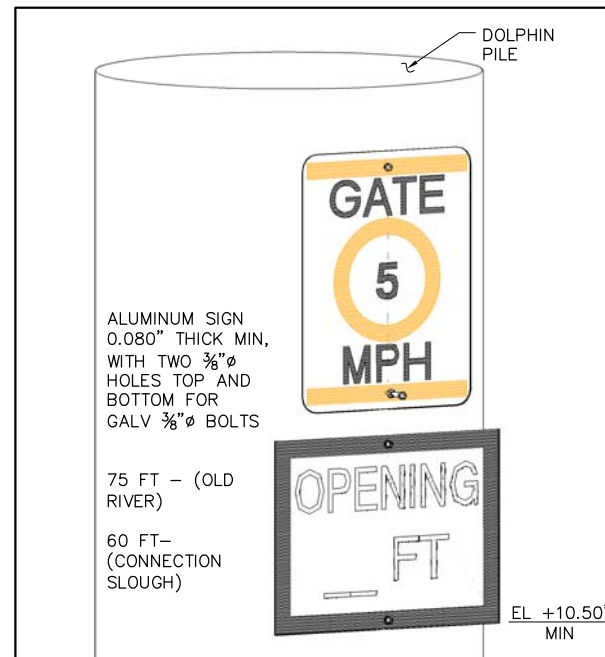

100% SUBMITTAL
REVISION 1

IF SHEET IS LESS THAN 22" x 34"
IT IS A REDUCED PRINT -
SCALE REDUCED ACCORDINGLY.

REVISION	DESCRIPTION	BY	DATE



San Luis & Delta-Mendota Water Authority
842 6th Street, Suite 7
PO Box 2157
Los Banos, California 93635



2001 N. Main Street, Suite 360
Walnut Creek, California 94596
(925) 944-5411

DSGN	DR	CHK
TDB	TAE/AB	RBD
JOB NO.	SUBMITTED BY	
6097-03	RMP	

 
2-GATES FISH PROTECTION
DEMONSTRATION PROJECT

DATE 10/02/09

SHEET 72 OF 78

AIDS TO NAVIGATION DETAILS
SHEET 2


C76



- SERVICE PANEL AND
TRANSFER SWITCH ELEVATION**



 - ① PUMPCO GALV. STEEL LIGHT POLE
- ② VERIFY BOLT CIRCLE & SPACING DIMENSIONS WITH MFG.
- ③ FOR FOUNDATION SEE DWG C82.
- ④ OVERHEAD LINE SHALL COMPLY TO STATE OF CALIFORNIA
GENERAL ORDER NO. 95. BASIC MINIMUM ALLOWABLE VERTICAL
CLEARANCE TO GROUND.



GENERAL NOTES:

1. PROVIDE AND INSTALL MIN 20'-0"L, 1-#3/0 MIN. BARE COPPER UFER GROUND WIRE 2" ABOVE BOTTOM OF PAD. BOND TO ELECTRICAL EQUIPMENT.
2. ANCHOR EQUIPMENT TO CONCRETE PAD WITH ANCHORS PER EQUIPMENT MANUFACTURER'S INSTALLATION INSTRUCTIONS.
3. PROVIDE 6'-0" MIN. CLEAR WORKING SPACE AROUND EQUIPMENT.
4. STUB CONDUITS IN EQUIPMENT AT LOCATIONS PROVIDED BY EQUIPMENT MANUFACTURERS INSTALLATION INSTRUCTIONS. COORDINATE EXACT LOCATION WITH MANUFACTURERS INSTALLATION INSTRUCTIONS.
5. ALL UNDER GROUND CONDUIT SHALL BE SCH 40 PVC 36" BELOW FINISH GRADE.

REVISION	DESCRIPTION	BY	DATE



San Luis & Delta-Mendota Water Authority
842 6th Street, Suite 7
PO Box 2157
Los Banos, California 93635



2001 N. Main Street, Suite 360
Walnut Creek, California 94596
(925) 944-5411

DSGN DM	DR AB/EP	CHK CBS
JOB NO. 6097-03	SUBMITTED BY RMR	

100% SUBMITTAL
REVISION 1

IF SHEET IS LESS THAN 22" x 34"
IT IS A REDUCED PRINT –
SCALE REDUCED ACCORDINGLY.


2-GATES FISH PROTECTION
DEMONSTRATION PROJECT

DATE 10/02/09

SHEET 73 OF 78

UTILITY YARD DETAILS


C77

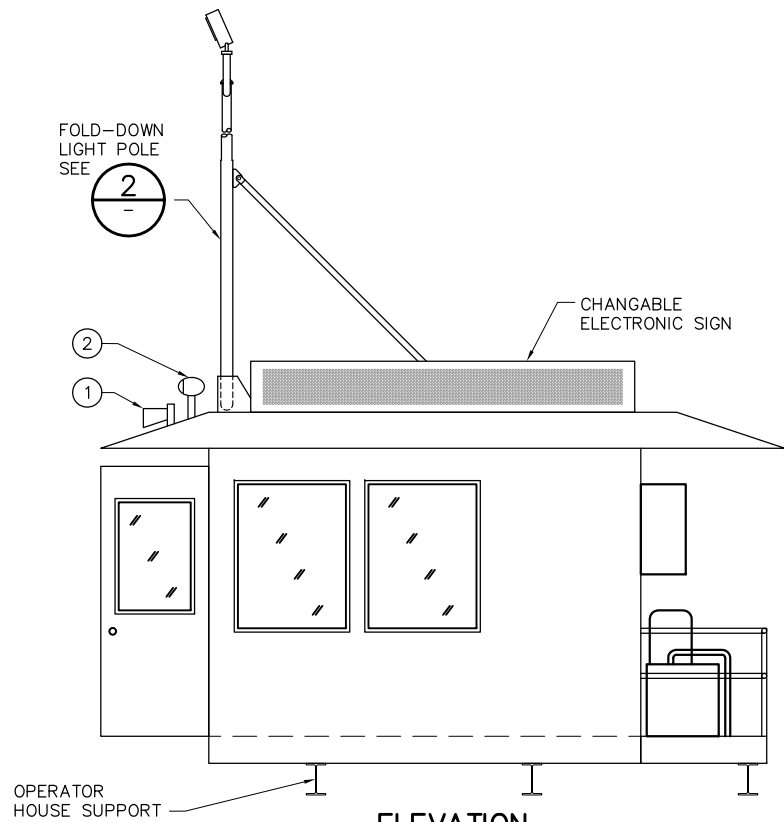


ELEVATION
SCALE: 3/8" = 1'-0"

NOTES:


- 1 SECO HAILER HORN
40 HMS, 15 WITH
STANDARD HORIZON
30W LOUD HAILER
MFG #VLH-3000
- 2 REMOTE CONTROLLED SEARCHLIGHT,
ACR ELECTRONICS
MFG #RCL-75 SPOTLIGHT
AND 17' L CABLE HARNESS

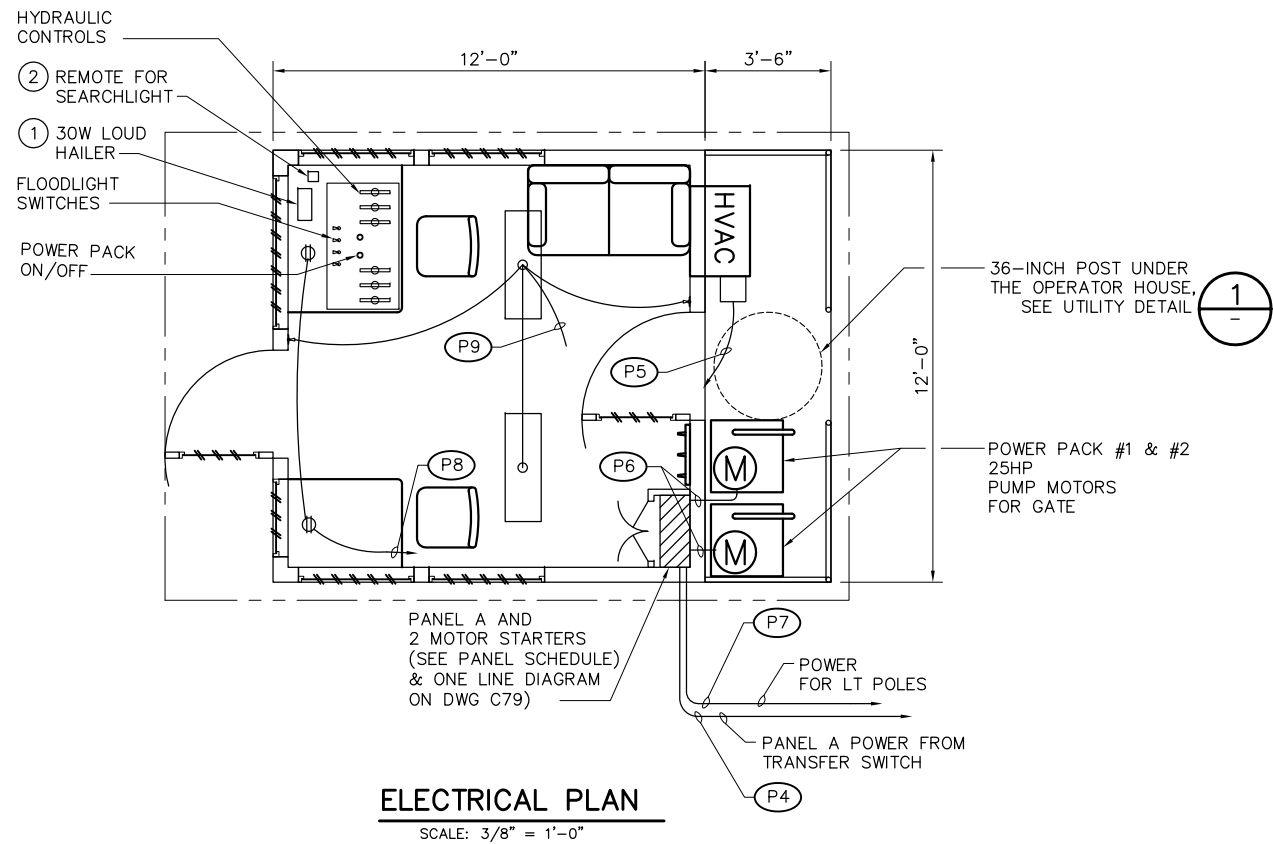


ELECTRICAL PLAN

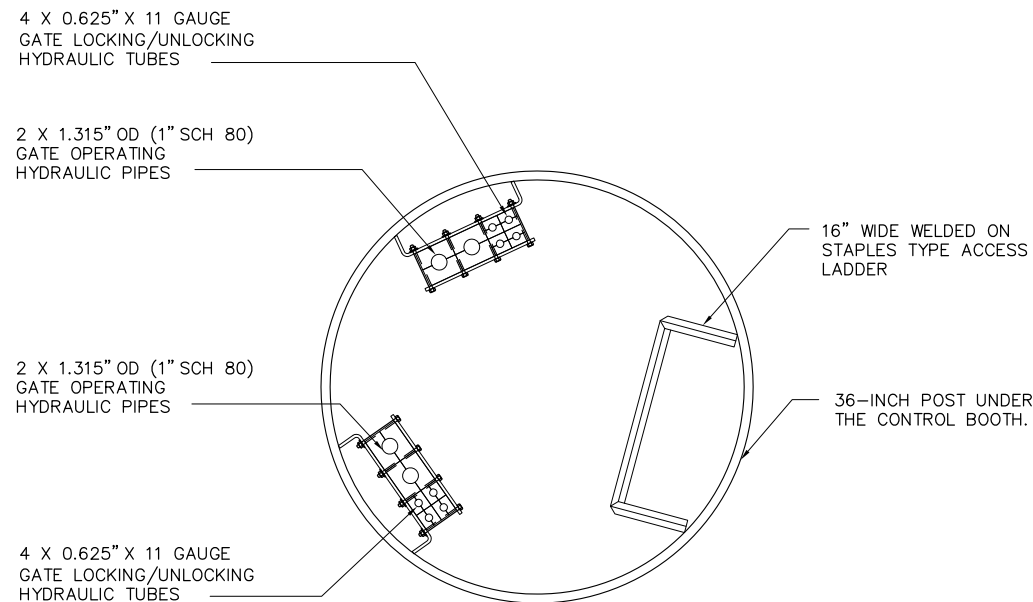

1 UTILITY DETAIL
SCALE: 1 1/2" = 1'-0"

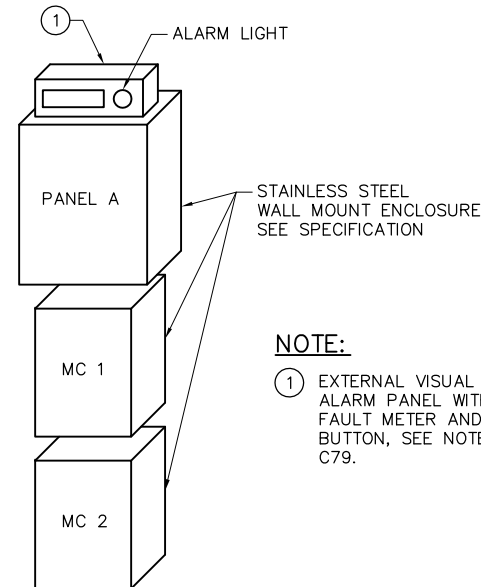

ELECTRICAL CABINET ARRANGEMENT
NTS

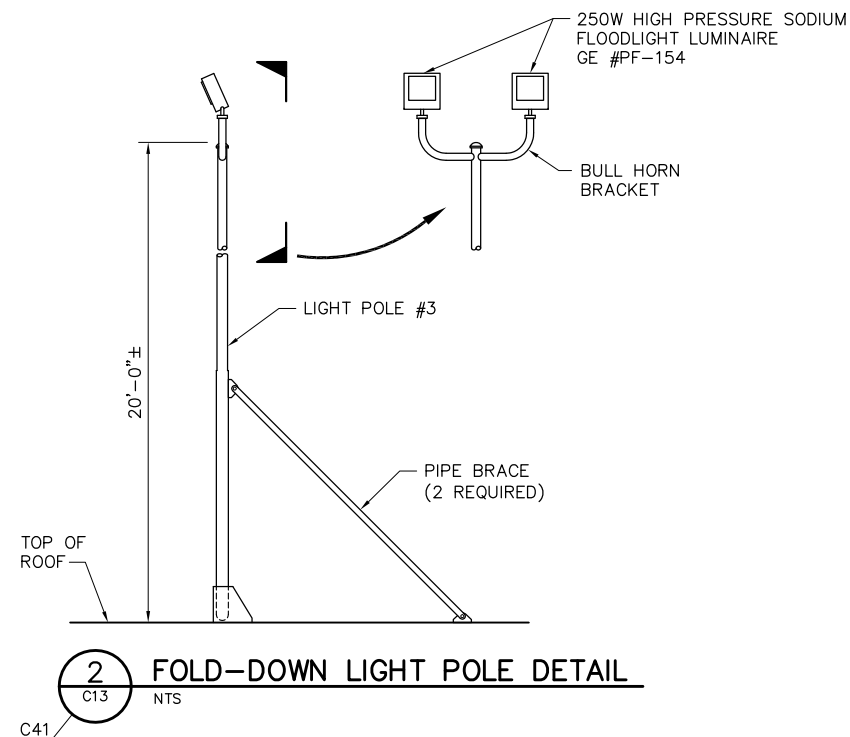

**100% SUBMITTAL
REVISION 1**

IF SHEET IS LESS THAN 22" x 34"
IT IS A REDUCED PRINT -
SCALE REDUCED ACCORDINGLY.

P:\6097-03 SWC GATE DESIGN\CADD\DWG\609703-C78.DWG 10/1/2009 9:36 AM

REVISION	DESCRIPTION	BY	DATE



San Luis & Delta-Mendota Water Authority
842 6th Street, Suite 7
PO Box 2157
Los Banos, California 93635



2001 N. Main Street, Suite 360
Walnut Creek, California 94596
(925) 944-5411

DSGN	CBS	DR	AB/EP	CHK	TDB
JOB NO.	6097-03	SUBMITTED BY	RMR		

2-GATES FISH PROTECTION
DEMONSTRATION PROJECT


DATE 10/02/09

SHEET 74 OF 78

**OPERATOR HOUSE
EQUIPMENT AND DETAILS**

C78

P:\6097-03 SWC GATE DESIGN\CADD\DWG\609703-C79.DWG 10/1/2009 9:34 AM

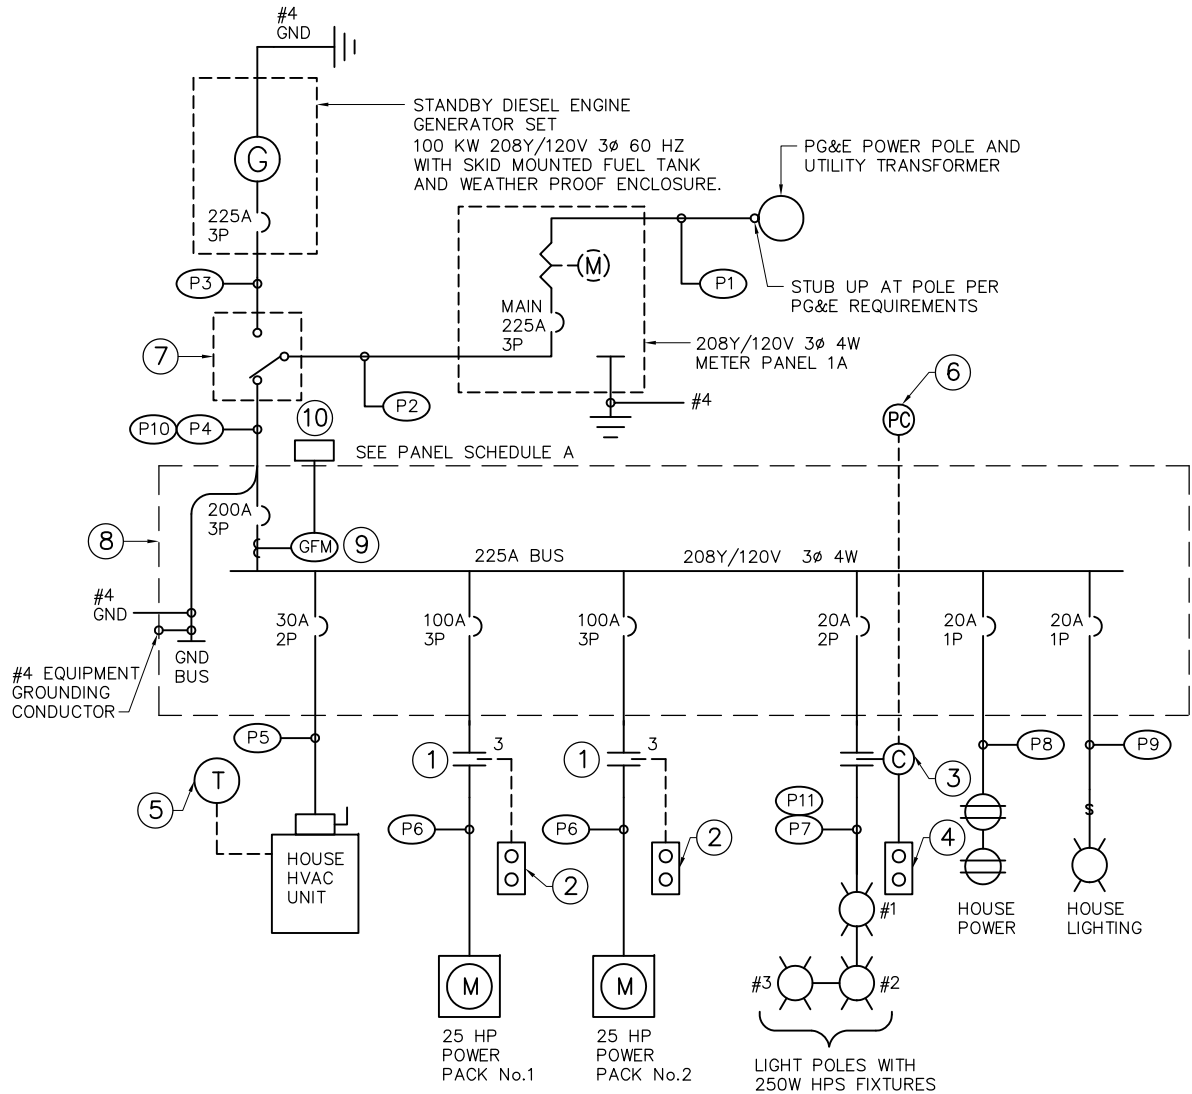

NOTES:

- 1 NEMA SIZE 3 COMBINATION MOTOR STARTER
- 2 POWER PACK ON/OFF CONTROL IN OPERATOR HOUSE
- 3 30A LIGHTING CONTACTOR
- 4 FLOOD LIGHT CONTROL. HAND OFF AUTO IN OPERATOR HOUSE
- 5 THERMOSTAT CONTROL IN OPERATOR HOUSE
- 6 PHOTO CELL LOCATED ON TOP OF OPERATOR HOUSE
- 7 225A - 4W 208Y/120V 3PH. 4 POLE NONAUTOMATIC TRANSFER SWITCH IN A NEMA 3R ENCLOSURE
- 8 PANEL "A" LOCATED IN OPERATOR HOUSE
- 9 GROUND FAULT MONITOR CAT NO. RCM470LY BY BENDER WITH CT's SIZED TO ACCEPT FEEDER CABLES AND AN EXTERNAL VISUAL SIGNAL LIGHT ALARM PANEL WITH GROUND FAULT METER
- 10 EXTERNAL ALARM PANEL FOR GROUND FAULT MONITOR

ONE LINE DIAGRAM
N.T.S.

GENERAL NOTES:

- 1. ALL EQUIPMENT METAL PARTS SHALL BE BONDED WITH A CODE SIZE GROUND CONDUCTOR.
- 2. EQUIPMENT SHALL NOT BE GROUNDED TO THE BARGE HULL.

PANEL: A

LOCATION : CONTROL HOUSE										VOLTAGE/PHASE : 208Y/120V, 3Ø, 4W										FED FROM : PANEL 1A									
MOUNTING : SURFACE										BUS AMPS : 225A										MINIMUM BUS BRACING : 10 KA									
										MAIN BREAKER : 200A 3P																			
LOADS		SEE NOTE	OUTLETS			VOLT-AMPS			BKR/ POLE		BKR/ POLE		VOLT-AMPS			OUTLETS			SEE NOTE	LOADS									
			LTG	REC	MISC	A	B	C	CKT		A	B	C		A	B	C	MISC	REC		LTG								
POWER PACK #1	1				1	9360			1	100/3	*-----	20/2	2	500						4	2	OUT SIDE LIGHTS							
25 HP MOTOR							9360		3	.	-----*	.	4		500														
								9360	5	.	-----*	20/1	6				720		2			HOUSE RECEPT							
POWER PACK #2	1				1	9360			7	100/3	*-----	20/1	8	200						2		HOUSE LIGHTS							
25 HP MOTOR							9360		9	.	-----*		10									SPACE							
								9360	11	.	-----*		12									SPACE							
HOUSE					1	2000			13	30/2	*-----		14									SPACE							
HVAC UNIT							2000		15	.	-----*		16									SPACE							
SPARE									17	20/1	-----*		18									SPACE							
SPARE									19	20/1	*-----		20									SPACE							
SPARE									21	20/1	-----*		22									SPACE							
SPARE									23	20/1	-----*		24									SPACE							
TOTAL ØA = 21420 VOLT-AMPS																													
TOTAL ØB = 21220 VOLT-AMPS																													
TOTAL ØC = 19440 VOLT-AMPS																													
LCL = 300 VOLT-AMPS																													
TOTAL = 62380 VA @ 208V, 3Ø 173.3 AMPS																													
NOTES: 1. CONTROLLED BY SIZE 3 MOTOR STARTER																													
2. CONTROLLED BY PHOTOCELL AND HAND-OFF-AUTO SWITCH																													

CONDUIT AND FEEDER SCHEDULE

	CONDUIT	CONDUCTOR	REMARKS
P1	3" PVC	PULL ROPE	CONDUCTORS BY PG&E
P2	3" PVC	4 #4/O & 1 #4 GND	TO TRANSFER SWITCH
P3	3" PVC	4 #4/O & 1 #4 GND	TO TRANSFER SWITCH
P4	3" PVC	4 #4/O & 1 #4 GND	SURVING PANEL A
P5	1" PVC	2 #10 & 1 #4 GND	HVAC
P6	1 1/4" PVC	3 #2 & 1 #2 GND	POWER PACK #1 & #2
P7	1" PVC	2 #8 & 1 #8 GND	AREA LIGHTING
P8	1/2" PVC	2 #12 & 1 #12 GND	HOUSE POWER
P9	1/2" PVC	2 #12 & 1 #12 GND	HOUSE LIGHTING
* P10	-	4 #4/O & 1 #4 GND	OVERHEAD CABLE
* P11	-	2 #1/O & 1 #1/O NET	OVERHEAD CABLE

* PAC 600V PARALLEL AERIAL CABLE ALUMINUM HD POLY 75' C.

100% SUBMITTAL
REVISION 1

IF SHEET IS LESS THAN 22" x 34"
IT IS A REDUCED PRINT -
SCALE REDUCED ACCORDINGLY.

REVISION	DESCRIPTION	BY	DATE



San Luis & Delta-Mendota Water Authority
842 6th Street, Suite 7
PO Box 2157
Los Banos, California 93635



2001 N. Main Street, Suite 360
Walnut Creek, California 94596
(925) 944-5411

DSGN DM	DR AB/EP	CHK CBS
JOB NO. 6097-03	SUBMITTED BY RMR	

2-GATES FISH PROTECTION
DEMONSTRATION PROJECT


DATE 10/02/09

SHEET 75 OF 78

ELECTRICAL SYSTEM DIAGRAM


C79

P:\6097-03 SWC GATE DESIGN\CADD\DWG\609703-C80.DWG 9/1/2009 10:44 AM

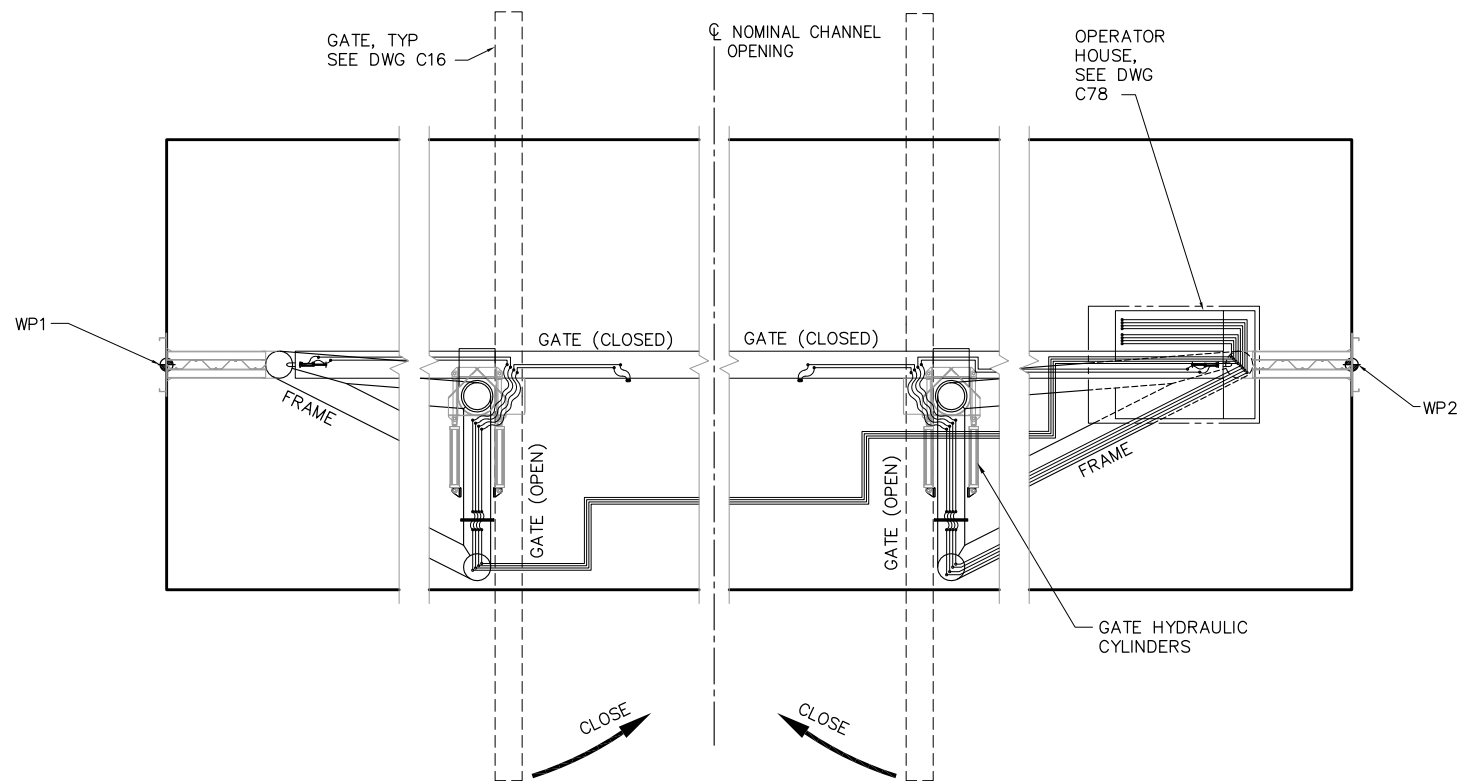


GATE LOCKING HYDRAULIC DIAGRAM

SCALE: 3/32" = 1'-0"

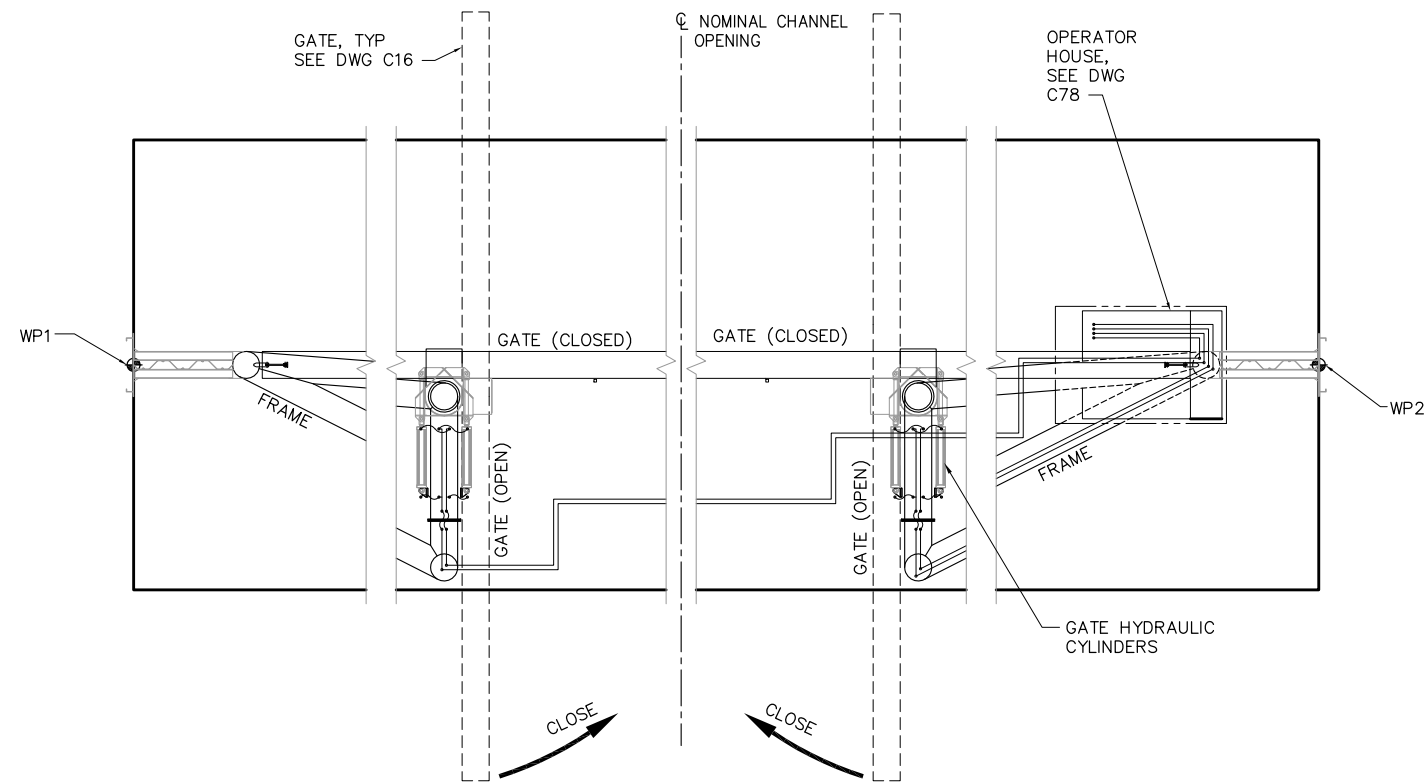


GATE OPERATOR HYDRAULIC DIAGRAM

SCALE: 3/32" = 1'-0"

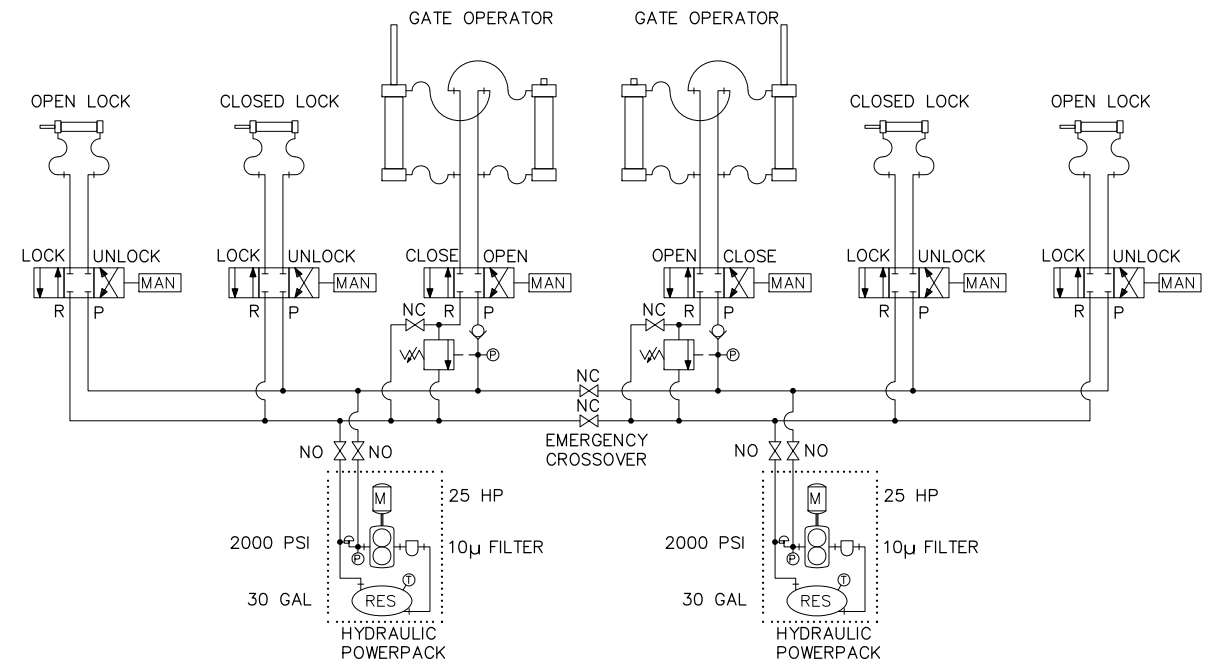

HYDRAULIC SYSTEM SCHEMATIC

NTS

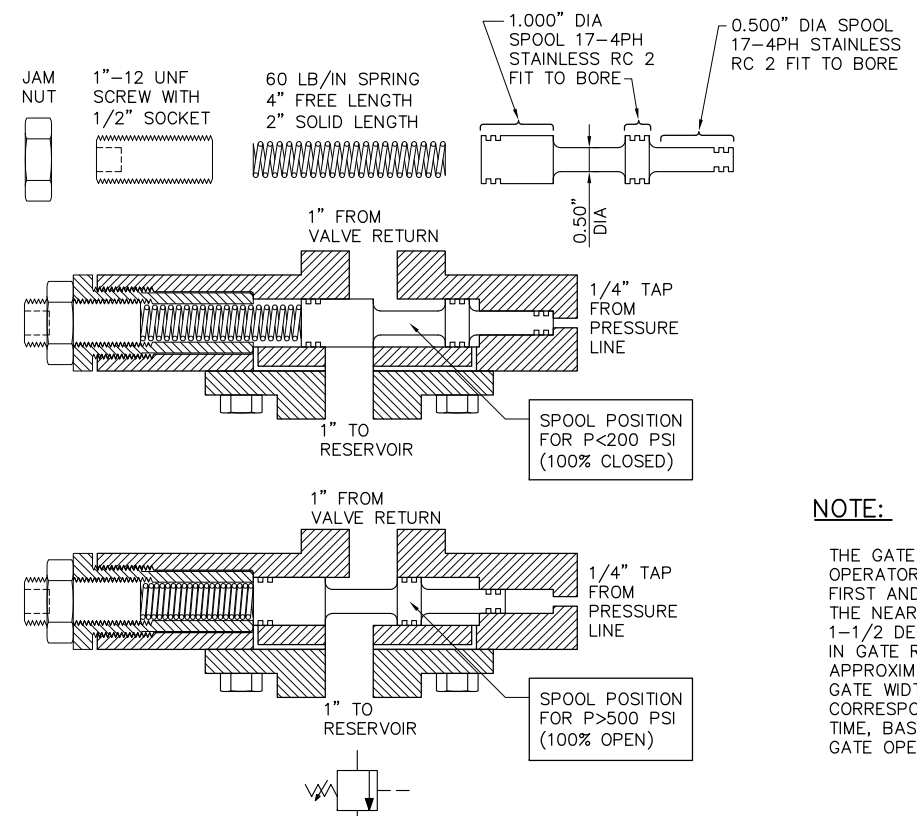

TYPICAL BRAKE VALVE

(EXTERNALLY PILOTED COUNTERBALANCE VALVE)

NTS


NOTE:

THE GATE FARTHEST FROM THE OPERATOR HOUSE MUST BEGIN OPENING FIRST AND CLOSE SLIGHTLY LATER THAN THE NEAR GATE WITH APPROXIMATELY 1-1/2 DEGREES MAXIMUM DIFFERENCE IN GATE ROTATION. (1-1/2 DEGREES IS APPROXIMATELY ONE-HALF OF THE GATE WIDTH LEAD OR LAG, AND CORRESPONDS TO A 4 SECOND DELAY TIME, BASED ON A 4 MINUTE TOTAL GATE OPENING TIME.)

**100% SUBMITTAL
REVISION 1**

IF SHEET IS LESS THAN 22" x 34"
IT IS A REDUCED PRINT -
SCALE REDUCED ACCORDINGLY.

REVISION	DESCRIPTION	BY	DATE

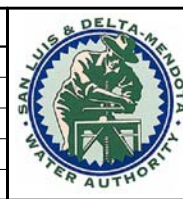

San Luis & Delta-Mendota Water Authority
842 6th Street, Suite 7
PO Box 2157
Los Banos, California 93635



2001 N. Main Street, Suite 360
Walnut Creek, California 94596
(925) 944-5411

DSGN	CBS	DR	AB	CHK	TDB
JOB NO.	6097-03	SUBMITTED BY	RMR		

2-GATES FISH PROTECTION
DEMONSTRATION PROJECT


HYDRAULICS SYSTEM DIAGRAM

DATE 10/02/09


SHEET 76 OF 78

C80


P:\6097-03 SWC GATE DESIGN\CADD\DWG\609703-C81.DWG 9/28/2009 10:40 AM

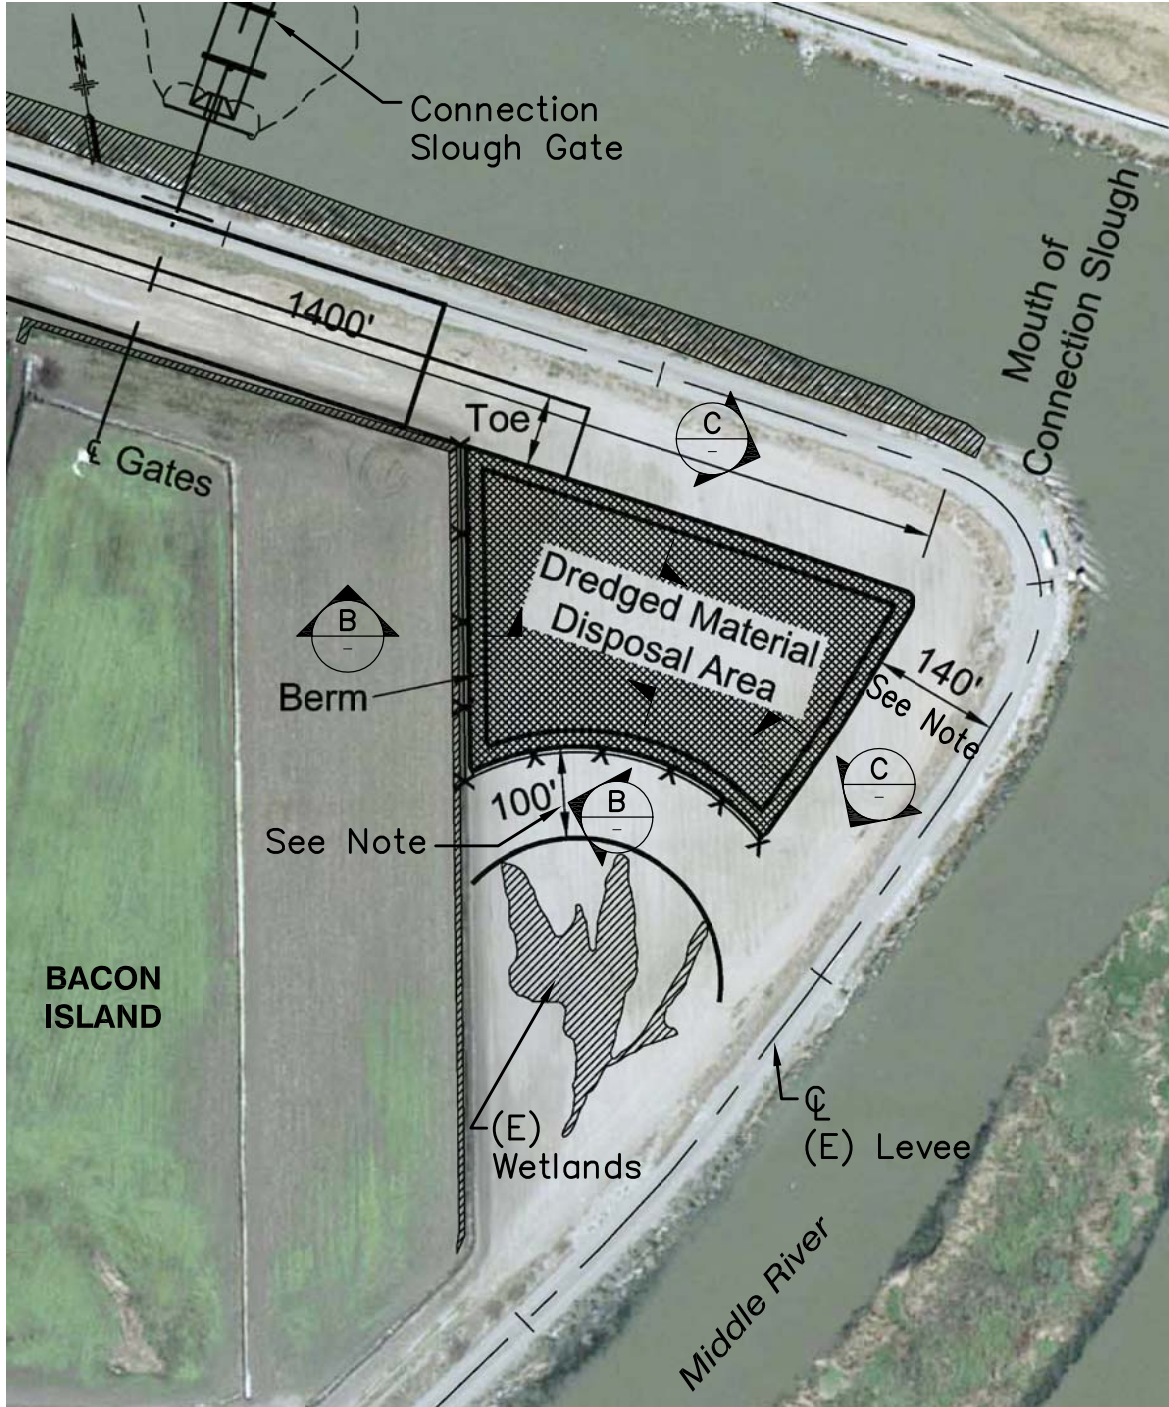

A DISPOSAL SITE PLAN
NTS
NOTE: SEE DWG G4 FOR LOCATION.

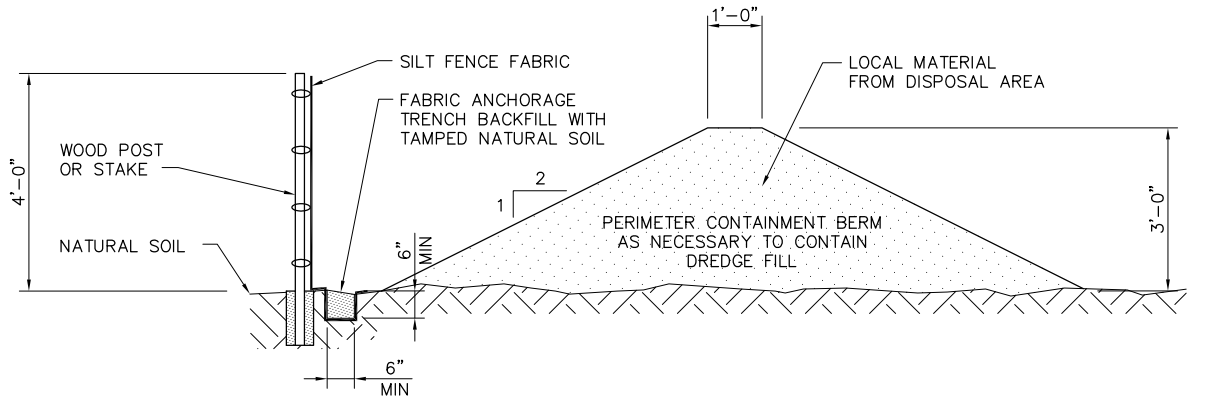

B SECTION
SCALE: NONE

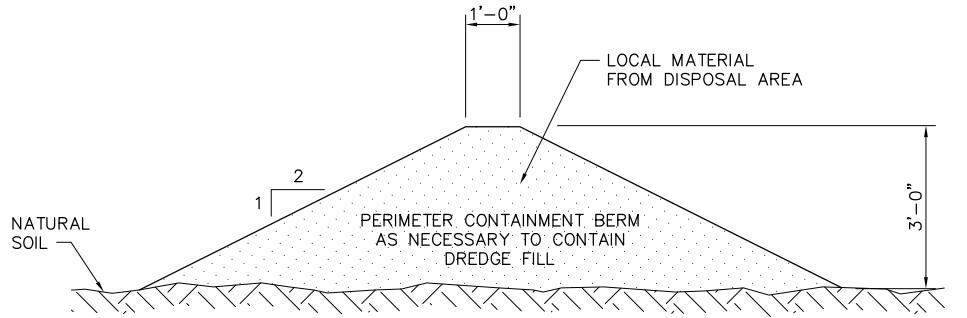

C SECTION
SCALE: NONE

NOTE:
NO DREDGE MATERIAL SHALL BE PLACED WITHIN 140'
OF THE LEVEE CENTERLINE AND 100' OF THE WETLANDS.

**100% SUBMITTAL
REVISION 1**

IF SHEET IS LESS THAN 22" x 34"
IT IS A REDUCED PRINT -
SCALE REDUCED ACCORDINGLY.

REVISION	DESCRIPTION	BY	DATE



San Luis & Delta-Mendota Water Authority
842 6th Street, Suite 7
PO Box 2157
Los Banos, California 93635



2001 N. Main Street, Suite 360
Walnut Creek, California 94596
(925) 944-5411

DSGN	TDB	DR	TAE/AB	CHK	GTH
JOB NO.	6097-03	SUBMITTED BY	RMR		

2-GATES FISH PROTECTION
DEMONSTRATION PROJECT


DREDGED MATERIAL DISPOSAL SITE

DATE 10/02/09


SHEET 77 OF 78

C81


P:\6097-03 SWC GATE DESIGN\CADD\DWG\609703-C82.DWG 9/29/2009 3:57 PM

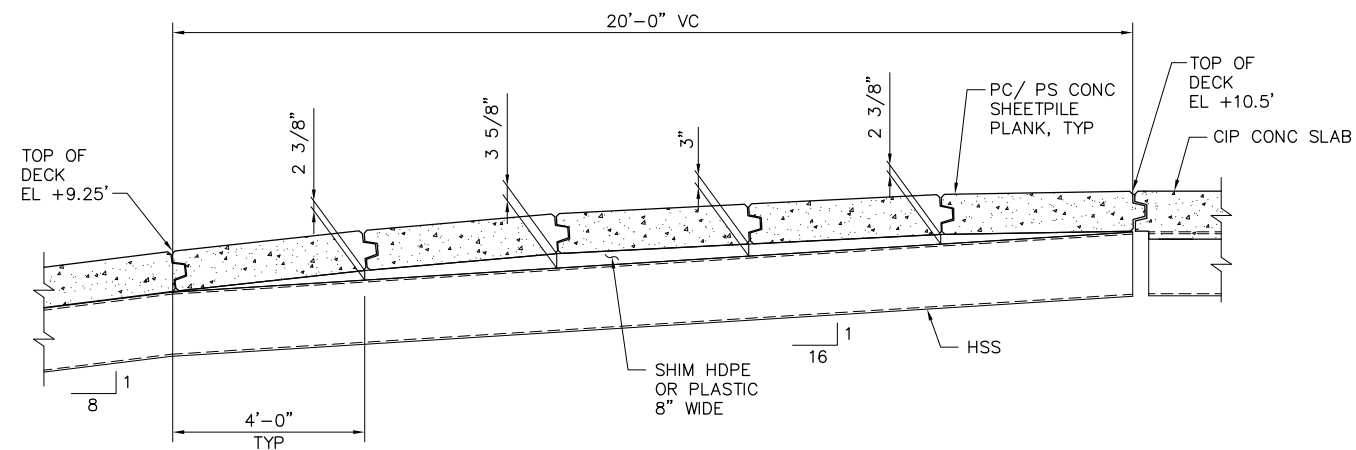


1
C7
DETAIL
SCALE: 1/2" = 1'-0"

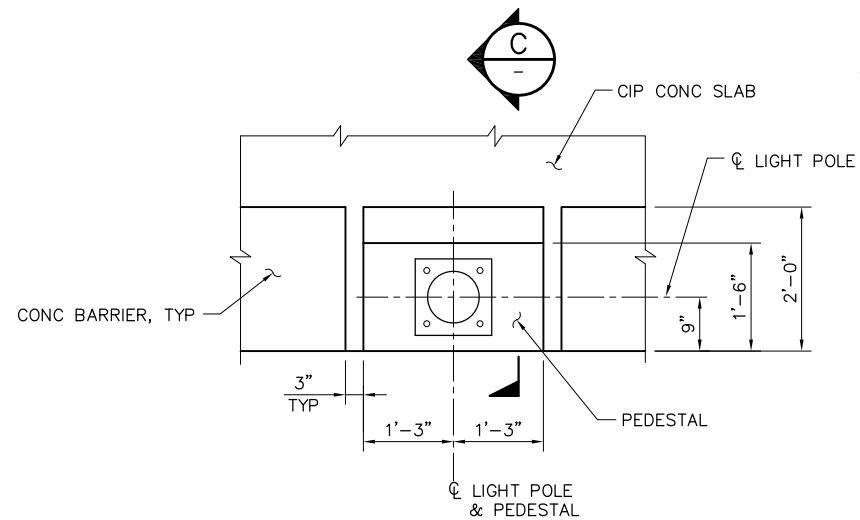


3
C39
DETAIL
SCALE: 3/4" = 1'-0"

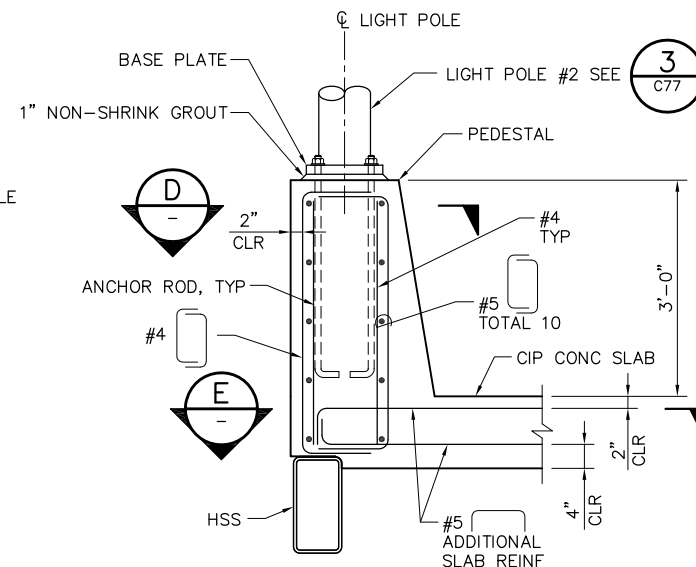


C
SECTION
SCALE: 3/4" = 1'-0"

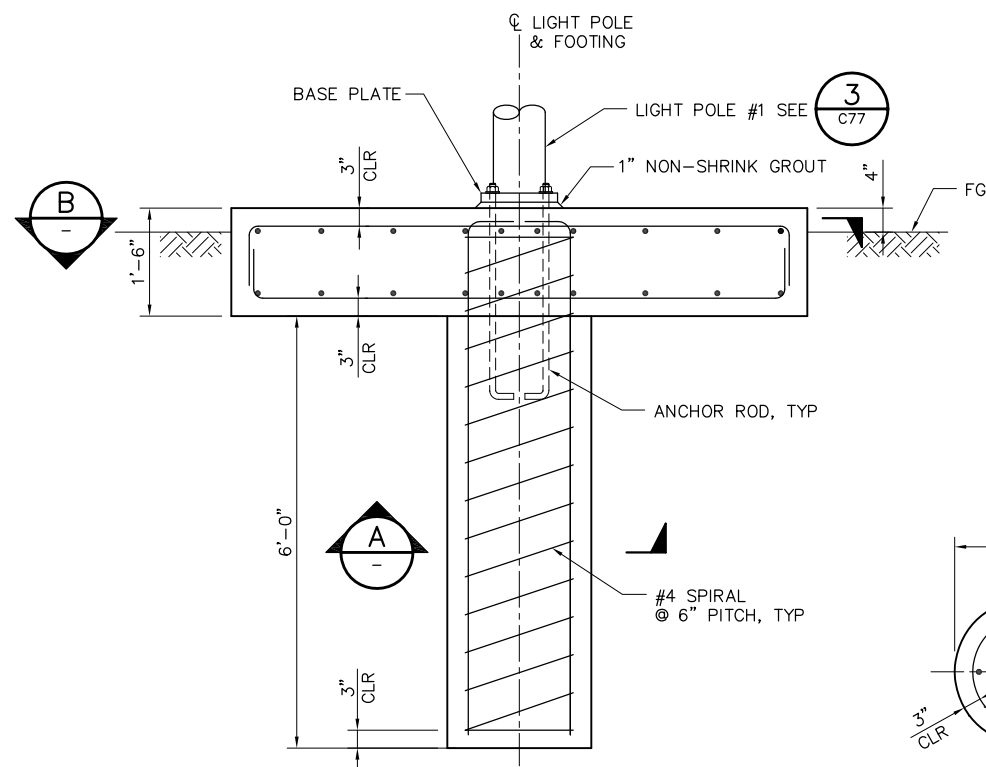


2
C77
DETAIL
SCALE: 3/4" = 1'-0"

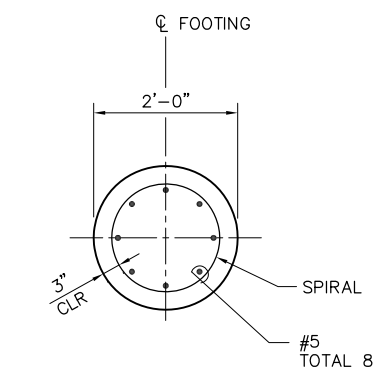


A
SECTION
SCALE: 3/4" = 1'-0"

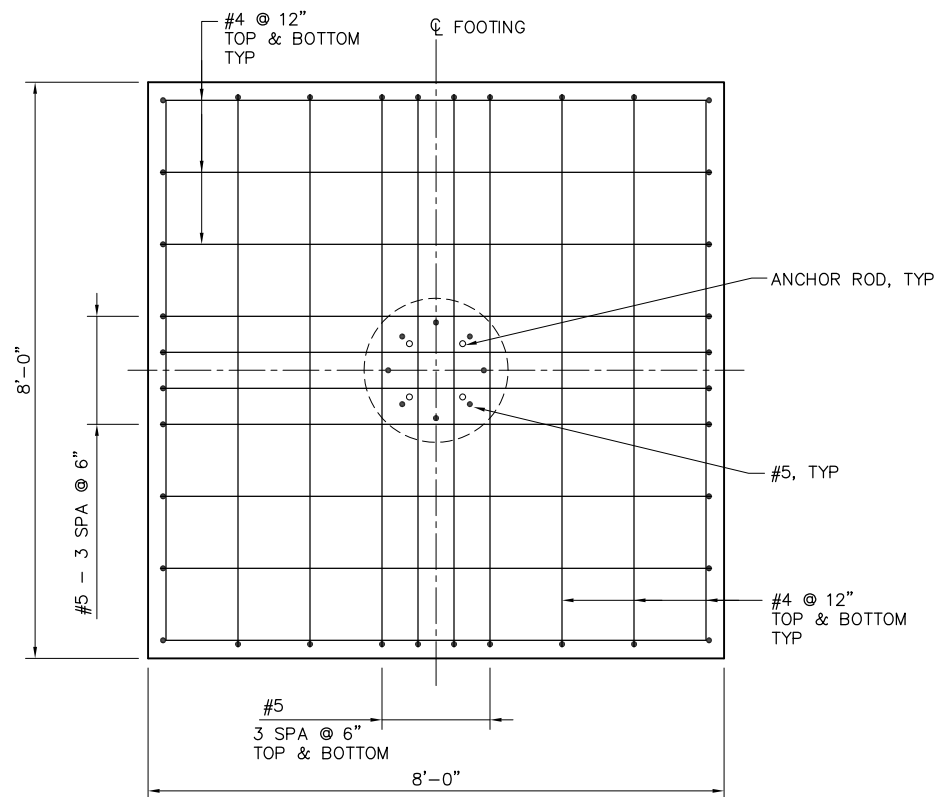

B
SECTION
SCALE: 3/4" = 1'-0"

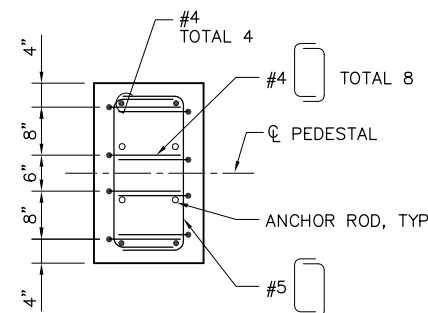

D
SECTION
SCALE: 3/4" = 1'-0"

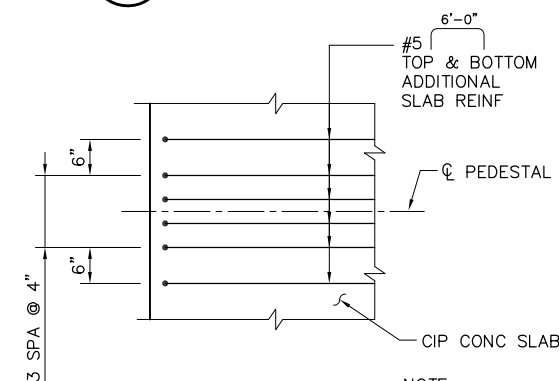

E
SECTION
SCALE: 3/4" = 1'-0"

NOTE:
PEDESTAL REINFORCEMENT
NOT SHOWN FOR CLARITY.

2'-0" 0'-0" 1'-0" 2'-0"
SCALE: 3/4" = 1'-0"

**100% SUBMITTAL
REVISION 1**

IF SHEET IS LESS THAN 22" x 34"
IT IS A REDUCED PRINT -
SCALE REDUCED ACCORDINGLY.

REVISION	DESCRIPTION	BY	DATE



San Luis & Delta-Mendota Water Authority
842 6th Street, Suite 7
PO Box 2157
Los Banos, California 93635



2001 N. Main Street, Suite 360
Walnut Creek, California 94596
(925) 944-5411

DSGN	JMB	DR	EP	CHK	TDB
JOB NO.	6097-03	SUBMITTED BY	RMR		

2-GATES FISH PROTECTION
DEMONSTRATION PROJECT

DATE 10/02/09

SHEET 78 OF 78

MISCELLANEOUS DETAILS

C82