



100% Design Plans for Old River Site and Connection Slough Sites

BACON ISLAND, CALIFORNIA

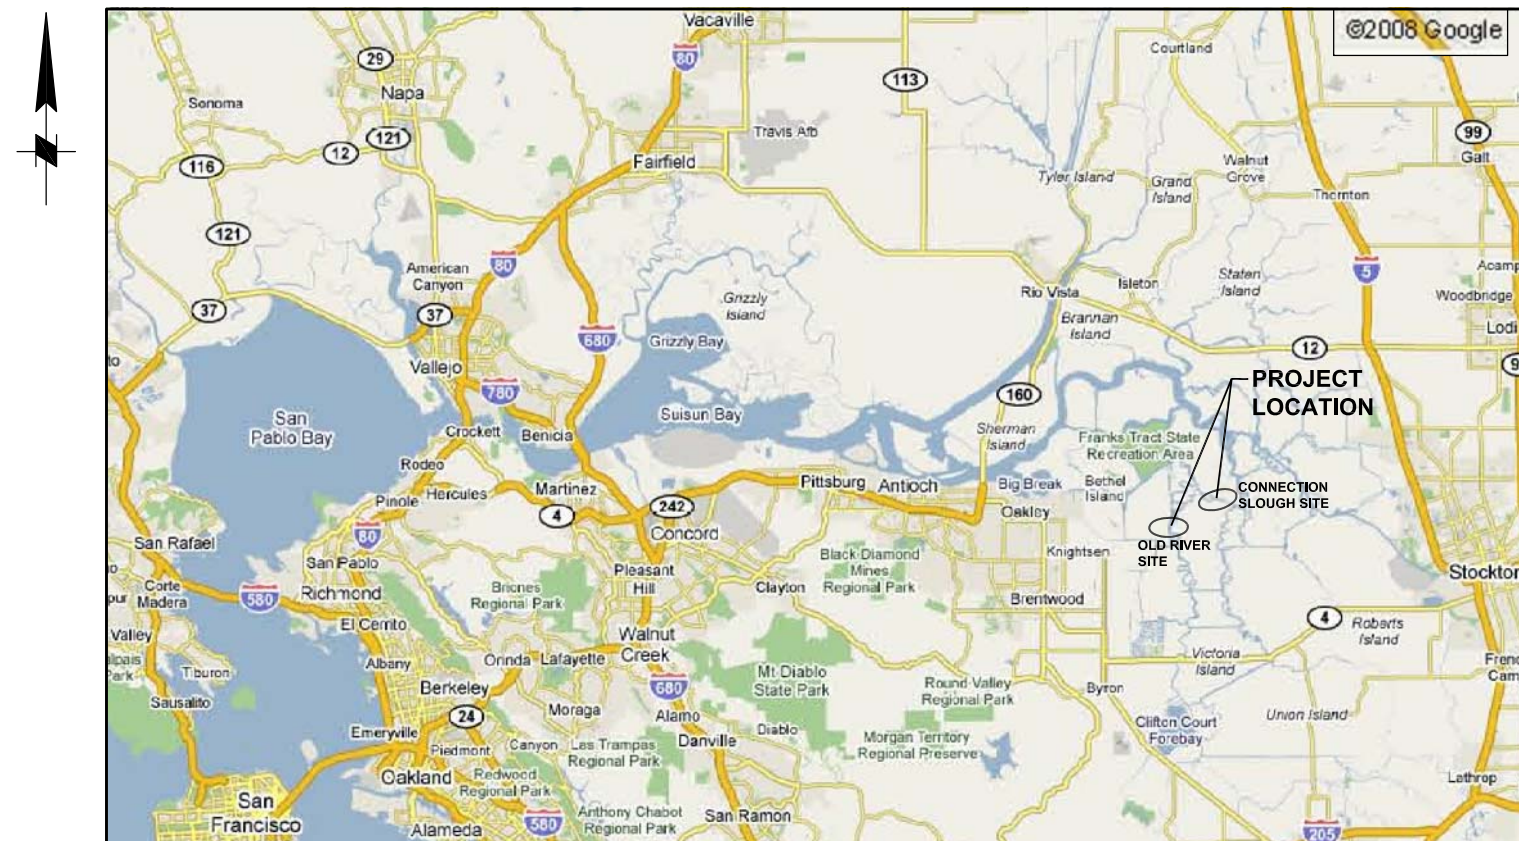

VICINITY MAP
NTS

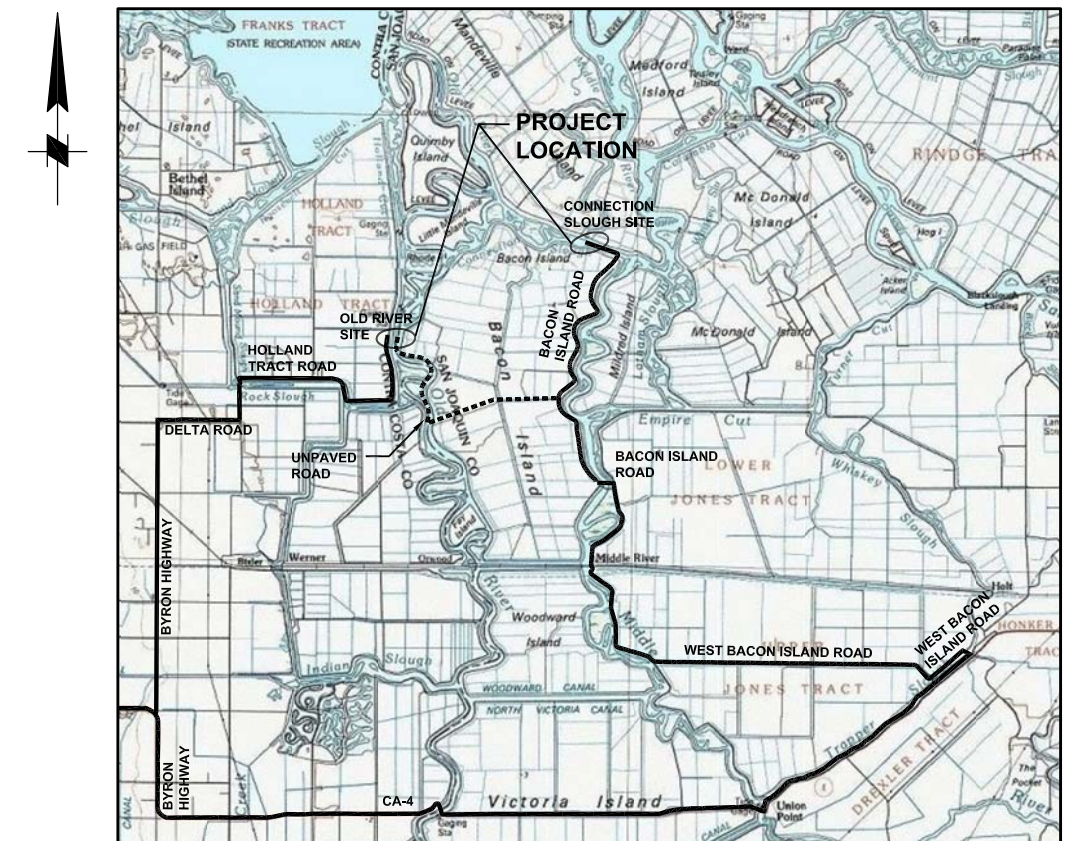

LOCATION MAP
NTS

100% SUBMITTAL

IF SHEET IS LESS THAN 22" x 34"
IT IS A REDUCED PRINT -
SCALE REDUCED ACCORDINGLY.

REVISION	DESCRIPTION	BY	DATE	 San Luis & Delta-Mendota Water Authority 842 6th Street, Suite 7 PO Box 2157 Los Banos, California 93635 APPROVED _____ FRANCY C. MIZUNO, PE C35136 San Luis & Delta-Mendota Water Authority APPROVED _____ DENNIS G. MAJORS PE C21297 Metropolitan Water District of Southern California	 2001 N. Main Street, Suite 360 Walnut Creek, California 94596 (925) 944-5411	TWO GATE FISH PROTECTION PLAN			DATE 08/31/09	
								SHEET 1 OF 78		
								TITLE SHEET		G1

P:\6097-03 SWC GATE DESIGN\CADD\DWG\609703-G2.DWG 8/27/2009 9:40 AM

INDEX OF DRAWINGS

SHEET NUMBER	DRAWING NUMBER	DESCRIPTION
		<u>GENERAL</u>
1	G1	TITLE SHEET
2	G2	INDEX OF DRAWINGS
3	G3	GENERAL NOTES, ABBREVIATIONS AND LEGEND
4	G4	PROJECT GENERAL PLAN
		<u>OLD RIVER</u>
5	C1	OLD RIVER, SITE PLAN
6	C2	OLD RIVER, DREDGING PLAN AND SECTION
7	C3	OLD RIVER, BARGE BEDDING PLAN AND SECTIONS
8	C4	OLD RIVER, BARGE – ROCK FILL PLAN AND SECTIONS
9	C5	OLD RIVER, SHEET PILE WALL ARRANGEMENT PLAN AND ELEVATION, SHEET 1
10	C6	OLD RIVER SHEET PILE WALL ARRANGEMENT PLAN AND ELEVATION, SHEET 2
11	C7	OLD RIVER, BOAT RAMP PLAN AND SECTION
12	C7.1	OLD RIVER, BOAT RAMP PILE PLAN
13	C7.2	OLD RIVER, BOAT RAMP FRAMING PLAN
14	C8	OLD RIVER, BOAT RAMP DETAILS AND SECTIONS, SHEET 1
15	C9	OLD RIVER, BOAT RAMP DETAILS AND SECTIONS, SHEET 2
16	C10	OLD RIVER, BOAT RAMP DETAILS AND SECTIONS, SHEET 3
17	C11	OLD RIVER, CATWALK PLAN AND ELEVATION, SHEET 1
18	C12	OLD RIVER, CATWALK PLAN AND ELEVATION, SHEET 2
19	C13	OLD RIVER, ELECTRICAL SITE PLAN
20	C14	OLD RIVER, BARGE GENERAL ARRANGEMENT PLAN
21	C15	OLD RIVER, BARGE GENERAL ARRANGEMENT ELEVATION
22	C16	OLD RIVER, GATE SCANTLINGS
23	C17	OLD RIVER, GATE FRAMING LAYOUT
24	C18	OLD RIVER, GATE STRUCTURAL DETAILS, SHEET 1
25	C19	OLD RIVER, GATE STRUCTURAL DETAILS, SHEET 2
26	C20	OLD RIVER, GATE STRUCTURAL DETAILS, SHEET 3
27	C21	OLD RIVER, GATE STRUCTURAL DETAILS, SHEET 4
28	C22	OLD RIVER, GATE STRUCTURAL DETAILS, SHEET 5
29	C23	OLD RIVER, GATE MECHANICAL DETAILS, SHEET 1
30	C24	OLD RIVER, GATE MECHANICAL DETAILS, SHEET 2
31	C25	OLD RIVER, END WALL SCANTLINGS
32	C26	OLD RIVER, AIDS TO NAVIGATION PLAN

SHEET NUMBER	DRAWING NUMBER	DESCRIPTION
		<u>CONNECTION SLOUGH</u>
33	C31	CONNECTION SLOUGH, SITE PLAN
34	C32	CONNECTION SLOUGH, DREDGING – PLAN AND SECTION
35	C33	CONNECTION SLOUGH, BARGE BEDDING PLAN
36	C34	CONNECTION SLOUGH, BARGE–ROCK FILL PLAN AND SECTIONS
37	C35	CONNECTION SLOUGH, SHEET PILE WALL ARRANGEMENT PLAN AND ELEVATION
38	C36	CONNECTION SLOUGH, BOAT RAMP PLAN AND SECTION
39	C36.1	CONNECTION SLOUGH, BOAT RAMP PILE PLAN
40	C36.2	CONNECTION SLOUGH, BOAT RAMP FRAMING PLAN
41	C37	CONNECTION SLOUGH, BOAT RAMP DETAILS AND SECTIONS, SHEET 1
42	C38	CONNECTION SLOUGH, BOAT RAMP DETAILS AND SECTIONS, SHEET 2
43	C39	CONNECTION SLOUGH, BOAT RAMP DETAILS AND SECTIONS, SHEET 3
44	C40	CONNECTION SLOUGH, CATWALK – PLAN AND ELEVATION
45	C41	CONNECTION SLOUGH, ELECTRICAL SITE PLAN
46	C42	CONNECTION SLOUGH, BARGE GENERAL ARRANGEMENT PLAN
47	C43	CONNECTION SLOUGH, BARGE GENERAL ARRANGEMENT ELEVATION
48	C44	CONNECTION SLOUGH, GATE SCANTLINGS
49	C45	CONNECTION SLOUGH, GATE FRAMING LAYOUT
50	C46	CONNECTION SLOUGH, GATE STRUCTURAL DETAILS, SHEET 1
51	C47	CONNECTION SLOUGH, GATE STRUCTURAL DETAILS, SHEET 2
52	C48	CONNECTION SLOUGH, GATE STRUCTURAL DETAILS, SHEET 3
53	C49	CONNECTION SLOUGH, GATE STRUCTURAL DETAILS, SHEET 4
54	C50	CONNECTION SLOUGH, GATE STRUCTURAL DETAILS, SHEET 5
55	C51	CONNECTION SLOUGH, GATE MECHANICAL DETAILS, SHEET 1
56	C52	CONNECTION SLOUGH, GATE MECHANICAL DETAILS, SHEET 2
57	C53	CONNECTION SLOUGH, END WALL SCANTLINGS
58	C54	CONNECTION SLOUGH, AIDS TO NAVIGATION PLAN

SHEET NUMBER	DRAWING NUMBER	DESCRIPTION
		<u>COMMON DETAILS</u>
59	C63	SHEET PILE WALL DETAILS, SHEET 1
60	C64	SHEET PILE WALL DETAILS, SHEET 2
61	C65	BOAT RAMP PLAN AND SECTIONS
62	C66	BOAT RAMP DETAILS
63	C67	BOARDING FLOAT PLAN AND ELEVATION
64	C68	BOARDING FLOAT DETAILS
65	C69	CATWALK DETAILS, SHEET 1
66	C70	CATWALK DETAILS, SHEET 2
67	C71	CATWALK DETAILS, SHEET 3
68	C72	CATWALK DETAILS, SHEET 4
69	C73	CATWALK DETAILS, SHEET 5
70	C74	CATWALK DETAILS, SHEET 6
71	C75	AIDS TO NAVIGATION DETAILS, SHEET 1
72	C76	AIDS TO NAVIGATION DETAILS, SHEET 2
73	C77	UTILITY YARD DETAILS
74	C78	OPERATOR HOUSE EQUIPMENT AND DETAILS
75	C79	ELECTRICAL SYSTEM DIAGRAM
76	C80	HYDRAULICS SYSTEM DIAGRAM
77	C81	DREDGED MATERIAL DISPOSAL SITE
78	C82	MISCELLANEOUS DETAILS

100% SUBMITTAL

IF SHEET IS LESS THAN 22” x 34”
IT IS A REDUCED PRINT –
SCALE REDUCED ACCORDINGLY.

REVISION	DESCRIPTION	BY	DATE



San Luis & Delta–Mendota Water Authority
842 6th Street, Suite 7
PO Box 2157
Los Banos, California 93635

APPROVED _____
FRANCY C. MIZUNO, PE C35136
San Luis & Delta–Mendota Water Authority

APPROVED _____
DENNIS G. MAJORS PE C21297
Metropolitan Water District of Southern California





2001 N. Main Street, Suite 360
Walnut Creek, California 94596
(925) 944–5411

DSGN	TDB	DR	AB	CHK	GTH
JOB NO. 6097–03		SUBMITTED BY RMR			

TWO GATE FISH PROTECTION PLAN	DATE 08/31/09
	SHEET 2 OF 78
INDEX OF DRAWINGS	G2

GENERAL NOTES

1. BATHYMETRY SURVEYED BY ENVIRONMENTAL DATA SOLUTIONS ON JUNE 23, 2008 AND REPRESENTS CONDITIONS ON THAT DATE.
2. KING PILE TYPE (36 INCH OD x 0.75 INCH WT) AND SPACING SHOWN ON THE PLANS WILL BE ADJUSTED ON THE BASIS OF IN-SITU SOIL BORING DATA AS SOON AS THIS INFORMATION BECOMES AVAILABLE.

VERTICAL DATUM

 
PROJECT ELEVATIONS ARE BASED ON NAVD’88.

HORIZONTAL DATUM

PROJECT COORDINATES ARE BASED ON THE CALIFORNIA STATE PLANE COORDINATE SYSTEM NAD 1983, ZONE 3.

DESIGN CONDITIONS

LIVE LOADS: CATWALK: 100 PSF
BOAT RAMP: 5,000 LBS
CONCENTRATED WHEEL LOAD (TOTAL 2 PER AXLE)



WATER ELEVATION: GATES AND SHEET PILES/ KING PILES/ ABUTMENT WALL:
DIFFERENTIAL WATER ELEVATION = 3.6 FT

EARTHQUAKE: QUASI – STATIC LATERAL SEISMIC
ACCELERATION, SA = 0.3g BASED ON 2006 IBC

CURRENT: CURRENT OF 2 KNOTS (3.4 FT/SEC) FREE STREAM VELOCITY

SHIP IMPACT: DOLPHINS/MONOPILES: ACCIDENTAL IMPACT 95 KIP LOAD
AT EL +7.0’

OPERATING LOAD: GATE/ FRAME: HYDRAULIC ACTUATORS (PISTON FORCES)


OLD RIVER SITE $F_1 = +226.2 \text{ KIP}$ $F_2 = -149.2 \text{ KIP}$
 -149.2 KIP $+226.2 \text{ KIP}$
 (COMPRESSION +, TENSION –)

CONNECTION $F_1 = +157.1 \text{ KIP}$ $F_2 = -109.6 \text{ KIP}$
SLOUGH SITE -109.6 KIP $+157.1 \text{ KIP}$
 (COMPRESSION +, TENSION –)

ABBREVIATIONS


&	AND	NAD	NORTH AMERICAN DATUM
#	NUMBER	NAVD	NORTH AMERICAN VERTICAL DATUM
%	PERCENT	NTS	NOT TO SCALE
APPROX	APPROXIMATE	OC	ON CENTER
ASTM	ASTM INTERNATIONAL	OD	OUTSIDE DIAMETER
C/C	CENTER TO CENTER	OG	ORIGINAL GROUND
CJP	COMPLETE JOINT PENETRATION	OPP	OPPOSITE
⌀	CENTER LINE	PC/PS	PRECAST/PRESTRESSED
CIP	CAST-IN-PLACE	PL	PLATE
CLR	CLEAR	PJP	PARTIAL JOINT PENETRATION
CONC	CONCRETE	PSF	POUNDS PER SQUARE FOOT
CONT	CONTINUOUS	REF	REFERENCE
DIA, ⌀	DIAMETER	REINF	REINFORCEMENT
DIMS	DIMENSIONS	SA	SEISMIC ACCELERATION
DWG	DRAWING	SCH	SCHEDULE
DWT	DEAD WEIGHT	SIM	SIMILAR
(E)	EXISTING	SPA	SPACES
EL	ELEVATION	STD	STANDARD
EJ	EXPANSION JOINT	STIF	STIFFENER
EW	EACH WAY	SYMM	SYMMETRICAL
FG	FINISH GRADE	THRU	THROUGH
FT	FOOT OR FEET	TYP	TYPICAL
GALV	GALVANIZED	UHMW	ULTRA HIGH MOLECULAR WEIGHT
H	HORIZONTAL	UON	UNLESS OTHERWISE NOTED
HD	HEAD	V	VERTICAL
HDPE	HIGH DENSITY POLYETHYLENE	VC	VERTICAL CURVE
HW	HIGH WATER	WP	WORK POINT
IBC	INTERNATIONAL BUILDING CODE	WT	WALL THICKNESS
ID	INSIDE DIAMETER	W/	WITH
INFO	INFORMATION		
LB	POUND		
LW	LOW WATER		
MAX	MAXIMUM		
MFG	MANUFACTURING		
MIN	MINIMUM		

CROSS-REFERENCE LEGEND

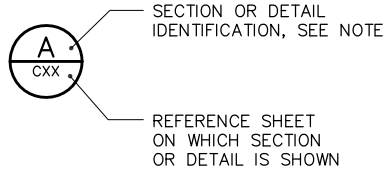

NOTE: LETTER INDICATES SECTION; NUMBER INDICATES DETAIL. WHERE THERE IS NO REFERENCE SHEET INDICATED, IT MEANS THE DETAIL OR SECTION IS TAKEN AND SHOWN ON THE SAME SHEET.

LEGEND

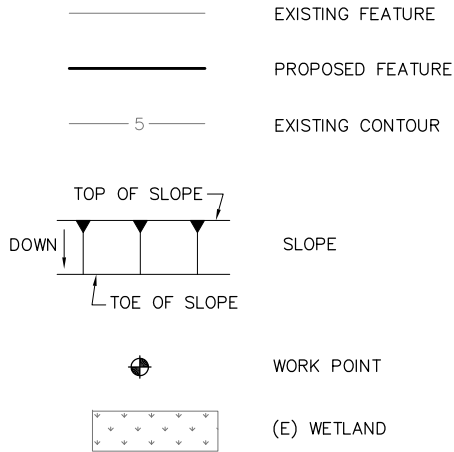

100% SUBMITTAL IF SHEET IS LESS THAN 22” x 34”
IT IS A REDUCED PRINT –
SCALE REDUCED ACCORDINGLY.

REVISION	DESCRIPTION	BY	DATE



San Luis & Delta-Mendota Water Authority
842 6th Street, Suite 7
PO Box 2157
Los Banos, California 93635

APPROVED _____
FRANCY C. MIZUNO, PE C35136
San Luis & Delta-Mendota Water Authority

APPROVED _____
DENNIS G. MAJORS PE C21297
Metropolitan Water District of Southern California



2001 N. Main Street, Suite 360
Walnut Creek, California 94596
(925) 944-5411


DSGN	TDB	DR	AB	CHK	GTH
JOB NO. 6097-03		SUBMITTED BY RMR			

TWO GATE FISH PROTECTION PLAN	DATE 08/31/09
	SHEET 3 OF 78
ABBREVIATIONS, LEGEND AND GENERAL NOTES	G3

P:\6097-03 SWC GATE DESIGN\CADD\DWG\609703-G4.DWG 8/27/2009 2:33 PM



 PROJECT GENERAL PLAN
SCALE: 1"= 1000'



100% SUBMITTAL IF SHEET IS LESS THAN 22" x 34"
IT IS A REDUCED PRINT -
SCALE REDUCED ACCORDINGLY.

REVISION	DESCRIPTION	BY	DATE



San Luis & Delta-Mendota Water Authority
842 6th Street, Suite 7
PO Box 2157
Los Banos, California 93635

APPROVED _____
FRANCY C. MIZUNO, PE C35136
San Luis & Delta-Mendota Water Authority

APPROVED _____
DENNIS G. MAJORS PE C21297
Metropolitan Water District of Southern California



2001 N. Main Street, Suite 360
Walnut Creek, California 94596
(925) 944-5411

DSGN	TDB	DR	EP	CHK	GTH
JOB NO.	6097-03	SUBMITTED BY	RMR		

TWO GATE FISH PROTECTION PLAN


DATE 08/31/09

SHEET 4 OF 78


PROJECT GENERAL PLAN

G4

P:\6097-03 SWC GATE DESIGN\CADD\DWG\609703-C1.DWG 8/30/2009 9:08 PM

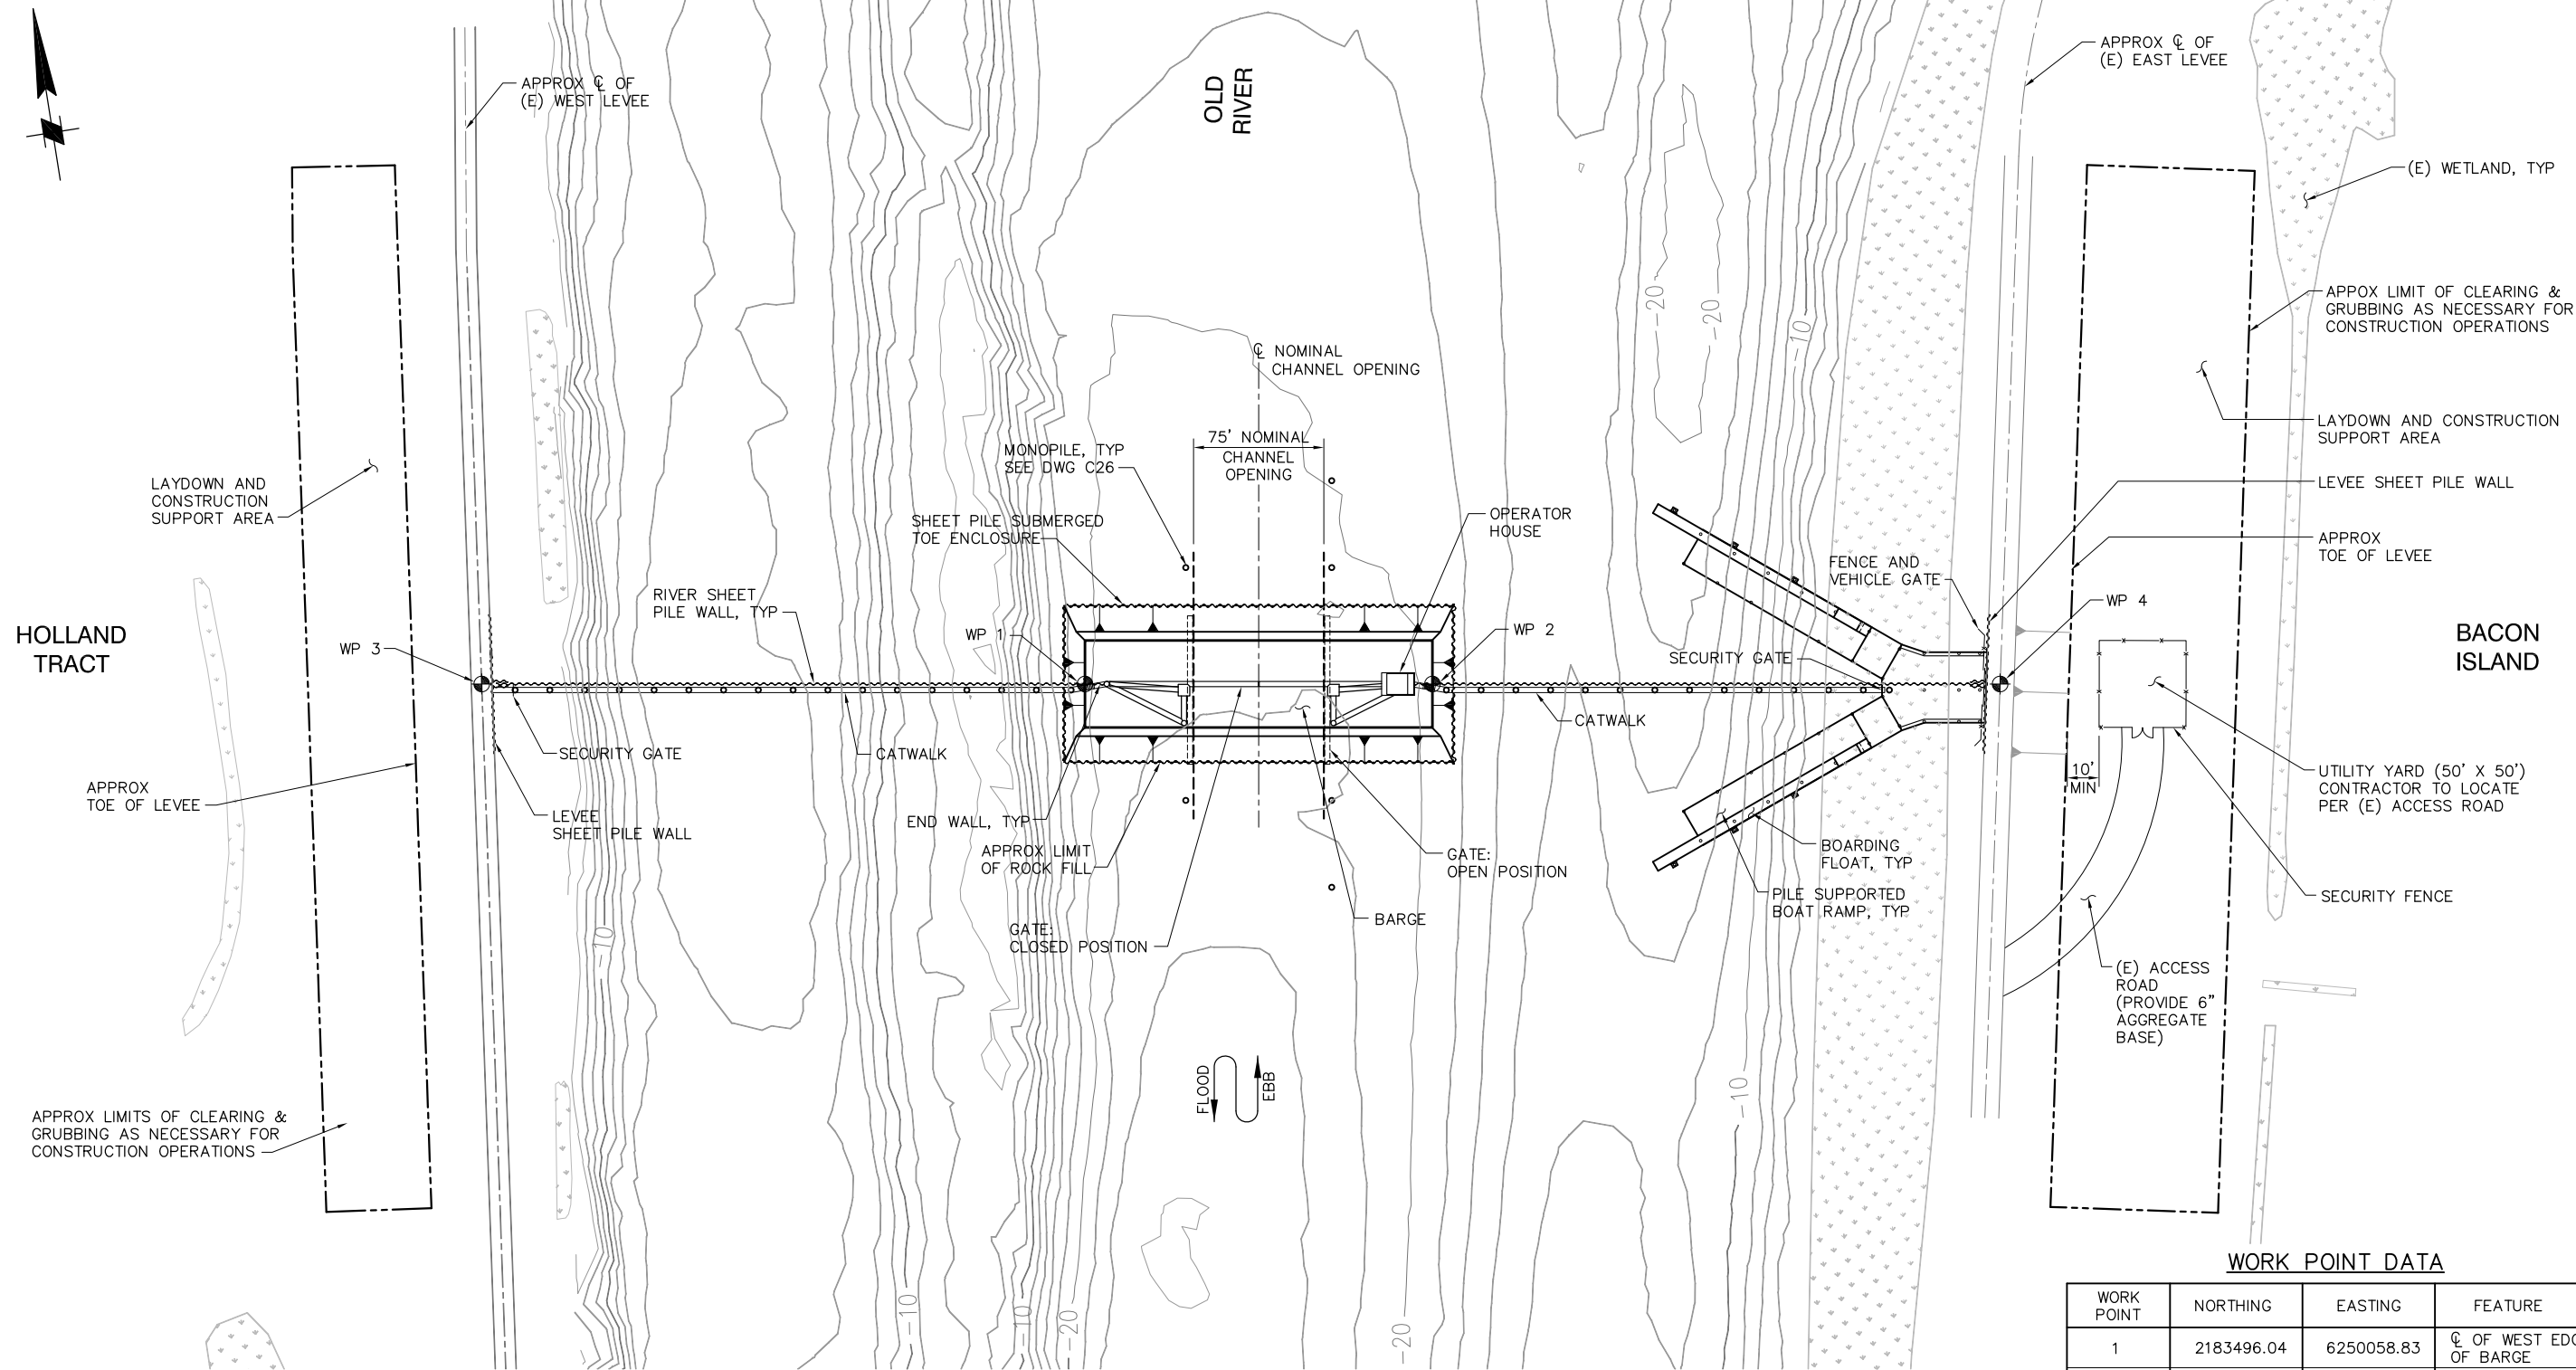

SITE PLAN
SCALE: 1"= 50'

 

WORK POINT DATA

WORK POINT	NORTHING	EASTING	FEATURE
1	2183496.04	6250058.83	CL OF WEST EDGE OF BARGE
2	2183465.50	6250256.48	CL OF EAST EDGE OF BARGE
3	2183549.08	6249715.65	CL OF WEST LEVEE AND GATE
4	2183415.60	6250579.41	CL OF EAST LEVEE AND GATE

100% SUBMITTAL

IF SHEET IS LESS THAN 22" x 34"
IT IS A REDUCED PRINT -
SCALE REDUCED ACCORDINGLY.

REVISION	DESCRIPTION	BY	DATE



San Luis & Delta-Mendota Water Authority
842 6th Street, Suite 7
PO Box 2157
Los Banos, California 93635

APPROVED _____
FRANCY C. MIZUNO, PE C35136
San Luis & Delta-Mendota Water Authority

APPROVED _____
DENNIS G. MAJORS PE C21297
Metropolitan Water District of Southern California



2001 N. Main Street, Suite 360
Walnut Creek, California 94596
(925) 944-5411

DSGN	TDB	DR	EP/AB	CHK	GTH
JOB NO.	6097-03	SUBMITTED BY	RMR		



TWO GATE FISH PROTECTION PLAN

OLD RIVER
SITE PLAN


DATE 08/31/09

SHEET 5 OF 78

C1

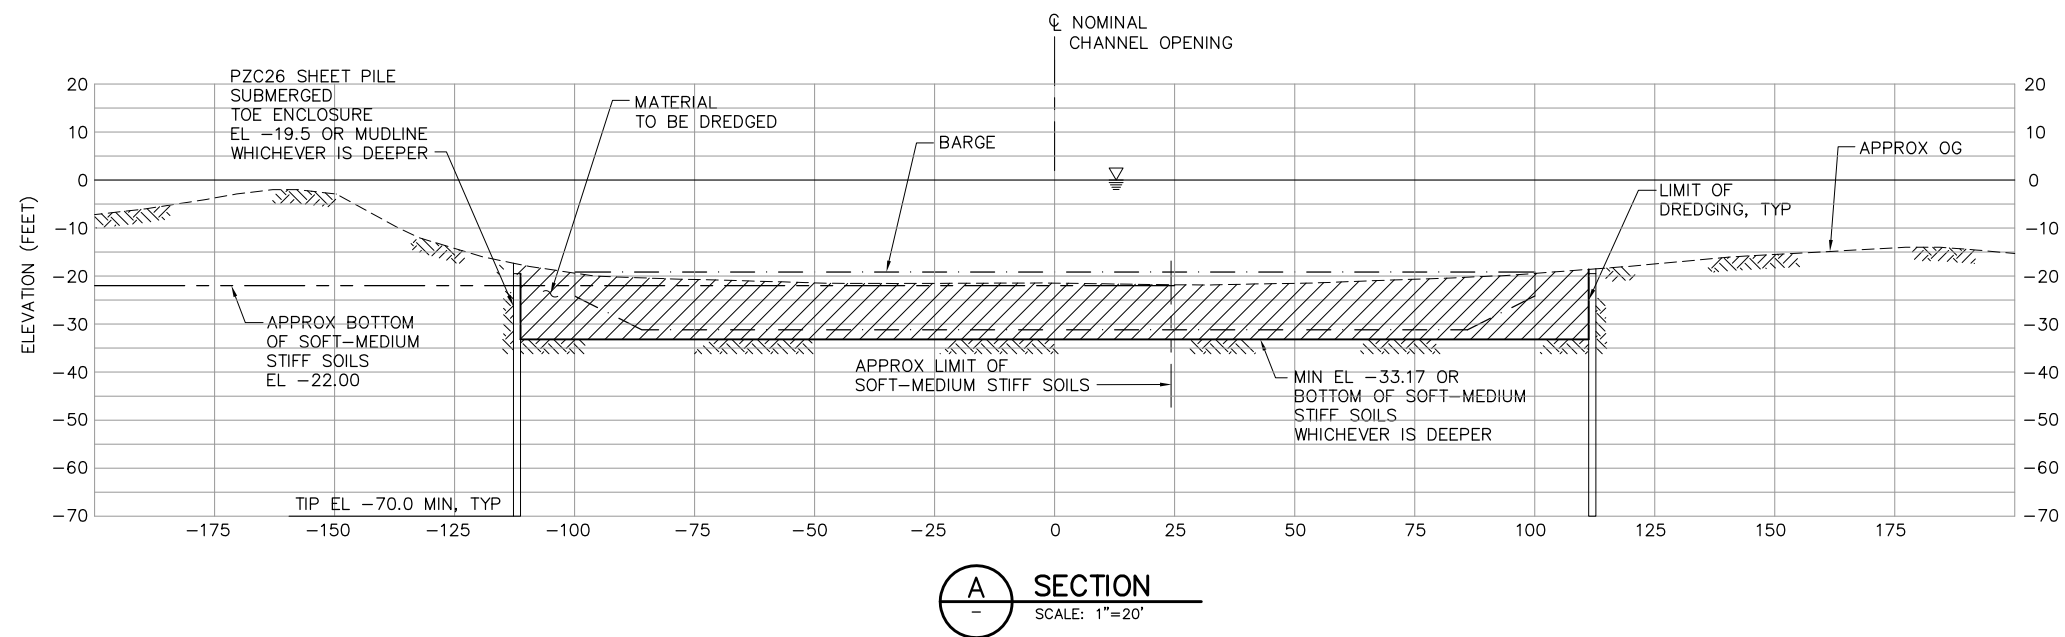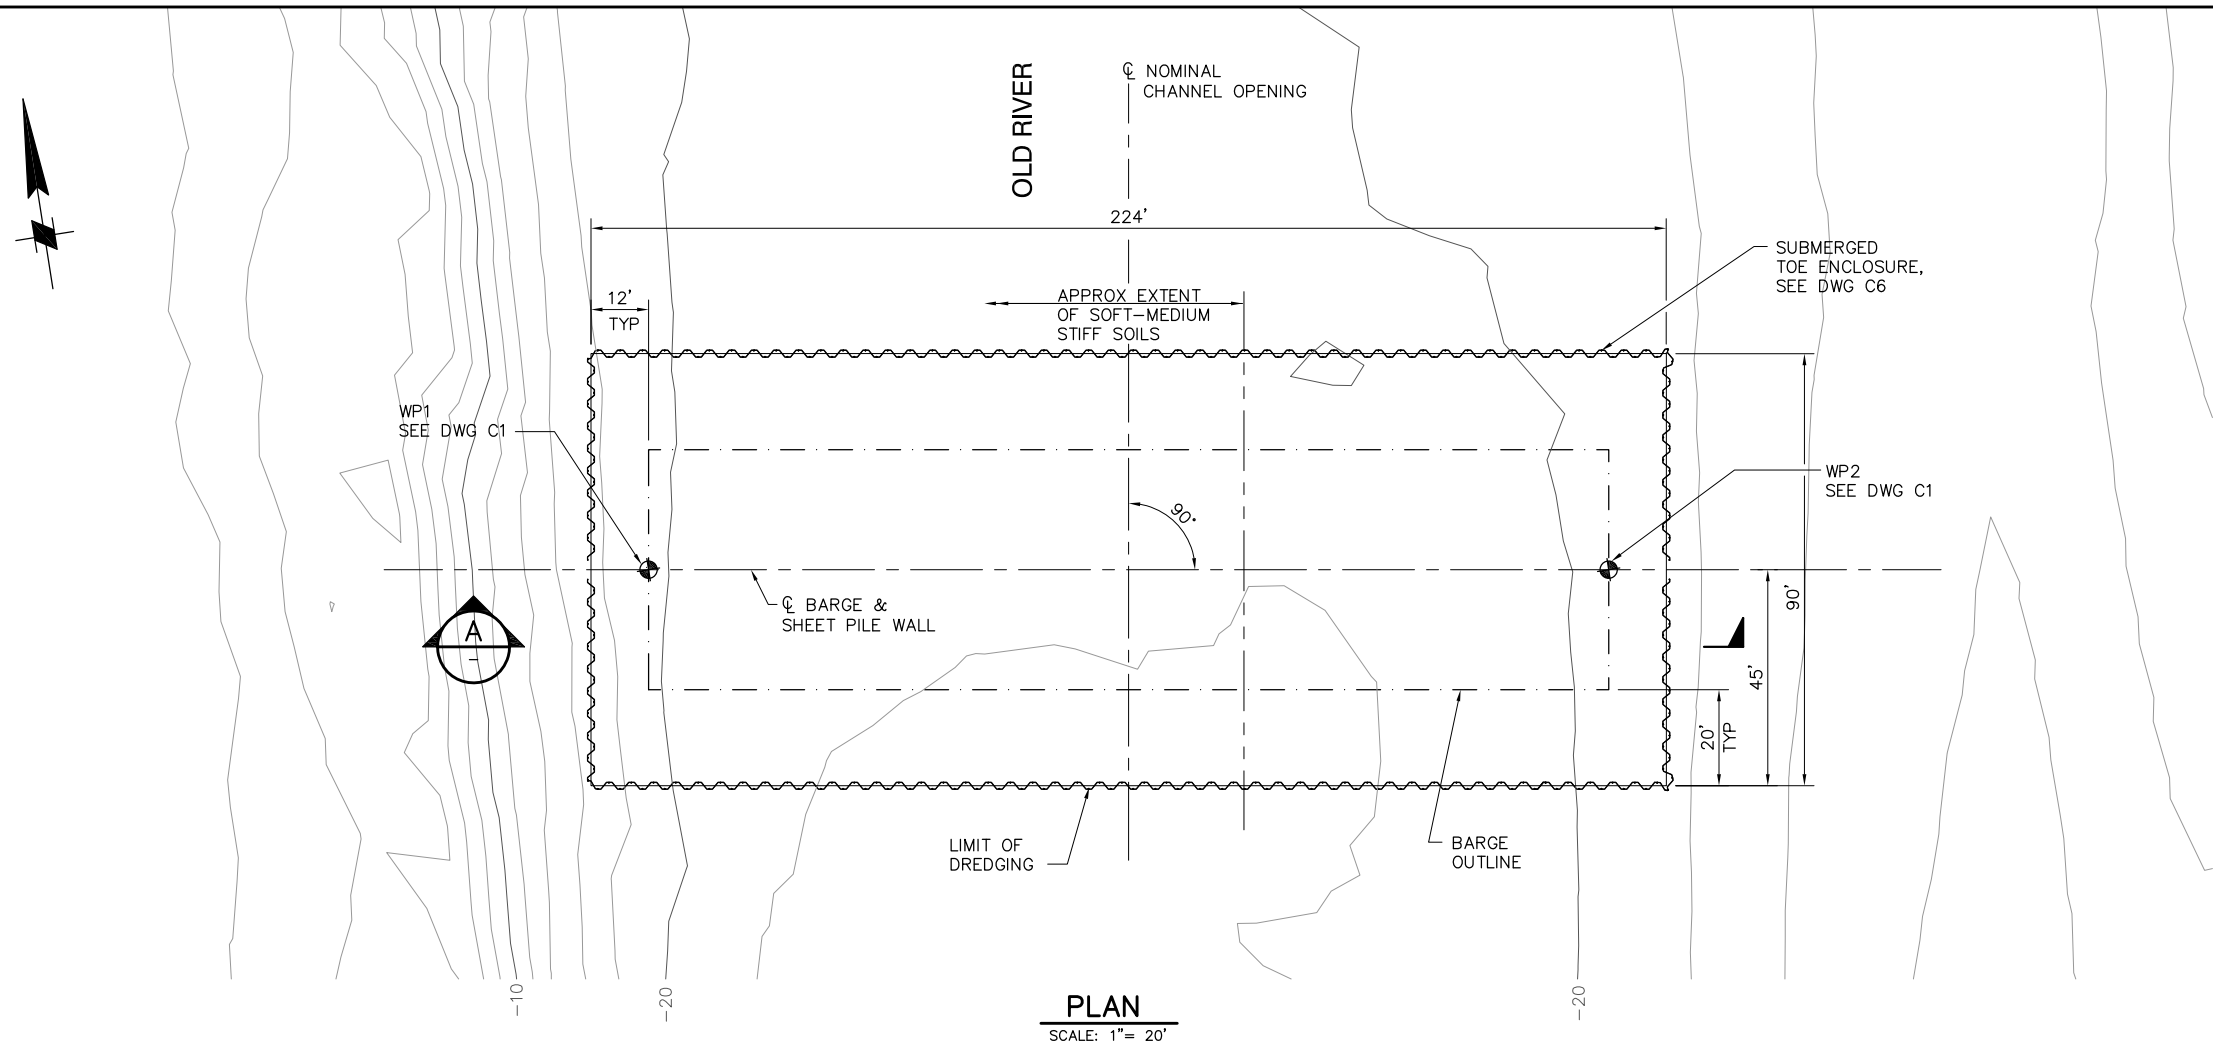


 NOTE:
GATE AND ALL OTHER FEATURES
NOT SHOWN FOR CLARITY.







100% SUBMITTAL

 IF SHEET IS LESS THAN 22" x 34"
IT IS A REDUCED PRINT –
SCALE REDUCED ACCORDINGLY.

REVISION	DESCRIPTION	BY	DATE	 San Luis & Delta-Mendota Water Authority 842 6th Street, Suite 7 PO Box 2157 Los Banos, California 93635 APPROVED _____ FRANCY C. MIZUNO, PE C35136 San Luis & Delta-Mendota Water Authority APPROVED _____ DENNIS G. MAJORS PE C21297 Metropolitan Water District of Southern California	 2001 N. Main Street, Suite 360 Walnut Creek, California 94596 (925) 944-5411	TWO GATE FISH PROTECTION PLAN			DATE 08/31/09	
								SHEET 6 OF 78		
								OLD RIVER DREDGING PLAN AND SECTION		C2

 P:\6097-03 SWC GATE DESIGN\CADD\DWG\609703-C3.DWG 8/31/2009 11:23 AM

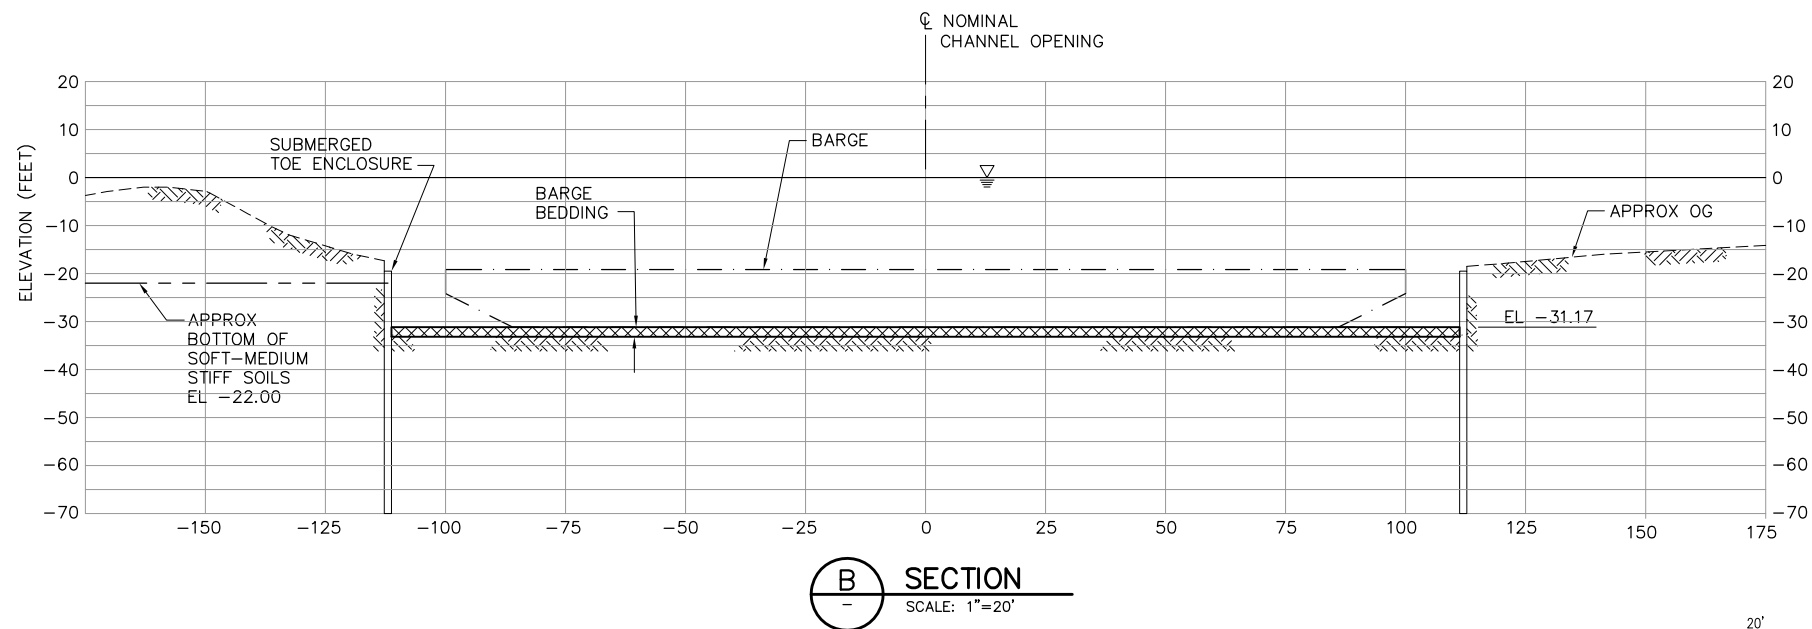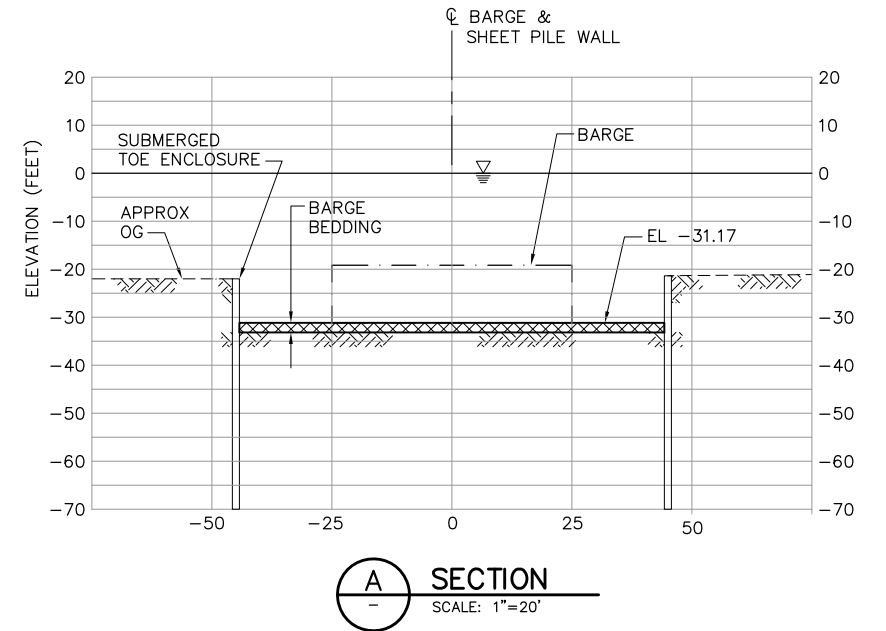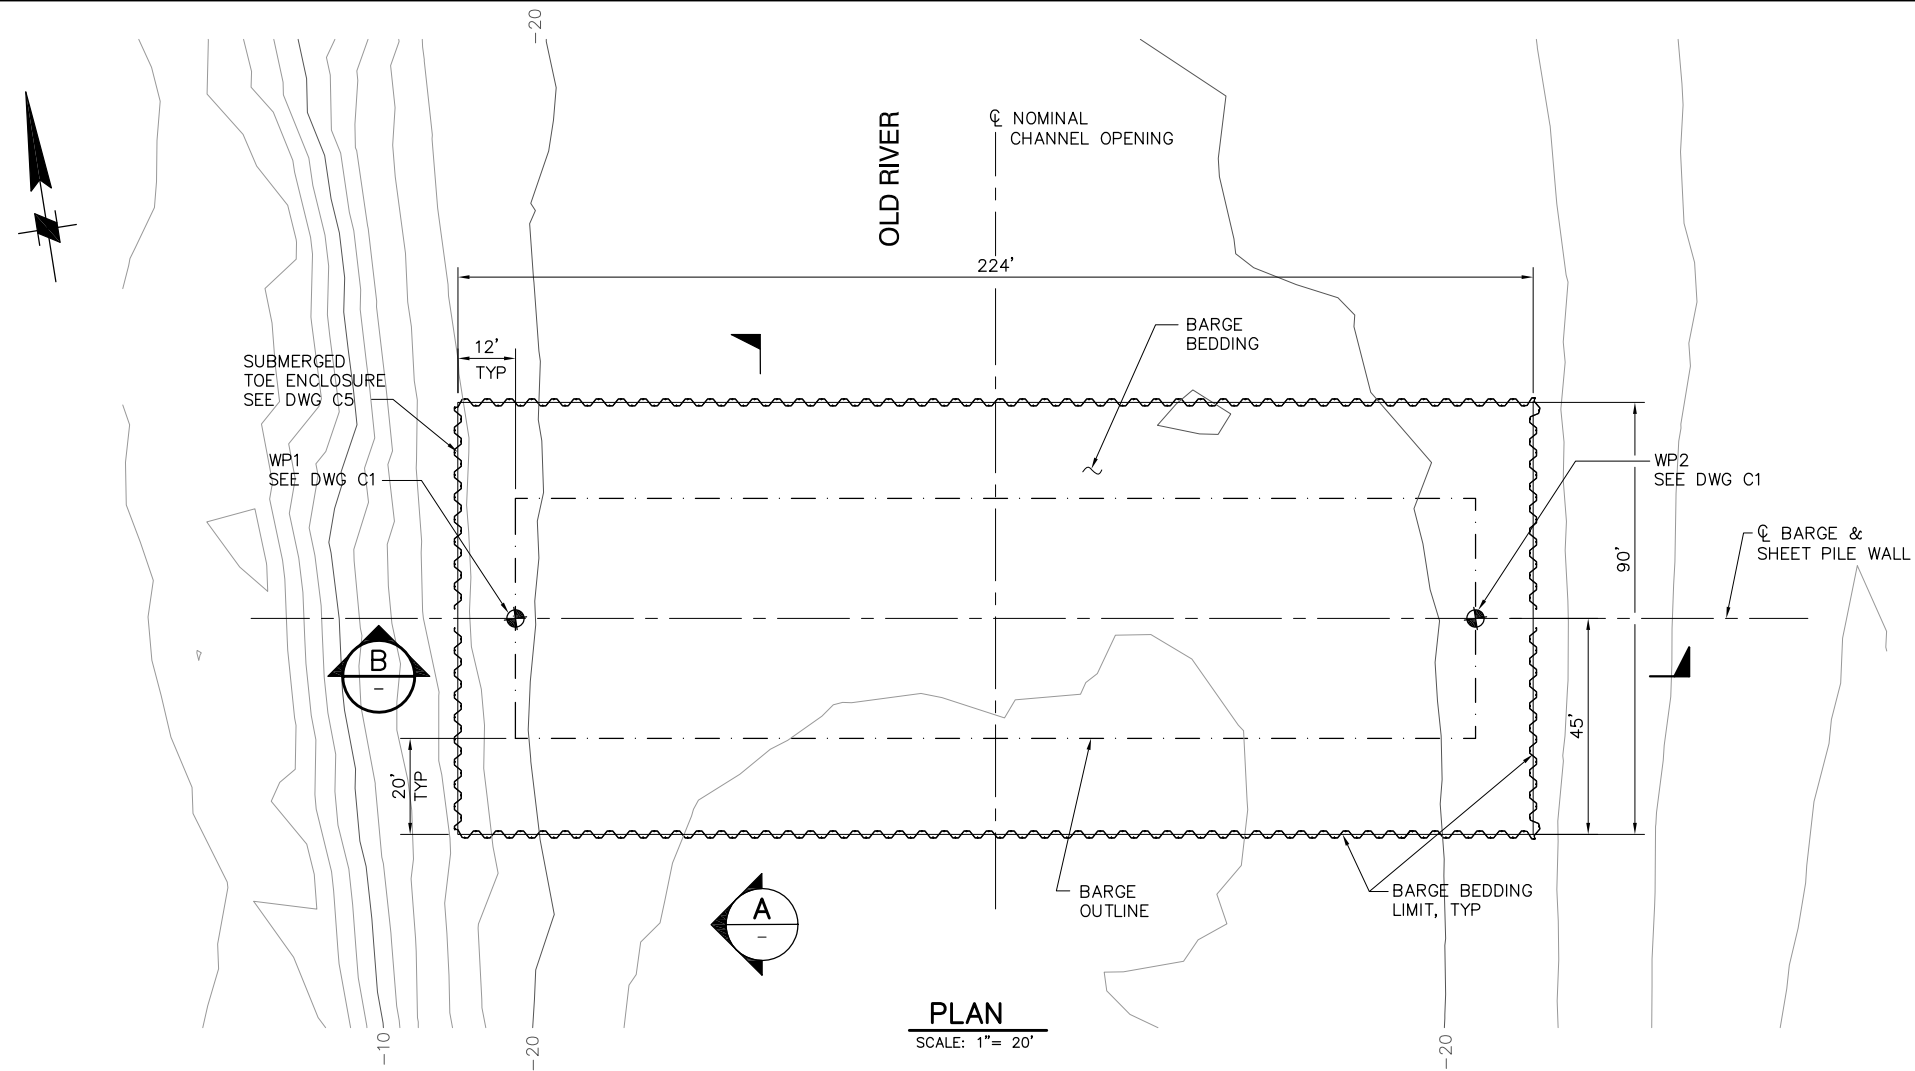

NOTE:
GATE AND ALL OTHER FEATURES
NOT SHOWN FOR CLARITY.

100% SUBMITTAL IF SHEET IS LESS THAN 22" x 34"
IT IS A REDUCED PRINT -
SCALE REDUCED ACCORDINGLY.

REVISION	DESCRIPTION	BY	DATE



San Luis & Delta-Mendota Water Authority
842 6th Street, Suite 7
PO Box 2157
Los Banos, California 93635

APPROVED _____
FRANCY C. MIZUNO, PE C35136
San Luis & Delta-Mendota Water Authority

APPROVED _____
DENNIS G. MAJORS PE C21297
Metropolitan Water District of Southern California






2001 N. Main Street, Suite 360
Walnut Creek, California 94596
(925) 944-5411

DSGN	TDB	DR	AB	CHK	GTH
JOB NO.		SUBMITTED BY			
6097-03		RMR			


TWO GATE FISH PROTECTION PLAN		DATE 08/31/09
OLD RIVER BARGE BEDDING PLAN AND SECTIONS		SHEET 7 OF 78
		C3

P:\6097-03 SWC GATE DESIGN\CADD\DWG\609703-C4.DWG 8/28/2009 7:31 PM

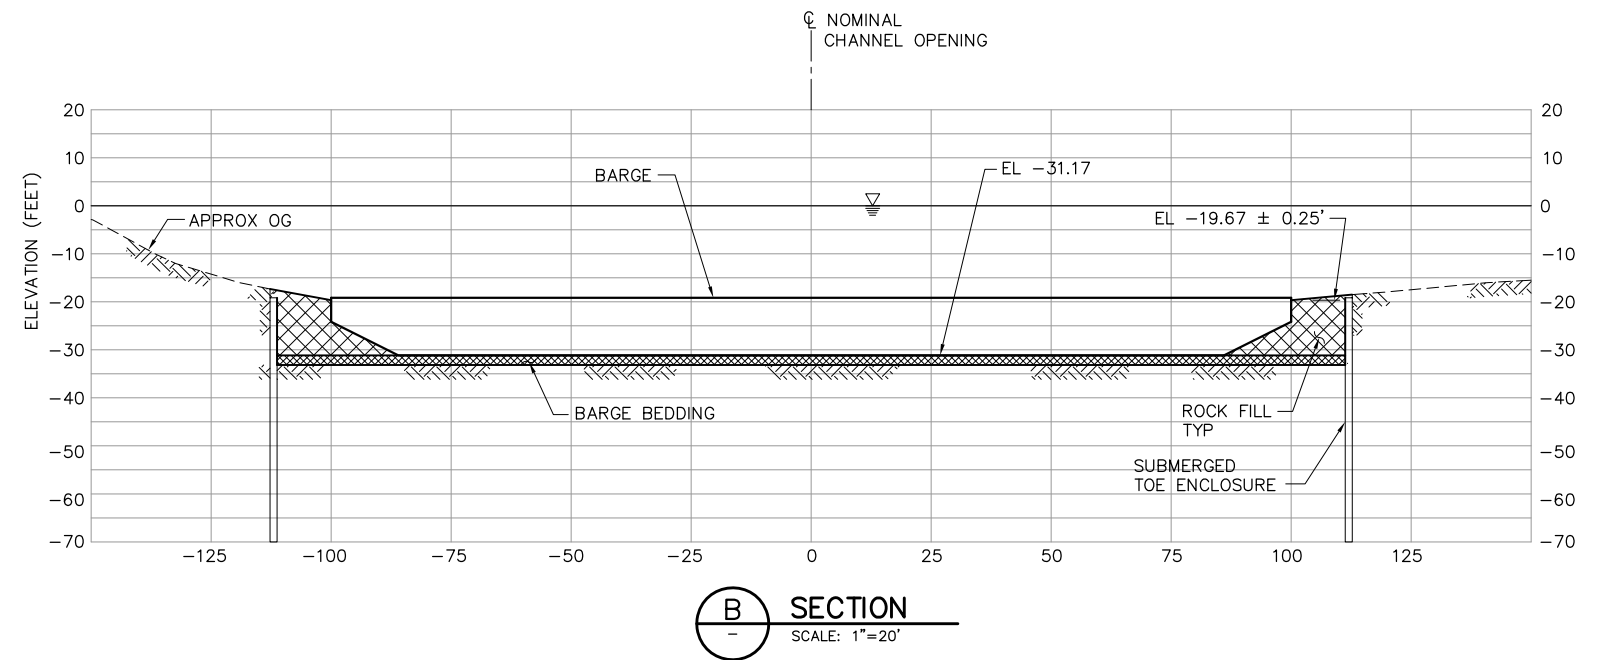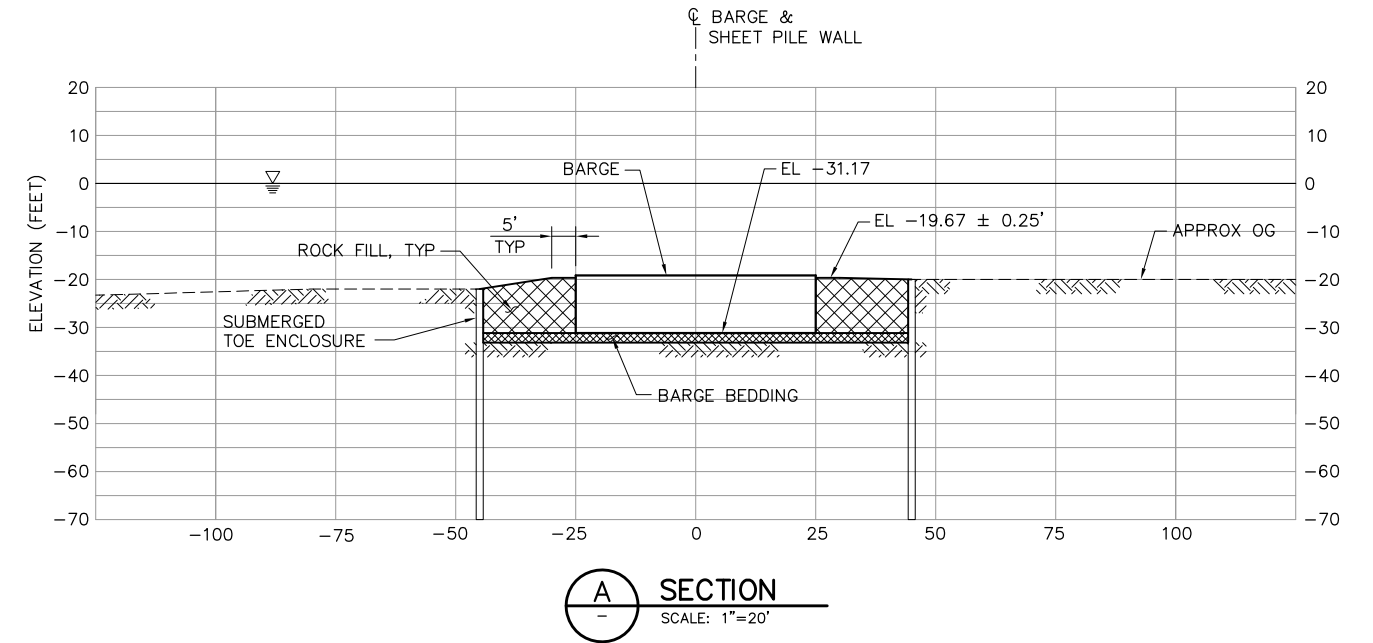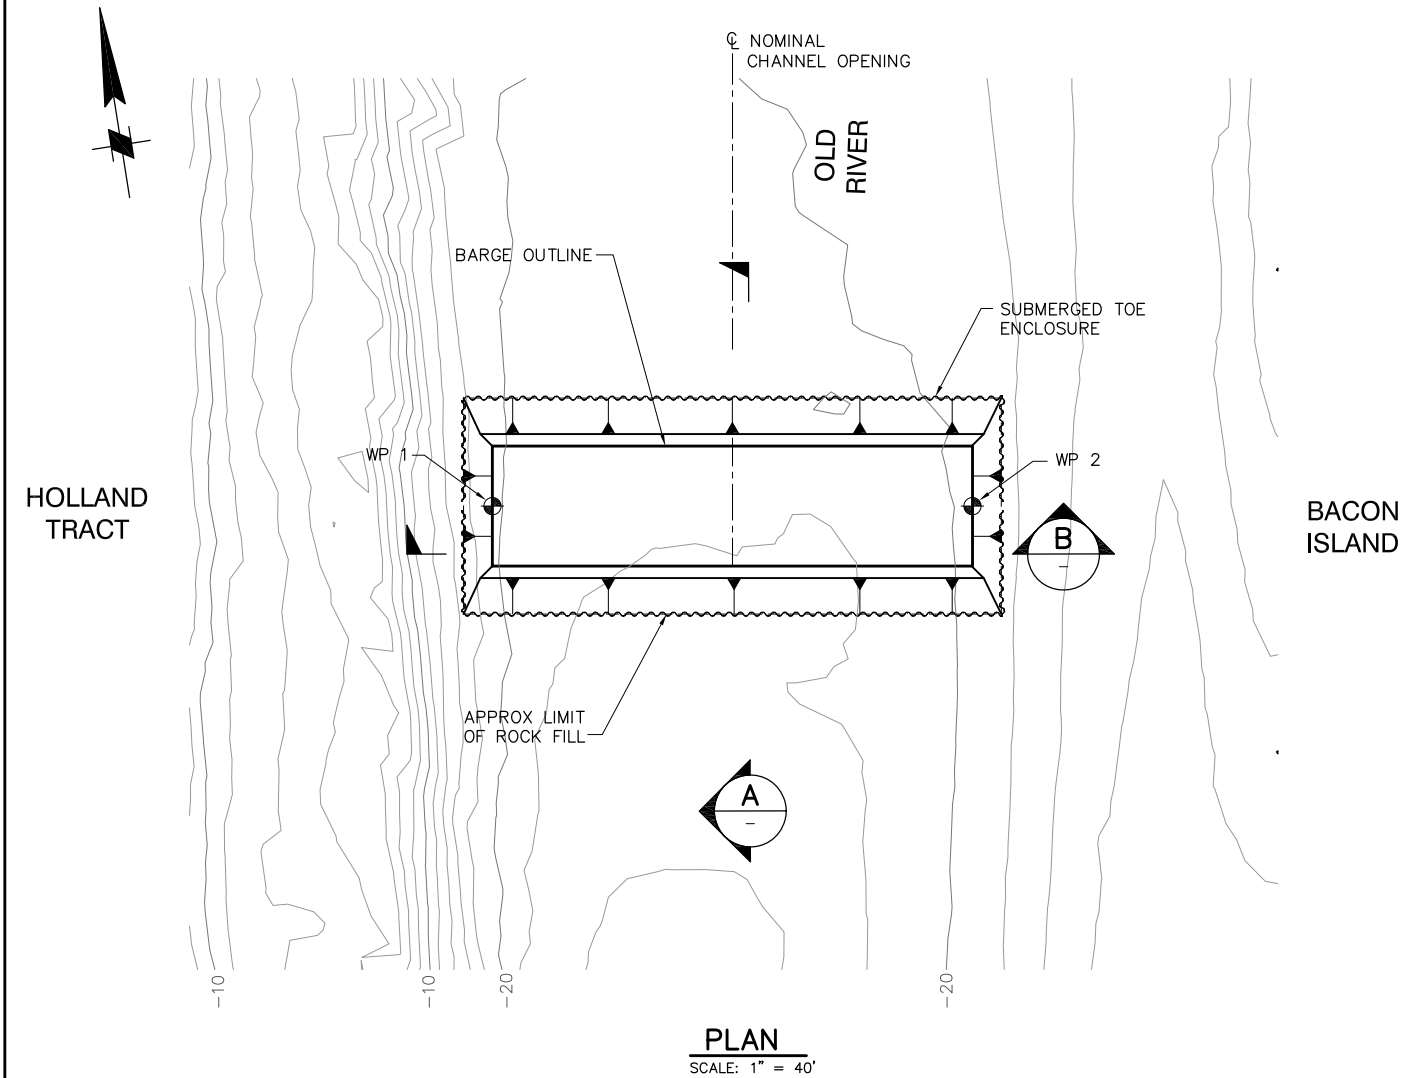

NOTES:

 1. KING PILES AND SHEET PILES NEAR BARGE SHALL BE PLACED BEFORE ROCK LOCKING FILL.
2. GATE AND ALL OTHER FEATURES NOT SHOWN FOR CLARITY



100% SUBMITTAL

IF SHEET IS LESS THAN 22" x 34"
IT IS A REDUCED PRINT -
SCALE REDUCED ACCORDINGLY.

REVISION	DESCRIPTION	BY	DATE



San Luis & Delta-Mendota Water Authority
842 6th Street, Suite 7
PO Box 2157
Los Banos, California 93635

APPROVED _____
FRANCY C. MIZUNO, PE C35136
San Luis & Delta-Mendota Water Authority

APPROVED _____
DENNIS G. MAJORS PE C21297
Metropolitan Water District of Southern California



2001 N. Main Street, Suite 360
Walnut Creek, California 94596
(925) 944-5411

DSGN	JMB	DR	EP/AB	CHK	TDB
JOB NO.	6097-03	SUBMITTED BY	RMR		

TWO GATE FISH PROTECTION PLAN

DATE 08/31/09


SHEET 8 OF 78

OLD RIVER
BARGE - ROCK FILL
PLAN AND SECTIONS

C4

P:\6097-03 SWC GATE DESIGN\CADD\DWG\609703-C5.DWG 8/31/2009 11:24 AM


HOLLAND
TRACT

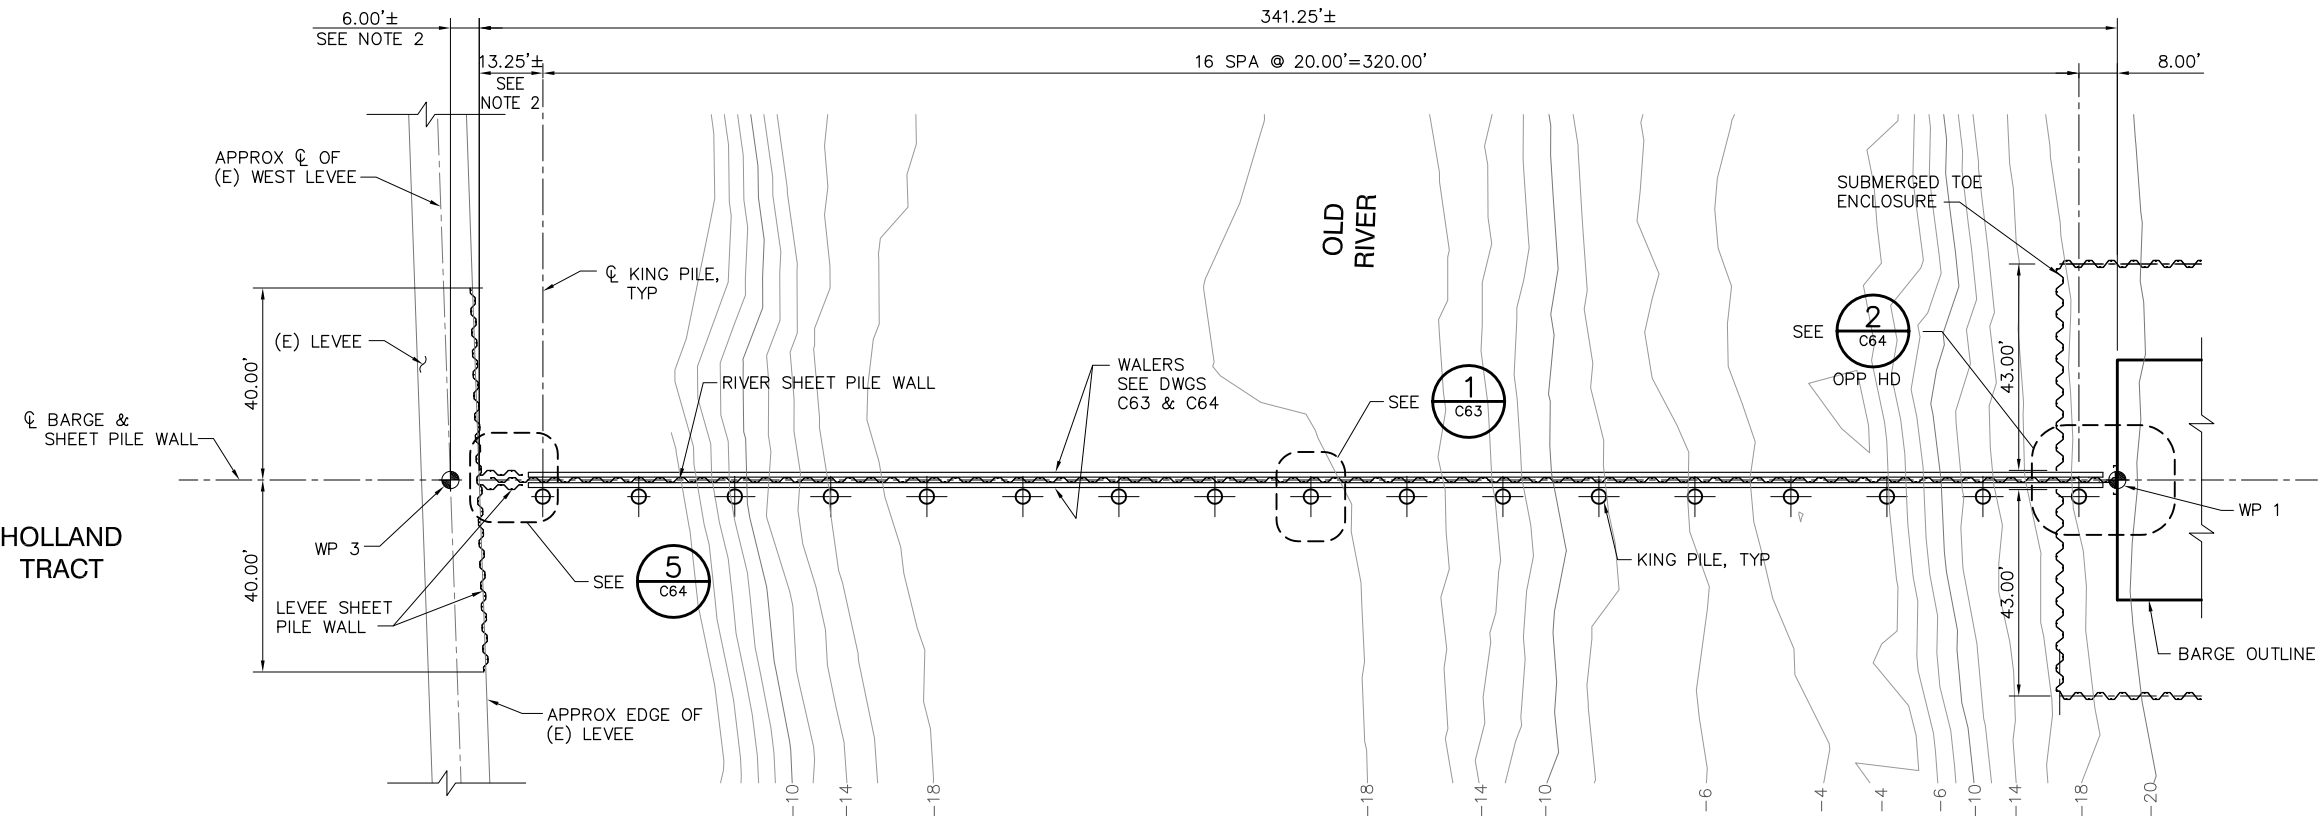

PLAN

SCALE: 1" = 20'

NOTE:
CATWALK NOT SHOWN
FOR CLARITY.

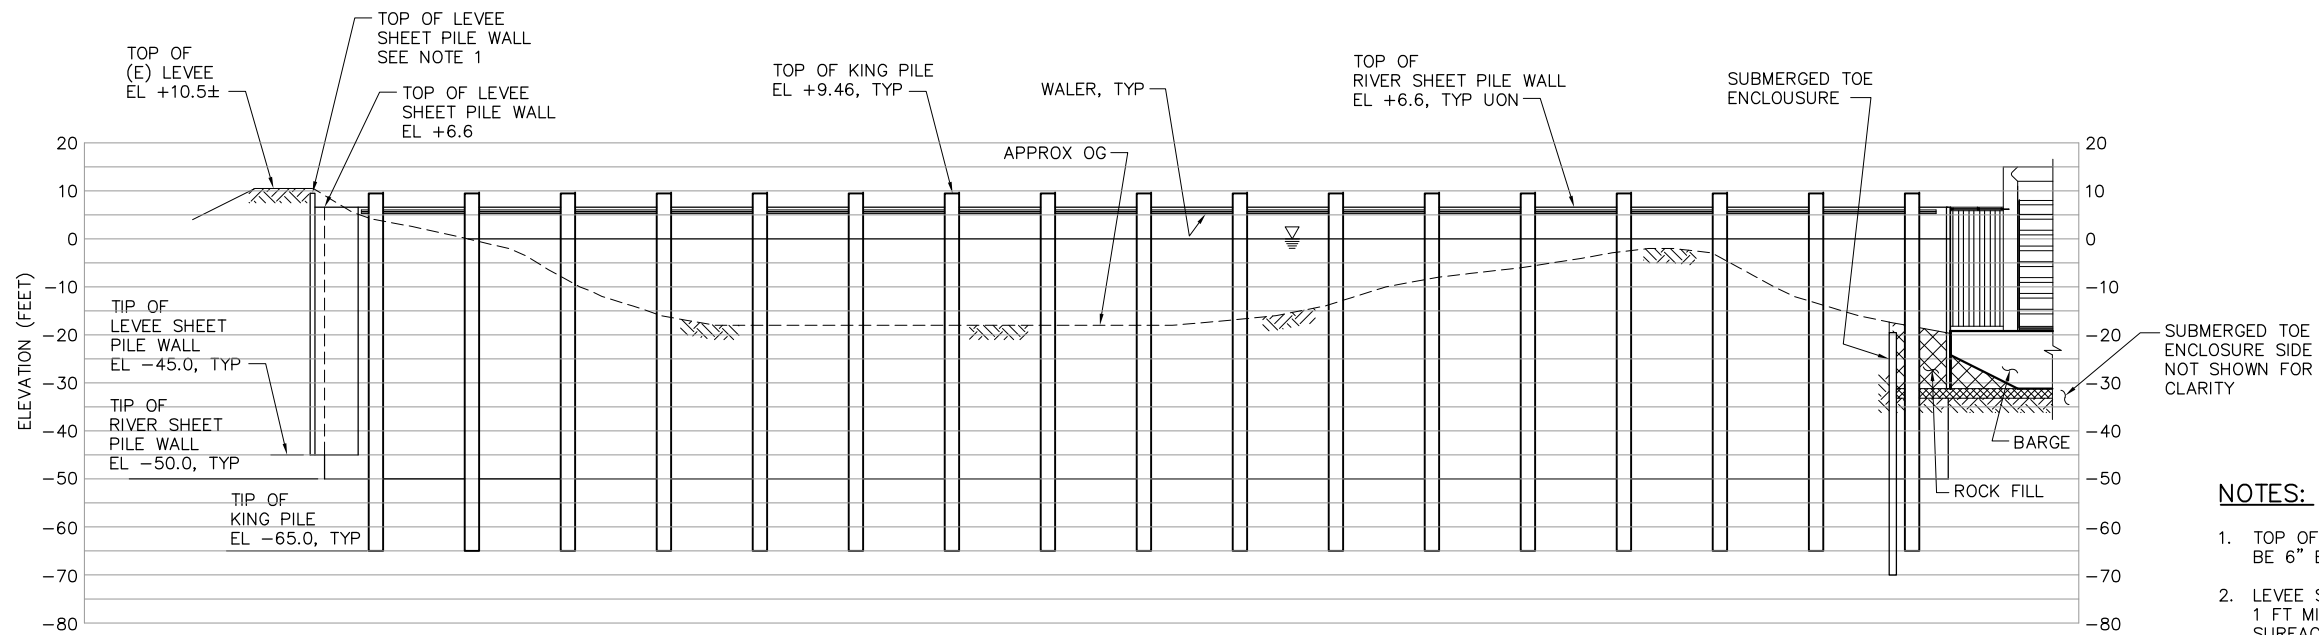

ELEVATION

SCALE: 1" = 20'

NOTE:
CATWALK NOT SHOWN
FOR CLARITY.



SCALE: 1" = 20'

100% SUBMITTAL

IF SHEET IS LESS THAN 22" x 34"
IT IS A REDUCED PRINT -
SCALE REDUCED ACCORDINGLY.

NOTES:

1. TOP OF LEVEE SHEET PILE WALL SHALL BE 6" BELOW TOP OF (E) LEVEE UON.
2. LEVEE SHEET PILE WALL TO BE LOCATED 1 FT MIN OFF THE EDGE OF (E) ROAD SURFACE.

REVISION	DESCRIPTION	BY	DATE



San Luis & Delta-Mendota Water Authority
842 6th Street, Suite 7
PO Box 2157
Los Banos, California 93635

APPROVED _____
FRANCY C. MIZUNO, PE C35136
San Luis & Delta-Mendota Water Authority

APPROVED _____
DENNIS G. MAJORS PE C21297
Metropolitan Water District of Southern California



2001 N. Main Street, Suite 360
Walnut Creek, California 94596
(925) 944-5411

DSGN JMB DR EP/AB CHK TDB
JOB NO. 6097-03 SUBMITTED BY RMR


TWO GATE FISH PROTECTION PLAN

OLD RIVER
SHEET PILE WALL ARRANGEMENT
PLAN AND ELEVATION, SHEET 1


DATE 08/31/09

SHEET 9 OF 78


C5

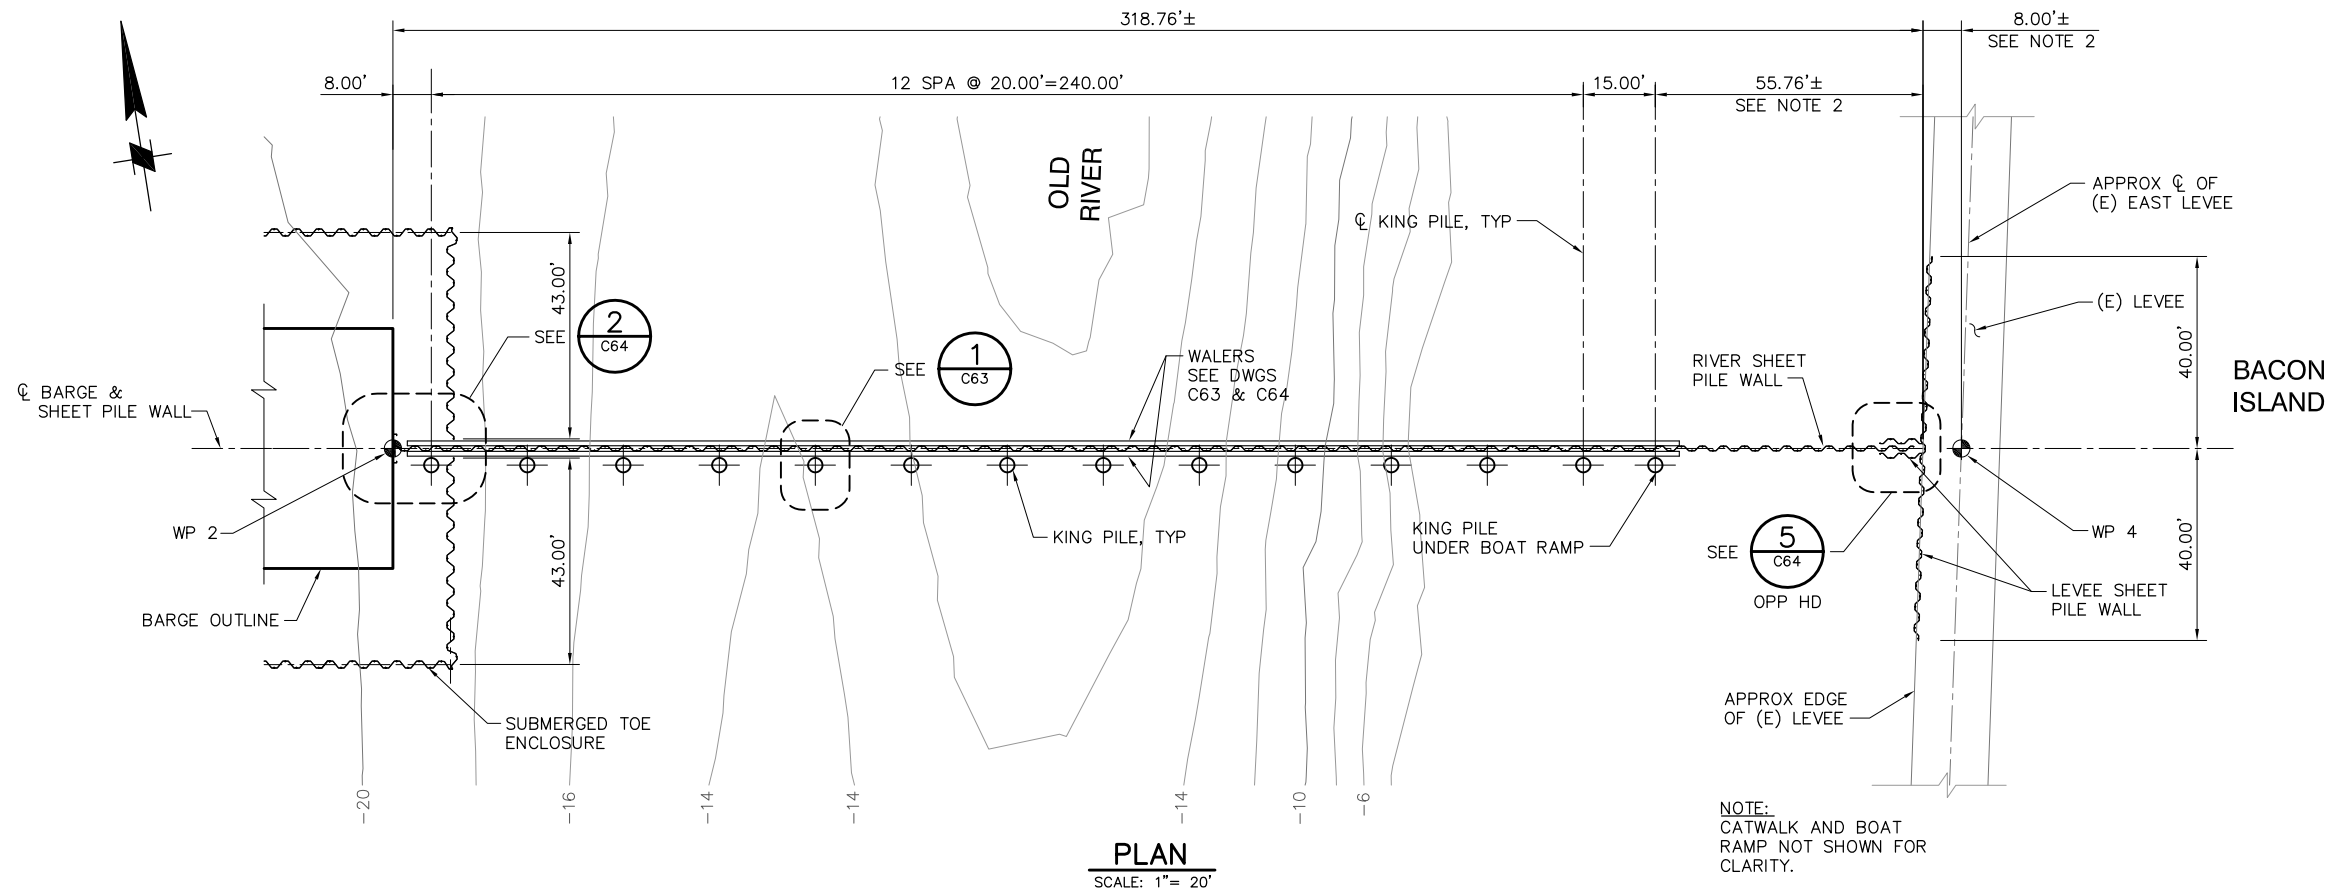

NOTE:
CATWALK AND BOAT
RAMP NOT SHOWN FOR
CLARITY.

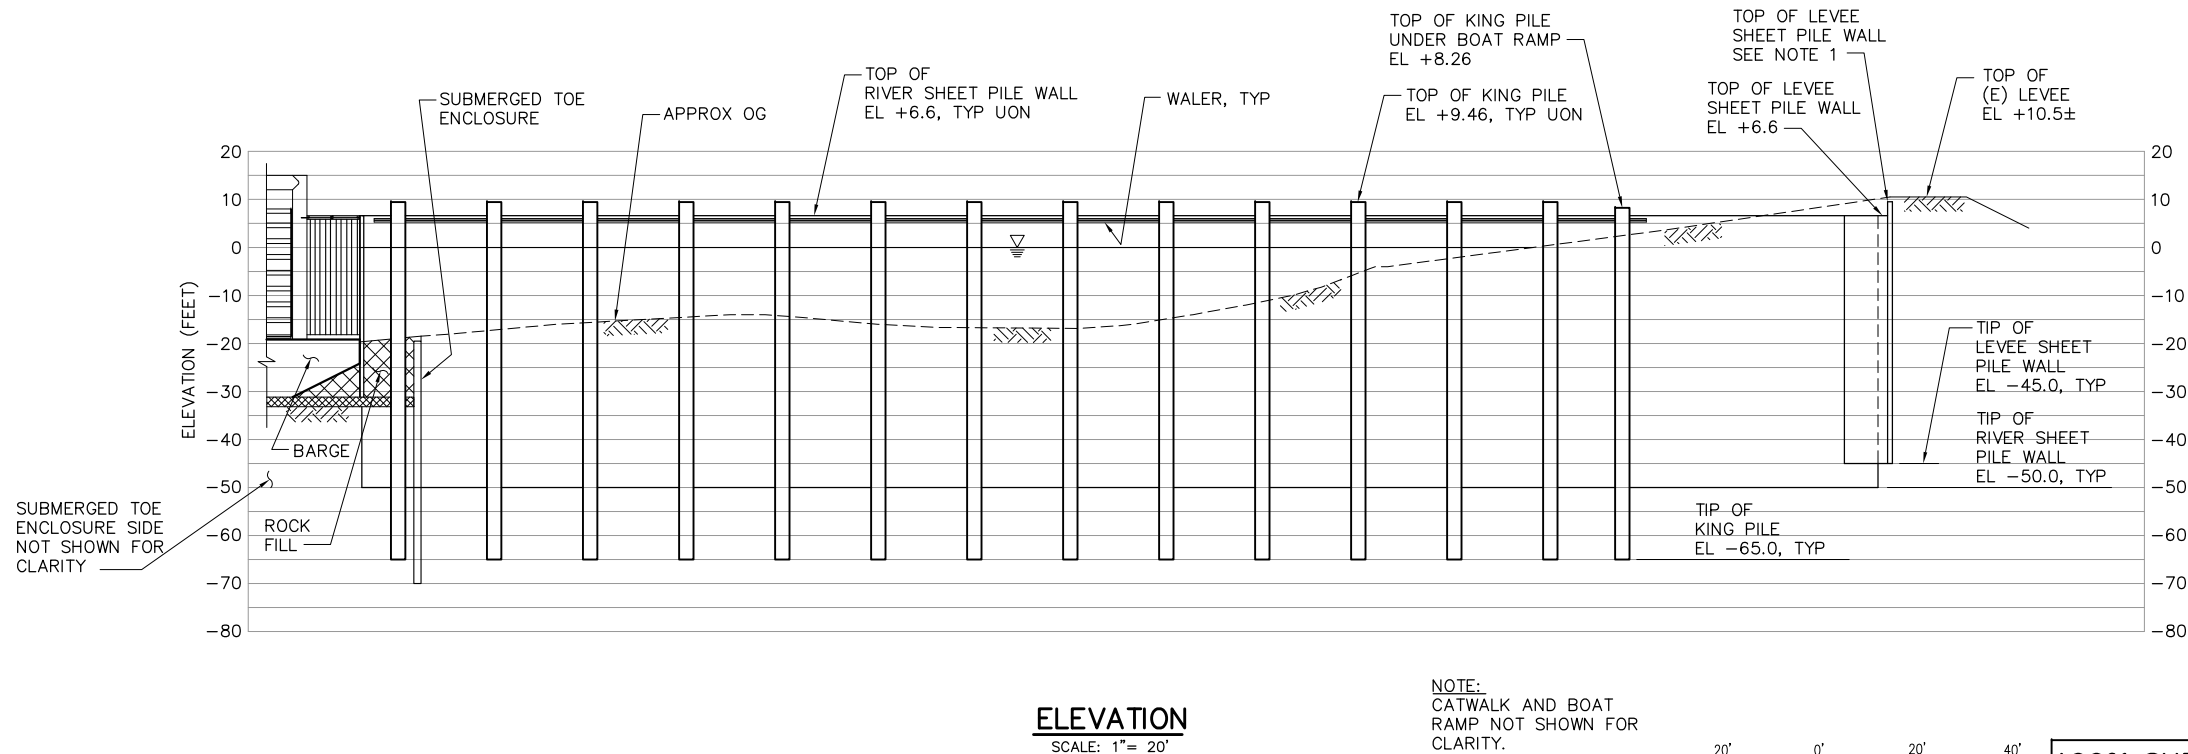

 NOTE:
CATWALK AND BOAT
RAMP NOT SHOWN FOR
CLARITY.



100% SUBMITTAL

NOTES:

1. TOP OF LEVEE SHEET PILE WALL SHALL BE 6" BELOW TOP OF (E) LEVEE UON.
2. LEVEE SHEET PILE WALL TO BE LOCATED 1 FT MIN OFF THE EDGE OF (E) ROAD SURFACE.

IF SHEET IS LESS THAN 22" x 34"
IT IS A REDUCED PRINT -
SCALE REDUCED ACCORDINGLY.

P:\6097-03 SWC GATE DESIGN\CADD\DWG\609703-C6.DWG 8/31/2009 8:36 AM

REVISION	DESCRIPTION	BY	DATE

San Luis & Delta-Mendota Water Authority
842 6th Street, Suite 7
PO Box 2157
Los Banos, California 93635

APPROVED _____
FRANCY C. MIZUNO, PE C35136
San Luis & Delta-Mendota Water Authority



APPROVED _____
DENNIS G. MAJORS PE C21297
Metropolitan Water District of Southern California

2001 N. Main Street, Suite 360
Walnut Creek, California 94596
(925) 944-5411

DSGN JMB	DR EP/AB	CHK TDB	
JOB NO. 6097-03	SUBMITTED BY RMR		


TWO GATE FISH PROTECTION PLAN OLD RIVER SHEET PILE WALL ARRANGEMENT PLAN AND ELEVATION, SHEET 2		DATE 08/31/09
		SHEET 10 OF 78
		C6

P:\6097-03 SWC GATE DESIGN\CADD\DWG\609703-C7.DWG 8/26/2009 9:22 AM

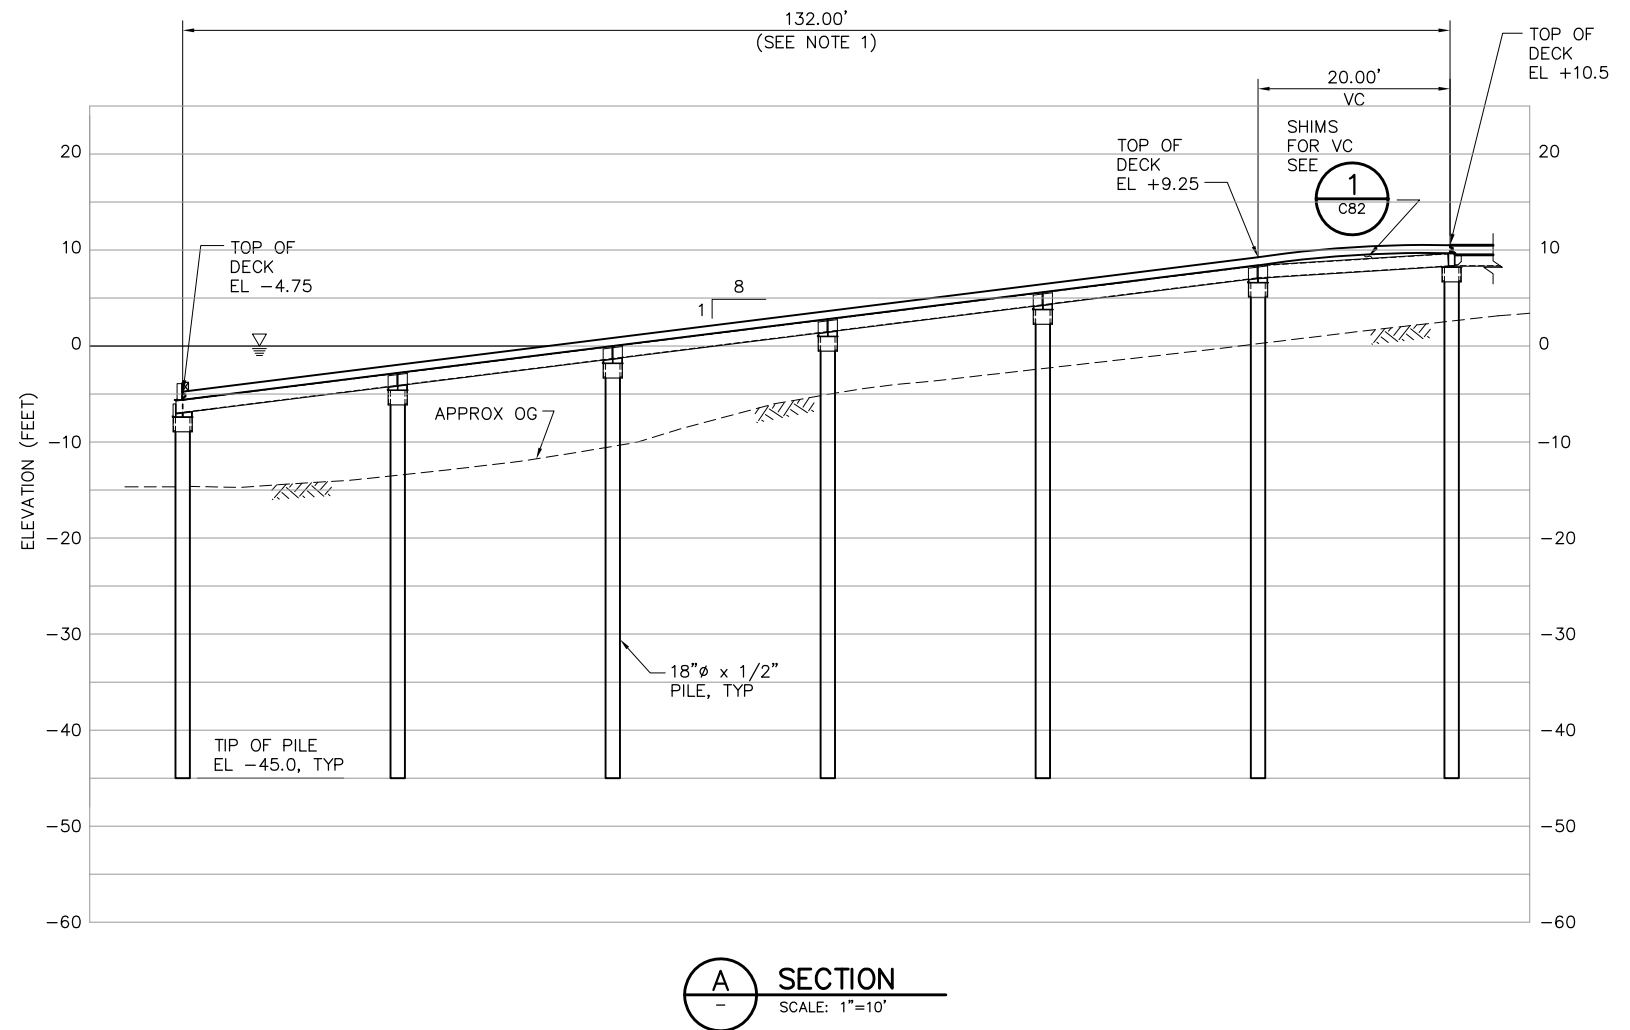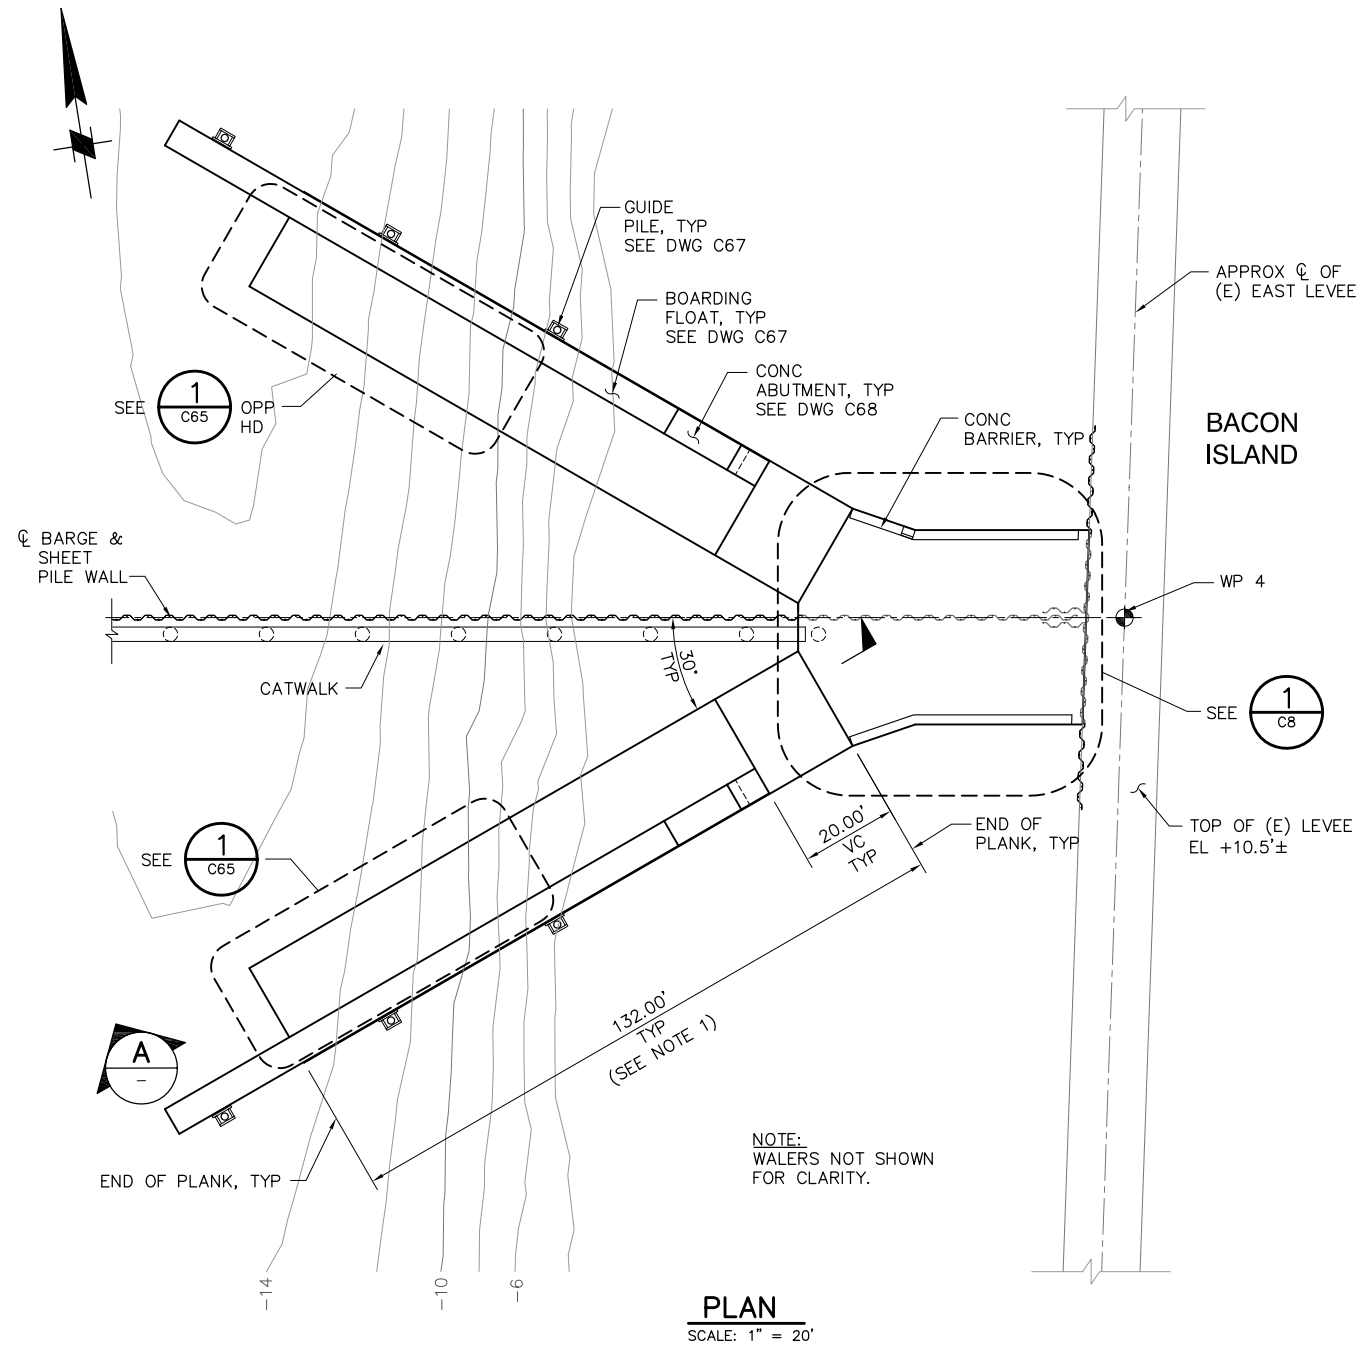

NOTES:

1. TRUE LENGTH OF RAMP ACCOUNTS FOR AN AVERAGE GAP OF 3/8" PER PLANK JOINT.

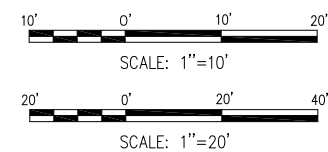

100% SUBMITTAL

IF SHEET IS LESS THAN 22" x 34"
IT IS A REDUCED PRINT -
SCALE REDUCED ACCORDINGLY.

REVISION	DESCRIPTION	BY	DATE



San Luis & Delta-Mendota Water Authority
842 6th Street, Suite 7
PO Box 2157
Los Banos, California 93635

APPROVED _____
FRANCY C. MIZUNO, PE C35136
San Luis & Delta-Mendota Water Authority

APPROVED _____
DENNIS G. MAJORS PE C21297
Metropolitan Water District of Southern California



2001 N. Main Street, Suite 360
Walnut Creek, California 94596
(925) 944-5411

DSGN	JMB	DR	EP/AB	CHK	TDB
JOB NO.	6097-03	SUBMITTED BY	RMR		

TWO GATE FISH PROTECTION PLAN

 

OLD RIVER
BOAT RAMP PLAN AND SECTION

DATE 08/31/09

SHEET 11 OF 78

C7

F:\6097-03 SWC GATE DESIGN\CADD\DWG\609703-C7.1.DWG 8/31/2009 9:15 AM

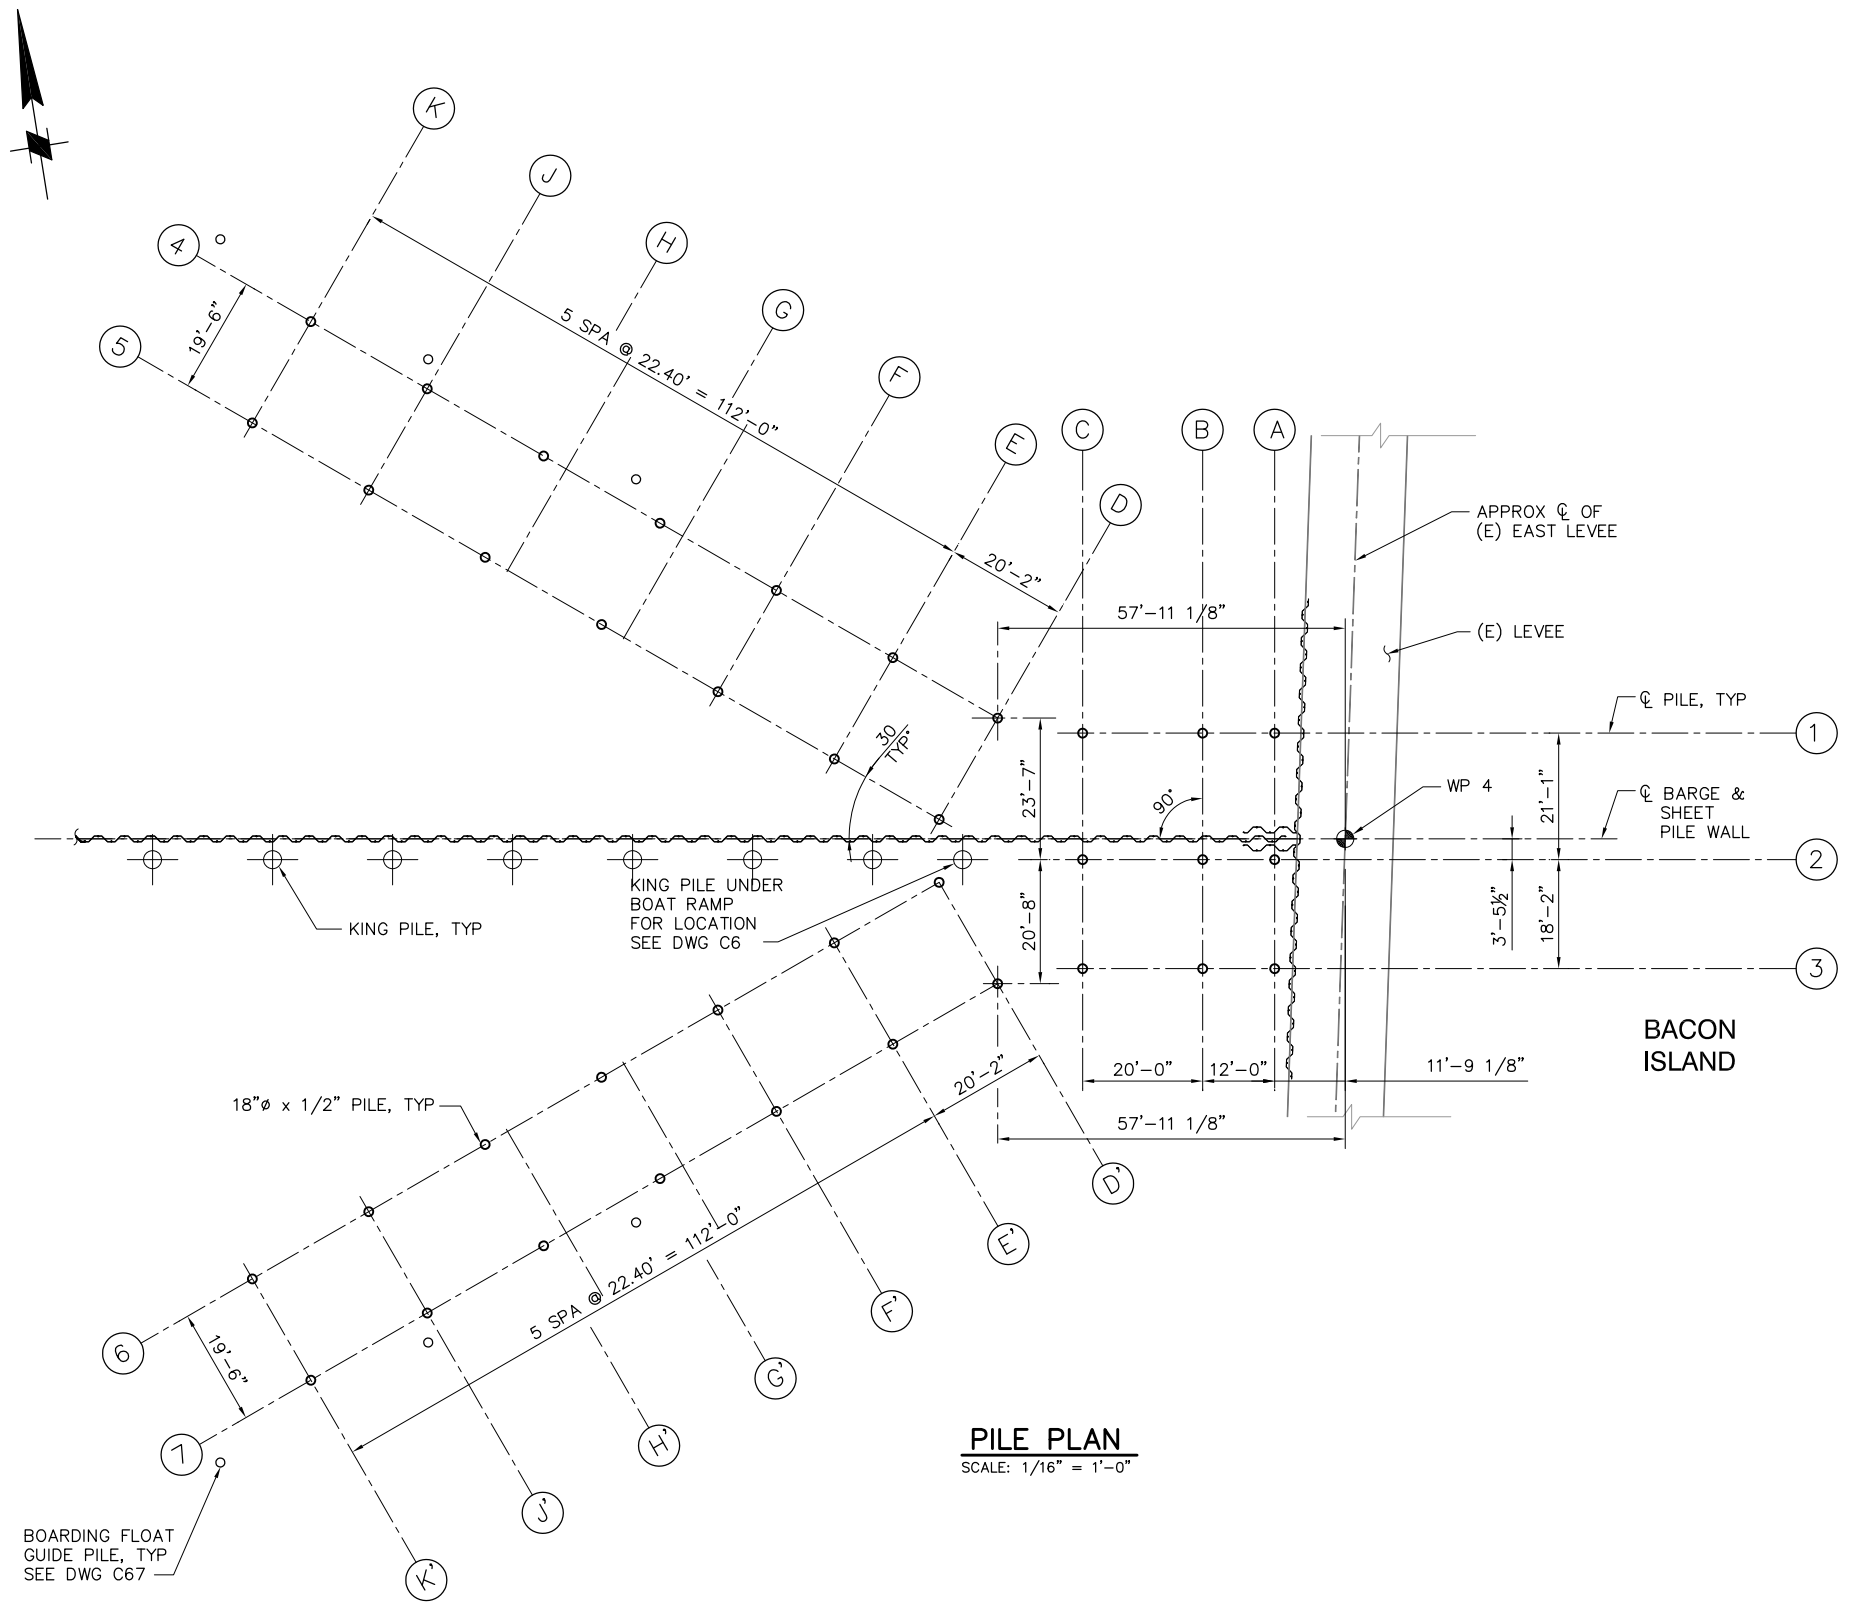

100% SUBMITTAL

IF SHEET IS LESS THAN 22" x 34"
IT IS A REDUCED PRINT -
SCALE REDUCED ACCORDINGLY.

REVISION	DESCRIPTION	BY	DATE



San Luis & Delta-Mendota Water Authority
842 6th Street, Suite 7
PO Box 2157
Los Banos, California 93635

APPROVED _____
FRANCY C. MIZUNO, PE C35136
San Luis & Delta-Mendota Water Authority

APPROVED _____
DENNIS G. MAJORS PE C21297
Metropolitan Water District of Southern California



2001 N. Main Street, Suite 360
Walnut Creek, California 94596
(925) 944-5411

DSGN	JMB	DR	EP/AB	CHK	TDB
JOB NO.	6097-03	SUBMITTED BY	RMR		

TWO GATE FISH PROTECTION PLAN


DATE 08/31/09

SHEET 12 OF 78

OLD RIVER
BOAT RAMP PILE PLAN

C7.1

P:\6097-03 SWC GATE DESIGN\CADD\DWG\609703-C7.2.DWG 8/31/2009 9:16 AM

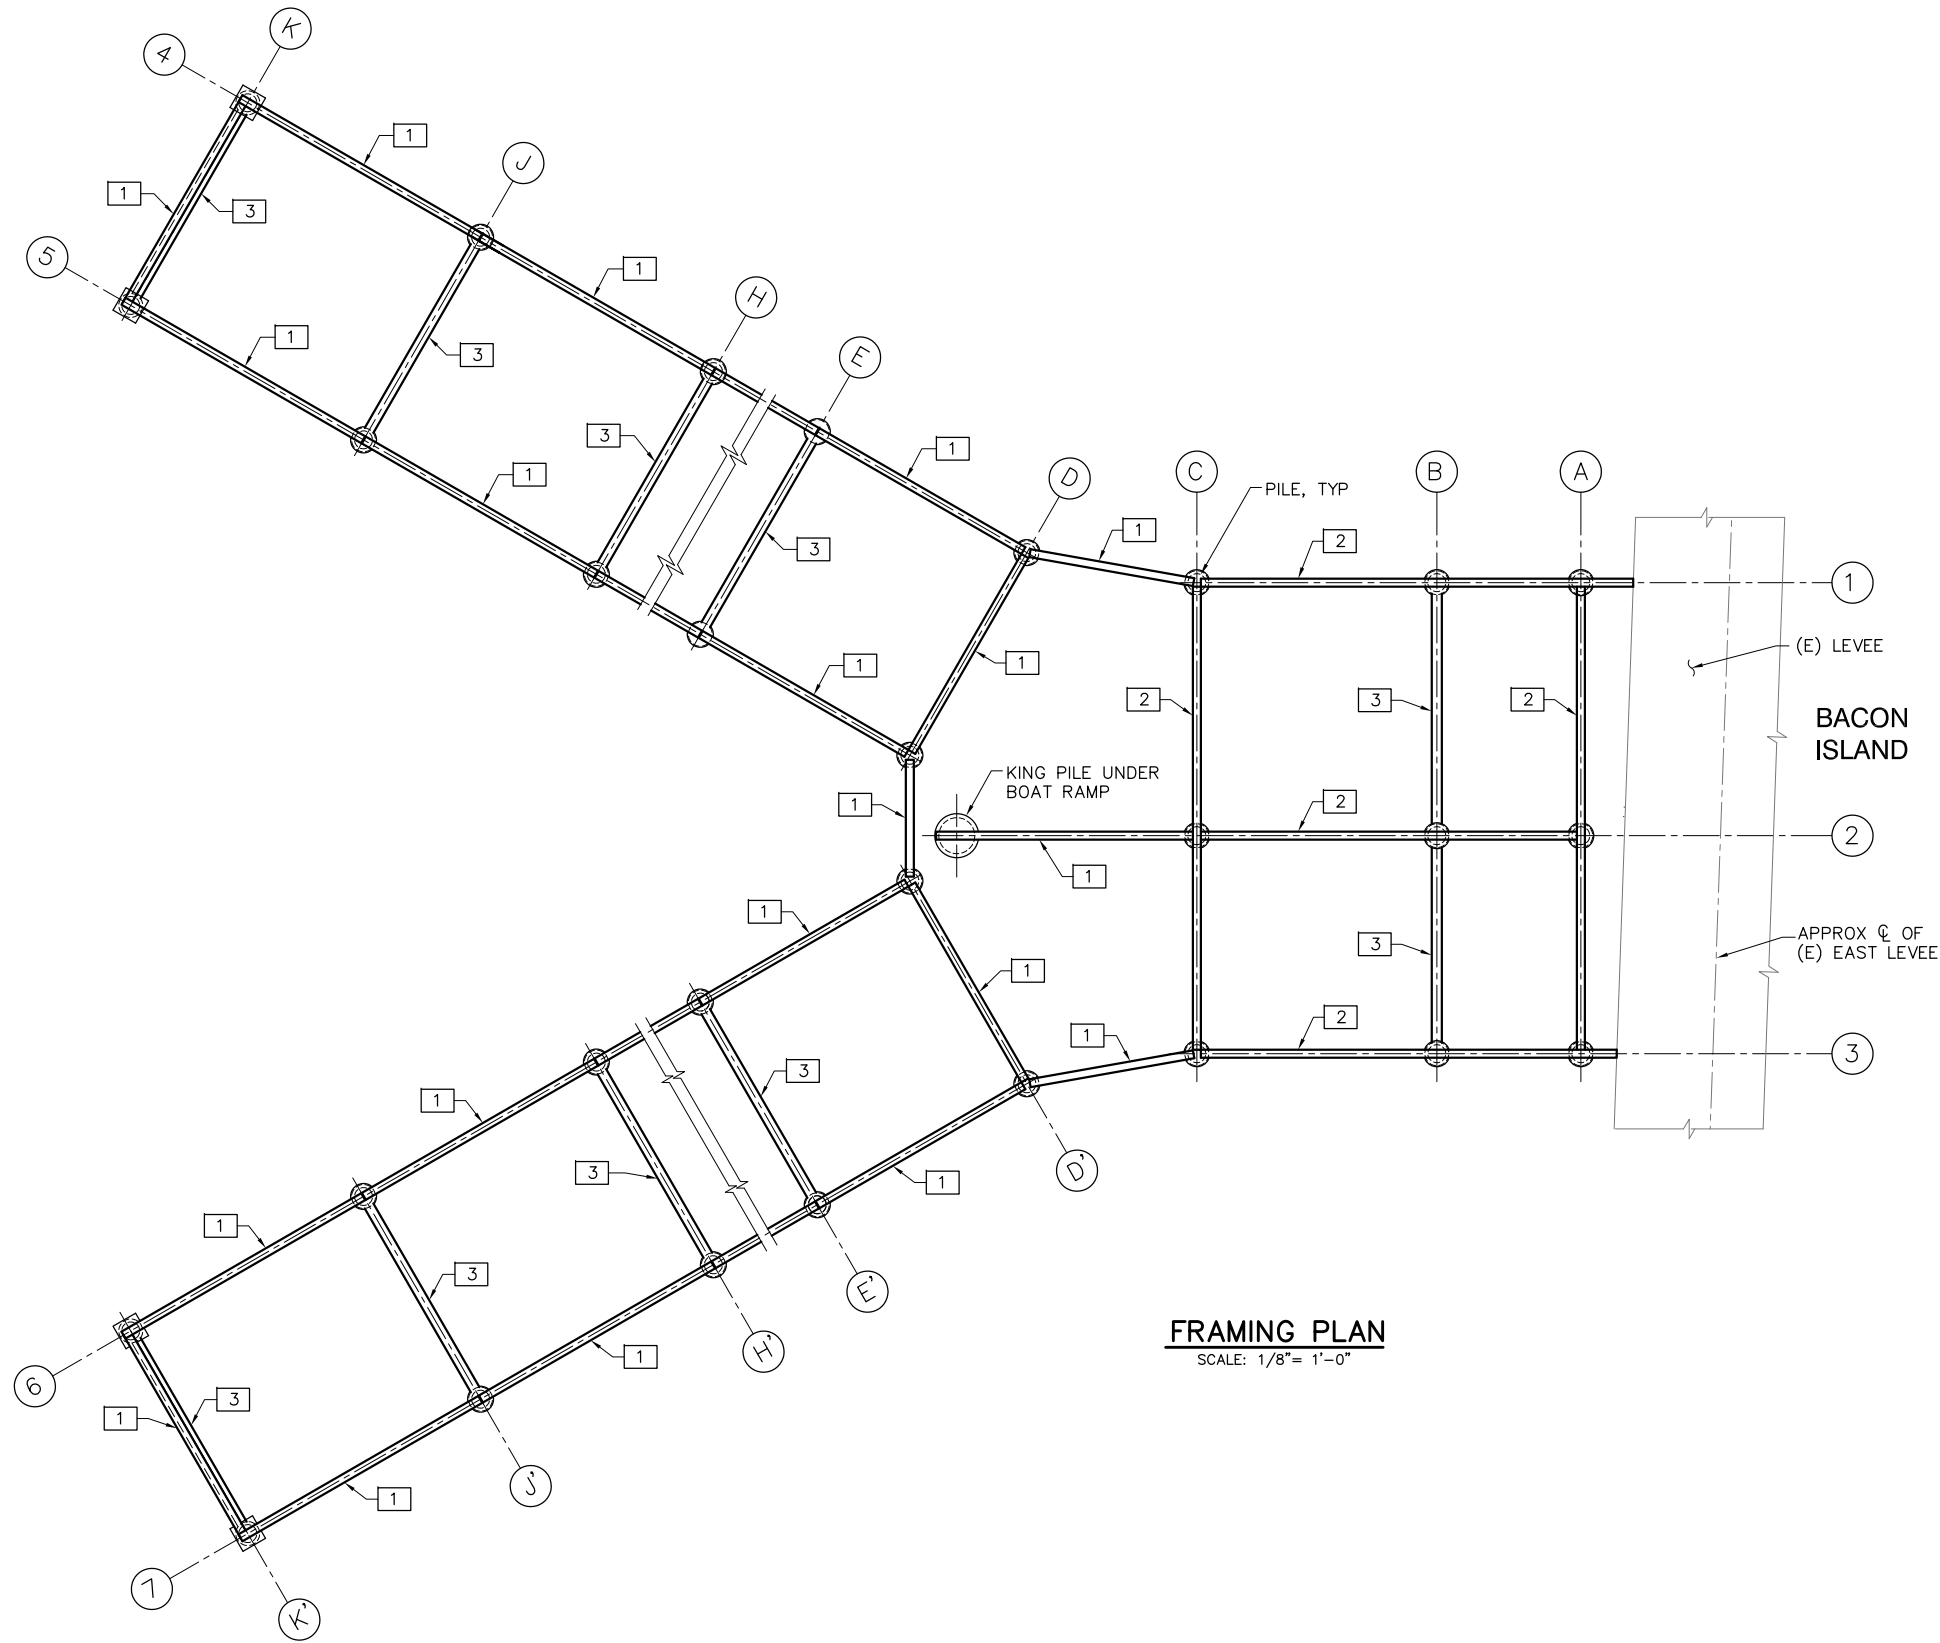


FRAMING PLAN
SCALE: 1/8"= 1'-0"

LEGEND:

- 1 HSS 16x8x1/2
- 2 HSS 16x8x1/2 CONTINUOUS THRU SUPPORT
- 3 10"Ø XSTRONG PIPE TRANSVERSE "CAP" BEAM

NOTE:

 LEVEE SHEET PILE WALL, RIVER SHEET PILE WALL AND KING PILES NOT SHOWN FOR CLARITY.



100% SUBMITTAL

IF SHEET IS LESS THAN 22" x 34"
IT IS A REDUCED PRINT -
SCALE REDUCED ACCORDINGLY.

REVISION	DESCRIPTION	BY	DATE



San Luis & Delta-Mendota Water Authority
842 6th Street, Suite 7
PO Box 2157
Los Banos, California 93635

APPROVED _____
FRANCY C. MIZUNO, PE C35136
San Luis & Delta-Mendota Water Authority

APPROVED _____
DENNIS G. MAJORS PE C21297
Metropolitan Water District of Southern California



2001 N. Main Street, Suite 360
Walnut Creek, California 94596
(925) 944-5411

DSGN	JMB	DR	EP/AB	CHK	TDB
JOB NO.	6097-03	SUBMITTED BY	RMR		

TWO GATE FISH PROTECTION PLAN


DATE 08/31/09

SHEET 13 OF 78

**OLD RIVER
BOAT RAMP FRAMING PLAN**

C7.2

P:\6097-03 SWC GATE DESIGN\CADD\DWG\609703-C8.DWG 8/31/2009 9:50 AM

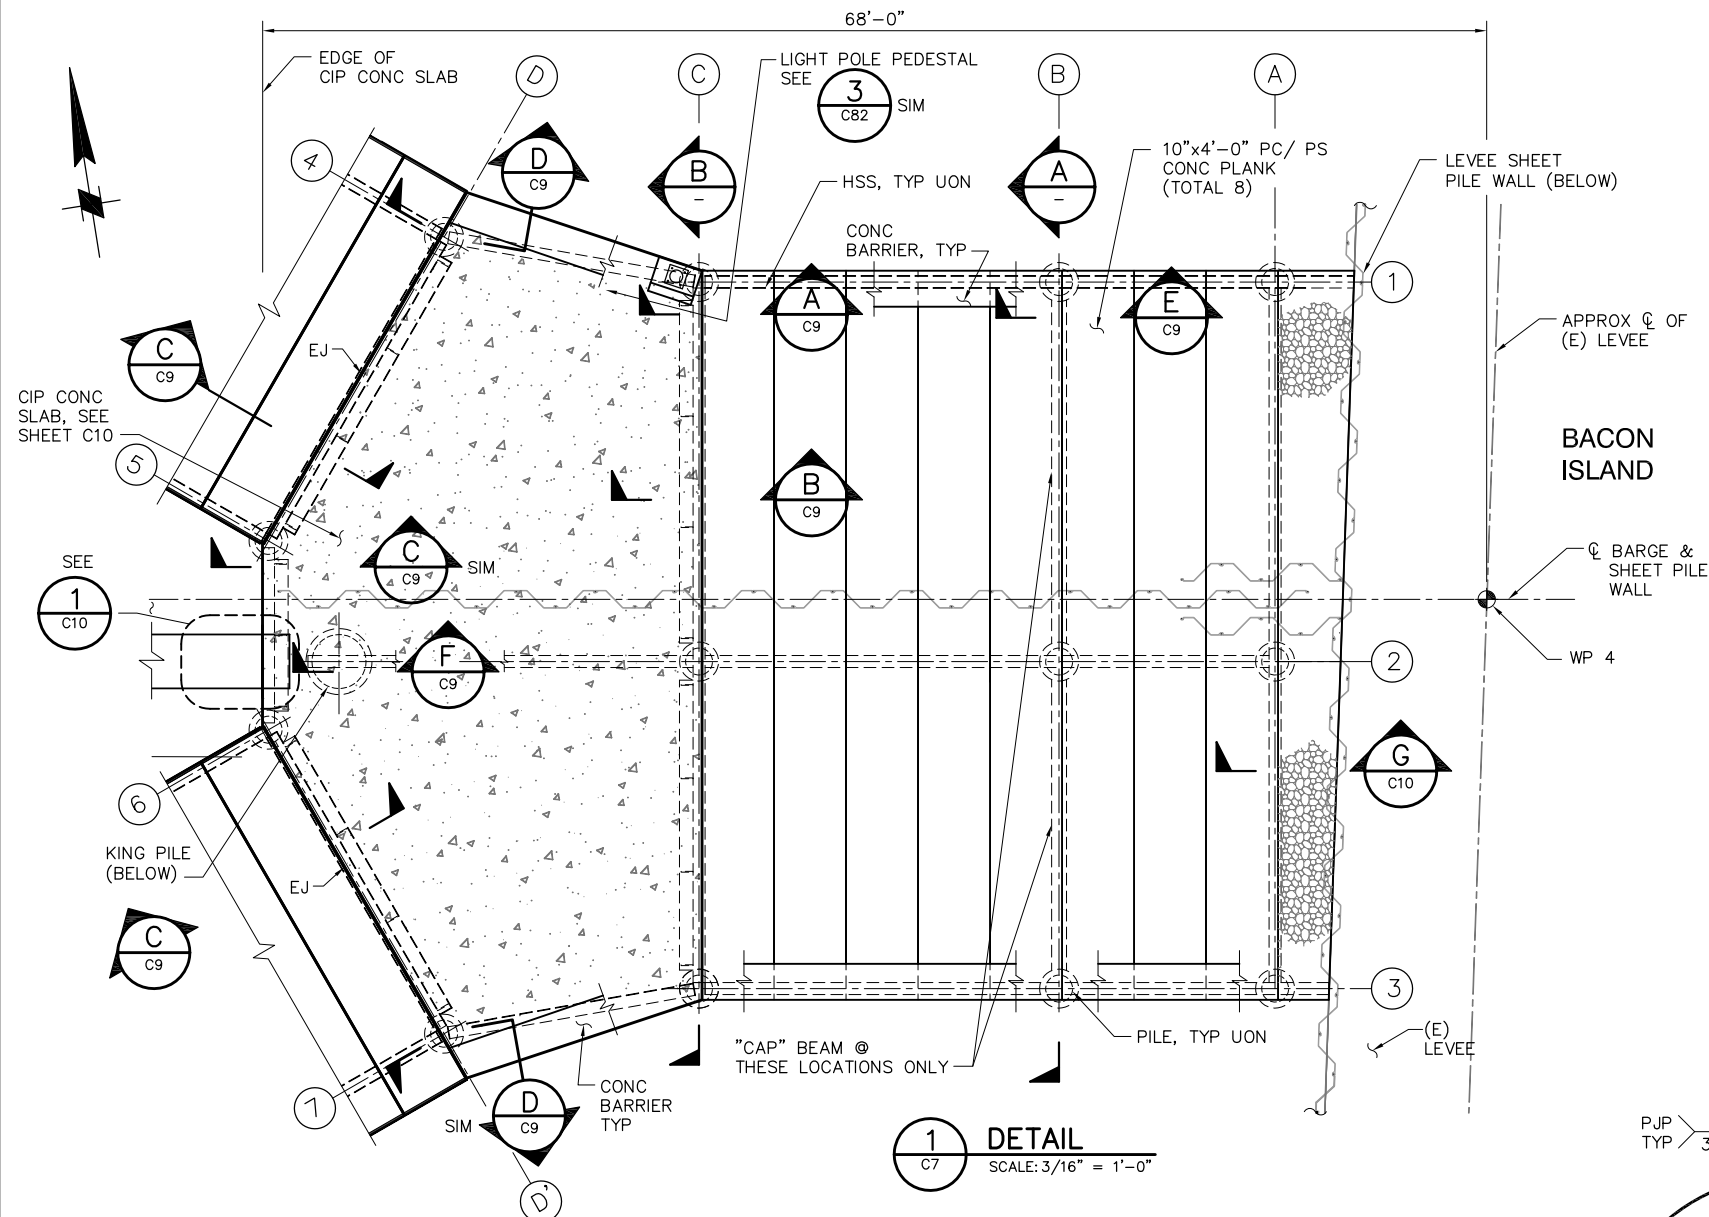

BACON ISLAND

NOTES:

1. ALL PC/PS PLANKS SHALL BEAR ON/AGAINST NEOPRENE "UNDERLAYMENT" BEARING STRIP WITH A MINIMUM 1/8" THICKNESS.

SECTION A
SCALE: 1/2"=1'-0"

WELDING NOTE:

ALL STIFFENER PLATES SHALL HAVE DOUBLE SIDED 1/4" FILLET WELDS UON.


DETAIL 1
SCALE: 3/16"=1'-0"

SECTION B
SCALE: 1/2"=1'-0"

TYPICAL PILE CAP FOR 18"Ø PILE UON

DETAIL 2
SCALE: 1"=1'-0"

 DETAIL 3
SCALE: 1"=1'-0"



100% SUBMITTAL

IF SHEET IS LESS THAN 22" x 34" IT IS A REDUCED PRINT - SCALE REDUCED ACCORDINGLY.

REVISION	DESCRIPTION	BY	DATE



San Luis & Delta-Mendota Water Authority
842 6th Street, Suite 7
PO Box 2157
Los Banos, California 93635

APPROVED _____
FRANCY C. MIZUNO, PE C35136
San Luis & Delta-Mendota Water Authority

APPROVED _____
DENNIS G. MAJORS PE C21297
Metropolitan Water District of Southern California







2001 N. Main Street, Suite 360
Walnut Creek, California 94596
(925) 944-5411

DSGN	JMB	DR	EP	CHK	TDB
JOB NO.	6097-03	SUBMITTED BY	RMR		




TWO GATE FISH PROTECTION PLAN	DATE 08/31/09
OLD RIVER BOAT RAMP DETAILS AND SECTIONS SHEET 1	SHEET 14 OF 78
C8	

P:\6097-03 SWC GATE DESIGN\CADD\DWG\609703-C9.DWG 8/25/2009 10:02 AM

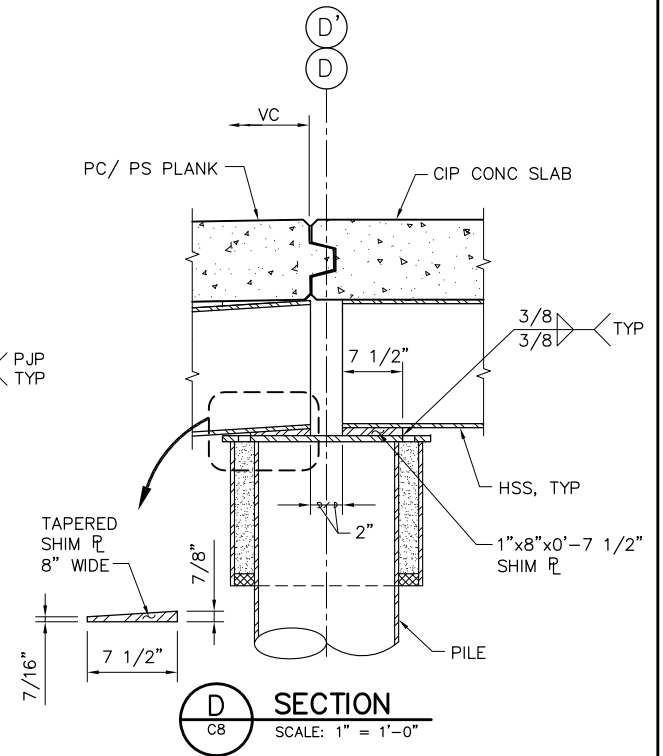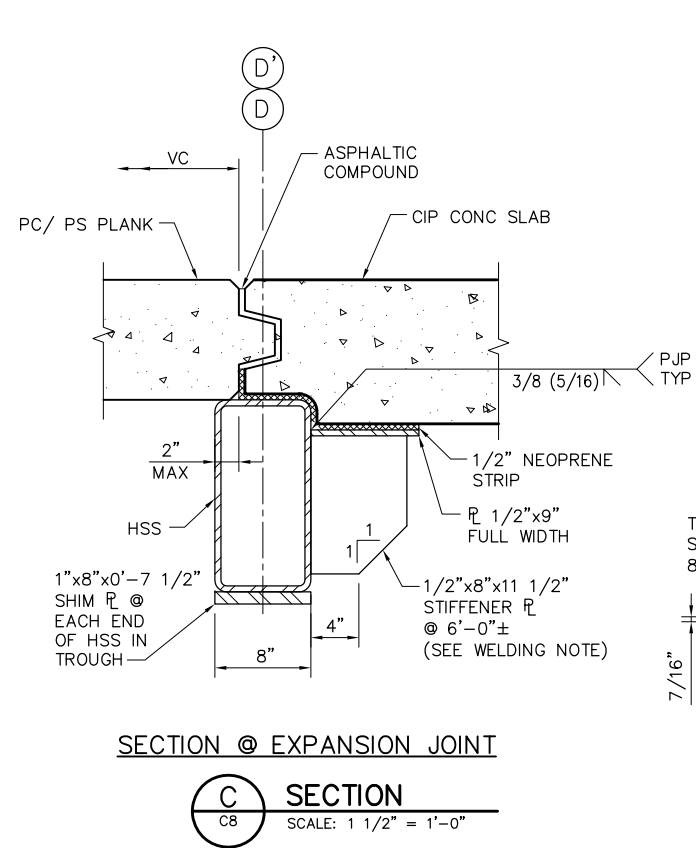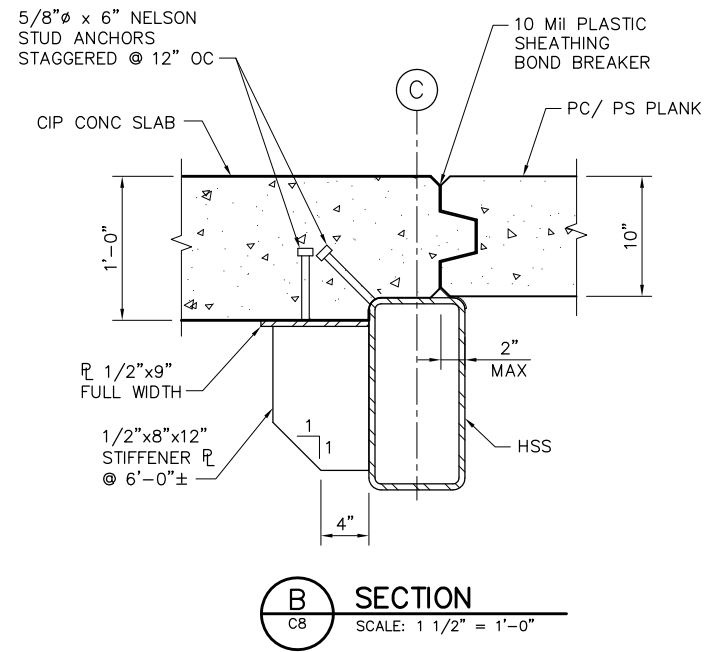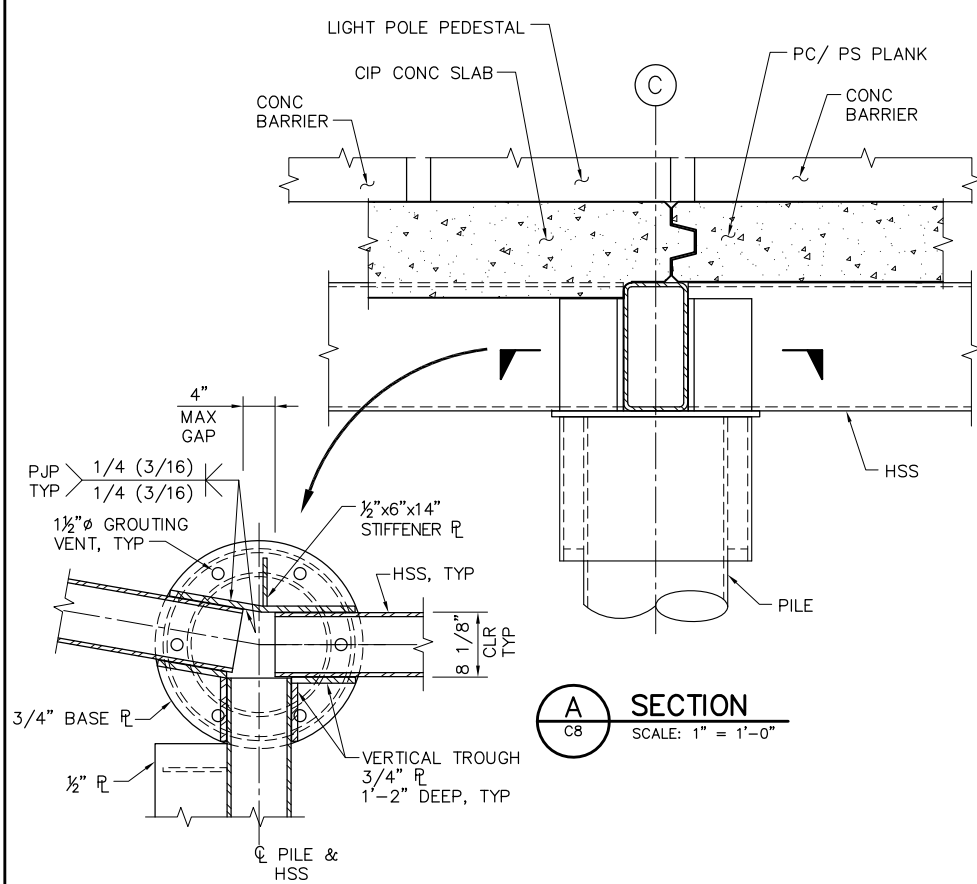

WELDING NOTE:

 
ALL STIFFENER PLATES SHALL HAVE DOUBLE SIDED 1/4" FILLET WELDS UON.

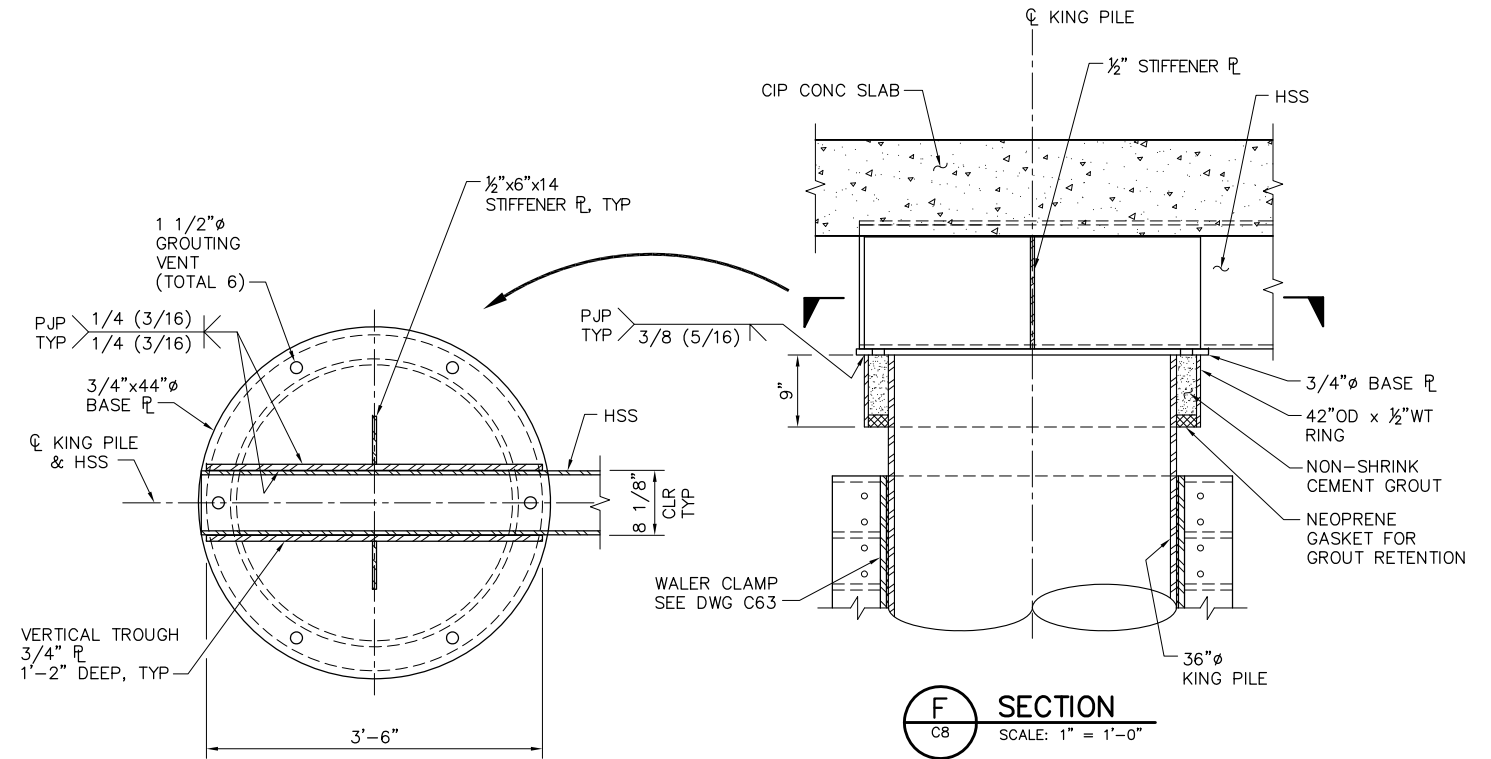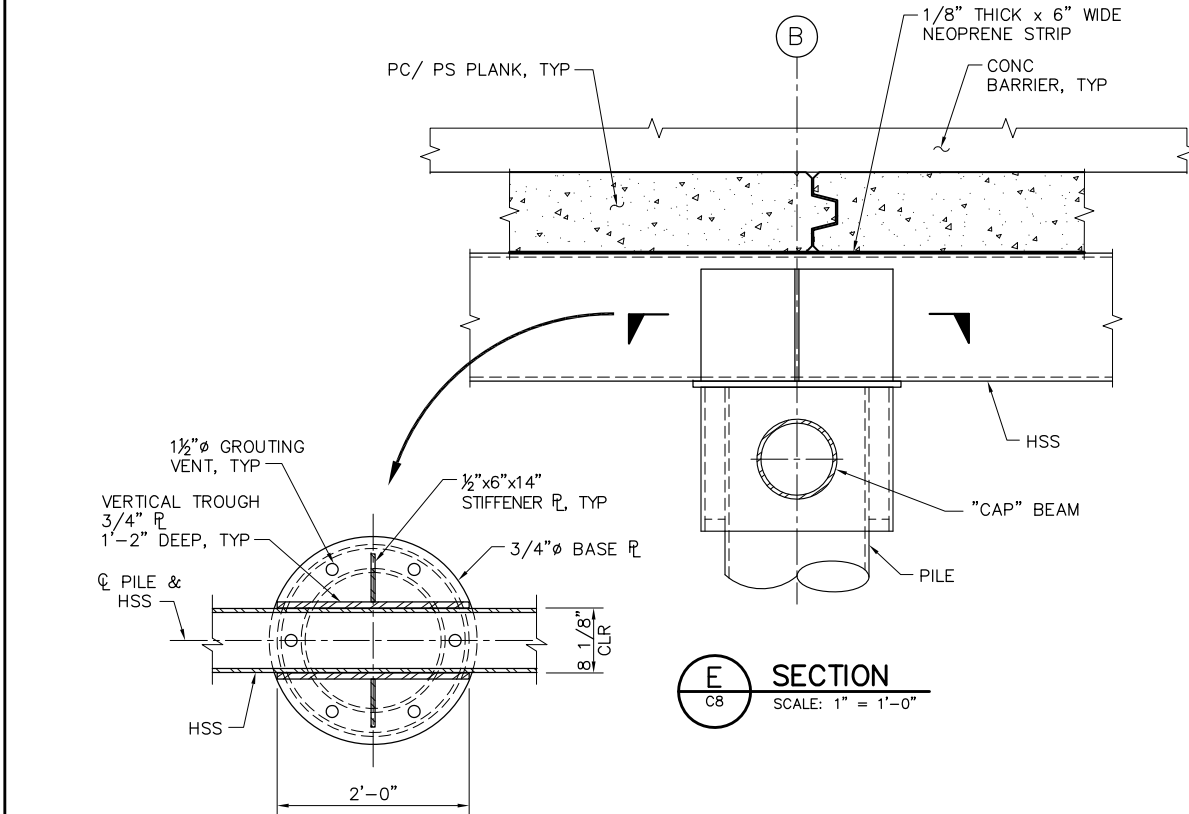

100% SUBMITTAL

IF SHEET IS LESS THAN 22" x 34"
IT IS A REDUCED PRINT -
SCALE REDUCED ACCORDINGLY.

REVISION	DESCRIPTION	BY	DATE

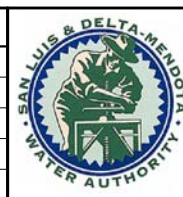

San Luis & Delta-Mendota Water Authority
842 6th Street, Suite 7
PO Box 2157
Los Banos, California 93635


APPROVED _____
FRANCY C. MIZUNO, PE C35136
San Luis & Delta-Mendota Water Authority

APPROVED _____
DENNIS G. MAJORS PE C21297
Metropolitan Water District of Southern California


		2001 N. Main Street, Suite 360 Walnut Creek, California 94596 (925) 944-5411	
DSGN	JMB	DR	EP
JOB NO.	6097-03	SUBMITTED BY	RMR

TWO GATE FISH PROTECTION PLAN		DATE 08/31/09
OLD RIVER BOAT RAMP DETAILS AND SECTIONS SHEET 2		SHEET 15 OF 78
C9		


P:\6097-03 SMC GATE DESIGN\CADD\DWG\609703-C10.DWG 8/25/2009 10:03 AM

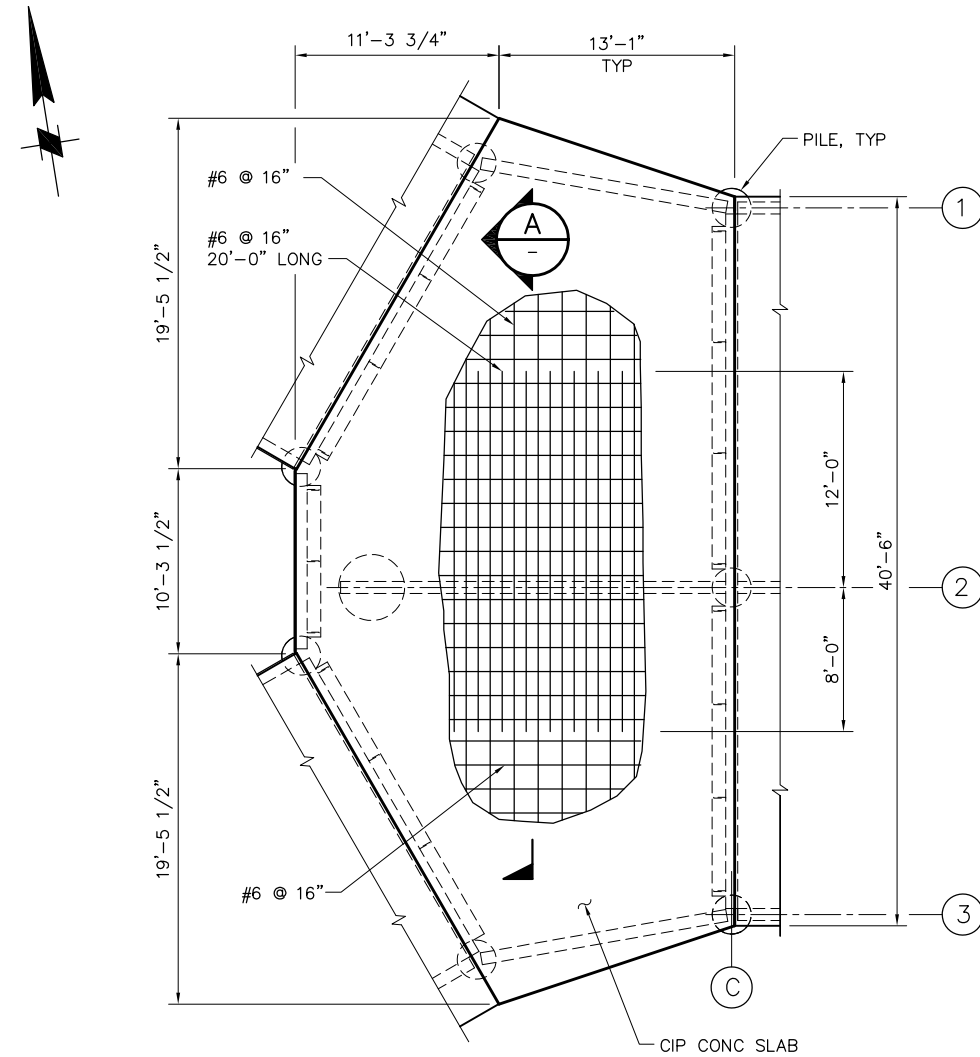


TOP SLAB REINFORCEMENT
SCALE: 3/16" = 1'-0"

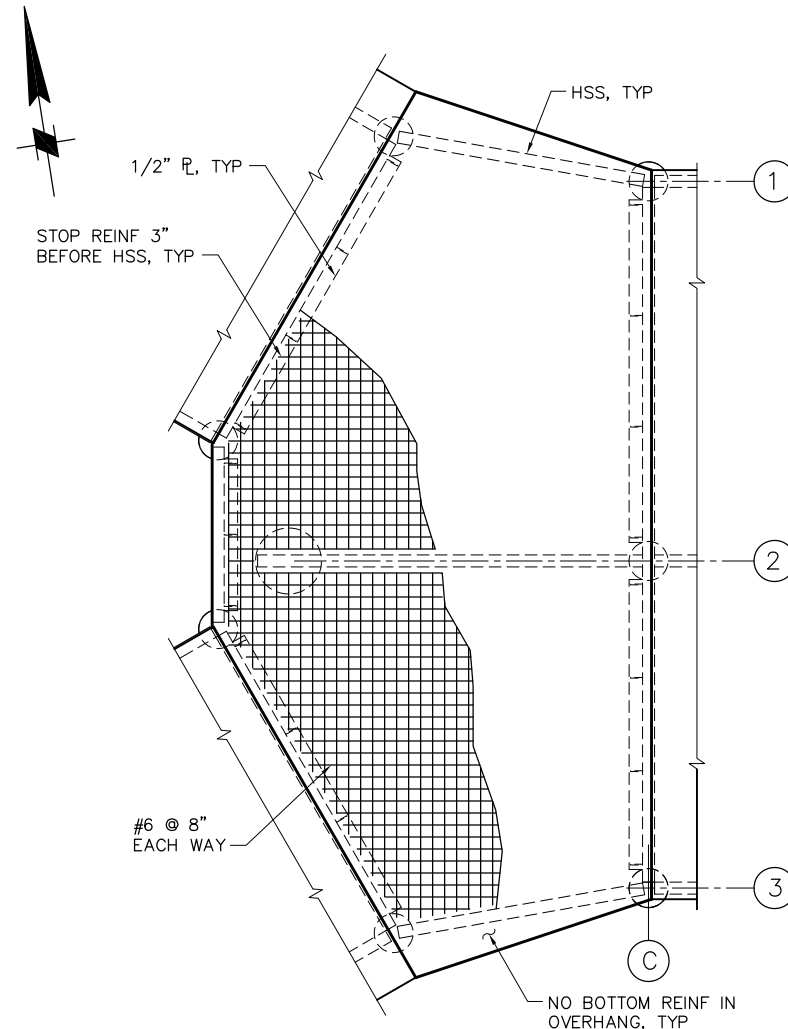


BOTTOM SLAB REINFORCEMENT
SCALE: 3/16" = 1'-0"

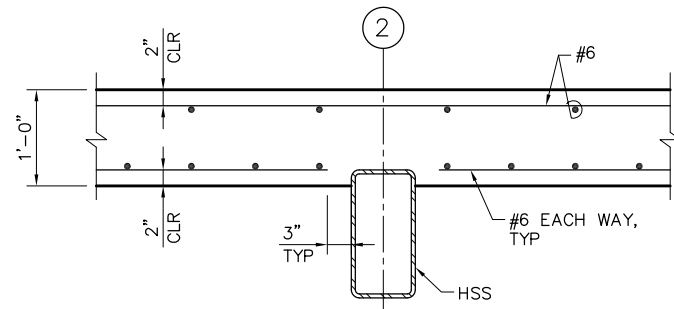


SECTION A
SCALE: 1" = 1'-0"

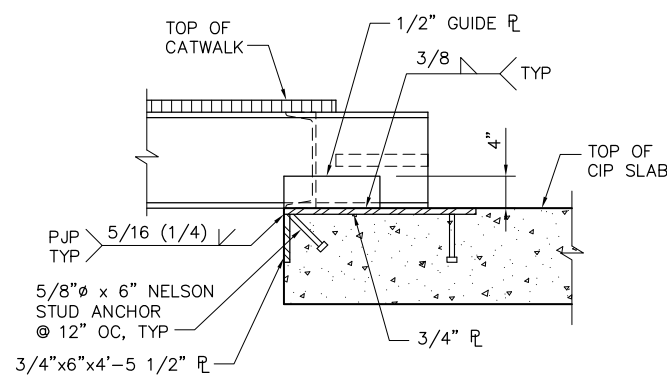

SECTION B
SCALE: 1" = 1'-0"

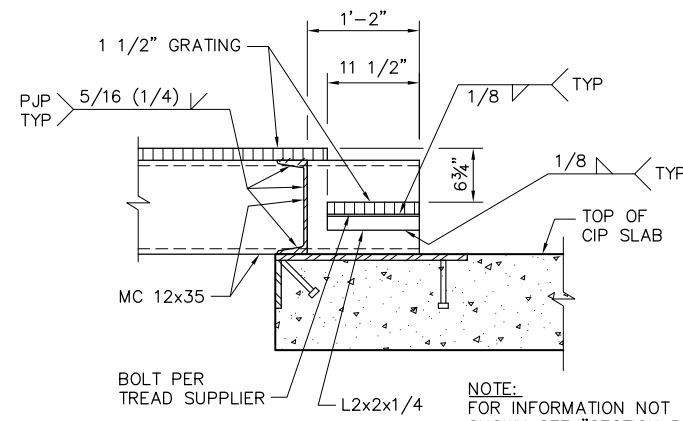


SECTION C
SCALE: 1" = 1'-0"

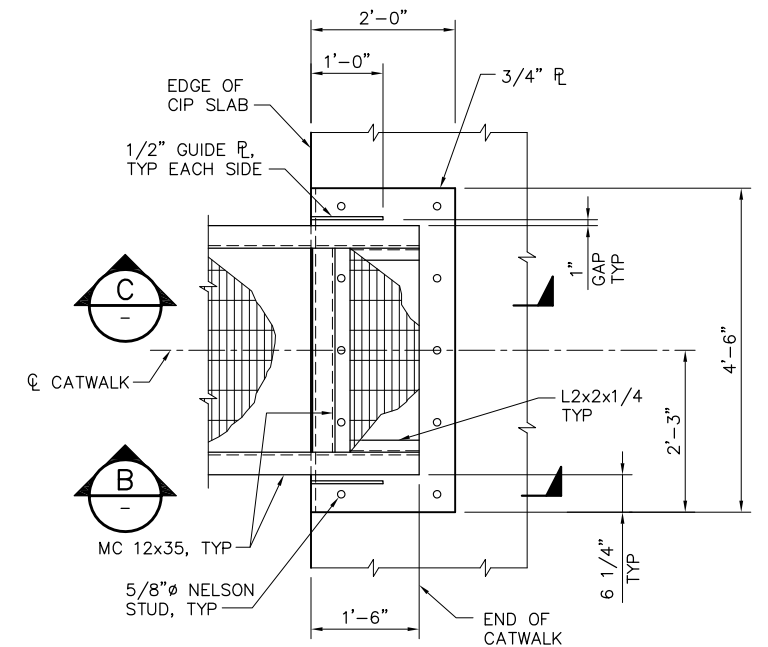


PLAN AT END OF CATWALK
SCALE: 3/4" = 1'-0"

1
C8
SCALE: 3/4" = 1'-0"

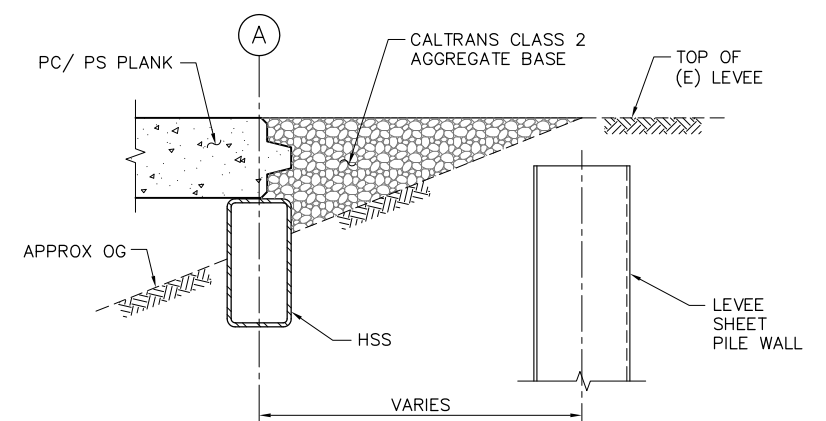

SECTION G
SCALE: 1" = 1'-0"

 

100% SUBMITTAL

IF SHEET IS LESS THAN 22" x 34"
IT IS A REDUCED PRINT -
SCALE REDUCED ACCORDINGLY.

REVISION	DESCRIPTION	BY	DATE



San Luis & Delta-Mendota Water Authority
842 6th Street, Suite 7
PO Box 2157
Los Banos, California 93635

APPROVED _____
FRANCY C. MIZUNO, PE C35136
San Luis & Delta-Mendota Water Authority

APPROVED _____
DENNIS G. MAJORS PE C21297
Metropolitan Water District of Southern California




2001 N. Main Street, Suite 360
Walnut Creek, California 94596
(925) 944-5411


DSGN JMB DR EP CHK TDB
JOB NO. 6097-03 SUBMITTED BY RMR

TWO GATE FISH PROTECTION PLAN	DATE 08/31/09
OLD RIVER BOAT RAMP DETAILS AND SECTIONS SHEET 3	SHEET 16 OF 78
	C10

P:\6097-03 SWC GATE DESIGN\CADD\DWG\609703-C11.DWG 8/31/2009 9:24 AM

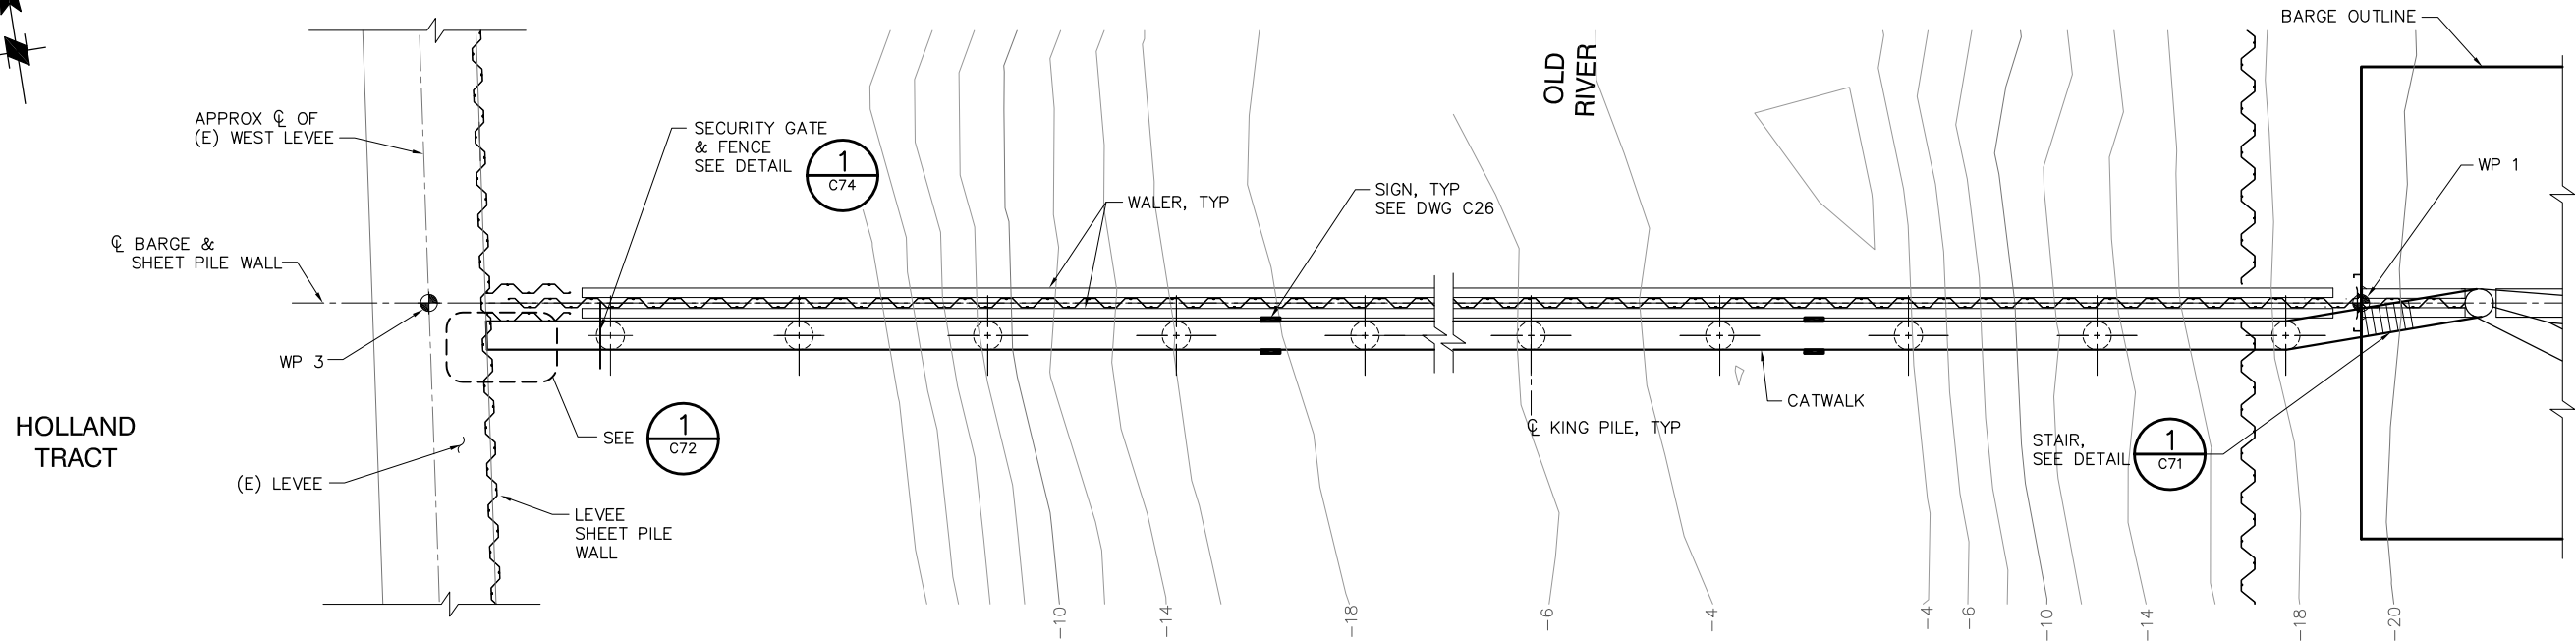


PLAN
SCALE: 1"= 10'

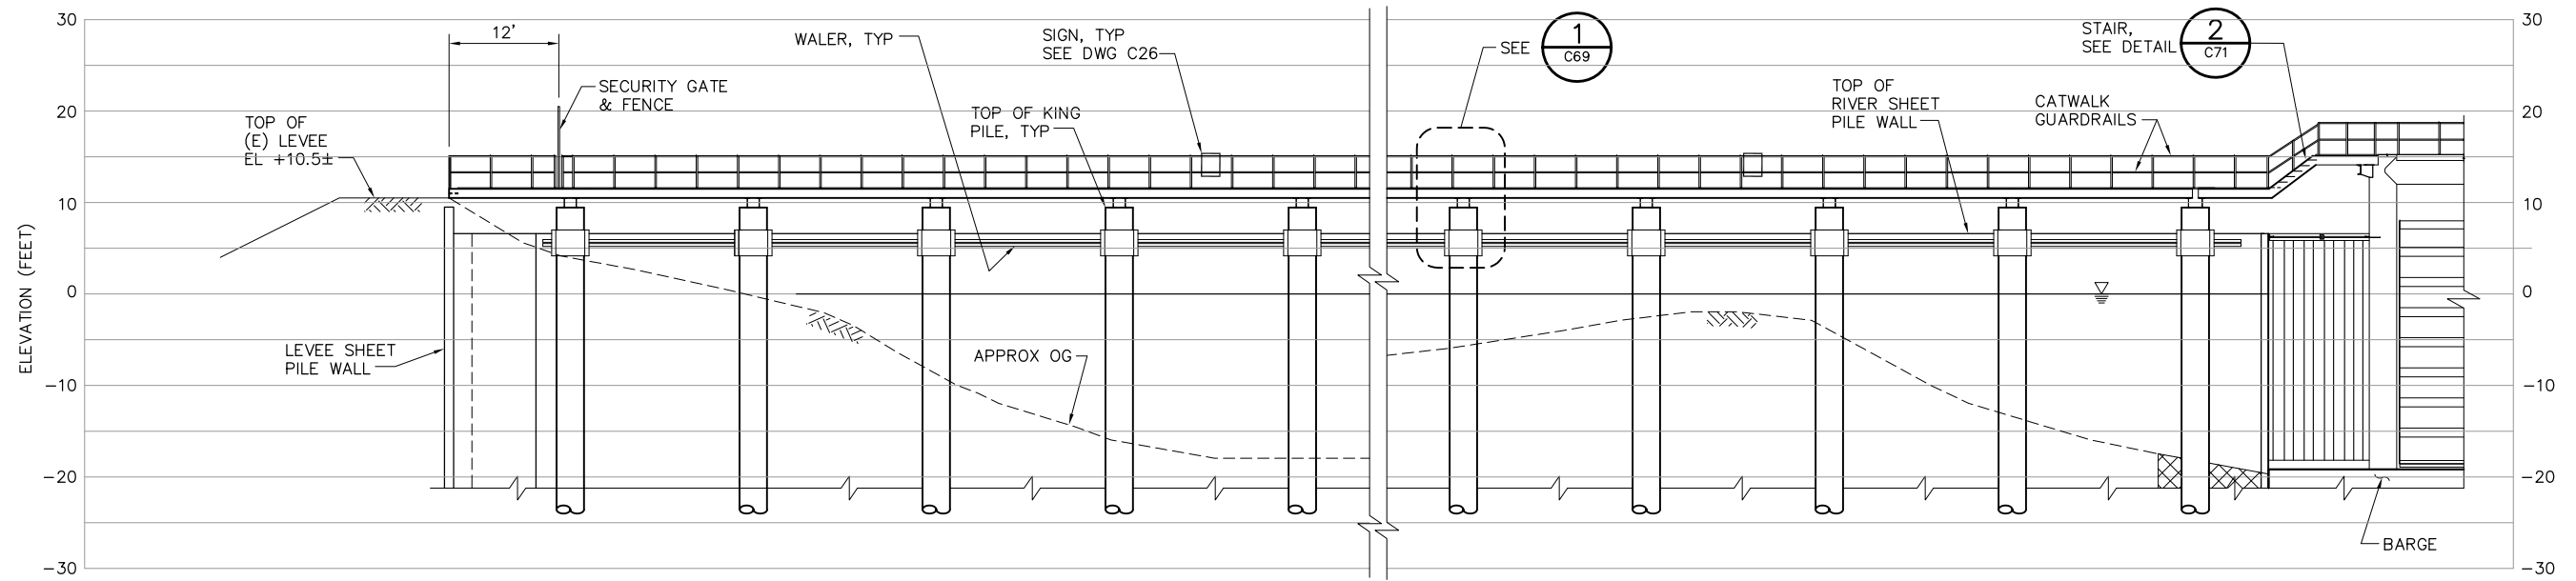

ELEVATION
SCALE: 1"= 10'

 NOTE: SUBMERGED TOE ENCLOSURE
NOT SHOWN FOR CLARITY.



100% SUBMITTAL

IF SHEET IS LESS THAN 22" x 34"
IT IS A REDUCED PRINT -
SCALE REDUCED ACCORDINGLY.

REVISION	DESCRIPTION	BY	DATE



San Luis & Delta-Mendota Water Authority
842 6th Street, Suite 7
PO Box 2157
Los Banos, California 93635


APPROVED _____
FRANCY C. MIZUNO, PE C35136
San Luis & Delta-Mendota Water Authority

APPROVED _____
DENNIS G. MAJORS PE C21297
Metropolitan Water District of Southern California


 Moffatt & Nichol		2001 N. Main Street, Suite 360 Walnut Creek, California 94596 (925) 944-5411	
DSGN	JMB	DR	EP/AB
JOB NO.	6097-03	SUBMITTED BY	RMR
CHK	TDB		

TWO GATE FISH PROTECTION PLAN		DATE 08/31/09
OLD RIVER CATWALK PLAN AND ELEVATION, SHEET 1		SHEET 17 OF 78
		C11

P:\6097-03 SWC GATE DESIGN\CADD\DWG\609703-C12.DWG 8/31/2009 9:25 AM

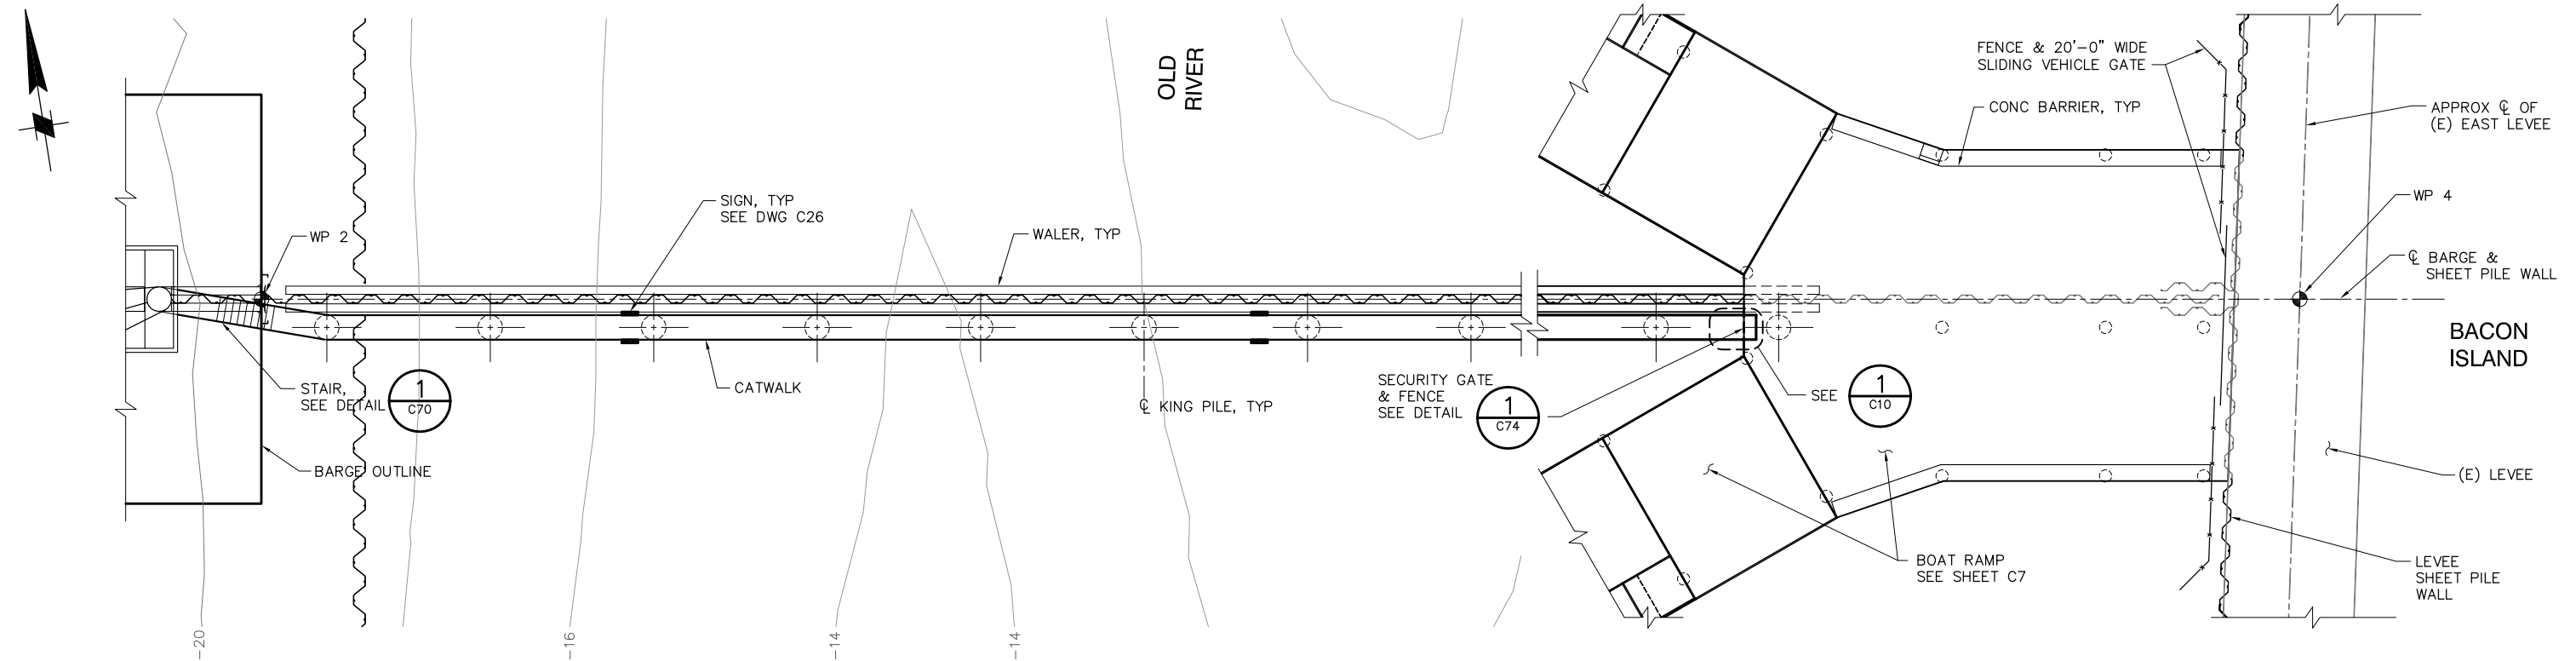


PLAN
SCALE: 1"= 10'

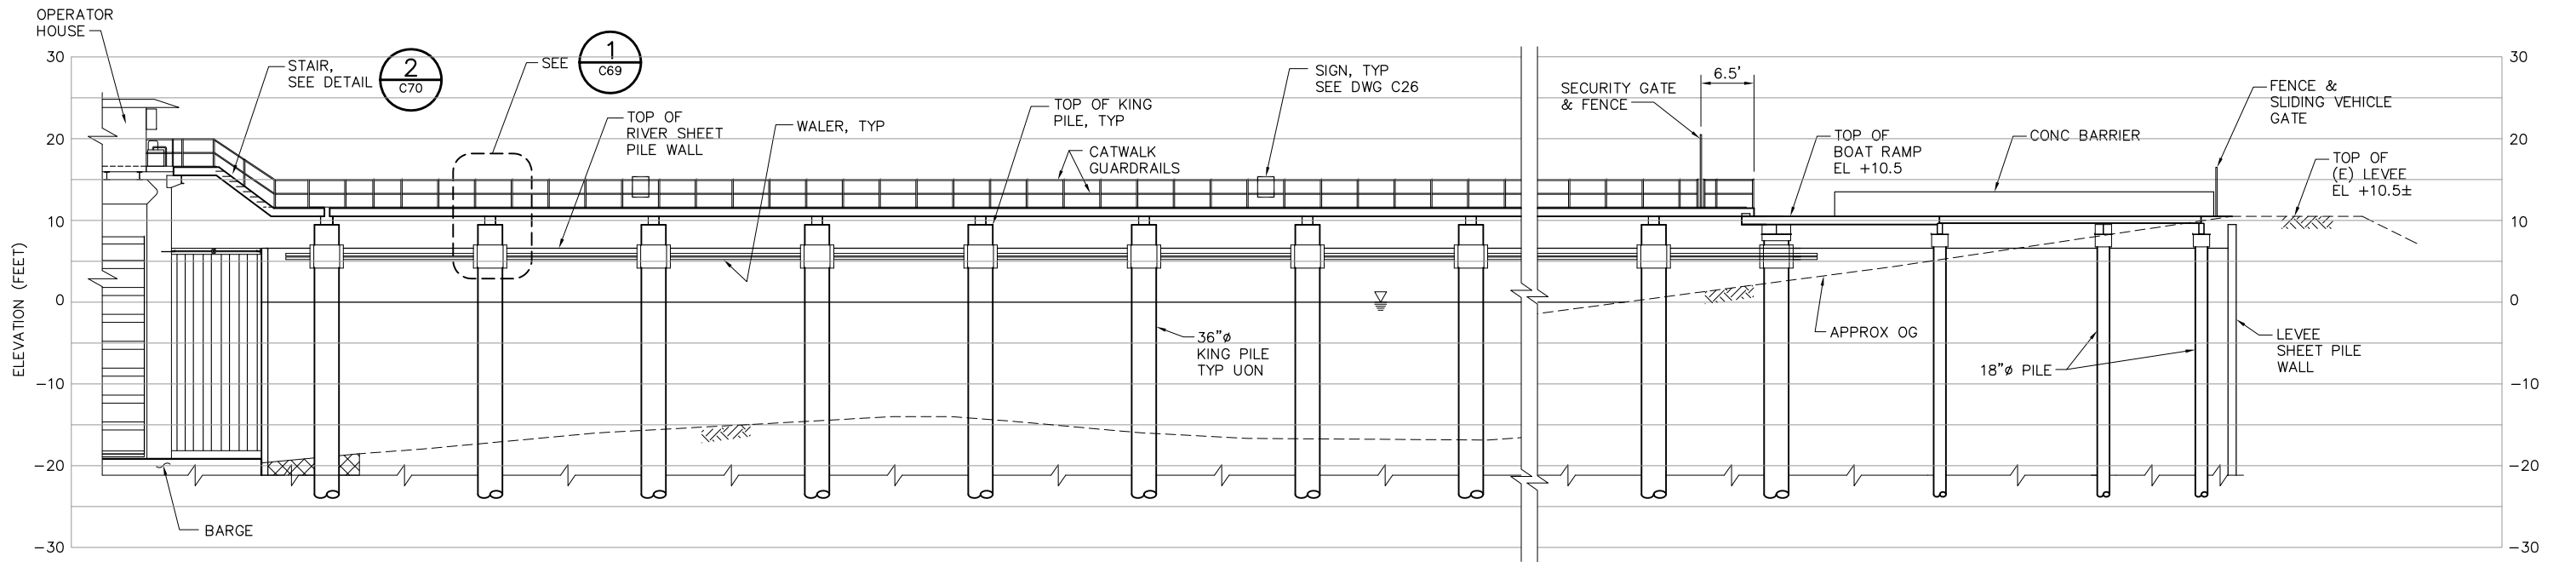

ELEVATION
SCALE: 1"= 10'

 NOTE: SUBMERGED TOE ENCLOSURE
NOT SHOWN FOR CLARITY.



100% SUBMITTAL

IF SHEET IS LESS THAN 22" x 34"
IT IS A REDUCED PRINT -
SCALE REDUCED ACCORDINGLY.

REVISION	DESCRIPTION	BY	DATE



San Luis & Delta-Mendota Water Authority
842 6th Street, Suite 7
PO Box 2157
Los Banos, California 93635

APPROVED _____
FRANCY C. MIZUNO, PE C35136
San Luis & Delta-Mendota Water Authority

APPROVED _____
DENNIS G. MAJORS PE C21297
Metropolitan Water District of Southern California

		2001 N. Main Street, Suite 360 Walnut Creek, California 94596 (925) 944-5411	
DSGN	JMB	DR	EP/AB
JOB NO.	6097-03	SUBMITTED BY	RMR

TWO GATE FISH PROTECTION PLAN		DATE 08/31/09
OLD RIVER CATWALK PLAN AND ELEVATION, SHEET 2		SHEET 18 OF 78
		C12

P:\6097-03 SWC GATE DESIGN\CADD\DWG\609703-C13.DWG 8/31/2009 11:20 AM



HOLLAND TRACT

LAYDOWN AND
CONSTRUCTION
SUPPORT AREA

APPROX C. OF
(E) LEVEE, TYP

SHEET PILE WALL, TYP

OLD RIVER

OPERATOR HOUSE

OPERATOR HOUSE POWER
FROM TRANSFER SWITCH,
ROUTE OVER LEVEE, UNDER
CATWALK & BOAT RAMP

LIGHT POLE #2 SEE 3
C77

FOLD-DOWN LIGHT
POLE #3 WITH TWO
FLOODLIGHTS SEE 2
C78

CATWALK

P4 P7
SEE DWG C79

BOAT RAMP

GENERATOR SET
& FUEL TANK

BOARDING
FLOAT, TYP

LAYDOWN AND
CONSTRUCTION
SUPPORT AREA

P10 P11
SEE DWG C79

(E) PG&E POWER POLE

METER PANEL 1A &
TRANSFER SWITCH

LIGHT POLE #1 SEE 3
C77

UTILITY YARD FOR
ELECTRICAL EQUIPMENT SEE 1
C77

BACON
ISLAND

SECURITY FENCE

ELECTRICAL SITE PLAN

SCALE: 1"= 50'



SCALE: 1"=50'

100% SUBMITTAL

IF SHEET IS LESS THAN 22" x 34"
IT IS A REDUCED PRINT -
SCALE REDUCED ACCORDINGLY.

REVISION	DESCRIPTION	BY	DATE



San Luis & Delta-Mendota Water Authority
842 6th Street, Suite 7
PO Box 2157
Los Banos, California 93635

APPROVED FRANCY C. MIZUNO, PE C35136
San Luis & Delta-Mendota Water Authority

APPROVED DENNIS G. MAJORS PE C21297
Metropolitan Water District of Southern California



2001 N. Main Street, Suite 360
Walnut Creek, California 94596
(925) 944-5411

DSGN	DM	DR	AB	CHK	CBS
JOB NO.	6097-03	SUBMITTED BY	RMR		

TWO GATE FISH PROTECTION PLAN


DATE 08/31/09

SHEET 19 OF 78

**OLD RIVER
ELECTRICAL SITE PLAN**


C13

P:\6097-03 SWC GATE DESIGN\CADD\DWG\609703-C14.DWG 8/30/2009 7:55 PM

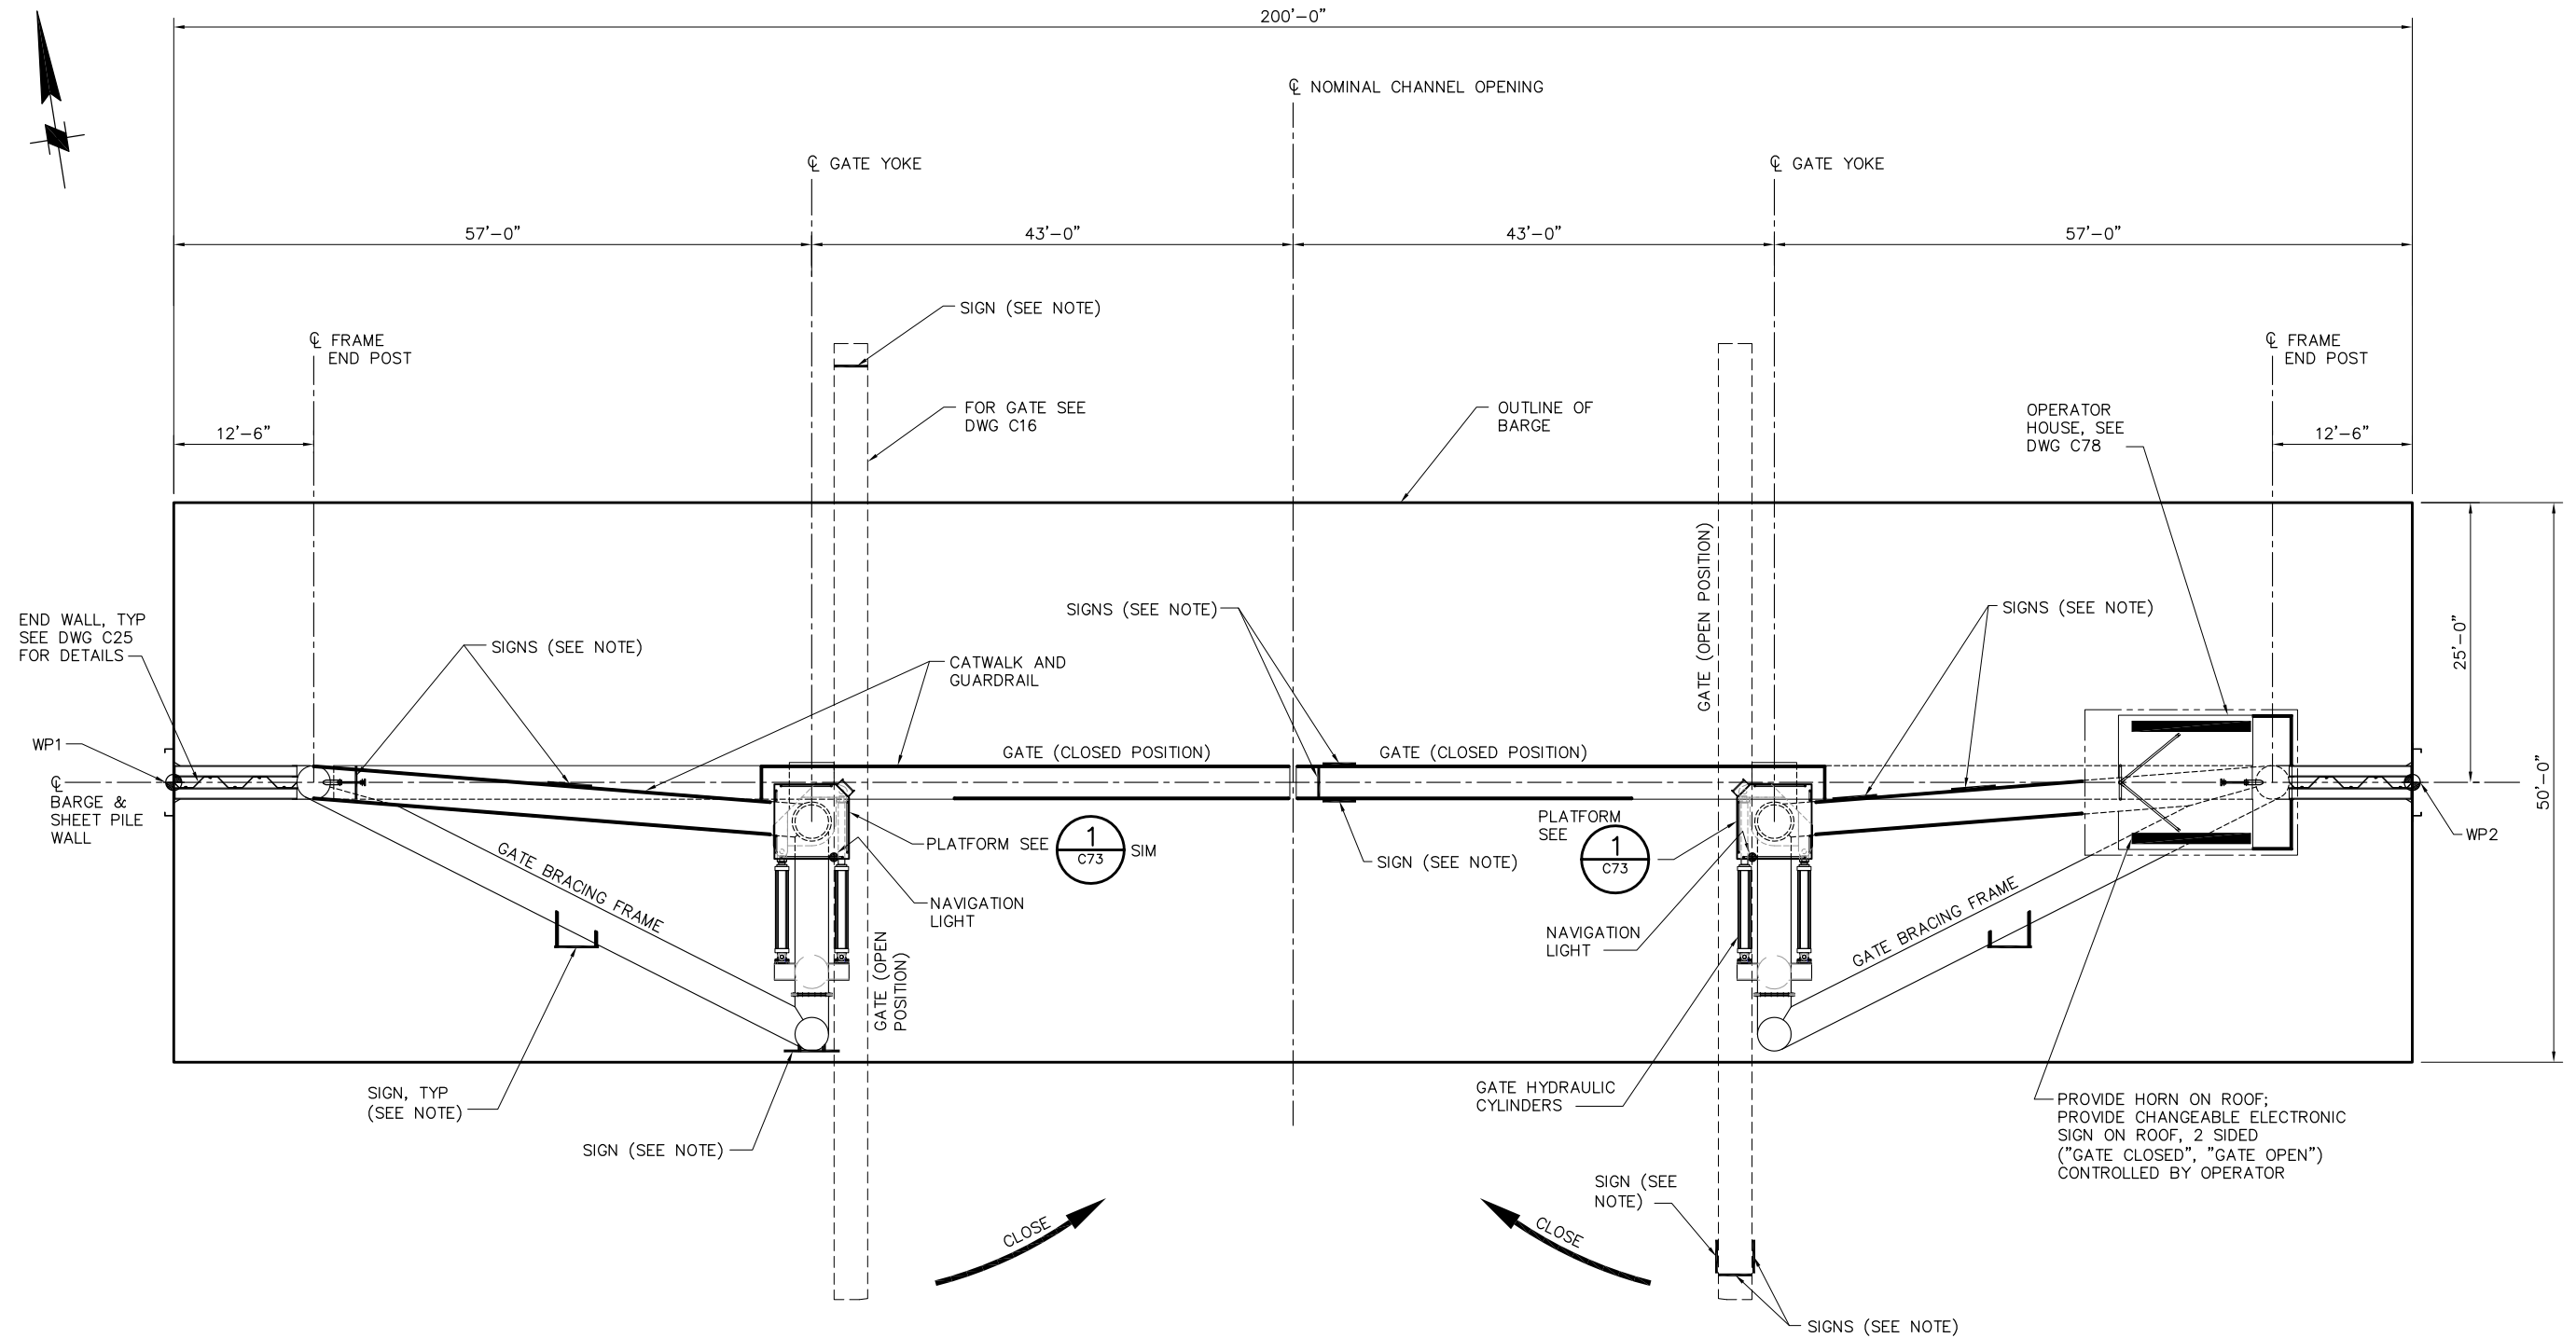

BARGE PLAN
SCALE: 1/8"=1'-0"

 NOTE:
FOR SIGNAGE, SEE DRAWING C26.



100% SUBMITTAL

IF SHEET IS LESS THAN 22" x 34"
IT IS A REDUCED PRINT -
SCALE REDUCED ACCORDINGLY.

REVISION	DESCRIPTION	BY	DATE



San Luis & Delta-Mendota Water Authority
842 6th Street, Suite 7
PO Box 2157
Los Banos, California 93635

APPROVED _____
FRANCY C. MIZUNO, PE C35136
San Luis & Delta-Mendota Water Authority

APPROVED _____
DENNIS G. MAJORS PE C21297
Metropolitan Water District of Southern California




2001 N. Main Street, Suite 360
Walnut Creek, California 94596
(925) 944-5411

DSGN	CBS	DR	AB	CHK	TDB
JOB NO.	SUBMITTED BY				
6097-03	RMR				

TWO GATE FISH PROTECTION PLAN OLD RIVER BARGE GENERAL ARRANGEMENT PLAN	DATE 08/31/09
	SHEET 20 OF 78
C14	

P:\6097-03 SWC GATE DESIGN\CADD\DWG\609703-C15.DWG 8/30/2009 2:55 PM

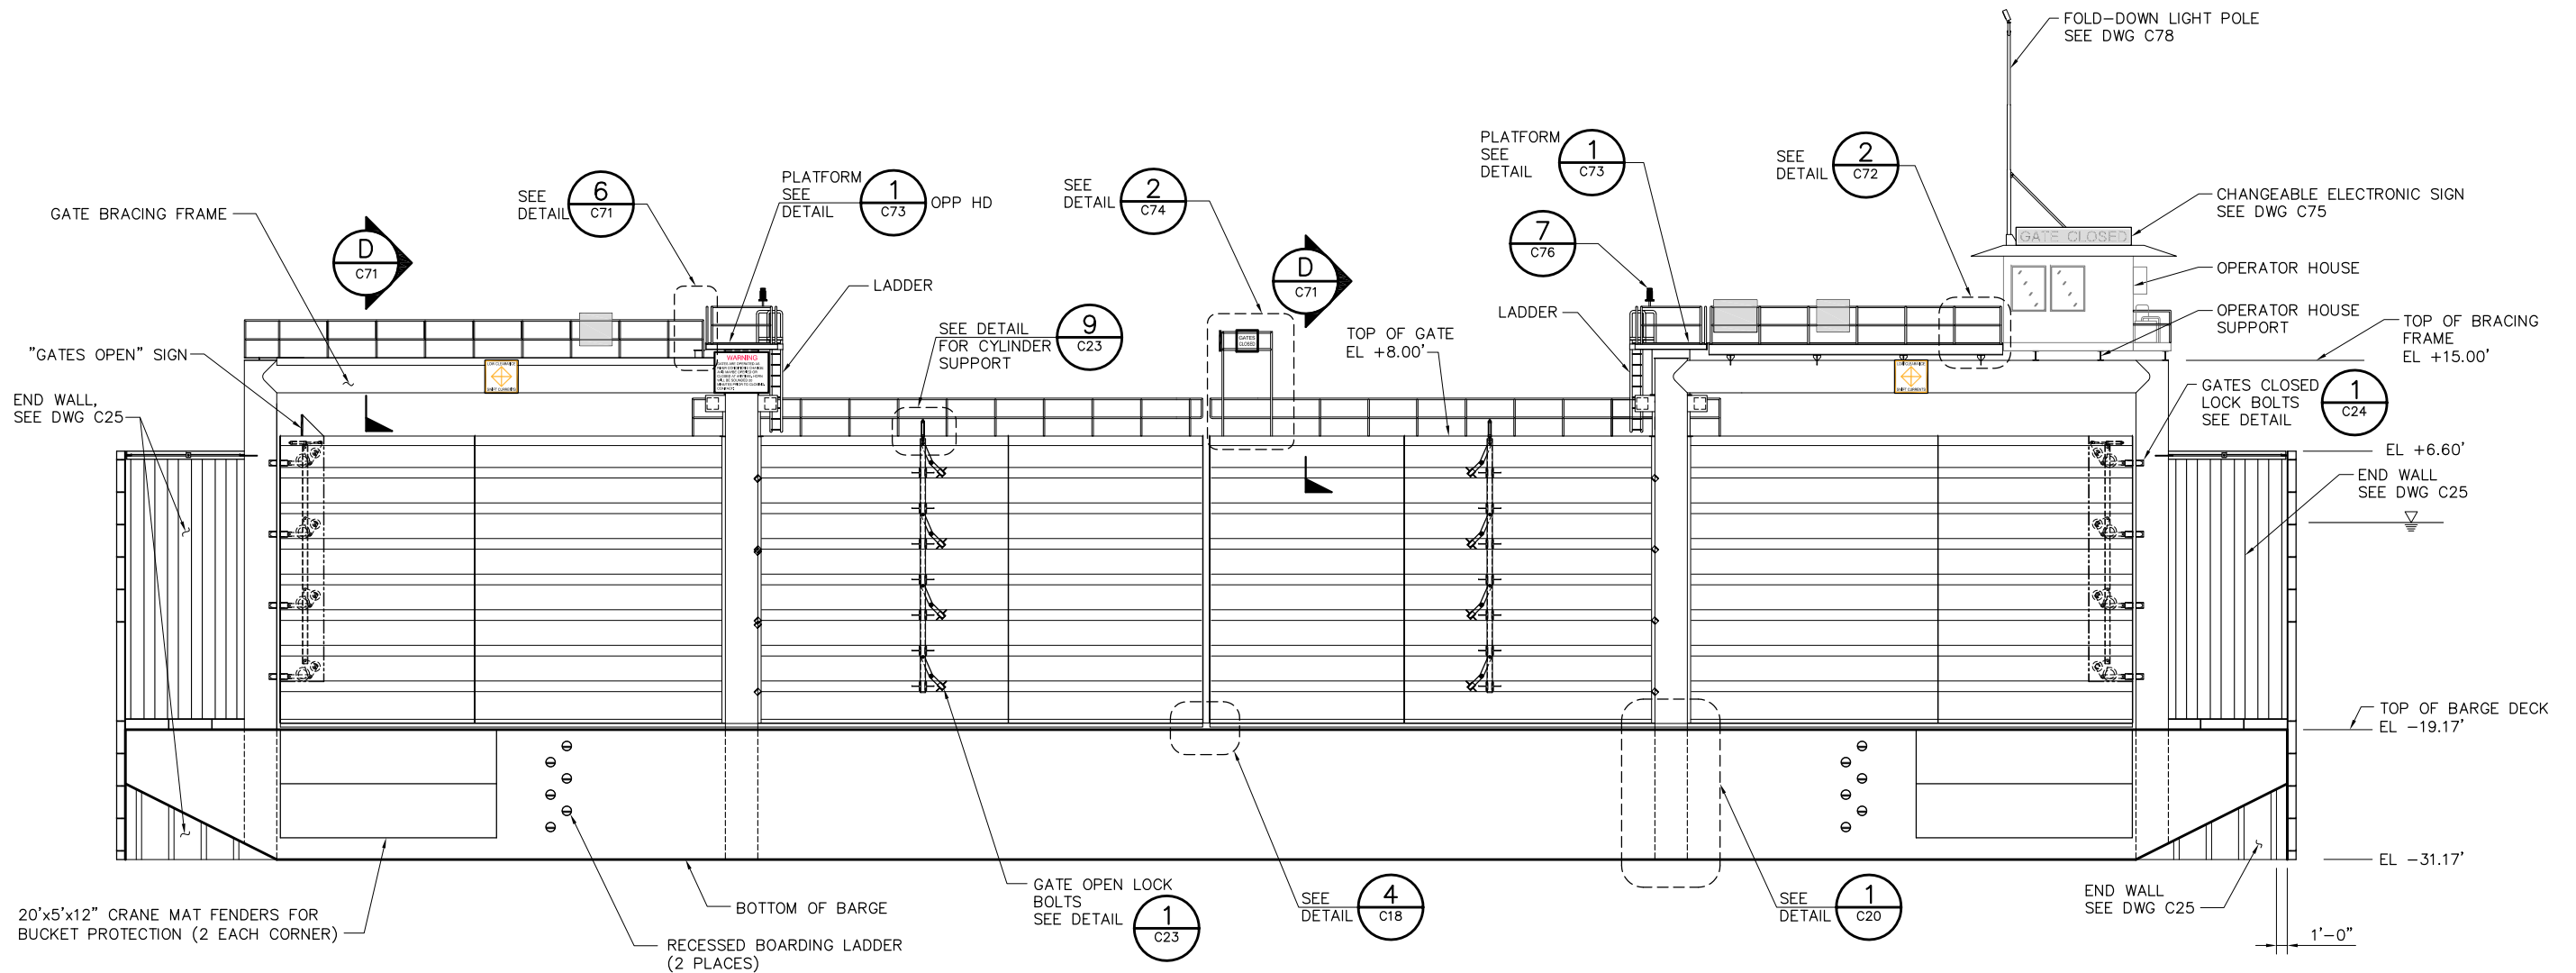

ELEVATION
SCALE: 1/8"= 1'-0"

NOTE: GATES SHOWN IN CLOSED POSITION

NOTES:

1. FOR SIGNAGE SEE DRAWING C26.
2. FOR CATWALK STAIRWAY SEE DRAWINGS C11 AND C12.

8'-0" 0'-0" 8'-0" 16'-0"
SCALE: 1/8"=1'-0"

100% SUBMITTAL

IF SHEET IS LESS THAN 22" x 34"
IT IS A REDUCED PRINT -
SCALE REDUCED ACCORDINGLY.

REVISION	DESCRIPTION	BY	DATE



San Luis & Delta-Mendota Water Authority
842 6th Street, Suite 7
PO Box 2157
Los Banos, California 93635


APPROVED _____
FRANCY C. MIZUNO, PE C35136
San Luis & Delta-Mendota Water Authority

APPROVED _____
DENNIS G. MAJORS PE C21297
Metropolitan Water District of Southern California

		2001 N. Main Street, Suite 360 Walnut Creek, California 94596 (925) 944-5411	
DSGN	JMB	DR	AB
JOB NO.	6097-03	SUBMITTED BY	RMR



TWO GATE FISH PROTECTION PLAN OLD RIVER BARGE GENERAL ARRANGEMENT ELEVATION	DATE 08/31/09
	SHEET 21 OF 78
C15	

P:\6097-03 SVC GATE DESIGN\CADD\DWG\609703-C16.DWG 8/31/2009 9:36 AM

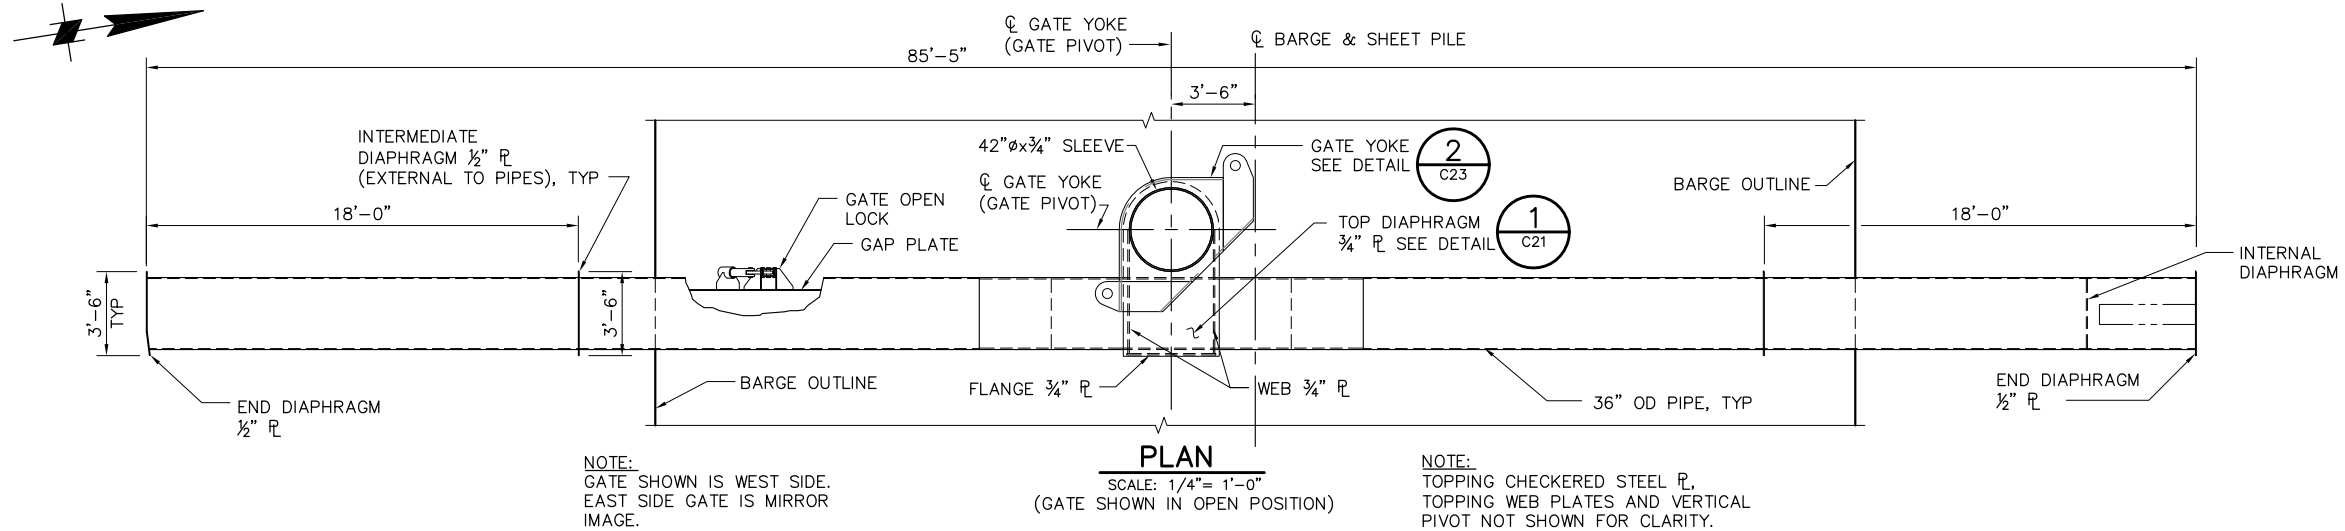

WELDING NOTES:

1. ALL GATE AND PIPE FRAMING STRUCTURAL WELDS SHALL BE COMPLETE JOINT PENETRATION (CJP) WELDS UON.
2. BACKING BARS SHALL NOT BE LEFT IN PLACE
3. ALL WELDS SHALL BE PREQUALIFIED.
4. ALL WELDING AND NON-DESTRUCTIVE TESTING (N.D.T.) INSPECTIONS SHALL BE IN ACCORDANCE WITH AWS-D1.1.

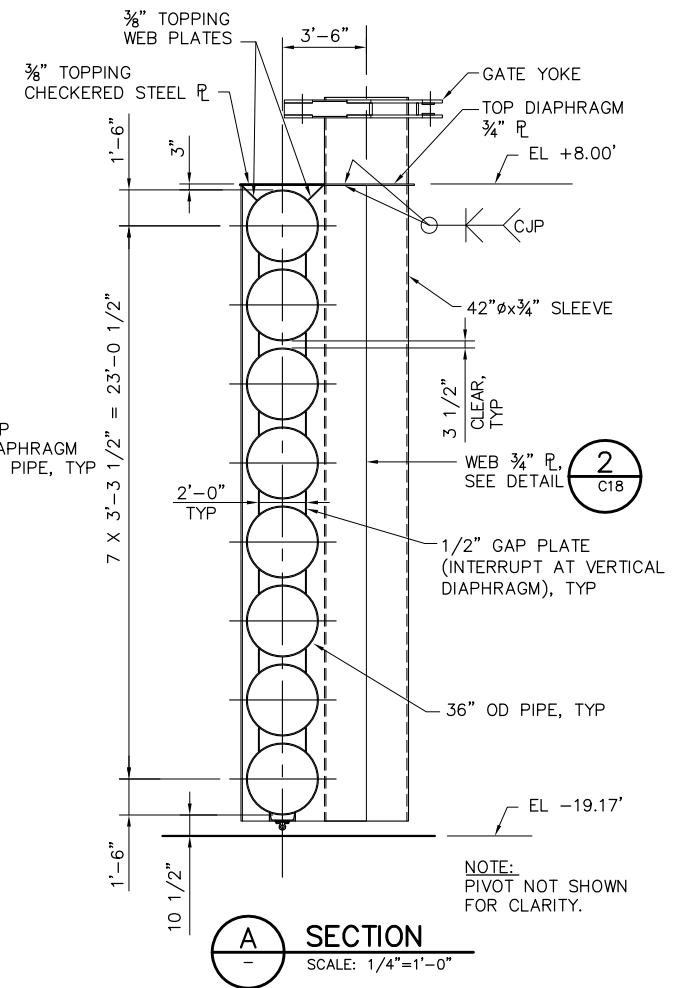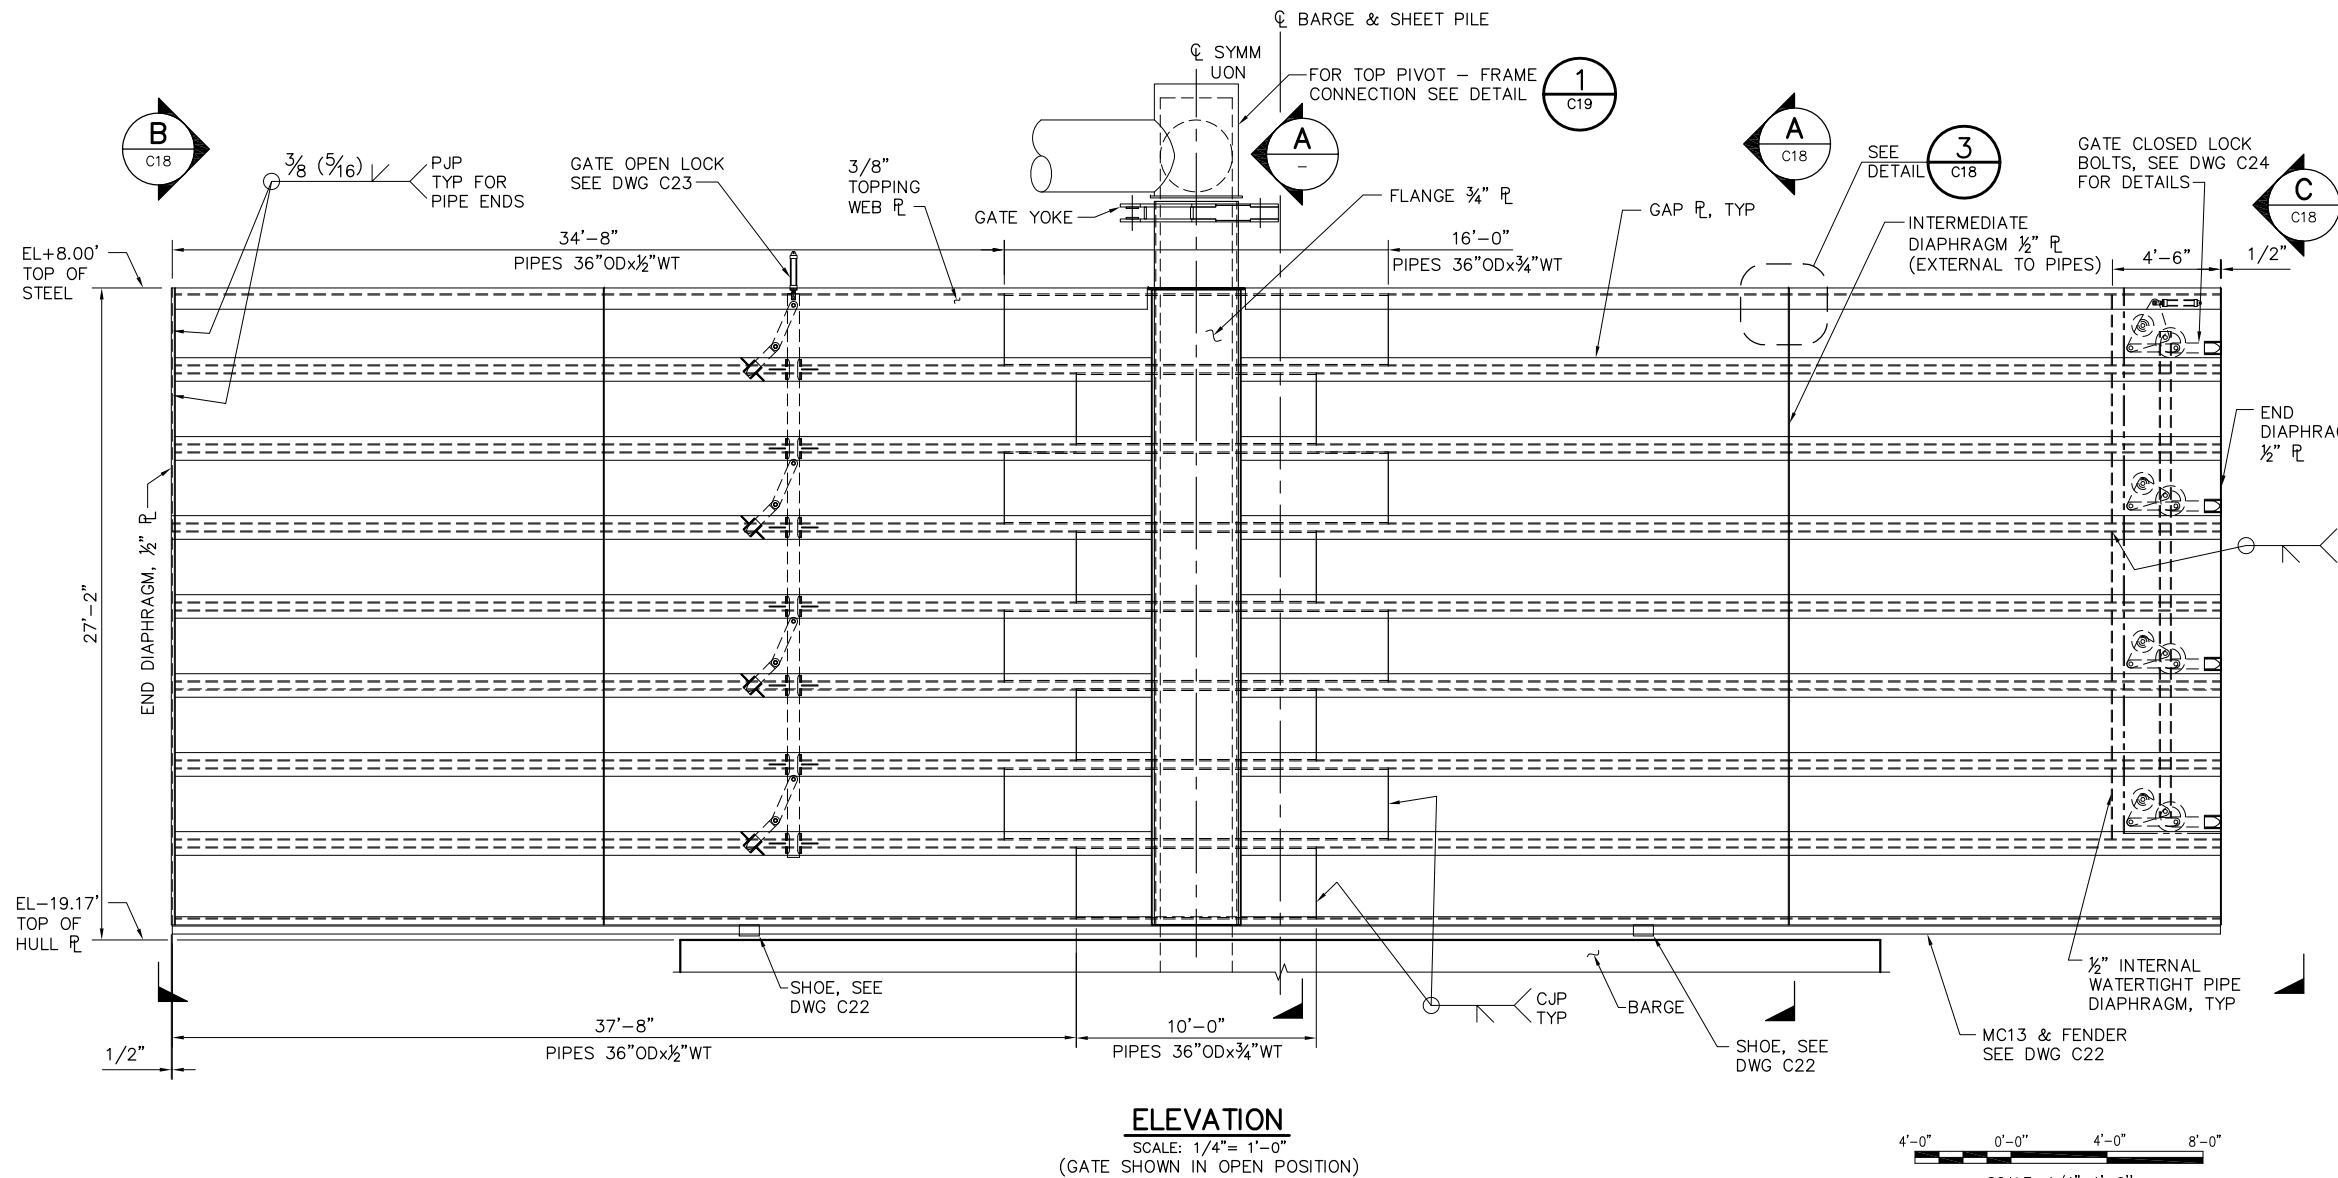

100% SUBMITTAL

IF SHEET IS LESS THAN 22" x 34"
IT IS A REDUCED PRINT -
SCALE REDUCED ACCORDINGLY.

REVISION	DESCRIPTION	BY	DATE



San Luis & Delta-Mendota Water Authority
842 6th Street, Suite 7
PO Box 2157
Los Banos, California 93635

APPROVED
FRANCY C. MIZUNO, PE C35136
San Luis & Delta-Mendota Water Authority

APPROVED
DENNIS G. MAJORS PE C21297
Metropolitan Water District of Southern California



2001 N. Main Street, Suite 360
Walnut Creek, California 94596
(925) 944-5411

DSGN	JMB	DR	AB	CHK	TDB
JOB NO.	6097-03	SUBMITTED BY	RMR		

TWO GATE FISH PROTECTION PLAN


DATE 08/31/09

SHEET 22 OF 78


OLD RIVER
GATE SCANTLINGS

C16


P:\6097-03 SWC GATE DESIGN\CADD\DWG\609703-C17.DWG 8/30/2009 3:34 PM

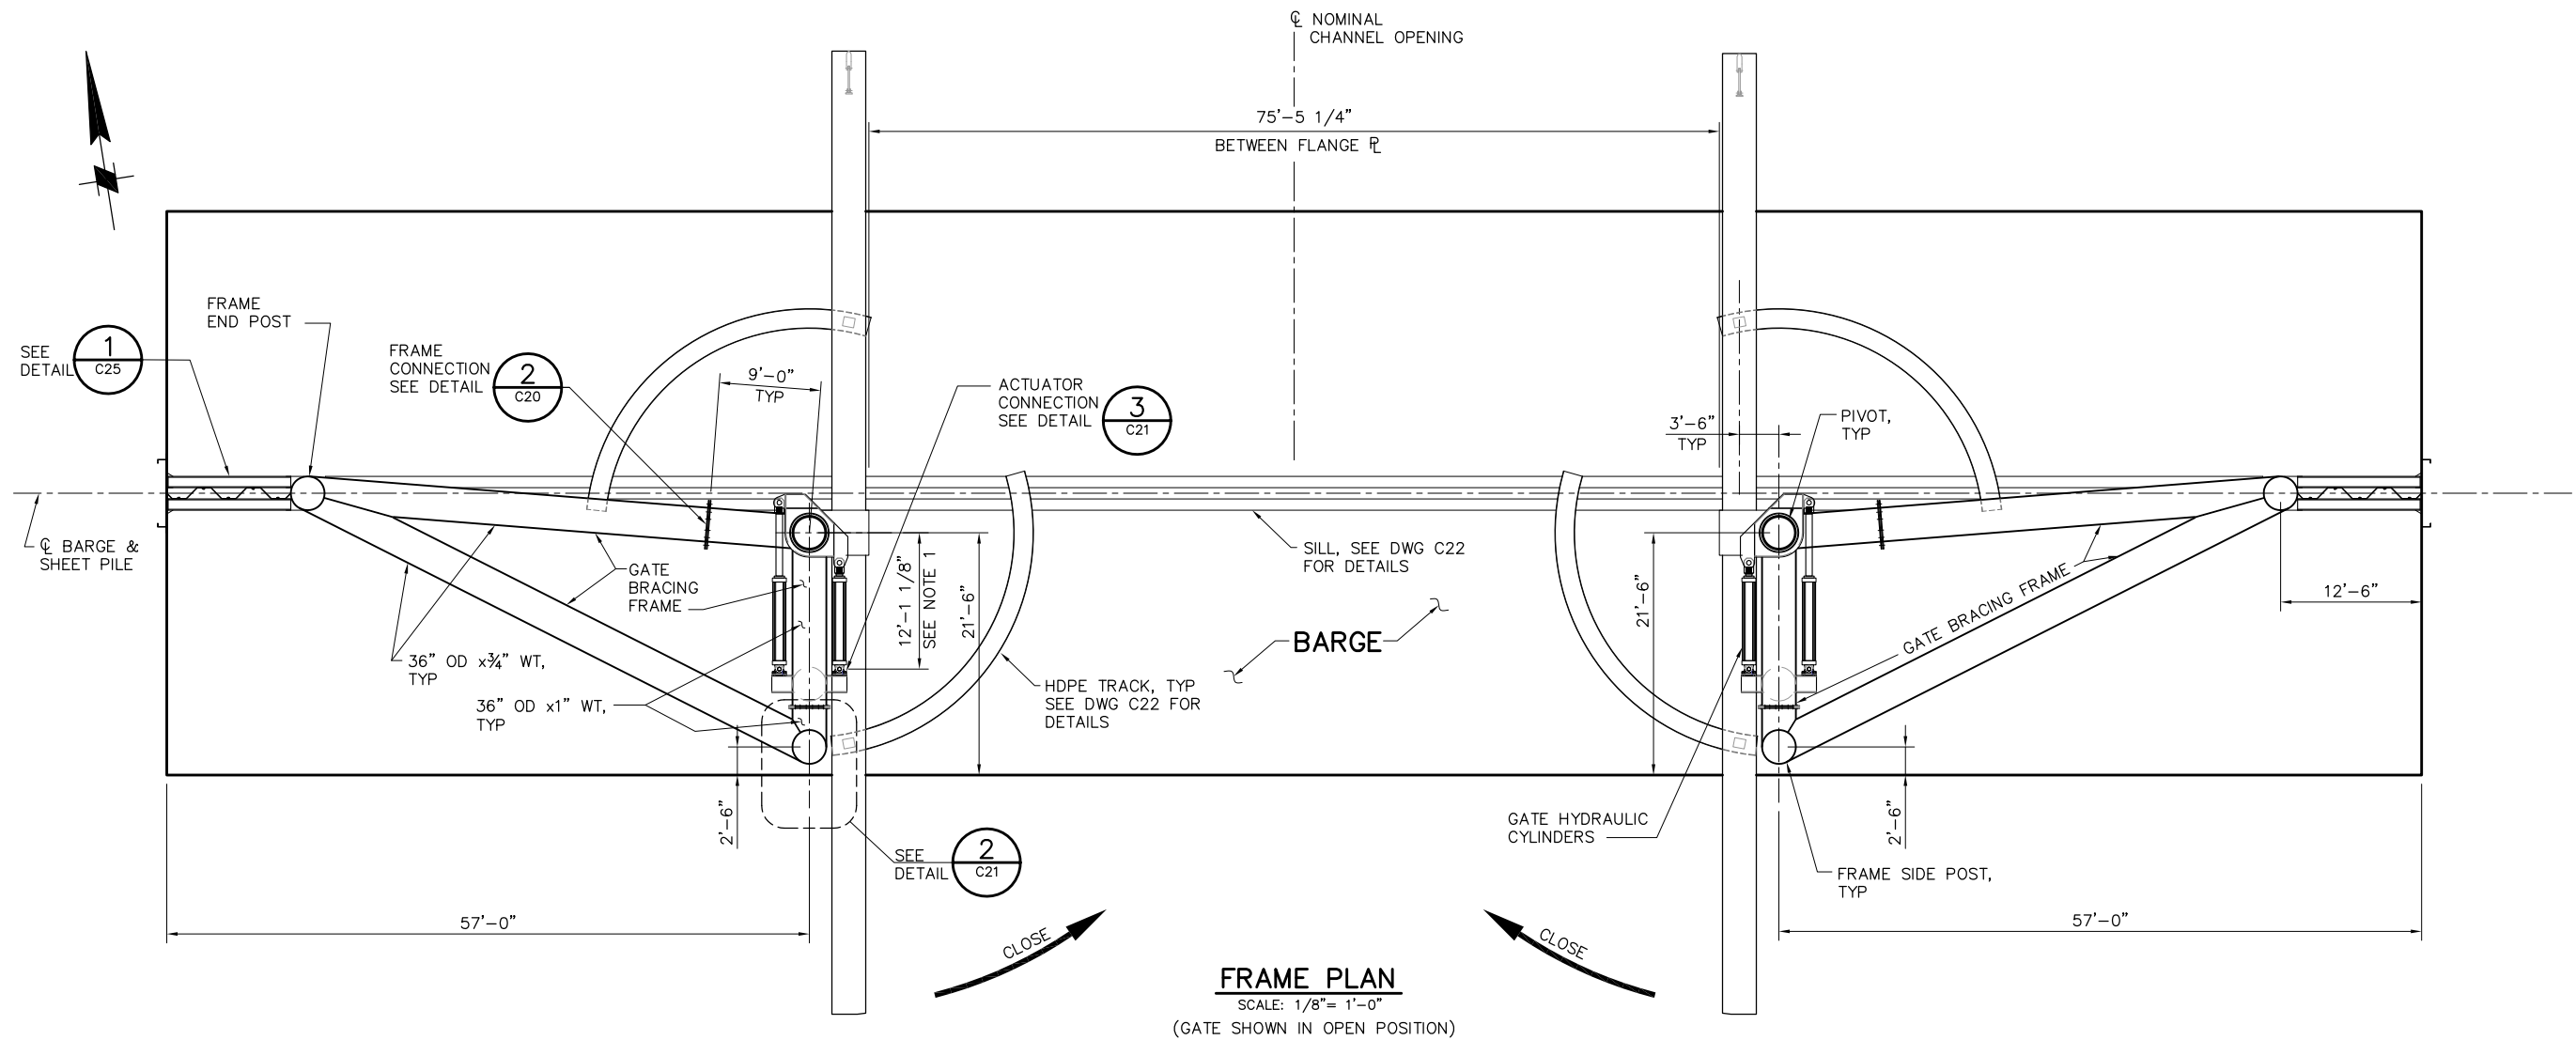

FRAME PLAN
SCALE: 1/8" = 1'-0"
(GATE SHOWN IN OPEN POSITION)

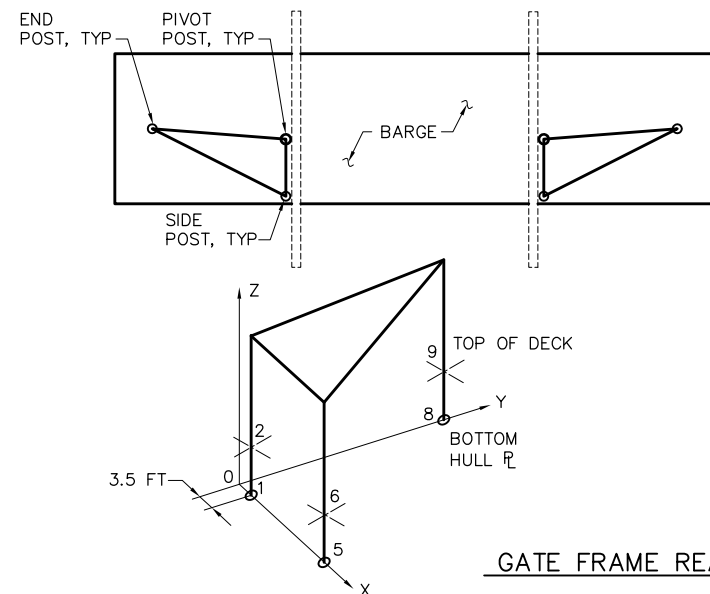

GATE FRAME REACTIONS

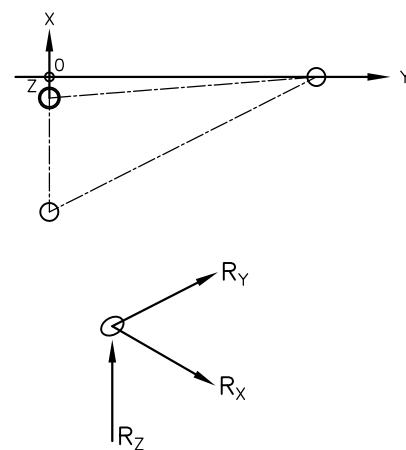


SERVICE LOAD REACTIONS (INCLUDES A 1.2 FACTOR)
(FOR LRFD USE A 1.6 FACTOR WITH THESE REACTIONS)

LOCATION ON BARGE	NODE	R _X (KIP)	R _Y (KIP)	R _Z (KIP)	DESCRIPTION
BOTTOM HULL $\bar{L}$	1	+240 -240	+30 -30	+230 -130	PIVOT
	5	+250 -250	-60 +60	-130 +230	SIDE POST
	8	+50 -50	+40 -40	+100	END POST
TOP OF DECK	2	+710 -710	-50 +50	0	PIVOT
	6	+410 -410	-90 +90	0	SIDE POST
	9	+100 -100	-70 +70	0	END POST

NOTE: CONTRACTOR SHALL PROVIDE A BARGE ADEQUATE TO SUPPORT THESE LOADS.

NOTES:

 1. DIMENSION MAY VARY DEPENDING ON ACTUATOR VENDER.



100% SUBMITTAL

IF SHEET IS LESS THAN 22" x 34"
IT IS A REDUCED PRINT -
SCALE REDUCED ACCORDINGLY.

REVISION	DESCRIPTION	BY	DATE



San Luis & Delta-Mendota Water Authority
842 6th Street, Suite 7
PO Box 2157
Los Banos, California 93635



APPROVED _____
FRANCY C. MIZUNO, PE C35136
San Luis & Delta-Mendota Water Authority

APPROVED _____
DENNIS G. MAJORS PE C21297
Metropolitan Water District of Southern California

		2001 N. Main Street, Suite 360 Walnut Creek, California 94596 (925) 944-5411	
DSGN	CBS	DR	AB
JOB NO.	6097-03	CHK	TDB
SUBMITTED BY		RMR	


TWO GATE FISH PROTECTION PLAN		DATE 08/31/09
OLD RIVER GATE FRAMING LAYOUT		SHEET 23 OF 78
		C17

P:\6097-03 SWC GATE DESIGN\CADD\DWG\609703-C18.DWG 8/27/2009 1:50 PM

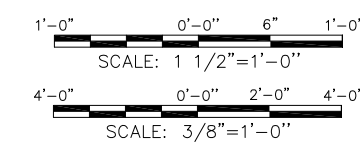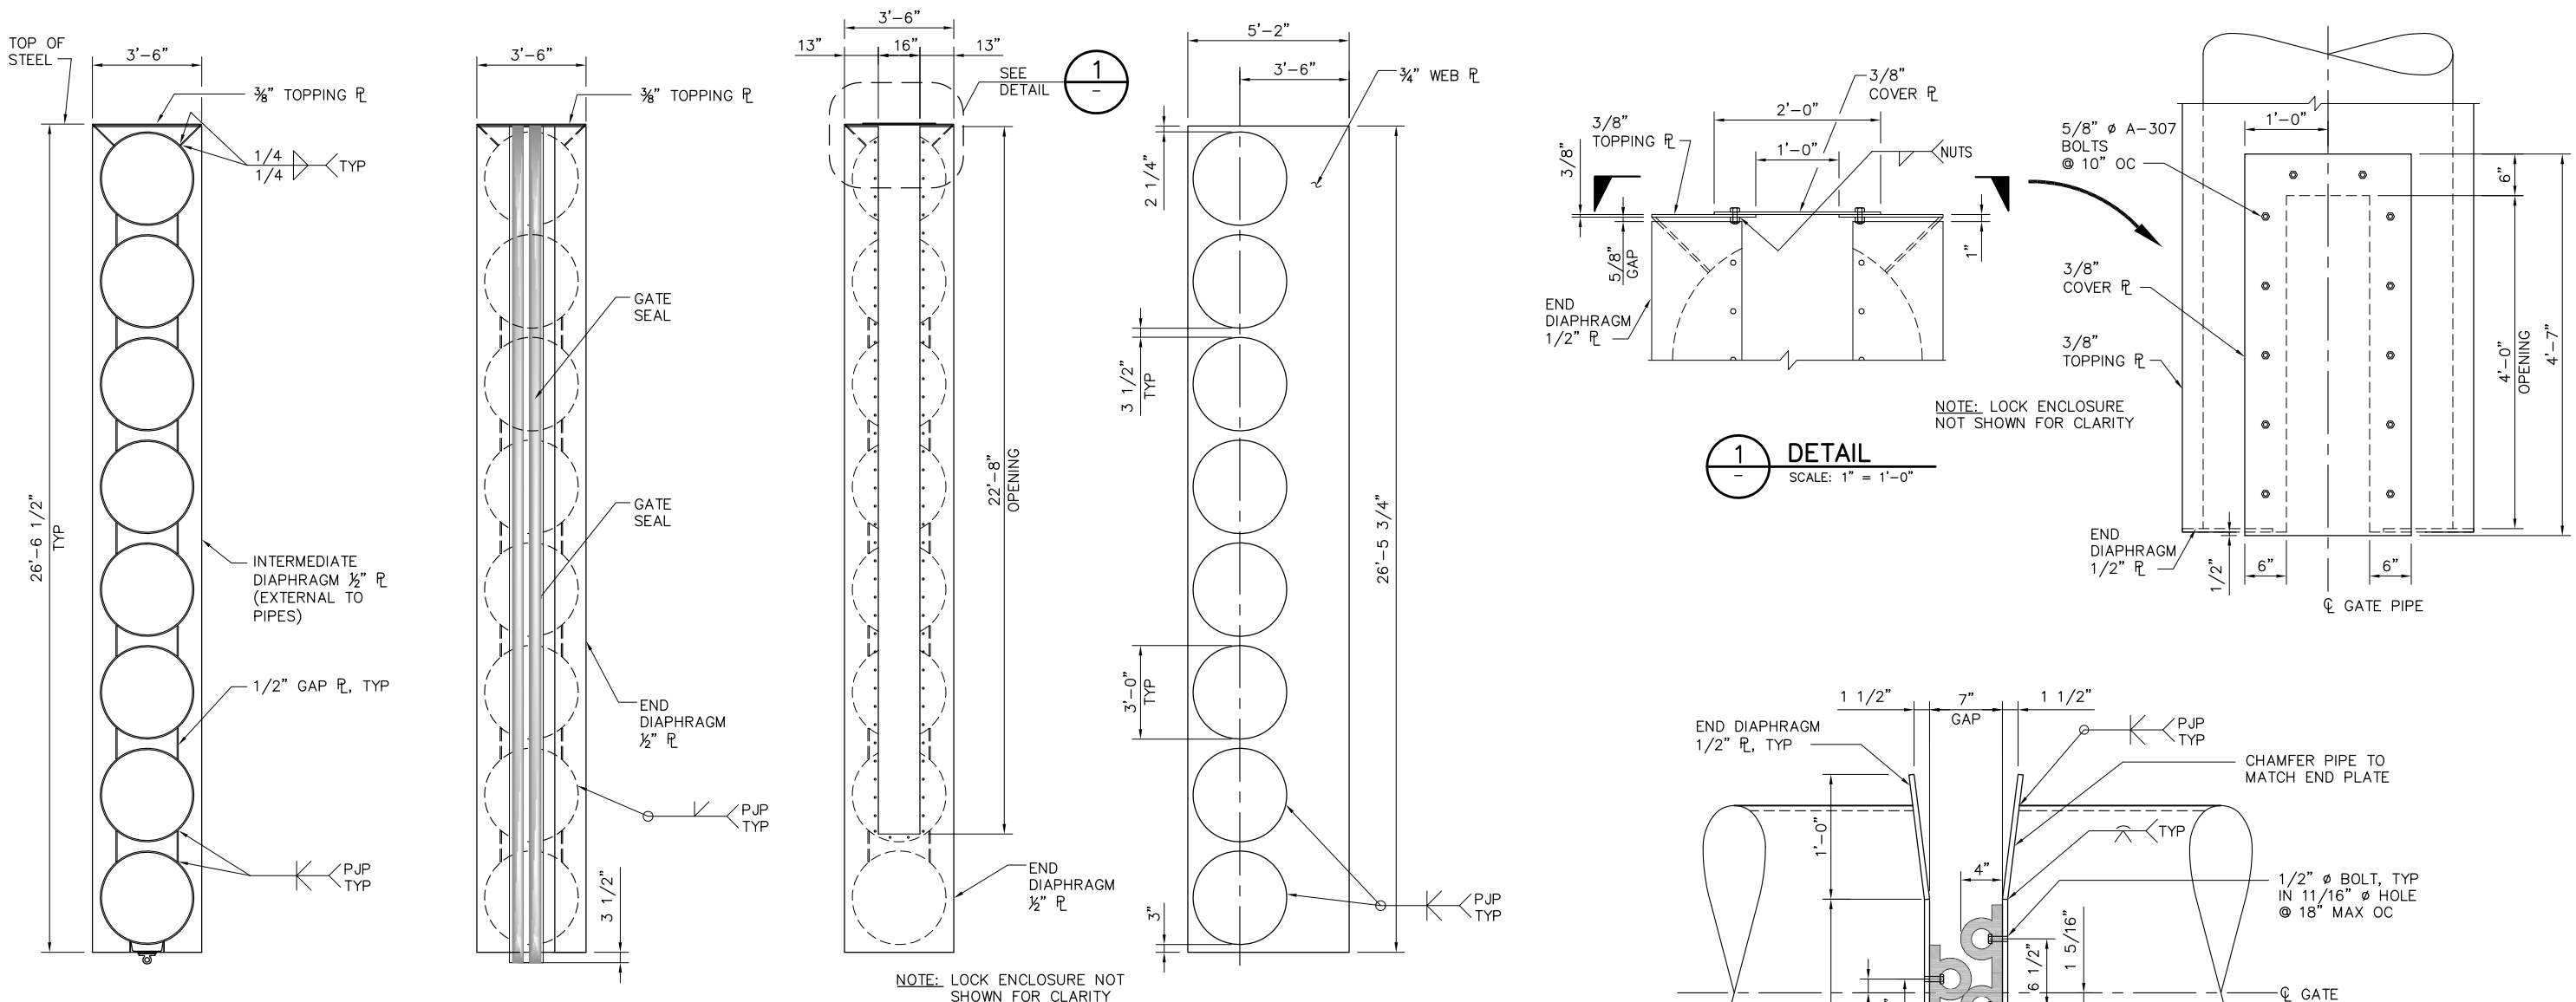

100% SUBMITTAL IF SHEET IS LESS THAN 22" x 34" IT IS A REDUCED PRINT - SCALE REDUCED ACCORDINGLY.

REVISION	DESCRIPTION	BY	DATE

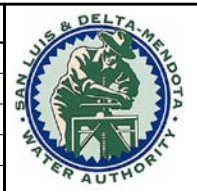

San Luis & Delta-Mendota Water Authority
842 6th Street, Suite 7
PO Box 2157
Los Banos, California 93635

APPROVED _____
FRANCY C. MIZUNO, PE C35136
San Luis & Delta-Mendota Water Authority



APPROVED _____
DENNIS G. MAJORS PE C21297
Metropolitan Water District of Southern California



2001 N. Main Street, Suite 360
Walnut Creek, California 94596
(925) 944-5411


DSGN	JMB	DR	AB	CHK	TDB
JOB NO.	SUBMITTED BY				
6097-03	RMR				

TWO GATE FISH PROTECTION PLAN		DATE 08/31/09
OLD RIVER GATE STRUCTURAL DETAILS, SHEET 1		SHEET 24 OF 78
C18		

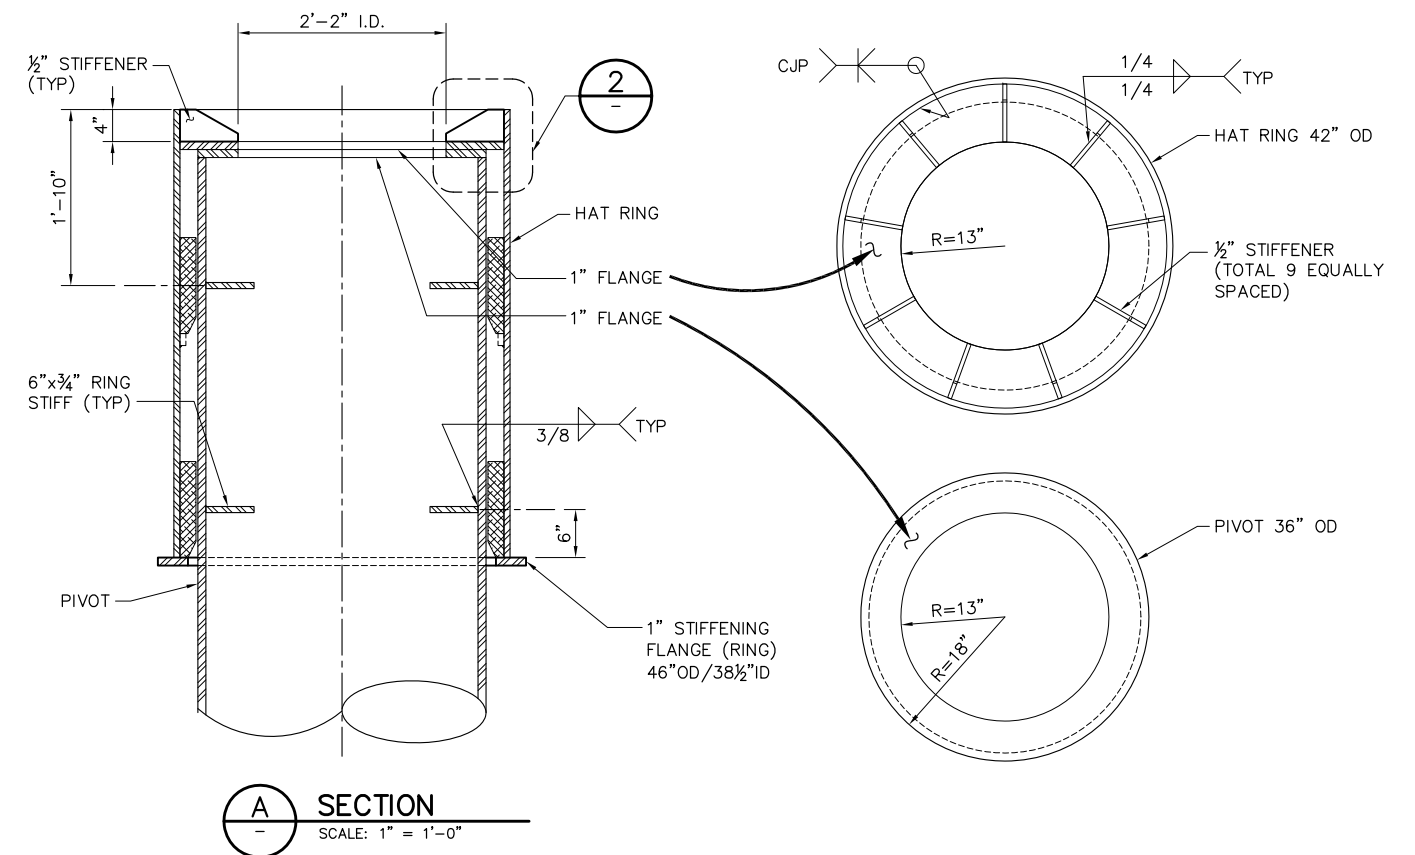 

1'-0" 0'-0" 1'-0" 2'-0"
SCALE: 1"=1'-0"






REVISION	DESCRIPTION	BY	DATE

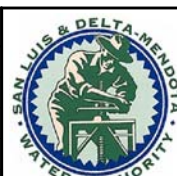

DSGN	JMB/CBS	DR	AB	CHK	TDB
JOB NO.	6097-03	SUBMITTED BY	RMR		


C19

P:\6097-03 SWC GATE DESIGN\CADD\DWG\609703-C20.DWG 8/30/2009 2:44 PM

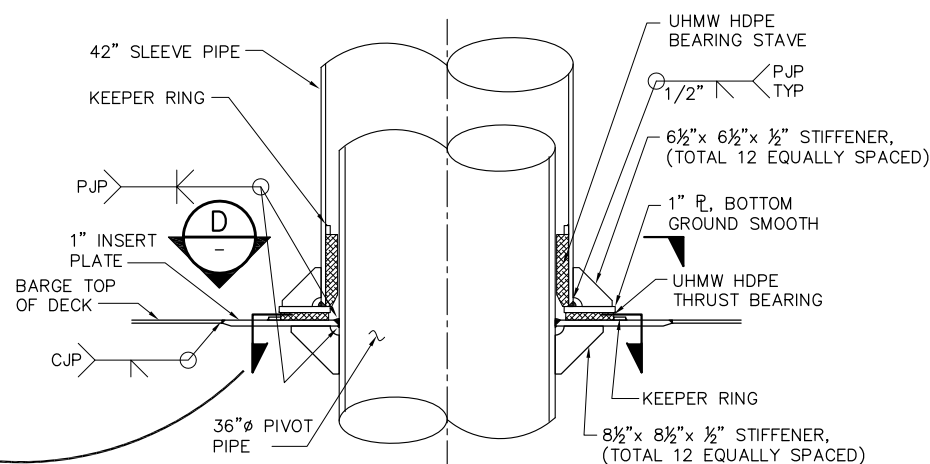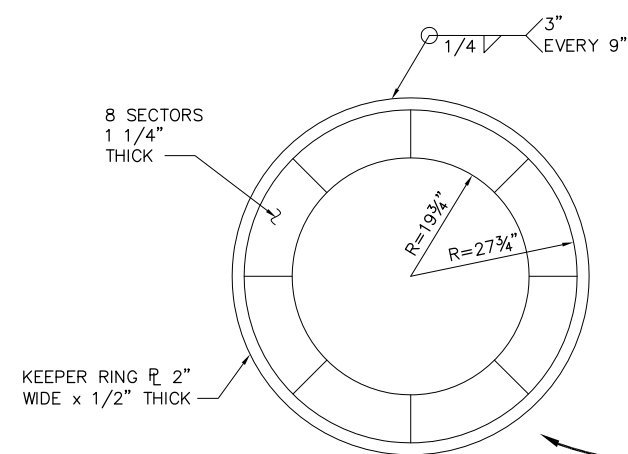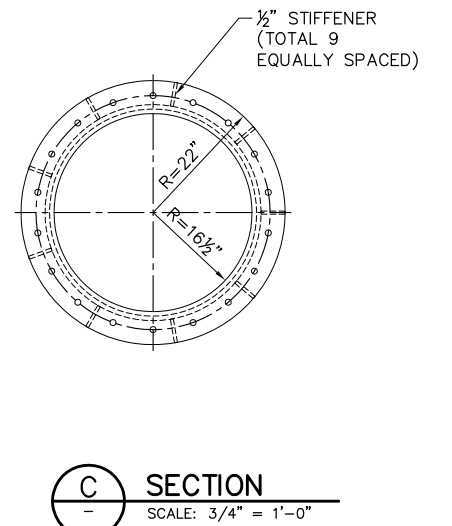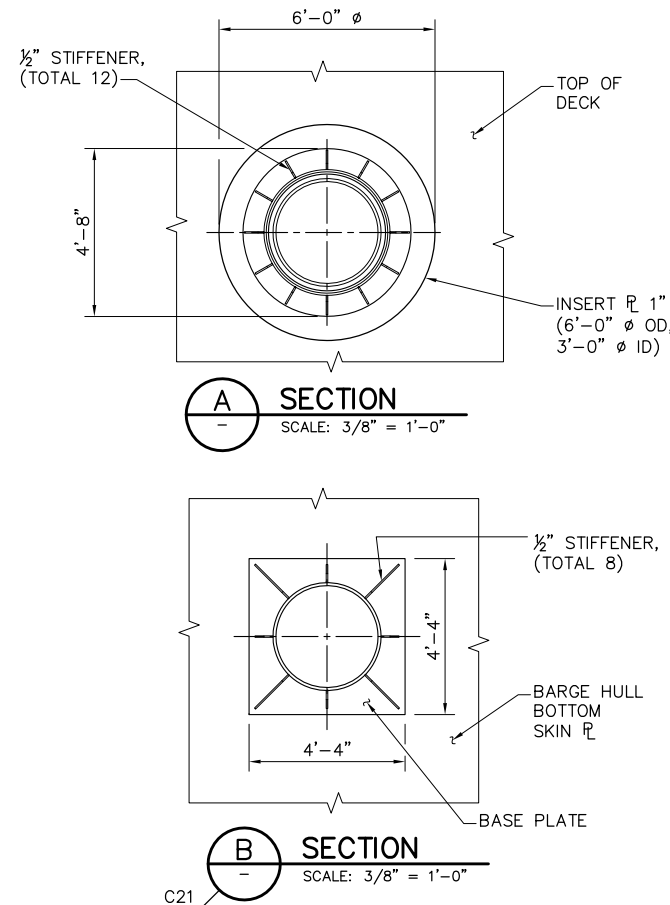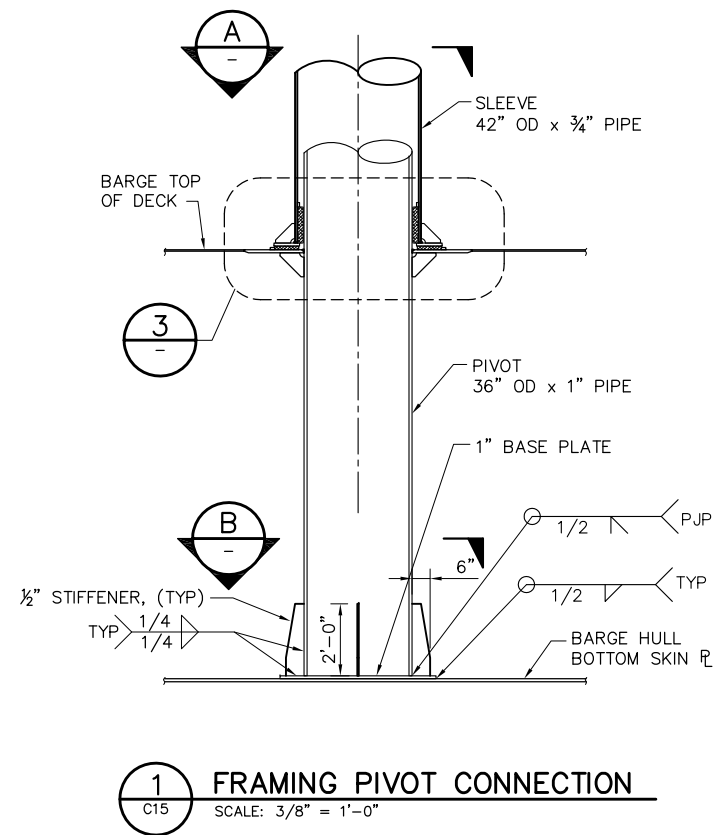

NOTES:

1. ALL STIFFENER WELDS SHALL BE SYMMETRICAL 1/4" MIN. FILLET WELDS U.N.O.

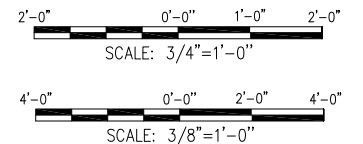

100% SUBMITTAL

IF SHEET IS LESS THAN 22" x 34"
IT IS A REDUCED PRINT -
SCALE REDUCED ACCORDINGLY.

REVISION	DESCRIPTION	BY	DATE



San Luis & Delta-Mendota Water Authority
842 6th Street, Suite 7
PO Box 2157
Los Banos, California 93635

APPROVED _____
FRANCY C. MIZUNO, PE C35136
San Luis & Delta-Mendota Water Authority

APPROVED _____
DENNIS G. MAJORS PE C21297
Metropolitan Water District of Southern California

		2001 N. Main Street, Suite 360 Walnut Creek, California 94596 (925) 944-5411	
DSGN	JMB/CBS	DR	AB
JOB NO.	6097-03	SUBMITTED BY	RMR

TWO GATE FISH PROTECTION PLAN		DATE 08/31/09
OLD RIVER GATE STRUCTURAL DETAILS SHEET 3		SHEET 26 OF 78
C20		

2 "SIDE POST" CONNECTION
 SCALE: 1/2" = 1'-0"

The drawing includes the following details and labels:

- Side View (Left):**
 - FRAME SIDE POST
 - RING STIFFENER
 - 8 1/4"
 - 3/4"
 - 3/4" CONNECTION DIAPHRAM PLATE
 - PIN SOCKET (SEE DETAIL)
 - 6 C23
 - PIPE LENGTH 3'-5"
- Cross-Section View (Right):**
 - EL +15'-2 1/2"
 - 38" x 1 1/2" COVER
 - 2" MAX
 - CONNECTION FLANGE
 - CJP TYP
 - 3/4" RING STIFFENER
 - PIN SOCKET (4 PLACES)
 - FRAME SIDE POST
 - PJP TYP
 - 36" OD x 1" POST
 - 1" INSERT 6'-0" OD, 3'-0" ID
 - CJP TYP
 - TOP DECK PLATE
 - 1" BASE PLATE
 - 6"
 - 1/2"
 - 1/2" TYP
 - 1/4" TYP
 - 1/4"
 - 1/2" STIFFENER, (TYP)
 - HULL BOTTOM SKIN PLATE
 - 2'-0"
 - SIM B C20

2'-8"

36"Ø GATE BRACING FRAME

PARTIAL Π

FRAME CONNECTION DETAIL SEE $\frac{2}{C20}$

Diagram showing the elevation view of the gate bracing frame. The frame is a vertical cylinder with a diameter of 36 inches. It is supported by a base plate. The frame is braced by a horizontal member (labeled 2'-8") and a vertical member (labeled PARTIAL Π). The frame is connected to the gate structure (labeled D) and the gate connection detail is shown in detail (labeled 2/C20).

FRAME CONNECTION
DETAIL SEE 2
C20

36"Ø GATE
BRACING FRAME

CJP
TYP

36"Ø X 1"
BRACKET STUB

3/4" CLOSURE PL

18" SQ BRACKET
3/4" PL T&B,
1" PL EA SIDE

B SECTION

SCALE: 1/2" = 1'-0"

36" ϕ GATE BRACING FRAME

36" ϕ BRACKET STUB

$\frac{3}{4}$ " PARTIAL ϕ

6'-8"

2'-3"

3'-4"

1'-6"

0"

SECTION

SCALE: 1/2" = 1'-0"

36" Ø GATE BRACING FRAME

1'-9"

1'-6"

NFPA PIVOT BRACKET, MODEL 76, PART NO. C1906-76

3/4" PARTIAL FL


C

SECTION

SCALE: 1/2" = 1'-0"

4

C SECTION
SCALE: 1/2" = 1'-0"


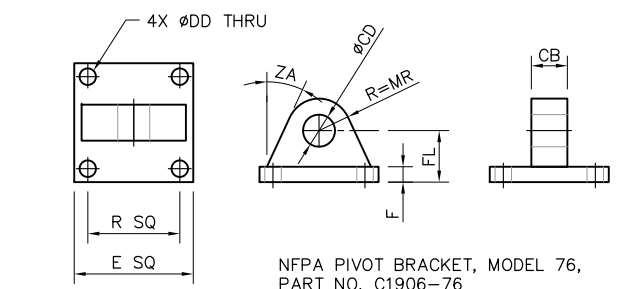


4 DETAIL
SCALE: 1"=1'-0"

2'-0" 0'-0" 2'-0" 4'-0"


SCALE: 1/2"=1'-0"

REVISION	DESCRIPTION	BY	DATE

 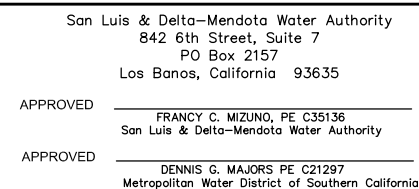


C21


P:\6097-03 SVC GATE DESIGN\CADD\DWG\609703-C22.DWG 8/27/2009 1:45 PM

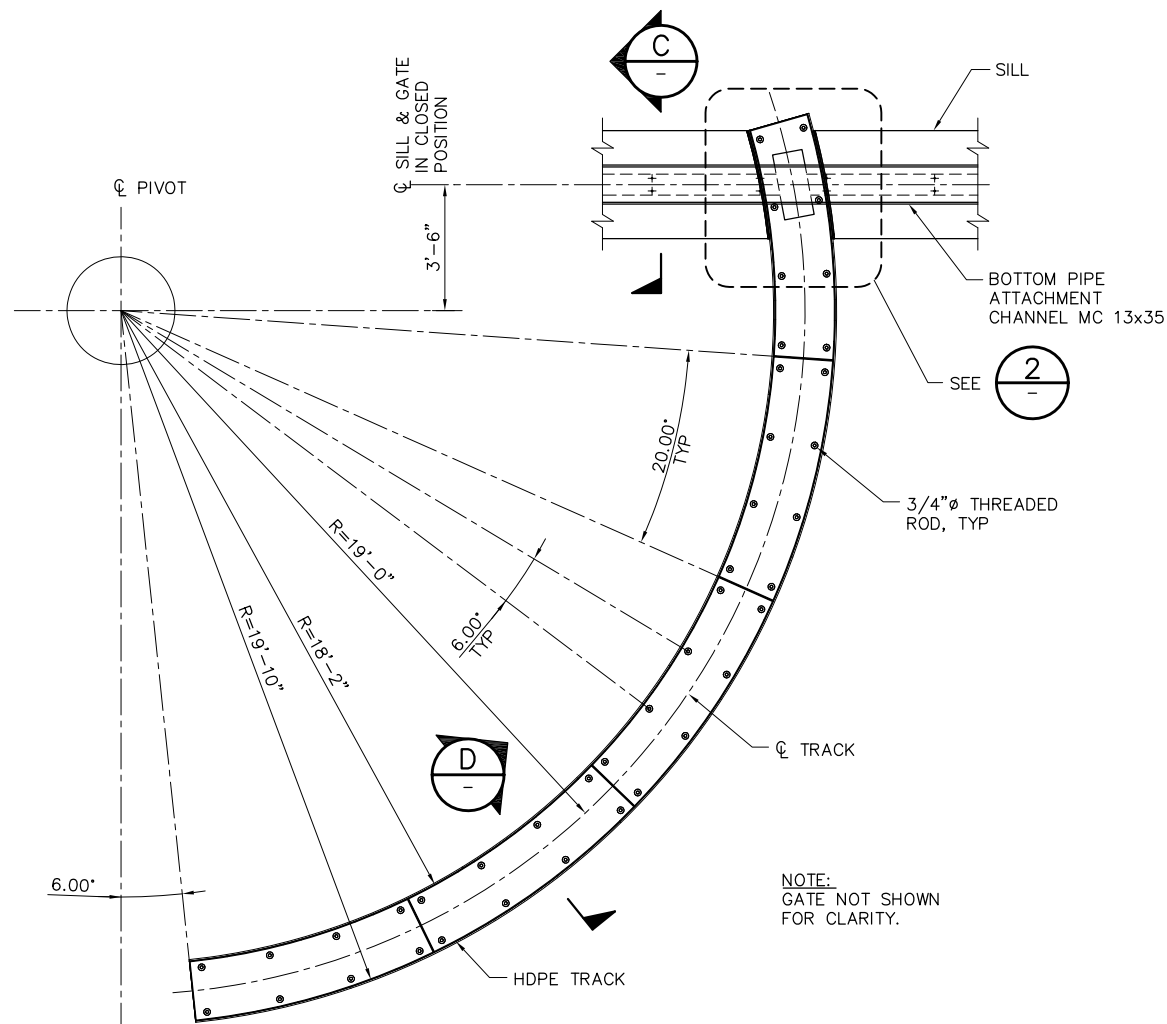


1 TRACK DETAIL
SCALE: 3/8" = 1'-0"

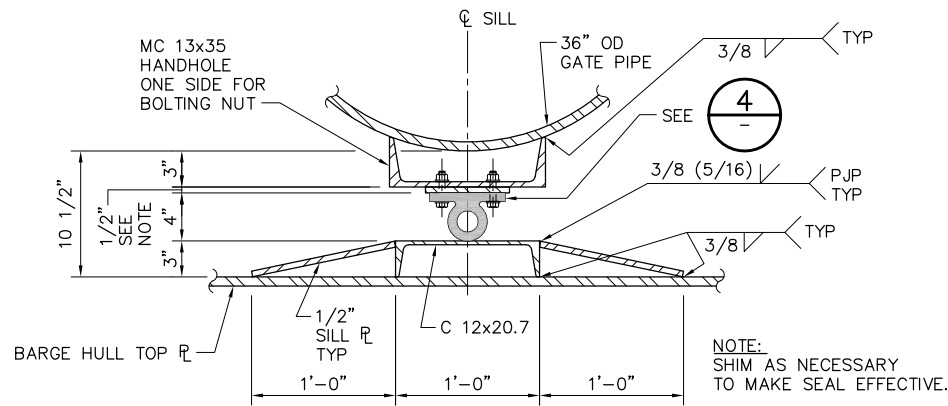


2 SECTION
SCALE: 1 1/2" = 1'-0"

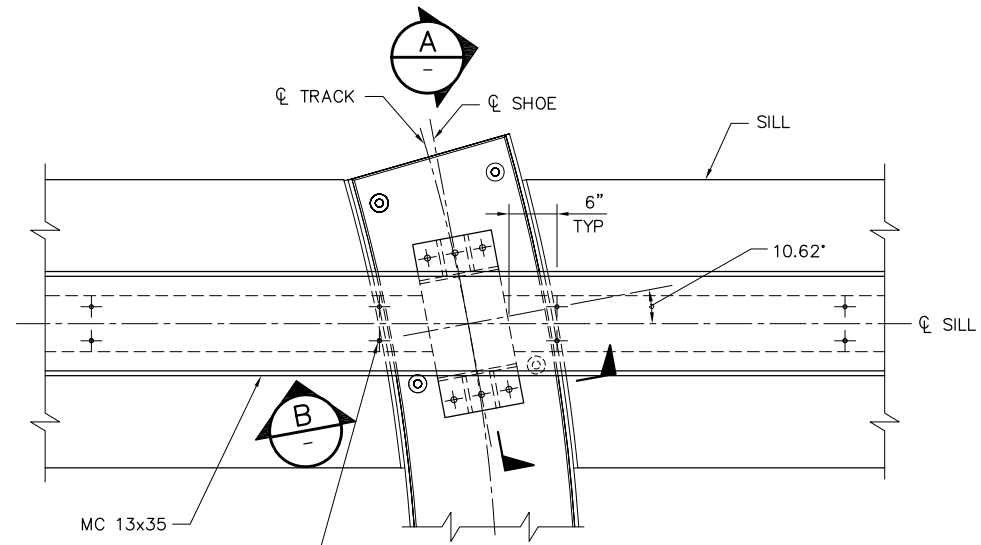


3 DETAIL
SCALE: 1" = 1'-0"

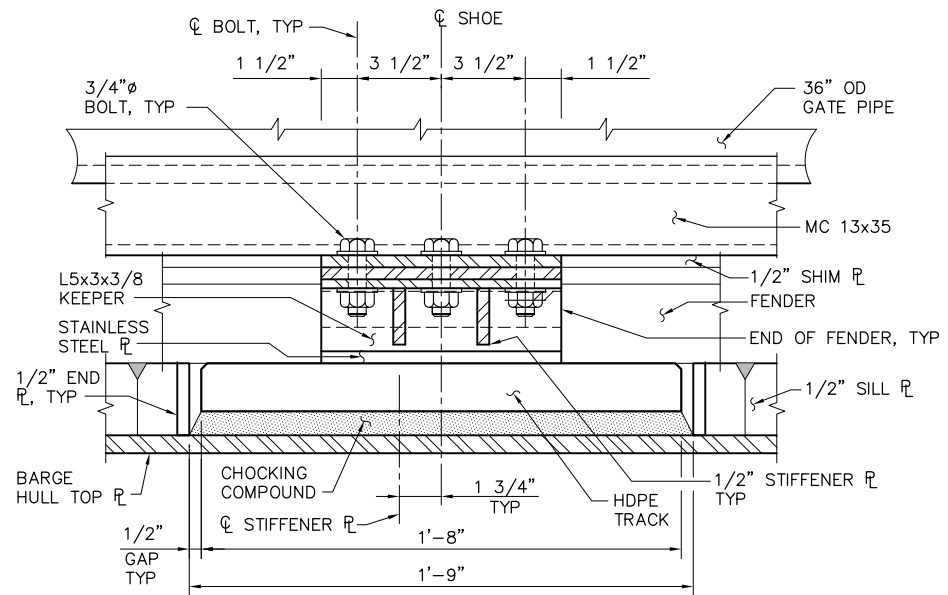


4 SECTION
SCALE: 3" = 1'-0"

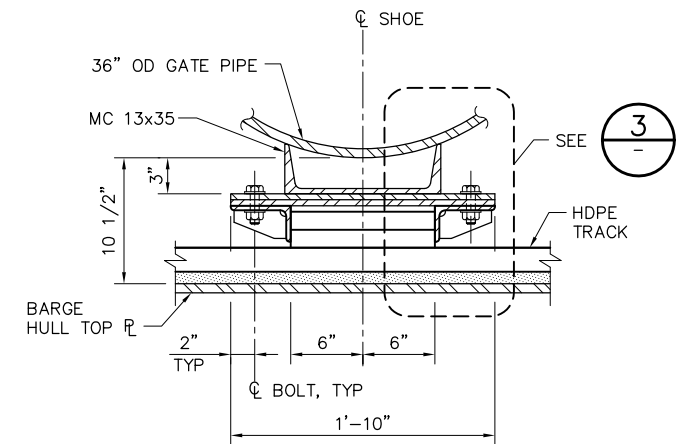


5 SECTION
SCALE: 1 1/2" = 1'-0"

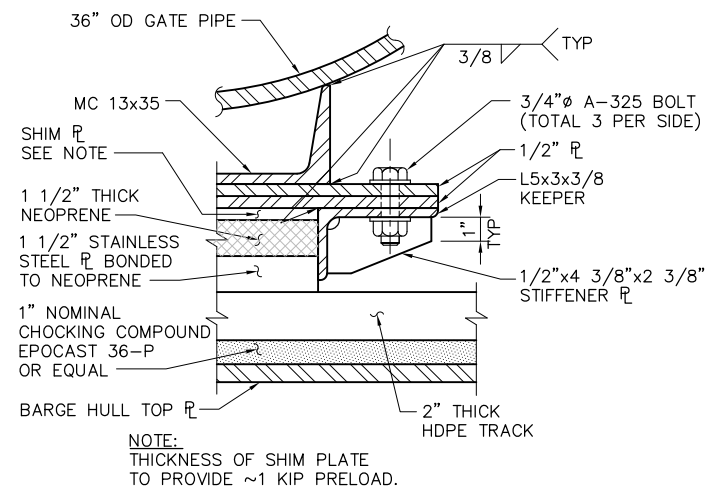


6 DETAIL
SCALE: 3" = 1'-0"

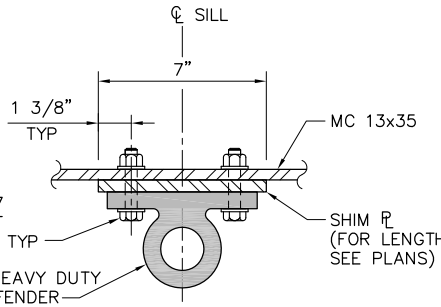


7 DETAIL
SCALE: 3" = 1'-0"

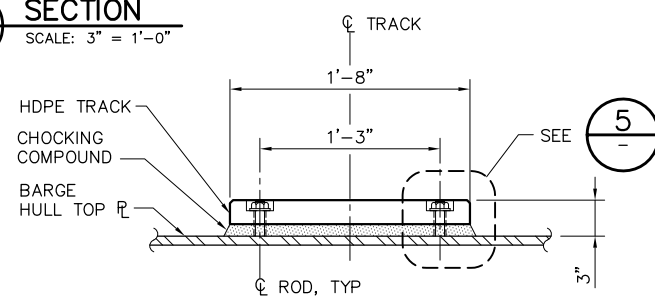

8 SECTION
SCALE: 1 1/2" = 1'-0"

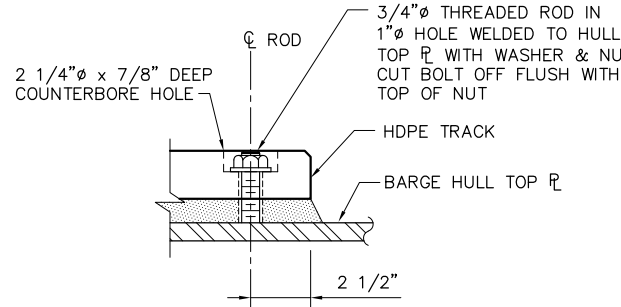

9 DETAIL
SCALE: 3" = 1'-0"

 

100% SUBMITTAL IF SHEET IS LESS THAN 22" x 34" IT IS A REDUCED PRINT - SCALE REDUCED ACCORDINGLY.

REVISION	DESCRIPTION	BY	DATE



San Luis & Delta-Mendota Water Authority
842 6th Street, Suite 7
PO Box 2157
Los Banos, California 93635

APPROVED
FRANCY C. MIZUNO, PE C35136
San Luis & Delta-Mendota Water Authority

APPROVED
DENNIS G. MAJORS PE C21297
Metropolitan Water District of Southern California


Moffatt & Nichol		2001 N. Main Street, Suite 360 Walnut Creek, California 94596 (925) 944-5411	
DSGN	JMB	DR	AB
JOB NO.	6097-03	SUBMITTED BY	RMR

TWO GATE FISH PROTECTION PLAN


OLD RIVER
GATE STRUCTURAL DETAILS,
SHEET 5

DATE 08/31/09
SHEET 28 OF 78
C22

P:\6097-03 SWC GATE DESIGN\CADD\DWG\609703-C23.DWG 8/30/2009 4:35 PM

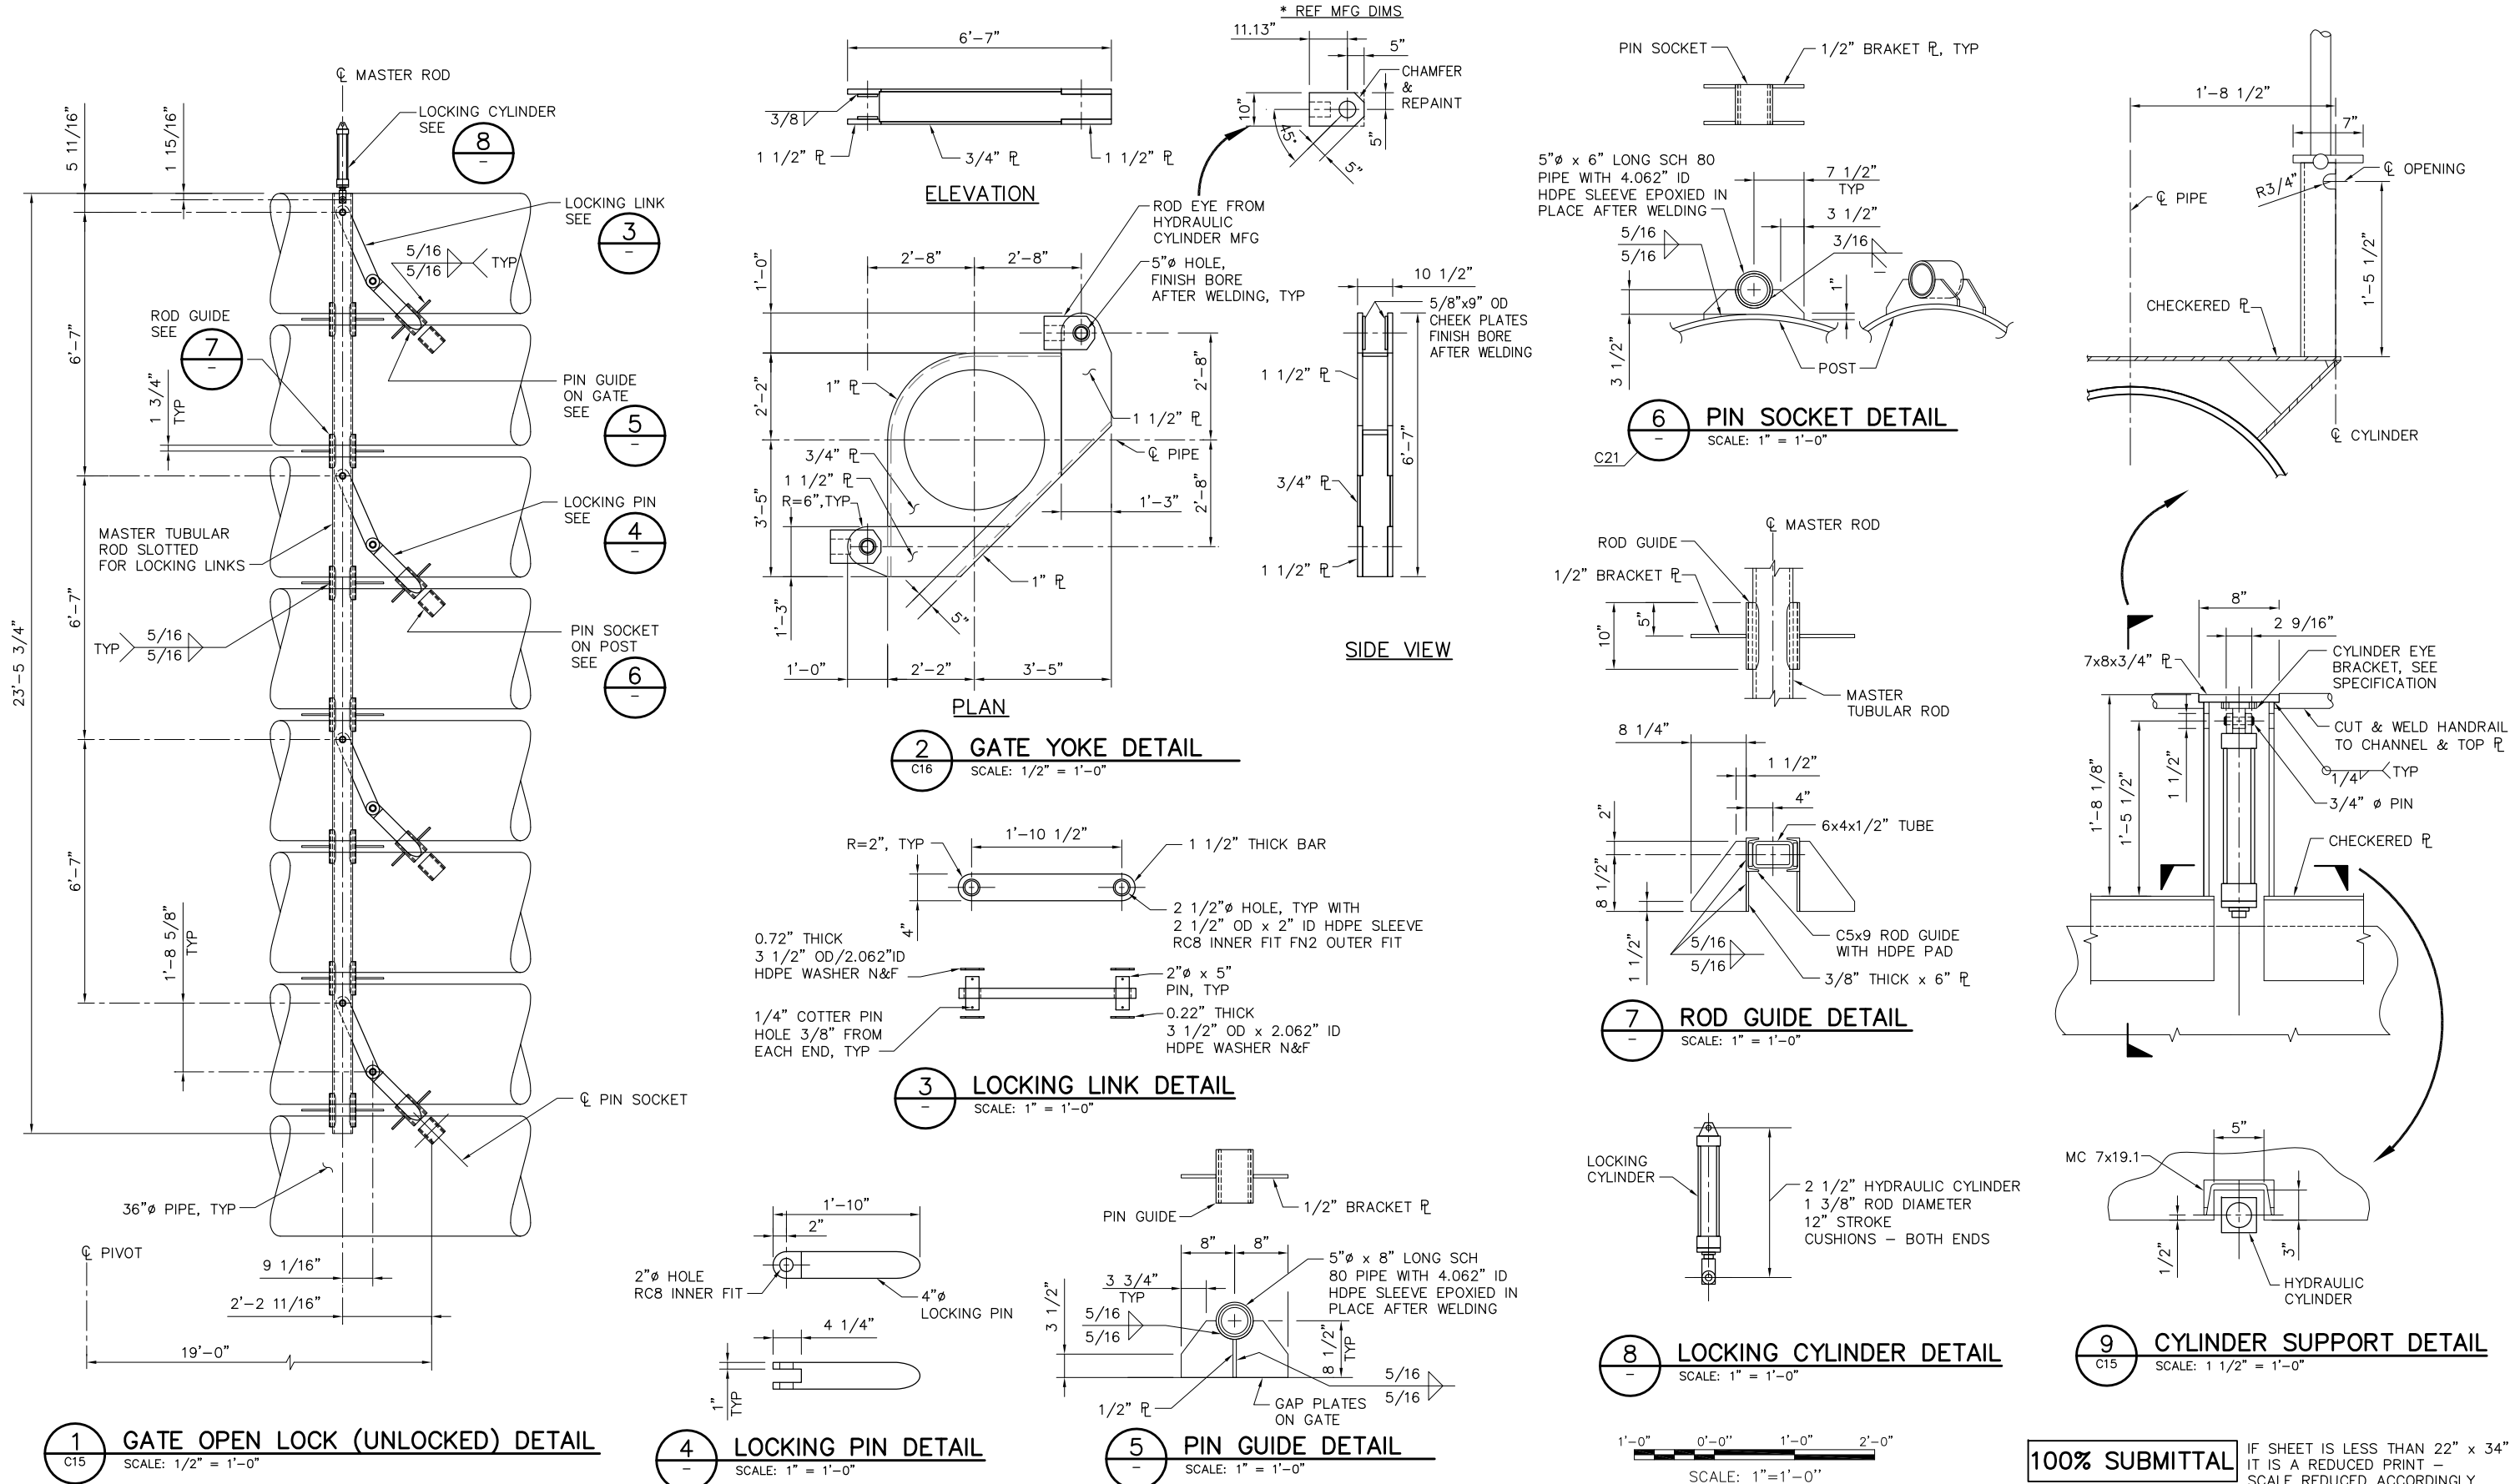

REVISION	DESCRIPTION	BY	DATE

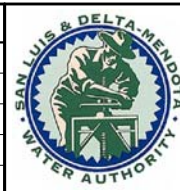

San Luis & Delta-Mendota Water Authority
842 6th Street, Suite 7
PO Box 2157
Los Banos, California 93635

APPROVED
FRANCY C. MIZUNO, PE C35136
San Luis & Delta-Mendota Water Authority

APPROVED
DENNIS G. MAJORS PE C21297
Metropolitan Water District of Southern California
















2001 N. Main Street, Suite 360
Walnut Creek, California 94596
(925) 944-5411

DSGN CBS DR AB/TAE CHK TDB
JOB NO. 6097-03 SUBMITTED BY RMR

TWO GATE FISH PROTECTION PLAN	DATE 08/31/09
OLD RIVER GATE MECHANICAL DETAILS SHEET 1	SHEET 29 OF 78
C23	

P:\6097-03 SWC GATE DESIGN\CADD\DWG\609703-C24.DWG 8/29/2009 7:45 PM

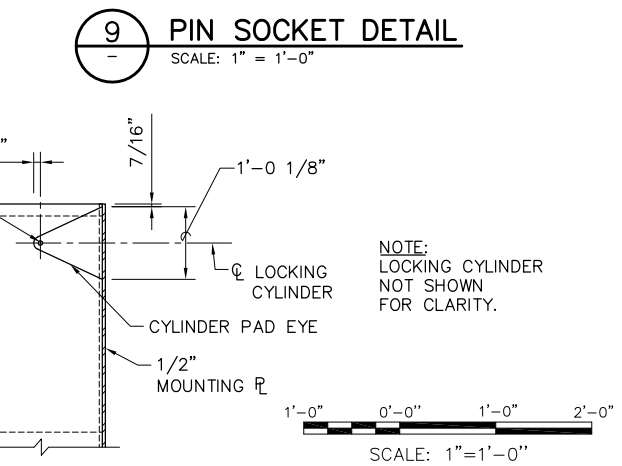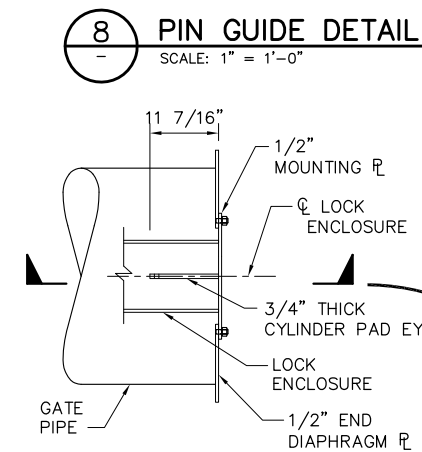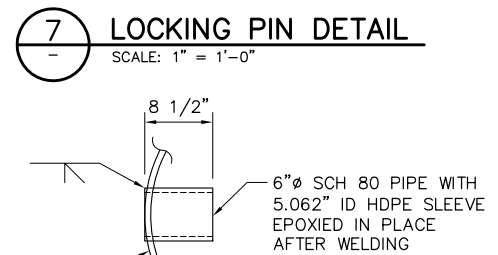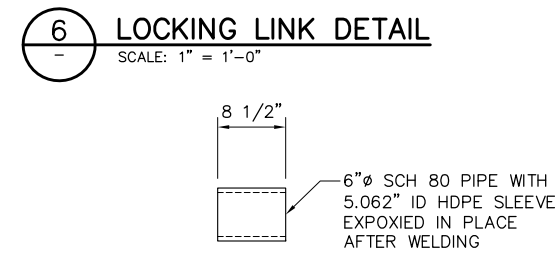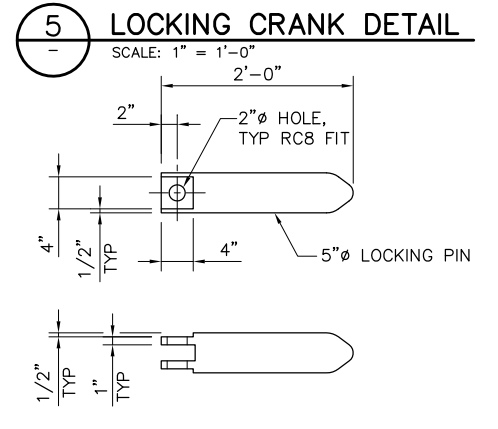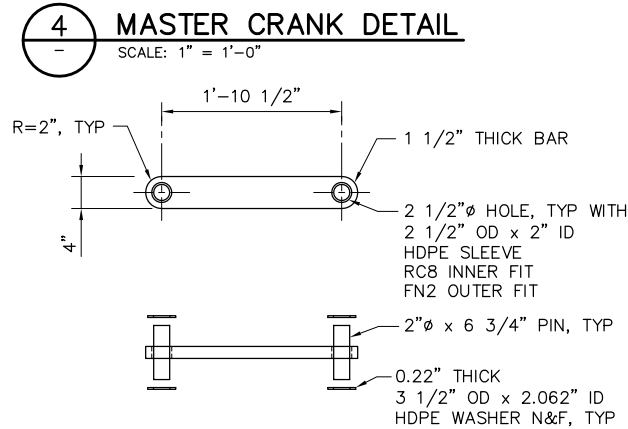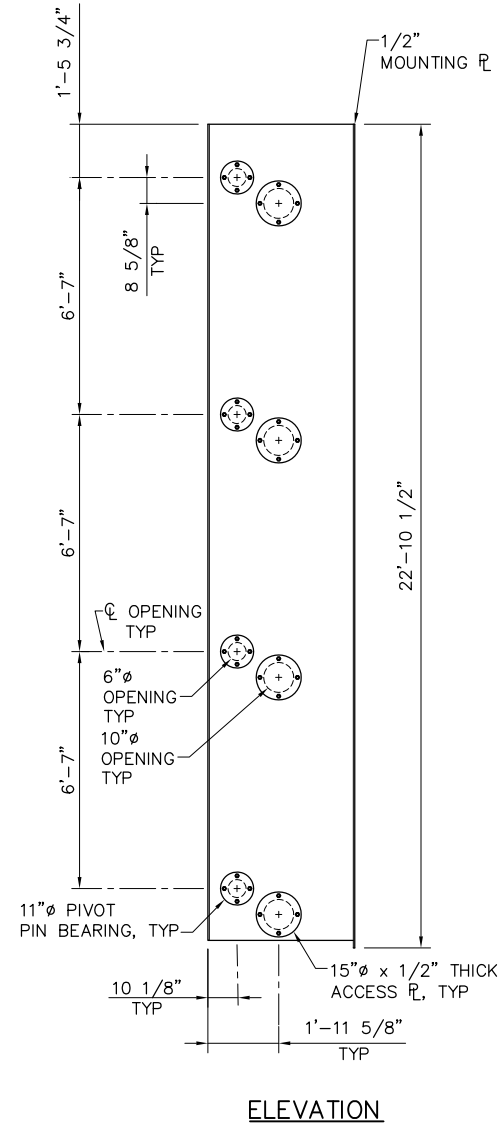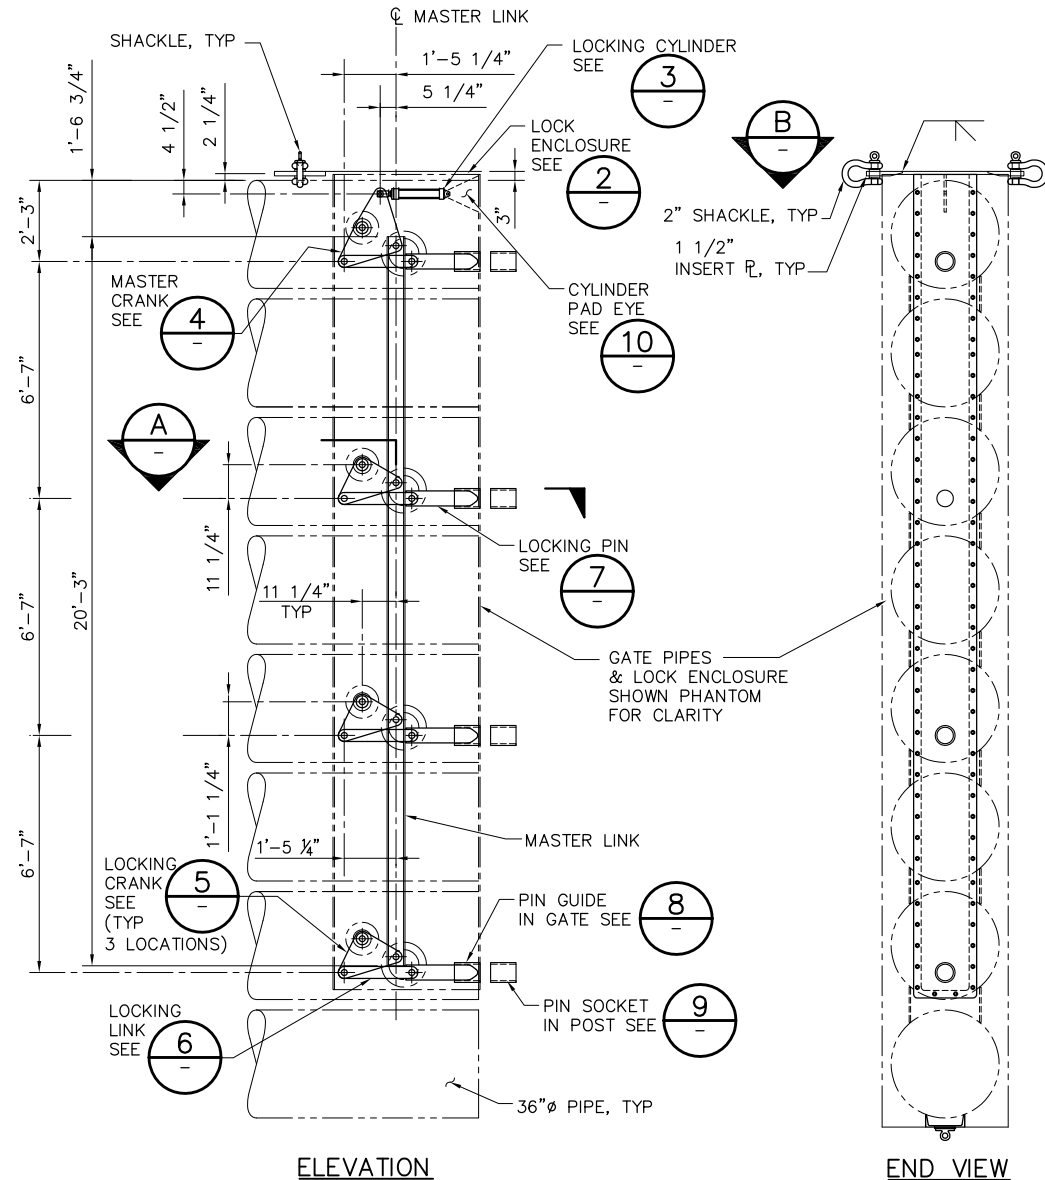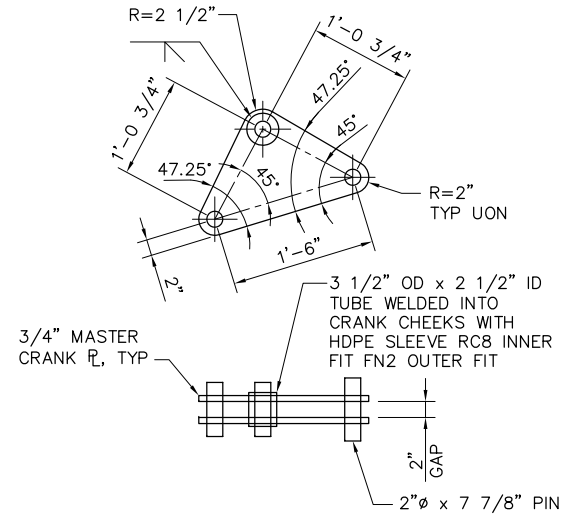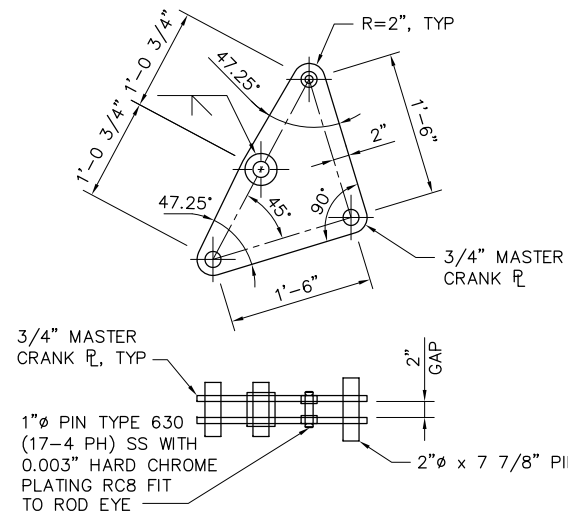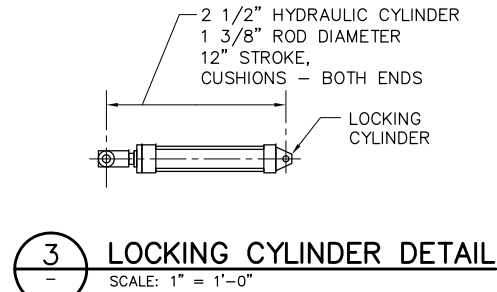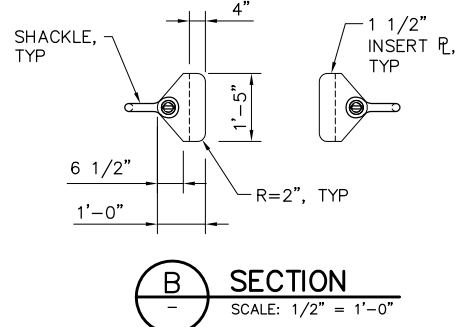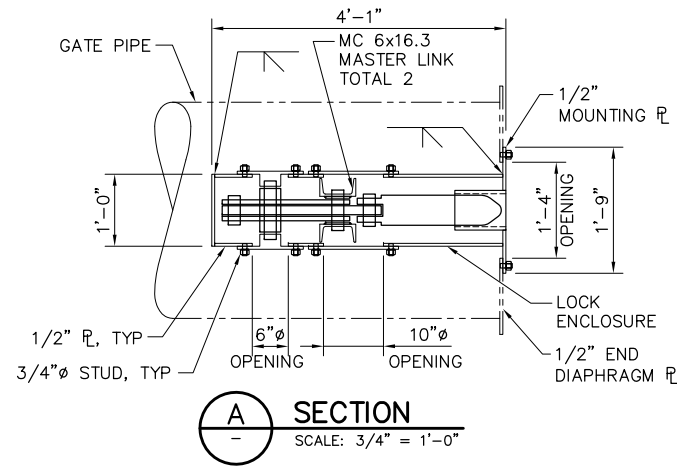


1 GATE CLOSED LOCK (UNLOCKED) DETAIL
SCALE: 3/8" = 1'-0"

2 LOCK ENCLOSURE DETAIL
SCALE: 3/8" = 1'-0"

10 CYLINDER PAD EYE DETAIL
SCALE: 3/4" = 1'-0"

100% SUBMITTAL
IF SHEET IS LESS THAN 22" x 34"
IT IS A REDUCED PRINT -
SCALE REDUCED ACCORDINGLY.

REVISION	DESCRIPTION	BY	DATE

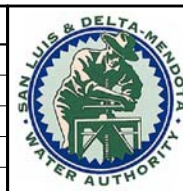

San Luis & Delta-Mendota Water Authority
842 6th Street, Suite 7
PO Box 2157
Los Banos, California 93635

APPROVED
FRANCY C. MIZUNO, PE C35136
San Luis & Delta-Mendota Water Authority

APPROVED
DENNIS G. MAJORS PE C21297
Metropolitan Water District of Southern California




2001 N. Main Street, Suite 360
Walnut Creek, California 94596
(925) 944-5411

DSGN CBS DR AB CHK TDB
JOB NO. 6097-03 SUBMITTED BY RMR


TWO GATE FISH PROTECTION PLAN

OLD RIVER
GATE MECHANICAL DETAILS
SHEET 2

DATE 08/31/09
SHEET 30 OF 78
C24

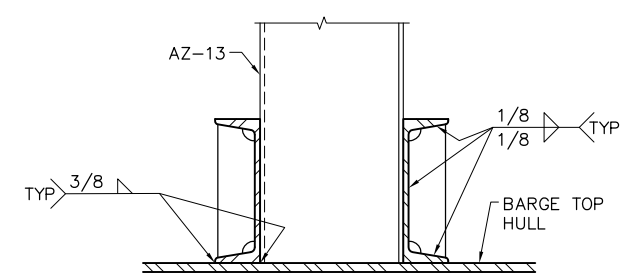


E SECTION
- SCALE: 3/4"=1'-0"

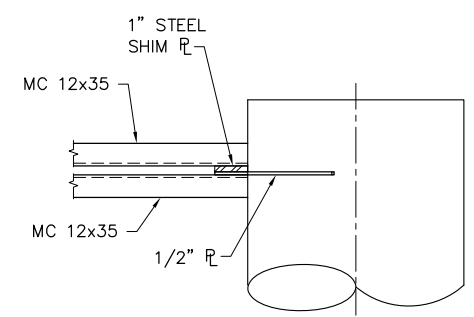


100% SUBMITTAL IF SHEET IS LESS THAN 22" x 34"
IT IS A REDUCED PRINT –
SCALE REDUCED ACCORDINGLY.

TWO GATE FISH PROTECTION PLAN	DATE 08/31/09
	SHEET 31 OF 78
OLD RIVER END WALL SCANTLINGS	C25

P:\6097-03 SWC GATE DESIGN\CADD\DWG\609703-C26.DWG 8/31/2009 9:52 AM

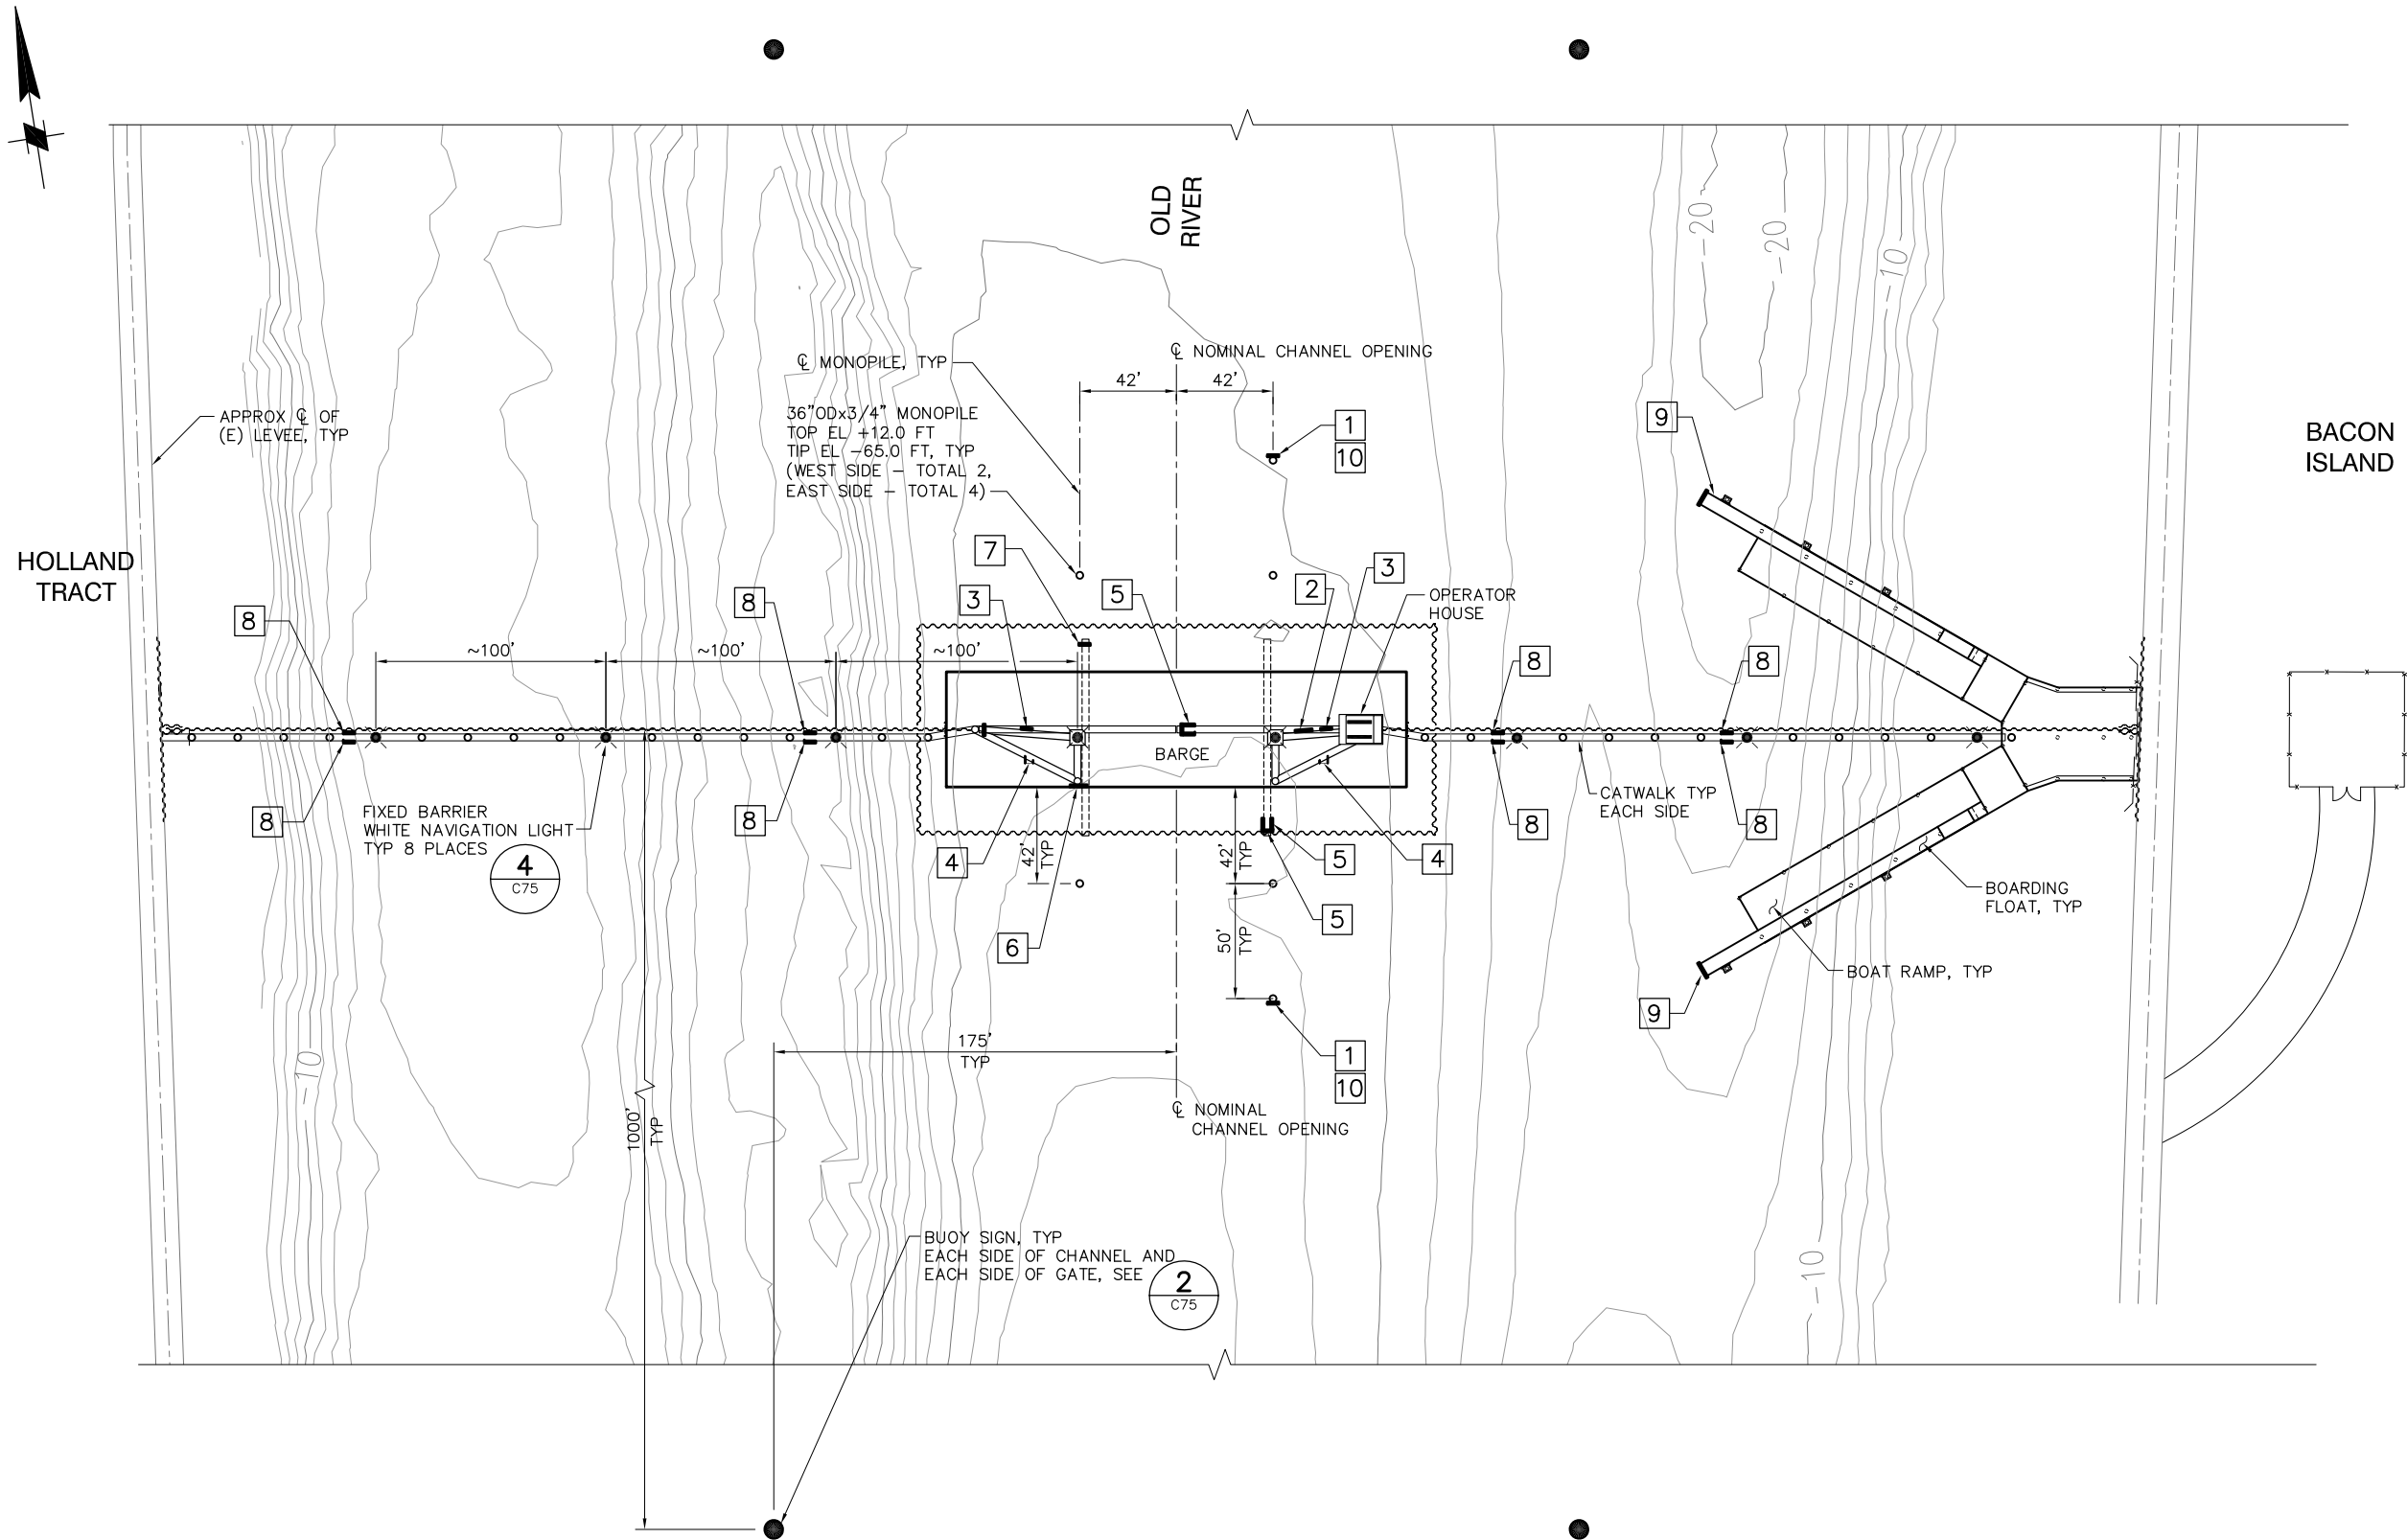

PLAN
SCALE: 1"= 40'

 

100% SUBMITTAL

IF SHEET IS LESS THAN 22" x 34"
IT IS A REDUCED PRINT -
SCALE REDUCED ACCORDINGLY.

SIGN DATA

LOCATION	SIGN	SIGN DETAIL	SIGN MOUNTING DETAIL
1	GATE 5 MPH	1 C75	1 C76
2	GATE WARNING SIGN	5 C75	5 C76
3	DANGER SIGN	7 C75	5 C76
4	DANGER SIGN	7 C75	3 C76
5	GATE POSITION SIGNS "GATES OPEN" "GATES CLOSED"	6 C75	2 C74
6	GATE WARNING SIGN	5 C75	2 C76
7	GATE POSITION SIGN "GATES OPEN"	6 C75	4 C76
8	STAY BACK WARNING SIGN	9 C75	5 C76
9	BOAT RAMP DOCK SIGN	3 C75	6 C76
10	GATE OPENING SIGN	10 C75	1 C76

REVISION	DESCRIPTION	BY	DATE



San Luis & Delta-Mendota Water Authority
842 6th Street, Suite 7
PO Box 2157
Los Banos, California 93635

APPROVED _____
FRANCY C. MIZUNO, PE C35136
San Luis & Delta-Mendota Water Authority

APPROVED _____
DENNIS G. MAJORS PE C21297
Metropolitan Water District of Southern California




2001 N. Main Street, Suite 360
Walnut Creek, California 94596
(925) 944-5411

DSGN	RBD	DR	AB	CHK	TDB
JOB NO. 6097-03		SUBMITTED BY RMR			

TWO GATE FISH PROTECTION PLAN		DATE 08/31/09
OLD RIVER AIDS TO NAVIGATION PLAN		SHEET 32 OF 78
		C26

P:\6097-03 SWC GATE DESIGN\CADD\DWG\609703-C31.DWG 8/28/2009 9:50 AM

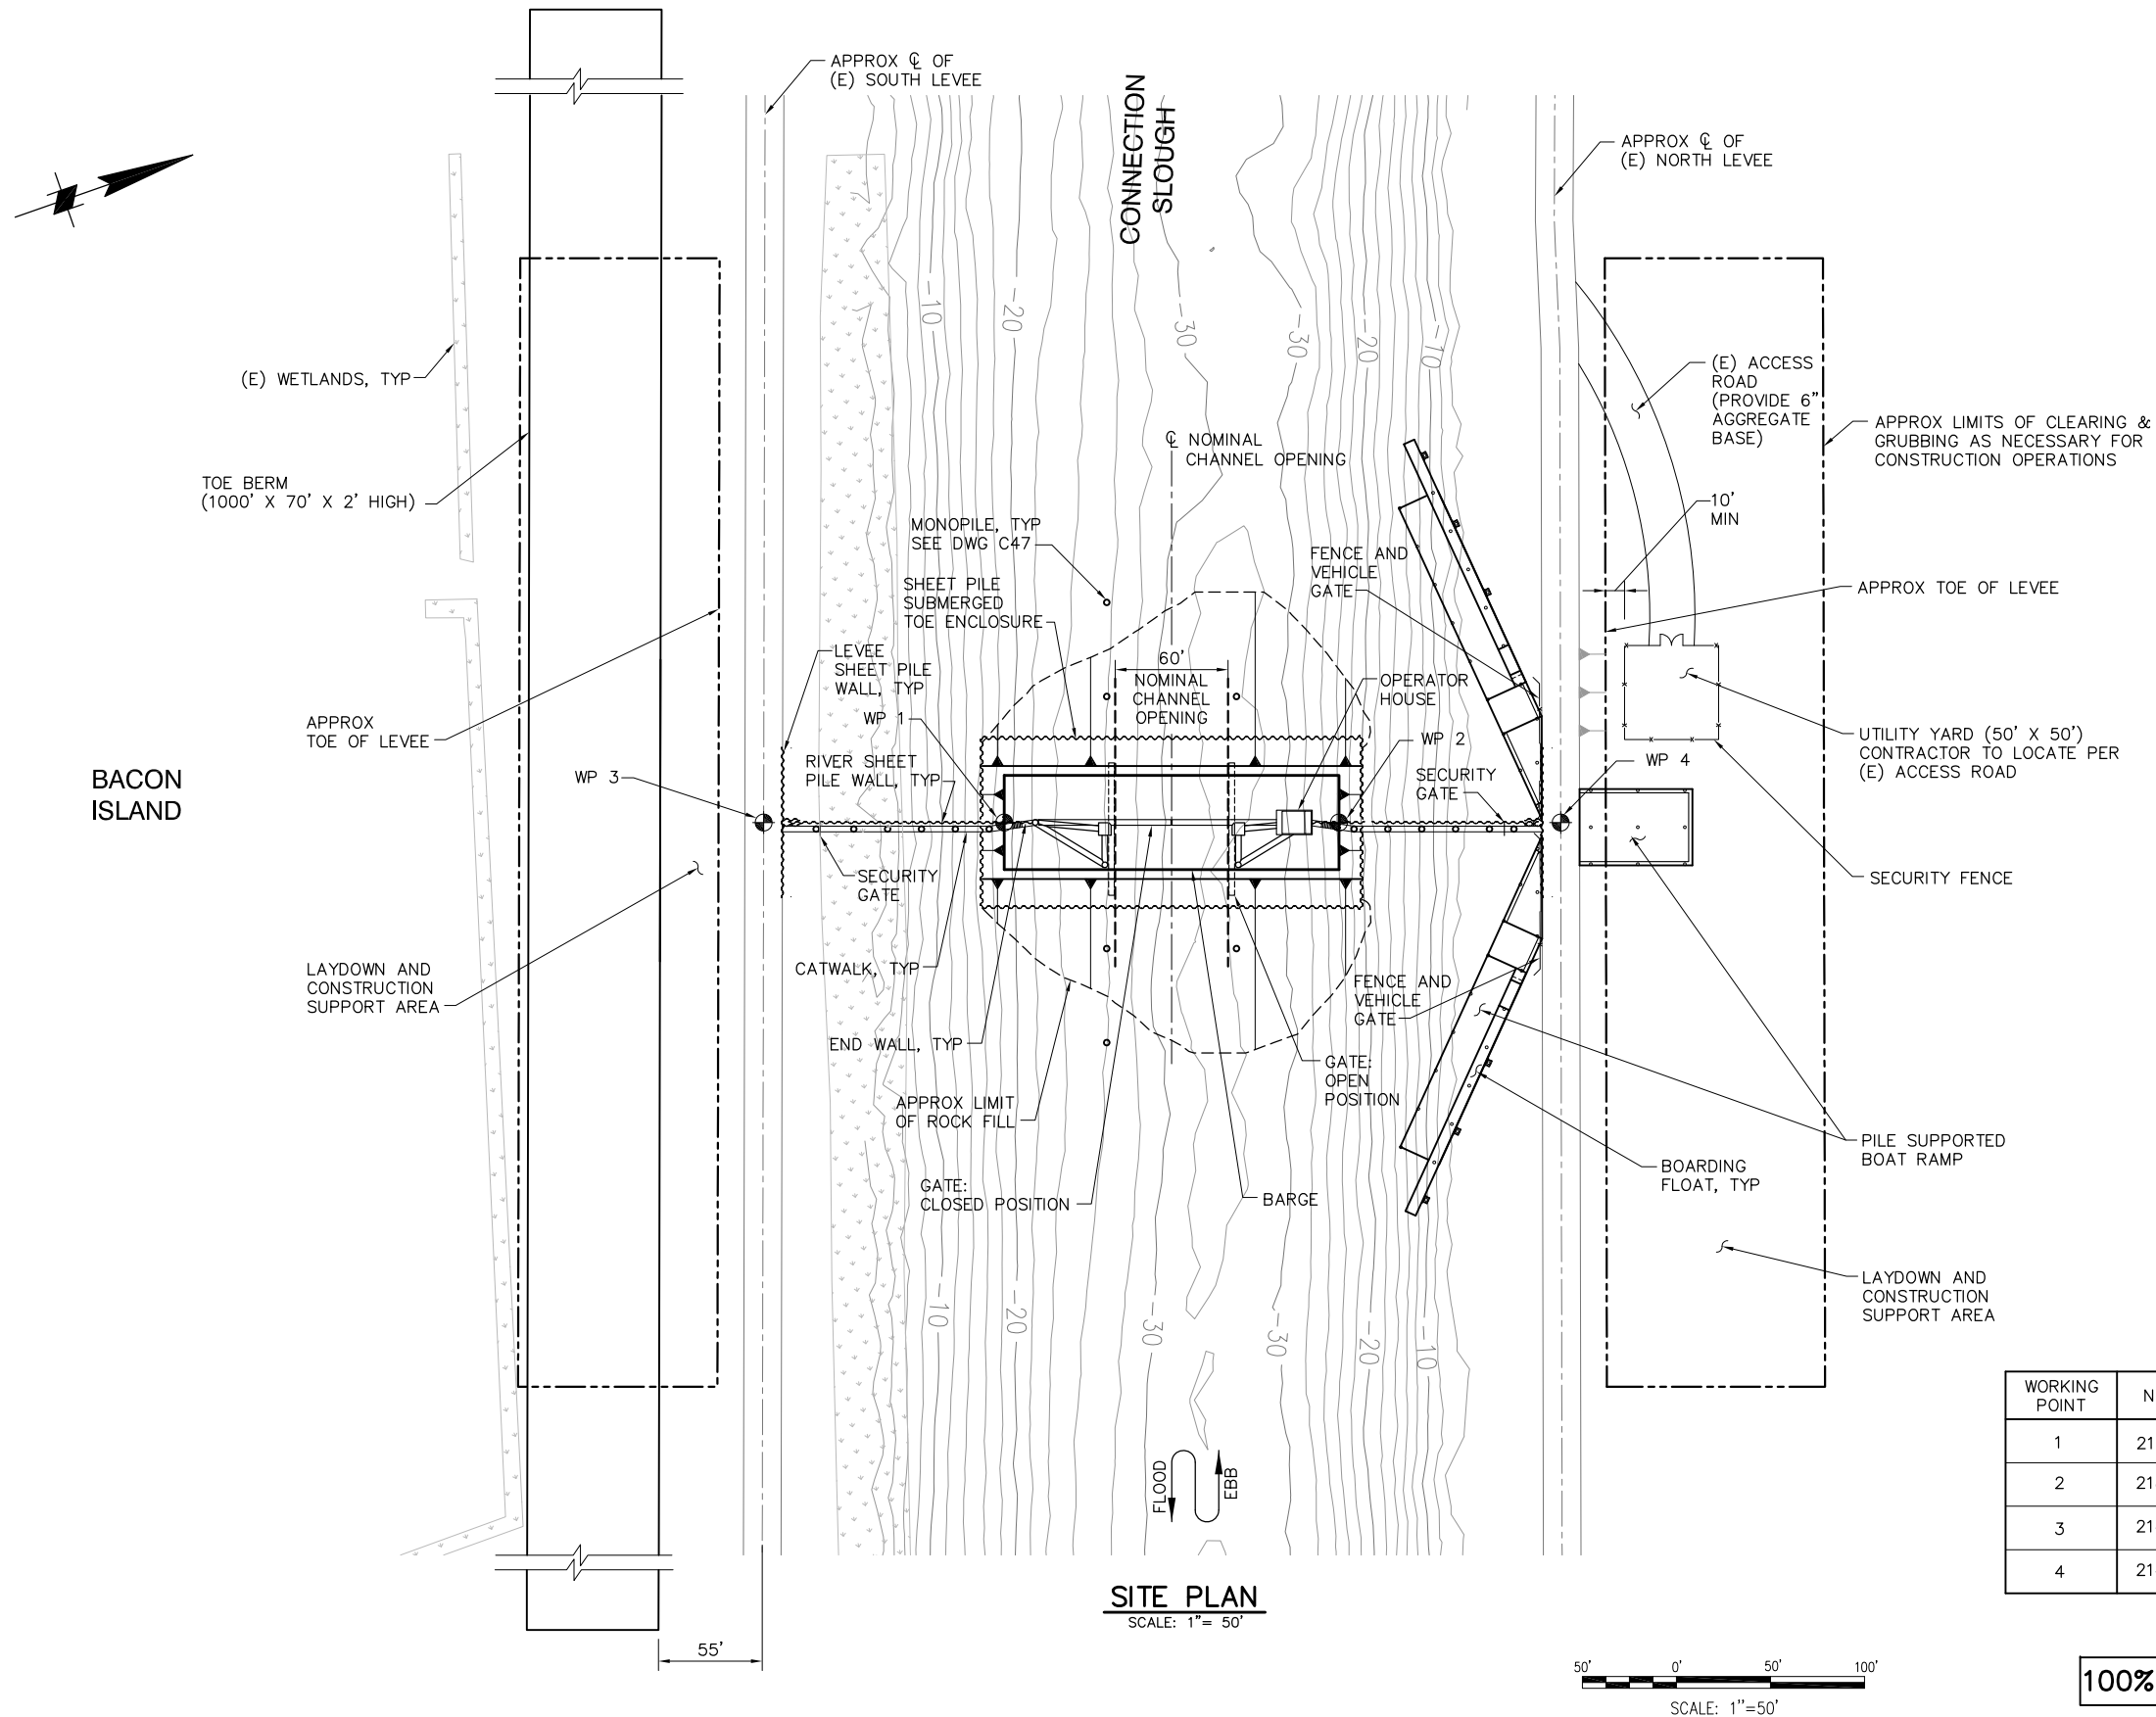

MANDEVILLE ISLAND

WORK POINT DATA

WORKING POINT	NORTHING	EASTING	FEATURE
1	2189371.89	6265762.17	CL OF SOUTH SIDE OF BARGE
2	2189539.90	6265820.98	CL OF NORTH SIDE OF BARGE
3	2189251.19	6265719.91	CL OF SOUTH LEVEE AND GATE
4	2189651.16	6265859.94	CL OF NORTH LEVEE AND GATE

100% SUBMITTAL

IF SHEET IS LESS THAN 22" x 34"
IT IS A REDUCED PRINT -
SCALE REDUCED ACCORDINGLY.

REVISION	DESCRIPTION	BY	DATE



San Luis & Delta-Mendota Water Authority
842 6th Street, Suite 7
PO Box 2157
Los Banos, California 93635

APPROVED _____
FRANCY C. MIZUNO, PE C35136
San Luis & Delta-Mendota Water Authority

APPROVED _____
DENNIS G. MAJORS PE C21297
Metropolitan Water District of Southern California





2001 N. Main Street, Suite 360
Walnut Creek, California 94596
(925) 944-5411


DSGN	TDB	DR	EP/AB	CHK	GTH
JOB NO. 6097-03		SUBMITTED BY RMR			

TWO GATE FISH PROTECTION PLAN	DATE 08/31/09
	SHEET 33 OF 78
CONNECTION SLOUGH SITE PLAN	C31

P:\6097-03 SWC GATE DESIGN\CADD\DWG\609703-C32.DWG 8/28/2009 5:25 PM

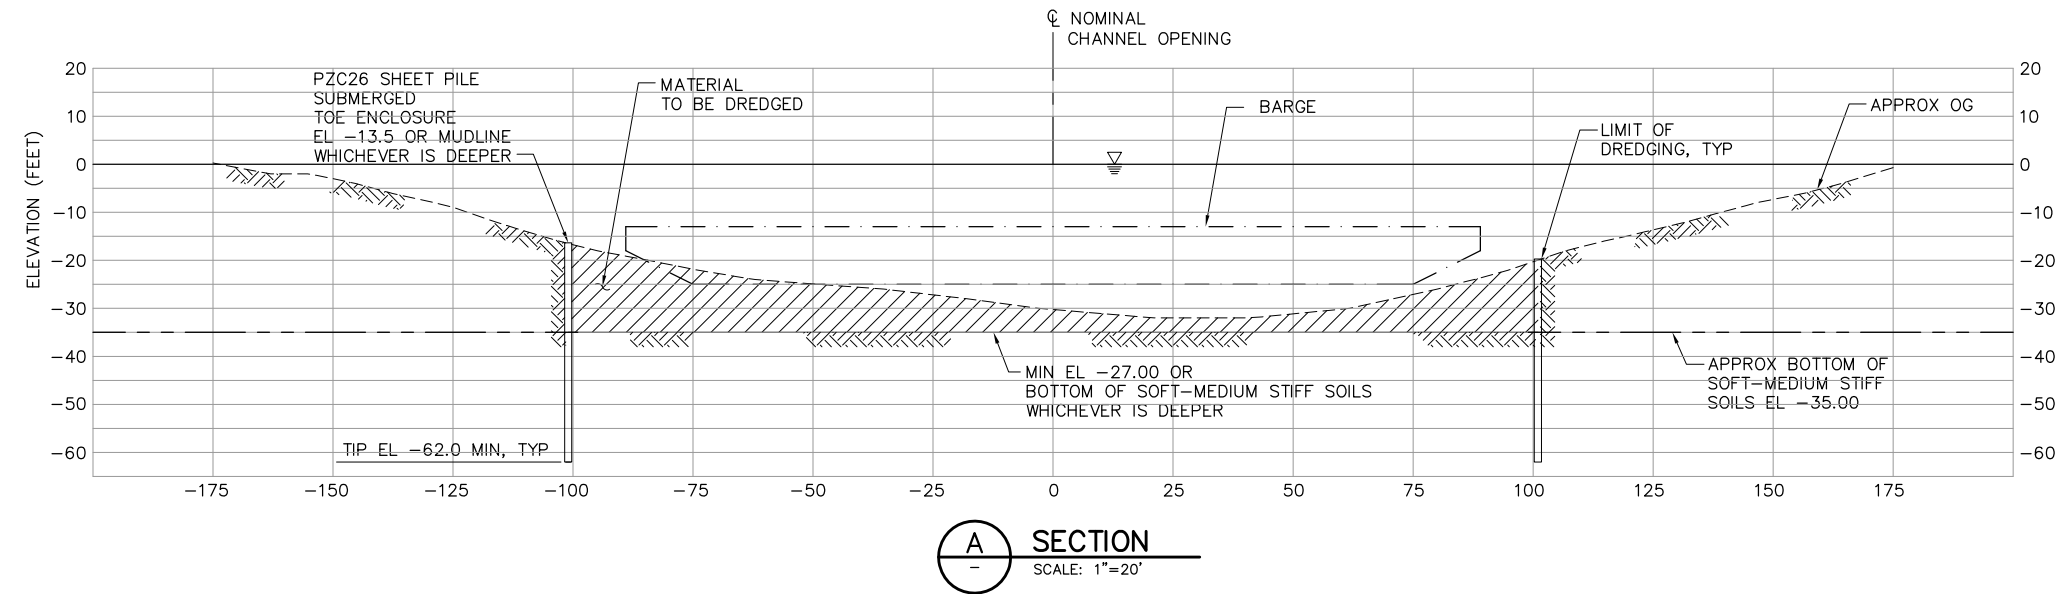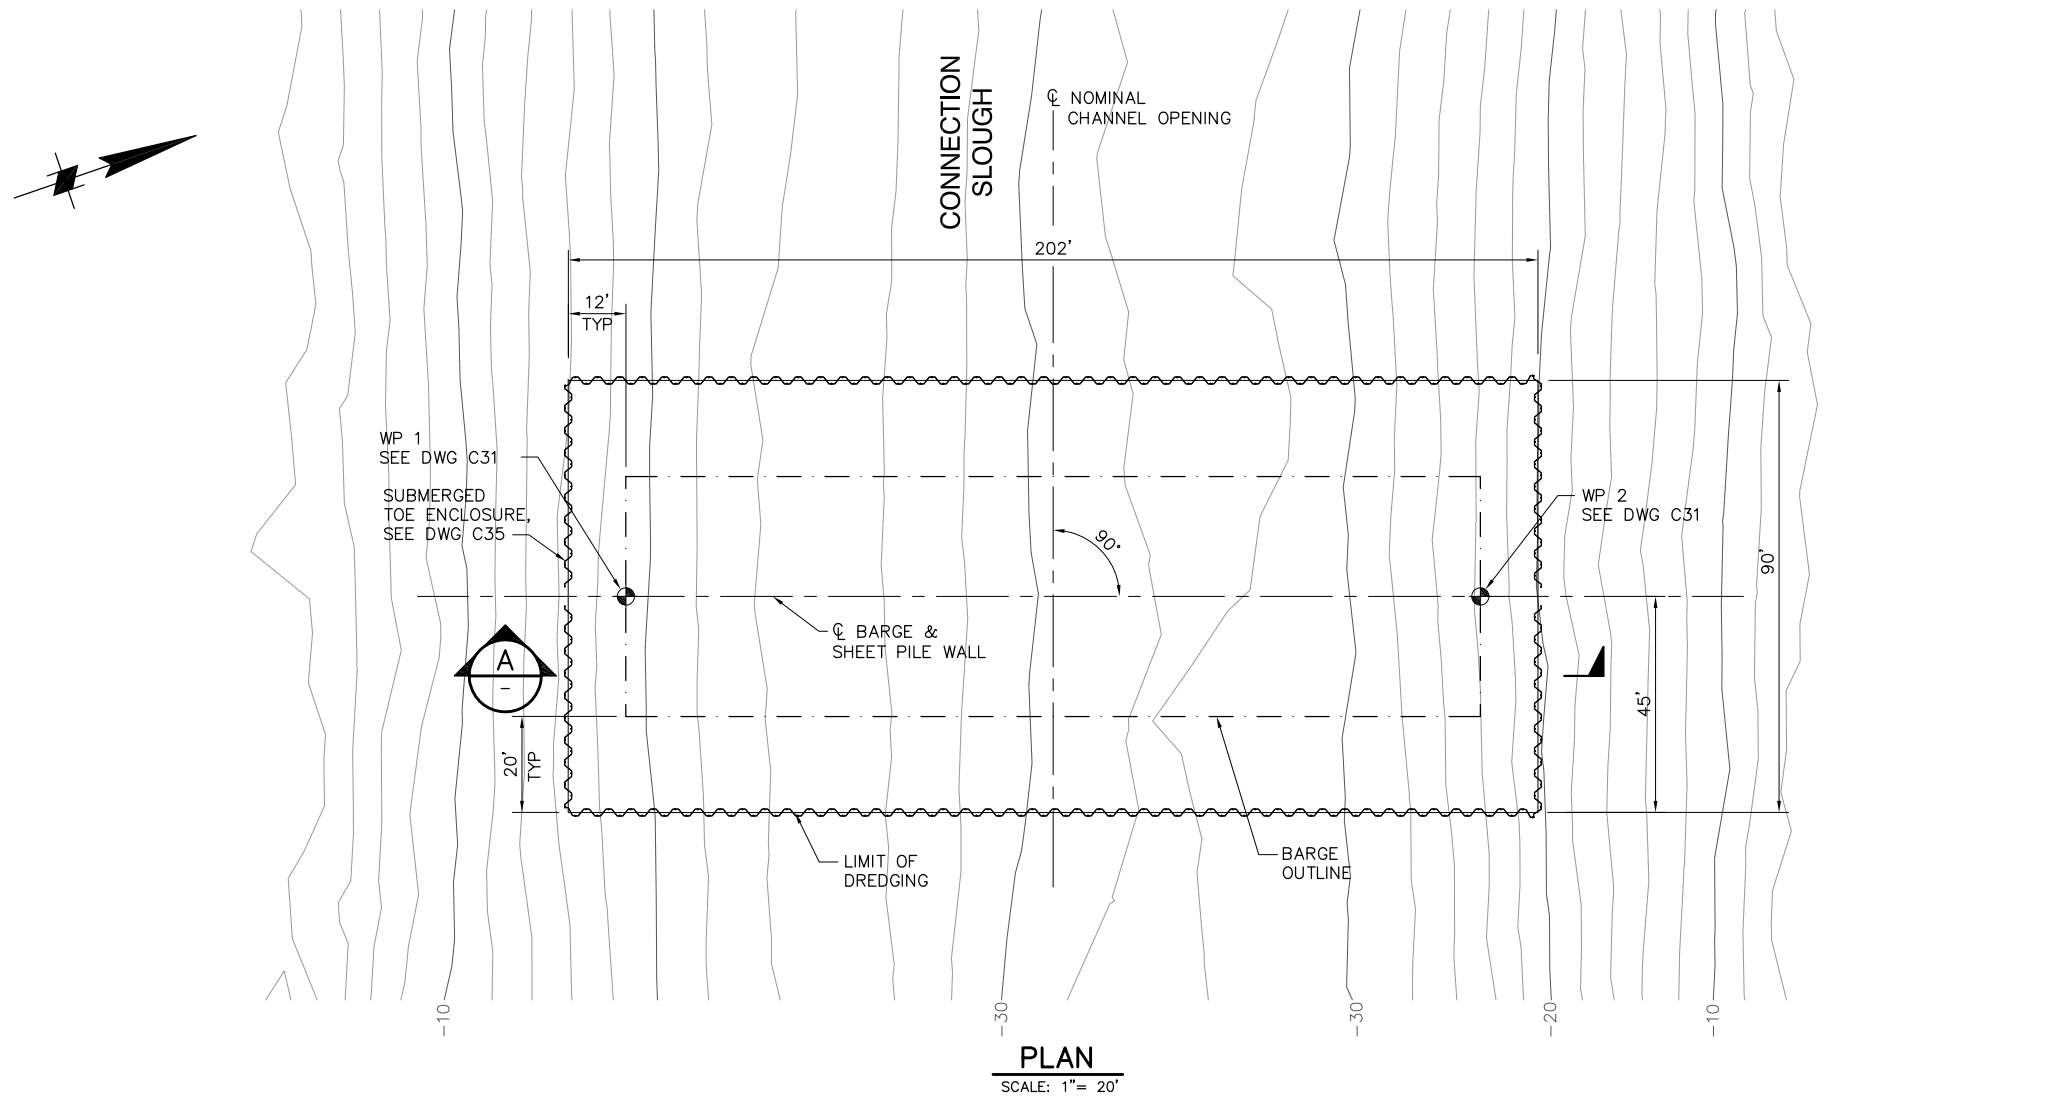

 NOTE:
GATE AND ALL OTHER FEATURES
NOT SHOWN FOR CLARITY.



100% SUBMITTAL IF SHEET IS LESS THAN 22" x 34"
IT IS A REDUCED PRINT -
SCALE REDUCED ACCORDINGLY.

REVISION	DESCRIPTION	BY	DATE



San Luis & Delta-Mendota Water Authority
842 6th Street, Suite 7
PO Box 2157
Los Banos, California 93635

APPROVED _____
FRANCY C. MIZUNO, PE C35136
San Luis & Delta-Mendota Water Authority

APPROVED _____
DENNIS G. MAJORS PE C21297
Metropolitan Water District of Southern California






2001 N. Main Street, Suite 360
Walnut Creek, California 94596
(925) 944-5411

DSGN	TDB	DR	EP/AB	CHK	GTH
JOB NO. 6097-03		SUBMITTED BY RMR			


TWO GATE FISH PROTECTION PLAN					
CONNECTION SLOUGH DREDGING PLAN AND SECTION					

DATE 08/31/09
SHEET 34 OF 78
C32

P:\6097-03 SWC GATE DESIGN\CADD\DWG\609703-C33.DWG 8/28/2009 6:36 PM

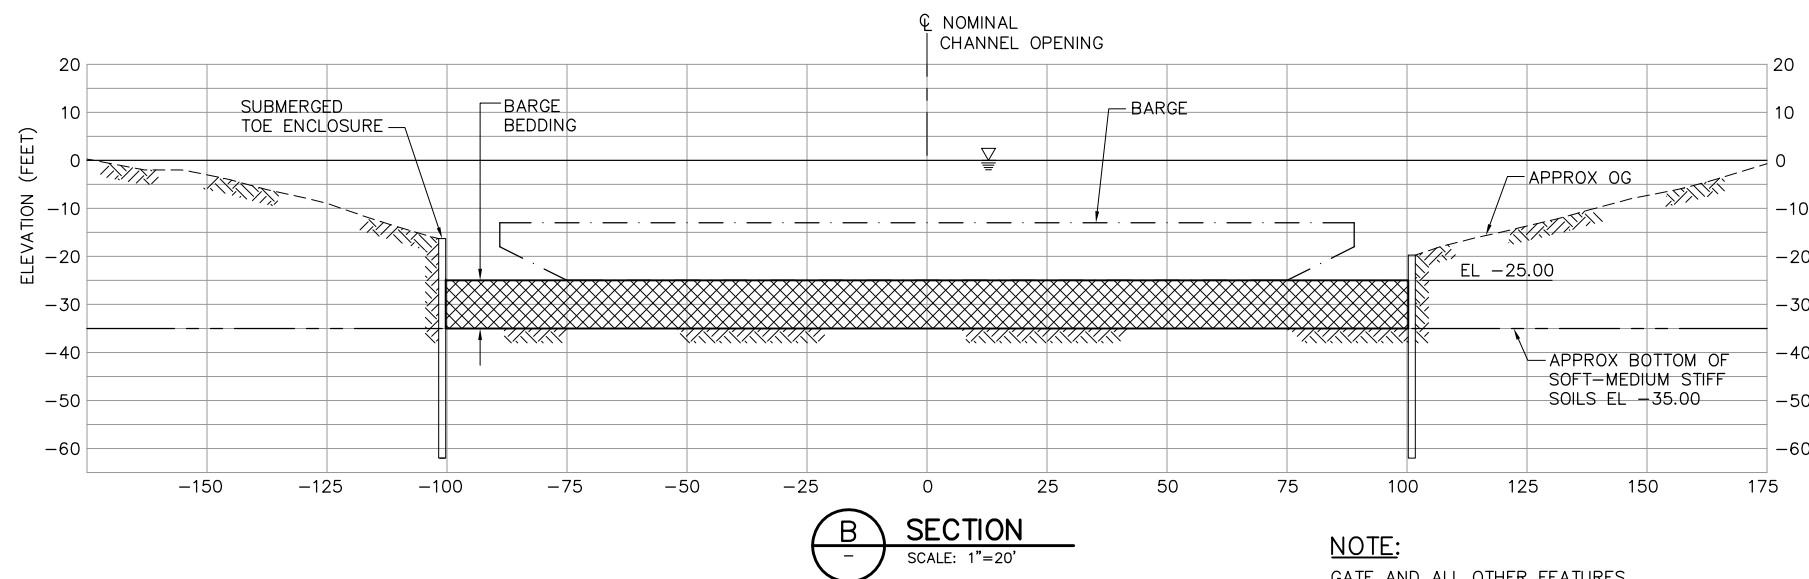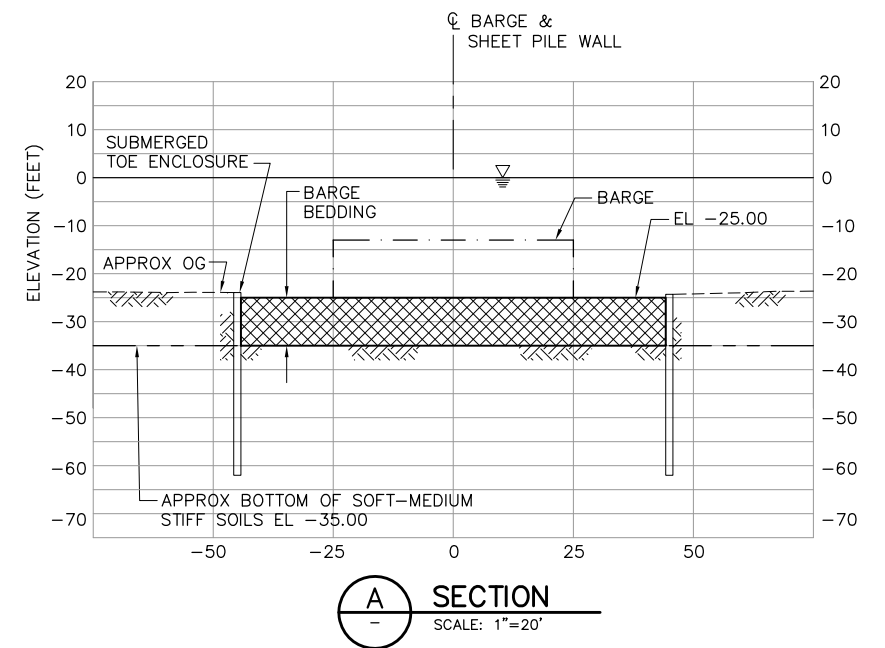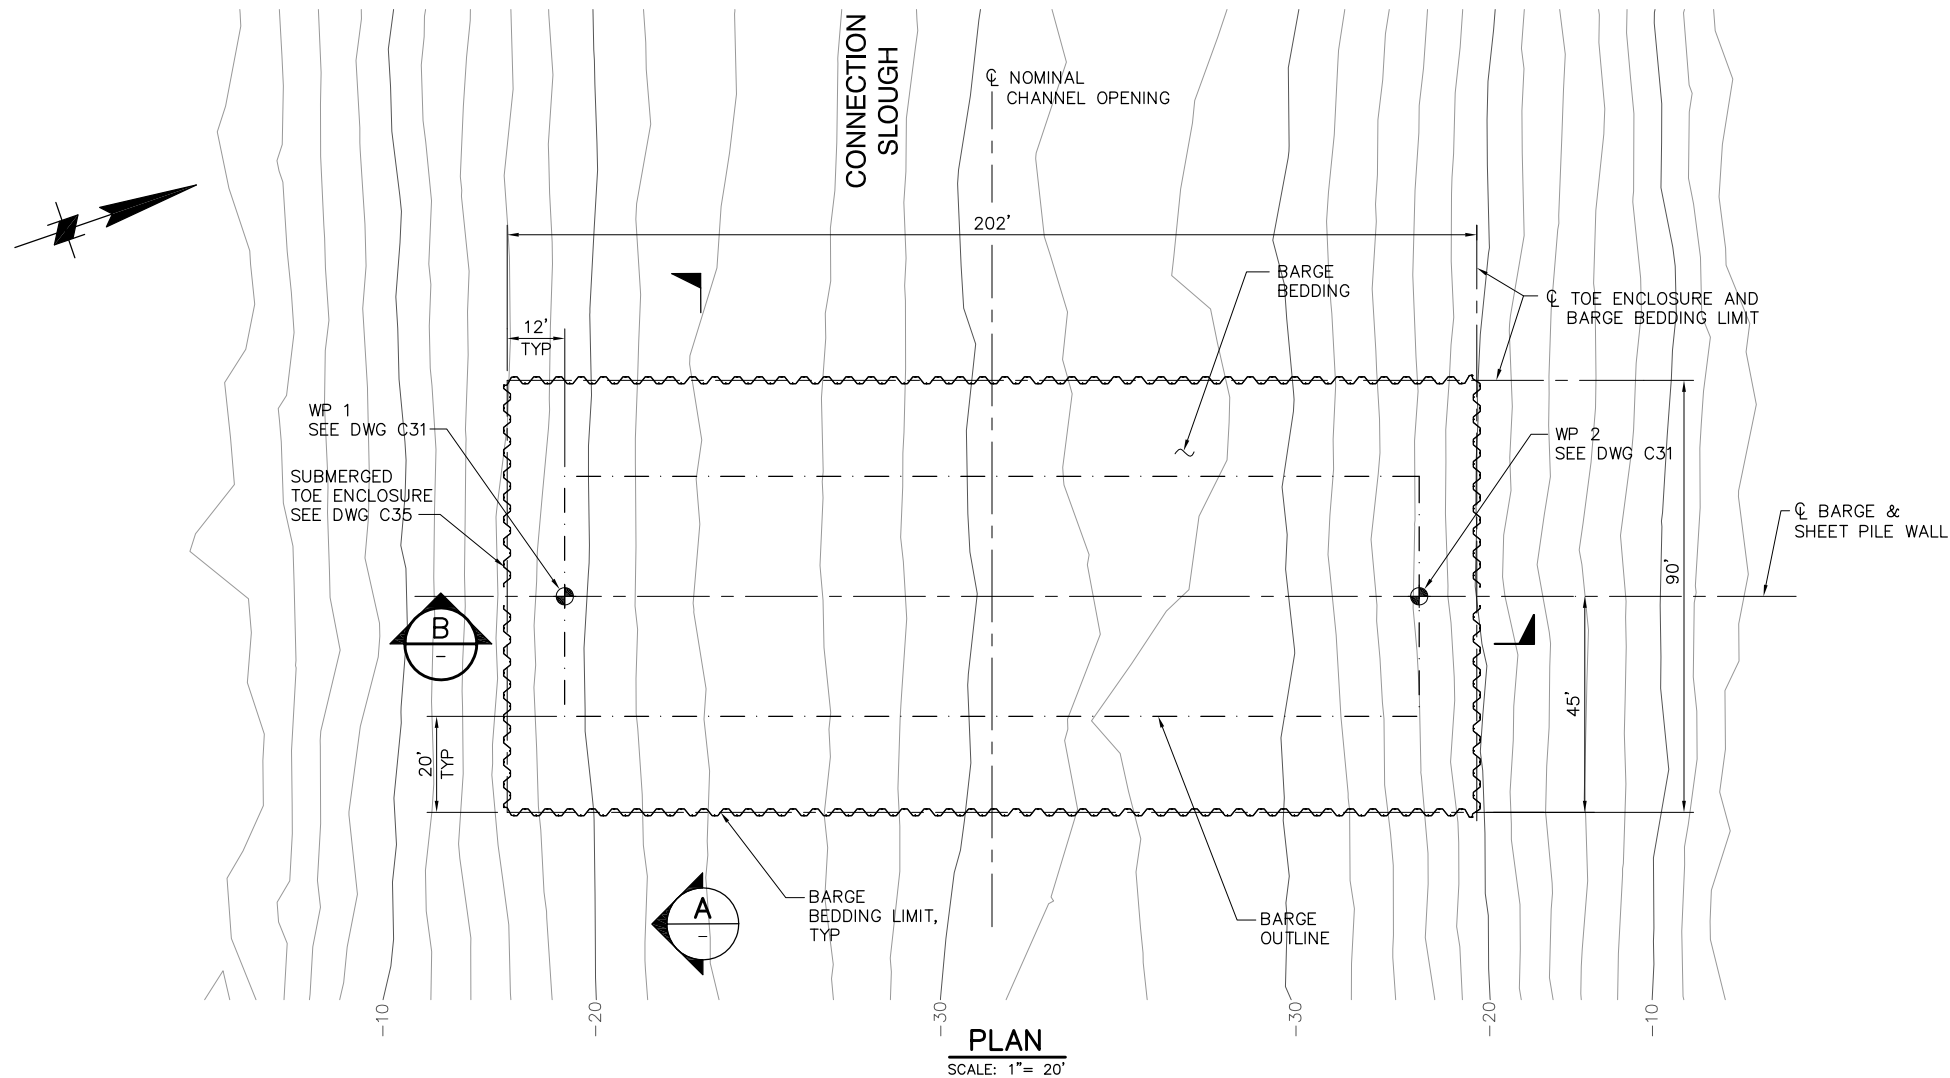

 NOTE:
GATE AND ALL OTHER FEATURES
NOT SHOWN FOR CLARITY.



100% SUBMITTAL

IF SHEET IS LESS THAN 22" x 34"
IT IS A REDUCED PRINT -
SCALE REDUCED ACCORDINGLY.

REVISION	DESCRIPTION	BY	DATE



San Luis & Delta-Mendota Water Authority
842 6th Street, Suite 7
PO Box 2157
Los Banos, California 93635

APPROVED _____
FRANCY C. MIZUNO, PE C35136
San Luis & Delta-Mendota Water Authority

APPROVED _____
DENNIS G. MAJORS PE C21297
Metropolitan Water District of Southern California




2001 N. Main Street, Suite 360
Walnut Creek, California 94596
(925) 944-5411

DSGN	TDB	DR	EP/AB	CHK	GTH
JOB NO.		SUBMITTED BY			
6097-03		RMR			

TWO GATE FISH PROTECTION PLAN		DATE 08/31/09
CONNECTION SLOUGH, BARGE BEDDING PLAN		SHEET 35 OF 78
C33		



P:\6097-03 SWC GATE DESIGN\CADD\DWG\609703-C34.DWG 8/28/2009 6:54 PM

BACON
ISLAND

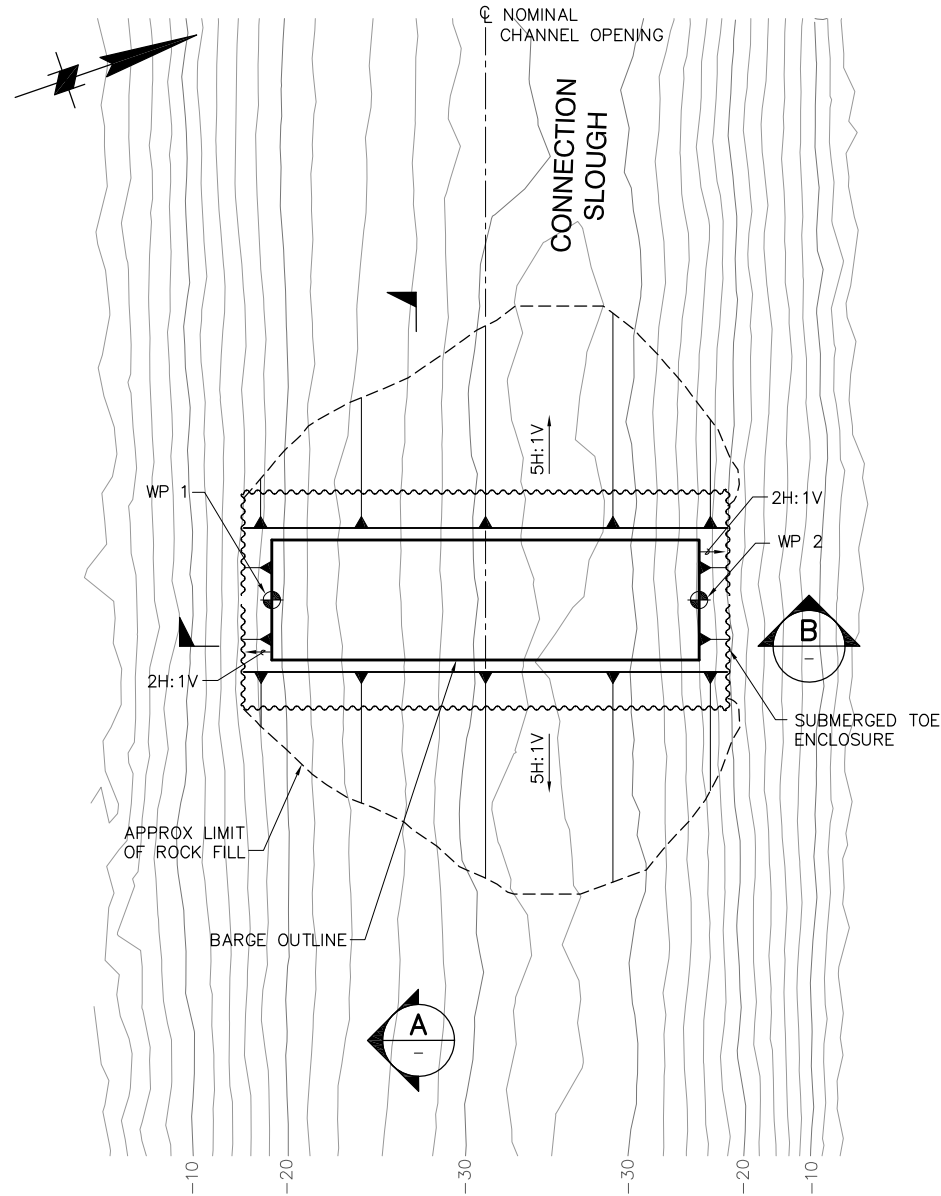


PLAN
SCALE: 1"= 40'

MANDEVILLE
ISLAND

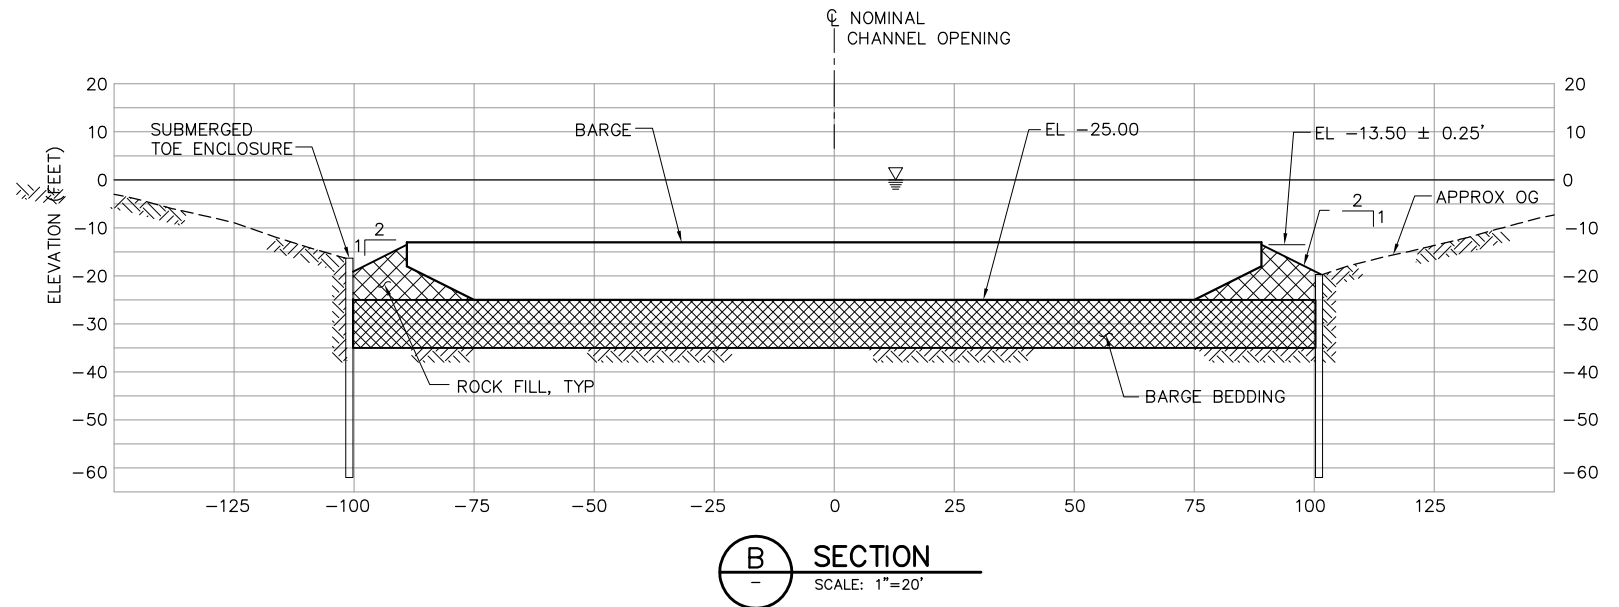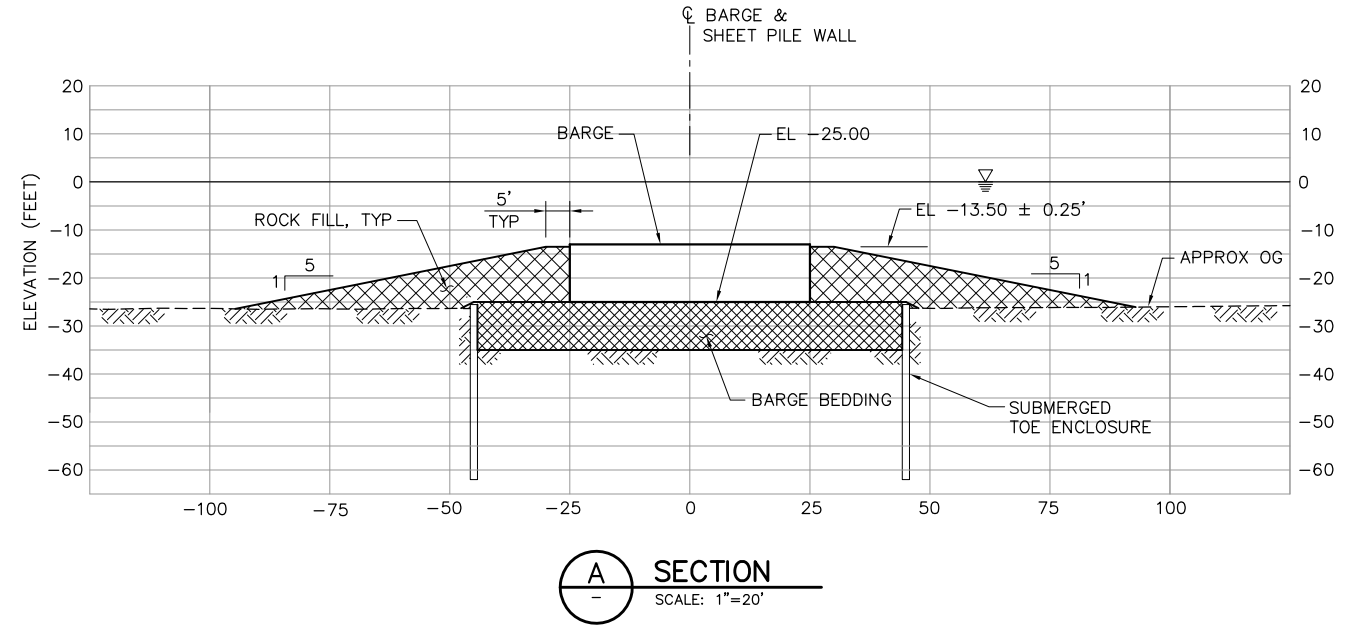

NOTES:

 1. KING PILES AND SHEET PILES NEAR BARGE SHALL BE PLACED BEFORE ROCK FILL.
2. GATE AND ALL OTHER FEATURES NOT SHOWN FOR CLARITY.



100% SUBMITTAL

IF SHEET IS LESS THAN 22" x 34"
IT IS A REDUCED PRINT -
SCALE REDUCED ACCORDINGLY.

REVISION	DESCRIPTION	BY	DATE



San Luis & Delta-Mendota Water Authority
842 6th Street, Suite 7
PO Box 2157
Los Banos, California 93635

APPROVED _____
FRANCY C. MIZUNO, PE C35136
San Luis & Delta-Mendota Water Authority

APPROVED _____
DENNIS G. MAJORS PE C21297
Metropolitan Water District of Southern California







2001 N. Main Street, Suite 360
Walnut Creek, California 94596
(925) 944-5411

DSGN	JMB	DR	EP/AB	CHK	TDB
JOB NO.	SUBMITTED BY				
6097-03	RMR				

TWO GATE FISH PROTECTION PLAN		DATE 08/31/09
CONNECTION SLOUGH BARGE - ROCK FILL PLAN AND SECTIONS		SHEET 36 OF 78
		C34


P:\6097-03 SWC GATE DESIGN\CADD\DWG\609703-C35.DWG 8/28/2009 4:17 PM

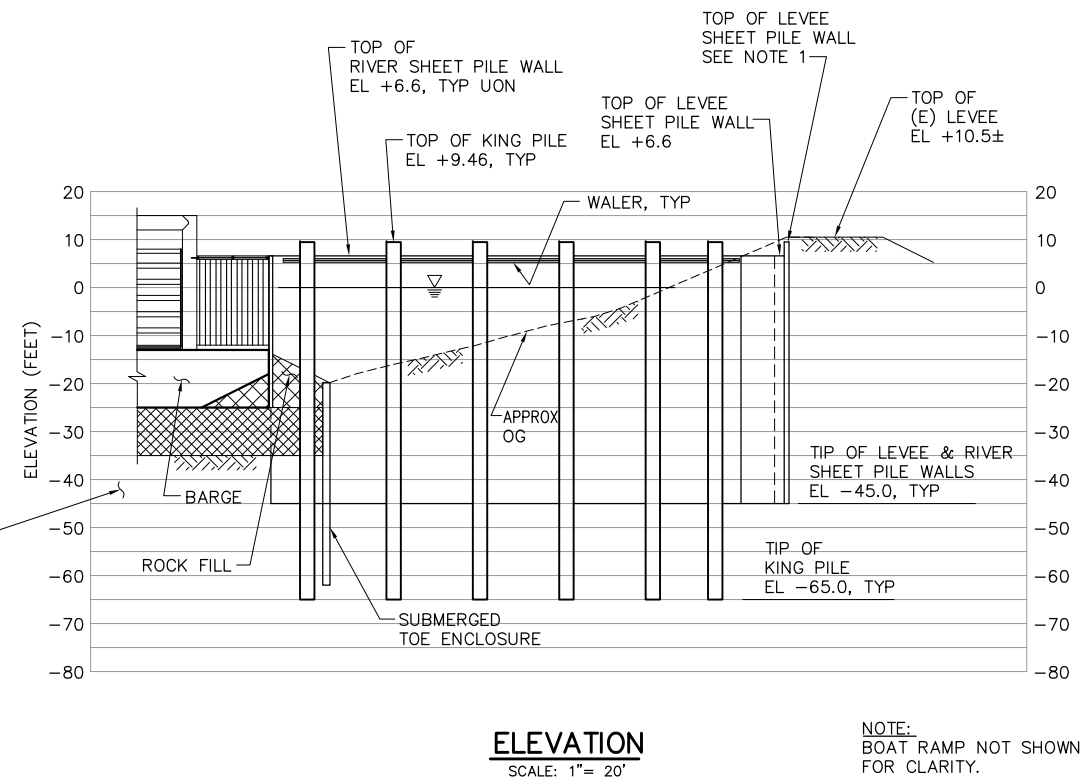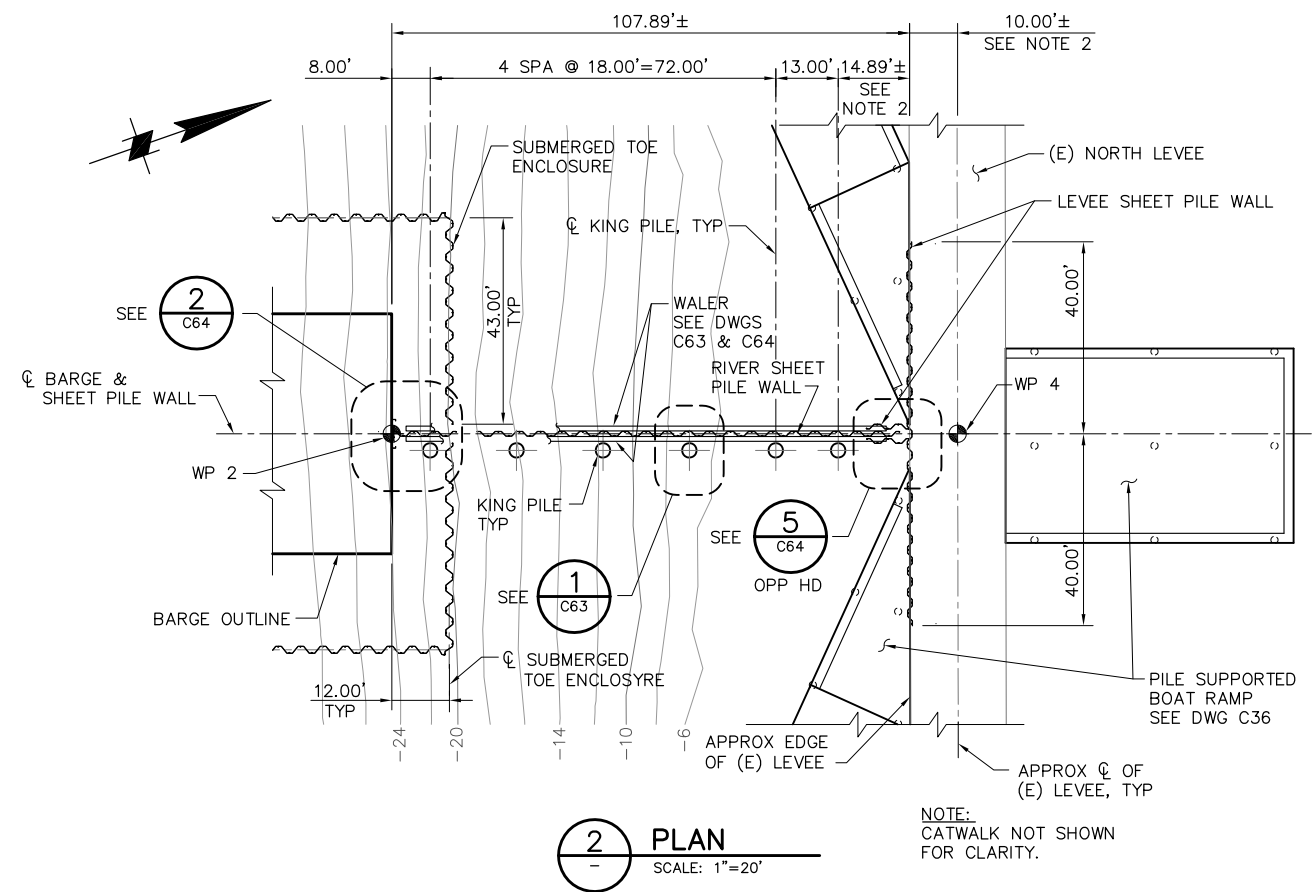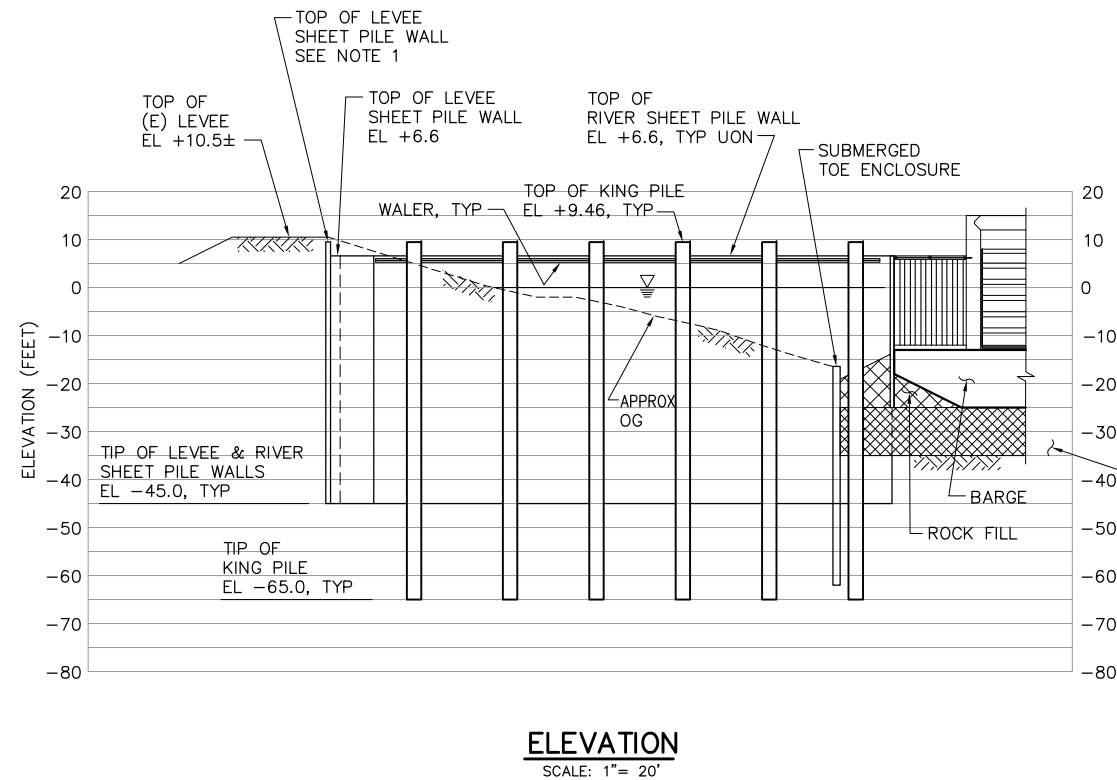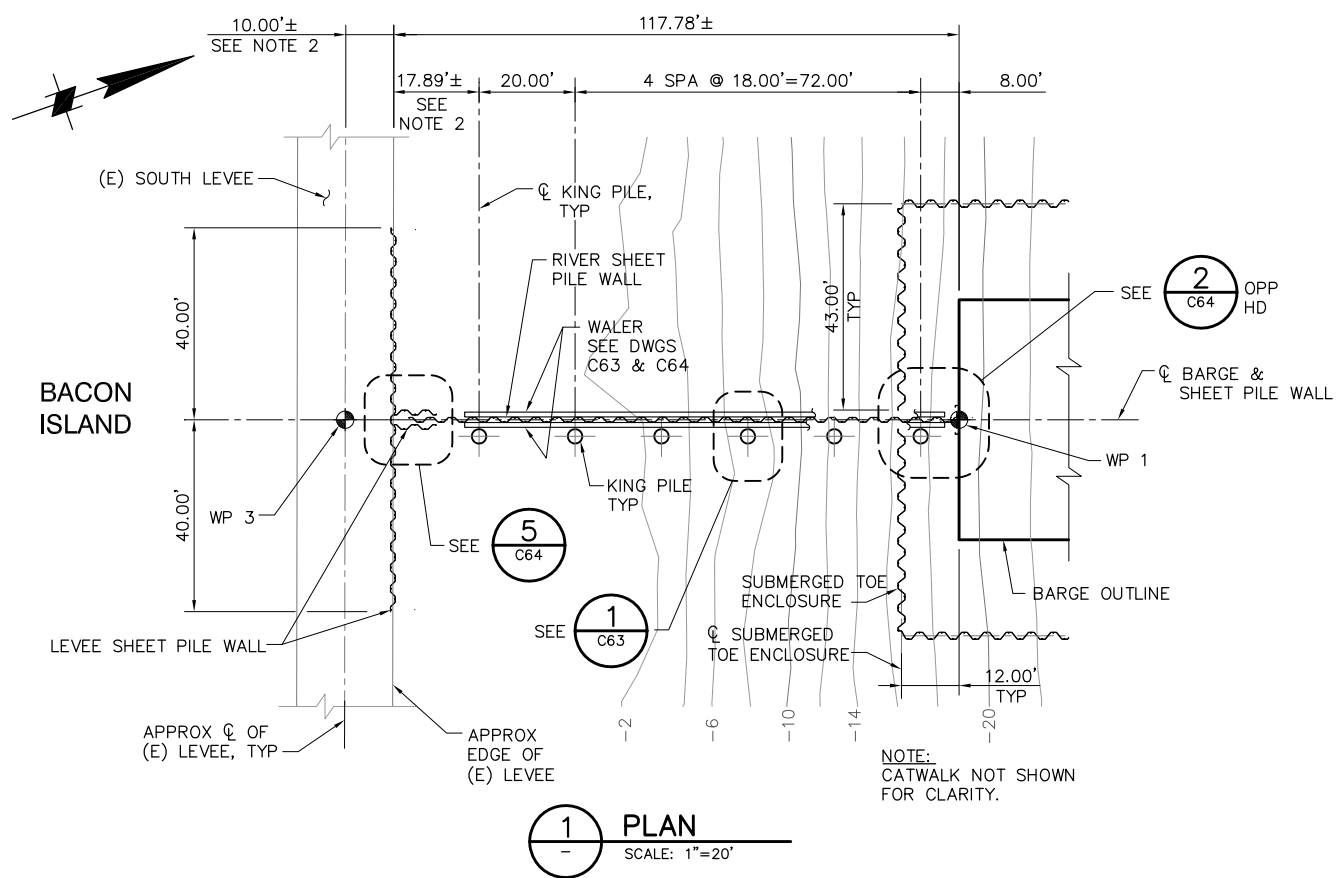

NOTES:

1. TOP OF LEVEE SHEET PILE WALL SHALL BE 6" BELOW TOP OF (E) LEVEE UON.
2. LEVEE SHEET PILE WALL TO BE LOCATED 1 FT MIN OFF THE EDGE OF (E) ROAD SURFACE.

 
NOTE:
BOAT RAMP NOT SHOWN
FOR CLARITY.



100% SUBMITTAL

IF SHEET IS LESS THAN 22" x 34"
IT IS A REDUCED PRINT -
SCALE REDUCED ACCORDINGLY.

REVISION	DESCRIPTION	BY	DATE

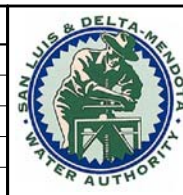

San Luis & Delta-Mendota Water Authority
842 6th Street, Suite 7
PO Box 2157
Los Banos, California 93635

APPROVED _____
FRANCY C. MIZUNO, PE C35136
San Luis & Delta-Mendota Water Authority

APPROVED _____
DENNIS G. MAJORS PE C21297
Metropolitan Water District of Southern California

Moffatt & Nichol

2001 N. Main Street, Suite 360
Walnut Creek, California 94596
(925) 944-5411



DSGN JMB DR EP/AB CHK TDB
JOB NO. 6097-03 SUBMITTED BY RMR

TWO GATE FISH PROTECTION PLAN

CONNECTION SLOUGH
SHEET PILE WALL ARRANGEMENT
PLAN AND ELEVATION


DATE 08/31/09
SHEET 37 OF 78
C35

P:\6097-03 SWC GATE DESIGN\CADD\DWG\609703-C36.DWG 8/31/2009 9:27 AM

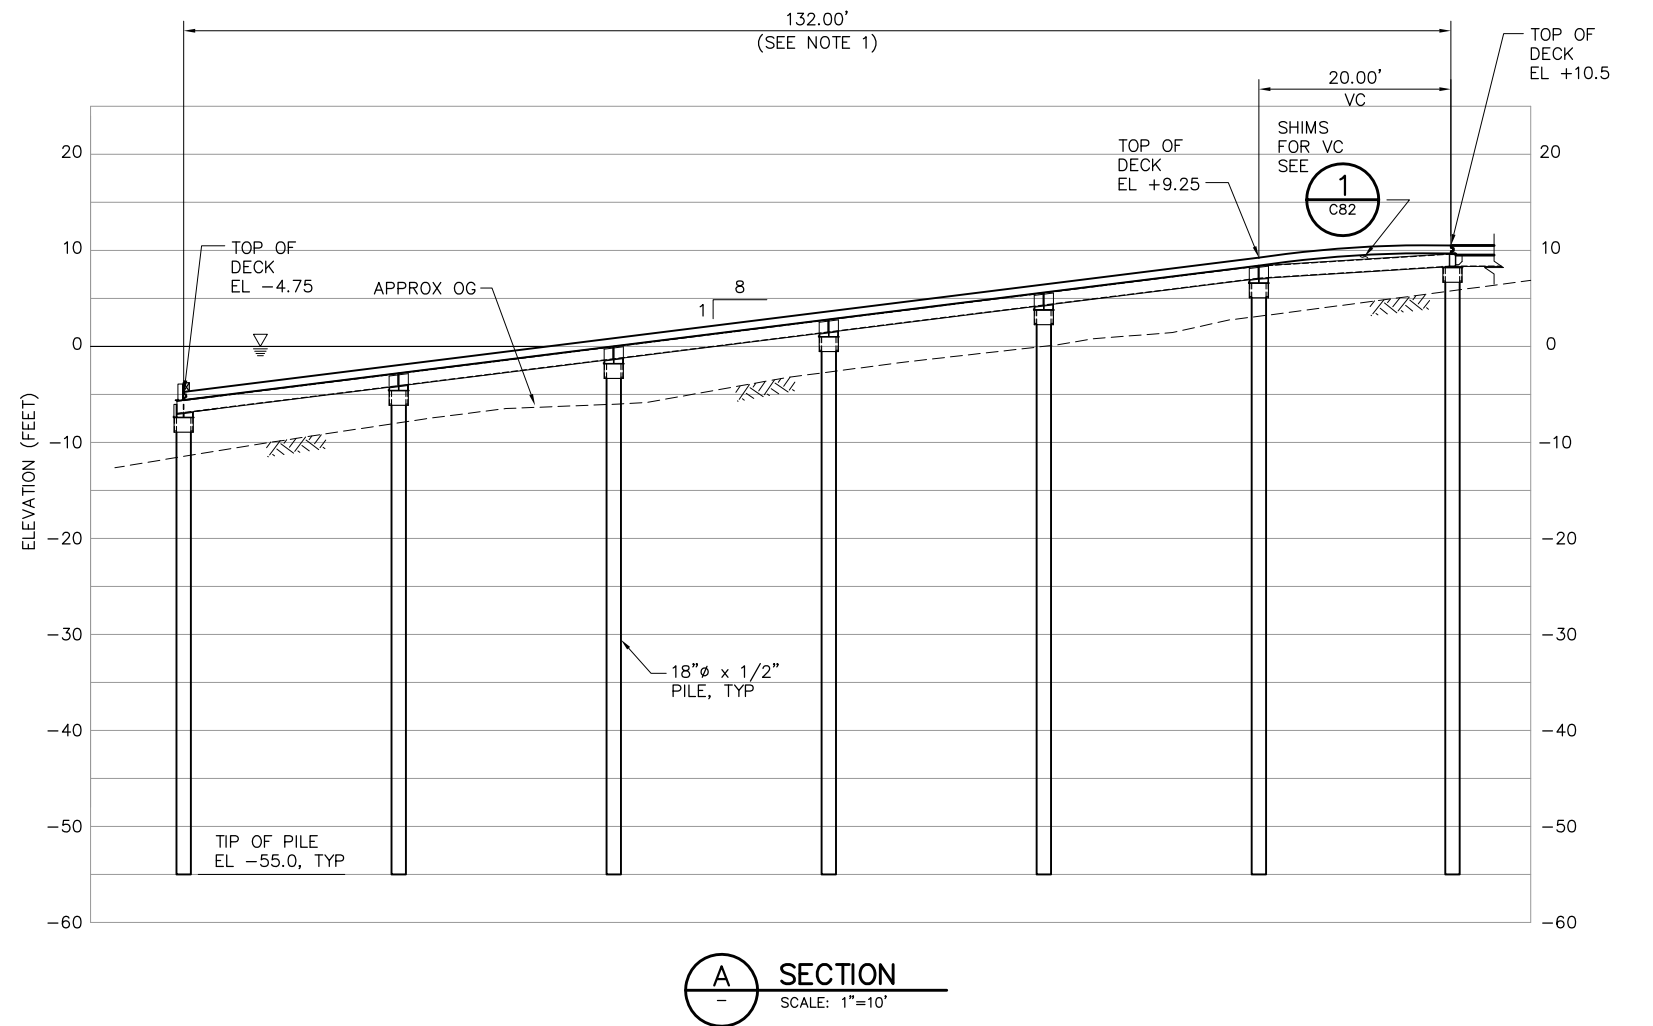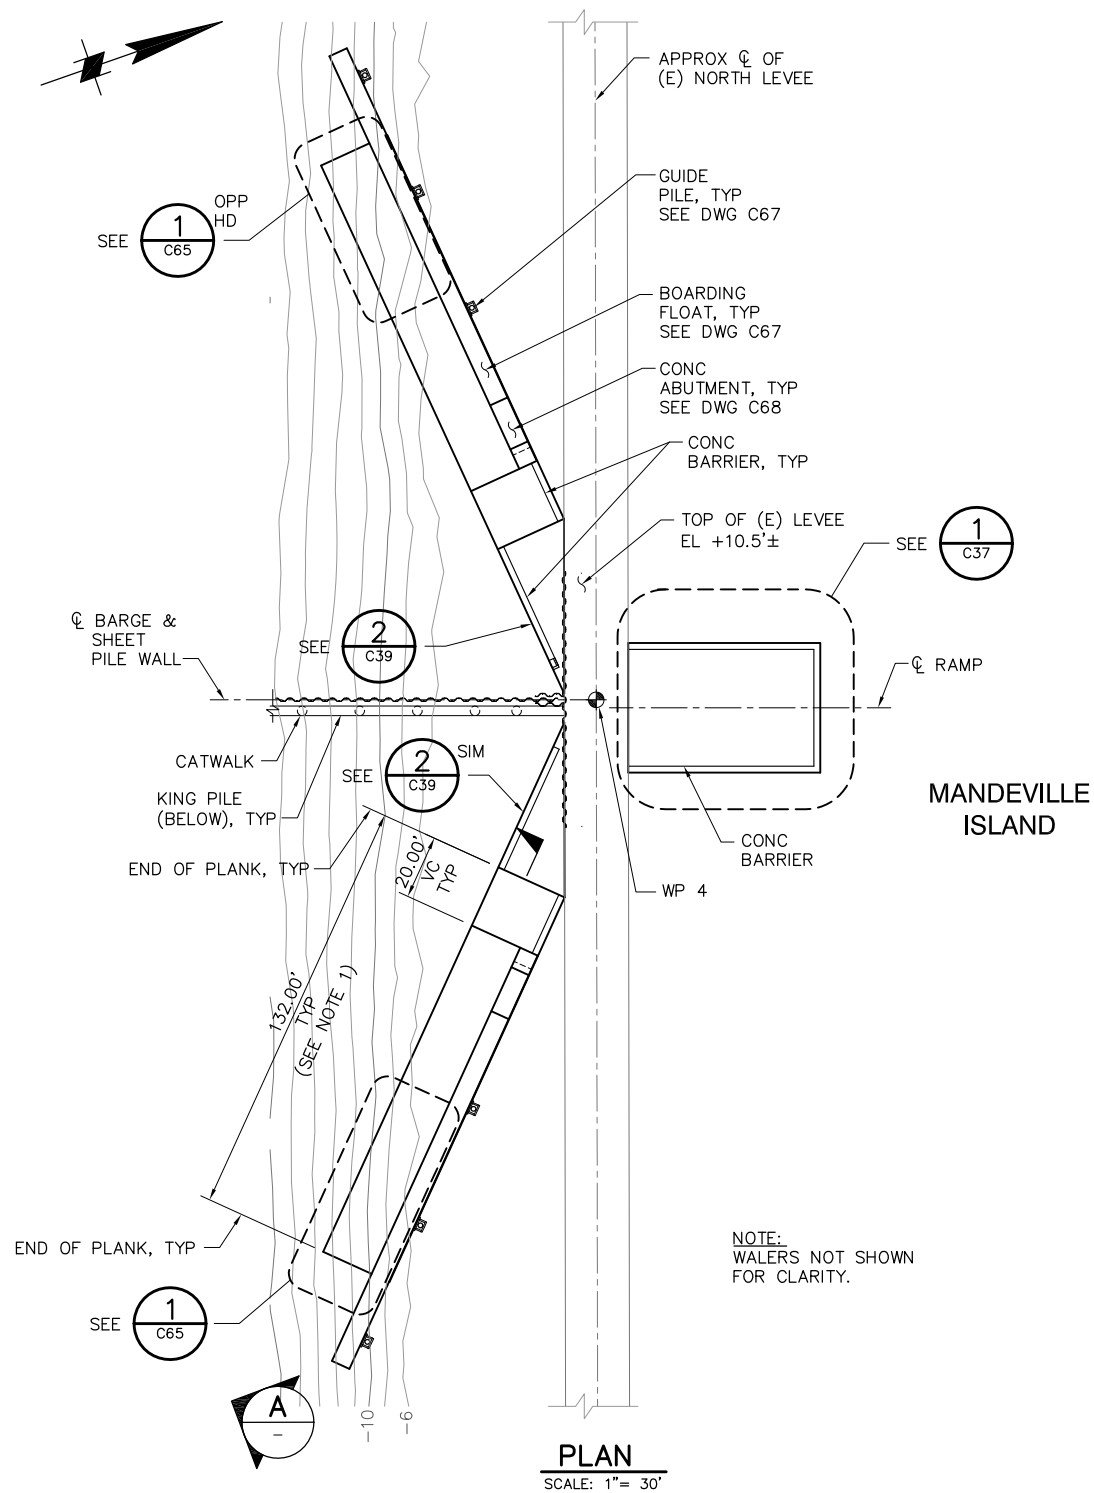

NOTES:


1. TRUE LENGTH OF RAMP ACCOUNTS FOR AN AVERAGE GAP OF 3/8" PER PLANK JOINT.

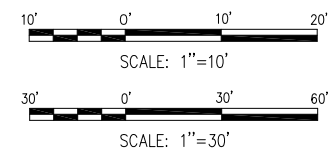

100% SUBMITTAL

IF SHEET IS LESS THAN 22" x 34"
IT IS A REDUCED PRINT -
SCALE REDUCED ACCORDINGLY.

REVISION	DESCRIPTION	BY	DATE

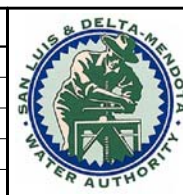

San Luis & Delta-Mendota Water Authority
842 6th Street, Suite 7
PO Box 2157
Los Banos, California 93635


APPROVED _____
FRANCY C. MIZUNO, PE C35136
San Luis & Delta-Mendota Water Authority

APPROVED _____
DENNIS G. MAJORS PE C21297
Metropolitan Water District of Southern California


		2001 N. Main Street, Suite 360 Walnut Creek, California 94596 (925) 944-5411	
DSGN	JMB	DR	EP/AB
JOB NO.	6097-03	SUBMITTED BY	RMR
CHK	TDB		

TWO GATE FISH PROTECTION PLAN		DATE 08/31/09
CONNECTION SLOUGH BOAT RAMP PLAN AND SECTION		SHEET 38 OF 78
		C36

P:\6097-03 SWC GATE DESIGN\CADD\DWG\609703-C36.1.DWG 8/27/2009 2:21 PM

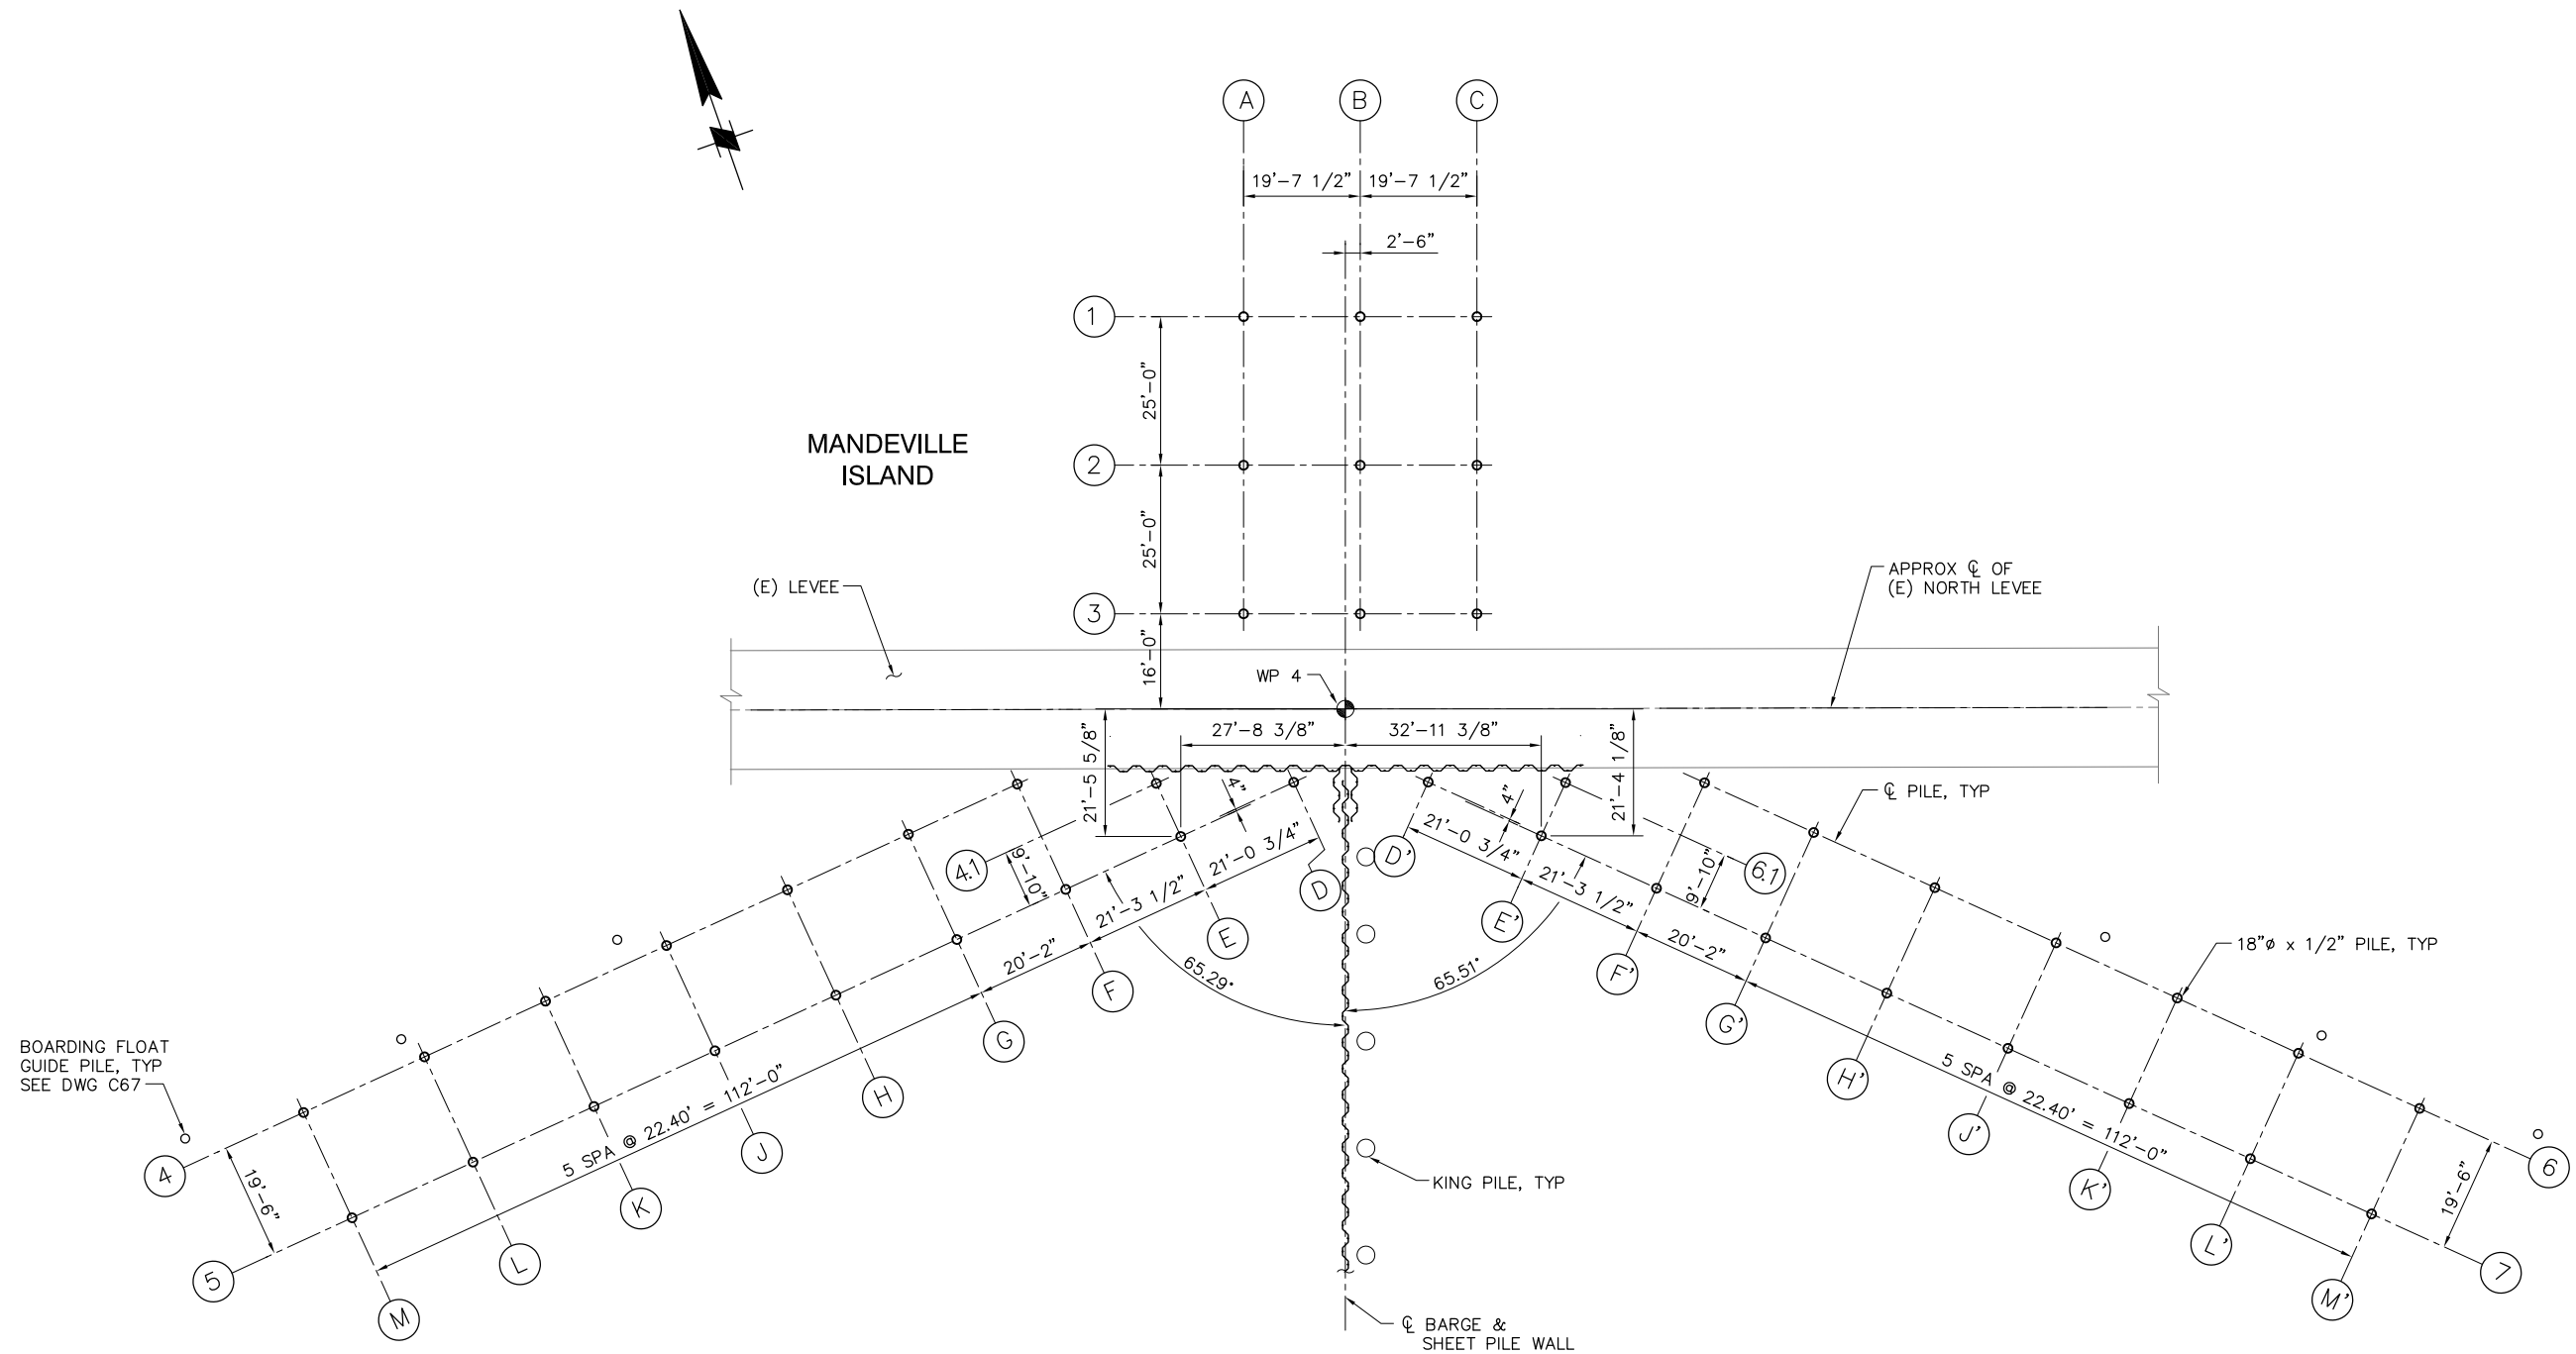

PILE PLAN
SCALE: 1/16" = 1'-0"

 

100% SUBMITTAL

IF SHEET IS LESS THAN 22" x 34"
IT IS A REDUCED PRINT -
SCALE REDUCED ACCORDINGLY.

REVISION	DESCRIPTION	BY	DATE



San Luis & Delta-Mendota Water Authority
842 6th Street, Suite 7
PO Box 2157
Los Banos, California 93635

APPROVED _____
FRANCY C. MIZUNO, PE C35136
San Luis & Delta-Mendota Water Authority

APPROVED _____
DENNIS G. MAJORS PE C21297
Metropolitan Water District of Southern California




2001 N. Main Street, Suite 360
Walnut Creek, California 94596
(925) 944-5411

DSGN	JMB	DR	EP/AB	CHK	TDB
JOB NO.	SUBMITTED BY				
6097-03	RMR				

TWO GATE FISH PROTECTION PLAN		DATE 08/31/09
CONNECTION SLOUGH BOAT RAMP PILE PLAN		SHEET 39 OF 78
		C36.1

P:\6097-03 SWC GATE DESIGN\CADD\DWG\609703-C36.2.DWG 8/27/2009 9:20 AM

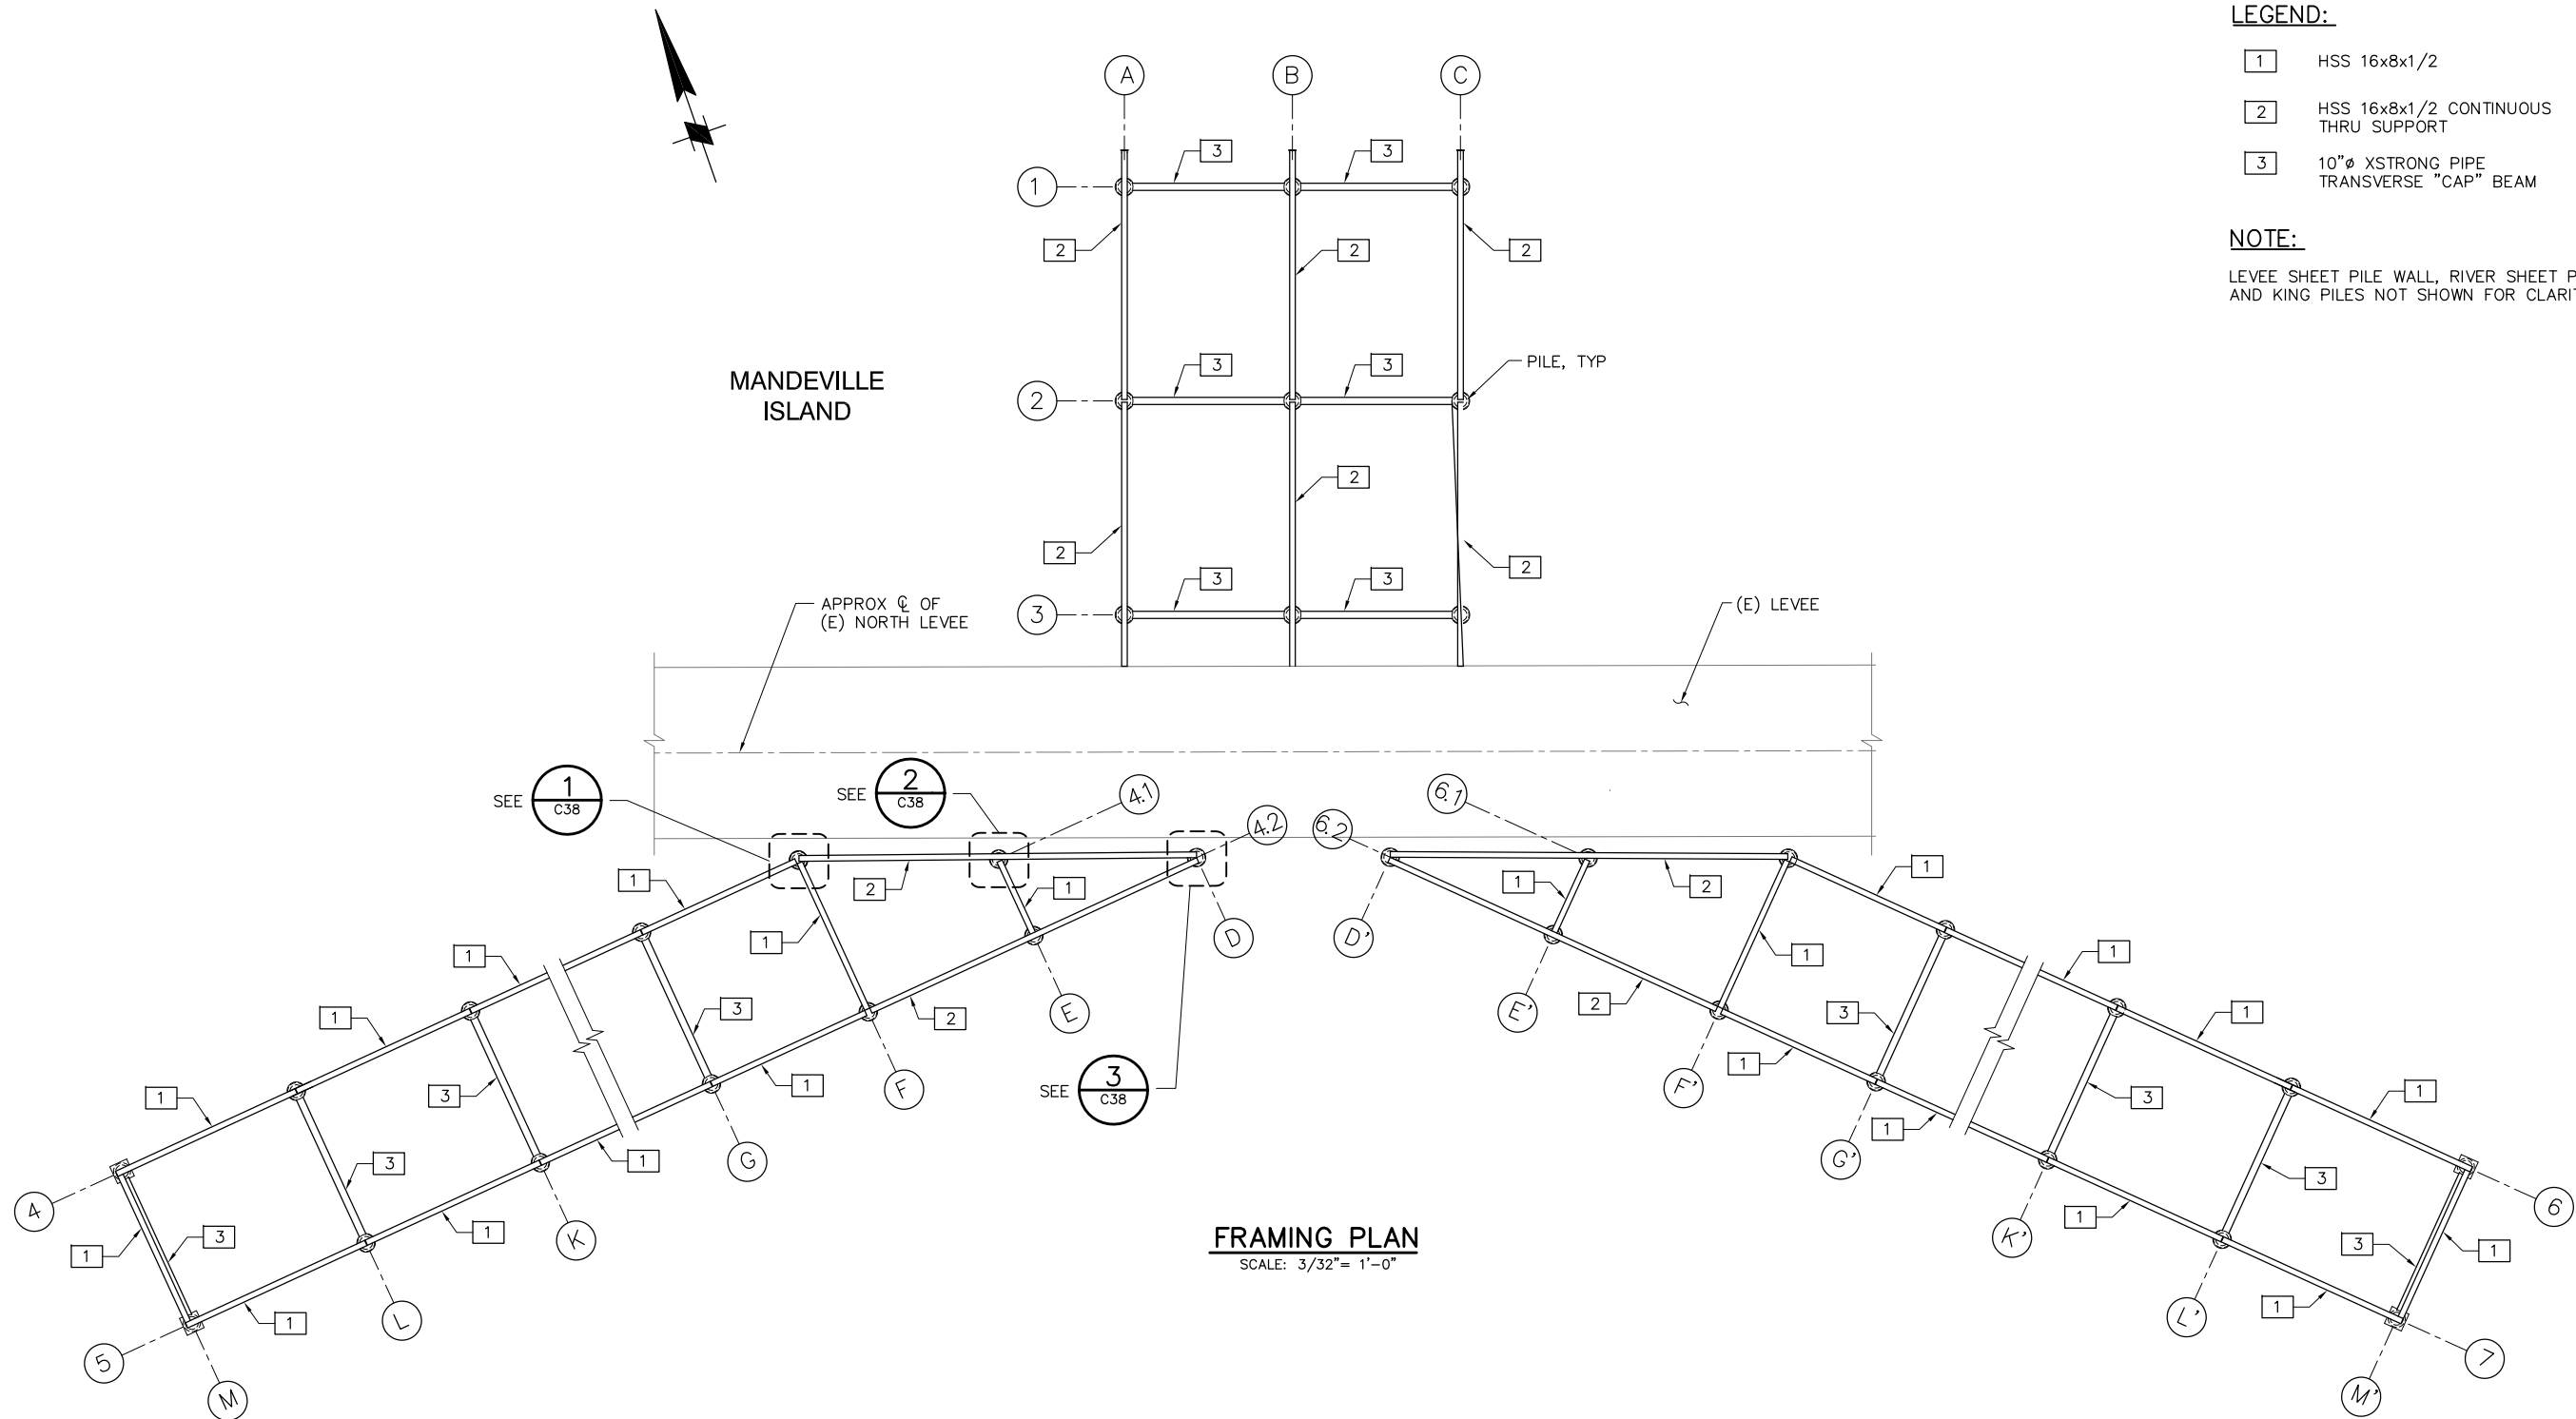


LEGEND:

- 1 HSS 16x8x1/2
- 2 HSS 16x8x1/2 CONTINUOUS THRU SUPPORT
- 3 10"Ø XSTRONG PIPE TRANSVERSE "CAP" BEAM

NOTE:

 
LEVEE SHEET PILE WALL, RIVER SHEET PILE WALL AND KING PILES NOT SHOWN FOR CLARITY.



100% SUBMITTAL

IF SHEET IS LESS THAN 22" x 34"
IT IS A REDUCED PRINT -
SCALE REDUCED ACCORDINGLY.


REVISION	DESCRIPTION	BY	DATE

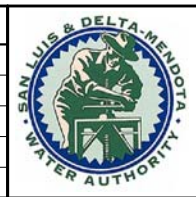

San Luis & Delta-Mendota Water Authority
842 6th Street, Suite 7
PO Box 2157
Los Banos, California 93635

APPROVED _____
FRANCY C. MIZUNO, PE C35136
San Luis & Delta-Mendota Water Authority

 APPROVED _____
DENNIS G. MAJORS PE C21297
Metropolitan Water District of Southern California



2001 N. Main Street, Suite 360
Walnut Creek, California 94596
(925) 944-5411

DSGN	JMB	DR	EP/AB	CHK	TDB
JOB NO.	SUBMITTED BY				
6097-03	RMR				

TWO GATE FISH PROTECTION PLAN


CONNECTION SLOUGH
BOAT RAMP FRAMING PLAN

DATE 08/31/09

SHEET 40 OF 78

C36.2

P:\6097-03 SWC GATE DESIGN\CADD\DWG\609703-C37.DWG 8/27/2009 9:24 AM

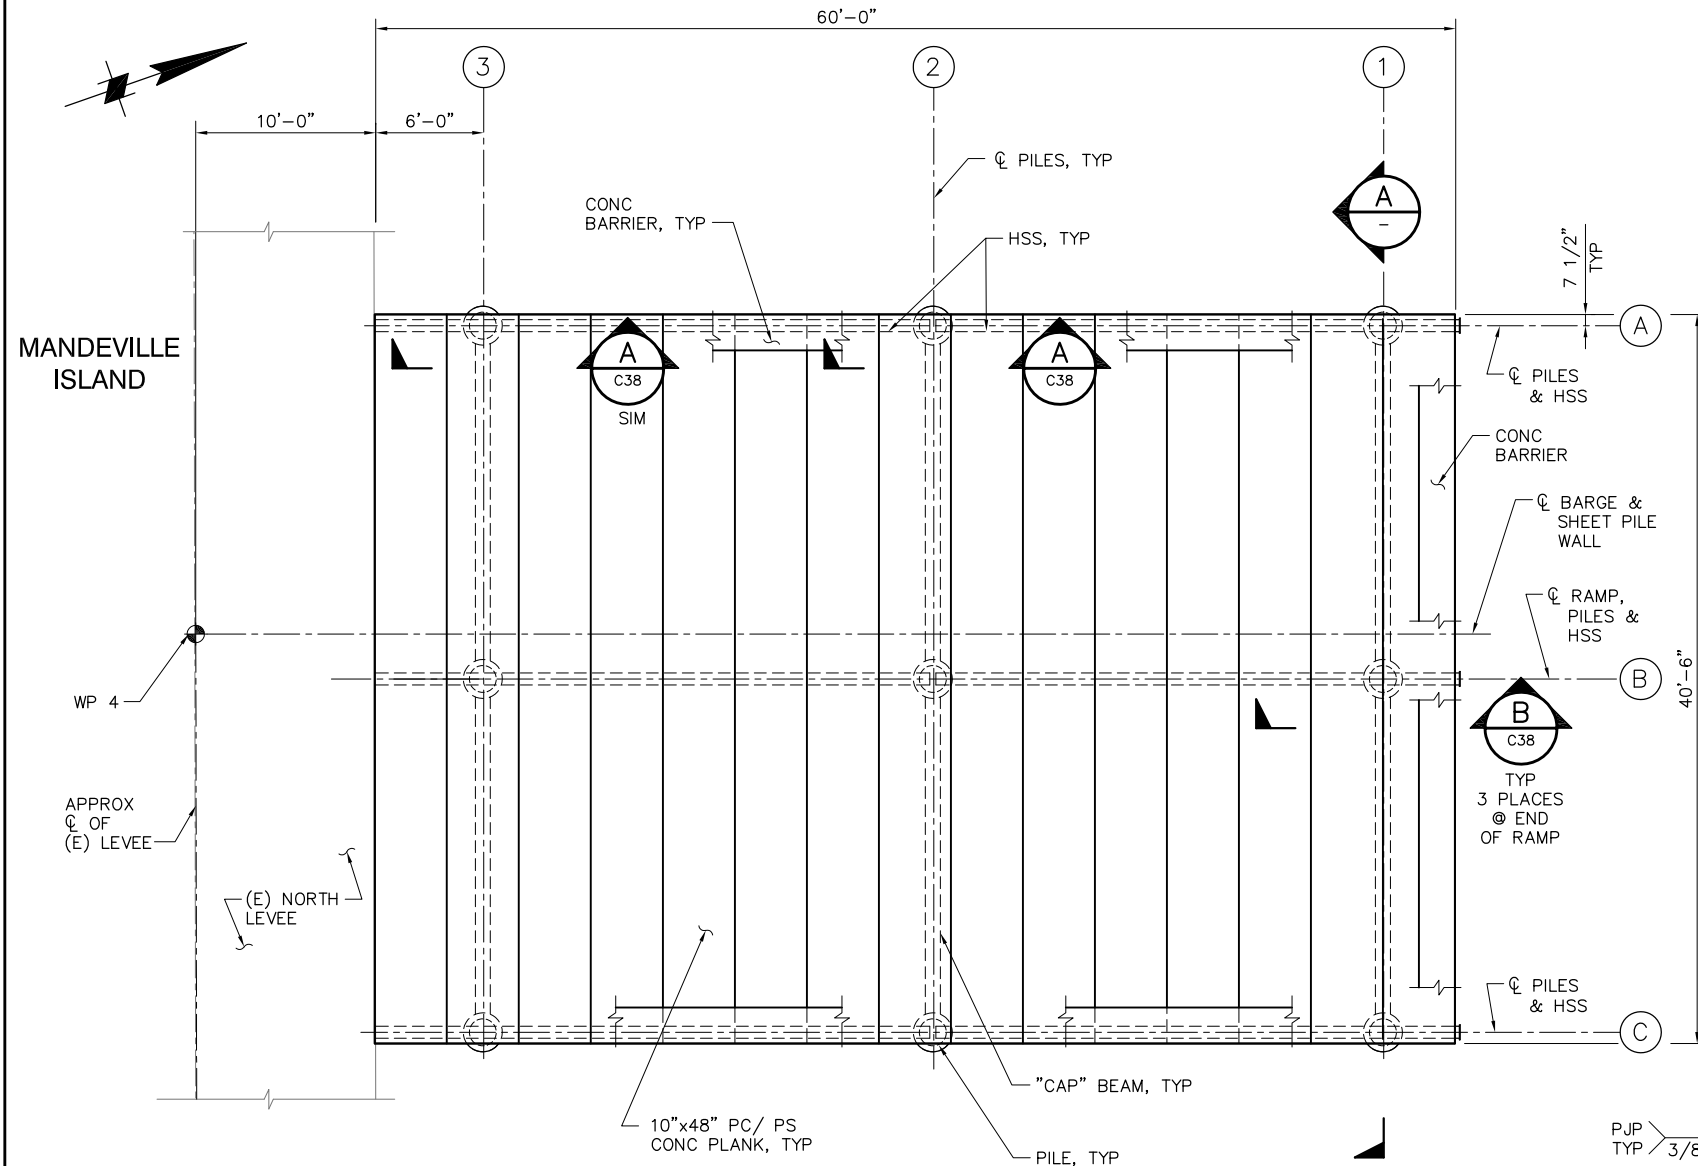


1 DETAIL
SCALE: 3/16" = 1'-0"

NOTES:


- ALL PC/PS PLANKS SHALL BEAR ON/AGAINST NEOPRENE "UNDERLAYMENT" BEARING STRIP WITH A MINIMUM 1/8" THICKNESS.

WELDING NOTE:


ALL STIFFENER PLATES SHALL HAVE DOUBLE SIDED 1/4" FILLET WELDS UON.

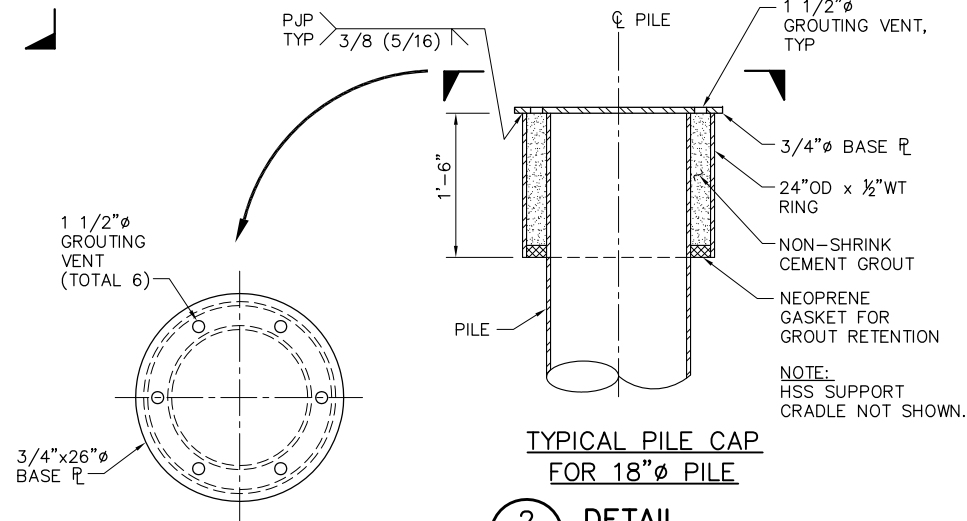

2 DETAIL
SCALE: 1" = 1'-0"

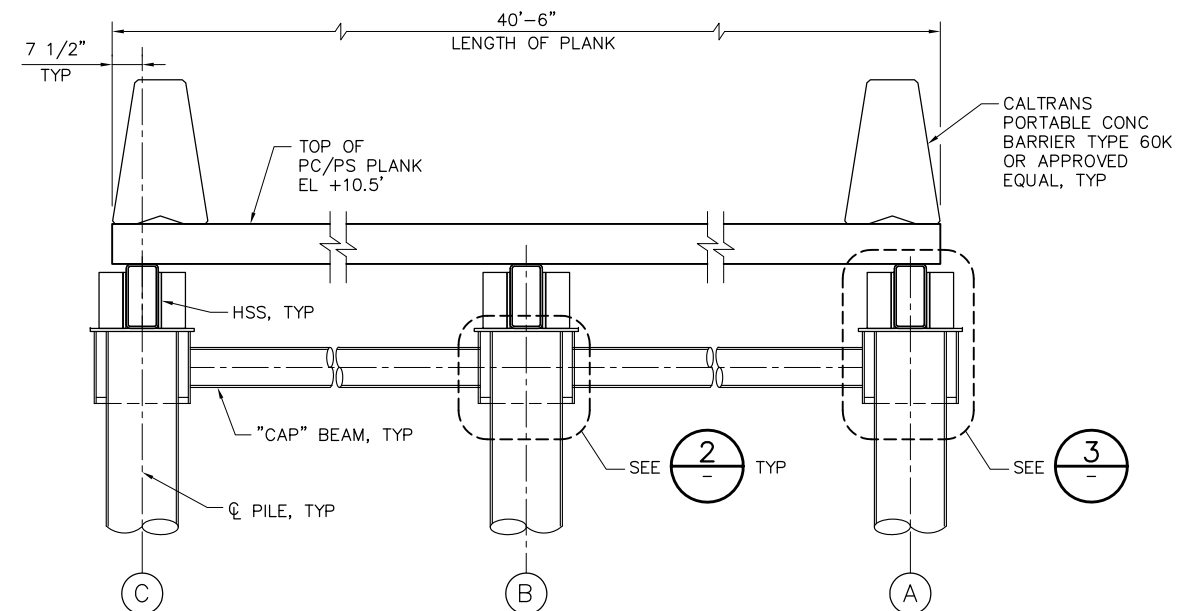

A SECTION
SCALE: 1/2" = 1'-0"

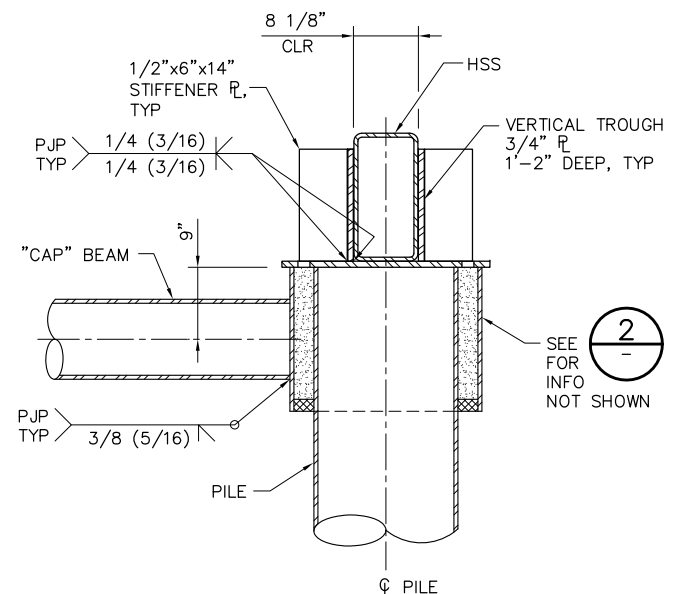

3 DETAIL
SCALE: 1" = 1'-0"

1'-0" 0'-0" 1'-0" 2'-0"
SCALE: 1" = 1'-0"

100% SUBMITTAL

IF SHEET IS LESS THAN 22" x 34"
IT IS A REDUCED PRINT -
SCALE REDUCED ACCORDINGLY.

REVISION	DESCRIPTION	BY	DATE



San Luis & Delta-Mendota Water Authority
842 6th Street, Suite 7
PO Box 2157
Los Banos, California 93635


APPROVED _____
FRANCY C. MIZUNO, PE C35136
San Luis & Delta-Mendota Water Authority

APPROVED _____
DENNIS G. MAJORS PE C21297
Metropolitan Water District of Southern California

		2001 N. Main Street, Suite 360 Walnut Creek, California 94596 (925) 944-5411	
DSGN	JMB	DR	EP/AB
JOB NO.	6097-03	CHK	TDB
SUBMITTED BY		RMR	

TWO GATE FISH PROTECTION PLAN		DATE 08/31/09
CONNECTION SLOUGH BOAT RAMP DETAILS AND SECTIONS SHEET 1		SHEET 41 OF 78
C37		

P:\6097-03 SVC GATE DESIGN\CADD\DWG\609703-C38.DWG 8/27/2009 9:21 AM

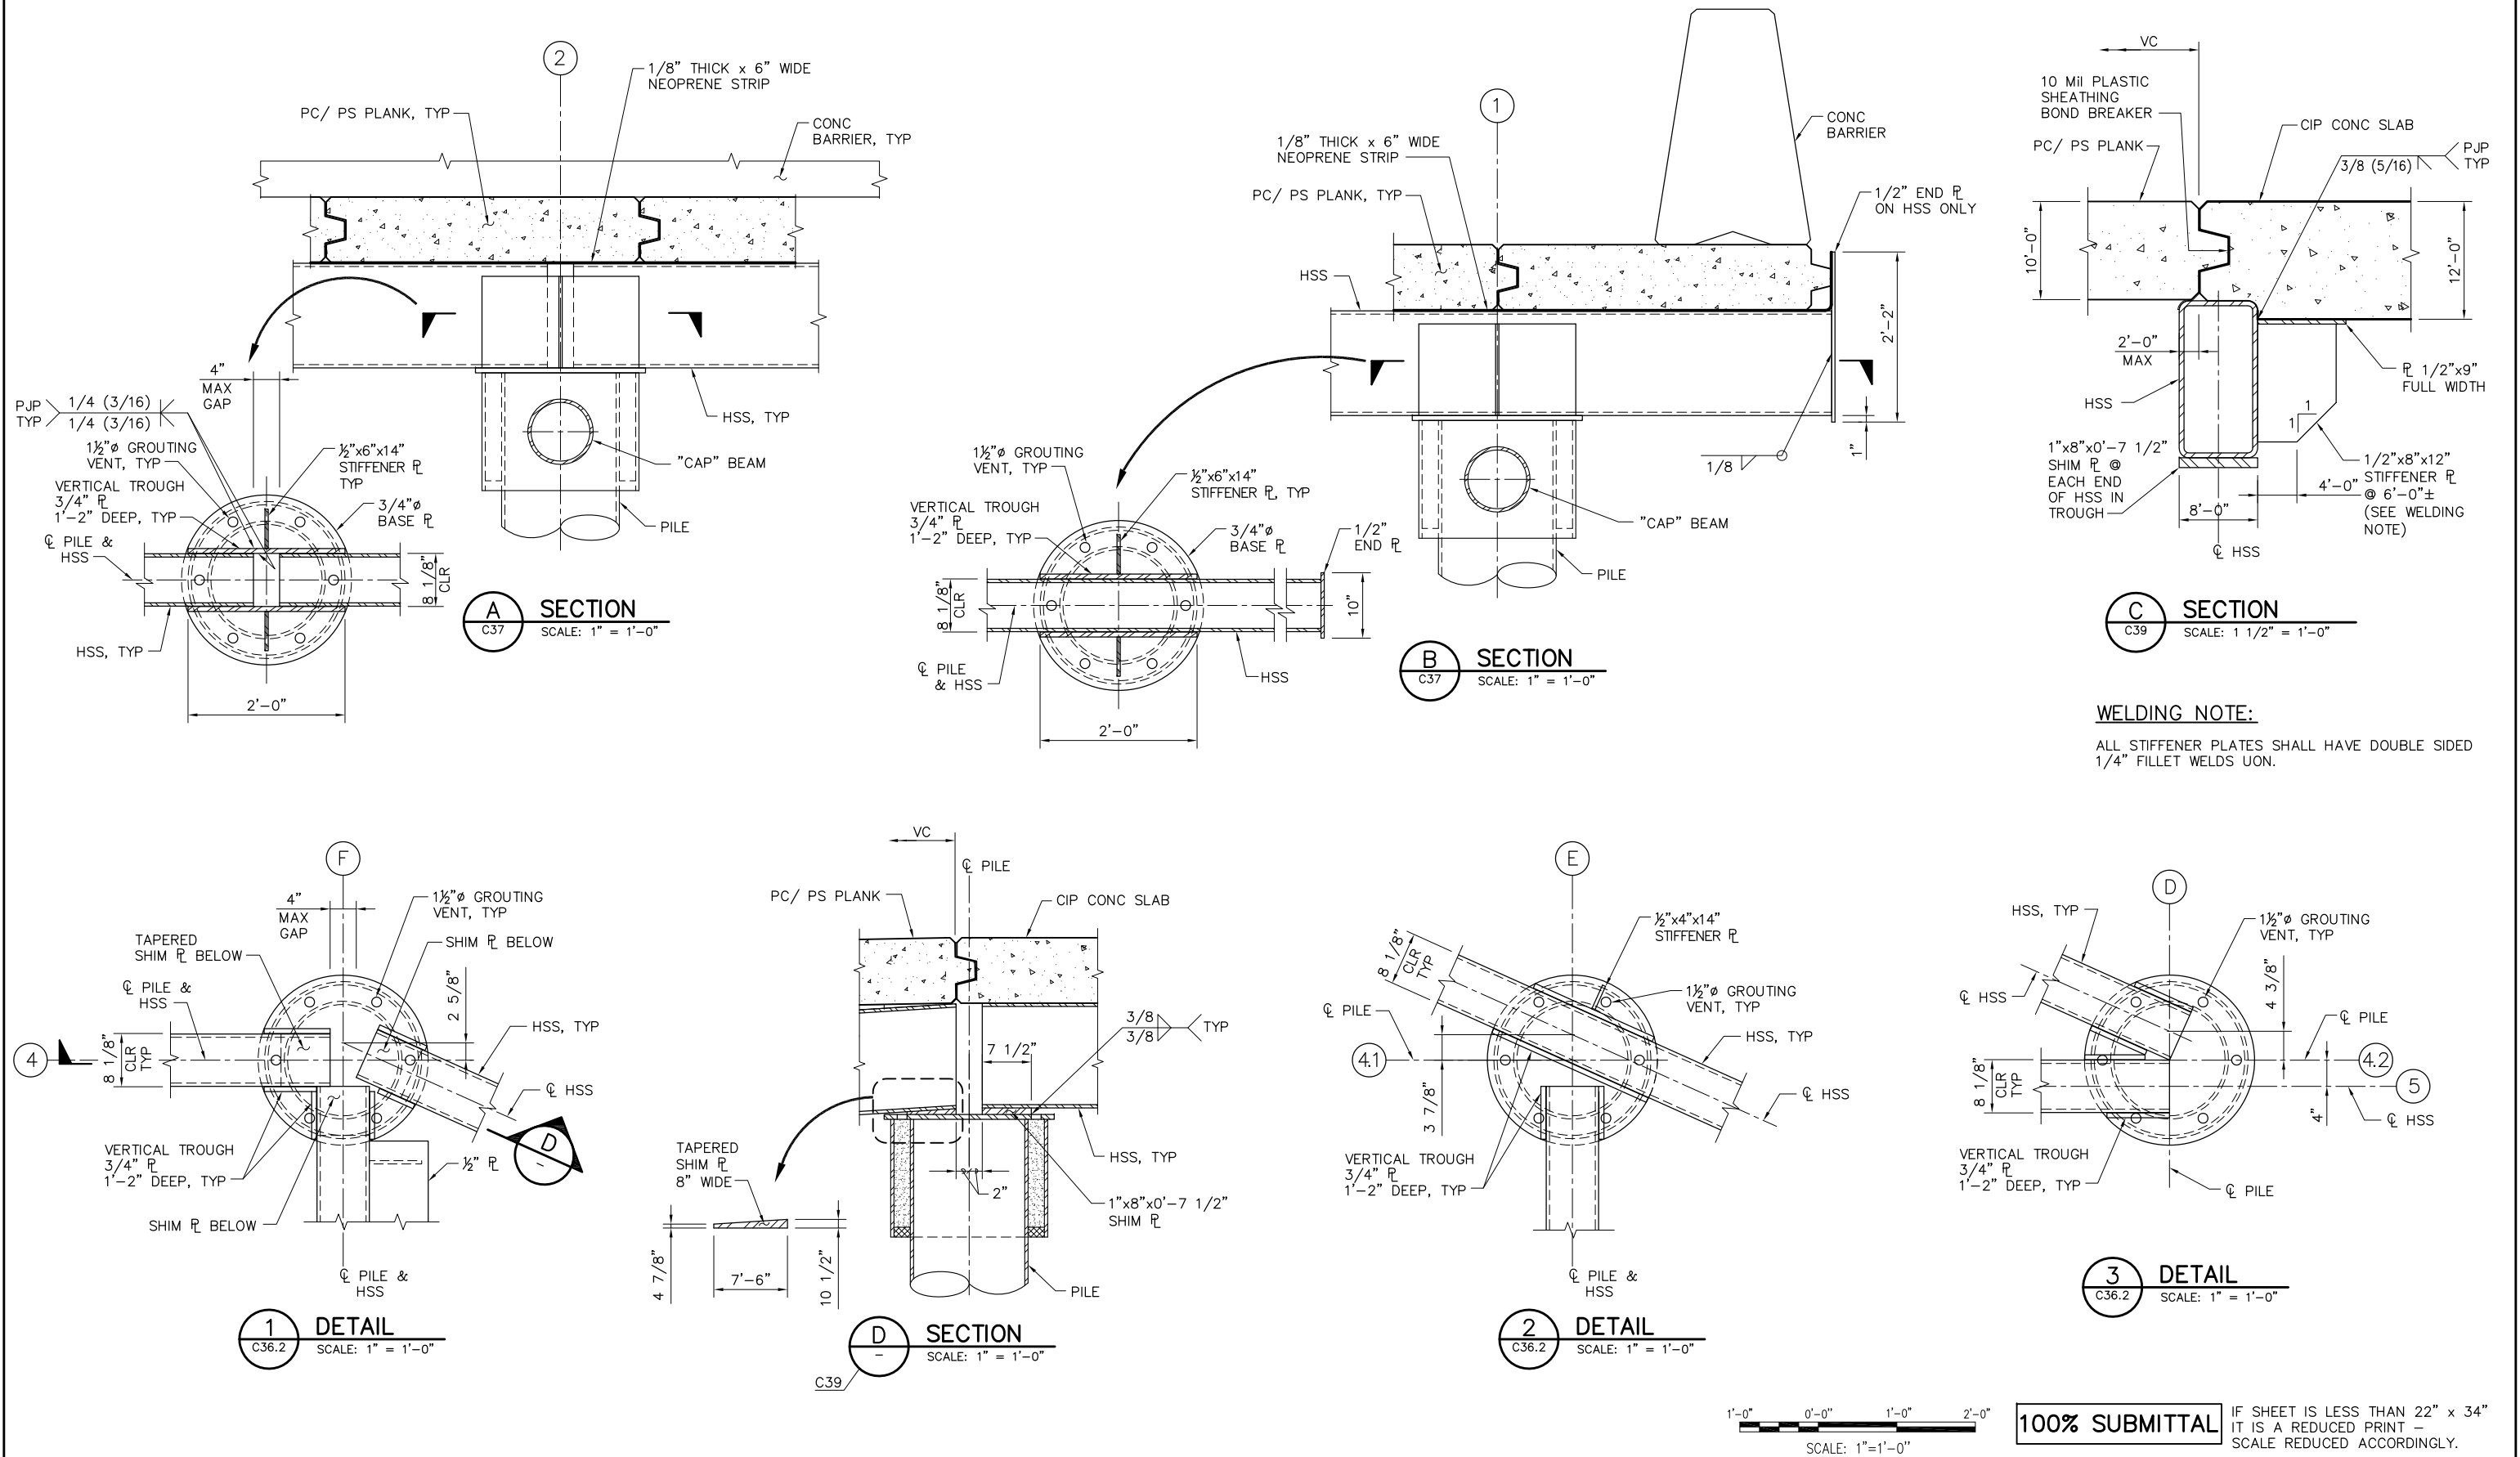

REVISION	DESCRIPTION	BY	DATE



San Luis & Delta-Mendota Water Authority
842 6th Street, Suite 7
PO Box 2157
Los Banos, California 93635

APPROVED _____
FRANCY C. MIZUNO, PE C35136
San Luis & Delta-Mendota Water Authority

APPROVED _____
DENNIS G. MAJORS PE C21297
Metropolitan Water District of Southern California




2001 N. Main Street, Suite 360
Walnut Creek, California 94596
(925) 944-5411


DSGN	JMB	DR	EP	CHK	TDB
JOB NO.	6097-03	SUBMITTED BY	RMR		

TWO GATE FISH PROTECTION PLAN	DATE 08/31/09
CONNECTION SLOUGH BOAT RAMP DETAILS AND SECTIONS SHEET 2	SHEET 42 OF 78
C38	


P:\6097-03 SWC GATE DESIGN\CADD\DWG\609703-C39.DWG 8/25/2009 5:15 PM

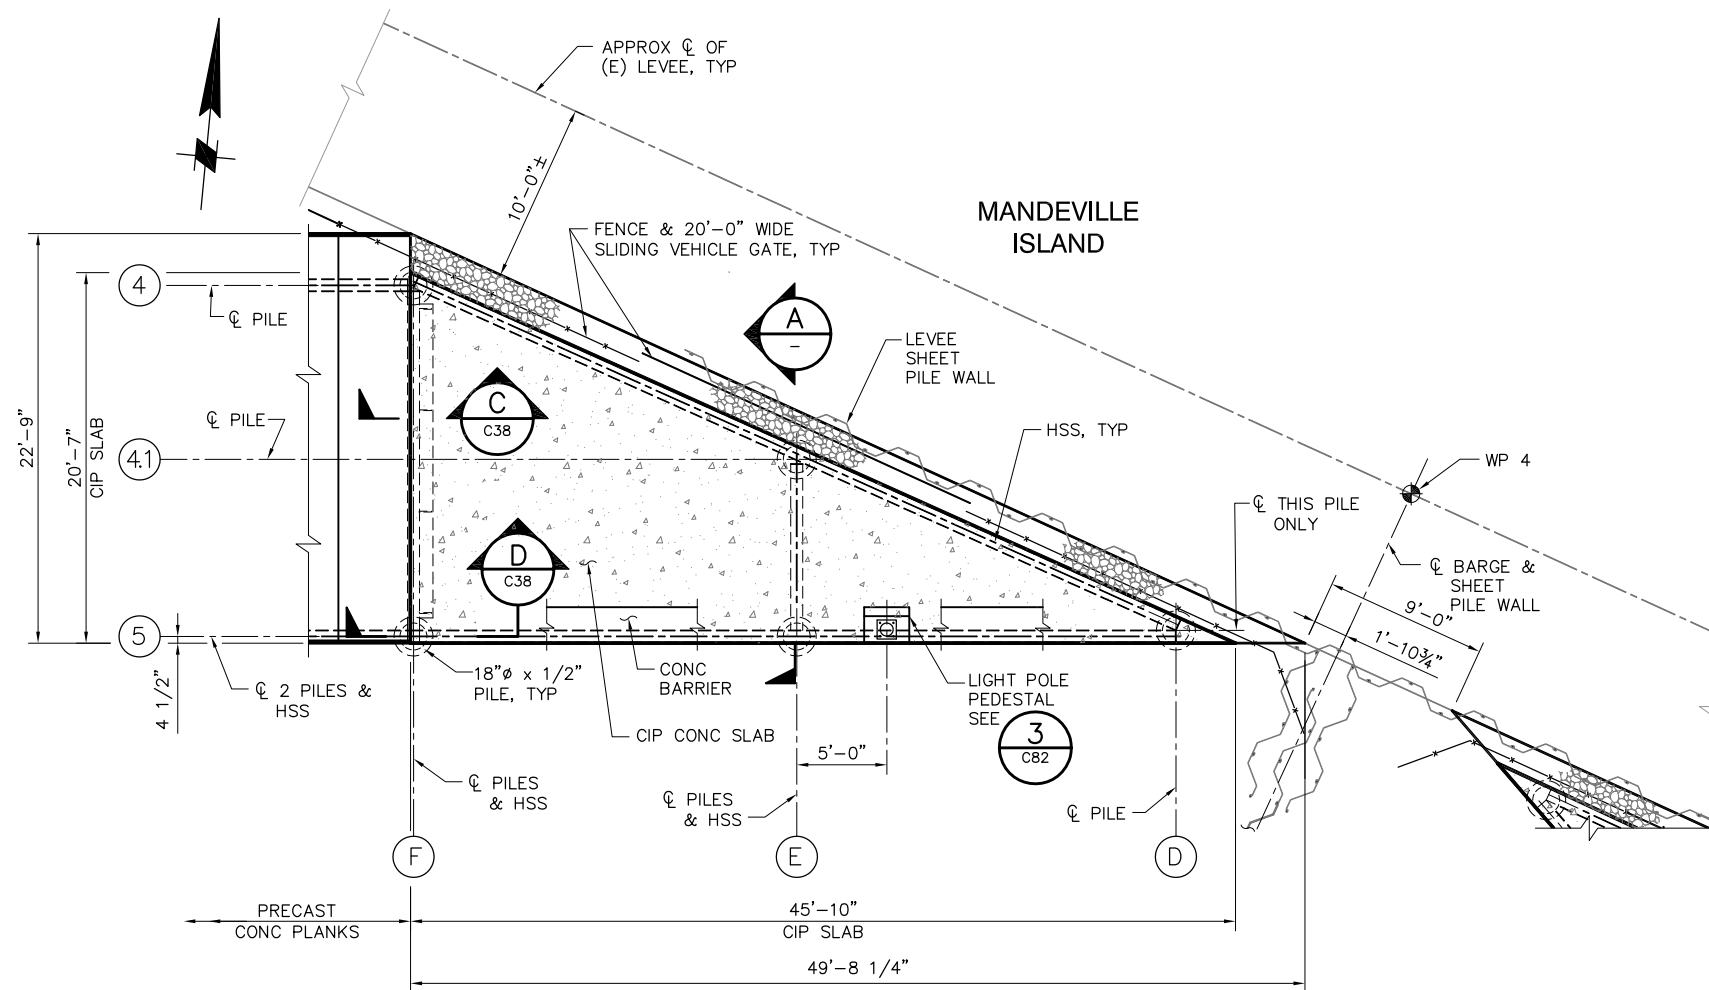


2 DETAIL
C36 SCALE: 3/16" = 1'-0"

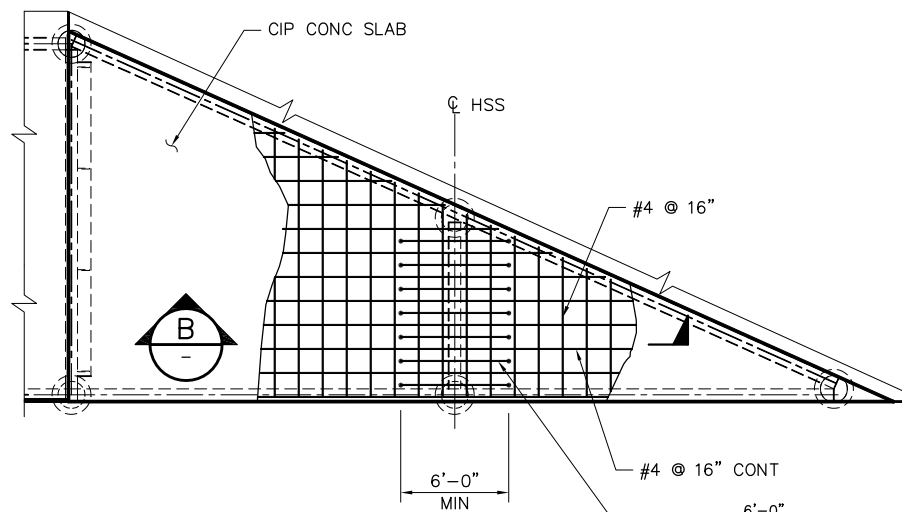


TOP SLAB REINFORCEMENT
SCALE: 3/16" = 1'-0"

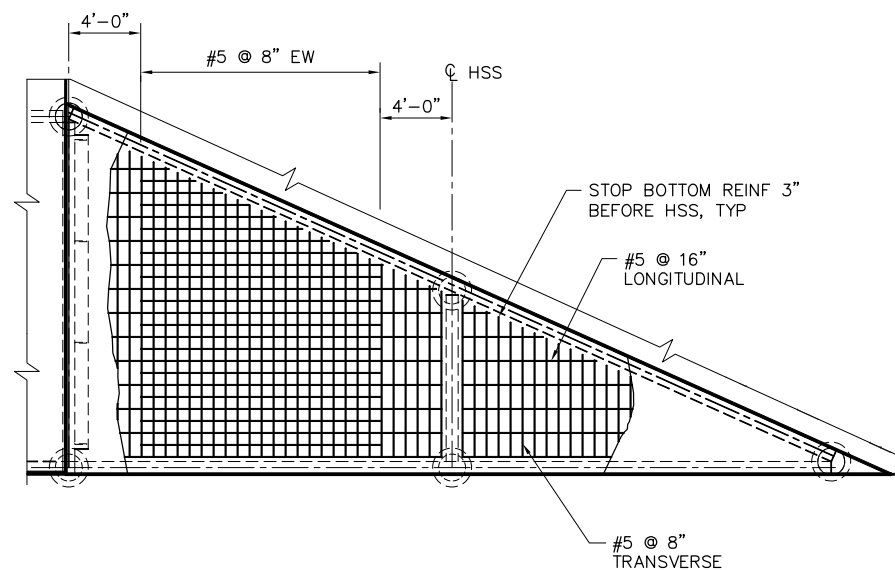


BOTTOM SLAB REINFORCEMENT
SCALE: 3/16" = 1'-0"

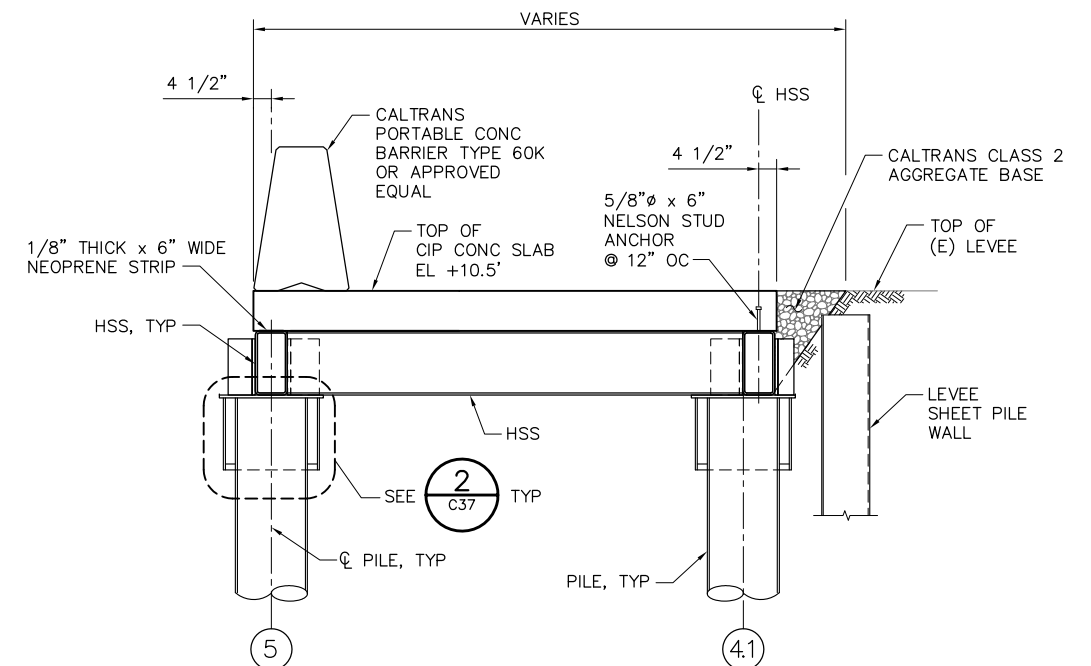

A SECTION
SCALE: 1/2" = 1'-0"

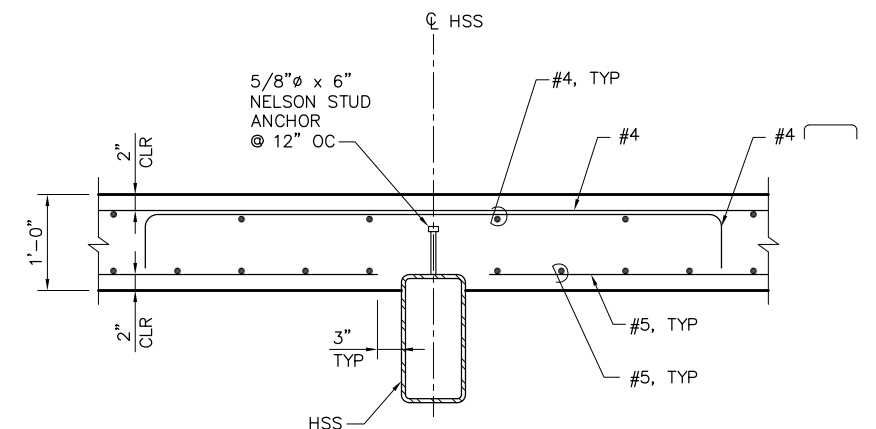


B SECTION
SCALE: 1" = 1'-0"

 

100% SUBMITTAL

IF SHEET IS LESS THAN 22" x 34"
IT IS A REDUCED PRINT -
SCALE REDUCED ACCORDINGLY.

REVISION	DESCRIPTION	BY	DATE

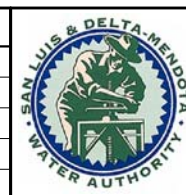

San Luis & Delta-Mendota Water Authority
842 6th Street, Suite 7
PO Box 2157
Los Banos, California 93635

APPROVED _____
FRANCY C. MIZUNO, PE C35136
San Luis & Delta-Mendota Water Authority

APPROVED _____
DENNIS G. MAJORS PE C21297
Metropolitan Water District of Southern California

DSGN JMB
JOB NO. 6097-03

DR EP/AB
SUBMITTED BY RMR

CHK TDB

2001 N. Main Street, Suite 360
Walnut Creek, California 94596
(925) 944-5411

 




TWO GATE FISH PROTECTION PLAN

CONNECTION SLOUGH
BOAT RAMP DETAILS AND SECTIONS
SHEET 3

DATE 08/31/09
SHEET 44 OF 78

C39

P:\6097-03 SWC GATE DESIGN\CADD\DWG\609703-C40.DWG 8/31/2009 9:35 AM

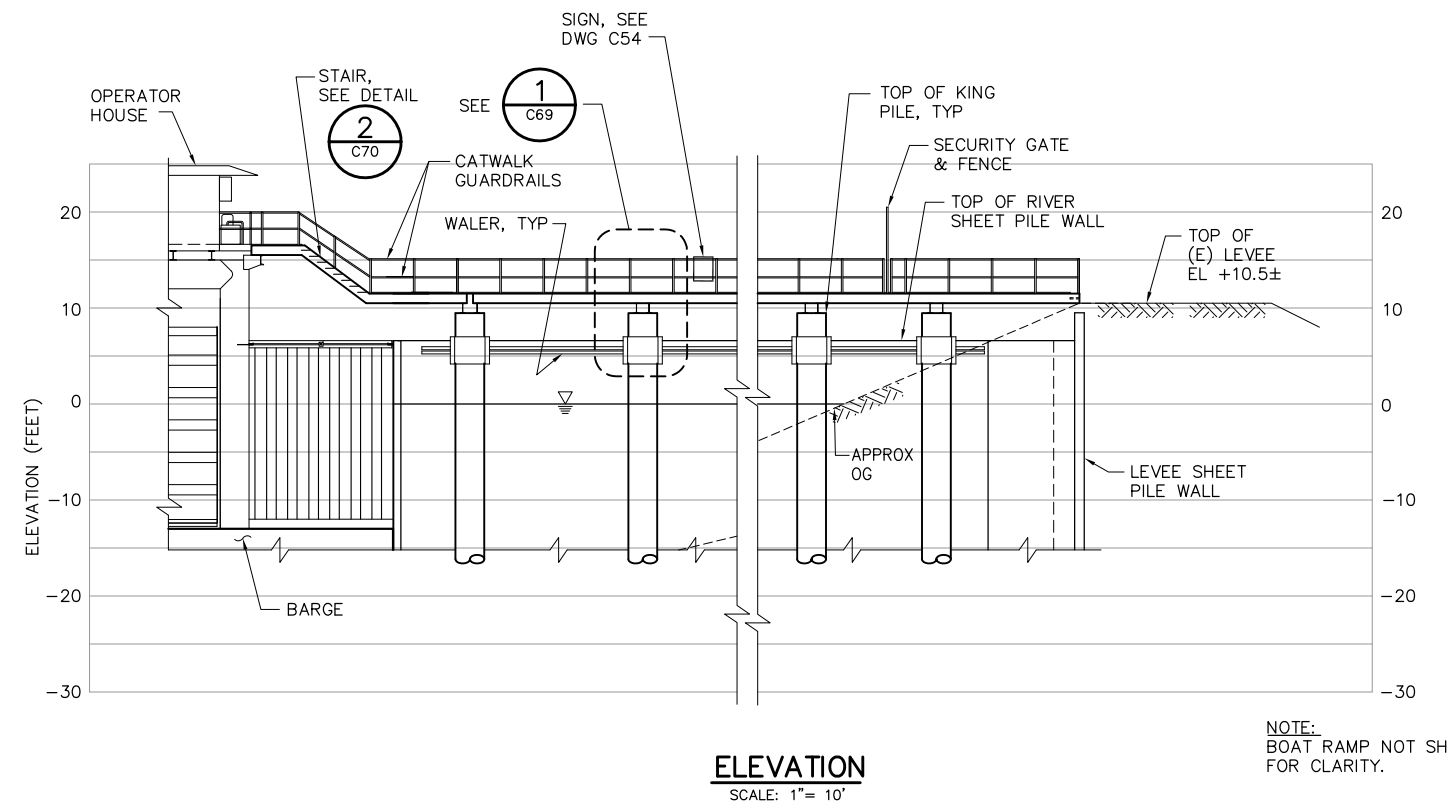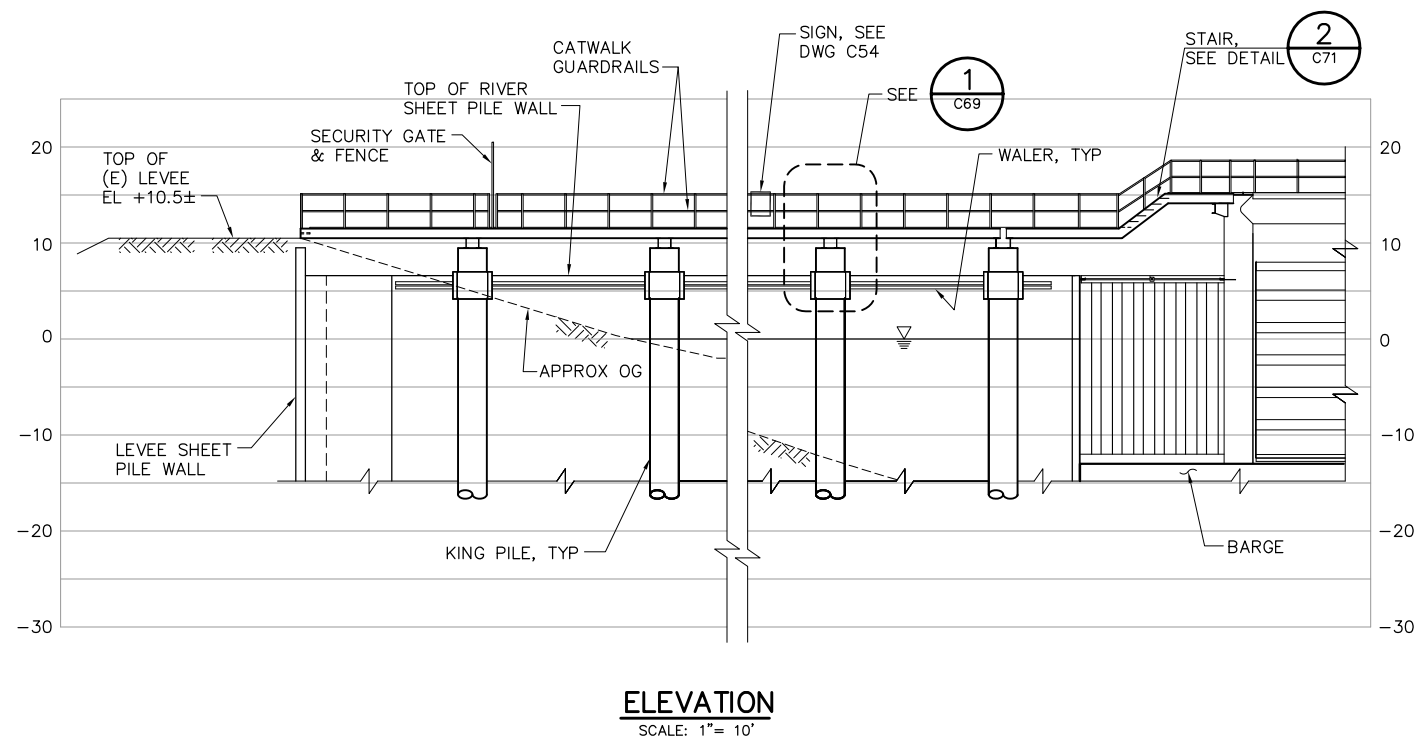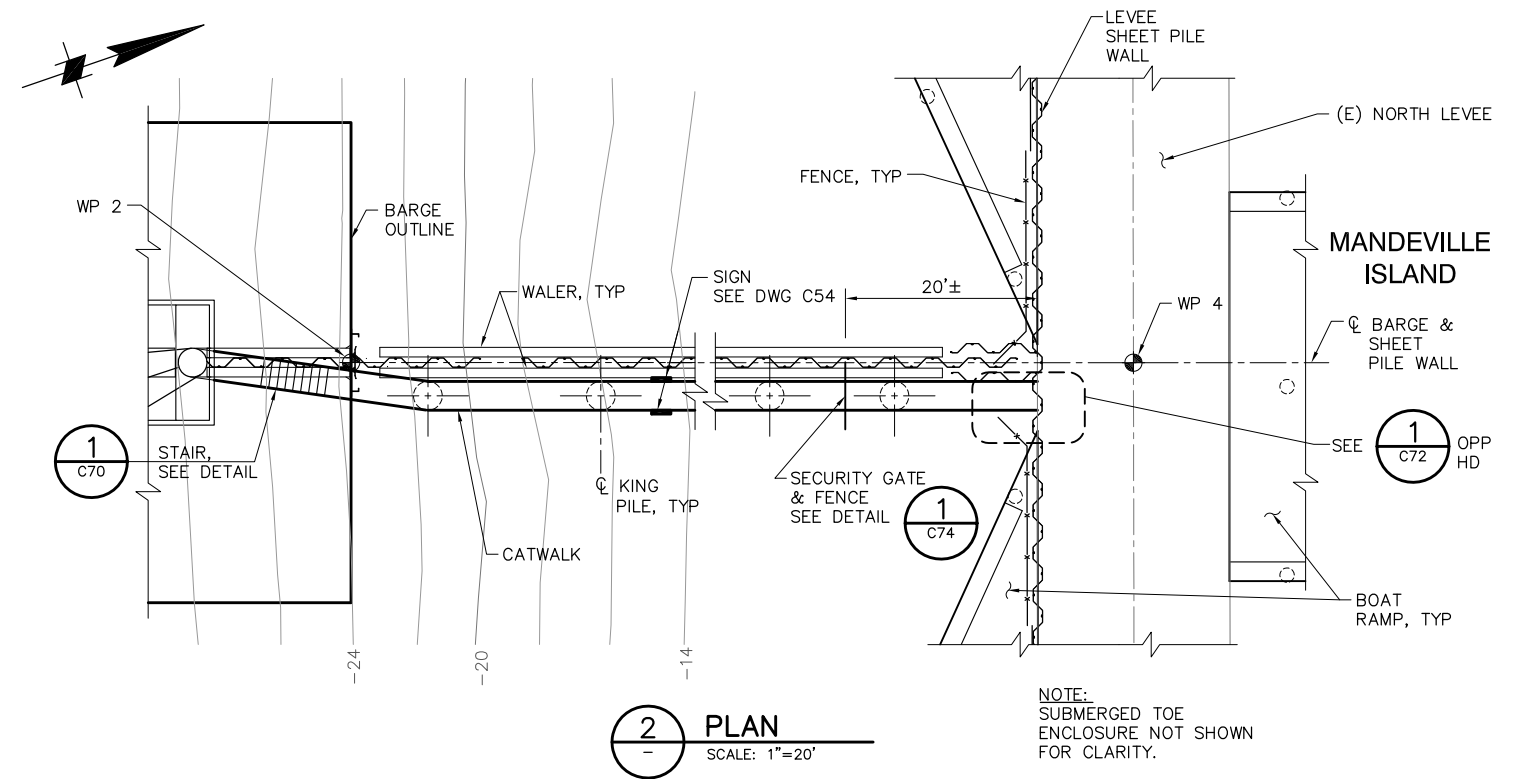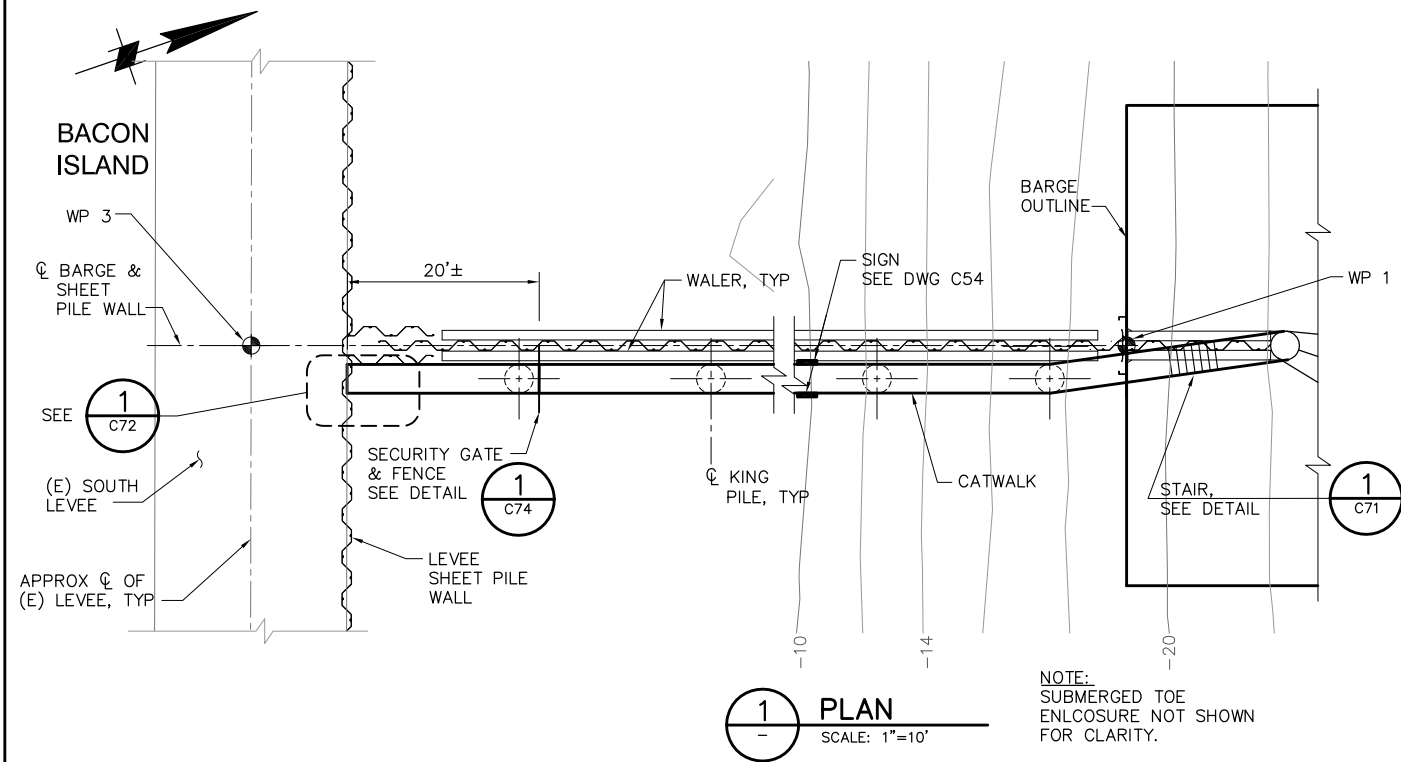

100% SUBMITTAL

IF SHEET IS LESS THAN 22" x 34"
IT IS A REDUCED PRINT -
SCALE REDUCED ACCORDINGLY.

REVISION	DESCRIPTION	BY	DATE



San Luis & Delta-Mendota Water Authority
842 6th Street, Suite 7
PO Box 2157
Los Banos, California 93635

APPROVED _____
FRANCY C. MIZUNO, PE C35136
San Luis & Delta-Mendota Water Authority

APPROVED _____
DENNIS G. MAJORS PE C21297
Metropolitan Water District of Southern California




2001 N. Main Street, Suite 360
Walnut Creek, California 94596
(925) 944-5411


DSGN	JMB	DR	EP/AB	CHK	TDB
JOB NO.	SUBMITTED BY				
6097-03	RMR				

TWO GATE FISH PROTECTION PLAN		DATE 08/31/09
CONNECTION SLOUGH CATWALK PLAN AND ELEVATION		SHEET 44 OF 78
C40		

P:\6097-03 SWC GATE DESIGN\CADD\DWG\609703-C41.DWG 8/28/2009 10:01 AM

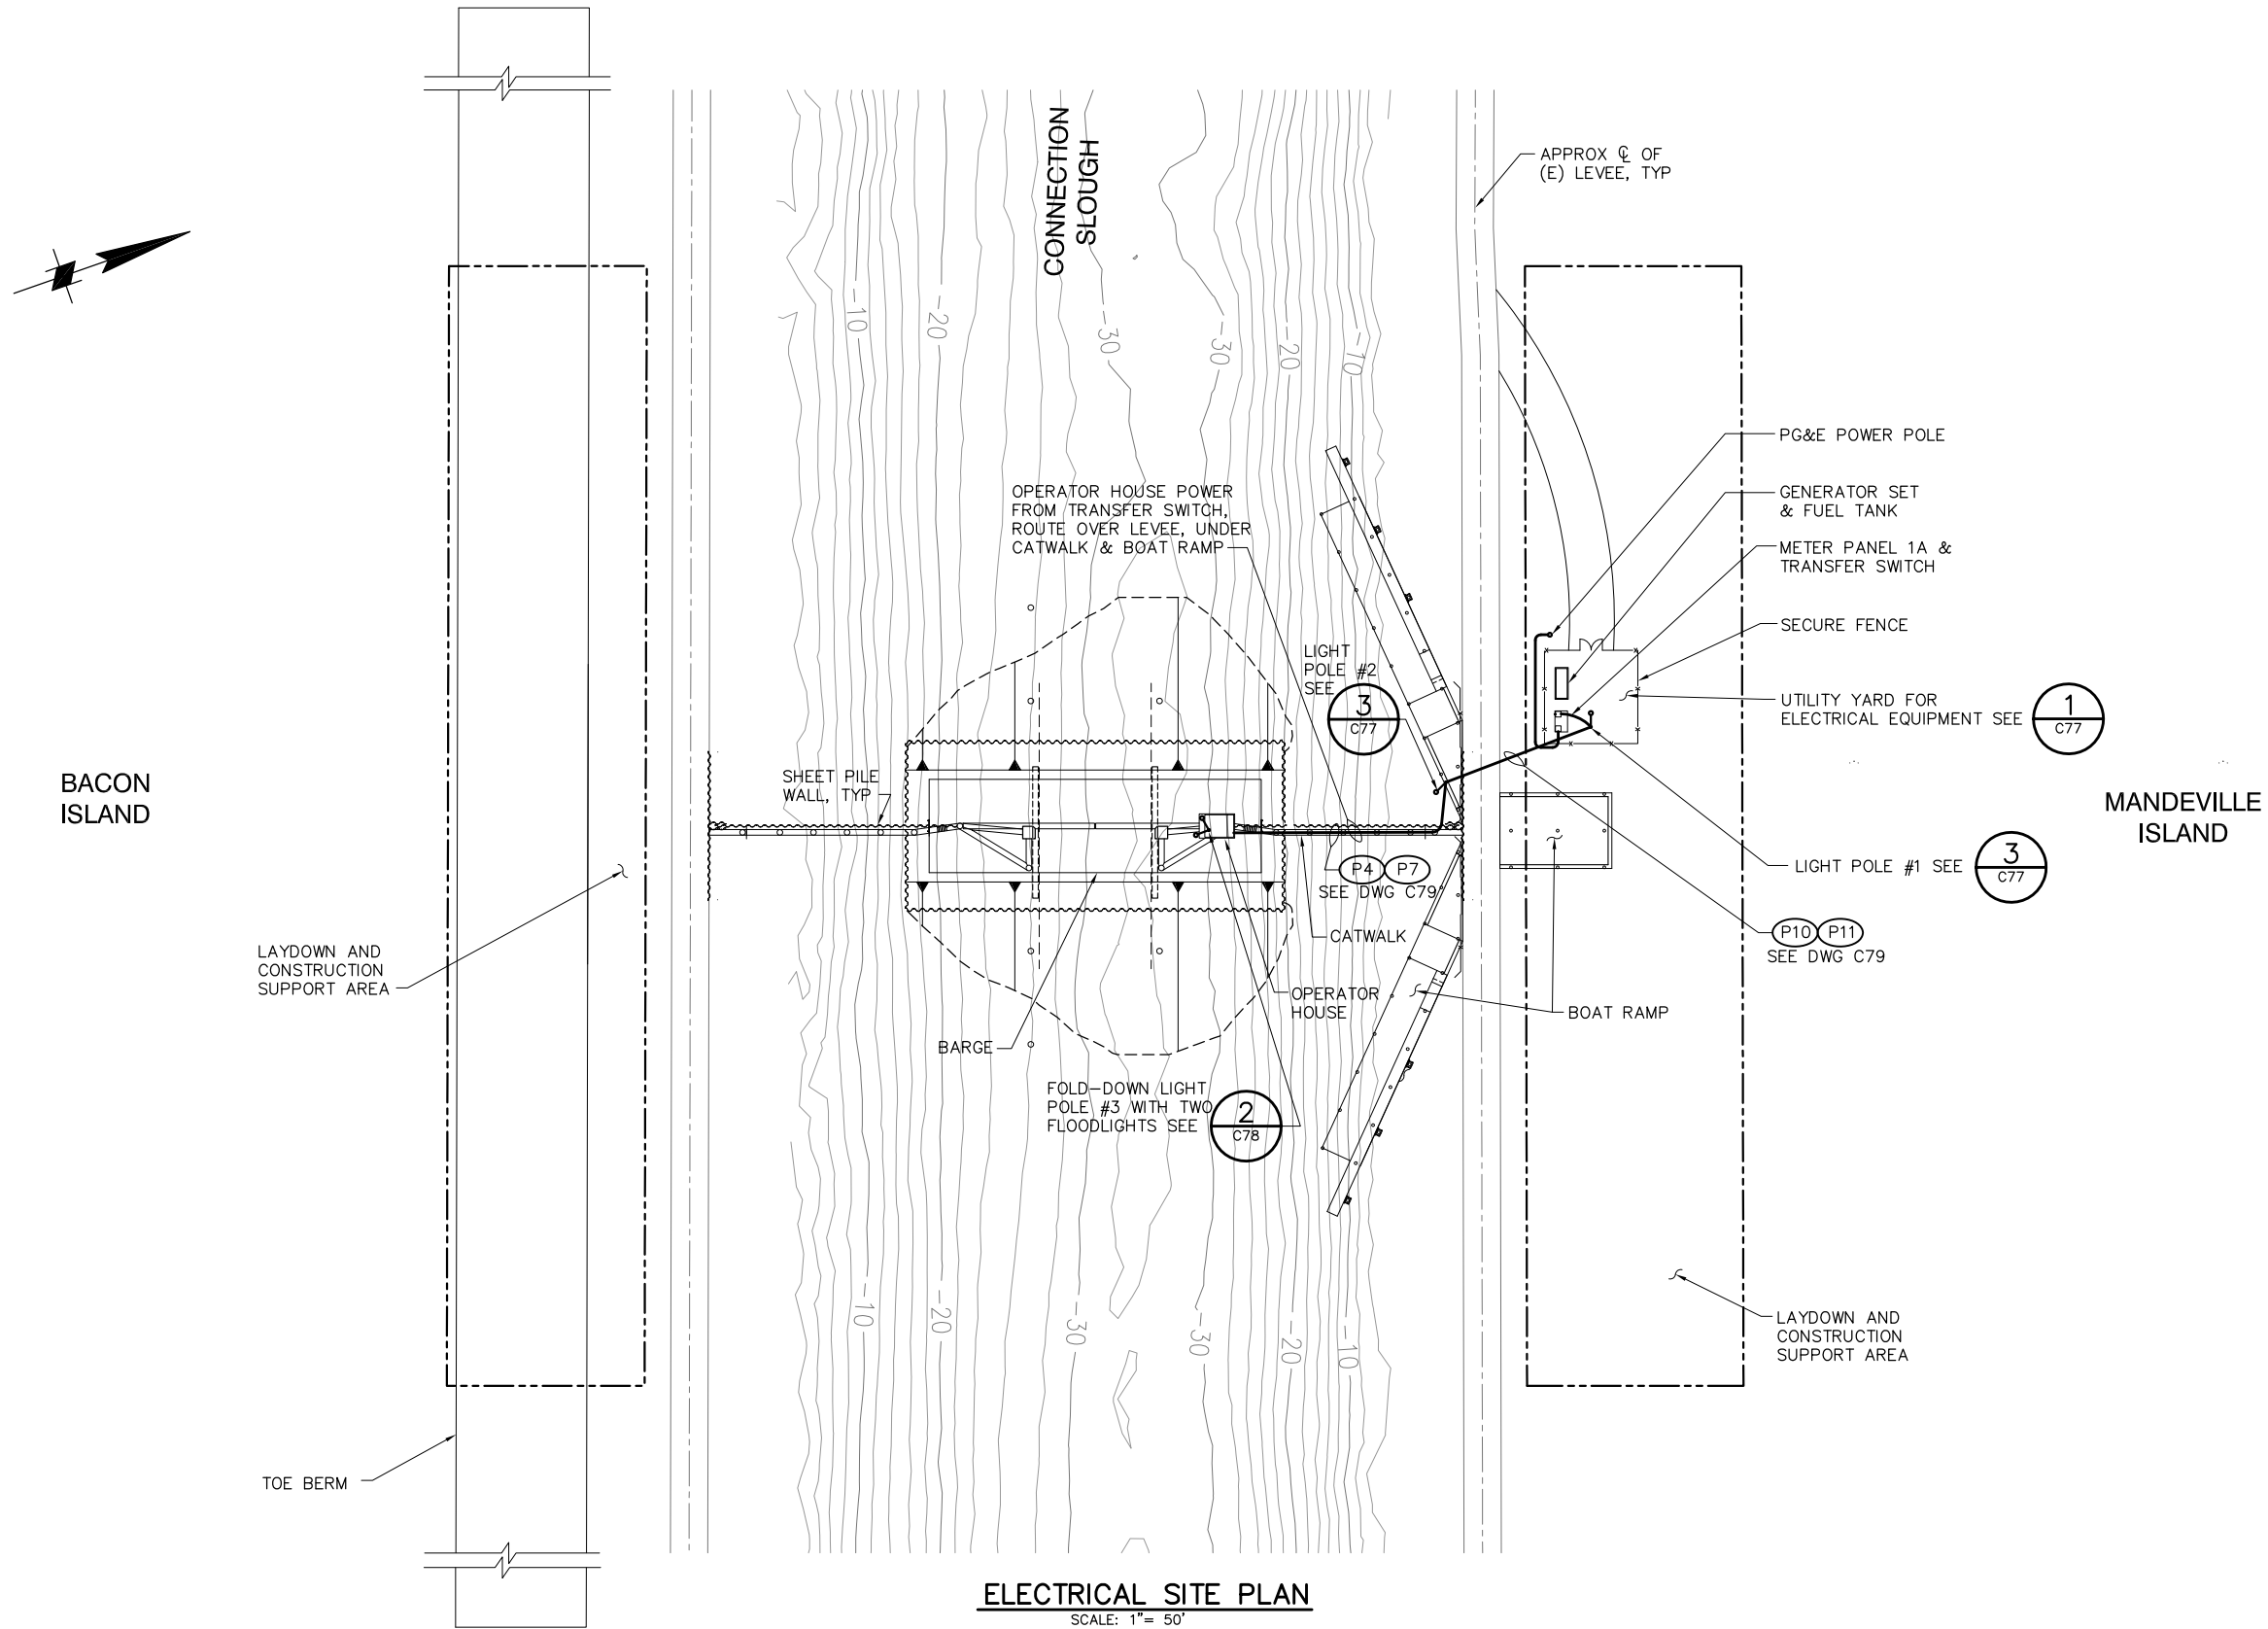

ELECTRICAL SITE PLAN
SCALE: 1"= 50'

 

100% SUBMITTAL

IF SHEET IS LESS THAN 22" x 34"
IT IS A REDUCED PRINT -
SCALE REDUCED ACCORDINGLY.

REVISION	DESCRIPTION	BY	DATE



San Luis & Delta-Mendota Water Authority
842 6th Street, Suite 7
PO Box 2157
Los Banos, California 93635

APPROVED _____
FRANCY C. MIZUNO, PE C35136
San Luis & Delta-Mendota Water Authority

APPROVED _____
DENNIS G. MAJORS PE C21297
Metropolitan Water District of Southern California



2001 N. Main Street, Suite 360
Walnut Creek, California 94596
(925) 944-5411

DSGN	DM	DR	AB	CHK	CBS
JOB NO.	6097-03	SUBMITTED BY			
		RMR			


 
TWO GATE FISH PROTECTION PLAN

DATE 08/31/09

SHEET 45 OF 78


**CONNECTION SLOUGH
ELECTRICAL SITE PLAN**

C41

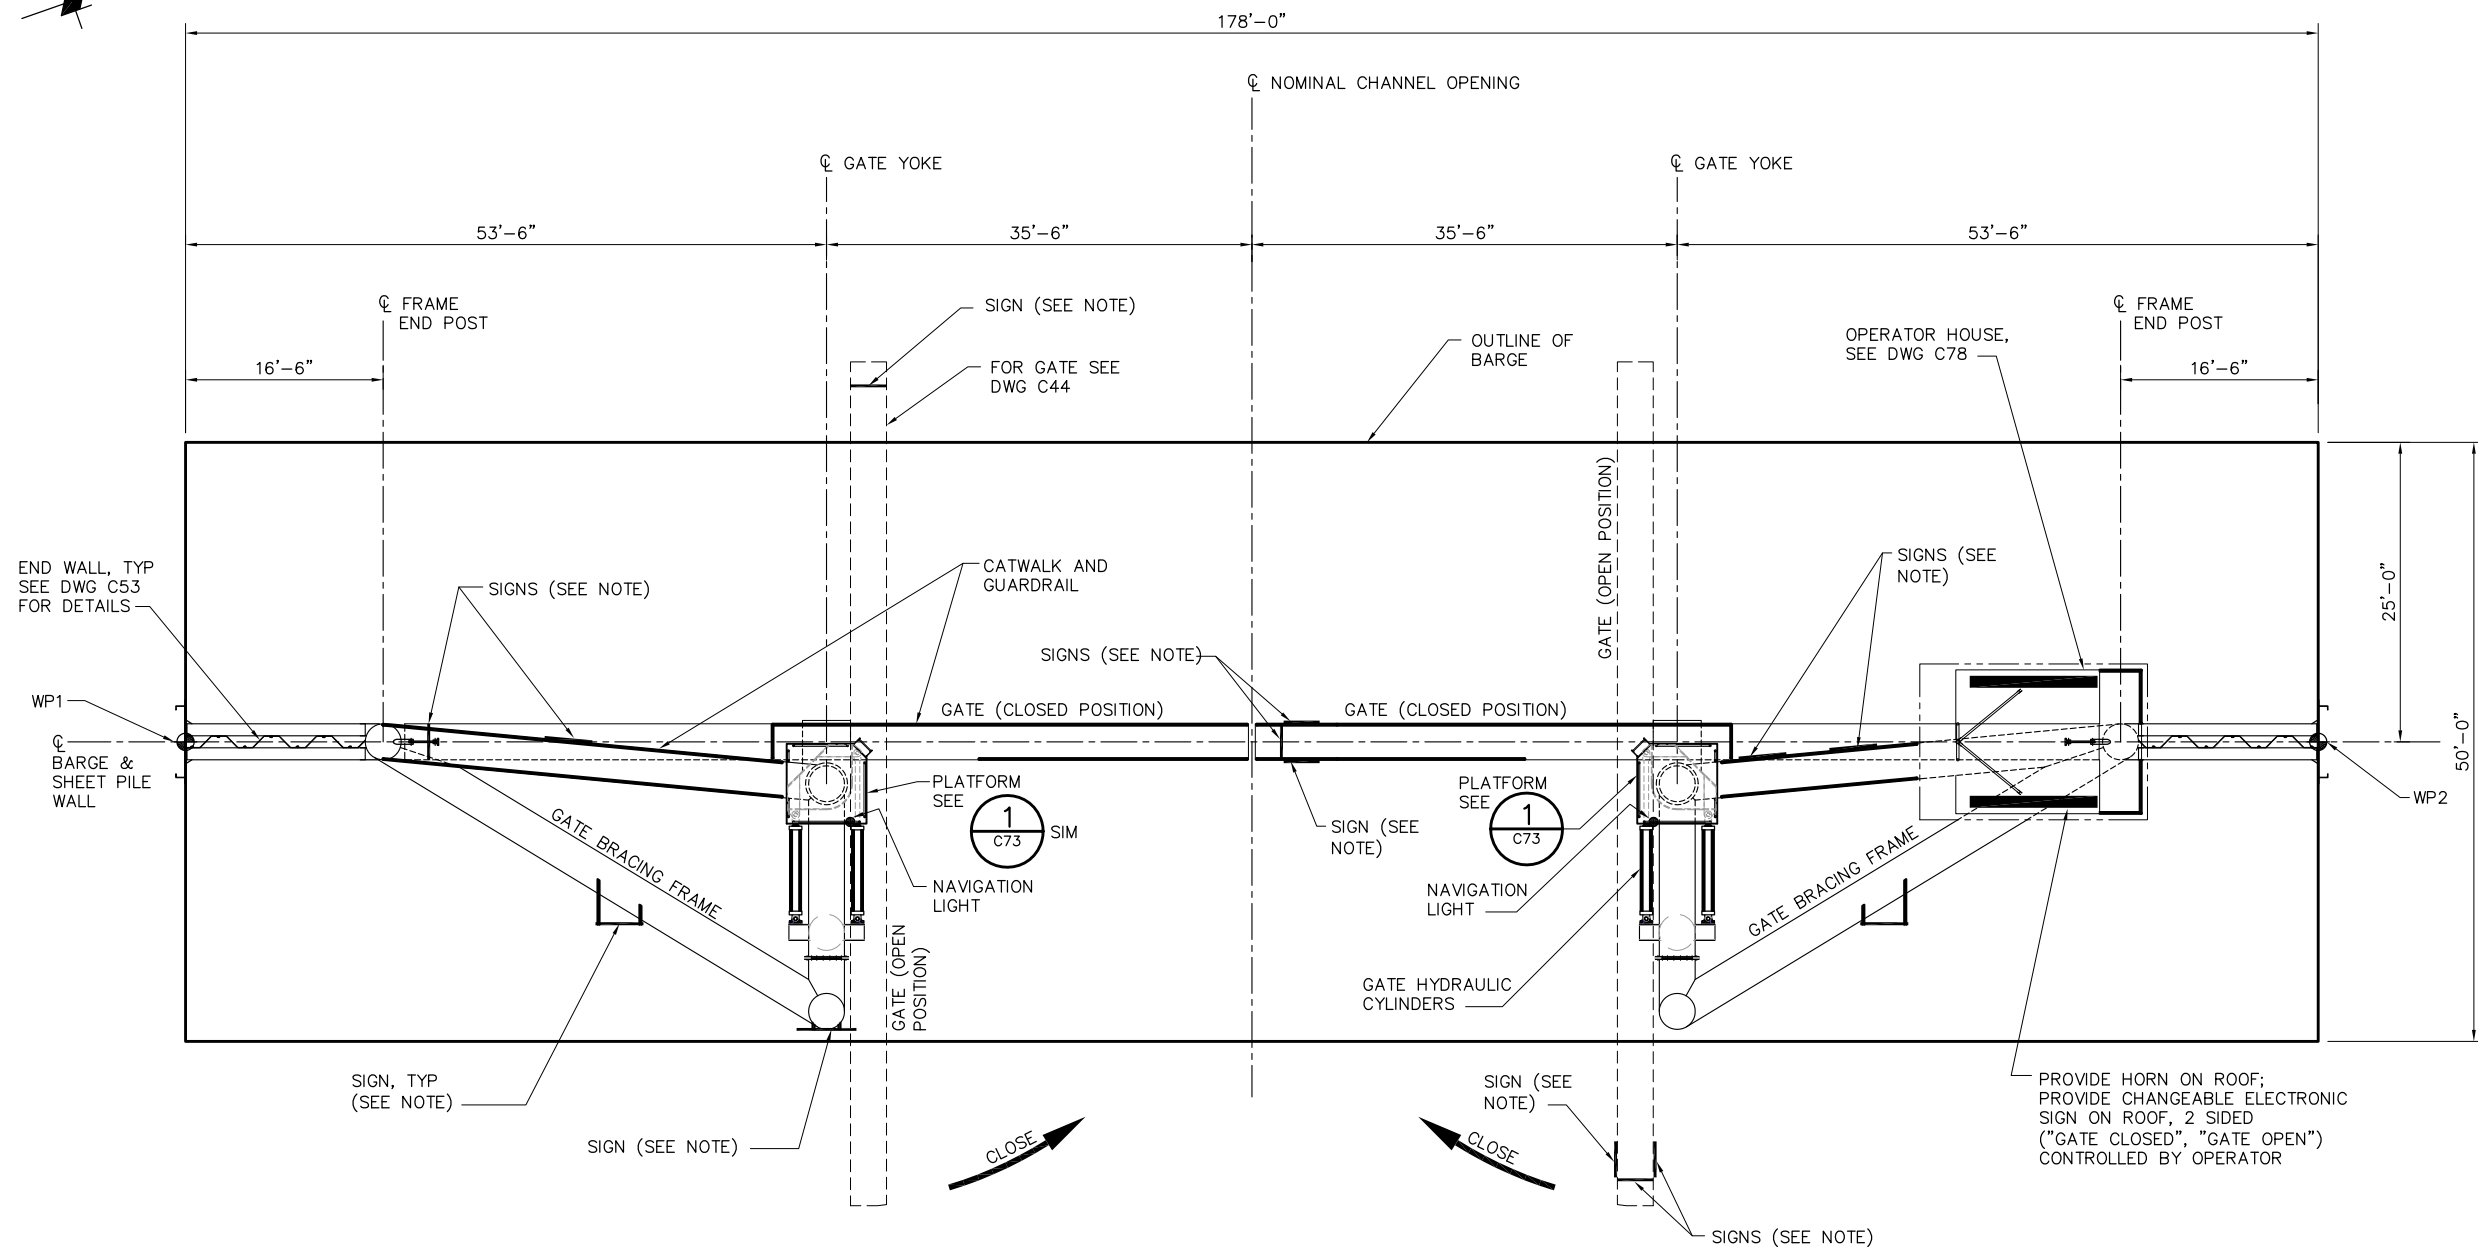

BARGE PLAN
SCALE: 1/8"= 1'-0"

 NOTE:
FOR SIGNAGE, SEE DRAWING C54.



100% SUBMITTAL

IF SHEET IS LESS THAN 22" x 34"
IT IS A REDUCED PRINT -
SCALE REDUCED ACCORDINGLY.

P:\6097-03 SWC GATE DESIGN\CADD\DWG\609703-C42.DWG 8/30/2009 4:22 PM

REVISION	DESCRIPTION	BY	DATE



San Luis & Delta-Mendota Water Authority
842 6th Street, Suite 7
PO Box 2157
Los Banos, California 93635

APPROVED _____
FRANCY C. MIZUNO, PE C35136
San Luis & Delta-Mendota Water Authority

APPROVED _____
DENNIS G. MAJORS PE C21297
Metropolitan Water District of Southern California




2001 N. Main Street, Suite 360
Walnut Creek, California 94596
(925) 944-5411

DSGN	CBS	DR	AB	CHK	TDB
JOB NO.	6097-03	SUBMITTED BY RMR			

TWO GATE FISH PROTECTION PLAN CONNECTION SLOUGH BARGE GENERAL ARRANGEMENT PLAN	DATE 08/31/09
	SHEET 46 OF 78
C42	

NOTES:


 
1. FOR SIGNAGE SEE DRAWING C54.
2. FOR CATWALK STAIRWAY SEE DRAWING C40.



100% SUBMITTAL

IF SHEET IS LESS THAN 22" x 34"
IT IS A REDUCED PRINT –
SCALE REDUCED ACCORDINGLY.

REVISION	DESCRIPTION	BY	DATE	 San Luis & Delta-Mendota Water Authority 842 6th Street, Suite 7 PO Box 2157 Los Banos, California 93635 APPROVED _____ FRANCY C. MIZUNO, PE C35136 San Luis & Delta-Mendota Water Authority APPROVED _____ DENNIS G. MAJORS PE C21297 Metropolitan Water District of Southern California	 2001 N. Main Street, Suite 360 Walnut Creek, California 94596 (925) 944-5411	TWO GATE FISH PROTECTION PLAN		DATE 08/31/09
						CONNECTION SLOUGH BARGE GENERAL ARRANGEMENT ELEVATION		SHEET 47 OF 78
				DSGN JMB	DR AB	CHK TDB		C43
				JOB NO. 6097-03	SUBMITTED BY RMR			

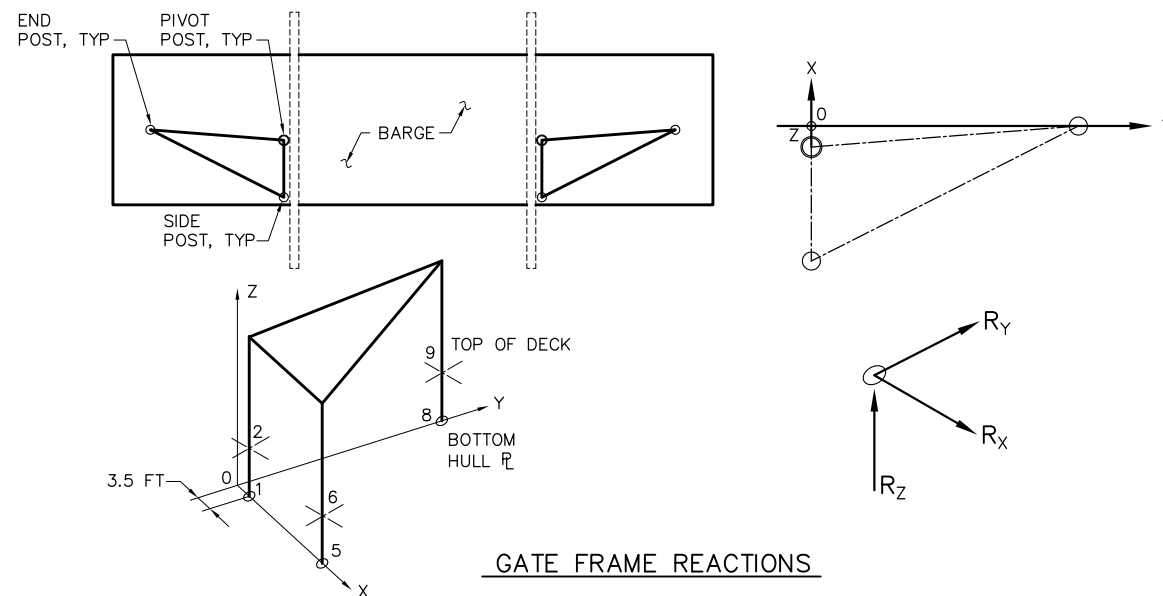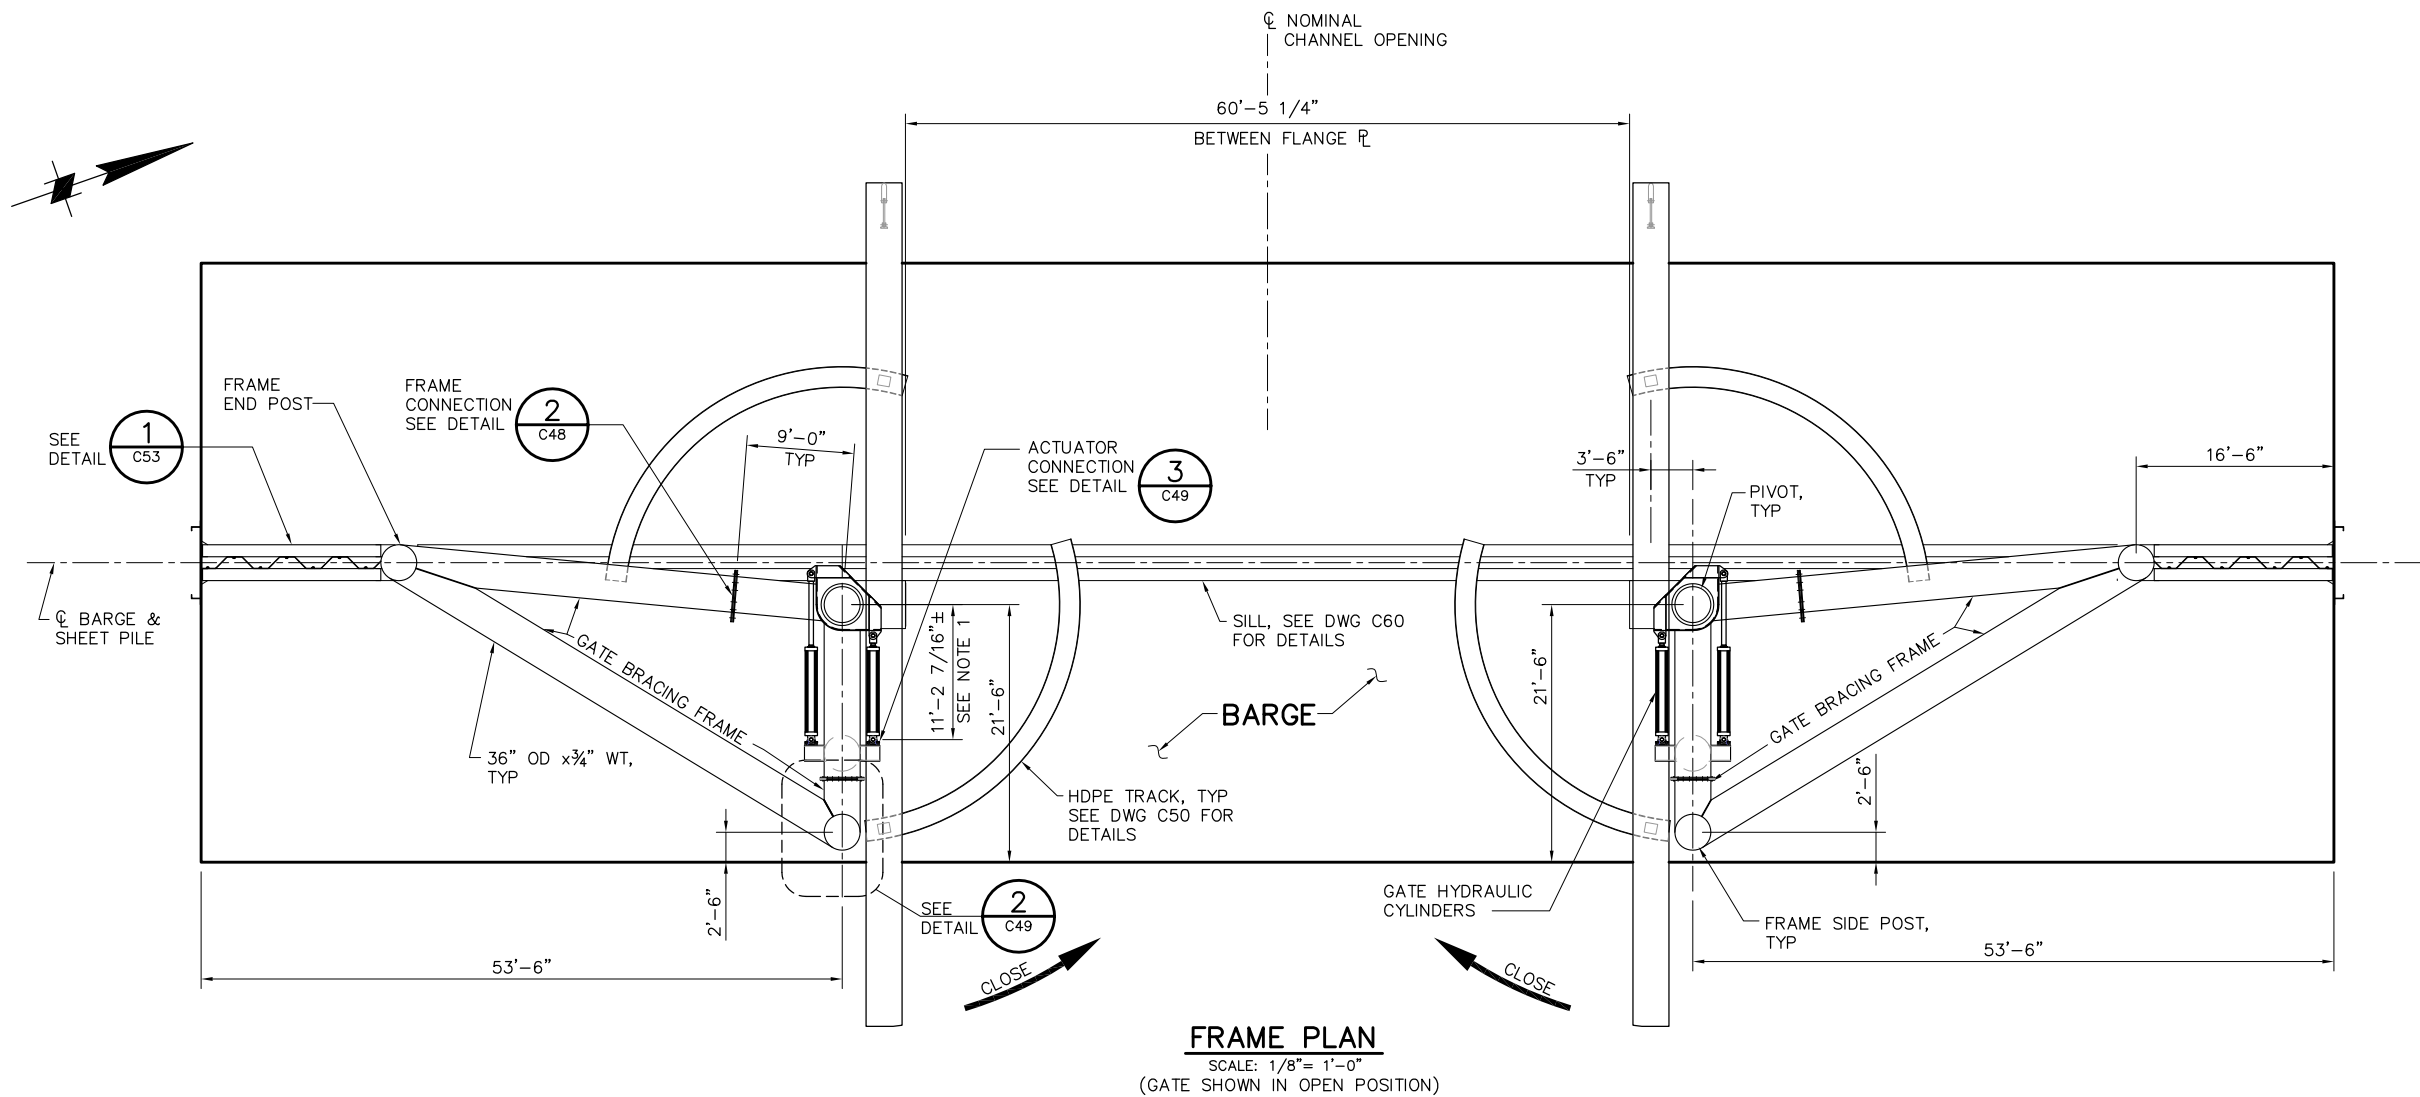


SERVICE LOAD REACTIONS (INCLUDES A 1.2 FACTOR)
(FOR LRFD USE A 1.6 FACTOR WITH THESE REACTIONS)

LOCATION ON BARGE	NODE	R _X (KIP)	R _Y (KIP)	R _Z (KIP)	DESCRIPTION
BOTTOM HULL $\bar{L}$	1	+140 -140	+30 -30	+200 -50	PIVOT
	5	+140 -140	-40 +40	-60 +170	SIDE POST
	8	+50 -50	+30 -30	+100	END POST
TOP OF DECK	2	+500 -500	-50 +50	0	PIVOT
	6	+260 -260	-60 +60	0	SIDE POST
	9	+100 -100	-50 +50	0	END POST

NOTE: CONTRACTOR SHALL PROVIDE A BARGE ADEQUATE TO SUPPORT THESE LOADS.

NOTES:

 - DIMENSION MAY VARY DEPENDING ON ACTUATOR VENDER.




100% SUBMITTAL

IF SHEET IS LESS THAN 22" x 34"
IT IS A REDUCED PRINT -
SCALE REDUCED ACCORDINGLY.

P:\6097-03 SWC GATE DESIGN\CADD\DWG\609703-C45.DWG 8/30/2009 4:19 PM

REVISION	DESCRIPTION	BY	DATE

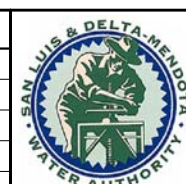

San Luis & Delta-Mendota Water Authority
842 6th Street, Suite 7
PO Box 2157
Los Banos, California 93635


APPROVED _____
FRANCY C. MIZUNO, PE C35136
San Luis & Delta-Mendota Water Authority

APPROVED _____
DENNIS G. MAJORS PE C21297
Metropolitan Water District of Southern California

		2001 N. Main Street, Suite 360 Walnut Creek, California 94596 (925) 944-5411	
DSGN	CBS	DR	AB
JOB NO.	6097-03	CHK	TDB
SUBMITTED BY		RMR	

TWO GATE FISH PROTECTION PLAN		DATE 08/31/09
CONNECTION SLOUGH GATE FRAMING LAYOUT		SHEET 49 OF 78
		C45

P:\6097-03 SWC GATE DESIGN\CADD\DWG\609703-C46.DWG 8/30/2009 4:33 PM

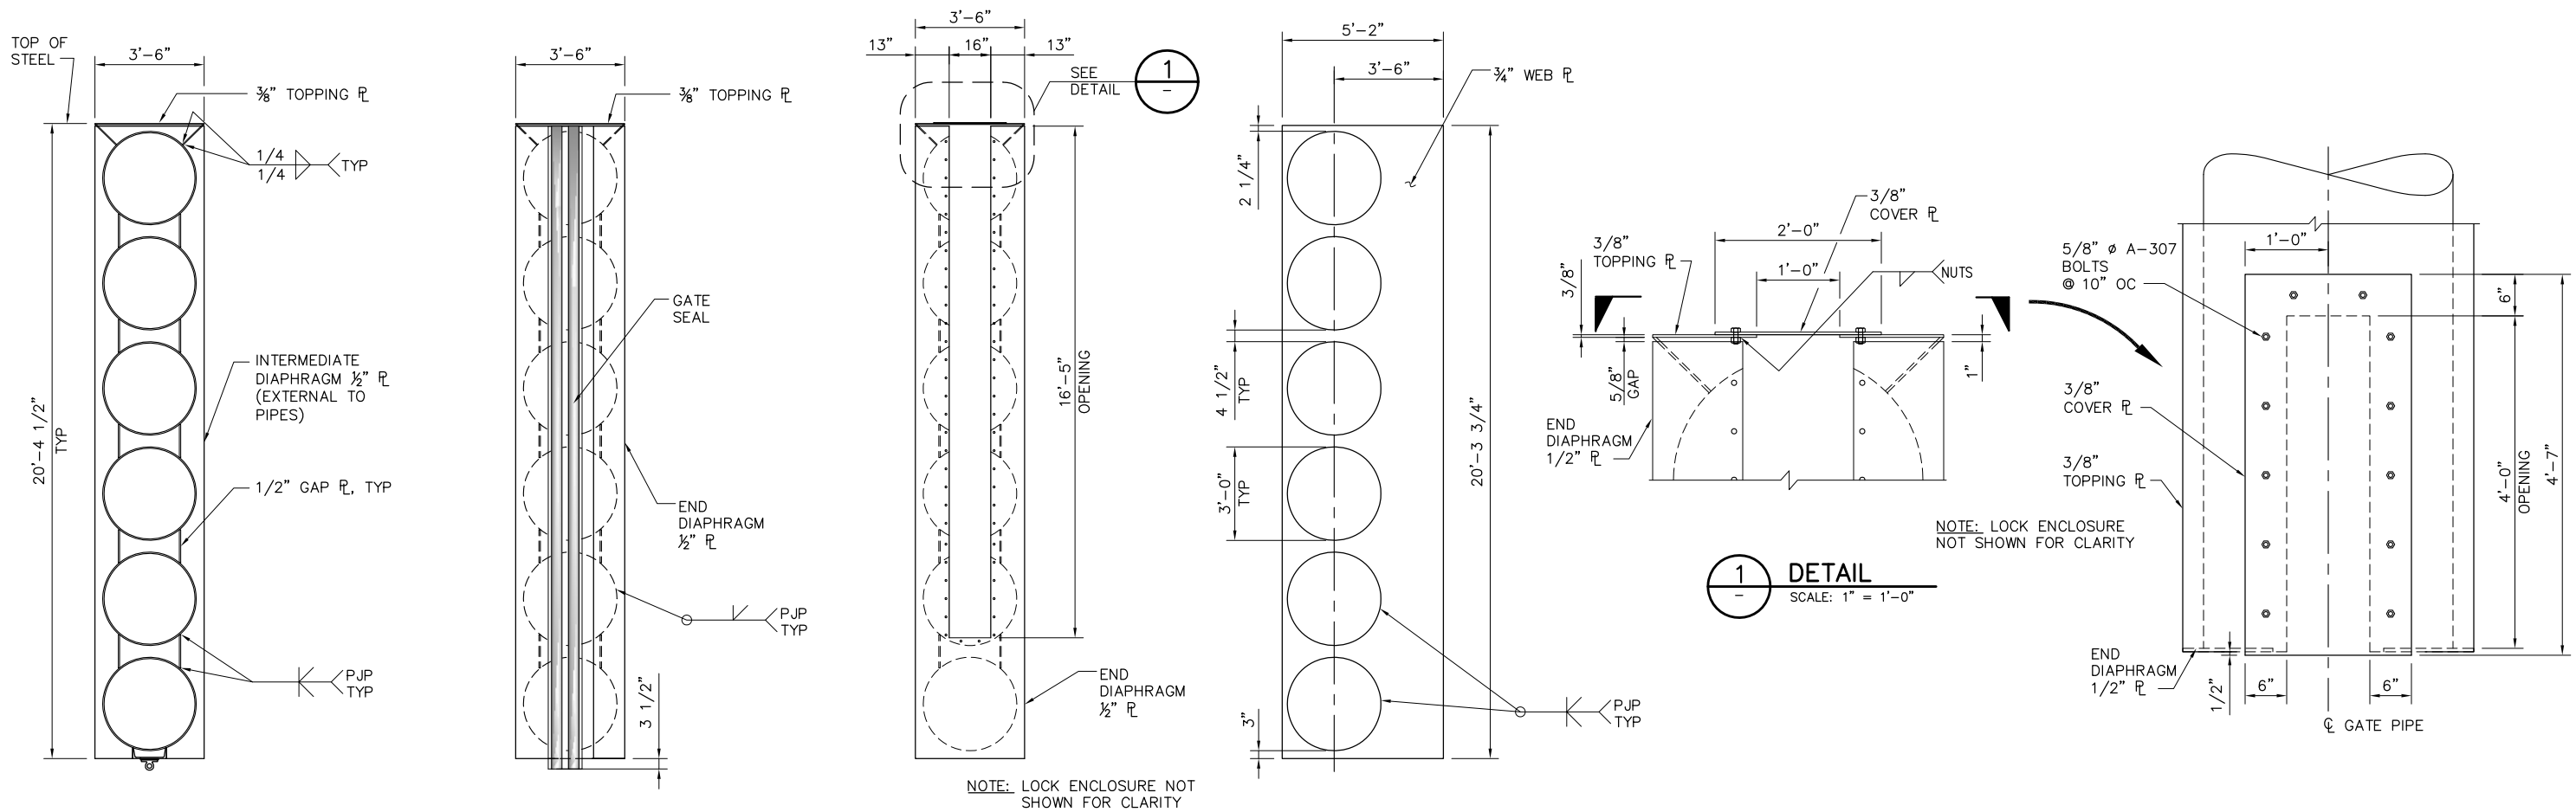


A SECTION
C44 SCALE: 3/8"=1'-0"

B ELEVATION
C44 SCALE: 3/8"=1'-0"


C ELEVATION
C44 SCALE: 3/8"=1'-0"

2 WEB PLATE DETAIL
C44 SCALE: 3/8"=1'-0"


1 DETAIL
SCALE: 1" = 1'-0"

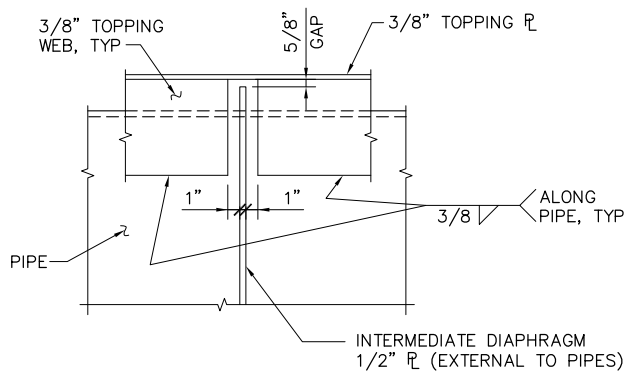

3 DETAIL
C44 SCALE: 1 1/2" = 1'-0"

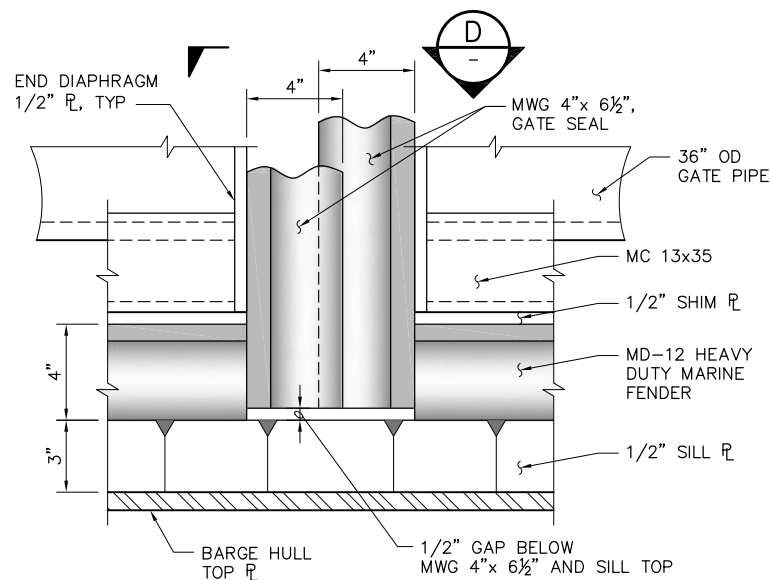


4 DETAIL
C43 SCALE: 3" = 1'-0"

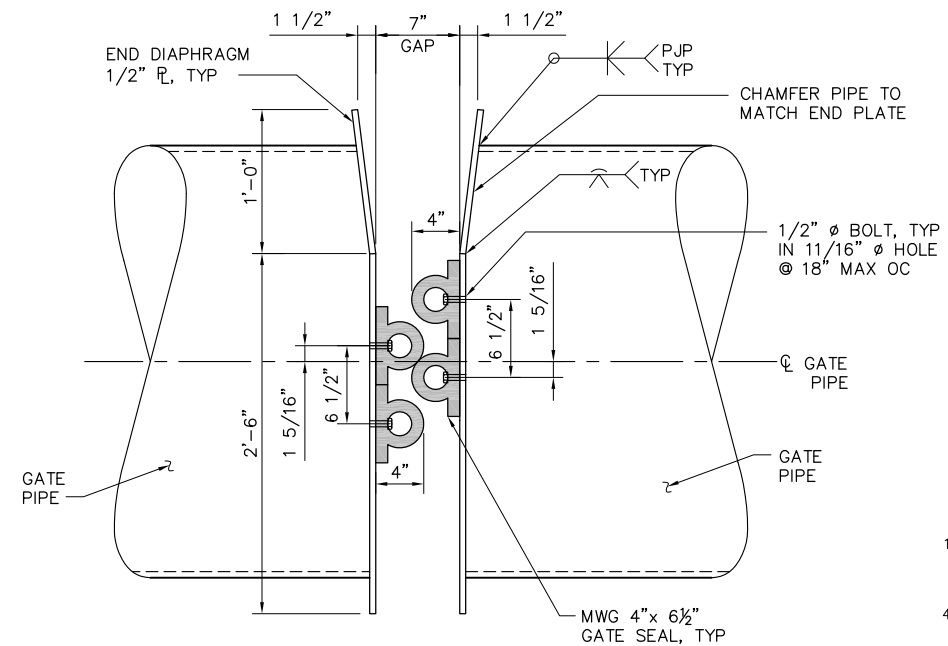

D SECTION
SCALE: 1 1/2" = 1'-0"


NOTE:
CHAMFER CATWALK TOPPING CHECKER PL ABOVE GATE MATING ENDS, TO PERMIT RELATIVE OPENING MOVEMENTS.

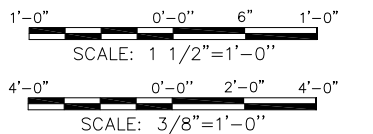

100% SUBMITTAL

IF SHEET IS LESS THAN 22" x 34"
IT IS A REDUCED PRINT -
SCALE REDUCED ACCORDINGLY.


REVISION	DESCRIPTION	BY	DATE

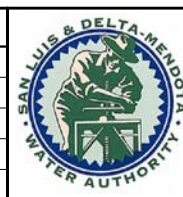

San Luis & Delta-Mendota Water Authority
842 6th Street, Suite 7
PO Box 2157
Los Banos, California 93635

APPROVED
FRANCY C. MIZUNO, PE C35136
San Luis & Delta-Mendota Water Authority

 APPROVED
DENNIS G. MAJORS PE C21297
Metropolitan Water District of Southern California




2001 N. Main Street, Suite 360
Walnut Creek, California 94596
(925) 944-5411


DSGN JMB DR AB CHK TDB
JOB NO. 6097-03 SUBMITTED BY RMR

TWO GATE FISH PROTECTION PLAN	DATE 08/31/09
CONNECTION SLOUGH GATE STRUCTURAL DETAILS, SHEET 1	SHEET 50 OF 78
C46	


P:\6097-03 SWC GATE DESIGN\CADD\DWG\609703-C47.DWG 8/30/2009 8:06 PM

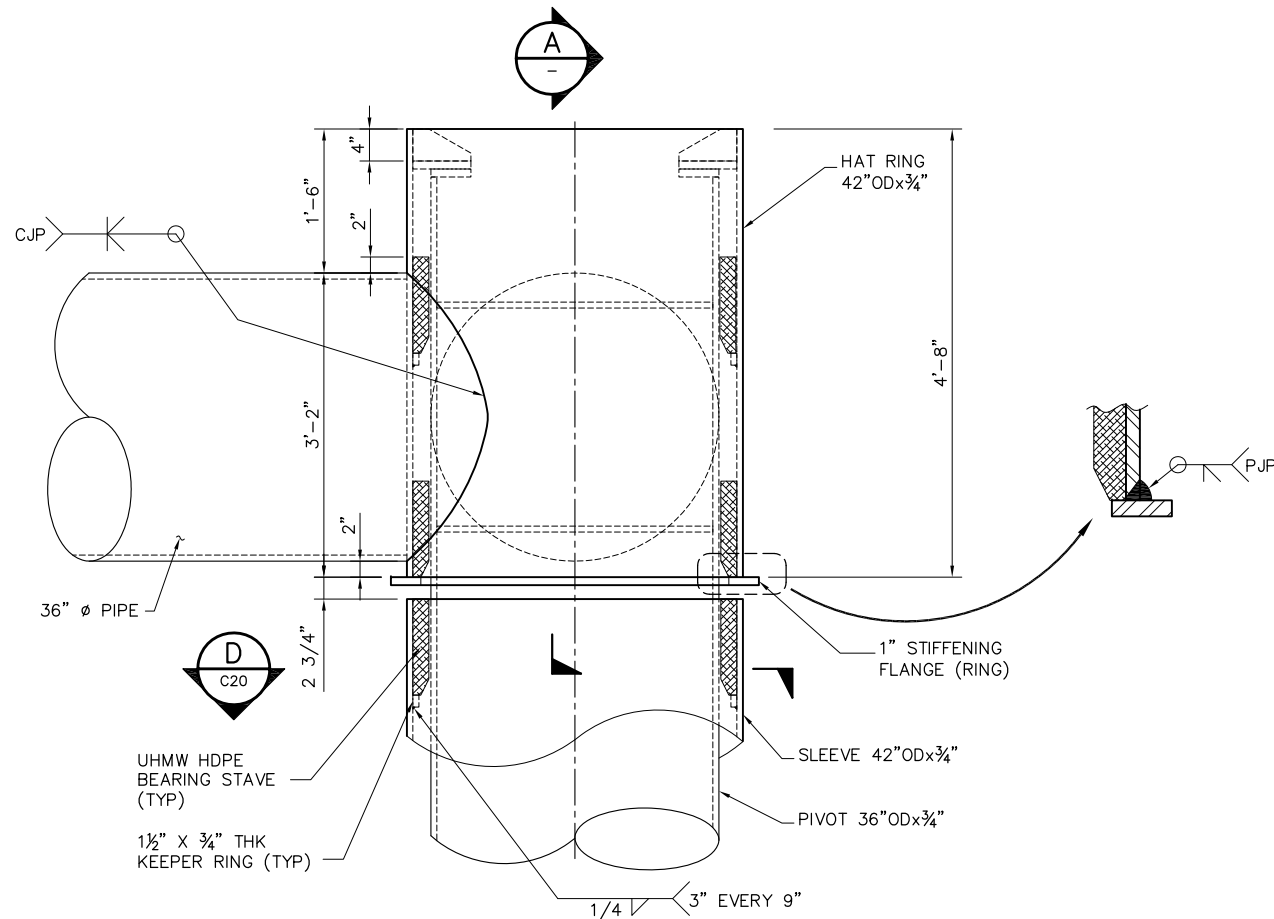

1 TOP PIVOT – FRAME CONNECTION
C44 SCALE: 1" = 1'-0"

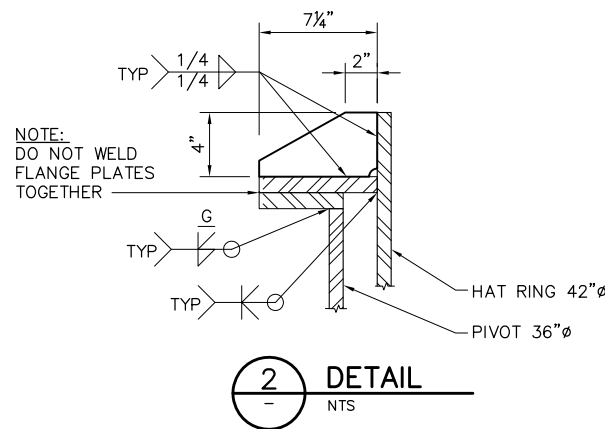

2 DETAIL
NTS

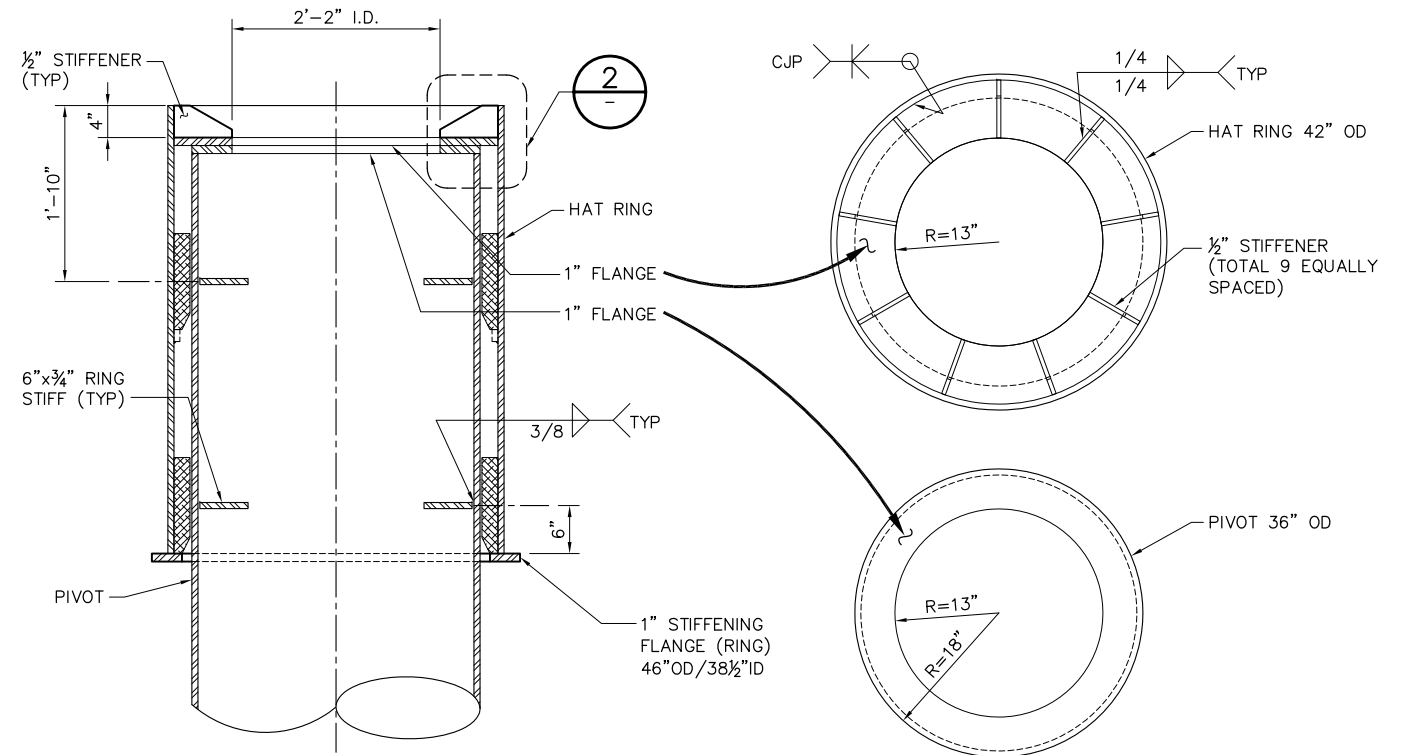

A SECTION
SCALE: 1" = 1'-0"

1'-0" 0'-0" 1'-0" 2'-0"
SCALE: 1"=1'-0"

NOTES:

- ALL STIFFENER WELDS SHALL BE SYMMETRICAL 1/4" MIN. FILLET WELDS U.N.O.

100% SUBMITTAL

IF SHEET IS LESS THAN 22" x 34"
IT IS A REDUCED PRINT –
SCALE REDUCED ACCORDINGLY.

REVISION	DESCRIPTION	BY	DATE



San Luis & Delta-Mendota Water Authority
842 6th Street, Suite 7
PO Box 2157
Los Banos, California 93635








APPROVED _____
FRANCY C. MIZUNO, PE C35136
San Luis & Delta-Mendota Water Authority

APPROVED _____
DENNIS G. MAJORS PE C21297
Metropolitan Water District of Southern California

		2001 N. Main Street, Suite 360 Walnut Creek, California 94596 (925) 944-5411	
DSGN	JMB/CBS	DR	AB/TAE
JOB NO.	6097-03	SUBMITTED BY	RMR


TWO GATE FISH PROTECTION PLAN		DATE 08/31/09
CONNECTION SLOUGH GATE STRUCTURAL DETAILS SHEET 2		SHEET 51 OF 78
		C47

P:\6097-03 SWC GATE DESIGN\CADD\DWG\609703-C48.DWG 8/30/2009 4:22 PM

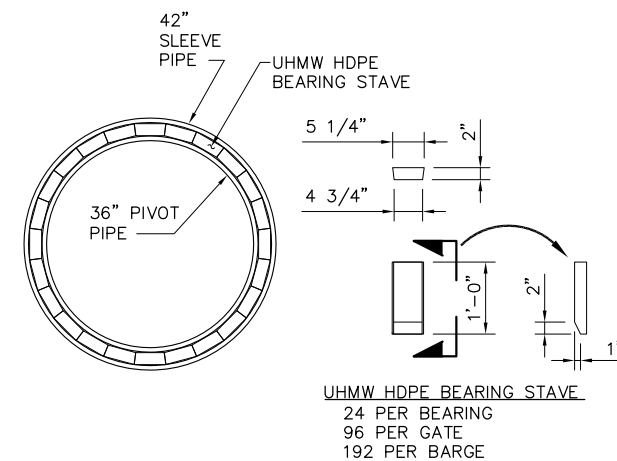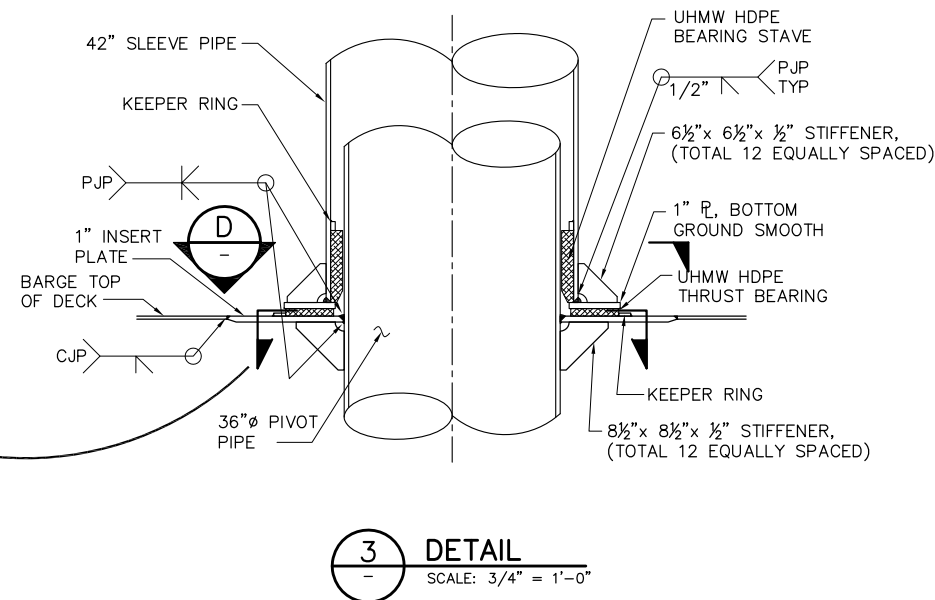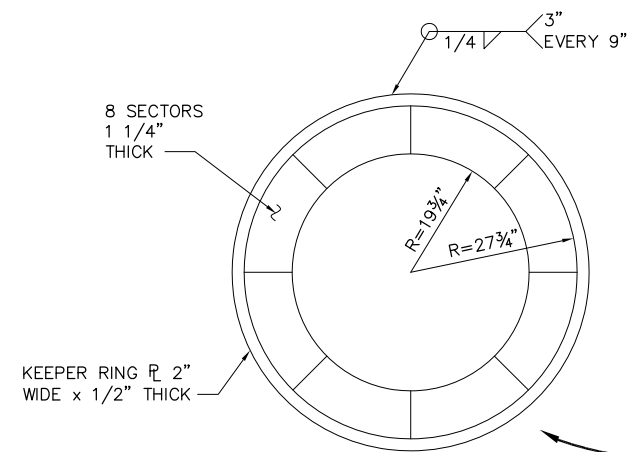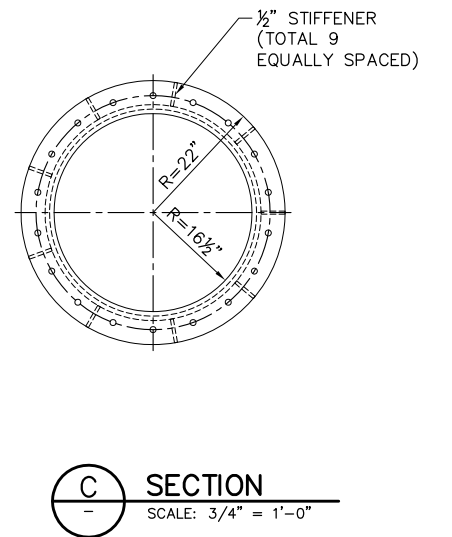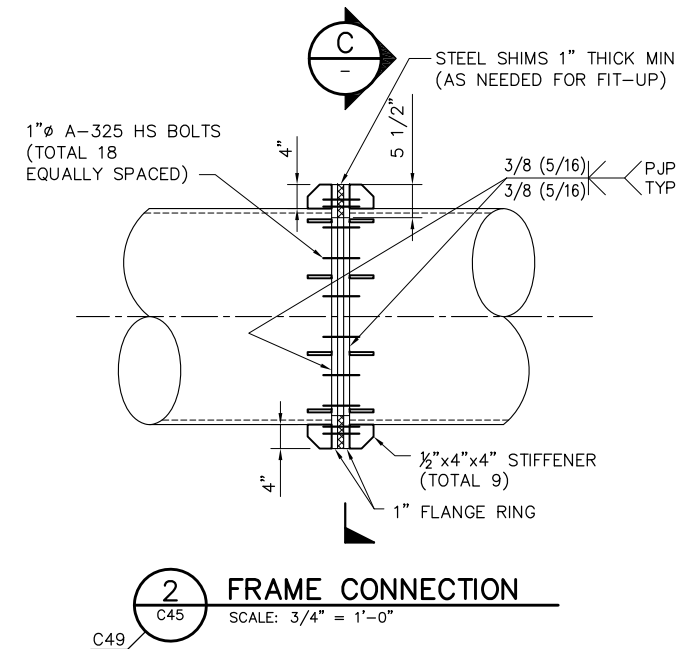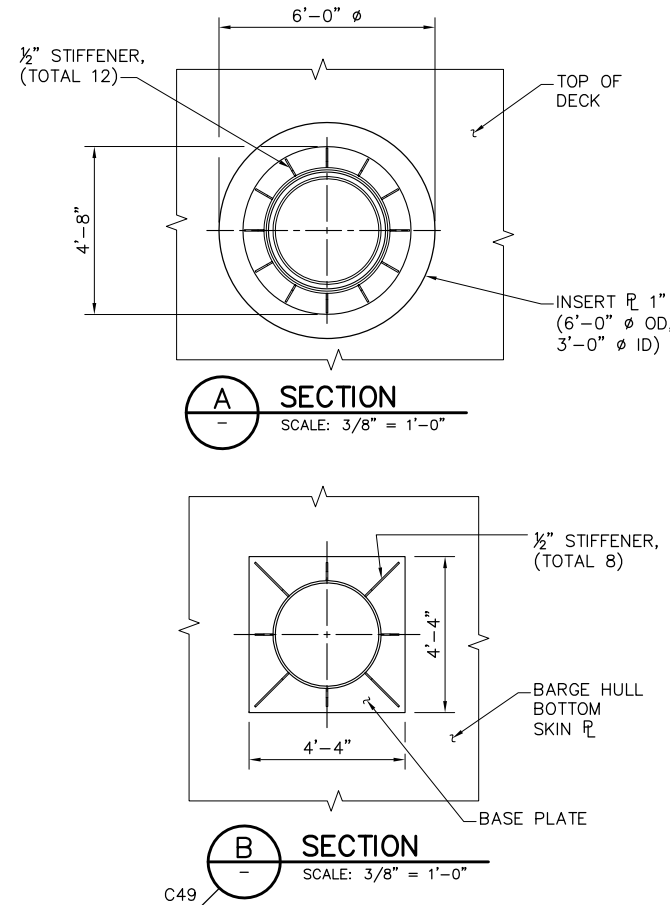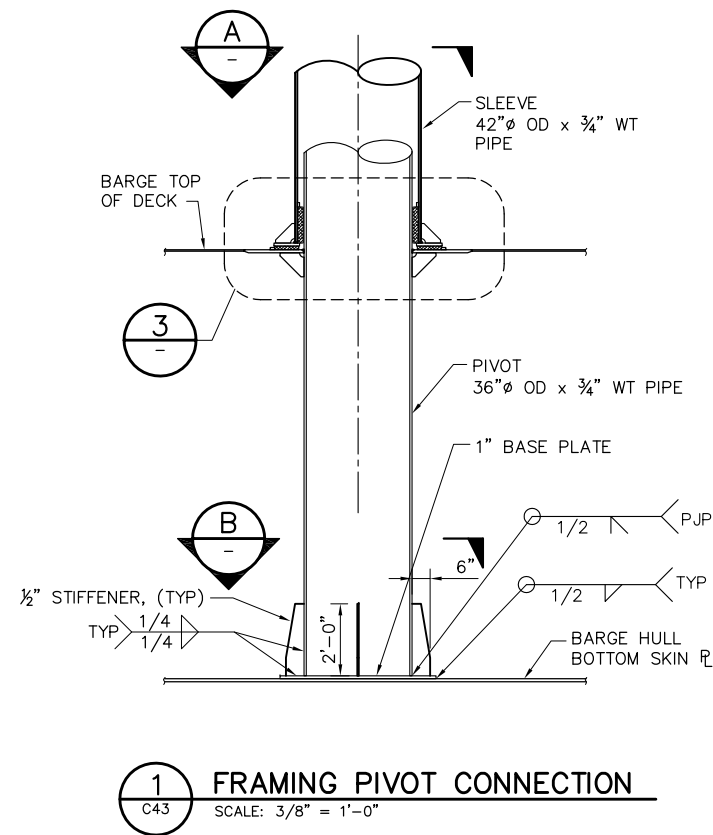

NOTES:


1. ALL STIFFENER WELDS SHALL BE SYMMETRICAL 1/4" MIN. FILLET WELDS U.N.O.

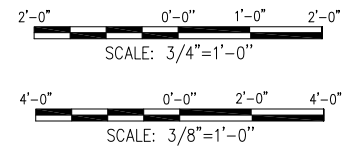

100% SUBMITTAL

IF SHEET IS LESS THAN 22" x 34"
IT IS A REDUCED PRINT -
SCALE REDUCED ACCORDINGLY.

REVISION	DESCRIPTION	BY	DATE

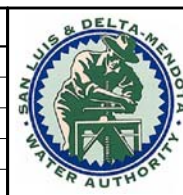

San Luis & Delta-Mendota Water Authority
842 6th Street, Suite 7
PO Box 2157
Los Banos, California 93635


APPROVED _____
FRANCY C. MIZUNO, PE C35136
San Luis & Delta-Mendota Water Authority

APPROVED _____
DENNIS G. MAJORS PE C21297
Metropolitan Water District of Southern California


		2001 N. Main Street, Suite 360 Walnut Creek, California 94596 (925) 944-5411	
DSGN	JMB/CBS	DR	AB
JOB NO.	6097-03	SUBMITTED BY	RMR

TWO GATE FISH PROTECTION PLAN		DATE 08/31/09
CONNECTION SLOUGH GATE STRUCTURAL DETAILS SHEET 3		SHEET 52 OF 78
C48		

P:\6097-03 SVC GATE DESIGN\CADD\DWG\609703-C49.DWG 8/30/2009 8:54 PM

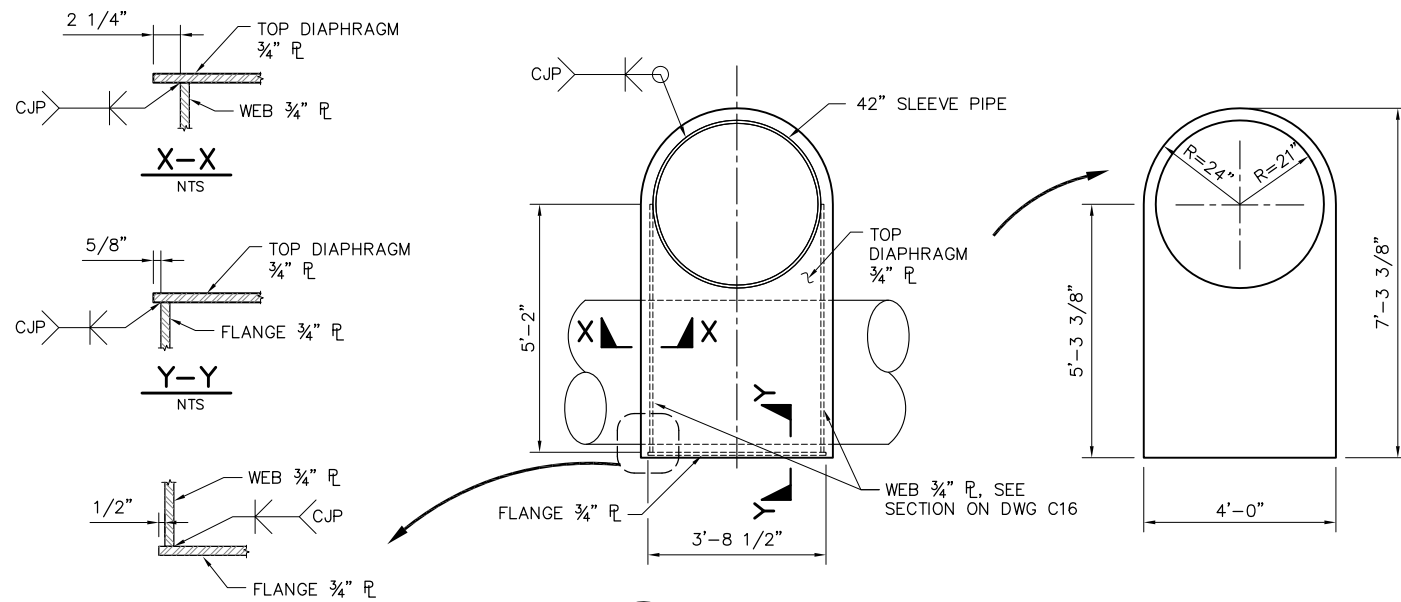


1 SLEEVE CONNECTION DETAIL
SCALE: 1/2" = 1'-0"

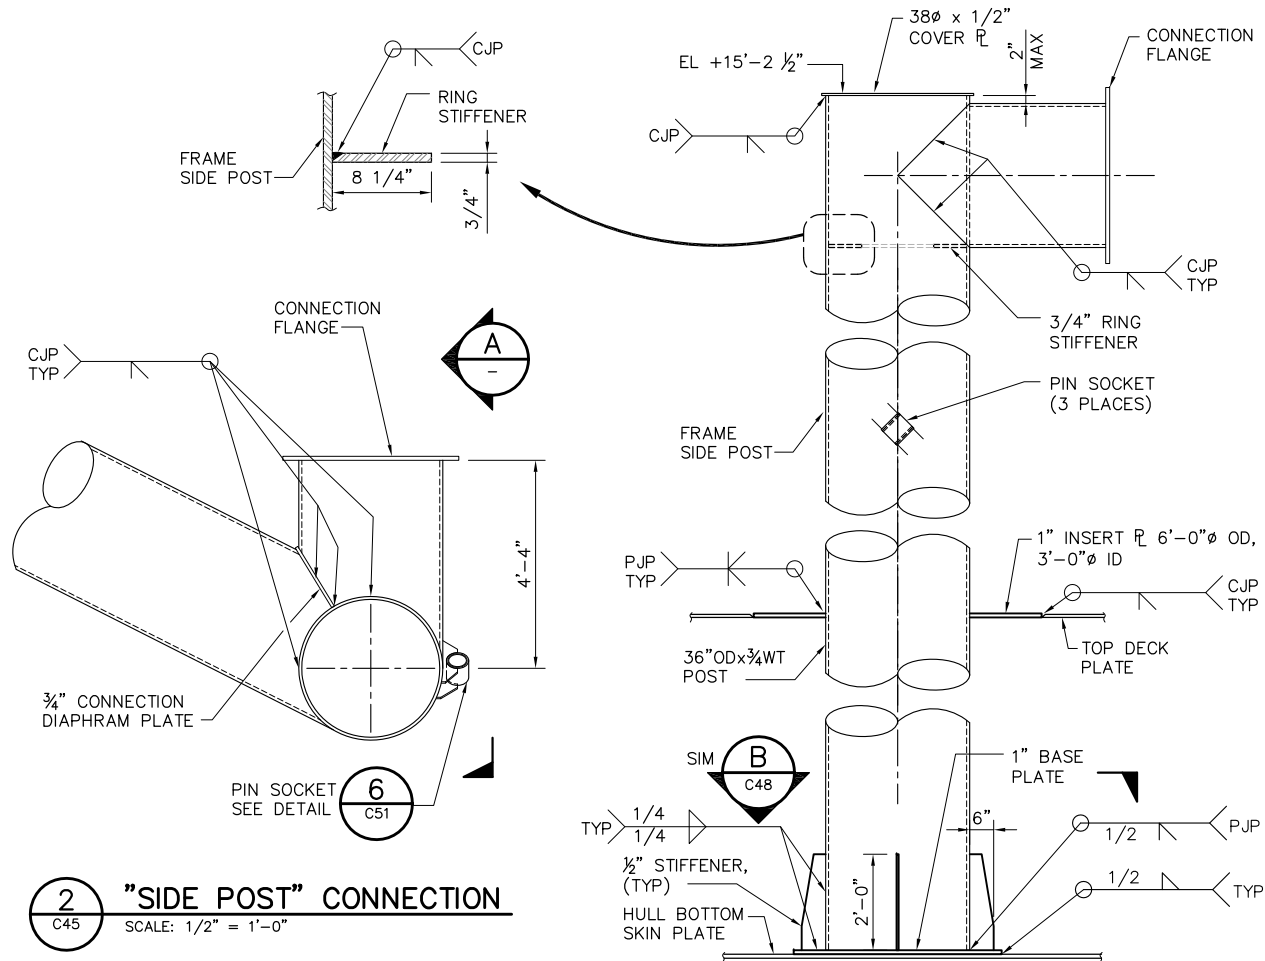


2 "SIDE POST" CONNECTION
SCALE: 1/2" = 1'-0"


A ELEVATION
SCALE: 1/2" = 1'-0"

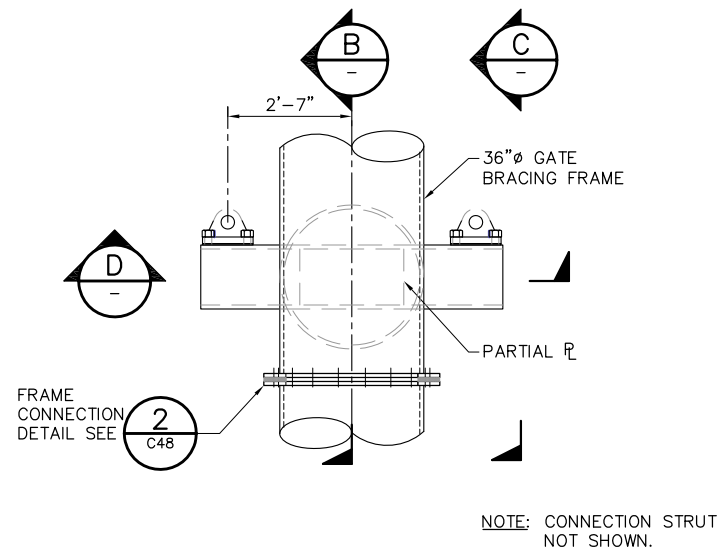


3 PLAN - ACTUATOR CONNECTION DETAIL
SCALE: 1/2" = 1'-0"

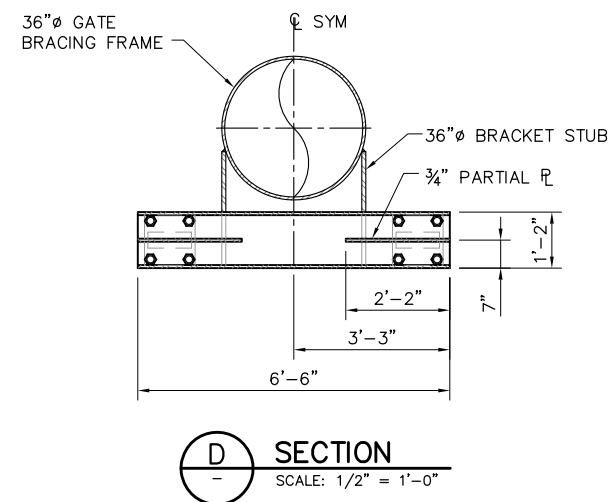


D SECTION
SCALE: 1/2" = 1'-0"

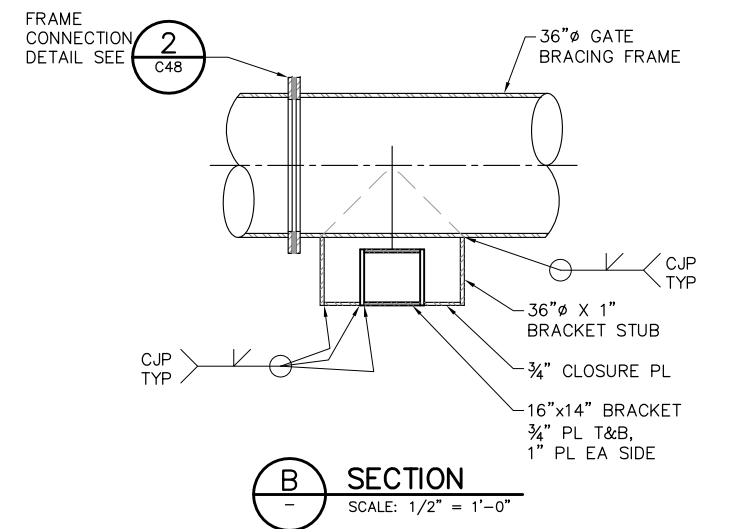

B SECTION
SCALE: 1/2" = 1'-0"

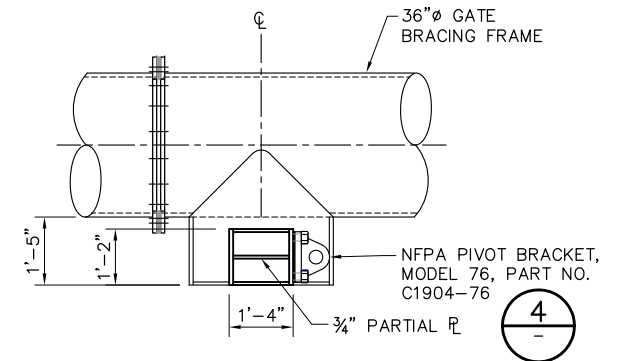

C SECTION
SCALE: 1/2" = 1'-0"

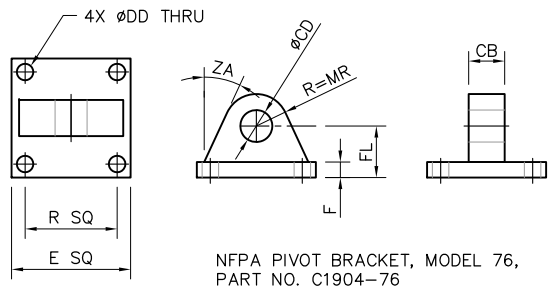

4 DETAIL
SCALE: 1"=1'-0"

CB	CD	DD	E	F	FL	MR	R	ZA
4.000	3.500	1.812	12.625	1.688	5.688	3.500	9.625	25'

100% SUBMITTAL

IF SHEET IS LESS THAN 22" x 34"
IT IS A REDUCED PRINT -
SCALE REDUCED ACCORDINGLY.

REVISION	DESCRIPTION	BY	DATE

San Luis & Delta-Mendota Water Authority
842 6th Street, Suite 7
PO Box 2157
Los Banos, California 93635

APPROVED _____
FRANCY C. MIZUNO, PE C35136
San Luis & Delta-Mendota Water Authority

APPROVED _____
DENNIS G. MAJORS PE C21297
Metropolitan Water District of Southern California


Moffatt & Nichol

2001 N. Main Street, Suite 360
Walnut Creek, California 94596
(925) 944-5411


DSGN JMB DR AB CHK CBS
JOB NO. 6097-03 SUBMITTED BY RMR

TWO GATE FISH PROTECTION PLAN	DATE 08/31/09
CONNECTION SLOUGH GATE STRUCTURAL DETAILS, SHEET 4	SHEET 53 OF 78
C49	


P:\6097-03 SVC GATE DESIGN\CADD\DWG\609703-C50.DWG 8/27/2009 9:25 AM

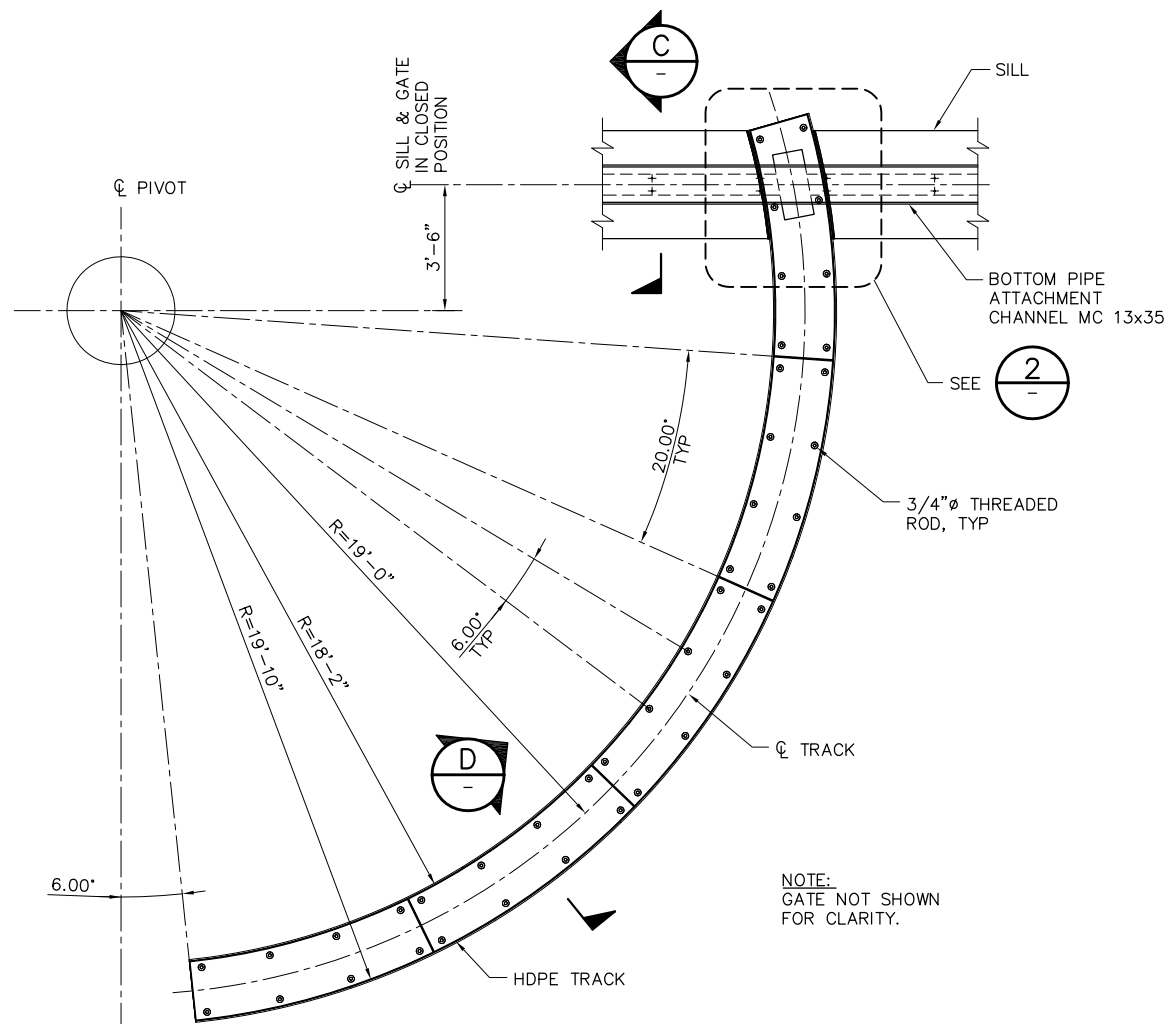


1 TRACK DETAIL
SCALE: 3/8" = 1'-0"

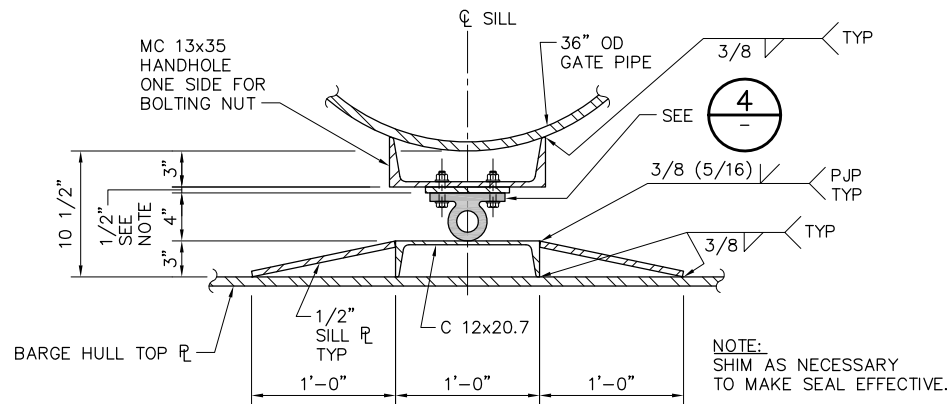


2 SECTION
SCALE: 1 1/2" = 1'-0"

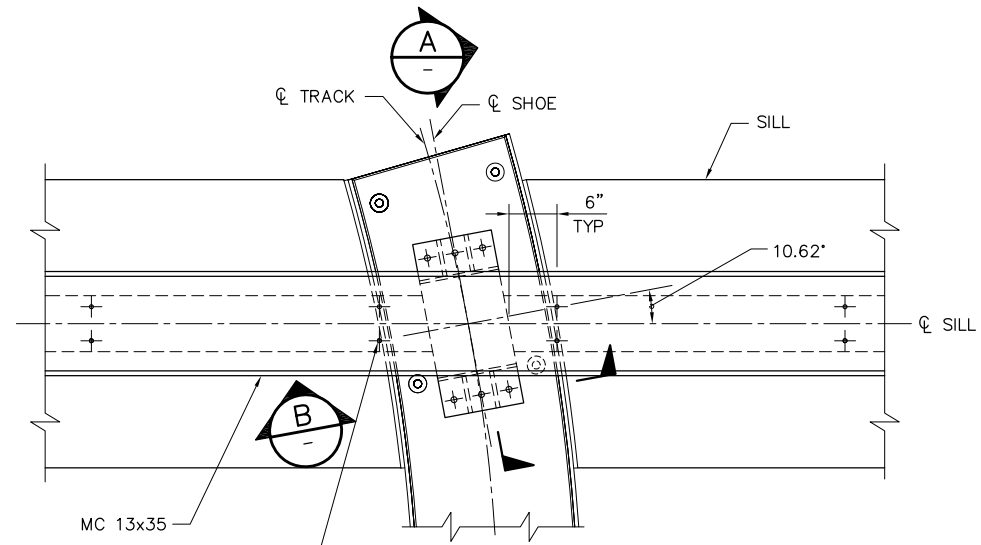


3 DETAIL
SCALE: 1" = 1'-0"

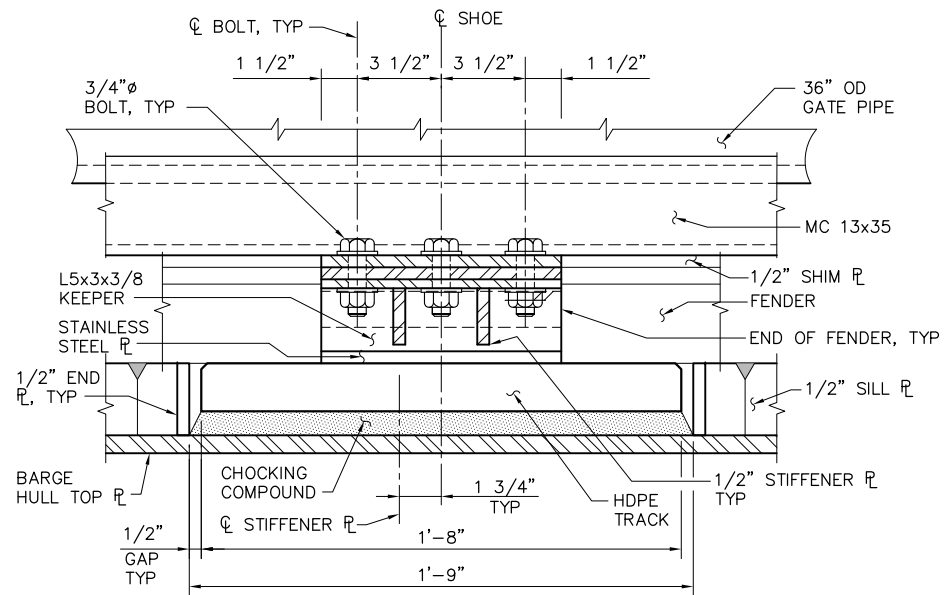


4 SECTION
SCALE: 3" = 1'-0"

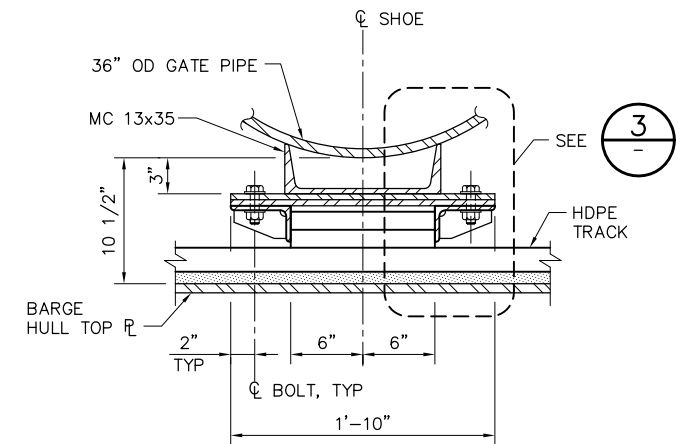


5 SECTION
SCALE: 1 1/2" = 1'-0"

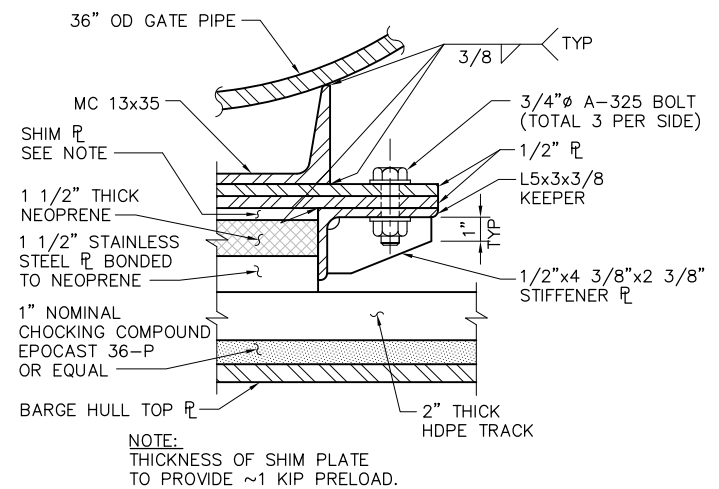


6 DETAIL
SCALE: 3" = 1'-0"

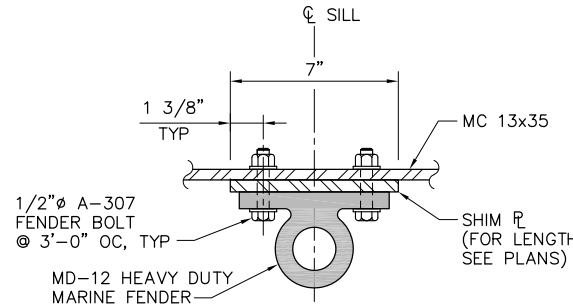

7 DETAIL
SCALE: 3" = 1'-0"

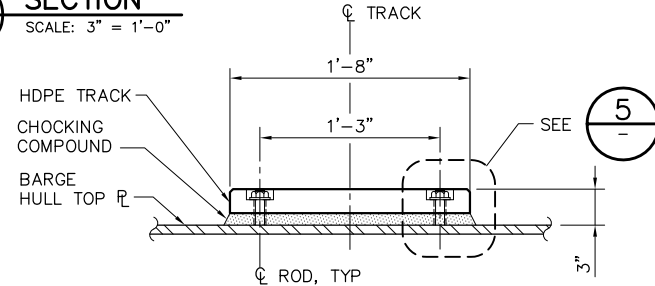

8 SECTION
SCALE: 1 1/2" = 1'-0"

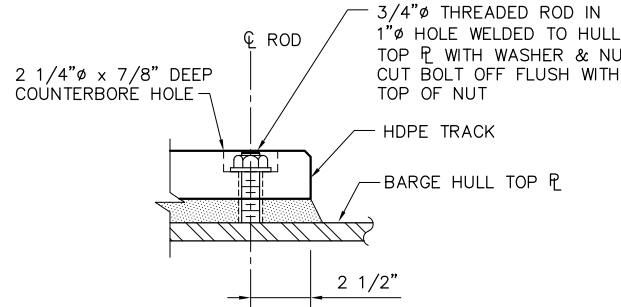

9 DETAIL
SCALE: 3" = 1'-0"

4'-0" 0'-0" 2'-0" 4'-0"
SCALE: 3/8"=1'-0"

100% SUBMITTAL IF SHEET IS LESS THAN 22" x 34" IT IS A REDUCED PRINT - SCALE REDUCED ACCORDINGLY.

REVISION	DESCRIPTION	BY	DATE



San Luis & Delta-Mendota Water Authority
842 6th Street, Suite 7
PO Box 2157
Los Banos, California 93635

APPROVED
FRANCY C. MIZUNO, PE C35136
San Luis & Delta-Mendota Water Authority

APPROVED
DENNIS G. MAJORS PE C21297
Metropolitan Water District of Southern California

Moffatt & Nichol
2001 N. Main Street, Suite 360
Walnut Creek, California 94596
(925) 944-5411


DSGN JMB DR EP/AB CHK CBS
JOB NO. 6097-03 SUBMITTED BY RMR

TWO GATE FISH PROTECTION PLAN


CONNECTION SLOUGH
GATE STRUCTURAL DETAILS,
SHEET 5

DATE 08/31/09
SHEET 54 OF 78
C50


P:\6097-03 SWC GATE DESIGN\CADD\DWG\609703-C51.DWG 8/27/2009 9:26 AM

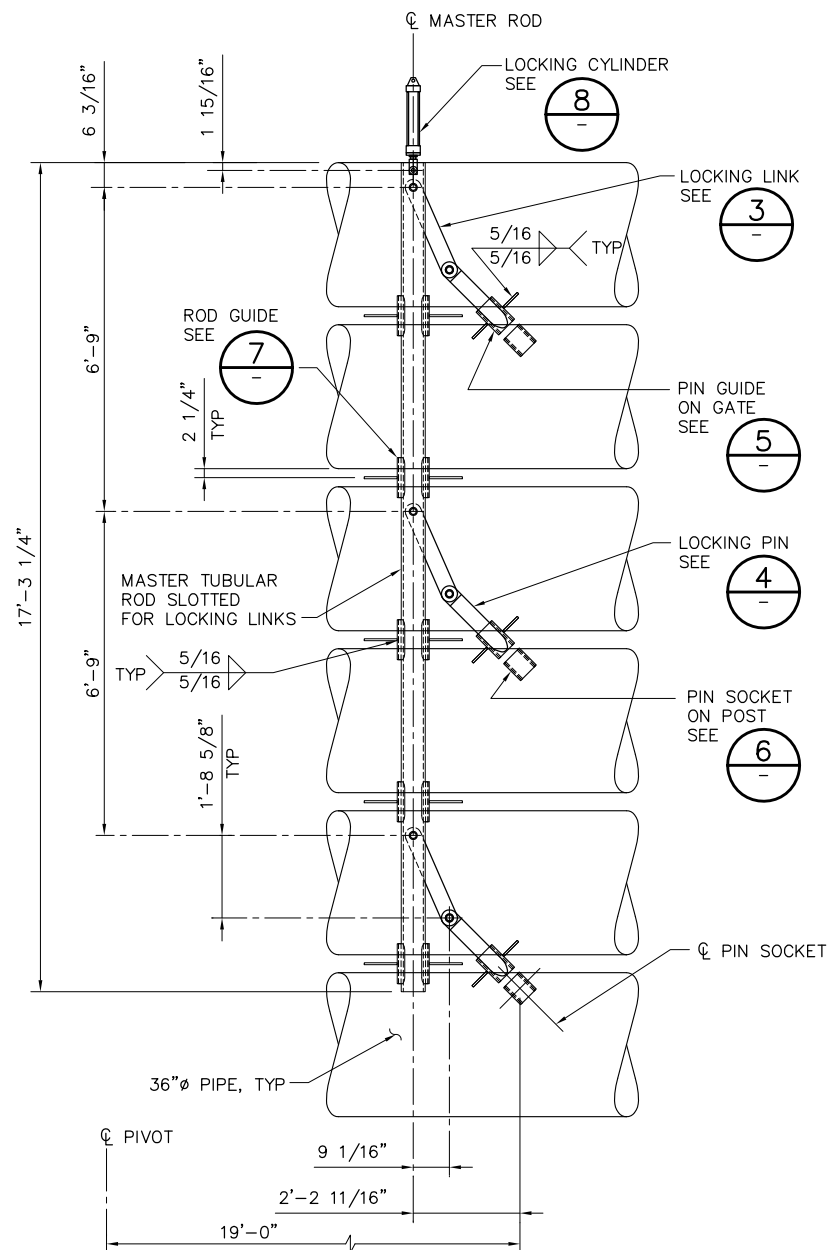


1 GATE OPEN LOCK (UNLOCKED) DETAIL
C43 SCALE: 1/2" = 1'-0"

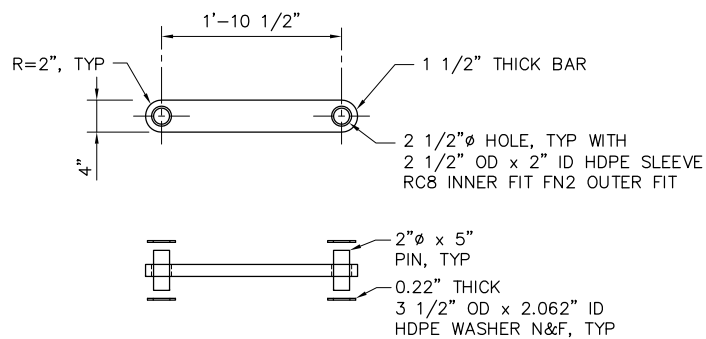


3 LOCKING LINK DETAIL
SCALE: 1" = 1'-0"

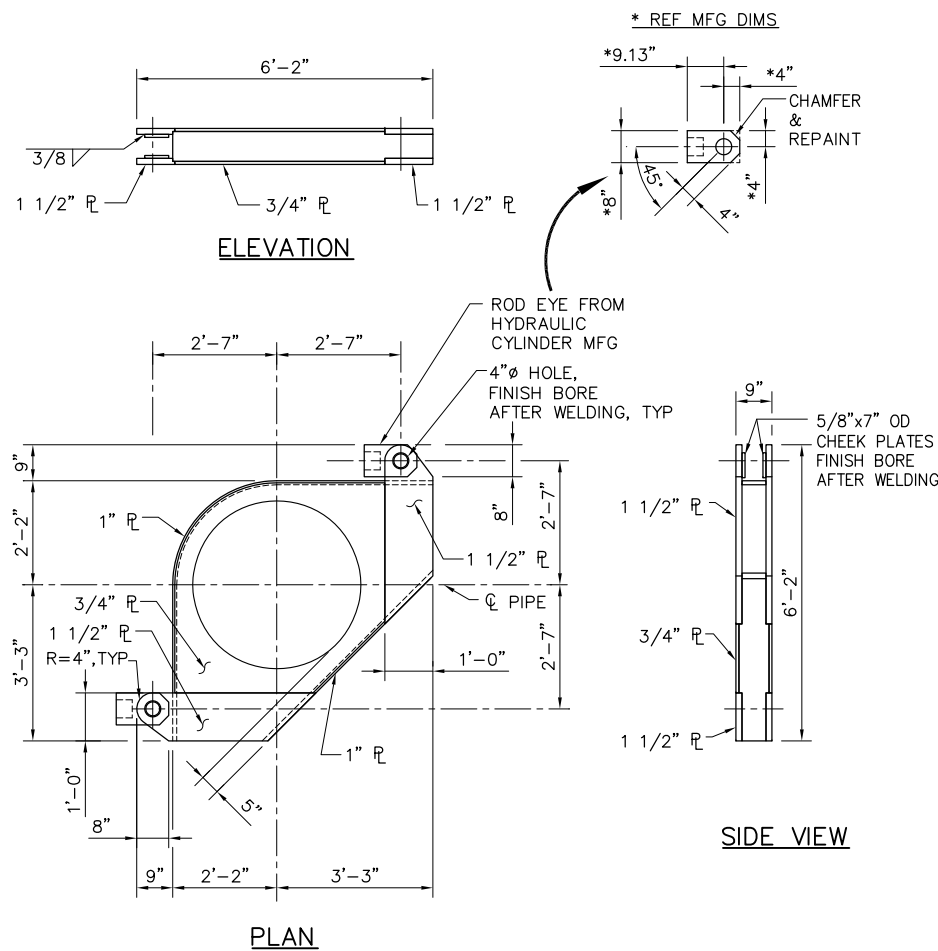


2 GATE YOKE DETAIL
C44 SCALE: 1/2" = 1'-0"

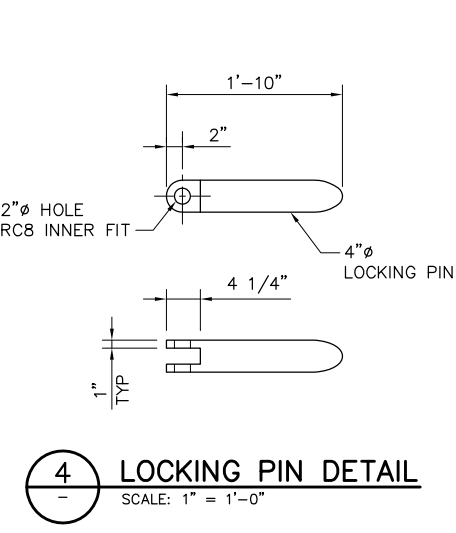


4 LOCKING PIN DETAIL
SCALE: 1" = 1'-0"

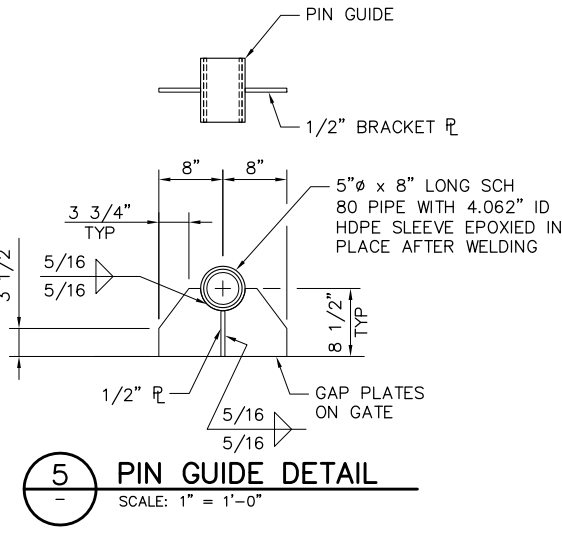


5 PIN GUIDE DETAIL
SCALE: 1" = 1'-0"

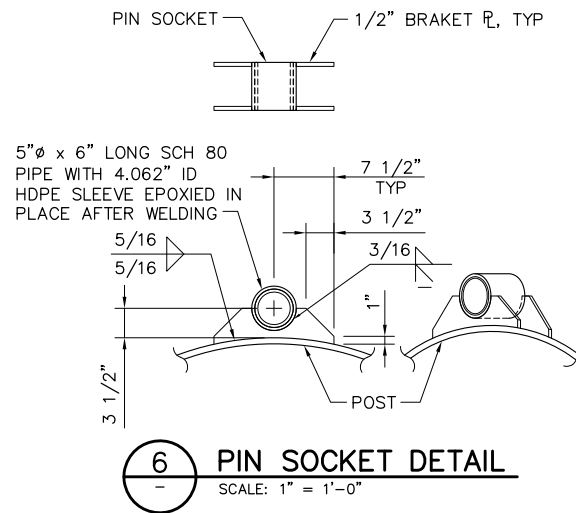


6 PIN SOCKET DETAIL
SCALE: 1" = 1'-0"

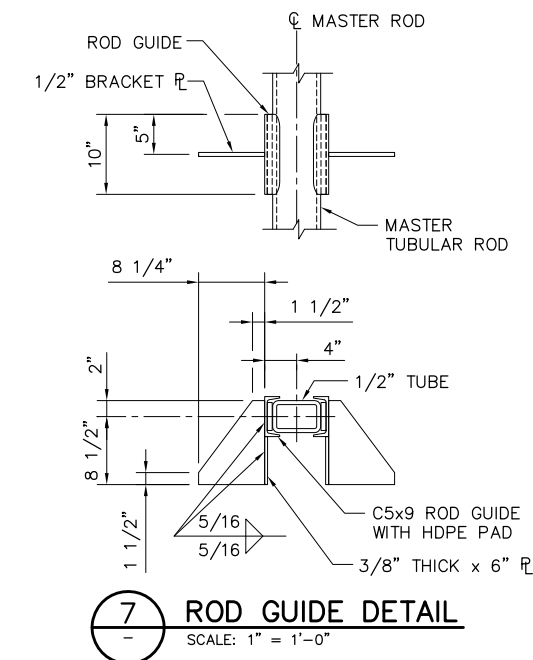

7 ROD GUIDE DETAIL
SCALE: 1" = 1'-0"

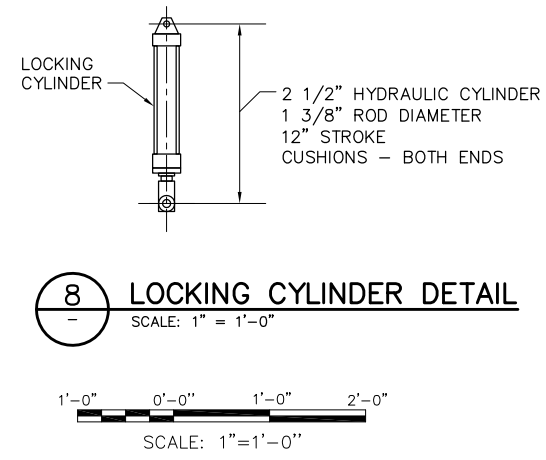

8 LOCKING CYLINDER DETAIL
SCALE: 1" = 1'-0"

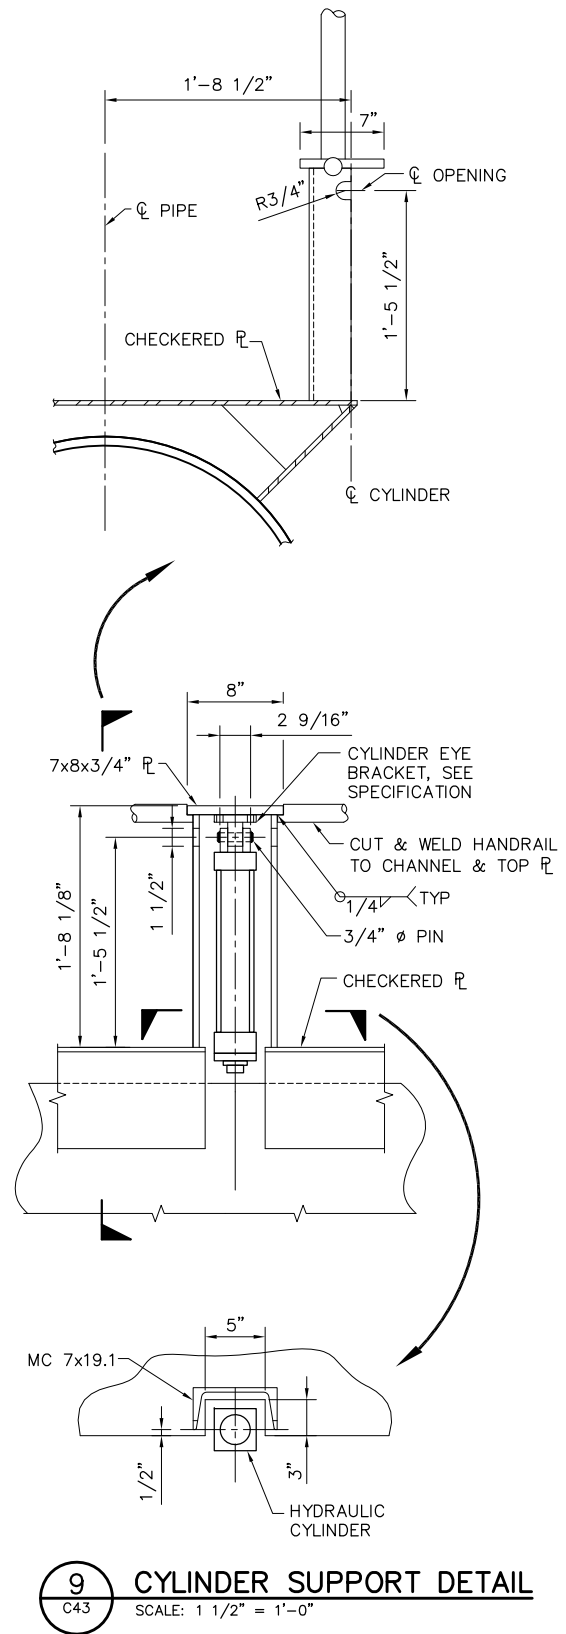

9 CYLINDER SUPPORT DETAIL
C43 SCALE: 1 1/2" = 1'-0"

100% SUBMITTAL IF SHEET IS LESS THAN 22" x 34" IT IS A REDUCED PRINT - SCALE REDUCED ACCORDINGLY.

REVISION	DESCRIPTION	BY	DATE



San Luis & Delta-Mendota Water Authority
842 6th Street, Suite 7
PO Box 2157
Los Banos, California 93635

APPROVED
FRANCY C. MIZUNO, PE C35136
San Luis & Delta-Mendota Water Authority

APPROVED
DENNIS G. MAJORS PE C21297
Metropolitan Water District of Southern California




2001 N. Main Street, Suite 360
Walnut Creek, California 94596
(925) 944-5411

DSGN CBS DR CBS/EP CHK TDB
JOB NO. 6097-03 SUBMITTED BY RMR

TWO GATE FISH PROTECTION PLAN	DATE 08/31/09
CONNECTION SLOUGH GATE MECHANICAL DETAILS SHEET 1	SHEET 55 OF 78
	C51


C52

P:\6097-03 SWC GATE DESIGN\CADD\DWG\609703-C53.DWG 8/28/2009 4:35 PM

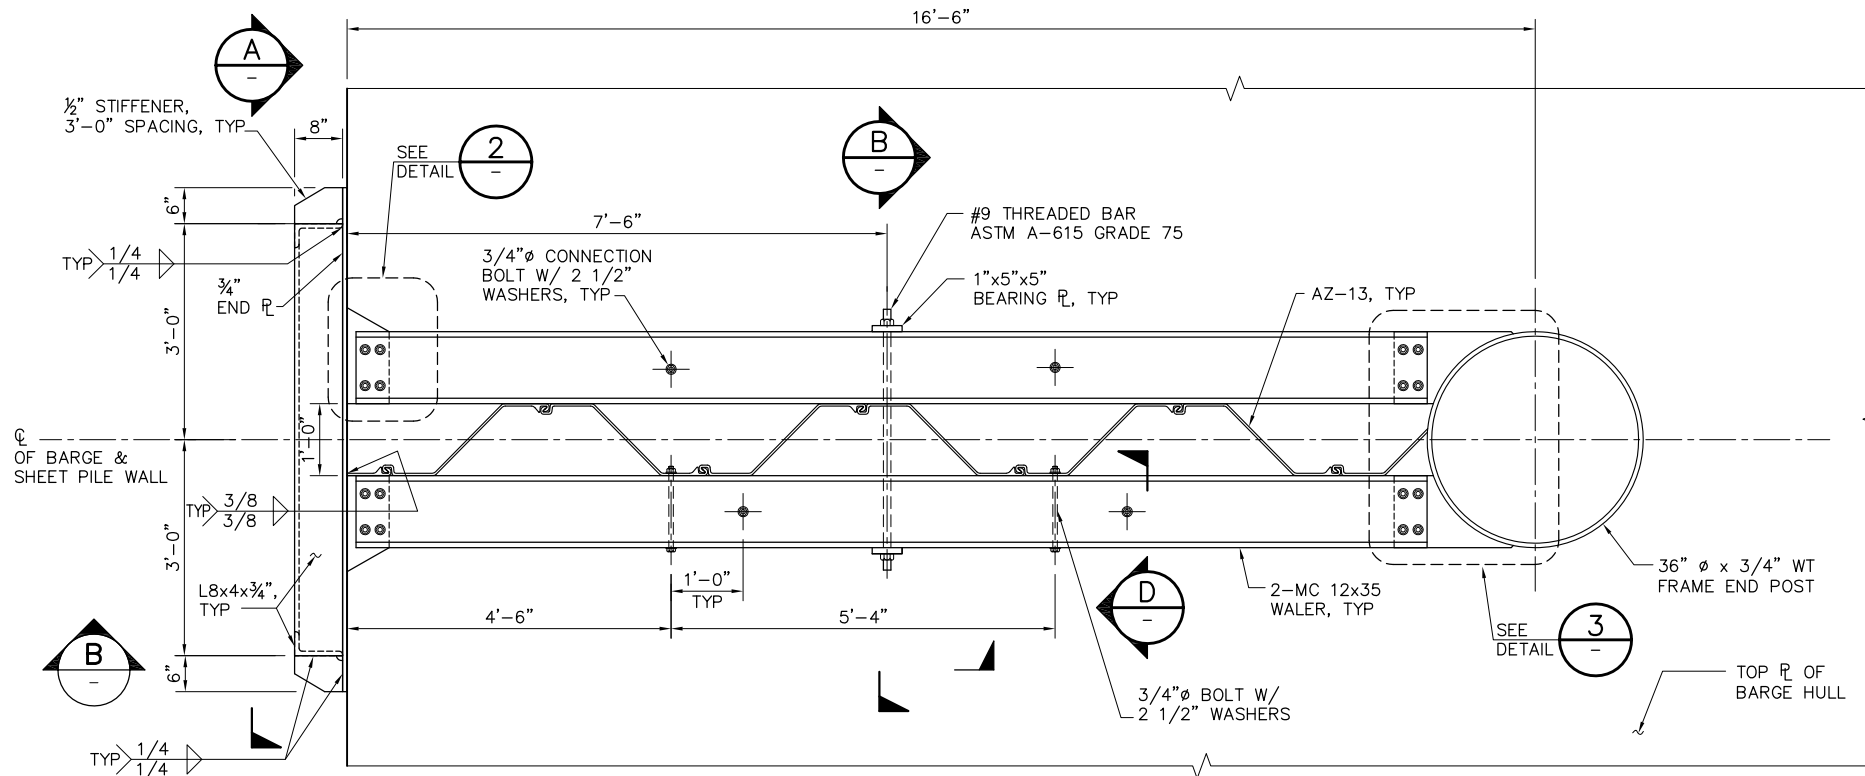


PLAN


1 DETAIL
SCALE: 3/4" = 1'-0"

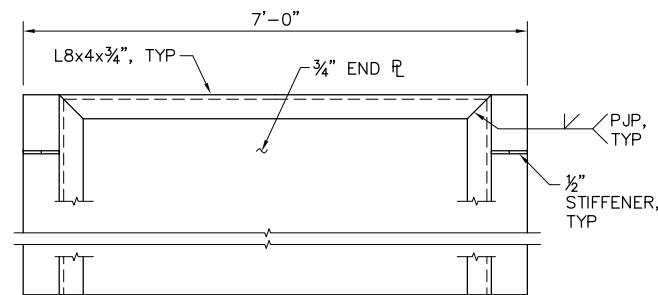


A SECTION
SCALE: 3/4" = 1'-0"

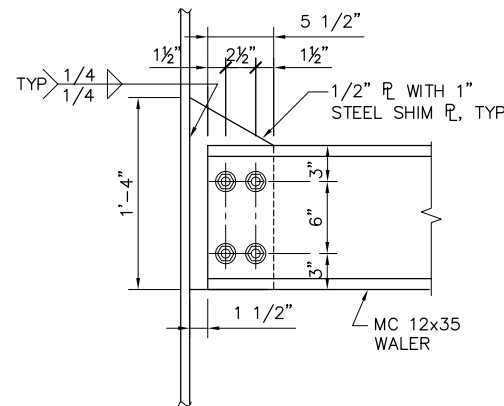

2 DETAIL
SCALE: 1 1/2" = 1'-0"


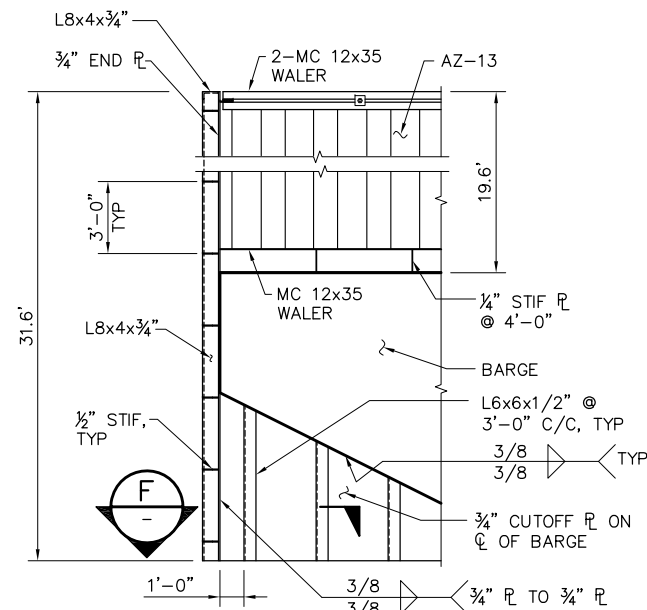


B SECTION
SCALE: 1/4" = 1'-0"

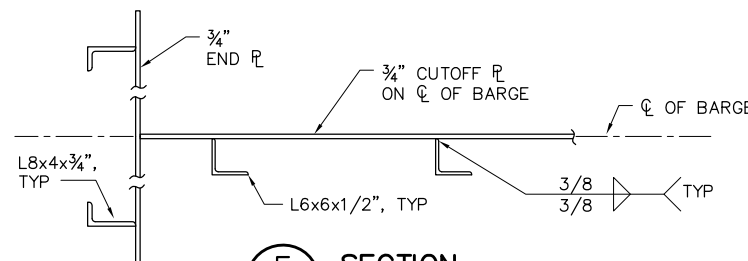


C SECTION
SCALE: 3/4" = 1'-0"


F SECTION
SCALE: 3/4" = 1'-0"

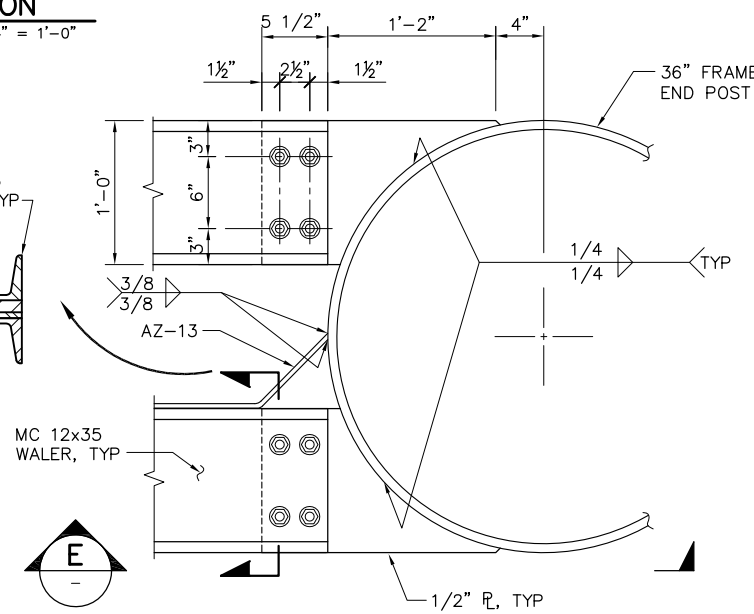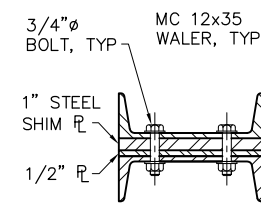


3 DETAIL
SCALE: 1 1/2" = 1'-0"

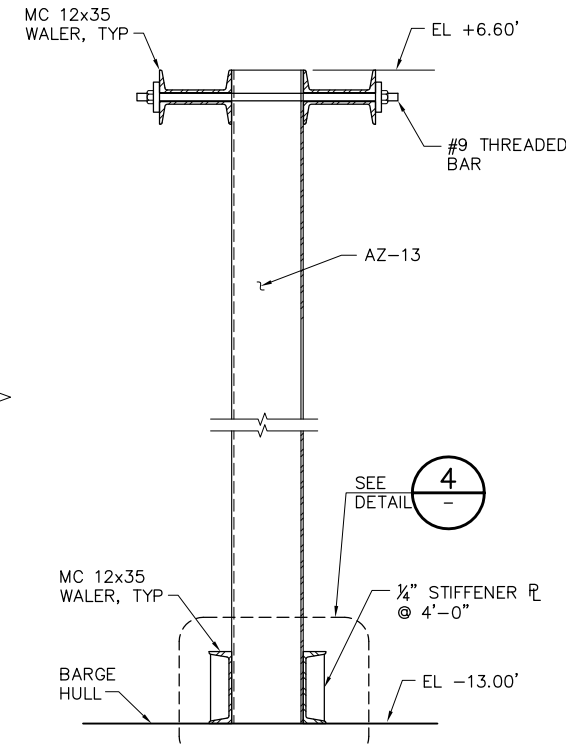


D SECTION
SCALE: 1 1/2" = 1'-0"

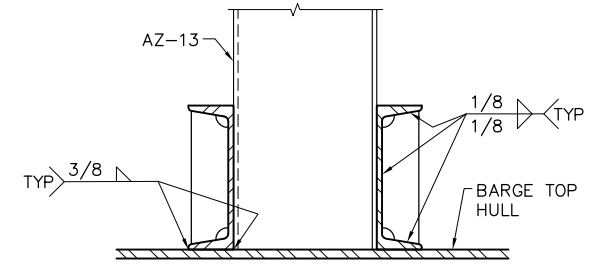

4 DETAIL
SCALE: 1 1/2" = 1'-0"

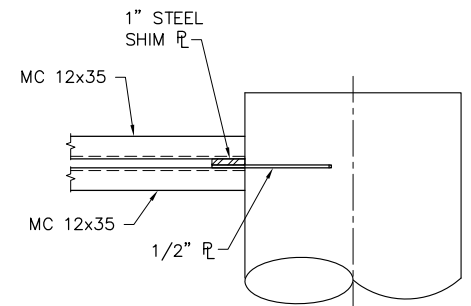

E SECTION
SCALE: 3/4" = 1'-0"

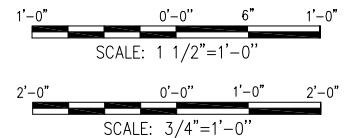

NOTE:
ALL BOLTS ARE ASTM A-307 U.O.N.

100% SUBMITTAL IF SHEET IS LESS THAN 22" x 34" IT IS A REDUCED PRINT - SCALE REDUCED ACCORDINGLY.

REVISION	DESCRIPTION	BY	DATE



San Luis & Delta-Mendota Water Authority
842 6th Street, Suite 7
PO Box 2157
Los Banos, California 93635

APPROVED
FRANCY C. MIZUNO, PE C35136
San Luis & Delta-Mendota Water Authority

APPROVED
DENNIS G. MAJORS PE C21297
Metropolitan Water District of Southern California




2001 N. Main Street, Suite 360
Walnut Creek, California 94596
(925) 944-5411


DSGN JMB DR AB CHK TDB
JOB NO. 6097-03 SUBMITTED BY RMR

TWO GATE FISH PROTECTION PLAN	DATE 08/31/09
CONNECTION SLOUGH END WALL SCANTLINGS	SHEET 57 OF 78
C53	

P:\6097-03 SWC GATE DESIGN\CADD\DWG\609703-C54.DWG 8/31/2009 11:09 AM

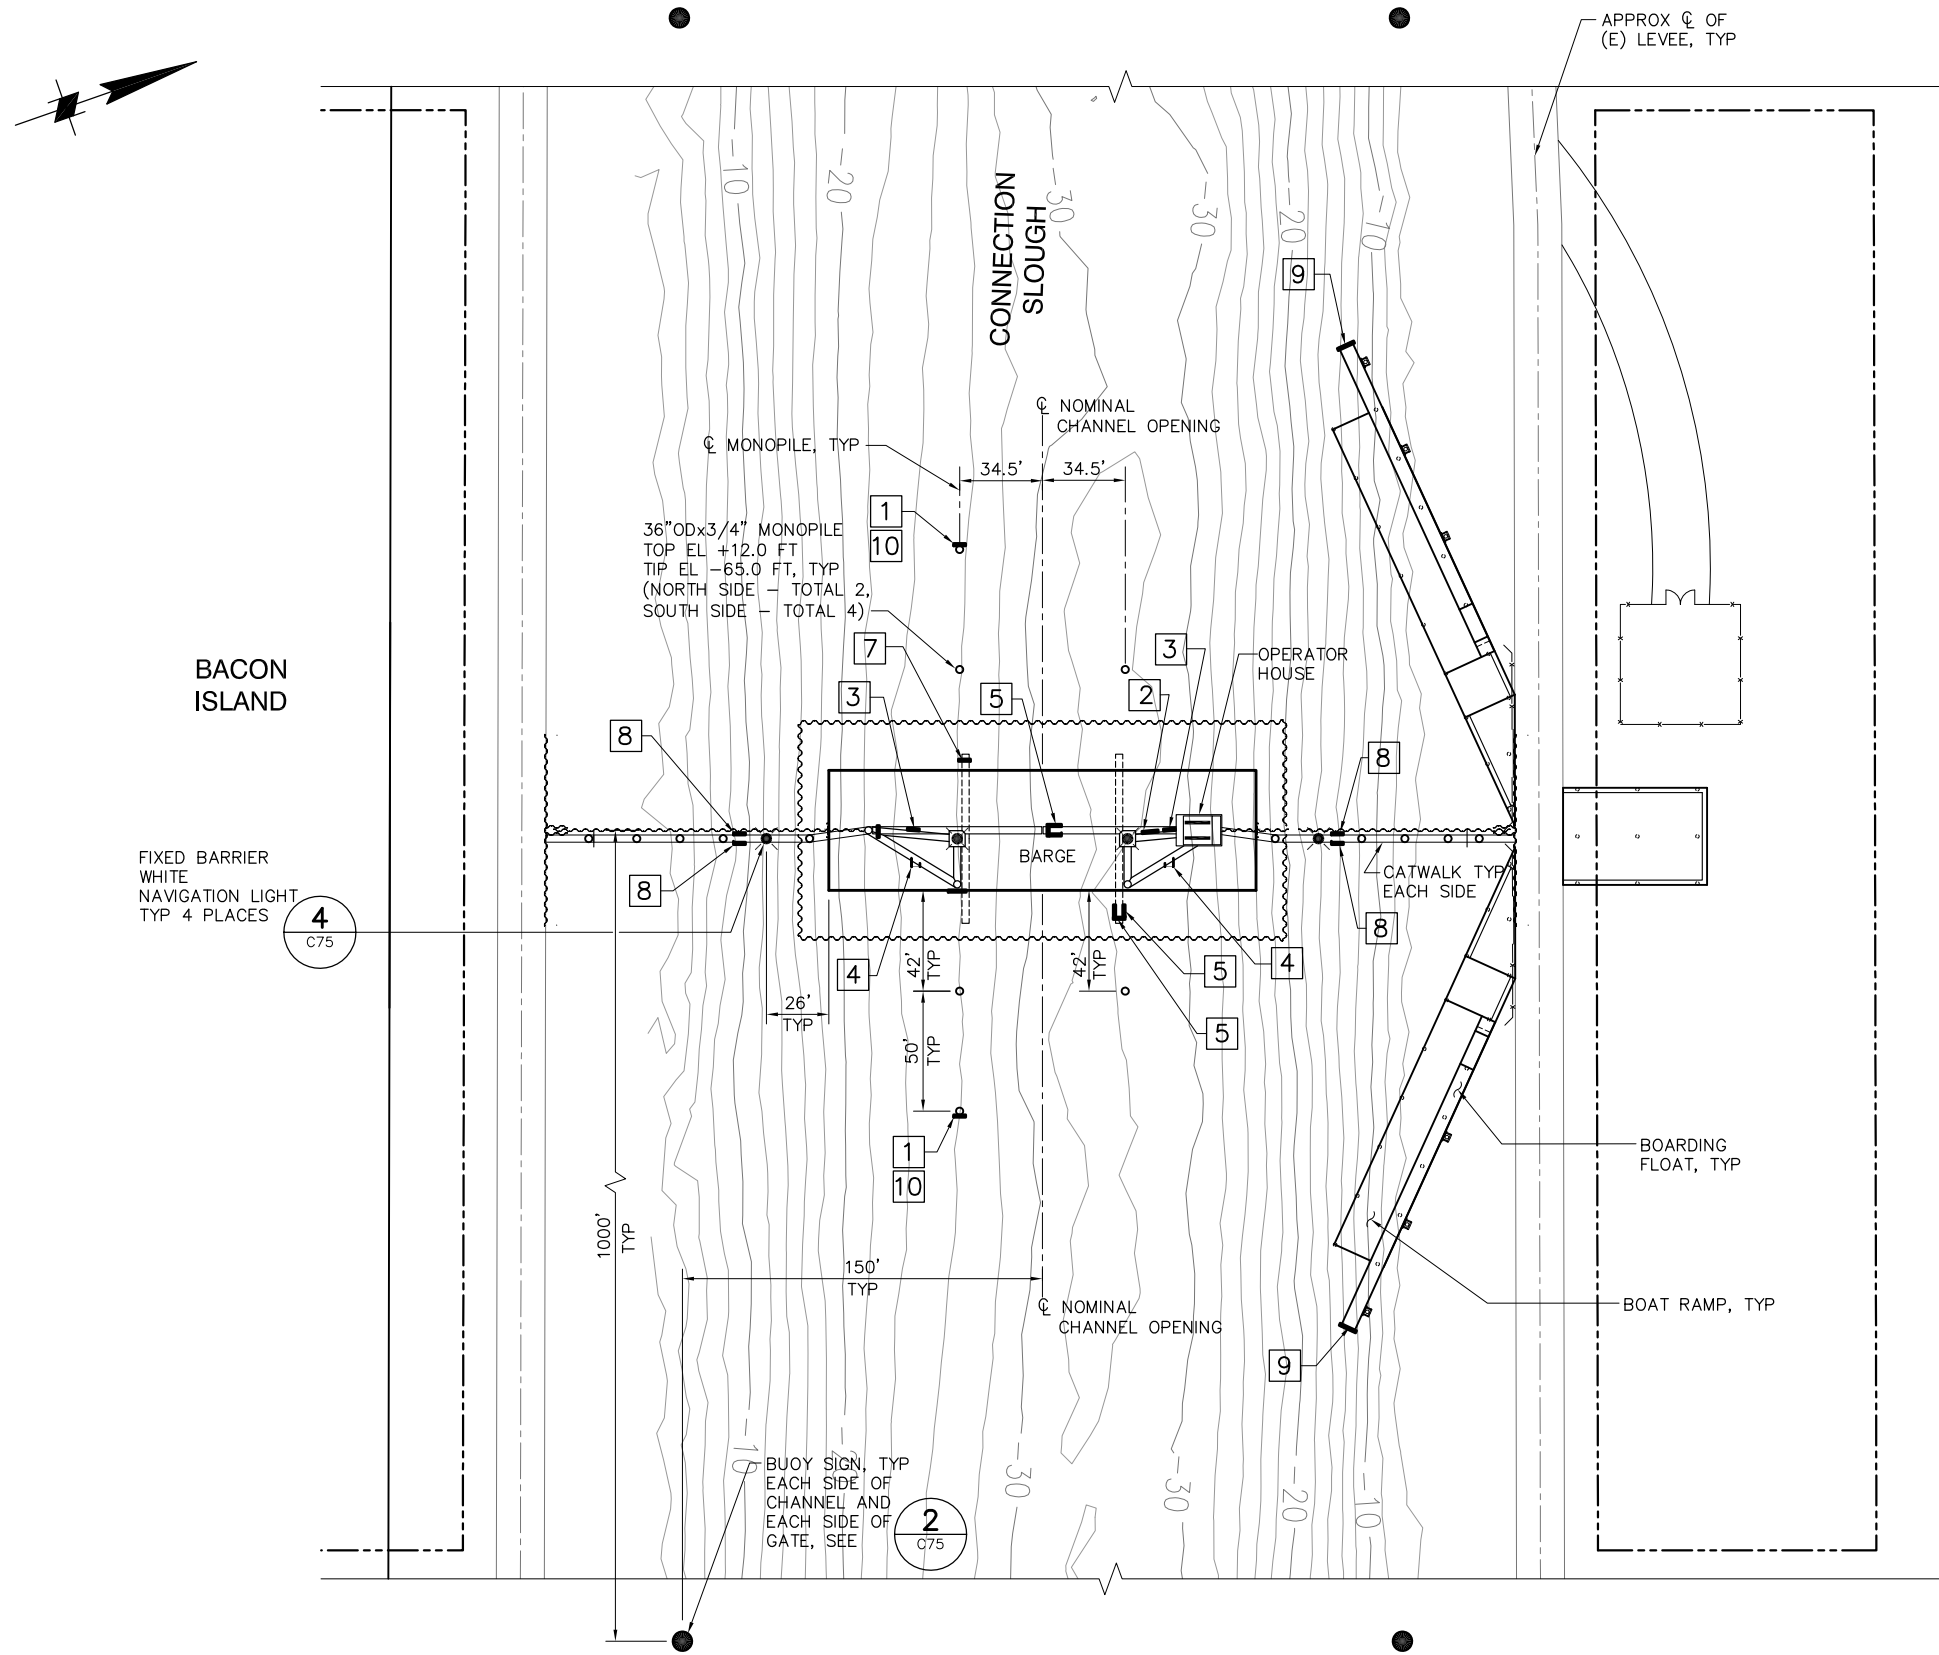

PLAN
SCALE: 1"= 40'

 

SIGN DATA

LOCATION	SIGN	SIGN DETAIL	SIGN MOUNTING DETAIL
1	GATE 5 MPH	1 C75	1 C76
2	GATE WARNING SIGN	5 C75	5 C76
3	DANGER SIGN	7 C75	5 C76
4	DANGER SIGN	7 C75	3 C76
5	GATE POSITION SIGNS "GATES OPEN" "GATES CLOSED"	6 C75	2 C74
6	GATE WARNING SIGN	5 C75	2 C76
7	GATE POSITION SIGN "GATES OPEN"	6 C75	4 C76
8	STAY BACK WARNING SIGN	9 C75	5 C76
9	BOAT RAMP DOCK SIGN	3 C75	6 C76
10	GATE OPENING SIGN	10 C75	1 C76

100% SUBMITTAL

IF SHEET IS LESS THAN 22" x 34"
IT IS A REDUCED PRINT -
SCALE REDUCED ACCORDINGLY.

REVISION	DESCRIPTION	BY	DATE



San Luis & Delta-Mendota Water Authority
842 6th Street, Suite 7
PO Box 2157
Los Banos, California 93635

APPROVED _____
FRANCY C. MIZUNO, PE C35136
San Luis & Delta-Mendota Water Authority

APPROVED _____
DENNIS G. MAJORS PE C21297
Metropolitan Water District of Southern California




2001 N. Main Street, Suite 360
Walnut Creek, California 94596
(925) 944-5411


DSGN	RBD	DR	AB	CHK	TDB
JOB NO. 6097-03		SUBMITTED BY RMR			

TWO GATE FISH PROTECTION PLAN CONNECTION SLOUGH AIDS TO NAVIGATION PLAN	DATE 08/31/09 SHEET 58 OF 78
	C54


P:\6097-03 SWC GATE DESIGN\CADD\DWG\609703-C64.DWG 8/28/2009 4:34 PM

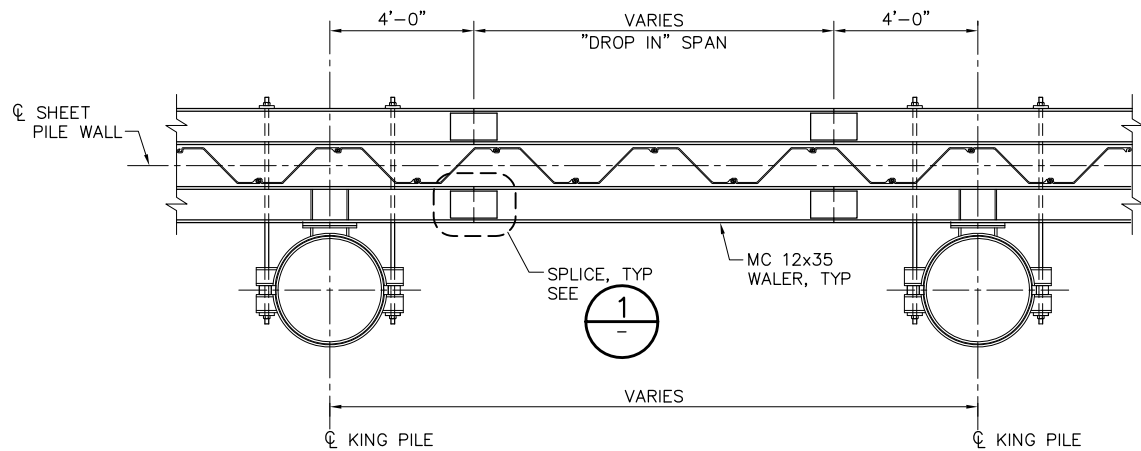


PLAN
TYPICAL WALER SPLICE DETAIL (SEE NOTE 1)
SCALE: 3/4" = 1'-0"

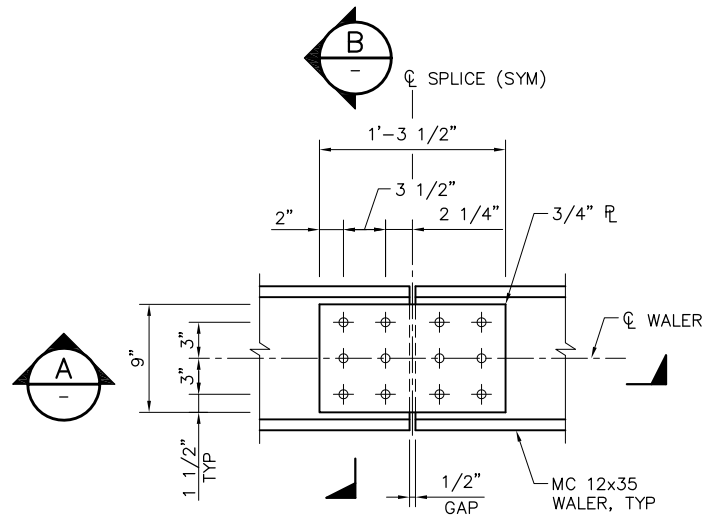


PLAN
1 DETAIL
SCALE: 1 1/2" = 1'-0"

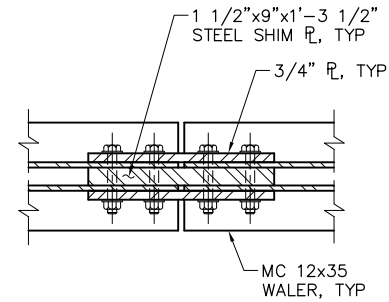


A SECTION
SCALE: 1 1/2" = 1'-0"

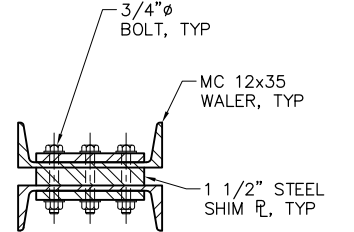


B SECTION
SCALE: 1 1/2" = 1'-0"

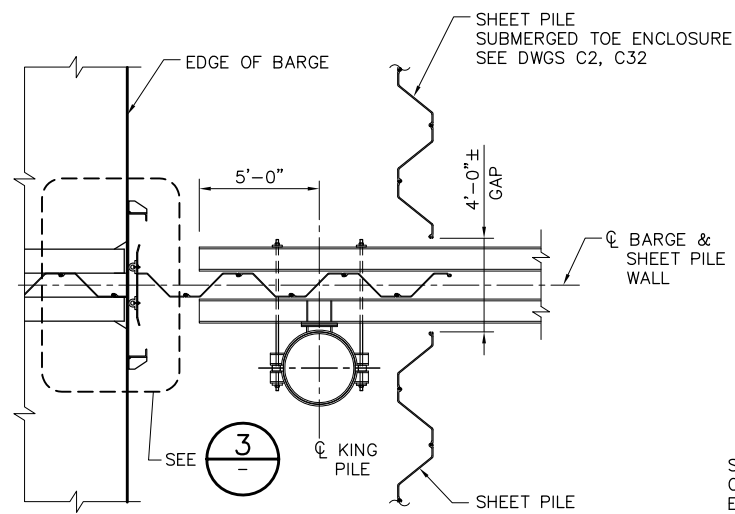


PLAN
2 DETAIL
SCALE: 1/4" = 1'-0"

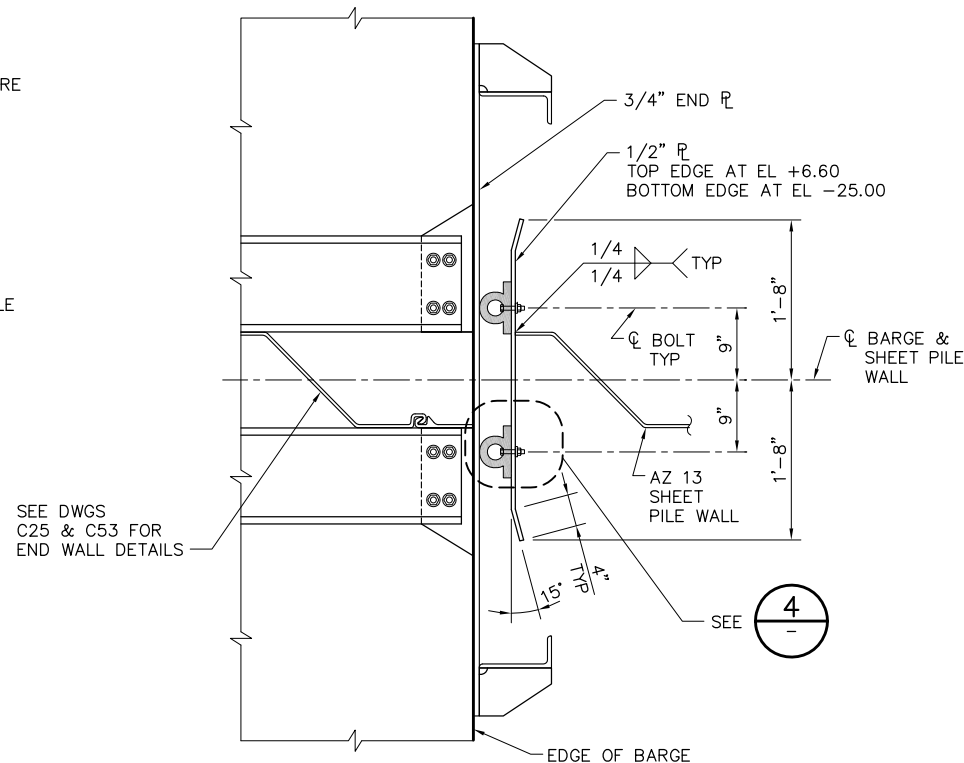

3 DETAIL
SCALE: 1" = 1'-0"

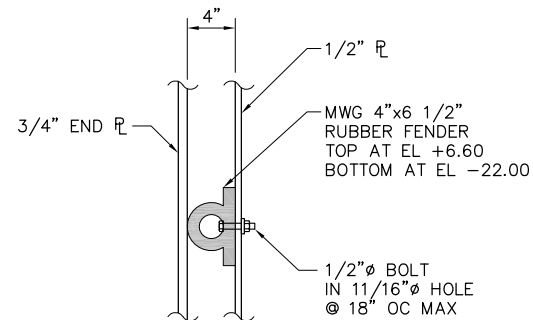


4 DETAIL
SCALE: 1 1/2" = 1'-0"

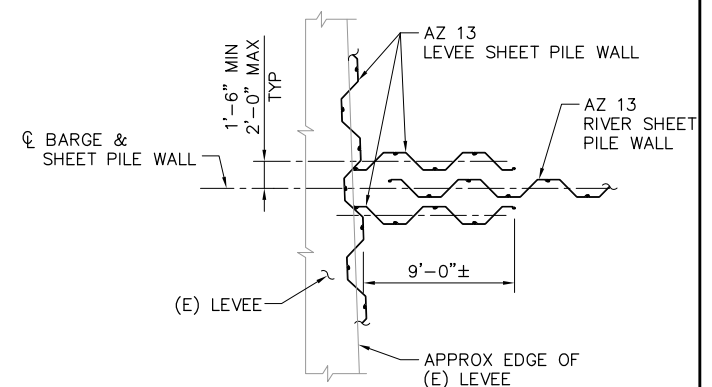

5 DETAIL
SCALE: 3/16" = 1'-0"

NOTES:

 1. LOCATE WALER SPLICES AS REQUIRED.



100% SUBMITTAL

IF SHEET IS LESS THAN 22" x 34"
IT IS A REDUCED PRINT -
SCALE REDUCED ACCORDINGLY.

REVISION	DESCRIPTION	BY	DATE



San Luis & Delta-Mendota Water Authority
842 6th Street, Suite 7
PO Box 2157
Los Banos, California 93635

APPROVED _____
FRANCY C. MIZUNO, PE C35136
San Luis & Delta-Mendota Water Authority

APPROVED _____
DENNIS G. MAJORS PE C21297
Metropolitan Water District of Southern California




2001 N. Main Street, Suite 360
Walnut Creek, California 94596
(925) 944-5411

DSGN JMB DR EP CHK TDB
JOB NO. 6097-03 SUBMITTED BY RMR

TWO GATE FISH PROTECTION PLAN		DATE 08/31/09
SHEET PILE WALL DETAILS SHEET 2		SHEET 60 OF 78
C64		

P:\6097-03 SWC GATE DESIGN\CADD\DWG\609703-C65.DWG 8/27/2009 9:30 AM

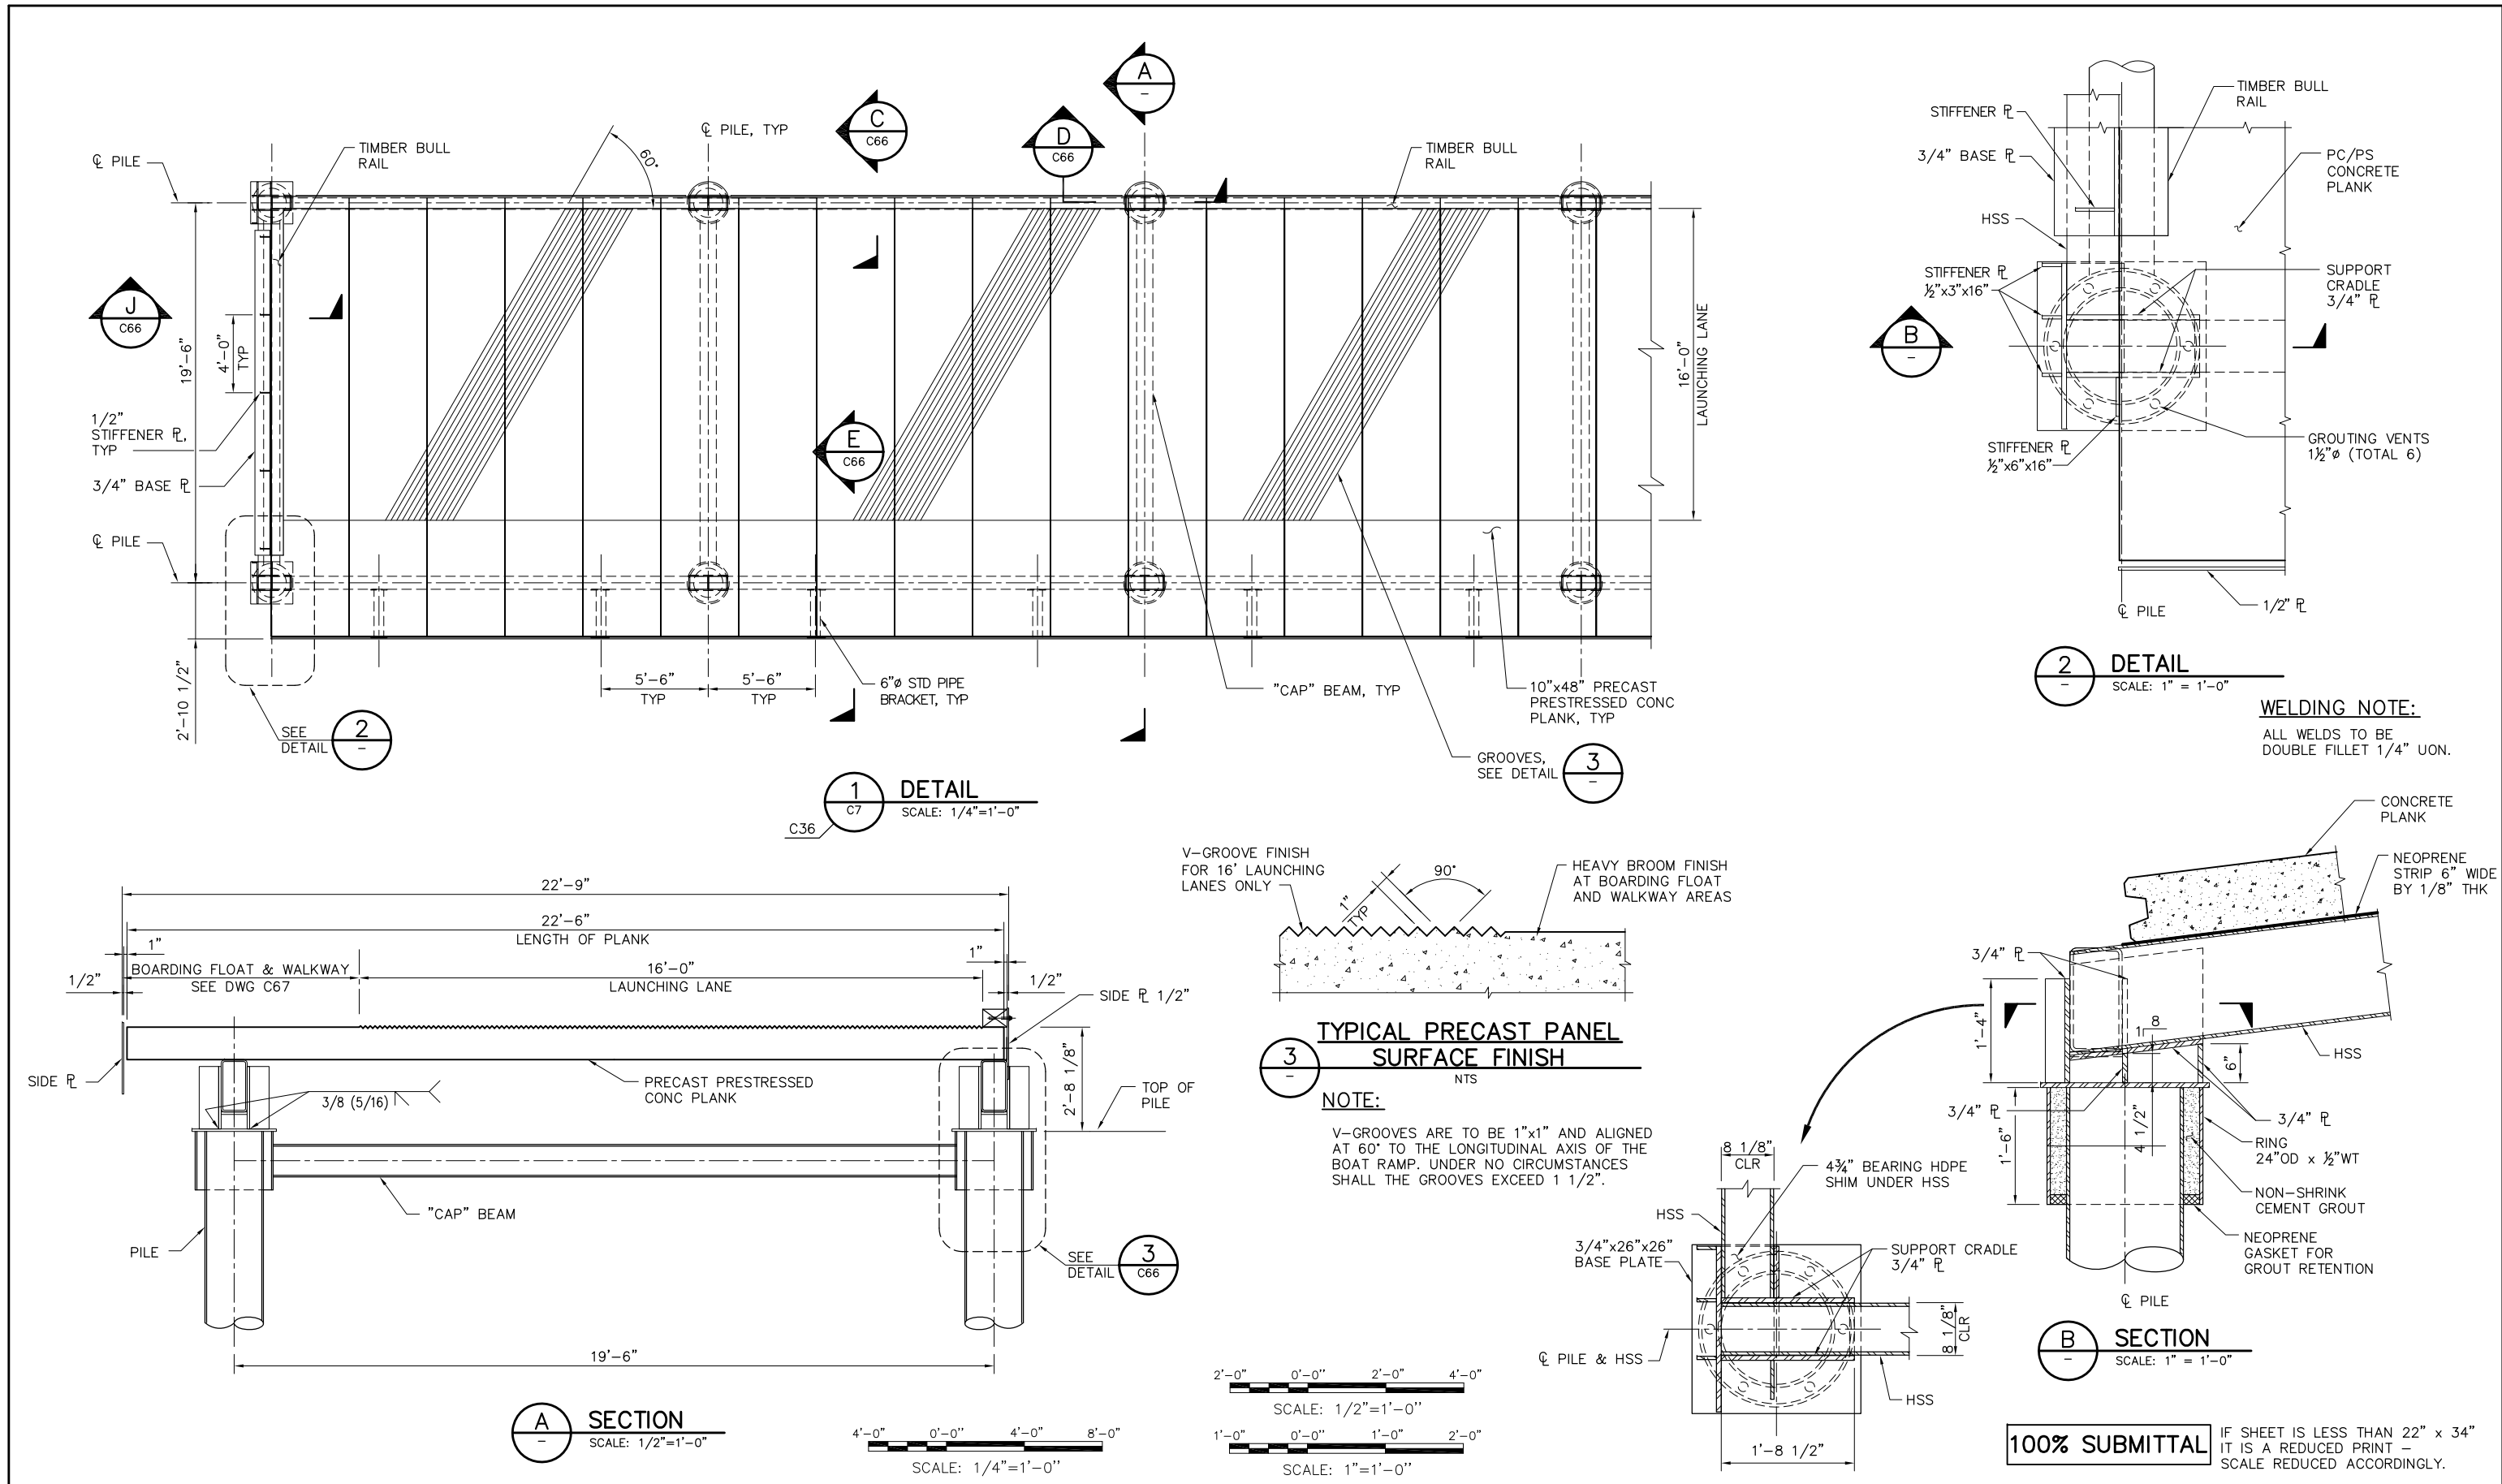

REVISION	DESCRIPTION	BY	DATE	 San Luis & Delta-Mendota Water Authority 842 6th Street, Suite 7 PO Box 2157 Los Banos, California 93635		 2001 N. Main Street, Suite 360 Walnut Creek, California 94596 (925) 944-5411		TWO GATE FISH PROTECTION PLAN		DATE 08/31/09
				APPROVED	FRANCY C. MIZUNO, PE C35136 San Luis & Delta-Mendota Water Authority	DSGN JMB	DR AB	CHK TDB	BOAT RAMP PLAN AND SECTIONS	SHEET 61 OF 78
				APPROVED	DENNIS G. MAJORS PE C21297 Metropolitan Water District of Southern California	JOB NO. 6097-03	SUBMITTED BY RMR			

[illegible]

SHIM AS NEEDED

TIMBER BULL RAIL

1/2" SIDE PLATE

1-10"

HSS 16 x 8 x 1/2 LOWER SEGMENT

2"

2"

8

HSS

3/8 (5/16) \

PJP

3/4" F

4 1/2"

6" TYP. UON

5 1/4" @ BEGINNING OF VC

3/4" F

VENTS (L 6)

1/2"x6"x19 STIFFENER F

3/4" END PLATE
TYP > 1/4

6"

5/8" ϕ x 7" LAG BOLT
@ 4'-0" OC, TYP

12x8 TREATED
TIMBER BULL RAIL

NEOPRENE END STRIP
1/4" THICK (16" WIDE)

1/2" STIFFENER PLATE
TYP > 3/8

3/4" BASE PLATE
TYP > 3/8

2"

1'-0"

2"

3/4" BASE PLATE

PC/PS PLANKS

HSS

BEARING HDPE SHIM
@ END OF HSS

8 1/8"

10" ϕ "CAP" BEAM

1'-2 1/2"

4 3/4"

ϕ PILE

1 1/2" SIDE R

6" Ø STD PIPE

3/4" Ø A-307 BOLTS (TOTAL 4)

3 1/2"

3"

2"

EACH SIDE

R 1/2"x10"x10"

1'-10"


NOTE:
NEOPRENE STRIPS SHALL BE
PREGLUED TO CONCRETE PLANKS.

1'-0" 0'-0" 1'-0" 2'-0"

SCALE: 1"=1'-0"


1'-0" 0'-0" 6" 1'-0"
SCALE: 1 1/2"=1'-0"

REVISION	DESCRIPTION	BY	DATE

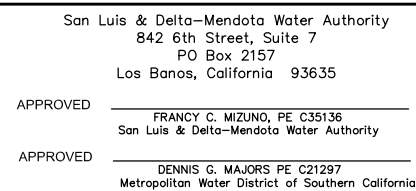

		2001 N. Main Street, Suite 360 Walnut Creek, California 94596 (925) 944-5411	
DSGN JMB	DR AB	CHK TDB	
JOB NO. 6097-03	SUBMITTED BY RMR		

TWO GATE FISH PROTECTION PLAN	DATE 08/31/09
	SHEET 62 OF 78
BOAT RAMP DETAILS	C66

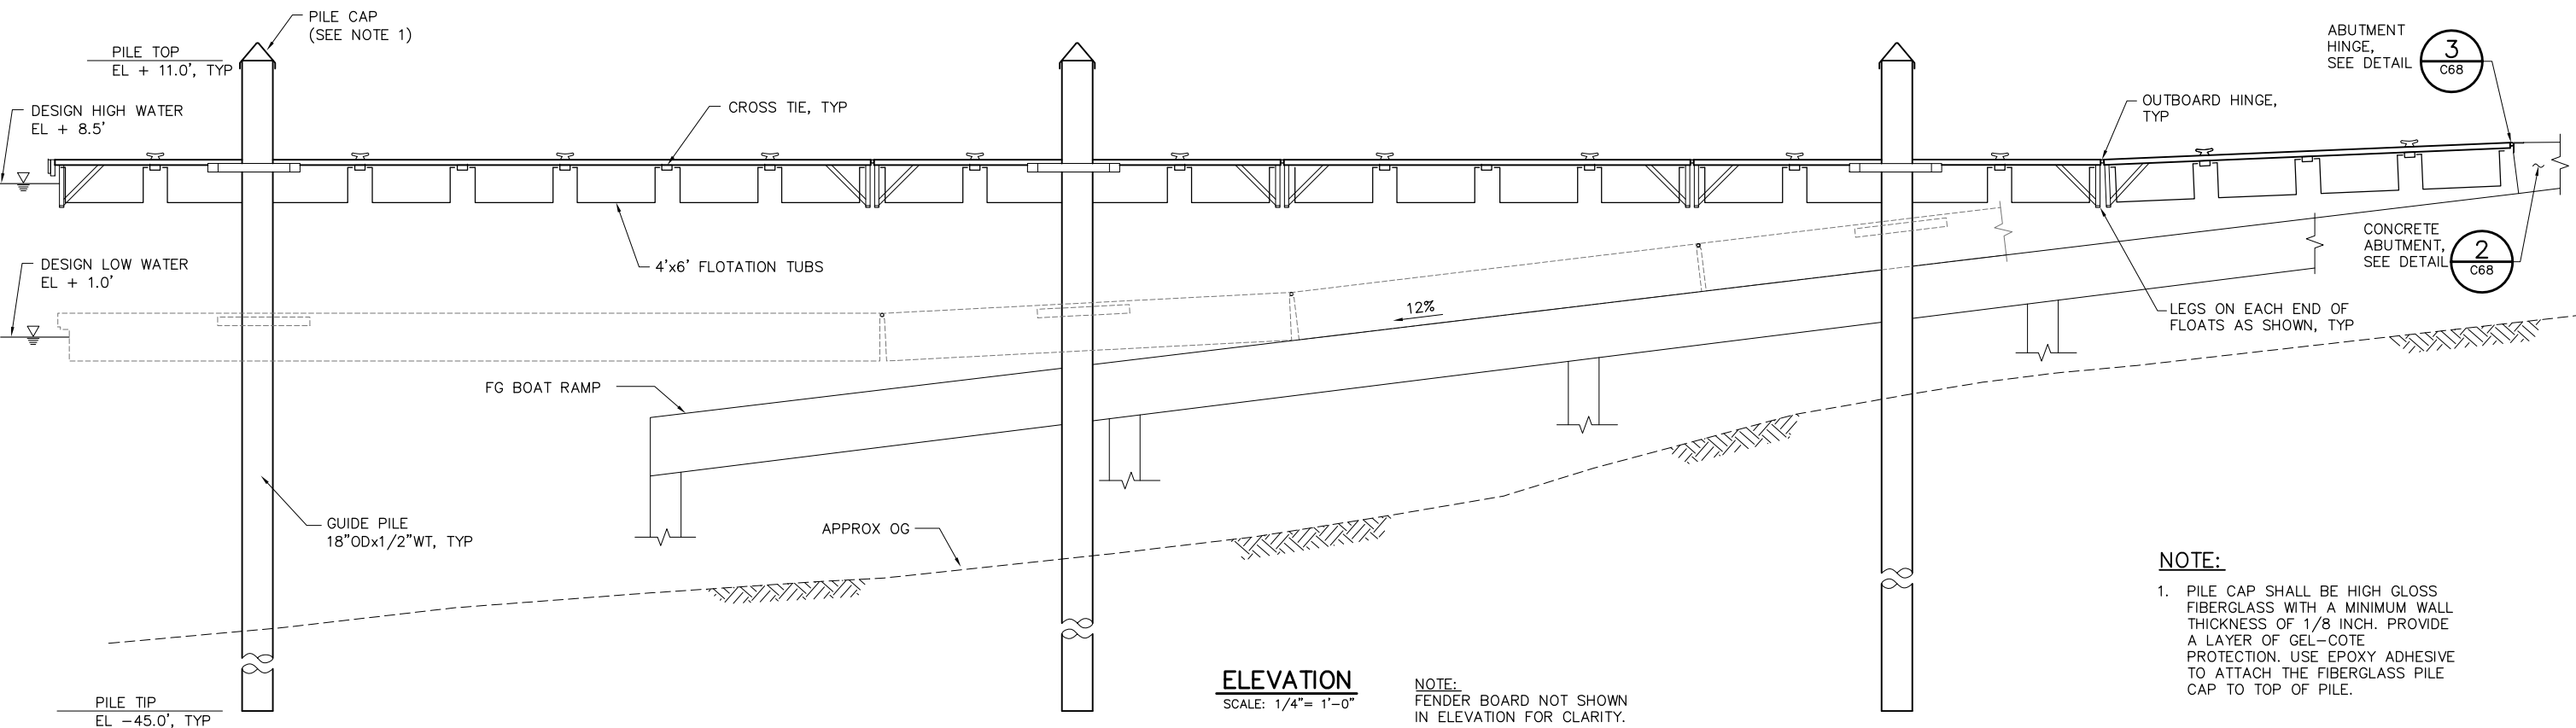

4'-0" 0'-0" 4'-0" 8'-0"

SCALE: 1/4"=1'-0"

IF SHEET IS LESS THAN 22" x 34"
IT IS A REDUCED PRINT –
SCALE REDUCED ACCORDINGLY.

REVISION	DESCRIPTION	BY	DATE



San Luis & Delta-Mendota Water Authority
842 6th Street, Suite 7
PO Box 2157
Los Banos, California 93635

APPROVED _____
FRANCY C. MIZUNO, PE C35136
San Luis & Delta-Mendota Water Authority

APPROVED _____
DENNIS G. MAJORS PE C21297
Metropolitan Water District of Southern California



2001 N. Main Street, Suite 360
Walnut Creek, California 94596
(925) 944-5411

DSGN	JMB	DR	AB	CHK	TDB
JOB NO.	6097-03	SUBMITTED BY RMR			

TWO GATE FISH PROTECTION PLAN


DATE 08/31/09

SHEET 63 OF 78


BOARDING FLOAT PLAN AND ELEVATION

C67


P:\6097-03 SWC GATE DESIGN\CADD\DWG\609703-C69.DWG 8/30/2009 11:35 PM

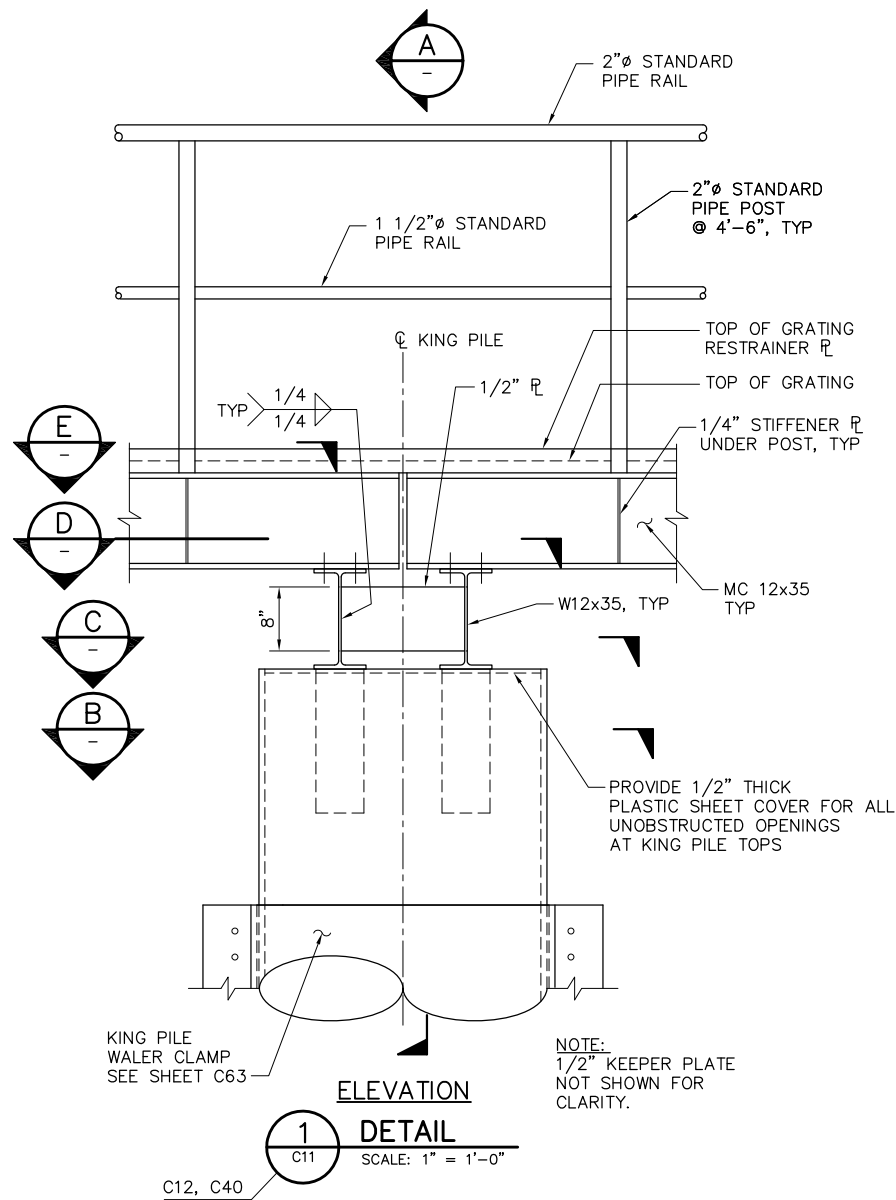


1 DETAIL
SCALE: 1" = 1'-0"

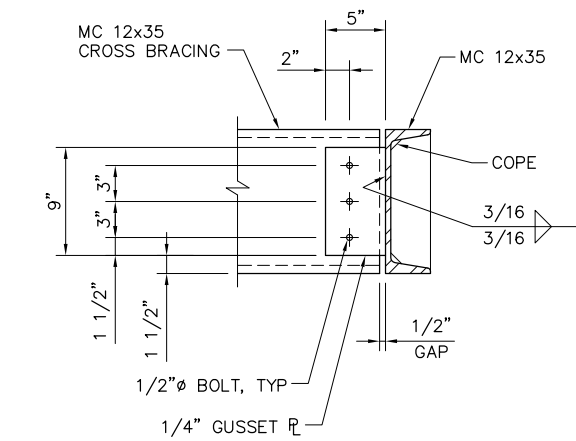


2 TYPICAL GUSSET CONNECTION DETAIL
SCALE: 1 1/2" = 1'-0"

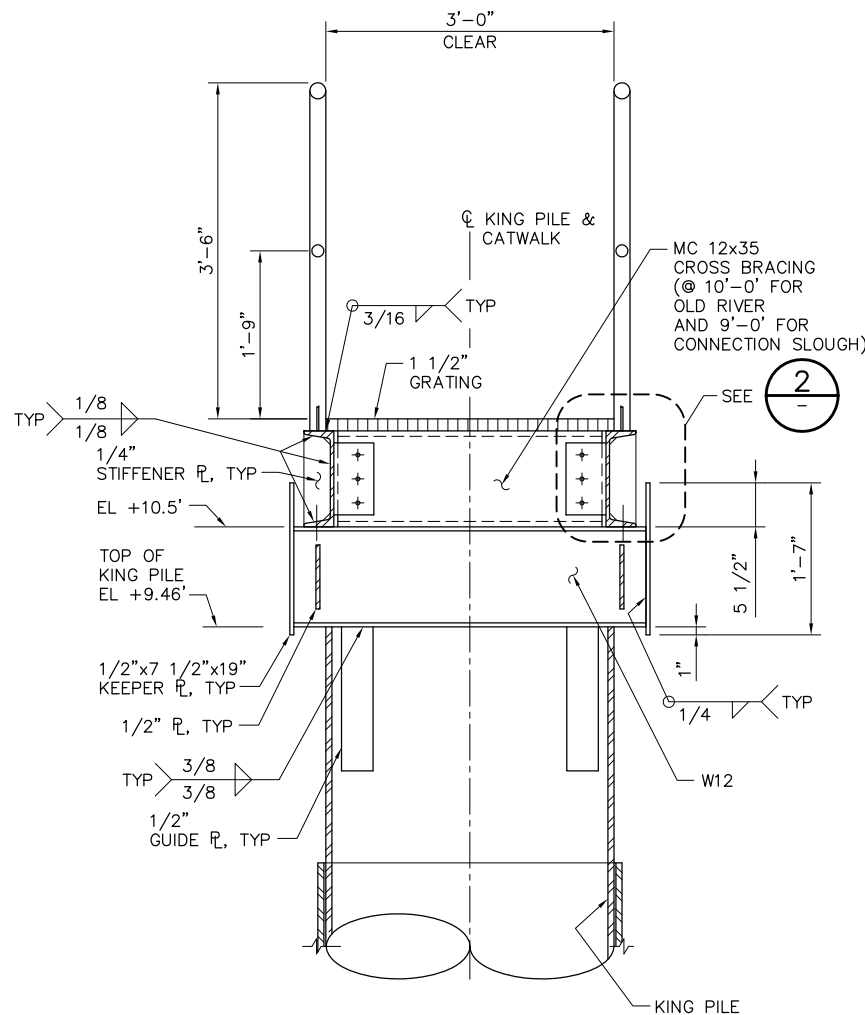


A SECTION
SCALE: 1" = 1'-0"

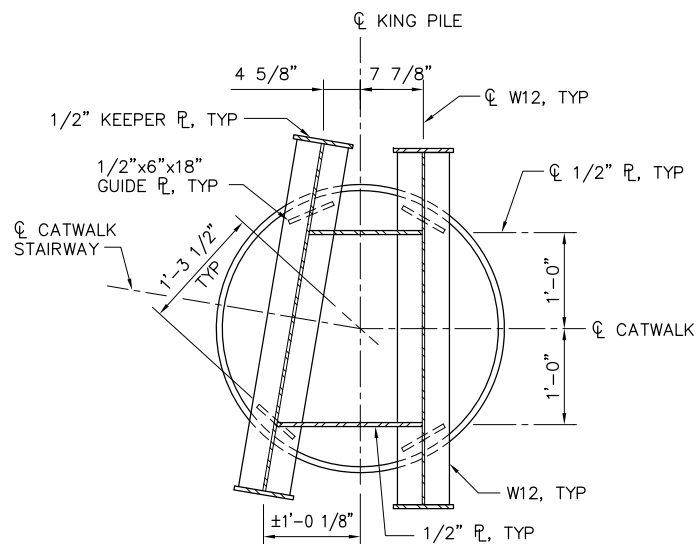


3 DETAIL
SCALE: 1" = 1'-0"

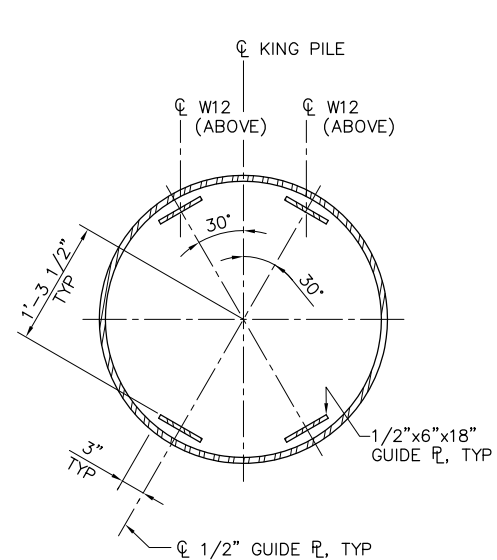


B SECTION
SCALE: 1" = 1'-0"

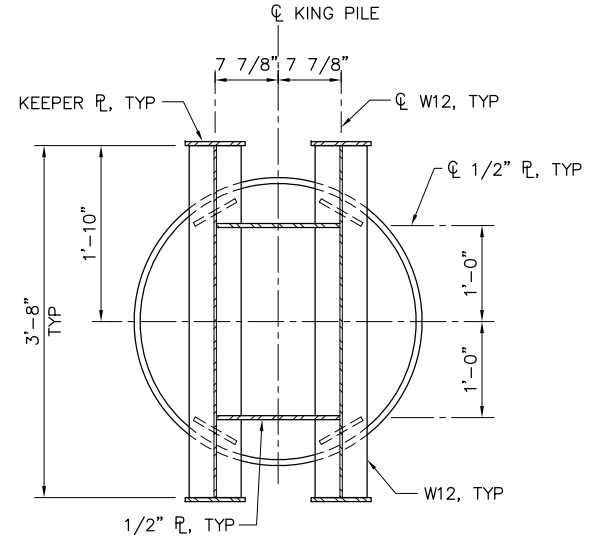

C SECTION
SCALE: 1" = 1'-0"

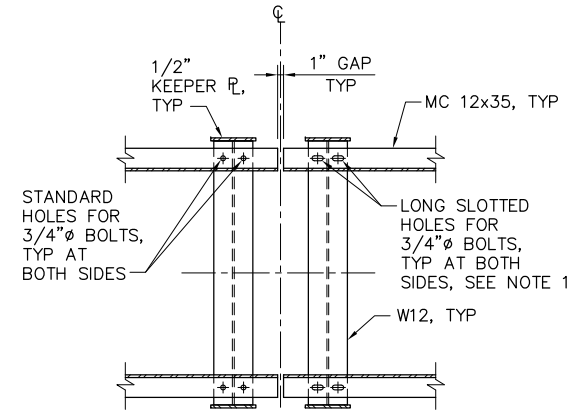

D SECTION
SCALE: 3/4" = 1'-0"

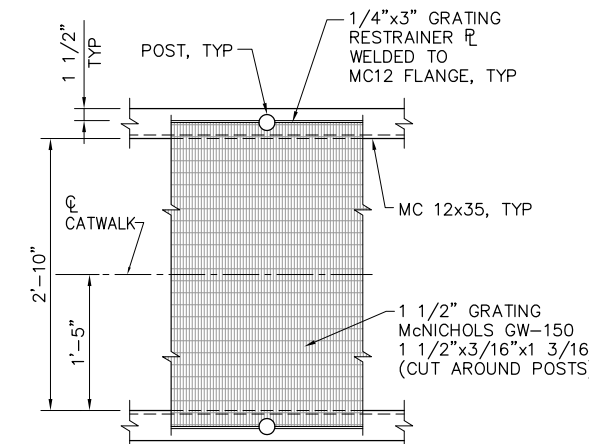

PLAN AT GRATING PLATE


E SECTION
SCALE: 1" = 1'-0"

- NOTES:**
- PROVIDE 1/16" THICK SLIDE PAD (HDPE OR EQUIVALENT) AT EXPANSION SUPPORTS WHERE LONG SLOTTED HOLES PERMIT EXPANSION.
 - FOR ADDITIONAL WELD INFORMATION SEE DWGS C70 AND C71.

2'-0" 0'-0" 1'-0" 2'-0"
SCALE: 3/4"=1'-0"

100% SUBMITTAL IF SHEET IS LESS THAN 22" x 34" IT IS A REDUCED PRINT - SCALE REDUCED ACCORDINGLY.

REVISION	DESCRIPTION	BY	DATE

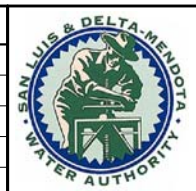

San Luis & Delta-Mendota Water Authority
842 6th Street, Suite 7
PO Box 2157
Los Banos, California 93635

APPROVED _____
FRANCY C. MIZUNO, PE C35136
San Luis & Delta-Mendota Water Authority

APPROVED _____
DENNIS G. MAJORS PE C21297
Metropolitan Water District of Southern California

Moffatt & Nichol
2001 N. Main Street, Suite 360
Walnut Creek, California 94596
(925) 944-5411

DSGN JMB DR EP/AB CHK TDB
JOB NO. 6097-03 SUBMITTED BY RMR


TWO GATE FISH PROTECTION PLAN

CATWALK DETAILS
SHEET 1


DATE 08/31/09
SHEET 65 OF 78

C69


P:\6097-03 SWC GATE DESIGN\CADD\DWG\609703-C70.DWG 8/27/2009 9:32 AM

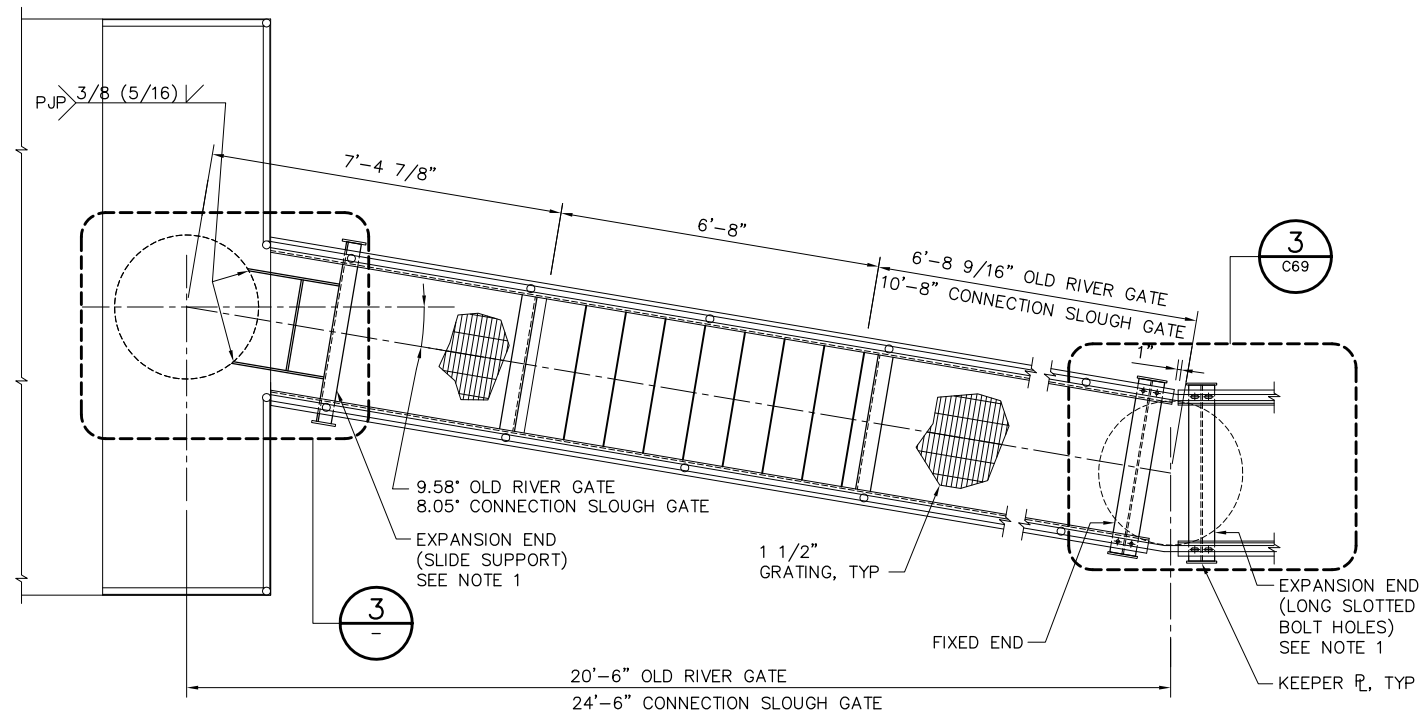


PLAN
1 DETAIL
C12 SCALE: 1/2" = 1'-0"

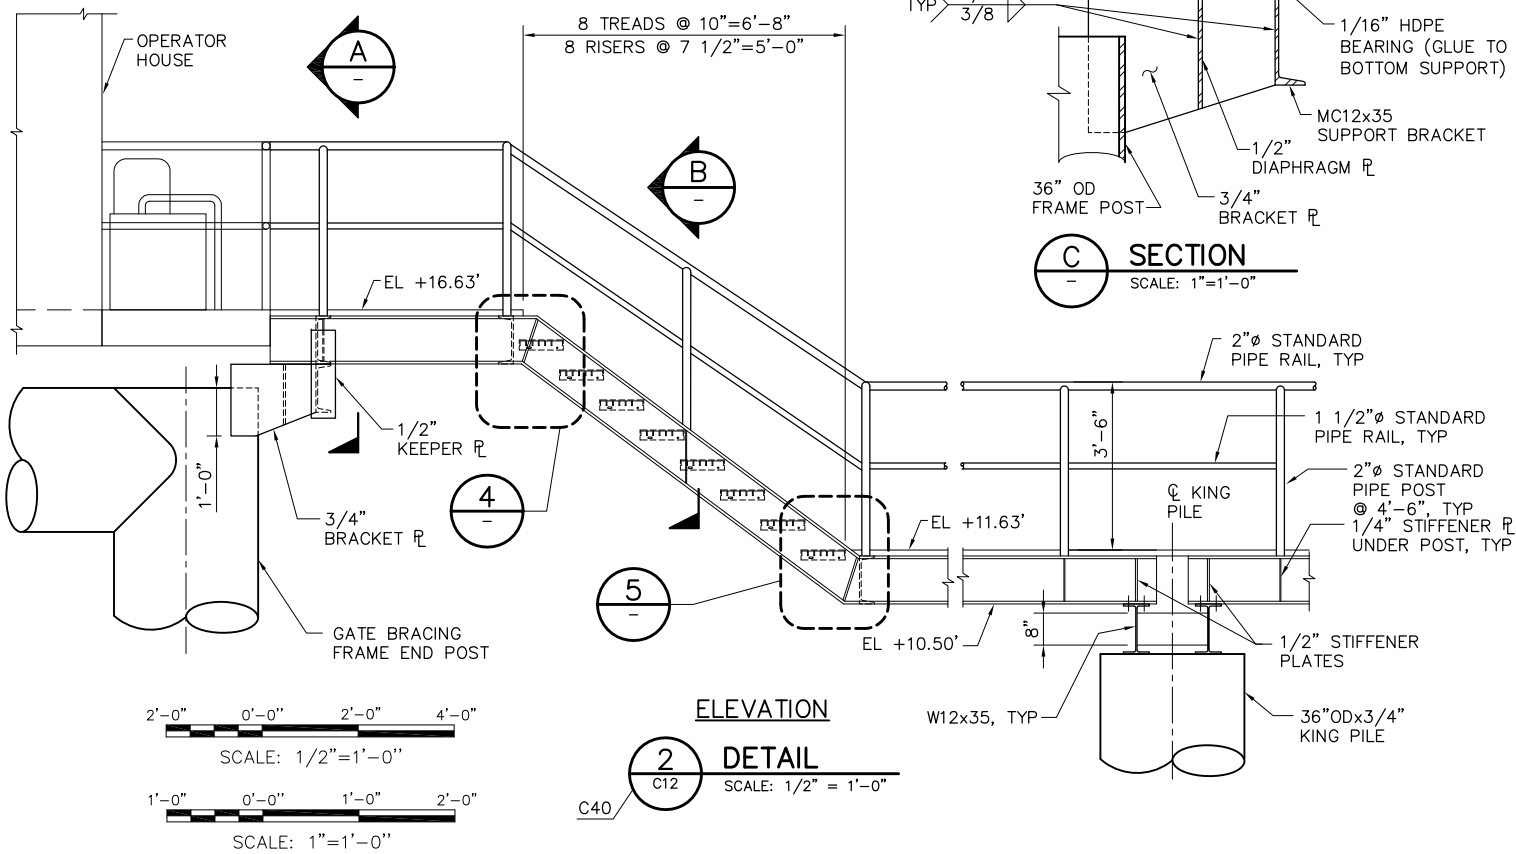


ELEVATION
2 DETAIL
C12 SCALE: 1/2" = 1'-0"

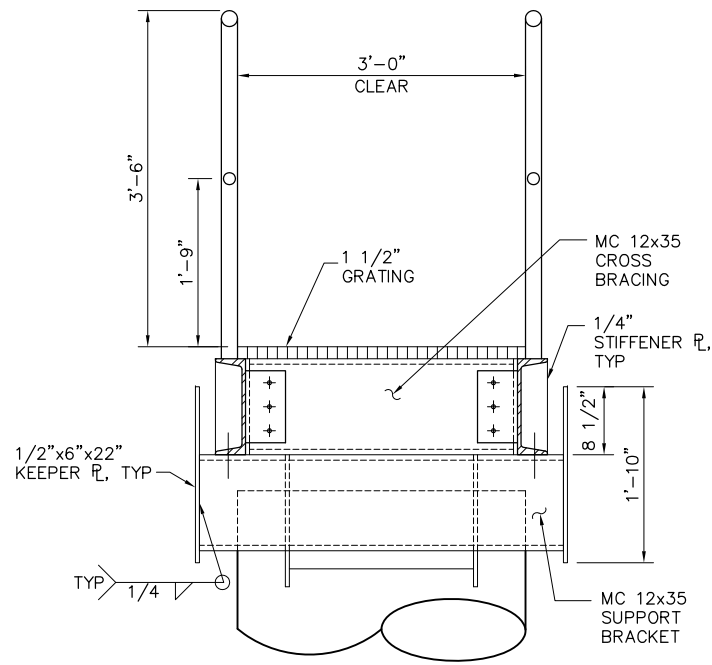


A SECTION
C71 SCALE: 1" = 1'-0"

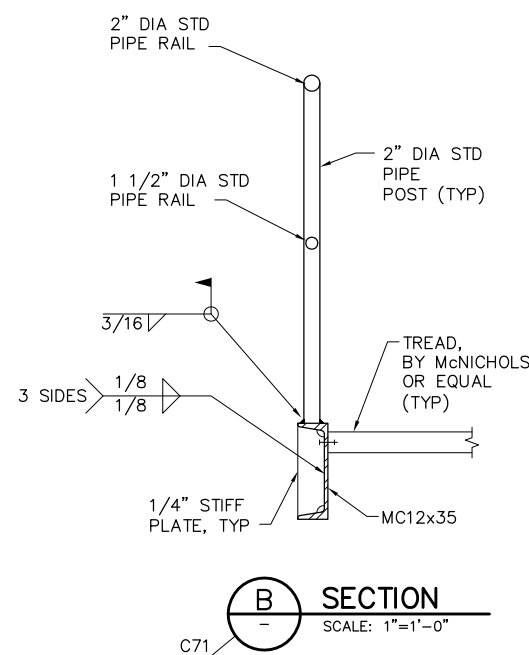


B SECTION
C71 SCALE: 1" = 1'-0"

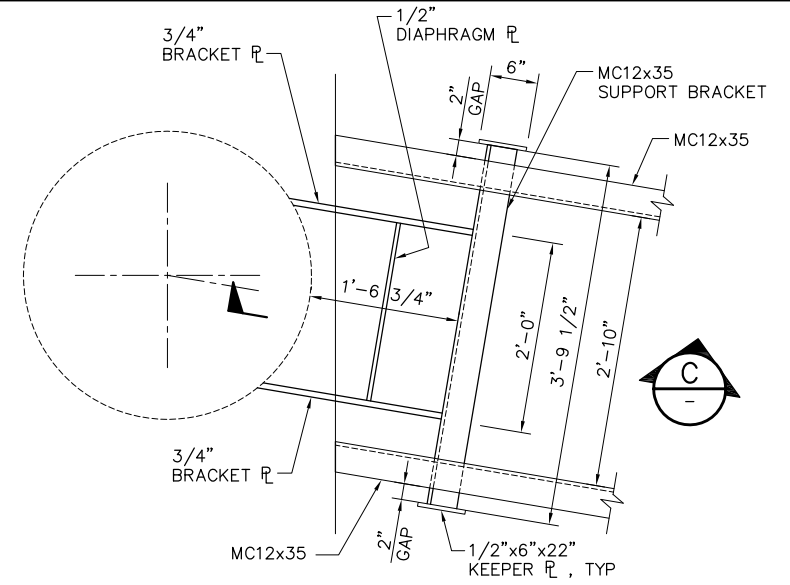

3 DETAIL
SCALE: 1" = 1'-0"

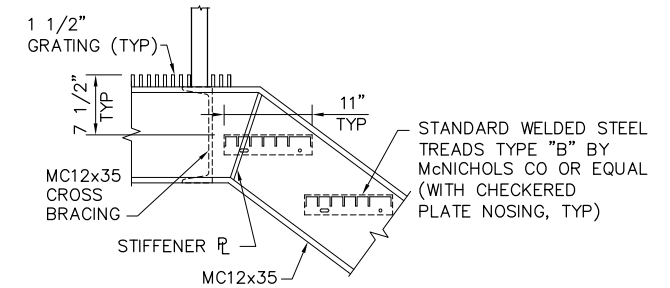

4 DETAIL
SCALE: 1" = 1'-0"

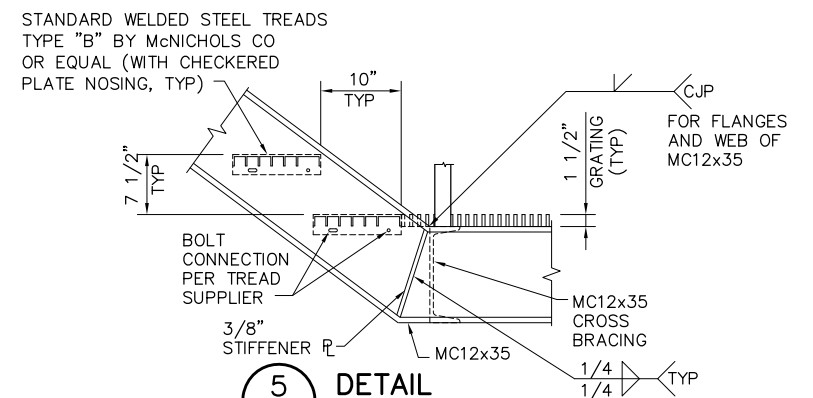

5 DETAIL
SCALE: 1" = 1'-0"


NOTES:

1. PROVIDE 1/16" THICK HDPE SLIDE/BEARING PLATE AT EXPANSION ENDS AT UNDERSIDE OF MC12x35.
2. FOR ADDITIONAL WELD INFORMATION SEE DWGS C69 AND C71.

100% SUBMITTAL

IF SHEET IS LESS THAN 22" x 34"
IT IS A REDUCED PRINT -
SCALE REDUCED ACCORDINGLY.

REVISION	DESCRIPTION	BY	DATE

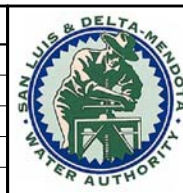

San Luis & Delta-Mendota Water Authority
842 6th Street, Suite 7
PO Box 2157
Los Banos, California 93635


APPROVED
FRANCY C. MIZUNO, PE C35136
San Luis & Delta-Mendota Water Authority

APPROVED
DENNIS G. MAJORS PE C21297
Metropolitan Water District of Southern California


		2001 N. Main Street, Suite 360 Walnut Creek, California 94596 (925) 944-5411	
DSGN	JMB	DR	AB/EP
JOB NO.	6097-03	SUBMITTED BY	RMR

TWO GATE FISH PROTECTION PLAN	DATE 08/31/09
CATWALK DETAILS SHEET 2	SHEET 66 OF 78
C70	


P:\6097-03 SWC GATE DESIGN\CADD\DWG\609703-C71.DWG 8/27/2009 9:32 AM

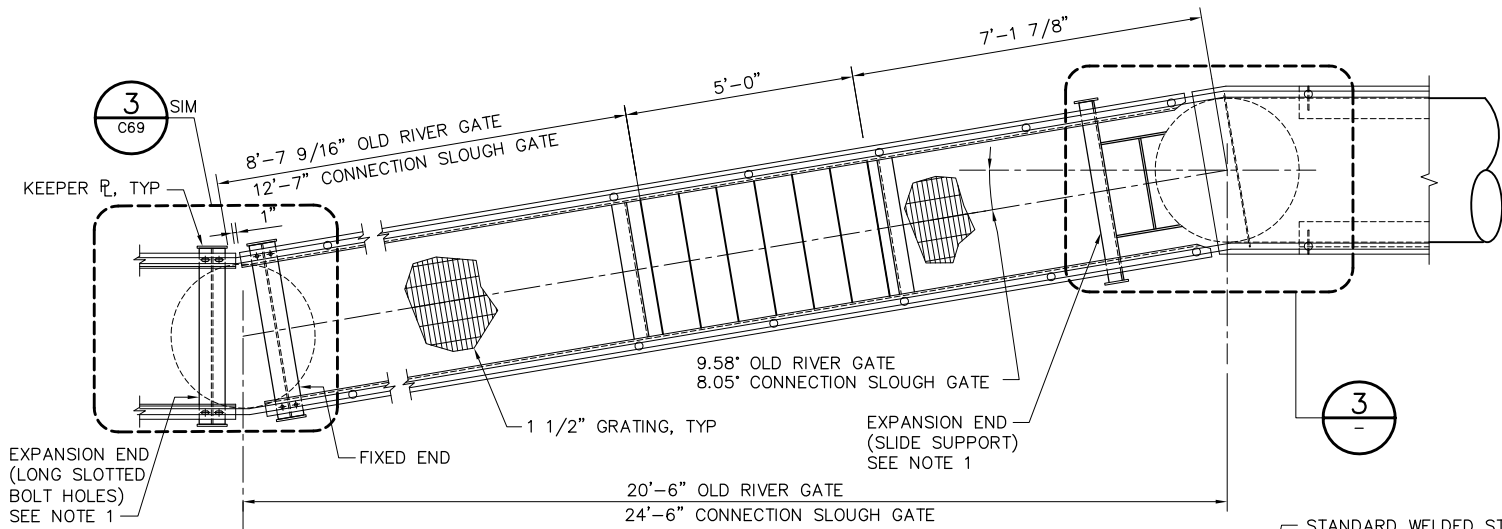


1 C11
SCALE: 1/2" = 1'-0"

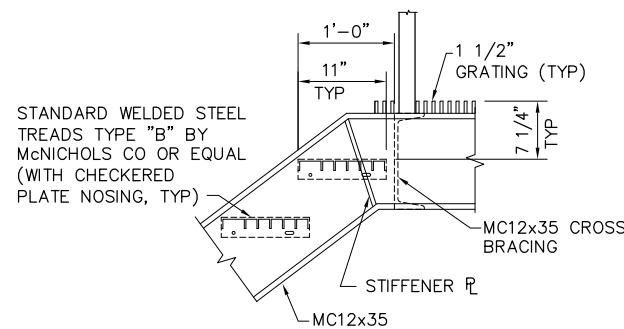


4
SCALE: 1"=1'-0"

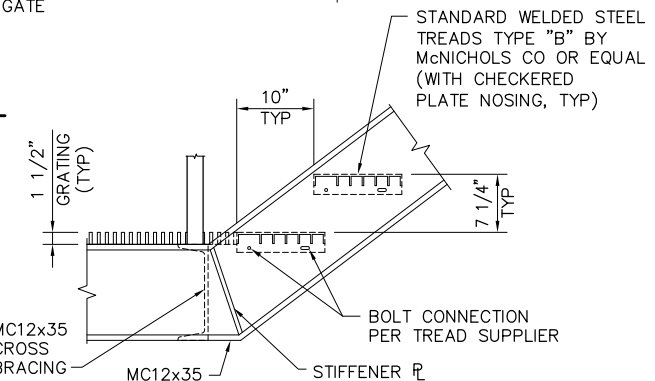


5
SCALE: 1"=1'-0"

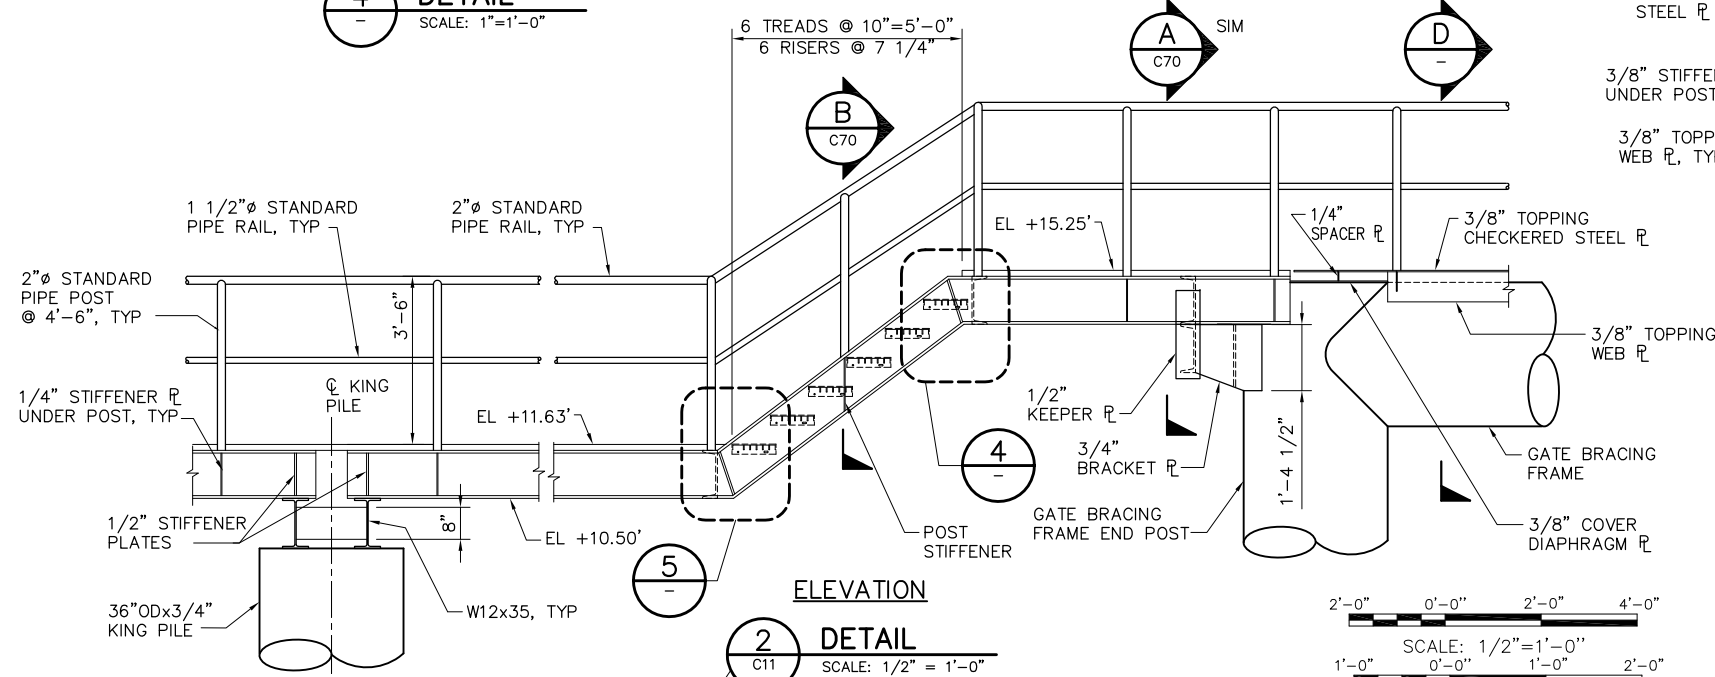

2 C11
SCALE: 1/2" = 1'-0"

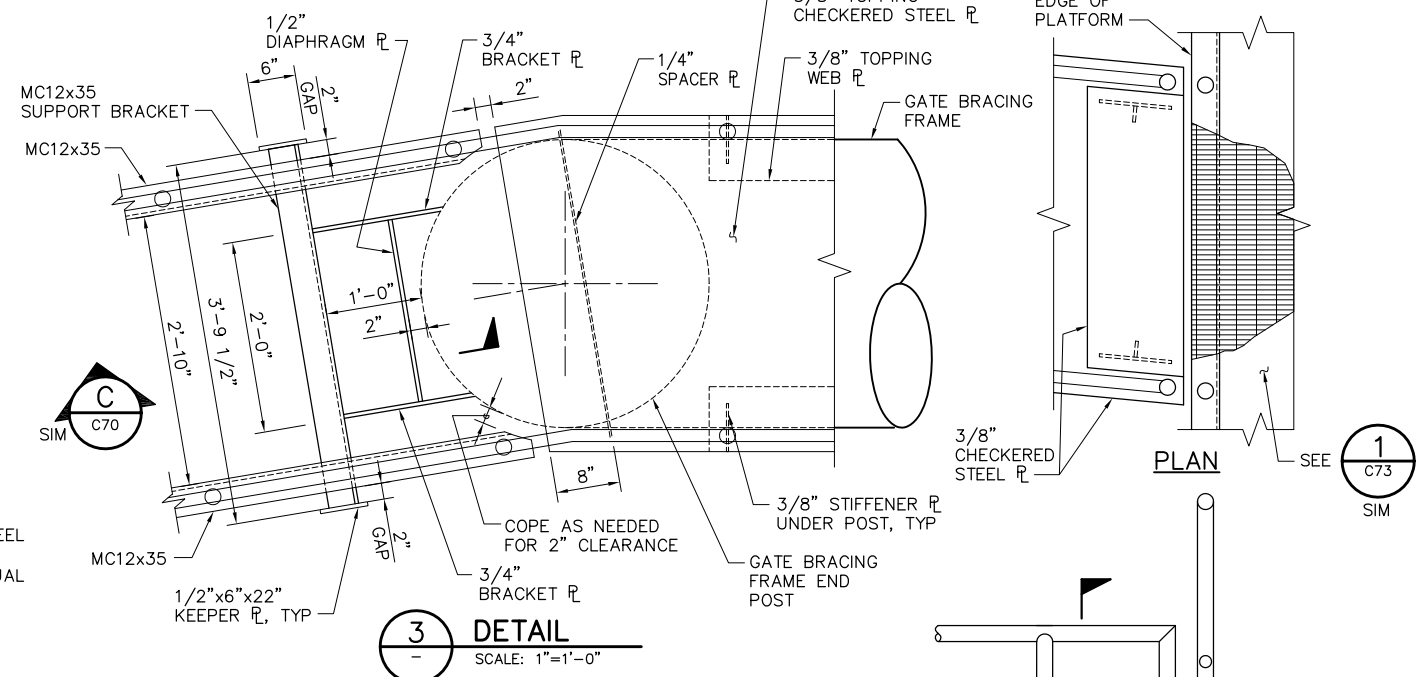

3
SCALE: 1"=1'-0"

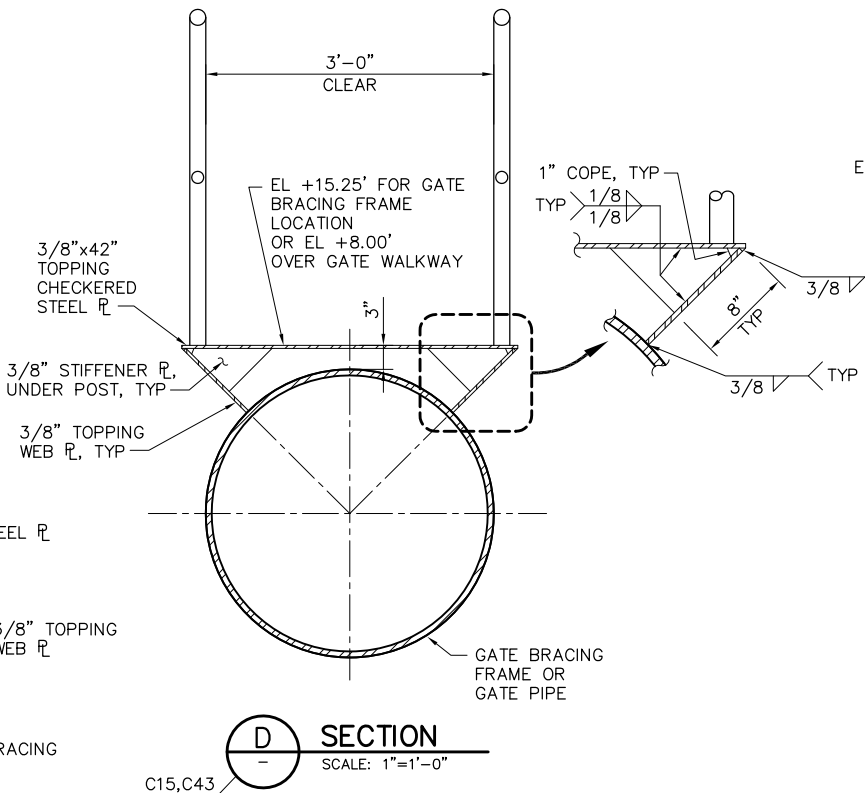

NOTES:

- PROVIDE 1/16" THICK HDPE SLIDE/BEARING PLATE AT EXPANSION ENDS AT UNDERSIDE OF MC12x35.
- FOR WELD INFORMATION SEE DWGS C69 AND C70.

100% SUBMITTAL

IF SHEET IS LESS THAN 22" x 34" IT IS A REDUCED PRINT - SCALE REDUCED ACCORDINGLY.

REVISION	DESCRIPTION	BY	DATE



San Luis & Delta-Mendota Water Authority
842 6th Street, Suite 7
PO Box 2157
Los Banos, California 93635


APPROVED
FRANCY C. MIZUNO, PE C35136
San Luis & Delta-Mendota Water Authority

APPROVED
DENNIS G. MAJORS PE C21297
Metropolitan Water District of Southern California

		2001 N. Main Street, Suite 360 Walnut Creek, California 94596 (925) 944-5411	
DSGN	JMB	DR	AB/EP
JOB NO.	6097-03	SUBMITTED BY	RMR


TWO GATE FISH PROTECTION PLAN		DATE	08/31/09
CATWALK DETAILS SHEET 3		SHEET	67 OF 78
C71			

P:\6097-03 SWC GATE DESIGN\CADD\DWG\609703-C72.DWG 8/30/2009 10:04 PM

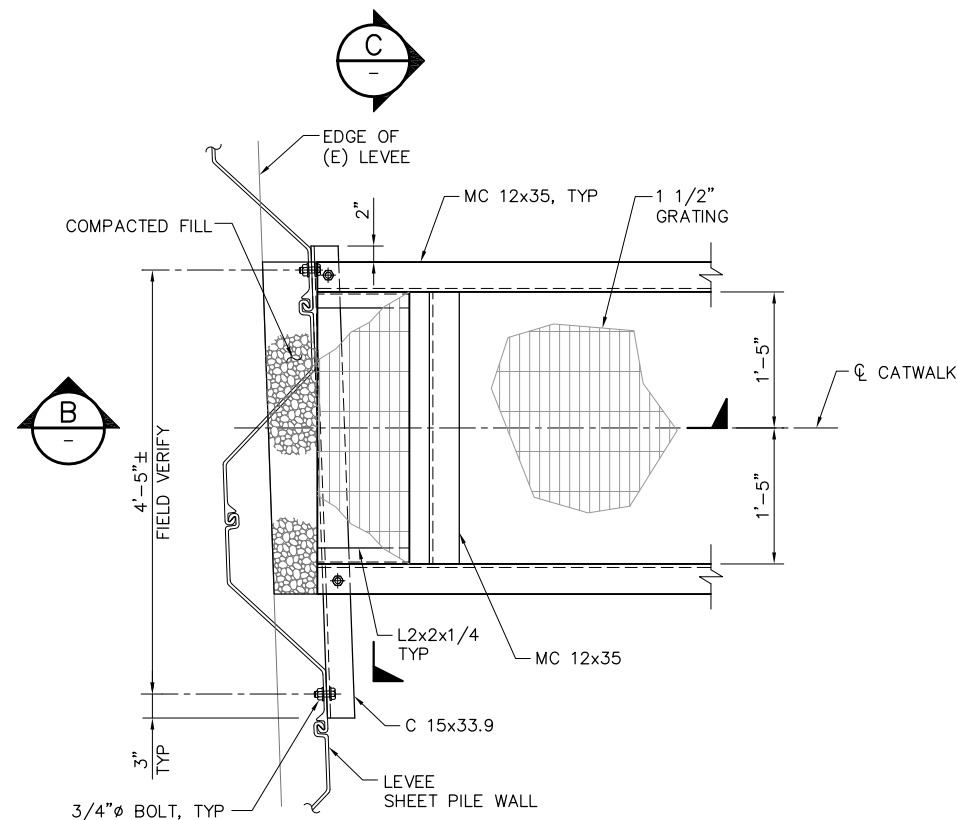


PLAN AT END OF CATWALK


1 **DETAIL**
C11 SCALE: 1" = 1'-0"
C40

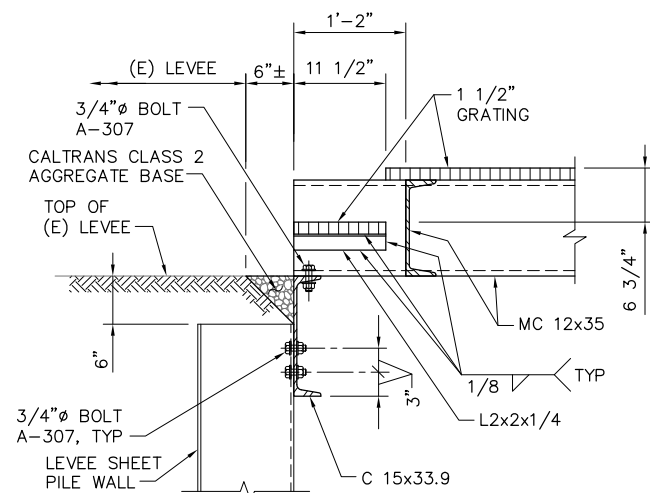

B **SECTION**
SCALE: 1" = 1'-0"

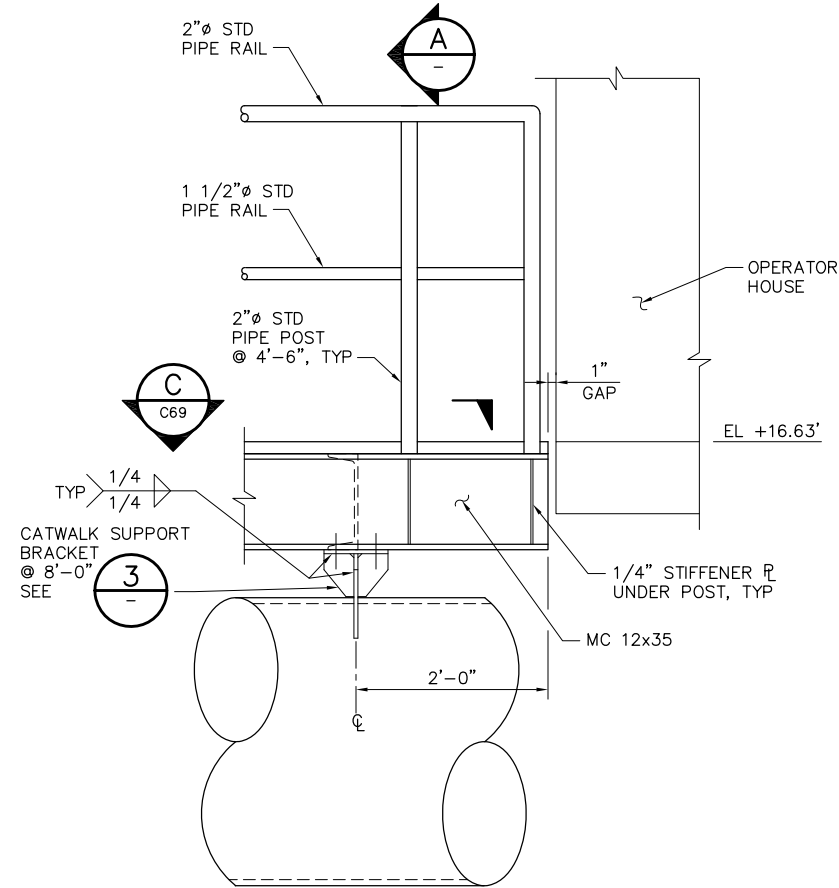

2 **DETAIL**
C15 SCALE: 1"=1'-0"
C43

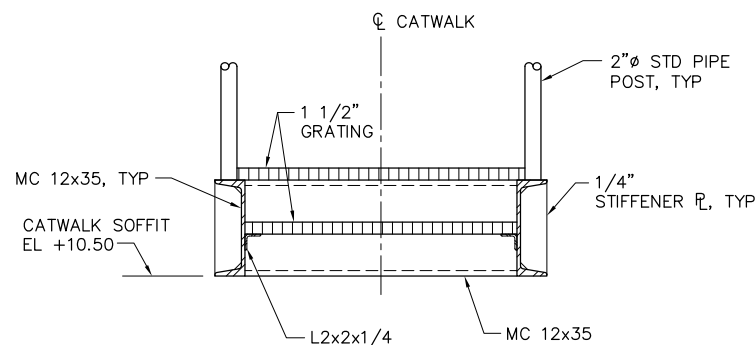

C **SECTION**
SCALE: 1" = 1'-0"


NOTE:

FOR ADDITIONAL WELD INFORMATION SEE DWGS C69, C70 AND C71.


1'-0" 0'-0" 1'-0" 2'-0"
SCALE: 1"=1'-0"

100% SUBMITTAL

IF SHEET IS LESS THAN 22" x 34"
IT IS A REDUCED PRINT -
SCALE REDUCED ACCORDINGLY.

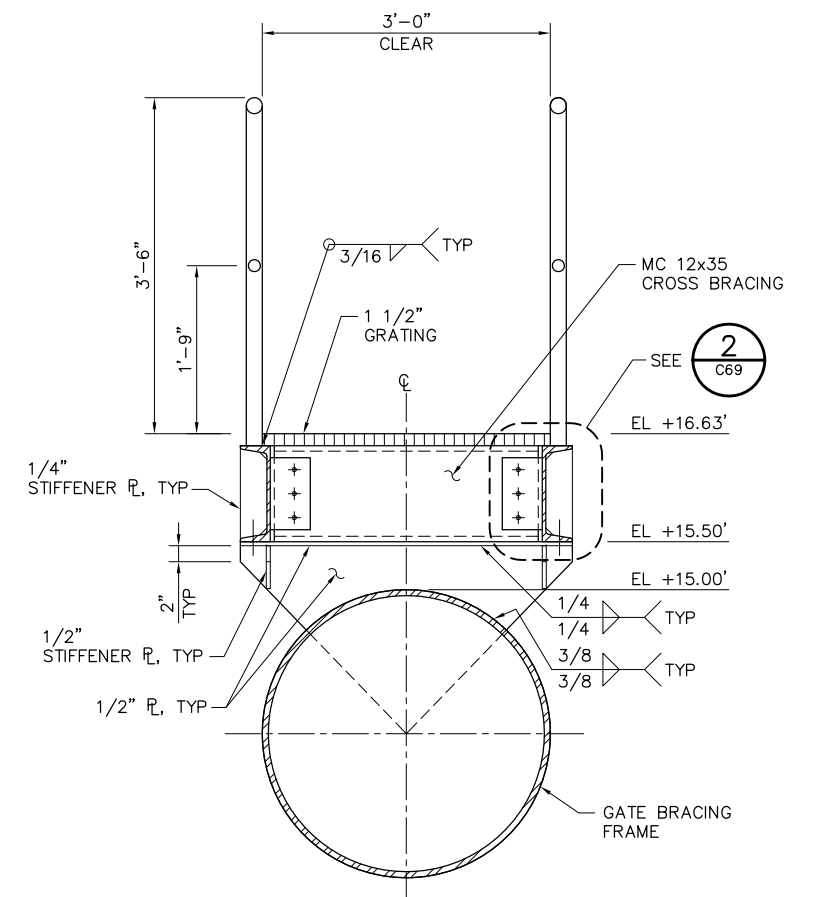


A **SECTION**
SCALE: 1"=1'-0"

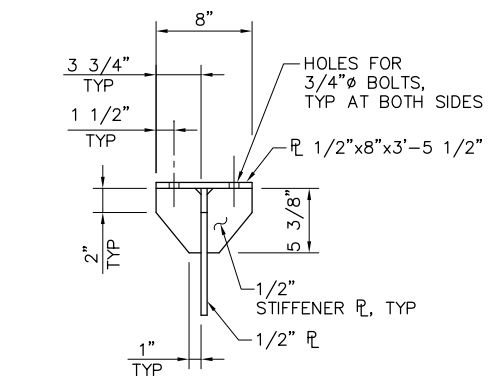

3 **DETAIL**
C73 SCALE: 1"=1'-0"

REVISION	DESCRIPTION	BY	DATE

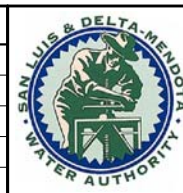

San Luis & Delta-Mendota Water Authority
842 6th Street, Suite 7
PO Box 2157
Los Banos, California 93635


APPROVED _____
FRANCY C. MIZUNO, PE C35136
San Luis & Delta-Mendota Water Authority

APPROVED _____
DENNIS G. MAJORS PE C21297
Metropolitan Water District of Southern California

		2001 N. Main Street, Suite 360 Walnut Creek, California 94596 (925) 944-5411	
DSGN	JMB	DR	EP
JOB NO.	6097-03	SUBMITTED BY	RMR

TWO GATE FISH PROTECTION PLAN	DATE 08/31/09
CATWALK DETAILS SHEET 4	SHEET 68 OF 78
C72	



P:\6097-03 SWC GATE DESIGN\CADD\DWG\609703-C74.DWG 8/27/2009 9:33 AM

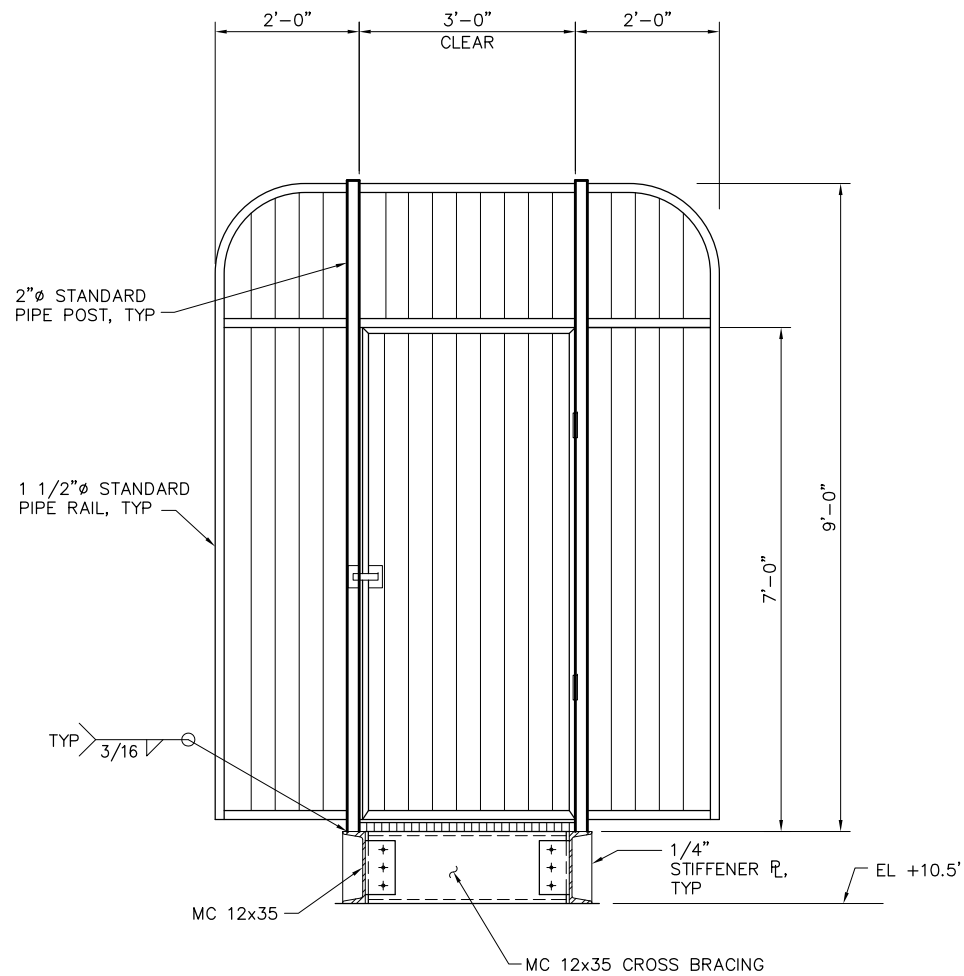

NOTE:
SECURITY GATE SHALL PROVIDE
A MINIMUM 36" CLEAR OPENING,
SHALL BE AUTOMATICALLY
CLOSING, AND SHALL INCLUDE
A LOCKABLE LATCH.

SECURITY GATE ELEVATION

1
C11
SCALE: 3/4" = 1'-0"

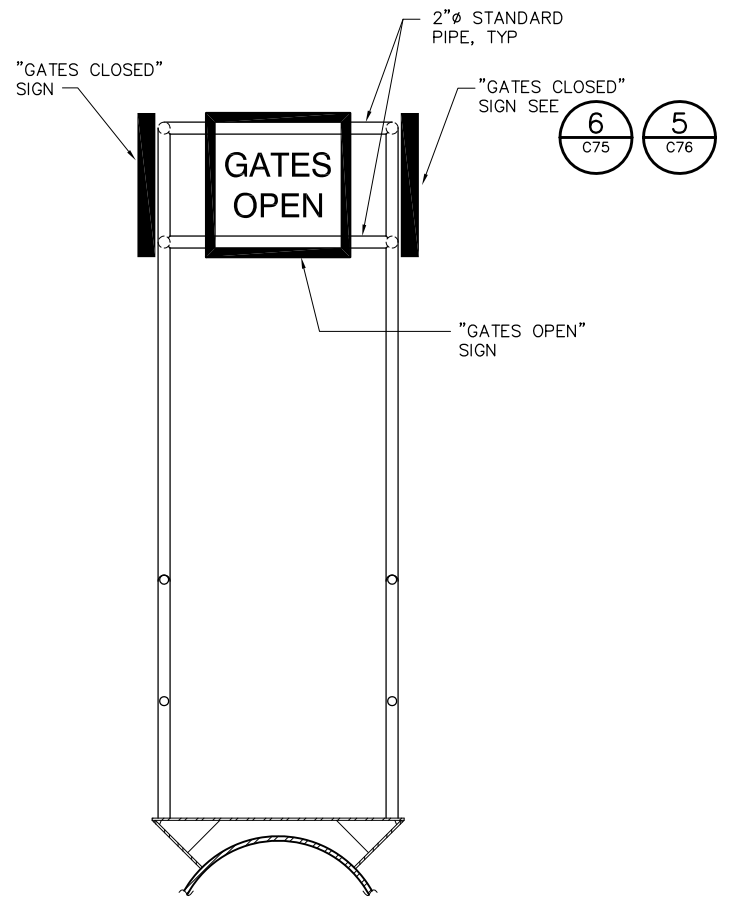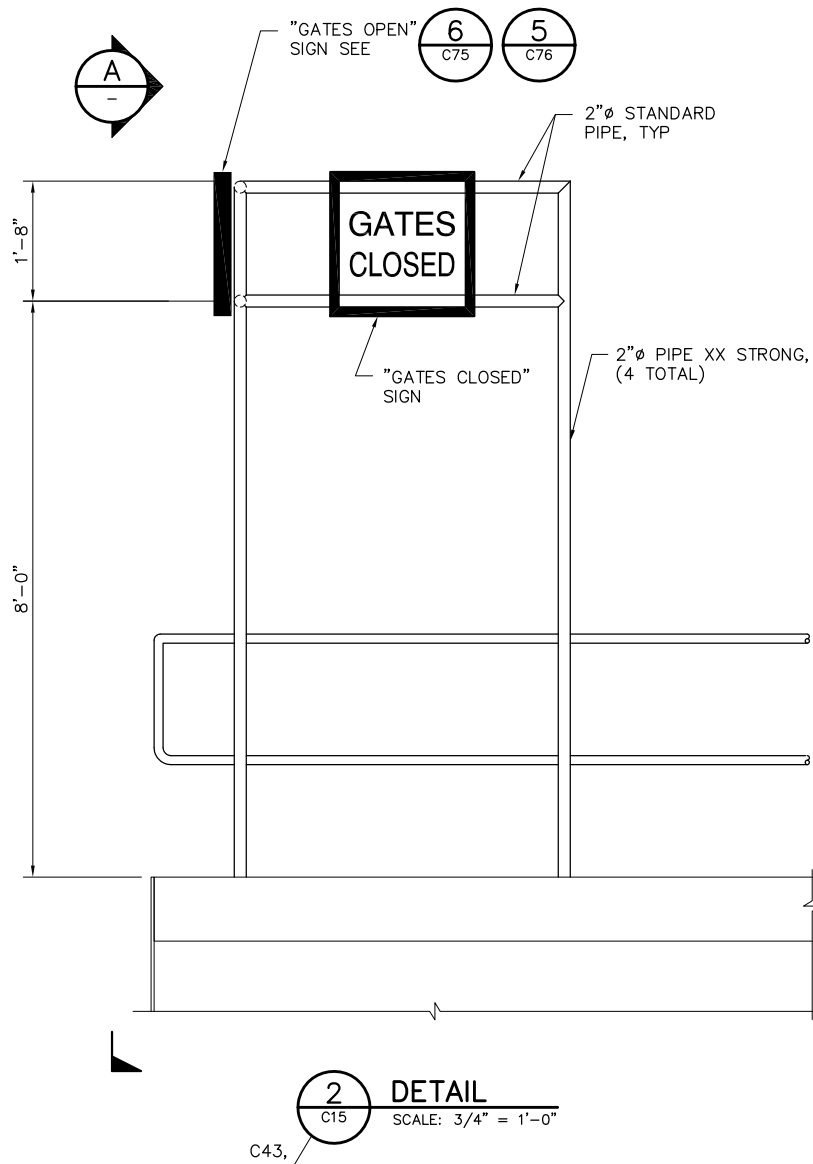

NOTE:
FOR ADDITIONAL WELD INFORMATION
SEE DWGS C68 THROUGH C73.

2'-0" 0'-0" 1'-0" 2'-0"
SCALE: 3/4"=1'-0"

100% SUBMITTAL

IF SHEET IS LESS THAN 22" x 34"
IT IS A REDUCED PRINT -
SCALE REDUCED ACCORDINGLY.

REVISION	DESCRIPTION	BY	DATE



San Luis & Delta-Mendota Water Authority
842 6th Street, Suite 7
PO Box 2157
Los Banos, California 93635

APPROVED
FRANCY C. MIZUNO, PE C35136
San Luis & Delta-Mendota Water Authority

APPROVED
DENNIS G. MAJORS PE C21297
Metropolitan Water District of Southern California



2001 N. Main Street, Suite 360
Walnut Creek, California 94596
(925) 944-5411

DSGN	JMB	DR	AB	CHK	TDB
JOB NO.	6097-03	SUBMITTED BY	RMR		

TWO GATE FISH PROTECTION PLAN


DATE 08/31/09

SHEET 70 OF 78

CATWALK DETAILS
SHEET 6


C74

P:\6097-03 SVC GATE DESIGN\CADD\DWG\609703-C75.DWG 8/30/2009 3:47 PM

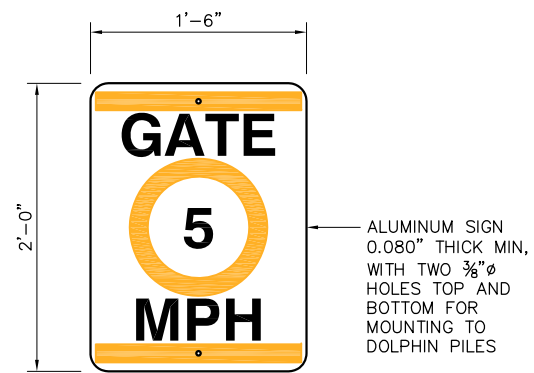

SIGNBOARD ON PILE, ORANGE
ON WHITE WITH BLACK LETTERS


1 GATE 5 MPH SIGN
C26 SCALE: 1/8" = 1'-0"
C54

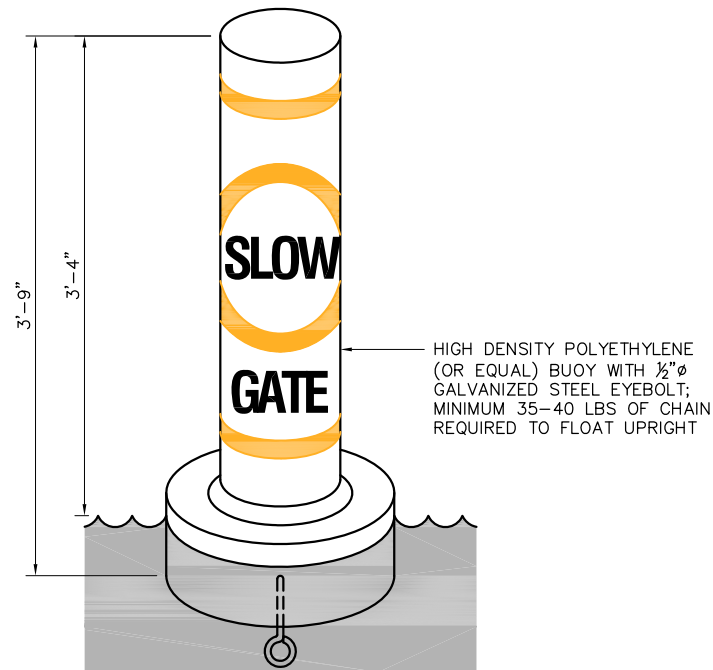

ORANGE ON WHITE WITH BLACK
LETTERS


NOTE:
45' OF 1/2" OPEN LINK CHAIN
WITH 25 LB DANFORTH
STANDARD ANCHOR.

2 SLOW GATE SIGN
C26 SCALE: 1/8" = 1'-0"
C54

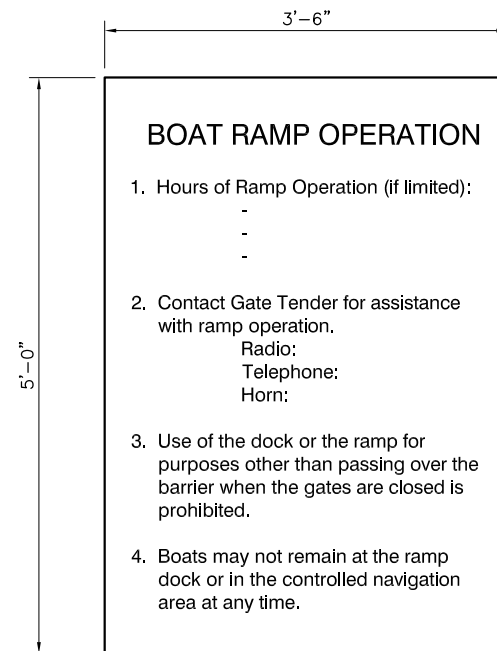

BLACK LETTERS ON WHITE
PAINTED ALUMINUM BOARD

3 BOAT RAMP DOCK SIGN
C26 SCALE: NONE
C54

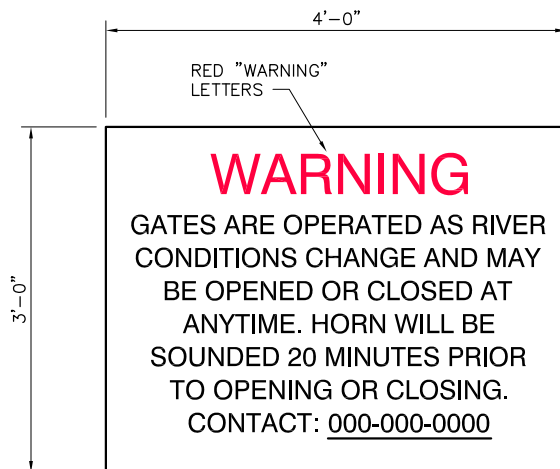


BLACK LETTERS ON WHITE PAINTED
ALUMINUM BOARD
CONTACT NUMBER TO BE PROVIDED BY OWNER

5 GATE WARNING SIGN
C26 SCALE: NONE
C54




BLACK LETTERS AND BORDER ON
WHITE PAINTED ALUMINUM BOARD

6 GATE POSITION SIGNS
C26 SCALE: 1/8" = 1'-0"
C54, C74

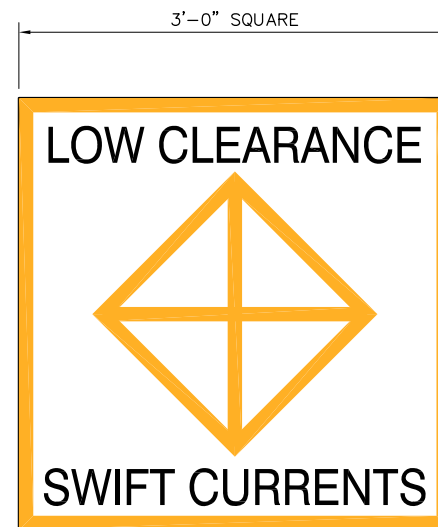


ORANGE SYMBOL AND BORDER,
BLACK LETTERS ON WHITE
PAINTED ALUMINUM BOARD

7 DANGER SIGN
C26 SCALE: 1/8" = 1'-0"
C54

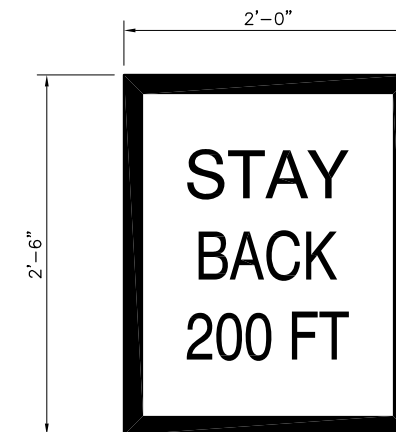


BLACK LETTERS AND BORDER ON WHITE PAINTED
ALUMINUM BOARD

9 STAY BACK WARNING SIGN
C26 SCALE: 1/8" = 1'-0"
C54

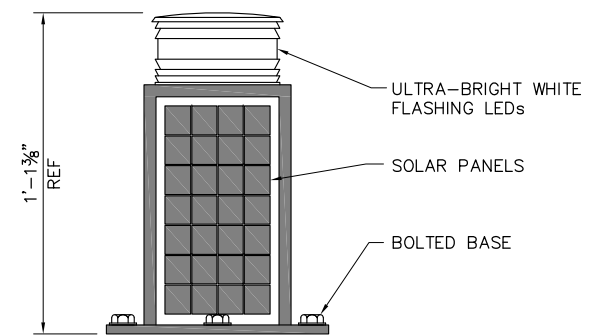

NAVIGATION LIGHT;
ATOP GATE PLATFORM AND ALONG SHEET PILE WHERE NOTED.
CARMANAH MODEL M702-5GPS OR EQUAL - SEE SPECIFICATIONS.

4 NAVIGATION LIGHT
C26 SCALE: NONE
C54

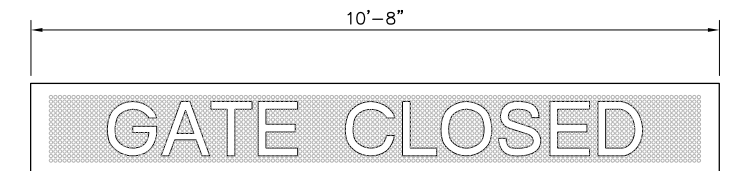


OR



CHANGEABLE ELECTRIC MESSAGEBOARD 12 LETTER, 12" HIGH,
VISIBLE FROM 600', MOUNTED ON OPERATOR HOUSE ROOF
ONE EACH FACING UPSTREAM & DOWNSTREAM.
MODEL PDR0112-12 FROM GRANDWELL DISPLAYS OR EQUAL

8 ELECTRONIC MESSAGE SIGN
C26 SCALE: NONE
C54

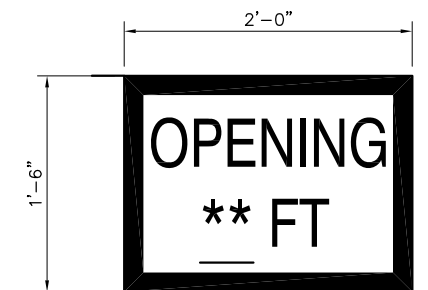

SIGN TO BE MOUNTED
ON DOLPHIN PILES
BENEATH GATE 5 MPH
SIGNS.
OLD RIVER ** 75 FT
CONSTRUCTION SLOUGH
** 60 FT

BLACK LETTERS AND BORDER ON WHITE
PAINTED ALUMINUM BOARD

10 GATE OPENING SIGN
C26 SCALE: 1/8" = 1'-0"
C54








NOTE:

SEE DRAWING C76 FOR SIGN MOUNTING DETAILS.

100% SUBMITTAL


IF SHEET IS LESS THAN 22" x 34"
IT IS A REDUCED PRINT -
SCALE REDUCED ACCORDINGLY.

REVISION	DESCRIPTION	BY	DATE	 San Luis & Delta-Mendota Water Authority 842 6th Street, Suite 7 PO Box 2157 Los Banos, California 93635 APPROVED _____ FRANCY C. MIZUNO, PE C35136 San Luis & Delta-Mendota Water Authority APPROVED _____ DENNIS G. MAJORS PE C21297 Metropolitan Water District of Southern California	 2001 N. Main Street, Suite 360 Walnut Creek, California 94596 (925) 944-5411	TWO GATE FISH PROTECTION PLAN		DATE 08/31/09
AIDS TO NAVIGATION DETAILS, SHEET 1		SHEET 71 OF 78						
		C75						

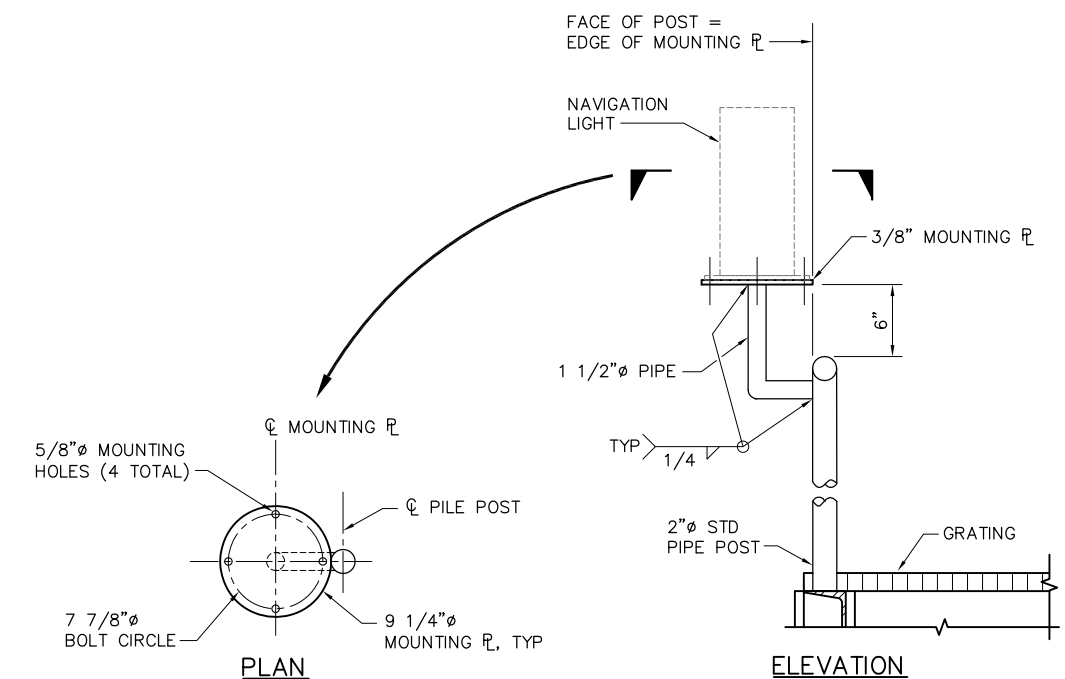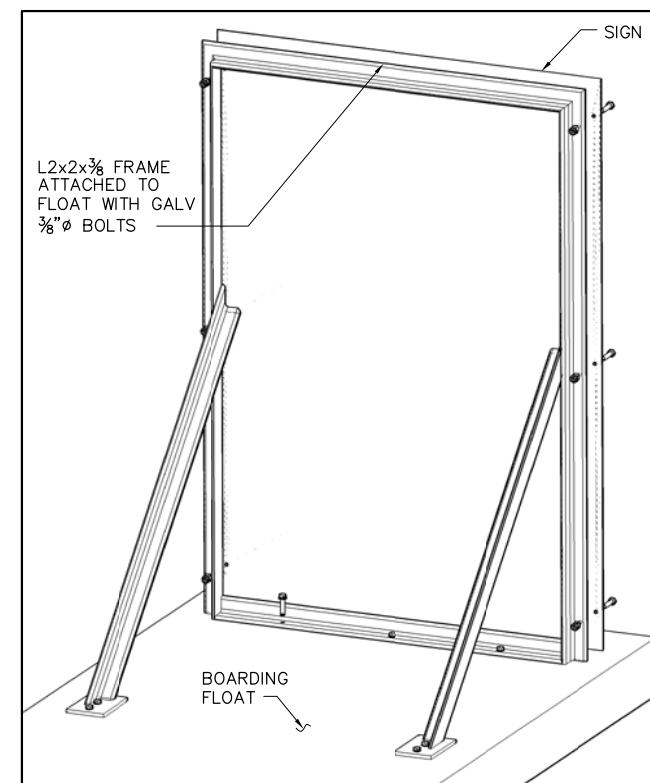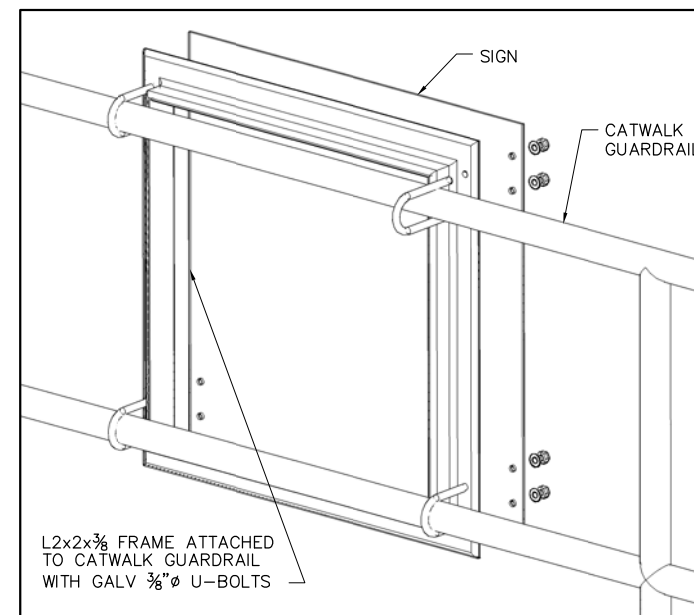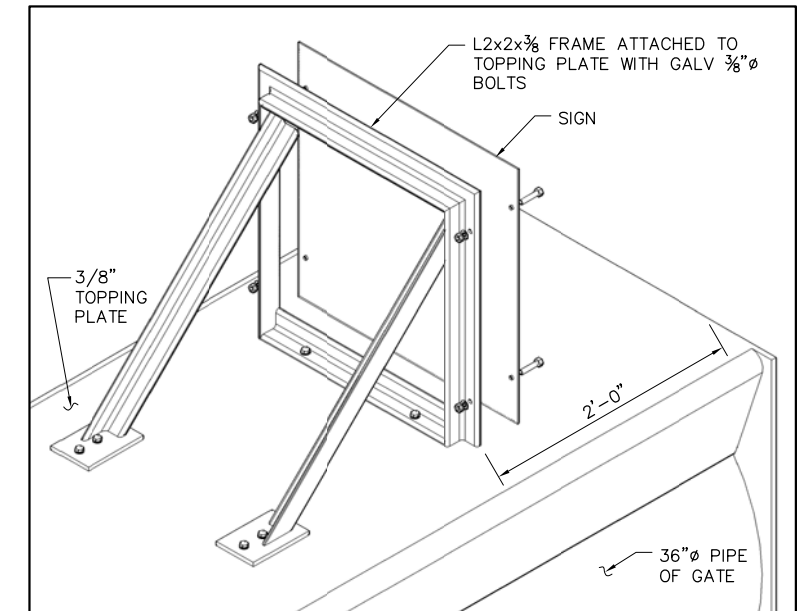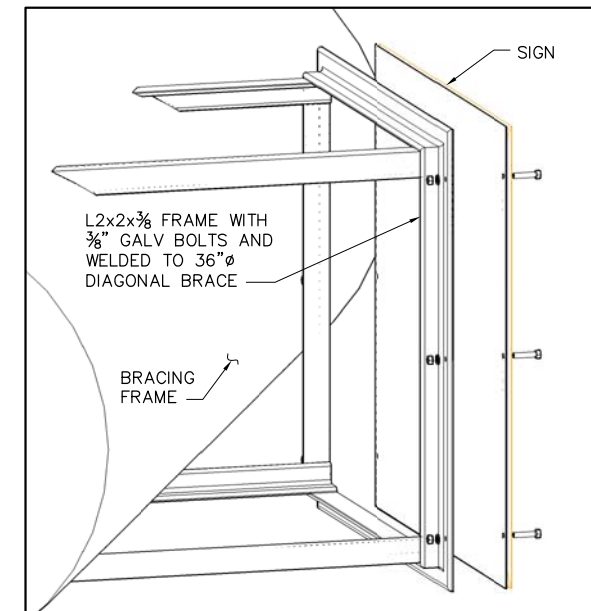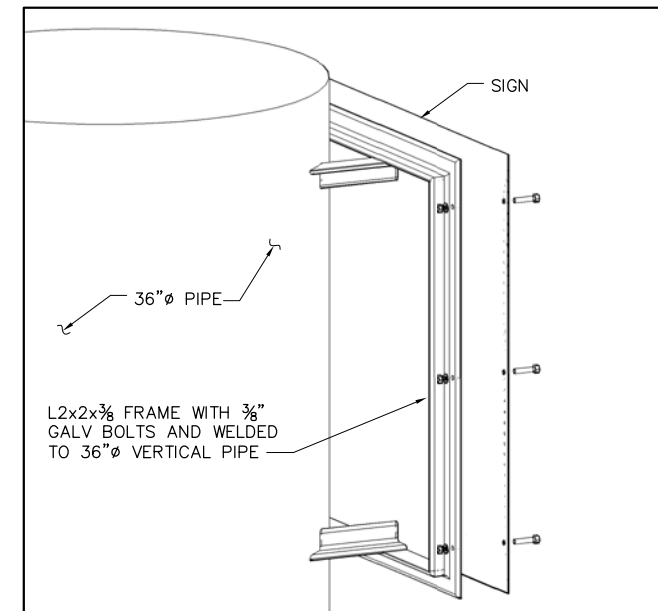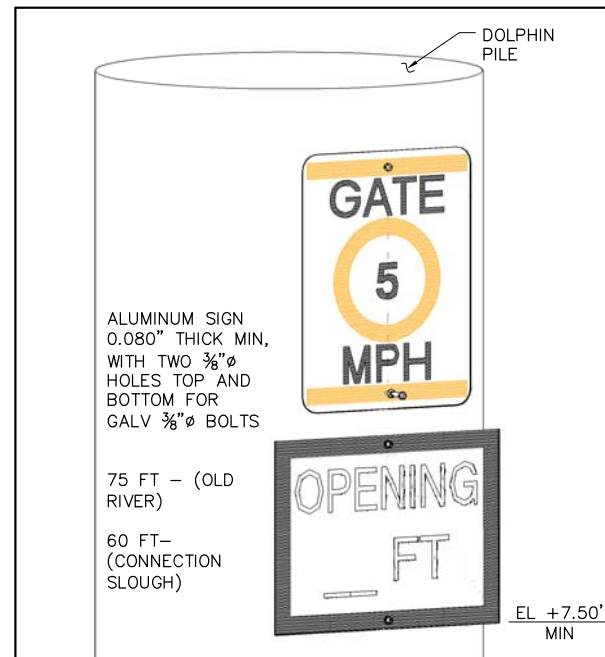

100% SUBMITTAL IF SHEET IS LESS THAN 22" x 34"
IT IS A REDUCED PRINT –
SCALE REDUCED ACCORDINGLY.

REVISION	DESCRIPTION	BY	DATE

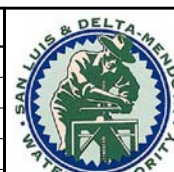

San Luis & Delta-Mendota Water Authority
842 6th Street, Suite 7
PO Box 2157
Los Banos, California 93635

APPROVED _____
FRANCY C. MIZUNO, PE C35136
San Luis & Delta-Mendota Water Authority

APPROVED _____
DENNIS G. MAJORS PE C21297
Metropolitan Water District of Southern California



2001 N. Main Street, Suite 360
Walnut Creek, California 94596
(925) 944-5411

DSGN TDB	DR TAE/AB	CHK RBD
JOB NO. 6097-03	SUBMITTED BY RMR	

TWO GATE FISH PROTECTION PLAN


DATE 08/31/09

SHEET 72 OF 78


AIDS TO NAVIGATION DETAILS
SHEET 2

C76

P:\6097-03 SMC GATE DESIGN\CADD\DWG\609703-C77.DWG 8/27/2009 9:34 AM

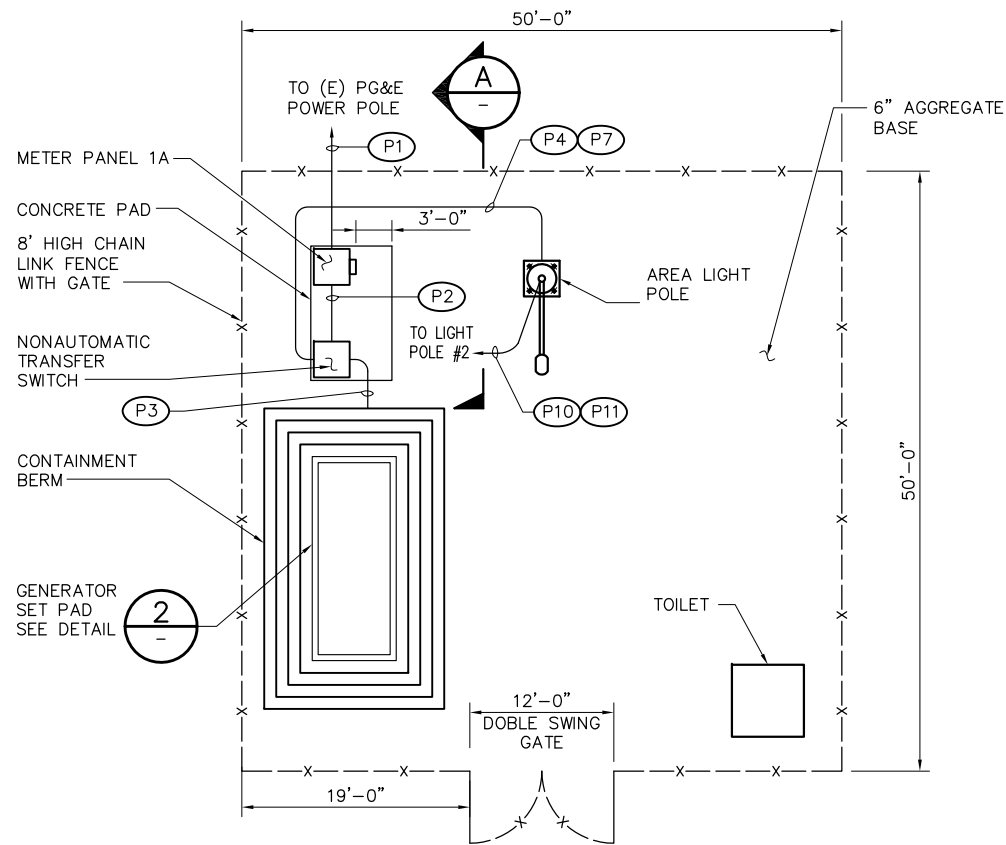


1 UTILITY YARD
C13
SCALE: 1/8"=1'-0"
C41

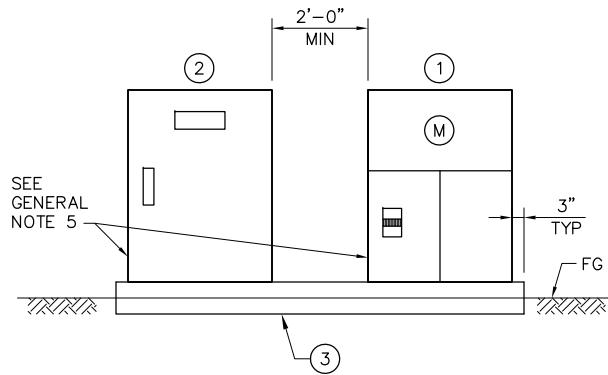

NOTES:

- 225A 208Y/120V 3Ø 4W METERED SERVICE PANEL "1A" IN A NEMA 3R ENCLOSURE.
- 225A 208Y/120V 3Ø 4 POLE NONAUTOMATIC TRANSFER SWITCH IN A NEMA 3R ENCLOSURE.
- 8" THICK CONCRETE PAD WITH #4 @ 12 EW, 4" ABOVE FINISH GRADE.


SERVICE PANEL AND TRANSFER SWITCH ELEVATION
A
NTS

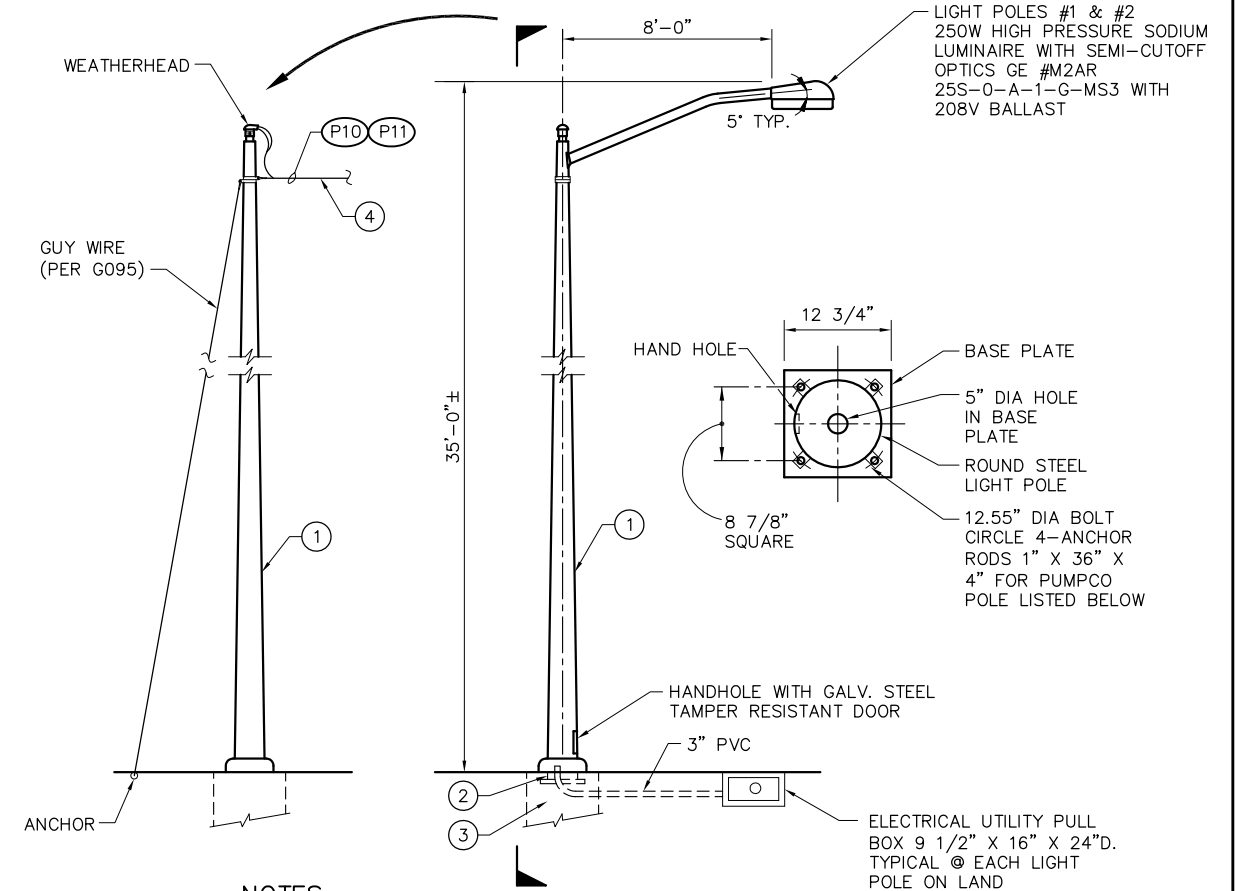

NOTES:

- PUMPCO GALV. STEEL LIGHT POLE
- VERIFY BOLT CIRCLE & SPACING DIMENSIONS WITH MFG.
- FOR FOUNDATION SEE DWG C82.
- OVERHEAD LINE SHALL COMPLY TO STATE OF CALIFORNIA GENERAL ORDER NO. 95. BASIC MINIMUM ALLOWABLE VERTICAL CLEARANCE TO GROUND.

3 AREA LIGHT POLE
C13
NTS
C82

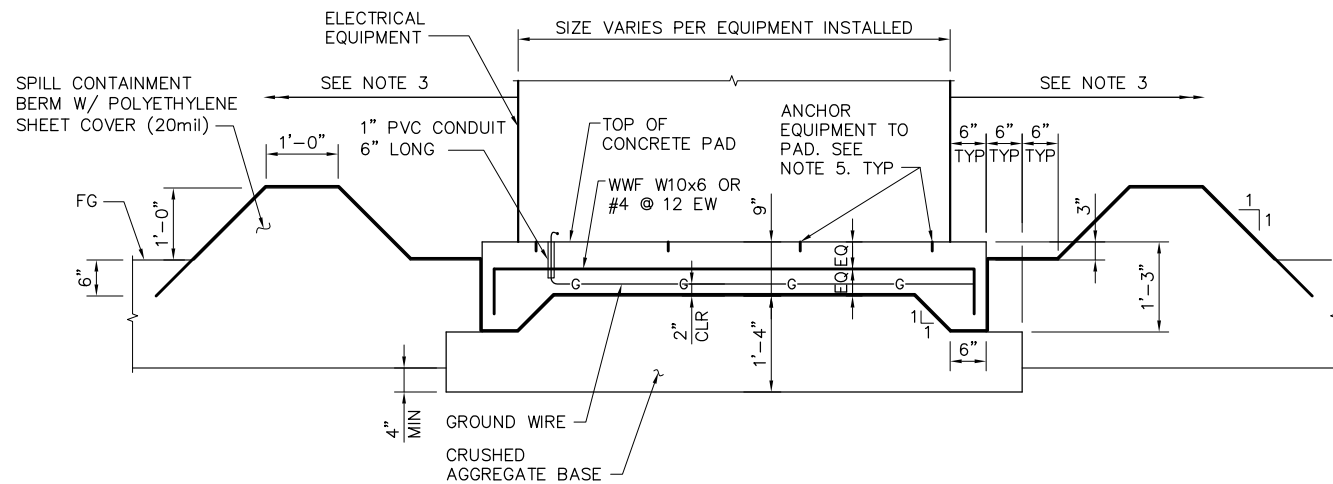

2 GENERATOR SET PAD DETAIL
NTS

GENERAL NOTES:

- PROVIDE AND INSTALL MIN 20'-0"L, 1-#3/0 MIN. BARE COPPER UFER GROUND WIRE 2" ABOVE BOTTOM OF PAD. BOND TO ELECTRICAL EQUIPMENT.
- ANCHOR EQUIPMENT TO CONCRETE PAD WITH ANCHORS PER EQUIPMENT MANUFACTURER'S INSTALLATION INSTRUCTIONS.
- PROVIDE 6'-0" MIN. CLEAR WORKING SPACE AROUND EQUIPMENT.
- STUB CONDUITS IN EQUIPMENT AT LOCATIONS PROVIDED BY EQUIPMENT MANUFACTURERS INSTALLATION INSTRUCTIONS. COORDINATE EXACT LOCATION WITH MANUFACTURERS INSTALLATION INSTRUCTIONS.
- ALL UNDER GROUND CONDUIT SHALL BE SCH 40 PVC 36" BELOW FINISH GRADE.

100% SUBMITTAL


IF SHEET IS LESS THAN 22" x 34"
IT IS A REDUCED PRINT -
SCALE REDUCED ACCORDINGLY.

REVISION	DESCRIPTION	BY	DATE

	San Luis & Delta-Mendota Water Authority 842 6th Street, Suite 7 PO Box 2157 Los Banos, California 93635
APPROVED	FRANCY C. MIZUNO, PE C35136 San Luis & Delta-Mendota Water Authority
APPROVED	DENNIS G. MAJORS PE C21297 Metropolitan Water District of Southern California

	 2001 N. Main Street, Suite 360 Walnut Creek, California 94596 (925) 944-5411			
	DSGN DM		DR AB/EP	CHK CBS
	JOB NO. 6097-03		SUBMITTED BY RMR	


TWO GATE FISH PROTECTION PLAN	DATE 08/31/09
UTILITY YARD DETAILS	SHEET 73 OF 78
	C77

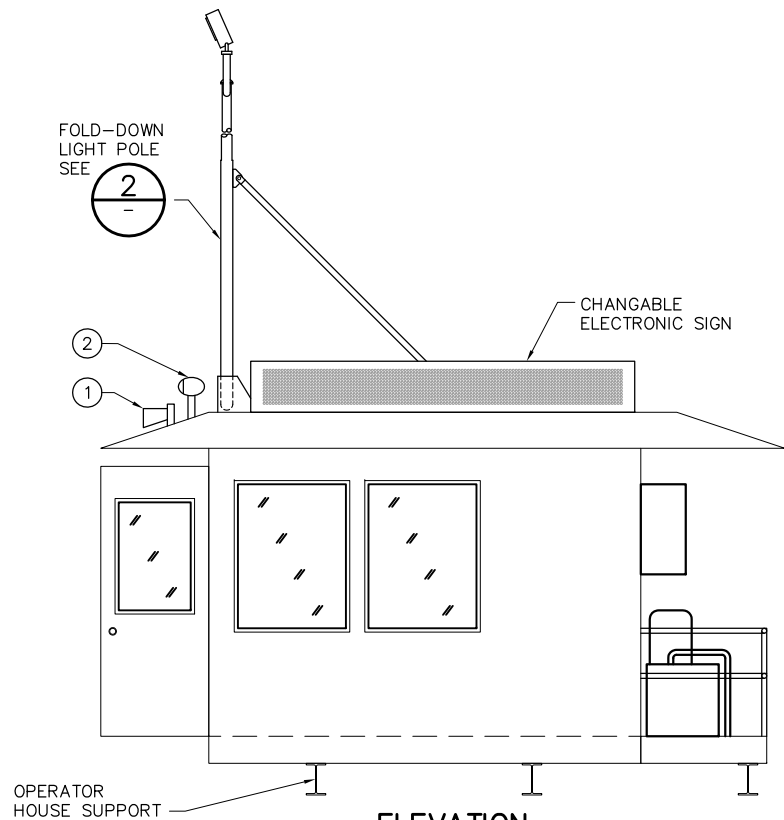


ELEVATION
SCALE: 3/8" = 1'-0"

NOTES:


- 1 SECO HAILER HORN 40 HMS, 15 WITH STANDARD HORIZON 30W LOUD HAILER MFG #VLH-3000
- 2 REMOTE CONTROLLED SEARCHLIGHT, ACR ELECTRONICS MFG #RCL-75 SPOTLIGHT AND 17' L CABLE HARNESS

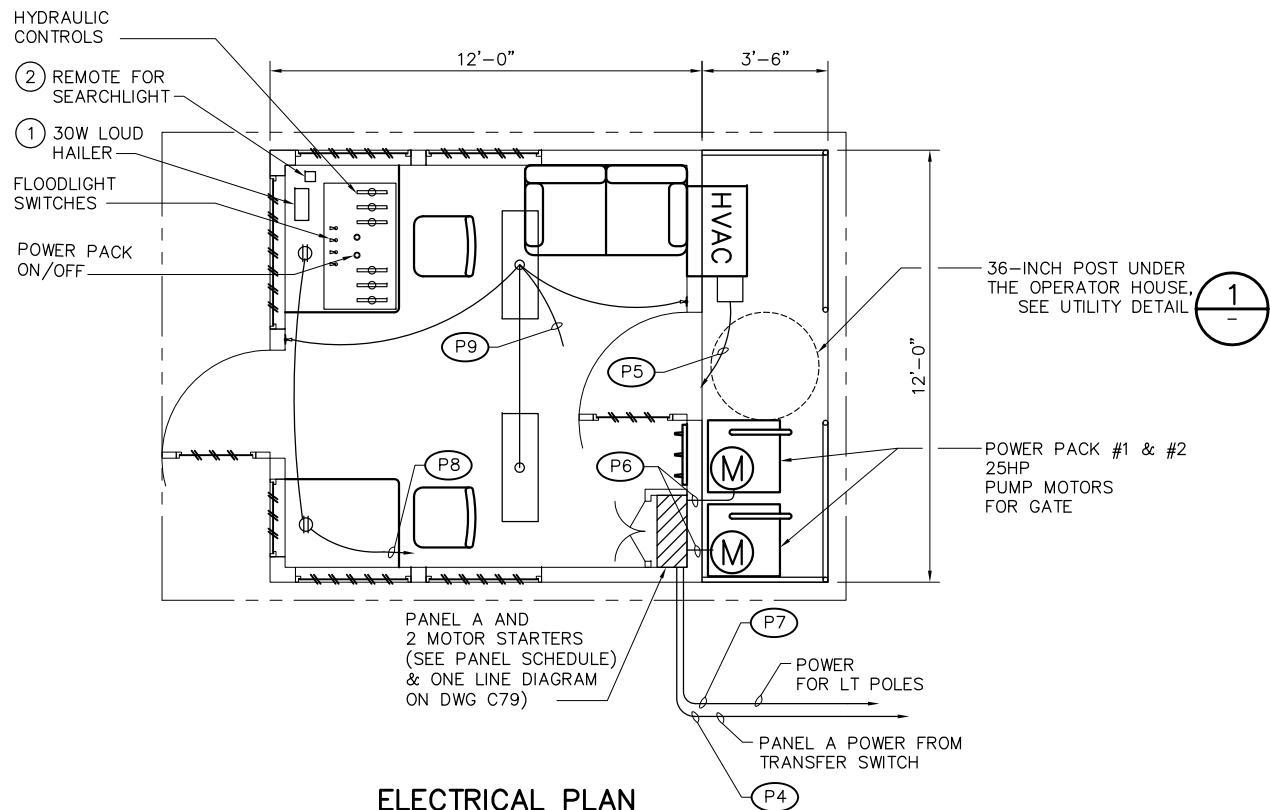

ELECTRICAL PLAN
SCALE: 3/8" = 1'-0"

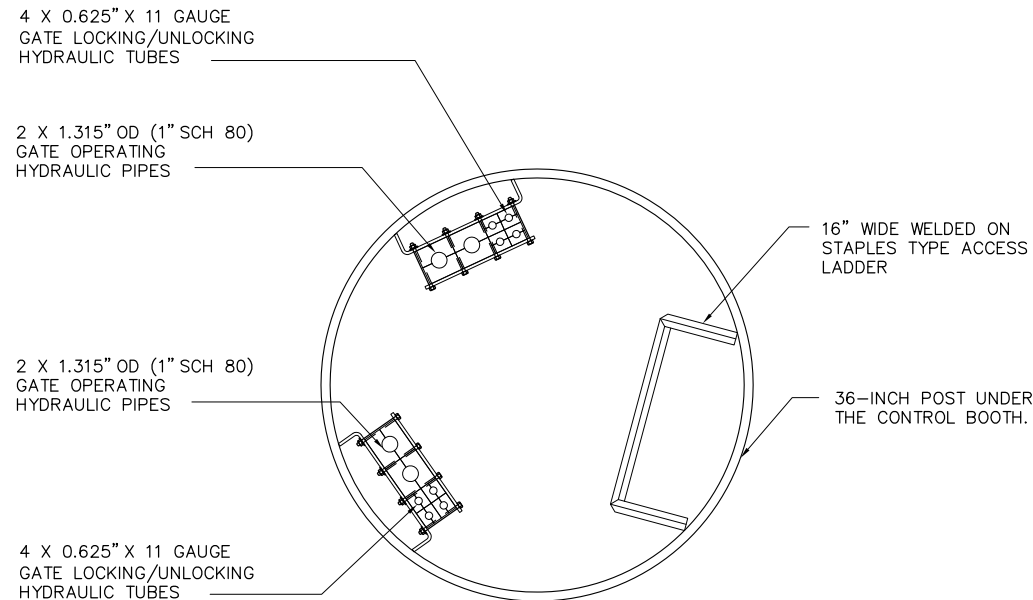


1 UTILITY DETAIL
SCALE: 1 1/2" = 1'-0"

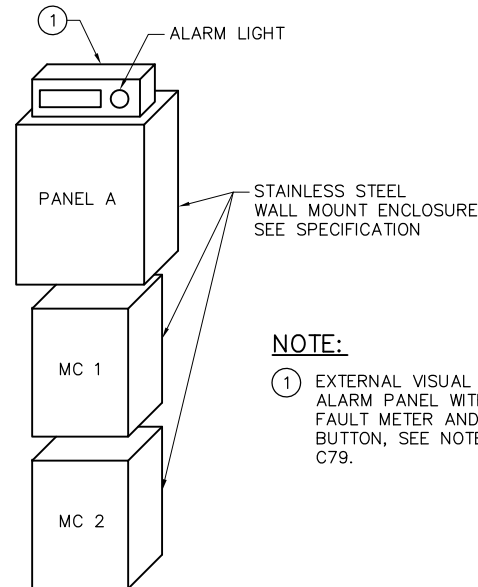

NOTE:

- 1 EXTERNAL VISUAL SIGNAL LIGHT ALARM PANEL WITH GROUND FAULT METER AND TEST RESET BUTTON, SEE NOTE 9 ON DWG C79.

ELECTRICAL CABINET ARRANGEMENT
NTS

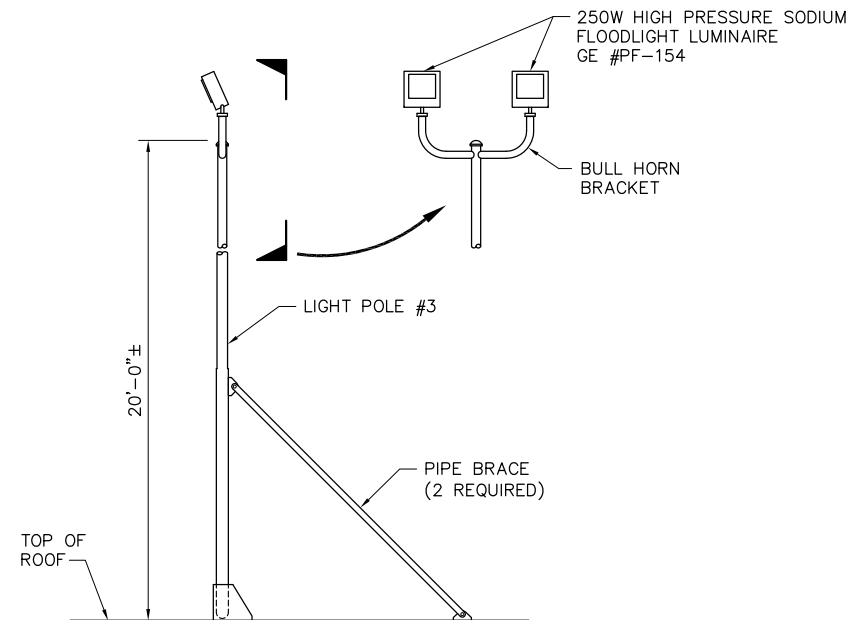

2 FOLD-DOWN LIGHT POLE DETAIL
C13 NTS

100% SUBMITTAL

IF SHEET IS LESS THAN 22" x 34" IT IS A REDUCED PRINT - SCALE REDUCED ACCORDINGLY.

P:\6097-03 SWC GATE DESIGN\CADD\DWG\609703-C78.DWG 8/27/2009 9:35 AM

REVISION	DESCRIPTION	BY	DATE

San Luis & Delta-Mendota Water Authority
842 6th Street, Suite 7
PO Box 2157
Los Banos, California 93635

APPROVED _____
FRANCY C. MIZUNO, PE C35136
San Luis & Delta-Mendota Water Authority


APPROVED _____
DENNIS G. MAJORS PE C21297
Metropolitan Water District of Southern California

2001 N. Main Street, Suite 360
Walnut Creek, California 94596
(925) 944-5411

DSGN	CBS	DR	AB/EP	CHK	TDB
JOB NO.	6097-03	SUBMITTED BY	RMR		

TWO GATE FISH PROTECTION PLAN		DATE	08/31/09
		SHEET	74 OF 78
OPERATOR HOUSE EQUIPMENT AND DETAILS		C78	

P:\6097-03 SWC GATE DESIGN\CADD\DWG\609703-C79.DWG 8/27/2009 9:35 AM

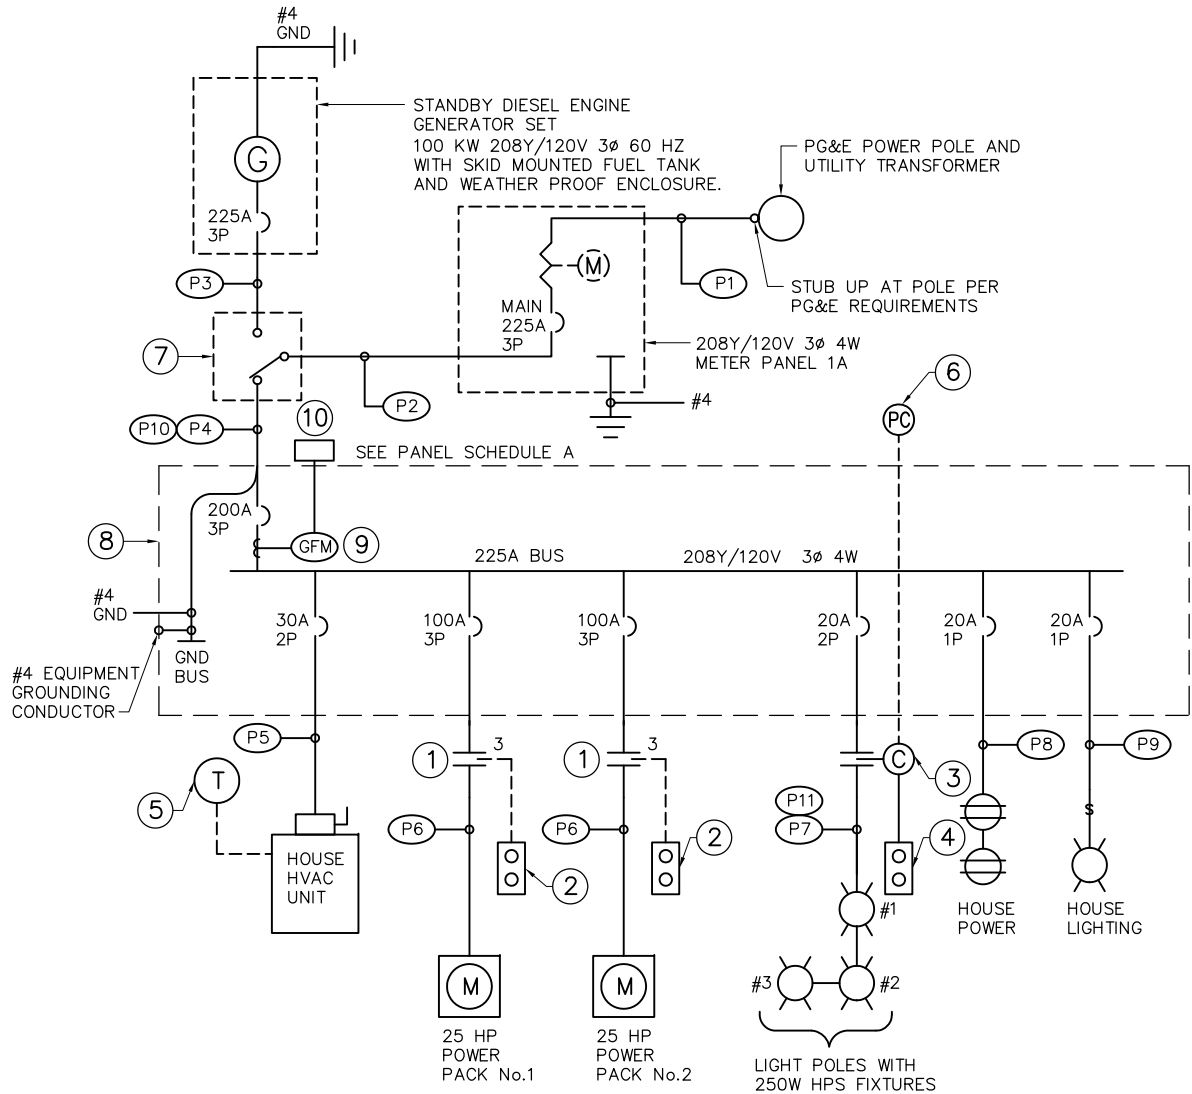

NOTES:

- 1 NEMA SIZE 3 COMBINATION MOTOR STARTER
- 2 POWER PACK ON/OFF CONTROL IN OPERATOR HOUSE
- 3 30A LIGHTING CONTACTOR
- 4 FLOOD LIGHT CONTROL. HAND OFF AUTO IN OPERATOR HOUSE
- 5 THERMOSTAT CONTROL IN OPERATOR HOUSE
- 6 PHOTO CELL LOCATED ON TOP OF OPERATOR HOUSE
- 7 225A - 4W 208Y/120V 3PH. 4 POLE NONAUTOMATIC TRANSFER SWITCH IN A NEMA 3R ENCLOSURE
- 8 PANEL "A" LOCATED IN OPERATOR HOUSE
- 9 GROUND FAULT MONITOR CAT NO. RCM470LY BY BENDER WITH CT's SIZED TO ACCEPT FEEDER CABLES AND AN EXTERNAL VISUAL SIGNAL LIGHT ALARM PANEL WITH GROUND FAULT METER
- 10 EXTERNAL ALARM PANEL FOR GROUND FAULT MONITOR

ONE LINE DIAGRAM
N.T.S.

GENERAL NOTES:

1. ALL EQUIPMENT METAL PARTS SHALL BE BONDED WITH A CODE SIZE GROUND CONDUCTOR.
2. EQUIPMENT SHALL NOT BE GROUNDED TO THE BARGE HULL.

PANEL: A

LOCATION : CONTROL HOUSE										VOLTAGE/PHASE : 208Y/120V, 3Ø, 4W										FED FROM : PANEL 1A									
MOUNTING : SURFACE										BUS AMPS : 225A										MINIMUM BUS BRACING : 10 KA									
										MAIN BREAKER : 200A 3P																			
LOADS		SEE NOTE	OUTLETS			VOLT-AMPS				BKR/ POLE	A B C			BKR/ POLE		VOLT-AMPS			OUTLETS			SEE NOTE	LOADS						
			LTG	REC	MISC	A	B	C	CKT							A	B	C	MISC	REC	LTG								
POWER PACK #1	1				1	9360			1	100/3	*-----	20/2	2	500							4	2	OUT SIDE LIGHTS						
25 HP MOTOR							9360		3	.	---*----	.	4			500													
								9360	5	.	-----*	20/1	6					720		2			HOUSE RECEPT						
POWER PACK #2	1				1	9360			7	100/3	*-----	20/1	8	200							2		HOUSE LIGHTS						
25 HP MOTOR							9360		9	.	---*----		10										SPACE						
								9360	11	.	-----*		12										SPACE						
HOUSE					1	2000			13	30/2	*-----		14										SPACE						
HVAC UNIT							2000		15	.	---*----		16										SPACE						
SPARE									17	20/1	-----*		18										SPACE						
SPARE									19	20/1	*-----		20										SPACE						
SPARE									21	20/1	---*----		22										SPACE						
SPARE									23	20/1	-----*		24										SPACE						
TOTAL ØA = 21420 VOLT-AMPS TOTAL ØB = 21220 VOLT-AMPS TOTAL ØC = 19440 VOLT-AMPS LCL = 300 VOLT-AMPS TOTAL = 62380 VA @ 208V, 3Ø 173.3 AMPS NOTES: 1. CONTROLLED BY SIZE 3 MOTOR STARTER 2. CONTROLLED BY PHOTOCELL AND HAND-OFF-AUTO SWITCH																													

CONDUIT AND FEEDER SCHEDULE

	CONDUIT	CONDUCTOR	REMARKS
P1	3" PVC	PULL ROPE	CONDUCTORS BY PG&E
P2	3" PVC	4 #4/0 & 1 #4 GND	TO TRANSFER SWITCH
P3	3" PVC	4 #4/0 & 1 #4 GND	TO TRANSFER SWITCH
P4	3" PVC	4 #4/0 & 1 #4 GND	SURVING PANEL A
P5	1" PVC	2 #10 & 1 #4 GND	HVAC
P6	1 1/4" PVC	3 #2 & 1 #2 GND	POWER PACK #1 & #2
P7	1" PVC	2 #8 & 1 #8 GND	AREA LIGHTING
P8	1/2" PVC	2 #12 & 1 #12 GND	HOUSE POWER
P9	1/2" PVC	2 #12 & 1 #12 GND	HOUSE LIGHTING
* P10	-	4 #4/0 & 1 #4 GND	OVERHEAD CABLE
* P11	-	2 #1/0 & 1 #1/0 NET	OVERHEAD CABLE

* PAC 600V PARALLEL AERIAL CABLE ALUMINUM HD POLY 75' C.

100% SUBMITTAL

IF SHEET IS LESS THAN 22" x 34"
IT IS A REDUCED PRINT -
SCALE REDUCED ACCORDINGLY.

REVISION	DESCRIPTION	BY	DATE



San Luis & Delta-Mendota Water Authority
842 6th Street, Suite 7
PO Box 2157
Los Banos, California 93635

APPROVED _____
FRANCY C. MIZUNO, PE C35136
San Luis & Delta-Mendota Water Authority

APPROVED _____
DENNIS G. MAJORS PE C21297
Metropolitan Water District of Southern California



2001 N. Main Street, Suite 360
Walnut Creek, California 94596
(925) 944-5411

DSGN	DM	DR	AB/EP	CHK	CBS
JOB NO.	6097-03	SUBMITTED BY	RMR		

TWO GATE FISH PROTECTION PLAN


DATE 08/31/09

SHEET 75 OF 78

ELECTRICAL SYSTEM DIAGRAM


C79

P:\6097-03 SWC GATE DESIGN\CADD\DWG\609703-C80.DWG 8/27/2009 9:35 AM

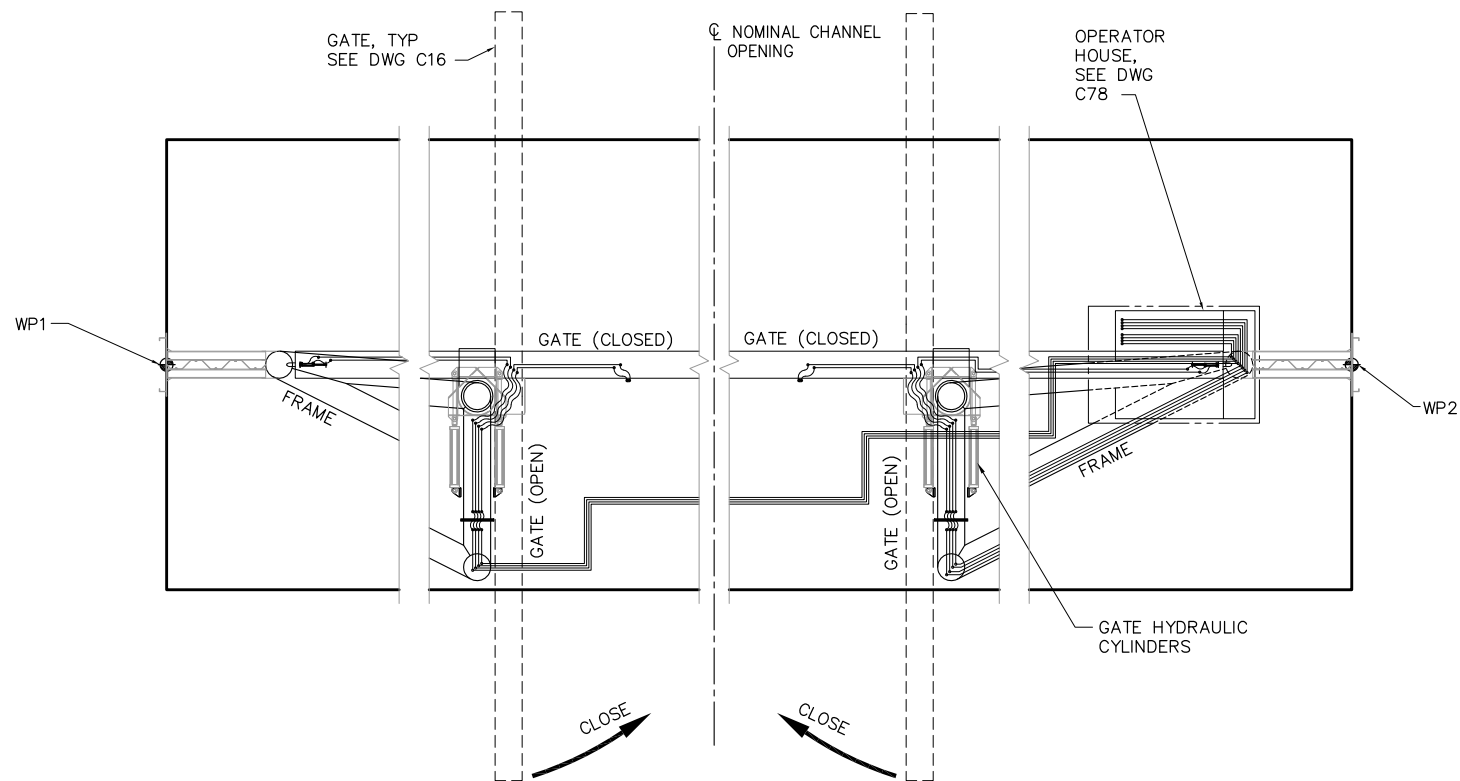


GATE LOCKING HYDRAULIC DIAGRAM

SCALE: 3/32" = 1'-0"

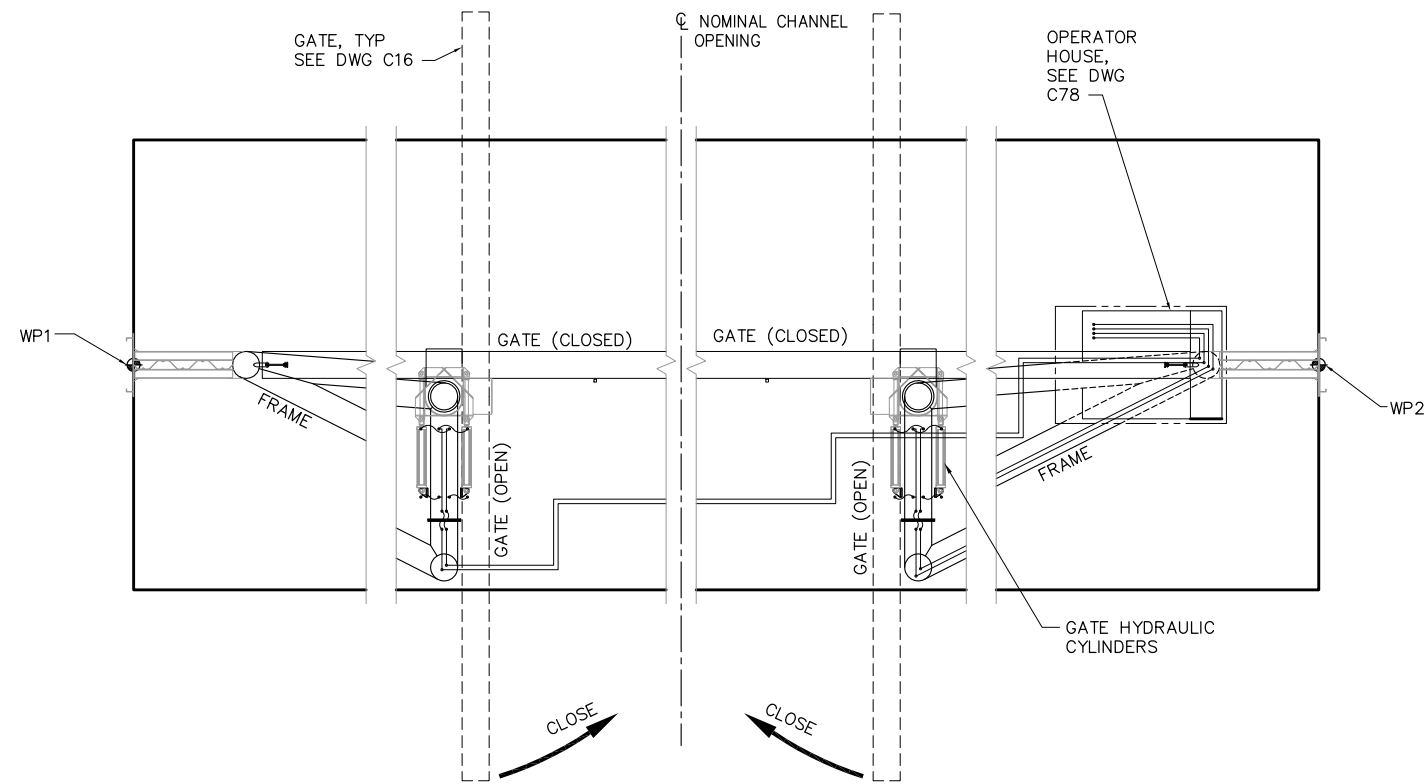


GATE OPERATOR HYDRAULIC DIAGRAM

SCALE: 3/32" = 1'-0"

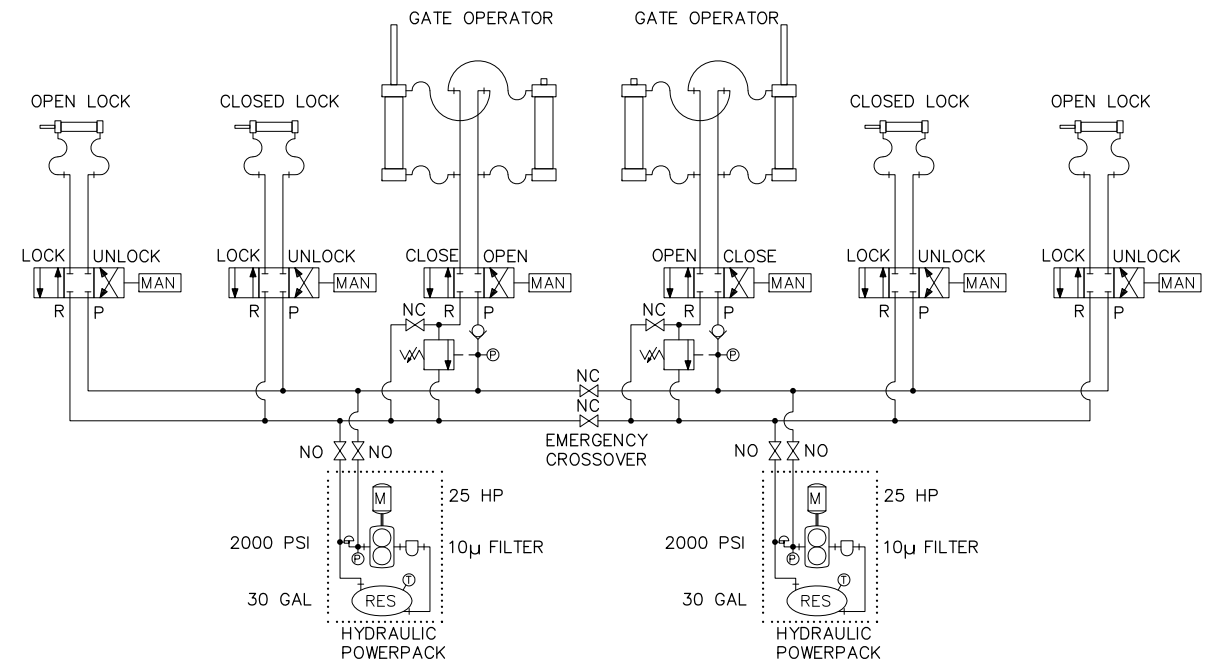

HYDRAULIC SYSTEM SCHEMATIC

NTS

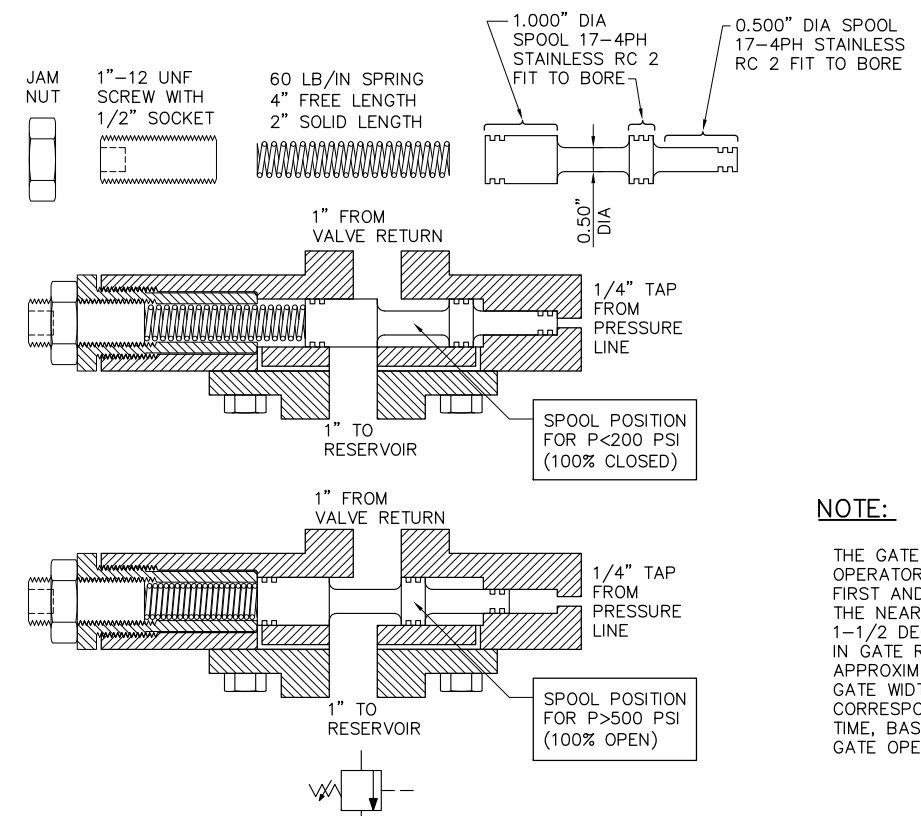

TYPICAL BRAKE VALVE

(EXTERNALLY PILOTED COUNTERBALANCE VALVE)

NTS

NOTE:

THE GATE FARTHEST FROM THE OPERATOR HOUSE MUST BEGIN OPENING FIRST AND CLOSE SLIGHTLY LATER THAN THE NEAR GATE WITH APPROXIMATELY 1-1/2 DEGREES MAXIMUM DIFFERENCE IN GATE ROTATION. (1-1/2 DEGREES IS APPROXIMATELY ONE-HALF OF THE GATE WIDTH LEAD OR LAG, AND CORRESPONDS TO A 4 SECOND DELAY TIME, BASED ON A 4 MINUTE TOTAL GATE OPENING TIME.)

100% SUBMITTAL

IF SHEET IS LESS THAN 22" x 34"
IT IS A REDUCED PRINT -
SCALE REDUCED ACCORDINGLY.

REVISION	DESCRIPTION	BY	DATE



San Luis & Delta-Mendota Water Authority
842 6th Street, Suite 7
PO Box 2157
Los Banos, California 93635

APPROVED _____
FRANCY C. MIZUNO, PE C35136
San Luis & Delta-Mendota Water Authority

APPROVED _____
DENNIS G. MAJORS PE C21297
Metropolitan Water District of Southern California




2001 N. Main Street, Suite 360
Walnut Creek, California 94596
(925) 944-5411


DSGN	CBS	DR	AB	CHK	TDB
JOB NO.	6097-03	SUBMITTED BY	RMR		

TWO GATE FISH PROTECTION PLAN	DATE 08/31/09
	SHEET 76 OF 78
HYDRAULICS SYSTEM DIAGRAM	C80


P:\6097-03 SMC GATE DESIGN\CADD\DWG\609703-C81.DWG 8/27/2009 9:36 AM

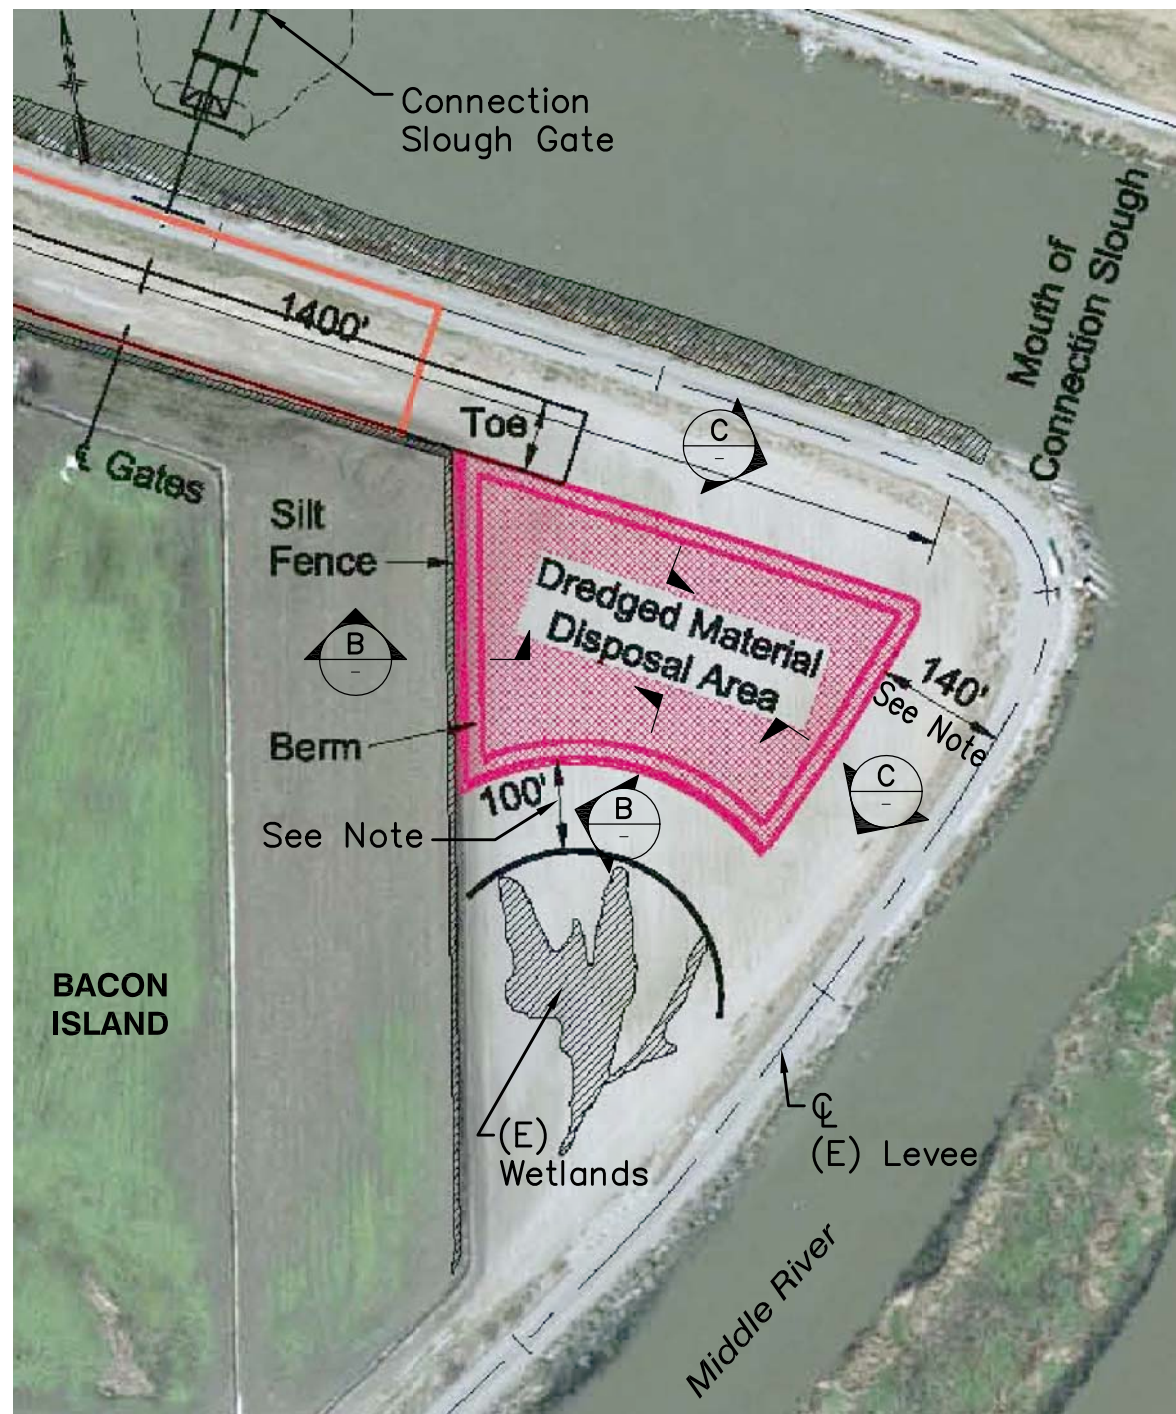

A DISPOSAL SITE PLAN
NTS
NOTE: SEE DWG G4 FOR LOCATION.

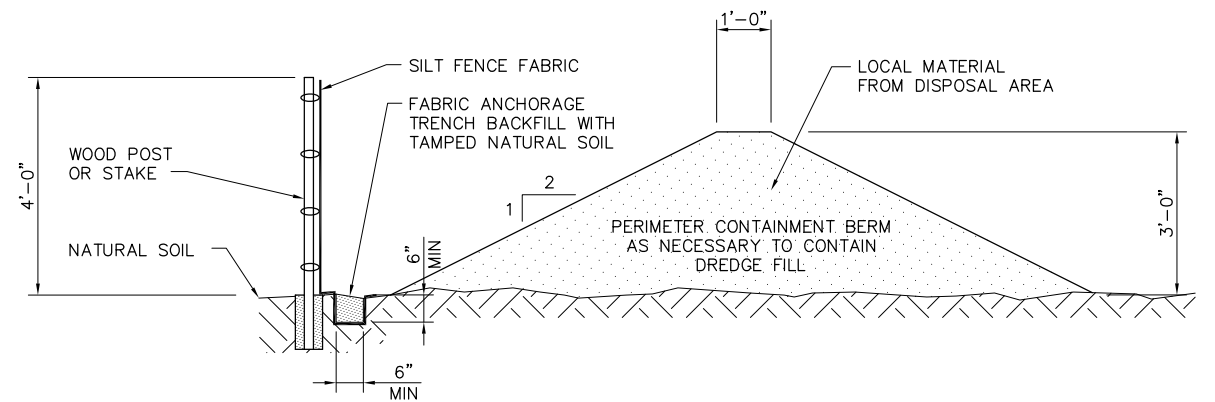

B SECTION
SCALE: NONE

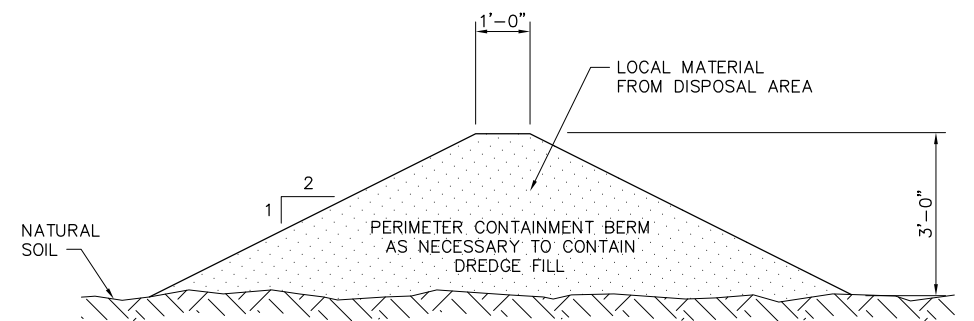

C SECTION
SCALE: NONE

NOTE:
NO DREDGE MATERIAL SHALL BE PLACED WITHIN 140'
OF THE LEVEE CENTERLINE AND 100' OF THE WETLANDS.

100% SUBMITTAL IF SHEET IS LESS THAN 22" x 34"
IT IS A REDUCED PRINT -
SCALE REDUCED ACCORDINGLY.

REVISION	DESCRIPTION	BY	DATE



San Luis & Delta-Mendota Water Authority
842 6th Street, Suite 7
PO Box 2157
Los Banos, California 93635

APPROVED _____
FRANCY C. MIZUNO, PE C35136
San Luis & Delta-Mendota Water Authority

APPROVED _____
DENNIS G. MAJORS PE C21297
Metropolitan Water District of Southern California




2001 N. Main Street, Suite 360
Walnut Creek, California 94596
(925) 944-5411


DSGN	TDB	DR	TAE/AB	CHK	GTH
JOB NO. 6097-03		SUBMITTED BY RMR			

TWO GATE FISH PROTECTION PLAN	DATE 08/31/09
	SHEET 77 OF 78
DREDGED MATERIAL DISPOSAL SITE	C81


P:\6097-03 SWC GATE DESIGN\CADD\DWG\609703-CB2.DWG 8/30/2009 5:02 PM

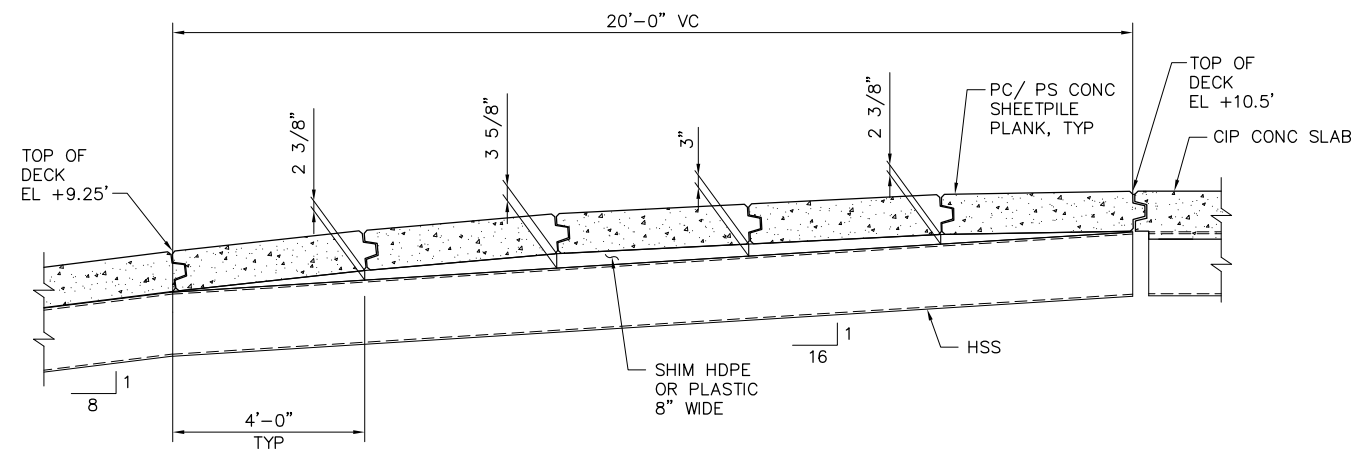


1
C7
DETAIL
SCALE: 1/2" = 1'-0"

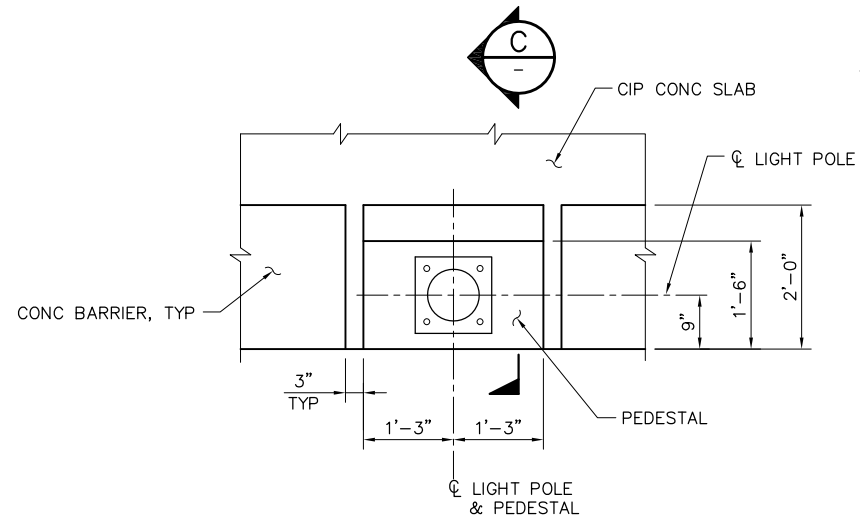


3
C39
DETAIL
SCALE: 3/4" = 1'-0"

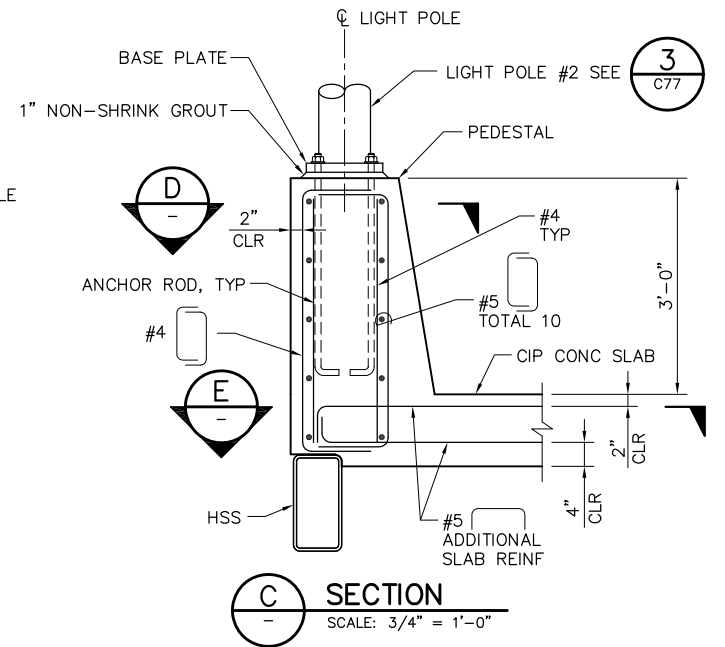


C
SECTION
SCALE: 3/4" = 1'-0"

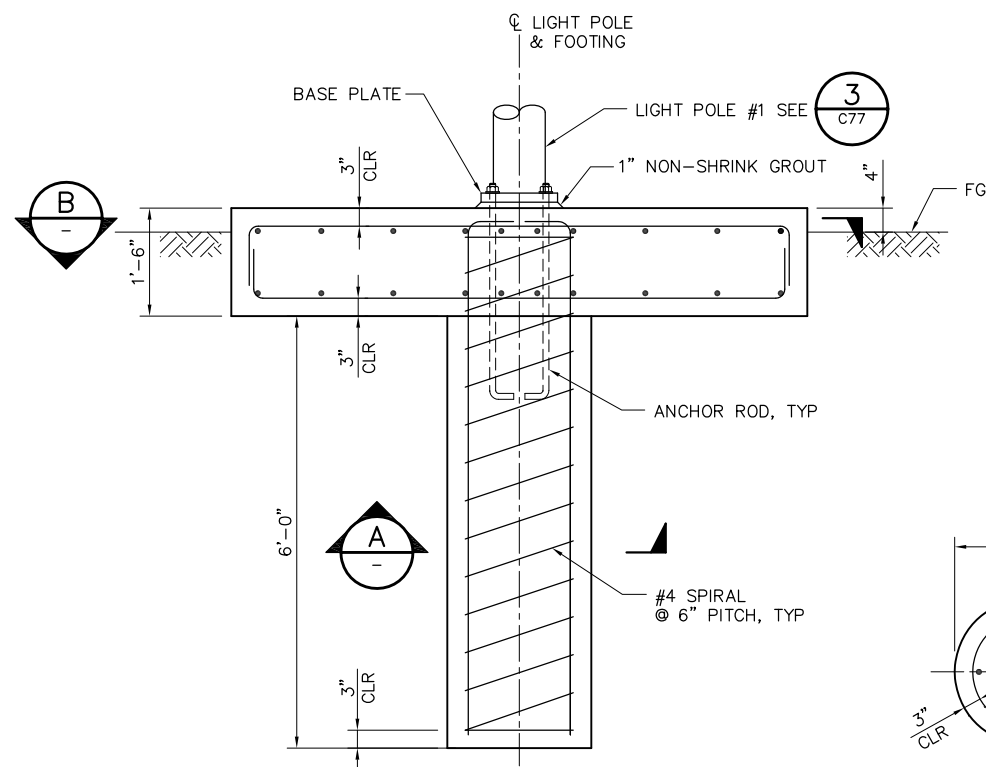


2
C77
DETAIL
SCALE: 3/4" = 1'-0"

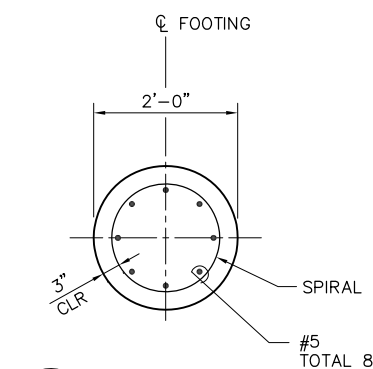


A
SECTION
SCALE: 3/4" = 1'-0"

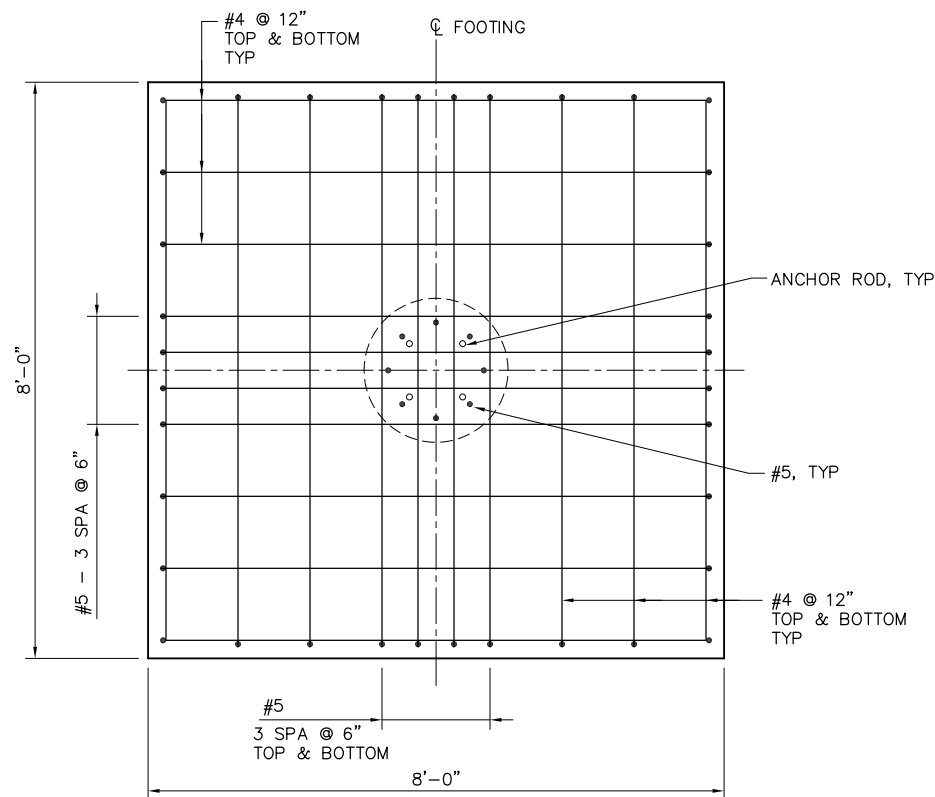

B
SECTION
SCALE: 3/4" = 1'-0"

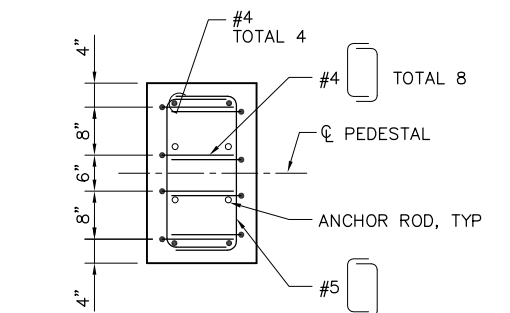


D
SECTION
SCALE: 3/4" = 1'-0"

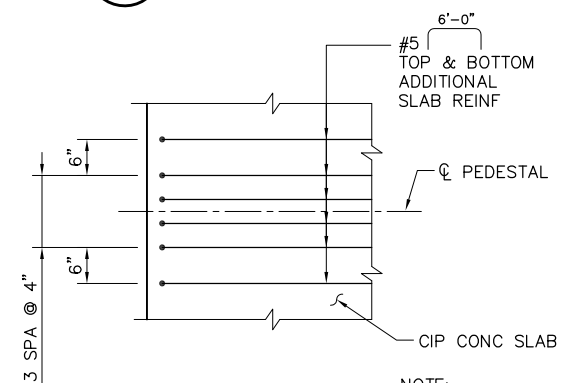

E
SECTION
SCALE: 3/4" = 1'-0"

 NOTE:
PEDESTAL REINFORCEMENT
NOT SHOWN FOR CLARITY.



100% SUBMITTAL IF SHEET IS LESS THAN 22" x 34"
IT IS A REDUCED PRINT -
SCALE REDUCED ACCORDINGLY.

REVISION	DESCRIPTION	BY	DATE



San Luis & Delta-Mendota Water Authority
842 6th Street, Suite 7
PO Box 2157
Los Banos, California 93635

APPROVED _____
FRANCY C. MIZUNO, PE C35136
San Luis & Delta-Mendota Water Authority

APPROVED _____
DENNIS G. MAJORS PE C21297
Metropolitan Water District of Southern California



2001 N. Main Street, Suite 360
Walnut Creek, California 94596
(925) 944-5411

DSGN	JMB	DR	EP	CHK	TDB
JOB NO.	SUBMITTED BY				
6097-03	RMR				

TWO GATE FISH PROTECTION PLAN		DATE 08/31/09
MISCELLANEOUS DETAILS		SHEET 78 OF 78
		C82